


POTENTIAL MOT
PHASE 1


MOT1: Southbound Moody Rd closed from Hidden Acres Circle to Hancock Bridge Parkway

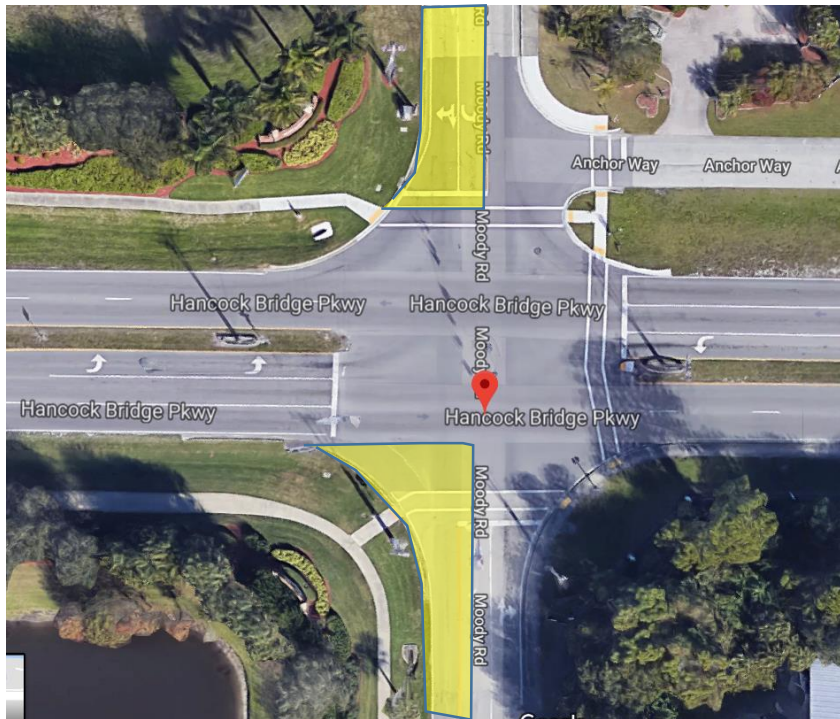


Southbound Moody Rd closed from Hancock Bridge Parkway to 950 Moody Rd

MOT2: Diverted traffic to Moody River Blvd

MOT1: Diverted traffic to Pondella Rd

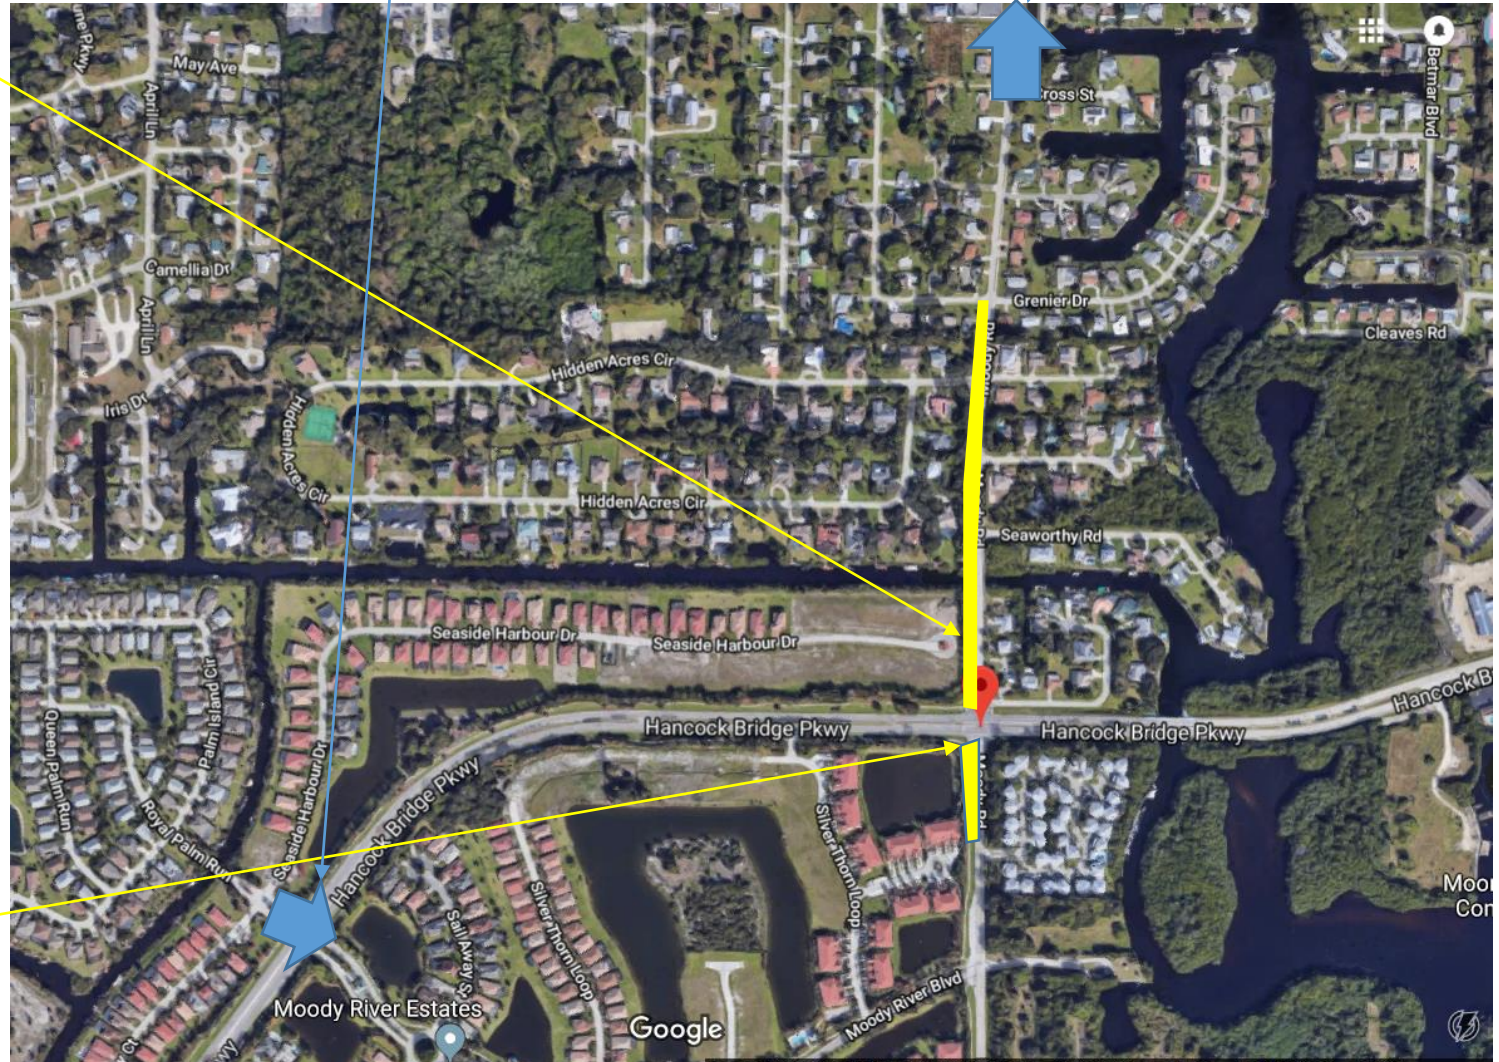

POTENTIAL MOT
Phase 1

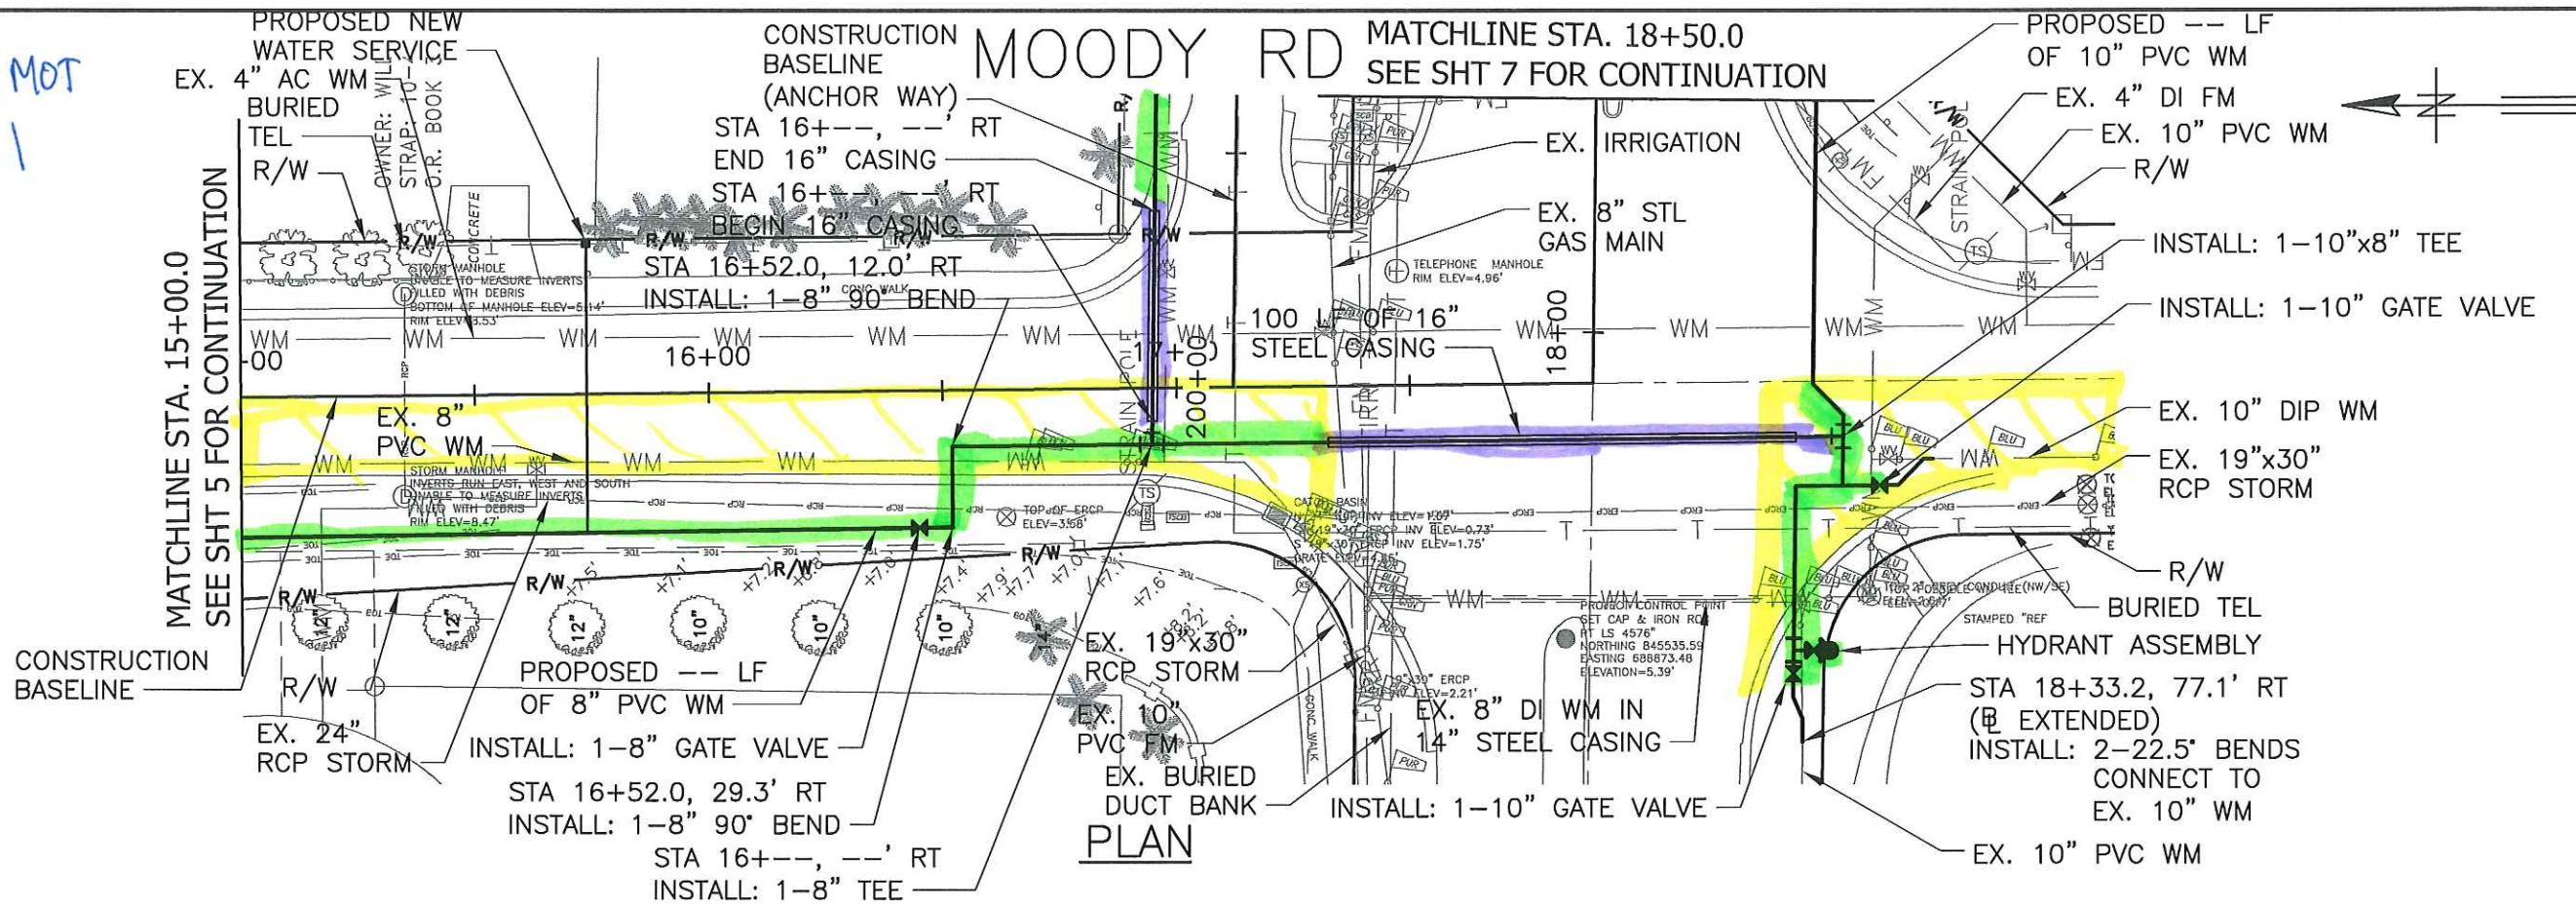

ROAD CLOSURE
TRENCHLESS INSTALLATION
OPEN-CUT INSTALLATION

PROFILE
SCALE: 1" = 40' HORIZ.
1" = 8' VERT.

GREELEY AND HANSEN
5260 SUMMERLIN COMMONS WAY,
SUITE 302
FORT MYERS, FLORIDA 33907
CERTIFICATE OF AUTHORIZATION NO. 37

0 40 FT
1" = 40' HORIZ.
0 8 FT
1" = 8' VERT.

DESIGNED EJ M, MSK
DRAWN JMW
CHECKED MSK


NO.	DATE	APPD	REVISION

P.E. NAME: MICHAEL S. KNOWLES P.E. NO. 67489
P.E. NAME:
DATE:

HANCOCK BRIDGE PKWY
WATER MAIN IMPROVEMENTS
CONTRACT NO. 7121
WATER MAIN - PLAN AND PROFILE
MOODY RD
STA 15+00.0 TO STA 18+50.0

W.O. NO. -
FILE: 0520A-P01
NO. 6 OF
DATE FEBRUARY 2018

POTENTIAL MOT
Phase 2

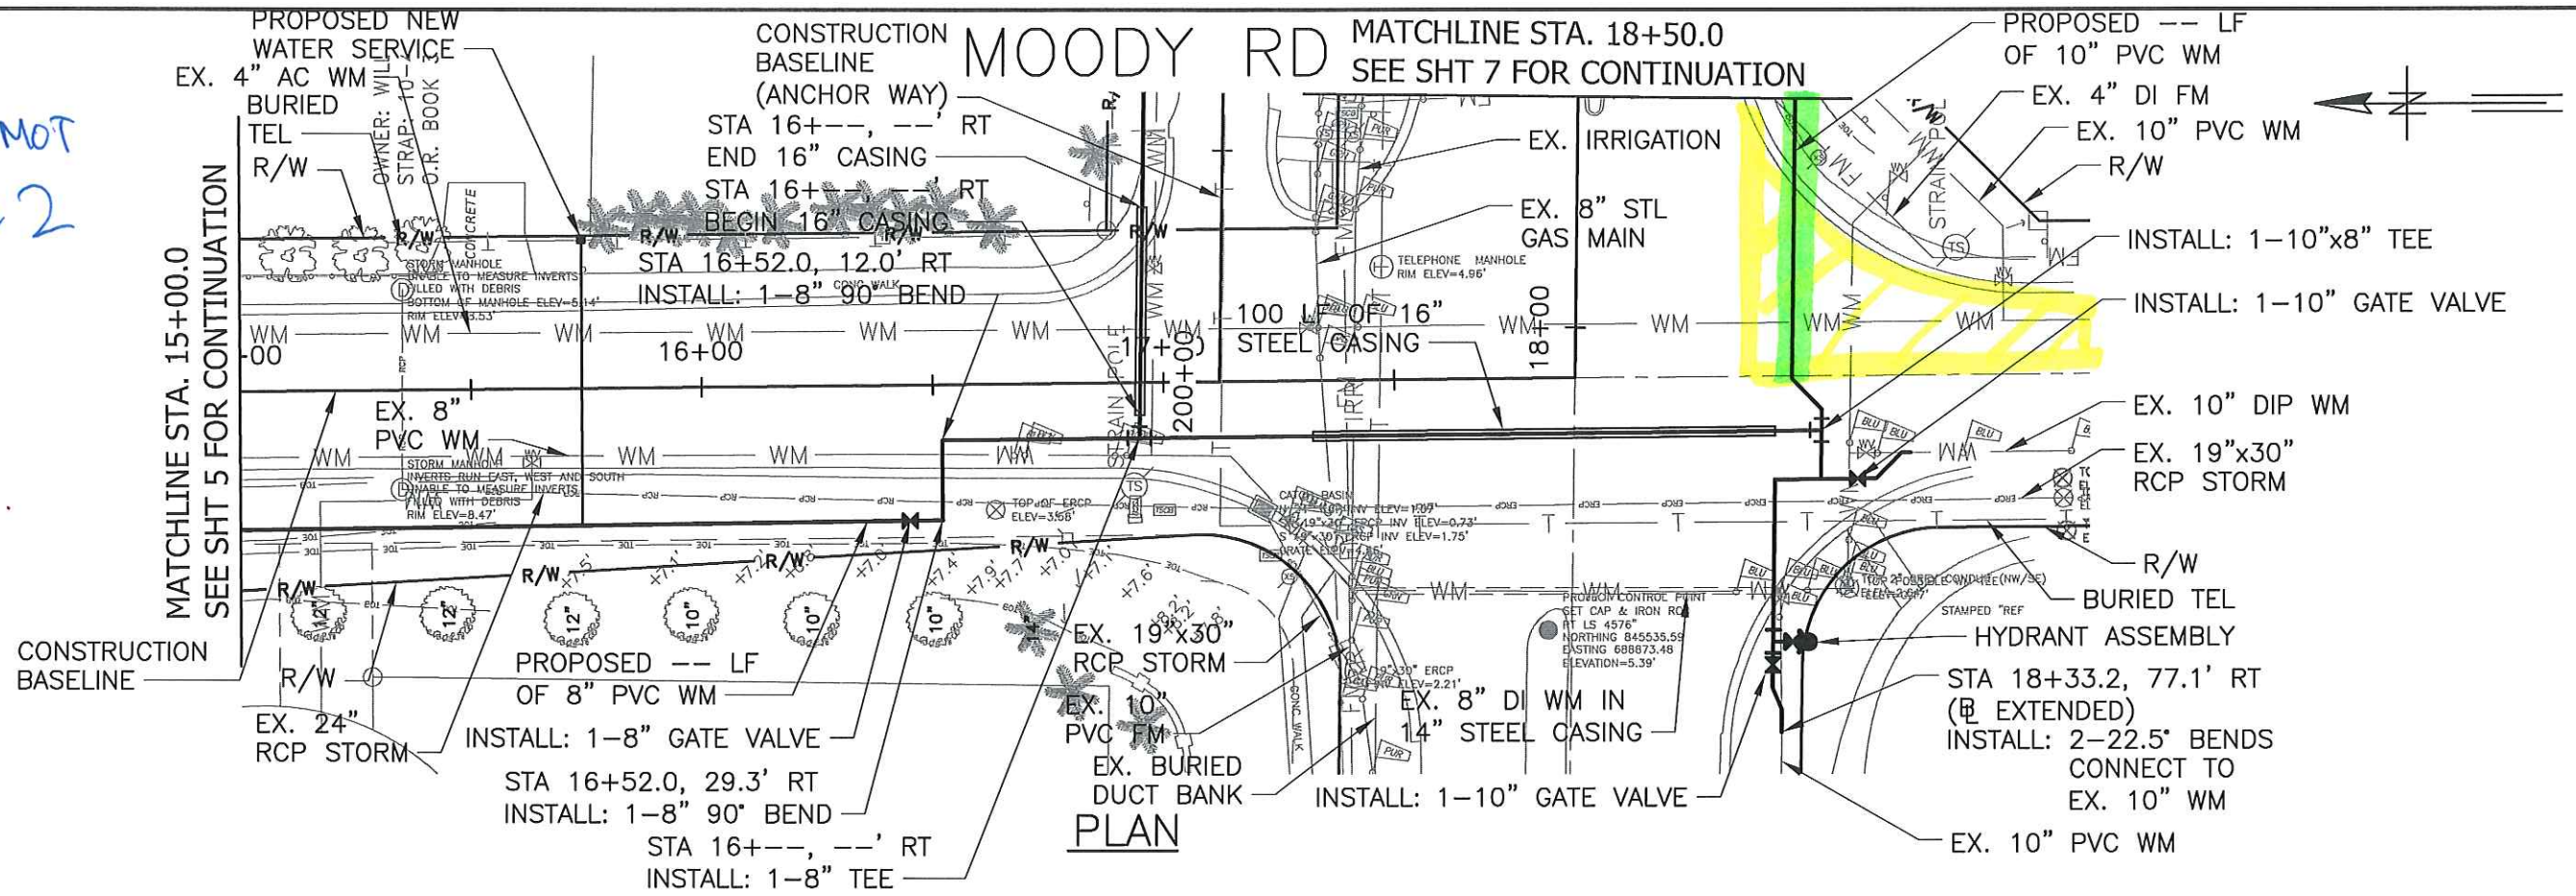

OPTION TO HAVE MOODY RD SOUTH OF HANCOCK BRIDGE RD
CLOSED IN BOTH DIRECTIONS - FASTER AND LESS EXPENSIVE

ROAD CLOSURE

TRENCHLESS INSTALLATION

OPEN-CUT INSTALLATION

PROFILE

SCALE: 1" = 40' HORIZ.
1" = 8' VERT.



5260 SUMMERLIN COMMONS WAY,
SUITE 302
FORT MYERS, FLORIDA 33907
CERTIFICATE OF AUTHORIZATION NO. 37



DESIGNED EJ, MSK
DRAWN JMW
CHECKED MSK


NO.	DATE	APPD	REVISION

P.E. NAME: MICHAEL S. KNOWLES P.E. NO. 67489
P.E. NAME: _____
DATE: _____

HANCOCK BRIDGE PKWY
WATER MAIN IMPROVEMENTS
CONTRACT NO. 7121
WATER MAIN - PLAN AND PROFILE
MOODY RD
STA 15+00.0 TO STA 18+50.0

W.O. NO. -
FILE: 0520A-P01
NO. 6 OF
DATE FEBRUARY 2018

POTENTIAL MOT
Phase 3
After Partial/Full
Clearance (FOEP)

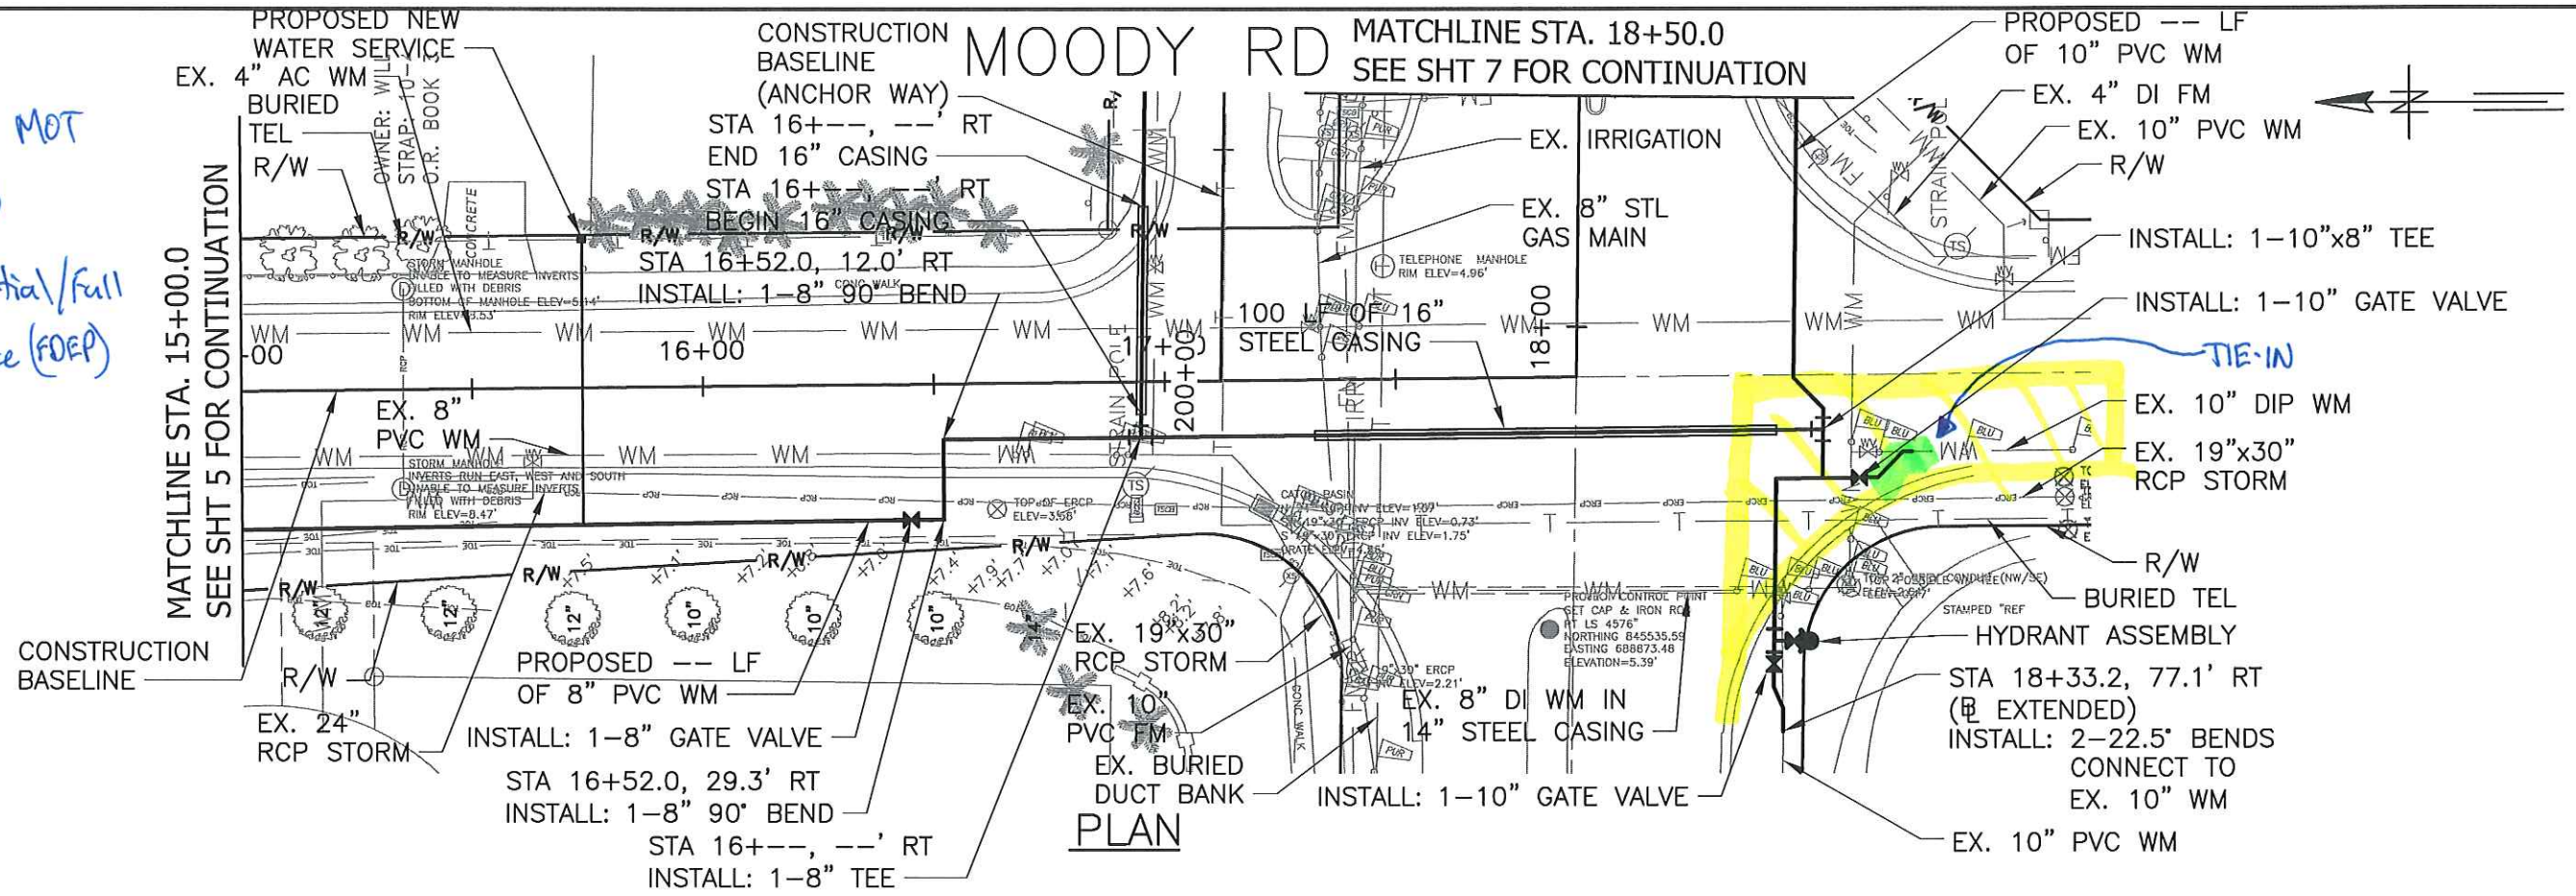

PLAN

PROFILE

SCALE: 1" = 40' HORIZ.
1" = 8' VERT.

ROAD CLOSURE

OPEN-CUT INSTALLATION

GREELEY AND HANSEN
5260 SUMMERLIN COMMONS WAY,
SUITE 302
FORT MYERS, FLORIDA 33907
CERTIFICATE OF AUTHORIZATION NO. 37

0	40 FT	1" = 40' HORIZ.
0	8 FT	1" = 8' VERT.
DESIGNED	EJM, MSK	
DRAWN	JMW	
CHECKED	MSK	

NO.	DATE	APPD	REVISION
P.E. NAME: MICHAEL S. KNOWLES		P.E. NO. 67489	
P.E. NAME:			
DATE:			

HANCOCK BRIDGE PKWY
WATER MAIN IMPROVEMENTS
CONTRACT NO. 7121
WATER MAIN - PLAN AND PROFILE
MOODY RD
STA 15+00.0 TO STA 18+50.0

W.O. NO.	-
FILE:	0520A-P01
NO. 6	OF
DATE	FEBRUARY 2018