

CONTRACT PLANS COMPONENTS

ROADWAY PLANS
SIGNING AND PAVEMENT MARKING PLANS
LIGHTING PLANS



LEE COUNTY
DEPARTMENT OF TRANSPORTATION

CONTRACT PLANS

INDEX OF ROADWAY PLANS

SHEET NO.	SHEET DESCRIPTION
1	KEY SHEET
2	SIGNATURE SHEET
3	SUMMARY OF PAY ITEMS
4-8	TYPICAL SECTIONS
9	TYPICAL SECTION DETAILS
10	SUMMARY OF DRAINAGE STRUCTURES
11	PROJECT LAYOUT
12	PROJECT CONTROL
13	PROJECT NOTES
14-17	PLAN SHEETS
18-21	PROFILE SHEETS
22	INTERSECTION DETAILS
23-26	INTERSECTION GRADING DETAILS
27-28	DRAINAGE STRUCTURES
29	ROADWAY SOIL SURVEY
30-46	CROSS SECTIONS
47	DRIVEWAY HALF SECTIONS
48-51	EROSION CONTROL
52-55	TEMPORARY TRAFFIC CONTROL
56-59	UTILITY ADJUSTMENTS
60	TREE PROTECTION DETAILS
SQ-1 - SQ-9	SUMMARY OF QUANTITIES

GATEWAY BOULEVARD AT GRIFFIN DRIVE
INTERSECTION CONTROL (ROUNDAABOUT)
LEE COUNTY PROJECT NO. 200672

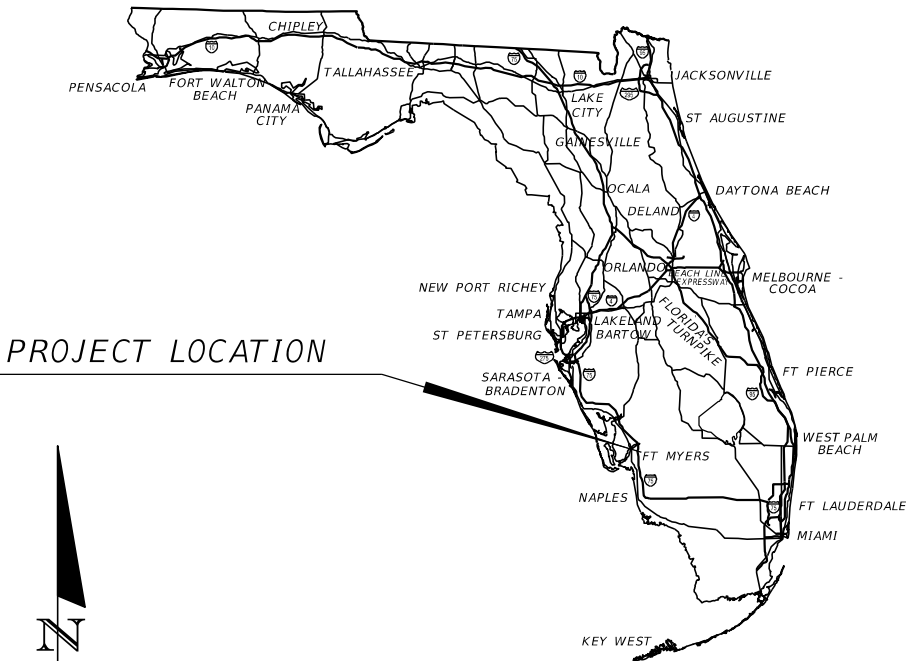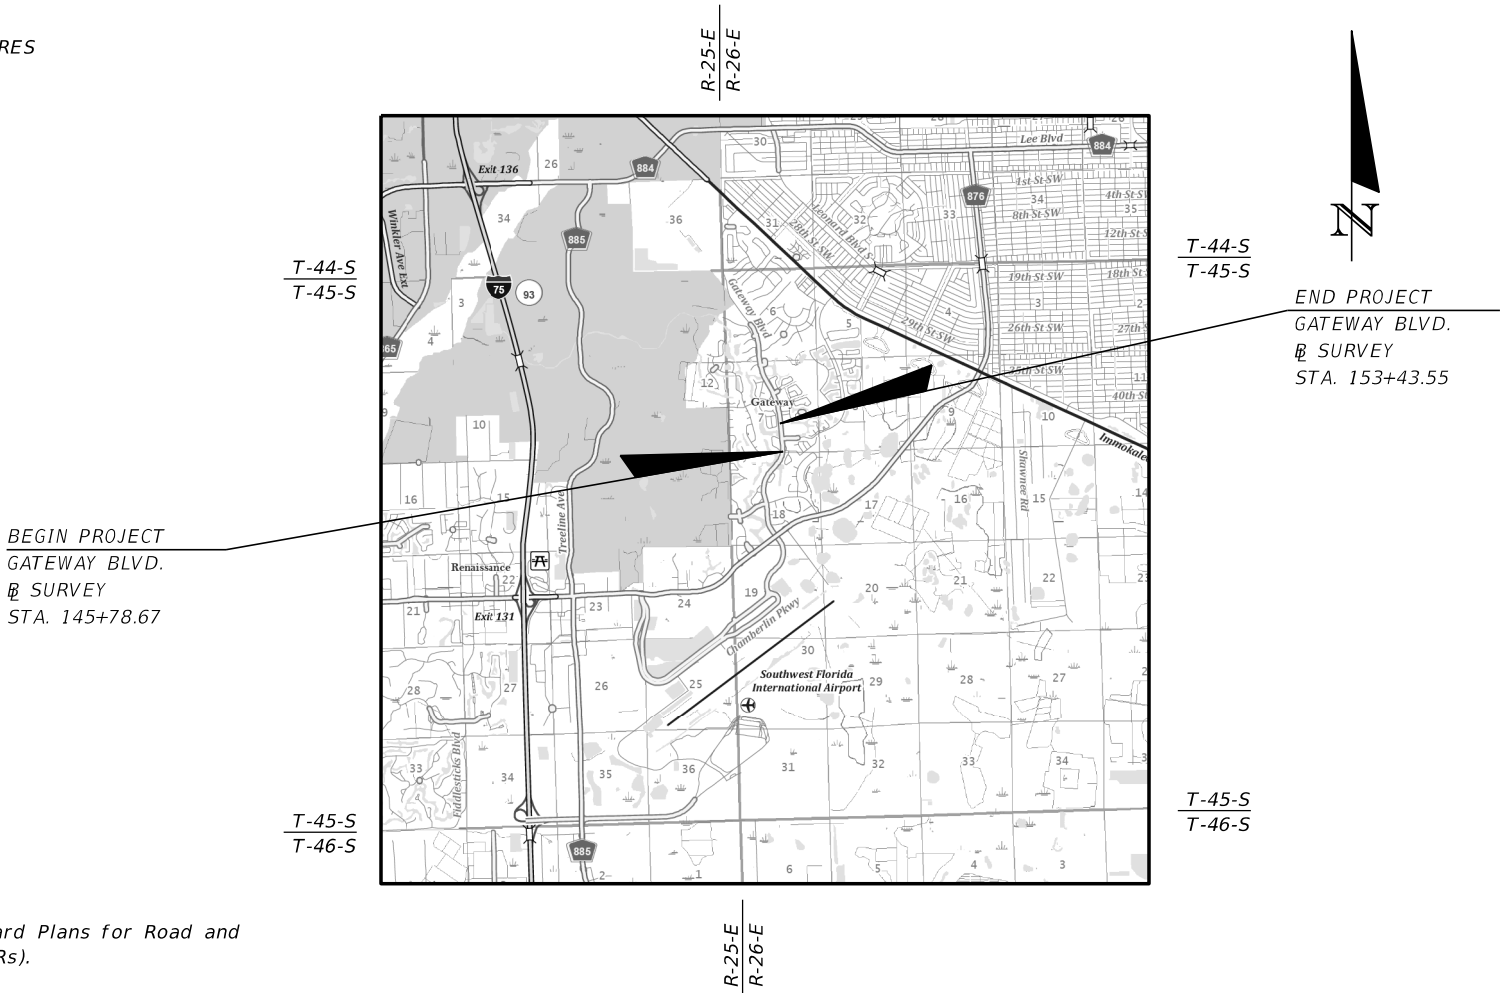

PROJECT LOCATION

60% PLANS
MARCH 2019
(NOT FOR CONSTRUCTION)

GOVERNING STANDARD PLANS:

Florida Department of Transportation, FY2020-21 Standard Plans for Road and Bridge Construction and applicable Interim Revisions (IRs).

Standard Plans for Road Construction and associated IRs are available at the following website: <http://www.fdot.gov/design/standardplans>

APPLICABLE IRs: N/A

GOVERNING STANDARD SPECIFICATIONS:

Lee County Department of Transportation Specifications, and Florida Department of Transportation, JULY2020 Standard Specifications for Road and Bridge Construction at the following website: <http://www.fdot.gov/programmanagement/Implemented/SpecBooks>


ROADWAY PLANS
ENGINEER OF RECORD:

JASON Y. YAM, P.E.
P.E. NO.: 62449
CARDNO, INC.
380 PARK PLACE BOULEVARD, SUITE 300
CLEARWATER, FL 33759
(727) 531-3505
CERTIFICATE OF AUTHORIZATION NO.: 29915

COUNTY PROJECT MANAGER:

Alejandro J. Slaibe, P.E.


CIP NO.	FISCAL YEAR	SHEET NO.
200672	20	1

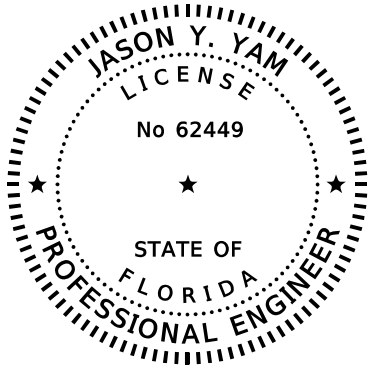

THIS DOCUMENT HAS BEEN DIGITALLY
SIGNED AND SEALED BY:

PRINTED COPIES OF THIS DOCUMENT ARE
NOT CONSIDERED SIGNED AND SEALED.
THE SIGNATURE SHOULD BE VERIFIED
ON THE ELECTRONIC DOCUMENTS,


CARDNO
380 PARK PLACE BOULEVARD, SUITE 300
CLEARWATER, FL 33759
PHONE NUMBER: (727) 531-3505
CERTIFICATE OF AUTHORIZATION NO. 29915
JASON Y. YAM, P.E. 62449

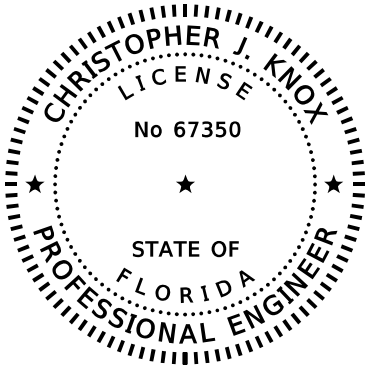

THIS DOCUMENT HAS BEEN DIGITALLY
SIGNED AND SEALED BY:

PRINTED COPIES OF THIS DOCUMENT ARE
NOT CONSIDERED SIGNED AND SEALED.
THE SIGNATURE SHOULD BE VERIFIED
ON THE ELECTRONIC DOCUMENTS,

CARDNO
380 PARK PLACE BOULEVARD, SUITE 300
CLEARWATER, FL 33759
PHONE NUMBER: (727) 531-3505
CERTIFICATE OF AUTHORIZATION NO. 29915
CHRISTOPHER J. KNOX, P.E. 67350

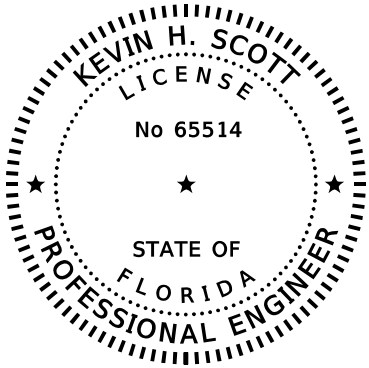

THIS DOCUMENT HAS BEEN DIGITALLY
SIGNED AND SEALED BY:

PRINTED COPIES OF THIS DOCUMENT ARE
NOT CONSIDERED SIGNED AND SEALED.
THE SIGNATURE SHOULD BE VERIFIED
ON THE ELECTRONIC DOCUMENTS,

TIERRA
7351 TEMPLE TERRACE HIGHWAY
TAMPA, FL 33637
PHONE NUMBER: (727) 531-3505
CERTIFICATE OF AUTHORIZATION NO. 6486
KEVIN H. SCOTT, P.E. 65514

THE ABOVE NAMED PROFESSIONAL ENGINEER SHALL BE RESPONSIBLE FOR THE
FOLLOWING SHEETS IN ACCORDANCE WITH RULE 61G15-23.004, F.A.C.

SHEET NO. SHEET DESCRIPTION

1	KEY SHEET
2	SIGNATURE SHEET
3	SUMMARY OF PAY ITEMS
4-8	TYPICAL SECTIONS
9	TYPICAL SECTION DETAILS
11	PROJECT LAYOUT
12	PROJECT CONTROL
13	PROJECT NOTES
14-17	PLAN SHEETS
18-21	PROFILE SHEETS
22	INTERSECTION DETAILS
23-26	INTERSECTION GRADING DETAILS
30-46	CROSS SECTIONS
47	DRIVEWAY HALF SECTIONS
52-55	TEMPORARY TRAFFIC CONTROL
56-59	UTILITY ADJUSTMENTS
60	TREE PROTECTION DETAILS
SQ-1 - SQ-9	SUMMARY OF QUANTITIES

THE ABOVE NAMED PROFESSIONAL ENGINEER SHALL BE RESPONSIBLE FOR THE
FOLLOWING SHEETS IN ACCORDANCE WITH RULE 61G15-23.004, F.A.C.

SHEET NO. SHEET DESCRIPTION


2	SIGNATURE SHEET
10	SUMMARY OF DRAINAGE STRUCTURES
27-28	DRAINAGE STRUCTURES
48-51	EROSION CONTROL

THE ABOVE NAMED PROFESSIONAL ENGINEER SHALL BE RESPONSIBLE FOR THE
FOLLOWING SHEETS IN ACCORDANCE WITH RULE 61G15-23.004, F.A.C.

SHEET NO. SHEET DESCRIPTION

2	SIGNATURE SHEET
29	ROADWAY SOIL SURVEY

REVISIONS					GATEWAY BOULEVARD AT GRIFFIN DRIVE INTERSECTION CONTROL (ROUNDABOUT)		COUNTY PROJECT NO.	SHT. NO.
DATE	DESCRIPTION	DATE	DESCRIPTION		SIGNATURE SHEET		200672	2
			JASON Y. YAM, P.E. P.E. LICENSE NUMBER 62449 CARDNO, INC. 380 PARK PLACE BOULEVARD, SUITE 300 CLEARWATER, FLORIDA 33759 CERTIFICATE OF AUTHORIZATION 29915					

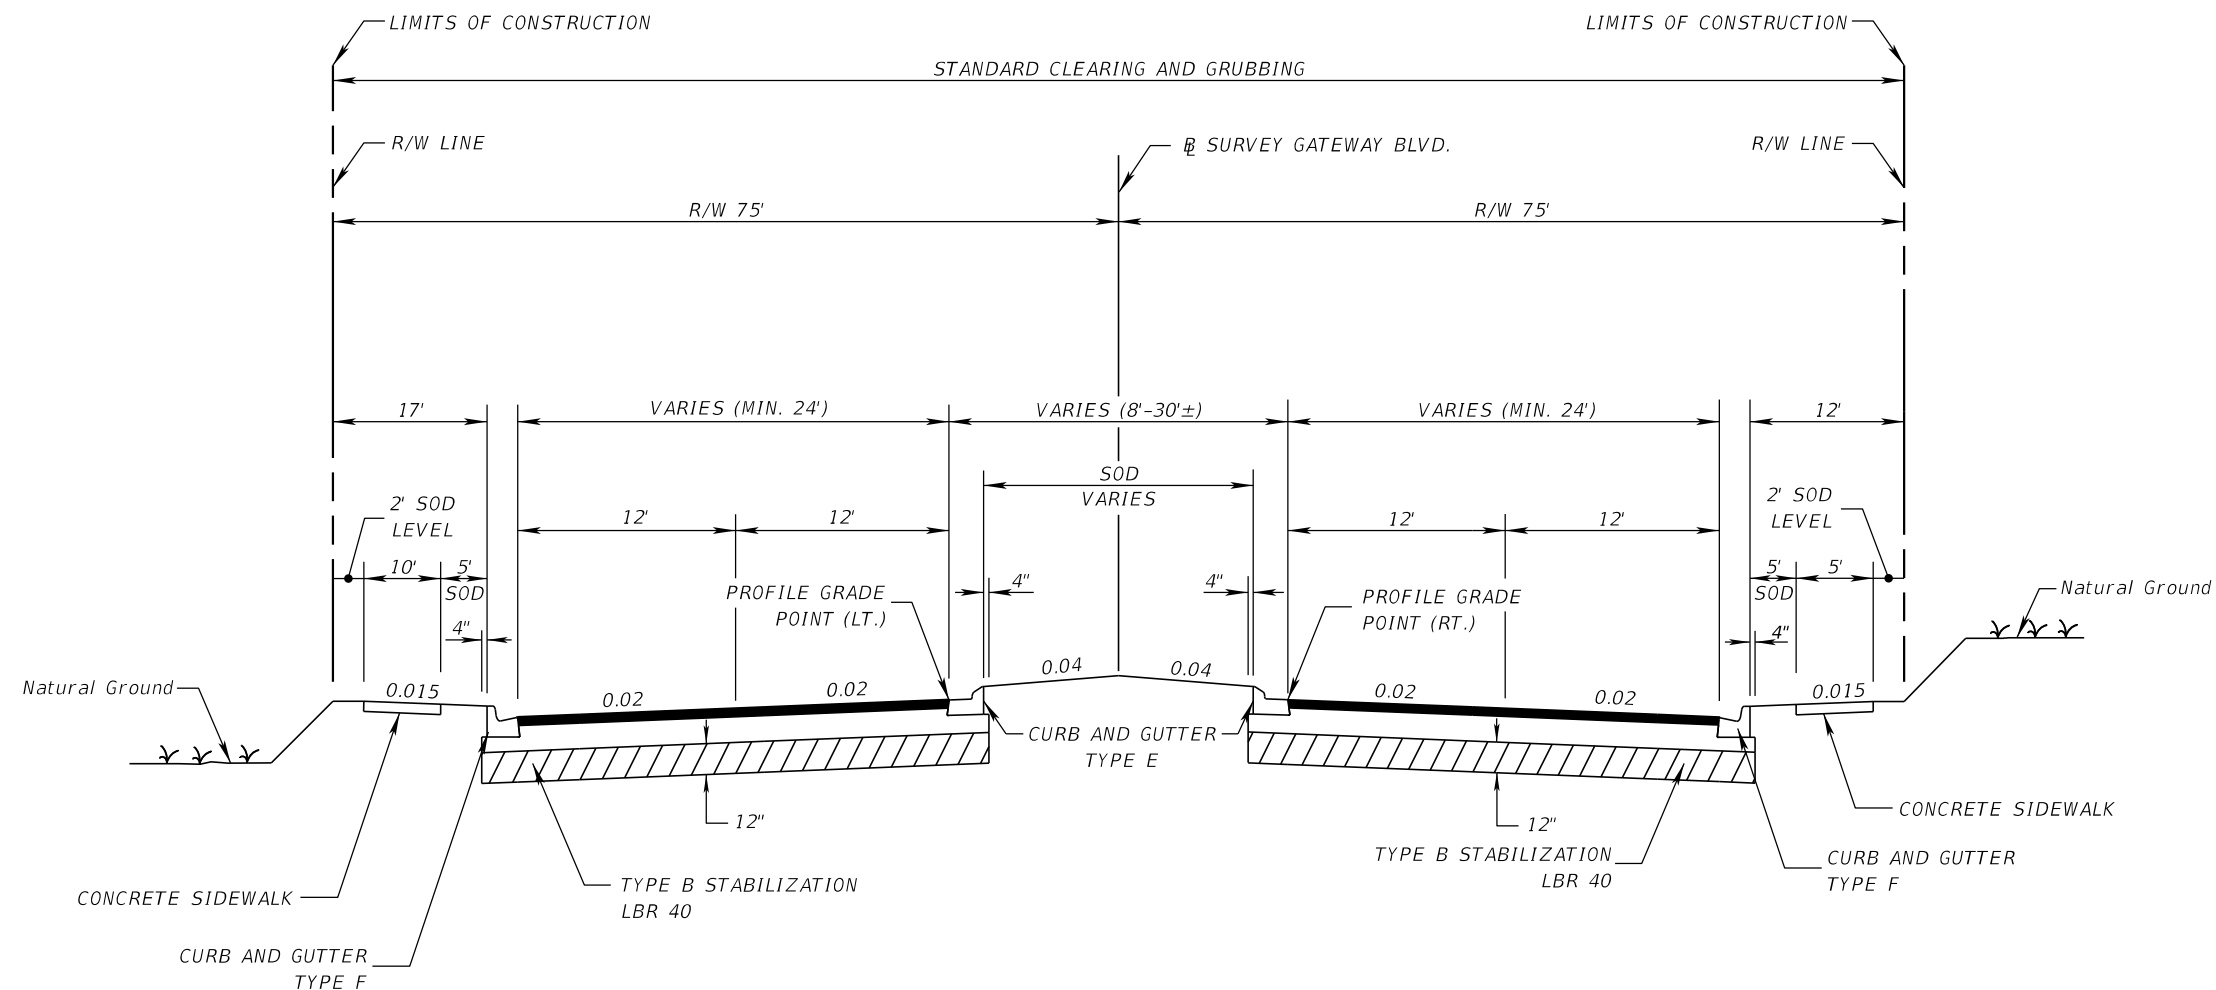

TYPICAL SECTION (1)

GATEWAY BLVD.

STA. 145+78.67 TO STA. 148+69.12 (RT.)
 STA. 146+74.57 TO STA. 148+70.09 (LT.)
 STA. 149+96.13 TO STA. 153+24.05 (RT.)
 STA. 149+97.20 TO STA. 153+43.55 (LT.)


TRAFFIC DATA

CURRENT YEAR = 2019 AADT = 23,100
 ESTIMATED OPENING YEAR = 2020 AADT = 19,000
 ESTIMATED DESIGN YEAR = 2040 AADT = 25,136
 DESIGN HOUR T = 3.4%
 DESIGN SPEED = 35 MPH

NEW CONSTRUCTION

OPTIONAL BASE GROUP 9 (TYPE B-12.5 ONLY) WITH
 TYPE SP STRUCTURAL COURSE (TRAFFIC C) (2.5")
 AND FRICTION COURSE FC-9.5 (TRAFFIC C) (1") (PG 76-22)

REVISIONS				JASON Y. YAM, P.E. P.E. LICENSE NUMBER 62449 CARDNO, INC. 380 PARK PLACE BOULEVARD, SUITE 300 CLEARWATER, FLORIDA 33759 CERTIFICATE OF AUTHORIZATION 29915		GATEWAY BOULEVARD AT GRIFFIN DRIVE INTERSECTION CONTROL (ROUNDBOUT)	COUNTY PROJECT NO.	SHT. NO.
DATE	DESCRIPTION	DATE	DESCRIPTION			TYPICAL SECTION (1)	200672	4

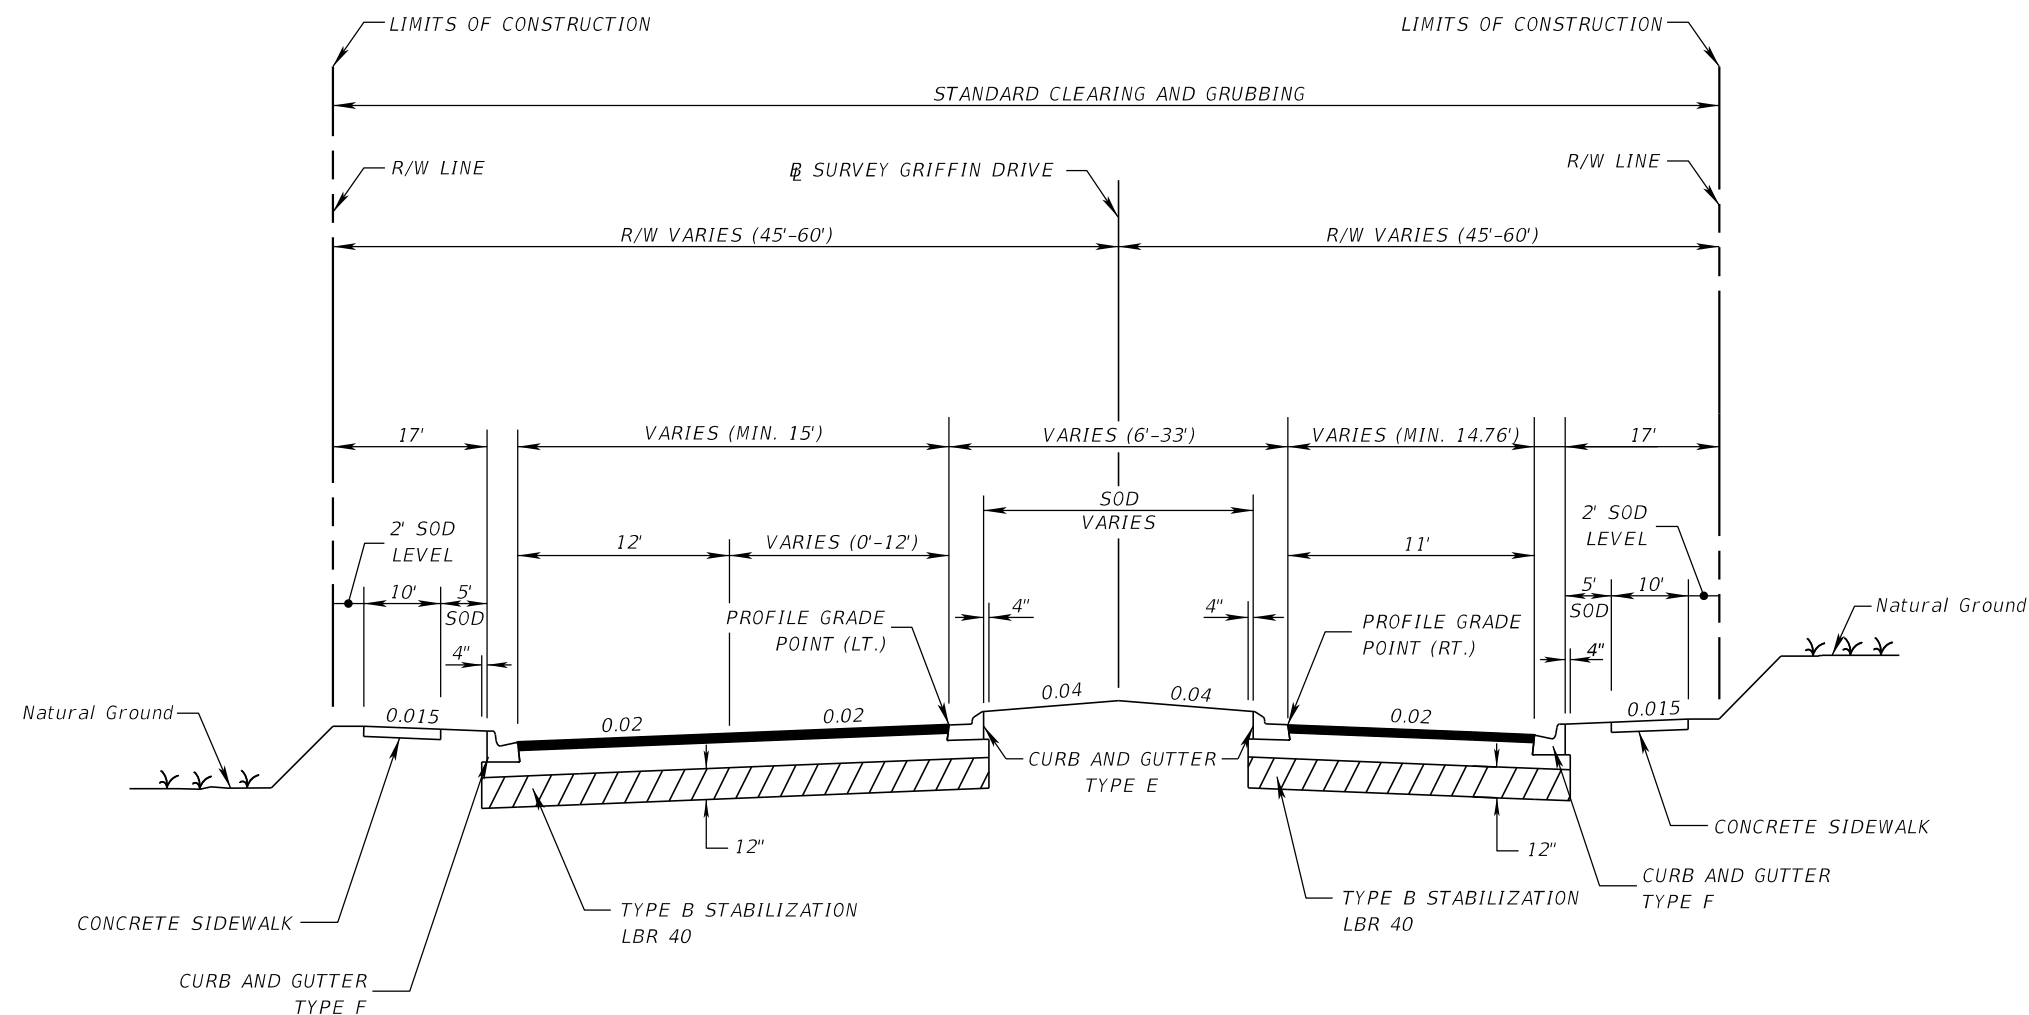

TYPICAL SECTION (2)

GRIFFIN DRIVE

STA. 317+88.90 TO STA. 322+86.05 (LT.)

STA. 317+88.94 TO STA. 321+35.18 (RT.)

NEW CONSTRUCTION

OPTIONAL BASE GROUP 9 (TYPE B-12.5 ONLY) WITH
TYPE SP STRUCTURAL COURSE (TRAFFIC C) (2.5")
AND FRICTION COURSE FC-9.5 (TRAFFIC C) (1") (PG 76-22)

STA. 317+94.29 TO STA. 328+87.98 (LT.)

MILLING AND RESURFACING

MILL (1")
OVERBUILD (SEE TABLE)*
AND FRICTION COURSE FC-9.5 (TRAFFIC C) (1") (PG 76-22)


STA. 314+42.65 TO STA. 315+55.02 (LT.)

WIDENING

OPTIONAL BASE GROUP 9 (TYPE B-12.5 ONLY) WITH
TYPE SP STRUCTURAL COURSE (TRAFFIC C) (2.5")
AND FRICTION COURSE FC-9.5 (TRAFFIC C) (1") (PG 76-22)

DESIGN SPEED = 35 MPH * SEE TYPICAL SECTION DETAIL SHEET

REVISIONS				JASON Y. YAM, P.E. P.E. LICENSE NUMBER 62449 CARDNO, INC. 380 PARK PLACE BOULEVARD, SUITE 300 CLEARWATER, FLORIDA 33759 CERTIFICATE OF AUTHORIZATION 29915		GATEWAY BOULEVARD AT GRIFFIN DRIVE INTERSECTION CONTROL (ROUNDBABOUT)	COUNTY PROJECT NO.	SHT. NO.
DATE	DESCRIPTION	DATE	DESCRIPTION			TYPICAL SECTION (2)	200672	5

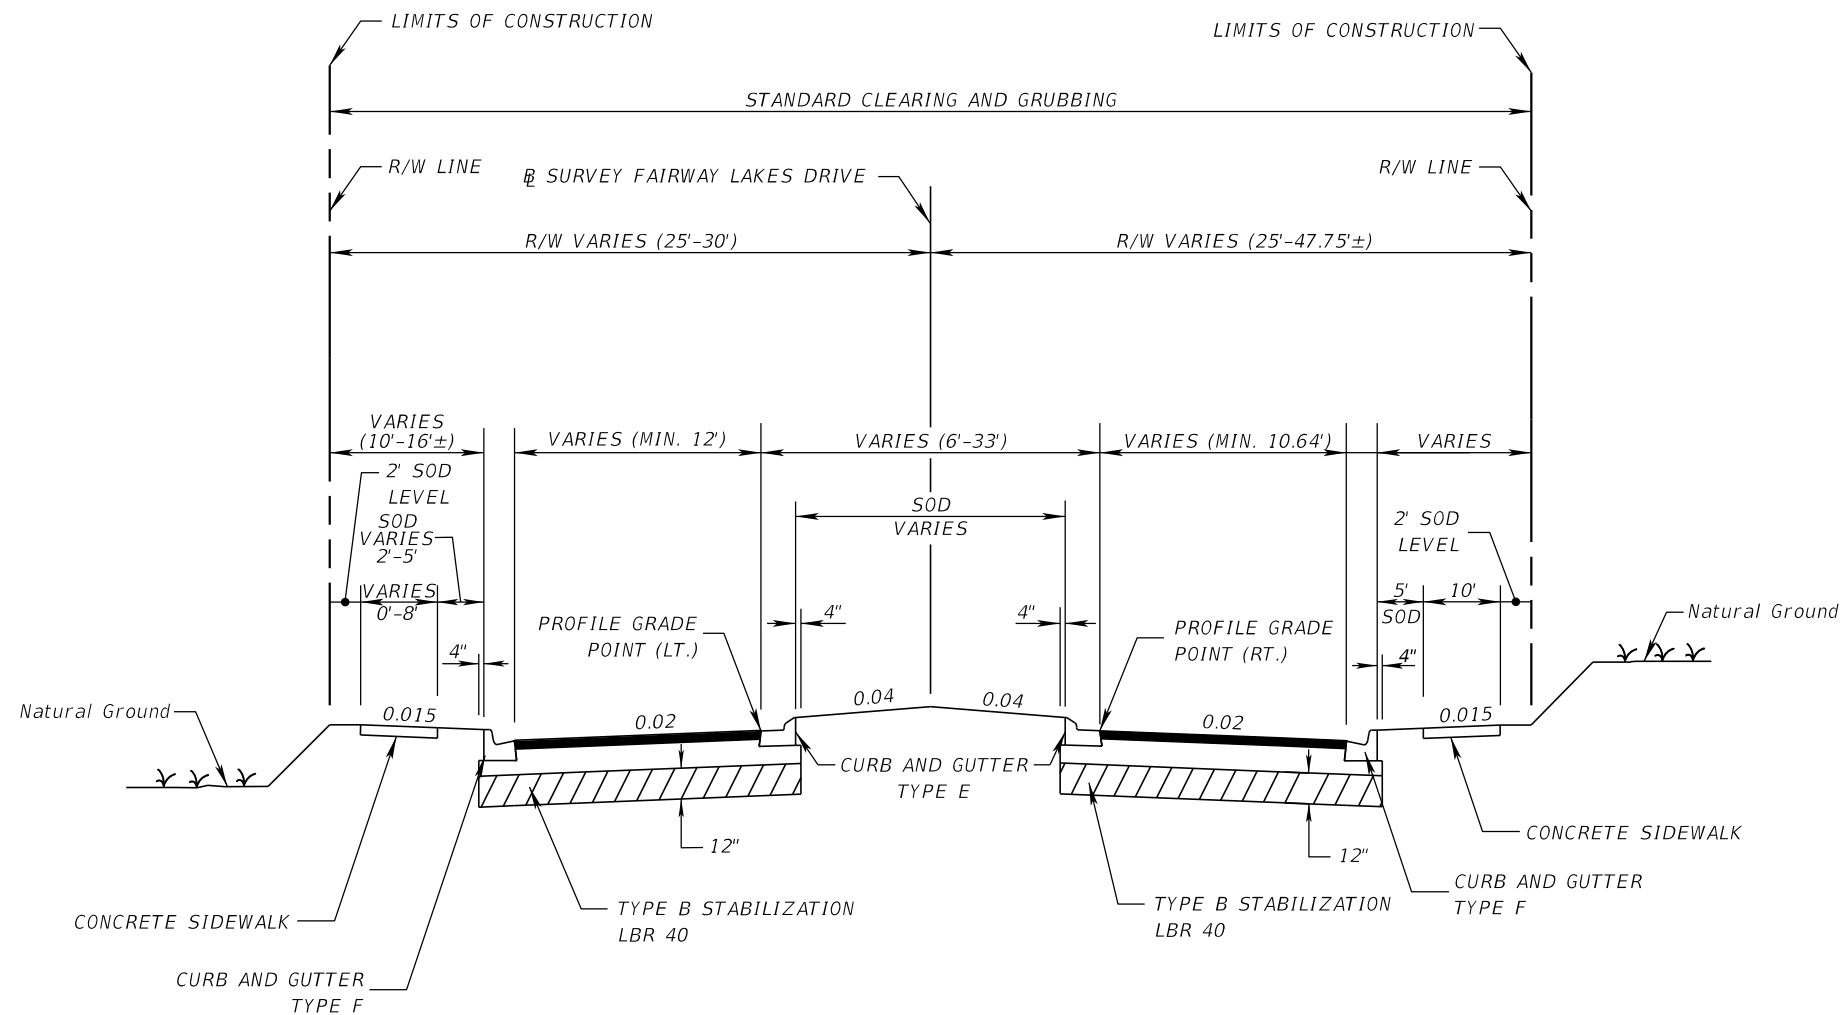

TYPICAL SECTION (3)
FAIRWAY LAKES DRIVE

STA. 314+42.89 TO STA. 315+80.00 (LT.)
STA. 314+42.89 TO STA. 315+08.66 (RT.)
MILLING AND RESURFACING

MILL (1")
OVERBUILD (SEE TABLE)*
AND FRICTION COURSE FC-9.5 (TRAFFIC C) (1") (PG 76-22)

STA. 315+80.00 TO STA. 316+35.09 (LT.)
STA. 315+08.66 TO STA. 316+36.79 (RT.)
NEW CONSTRUCTION


OPTIONAL BASE GROUP 9 (TYPE B-12.5 ONLY) WITH
TYPE SP STRUCTURAL COURSE (TRAFFIC C) (2.5")
AND FRICTION COURSE FC-9.5 (TRAFFIC C) (1") (PG 76-22)

STA. 314+42.89 TO STA. 315+63+15 (LT.)
STA. 314+58.93 TO STA. 315+06.92 (RT.)
WIDENING

OPTIONAL BASE GROUP 9 (TYPE B-12.5 ONLY) WITH
TYPE SP STRUCTURAL COURSE (TRAFFIC C) (2.5")
AND FRICTION COURSE FC-9.5 (TRAFFIC C) (1") (PG 76-22)

DESIGN SPEED = 25 MPH * SEE TYPICAL SECTION DETAIL SHEET

REVISIONS				JASON Y. YAM, P.E. P.E. LICENSE NUMBER 62449 CARDNO, INC. 380 PARK PLACE BOULEVARD, SUITE 300 CLEARWATER, FLORIDA 33759 CERTIFICATE OF AUTHORIZATION 29915	 DEPARTMENT OF TRANSPORTATION	GATEWAY BOULEVARD AT GRIFFIN DRIVE INTERSECTION CONTROL (ROUNDBOUT)	COUNTY PROJECT NO.	SHT. NO.
DATE	DESCRIPTION	DATE	DESCRIPTION			TYPICAL SECTION (3)	200672	6

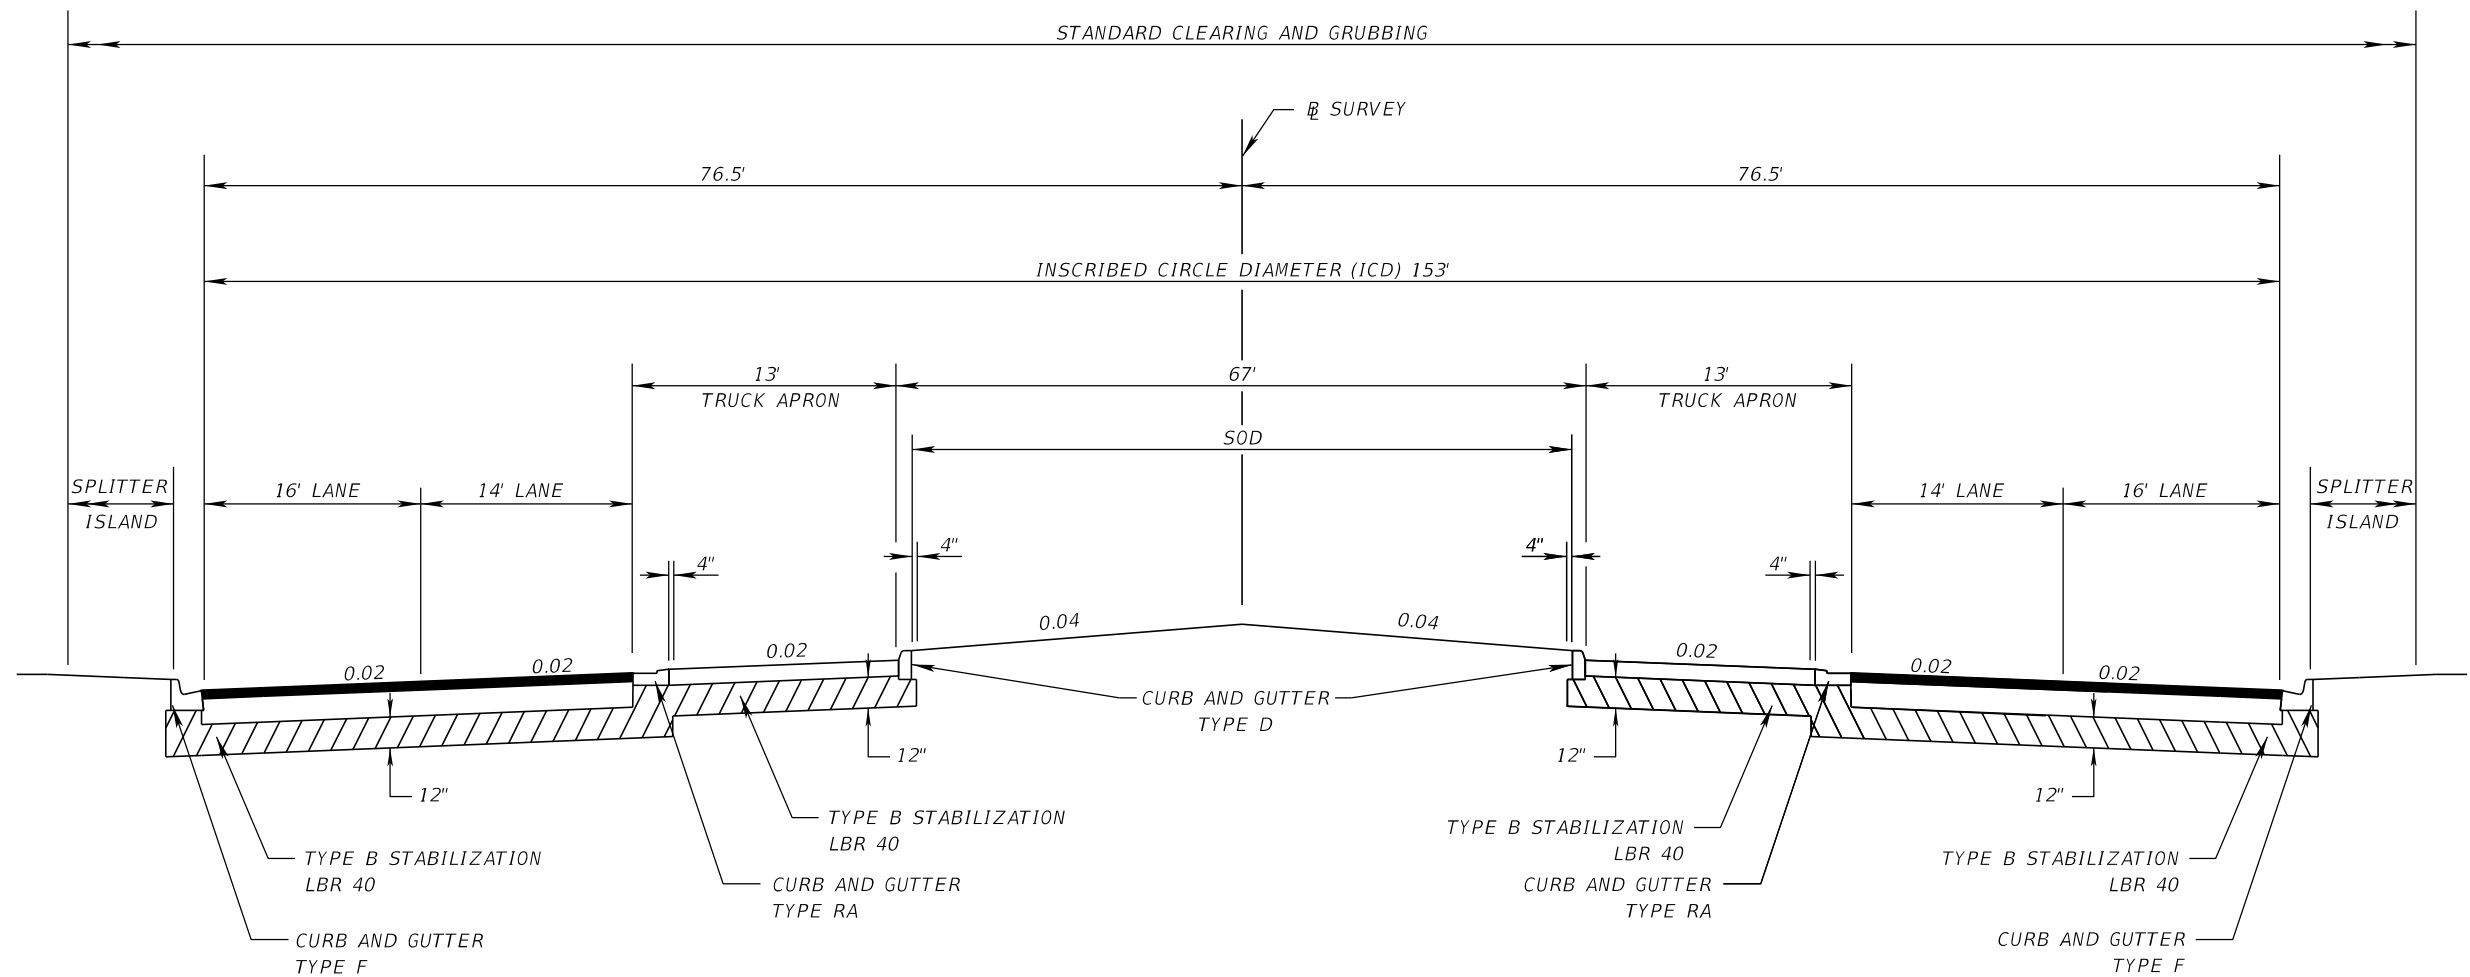

TYPICAL SECTION (4)
GATEWAY BLVD. ROUNDABOUT
STA. 148+70.09 TO 149+97.20

NEW CONSTRUCTION

OPTIONAL BASE GROUP 9 (B-12.5 ONLY) WITH
TYPE SP STRUCTURAL COURSE (TRAFFIC C) (2.5")
AND FRICTION COURSE FC-9.5 (TRAFFIC C) (1") (PG 76-22)

TRUCK APRON


CONCRETE PAVEMENT (12")
(AMS-STD-595-21105 RED)

TRAFFIC DATA

CURRENT YEAR = 2019 AADT = 23,100
ESTIMATED OPENING YEAR = 2020 AADT = 19,000
ESTIMATED DESIGN YEAR = 2040 AADT = 25,136
DESIGN HOUR T = 3.4%
DESIGN SPEED = 35 MPH

REVISIONS				JASON Y. YAM, P.E. P.E. LICENSE NUMBER 62449 CARDNO, INC. 380 PARK PLACE BOULEVARD, SUITE 300 CLEARWATER, FLORIDA 33759 CERTIFICATE OF AUTHORIZATION 29915		GATEWAY BOULEVARD AT GRIFFIN DRIVE INTERSECTION CONTROL (ROUNDABOUT)	COUNTY PROJECT NO.	SHT. NO.
DATE	DESCRIPTION	DATE	DESCRIPTION			TYPICAL SECTION (4)	200672	7

THE OFFICIAL RECORD OF THIS SHEET IS THE ELECTRONIC FILE DIGITALLY SIGNED AND SEALED UNDER RULE 61G15-23.004, F.A.C.

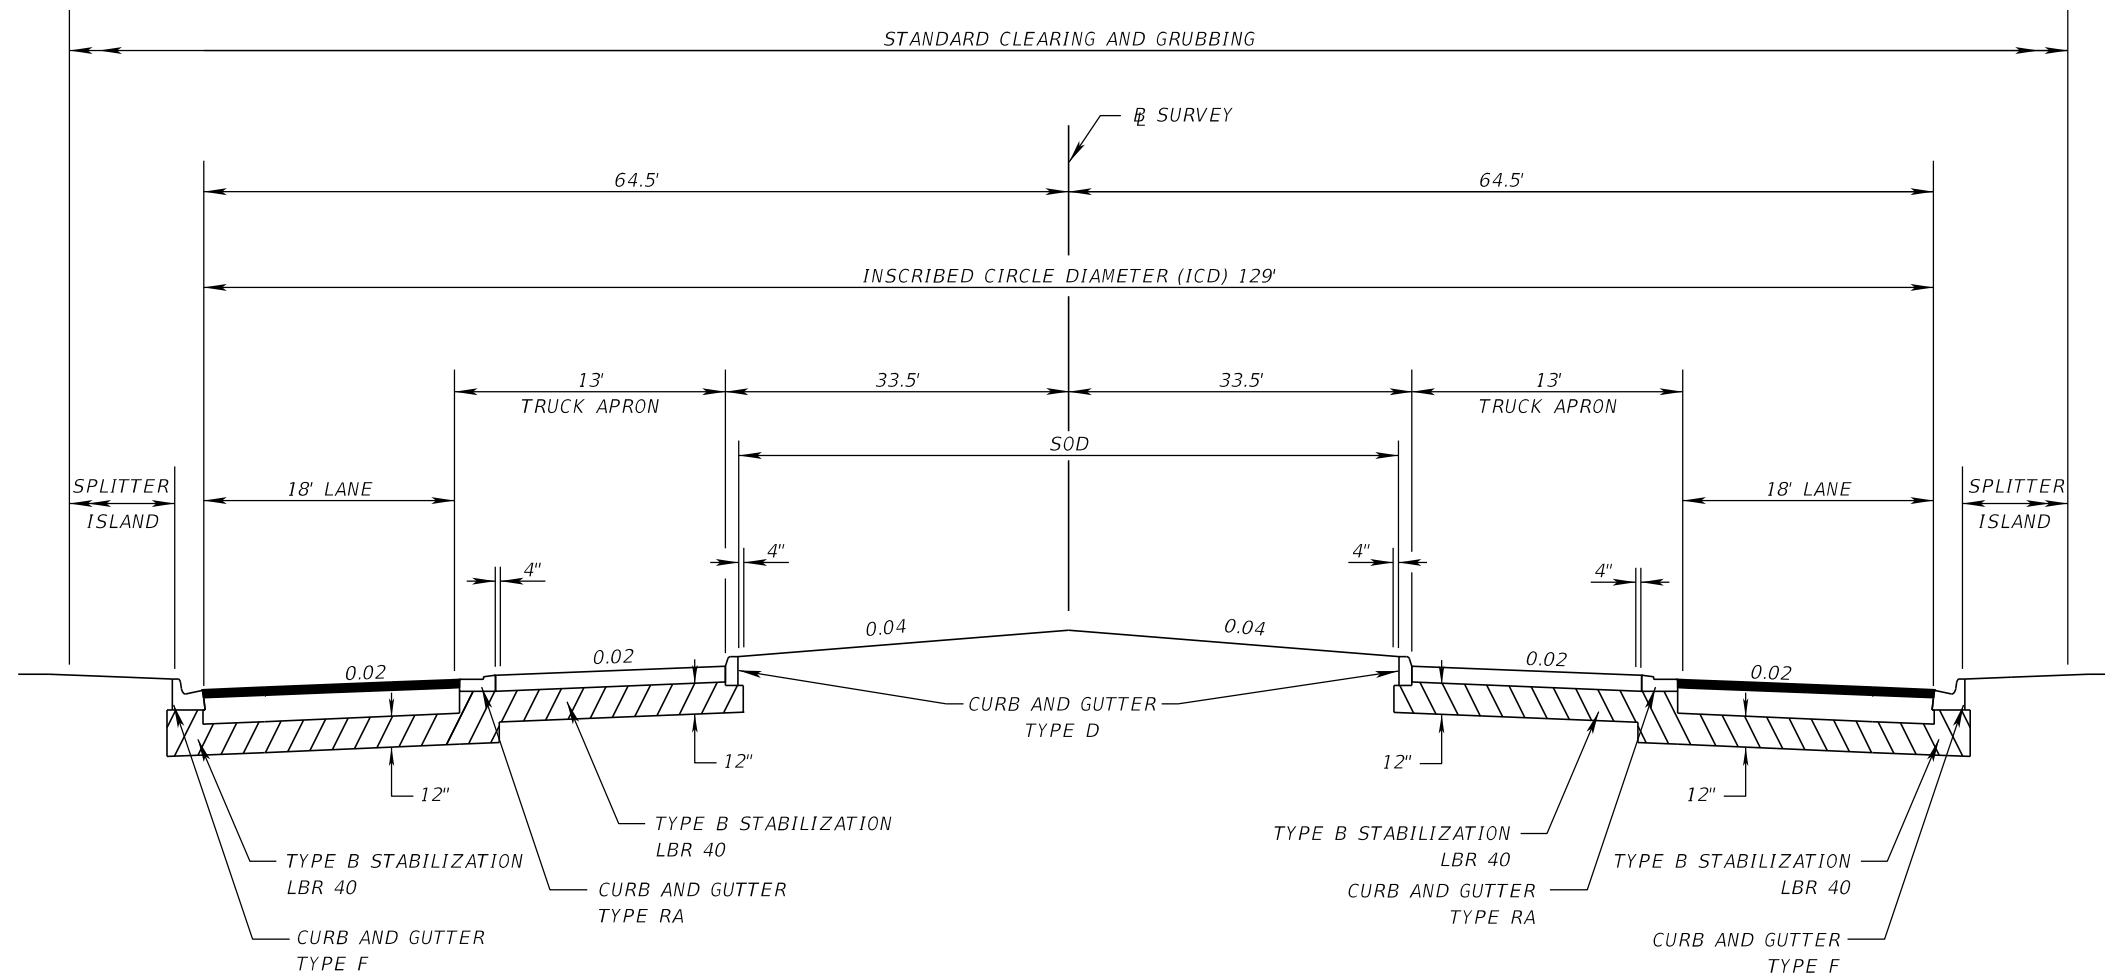

TYPICAL SECTION (5)
GRIFFIN DR. AND FAIRWAY LAKES DR. ROUNDABOUT
STA. 316+36.79 TO 317+88.94

NEW CONSTRUCTION

OPTIONAL BASE GROUP 9 (B-12.5 ONLY) WITH
 TYPE SP STRUCTURAL COURSE (TRAFFIC C) (2.5")
 AND FRICTION COURSE FC-9.5 (TRAFFIC C) (1") (PG 76-22)

TRUCK APRON


CONCRETE PAVEMENT (12")
 (AMS-STD-595-21105 RED)

REVISIONS				JASON Y. YAM, P.E. P.E. LICENSE NUMBER 62449 CARDNO, INC. 380 PARK PLACE BOULEVARD, SUITE 300 CLEARWATER, FLORIDA 33759 CERTIFICATE OF AUTHORIZATION 29915		GATEWAY BOULEVARD AT GRIFFIN DRIVE INTERSECTION CONTROL (ROUNDABOUT)	COUNTY PROJECT NO.	SHT. NO.
DATE	DESCRIPTION	DATE	DESCRIPTION			TYPICAL SECTION (5)	200672	8

SUMMARY OF ASPHALT OVERBUILD FAIRWAY LAKES DR						
LOCATION		EXIST CROSS SLOPE	PROPOSED SLOPE	MAX DEPTH OF OVERBUILD (IN)	WIDTH OF OVERBUILD (FT)	END AREA OF OVERBUILD (SY)
STATION	LANE					
314+42	WB	0.007	0.020	0.00	0	0
314+50	WB	0.011	0.020	0.00	0	0
315+00	WB	0.011	0.020	0.00	0	0
315+50	WB	0.008	0.020	0.28	12	2
315+80.00	WB	0.006	0.020	0.00	0	0

SUMMARY OF ASPHALT OVERBUILD GRIFFIN DR						
LOCATION		EXIST CROSS SLOPE	PROPOSED SLOPE	MAX DEPTH OF OVERBUILD (IN)	WIDTH OF OVERBUILD (FT)	AREA OF OVERBUILD (SY)
STATION	LANE					
317+90	WB	0.011	0.020	0.00		0
318+00	WB	0.005	0.020	0.53	12.3	6
318+50	WB	0.012	0.020	0.54	9.4	5
319+00	WB	0.012	0.020	0.73	11.5	8
319+50	WB	0.012	0.020	0.89	11	8
320+00	WB	0.012	0.020	0.94	25.4	20
320+50	WB	0.012	0.020	1.24	29	27
321+00	WB	0.012	0.020	0.90	28.4	24
321+50	WB	0.012	0.020	0.65	29.5	16
322+00	WB	0.012	0.020	0.30	29.5	9
322+50	WB	-0.007	0.020	0.05	9.2	0
322+86	WB	0.005	0.020	0.00	0	0

OVERBUILD TABLES

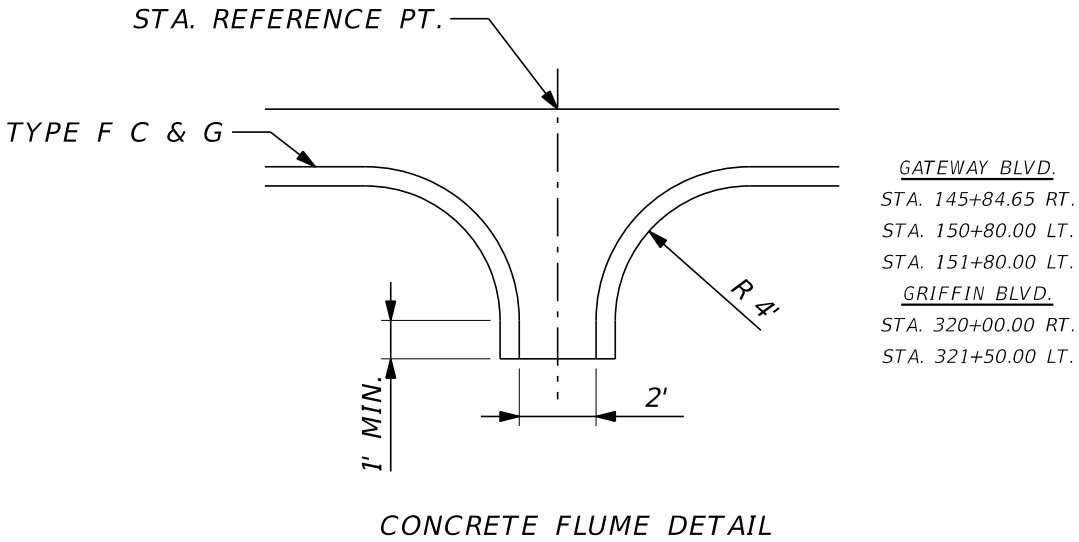

REVISIONS				JASON Y. YAM, P.E. P.E. LICENSE NUMBER 62449 CARDNO, INC. 380 PARK PLACE BOULEVARD, SUITE 300 CLEARWATER, FLORIDA 33759 CERTIFICATE OF AUTHORIZATION 29915		GATEWAY BOULEVARD AT GRIFFIN DRIVE INTERSECTION CONTROL (ROUNDABOUT)		COUNTY PROJECT NO.	SHT. NO.
DATE	DESCRIPTION	DATE	DESCRIPTION			TYPICAL SECTION DETAILS		200672	9

THE OFFICIAL RECORD OF THIS SHEET IS THE ELECTRONIC FILE DIGITALLY SIGNED AND SEALED UNDER RULE 61G15-23.004, F.A.C.

QTY.	STRUCT. NO.	STATION	SIDE	DESCRIPTION	BARRELS	STORM SEWER PIPE		CURB INLETS		DITCH BOTTOM INLETS		DITCH PAVT (SY)	REMARKS
						OTHER		P-5	P-6	C	C (J-BOT)		
						18"	24"	<10	<10	<10	<10		
GATEWAY BOULEVARD													
P	S-100	148+01	RT	CLOSED FLUME	1								
F													
P	S-101	148+00	LT	DBI & PIPE	1								
F													
P	S-102	148+54	LT	CURB INLET	1								
F													
P	S-103	150+80	LT	DBI & PIPE	1								
F													
P	S-104	151+80	LT	DBI & PIPE	1								
F													
P	S-105	154+26	LT	PIPE	1								
F													
SHEET TOTALS				PLAN QUANTITY		0	0	0	0	0	0	0	
				FINAL QUANTITY									

REVISIONS				CHRISTOPHER J. KNOX, P.E. P.E. LICENSE NUMBER 67350 CARDNO, INC. 380 PARK PLACE BOULEVARD, SUITE 300 CLEARWATER, FLORIDA 33759 CERTIFICATE OF AUTHORIZATION 29915	Lee County Southwest Florida DEPARTMENT OF TRANSPORTATION	GATEWAY BOULEVARD AT GRIFFIN DRIVE INTERSECTION CONTROL (ROUNDABOUT)		COUNTY NO.	SHT. NO.
DATE	DESCRIPTION	DATE	DESCRIPTION			SUMMARY OF DRAINAGE STRUCTURES		0671	10

THE OFFICIAL RECORD OF THIS SHEET IS THE ELECTRONIC FILE DIGITALLY SIGNED AND SEALED UNDER RULE 61G15-23.004, F.A.C.

CURVE DATA BL_GRIFFIN_18
PI STA. = 315+07.81
Δ = 34° 04' 09" (LT)
D = 35° 48' 36"
T = 49.02
L = 95.14
R = 160.00
PC STA. = 314+58.79
PT STA. = 315+53.92

CURVE DATA BL_GRIFFIN_15
PI STA. = 313+33.43
Δ = 26° 44' 07" (RT)
D = 22° 55' 06"
T = 59.41
L = 116.65
R = 250.00
PC STA. = 312+74.02
PT STA. = 313+90.68


CURVE DATA BL_GRIFFIN_12
PI STA. = 311+39.98
Δ = 103° 05' 08" (RT)
D = 57° 17' 45"
T = 125.91
L = 179.92
R = 100.00
PC STA. = 310+14.07
PT STA. = 311+93.99

CURVE DATA BL_GRIFFIN_9
PI STA. = 306+16.70
Δ = 58° 10' 45" (RT)
D = 31° 49' 52"
T = 100.14
L = 182.78
R = 180.00
PC STA. = 305+16.56
PT STA. = 306+99.33

CURVE DATA BL_GRIFFIN_6
PI STA. = 303+17.87
Δ = 16° 00' 00" (LT)
D = 20° 06' 14"
T = 40.05
L = 79.59
R = 285.00
PC STA. = 302+77.82
PT STA. = 303+57.41

CURVE DATA BL_GATEWAY3
PI STA. = 139+48.74
Δ = 47° 21' 37" (LT)
D = 4° 24' 30"
T = 570.12
L = 1,074.31
R = 1,300.00
PC STA. = 133+78.62
PT STA. = 144+52.93

CURVE DATA BL_GRIFFIN_21
PI STA. = 326+41.45
Δ = 9° 24' 01" (LT)
D = 1° 11' 37"
T = 394.64
L = 787.52
R = 4,800.00
PC STA. = 322+46.80
PT STA. = 330+34.32

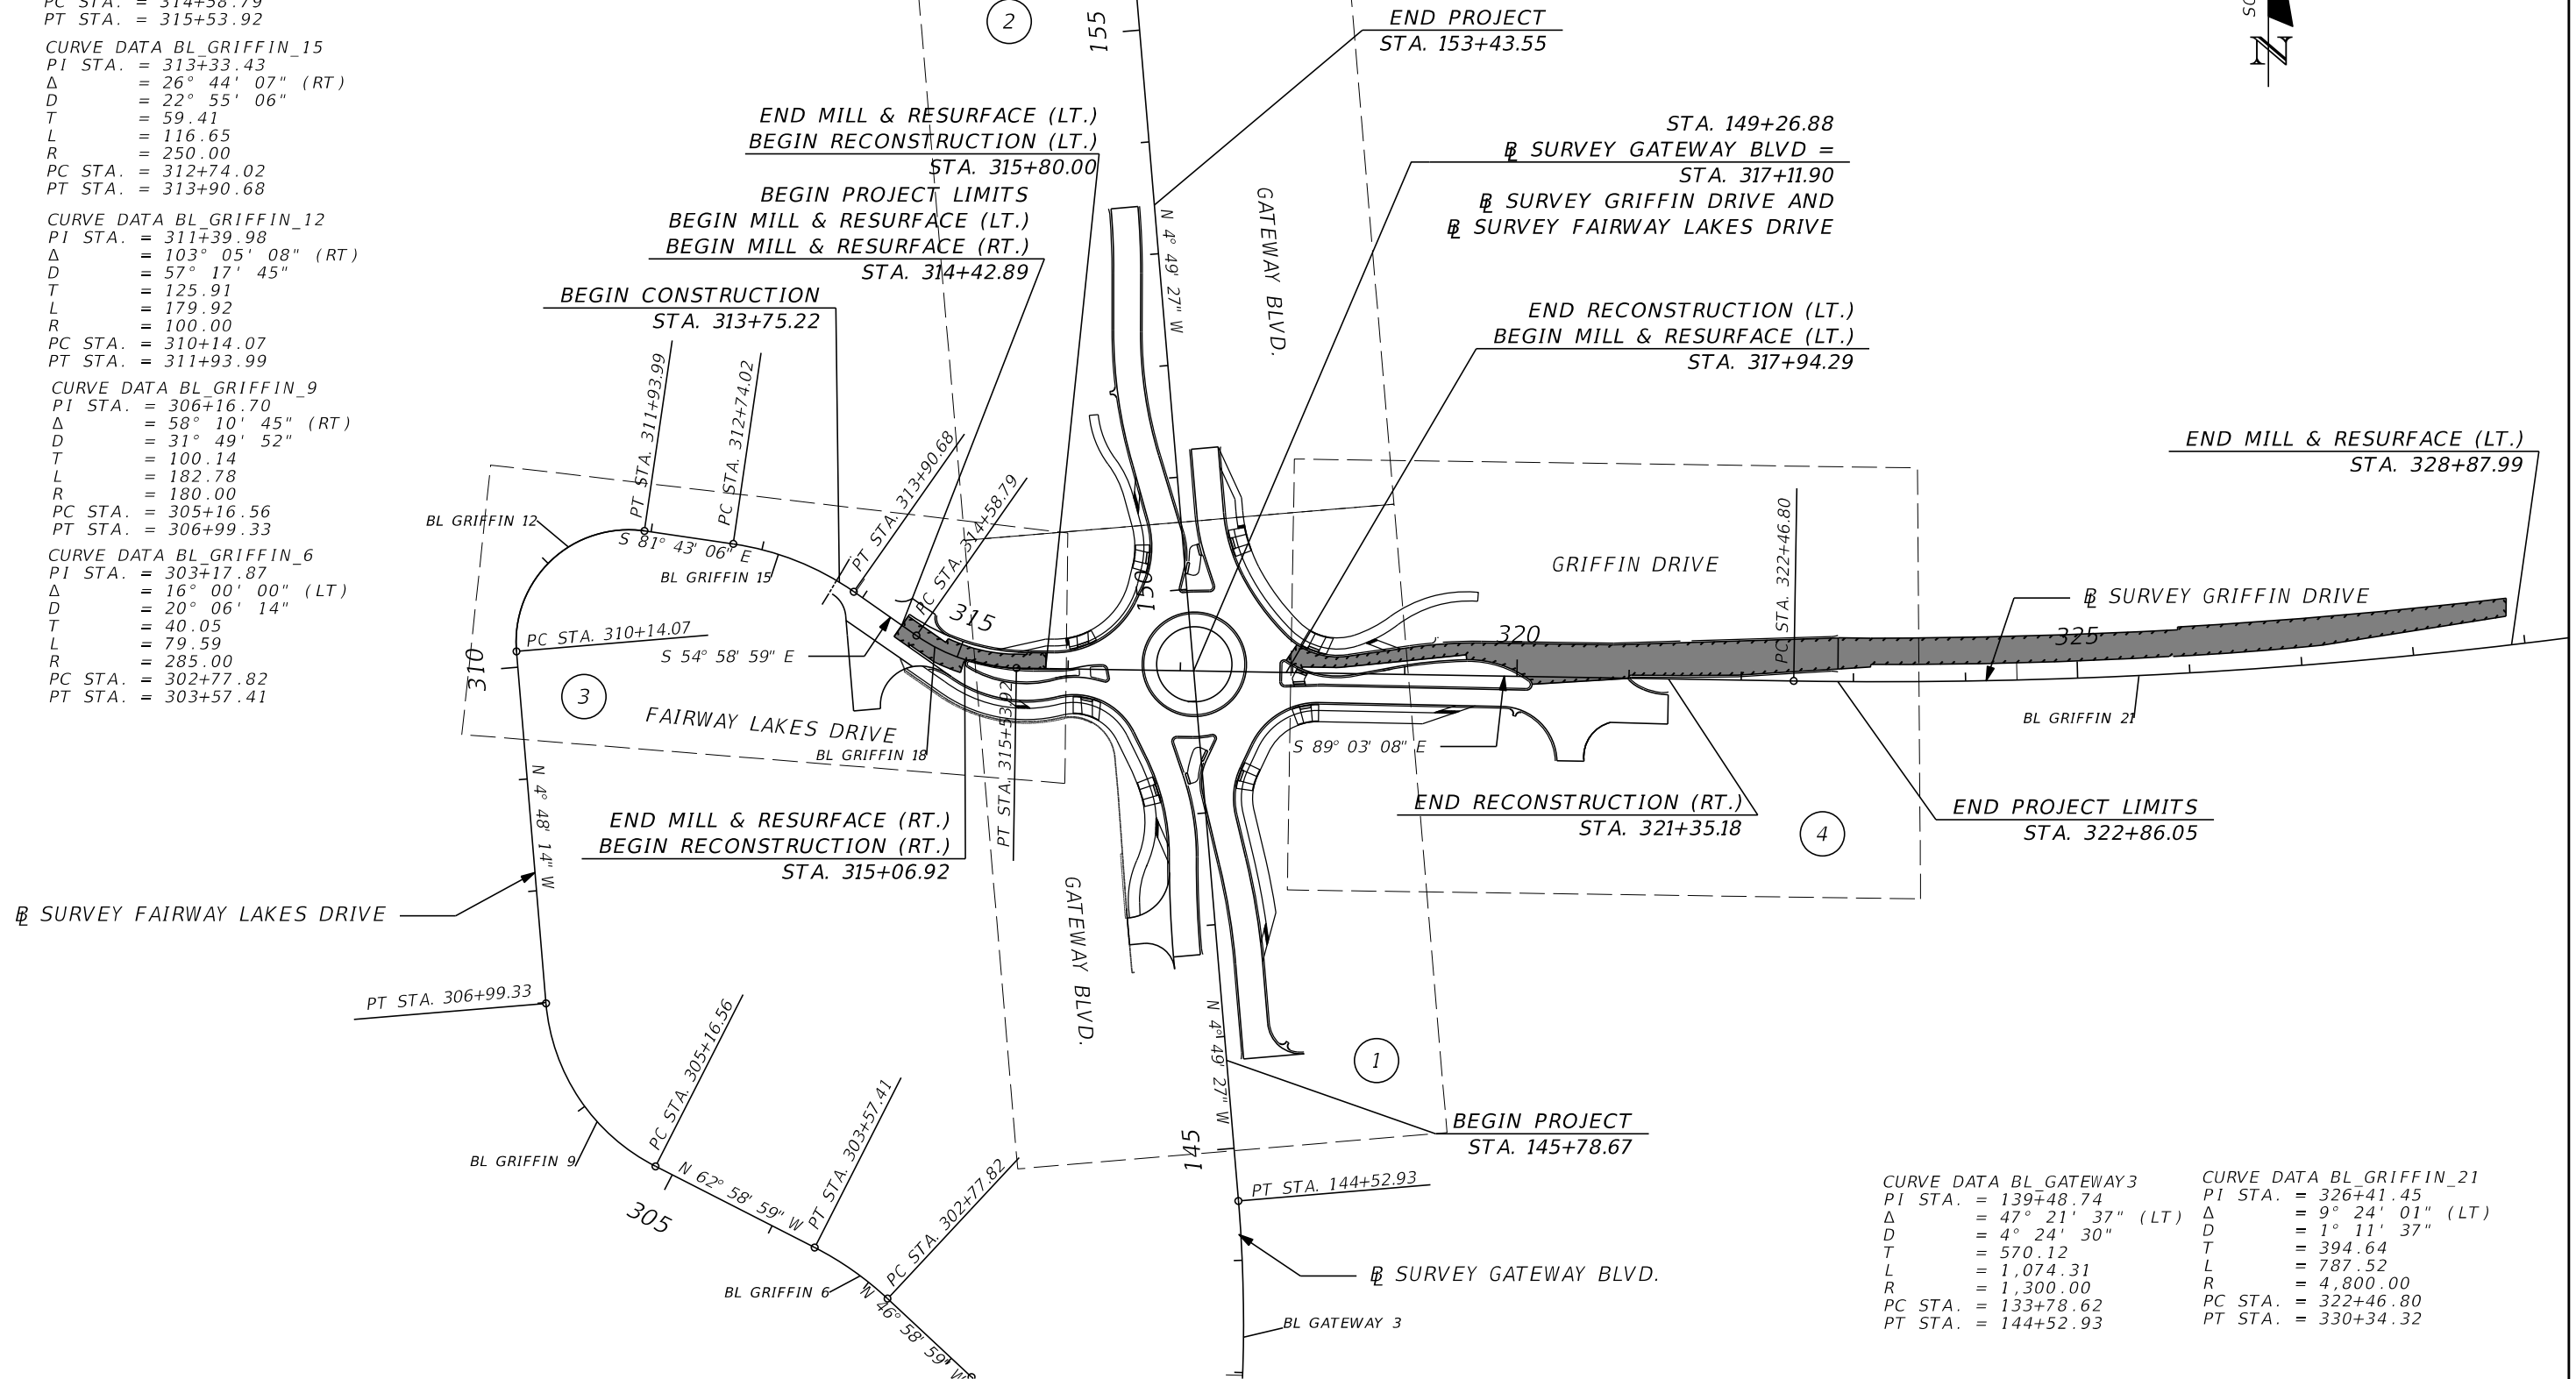

REVISIONS				JASON Y. YAM, P.E. P.E. LICENSE NUMBER 62449 CARDNO, INC. 380 PARK PLACE BOULEVARD, SUITE 300 CLEARWATER, FLORIDA 33759 CERTIFICATE OF AUTHORIZATION 29915		GATEWAY BOULEVARD AT GRIFFIN DRIVE INTERSECTION CONTROL (ROUNDAABOUT)		COUNTY PROJECT NO.	SHT. NO.
DATE	DESCRIPTION	DATE	DESCRIPTION			PROJECT LAYOUT		200672	11

THE OFFICIAL RECORD OF THIS SHEET IS THE ELECTRONIC FILE DIGITALLY SIGNED AND SEALED UNDER RULE 61G15-23.004, F.A.C.

COORDINATE TABLE				
POINT	NORTHING	EASTING	ELEVATION	DESCRIPTION
110	813504.75'	738296.18'	26.97'	SET 5/8" IR&C "CARDNO T.P. LB 7975"
105	813658.70'	738265.38'	27.21'	SET 5/8" IR&C "CARDNO T.P. LB 7975"
113	812805.74'	738187.71'	26.53'	SET N-D "CARDNO T.P. LB 7975"
106	813652.95'	738648.27"	26.15'	SET N-D "CARDNO T.P. LB 7975"
107	813649.38'	738897.12'	25.99'	SET N-D "CARDNO T.P. LB 7975"
108	813539.15'	738650.20'	26.36'	SET N-D "CARDNO T.P. LB 7975"
109	813534.44'	738362.93'	26.16'	SET 5/8" IR&C "CARDNO T.P. LB 7975"
111	813257.75'	738313.82'	27.38'	SET 5/8" IR&C "CARDNO T.P. LB 7975"
112	812763.47'	738298.99'	28.55'	SET N-D "CARDNO T.P. LB 7975"
114	813053.64'	738203.40'	27.18'	SET N-D "CARDNO T.P. LB 7975"
115	813560.82'	738154.20'	26.98'	SET 5/8" IR&C "CARDNO T.P. LB 7975"
116	813641.95'	737921.13'	25.24'	SET N-D "CARDNO T.P. LB 7975"
117	813642.60'	738167.23'	26.95'	SET 5/8" IR&C "CARDNO T.P. LB 7975"
118	814135.81'	738113.66'	25.91'	SET N-D "CARDNO T.P. LB 7975"
119	814233.15'	738105.78'	26.42'	SET N-D "CARDNO T.P. LB 7975"
120	814143.38'	738218.90'	26.38'	SET 5/8" IR&C "CARDNO T.P. LB 7975"
121	813899.42'	738273.67"	26.22'	SET 5/8" IR&C "CARDNO T.P. LB 7975"
102	813656.87'	738445.49'	26.13'	SET N-D "CARDNO T.P. LB 7975"
150	813696.64'	737728.11'	25.71'	SET N-D "CARDNO T.P. LB 7975"
151	813724.15'	737733.94'	25.77'	SET N-D "CARDNO T.P. LB 7975"

LEGEND:

	AIR RELEASE VALVE		FLAG POLE		SPRINKLER		FOUND CONCRETE MONUMENT
	BACKFLOW PREVENTER		FORCE MAIN		STEEL POST		FOUND DRILL HOLE
	BENCH MARK		FORCE MAIN AIR RELEASE VALVE		TELEPHONE BOX OR VAULT		FOUND IRON ROD
	BOLLARD		GAS PIPELINE MARKER		TELEPHONE CANISTER		FOUND IRON ROD & CAP
	CABLE RISER		GROUND LIGHT		TELEPHONE FLAG		FOUND NAIL
	CABLE TV BOX		GUARD RAIL		TELEPHONE MANHOLE		FOUND NAIL & DISK
	CATCH BASIN		GUY POLE		TELEPHONE RISER		FOUND PARKER KALON NAIL
	CENTERLINE		GUY WIRE		TOE OF SLOPE		FOUND PARKER KALON NAIL & DISK
	CLEANOUT		HAND-UP PARKING		TOP OF BANK		SET CONCRETE MONUMENT
	COORDINATE NUMBER		HOSE BIB		TRAFFIC SIGNAL BOX		SET DRILL HOLE
	CONCRETE POWER POLE		IRRIGATION BOX		TRAFFIC SIGNAL POLE		SET 5/8" IRON ROD & CAP "CARDNO LB 7975" U.O.N.
	DRAINAGE MANHOLE		IRRIGATION VALVE		UNKNOWN UTILITY VAULT OR BOX		SET MAG NAIL & DISK "CARDNO LB 7975" U.O.N.
	ELECTRICAL BOX		LIGHT POLE		UNKNOWN UTILITY MANHOLE		
	ELECTRIC OUTLET		MAIL BOX		UNDERGROUND UTILITIES		
	ELECTRIC METER		MITERED END		WATER MAIN		
	ELECTRIC LINE		WELL		WATER LINE FLAG		
	ELECTRIC FLAG		OVERHEAD POWER LINE		WATER METER		
	EXISTING ELEVATION		OVERHEAD TELEPHONE LINE		WATER VALVE		
	FENCE - BARBED WIRE		POWER POLE		WOOD SUPPORT POLE		
	FENCE - CHAIN LINK		POWER POLE w/RISER		YARD DRAIN		
	FENCE - WOOD		RECLAIM WATER LINE FLAG		CROSS WALK SIGNAL POLE		
	FIBER OPTIC MARKER / POST		SEWER LINE FLAG		CROSS WALK BUTTON POLE		
	FIBER OPTIC BOX		SANITARY SEWER LINE		BUSH		
	FIRE HYDRANT		SEWER MANHOLE		CABBAGE PALM		
	FIRE VALVE		SEWER VALVE		OAK TREE		
			SECURITY SENSOR		PALM TREE		
			SIGN SINGLE POST		PINE TREE		
			SIGN DOUBLE POST		SHADE TREE (VARIOUS TYPE)		

ABBREVIATIONS:

AC. = ACRE	MH = MANHOLE
A.C. = AIR CONDITIONER	MHWL = MEAN HIGH WATER LINE
A.K.A. = ALSO KNOWN AS	MISC. = MISCELLANEOUS
ALUM. = ALUMINUM	MON = MONUMENT
APPR. = APPROXIMATE	NAD = NORTH AMERICAN DATUM
AVE. = AVENUE	N.A.V.D. = NORTH AMERICAN VERTICAL DATUM
BLDG. = BUILDING	NGS = NATIONAL GEODETIC SURVEY
BLVD. = BOULEVARD	N.G.V.D. = NATIONAL GEODETIC VERTICAL DATUM (1929)
BM = BENCHMARK	No. = NUMBER
BOC = BACK OF CURB	N.T.S. = NOT TO SCALE
BOW = BACK OF WALK	N.T.T. = NAIL & TIN TAB
BSM = BUREAU OF SURVEYING AND MAPPING	O/H = OVERHANG
(C) = CALCULATED	O.H.W.L. = ORDINARY HIGH WATER LINE
CATV = CABLE TELEVISION	O.H.W.M. = ORDINARY HIGH WATER MARK
CB = CATCH BASIN	O.R. = OFFICIAL RECORD BOOK / PAGE
CBS = CONCRETE BLOCK STRUCTURE	(P) = PLAT
C.C.R. = CERTIFIED CORNER RECORD	PB = PLAT BOOK
CDB = CHORD BEARING	P.C. = POINT OF CURVATURE
CH = CHORD	PCP = PERMANENT CONTROL POINT
CLF = CHAIN LINK FENCE	PG (S) . = PAGE(S)
CM = CONCRETE MONUMENT	P.I. = POINT OF INTERSECTION
CMP = CORRUGATED METAL PIPE	PKN&D = PARKER-KALON NAIL & DISK
C.O. = CLEANOUT	PKWY. = PARKWAY
CONC. = CONCRETE	PL = PROPERTY LINE
CONT. = CONTROL	PLS = PROFESSIONAL LAND SURVEYOR
CPP = CORRUGATED PLASTIC PIPE	P.O.B. = POINT OF BEGINNING
COR. = CORNER	P.O.C. = POINT OF COMMENCEMENT
CORP. = CORPORATION	P.O.T. = POINT OF TERMINUS
C.P. = CONTROL POINT	PP = POWER POLE
C.R. = COUNTY ROAD	P.R.M. = PERMANENT REFERENCE MONUMENT
CT. = COURT	PROP. = PROPERTY
C.U.E. = COUNTY UTILITY EASEMENT	PSM = PROFESSIONAL SURVEYOR AND MAPPER
(D) = DEED	PT. = POINT
D.E. = DRAINAGE EASEMENT	P.T. = POINT OF TANGENCY
(DESC.) = DESCRIPTION	P.U.E. = PUBLIC UTILITY EASEMENT
DH = DRILL HOLE	PVC = POLY VINYL CHLORIDE
DIA. = DIAMETER	R = RADIUS OR RIGHT
DR. = DRIVE	(R) = RECORD
DWG. = DRAWING	RCP = REINFORCED CONCRETE PIPE
EL. = ELEVATION	RGE = RANGE
ELEC. = ELECTRIC	RLS = REGISTERED LAND SURVEYOR
EOP = EDGE OF PAVEMENT	R.R. = RAILROAD
EOW = EDGE OF WATER	RT = RIGHT
ERCP = ELLIPTICAL REINFORCED CONCRETE PIPE	RTA = RIGHT ANGLE
ESMT. = EASEMENT	R/W = RIGHT-OF-WAY
EXIST. = EXISTING	SEC. = SECTION
(F) = FIELD	S.F. = SQUARE FEET
FDEP = FLORIDA DEPARTMENT OF ENVIRONMENTAL PROTECTION	SFWMD = SOUTH FLORIDA WATER MANAGEMENT DISTRICT
FDOT = FLORIDA DEPARTMENT OF TRANSPORTATION	SHT. = SHEET
FEMA = FEDERAL EMERGENCY MANAGEMENT AGENCY	S.R. = STATE ROAD
F.F. = FINISHED FLOOR	S.S. = SANITARY SEWER
FND = FOUND	STA. = STATION
FPL OR FP&L = FLORIDA POWER & LIGHT	ST. = STREET
F.S. = FLORIDA STATUTES	SFWFMD = SOUTHWEST FLORIDA WATER MANAGEMENT DISTRICT
FT. = FOOT / FEET	T = TANGENT
GLO = GENERAL LAND OFFICE	TEL = TELEPHONE
GPS = GLOBAL POSITIONING SYSTEM	TIIF = TRUSTEES OF THE INTERNAL IMPROVEMENT FUND OF THE STATE OF FLORIDA
I.D. = IDENTIFICATION	TIITF = BOARD OF TRUSTEES OF THE INTERNAL IMPROVEMENT TRUST FUND OF THE STATE OF FLORIDA
I.D.D. = IONA DRAINAGE DISTRICT	TOB = TOP OF BANK
I.N. = INSTRUMENT NUMBER	TOE = TOE OF SLOPE
INC. = INCORPORATED	T.P. = TRAVERSE POINT
INST. = INSTRUMENT	TRANS. = TRANSITION
INV. = INVERT	TWP = TOWNSHIP
I.P. = IRON PIPE	TYP = TYPICAL
IR = IRON ROD (5/8" DIA. U.O.N.)	U.E. = UTILITY EASEMENT
IRC OR IR&C = IRON ROD & CAP	U.O.N. = UNLESS OTHERWISE NOTED
IRR. = IRRIGATION	USGS = UNITED STATES GEOLOGICAL SURVEY
L = LENGTH	w/ = WITH
LABINS = LAND BOUNDARY INFORMATION SYSTEM (STATE OF FLORIDA)	Y.D. = YARD DRAIN
LAT = LATITUDE	Δ = DELTA ANGLE
LB = LICENSED BUSINESS	± = MORE OR LESS
LN. = LANE	# = NUMBER
LONG = LONGITUDE	" " = STAMPING OF CAP OR DISK
LS = LICENSED SURVEYOR	
LT = LEFT	
(M) = MEASURED	
MAG = MAGNETIC	
ME = MITERED END	

REVISIONS					JASON Y. YAM, P.E. P.E. LICENSE NUMBER 62449 CARDNO, INC. 380 PARK PLACE BOULEVARD, SUITE 300 CLEARWATER, FLORIDA 33759 CERTIFICATE OF AUTHORIZATION 29915	 DEPARTMENT OF TRANSPORTATION	GATEWAY BOULEVARD AT GRIFFIN DRIVE INTERSECTION CONTROL (ROUNDABOUT)		COUNTY PROJECT NO.	SHT. NO.
DATE	DESCRIPTION	DATE	DESCRIPTION				PROJECT CONTROL		200672	12

PROJECT NOTES:

1. BENCHMARK ELEVATIONS SHOWN ON THE PLANS ARE NORTH AMERICAN VERTICAL DATUM OF 1988 (NAVD 88). COORDINATE SYSTEM FOR THIS PROJECT SHALL BE BASED ON THE FLORIDA STATE PLANE COORDINATE SYSTEM, FLORIDA WEST ZONE; NORTH AMERICAN DATUM OF 1983 (2011 ADJUSTMENT).

2. THE COST OF SAW CUTTING SHALL BE INCIDENTAL TO THE WORK BEING PERFORMED.

3. ALL LANES MUST BE ABLE TO BE RE-OPENED IN 12 HOURS FOR TRAFFIC DURING AN EVACUATION NOTICE OF A HURRICANE OR OTHER EMERGENCY EVENTS AND SHALL REMAIN OPEN FOR THE DURATION OF THE EVACUATION OR EVENT AS DIRECTED BY THE PROJECT ENGINEER.

4. PAVEMENT MARKINGS AND SIGNS SHALL BE IN ACCORDANCE WITH THE MANUAL ON UNIFORM TRAFFIC CONTROL DEVICES FOR STREETS AND HIGHWAYS AND FDOT STANDARD PLANS, INDEX 711-001

5. THE LOCATION(S) OF THE UTILITIES SHOWN IN THE PLANS (INCLUDING THOSE DESIGNATED VV, VH, AND VVH) ARE BASED ON LIMITED INVESTIGATION TECHNIQUES AND SHOULD BE CONSIDERED APPROXIMATE ONLY. THE VERIFIED LOCATIONS/ELEVATIONS APPLY ONLY AT THE POINTS SHOWN. INTERPOLATIONS BETWEEN THESE POINTS HAVE NOT BEEN VERIFIED. CONTRACTOR SHALL LOCATE AND VERIFY THE SIZE, LOCATION, AND DEPTH OF ALL EXISTING UTILITIES IN THE FIELD

6. CONTRACTOR SHALL VERIFY ALL UTILITIES AND PROVIDE AT LEAST 48 HOURS NOTICE TO THE INDIVIDUAL UTILITY COMPANIES AND LCDOT PRIOR TO CONSTRUCTION.
UTILITY/AGENCY OWNERS:COMPANY CONTACTTELEPHONE NUMBERS
CENTURYLINKEZEKIEL REID239-336-2030
COMCAST CABLESTEVE HUTSON754-221-1254
FLORIDA POWER AND LIGHTJUAN CRUZ941-423-4842
GATEWAY SERVICES DISTRICTCHRIS SHOEMAKER239-561-1313
LEE COUNTY UTILITIESALLAN MAKAU239-533-8598
TECO PEOPLES GAS (FT. MYERS)ANTHONY BAUBLITZ941-342-4025

7. A STORMWATER POLLUTION PREVENTION PLAN SHALL BE PREPARED IN ACCORDANCE WITH SECTION 104 OF THE FDOT SPECIFICATIONS, THE NOTICE OF INTENT SHALL BE PREPARED FOR THE NPDES STORMWATER PERMIT AND SUBMITTED TO OBTAIN PERMIT COVERAGE. FULL COMPENSATION FOR ALL ITEMS SHALL BE INCLUDED IN THE COST OF MAINTENANCE OF TRAFFIC.

8. IN ANY EXCAVATION WORK IT SHOULD BE NOTED THAT THE WATER TABLE IS HIGH IN THIS AREA. WATER TABLE SHOWN ON CROSS SECTIONS MAY DIFFER FROM SEASONAL HIGH WATER TABLE (SHWT).

9. ALL CONSTRUCTION IN THE COUNTY RIGHT-OF-WAY SHALL BE IN ACCORDANCE WITH THE CURRENT LEE COUNTY DEPARTMENT OF TRANSPORTATION STANDARDS AND ALL REQUIRED INSPECTIONS PERFORMED AS REQUIRED BY THEM. CONTRACTOR SHALL PROVIDE BOND AND PERMIT FEE AS REQUIRED.

10. CONCRETE SIDEWALK: USE CLASS 1, 3000 PSI (MINIMUM) CONCRETE. APPLY BROOM FINISH AND MAKE VERTICAL SAW CUTS AT 5' ON CENTER AT A DEPTH OF ¼ OF THE SLAB THICKNESS. PROVIDE PRE-FORMED EXPANSION JOINTS AT 50' ON CENTER. ALL CONCRETE SIDEWALK AND DRIVEWAYS TO BE 6" THICK.

11. ALL MATERIALS AND WORKMANSHIP UNDER THIS PROJECT SHALL BE IN ACCORDANCE WITH THE CURRENT CONSTRUCTION STANDARDS AND SPECIFICATIONS OF LEE COUNTY DEVELOPMENT STANDARDS, LEE COUNTY DEPARTMENT OF TRANSPORTATION (LCDOT) AND FLORIDA DEPARTMENT OF TRANSPORTATION (FDOT) STANDARD SPECIFICATIONS FOR ROAD AND BRIDGE CONSTRUCTION 2020-21, UNLESS OTHERWISE NOTED.

12. ALL PERVIOUS AREAS WITHIN THE PROJECT CONSTRUCTION LIMITS SHALL BE SODDED. EXISTING SOD IS MOSTLY SAINT AUGUSTINE. MATCH EXISTING OR LANDSCAPE IN ACCORDANCE WITH THE APPROVED LANDSCAPE PLAN IF INCLUDED WITH THIS PLAN SET OR PROVIDED SEPARATELY AS PART OF CONTRACT.

13. CONTRACTOR SHALL VERIFY ALL QUANTITIES SHOWN ON THE PLANS. IF ANY DISCREPANCIES IN QUANTITIES ARE FOUND, THE CONTRACTOR SHALL NOTIFY THE PROJECT ENGINEER AND/OR LCDOT.

14. ALL REGULATORY AND PERMITTING AGENCIES' REQUIREMENTS SHALL BE COMPLIED WITH.

15. APPROPRIATE TURBIDITY CONTROL DEVICES SUCH AS SILT FENCES WILL BE UTILIZED DURING ALL PHASES OF CONSTRUCTION. CONTRACTOR IS RESPONSIBLE FOR SUBMITTING THE NPDES NOTICE OF INTENT, NOTICE OF TERMINATION, AND LEE COUNTY RIGHT-OF-WAY PERMITS. NOI MUST BE FILED WITH FDEP IN ACCORDANCE WITH DEP DOCUMENT NO. 62-621 AT LEAST 48 HOURS PRIOR TO THE START OF CONSTRUCTION. CONTRACTOR IS RESPONSIBLE FOR DEVELOPING AND MAINTAINING AN EFFECTIVE STORMWATER POLLUTION PREVENTION PLAN.


16. ALL EXISTING PIPES THAT ARE TO REMAIN IN SERVICE WITHIN THE RIGHT-OF-WAY CORRIDOR ARE TO REMAIN IN PLACE UNLESS OTHERWISE NOTED IN THE PLANS.

17. ALL EXISTING DRAINAGE STRUCTURES ARE TO REMAIN UNLESS NOTED ON THE ROADWAY PLANS TO BE REMOVED.

18. CONTRACTOR SHALL MARK THE PROPERTY LINE LOCATION AND NOTIFY BUSINESS/HOME OWNERS TO REMOVE ANY EXISTING LANDSCAPING (I.E. SOD, BUSHES, TREES, ETC.) AND/OR SPRINKLER PIPE OR SPRINKLER HEADS AND FENCING THAT IS LOCATED WITHIN THE EXISTING PUBLIC RIGHT-OF-WAY OR EASEMENT AT LEAST ONE (1) WEEK PRIOR TO THE COMMENCEMENT OF CONSTRUCTION.

19. NOTIFY RESIDENCES AND BUSINESSES AT LEAST 48 HOURS IN ADVANCE OR ANY DISRUPTION IN SERVICE, INCLUDING DRIVEWAY CUTS.

REVISIONS					GATEWAY BOULEVARD AT GRIFFIN DRIVE INTERSECTION CONTROL (ROUNDABOUT)	COUNTY PROJECT NO.	SHT. NO.
DATE	DESCRIPTION	DATE	DESCRIPTION		PROJECT NOTES	200672	13
			JASON Y. YAM, P.E. P.E. LICENSE NUMBER 62449 CARDNO, INC. 380 PARK PLACE BOULEVARD, SUITE 300 CLEARWATER, FLORIDA 33759 CERTIFICATE OF AUTHORIZATION 29915				

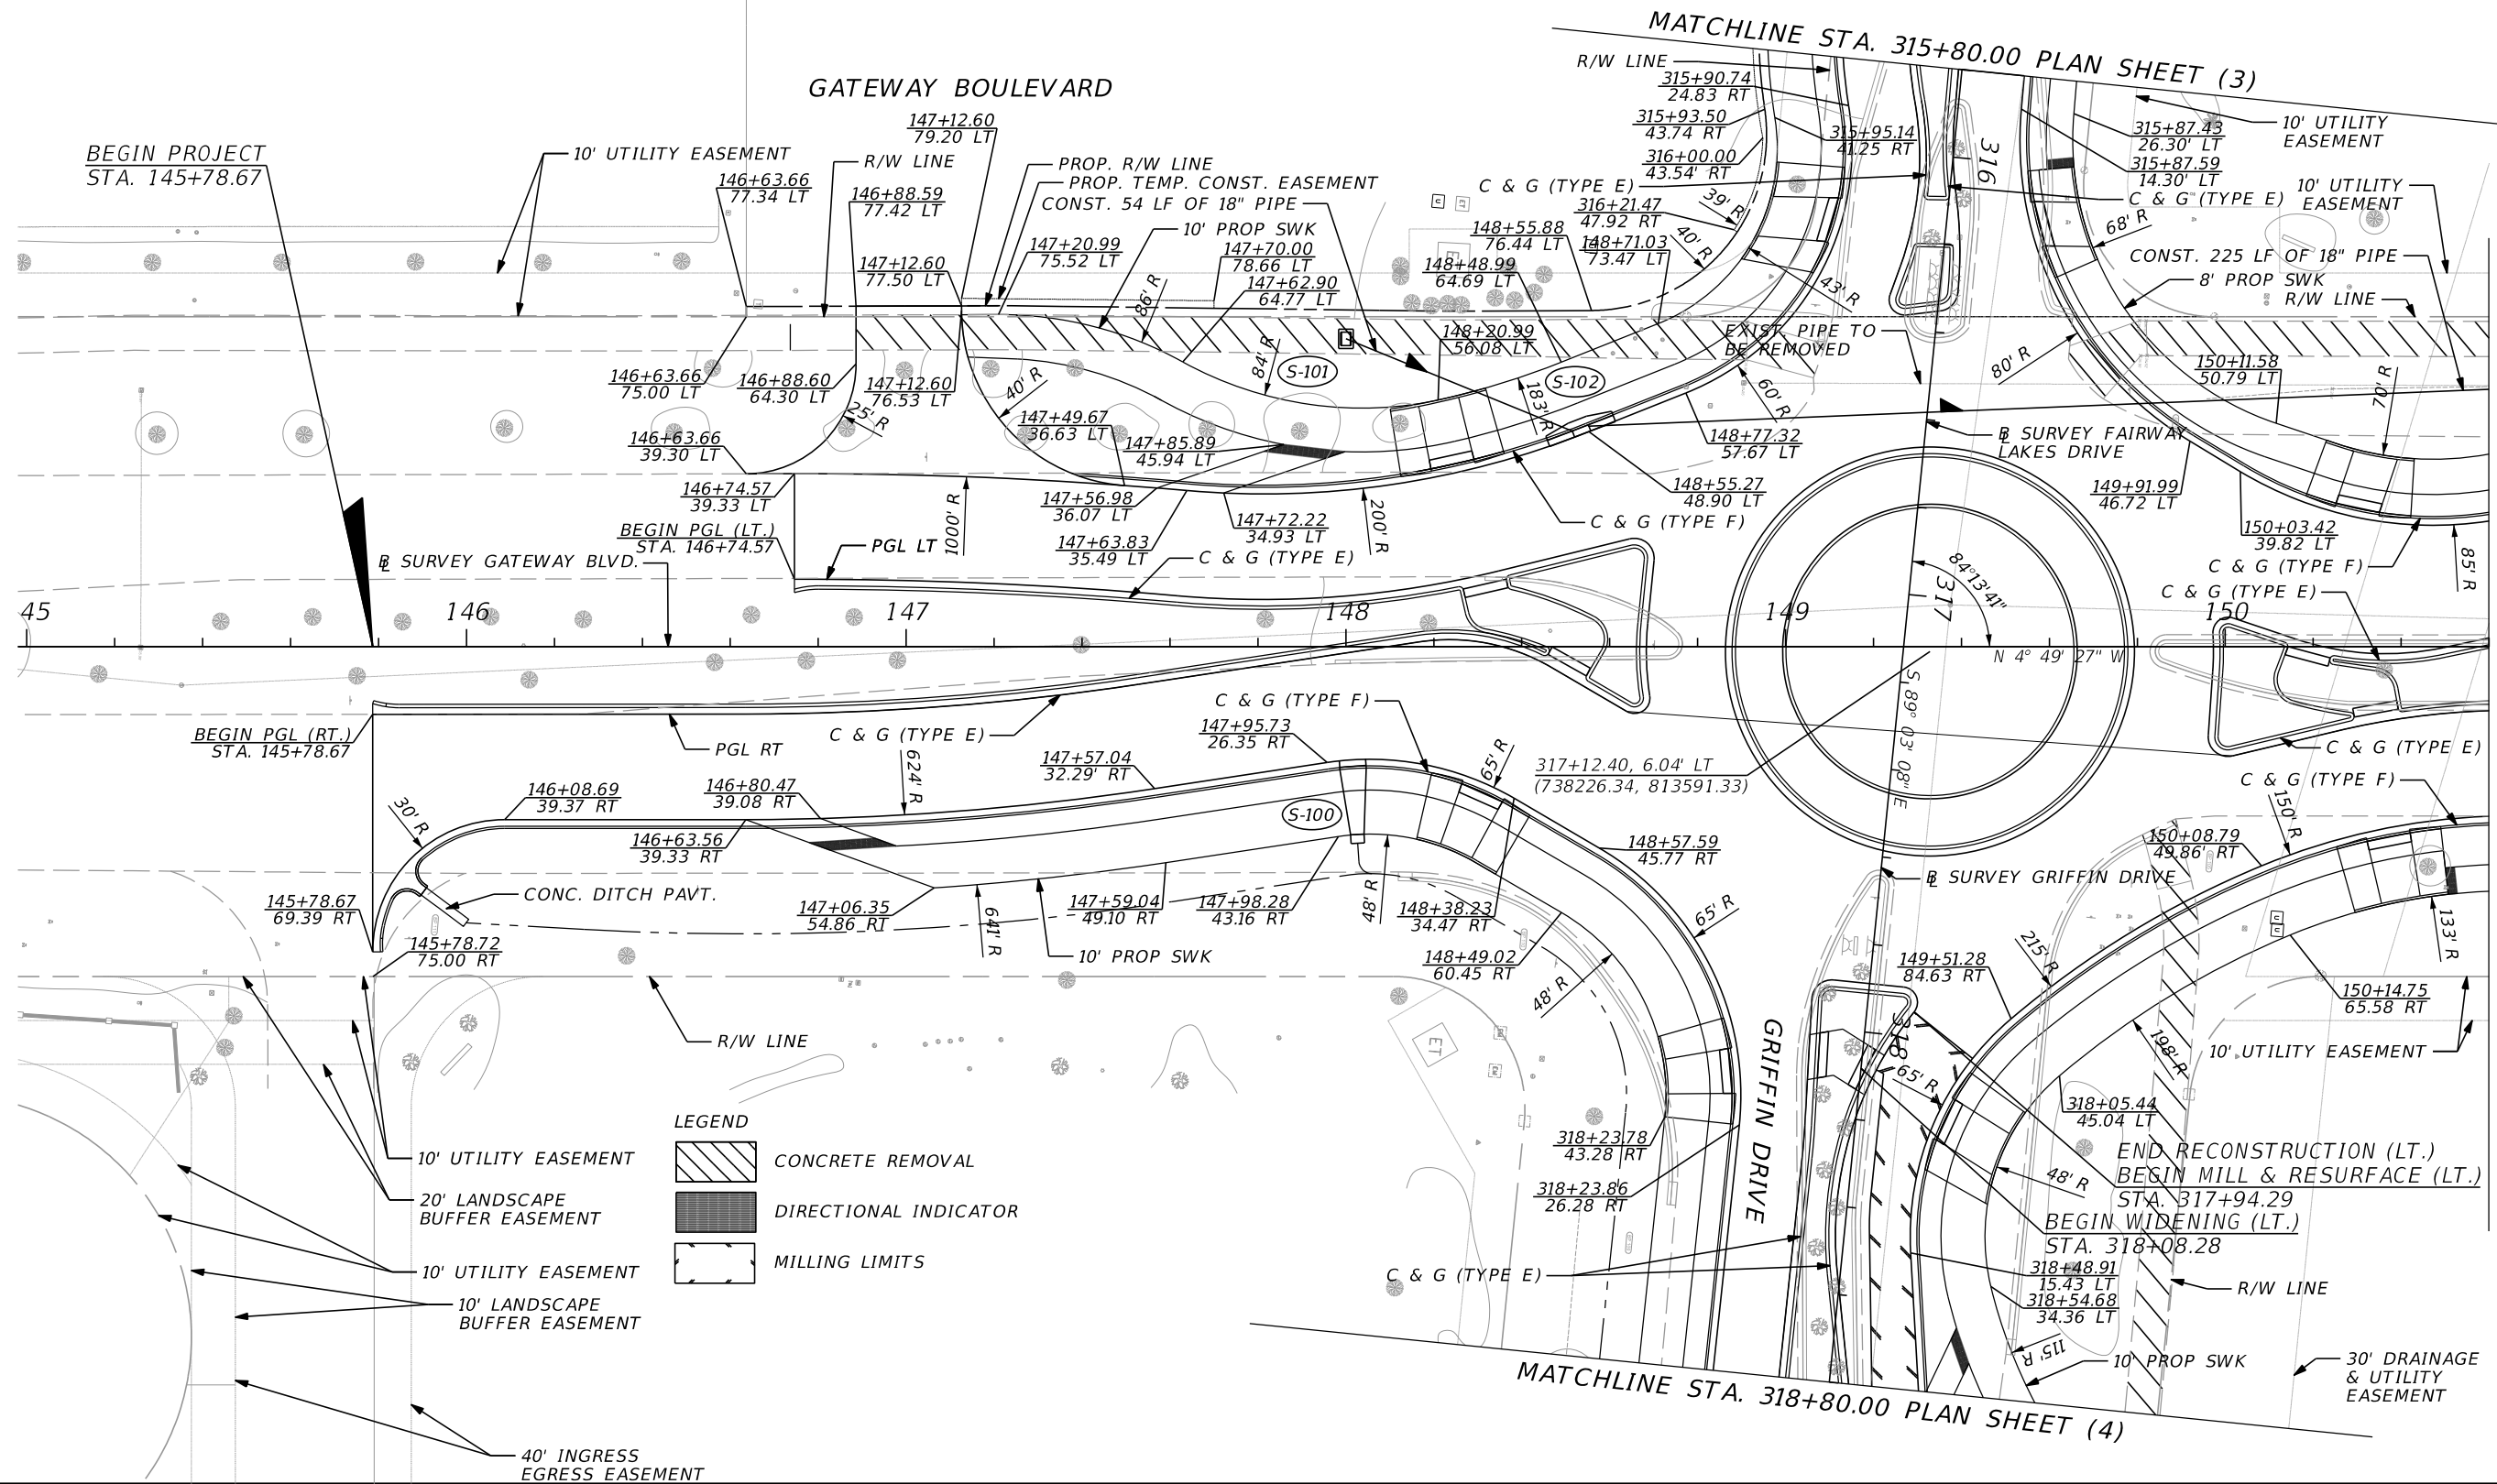

MATCHLINE STA. 150+60.00 PLAN SHEET (2)



LEGEND

	CONCRETE REMOVAL
	DIRECTIONAL INDICATOR
	MILLING LIMITS

REVISIONS				JASON Y. YAM, P.E. P.E. LICENSE NUMBER 62449 CARDNO, INC. 380 PARK PLACE BOULEVARD, SUITE 300 CLEARWATER, FLORIDA 33759 CERTIFICATE OF AUTHORIZATION 29915	 Lee County Southwest Florida DEPARTMENT OF TRANSPORTATION	GATEWAY BOULEVARD AT GRIFFIN DRIVE INTERSECTION CONTROL (ROUNDAABOUT)		COUNTY PROJECT NO.	SHT. NO.
DATE	DESCRIPTION	DATE	DESCRIPTION			PLAN SHEET (1)		200672	14

3/30/2020 8:30:43 AM J:\CR044\CR044002.02\ms\roadway\planrd01.dgn

 THE OFFICIAL RECORD OF THIS SHEET IS THE ELECTRONIC FILE DIGITALLY SIGNED AND SEALED UNDER RULE 61G15-23.004, F.A.C.

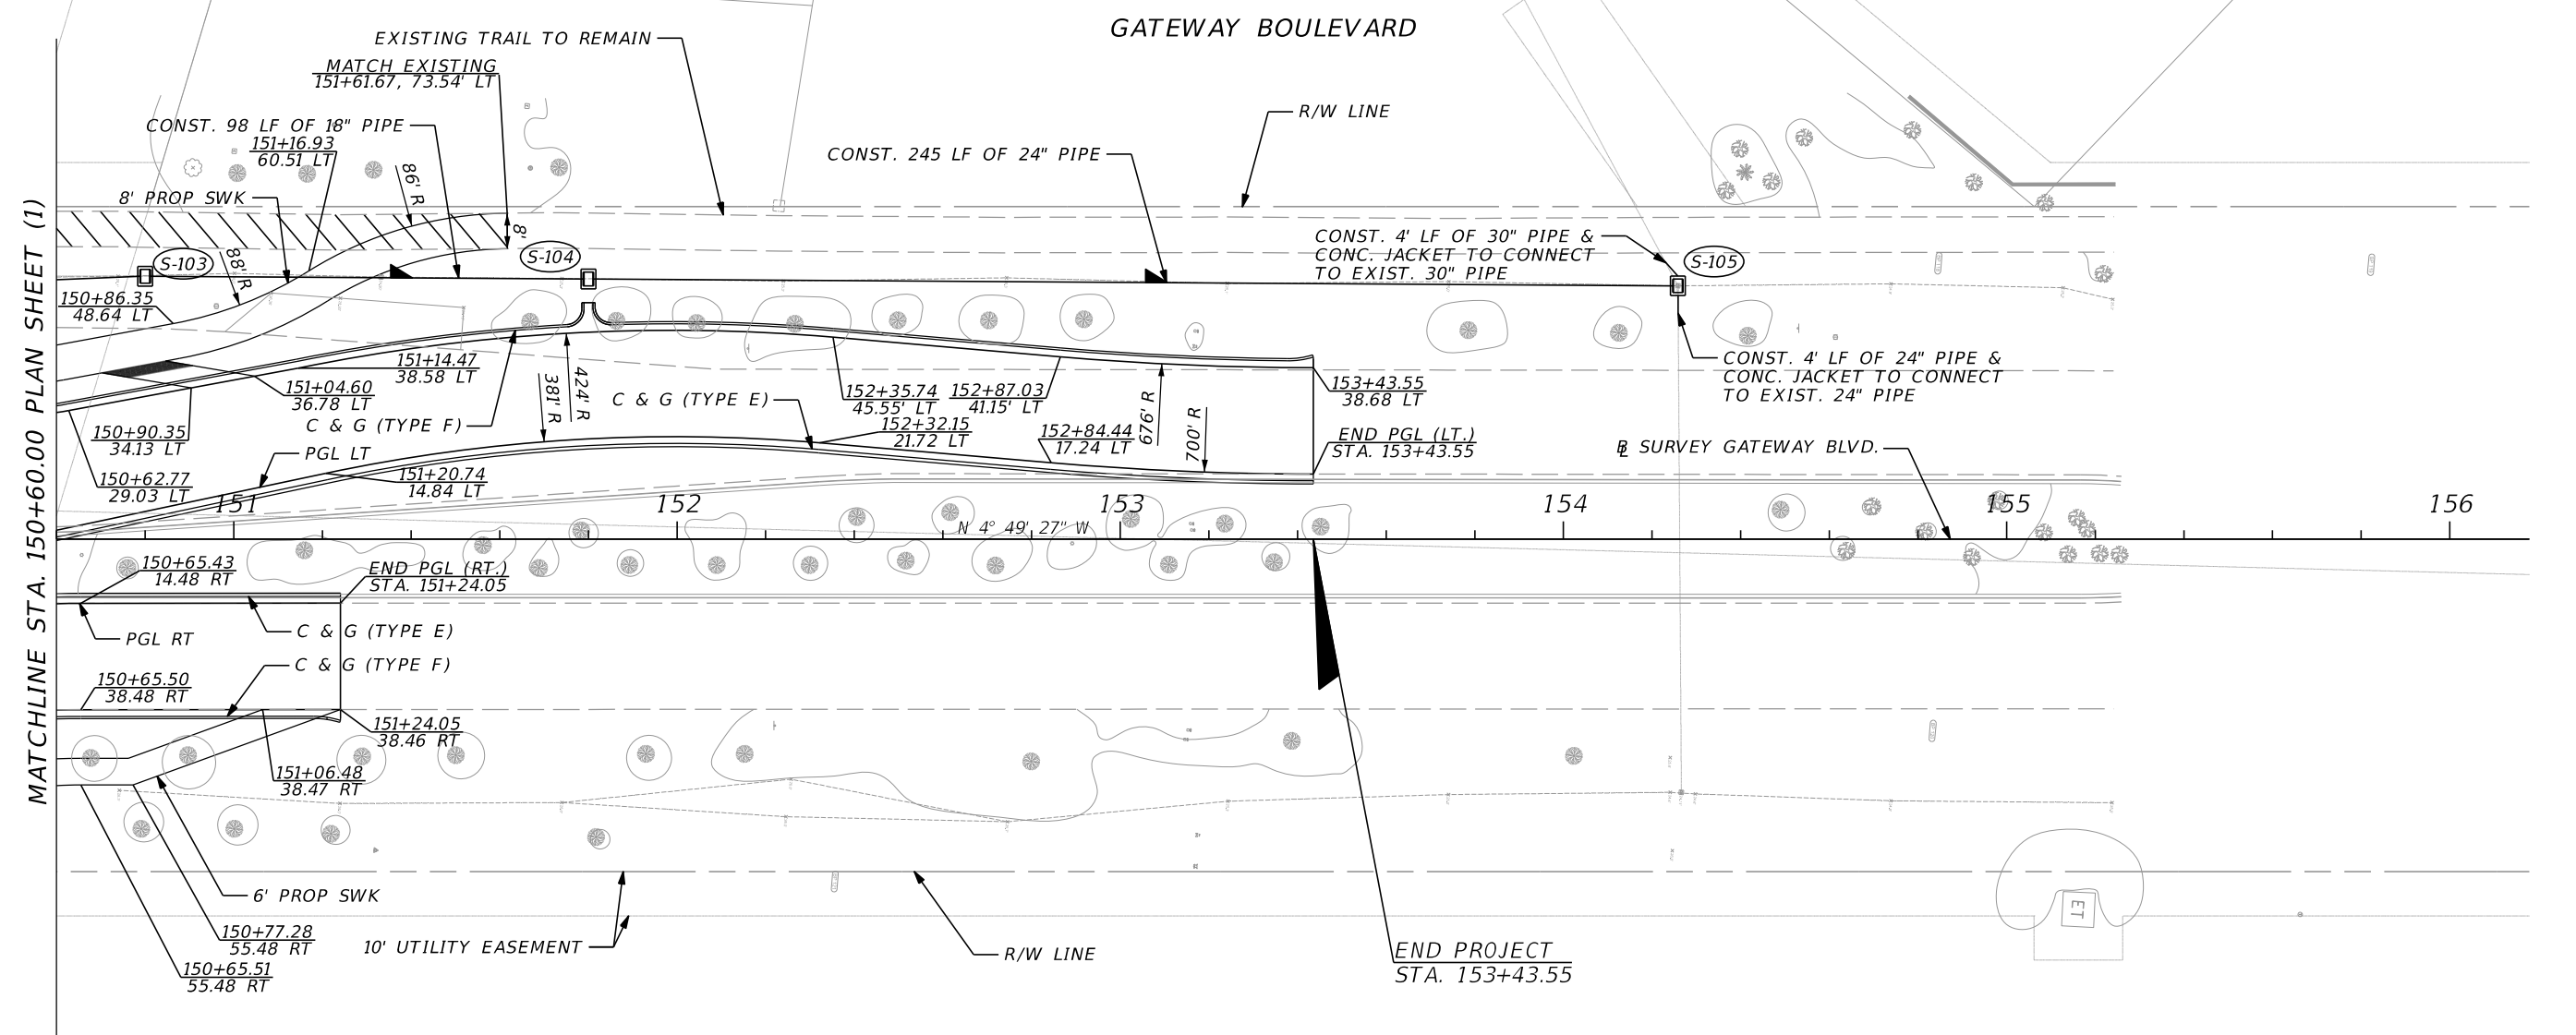


MATCHLINE STA. 150+60.00 PLAN SHEET (1)

- LEGEND
- CONCRETE REMOVAL
 - DIRECTIONAL INDICATOR
 - MILLING LIMITS

REVISIONS				JASON Y. YAM, P.E. P.E. LICENSE NUMBER 62449 CARDNO, INC. 380 PARK PLACE BOULEVARD, SUITE 300 CLEARWATER, FLORIDA 33759 CERTIFICATE OF AUTHORIZATION 29915		GATEWAY BOULEVARD AT GRIFFIN DRIVE INTERSECTION CONTROL (ROUNDBOUT)	COUNTY PROJECT NO.	SHT. NO.
DATE	DESCRIPTION	DATE	DESCRIPTION			PLAN SHEET (2)	200672	15



THE OFFICIAL RECORD OF THIS SHEET IS THE ELECTRONIC FILE DIGITALLY SIGNED AND SEALED UNDER RULE 61G15-23.004, F.A.C.

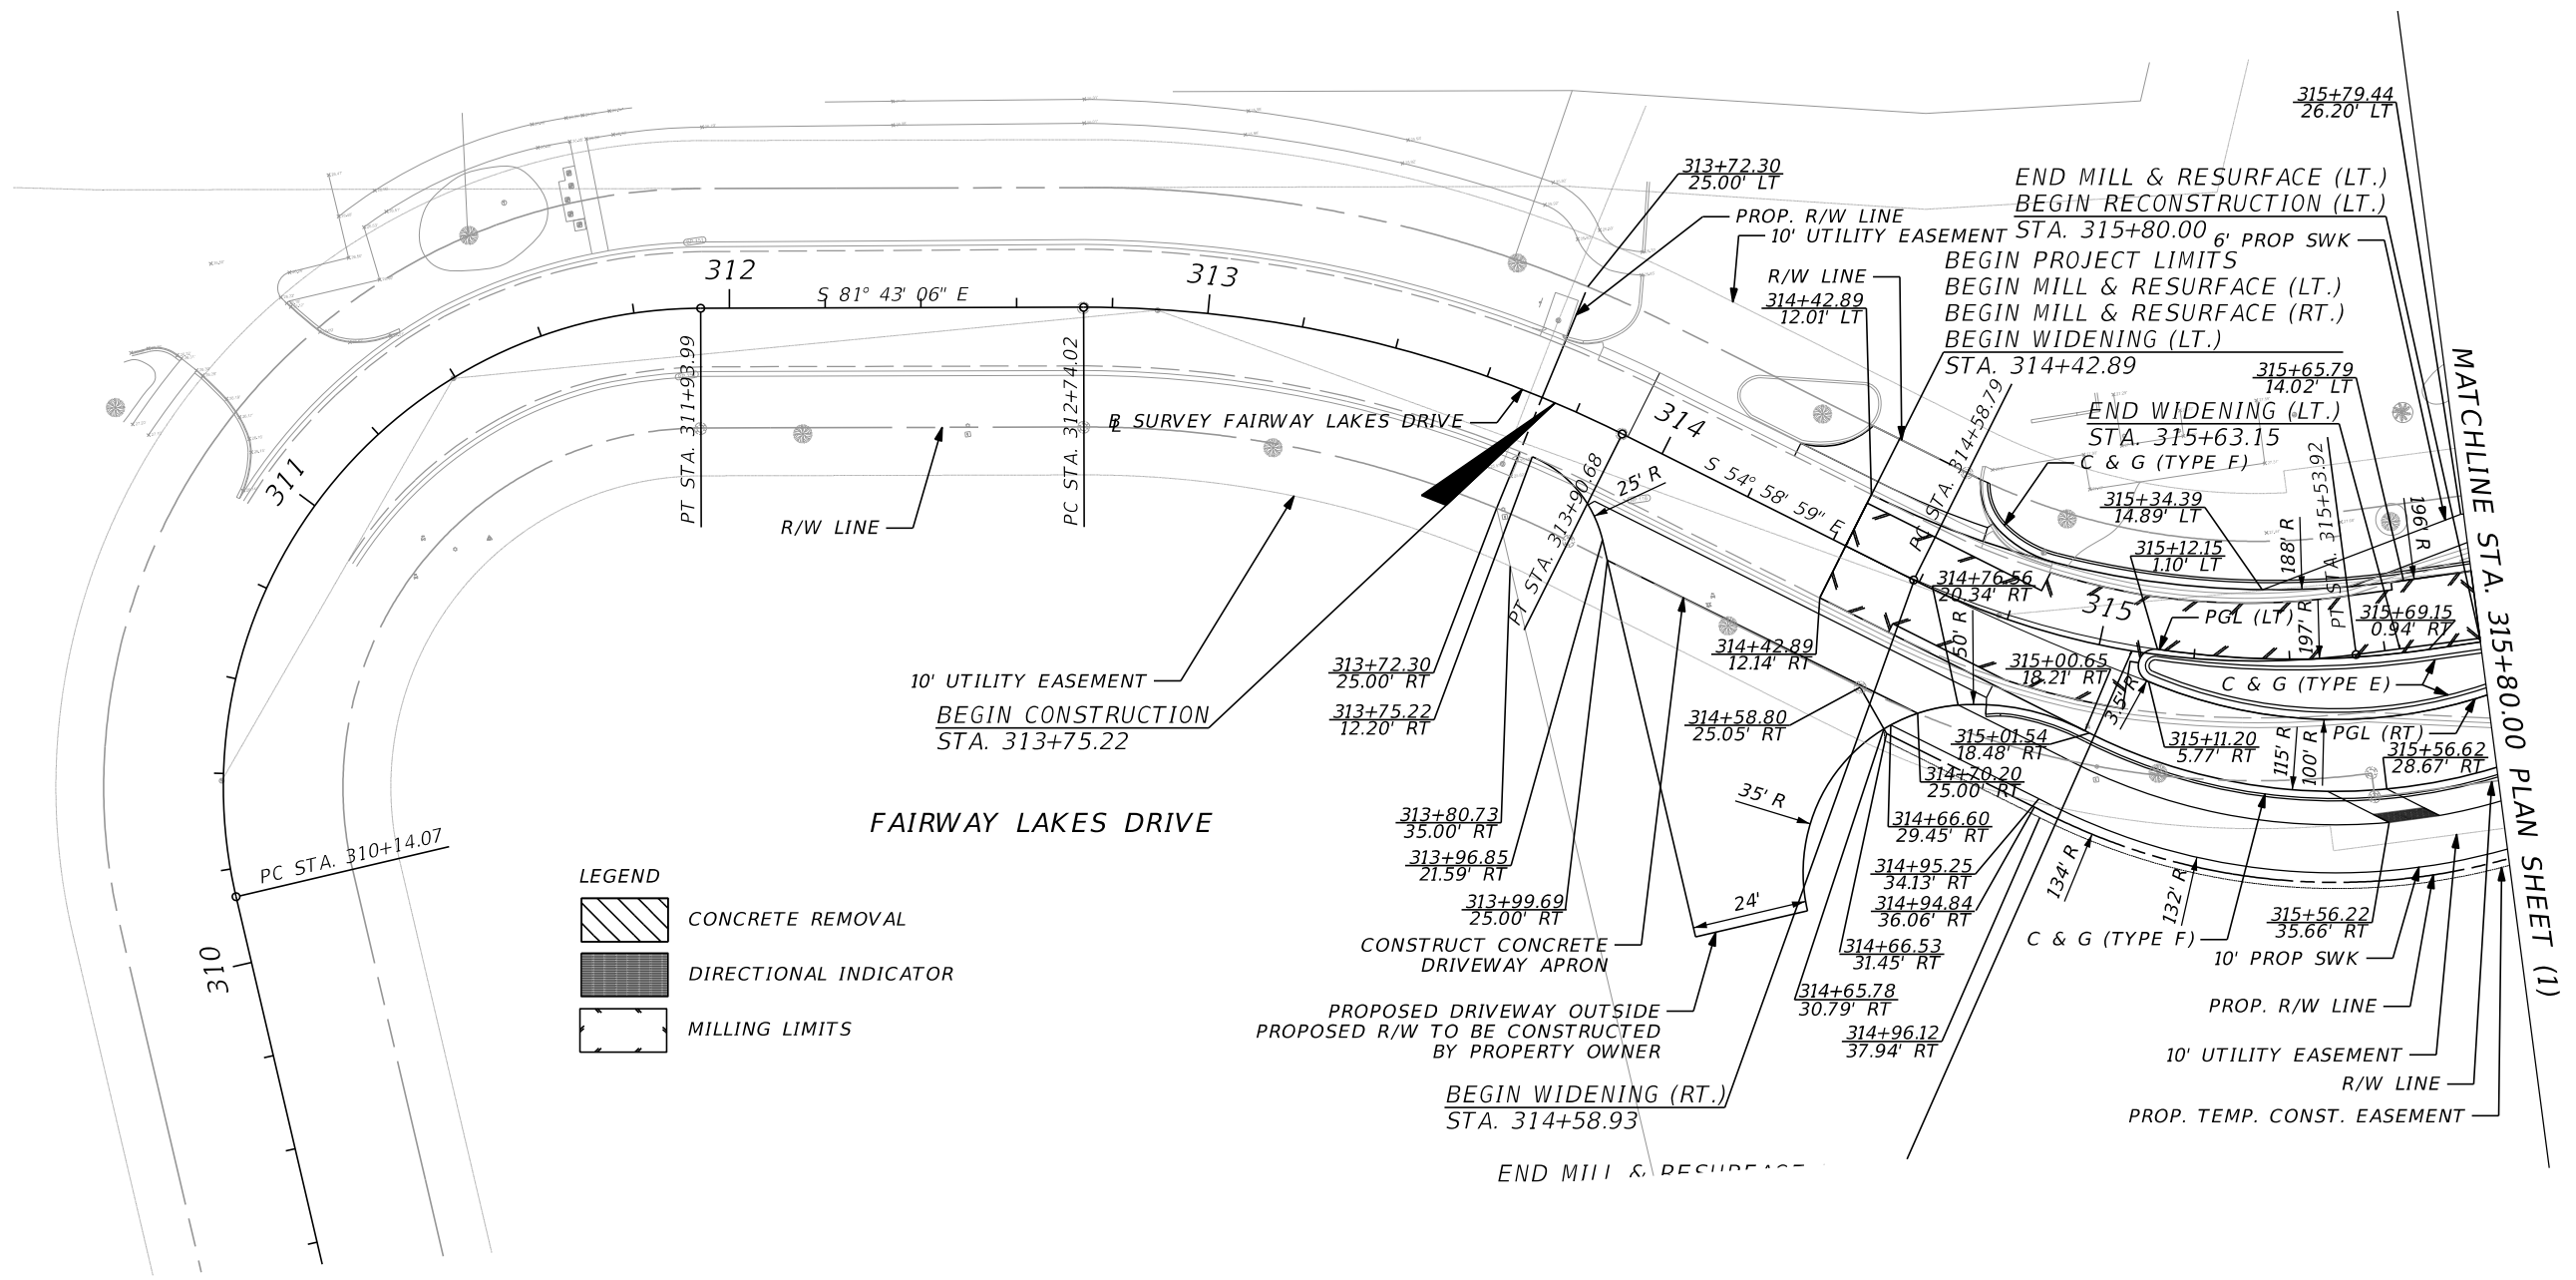

- LEGEND
- CONCRETE REMOVAL
 - DIRECTIONAL INDICATOR
 - MILLING LIMITS



REVISIONS				JASON Y. YAM, P.E. P.E. LICENSE NUMBER 62449 CARDNO, INC. 380 PARK PLACE BOULEVARD, SUITE 300 CLEARWATER, FLORIDA 33759 CERTIFICATE OF AUTHORIZATION 29915	 DEPARTMENT OF TRANSPORTATION	GATEWAY BOULEVARD AT GRIFFIN DRIVE INTERSECTION CONTROL (ROUNDBABOUT)		COUNTY PROJECT NO.	SHT. NO.
DATE	DESCRIPTION	DATE	DESCRIPTION			PLAN SHEET (3)		200672	16

THE OFFICIAL RECORD OF THIS SHEET IS THE ELECTRONIC FILE DIGITALLY SIGNED AND SEALED UNDER RULE 61G15-23.004, F.A.C.

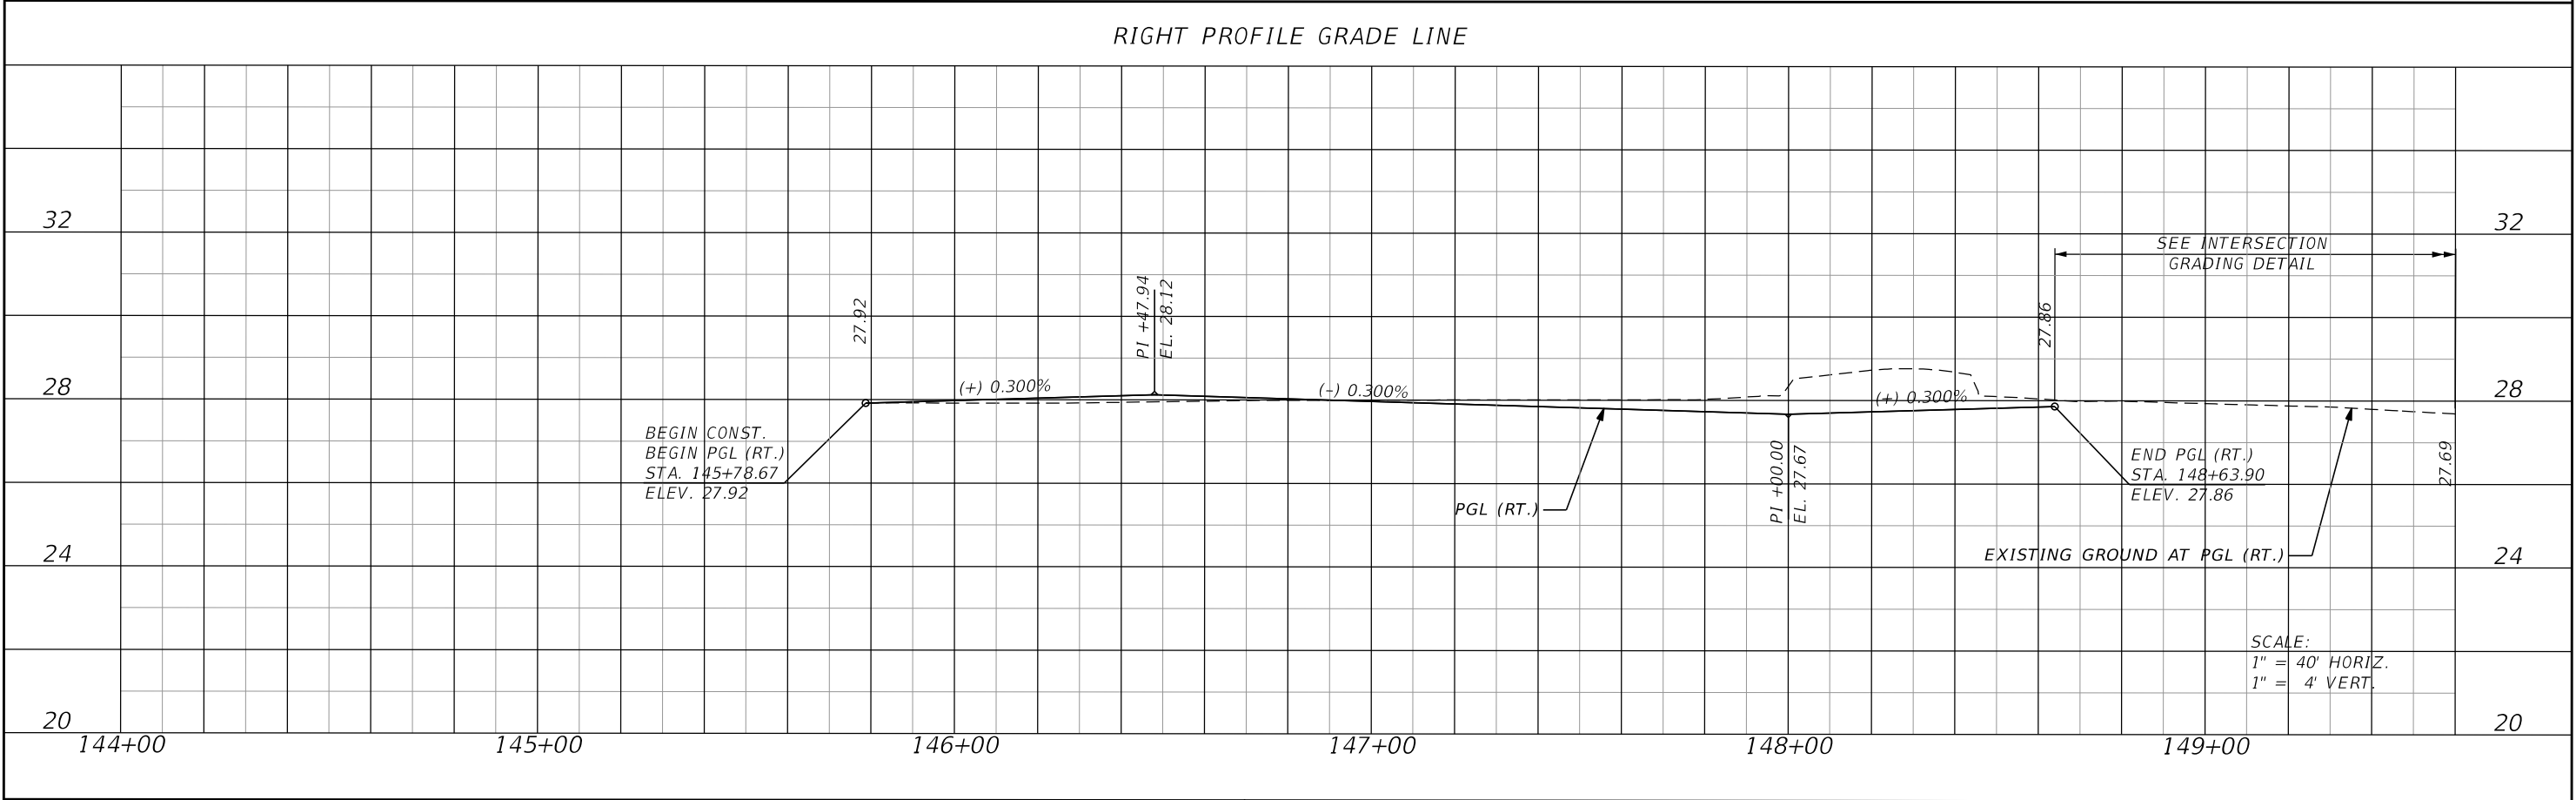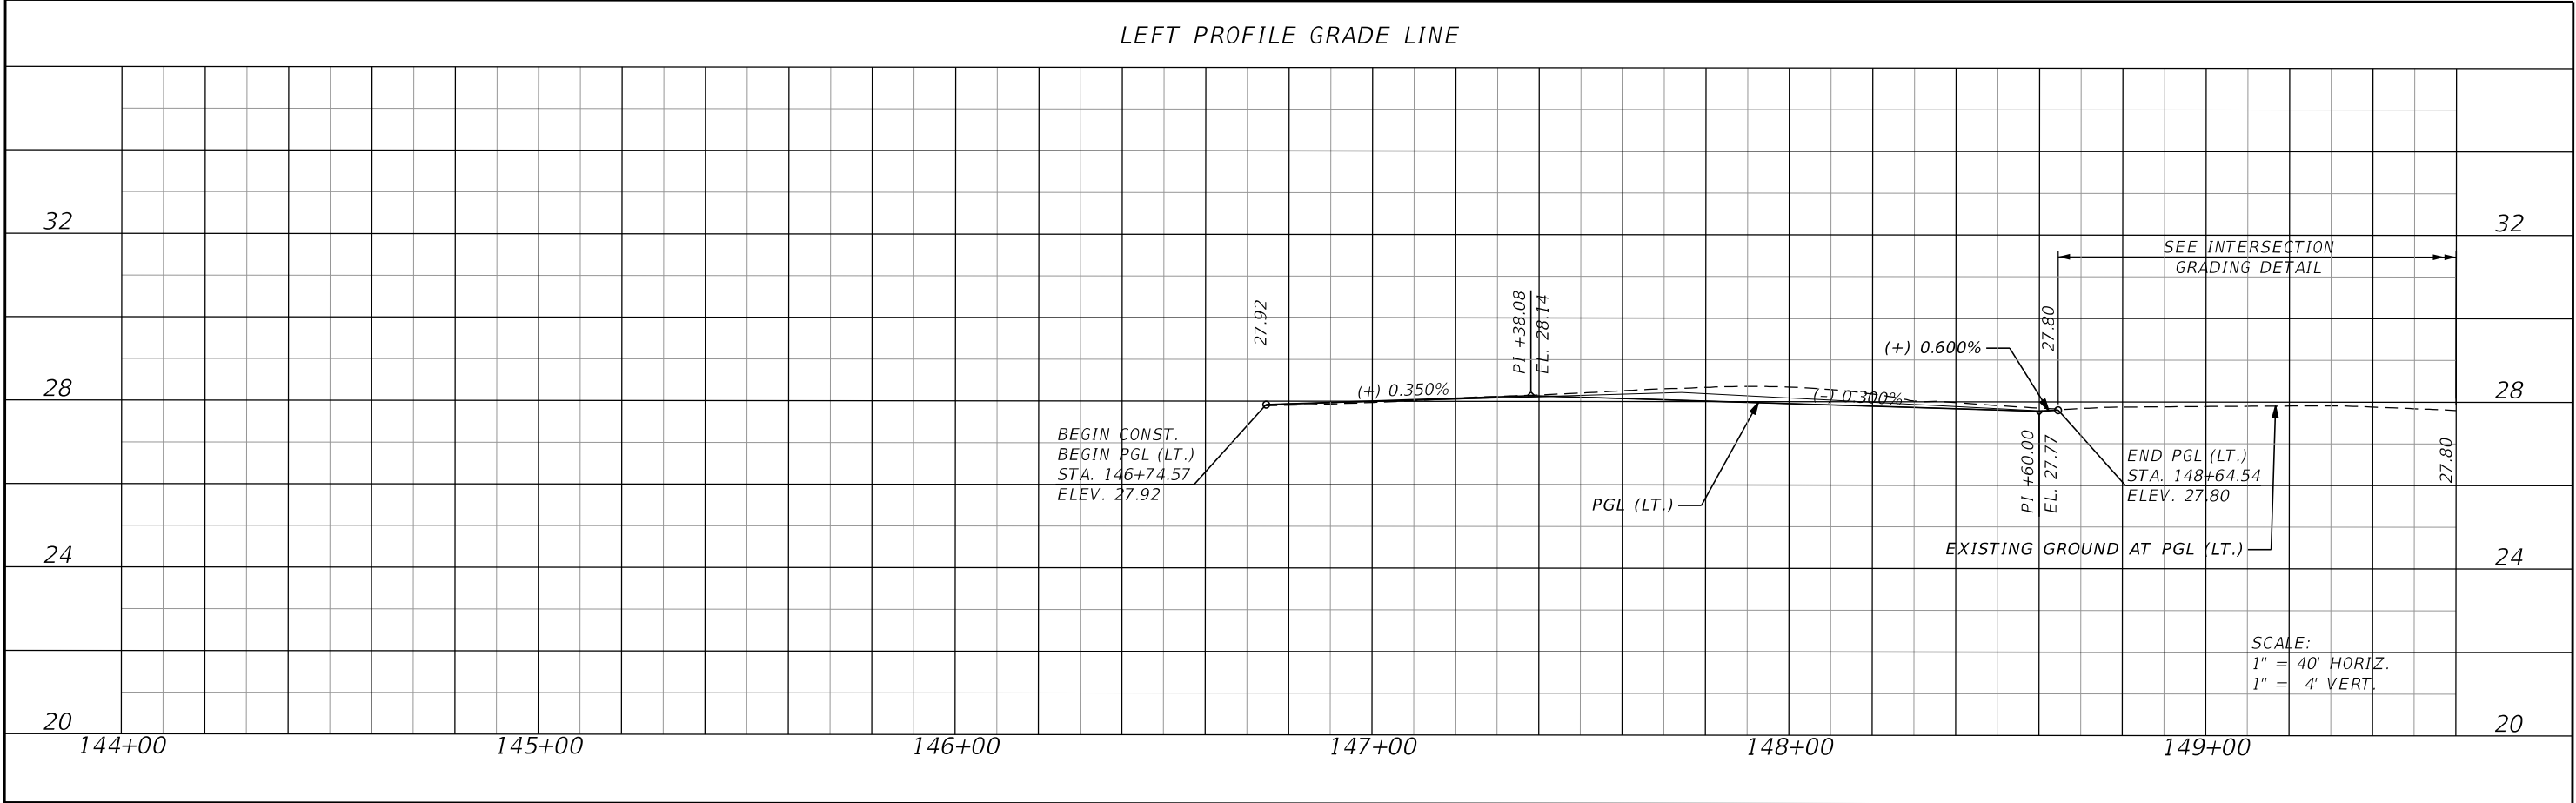



REVISIONS				JASON Y. YAM, P.E. P.E. LICENSE NUMBER 62449 CARDNO, INC. 380 PARK PLACE BOULEVARD, SUITE 300 CLEARWATER, FLORIDA 33759 CERTIFICATE OF AUTHORIZATION 29915		GATEWAY BOULEVARD AT GRIFFIN DRIVE INTERSECTION CONTROL (ROUNDBOUT)		CIP NO. 200672	SHT. NO. 18
DATE	DESCRIPTION	DATE	DESCRIPTION			ROADWAY PROFILE (1) (GATEWAY BOULEVARD)			

THE OFFICIAL RECORD OF THIS SHEET IS THE ELECTRONIC FILE DIGITALLY SIGNED AND SEALED UNDER RULE 61G15-23.004, F.A.C.

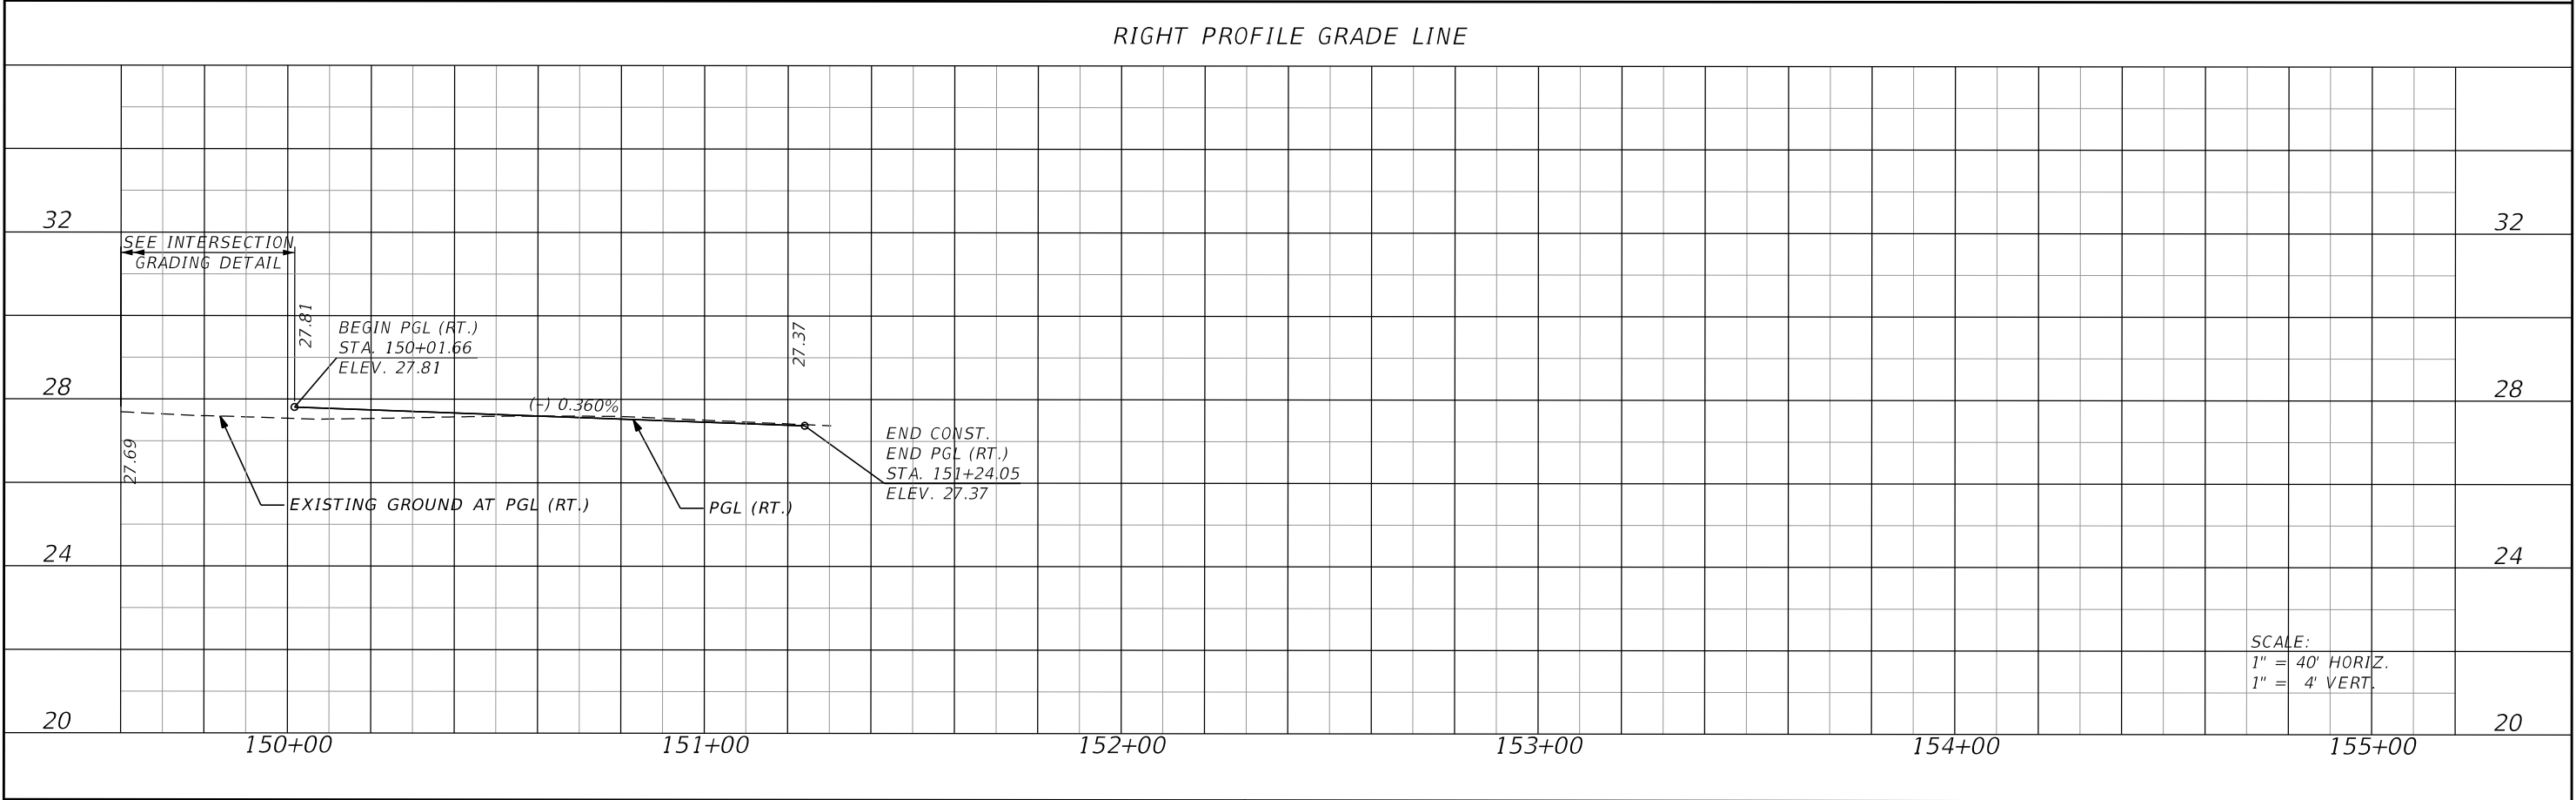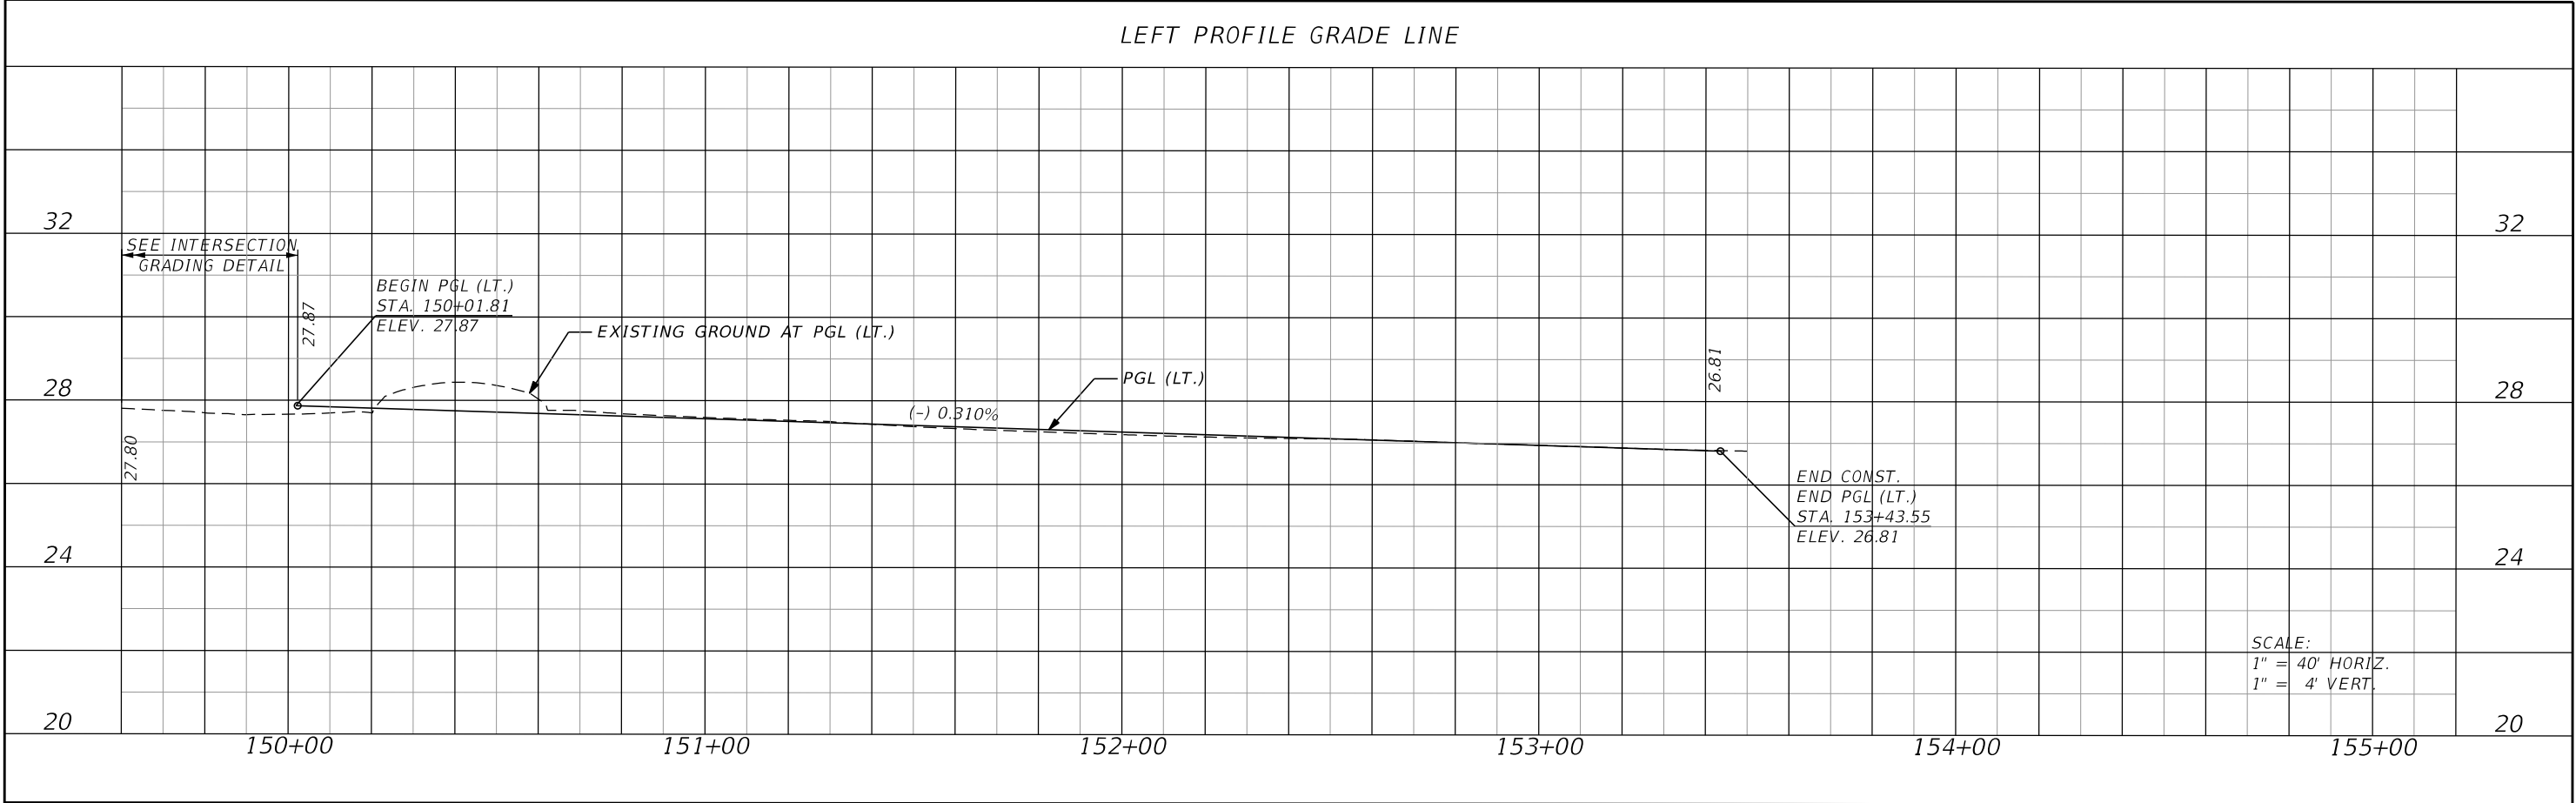



REVISIONS				JASON Y. YAM, P.E. P.E. LICENSE NUMBER 62449 CARDNO, INC. 380 PARK PLACE BOULEVARD, SUITE 300 CLEARWATER, FLORIDA 33759 CERTIFICATE OF AUTHORIZATION 29915		GATEWAY BOULEVARD AT GRIFFIN DRIVE INTERSECTION CONTROL (ROUNDAABOUT)		CIP NO. 200672	SHT. NO. 19
DATE	DESCRIPTION	DATE	DESCRIPTION			ROADWAY PROFILE (2) (GATEWAY BOULEVARD)			

THE OFFICIAL RECORD OF THIS SHEET IS THE ELECTRONIC FILE DIGITALLY SIGNED AND SEALED UNDER RULE 61G15-23.004, F.A.C.

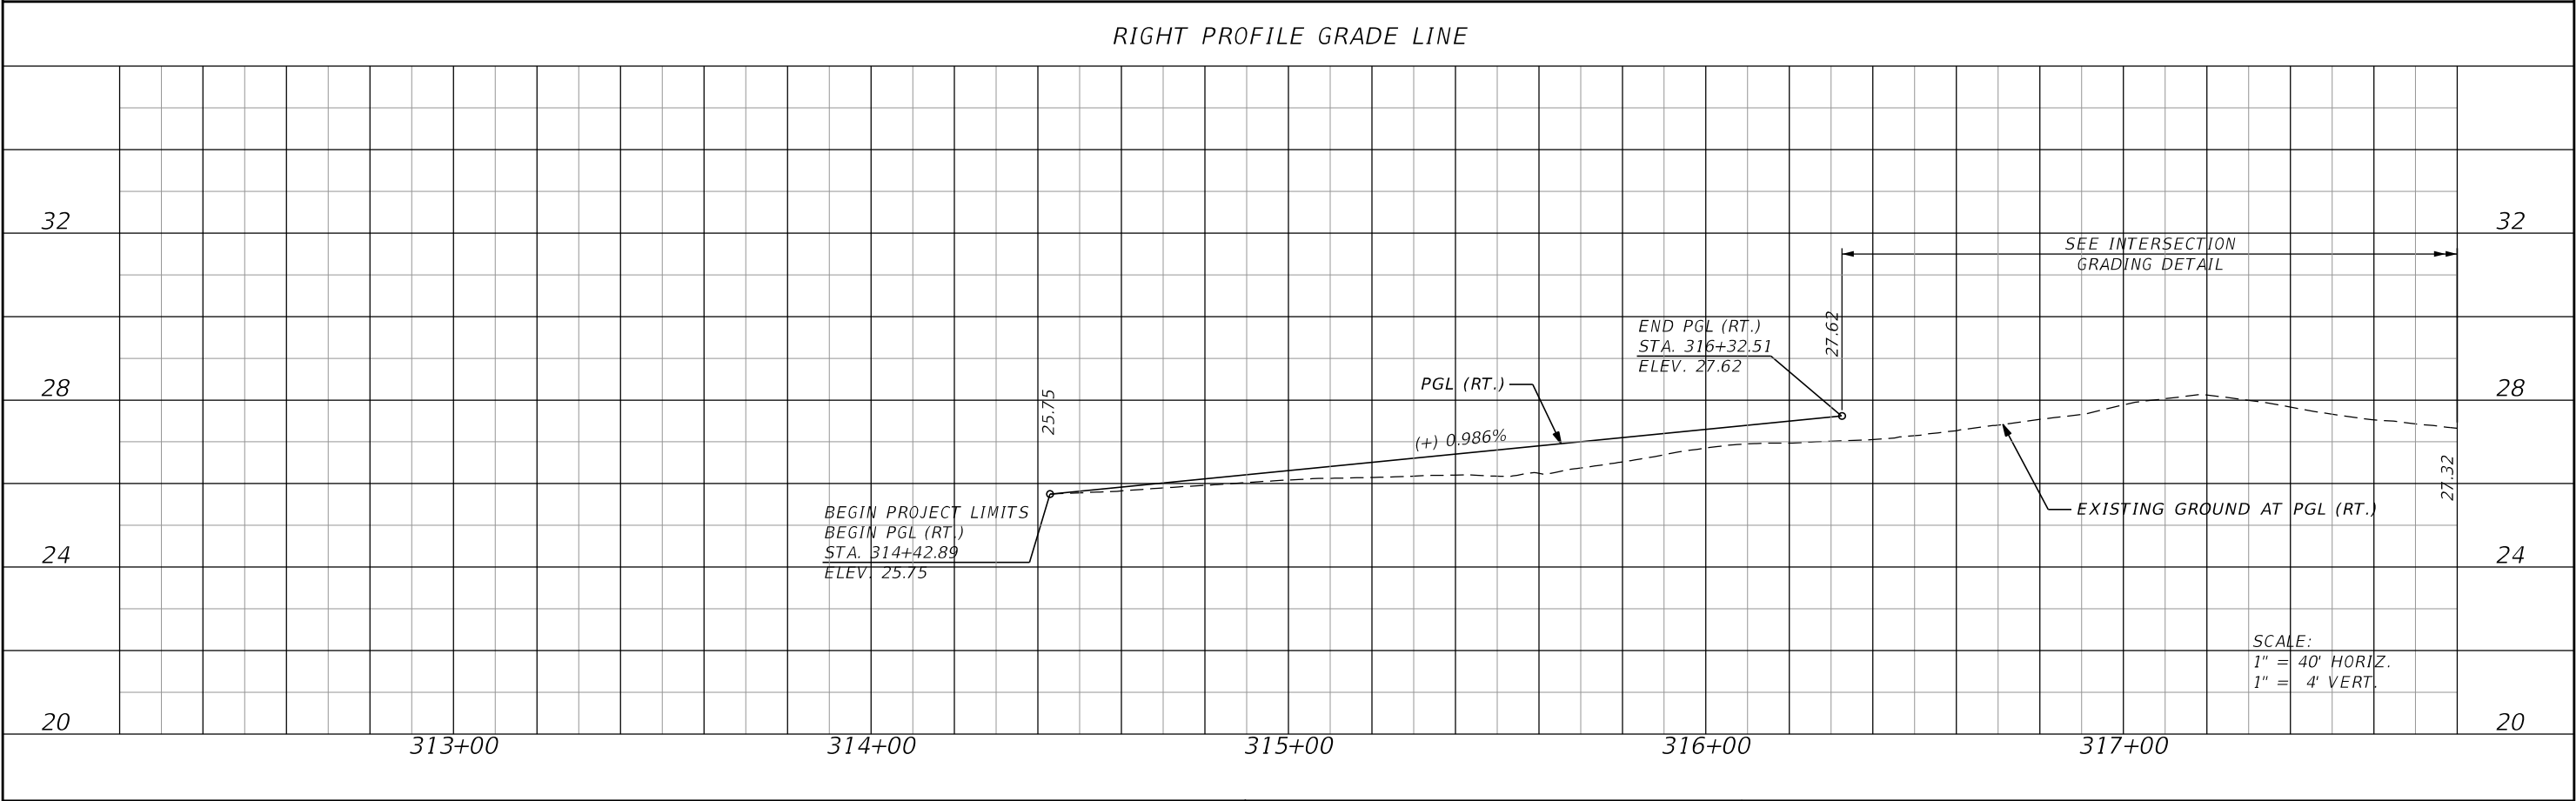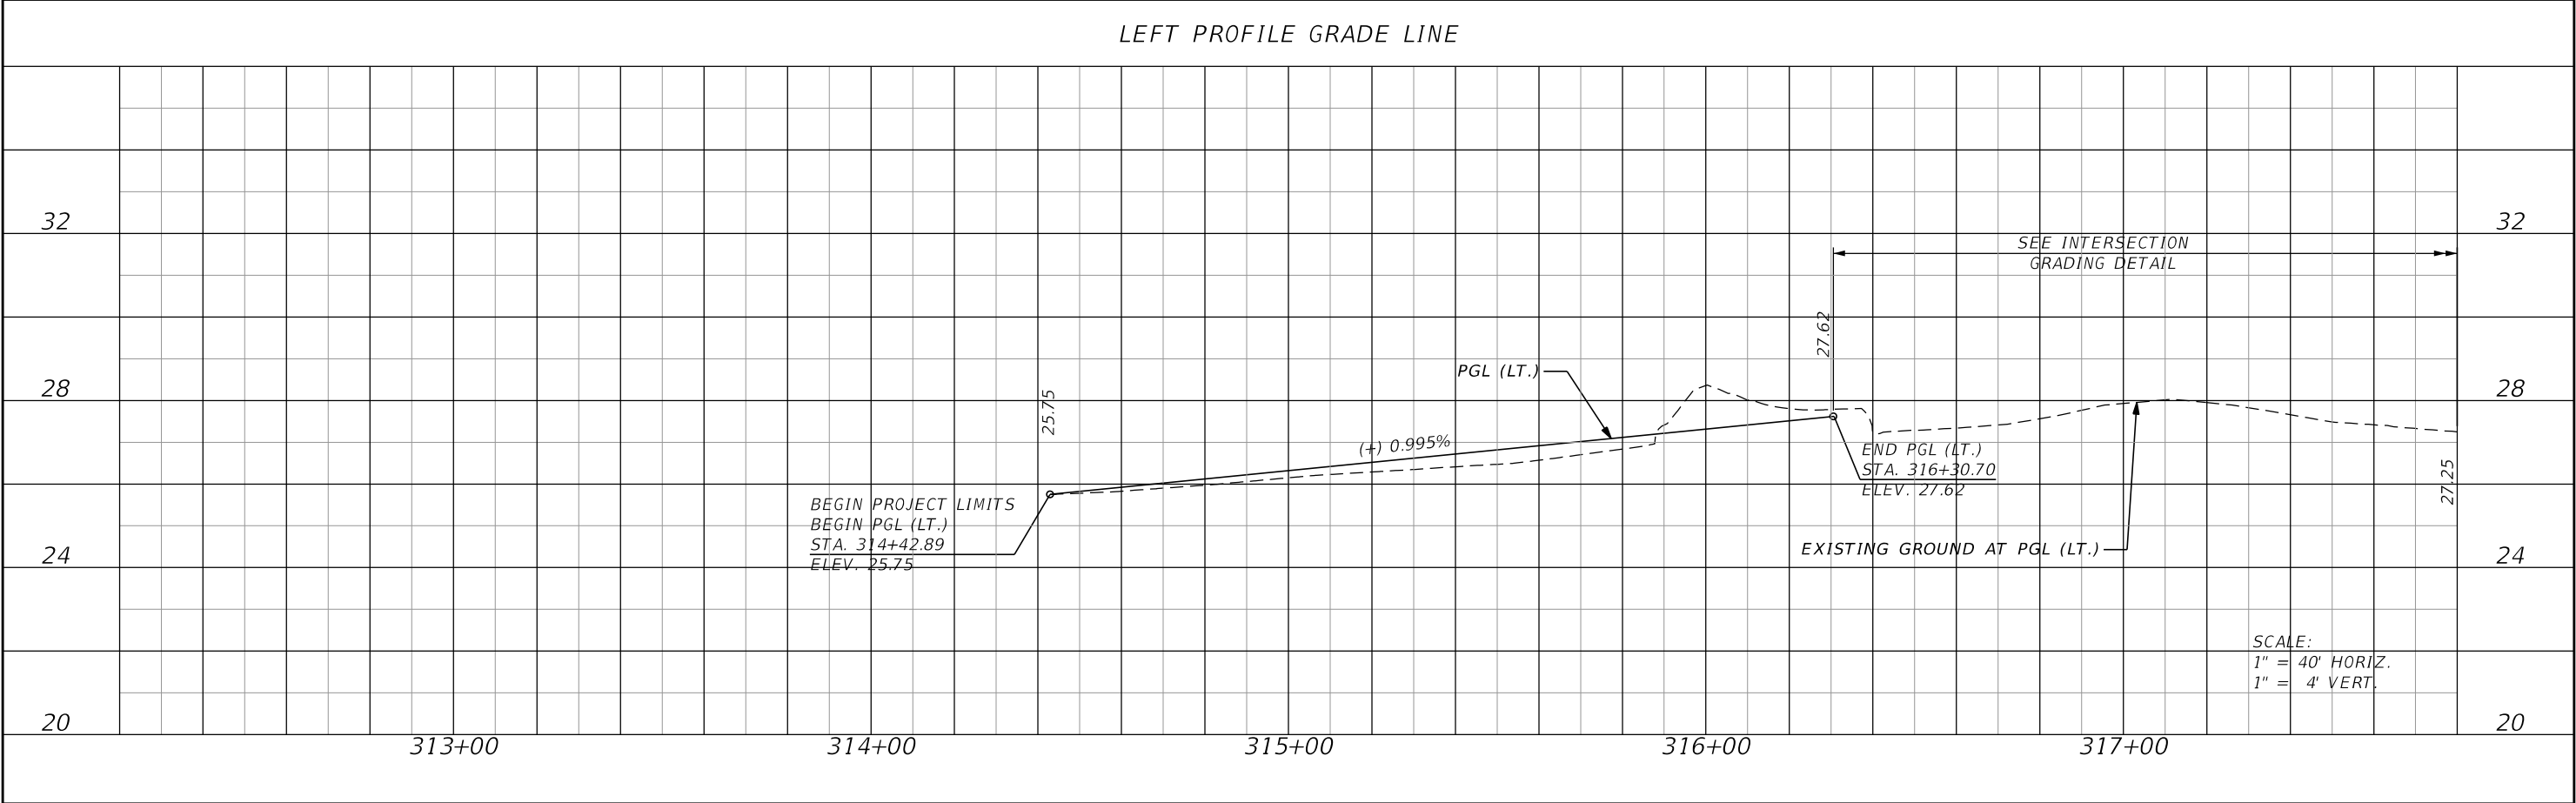


REVISIONS				JASON Y. YAM, P.E. P.E. LICENSE NUMBER 62449 CARDNO, INC. 380 PARK PLACE BOULEVARD, SUITE 300 CLEARWATER, FLORIDA 33759 CERTIFICATE OF AUTHORIZATION 29915		GATEWAY BOULEVARD AT GRIFFIN DRIVE INTERSECTION CONTROL (ROUNDBOUT)		CIP NO.	SHT. NO.
DATE	DESCRIPTION	DATE	DESCRIPTION			ROADWAY PROFILE (3) (FAIRWAY LAKES DRIVE)		200672	20

THE OFFICIAL RECORD OF THIS SHEET IS THE ELECTRONIC FILE DIGITALLY SIGNED AND SEALED UNDER RULE 61G15-23.004, F.A.C.

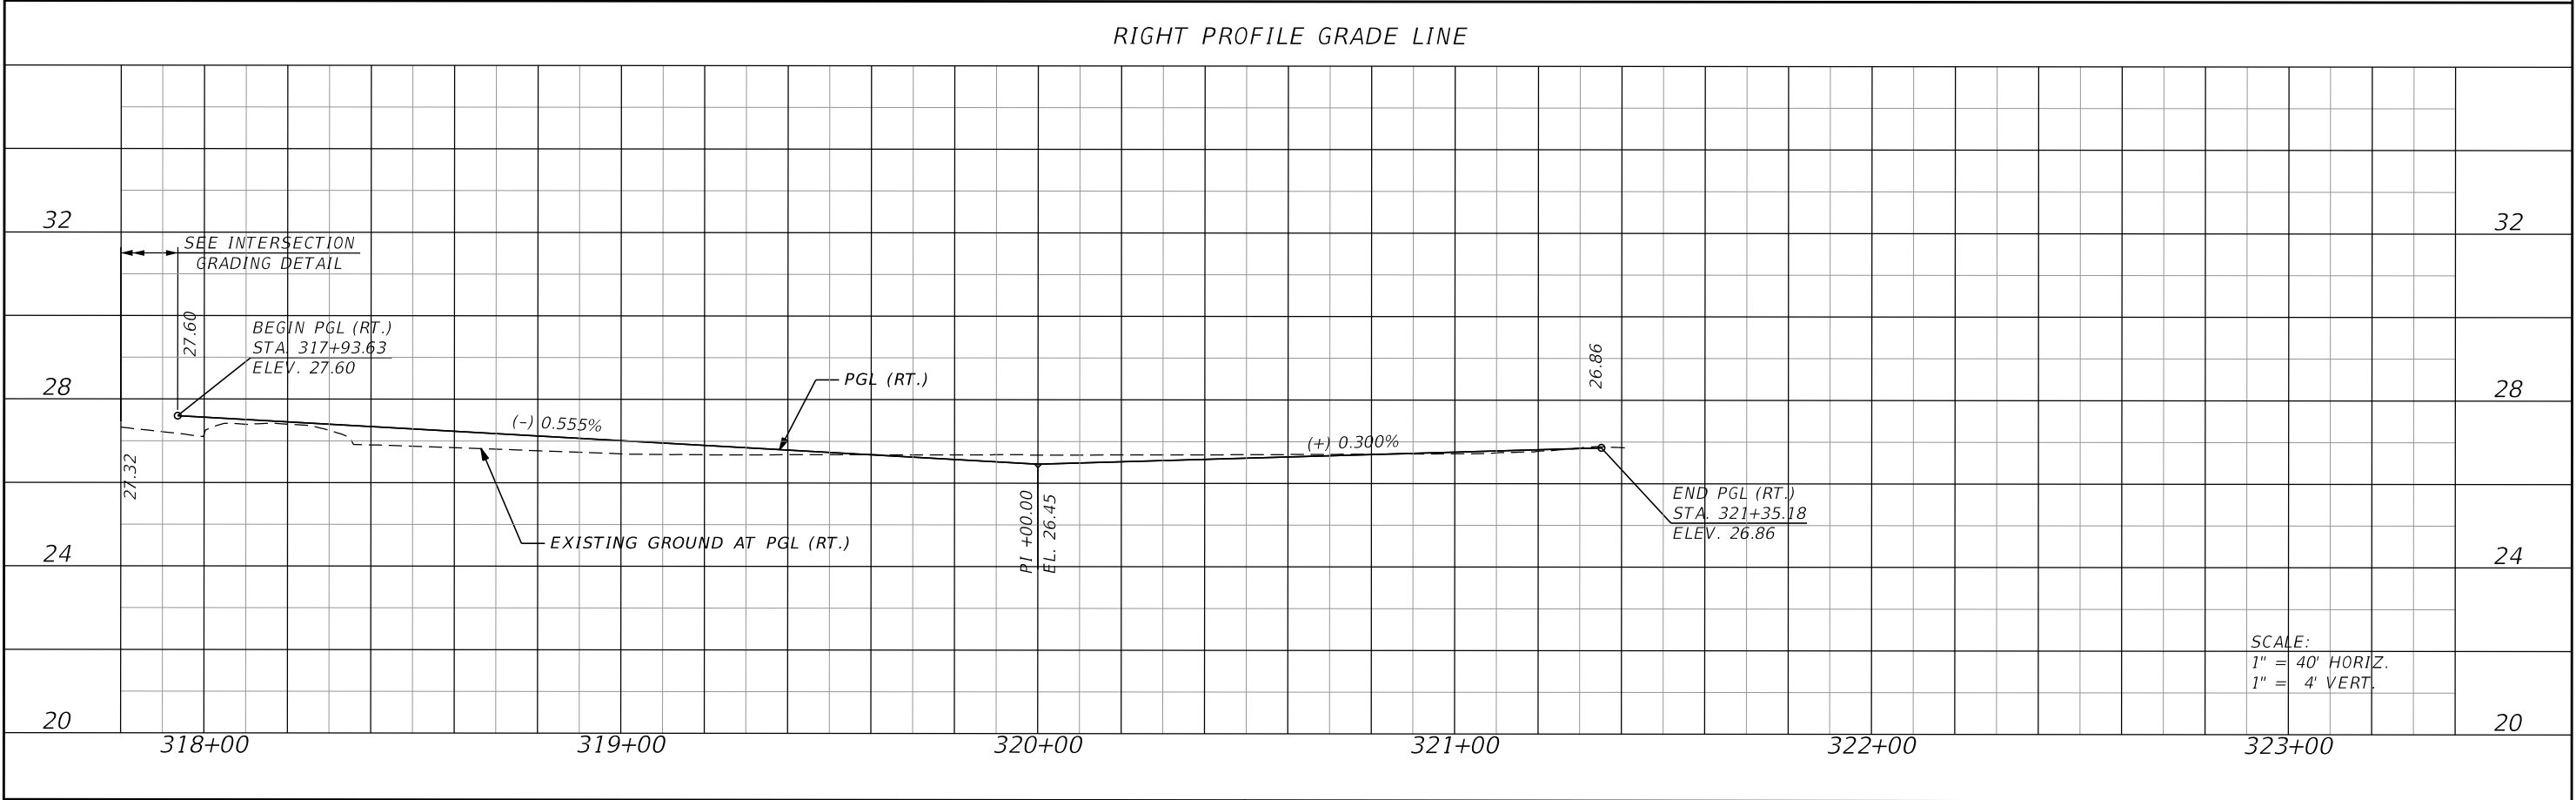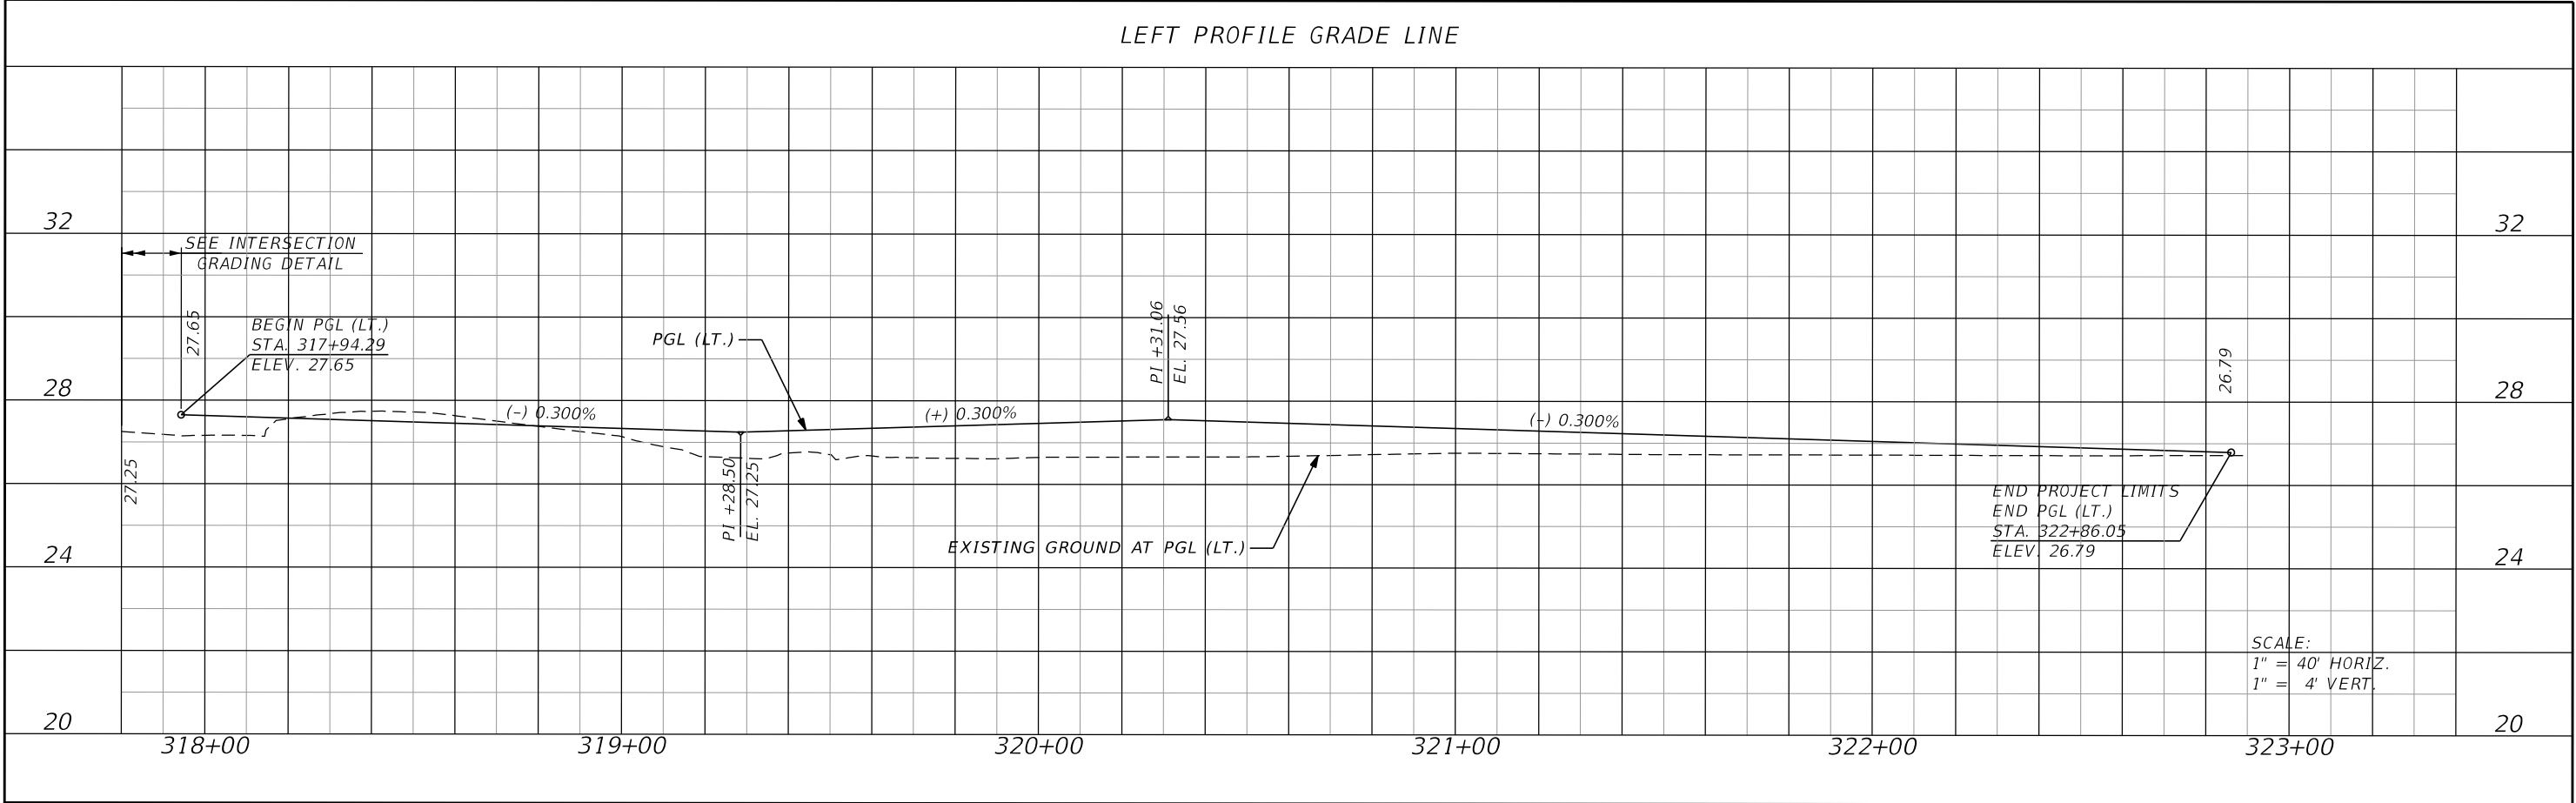


REVISIONS				JASON Y. YAM, P.E. P.E. LICENSE NUMBER 62449 CARDNO, INC. 380 PARK PLACE BOULEVARD, SUITE 300 CLEARWATER, FLORIDA 33759 CERTIFICATE OF AUTHORIZATION 29915	 DEPARTMENT OF TRANSPORTATION	GATEWAY BOULEVARD AT GRIFFIN DRIVE INTERSECTION CONTROL (ROUNDBOUT)		CIP NO.	SHT. NO.
DATE	DESCRIPTION	DATE	DESCRIPTION			ROADWAY PROFILE (4) (GRIFFIN DRIVE)			
								200672	21

THE OFFICIAL RECORD OF THIS SHEET IS THE ELECTRONIC FILE DIGITALLY SIGNED AND SEALED UNDER RULE 61G15-23.004, F.A.C.

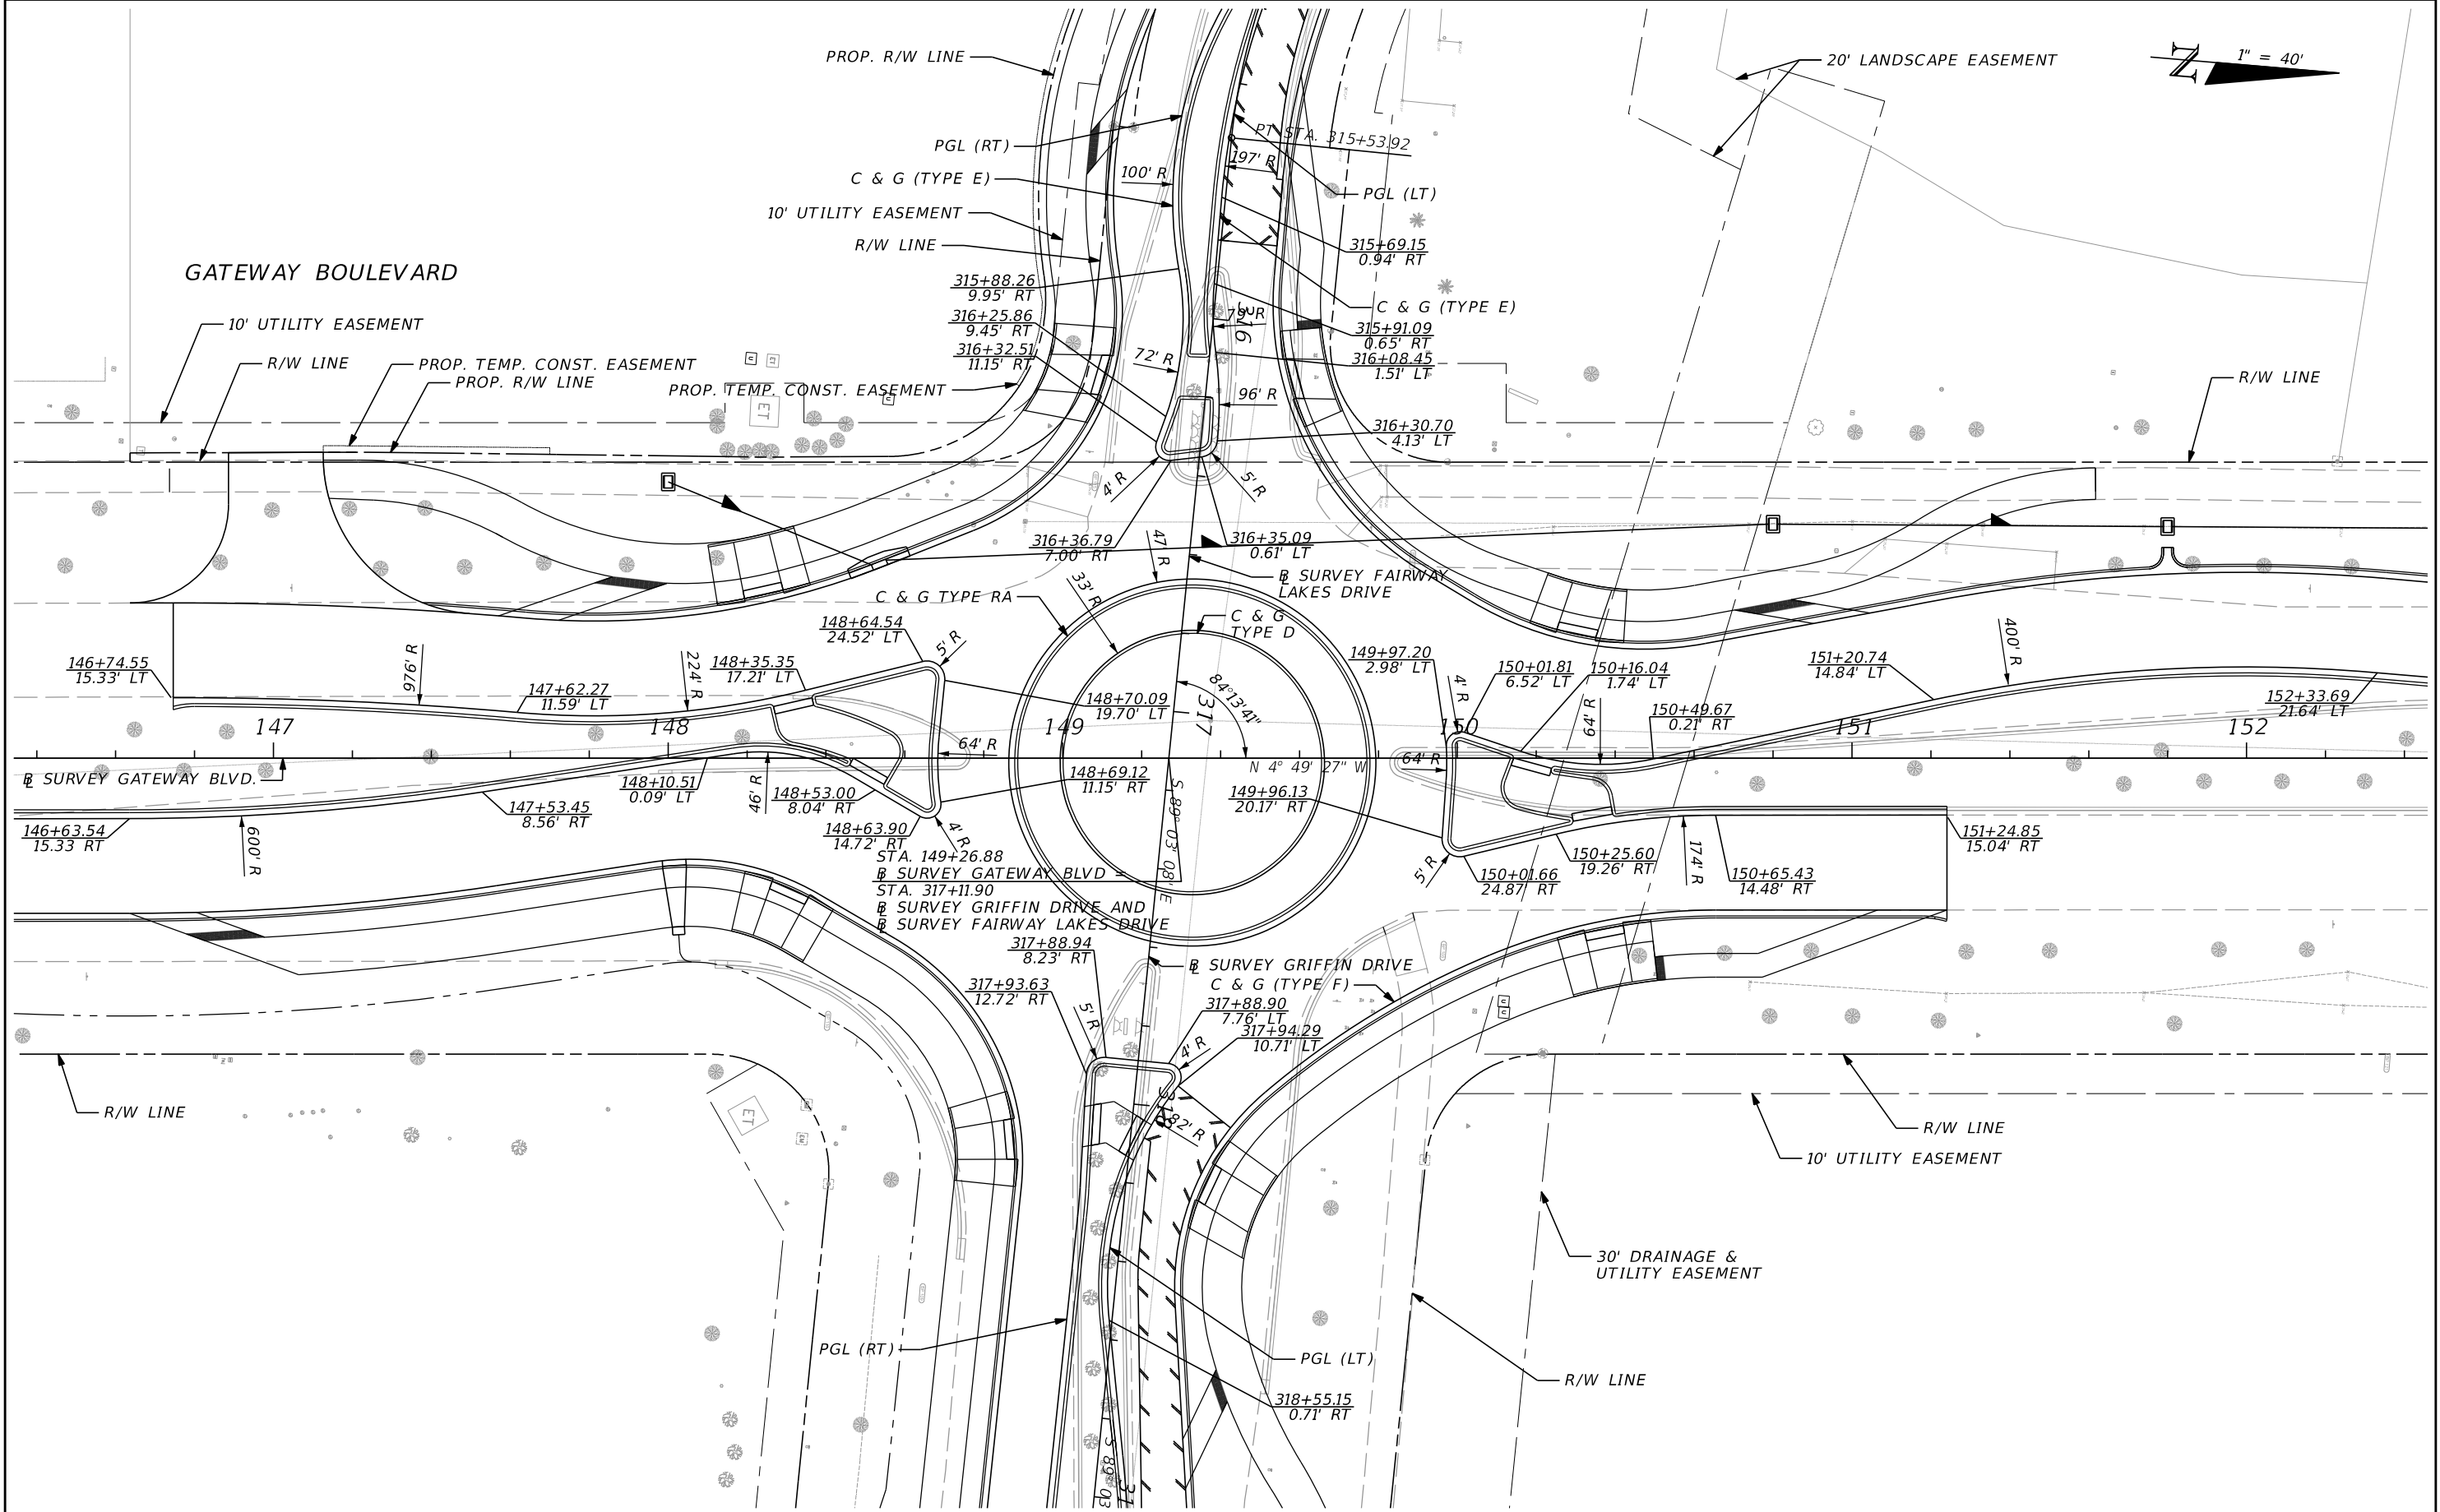


REVISIONS				JASON Y. YAM, P.E. P.E. LICENSE NUMBER 62449 CARDNO, INC. 380 PARK PLACE BOULEVARD, SUITE 300 CLEARWATER, FLORIDA 33759 CERTIFICATE OF AUTHORIZATION 29915	 DEPARTMENT OF TRANSPORTATION	GATEWAY BOULEVARD AT GRIFFIN DRIVE INTERSECTION CONTROL (ROUNDAABOUT)		COUNTY PROJECT NO.	SHT. NO.
DATE	DESCRIPTION	DATE	DESCRIPTION			INTERSECTION DETAILS		200672	22

THE OFFICIAL RECORD OF THIS SHEET IS THE ELECTRONIC FILE DIGITALLY SIGNED AND SEALED UNDER RULE 61G15-23.004, F.A.C.

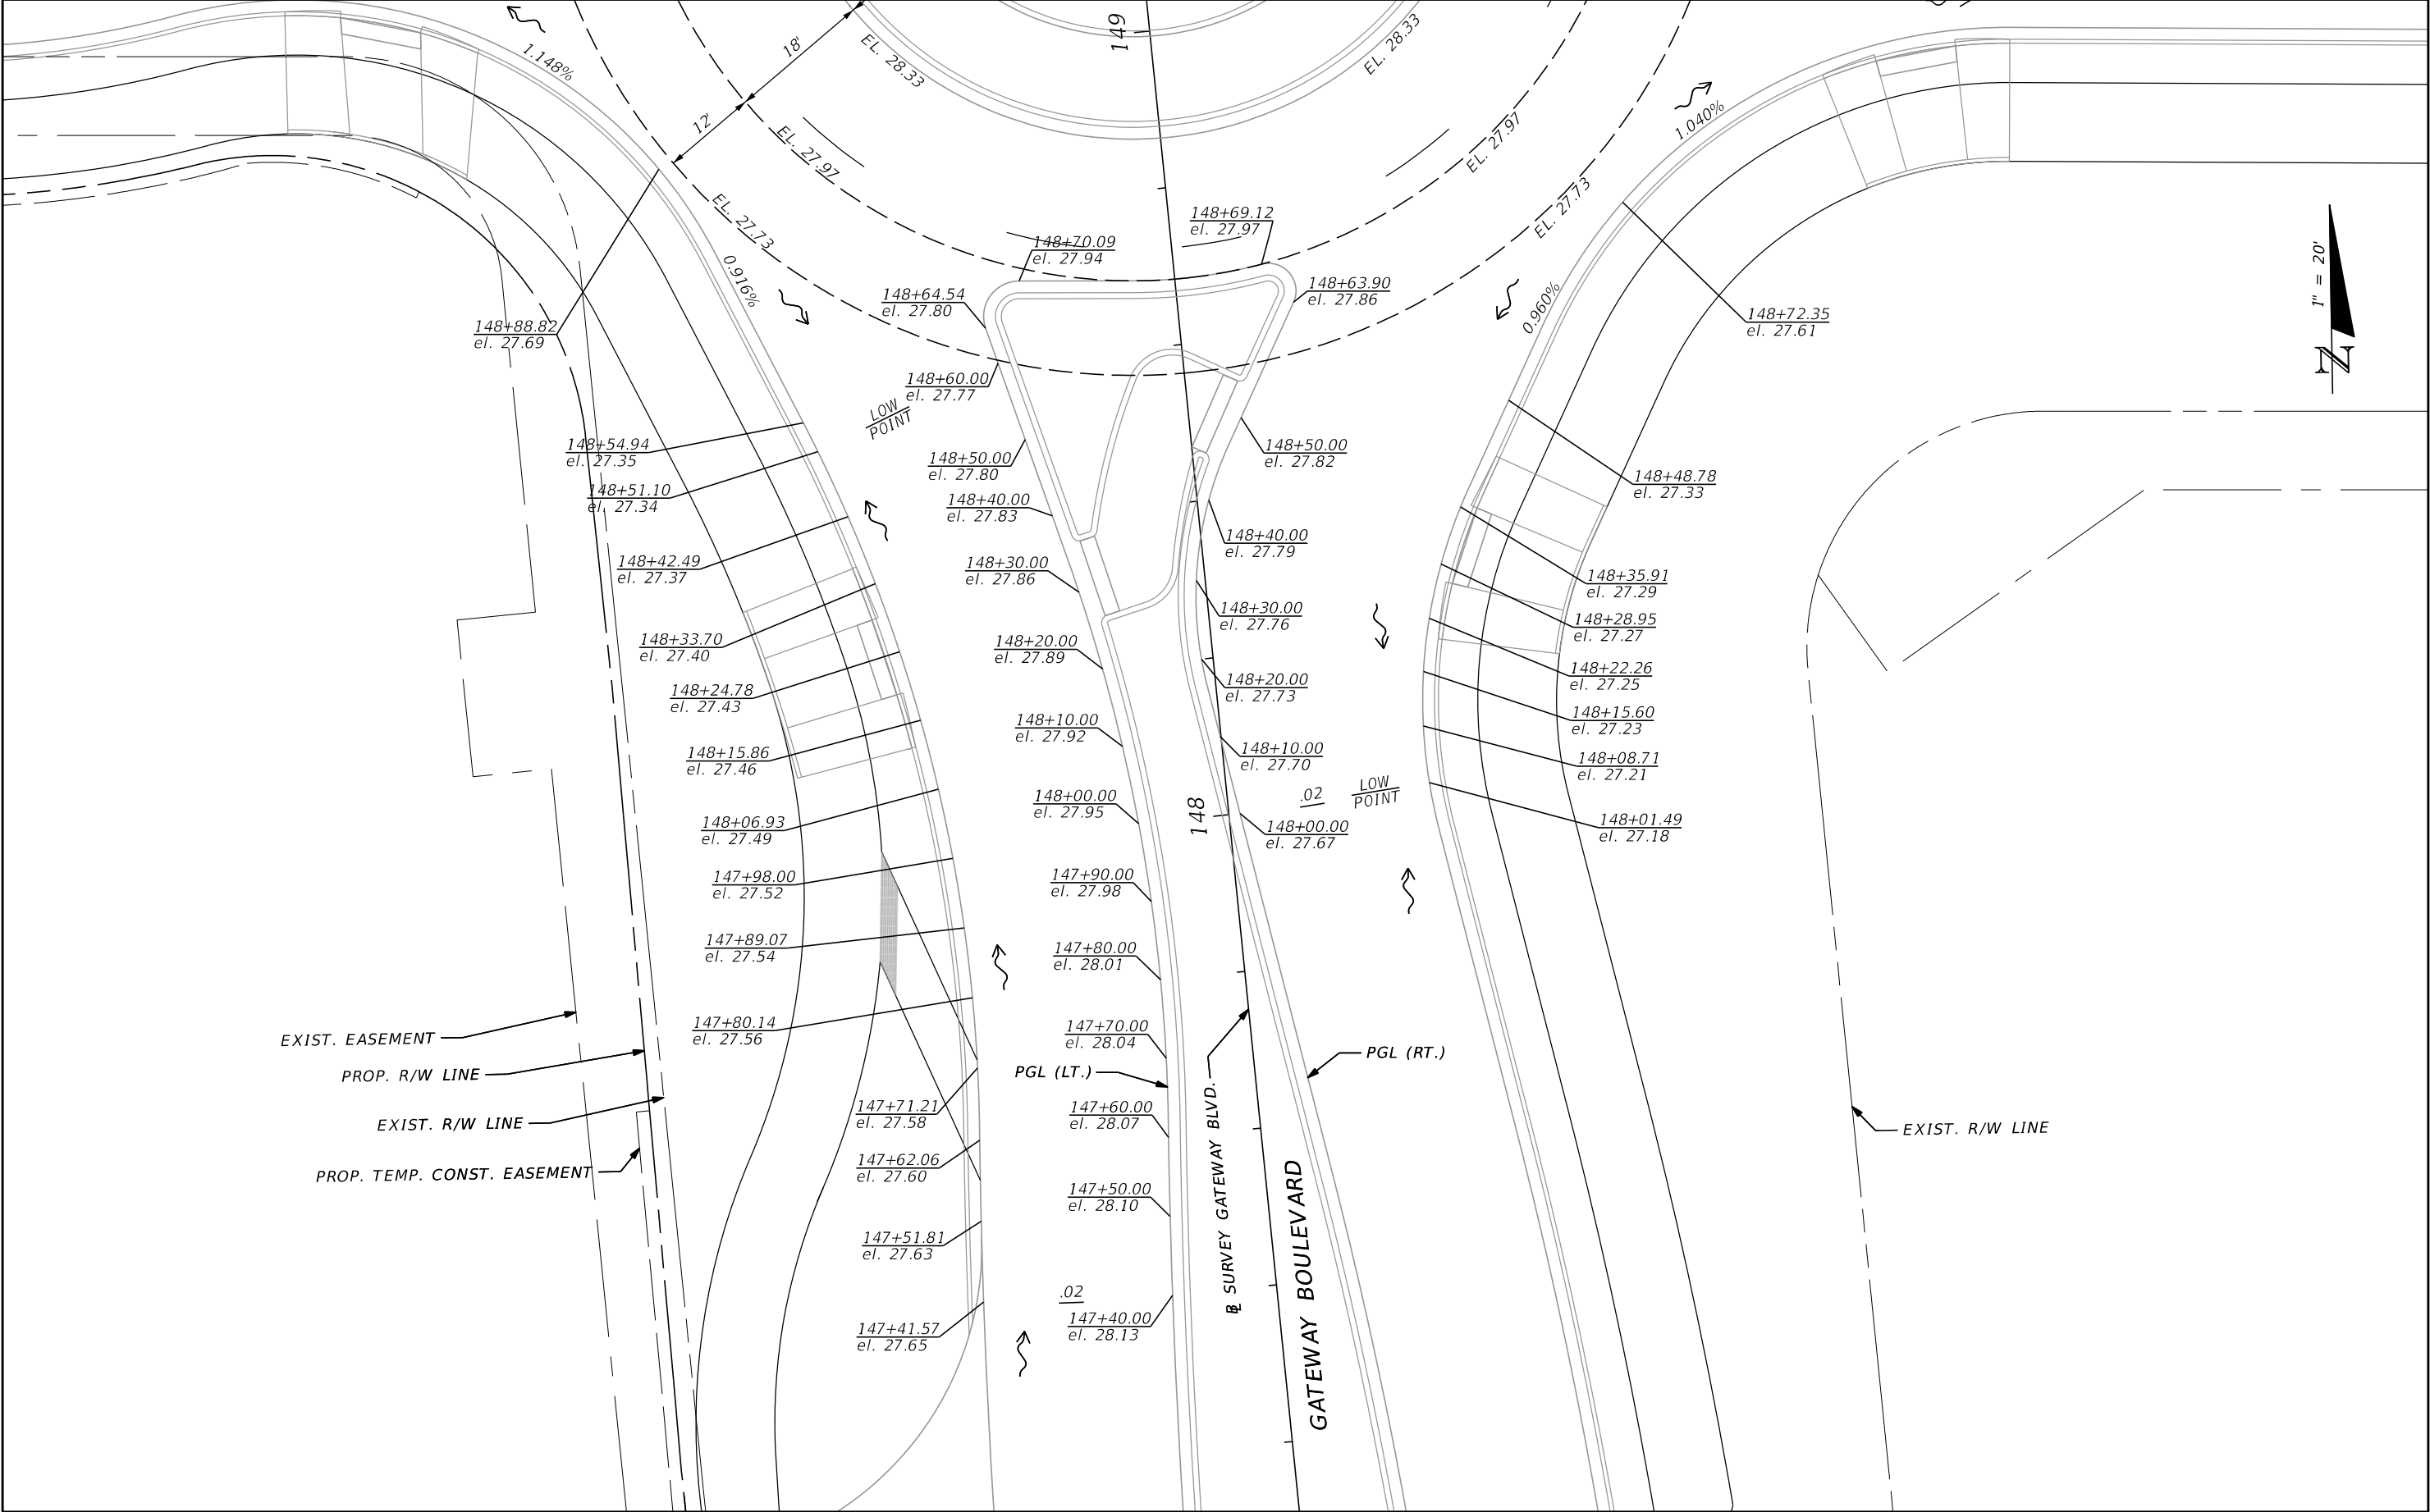


REVISIONS				JASON Y. YAM, P.E. P.E. LICENSE NUMBER 62449 CARDNO, INC. 380 PARK PLACE BOULEVARD, SUITE 300 CLEARWATER, FLORIDA 33759 CERTIFICATE OF AUTHORIZATION 29915	 DEPARTMENT OF TRANSPORTATION	GATEWAY BOULEVARD AT GRIFFIN DRIVE INTERSECTION CONTROL (ROUNDAABOUT)		COUNTY PROJECT NO.	SHT. NO.
DATE	DESCRIPTION	DATE	DESCRIPTION			INTERSECTION GRADING DETAIL (1)		200672	23

THE OFFICIAL RECORD OF THIS SHEET IS THE ELECTRONIC FILE DIGITALLY SIGNED AND SEALED UNDER RULE 61G15-23.004, F.A.C.

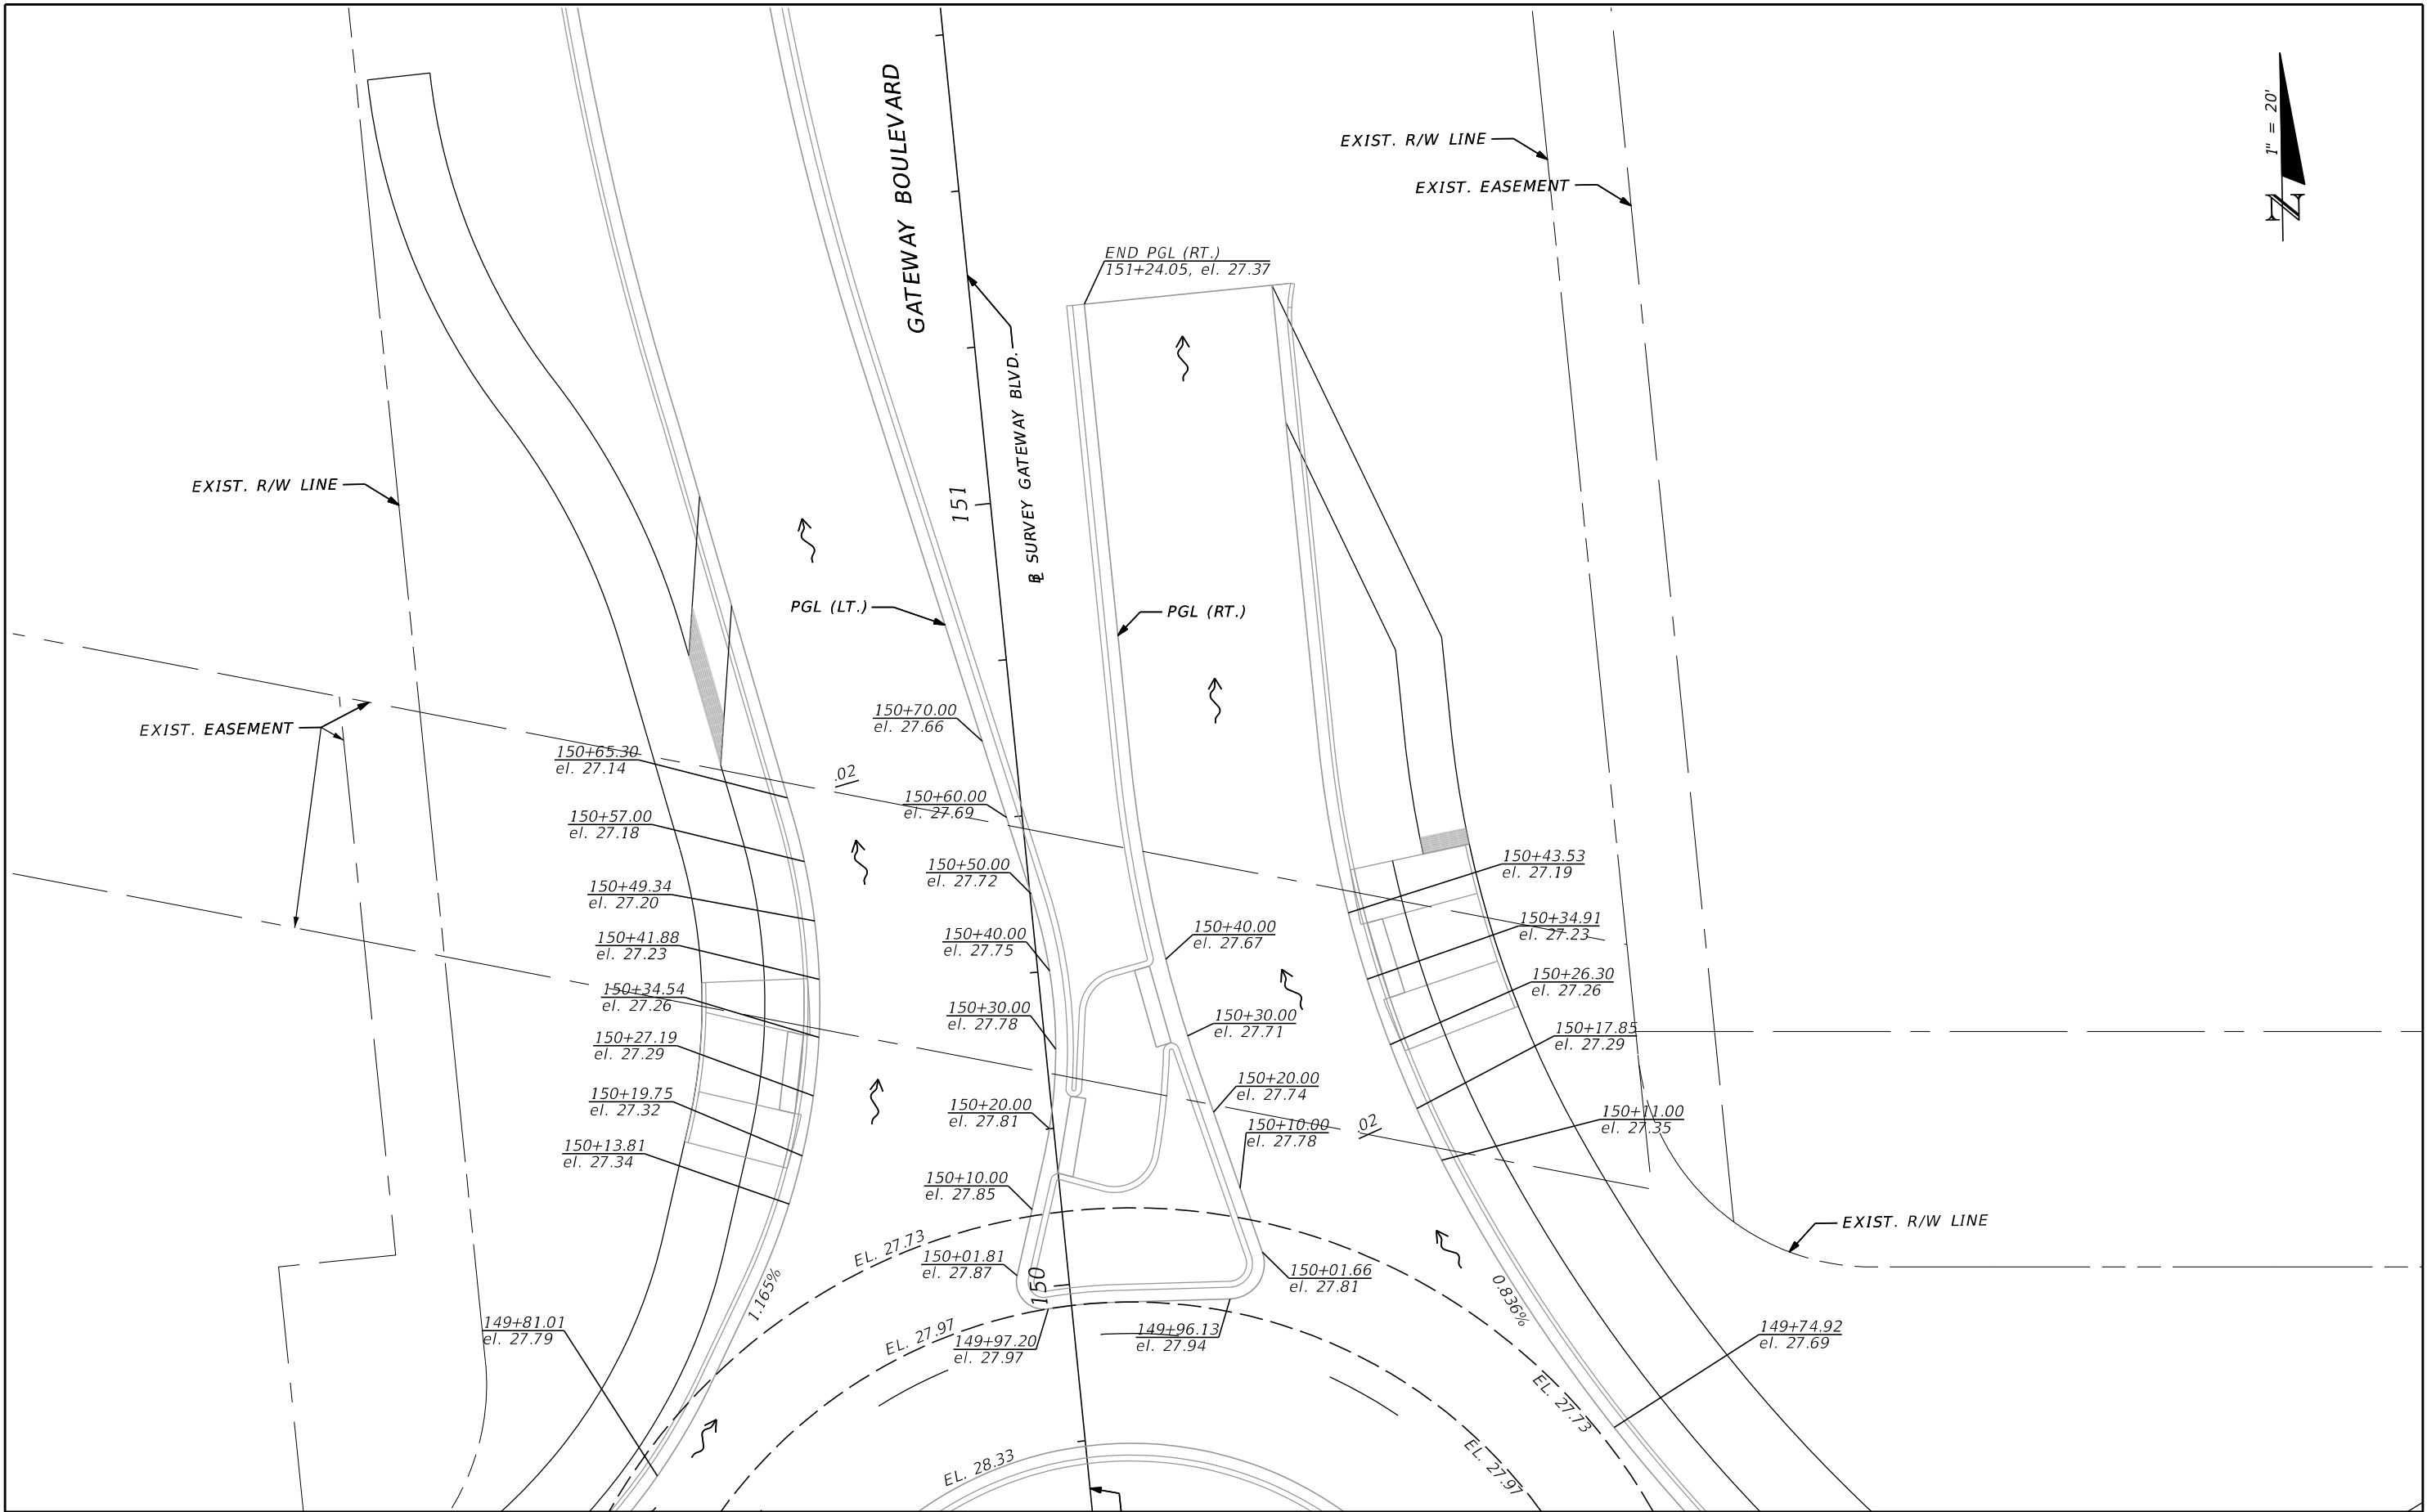


REVISIONS				JASON Y. YAM, P.E. P.E. LICENSE NUMBER 62449 CARDNO, INC. 380 PARK PLACE BOULEVARD, SUITE 300 CLEARWATER, FLORIDA 33759 CERTIFICATE OF AUTHORIZATION 29915	 DEPARTMENT OF TRANSPORTATION	GATEWAY BOULEVARD AT GRIFFIN DRIVE INTERSECTION CONTROL (ROUNDAABOUT)		COUNTY PROJECT NO.	SHT. NO.
DATE	DESCRIPTION	DATE	DESCRIPTION			INTERSECTION GRADING DETAIL (2)		200672	24

THE OFFICIAL RECORD OF THIS SHEET IS THE ELECTRONIC FILE DIGITALLY SIGNED AND SEALED UNDER RULE 61G15-23.004, F.A.C.

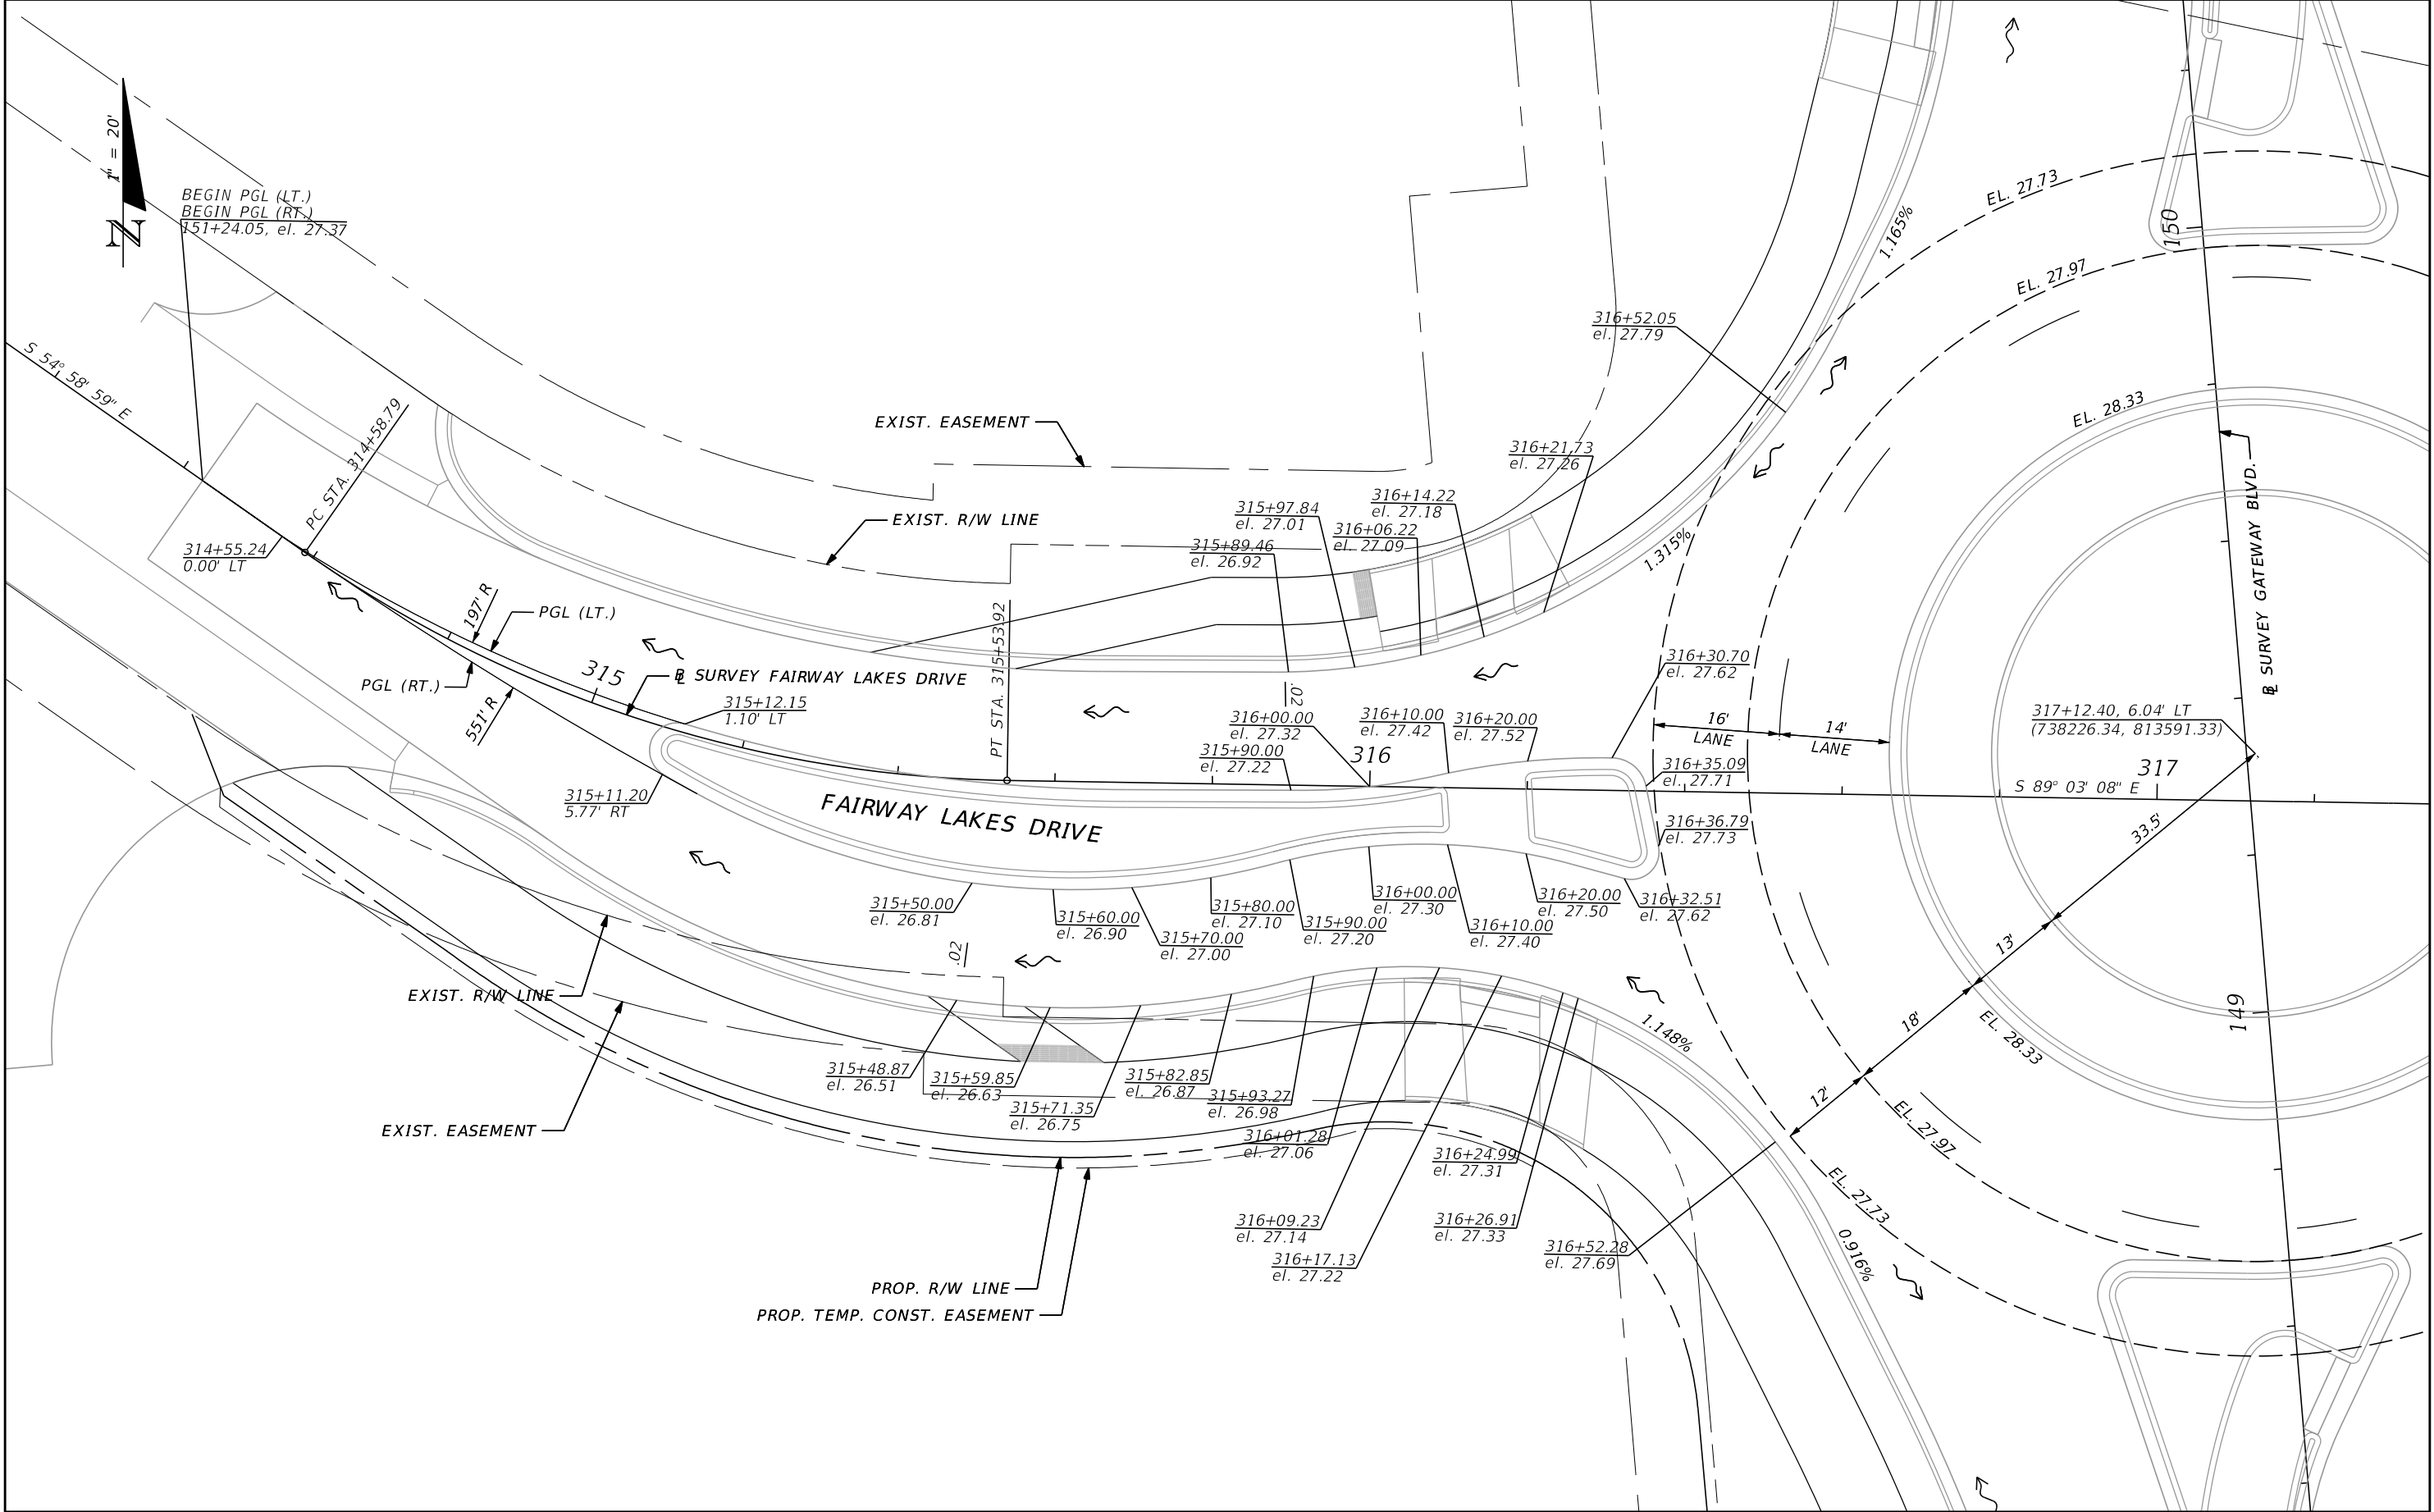


REVISIONS				JASON Y. YAM, P.E. P.E. LICENSE NUMBER 62449 CARDNO, INC. 380 PARK PLACE BOULEVARD, SUITE 300 CLEARWATER, FLORIDA 33759 CERTIFICATE OF AUTHORIZATION 29915	 DEPARTMENT OF TRANSPORTATION	GATEWAY BOULEVARD AT GRIFFIN DRIVE INTERSECTION CONTROL (ROUNDABOUT)		COUNTY PROJECT NO.	SHT. NO.
DATE	DESCRIPTION	DATE	DESCRIPTION			INTERSECTION GRADING DETAIL (3)		200672	25

THE OFFICIAL RECORD OF THIS SHEET IS THE ELECTRONIC FILE DIGITALLY SIGNED AND SEALED UNDER RULE 61G15-23.004, F.A.C.

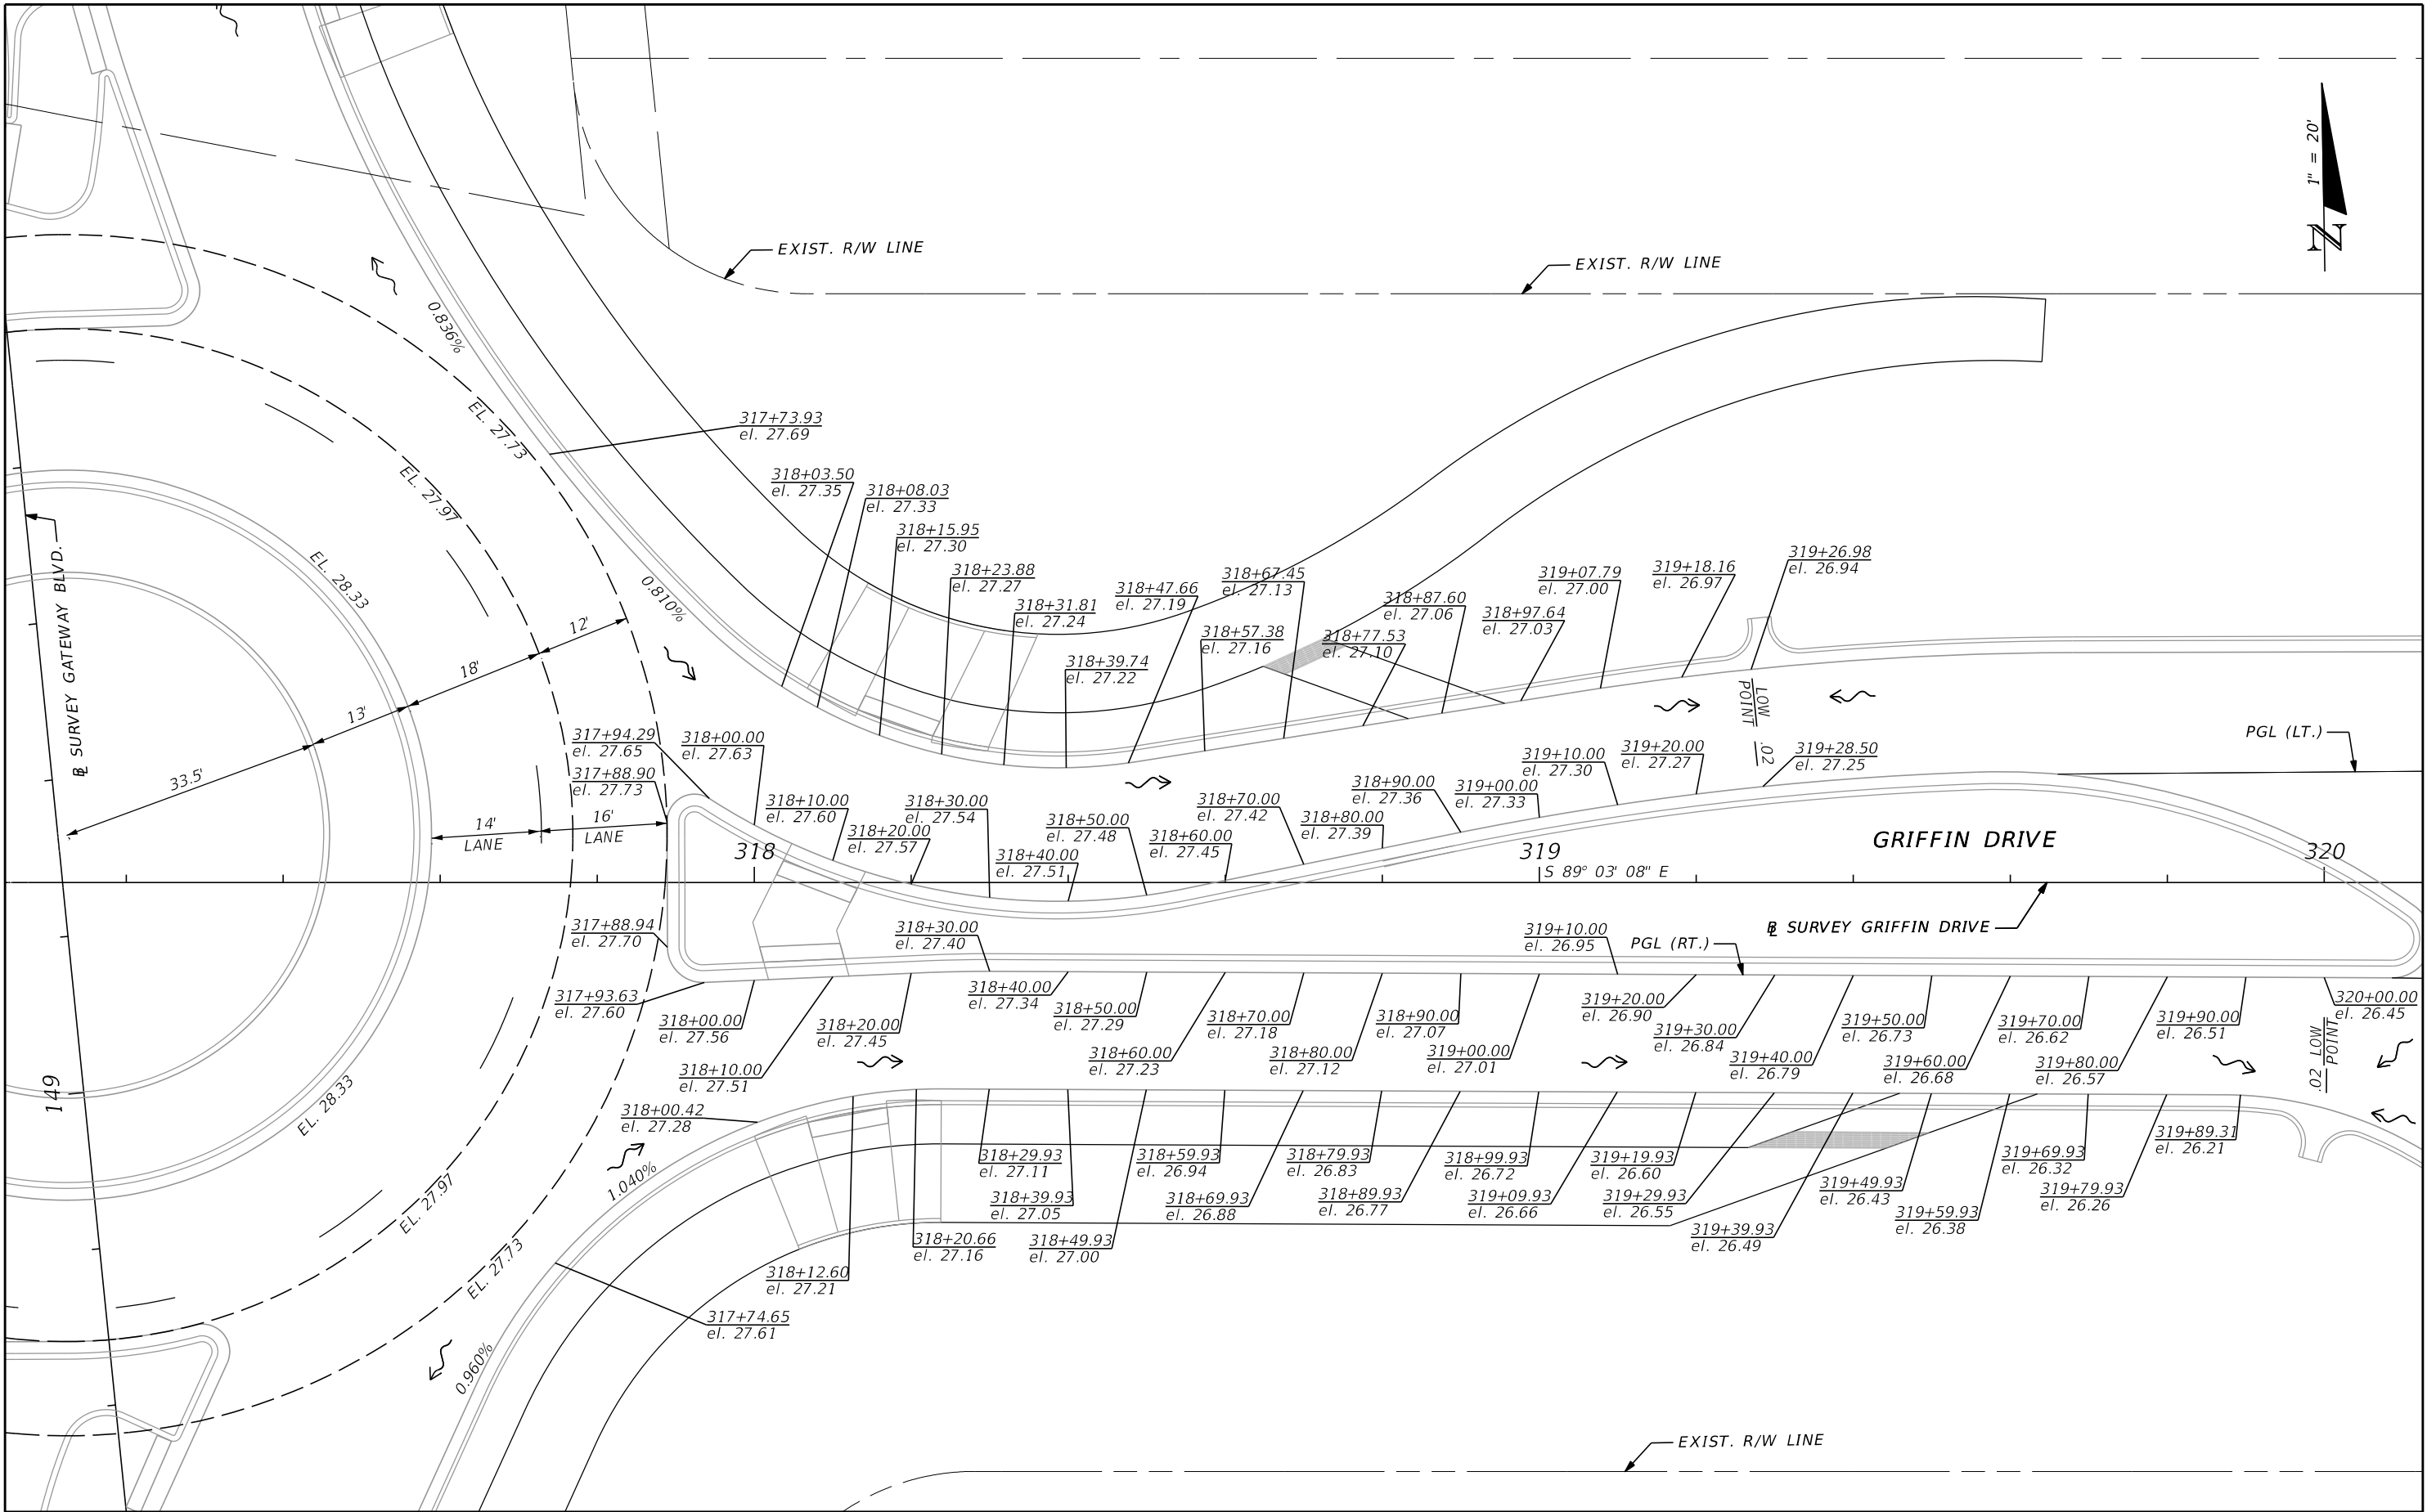


REVISIONS				JASON Y. YAM, P.E. P.E. LICENSE NUMBER 62449 CARDNO, INC. 380 PARK PLACE BOULEVARD, SUITE 300 CLEARWATER, FLORIDA 33759 CERTIFICATE OF AUTHORIZATION 29915		GATEWAY BOULEVARD AT GRIFFIN DRIVE INTERSECTION CONTROL (ROUNDBOUT)		COUNTY PROJECT NO.	SHT. NO.
DATE	DESCRIPTION	DATE	DESCRIPTION			INTERSECTION GRADING DETAIL (4)		200672	26

THE OFFICIAL RECORD OF THIS SHEET IS THE ELECTRONIC FILE DIGITALLY SIGNED AND SEALED UNDER RULE 61G15-23.004, F.A.C.

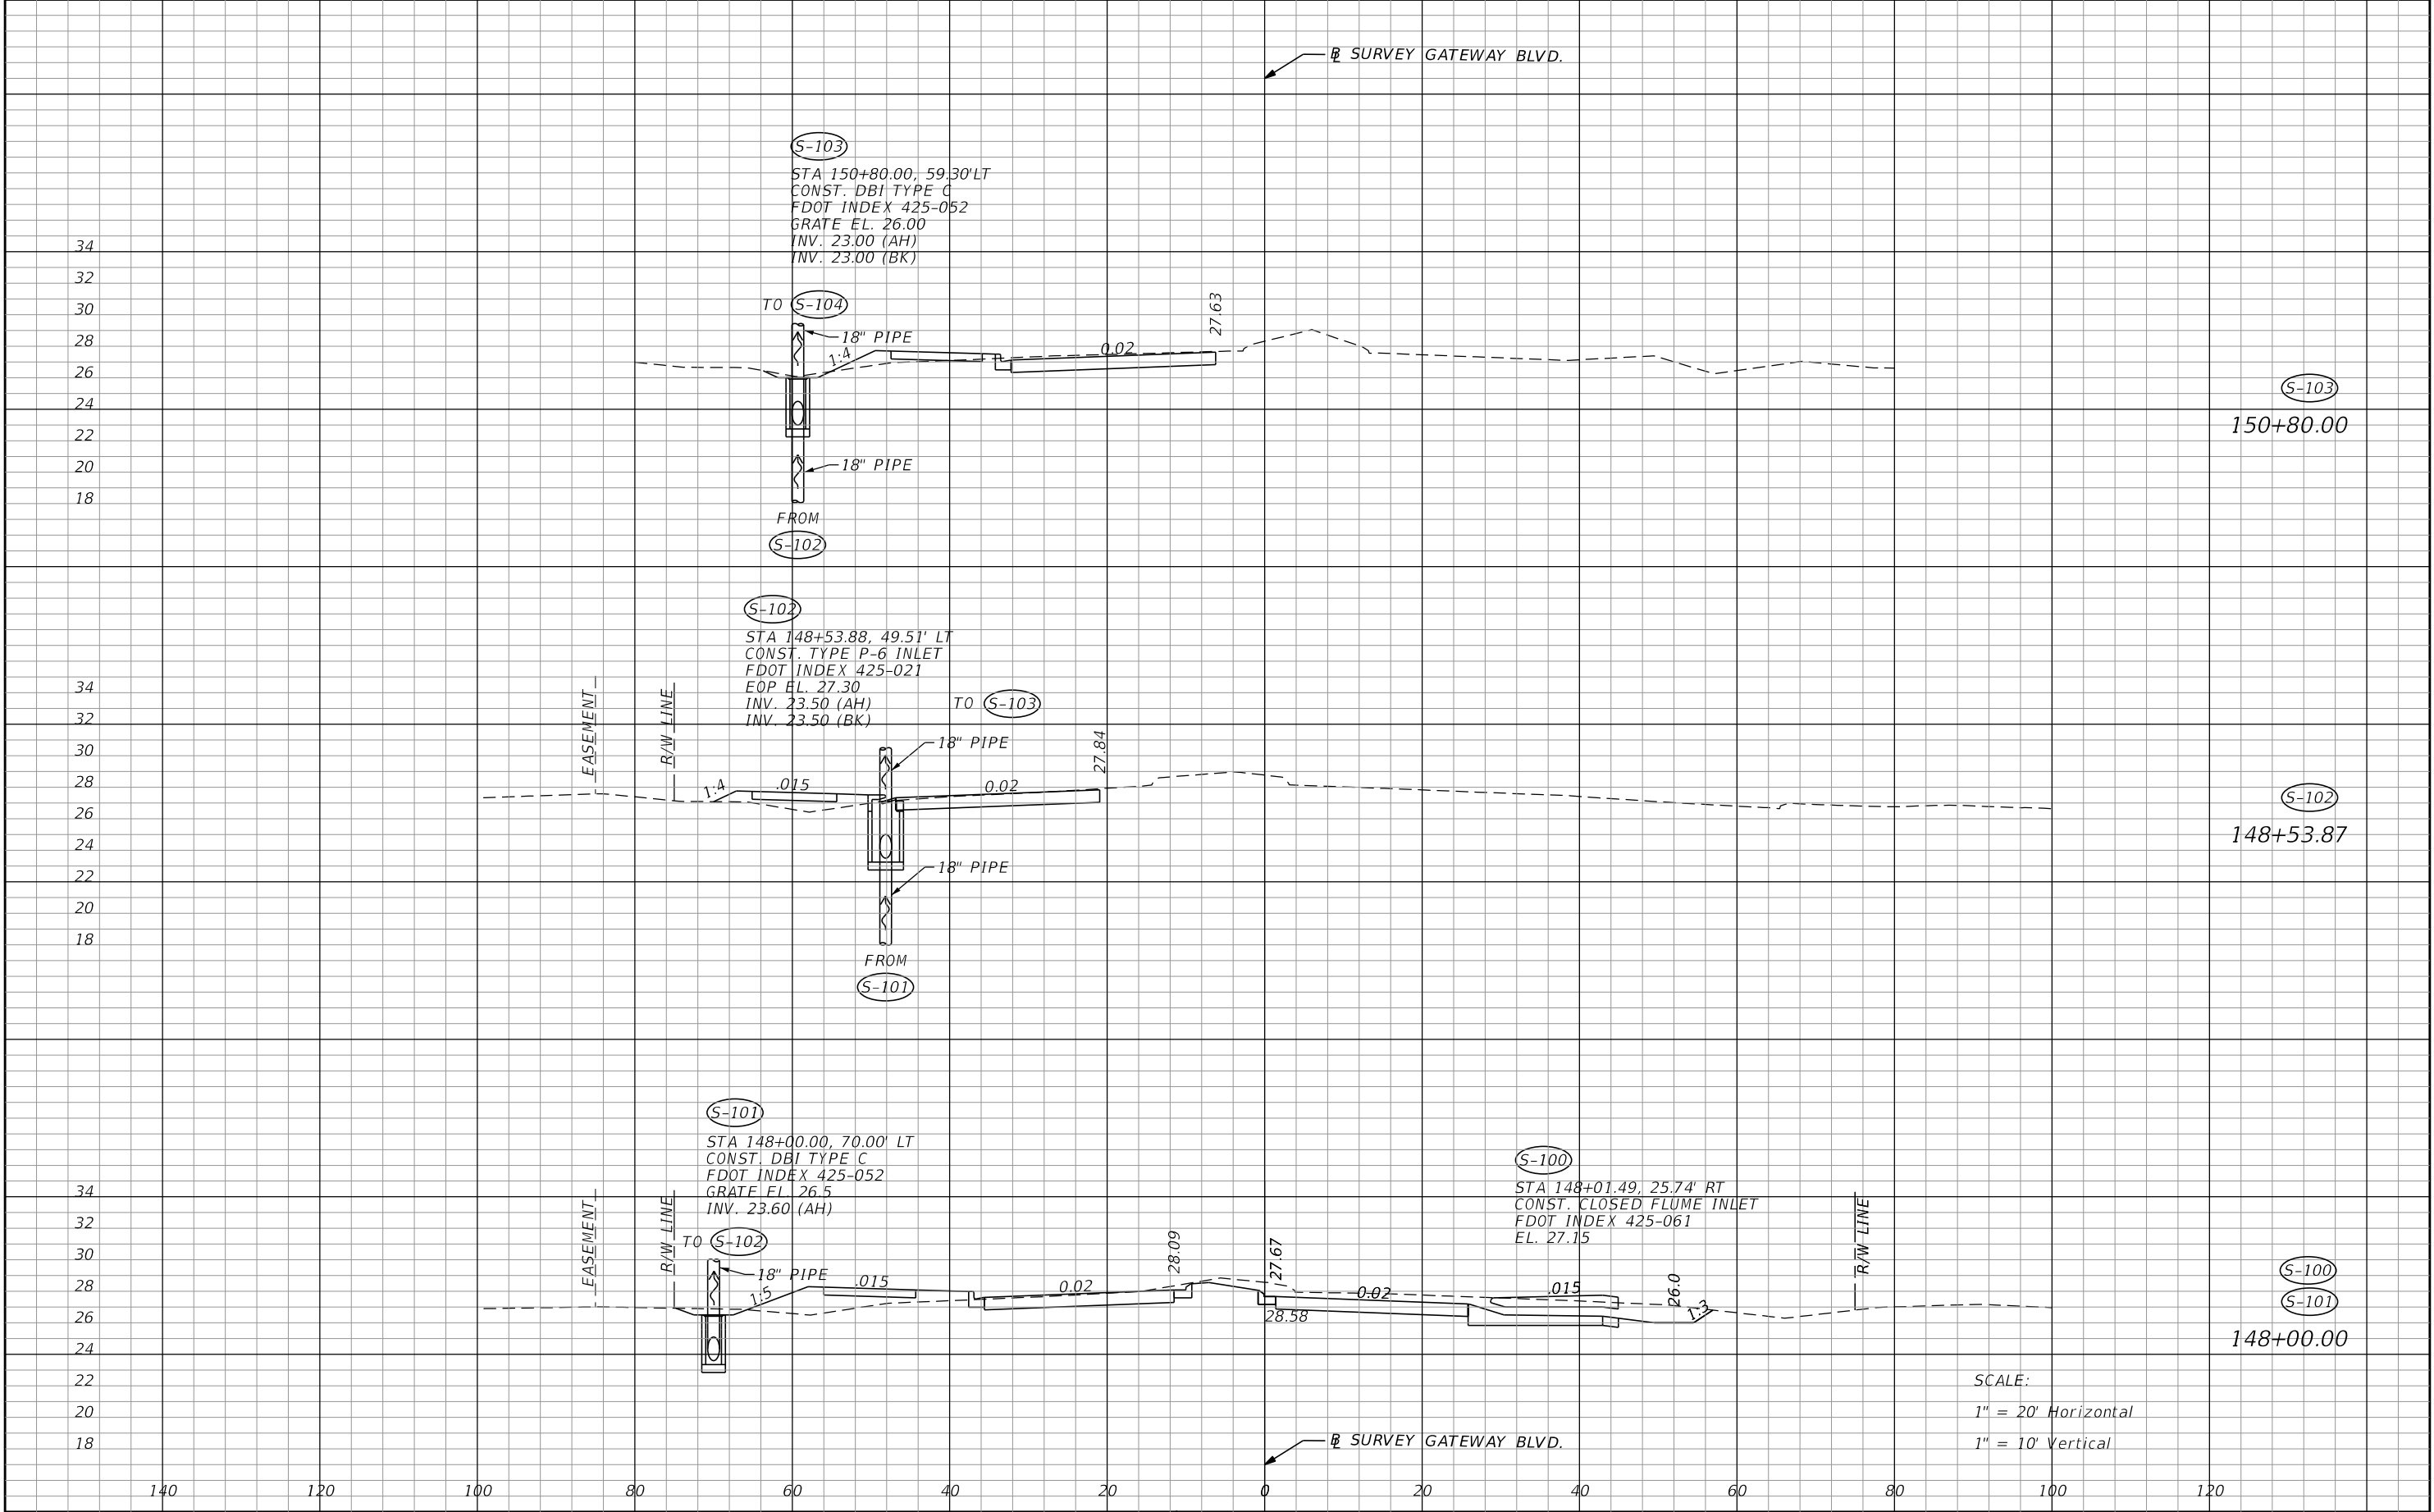


REVISIONS				CHRISTOPHER J. KNOX, P.E. P.E. LICENSE NUMBER 67350 CARDNO, INC. 380 PARK PLACE BOULEVARD, SUITE 300 CLEARWATER, FLORIDA 33759 CERTIFICATE OF AUTHORIZATION 29915	 DEPARTMENT OF TRANSPORTATION	GATEWAY BOULEVARD AT GRIFFIN DRIVE INTERSECTION CONTROL (ROUNDBOUT)		CIP NO.	SHT. NO.
DATE	DESCRIPTION	DATE	DESCRIPTION			DRAINAGE STRUCTURES (1)		200672	27

THE OFFICIAL RECORD OF THIS SHEET IS THE ELECTRONIC FILE DIGITALLY SIGNED AND SEALED UNDER RULE 61G15-23.004, F.A.C.

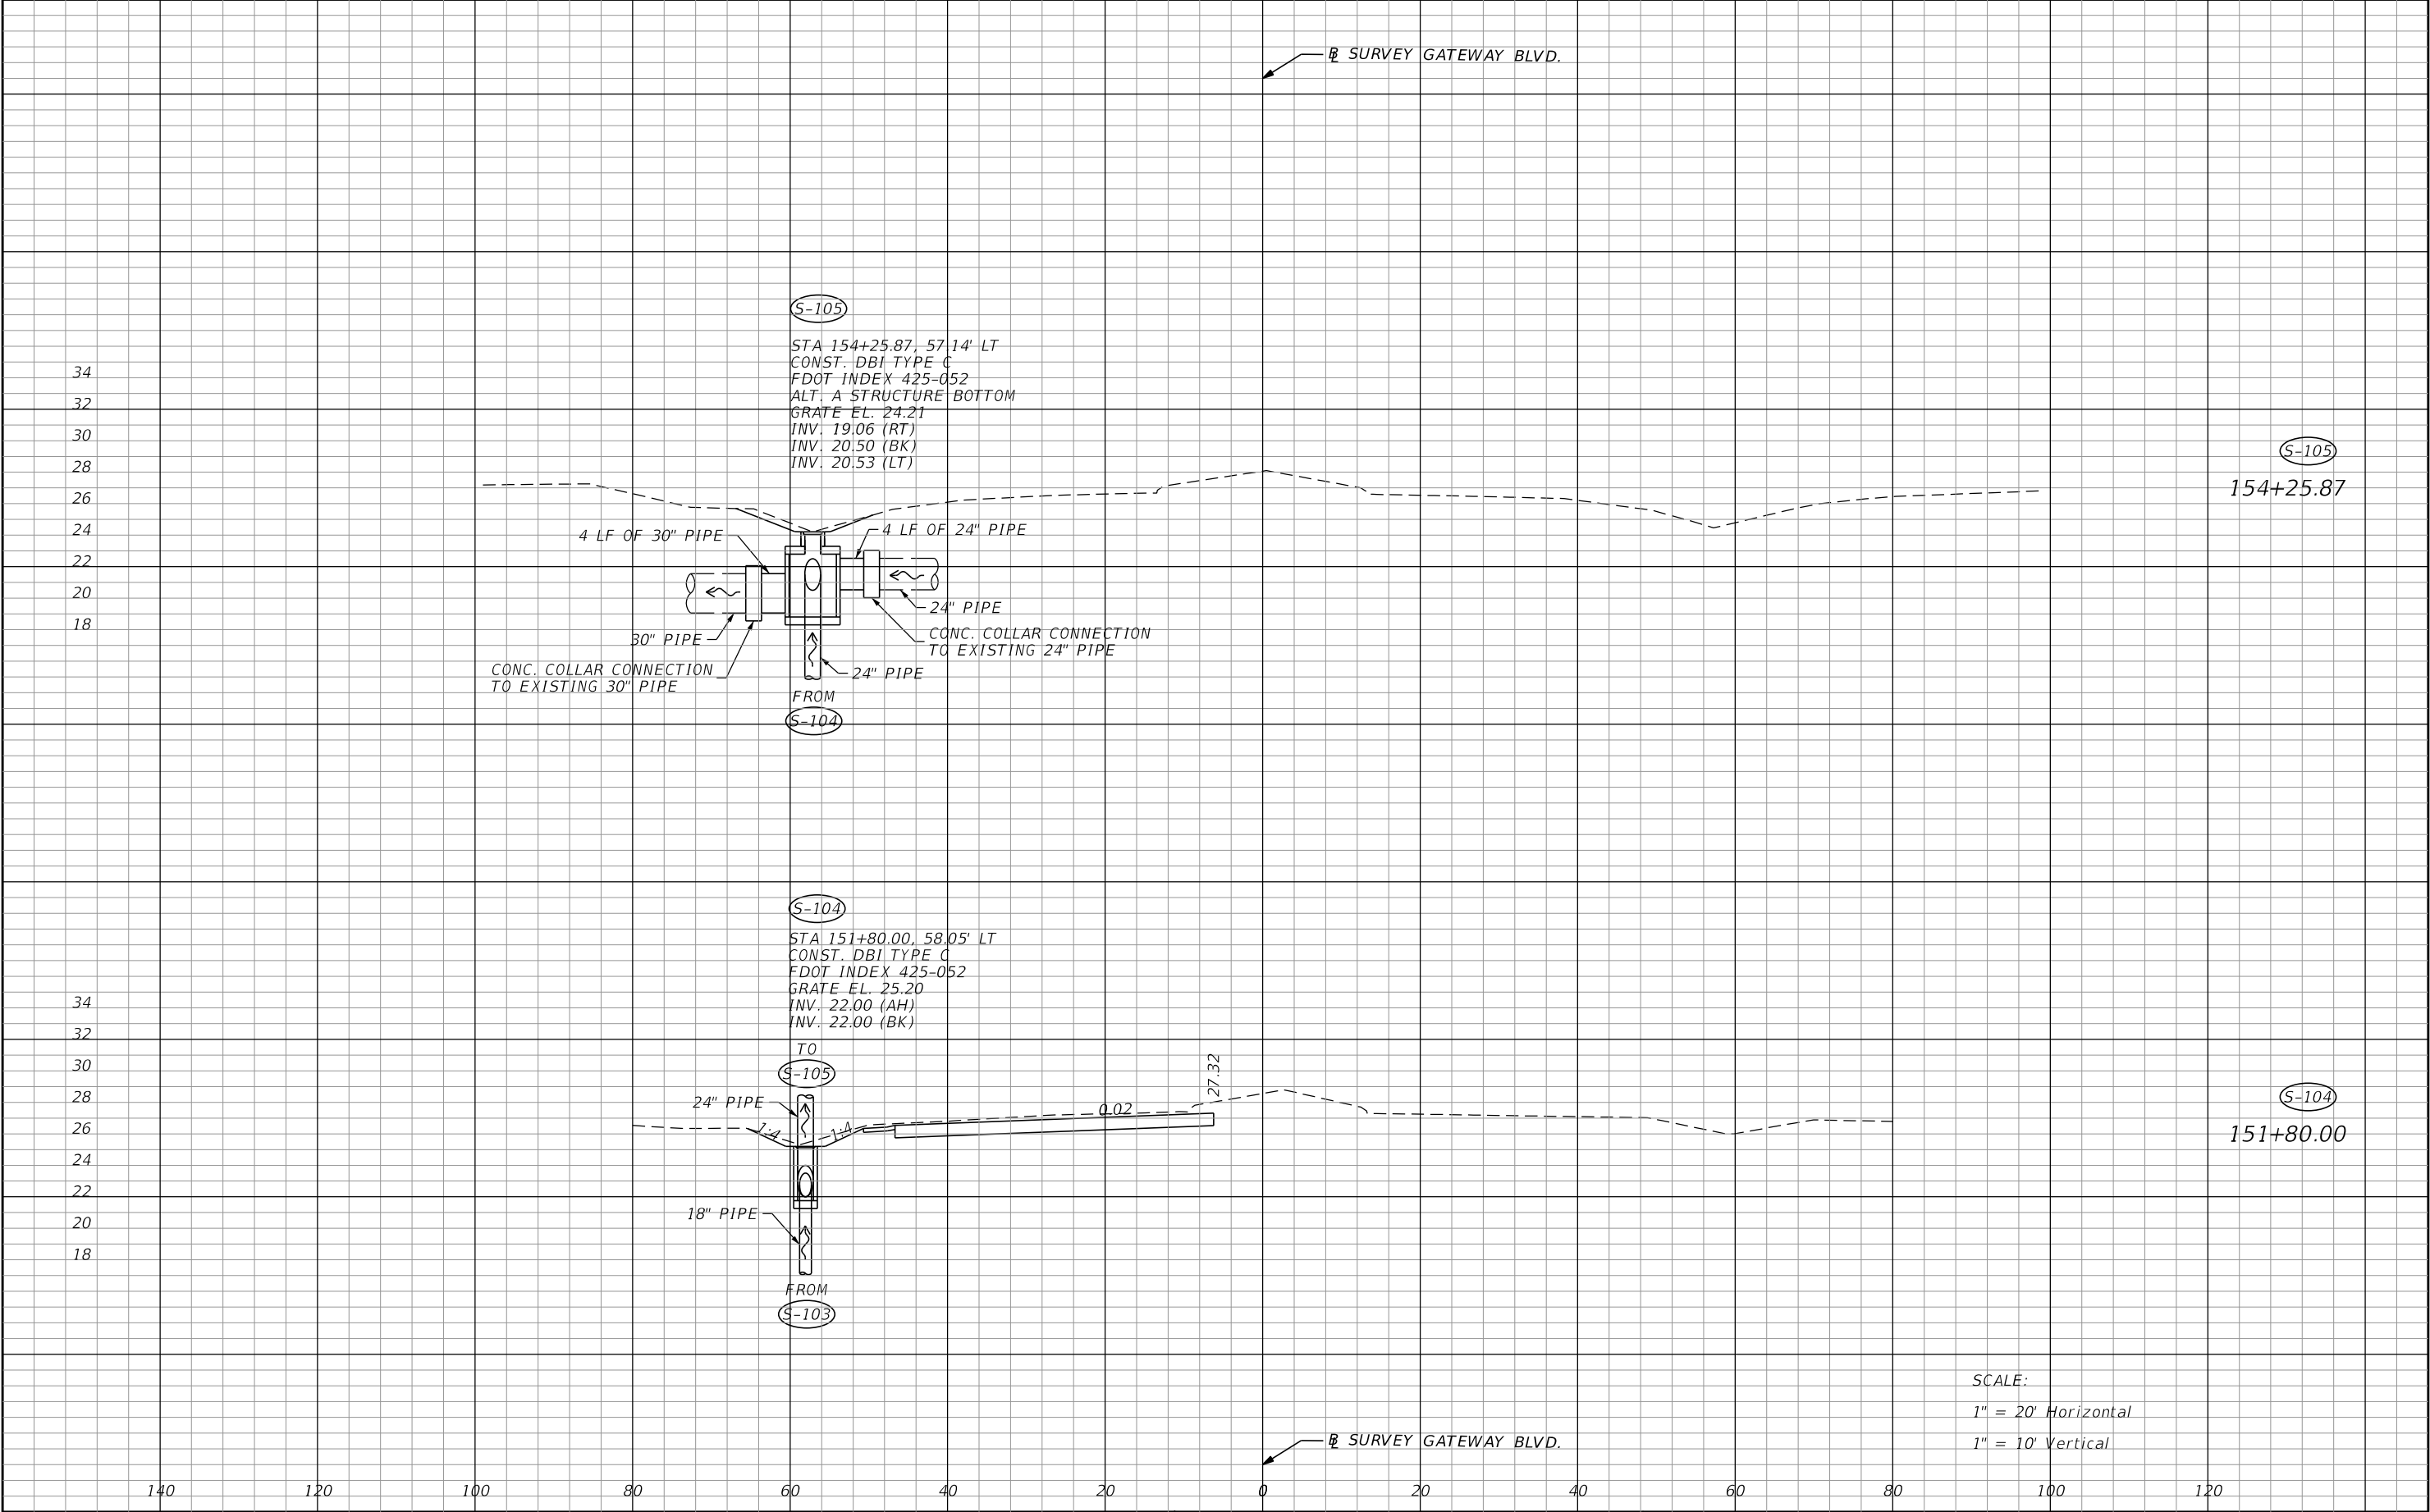


REVISIONS				CHRISTOPHER J. KNOX, P.E. P.E. LICENSE NUMBER 67350 CARDNO, INC. 380 PARK PLACE BOULEVARD, SUITE 300 CLEARWATER, FLORIDA 33759 CERTIFICATE OF AUTHORIZATION 29915	 Lee County Southwest Florida DEPARTMENT OF TRANSPORTATION	GATEWAY BOULEVARD AT GRIFFIN DRIVE INTERSECTION CONTROL (ROUNDBOUT)	CIP NO.	SHT. NO.
DATE	DESCRIPTION	DATE	DESCRIPTION			DRAINAGE STRUCTURES (2)	200672	28

THE OFFICIAL RECORD OF THIS SHEET IS THE ELECTRONIC FILE DIGITALLY SIGNED AND SEALED UNDER RULE 61G15-23.004, F.A.C.

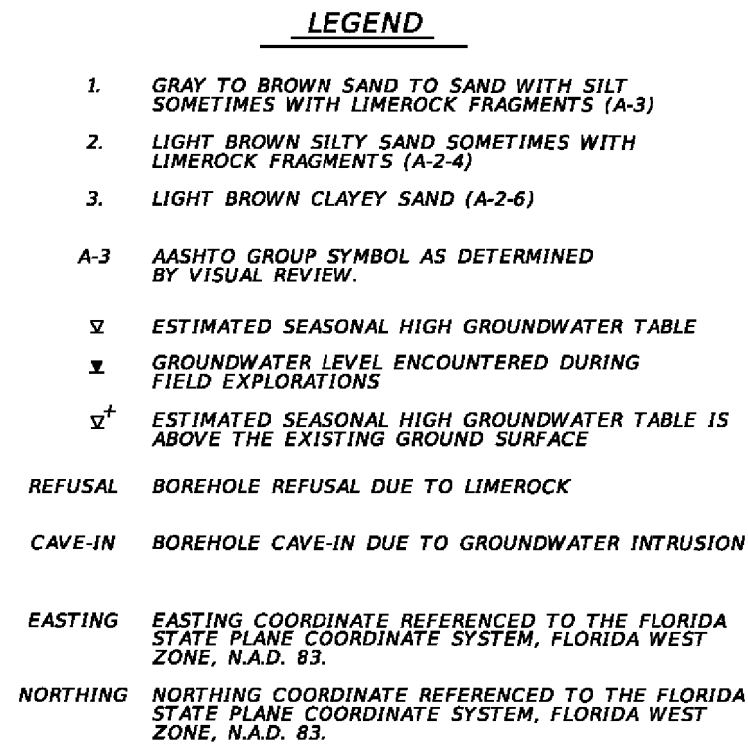


REVISIONS				KEVIN H. SCOTT, P.E. P.E. LICENSE NUMBER 65514 TIERRA, INC. 7351 TEMPLE TERRACE HIGHWAY TAMPA, FLORIDA 33637 CERTIFICATE OF AUTHORIZATION 6486	 Lee County Southwest Florida DEPARTMENT OF TRANSPORTATION	GATEWAY BOULEVARD AT GRIFFIN DRIVE INTERSECTION CONTROL (ROUNDAABOUT)	COUNTY PROJECT NO.	SHT. NO.
DATE	DESCRIPTION	DATE	DESCRIPTION			ROADWAY SOIL SURVEY	200672	29

THE OFFICIAL RECORD OF THIS SHEET IS THE ELECTRONIC FILE DIGITALLY SIGNED AND SEALED UNDER RULE 61G15-23.004, F.A.C.

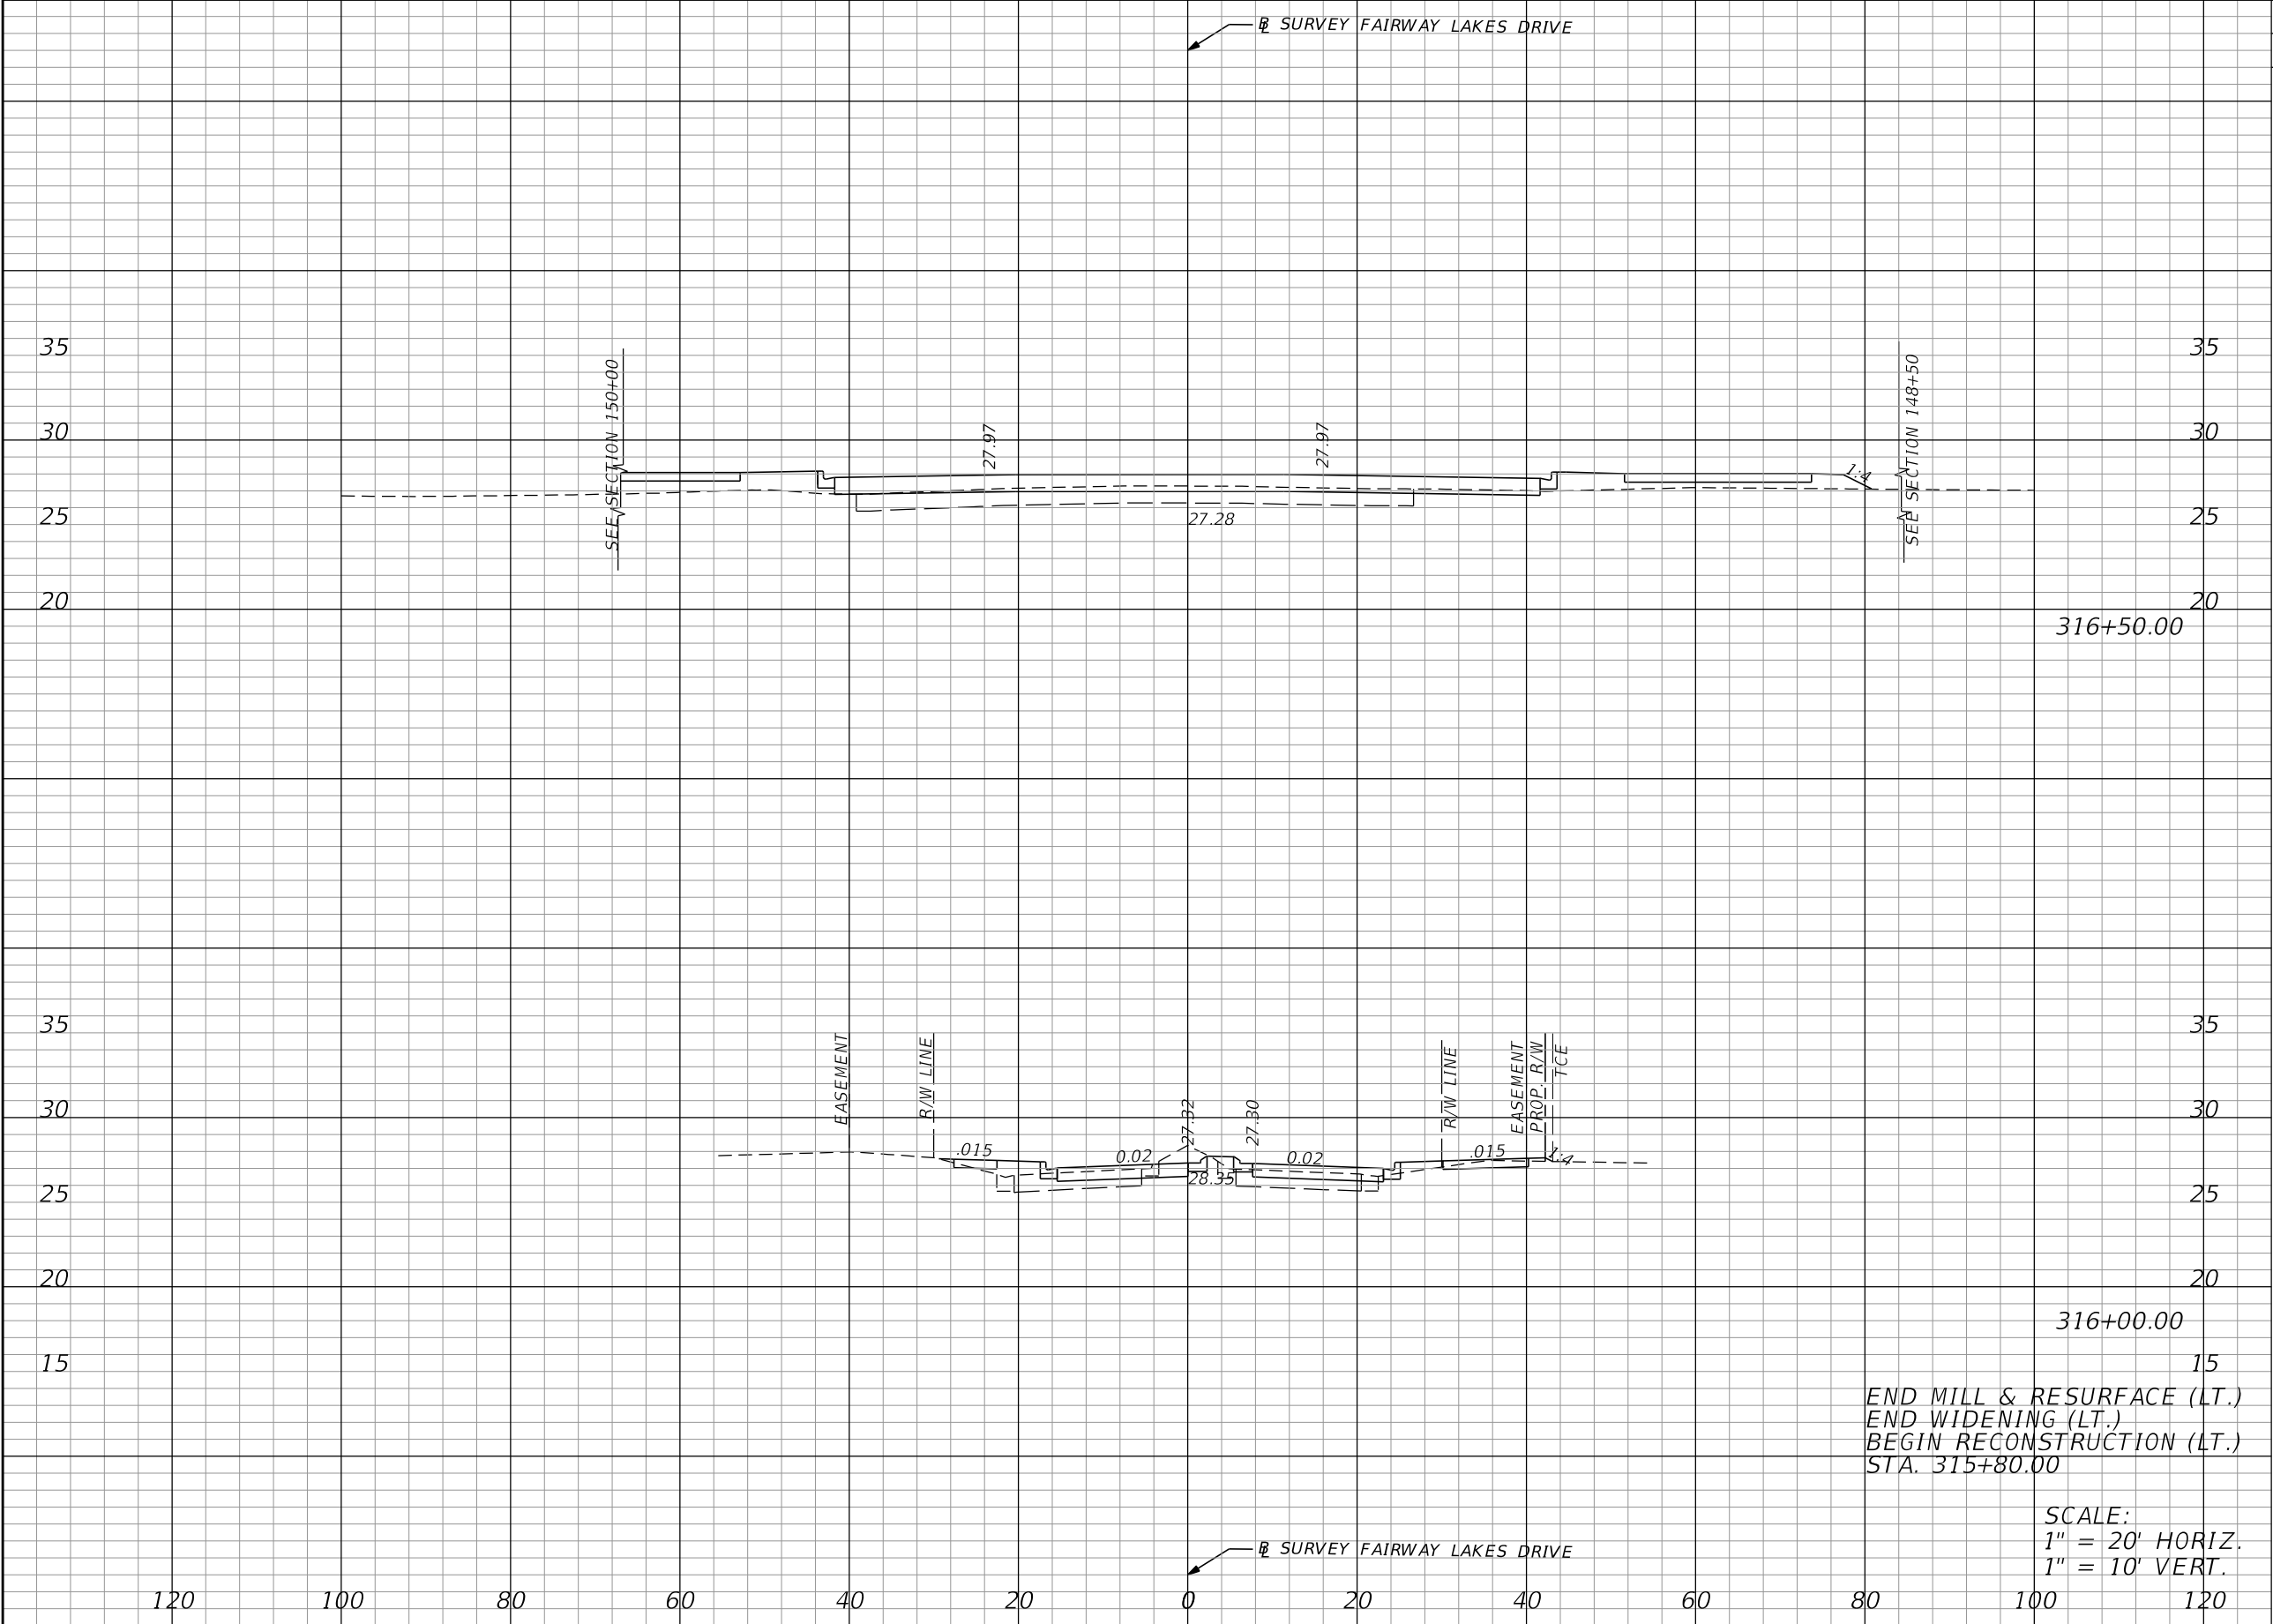

REVISIONS				JASON Y. YAM, P.E. P.E. LICENSE NUMBER 62449 CARDNO, INC. 380 PARK PLACE BOULEVARD, SUITE 300 CLEARWATER, FLORIDA 33759 CERTIFICATE OF AUTHORIZATION 29915	 Lee County <i>Southwest Florida</i> DEPARTMENT OF TRANSPORTATION	GATEWAY BOULEVARD AT GRIFFIN DRIVE INTERSECTION CONTROL (ROUNDABOUT)		CIP NO.	SHT. NO.
DATE	DESCRIPTION	DATE	DESCRIPTION			CROSS SECTIONS (FAIRWAY LAKES DRIVE)		200672	40

THE OFFICIAL RECORD OF THIS SHEET IS THE ELECTRONIC FILE DIGITALLY SIGNED AND SEALED UNDER RULE 61G15-23.004, F.A.C.

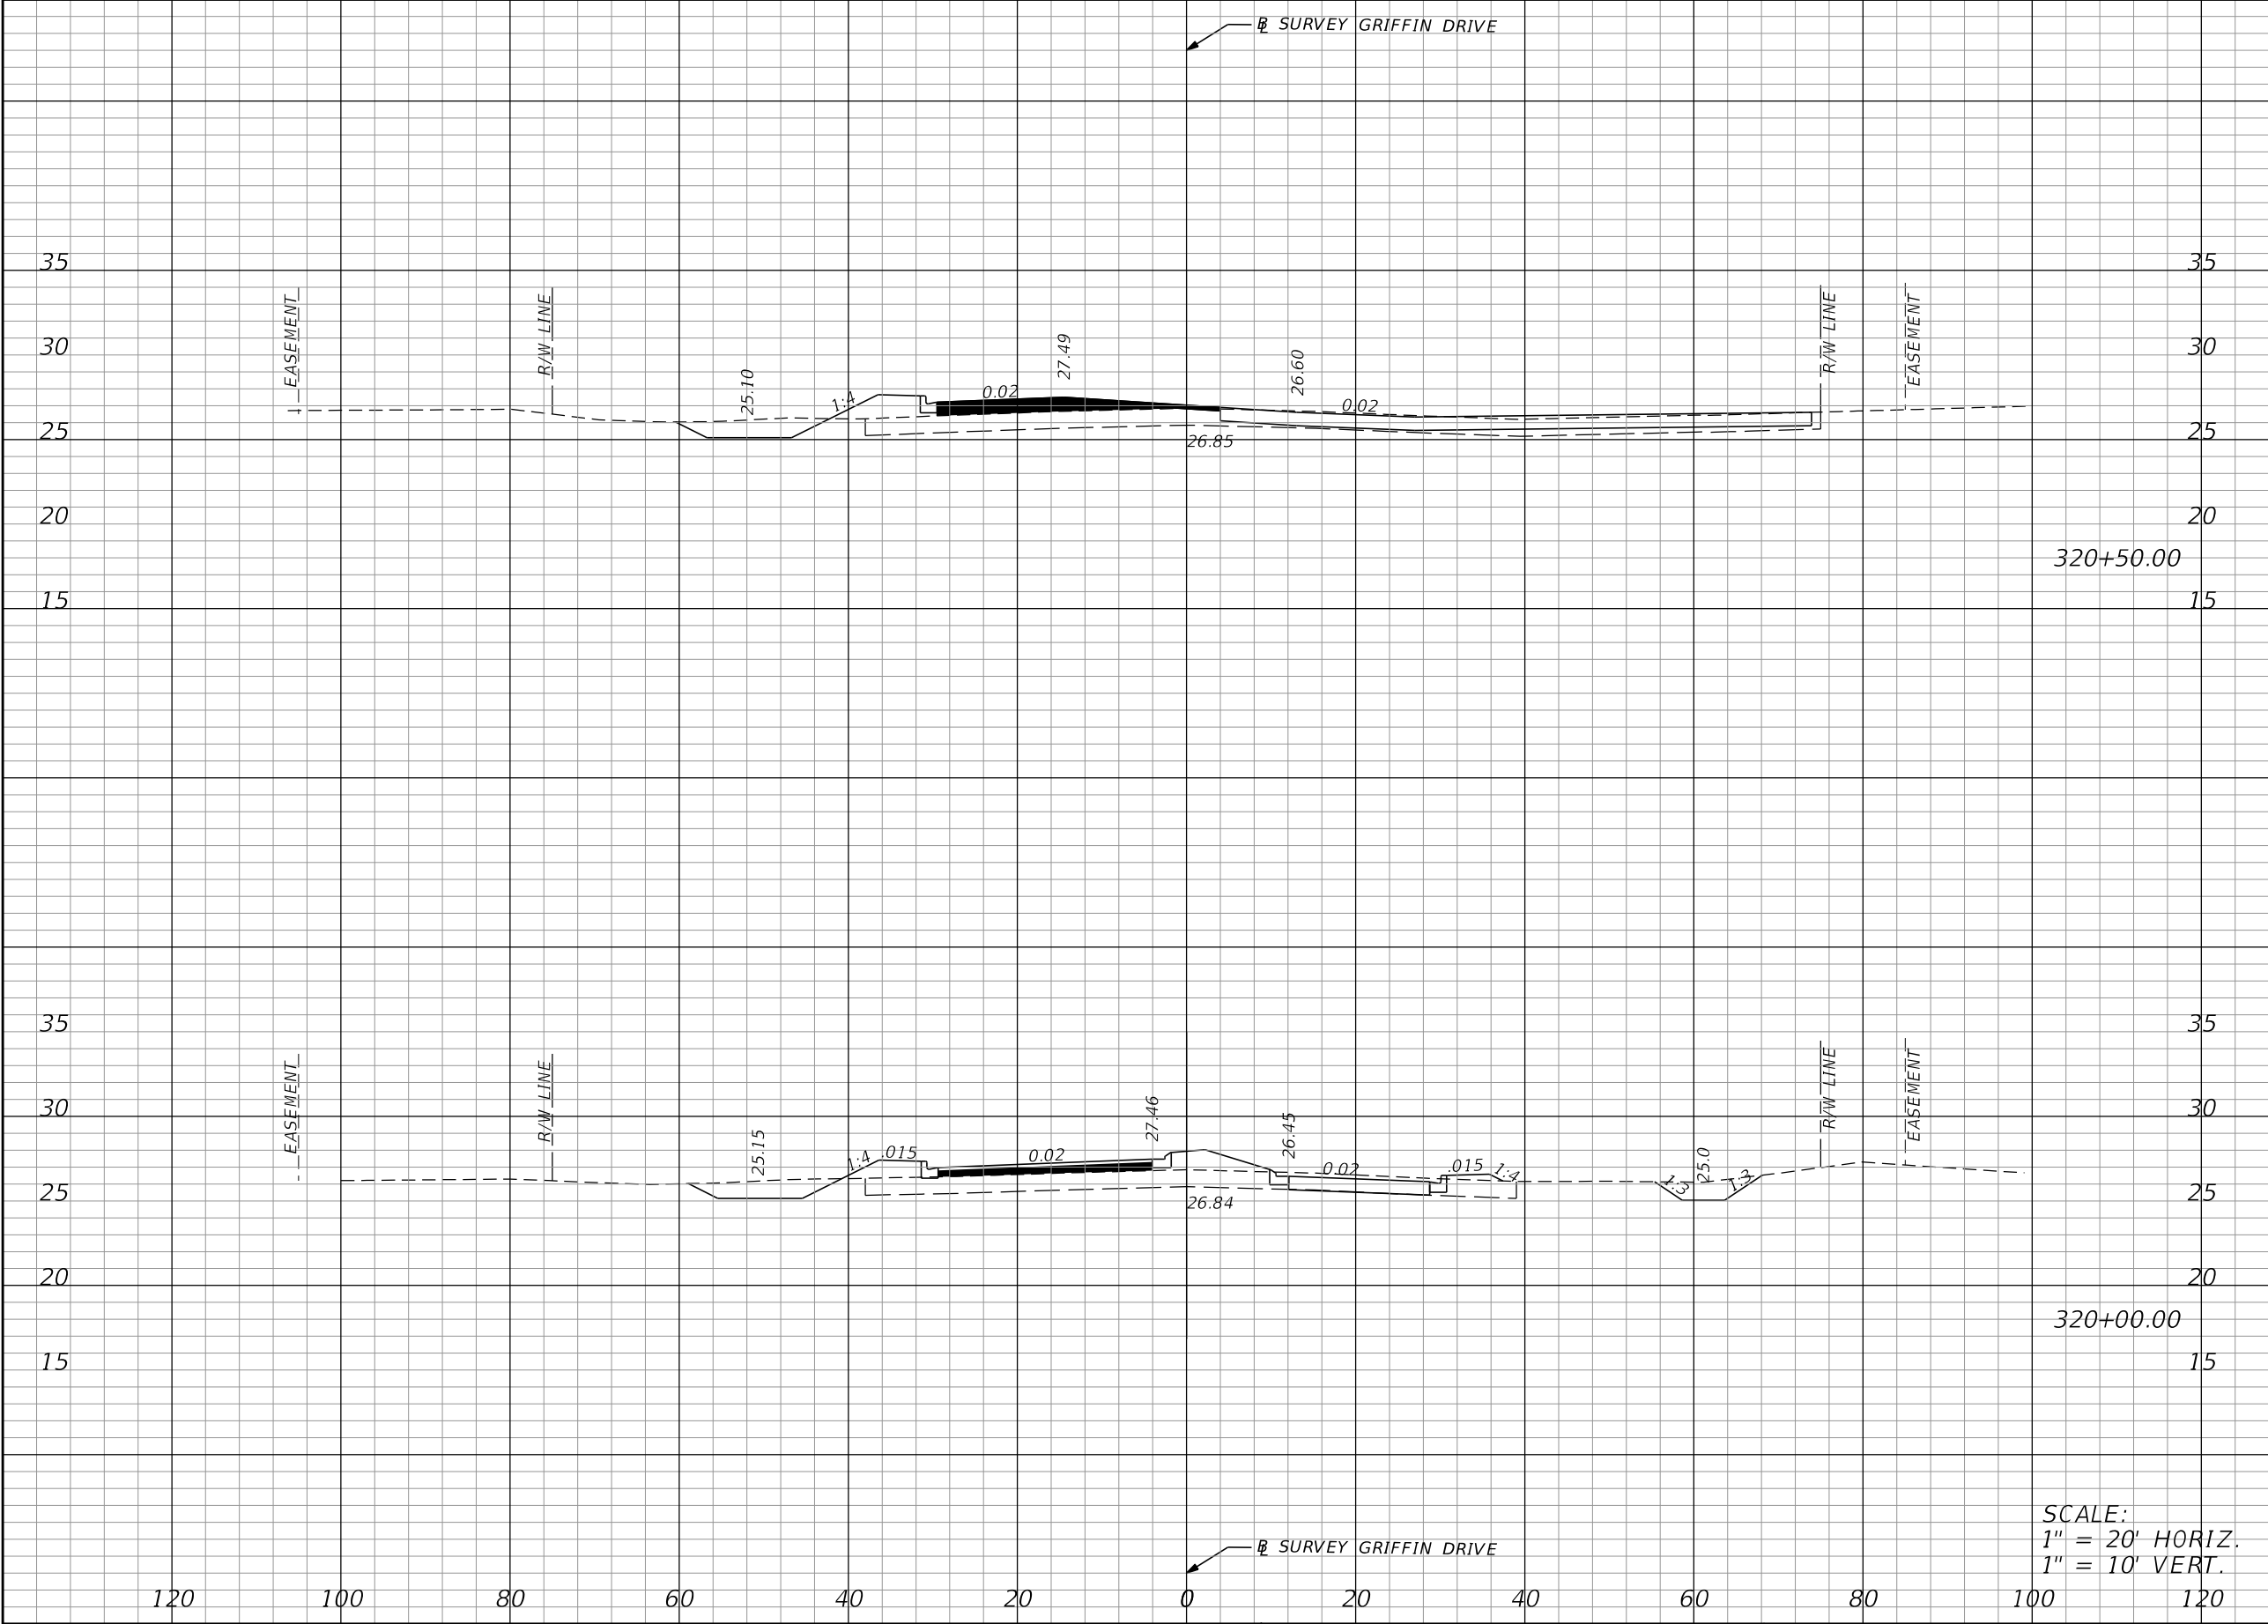

Regular		Exc.		Embankment	
A	V	A	V	A	V

REVISIONS			
DATE	DESCRIPTION	DATE	DESCRIPTION


JASON Y. YAM, P.E.
P.E. LICENSE NUMBER 62449
CARDNO, INC.
380 PARK PLACE BOULEVARD, SUITE 300
CLEARWATER, FLORIDA 33759
CERTIFICATE OF AUTHORIZATION 29915




GATEWAY BOULEVARD AT GRIFFIN DRIVE INTERSECTION CONTROL (ROUNDABOUT)	
CROSS SECTIONS (GRIFFIN DRIVE)	

CIP NO.	SHT. NO.
200672	44

THE OFFICIAL RECORD OF THIS SHEET IS THE ELECTRONIC FILE DIGITALLY SIGNED AND SEALED UNDER RULE 61G15-23.004, F.A.C.

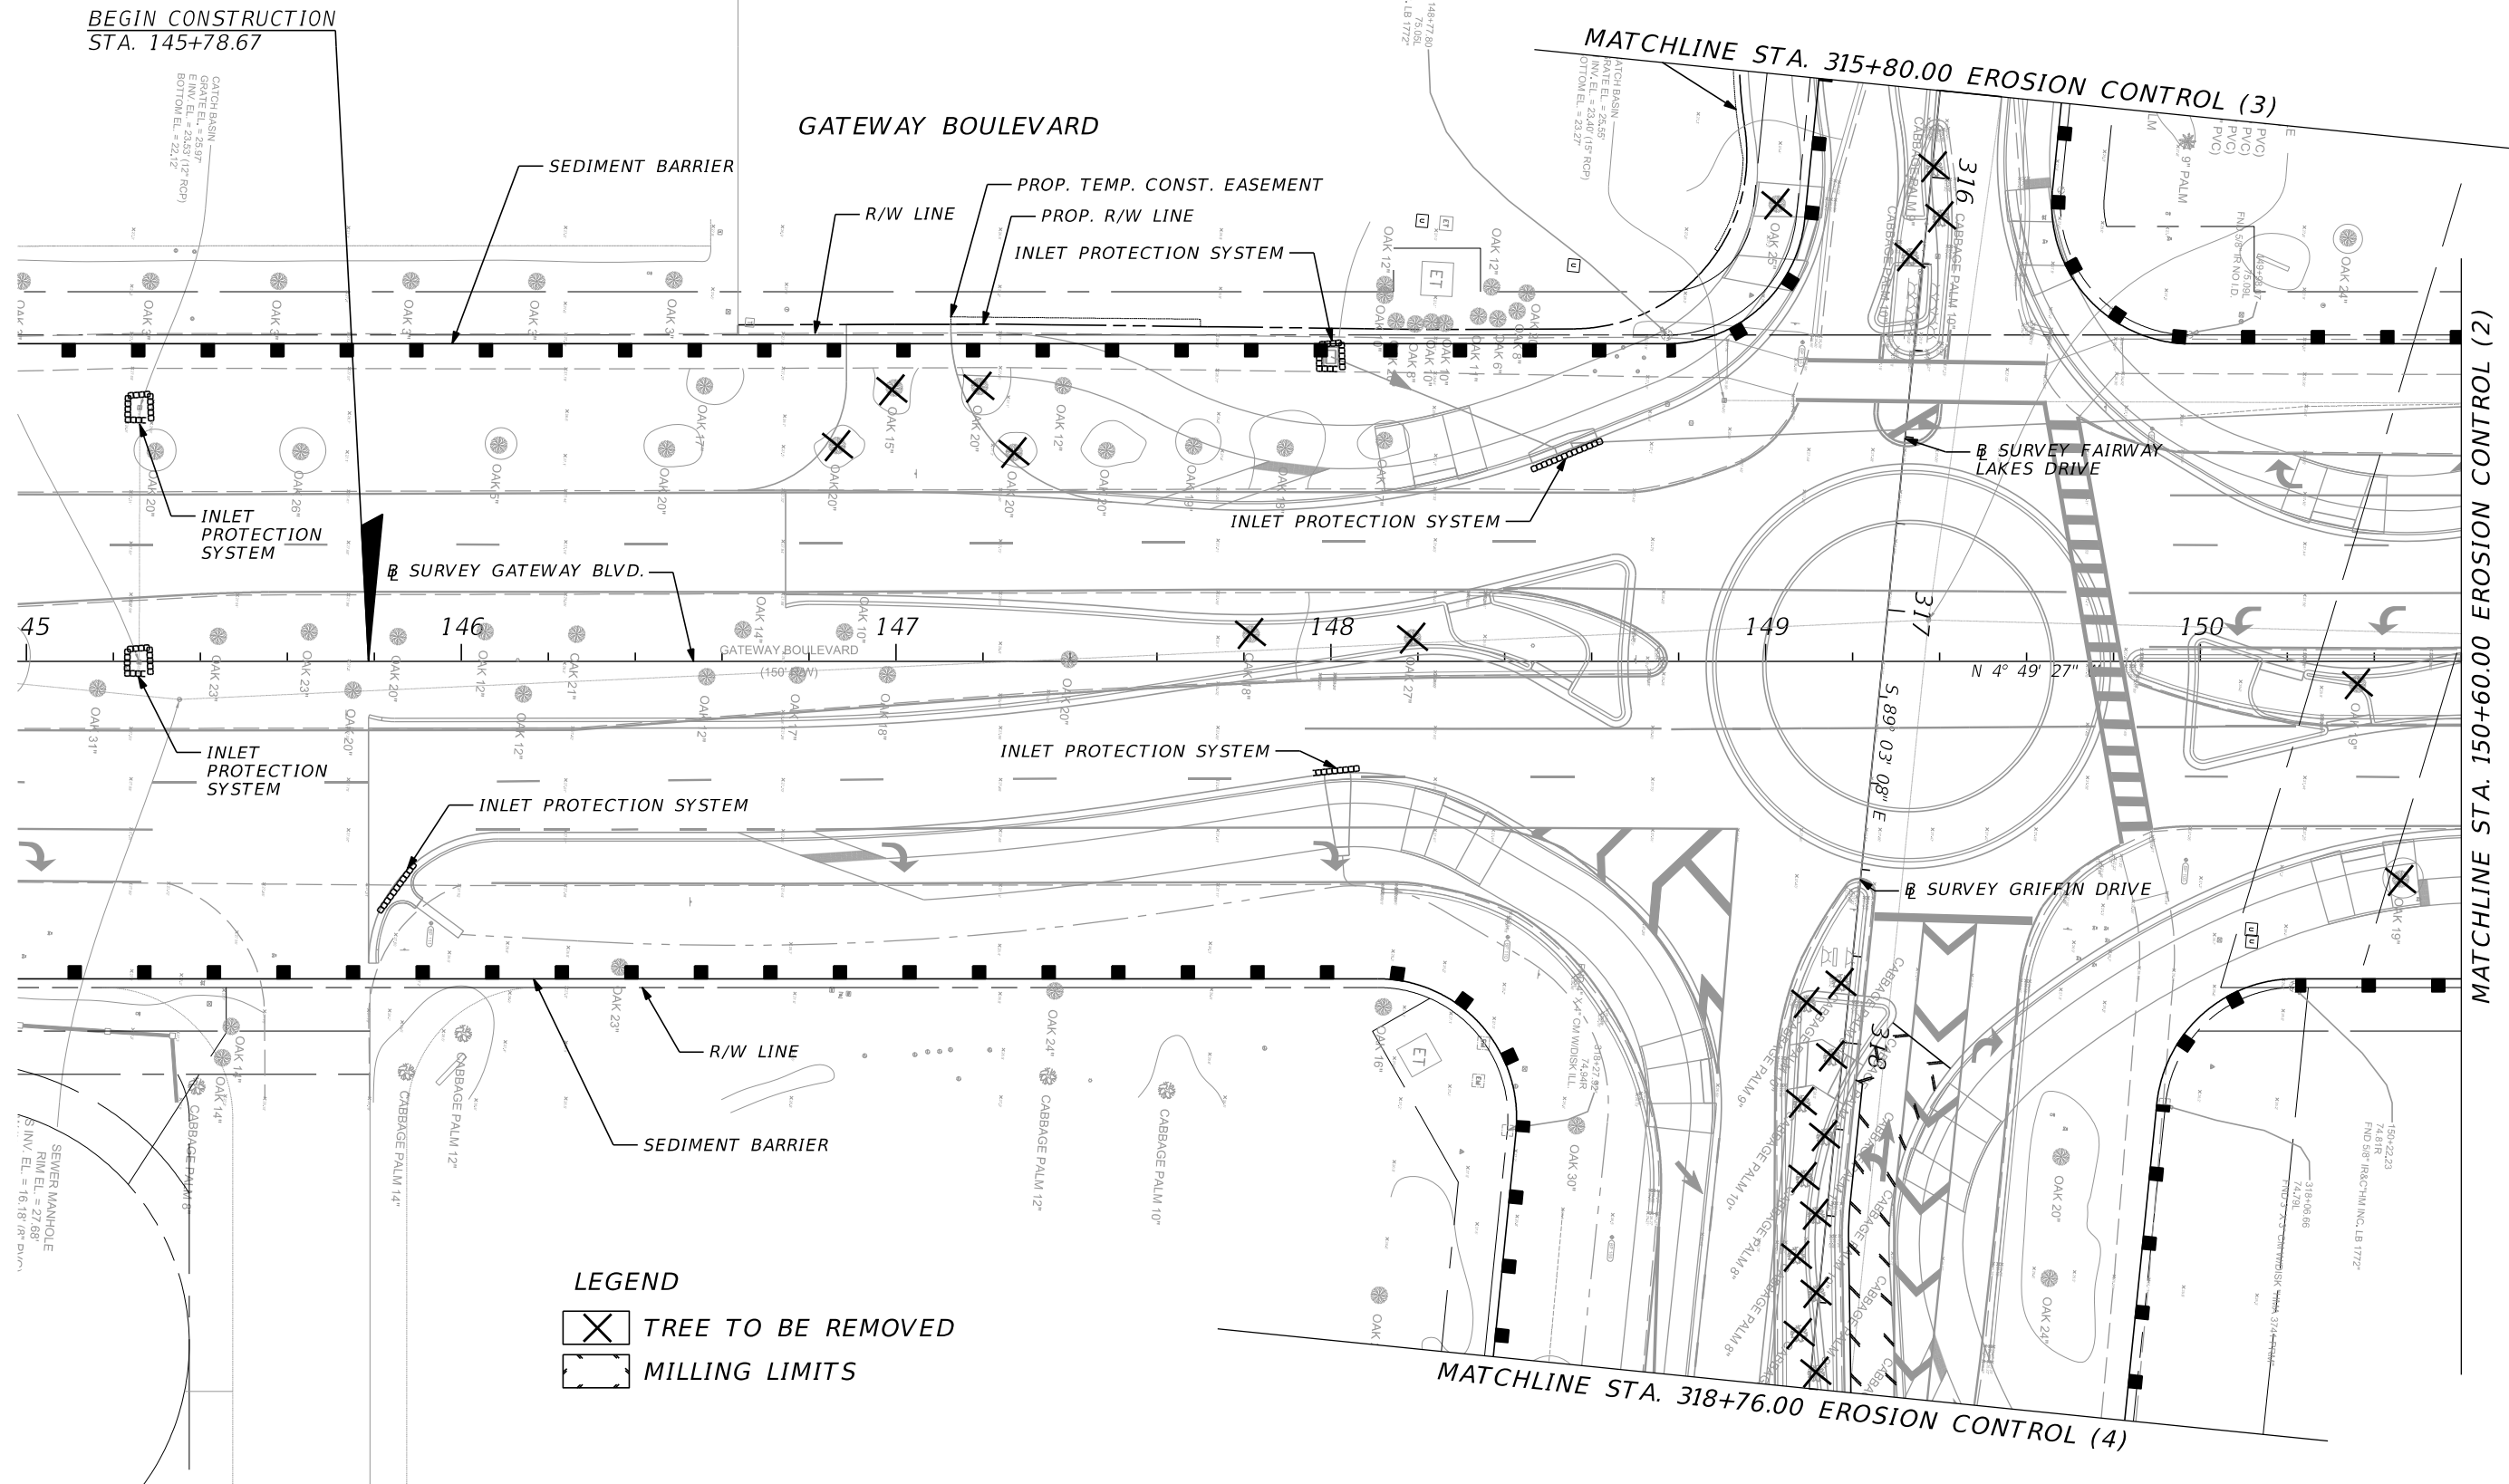


REVISIONS				JASON Y. YAM, P.E. P.E. LICENSE NUMBER 62449 CARDNO, INC. 380 PARK PLACE BOULEVARD, SUITE 300 CLEARWATER, FLORIDA 33759 CERTIFICATE OF AUTHORIZATION 29915	 DEPARTMENT OF TRANSPORTATION	GATEWAY BOULEVARD AT GRIFFIN DRIVE INTERSECTION CONTROL (ROUNDAABOUT)		COUNTY PROJECT NO.	SHT. NO.
DATE	DESCRIPTION	DATE	DESCRIPTION			EROSION CONTROL (1)		200672	48

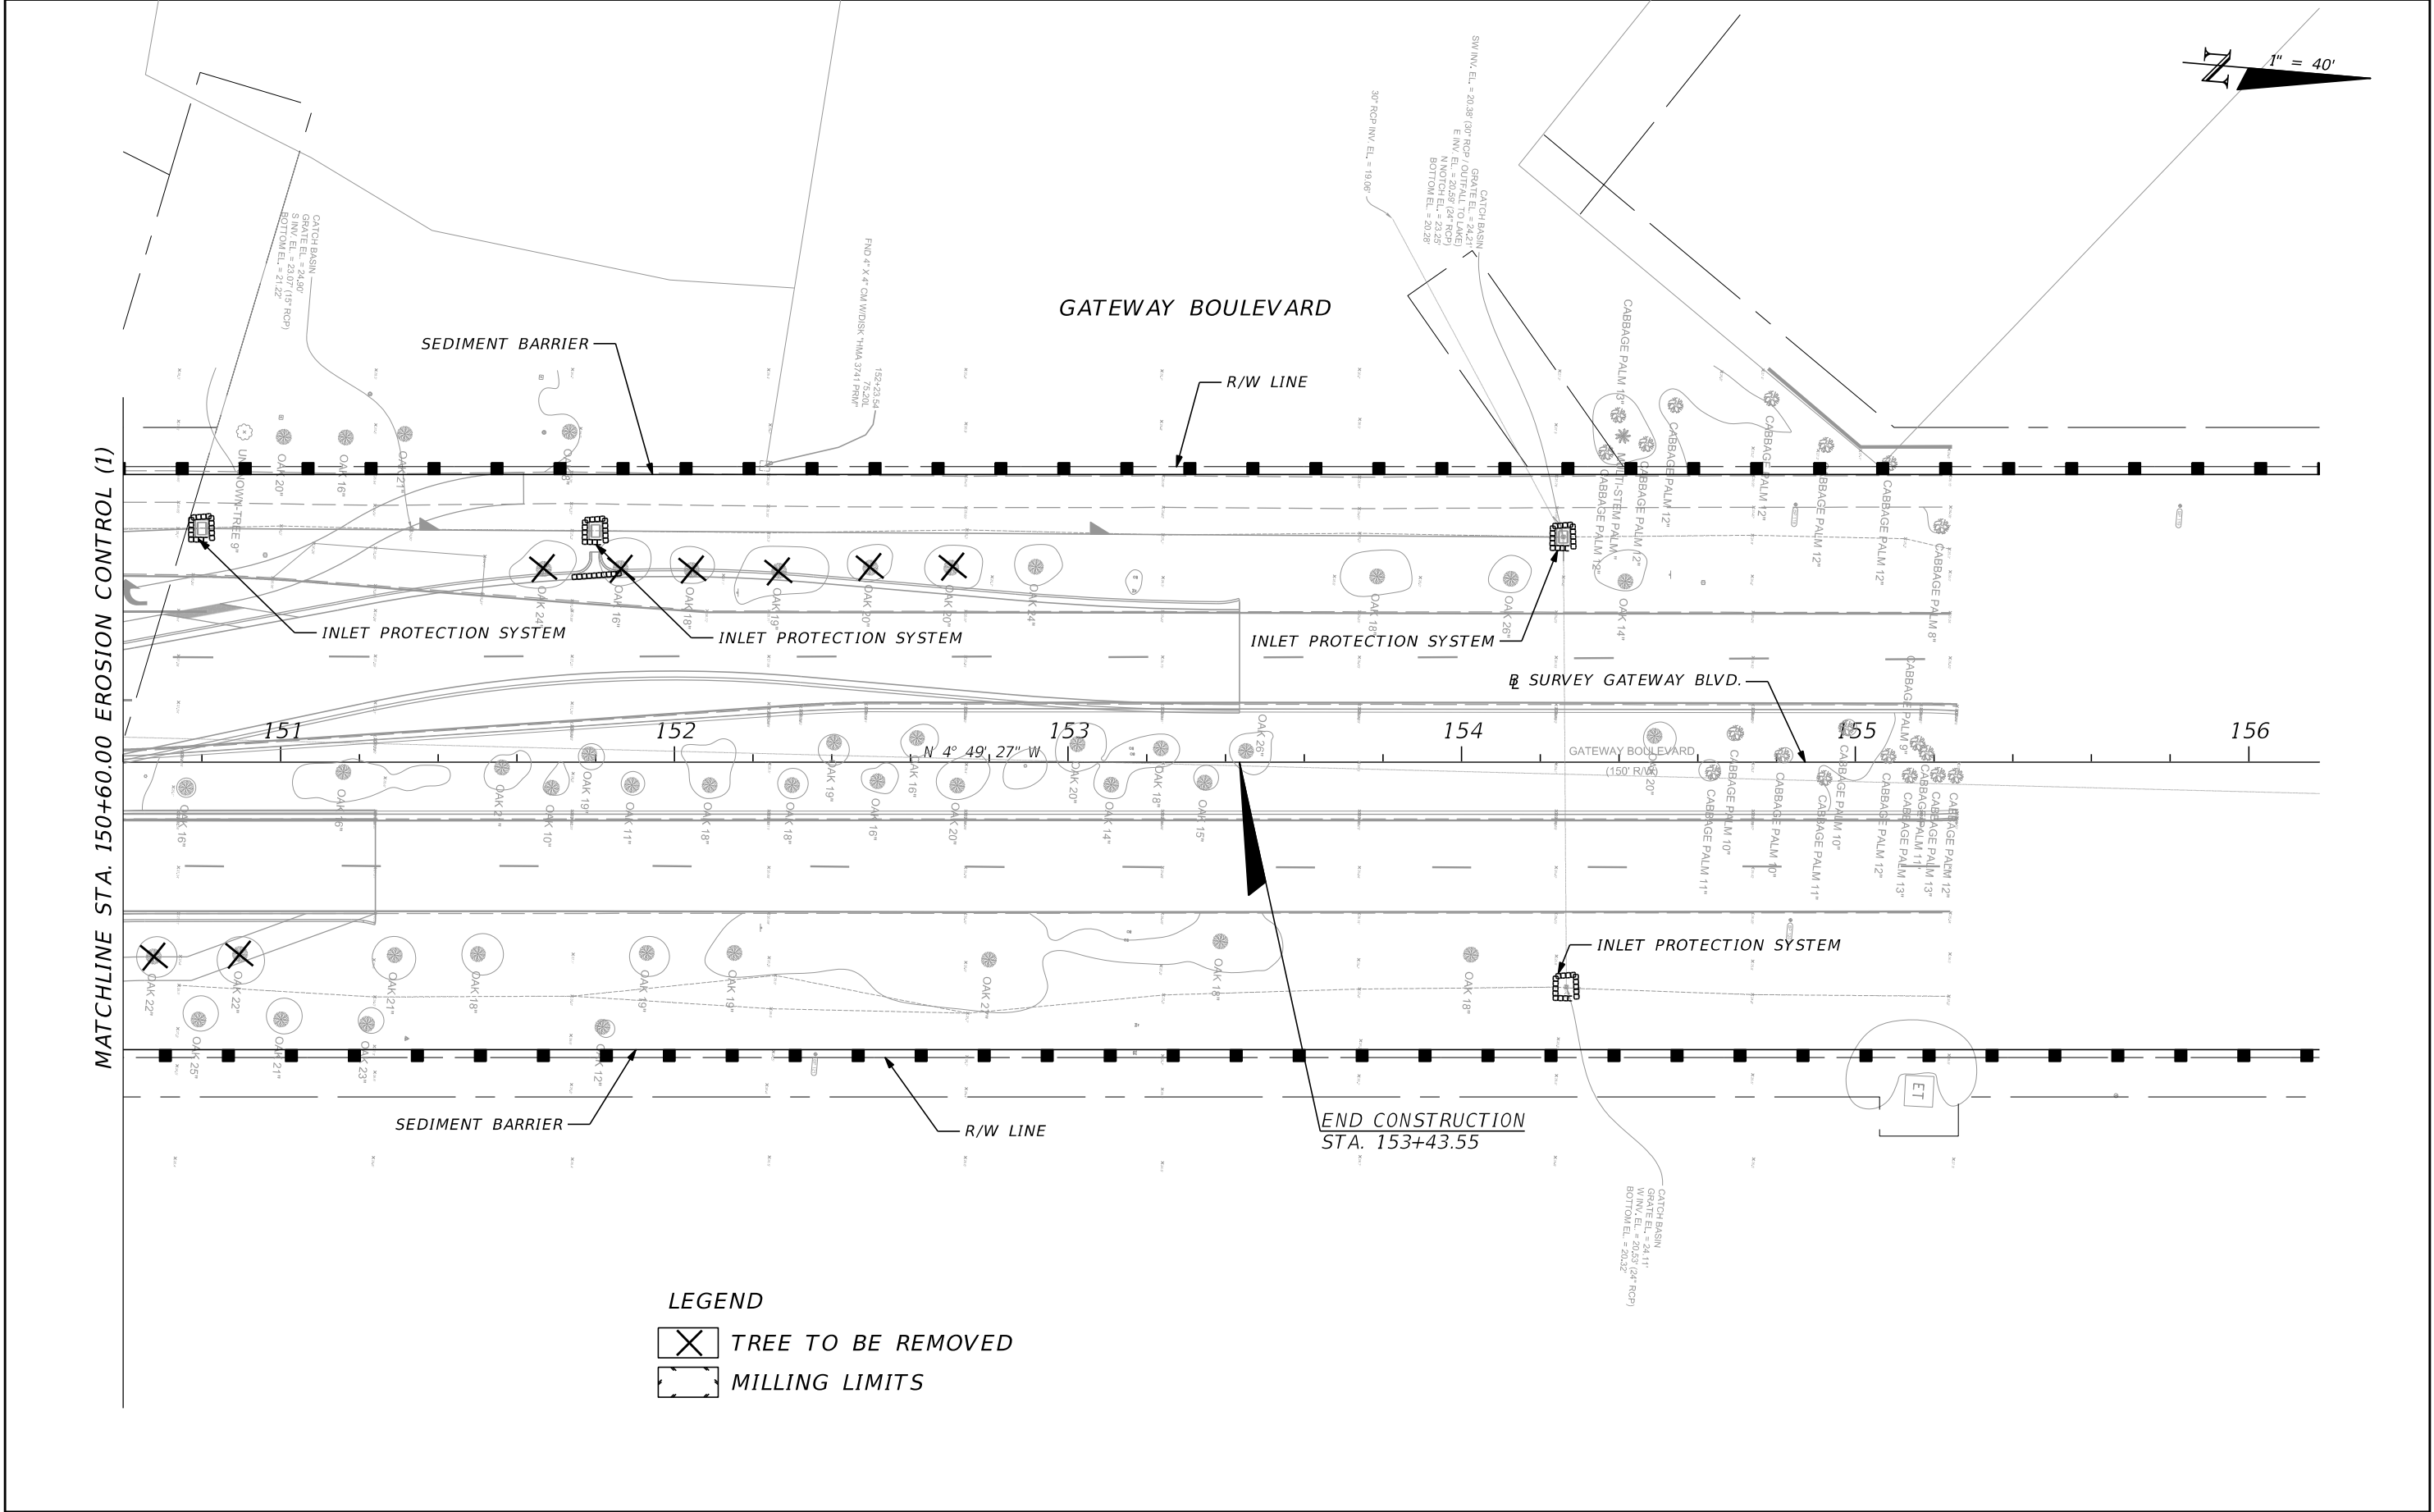

REVISIONS				JASON Y. YAM, P.E. P.E. LICENSE NUMBER 62449 CARDNO, INC. 380 PARK PLACE BOULEVARD, SUITE 300 CLEARWATER, FLORIDA 33759 CERTIFICATE OF AUTHORIZATION 29915	 DEPARTMENT OF TRANSPORTATION	GATEWAY BOULEVARD AT GRIFFIN DRIVE INTERSECTION CONTROL (ROUNDAABOUT)		COUNTY PROJECT NO.	SHT. NO.
DATE	DESCRIPTION	DATE	DESCRIPTION			EROSION CONTROL (2)		200672	49

THE OFFICIAL RECORD OF THIS SHEET IS THE ELECTRONIC FILE DIGITALLY SIGNED AND SEALED UNDER RULE 61G15-23.004, F.A.C.



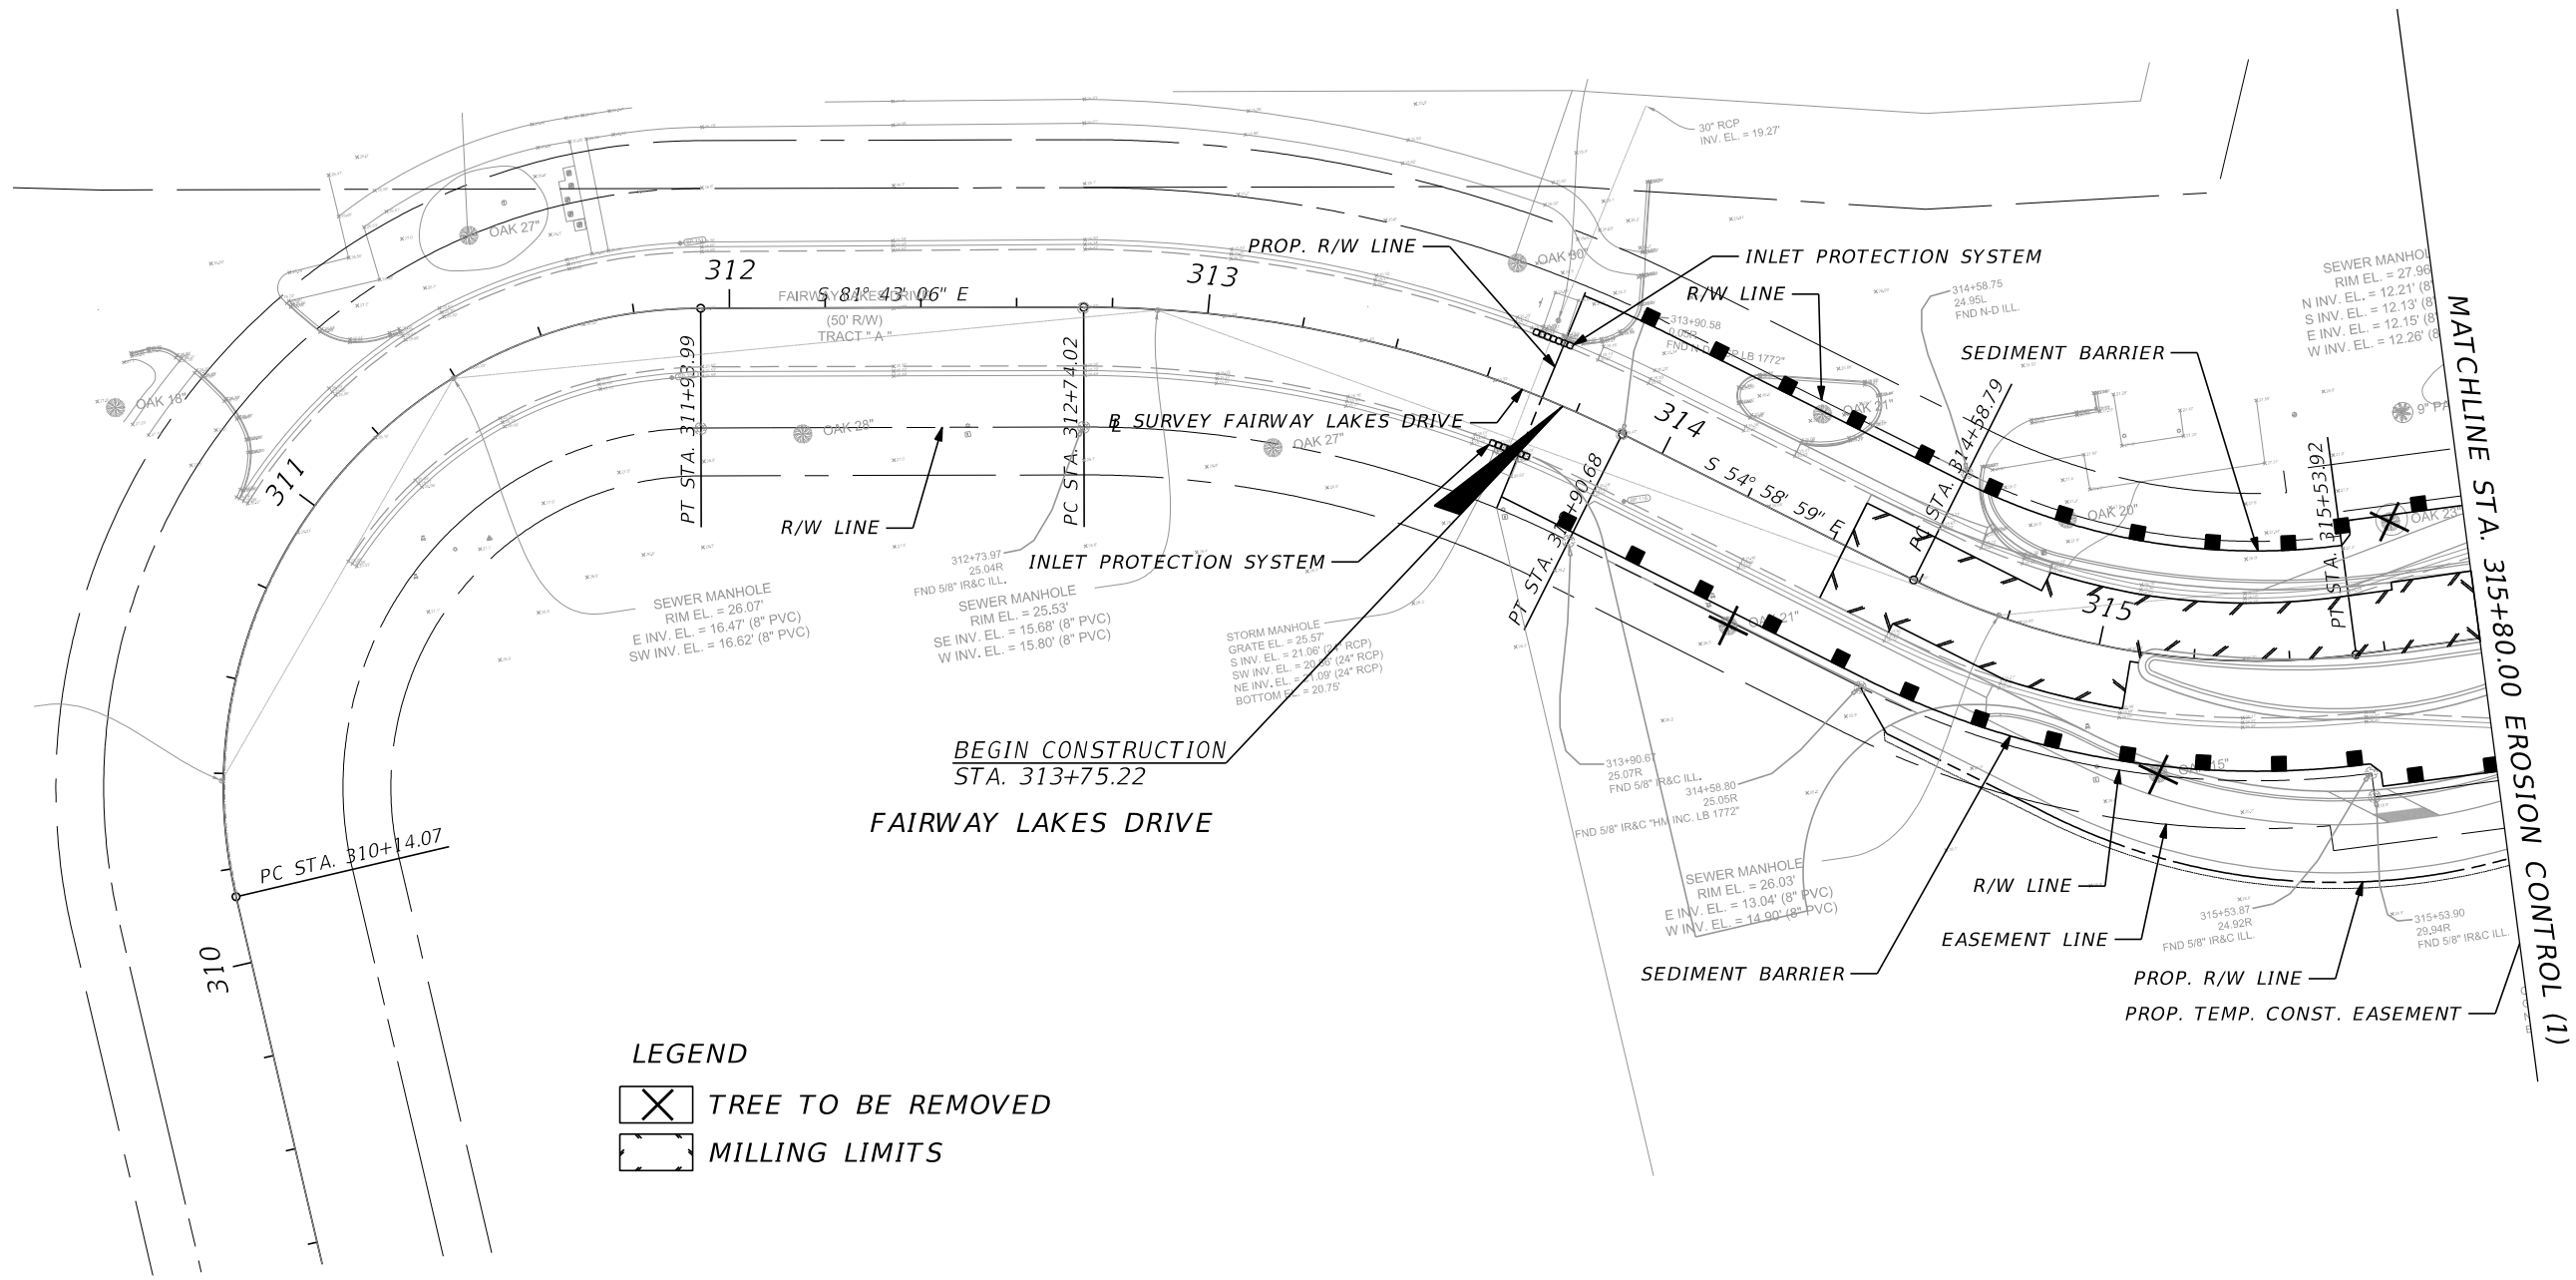


- LEGEND**
- TREE TO BE REMOVED
 - MILLING LIMITS

REVISIONS				JASON Y. YAM, P.E. P.E. LICENSE NUMBER 62449 CARDNO, INC. 380 PARK PLACE BOULEVARD, SUITE 300 CLEARWATER, FLORIDA 33759 CERTIFICATE OF AUTHORIZATION 29915	 DEPARTMENT OF TRANSPORTATION	GATEWAY BOULEVARD AT GRIFFIN DRIVE INTERSECTION CONTROL (ROUNDAABOUT)		COUNTY PROJECT NO.	SHT. NO.
DATE	DESCRIPTION	DATE	DESCRIPTION			EROSION CONTROL (3)		200672	50


THE OFFICIAL RECORD OF THIS SHEET IS THE ELECTRONIC FILE DIGITALLY SIGNED AND SEALED UNDER RULE 61G15-23.004, F.A.C.

CONSTRUCTION PHASING NOTES

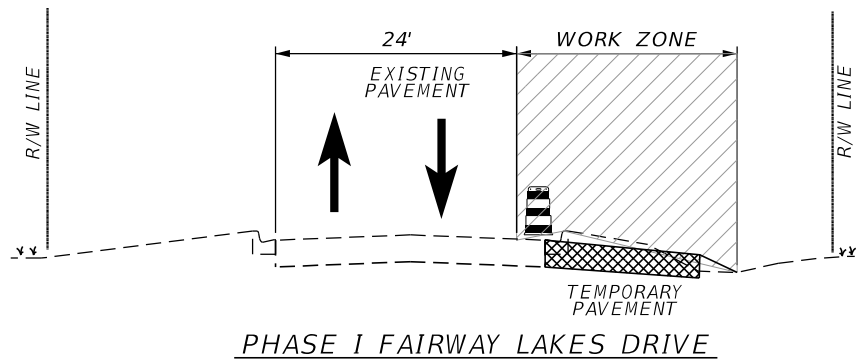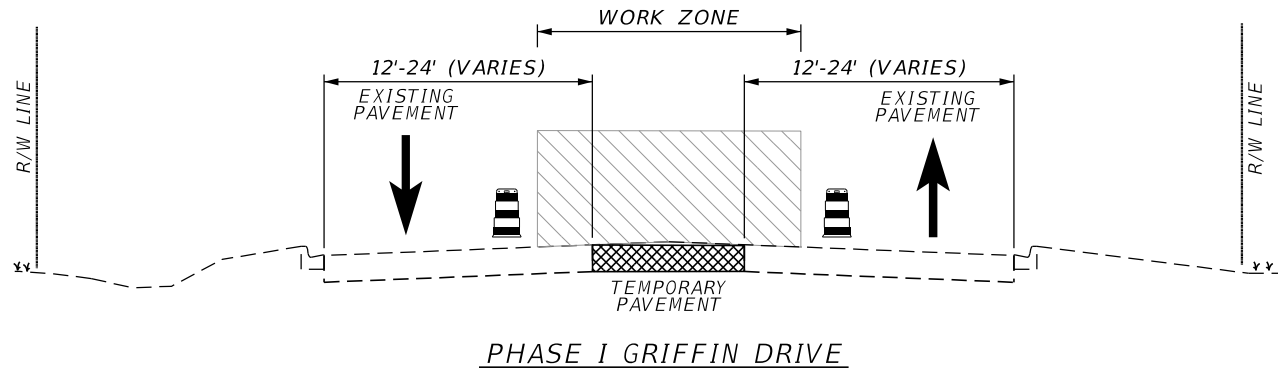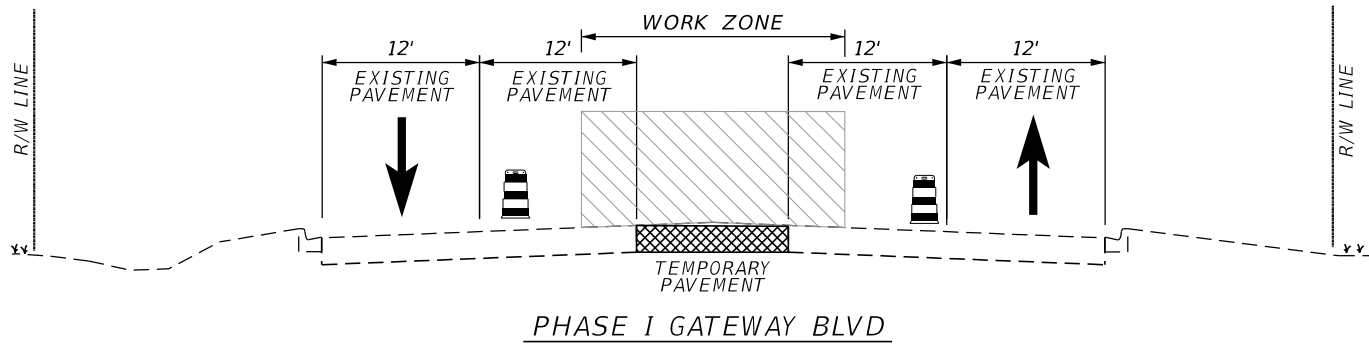


- PHASE I - OPERATIONS ARE TO INSTALL TEMPORARY PAVEMENT FOR PHASE II.
1. INSTALL SIGNING ON GATEWAY BLVD, GRIFFIN DRIVE, AND FAIRWAY LAKES DRIVE IN ACCORDANCE WITH THESE PLANS AND INDICES 102-601, 102-602, 102-603, 102-608, 102-611, 102-612, 102-613.
 2. SHIFT TRAFFIC AND CHANNELIZING DEVICES FOR PHASE I CONSTRUCTION. REMOVE CONFLICTING STRIPING
 3. CONSTRUCT TEMPORARY PAVEMENT FOR PHASE II.

REVISIONS				JASON Y. YAM, P.E. P.E. LICENSE NUMBER 62449 CARDNO, INC. 380 PARK PLACE BOULEVARD, SUITE 300 CLEARWATER, FLORIDA 33759 CERTIFICATE OF AUTHORIZATION 29915	 DEPARTMENT OF TRANSPORTATION	GATEWAY BOULEVARD AT GRIFFIN DRIVE INTERSECTION CONTROL (ROUNDABOUT)		COUNTY PROJECT NO.	SHT. NO.
DATE	DESCRIPTION	DATE	DESCRIPTION			TEMPORARY TRAFFIC CONTROL (1)		200672	52

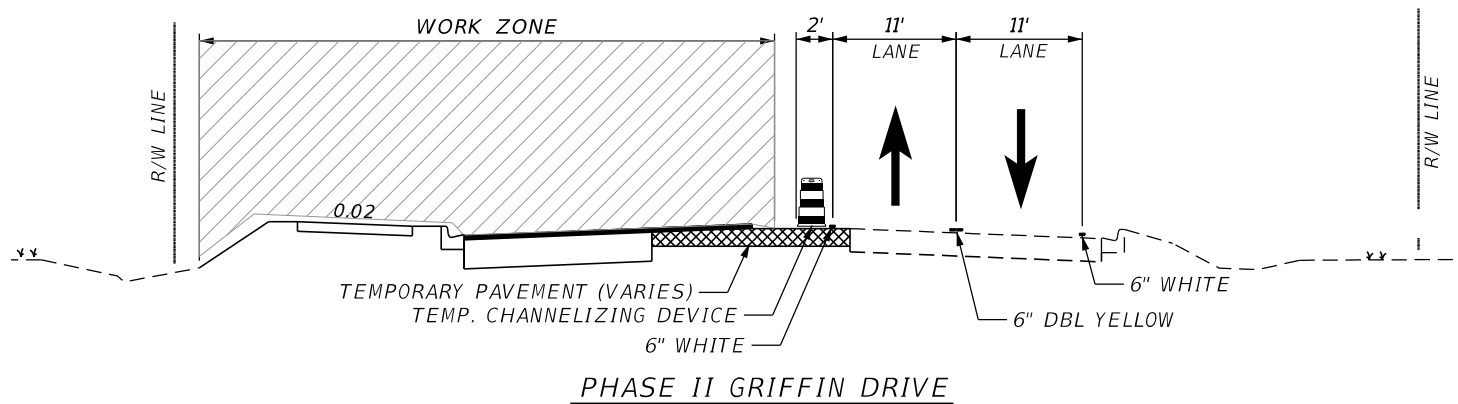


CONSTRUCTION PHASING NOTES

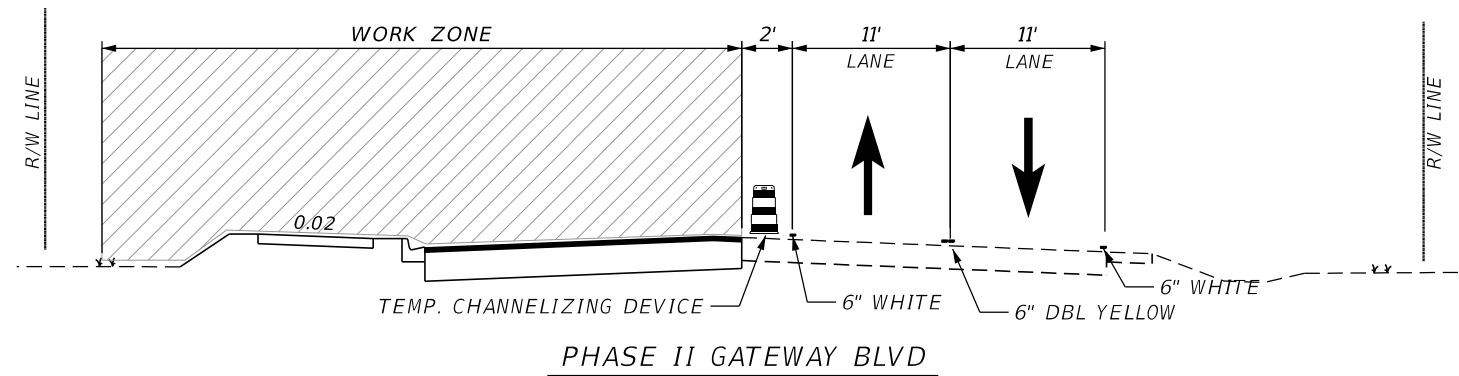


PHASE II - OPERATIONS ARE TO CONSTRUCT GATEWAY BLVD WEST SIDE (SB), FAIRWAY LAKES DRIVE NORTH SIDE (WB), AND GRIFFIN DRIVE NORTH SIDE (WB) NEW ALIGNMENT ALONG WITH TEMPORARY PAVEMENT.

1. INSTALL SIGNING ON GATEWAY BLVD, GRIFFIN DRIVE, AND FAIRWAY LAKES DRIVE IN ACCORDANCE WITH THESE PLANS AND INDICES 102-601, 102-602, 102-603, 102-608, 102-611, 102-612, 102-613.
2. SHIFT TRAFFIC AND CHANNELIZING DEVICES FOR PHASE II CONSTRUCTION.
3. CONSTRUCT GATEWAY BLVD EAST SIDE (NB), FAIRWAY LAKES DRIVE NORTH SIDE (WB), AND COMMERCE LAKES DRIVE NORTH SIDE (WB) NEW ALIGNMENT. THIS WILL INCLUDE LANES, SHOULDERS, CURB AND GUTTERS, SIDEWALKS, EXCLUDING TRAFFIC SEPARATORS AND ROUNDABOUT.
4. CONSTRUCT PROPOSED DRAINAGE AS INDICATED ON THIS PLAN SET.
5. CONSTRUCT TEMPORARY PAVEMENT FOR PHASE III.

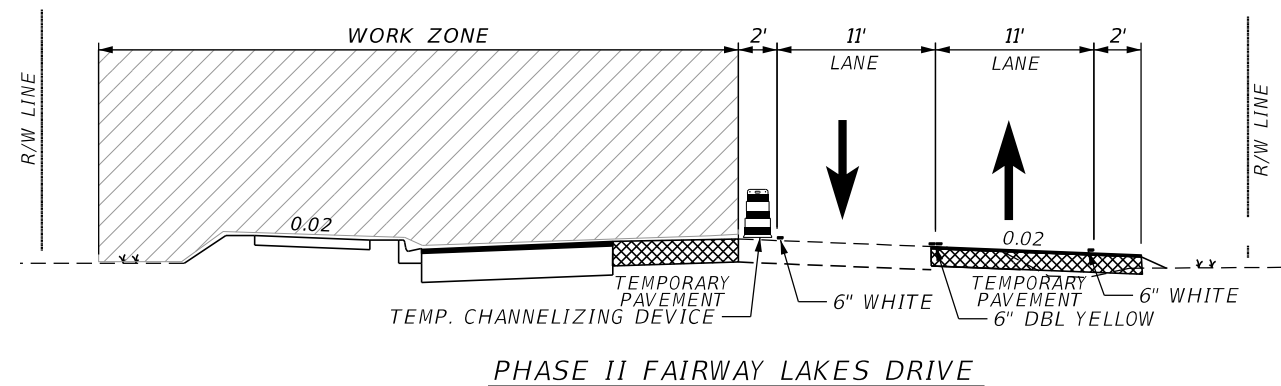


REVISIONS				JASON Y. YAM, P.E. P.E. LICENSE NUMBER 62449 CARDNO, INC. 380 PARK PLACE BOULEVARD, SUITE 300 CLEARWATER, FLORIDA 33759 CERTIFICATE OF AUTHORIZATION 29915		GATEWAY BOULEVARD AT GRIFFIN DRIVE INTERSECTION CONTROL (ROUNDABOUT)	COUNTY PROJECT NO.	SHT. NO.
DATE	DESCRIPTION	DATE	DESCRIPTION			TEMPORARY TRAFFIC CONTROL (2)	200672	53

CONSTRUCTION PHASING NOTES

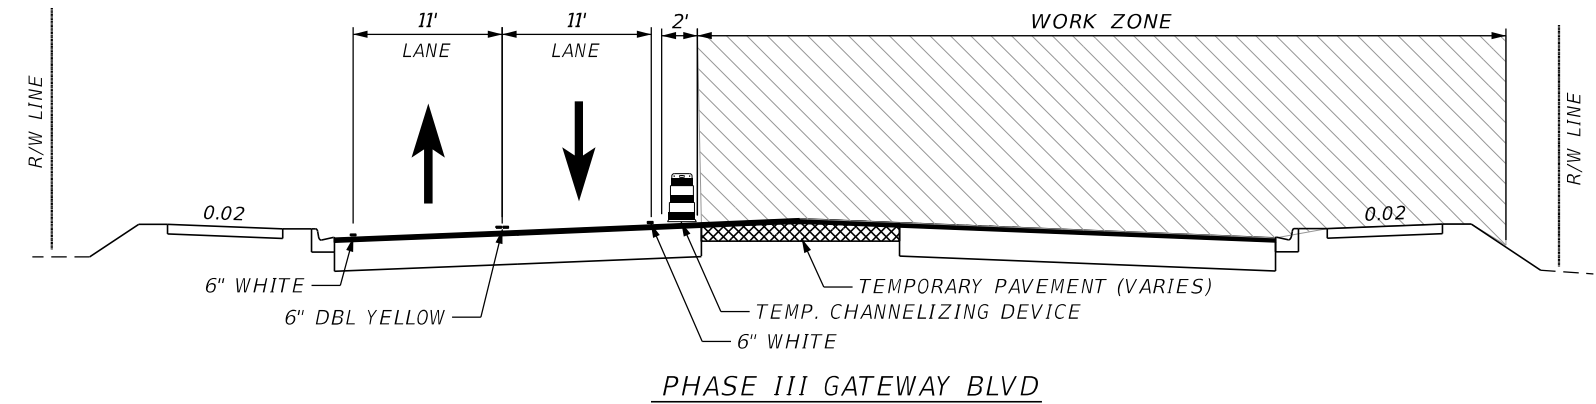


PHASE III - OPERATIONS ARE TO CONSTRUCT GATEWAY BLVD EAST SIDE (NB), FAIRWAY LAKES DRIVE SOUTH SIDE (EB), AND GRIFFIN DRIVE SOUTH SIDE (EB) NEW ALIGNMENT.

1. INSTALL SIGNING ON GATEWAY BLVD, GRIFFIN DRIVE, AND FAIRWAY LAKES DRIVE IN ACCORDANCE WITH THESE PLANS AND INDICES 102-601, 102-602, 102-603, 102-608, 102-611, 102-612, 102-613.
2. SHIFT TRAFFIC AND CHANNELIZING DEVICES FOR PHASE III CONSTRUCTION.
3. CONSTRUCT GATEWAY BLVD EAST SIDE (NB), FAIRWAY LAKES DRIVE SOUTH SIDE (EB), AND GRIFFIN DRIVE SOUTH SIDE (EB) NEW ALIGNMENT. THIS WILL INCLUDE LANES, CURB AND GUTTERS, SIDEWALKS, EXCLUDING TRAFFIC SEPARATORS AND ROUNDABOUT.
4. CONSTRUCT PROPOSED DRAINAGE AS INDICATED ON THIS PLAN SET.

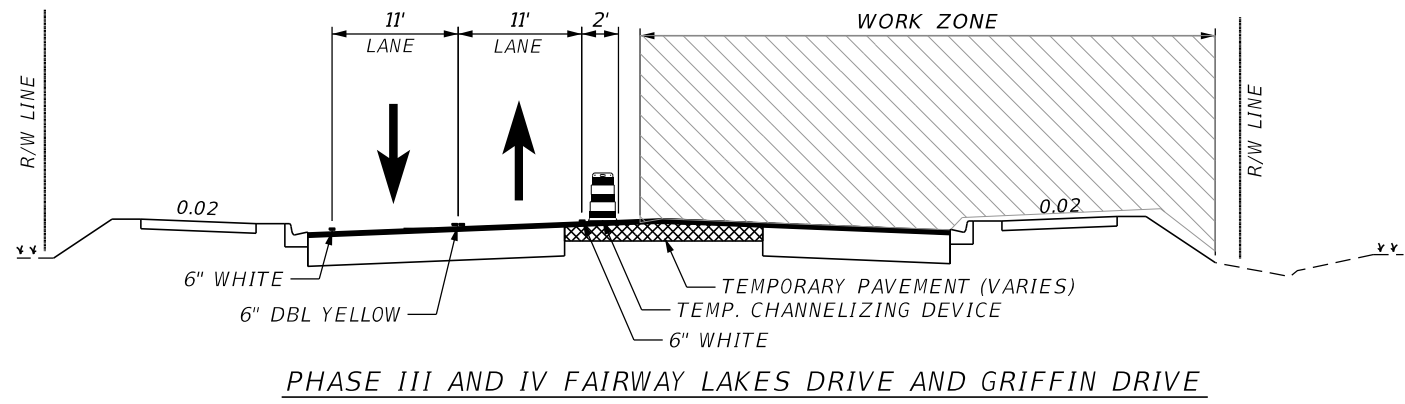


PHASE IV - OPERATIONS ARE TO CONSTRUCT THE SOUTHEAST SECTION OF THE PROPOSED INTERSECTION.

1. INSTALL SIGNING ON GATEWAY BLVD, GRIFFIN DRIVE, AND FAIRWAY LAKES DRIVE IN ACCORDANCE WITH THESE PLANS AND INDICES 102-601, 102-602, 102-603, 102-608, 102-611, 102-612, 102-613.
2. MOVE CHANNELIZING DEVICES AND SHIFT TRAFFIC FOR PHASE IV CONSTRUCTION.
3. CONSTRUCT THE INTERSECTION AREA OF GATEWAY BLVD AND FAIRWAY LAKES DRIVE WHICH WAS NOT ACCESSIBLE DURING PHASES II AND III.

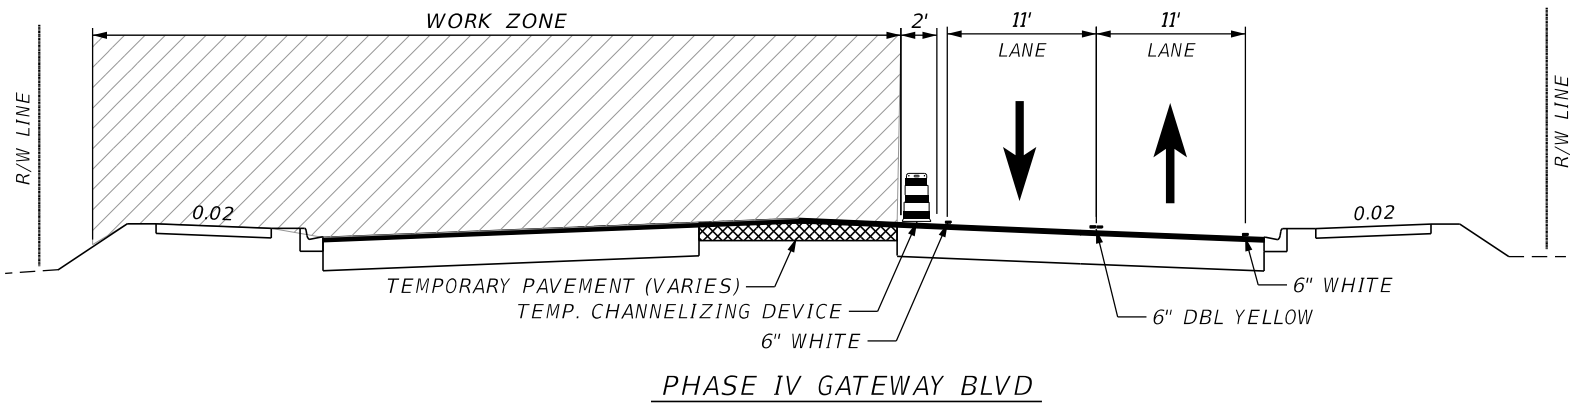

REVISIONS				JASON Y. YAM, P.E. P.E. LICENSE NUMBER 62449 CARDNO, INC. 380 PARK PLACE BOULEVARD, SUITE 300 CLEARWATER, FLORIDA 33759 CERTIFICATE OF AUTHORIZATION 29915		GATEWAY BOULEVARD AT GRIFFIN DRIVE INTERSECTION CONTROL (ROUNDABOUT)	COUNTY PROJECT NO.	SHT. NO.
DATE	DESCRIPTION	DATE	DESCRIPTION			TEMPORARY TRAFFIC CONTROL (3)	200672	54


CONSTRUCTION PHASING NOTES

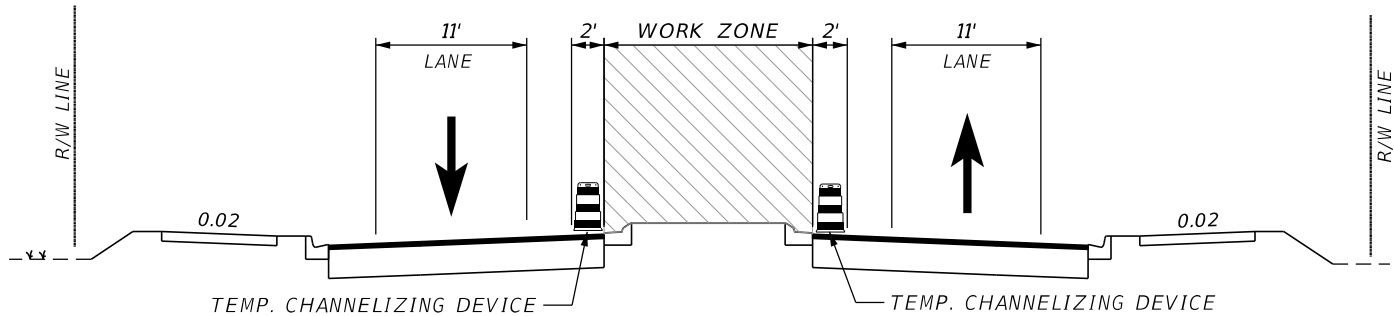

PHASE V FAIRWAY LAKES DRIVE AND GRIFFIN DRIVE

PHASE V - OPERATIONS ARE TO MOVE TRAFFIC ONTO NEWLY CONSTRUCTED ROADWAY AND CONSTRUCT TRAFFIC SEPARATORS, THE CENTER OF THE ROUNDABOUT, COMPLETE ANY REMAINING SIDEWALKS ON GRIFFIN DRIVE AND REMOVE TEMPORARY PAVEMENT FROM THE PREVIOUS PHASES OF CONSTRUCTION.


1. INSTALL SIGNING ON GATEWAY BLVD, GRIFFIN DRIVE, AND FAIRWAY LAKES DRIVE IN ACCORDANCE WITH THESE PLANS AND INDICES 102-601, 102-602, 102-603, 102-608, 102-611, 102-612, 102-613.
2. MILL AND RESURFACE GATEWAY BLVD AND GRIFFIN DRIVE.
3. MOVE CHANNELIZING DEVICES AND SHIFT TRAFFIC TO FINAL TRAFFIC PATTERN ON NEWLY CONSTRUCTED ROADWAYS. CONSTRUCT SPLITTER ISLANDS, REMAINING SIDEWALK ON GRIFFIN DRIVE, AS WELL AS CENTER OF THE ROUNDABOUT.
4. REMOVE TEMPORARY PAVEMENT FROM PREVIOUS PHASES.
4. COMPLETE INSTALLATION OF PERMANENT SIGNING WITHIN PROJECT LIMITS.
5. COMPLETE FRICTION COURSE WITHIN PROJECT LIMITS.
6. COMPLETE PLACEMENT OF THERMOPLASTIC PAVEMENT MARKINGS.

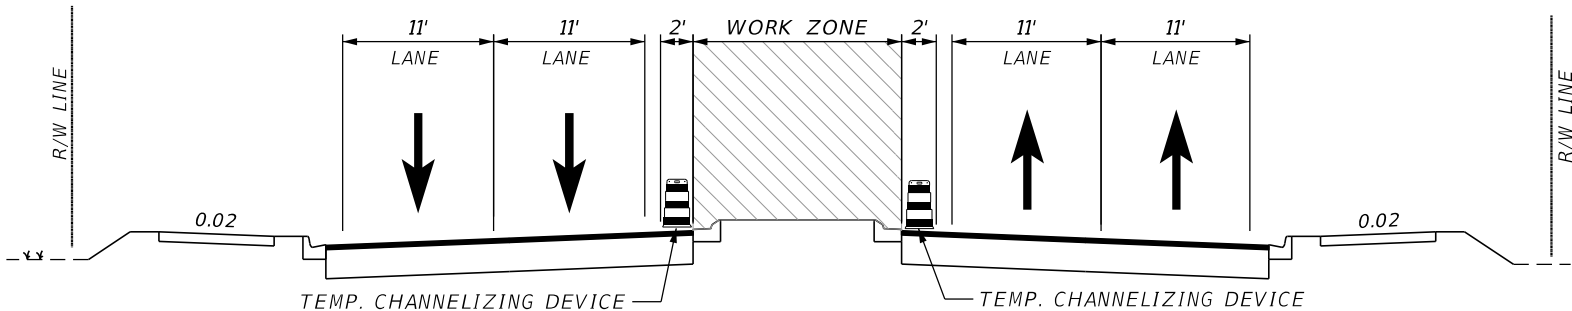


PHASE V GATEWAY BLVD

REVISIONS				JASON Y. YAM, P.E. P.E. LICENSE NUMBER 62449 CARDNO, INC. 380 PARK PLACE BOULEVARD, SUITE 300 CLEARWATER, FLORIDA 33759 CERTIFICATE OF AUTHORIZATION 29915	Lee County Southwest Florida DEPARTMENT OF TRANSPORTATION	GATEWAY BOULEVARD AT GRIFFIN DRIVE INTERSECTION CONTROL (ROUNDABOUT)	COUNTY PROJECT NO.	SHT. NO.
DATE	DESCRIPTION	DATE	DESCRIPTION			TEMPORARY TRAFFIC CONTROL (4)	200672	55

THE OFFICIAL RECORD OF THIS SHEET IS THE ELECTRONIC FILE DIGITALLY SIGNED AND SEALED UNDER RULE 61G15-23.004, F.A.C.

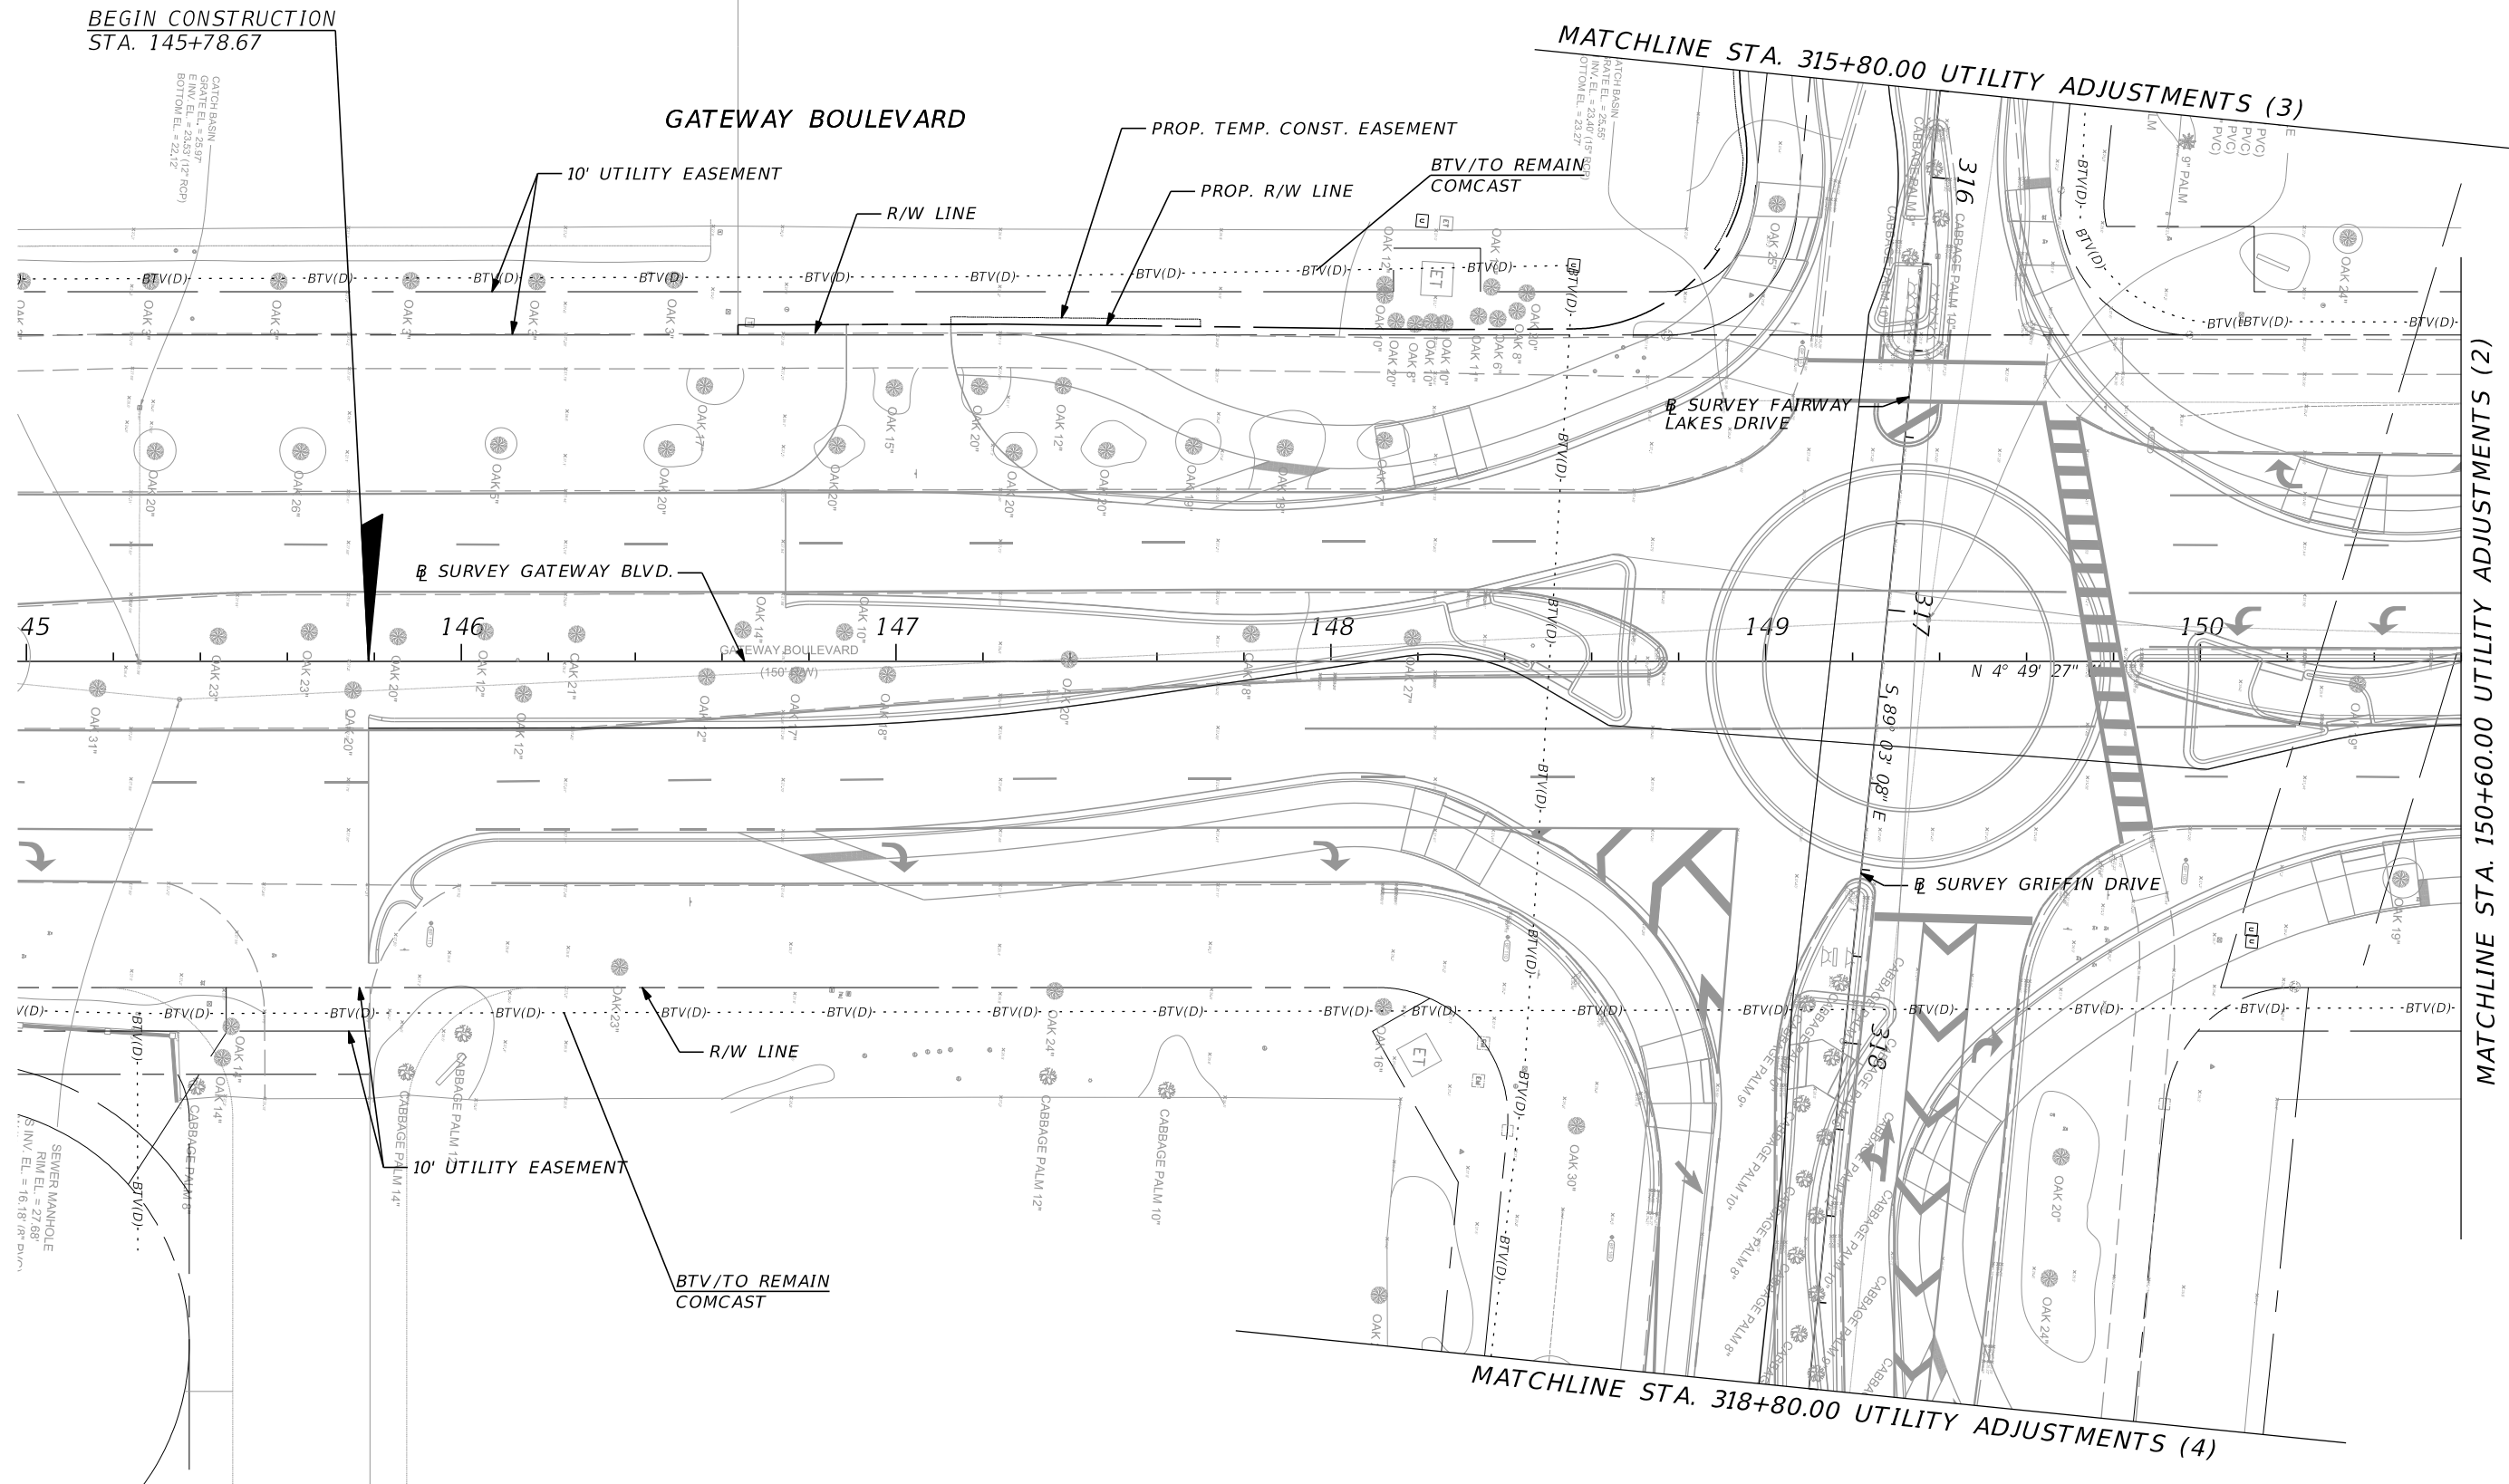


REVISIONS				JASON Y. YAM, P.E. P.E. LICENSE NUMBER 62449 CARDNO, INC. 380 PARK PLACE BOULEVARD, SUITE 300 CLEARWATER, FLORIDA 33759 CERTIFICATE OF AUTHORIZATION 29915	 Lee County Southwest Florida DEPARTMENT OF TRANSPORTATION	GATEWAY BOULEVARD AT GRIFFIN DRIVE INTERSECTION CONTROL (ROUNDAABOUT)		COUNTY PROJECT NO.	SHT. NO.
DATE	DESCRIPTION	DATE	DESCRIPTION			UTILITY ADJUSTMENTS (1)		200672	56

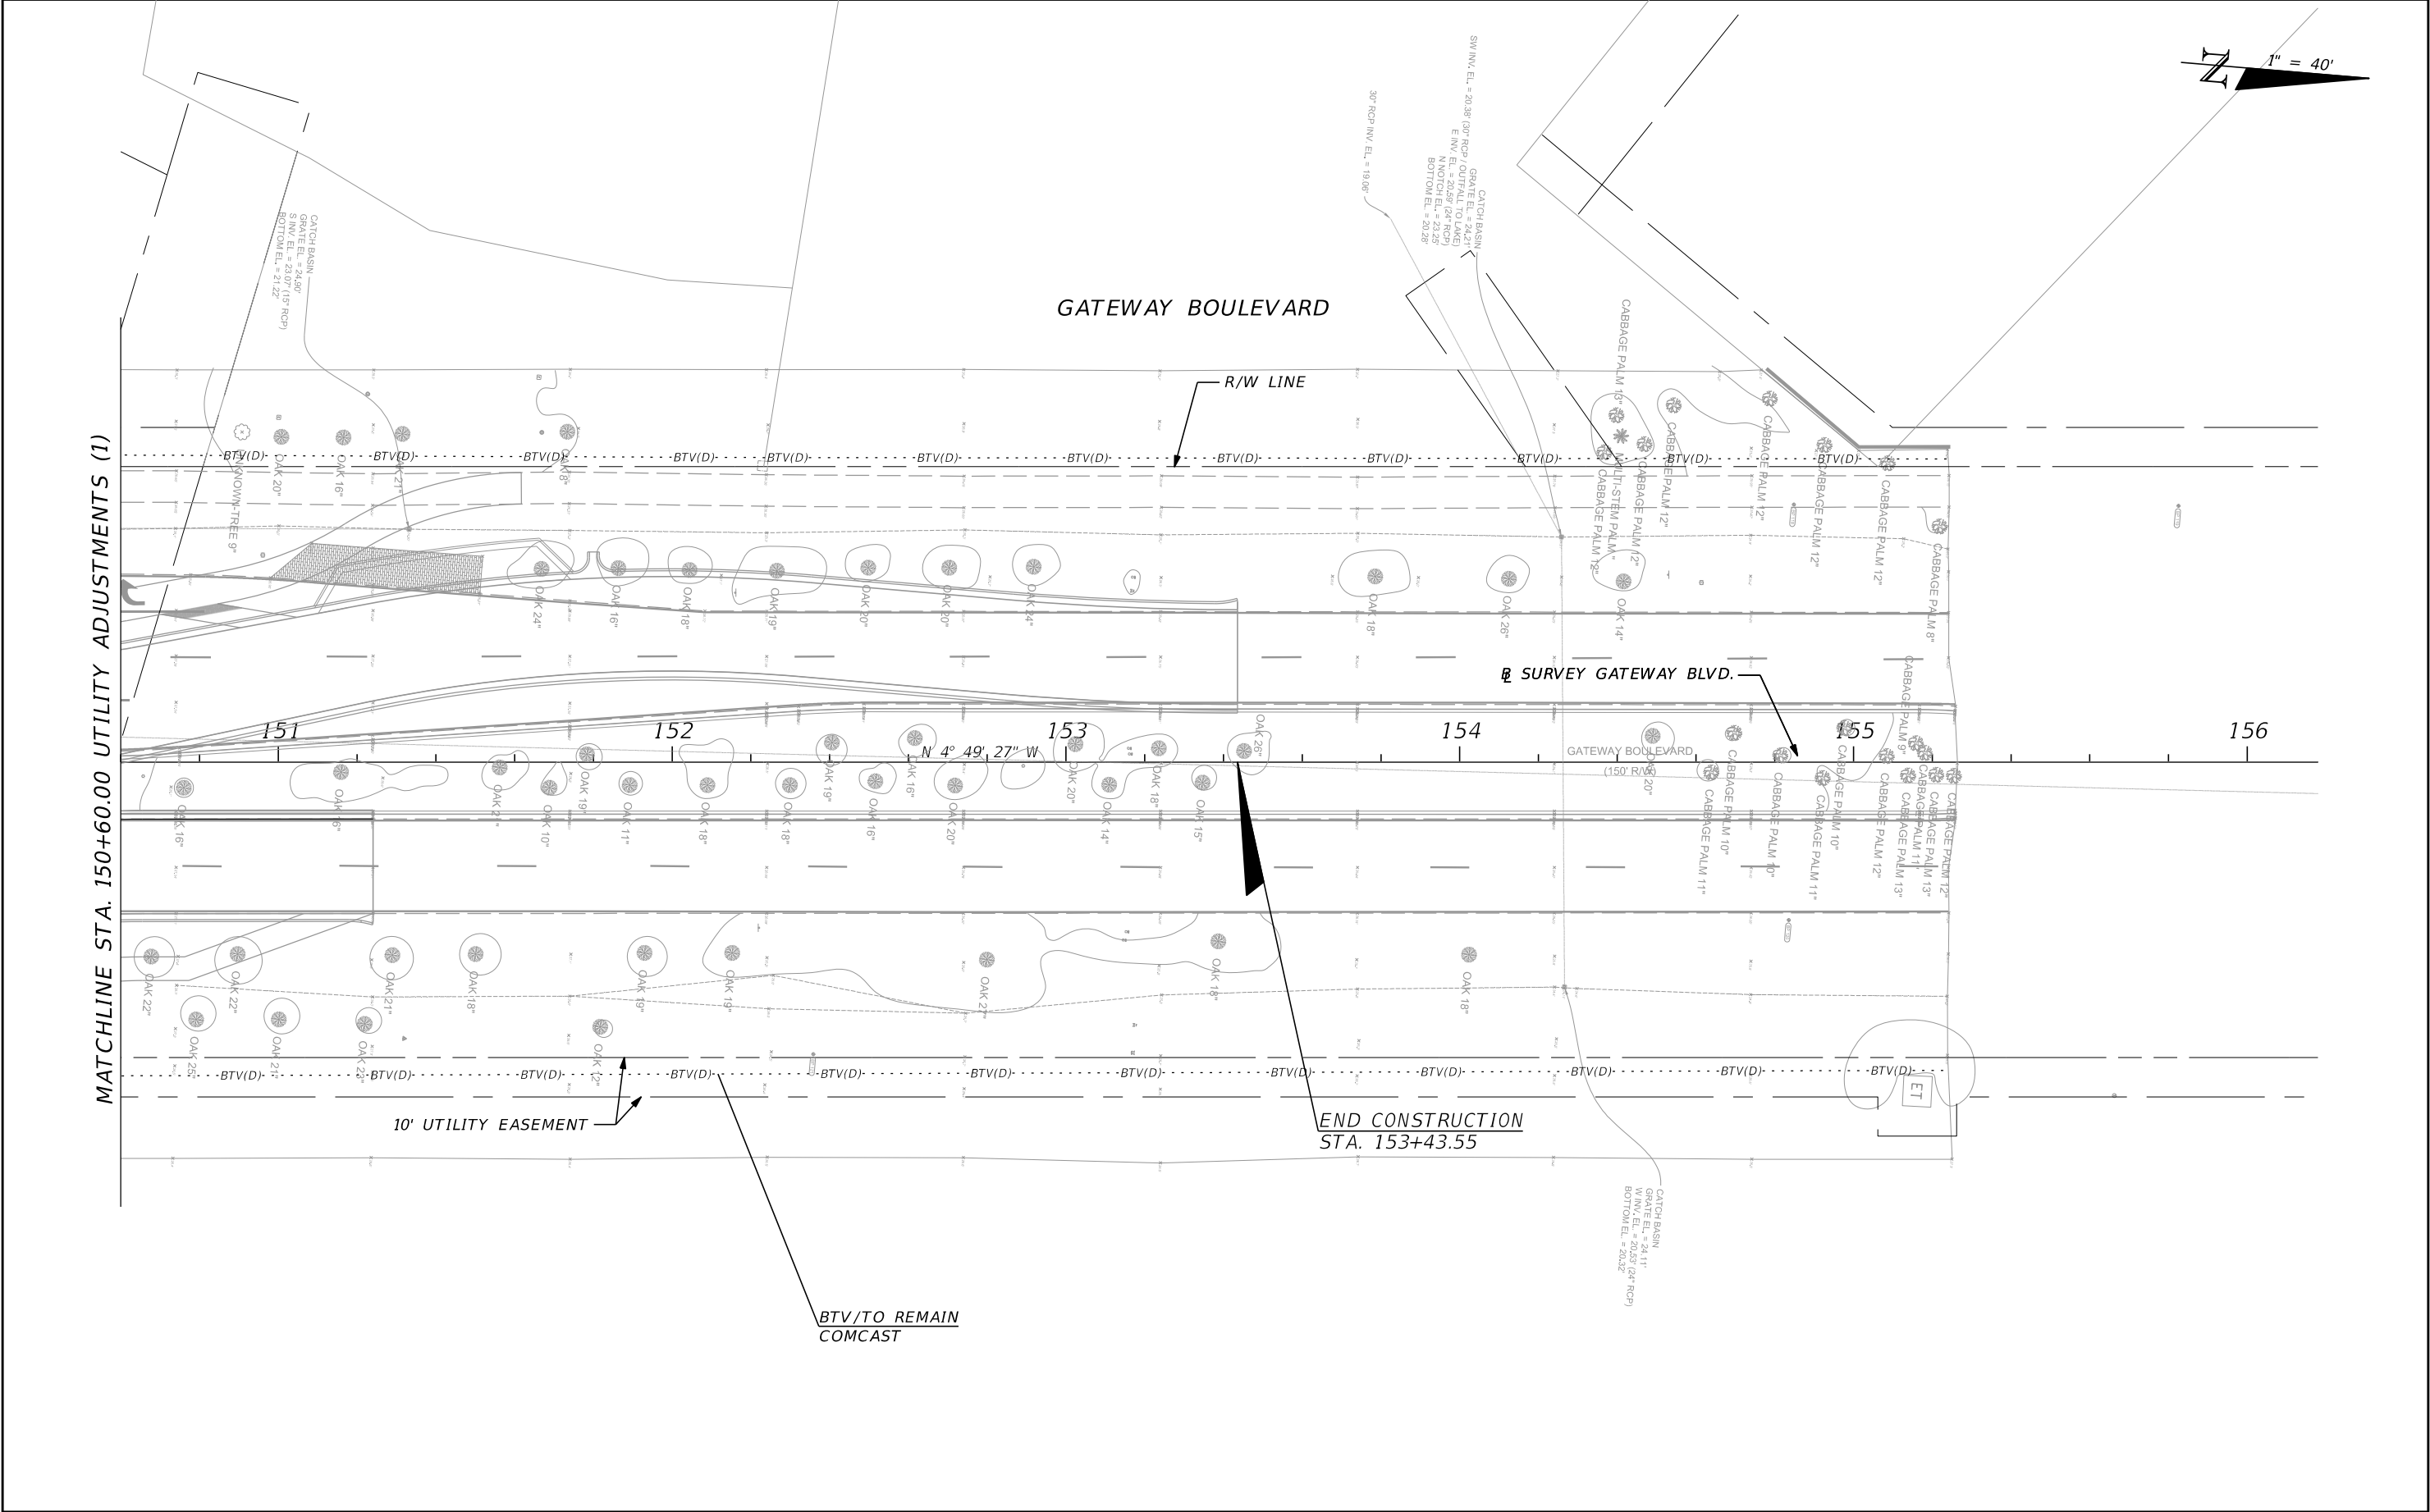

REVISIONS				JASON Y. YAM, P.E. P.E. LICENSE NUMBER 62449 CARDNO, INC. 380 PARK PLACE BOULEVARD, SUITE 300 CLEARWATER, FLORIDA 33759 CERTIFICATE OF AUTHORIZATION 29915	 DEPARTMENT OF TRANSPORTATION	GATEWAY BOULEVARD AT GRIFFIN DRIVE INTERSECTION CONTROL (ROUNDAABOUT)		COUNTY PROJECT NO.	SHT. NO.
DATE	DESCRIPTION	DATE	DESCRIPTION			UTILITY ADJUSTMENTS (2)		200672	57


THE OFFICIAL RECORD OF THIS SHEET IS THE ELECTRONIC FILE DIGITALLY SIGNED AND SEALED UNDER RULE 61G15-23.004, F.A.C.

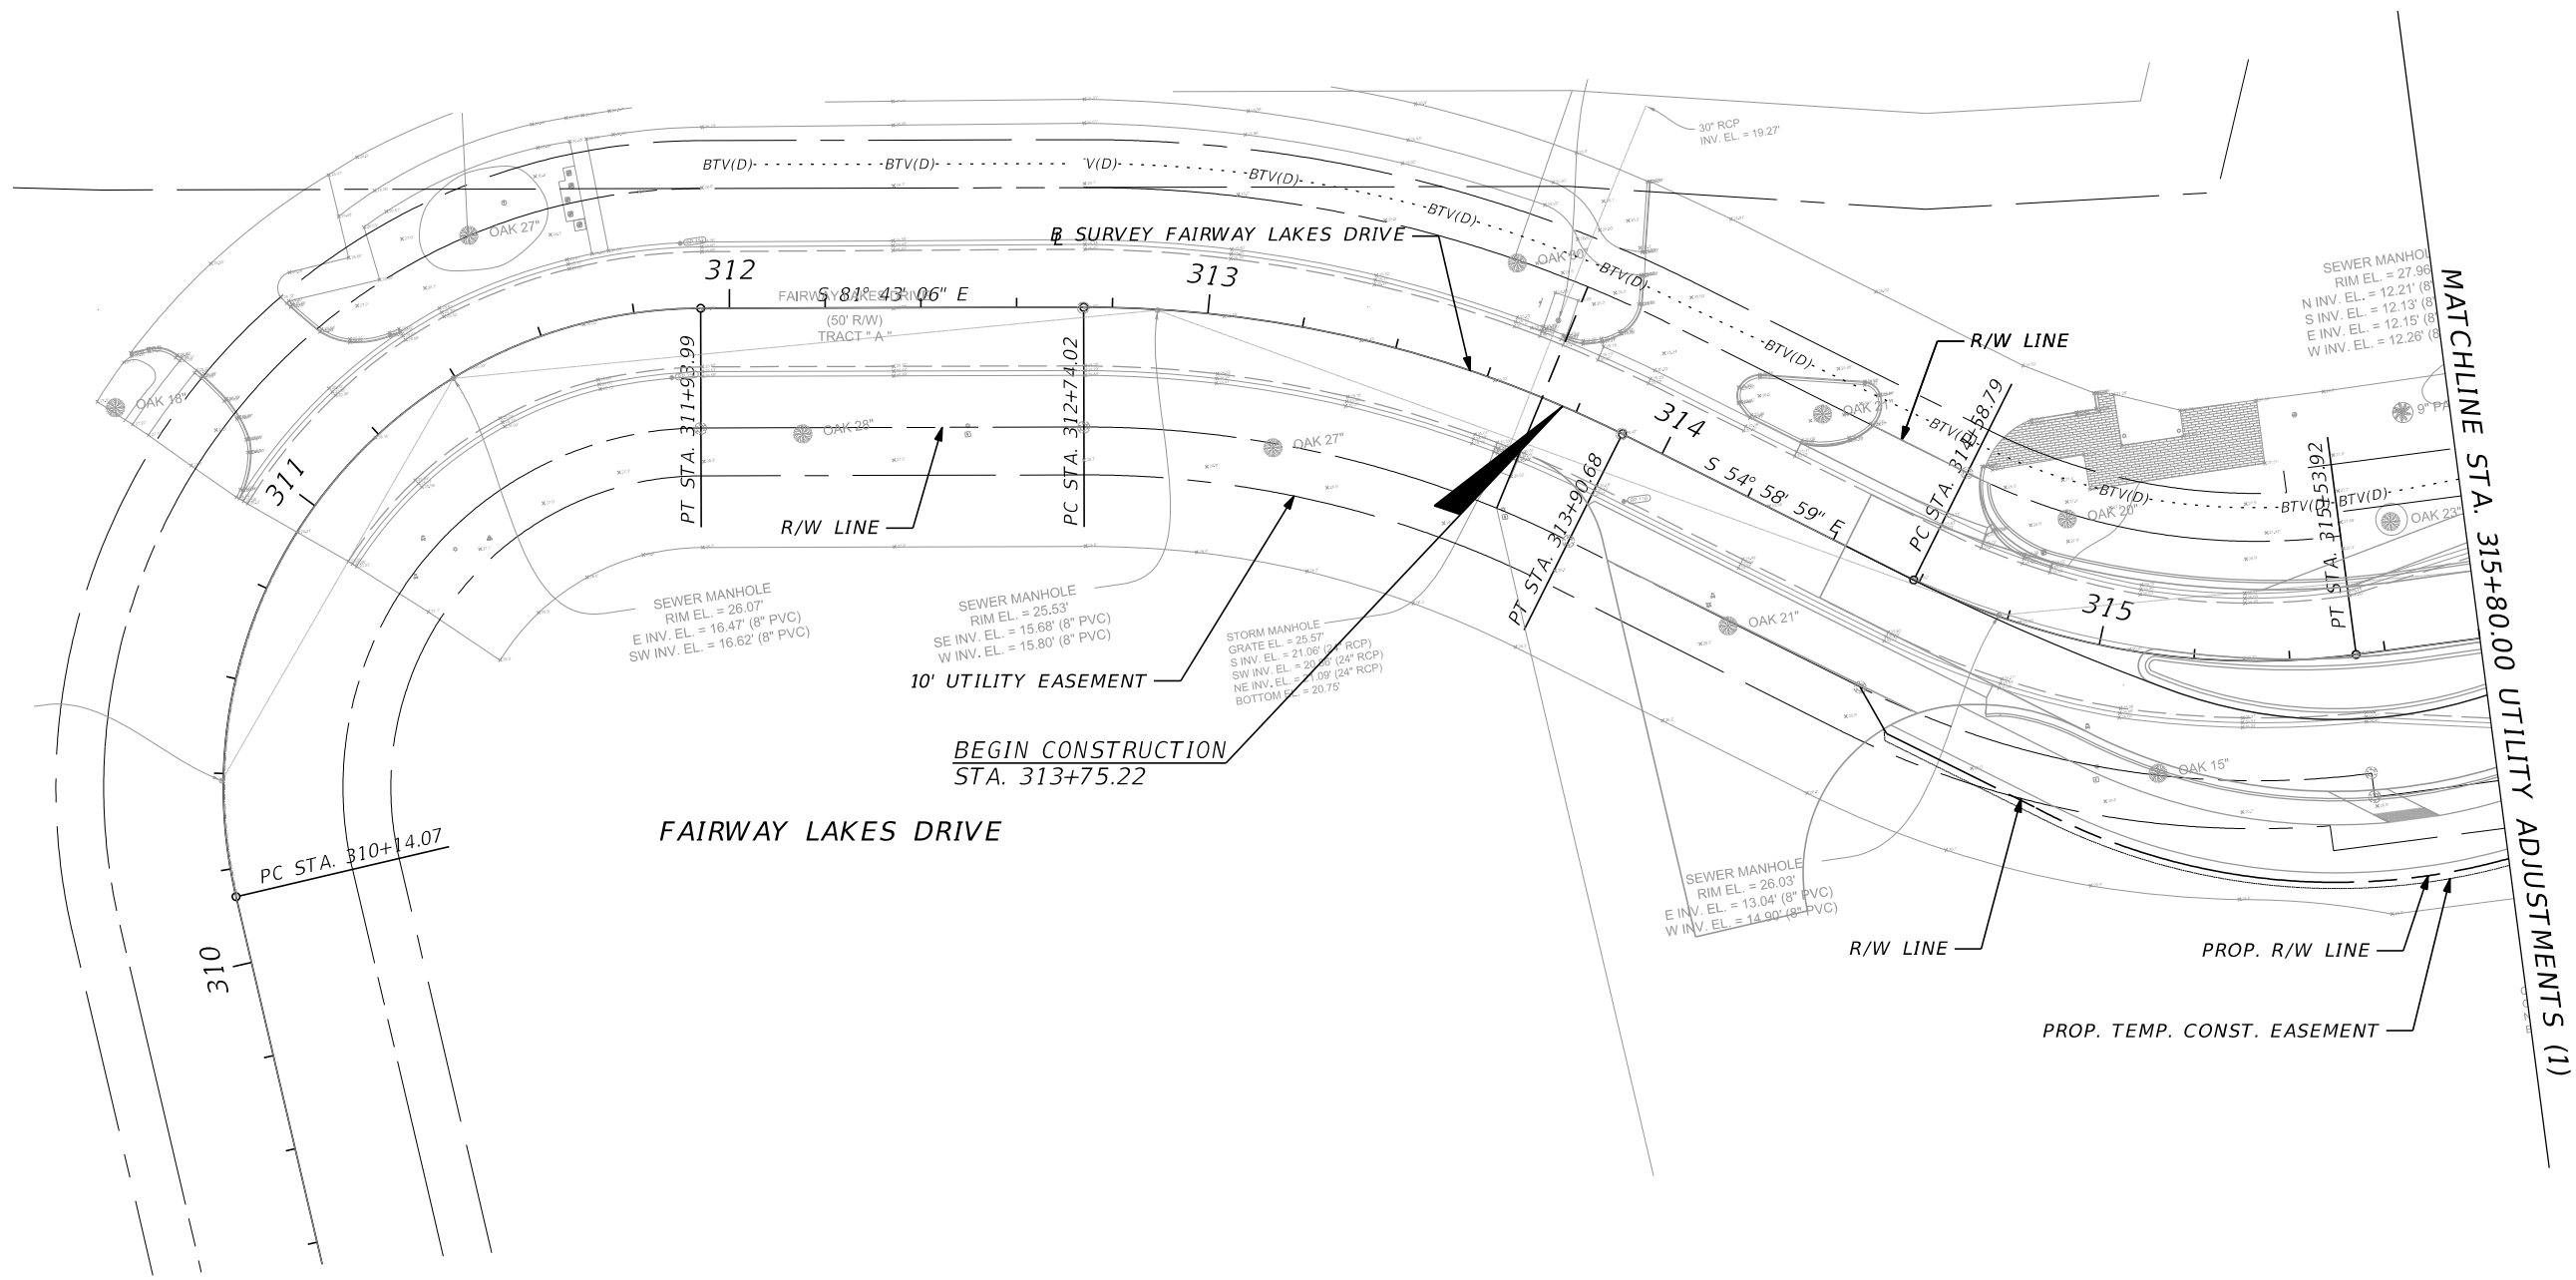

REVISIONS				JASON Y. YAM, P.E. P.E. LICENSE NUMBER 62449 CARDNO, INC. 380 PARK PLACE BOULEVARD, SUITE 300 CLEARWATER, FLORIDA 33759 CERTIFICATE OF AUTHORIZATION 29915	 DEPARTMENT OF TRANSPORTATION	GATEWAY BOULEVARD AT GRIFFIN DRIVE INTERSECTION CONTROL (ROUNDAABOUT)		COUNTY PROJECT NO.	SHT. NO.
DATE	DESCRIPTION	DATE	DESCRIPTION			UTILITY ADJUSTMENTS (3)		200672	58

THE OFFICIAL RECORD OF THIS SHEET IS THE ELECTRONIC FILE DIGITALLY SIGNED AND SEALED UNDER RULE 61G15-23.004, F.A.C.

MATCHLINE STA. 318+76.00 UTILITY ADJUSTMENTS (1)


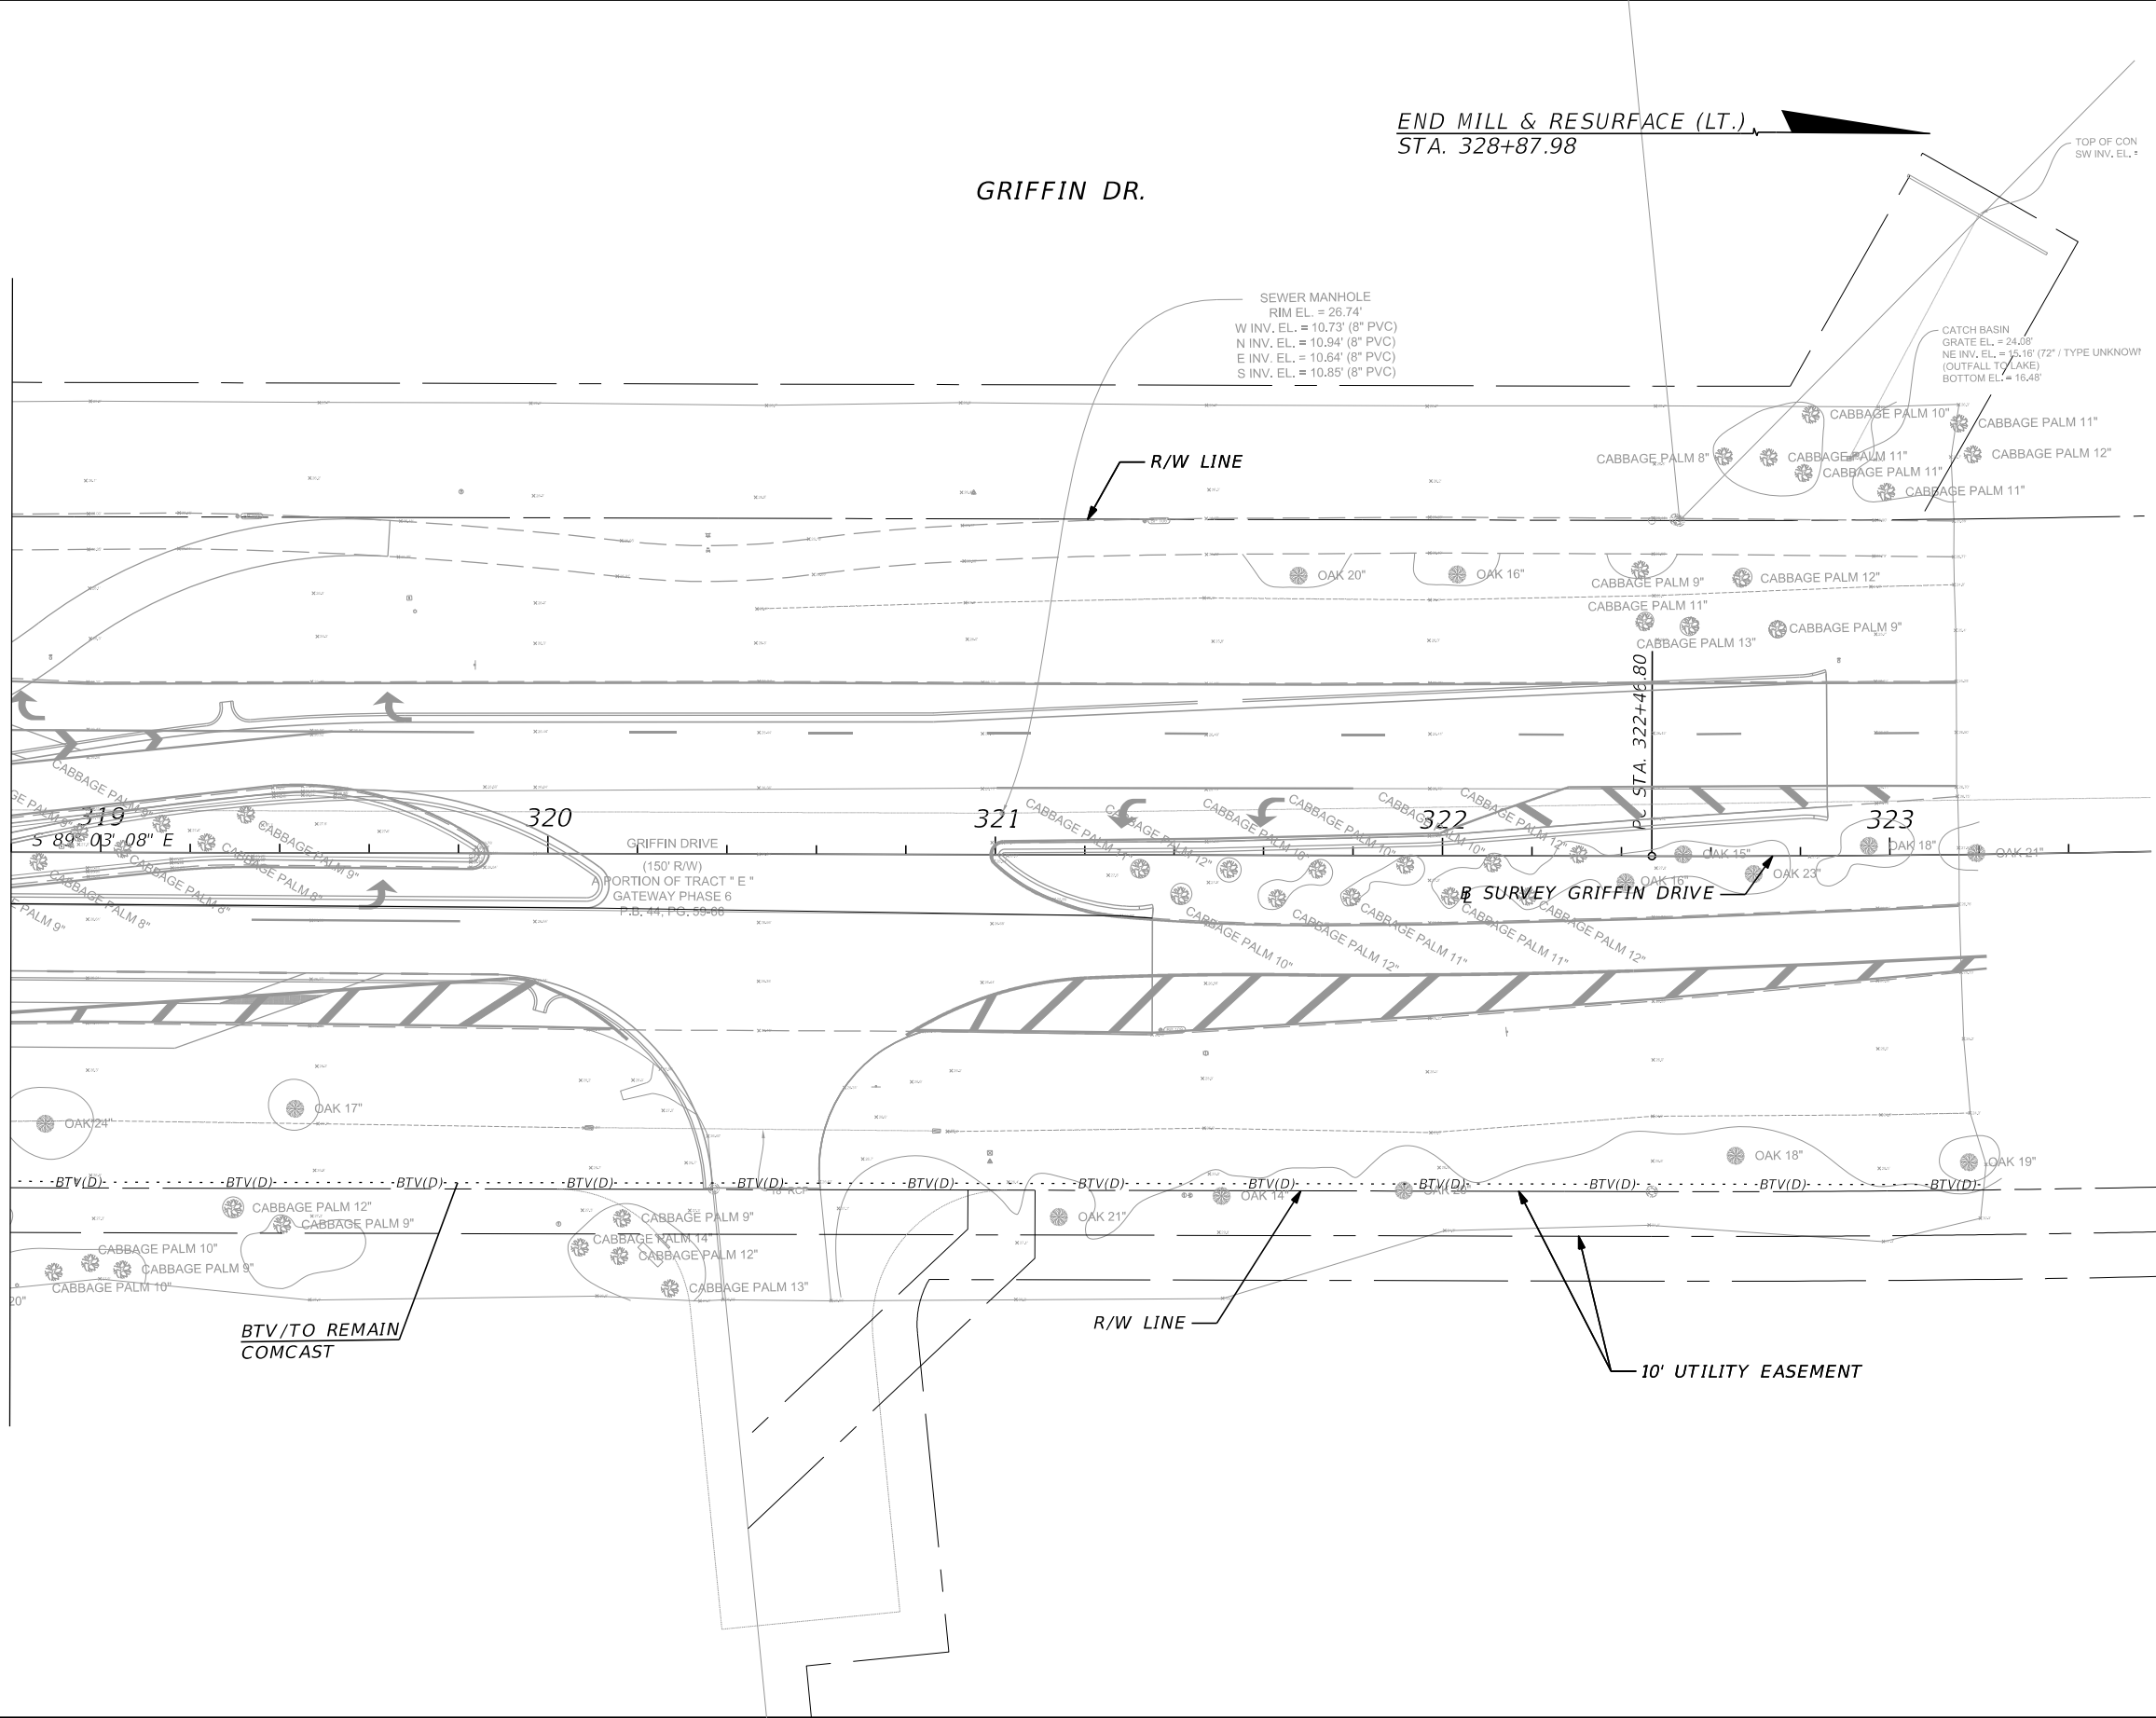


REVISIONS				JASON Y. YAM, P.E. P.E. LICENSE NUMBER 62449 CARDNO, INC. 380 PARK PLACE BOULEVARD, SUITE 300 CLEARWATER, FLORIDA 33759 CERTIFICATE OF AUTHORIZATION 29915	 DEPARTMENT OF TRANSPORTATION	GATEWAY BOULEVARD AT GRIFFIN DRIVE INTERSECTION CONTROL (ROUNABOUT)		COUNTY PROJECT NO.	SHT. NO.
DATE	DESCRIPTION	DATE	DESCRIPTION			UTILITY ADJUSTMENTS (4)		200672	59




THE OFFICIAL RECORD OF THIS SHEET IS THE ELECTRONIC FILE DIGITALLY SIGNED AND SEALED UNDER RULE 61G15-23.004, F.A.C.

NOTES:

1. Crown Dripline Protection Zone: Extends in all directions from trunk of tree to a distance equal to one foot per inch of trunk diameter at breast height.
2. Staging, storage, dumping, washing and operation of equipment is not permitted within the limits of the tree protection barrier, including during barrier installation.
3. Install all tree protection prior to commencement of construction and remove when directed by the engineer. Maintain protection at all times.
4. For closely spaced groups of trees, place the tree protection barrier around the entire group.
5. Inspect trunk protection and tree quarterly to prevent girdling. Adjust bands to allow tree growth as needed.
6. See plans for any additional requirements or modifications within the tree protection area.
7. Place weather resistant sign every 50' along the barrier, with 6" minimum text height and provide text in English and Spanish. Sign should read "Keep Out Tree Protection Area".
8. Alternate tree protection systems approved by the Engineer may be used in lieu of the tree protection barrier detailed on this Index.

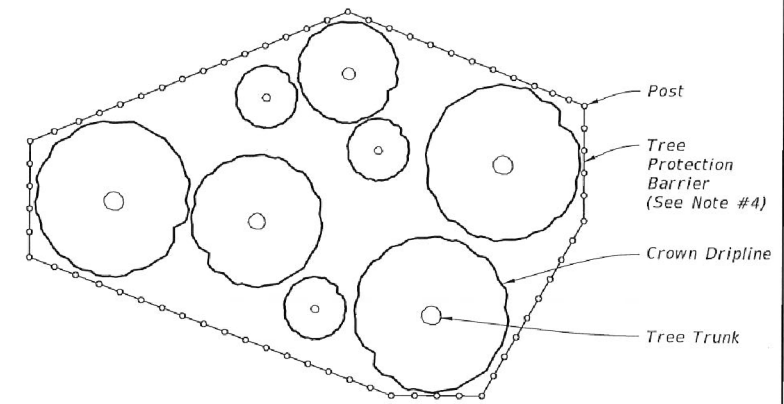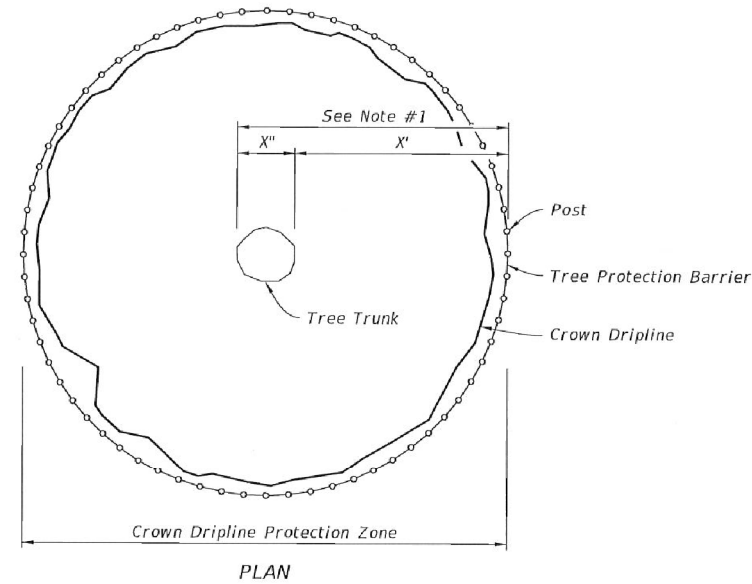

PLAN
PROTECTION BARRIER FOR TREE GROUPINGS

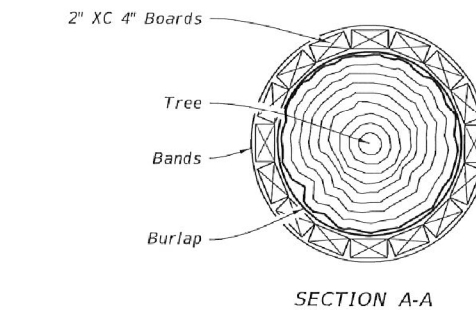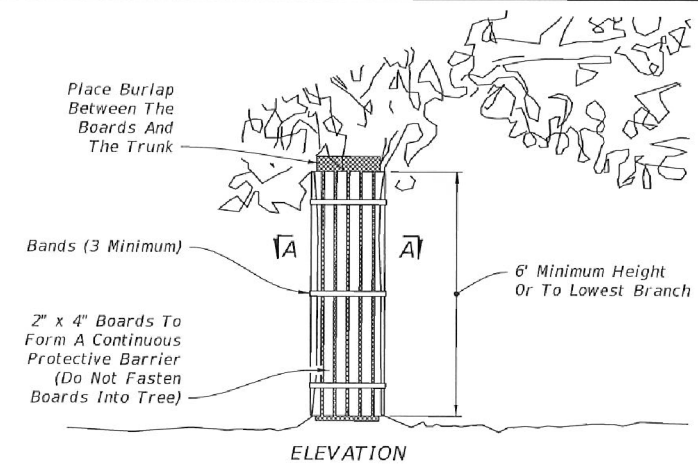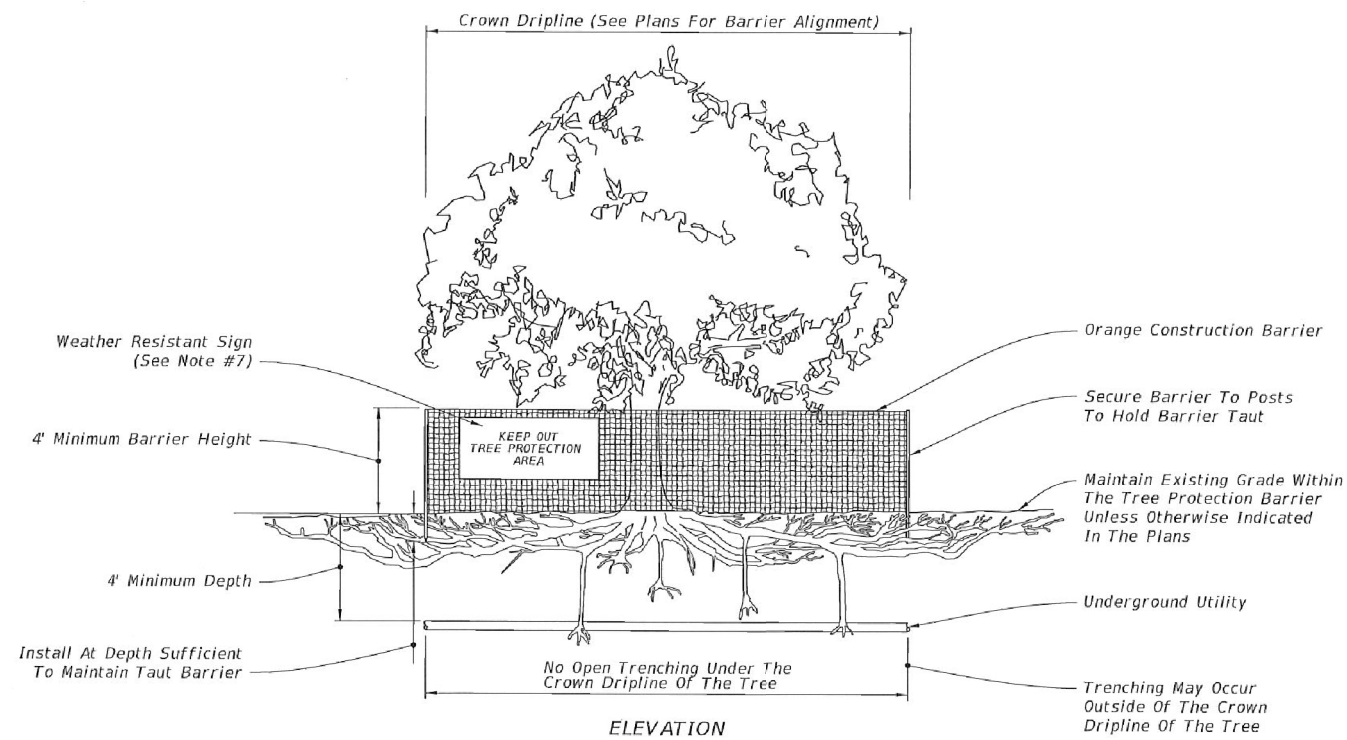

NOTES:

1. Install trunk protection when Tree Protection Barrier can not be reasonably erected.
2. See Selective Clearing and Grubbing Plan for location of trunk protection.
3. Adjust bands to allow tree growth (inspect quarterly to prevent girdling).

TRUNK PROTECTION

10/11/2016 9:24:43 AM

LAST REVISION	DESCRIPTION:	FDOT	FY 2017-18	TREE PROTECTION AND PRESERVATION	INDEX NO.	SHEET NO.
11/01/16			DESIGN STANDARDS		542	1 of 1

REVISIONS				JASON Y. YAM, P.E. P.E. LICENSE NUMBER 62449 CARDNO, INC. 380 PARK PLACE BOULEVARD, SUITE 300 CLEARWATER, FLORIDA 33759 CERTIFICATE OF AUTHORIZATION 29915	 Lee County Southwest Florida DEPARTMENT OF TRANSPORTATION	GATEWAY BOULEVARD AT GRIFFIN DRIVE INTERSECTION CONTROL (ROUNDABOUT)		COUNTY PROJECT NO.	SHT. NO.
DATE	DESCRIPTION	DATE	DESCRIPTION			TREE PROTECTION DETAILS		200672	60

PAY ITEM NOTES:

110-1-1 CLEARING AND GRUBBING INCLUDES THE COST OF TREE TRIMMING BY PROFESSIONAL ARBORISTS AND REMOVAL OF DEBRIS AT LOCATIONS WHERE TREE BRANCHES OR SHRUBS CONFLICT WITH THE PROPOSED LIGHTING POLES.

520-1-10 CONCRETE FLUME TO BE PAID AS CURB AND GUTTER.

570-1-2 EXISTING SOD IS MOSTLY ST. AUGUSTINE, MATCH EXISTING.

527-2 ALL DETECTABLE WARNINGS SHALL BE WET SET.

919-528 ALL DIRECTIONAL INDICATORS SHALL BE WET SET.

*** ROOT CONTROL BARRIER SHALL BE INSTALLED TO CONFORM TO THE REQUIREMENTS AS SET FORTH BY THE MANUFACTOURER, TO A MINIMAL DEPTH OF 12" BELOW FINISH GRADE OF ADJACENT SIDEWLAK OR CURBING. ROOT BARRIER SHALL BE FREE OF FOLDS AND TEARS TO PRODUCE AN EFFECTIVE BARRIER BETWEEN CONCRETE CONSTRUCTION AND TREES. INSTALLATION SHALL BE PERPENDICULAR TO FINISH GRADE AND ALL EDGES SHALL BE BELOW FINISH GRADE ONCE RESTORATION OF THE ADJACENT DISTURBED AREA HAS BEEN COMPLETED. THE CONTRACTOR SHALL PROVIDE TO THE ENGINEER A MANUFACTURER'S CERTIFICATE STATING THE MANUFACTURER'S NAME, PRODUCT NAME, STYLE NUMBER, CHEMICAL COMPOSITION, AND OTHER PERTINENT INFORMATION TO FULLY DESCRIBE THE PRODUCT. THE CONTRACTOR SHALL AFFIX AN APPLICABLE MSDS TO THE OUTSIDE OF EACH SHIPPING CONTAINER FOR THE PRODUCT.

SUMMARY OF LUMP SUM ITEMS					
PAY ITEM NO.	PAY ITEM DESCRIPTION	QUANTITY		DESIGN NOTES	CONSTRUCTION REMARKS
		P	F		
101-1	MOBILIZATION	1			

SUMMARY OF TEMPORARY TRAFFIC CONTROL PLAN ITEMS								
PAY ITEM NO.	PAY ITEM DESCRIPTION	UNIT	TOTAL		GRAND TOTAL		DESIGN NOTES	CONSTRUCTION REMARKS
			P	F	P	F		
102-1	MAINTENANCE OF TRAFFIC	LS	1		1		365 DA	

REVISIONS				JASON Y. YAM, P.E. P.E. LICENSE NUMBER 62449 CARDNO, INC. 380 PARK PLACE BOULEVARD, SUITE 300 CLEARWATER, FLORIDA 33759 CERTIFICATE OF AUTHORIZATION 29915	Lee County Southwest Florida DEPARTMENT OF TRANSPORTATION	GATEWAY BOULEVARD AT GRIFFIN DRIVE INTERSECTION CONTROL (ROUNDAABOUT)	COUNTY PROJECT NO.	SHT. NO.
DATE	DESCRIPTION	DATE	DESCRIPTION			SUMMARY OF QUANTITIES	200672	SQ-1

[illegible]

THE OFFICIAL RECORD OF THIS SHEET IS THE ELECTRONIC FILE DIGITALLY SIGNED AND SEALED UNDER RULE 61G15-23.004, F.A.C.

SUMMARY OF EARTHWORK					
PAY ITEM NO.	PAY ITEM DESCRIPTION	CY		DESIGN NOTES	CONSTRUCTION REMARKS
		P	F		
120-1	REGULAR EXCAVATION				
120-2	EMBANKMENT				

EARTHWORK HAS BEEN CALCULATED USING THE ASPHALT BASE OPTION. IF ANOTHER OPTION IS CONSTRUCTED, THERE SHALL BE NO REVISION TO THE EARTHWORK QUANTITIES FOR WHICH PAYMENT IS MADE BY PLAN QUANTITY.

SUMMARY OF TURNOUTS						
LOCATION	SIDE	AREA ID	0286 1		DESIGN NOTES	CONSTRUCTION REMARKS
STA. TO STA.			SY			
			P	F		
SUB-TOTAL :						
TOTAL :						

REVISIONS				JASON Y. YAM, P.E. P.E. LICENSE NUMBER 62449 CARDNO, INC. 380 PARK PLACE BOULEVARD, SUITE 300 CLEARWATER, FLORIDA 33759 CERTIFICATE OF AUTHORIZATION 29915	Lee County Southwest Florida DEPARTMENT OF TRANSPORTATION	GATEWAY BOULEVARD AT GRIFFIN DRIVE INTERSECTION CONTROL (ROUNDAABOUT)	COUNTY PROJECT NO.	SHT. NO.
DATE	DESCRIPTION	DATE	DESCRIPTION			SUMMARY OF QUANTITIES	200672	SQ-4

SUMMARY OF PAVEMENT												
PAY ITEM NO.	PAY ITEM DESCRIPTION	LOCATION		SIDE	AREA ID	UNIT	QUANTITY		TOTAL		DESIGN NOTES	CONSTRUCTION REMARKS
		STA. TO STA.	DESCRIPTION				P	F	P	F		
0160 4	TYPE B STABILIZATION											
0285 709	OPTIONAL BASE, BASE GROUP 9											
0327 70 1	MILLING EXIST ASPH PAVT, 1" AVG DEPTH											
0334 1 13	SUPERPAVE ASPHALTIC CONCRETE, TRAFFIC LEVEL C, FC-12.5 (2.5")											
0337 7 82	ASPHALTIC CONCRETE FRICTION COURSE, TRAFFIC LEVEL C, FC 9.5, PG 76-22 (1")											
0350 30 13	CONCRETE PAVEMENT FOR ROUNDABOUT APRON, 12" DEPTH											

REVISIONS				JASON Y. YAM, P.E. P.E. LICENSE NUMBER 62449 CARDNO, INC. 380 PARK PLACE BOULEVARD, SUITE 300 CLEARWATER, FLORIDA 33759 CERTIFICATE OF AUTHORIZATION 29915		GATEWAY BOULEVARD AT GRIFFIN DRIVE INTERSECTION CONTROL (ROUNDABOUT)	COUNTY PROJECT NO.	SHT. NO.
DATE	DESCRIPTION	DATE	DESCRIPTION			SUMMARY OF QUANTITIES	200672	SQ-5

kathleen.agodo

3/30/2020 8:44:37 AM

J:\CR044\CR044002.02\ms\roadway\SUMORD01.DGN

THE OFFICIAL RECORD OF THIS SHEET IS THE ELECTRONIC FILE DIGITALLY SIGNED AND SEALED UNDER RULE 61G15-23.004, F.A.C.

SUMMARY OF DITCH PAVEMENT								
LOCATION	SIDE	AREA ID	LENGTH	WIDTH	DITCH PAVEMENT - REINFORCED (4")		DESIGN NOTES	CONSTRUCTION REMARKS
					0524	1 29		
					SY			
STA. TO STA.					P	F		
SUB-TOTAL :								
TOTAL :								

REVISIONS				JASON Y. YAM, P.E. P.E. LICENSE NUMBER 62449 CARDNO, INC. 380 PARK PLACE BOULEVARD, SUITE 300 CLEARWATER, FLORIDA 33759 CERTIFICATE OF AUTHORIZATION 29915	 Lee County Southwest Florida DEPARTMENT OF TRANSPORTATION	GATEWAY BOULEVARD AT GRIFFIN DRIVE INTERSECTION CONTROL (ROUNABOUT)	COUNTY PROJECT NO.	SHT. NO.
DATE	DESCRIPTION	DATE	DESCRIPTION			SUMMARY OF QUANTITIES	200672	SQ-8

THE OFFICIAL RECORD OF THIS SHEET IS THE ELECTRONIC FILE DIGITALLY SIGNED AND SEALED UNDER RULE 61G15-23.004, F.A.C.

