

*LEE COUNTY
DEPARTMENT OF TRANSPORTATION*

BIG CARLOS PASS BRIDGE

FINANCIAL PROJECT ID: 445323-1-58-01

PROJECT No: CN160002

(FEDERAL FUNDS)

ETDM No: 14301


LEE COUNTY

COUNTY ROAD NO. 865 (ESTERO BOULEVARD)


SIGNING & PAVEMENT MARKINGS PLANS

*INDEX OF SIGNING AND
PAVEMENT MARKINGS PLANS*

SHEET NO.	SHEET DESCRIPTION
S-1	KEY SHEET
S-2 - S-3	TABULATION OF QUANTITIES
S-4	GENERAL NOTES
S-5 - S-13	SIGNING AND PAVEMENT MARKING PLAN
S-14	RRFB ELECTRICAL DETAIL
S-15 - S-16	GUIDESIGN WORKSHEET

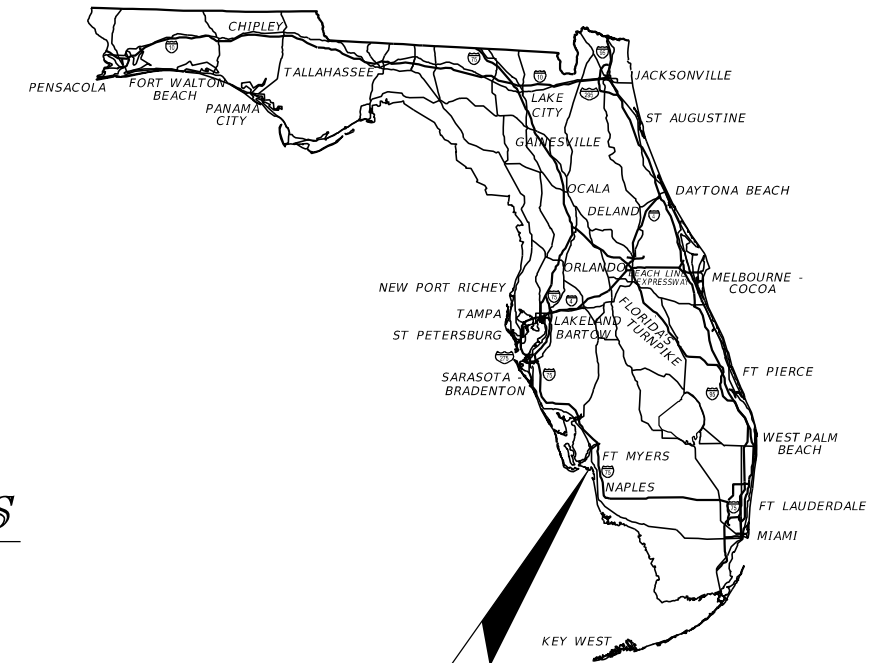

PROJECT LOCATION
<https://goo.gl/maps/qEgCgBkBYfuLdJQ36>

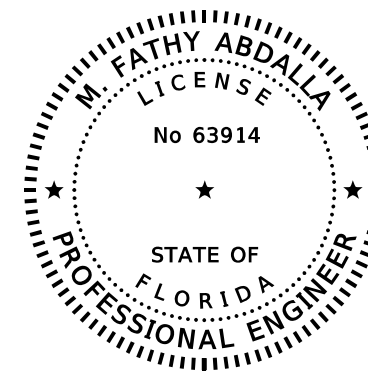

THIS ITEM HAS BEEN DIGITALLY
SIGNED AND SEALED BY

ON THE DATE ADJACENT TO THE SEAL
PRINTED COPIES OF THIS DOCUMENT ARE
NOT CONSIDERED SIGNED AND SEALED
AND THE SIGNATURE MUST BE VERIFIED
ON ANY ELECTRONIC COPIES.

**SIGNING & PAVEMENT
MARKINGS PLANS**

ENGINEER OF RECORD:

M. FATHY ABDALLA, P.E.
P.E. NO.: 63914
KISINGER CAMPO & ASSOCIATES CORP.
201 N. FRANKLIN STREET, SUITE 400
TAMPA, FL 33602
PHONE: (813) 871-5331
CONTRACT NO.: C-7533
VENDOR NO.: 59-1677145

LDOT PROJECT MANAGER:

THOMAS J. MARQUARDT, P.E.



SHEET
NO.

S-1

THE OFFICIAL RECORD OF THIS SHEET IS THE ELECTRONIC FILE DIGITALLY SIGNED AND SEALED UNDER RULE 61G15-23.004, F.A.C.

TABULATION OF QUANTITIES


PAY ITEM NO.	DESCRIPTION	UNIT	SHEET NUMBERS														TOTAL THIS SHEET		GRAND TOTAL	
			S-5		S-6		S-7		S-8		S-9		S-10		S-11		PLAN	FINAL	PLAN	FINAL
			PLAN	FINAL	PLAN	FINAL	PLAN	FINAL	PLAN	FINAL	PLAN	FINAL	PLAN	FINAL						
630-2-11	CONDUIT, FURNISH & INSTALL, OPEN TRENCH	LF																		
630-2-12	CONDUIT, FURNISH & INSTALL, DIRECTIONAL BORE	LF																		
632-7-1	SIGNAL CABLE- NEW OR RECONSTRUCTED INTERSECTION, FURNISH & INSTALL	PI																		
635-2-12	PULL & SPLICE BOX, F&I, 24" X 36" COVER SIZE	EA																		
639-1-122	ELECTRICAL POWER SERVICE, F&I, UNDERGROUND, METER PURCHASED BY CONTRACTOR	AS																		
654-2-18	MIDBLOCK CROSSWALK: REC RAPID FLASHING BEACON, FURNISH/INSTALL- AC, SIGN ASSEMBLY- BACK-BACK ACCESSIBLE DETECTOR	AS	2														2			
700-1-11	SINGLE POST SIGN, F&I GROUND MOUNT, UP TO 12 SF	AS	9												6		15			
700-1-21	SINGLE POST SIGN, F&I BARRIER MOUNT INDEX 11871/700-013 UP TO 12 SF	AS		4									6				10			
700-1-60	SINGLE POST SIGN, REMOVE	AS	6	18								14		7	3		48			
700-2-13	MULTI- POST SIGN, F&I GROUND MOUNT, 21-30 SF	AS		2													2			
700-2-60	MULTI- POST SIGN, REMOVE	AS	1	3			4		1		1		1				11			
700-3-501	SIGN PANEL, RELOCATE, UP TO 12 SF	EA	1												1		2			
705-10-3	OBJECT MARKER, TYPE 3	EA			1										1		2			
706-1-3	RAISED PAVEMENT MARKER, TYPE B	EA	43		57		30		30		30		92		113		395			
710-90	PAINTED PAVEMENT MARKINGS, FINAL SURFACE	LS																		
*	PAINTED PAVEMENT MARKINGS, STANDARD, WHITE, SOLID 6"	GM	0.298		0.110							0.004		0.635		0.844		1.891		
*	PAINTED PAVEMENT MARKINGS, STANDARD, WHITE, SOLID FOR CROSSWALK AND ROUNDABOUT, 12"	LF	159									44				80		283		
*	PAINTED PAVEMENT MARKINGS, STANDARD, WHITE, SOLID FOR STOP LINE OR CROSSWALK, 24"	LF	94												33		127			
*	PAINTED PAVEMENT MARKINGS, STANDARD, WHITE, 2-4 DOTTED GUIDELINE/ 6-10 GAP EXTENSION, 6"	GM	0.088		0.015									0.011		0.112		0.226		
*	PAINTED PAVEMENT MARKINGS, STANDARD, WHITE, MESSAGE	EA	4												2		6			
*	PAINTED PAVEMENT MARKINGS, STANDARD, WHITE, ARROWS	EA	4		1										10		15			
*	THERMOPLASTIC, STANDARD, YELLOW, 2-4 DOTTED GUIDE LINE /6-10 DOTTED EXTENSION LINE, 6"	GM	0.018												0.042		0.060			
*	PAINTED PAVEMENT MARKINGS, STANDARD, YELLOW, SOLID 6"	GM	0.377		0.166							0.002		0.537		0.646		1.727		
*	PAINTED PAVEMENT MARKINGS, STANDARD, YELLOW, SOLID FOR DIAGONAL OR CHEVRON, 18"	LF	118		58									83			259			
*	PAINTED PAVEMENT MARKINGS, STANDARD, YELLOW, SKIP, 6"	GM	0.076														0.076			
*	PAINTED PAVEMENT MARKINGS, STANDARD, BLUE, 6"	LF																		
711-11-123	THERMOPLASTIC, STANDARD, WHITE, SOLID, 12" FOR CROSSWALK AND ROUNDABOUT	LF	159									44			80		283			
711-11-125	THERMOPLASTIC, STANDARD, WHITE, SOLID 24" FOR STOP LINE OR CROSSWALK	LF	94												33		127			
711-11-141	THERMOPLASTIC, STANDARD, WHITE, 2-4 DOTTED GUIDELINE/ 6-10 GAP EXTENSION, 6"	GM	0.088		0.015									0.011		0.112		0.226		
711-11-160	THERMOPLASTIC, STANDARD, WHITE, MESSAGE	EA	4												2		6			
711-11-170	THERMOPLASTIC, STANDARD, WHITE, ARROW	EA	4		1										10		15			
711-11-241	THERMOPLASTIC, STANDARD, YELLOW, 2-4 DOTTED GUIDE LINE /6-10 DOTTED EXTENSION LINE, 6"	GM	0.018												0.042		0.060			
711-11-224	THERMOPLASTIC, STANDARD, YELLOW, SOLID, 18" FOR DIAGONAL OR CHEVRON	LF	118		58										83		259			
711-11-421	THERMOPLASTIC, STANDARD, BLUE, SOLID, 6"	LF																		
711-14-125	THERMOPLASTIC, PREFORMED, WHITE, SOLID, 24" FOR CROSSWALK	LF	70									24			60		154			
711-14-160	THERMOPLASTIC, PREFORMED, WHITE, MESSAGE	EA	4		2									2		3		11		
711-14-170	THERMOPLASTIC, PREFORMED, WHITE, ARROW	EA	4		2									2		3		11		
711-14-560	THERMOPLASTIC, PREFORMED, WHITE WITH BLACK CONTRAST ON CONCRETE PAVEMENT, MESSAGE OR SYMBOL	EA					2		4		2						8			
711-14-570	THERMOPLASTIC, PREFORMED, WHITE WITH BLACK CONTRAST, ARROW ON CONCRETE SURFACE	EA					2		4		2						8			
711-16-101	THERMOPLASTIC, STANDARD-OTHER SURFACES, WHITE, SOLID 6"	GM	0.298		0.110							0.004		0.635		0.844		1.891		
711-16-201	THERMOPLASTIC, STANDARD-OTHER SURFACES, YELLOW, SOLID, 6"	GM	0.377		0.166							0.002		0.537		0.646		1.727		
711-16-231	THERMOPLASTIC, STANDARD-OTHER SURFACES, YELLOW, SKIP, 6"	GM	0.076														0.076			
713-103-101	PERMANENT TAPE, WHITE, SOLID, 6" FOR CONCRETE BRIDGES	GM			0.253		0.455		0.454		0.454		0.100				1.716			
713-103-201	PERMANENT TAPE, YELLOW, SOLID, 6" FOR CONCRETE BRIDGES	GM			0.146		0.227		0.227		0.227		0.050				0.877			
715-4-70	LIGHT POLE COMPLETE, REMOVE POLE AND FOUNDATION	EA											2				2			

* These quantities are paid for under Painted Pavement Markings (Final Surface), Lump Sum - Item No. 710-90. The quantities shown are for one application; see Specification 710 for the number of applications required. Lump Sum - Item No. 710-90.

PAY ITEM NOTES:

635-2-12: REFER TO SECTION 3 OF "LEE COUNTY DEPARTMENT OF TRANSPORTATION PLAN SPECIFICATIONS FOR SIGNAL & STREET LIGHTING" FOR THE APPROVED DIMENSIONS OF SIGNAL PULL BOXES.

654-2-18: PROPOSED RECTANGULAR RAPID FLASHING BEACONS MUST BE THE CARMANAH SC315-G RRFB FOR THE PURPOSE OF RELIABILITY, INTERCHANGEABILITY, AND MAINTENANCE CONSIDERATIONS. REFER TO THE APPROVED PROPRIETARY PRODUCT CERTIFICATION FOR THE SPECIFICATIONS.

REVISIONS				 201 N. Franklin Street, Suite 400 Tampa, Florida 33602 Engineer of Record: M. Fathy Abdalla, P.E. P.E. No.: 63914	LEE COUNTY DEPARTMENT OF TRANSPORTATION			TABULATION OF QUANTITIES (1)	SHEET NO.
DATE	DESCRIPTION	DATE	DESCRIPTION		ROAD NO.	COUNTY	PROJECT NO.		
					CR 865	LEE	CN160002		S-2

THE OFFICIAL RECORD OF THIS SHEET IS THE ELECTRONIC FILE DIGITALLY SIGNED AND SEALED UNDER RULE 61G15-23.004, F.A.C.

TABULATION OF QUANTITIES

PAY ITEM NO.	DESCRIPTION	UNIT	SHEET NUMBERS												TOTAL THIS SHEET		GRAND TOTAL	
			S-12		S-13		S-14											
			PLAN	FINAL	PLAN	FINAL	PLAN	FINAL	PLAN	FINAL	PLAN	FINAL	PLAN	FINAL	PLAN	FINAL	PLAN	FINAL
630-2-11	CONDUIT, FURNISH & INSTALL, OPEN TRENCH	LF					162									162	162	
630-2-12	CONDUIT, FURNISH & INSTALL, DIRECTIONAL BORE	LF					50									50	50	
632-7-1	SIGNAL CABLE- NEW OR RECONSTRUCTED INTERSECTION, FURNISH & INSTALL	PI					1									1	1	
635-2-12	PULL & SPLICE BOX, F&I, 24" X 36" COVER SIZE	EA					3									3	3	
639-1-122	ELECTRICAL POWER SERVICE, F&I, UNDERGROUND, METER PURCHASED BY CONTRACTOR	AS					1									1	1	
654-2-18	MIDBLOCK CROSSWALK: REC RAPID FLASHING BEACON, FURNISH/INSTALL- AC, SIGN ASSEMBLY- BACK-BACK ACCESSIBLE DETECTOR	AS															2	
700-1-11	SINGLE POST SIGN, F&I GROUND MOUNT, UP TO 12 SF	AS	7		3											10	25	
700-1-21	SINGLE POST SIGN, F&I BARRIER MOUNT INDEX 11871/700-013 UP TO 12 SF	AS															10	
700-1-60	SINGLE POST SIGN, REMOVE	AS	1													1	49	
700-2-13	MULTI- POST SIGN, F&I GROUND MOUNT, 21-30 SF	AS															2	
700-2-60	MULTI- POST SIGN, REMOVE	AS															11	
700-3-501	SIGN PANEL, RELOCATE, UP TO 12 SF	EA															2	
705-10-3	OBJECT MARKER, TYPE 3	EA															2	
706-1-3	RAISED PAVEMENT MARKER, TYPE B	EA	78													78	473	
710-90	PAINTED PAVEMENT MARKINGS, FINAL SURFACE	LS															1	
*	PAINTED PAVEMENT MARKINGS, STANDARD, WHITE, SOLID 6"	GM	0.337													0.337	2.229	
*	PAINTED PAVEMENT MARKINGS, STANDARD, WHITE, SOLID FOR CROSSWALK AND ROUNDABOUT, 12"	LF															283	
*	PAINTED PAVEMENT MARKINGS, STANDARD, WHITE, SOLID FOR STOP LINE OR CROSSWALK, 24"	LF															127	
*	PAINTED PAVEMENT MARKINGS, STANDARD, WHITE, 2-4 DOTTED GUIDELINE/ 6-10 GAP EXTENSION, 6"	GM	0.135													0.135	0.361	
*	PAINTED PAVEMENT MARKINGS, STANDARD, WHITE, MESSAGE	EA	2													2	8	
*	PAINTED PAVEMENT MARKINGS, STANDARD, WHITE, ARROWS	EA	8													8	23	
*	THERMOPLASTIC, STANDARD, YELLOW, 2-4 DOTTED GUIDE LINE /6-10 DOTTED EXTENSION LINE, 6"	GM															0.060	
*	PAINTED PAVEMENT MARKINGS, STANDARD, YELLOW, SOLID 6"	GM	0.245													0.245	1.973	
*	PAINTED PAVEMENT MARKINGS, STANDARD, YELLOW, SOLID FOR DIAGONAL OR CHEVRON, 18"	LF	52													52	311	
*	PAINTED PAVEMENT MARKINGS, STANDARD, YELLOW, SKIP, 6"	GM															0.076	
*	PAINTED PAVEMENT MARKINGS, STANDARD, BLUE, 6"	LF			108											108	108	
711-11-123	THERMOPLASTIC, STANDARD, WHITE, SOLID, 12" FOR CROSSWALK AND ROUNDABOUT	LF															283	
711-11-125	THERMOPLASTIC, STANDARD, WHITE, SOLID 24" FOR STOP LINE OR CROSSWALK	LF															127	
711-11-141	THERMOPLASTIC, STANDARD, WHITE, 2-4 DOTTED GUIDELINE/ 6-10 GAP EXTENSION, 6"	GM	0.135													0.135	0.361	
711-11-160	THERMOPLASTIC, STANDARD, WHITE, MESSAGE	EA	2													2	8	
711-11-170	THERMOPLASTIC, STANDARD, WHITE, ARROW	EA	8													8	23	
711-11-241	THERMOPLASTIC, STANDARD, YELLOW, 2-4 DOTTED GUIDE LINE /6-10 DOTTED EXTENSION LINE, 6"	GM															0.060	
711-11-224	THERMOPLASTIC, STANDARD, YELLOW, SOLID, 18" FOR DIAGONAL OR CHEVRON	LF	52													52	311	
711-11-421	THERMOPLASTIC, STANDARD, BLUE, SOLID, 6"	LF			108											108	262	
711-14-125	THERMOPLASTIC, PREFORMED, WHITE, SOLID, 24" FOR CROSSWALK	LF															154	
711-14-160	THERMOPLASTIC, PREFORMED, WHITE, MESSAGE	EA	3		3											6	17	
711-14-170	THERMOPLASTIC, PREFORMED, WHITE, ARROW	EA	3													3	14	
711-14-560	THERMOPLASTIC, PREFORMED, WHITE WITH BLACK CONTRAST ON CONCRETE PAVEMENT, MESSAGE OR SYMBOL	EA															8	
711-14-570	THERMOPLASTIC, PREFORMED, WHITE WITH BLACK CONTRAST, ARROW ON CONCRETE SURFACE	EA															8	
711-16-101	THERMOPLASTIC, STANDARD-OTHER SURFACES, WHITE, SOLID 6"	GM	0.337		0.028											0.365	2.257	
711-16-201	THERMOPLASTIC, STANDARD-OTHER SURFACES, YELLOW, SOLID, 6"	GM	0.245													0.245	1.973	
711-16-231	THERMOPLASTIC, STANDARD-OTHER SURFACES, YELLOW, SKIP, 6"	GM															0.076	
713-103-101	PERMANENT TAPE, WHITE, SOLID, 6" FOR CONCRETE BRIDGES	GM															1.716	
713-103-201	PERMANENT TAPE, YELLOW, SOLID, 6" FOR CONCRETE BRIDGES	GM															0.877	
715-4-70	LIGHT POLE COMPLETE, REMOVE POLE AND FOUNDATION	EA															2	

* These quantities are paid for under Painted Pavement Markings (Final Surface), Lump Sum - Item No. 710-90. The quantities shown are for one application; see Specification 710 for the number of applications required. Lump Sum - Item No. 710-90.

PAY ITEM NOTES:

635-2-12: REFER TO SECTION 3 OF "LEE COUNTY DEPARTMENT OF TRANSPORTATION PLAN SPECIFICATIONS FOR SIGNAL & STREET LIGHTING" FOR THE APPROVED DIMENSIONS OF SIGNAL PULL BOXES.

654-2-18: PROPOSED RECTANGULAR RAPID FLASHING BEACONS MUST BE THE CARMANAH SC315-G RRFB FOR THE PURPOSE OF RELIABILITY, INTERCHANGEABILITY, AND MAINTENANCE CONSIDERATIONS. REFER TO THE APPROVED PROPRIETARY PRODUCT CERTIFICATION FOR THE SPECIFICATIONS.

REVISIONS			
DATE	DESCRIPTION	DATE	DESCRIPTION

KCA 201 N. Franklin Street, Suite 400
Tampa, Florida 33602
KISINGER CAMPO & ASSOCIATES Engineer of Record: M. Fathy Abdalla, P.E.
P.E. No.: 63914

LEE COUNTY DEPARTMENT OF TRANSPORTATION

ROAD NO.	COUNTY	PROJECT NO.
CR 865	LEE	CN160002



TABULATION OF QUANTITIES (2)

SHEET NO. S-3

THE OFFICIAL RECORD OF THIS SHEET IS THE ELECTRONIC FILE DIGITALLY SIGNED AND SEALED UNDER RULE 61G15-23.004, F.A.C.

GENERAL NOTES

1. THE LOCATION(S) OF THE UTILITIES SHOWN IN THE PLANS (INCLUDING THOSE DESIGNATED VV, VH, AND VVH) ARE BASED ON LIMITED INVESTIGATION TECHNIQUES AND SHOULD BE CONSIDERED APPROXIMATE ONLY. THE VERIFIED LOCATIONS/ELEVATIONS APPLY ONLY AT THE POINTS SHOWN. INTERPOLATIONS BETWEEN THESE POINTS HAVE NOT BEEN VERIFIED.
2. CALL SUNSHINE 811 AT 1-800-432-4770 AND THE UTILITY OWNERS TWO FULL BUSINESS DAYS BEFORE BEGINNING WORK. ALL UTILITIES MAY NOT BE MEMBERS OF SUNSHINE 811 AND WILL THEREFORE REQUIRE DIRECT CONTACT.
3. EXISTING SIGN ASSEMBLIES TO BE REMOVED WILL BE PLACED IN AREAS APPROVED BY THE ENGINEER FOR PICK UP BY LCDOT OPERATIONS DIVISION. ANY SIGNS NOT TAKEN BY THE LCDOT OPERATIONS DIVISION WILL BE DISPOSED OF BY THE CONTRACTOR AT THEIR EXPENSE.
4. WHERE FOOTER OR FOUNDATION ARE TO BE INSTALLED BY AUGURING OR DRILLING, SURVEY AND STAKE OR PAINT TO AN ACCURACY OF 0.1 FEET PRIOR TO REQUESTING UTILITY LOCATES. STAKE OR PAINT THE CENTER OF EACH LOCATION CLEARLY LABEL WITH STATION, OFFSET, IDENTIFYING STRUCTURE NUMBER, AND DIAMETER OF EXCAVATION IN INCHES.
5. WHERE AUGERING OR DRILLING, EXCAVATE THE FIRST 4 FEET BY NON MECHANICAL AND NON DESTRUCTIVE MEANS.
6. PAVEMENT MARKINGS ON ASPHALT PAVEMENT SHALL BE STANDARD THERMOPLASTIC EXCEPT FOR SPECIAL EMPHASIS CROSSWALKS. USE PREFORMED THERMOPLASTIC FOR THE LONGITUDINAL STRIPES WITHIN THE SPECIAL EMPHASIS CROSSWALKS. PAVEMENT MARKINGS ON CONCRETE PAVEMENT SHALL BE PERMANENT TAPE. PAVEMENT ARROWS AND MESSAGES ON CONCRETE PAVEMENT SHALL HAVE A BLACK CONTRAST THERMOPLASTIC BLOCK.
7. DECORATIVE WELCOME SIGNS TO BE REMOVED FOR THE TOWN OF FORT MYERS BEACH AND THE CITY OF BONITA SPRINGS SHALL BE DELIVERED TO THE RESPECTIVE LOCAL AGENCY.
8. ADHERE TO REQUIREMENTS IN "LEE COUNTY DEPARTMENT OF TRANSPORTATION PLAN SPECIFICATIONS FOR SIGNAL & STREET LIGHTING", JANUARY 2021. CONTACT LEE COUNTY DEPARTMENT OF TRANSPORTATION (LCDOT) FOR ANY QUESTIONS REGARDING EQUIPMENT OR INSTALLATION REQUIREMENTS. FOLLOW THE FDOT GOVERNING STANDARDS AND SPECIFICATIONS FOR ALL ITEMS NOT COVERED BY LEE COUNTY SPECIFICATIONS.
9. QUALIFICATIONS FOR PERSONNEL SUPERVISING OR PERFORMING WORK INVOLVING ELECTRICAL OR SOLAR POWER TRAFFIC CONTROL DEVICES AND RELATED COMPONENTS (RRFB, FLASHERS, AND SCHOOL FLASHERS) ARE THAT WORK MUST BE PERFORMED BY AN EMPLOYEE OF THE CONTRACTOR THAT HOLDS A CURRENT IMSA TRAFFIC SIGNAL FIELD TECHNICIAN LEVEL II CERTIFICATION OR HIGHER; AND MUST BE PRESENT AT THE FINAL INSPECTION OF THE PROJECT.

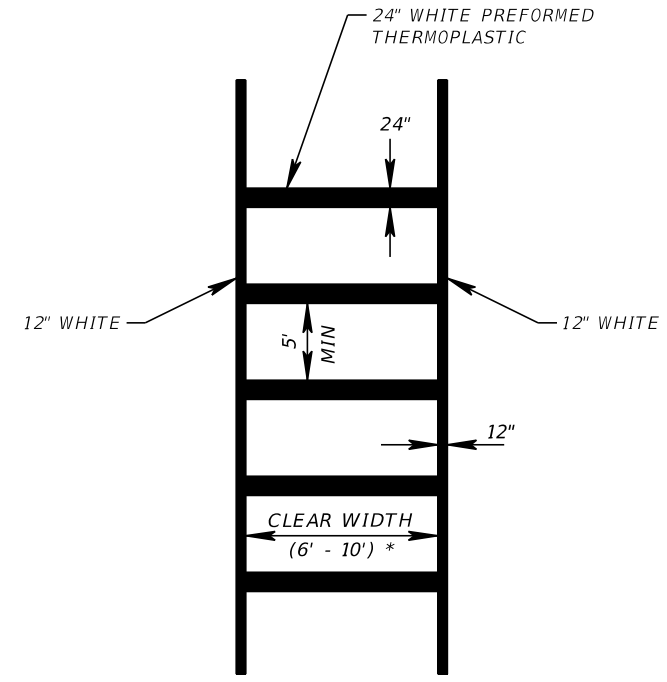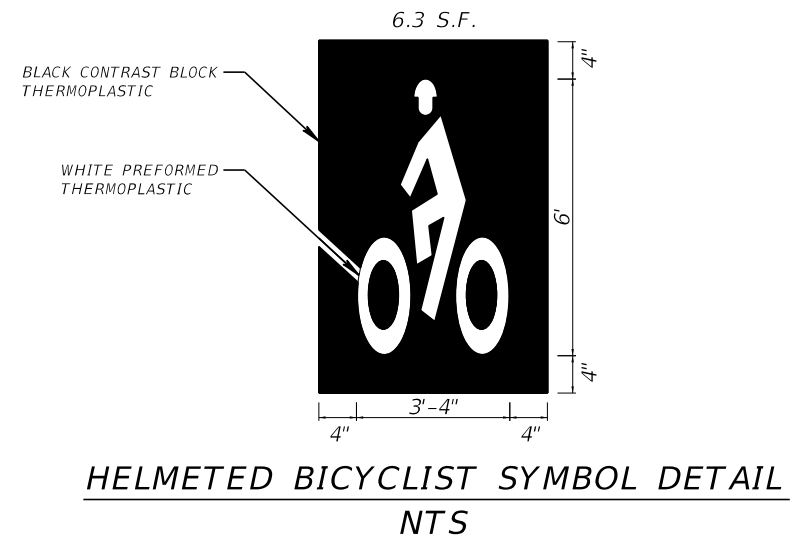

* UNLESS OTHERWISE SPECIFIED IN PLANS.


REVISIONS				201 N. Franklin Street, Suite 400 Tampa, Florida 33602 Engineer of Record: M. Fathy Abdalla, P.E. P.E. No.: 63914	LEE COUNTY DEPARTMENT OF TRANSPORTATION			SHEET NO. S-4
DATE	DESCRIPTION	DATE	DESCRIPTION		ROAD NO.	COUNTY	PROJECT NO.	
					CR 865	LEE	CN160002	

GENERAL NOTES

THE OFFICIAL RECORD OF THIS SHEET IS THE ELECTRONIC FILE DIGITALLY SIGNED AND SEALED UNDER RULE 61G15-23.004, F.A.C.

ESTERO BLVD.

 RELOCATE EXISTING SIGN
PANEL ON NEW POST
700-3-501 1 EA
STA. 409+94




BEGIN CONSTRUCTION
BEGIN SIGNING &
PAVEMENT MARKINGS
C CONST. BIG CARLOS
STA. 405+00.00

6" DBL. YELLOW
WITH 2 - Y/Y RPMS

RECTANGULAR RAPID
FLASHING BEACON *
W11-2
30" X 30"
W16-7P
24" X 12"
654-2-18 1 AS
STA. 408+37

R1-1
36" X 36"
700-1-11 1 AS
STA. 410+22

REMOVE EXIST. SIGN.
RELOCATE "BLIND PEDESTRIAN"
PLAQUE TO SIGN ASSEMBLY
AT STA. 411+22

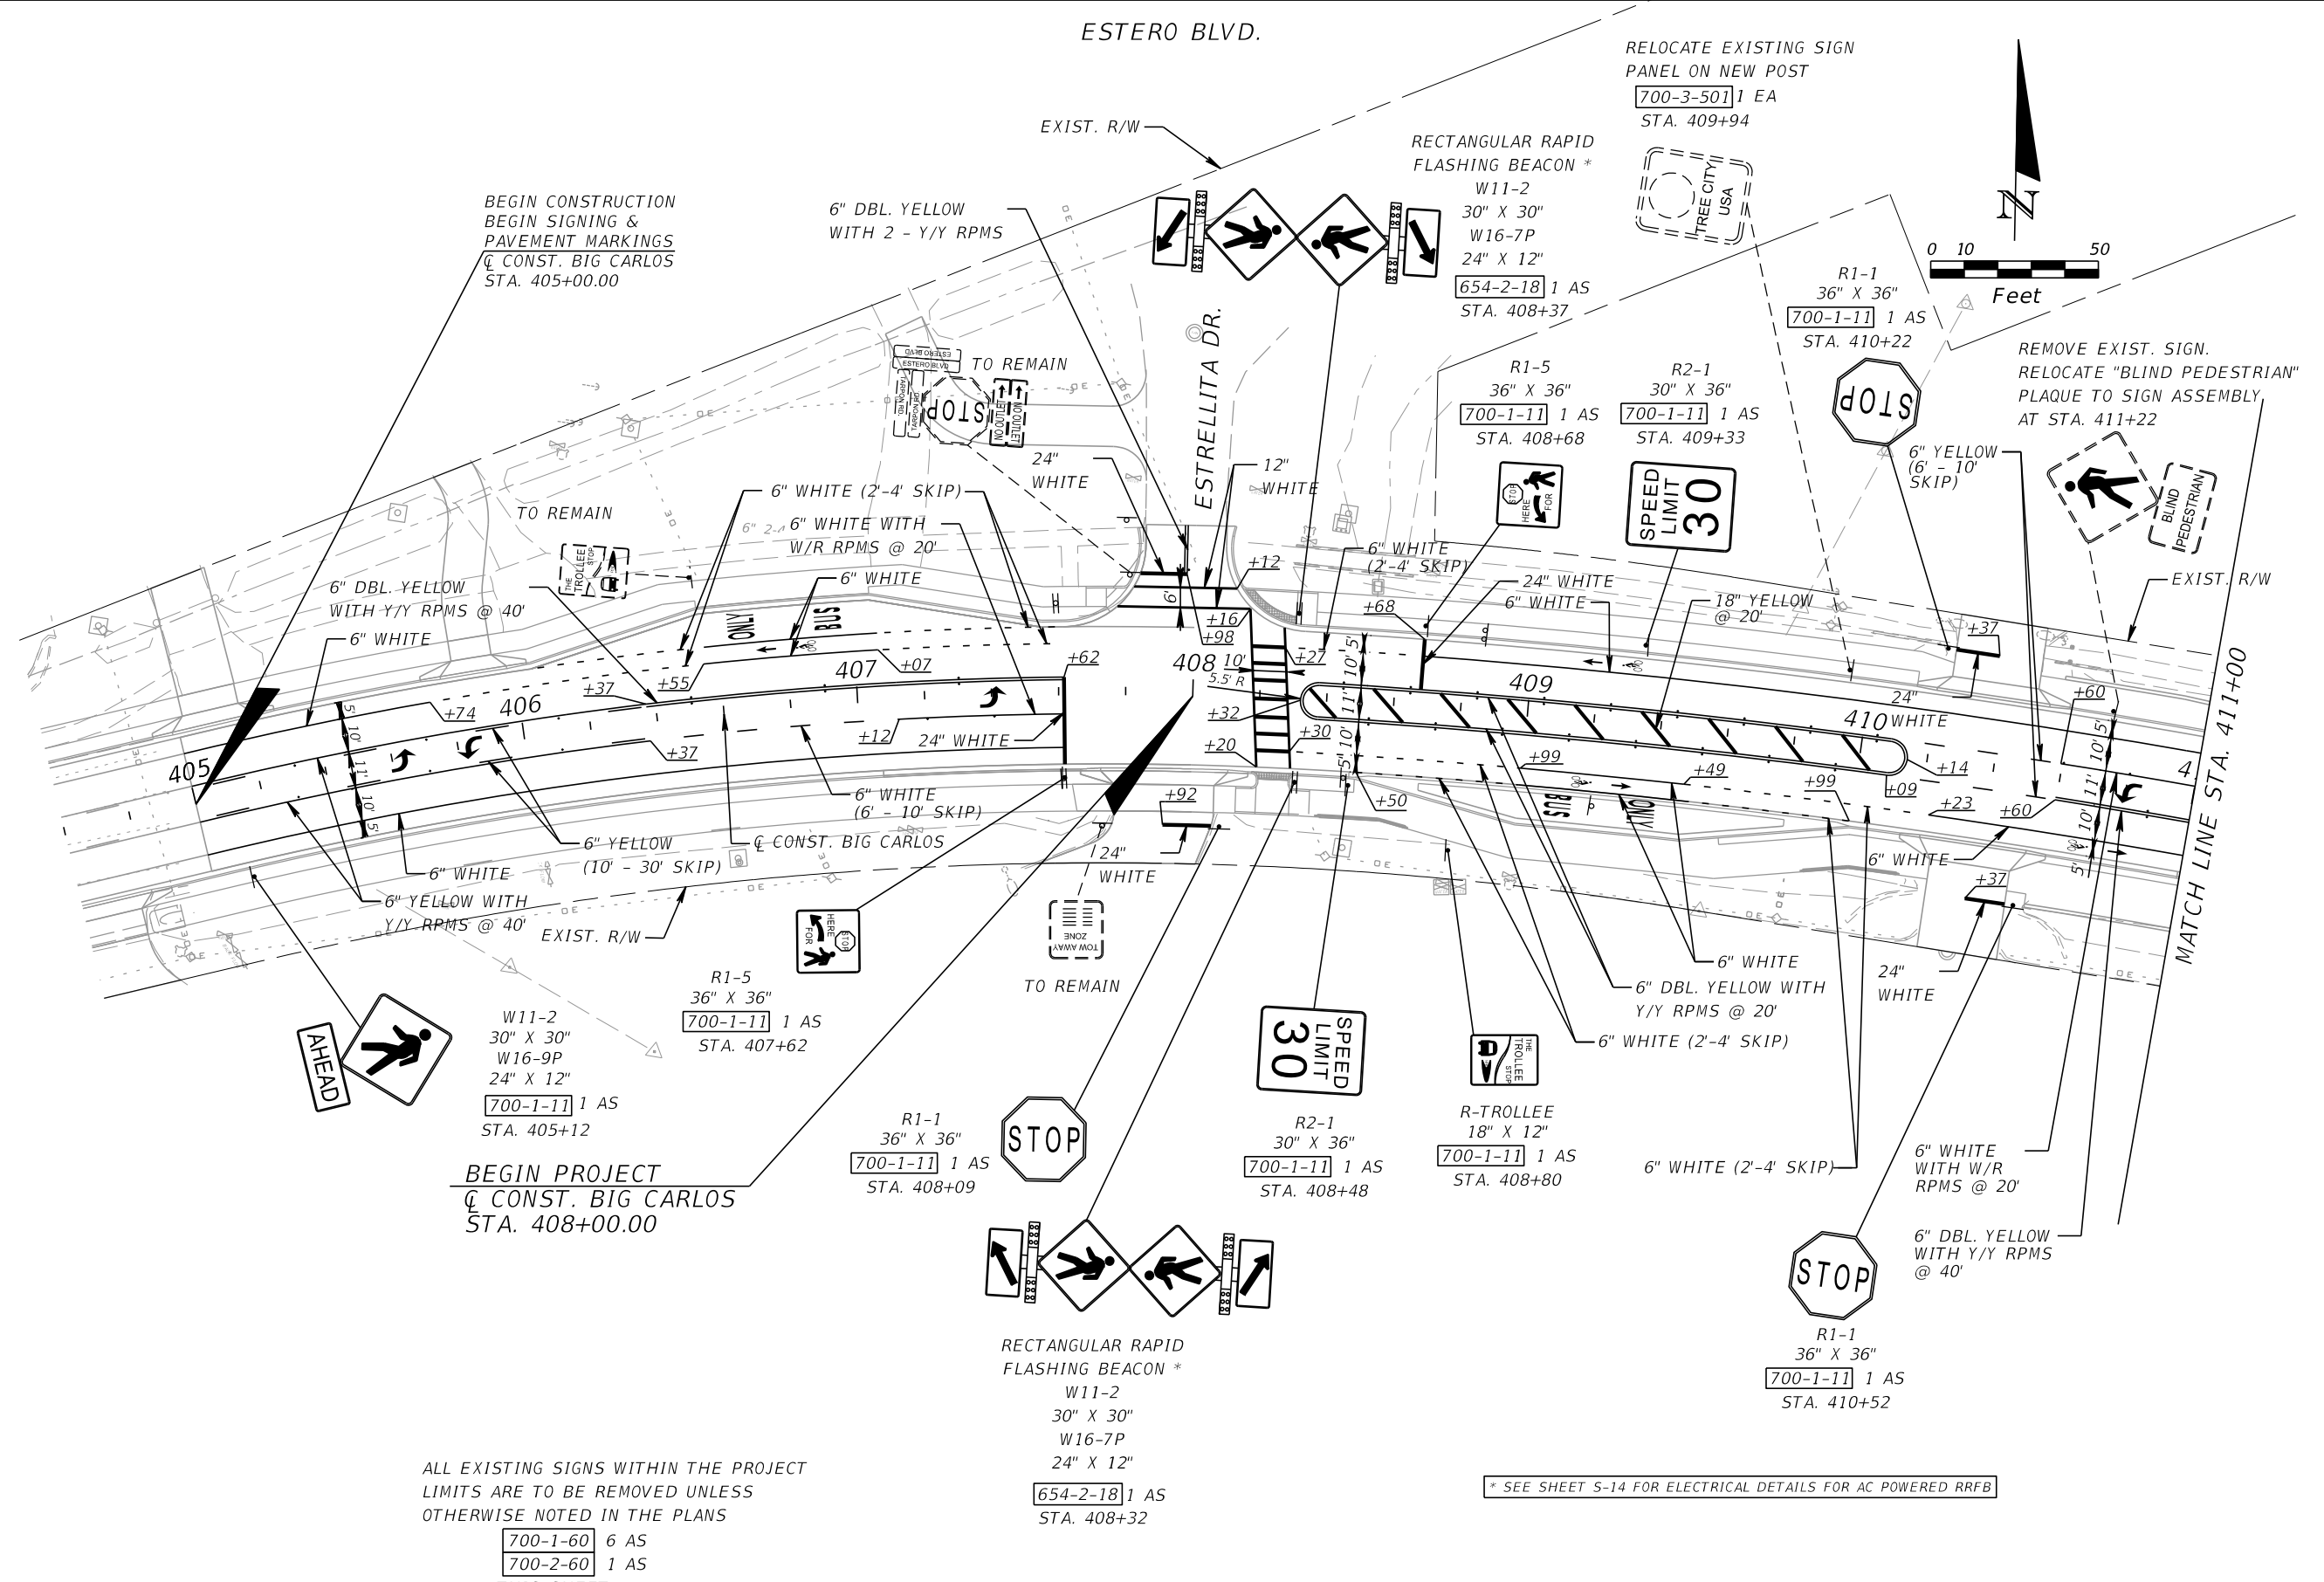

AHEAD
700-1-11 1 AS
STA. 405+12

BEGIN PROJECT
C CONST. BIG CARLOS
STA. 408+00.00

R1-5
36" X 36"
700-1-11 1 AS
STA. 407+62

R1-1
36" X 36"
700-1-11 1 AS
STA. 408+09

STOP

SPEED
LIMIT
30

R2-1
30" X 36"
700-1-11 1 AS
STA. 408+48

R-TROLLEE
18" X 12"
700-1-11 1 AS
STA. 408+80

6" DBL. YELLOW WITH
Y/Y RPMS @ 20'

STOP

R1-1
36" X 36"
700-1-11 1 AS
STA. 410+52

ALL EXISTING SIGNS WITHIN THE PROJECT
LIMITS ARE TO BE REMOVED UNLESS
OTHERWISE NOTED IN THE PLANS

700-1-60 6 AS
700-2-60 1 AS
THIS SHEET

RECTANGULAR RAPID
FLASHING BEACON *
W11-2
30" X 30"
W16-7P
24" X 12"
654-2-18 1 AS
STA. 408+32

* SEE SHEET S-14 FOR ELECTRICAL DETAILS FOR AC POWERED RRFB

REVISIONS			
DATE	DESCRIPTION	DATE	DESCRIPTION



KCA
KISINGER CAMPO & ASSOCIATES
201 N. Franklin Street, Suite 400
Tampa, Florida 33602
Engineer of Record: M. Fathy Abdalla, P.E.
P.E. No.: 63914

LEE COUNTY DEPARTMENT OF TRANSPORTATION		
ROAD NO.	COUNTY	PROJECT NO.
CR 865	LEE	CN160002

**SIGNING & PAVEMENT
MARKING PLAN (1)**

SHEET NO.
S-5

THE OFFICIAL RECORD OF THIS SHEET IS THE ELECTRONIC FILE DIGITALLY SIGNED AND SEALED UNDER RULE 61G15-23.004, F.A.C.

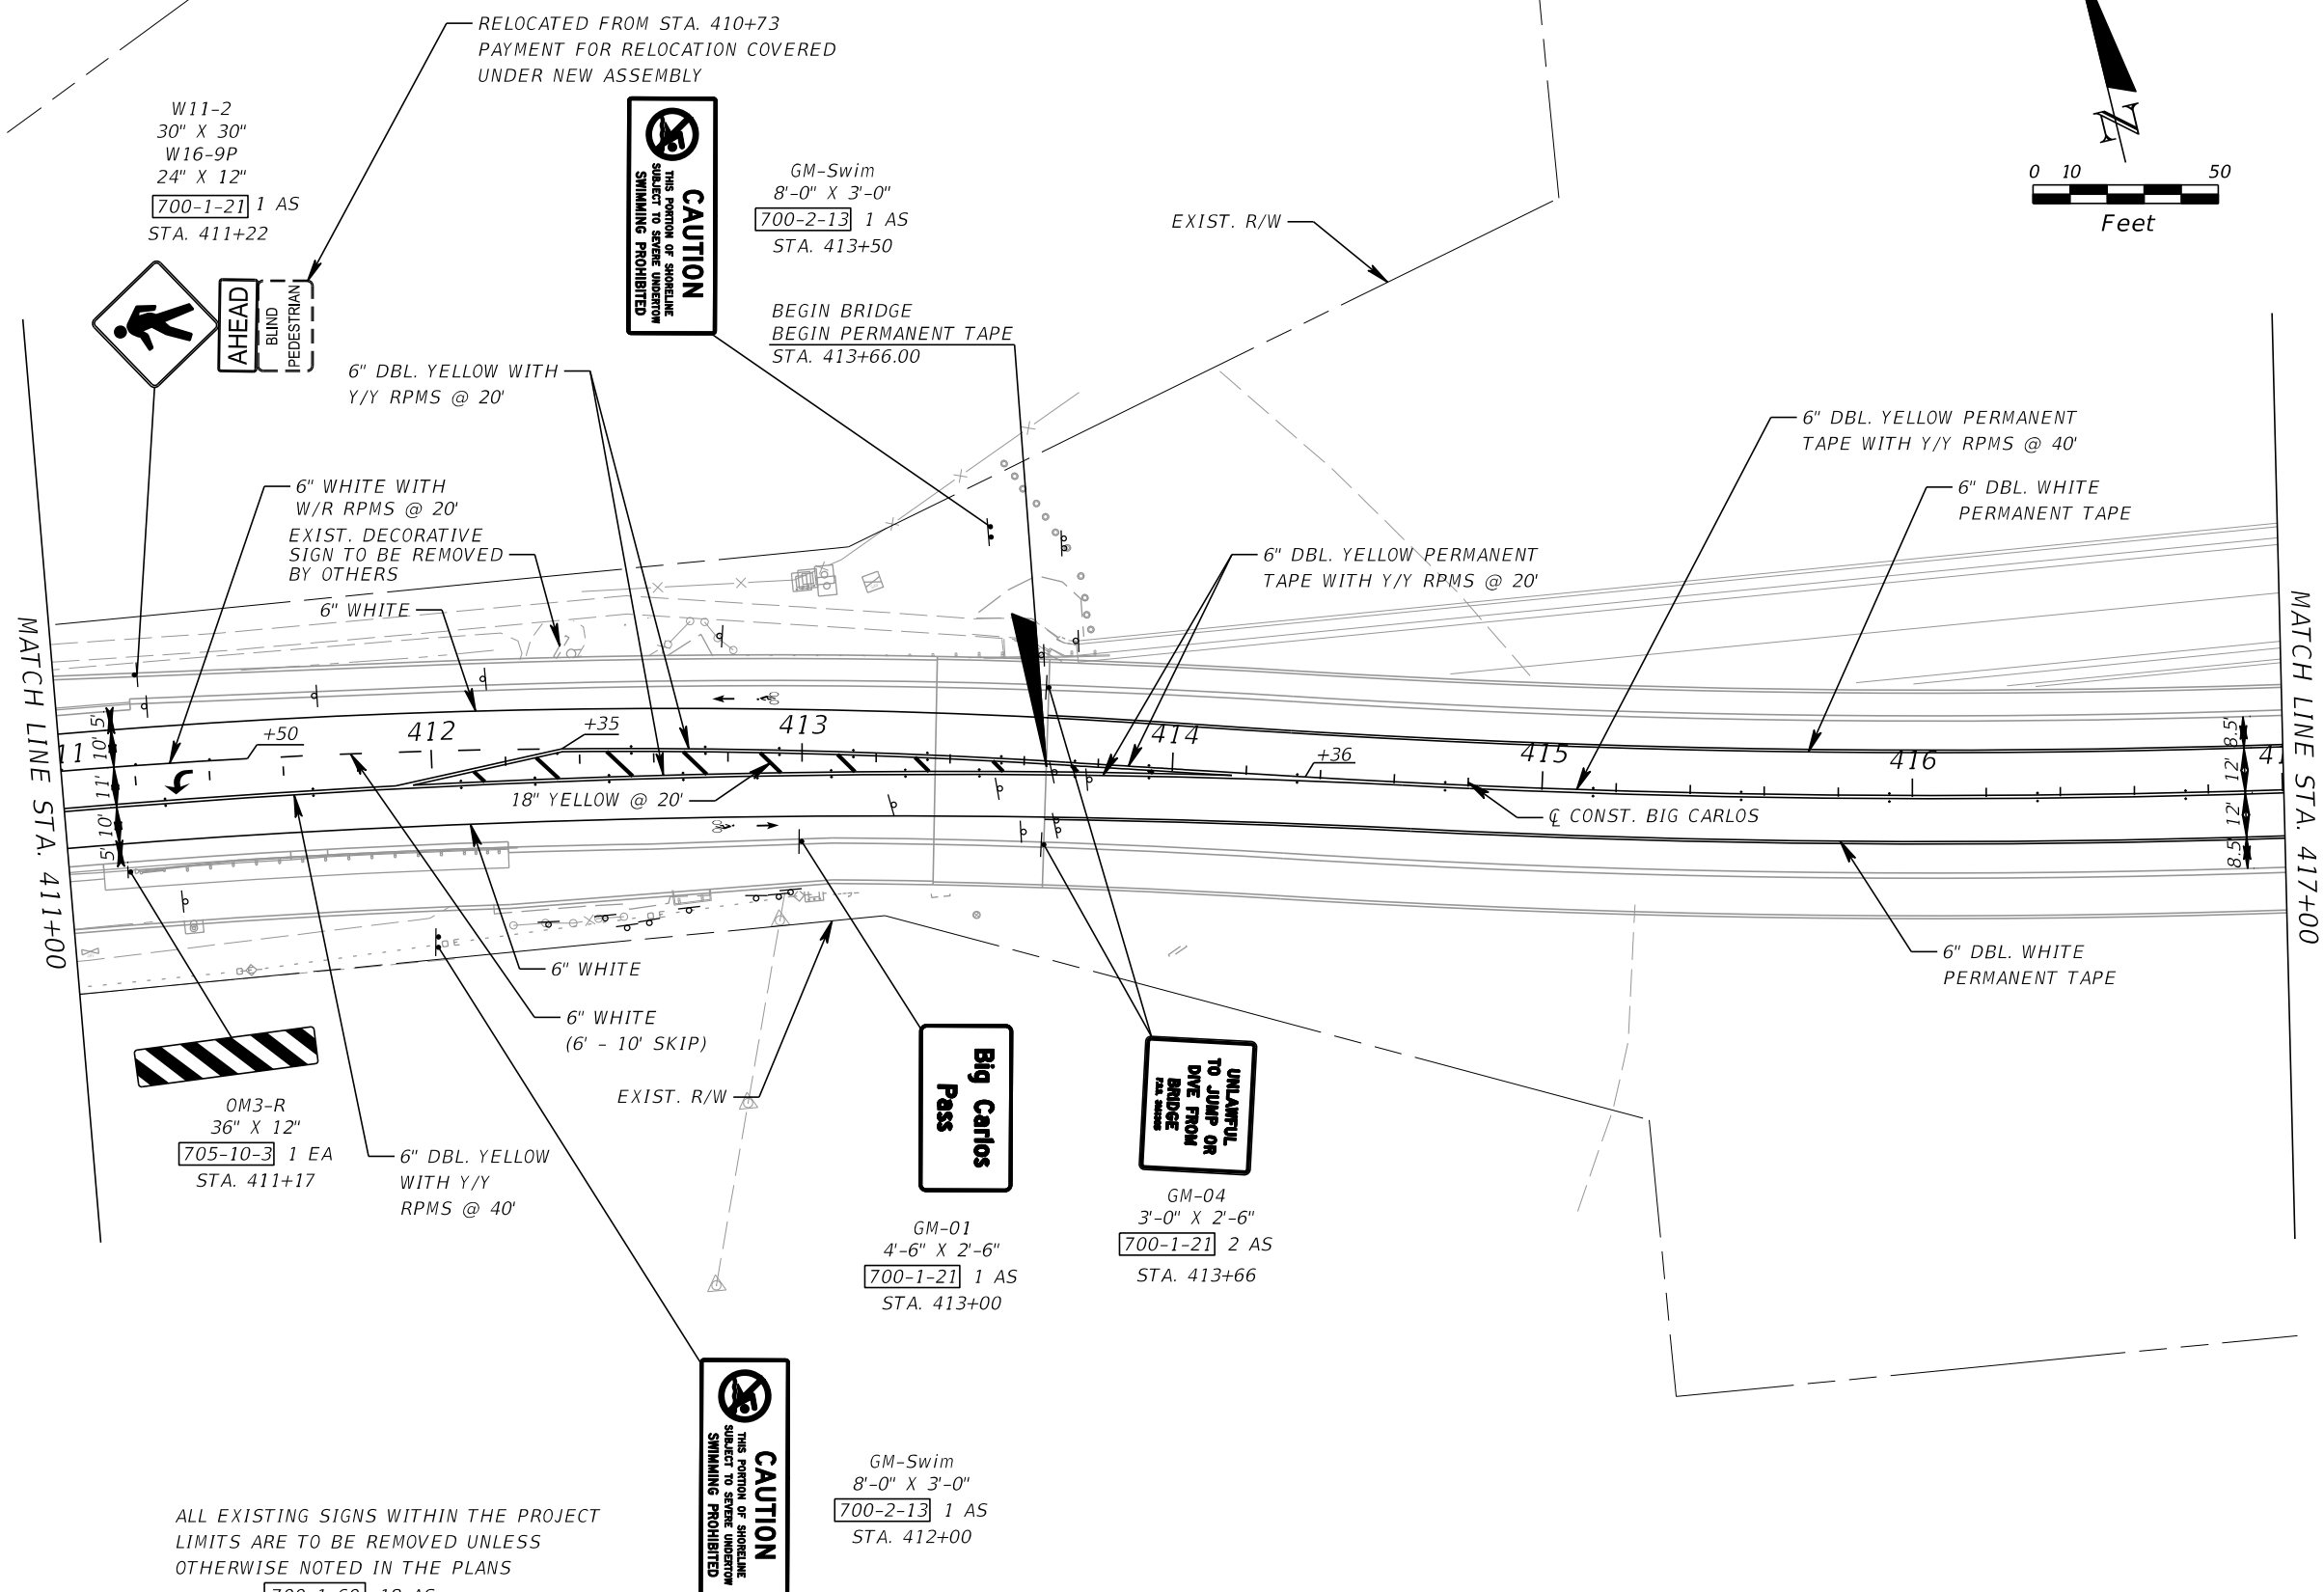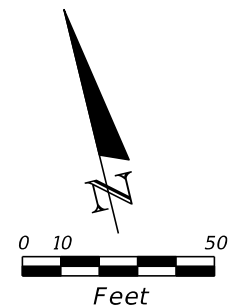

ALL EXISTING SIGNS WITHIN THE PROJECT LIMITS ARE TO BE REMOVED UNLESS OTHERWISE NOTED IN THE PLANS
 700-1-60 18 AS
 700-2-60 3 AS
 THIS SHEET

REVISIONS			
DATE	DESCRIPTION	DATE	DESCRIPTION



KCA 201 N. Franklin Street, Suite 400
 Tampa, Florida 33602
 KISINGER CAMPO Engineer of Record: M. Fathy Abdalla, P.E.
 & ASSOCIATES P.E. No.: 63914

LEE COUNTY DEPARTMENT OF TRANSPORTATION		
ROAD NO.	COUNTY	PROJECT NO.
CR 865	LEE	CN160002

**SIGNING & PAVEMENT
 MARKING PLAN (2)**


SHEET NO.
S-6

THE OFFICIAL RECORD OF THIS SHEET IS THE ELECTRONIC FILE DIGITALLY SIGNED AND SEALED UNDER RULE 61G15-23.004, F.A.C.

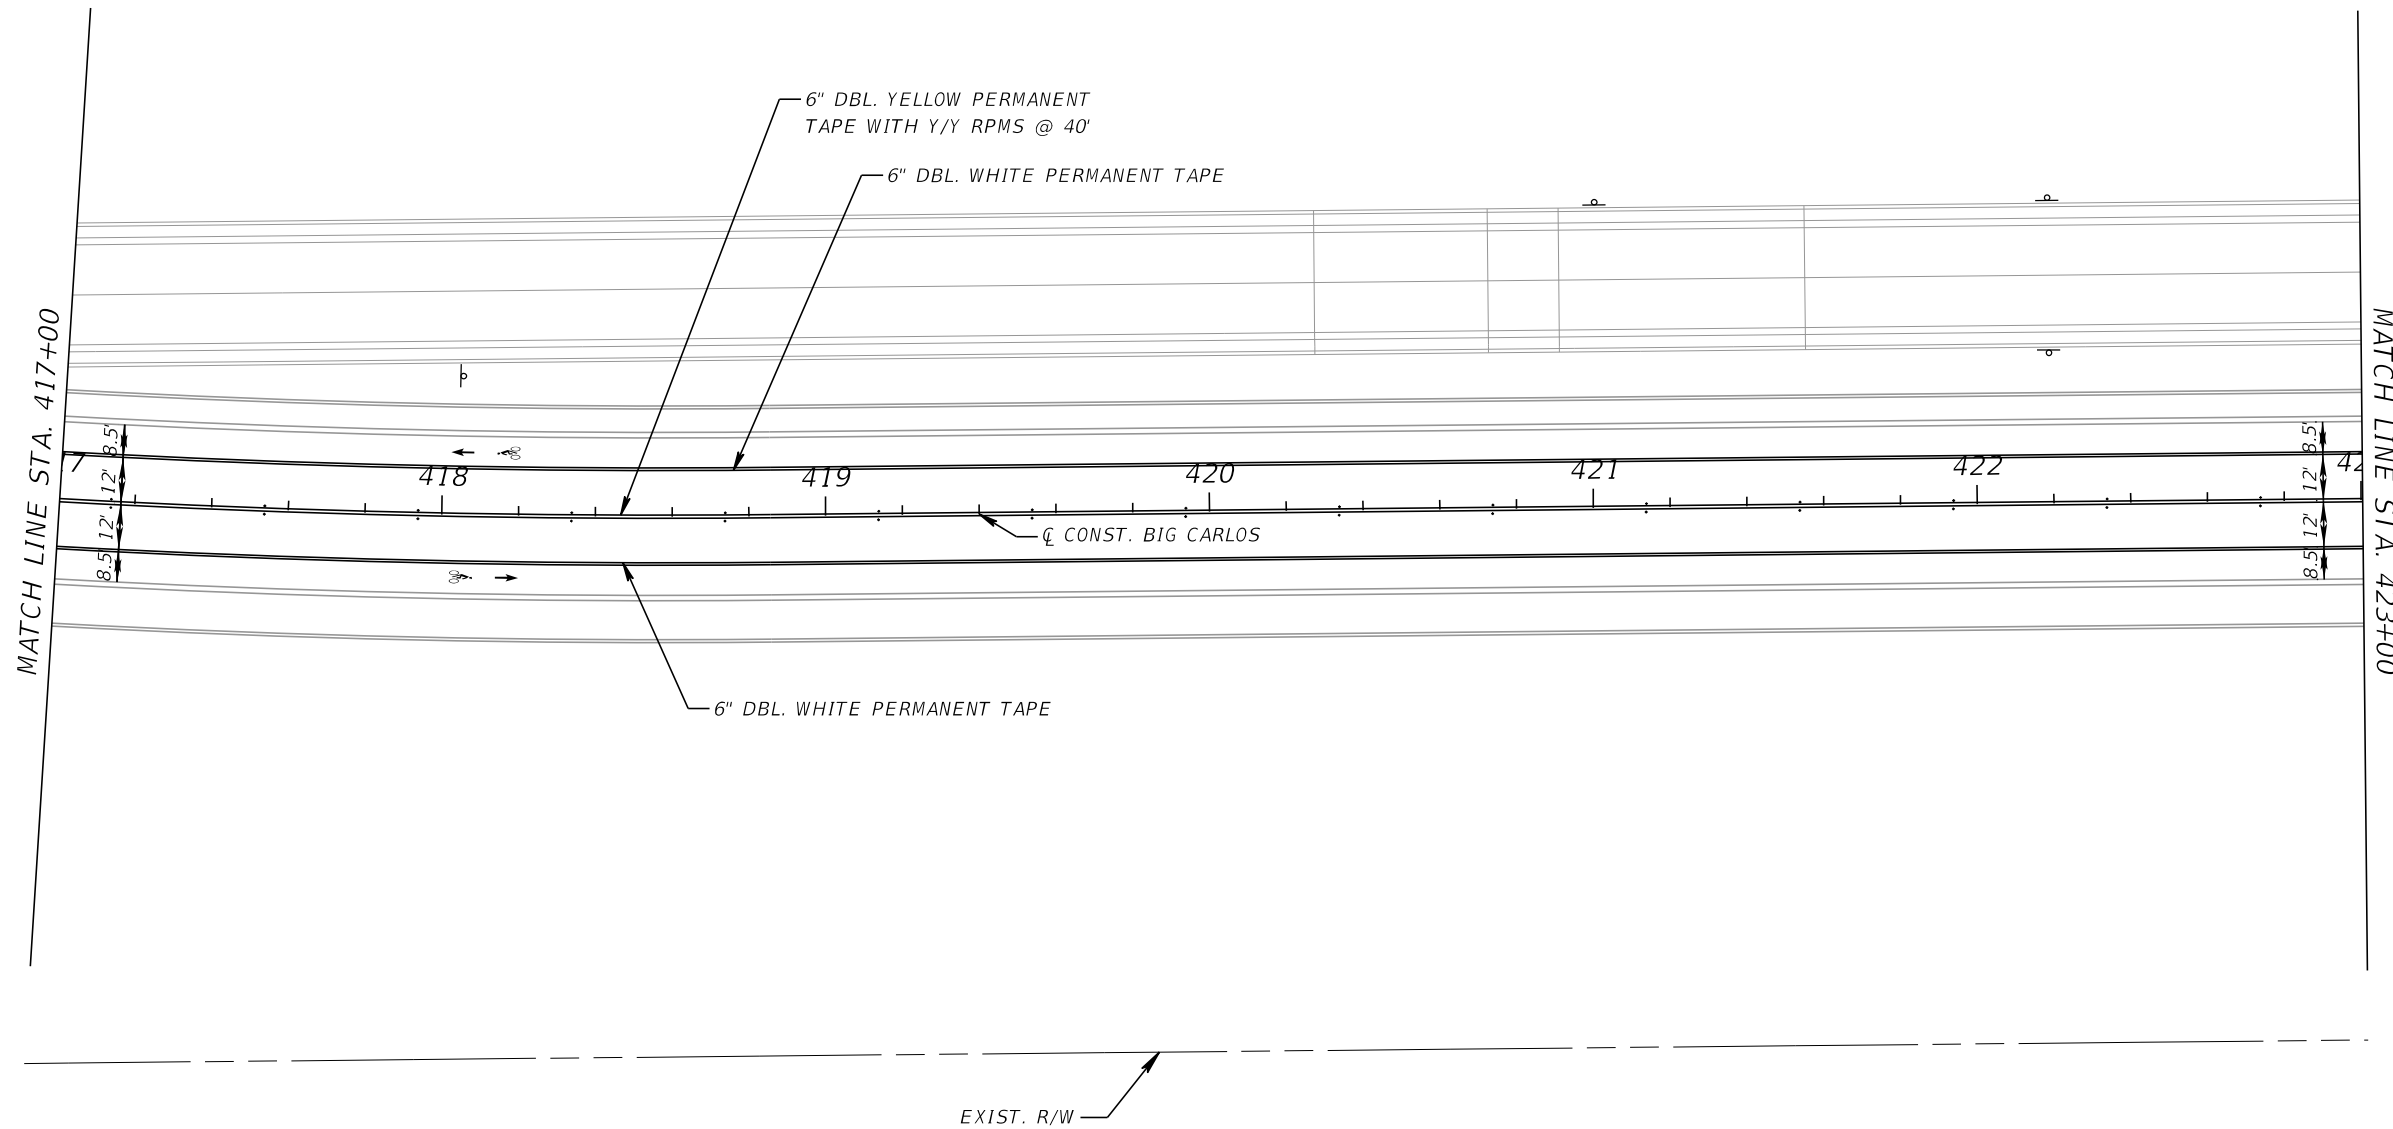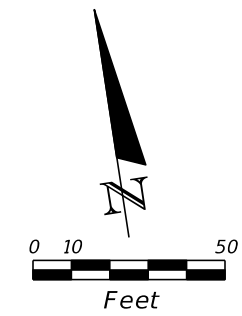



ALL EXISTING SIGNS WITHIN THE PROJECT
LIMITS ARE TO BE REMOVED UNLESS
OTHERWISE NOTED IN THE PLANS

700-1-60 4 AS
THIS SHEET

REVISIONS				 201 N. Franklin Street, Suite 400 Tampa, Florida 33602 Engineer of Record: M. Fathy Abdalla, P.E. P.E. No.: 63914	LEE COUNTY DEPARTMENT OF TRANSPORTATION			SIGNING & PAVEMENT MARKING PLAN (3)	SHEET NO.
DATE	DESCRIPTION	DATE	DESCRIPTION		ROAD NO.	COUNTY	PROJECT NO.		S-7
					CR 865	LEE	CN160002		


THE OFFICIAL RECORD OF THIS SHEET IS THE ELECTRONIC FILE DIGITALLY SIGNED AND SEALED UNDER RULE 61G15-23.004, F.A.C.

ESTERO BLVD.

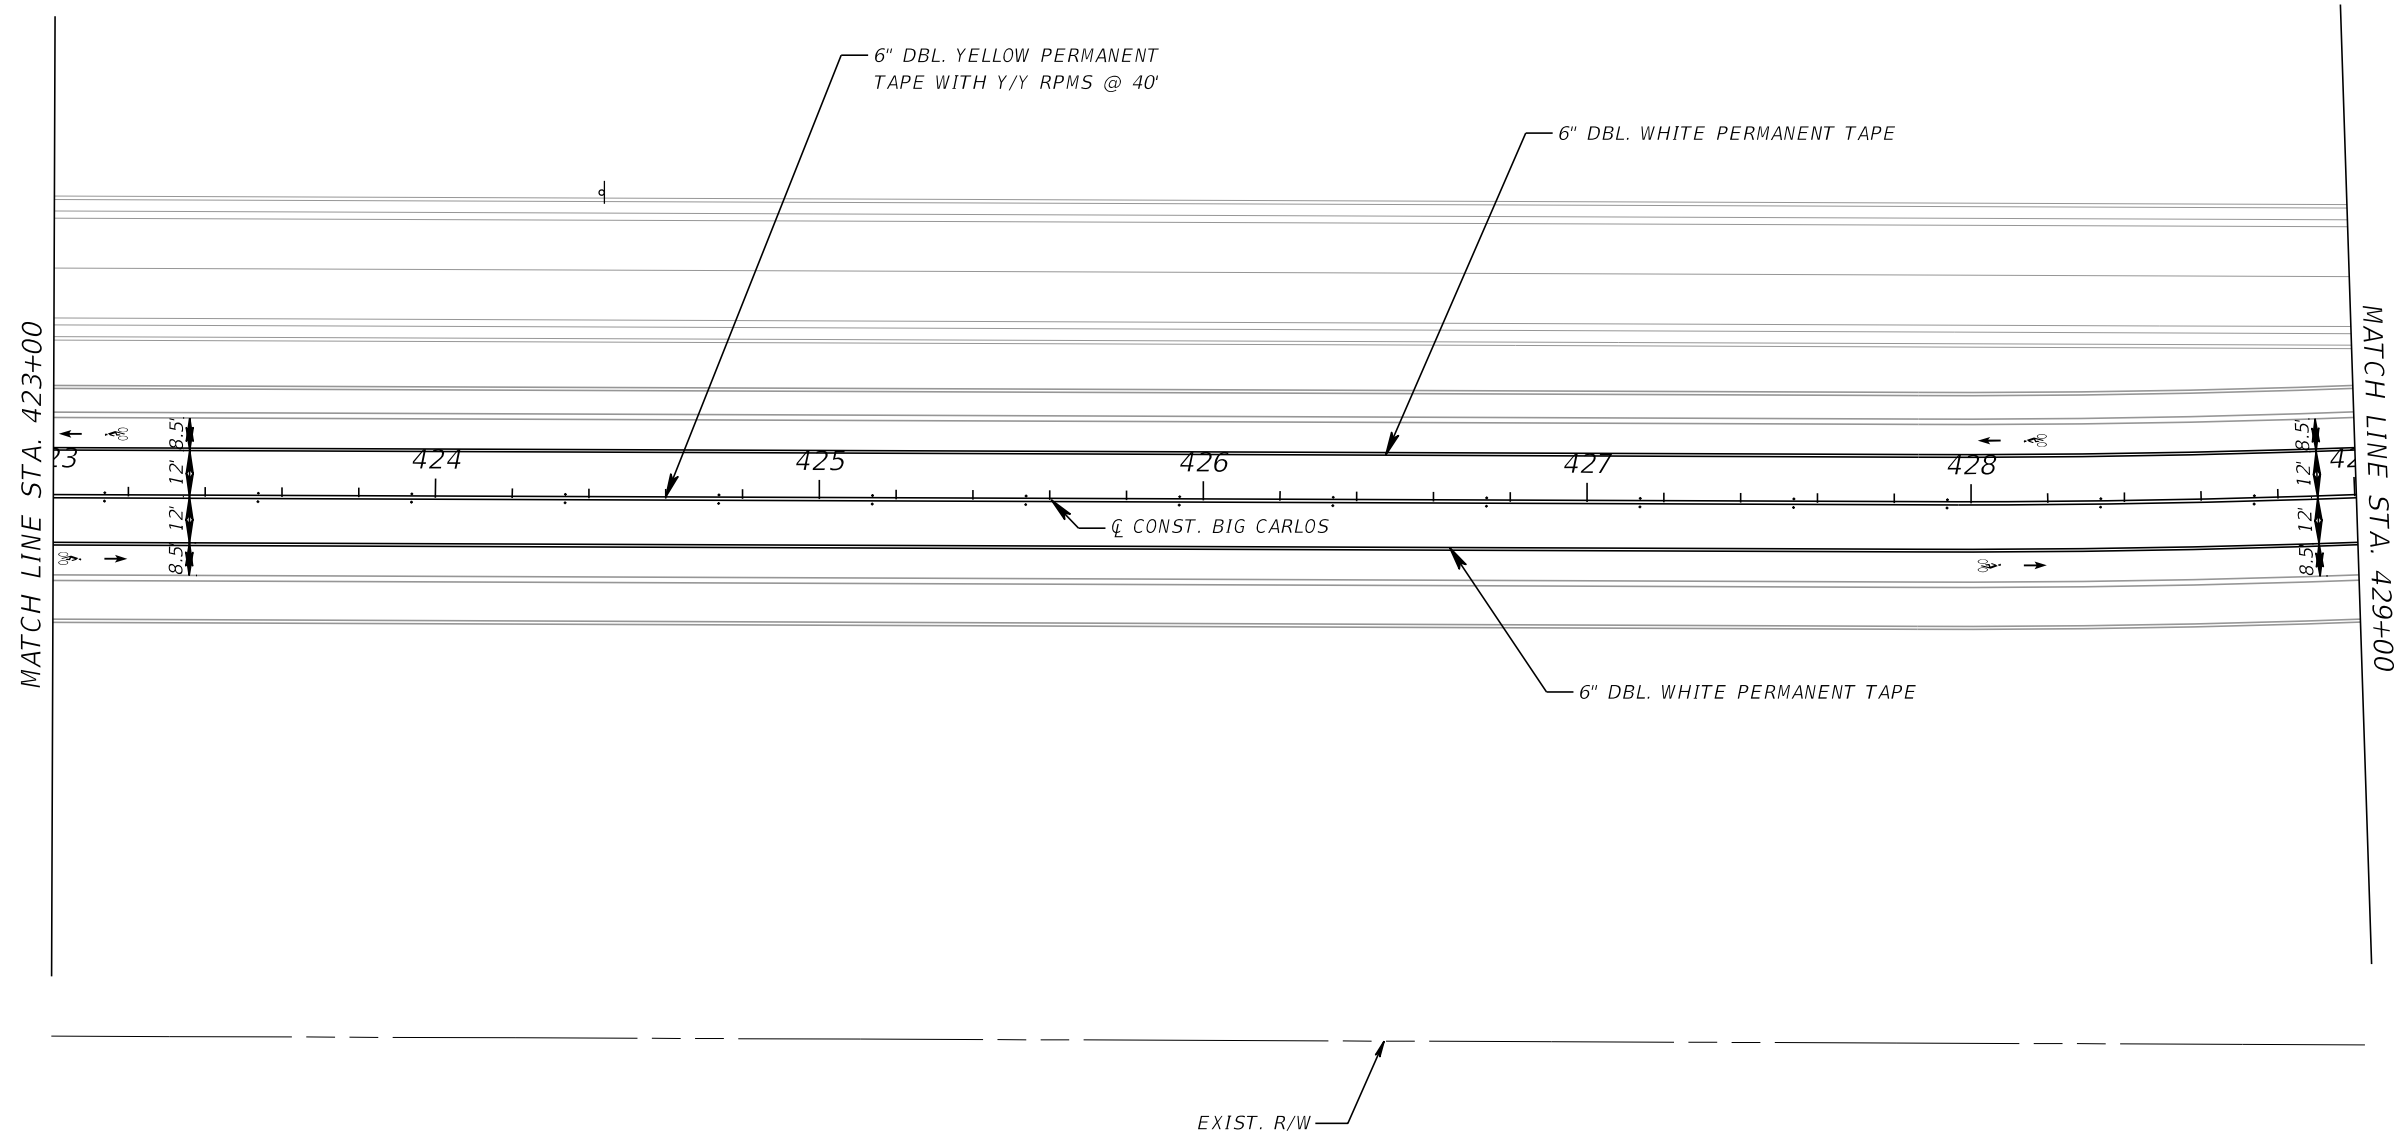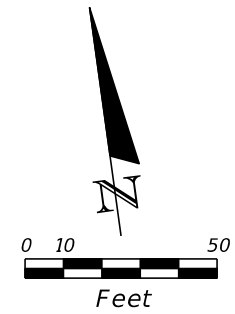



ALL EXISTING SIGNS WITHIN THE PROJECT
LIMITS ARE TO BE REMOVED UNLESS
OTHERWISE NOTED IN THE PLANS

700-1-60 1 AS
THIS SHEET

REVISIONS				 201 N. Franklin Street, Suite 400 Tampa, Florida 33602 Engineer of Record: M. Fathy Abdalla, P.E. P.E. No.: 63914	LEE COUNTY DEPARTMENT OF TRANSPORTATION			SIGNING & PAVEMENT MARKING PLAN (4)	SHEET NO.
DATE	DESCRIPTION	DATE	DESCRIPTION		ROAD NO.	COUNTY	PROJECT NO.		S-8
					CR 865	LEE	CN160002		

THE OFFICIAL RECORD OF THIS SHEET IS THE ELECTRONIC FILE DIGITALLY SIGNED AND SEALED UNDER RULE 61G15-23.004, F.A.C.

ESTERO BLVD.

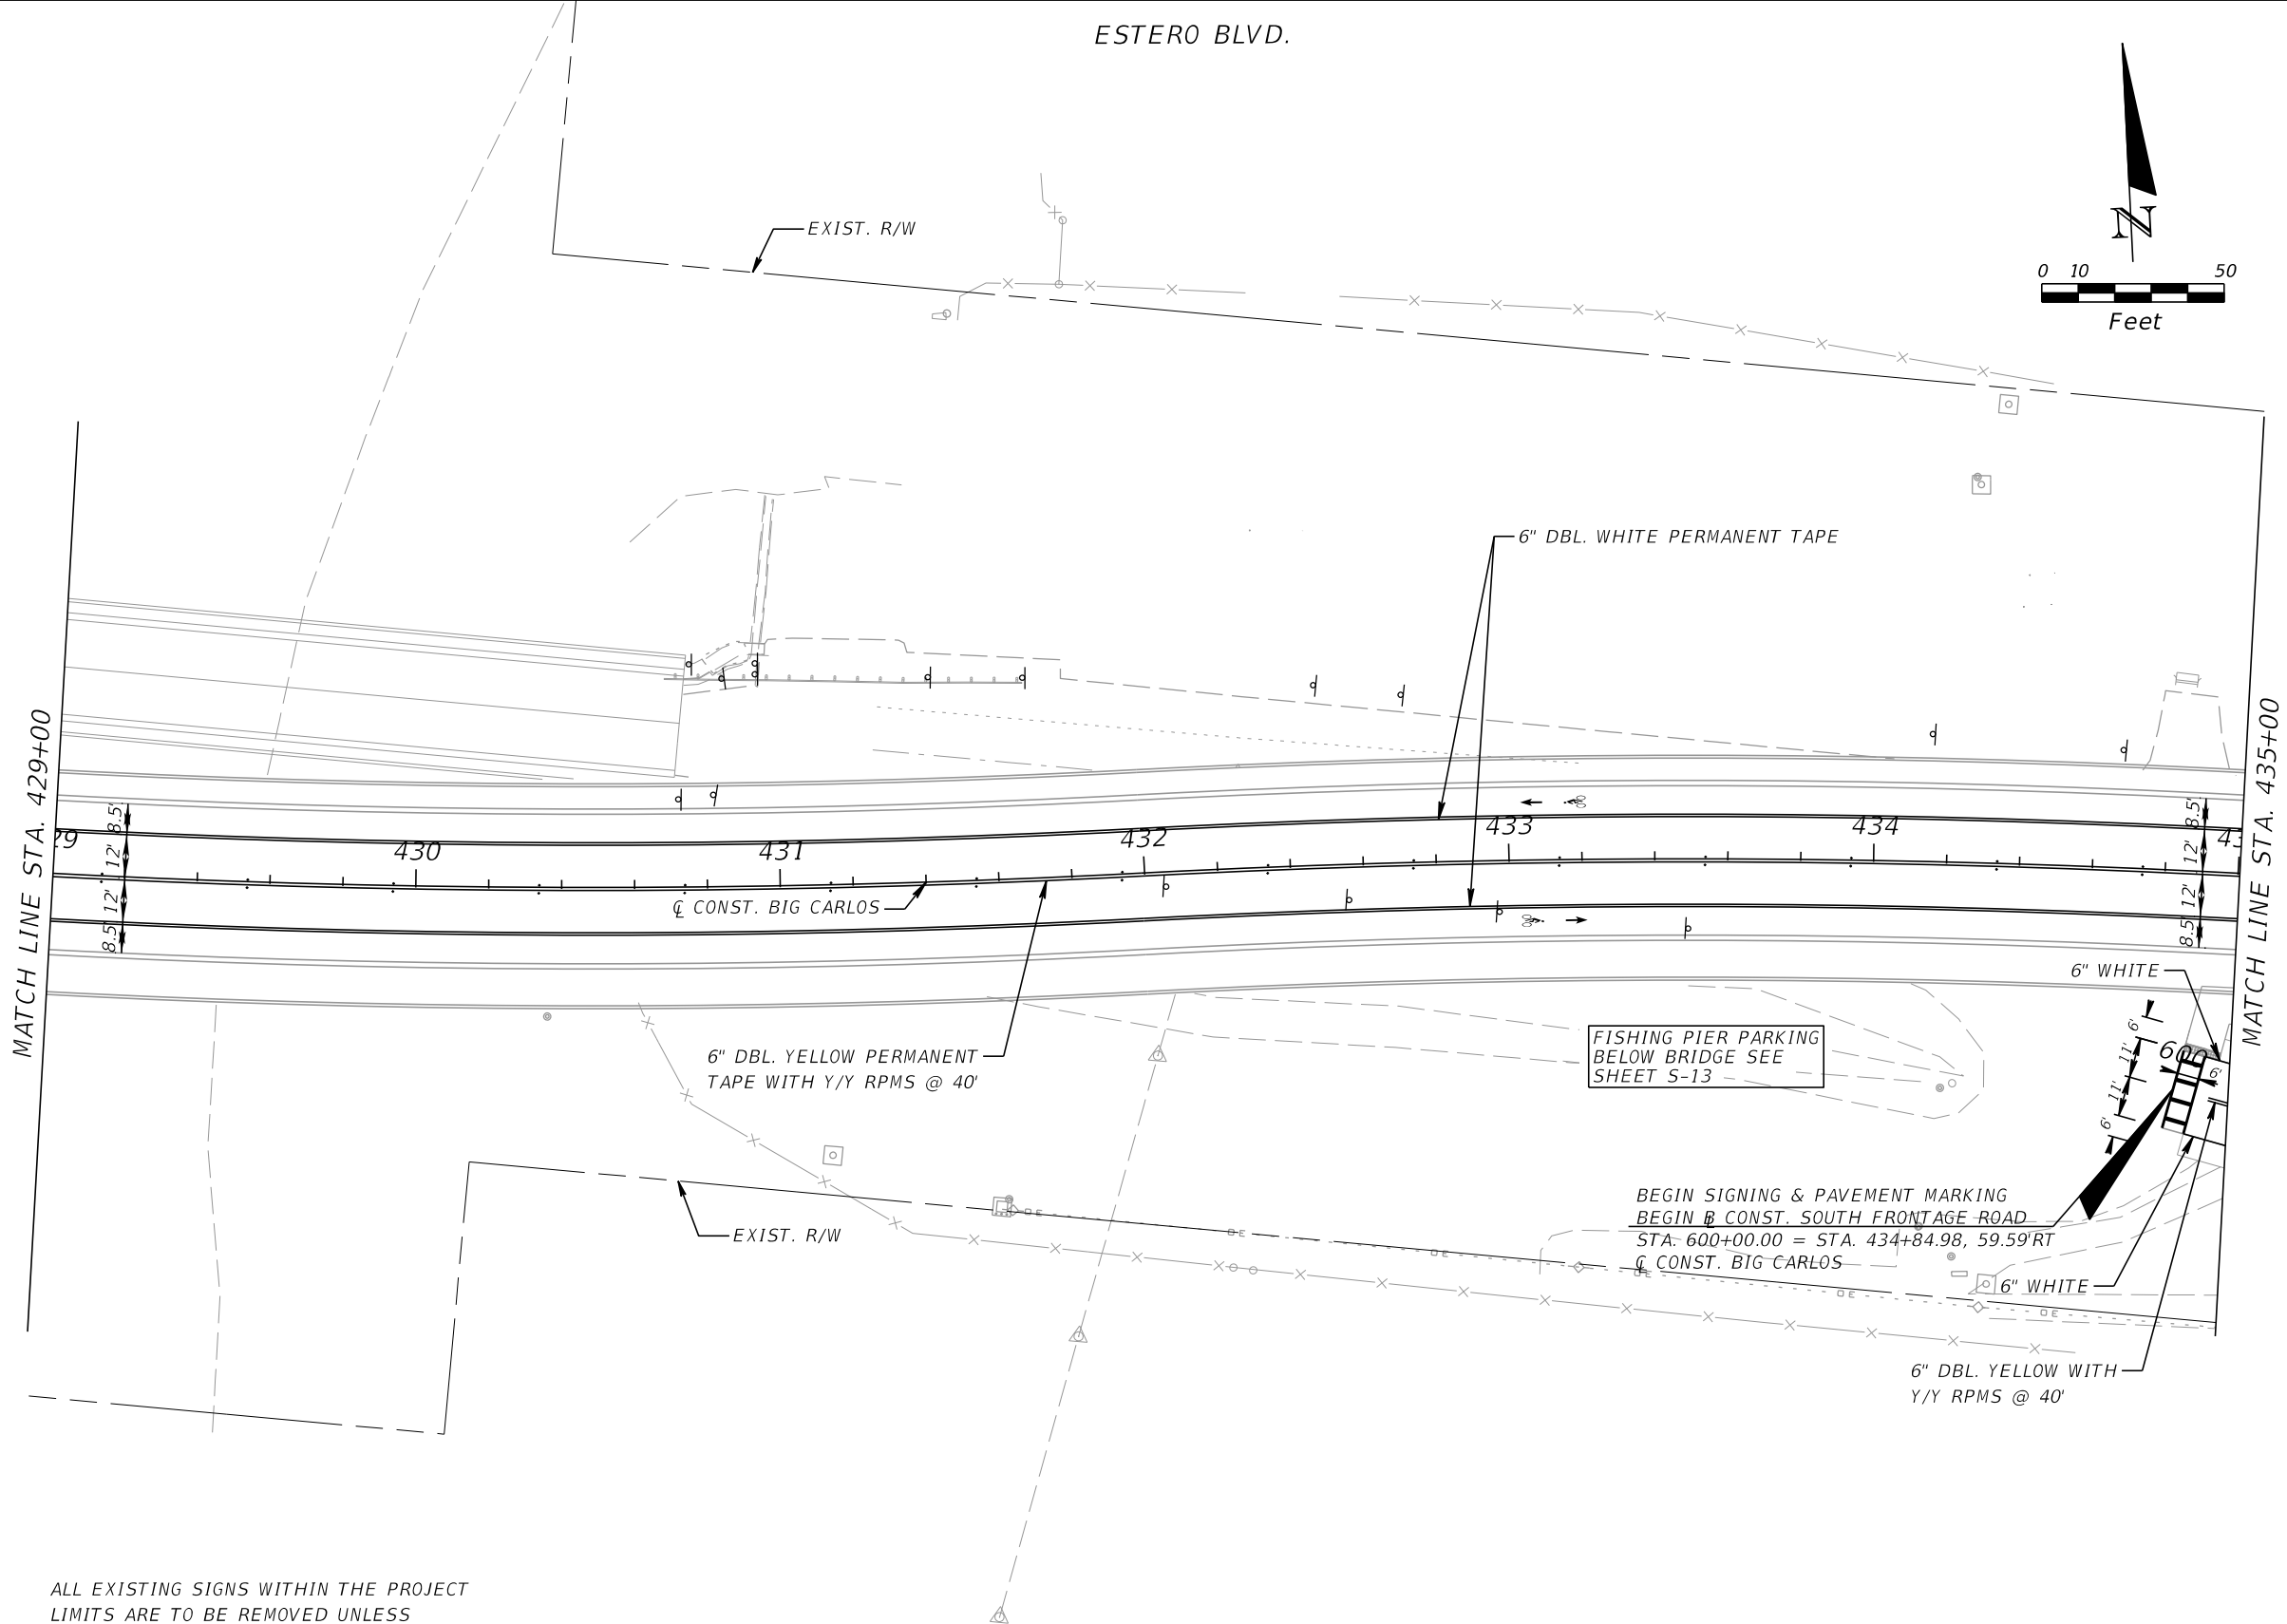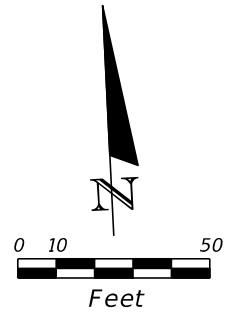

ALL EXISTING SIGNS WITHIN THE PROJECT LIMITS ARE TO BE REMOVED UNLESS OTHERWISE NOTED IN THE PLANS

700-1-60	14 AS
700-2-60	1 AS

THIS SHEET

REVISIONS			
DATE	DESCRIPTION	DATE	DESCRIPTION

KCA
 KISINGER CAMPO & ASSOCIATES
 201 N. Franklin Street, Suite 400
 Tampa, Florida 33602
 Engineer of Record: M. Fathy Abdalla, P.E.
 P.E. No.: 63914


LEE COUNTY DEPARTMENT OF TRANSPORTATION		
ROAD NO.	COUNTY	PROJECT NO.
CR 865	LEE	CN160002

SIGNING & PAVEMENT MARKING PLAN (5)

SHEET NO.
S-9

THE OFFICIAL RECORD OF THIS SHEET IS THE ELECTRONIC FILE DIGITALLY SIGNED AND SEALED UNDER RULE 61G15-23.004, F.A.C.

ESTERO BLVD.

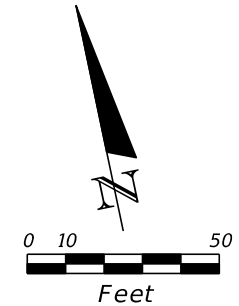

BEGIN SIGNING & PAVEMENT MARKING NORTH FRONTAGE RD. STA. 500+69.38

REMOVE EXIST. LIGHT POLES. 715-4-70 2 AS

6" DBL. YELLOW PERMANENT TAPE WITH Y/Y RPMS @ 40'

6" DBL. WHITE PERMANENT TAPE

UNLAWFUL TO JUMP OR DIVE FROM BRIDGE FOR SWIMMING

GM-04
3'-0" X 2'-6"
700-1-21 2 AS
STA. 436+32
STA. 436+32

END BRIDGE
END PERMANENT TAPE
STA. 436+32.00

Big Carlos Pass

GM-01
4'-6" X 2'-6"
700-1-21 1 AS
STA. 437+00

R2-1
30" X 36"
700-1-21 1 AS
STA. 439+00

SPEED LIMIT 30


6" DBL. YELLOW WITH Y/Y RPMS @ 20'

6" DBL. YELLOW WITH Y/Y RPMS @ 40'

6" WHITE

MATCH LINE STA. 435+00

MATCH LINE STA. 441+00

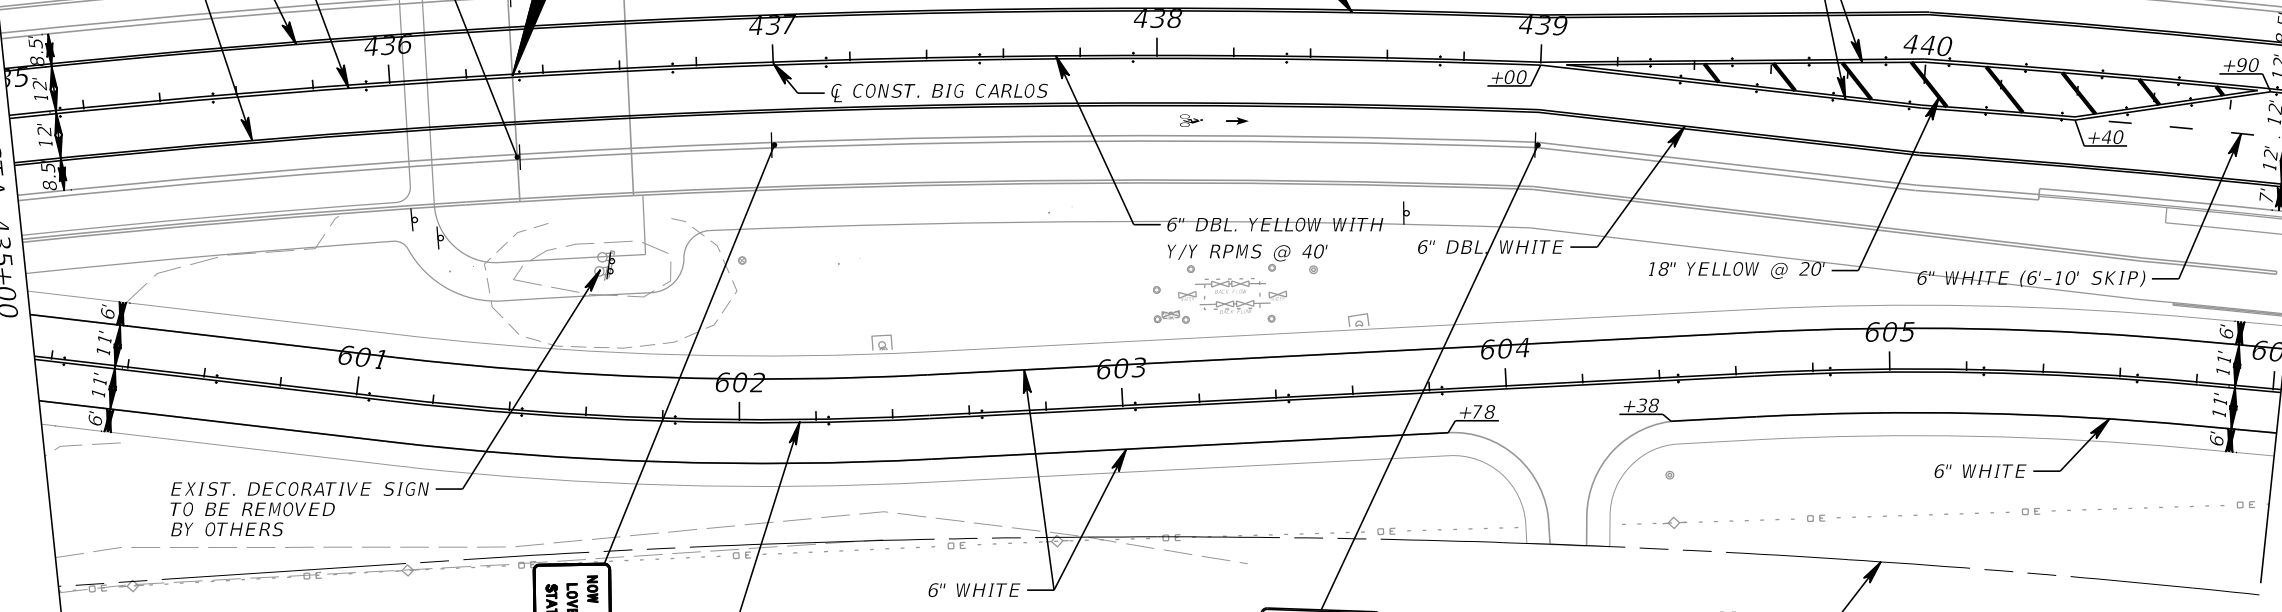

EXIST. DECORATIVE SIGN TO BE REMOVED BY OTHERS

GM-03
4'-0" X 2'-6"
700-1-21 1 AS
STA. 437+00

NOW ENTERING LOVERS KEY STATE PARK

6" DBL. YELLOW WITH Y/Y RPMS @ 40'

SPEED LIMIT 35

R2-1
30" X 36"
700-1-21 1 AS
STA. 439+00

ALL EXISTING SIGNS WITHIN THE PROJECT LIMITS ARE TO BE REMOVED UNLESS OTHERWISE NOTED IN THE PLANS

700-1-60 7 AS
700-2-60 3 AS
THIS SHEET

REVISIONS			
DATE	DESCRIPTION	DATE	DESCRIPTION

KCA
KISINGER CAMPO & ASSOCIATES
201 N. Franklin Street, Suite 400
Tampa, Florida 33602
Engineer of Record: M. Fathy Abdalla, P.E.
P.E. No.: 63914


LEE COUNTY DEPARTMENT OF TRANSPORTATION		
ROAD NO.	COUNTY	PROJECT NO.
CR 865	LEE	CN160002

SIGNING & PAVEMENT MARKING PLAN (6)

SHEET NO. S-10

THE OFFICIAL RECORD OF THIS SHEET IS THE ELECTRONIC FILE DIGITALLY SIGNED AND SEALED UNDER RULE 61G15-23.004, F.A.C.

ESTERO BLVD.

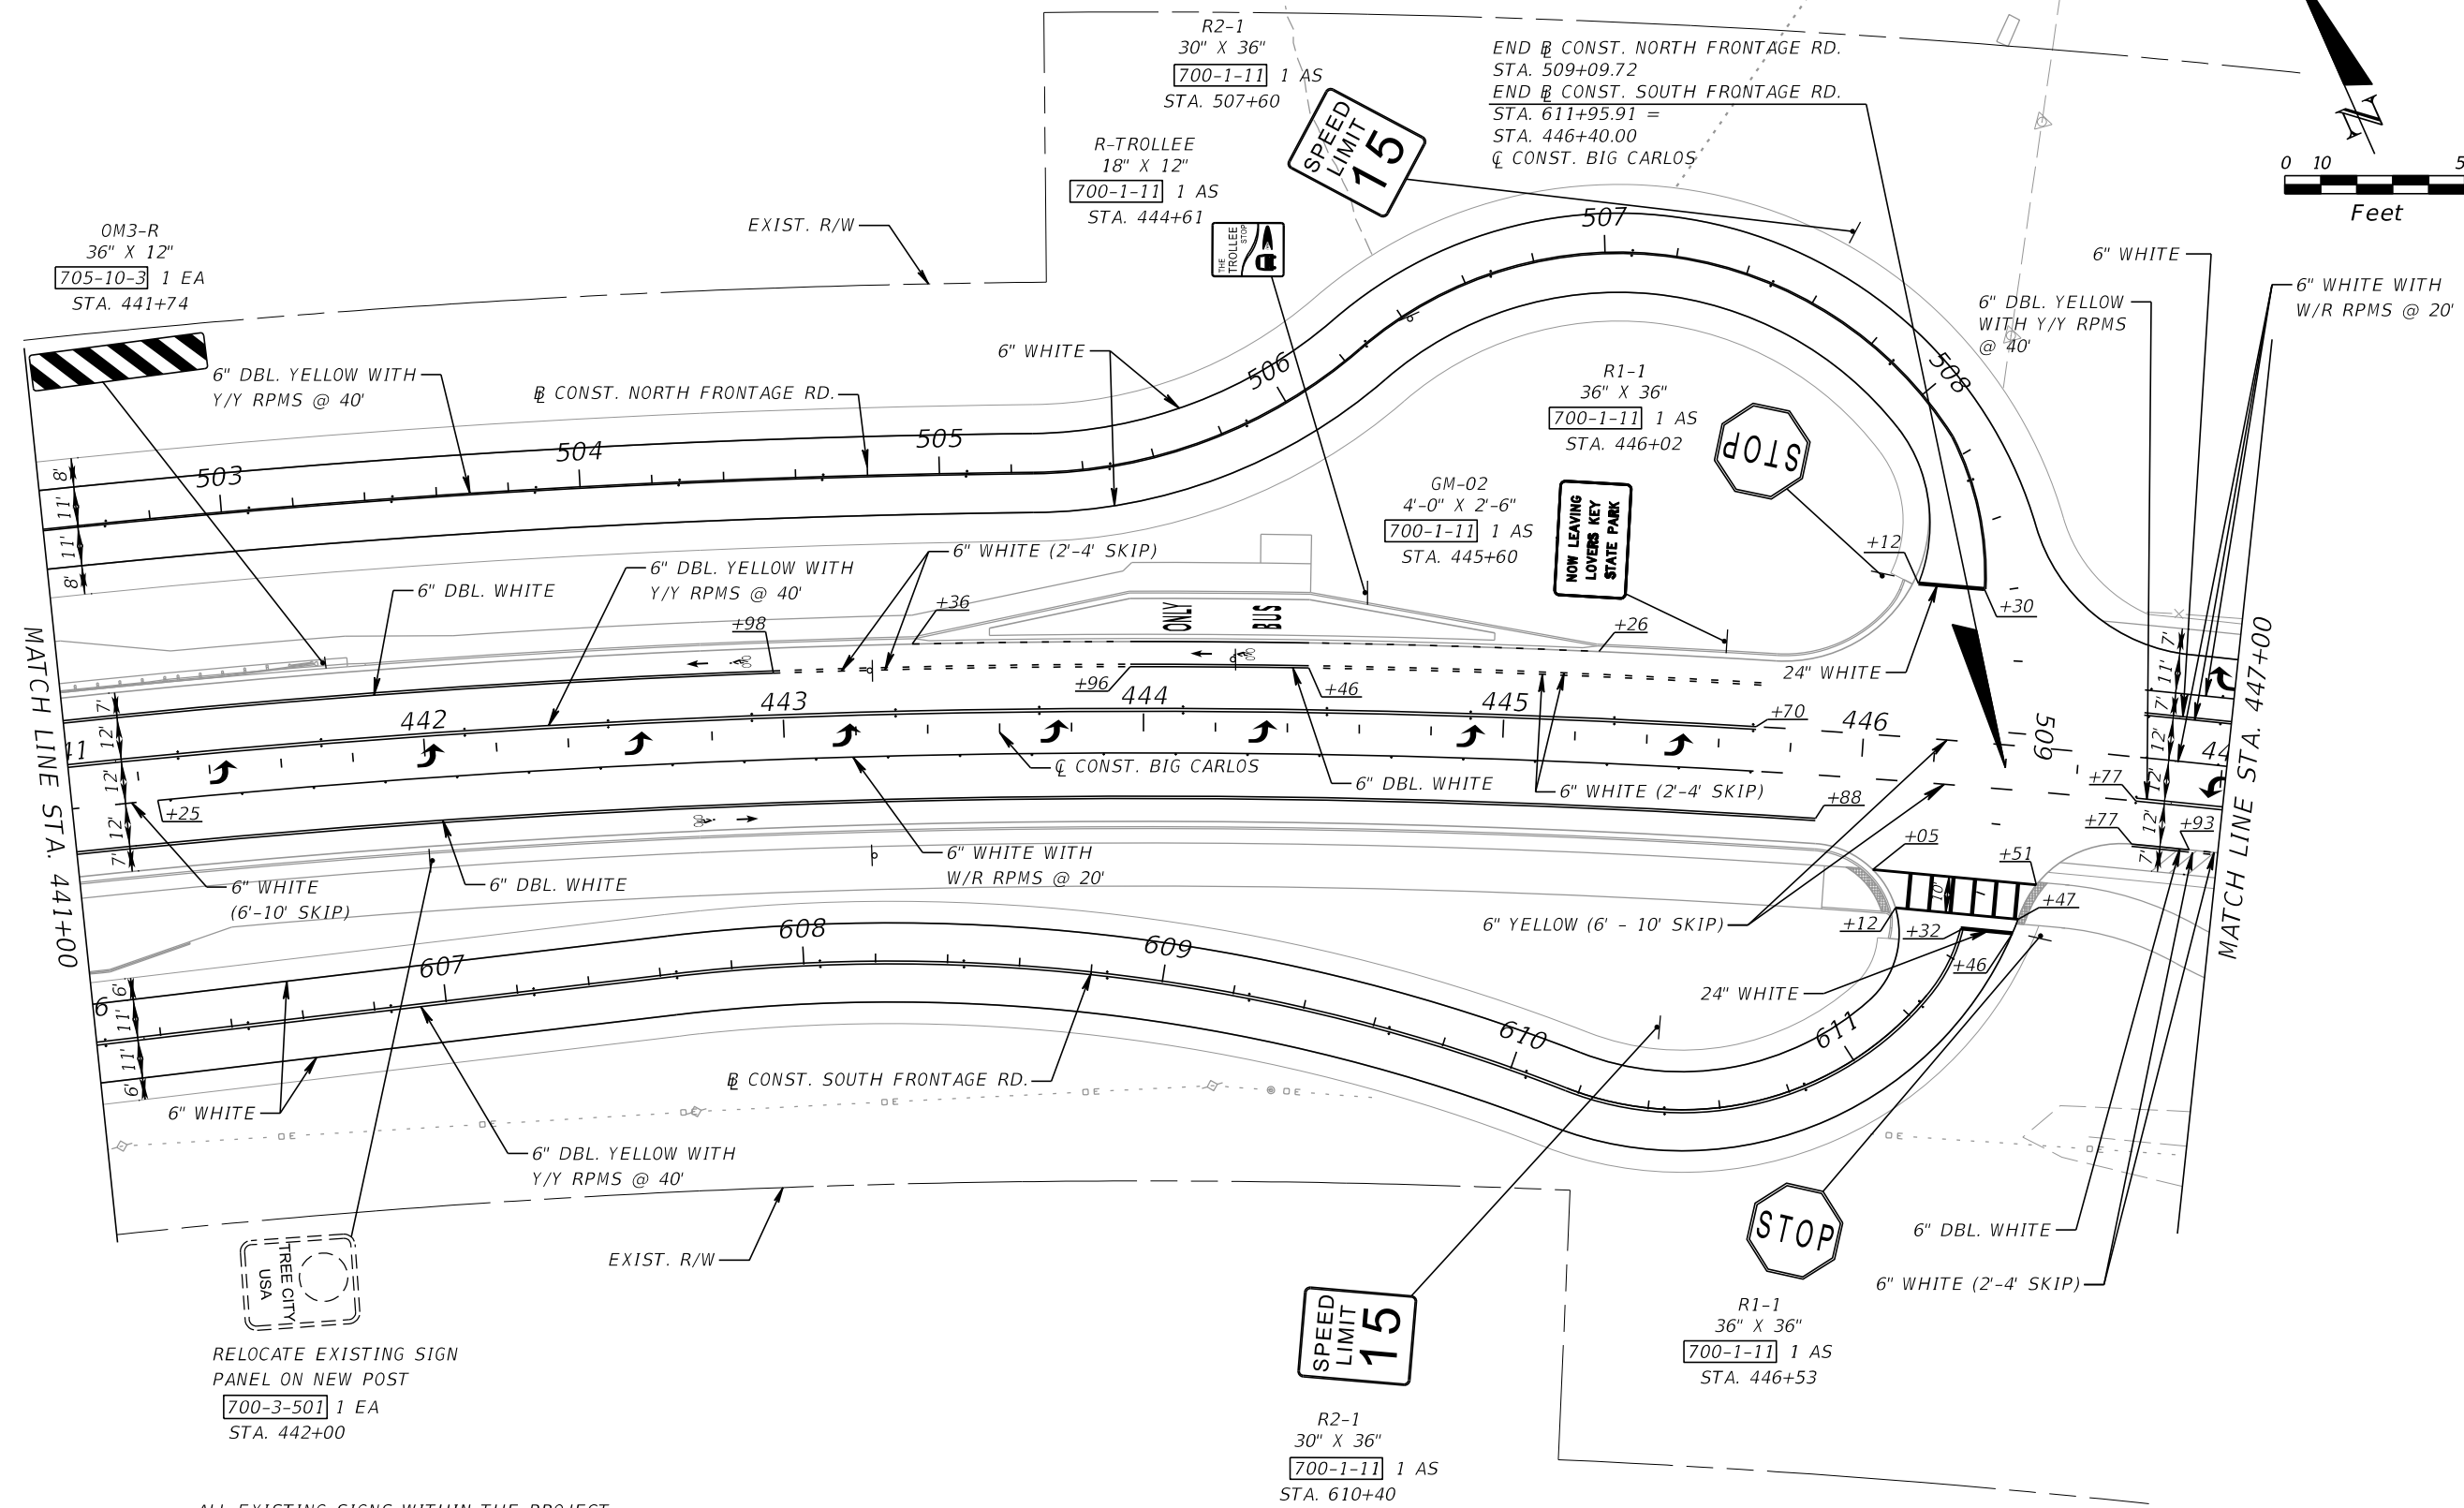

RELOCATE EXISTING SIGN
PANEL ON NEW POST
700-3-501 1 EA
STA. 442+00

ALL EXISTING SIGNS WITHIN THE PROJECT
LIMITS ARE TO BE REMOVED UNLESS
OTHERWISE NOTED IN THE PLANS
700-1-60 3 AS
THIS SHEET

REVISIONS			
DATE	DESCRIPTION	DATE	DESCRIPTION




KCA
KISINGER CAMPO & ASSOCIATES
201 N. Franklin Street, Suite 400
Tampa, Florida 33602
Engineer of Record: M. Fathy Abdalla, P.E.
P.E. No.: 63914

LEE COUNTY DEPARTMENT OF TRANSPORTATION		
ROAD NO.	COUNTY	PROJECT NO.
CR 865	LEE	CN160002

**SIGNING & PAVEMENT
MARKING PLAN (7)**

SHEET NO.
S-11

 THE OFFICIAL RECORD OF THIS SHEET IS THE ELECTRONIC FILE DIGITALLY SIGNED AND SEALED UNDER RULE 61G15-23.004, F.A.C.

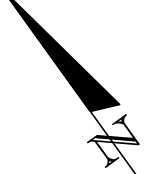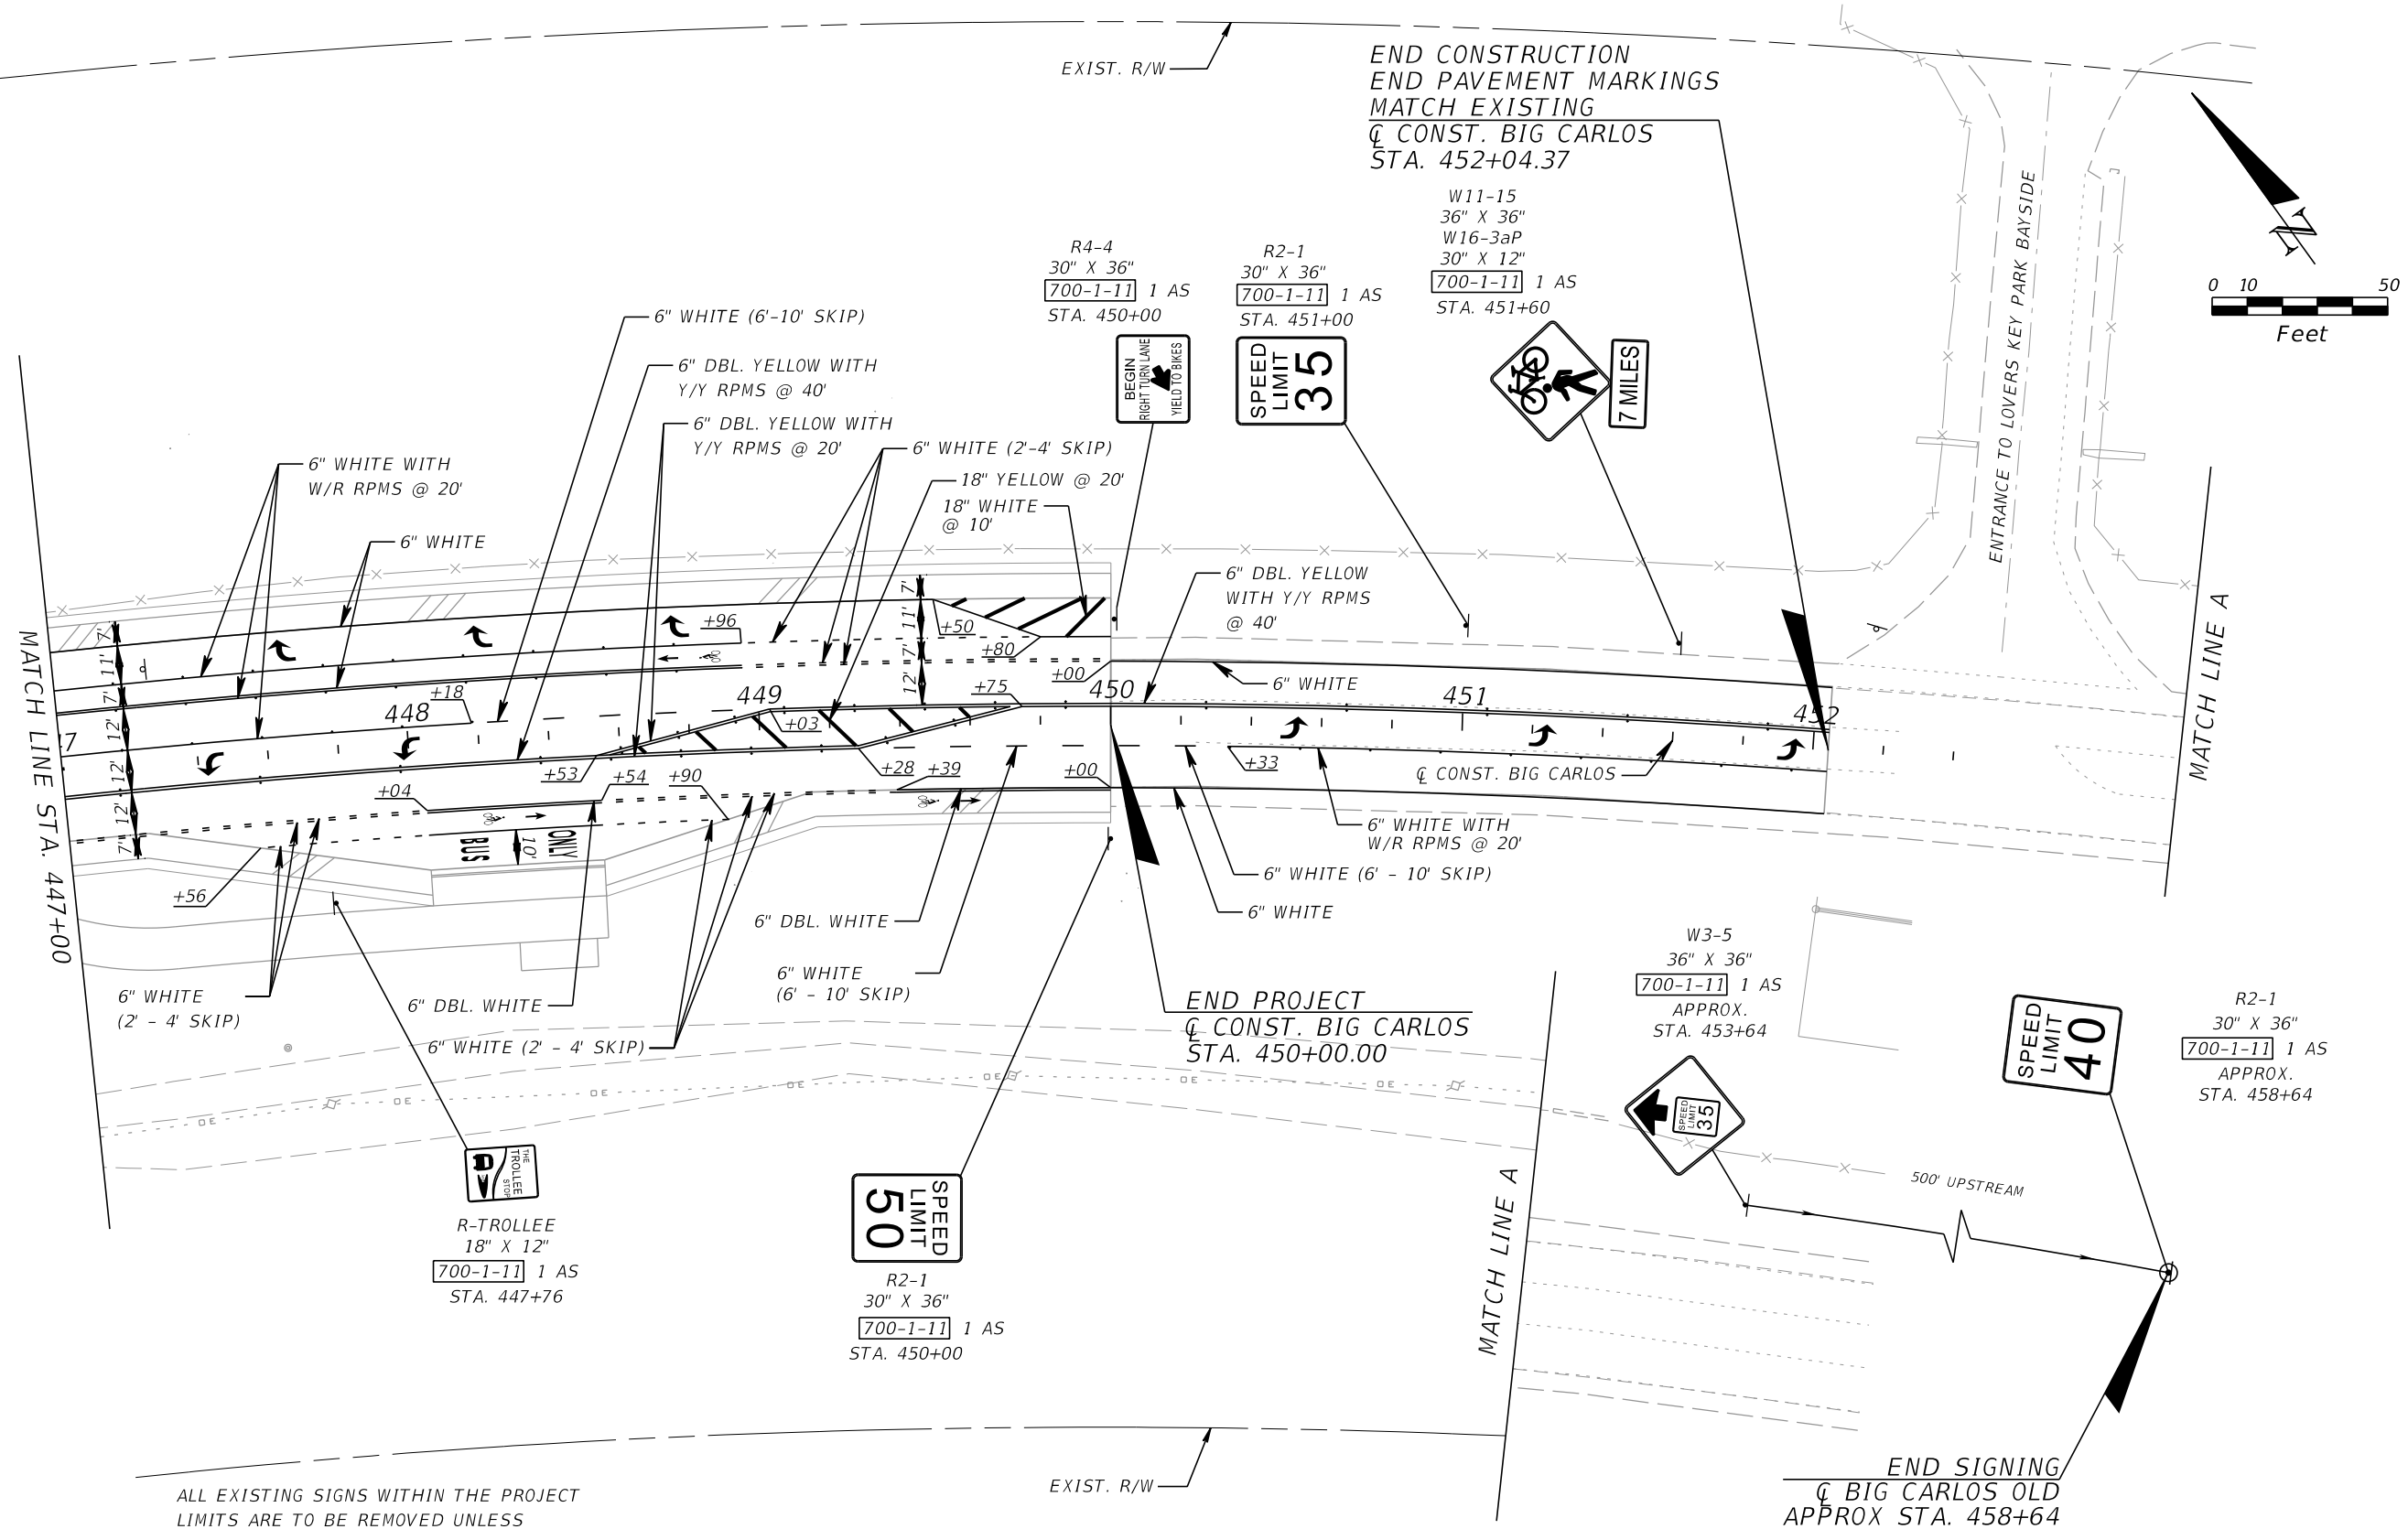

ALL EXISTING SIGNS WITHIN THE PROJECT LIMITS ARE TO BE REMOVED UNLESS OTHERWISE NOTED IN THE PLANS
 700-1-60 2 AS
 THIS SHEET

REVISIONS			
DATE	DESCRIPTION	DATE	DESCRIPTION

KCA 201 N. Franklin Street, Suite 400
 Tampa, Florida 33602
 KISINGER CAMPO & ASSOCIATES Engineer of Record: M. Fathy Abdalla, P.E.
 P.E. No.: 63914

LEE COUNTY DEPARTMENT OF TRANSPORTATION		
ROAD NO.	COUNTY	PROJECT NO.
CR 865	LEE	CN160002



SIGNING & PAVEMENT MARKING PLAN (8)

SHEET NO.
S-12

THE OFFICIAL RECORD OF THIS SHEET IS THE ELECTRONIC FILE DIGITALLY SIGNED AND SEALED UNDER RULE 61G15-23.004, F.A.C.



FTP-21-06
18" X 30"
FTP-22-06
12" X 6"
700-1-11 3 AS
STA 431+72

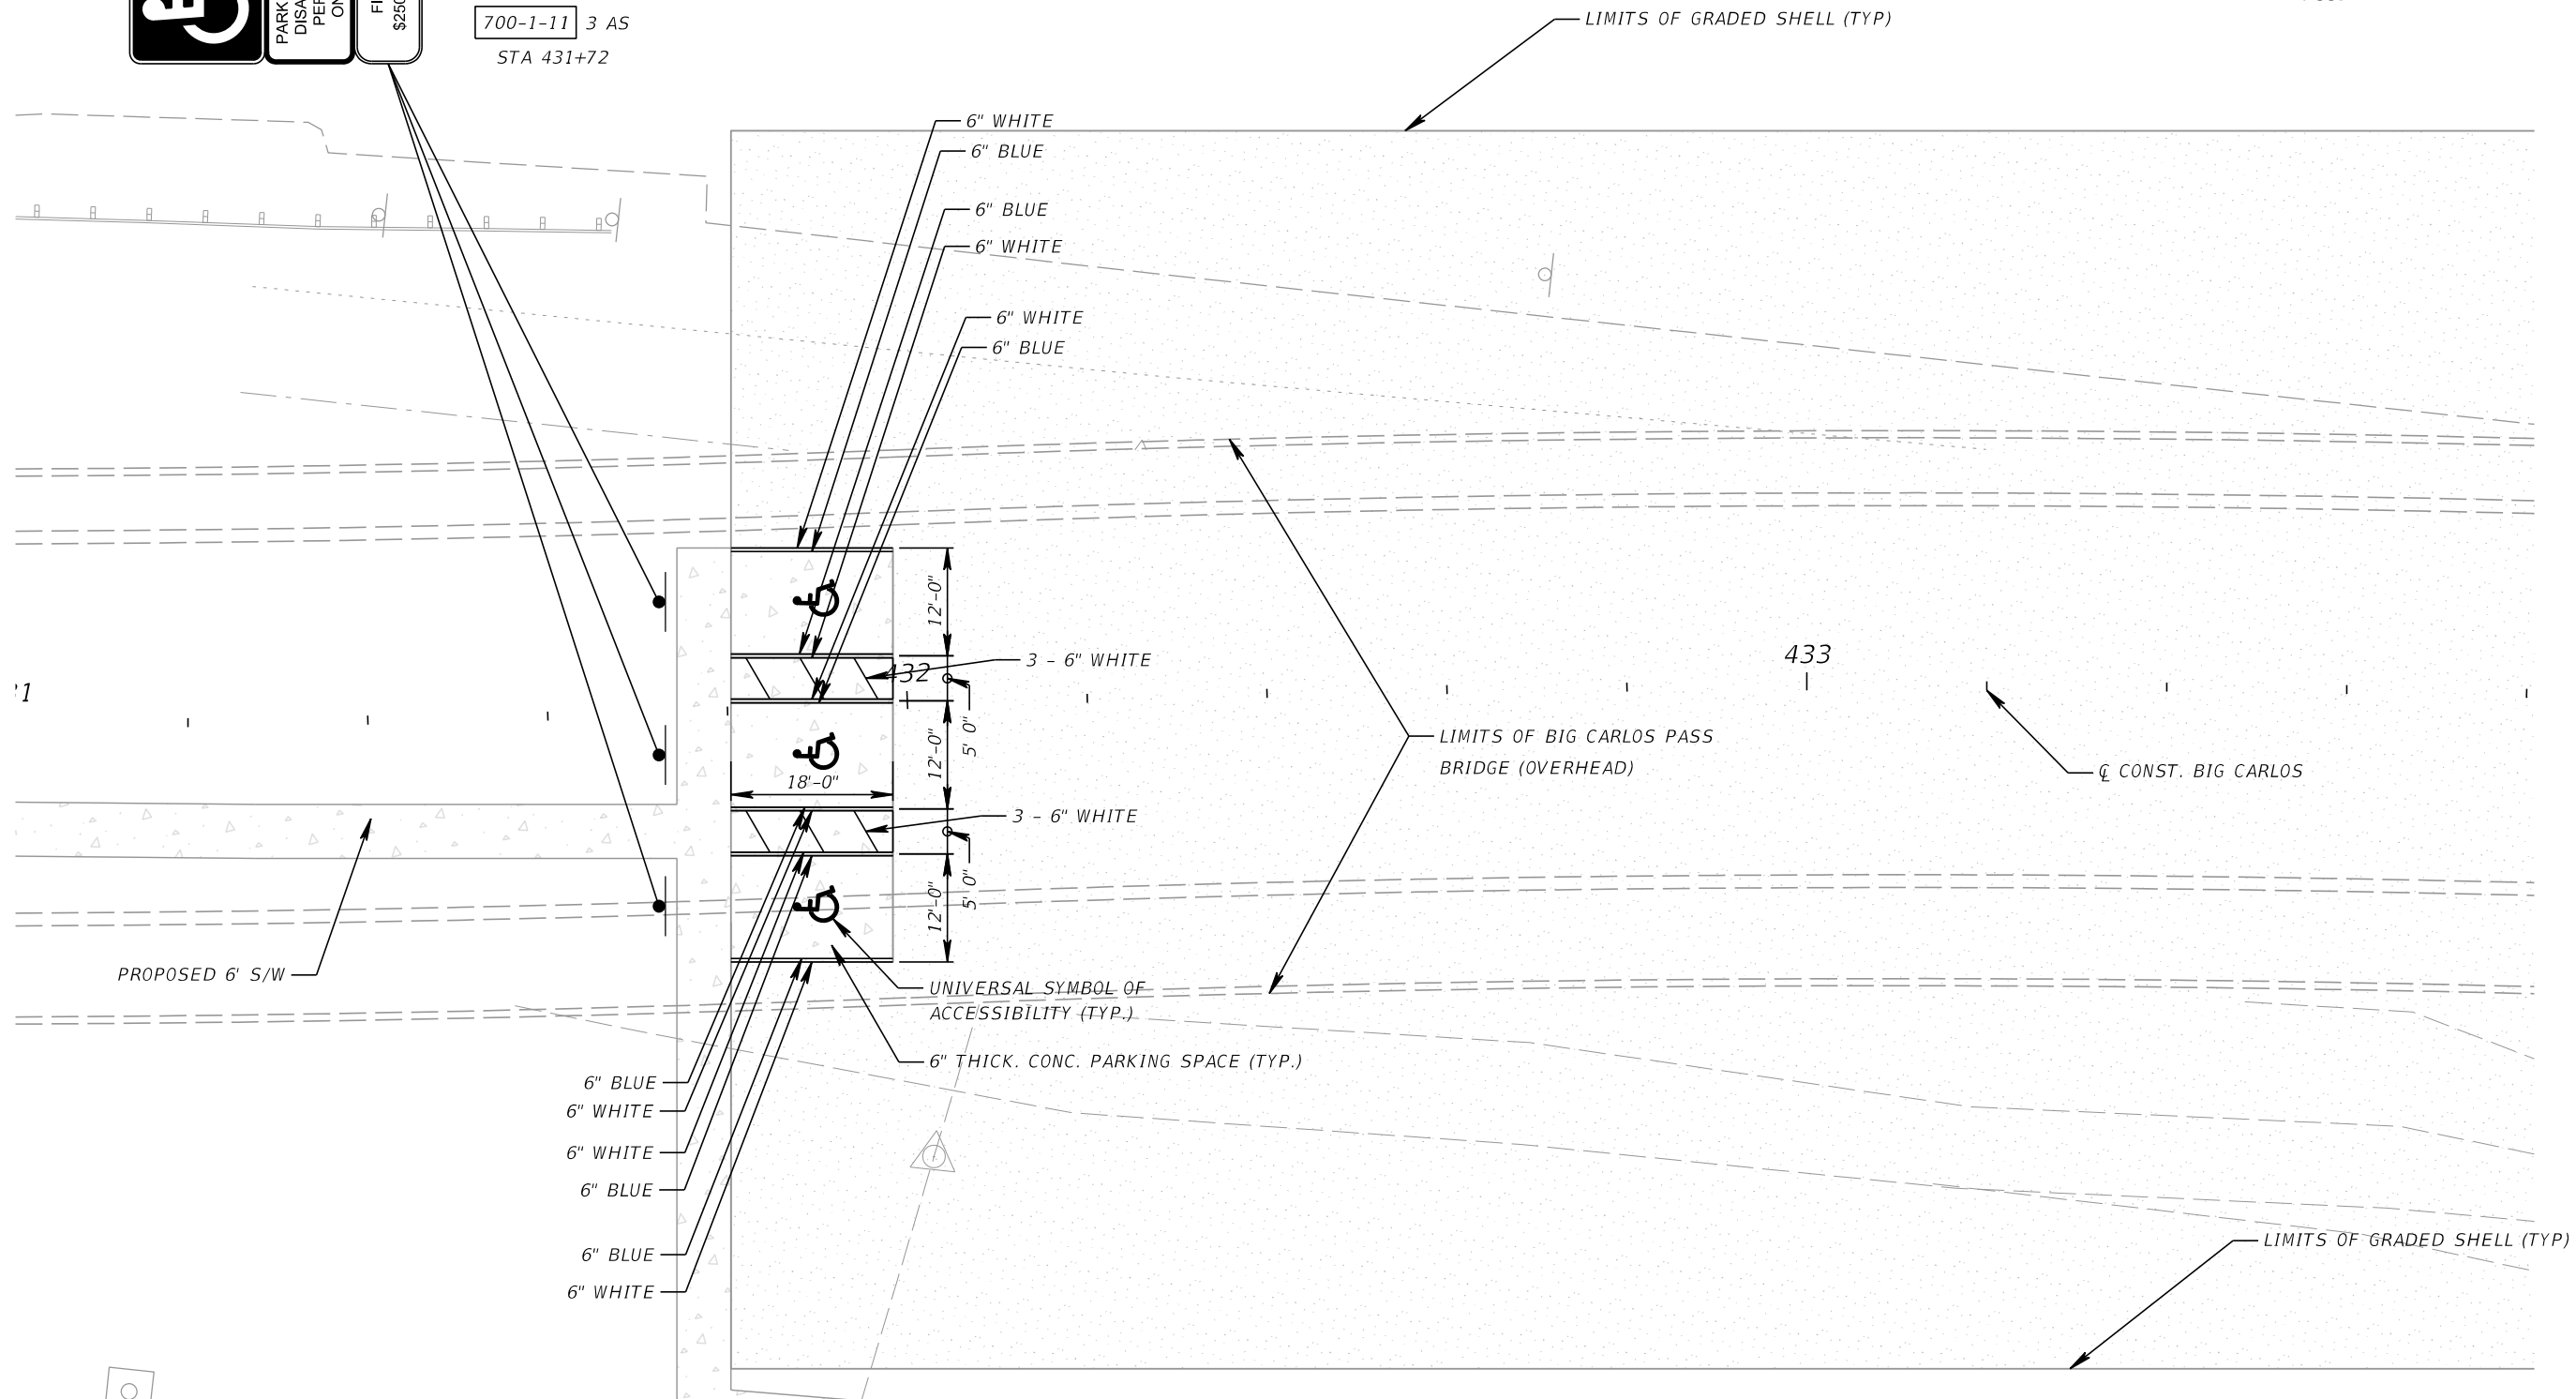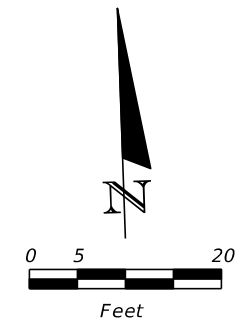

REVISIONS			
DATE	DESCRIPTION	DATE	DESCRIPTION


KCA
KISINGER CAMPO & ASSOCIATES
201 N. Franklin Street, Suite 400
Tampa, Florida 33602
Engineer of Record: M. Fathy Abdalla, P.E.
P.E. No.: 63914

LEE COUNTY DEPARTMENT OF TRANSPORTATION		
ROAD NO.	COUNTY	PROJECT NO.
CR 865	LEE	CN160002

**SIGNING & PAVEMENT
MARKING PLAN (9)**

SHEET NO.
S-13

THE OFFICIAL RECORD OF THIS SHEET IS THE ELECTRONIC FILE DIGITALLY SIGNED AND SEALED UNDER RULE 61G15-23.004, F.A.C.

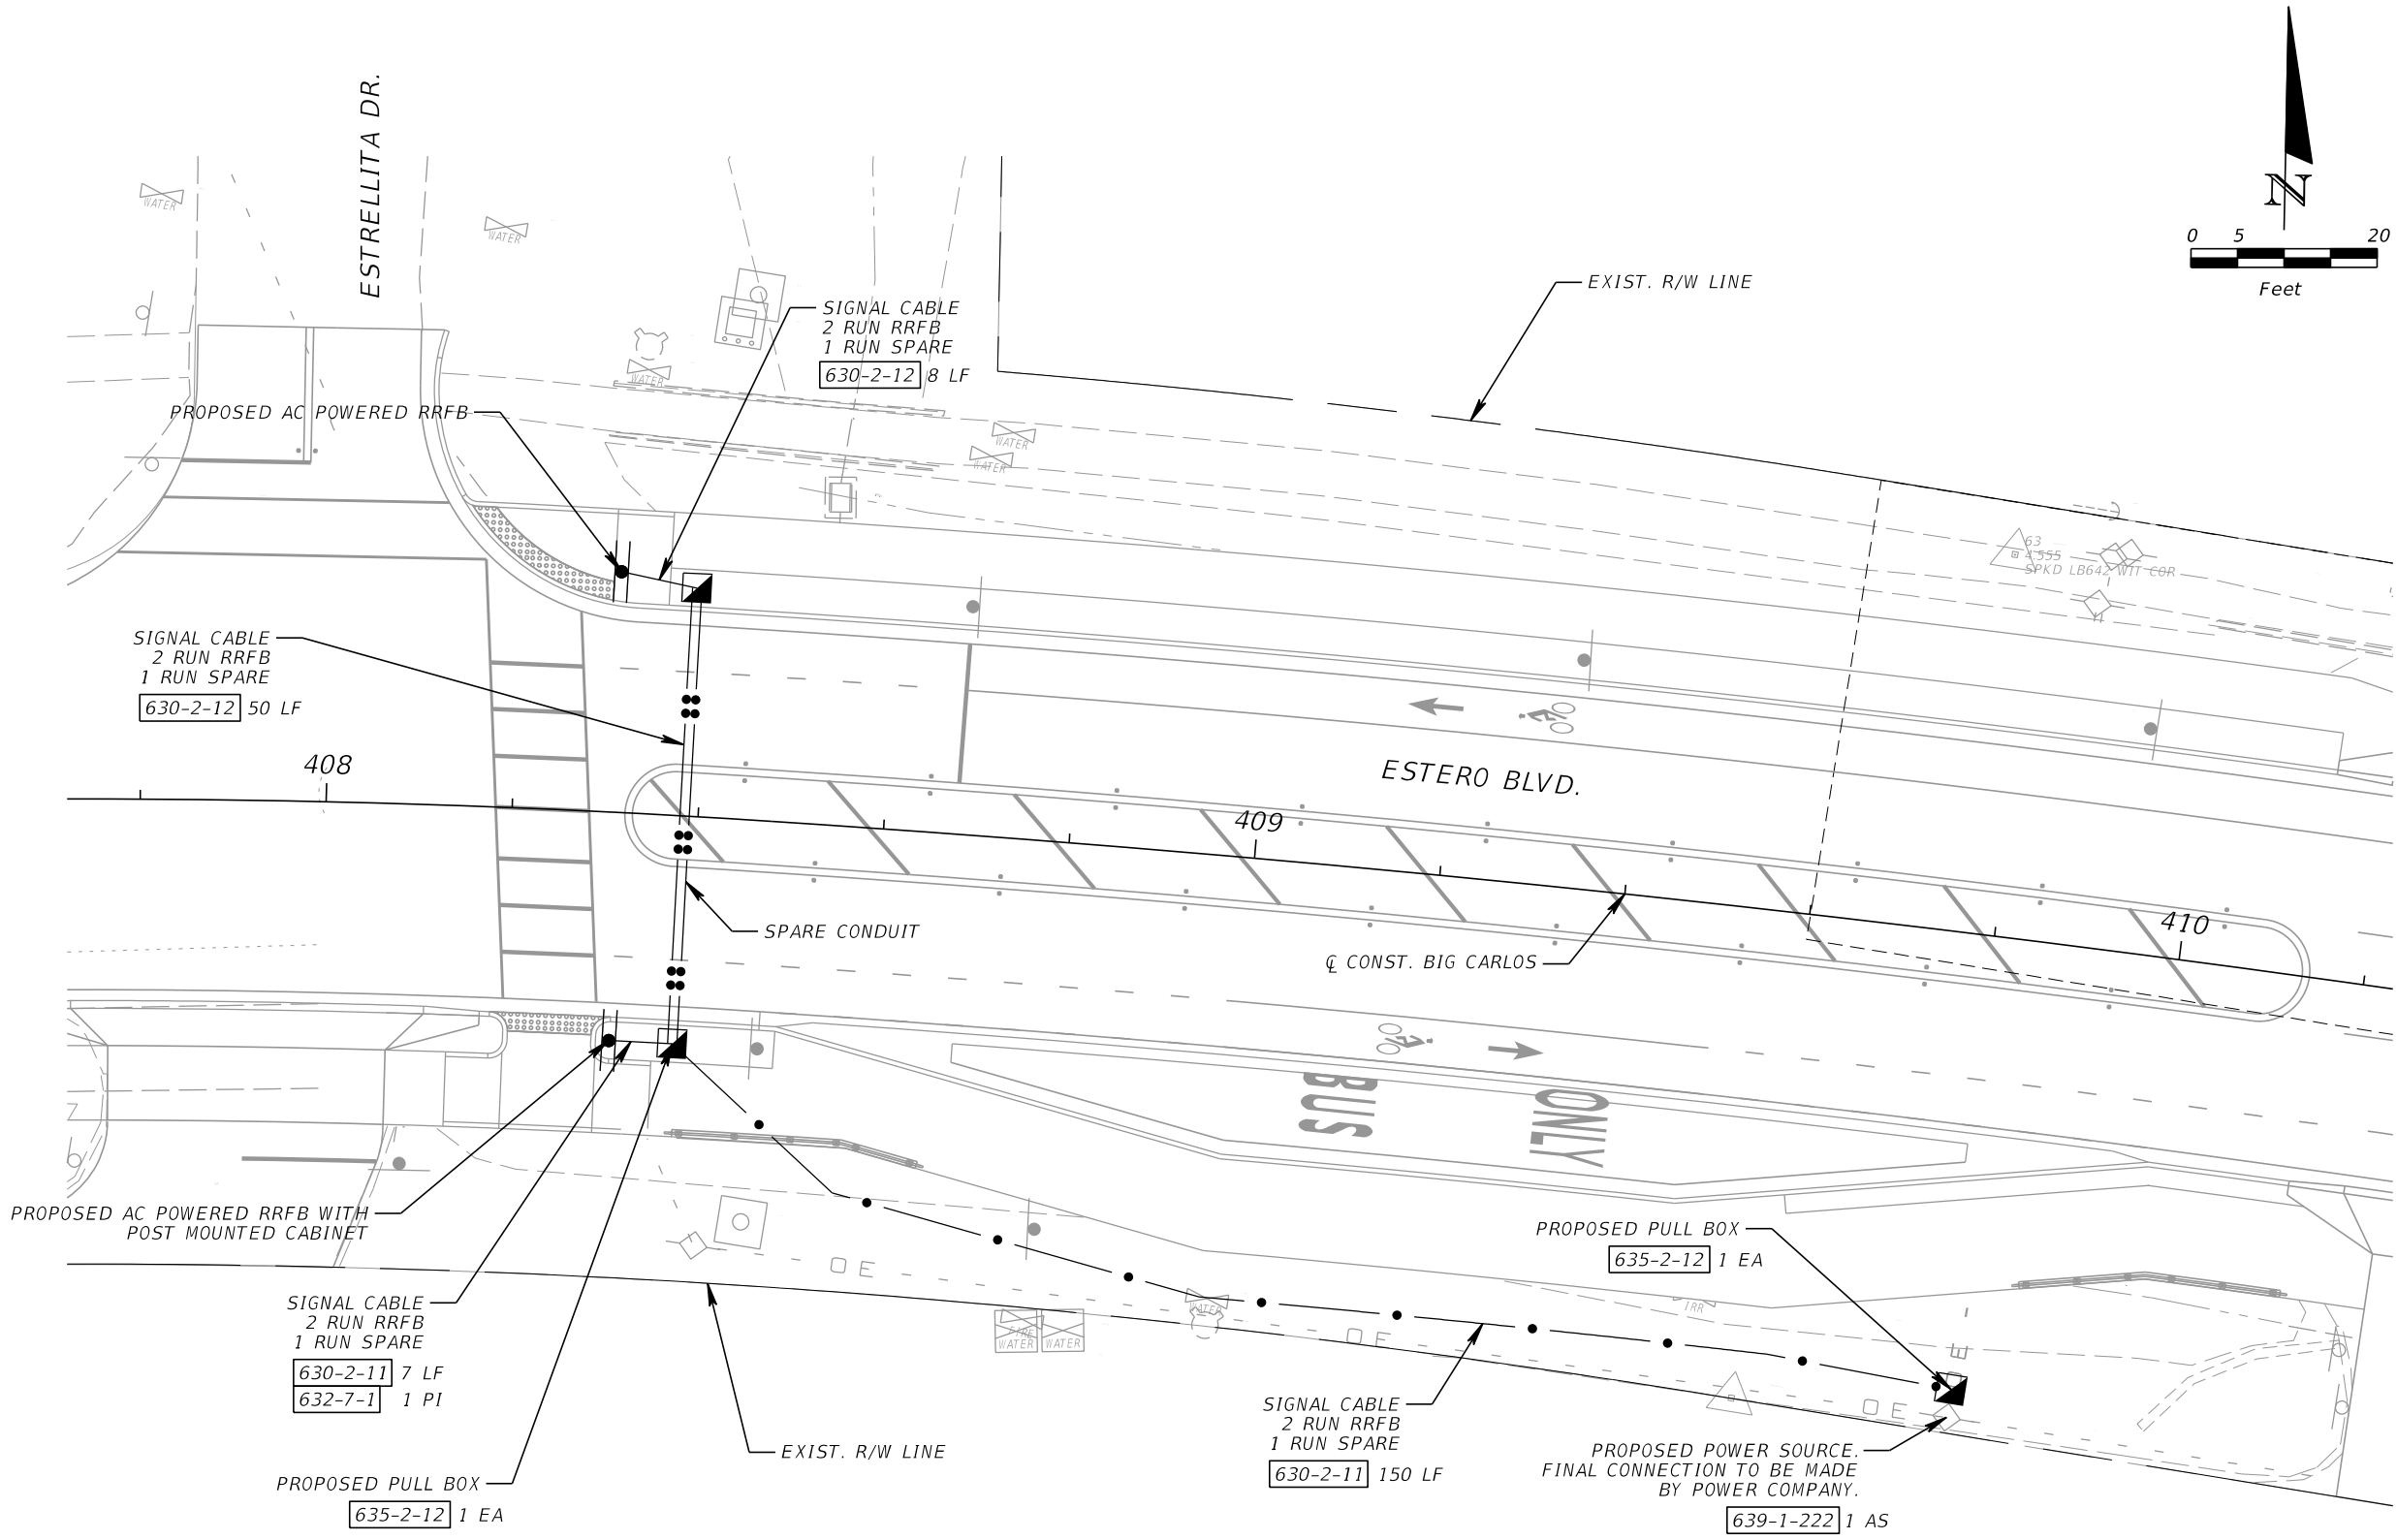

THE OFFICIAL RECORD OF THIS SHEET IS THE ELECTRONIC FILE DIGITALLY SIGNED AND SEALED UNDER RULE 61G15-23.004, F.A.C.

REVISIONS				KCA 201 N. Franklin Street, Suite 400 Tampa, Florida 33602 Engineer of Record: M. Fathy Abdalla, P.E. P.E. No.: 63914	LEE COUNTY DEPARTMENT OF TRANSPORTATION			RRFB ELECTRICAL DETAIL	SHEET NO.
DATE	DESCRIPTION	DATE	DESCRIPTION		ROAD NO.	COUNTY	PROJECT NO.		S-14
					CR 865	LEE	CN160002		

