

LEE COUNTY
DEPARTMENT OF TRANSPORTATION

INDEX OF PLANS

SHEET NO.	SHEET DESCRIPTION
01	KEY SHEET
02	SIGNATURE SHEET
03 - 05	TYPICAL SECTION
06	DRAINAGE MAP
07	PROJECT LAYOUT
08	PROJECT CONTROL SHEET
09	SUMMARY OF DRIVEWAYS
10	SUMMARY OF PAY ITEMS
11 - 12	SUMMARY OF DRAINAGE STRUCTURES
13	DRAINAGE DETAILS
13A	ADS NYLOPLAST DRAINAGE STRUCTURE DETAILS
14	GENERAL NOTES
15 - 22	SIDEWALK PLAN AND PROFILE
23 - 23A	INTERSECTION DETAIL
23B	CURB RETURN PROFILES
23C	SIDEWALK DETAIL
24 - 37A	DRAINAGE STRUCTURES
38 - 63B	CROSS SECTIONS
64 - 68A	SIGNING AND PAVEMENT MARKING PLAN
68B	TEMPORARY TRAFFIC CONTROL NOTES
68C	LEE COUNTY UTILITIES NOTES
69 - 76	UTILITY PLAN AND PROFILE
77 - 79	UTILITY CROSSING DETAILS
80 - 81	WATERMAIN DETAILS
82 - 83	SUE SHEET
84 - 89	LCU STANDARD DETAILS
90 - 93	UTILITY ADJUSTMENTS
94 - 98	EROSION CONTROL PLAN
99	EROSION CONTROL PLAN STATE ROAD 80





BY:

PLAN SET

CW3 PROJECT NUMBER 20-0016A
LEE COUNTY PROJECT NUMBER CN200224JJB

ORANGE RIVER BLVD. SIDEWALK
AND WATERMAIN REPLACEMENT

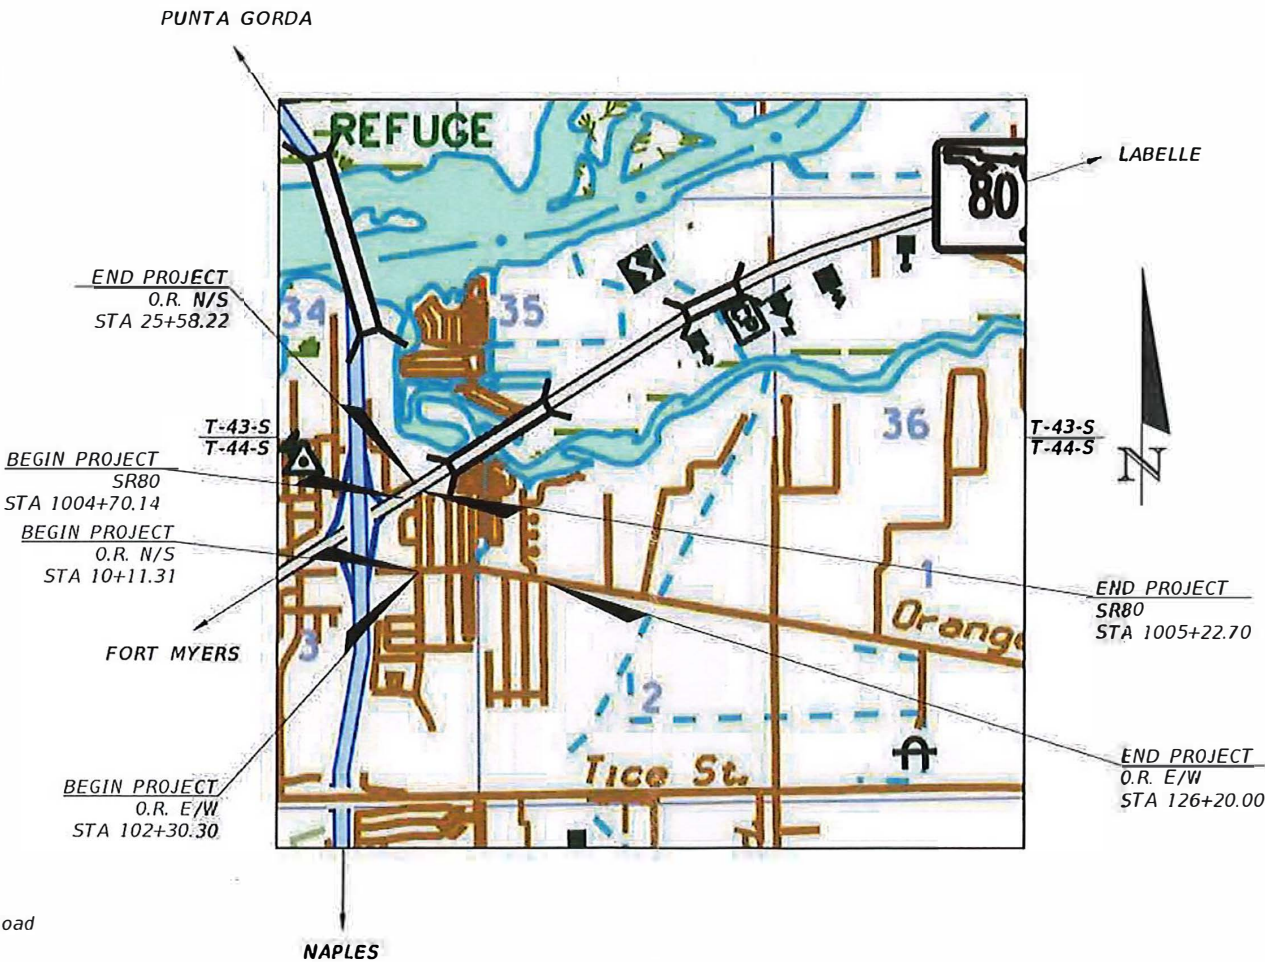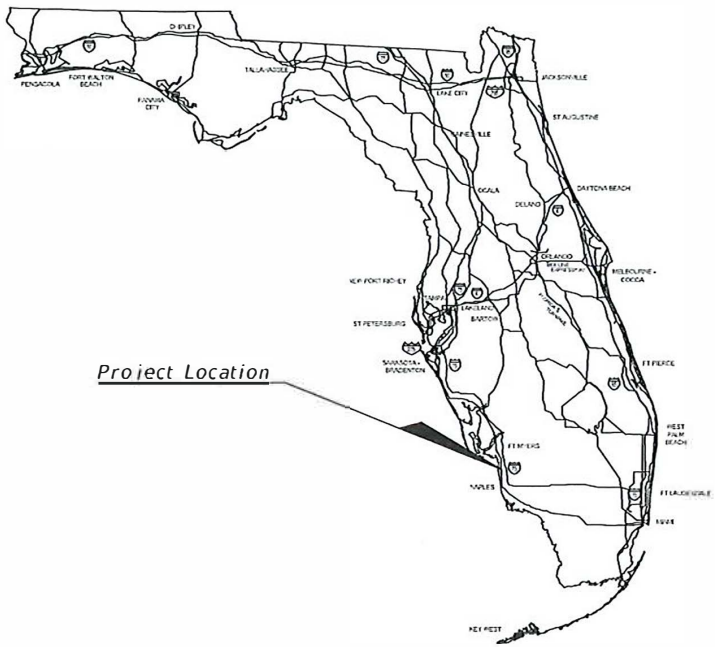

THIS DOCUMENT HAS BEEN DIGITALLY
SIGNED AND SEALED BY:

PRINTED COPIES OF THIS DOCUMENT
ARE NOT CONSIDERED SIGNED AND
SEALED. THE SIGNATURE MUST BE
VERIFIED ON THE ELECTRONIC
DOCUMENTS.

ROADWAY PLANS
ENGINEER OF RECORD:

CLAIR WRIGHT, III, P.E.
P.E. No.: 64089
CW3 ENGINEERING, INC.
5783 BAYSHORE RD., SUITE 113
NORTH FT. MYERS, FL 33917



LEE COUNTY PROJECT MANAGER:
DAVID M. MURPHY, P.E.

GOVERNING STANDARD PLANS:
Florida Department of Transportation, FY2023-24 Standard plans for Road
and Bridge Construction and applicable Interim Revisions (Irs).


Standard Plans for Road Construction and associated Irs are available at
the following website:

<http://www.fdot.gov/design/Standardplans>
APPLICABLE IRS:

Standard Plans for Bridge Construction are included in the Structures Plans
Component.

SHEET
NO.

01

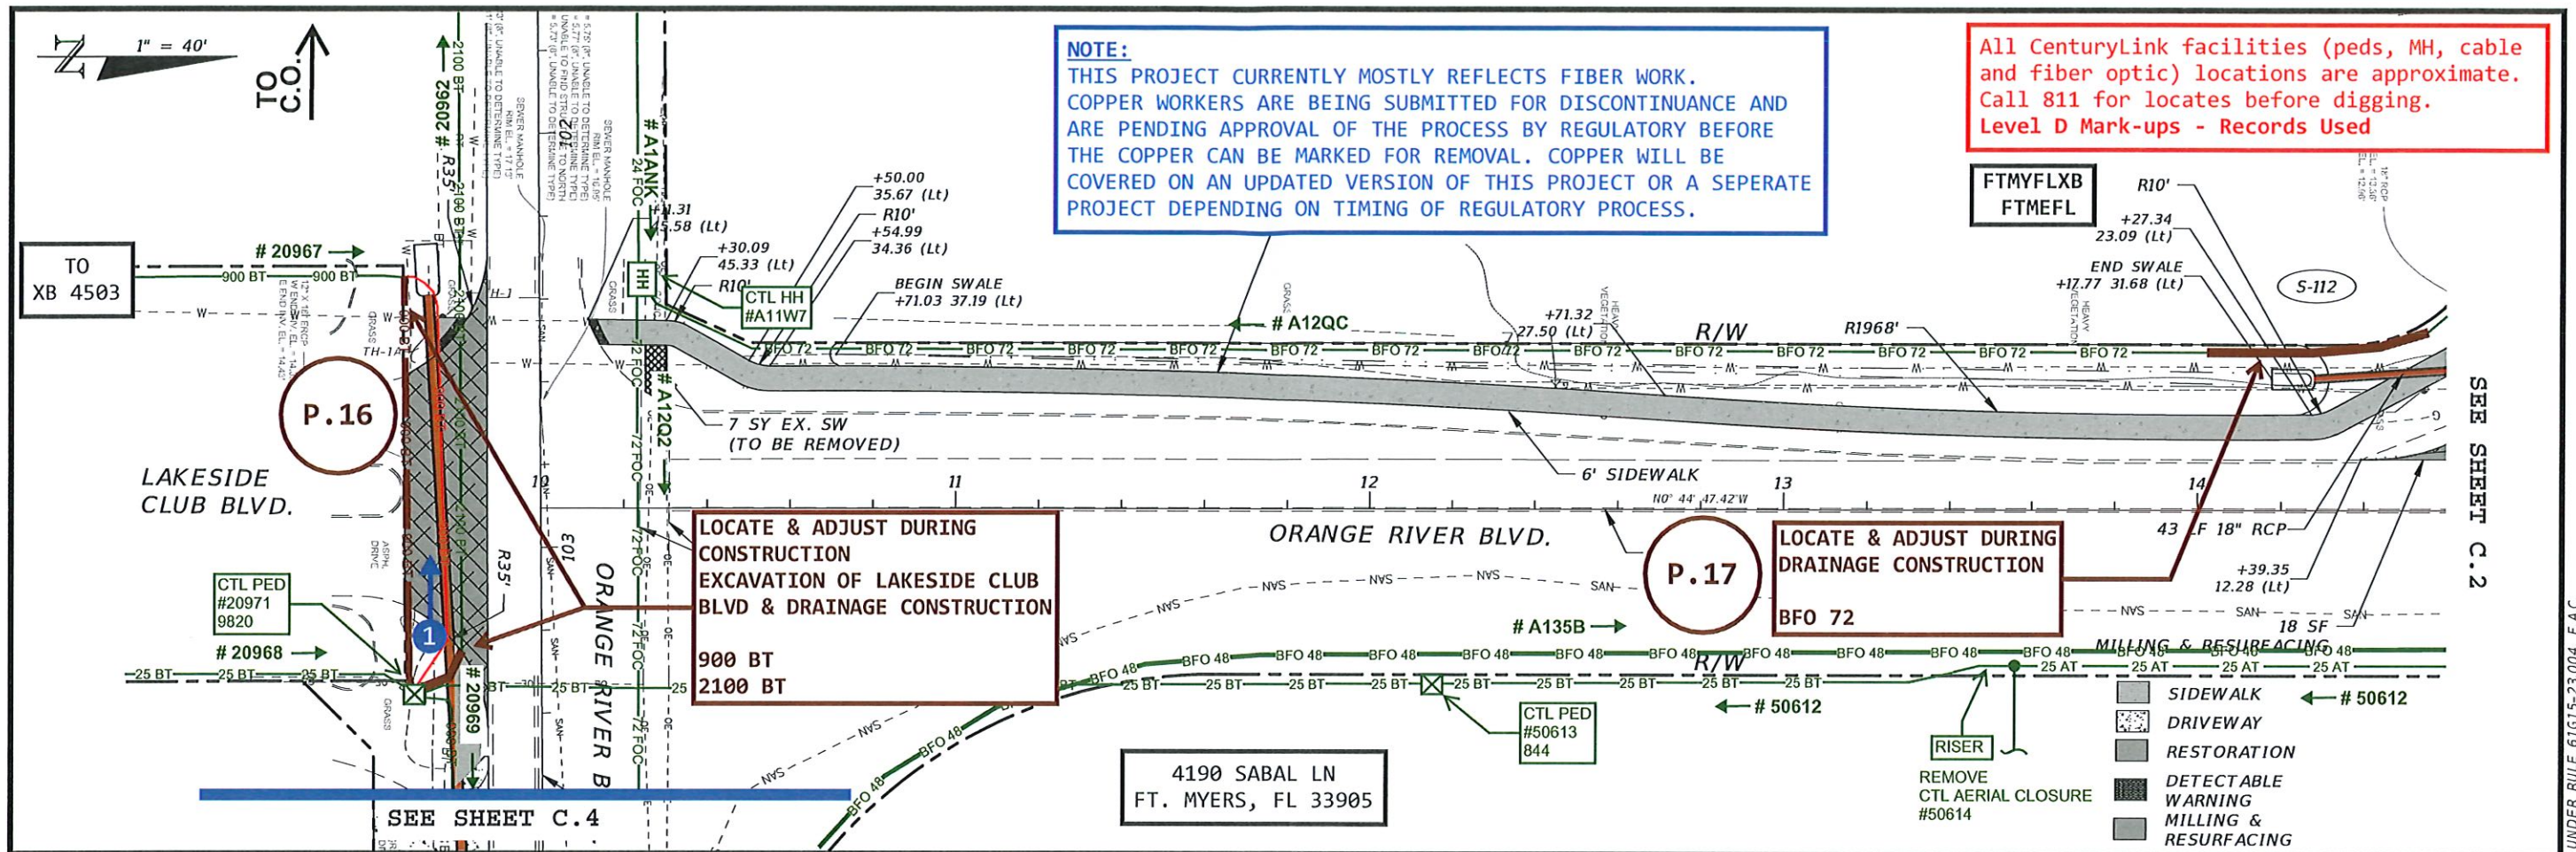

NOTE:
THIS PROJECT CURRENTLY MOSTLY REFLECTS FIBER WORK. COPPER WORKERS ARE BEING SUBMITTED FOR DISCONTINUANCE AND ARE PENDING APPROVAL OF THE PROCESS BY REGULATORY BEFORE THE COPPER CAN BE MARKED FOR REMOVAL. COPPER WILL BE COVERED ON AN UPDATED VERSION OF THIS PROJECT OR A SEPERATE PROJECT DEPENDING ON TIMING OF REGULATORY PROCESS.

All CenturyLink facilities (peds, MH, cable and fiber optic) locations are approximate. Call 811 for locates before digging. Level D Mark-ups - Records Used

LOCATE & ADJUST DURING CONSTRUCTION EXCAVATION OF LAKESIDE CLUB BLVD & DRAINAGE CONSTRUCTION

LOCATE & ADJUST DURING DRAINAGE CONSTRUCTION

4190 SABAL LN
FT. MYERS, FL 33905



PICTURES TAKEN ON 11/5/2024
SYMBOL SHOWS APPROXIMATE LOCATION, DIRECTION, & NUMBER OF PICTURE

P.16
DURING ROAD CONSTRUCTION ON LAKESIDE CLUB BLVD FOR NEW DRAINAGE, ADJUST 900 BT TO REAR OF ROW TO PRESERVE CABLE.

LOCATE & PROTECT/ADJUST 2100 BT DURING THE SAME CONSTRUCTION EFFORT.


COPPER CABLE TO EAST OF OF PED #20971 HAS BEEN SUBMITTED FOR DISCONTINUANCE.

THE 900 BT ON LAKESIDE CLUB BLVD FEEDS XB 4503 AND INCLUDES POTS, HSI, AND SPC CKT.

LAKESIDE CLUB BLVD IS A PRIVATE ROADWAY WITHOUT AN EXISTING EASEMENT ON RECORD AND SO WE CANNOT PLACE NEW FACILITIES WITHIN ITS BOUNDS.

INSTEAD WE MUST ADJUST THE EXISTING CABLE AS POSSIBLE AND WILL NEED TO COORDINATE WITH THE ROAD CONSTRUCTION EFFORTS WHEN THEY REMOVE A PORTION OF PAVEMENT FOR THEIR DRAINAGE WORK WE CAN THEN MOVE OUR CABLES.

SOME LOCATE & ADJUST MAY BE REQUIRED IF THEIR EXCAVATION DOES NOT EXPOSE ALL AREAS OF THE CABLE THAT REQUIRE ADJUSTMENT.

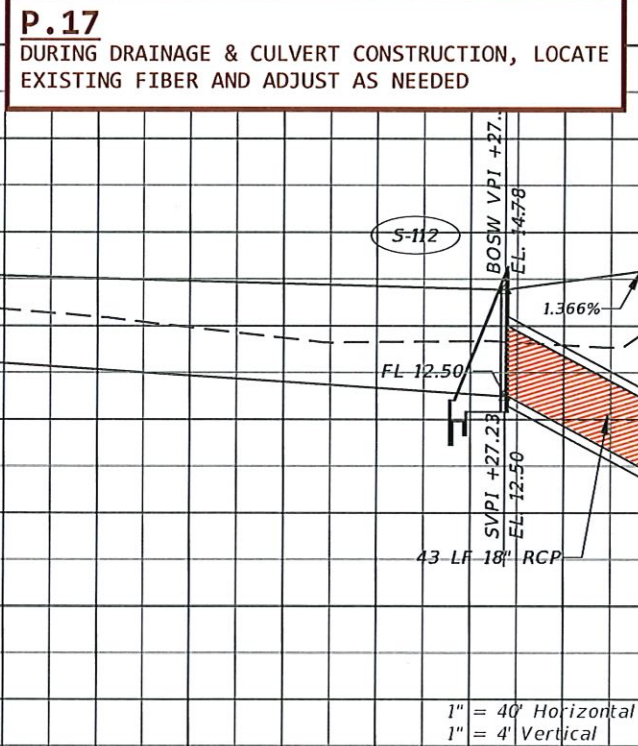

TT ENG: Vivian Mckeen
PHONE: 630-217-9384
vmckeen@congruex.com
TT#: TERR- 1008951
http://www.terratechllc.net

0' 40'
SCALE: 1" = 40'

LEE COUNTY PROJECT NUMBER CN200224JJB
LUMEN PROJECT #P.043315
ORANGE RIVER BLVD SIDEWALK AND WATERMAIN REPLACEMENT - LEE COUNTY
CENTURYLINK-LUMEN CONSTRUCTION PLANS
UTILITY PLAN

ENG: KEN STINNETT
PHONE: 239-920-5935
EMAIL: Kenneth.Stinnett@Lumen.com
PROJECT: P.043315


LEGEND

EXISTING	REMOVAL/ABANDON	PROPOSED
BURIED FIBER OPTIC	BFO	EFO
BURIED COPPER	BT	BT
UG CONDUIT SYSTEM	CONDUIT	CONDUIT


SEE SHEET B-1 FOR LEGENDS

C.1
SHT 4 OF 14

THE OFFICIAL RECORD OF THIS SHEET IS THE ELECTRONIC FILE DIGITALLY SIGNED AND SEALED UNDER RULE 61G15-23.004, F.A.C.

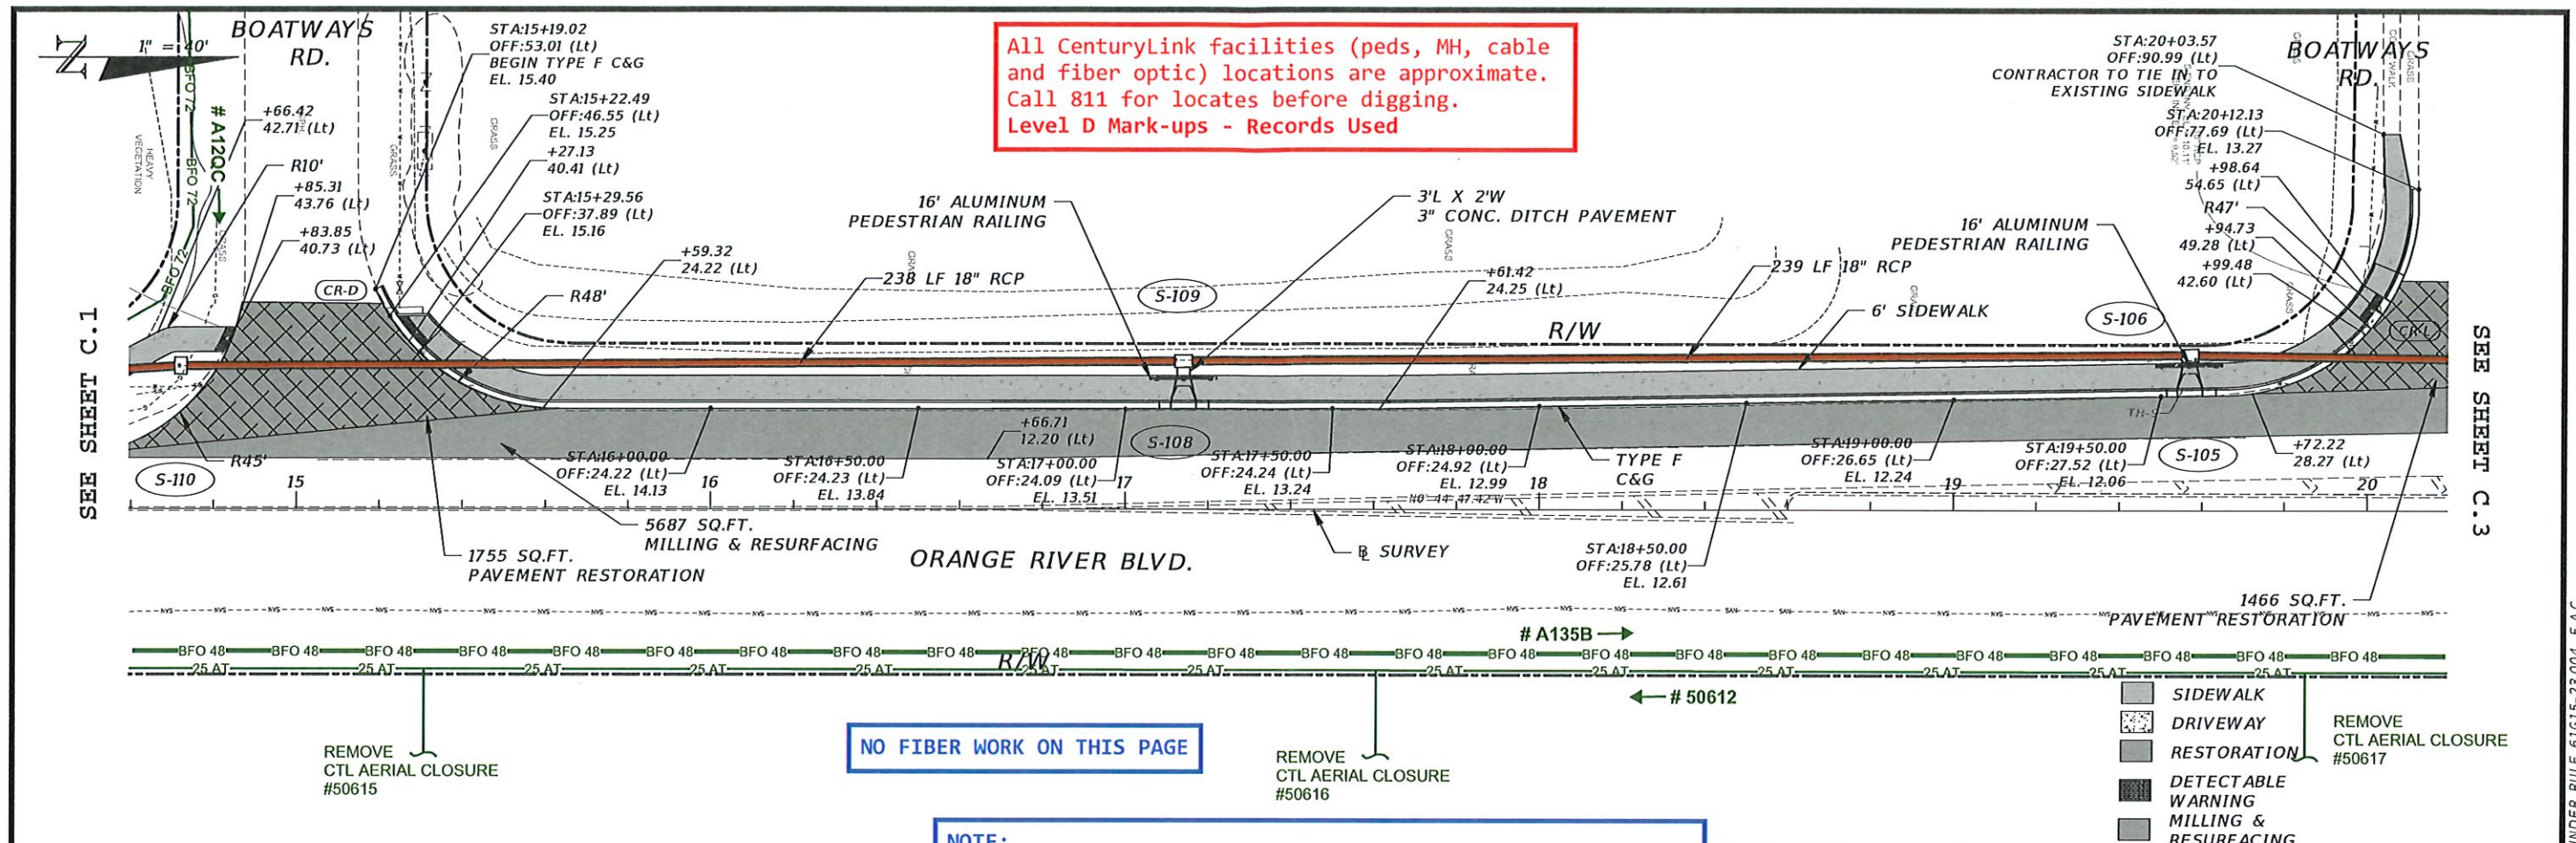

NOTE:
 THIS PROJECT CURRENTLY MOSTLY REFLECTS FIBER WORK. COPPER WORKERS ARE BEING SUBMITTED FOR DISCONTINUANCE AND ARE PENDING APPROVAL OF THE PROCESS BY REGULATORY BEFORE THE COPPER CAN BE MARKED FOR REMOVAL. COPPER WILL BE COVERED ON AN UPDATED VERSION OF THIS PROJECT OR A SEPERATE PROJECT DEPENDING ON TIMING OF REGULATORY PROCESS.

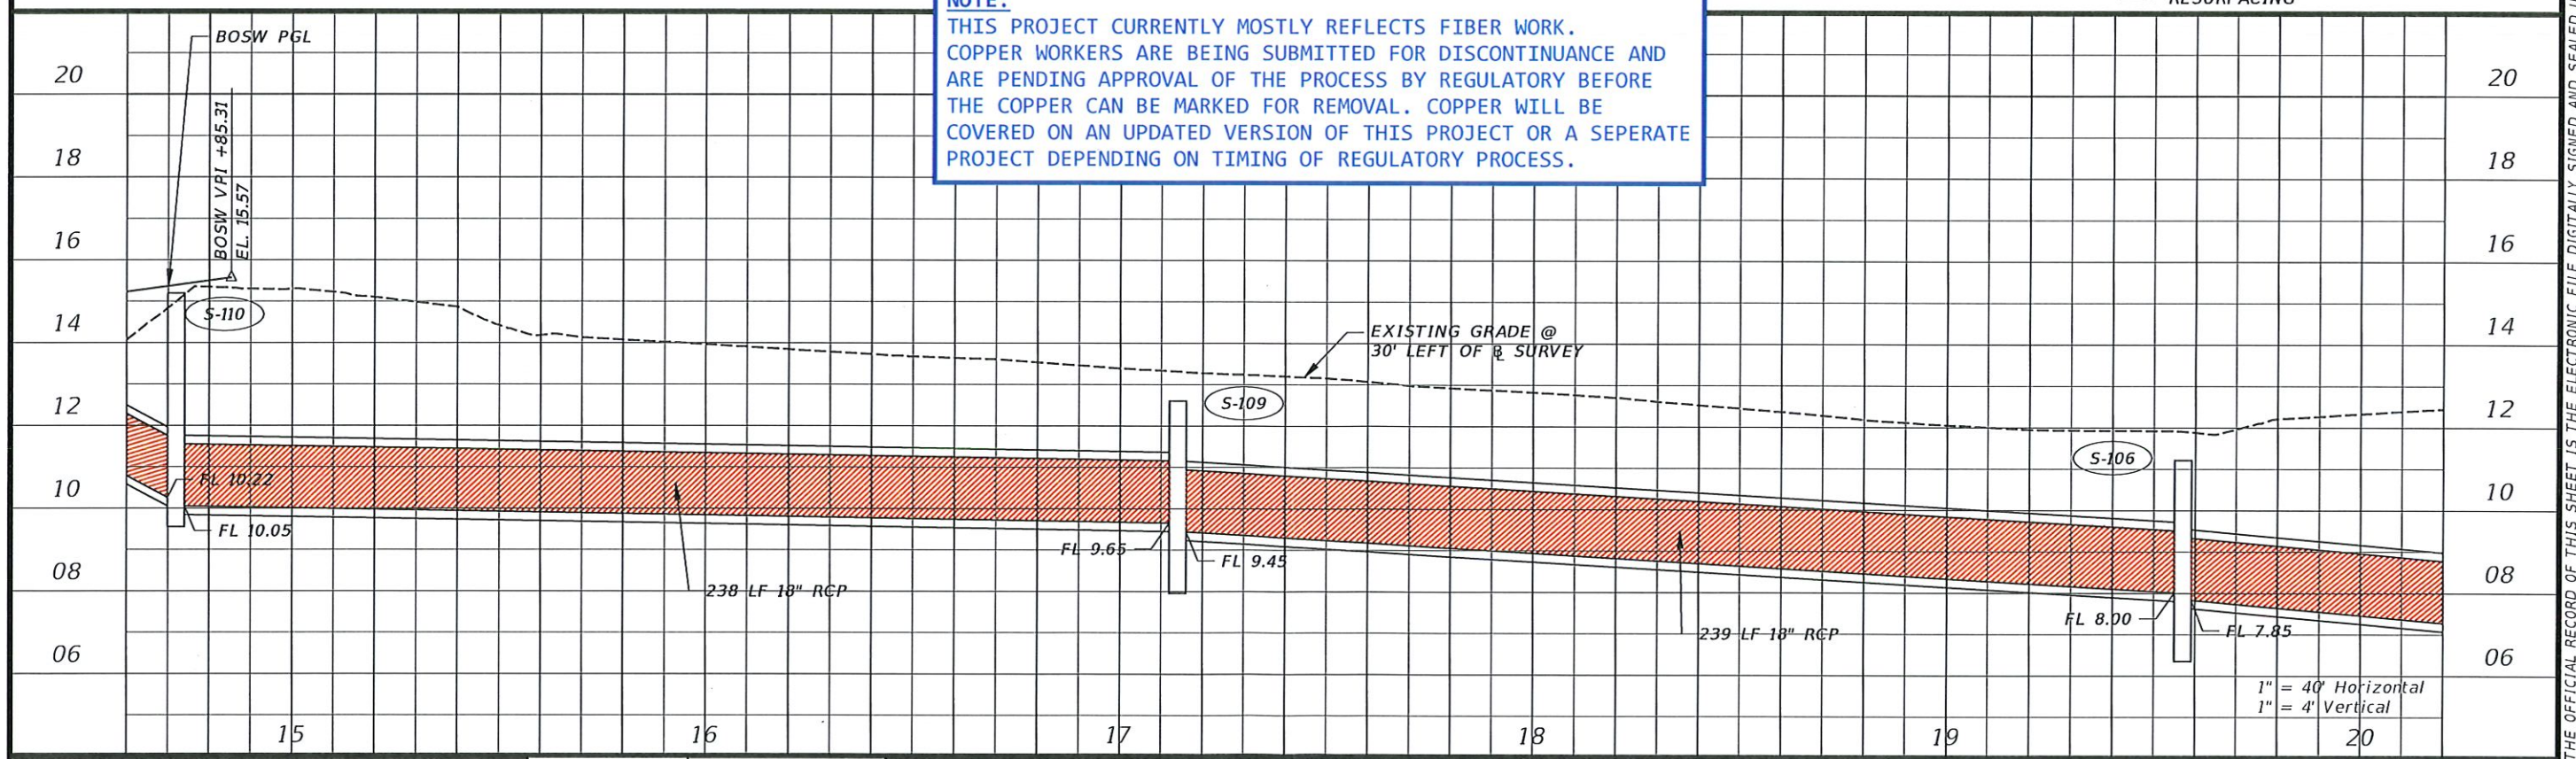

TT ENG: Vivian Mckeen
 PHONE: 630-217-9384
 vmckeen@congruex.com
 TT#: TERR- 1008951
 http://www.terratechllc.net

0' 40'

SCALE: 1" = 40'

LEE COUNTY PROJECT NUMBER CN200224JJB
 LUMEN PROJECT #P.043315
 ORANGE RIVER BLVD SIDEWALK AND WATERMAIN REPLACEMENT - LEE COUNTY

CENTURYLINK-LUMEN CONSTRUCTION PLANS

UTILITY PLAN

LUMEN CenturyLink

ENG: KEN STINNETT
 PHONE: 239-920-5935
 EMAIL: Kenneth.Stinnett@Lumen.com
 PROJECT: P.043315

LEGEND


	EXISTING	REMOVAL/ABANDON	PROPOSED
BURIED FIBER OPTIC	EFO	EFO	EFO
BURIED COPPER	BT	BT	BT
UG CONDUIT SYSTEM	CONDUIT	CONDUIT	CONDUIT

SEE SHEET B-1 FOR LEGENDS

C.2

SHT 5 OF 14


THE OFFICIAL RECORD OF THIS SHEET IS THE ELECTRONIC FILE DIGITALLY SIGNED AND SEALED UNDER RULE 61G15-23.004, F.A.C.

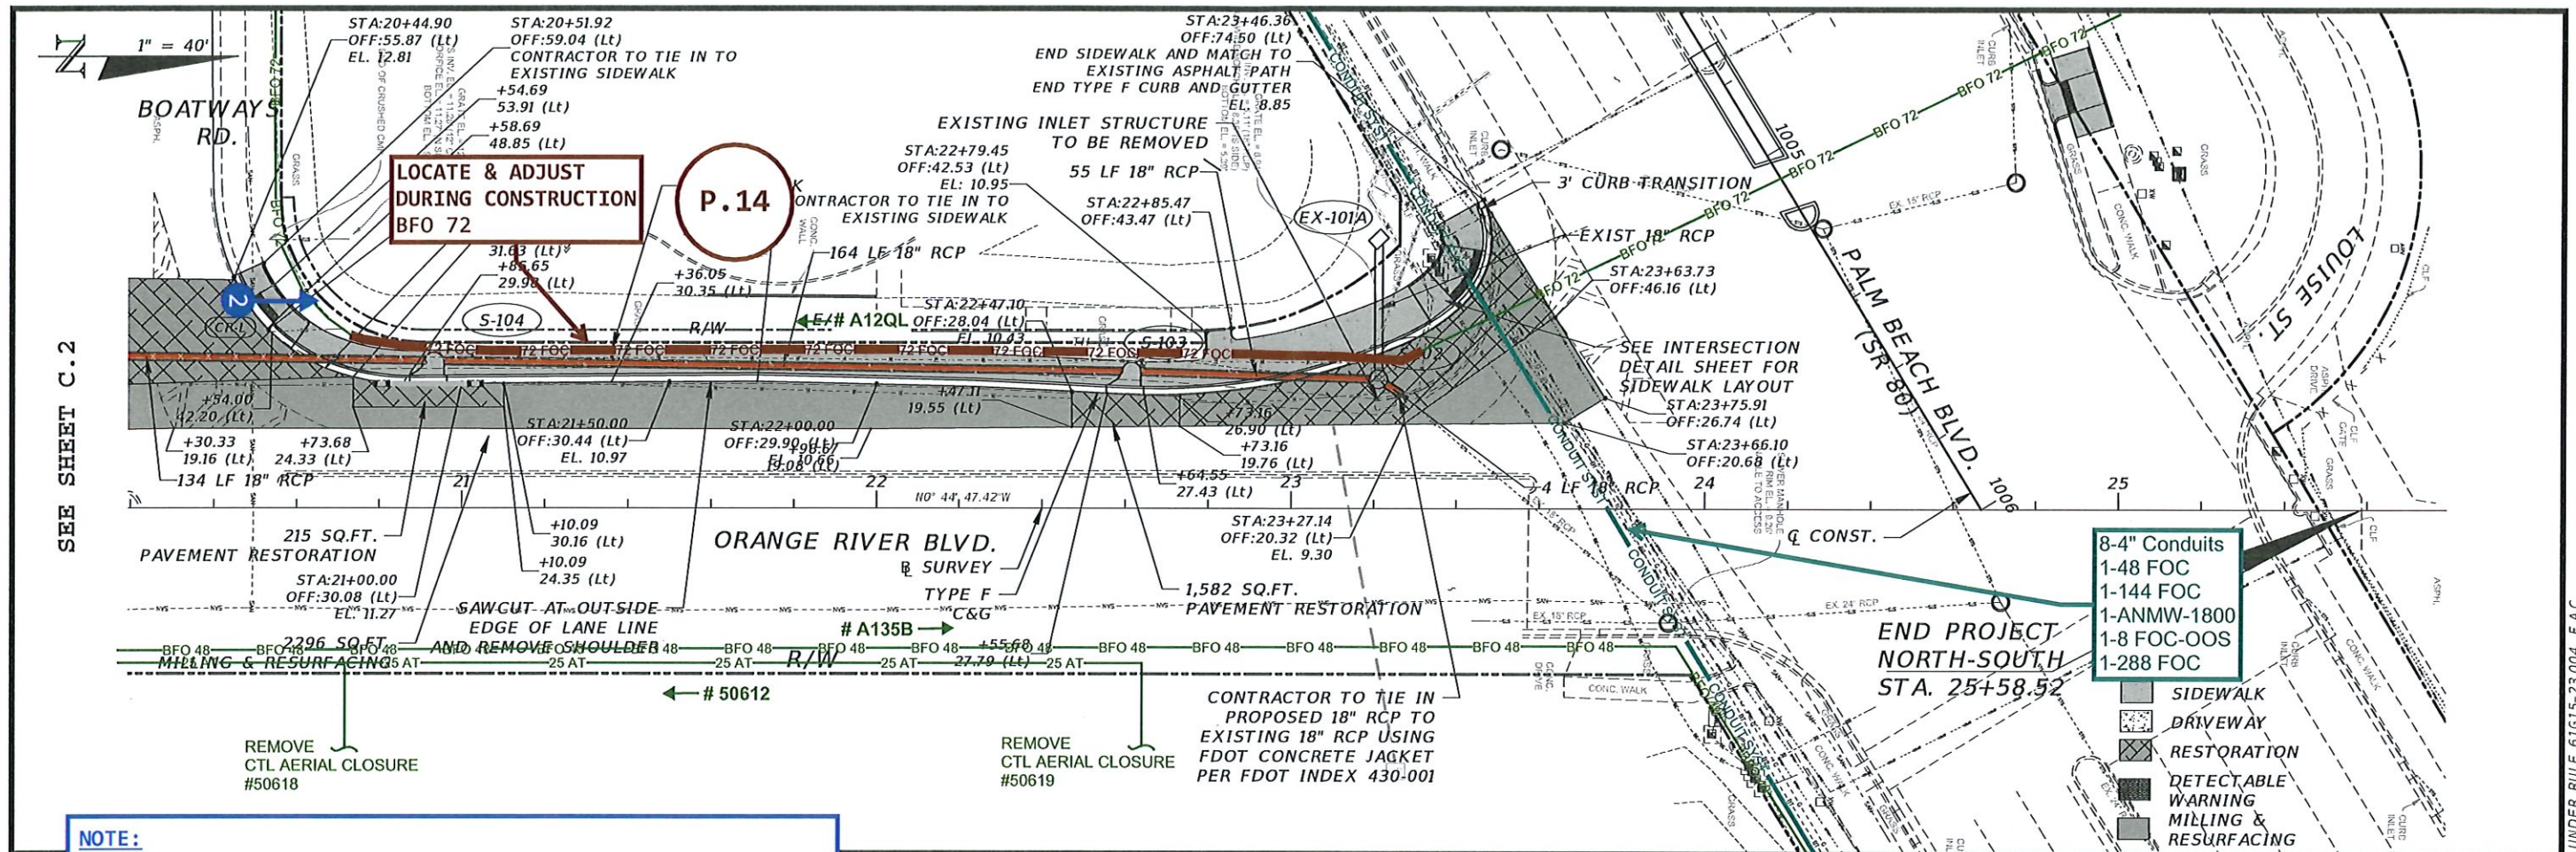


NOTE:
 THIS PROJECT CURRENTLY MOSTLY REFLECTS FIBER WORK. COPPER WORKERS ARE BEING SUBMITTED FOR DISCONTINUANCE AND ARE PENDING APPROVAL OF THE PROCESS BY REGULATORY BEFORE THE COPPER CAN BE MARKED FOR REMOVAL. COPPER WILL BE COVERED ON AN UPDATED VERSION OF THIS PROJECT OR A SEPERATE PROJECT DEPENDING ON TIMING OF REGULATORY PROCESS.

P.14
 LOCATE & ADJUST DURING CONSTRUCTION
 BFO 72

All CenturyLink facilities (peds, MH, cable and fiber optic) locations are approximate. Call 811 for locates before digging. Level D Mark-ups - Records Used

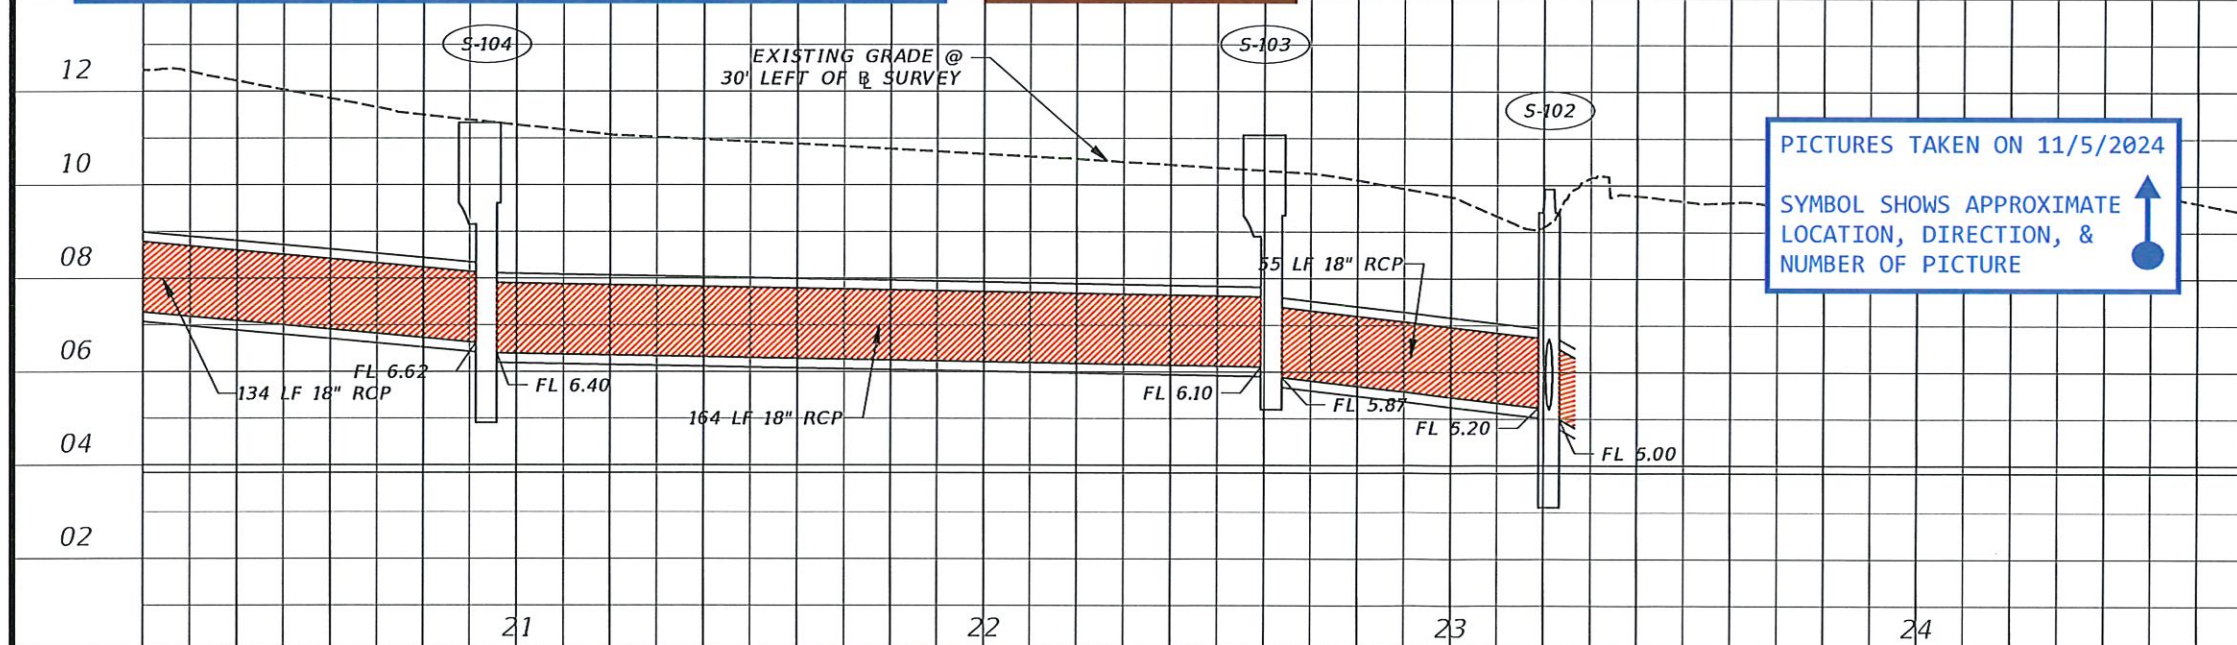

THE OFFICIAL RECORD OF THIS SHEET IS THE ELECTRONIC FILE DIGITALLY SIGNED AND SEALED UNDER RULE 61G15-23.004, F.A.C.

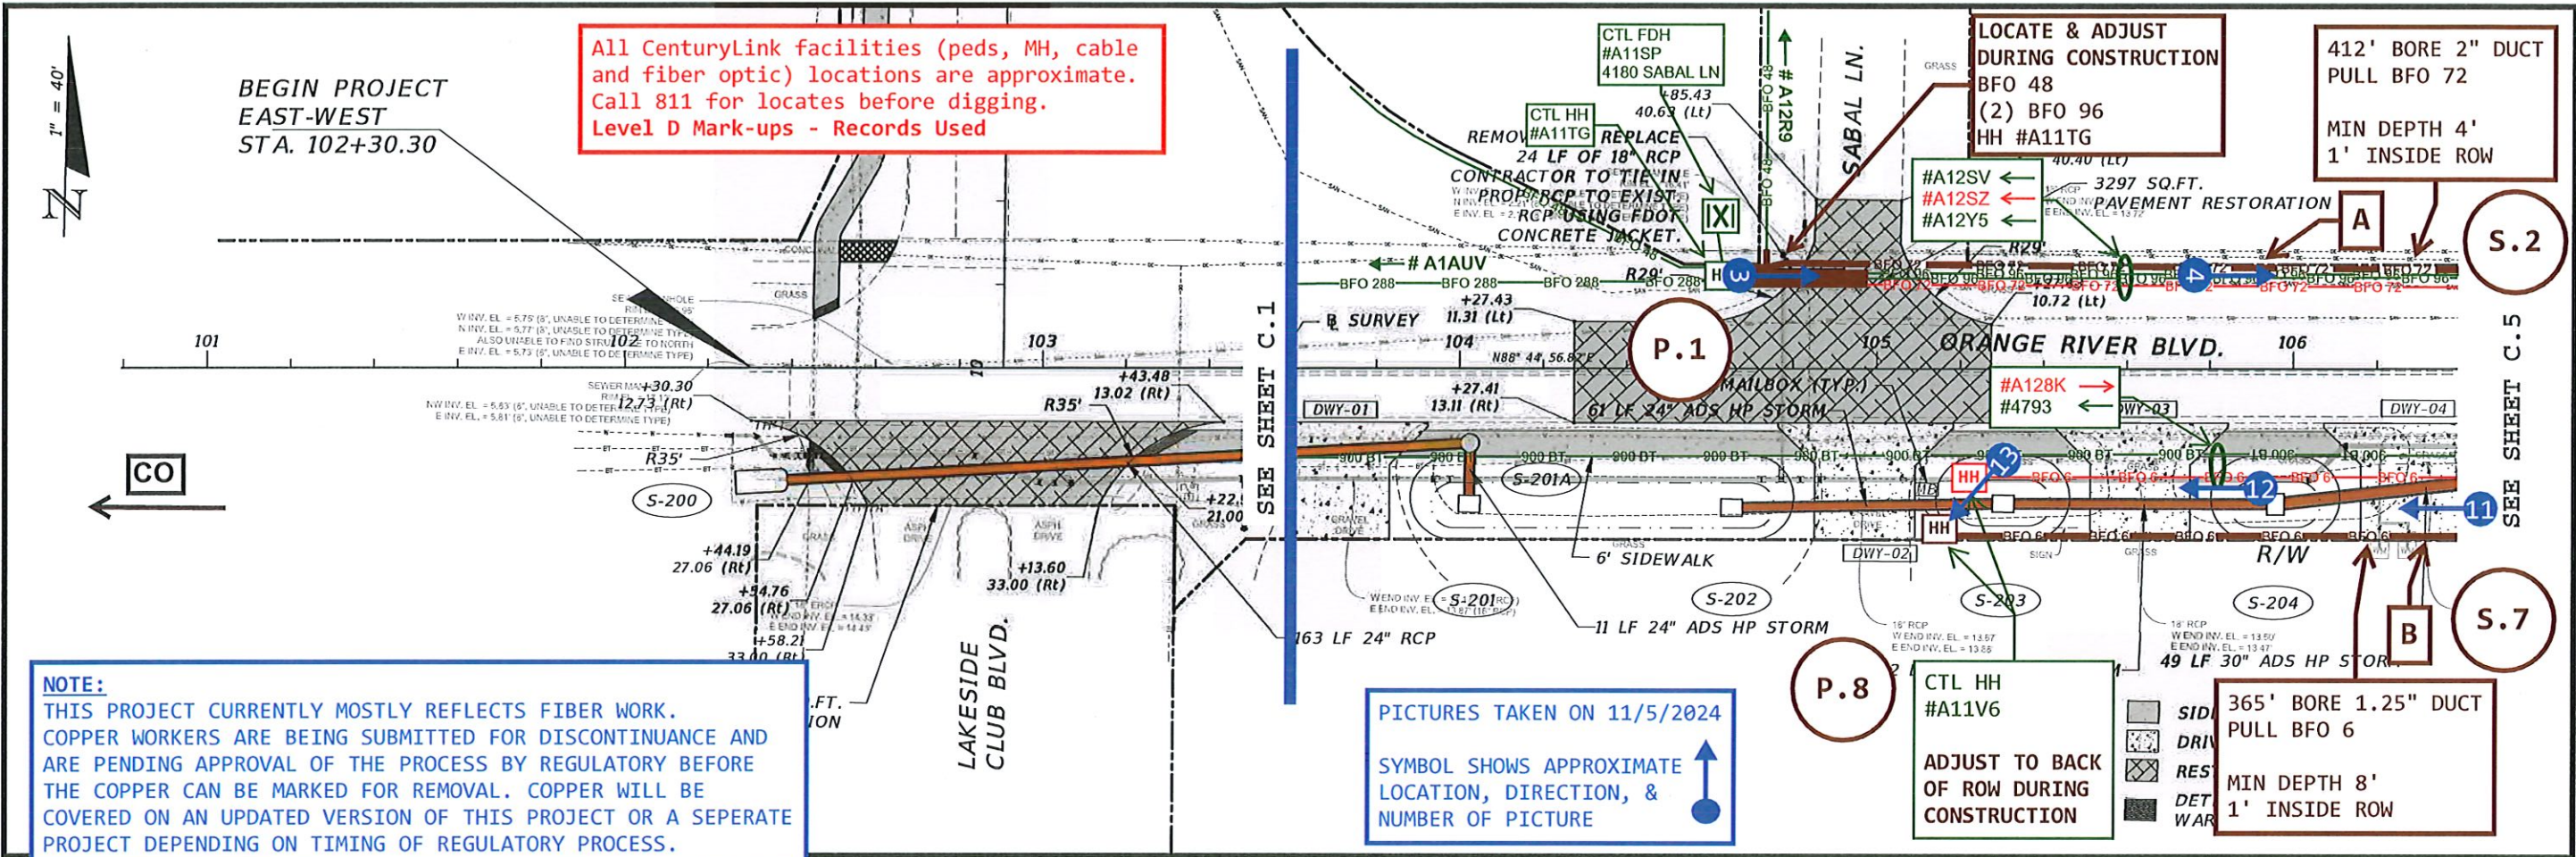

TERRA
A CONGRUUX COMPANY

TT ENG: Vivian Mckean
PHONE: 630-217-9384
vmckean@congruex.com
TT#: TERR- 1008951
http://www.terratechllc.net

LEE COUNTY PROJECT NUMBER CN200224JJB
LUMEN PROJECT #P.043315
ORANGE RIVER BLVD SIDEWALK AND WATERMAIN REPLACEMENT - LEE COUNTY

CENTURYLINK-LUMEN CONSTRUCTION PLANS

UTILITY PLAN

LUMEN CenturyLink

ENG: KEN STINNETT
PHONE: 239-920-5935
EMAIL: Kenneth.Stinnett@Lumen.com
PROJECT: P.043315

LEGEND

EXISTING

REMOVAL/ABANDON

PROPOSED

BURIED FIBER OPTIC

BURIED COPPER




UG CONDUIT SYSTEM

SEE SHEET B-1 FOR LEGENDS

P.043315

C.4

SHT 7 OF 14

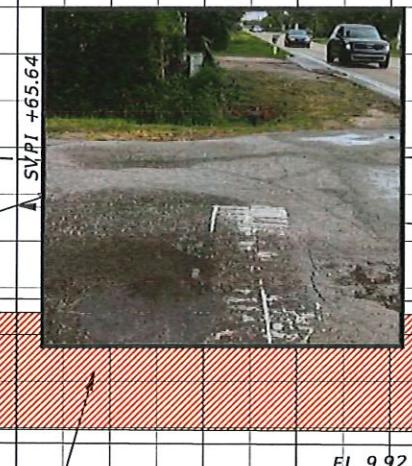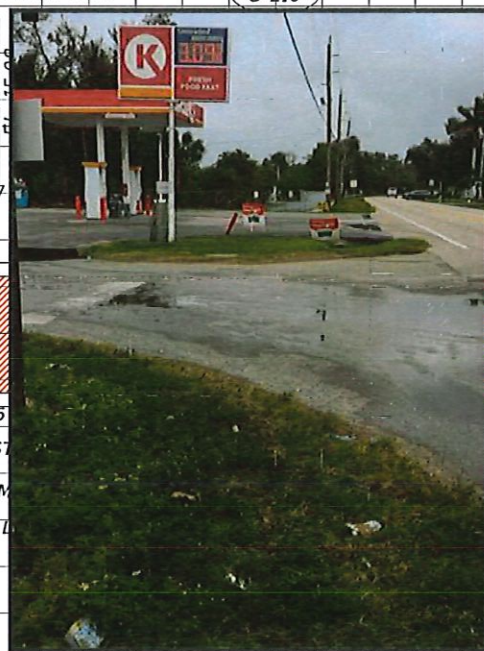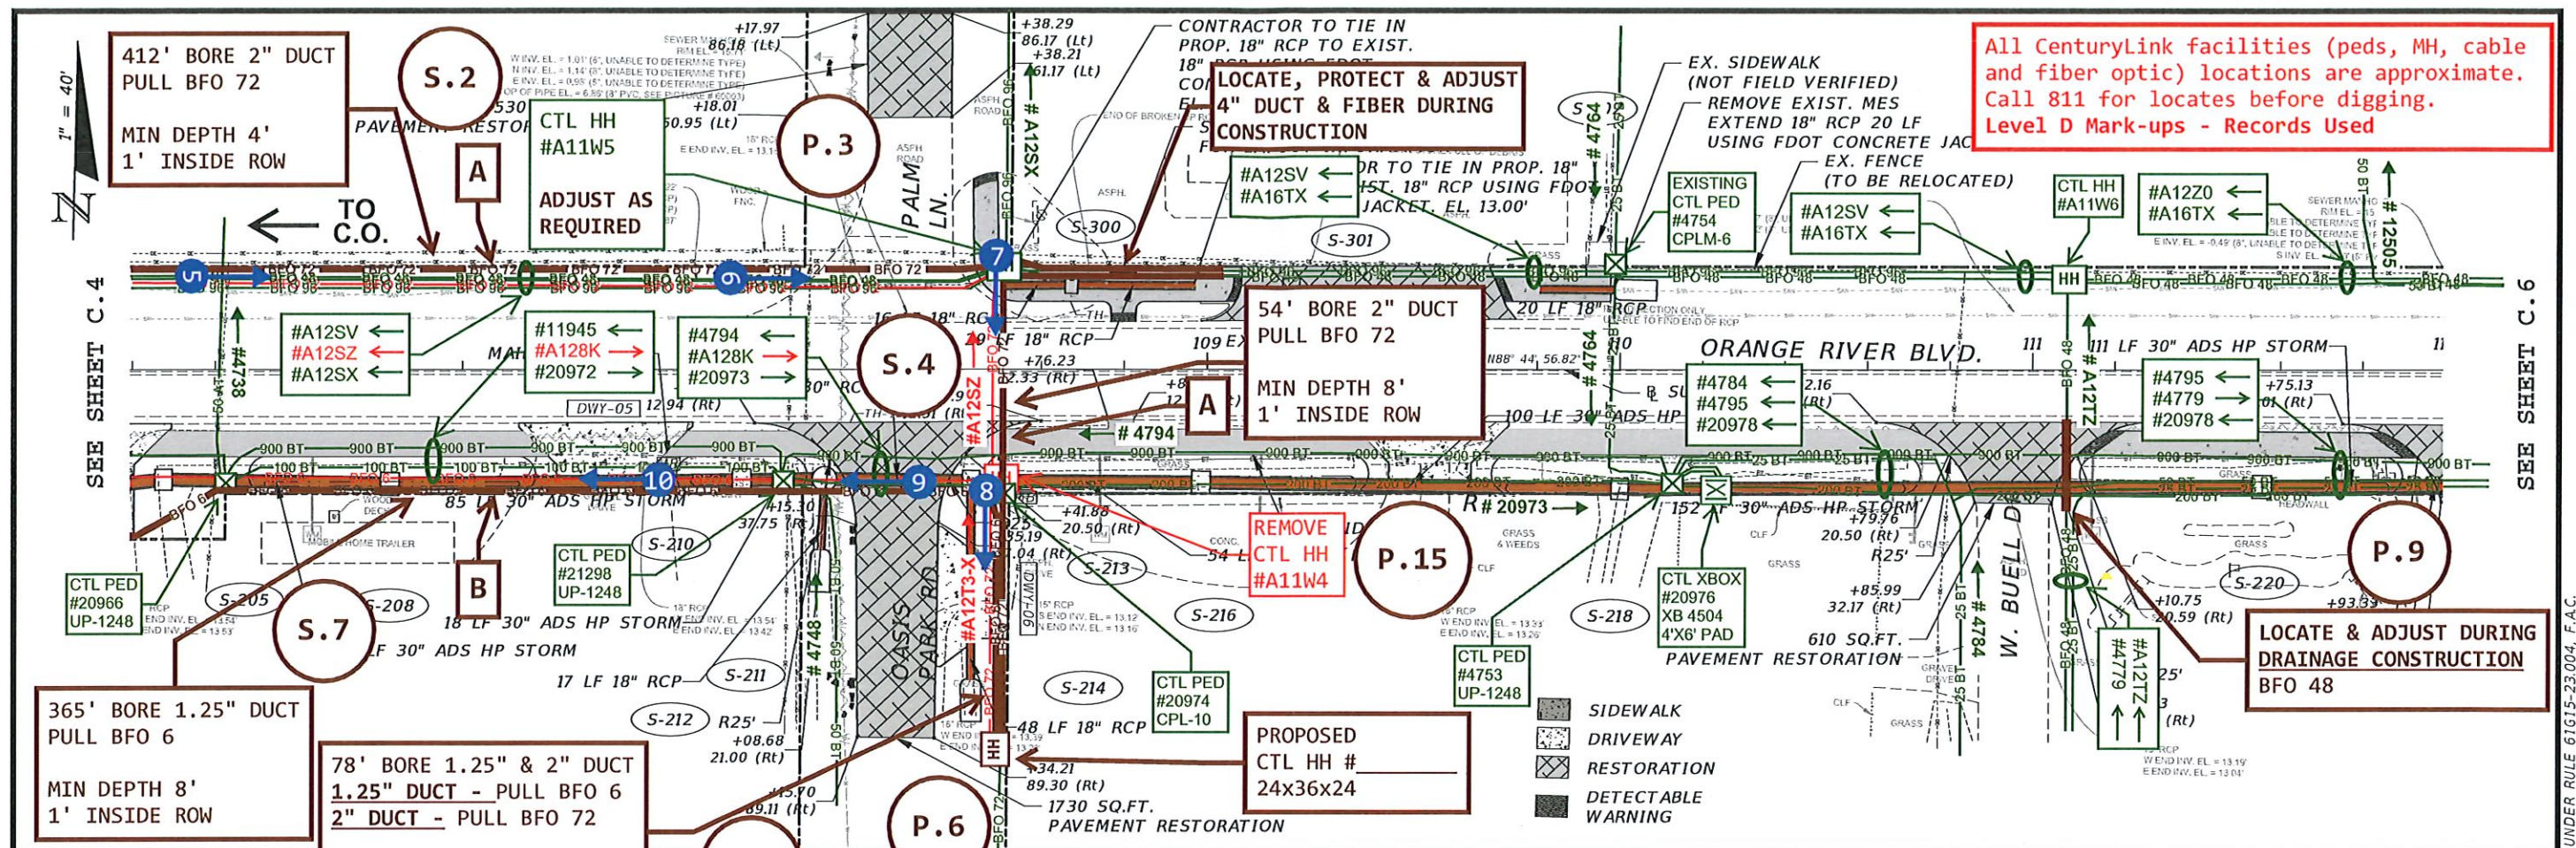

PICTURES TAKEN ON 11/5/2024

SYMBOL SHOWS APPROXIMATE
LOCATION, DIRECTION, &
NUMBER OF PICTURE

= 40' Horizontal
= 4' Vertical



TT ENG: Vivian McKeon
PHONE: 630-217-9384
vmckeon@congruex.com
TT#: TERR- 1008951
<http://www.terratechllc.net>



 
0' 40'

SCALE: 1" = 40'

LEE COUNTY PROJECT NUMBER CN200224JJJB
LUMEN PROJECT #P.043315
ORANGE RIVER BLVD SIDEWALK AND WATERMAIN REPLACEMENT - LEE COUNTY
CENTURYLINK-LUMEN CONSTRUCTION PLANS
UTILITY PLAN

LUMEN  **CenturyLink**
ENG: KEN STINNETT
PHONE: 239-920-5935
EMAIL: Kenneth.Stinnett@Lumen.com
PROJECT: P.043315

LEGEND

	<u>EXISTING</u>	<u>REMOVAL/ABANDON</u>	<u>PROPOSED</u>
BURIED FIBER OPTIC			
BURIED COPPER			
UG CONDUIT SYSTEM			

SEE SHEET B-1 FOR LEGENDS



P.043315

C.5

**SHT 9
OF 14**

THE OFFICIAL RECORD OF THIS SHEET IS THE ELECTRONIC FILE DIGITALLY SIGNED AND SEALED UNDER RULE 61G15-23.004, F.A.C.

All CenturyLink facilities (peds, MH, cable and fiber optic) locations are approximate. Call 811 for locates before digging. Level D Mark-ups - Records Used

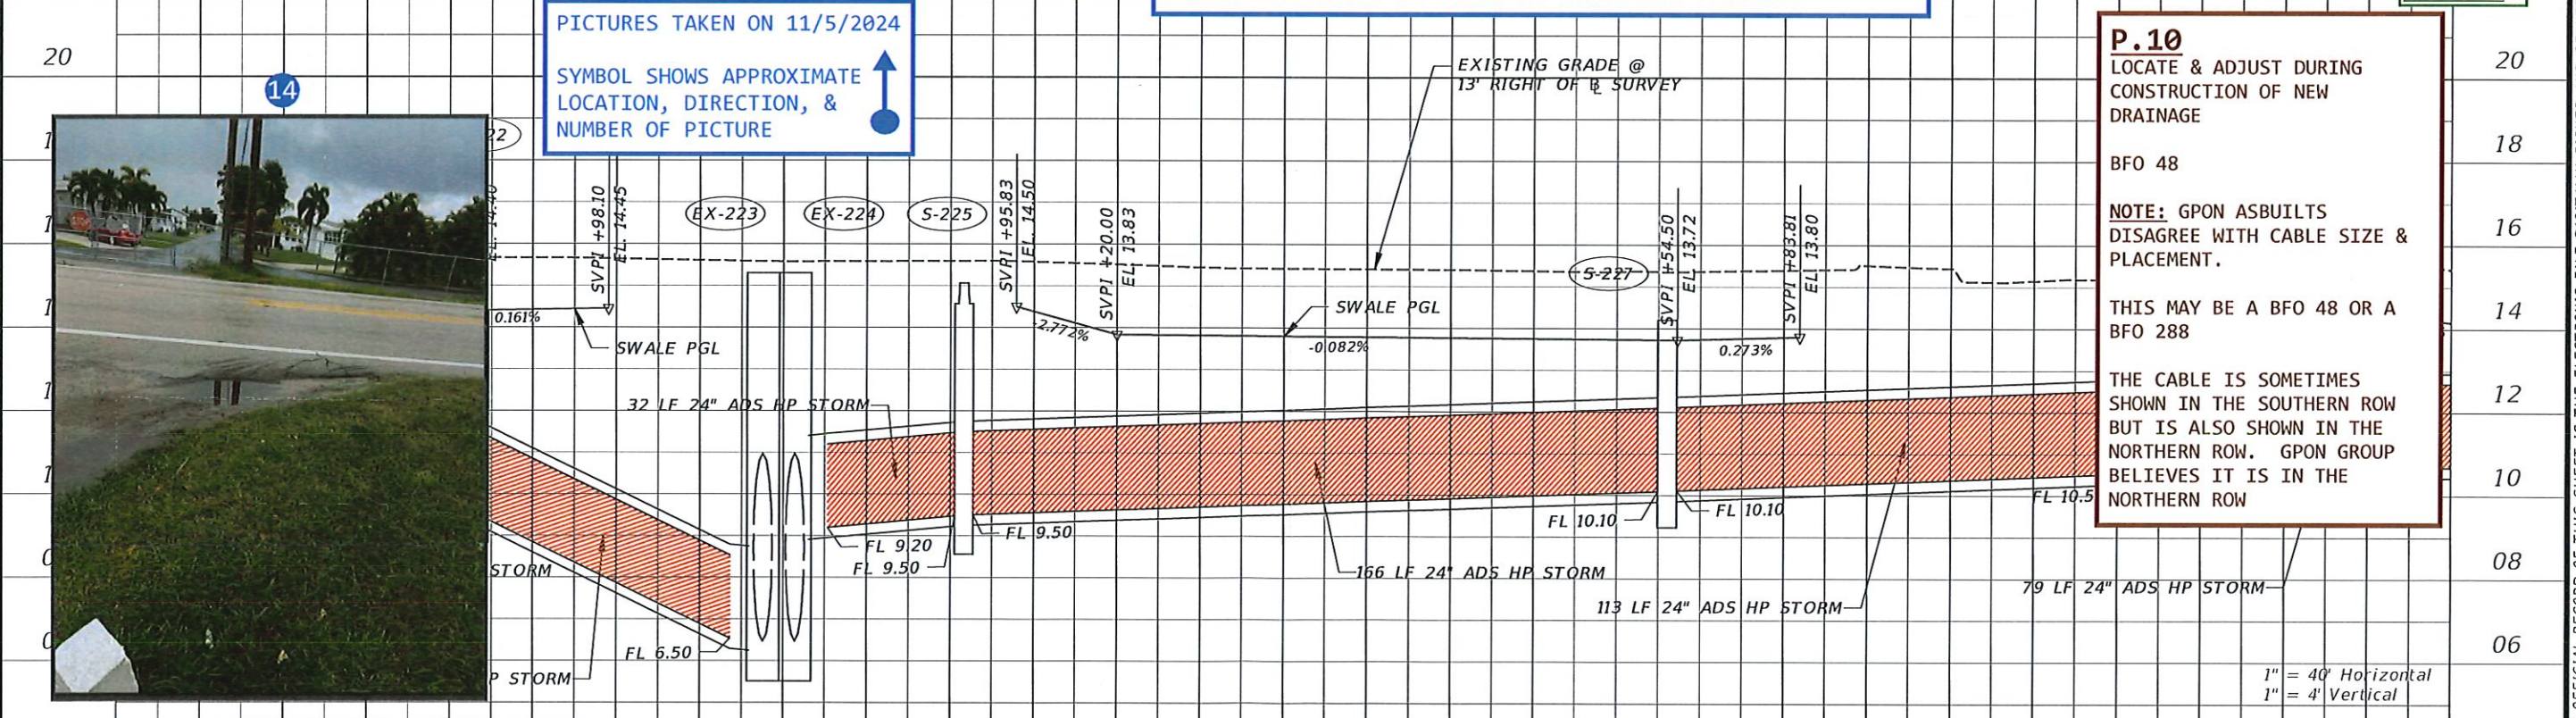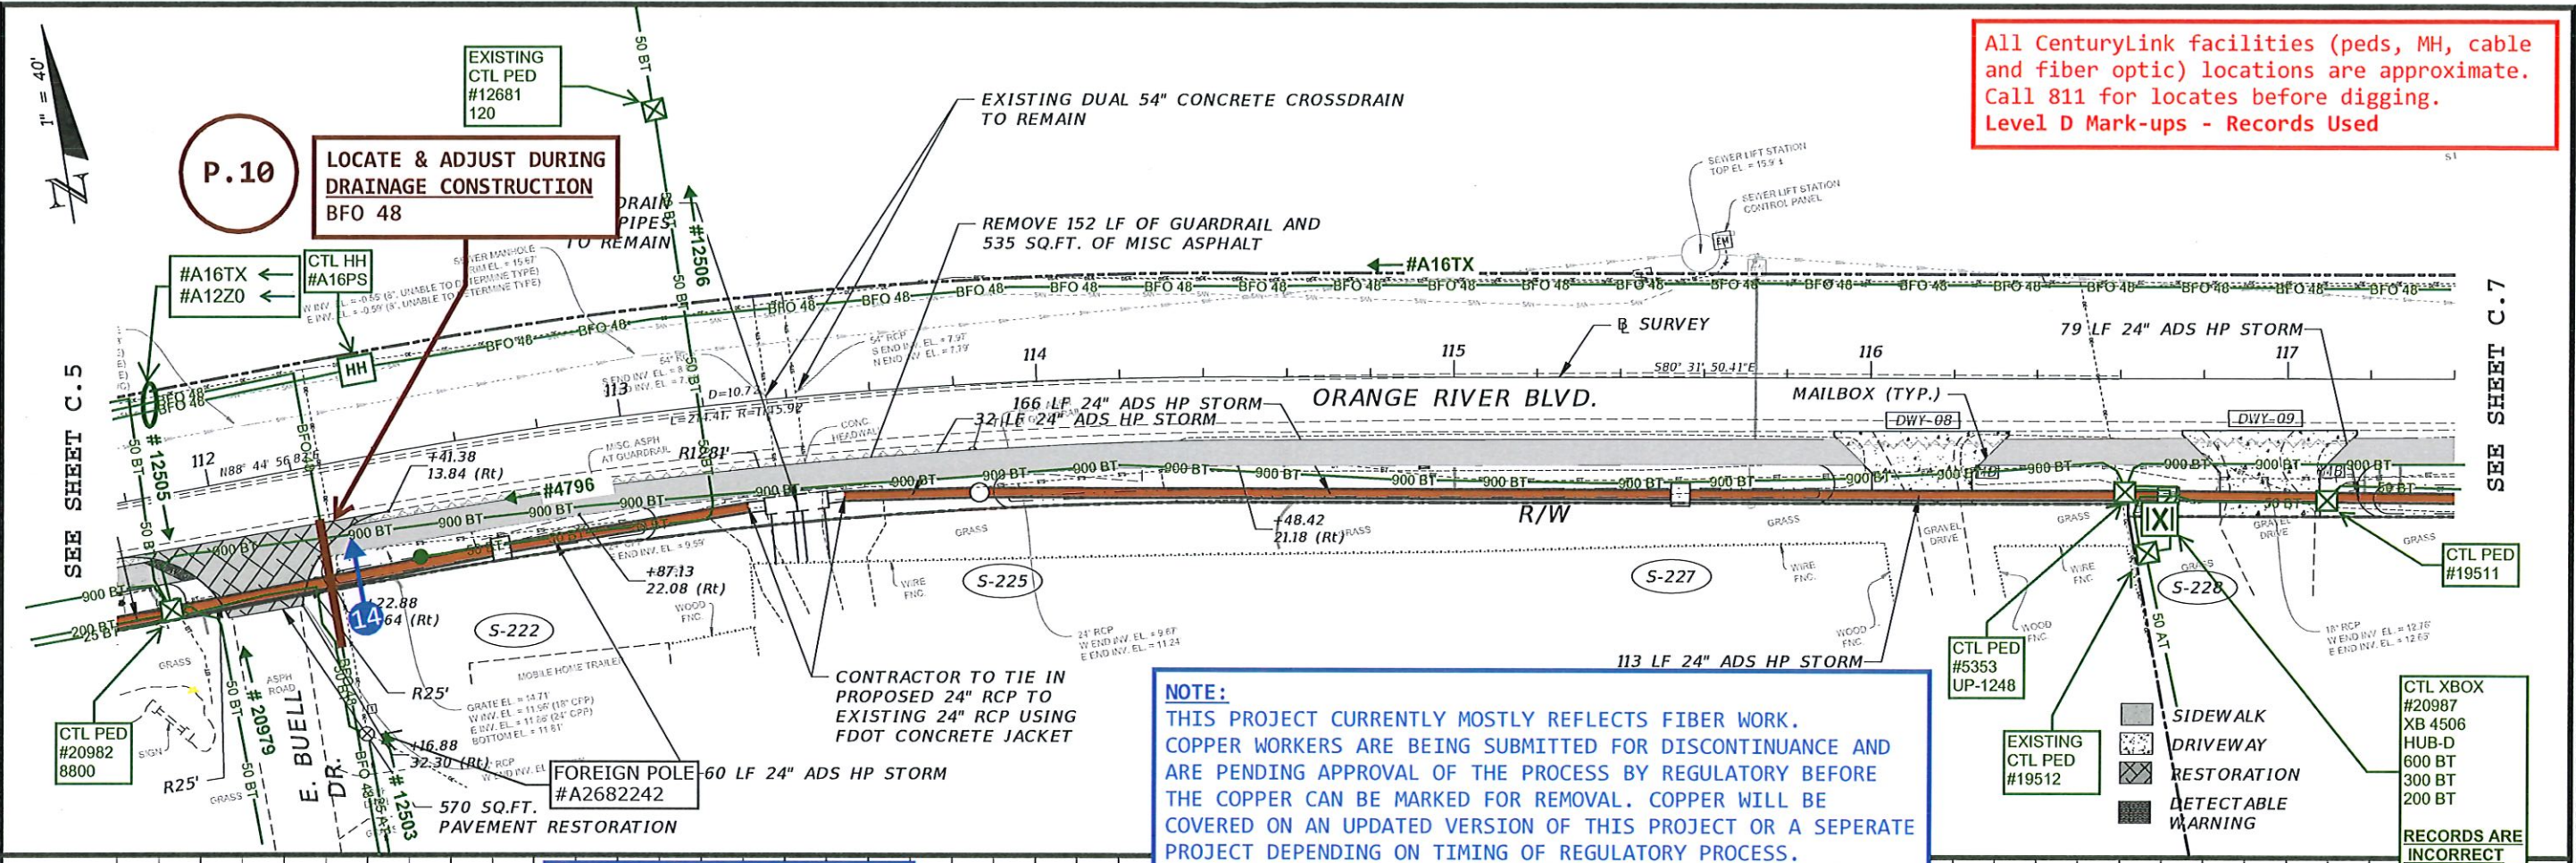

TT ENG: Vivian Mckeen
PHONE: 630-217-9384
vmckeen@congruex.com
TT#: TERR- 1008951
http://www.terratechllc.net

0' 40'

SCALE: 1" = 40'

LEE COUNTY PROJECT NUMBER CN200224JJB
LUMEN PROJECT #P.043315
ORANGE RIVER BLVD SIDEWALK AND WATERMAIN REPLACEMENT - LEE COUNTY

CENTURYLINK-LUMEN CONSTRUCTION PLANS

UTILITY PLAN

ENG: KEN STINNETT
PHONE: 239-920-5935
EMAIL: Kenneth.Stinnett@Lumen.com
PROJECT: P.043315

LEGEND

	EXISTING	REMOVAL/ABANDON	PROPOSED
BURIED FIBER OPTIC	EFO	EFO	EFO
BURIED COPPER	BT	BT	BT
UG CONDUIT SYSTEM	CONDUIT	CONDUIT	CONDUIT

SEE SHEET B-1 FOR LEGENDS

P.043315

C.6

SHT 11 OF 14

LOCATE & ADJUST AS REQUIRED
DURING DRAINAGE CONSTRUCTION

CONCLUSION



P.13
LOCATE & ADJUST DURING
CONSTRUCTION OF NEW DRAINAGE

19



**LOCATE & ADJUST DURING
CONSTRUCTION OF NEW DRAINAGE**

SEE SHEET C.8

C.7
SHT 12
OF 14

LEGEND


EXISTING REMOVAL / ABANDON PROPOSED

October 31, 2024 - 1:04pm J:\20-0016A Orange River SW\CADD\DWG\21-20-0016A-SW-PAP.dwg



1" = 40'

SEE SHEET C.7

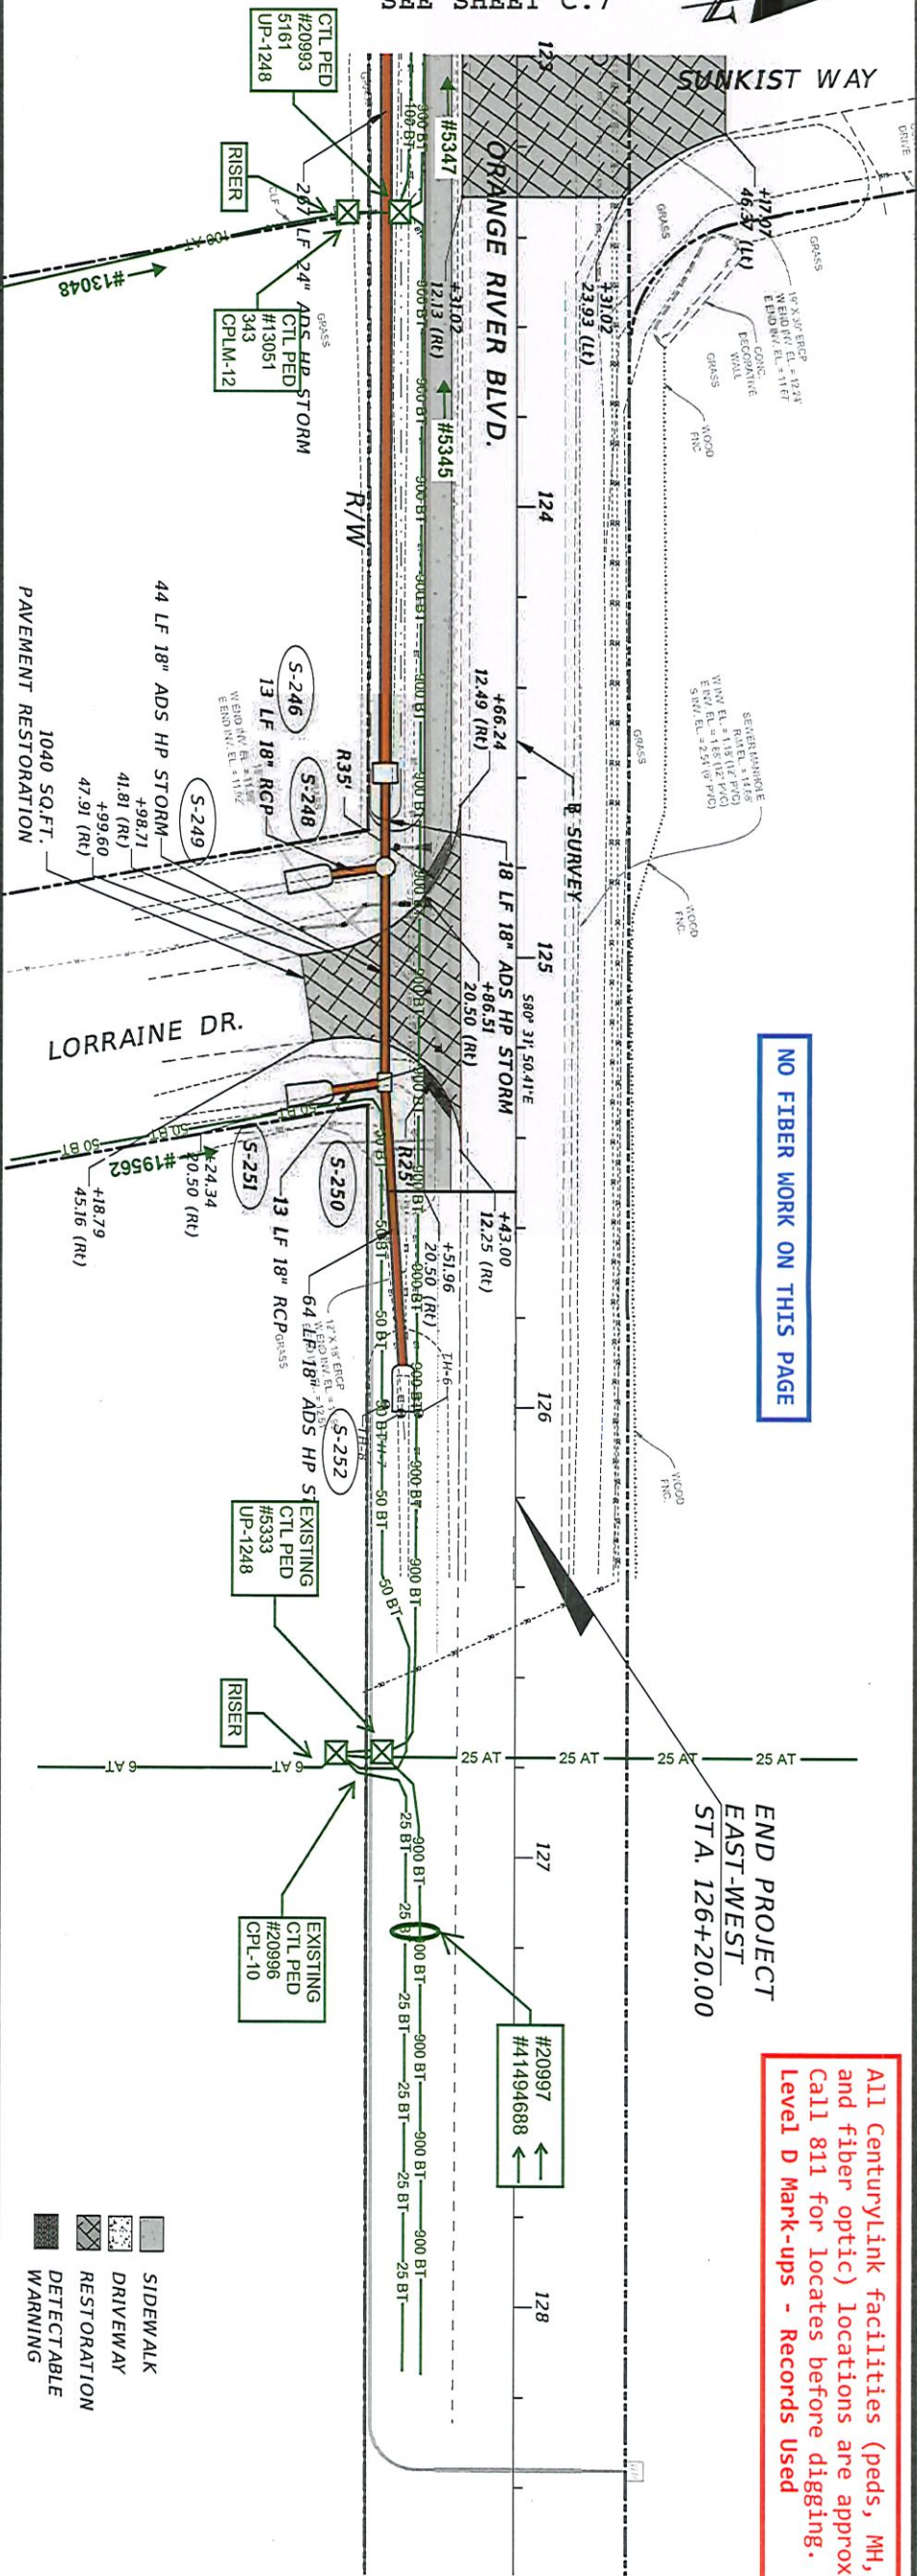

NO FIBER WORK ON THIS PAGE

END PROJECT
EAST-WEST
STA. 126+20.00

All Centurylink facilities (peds, MH, cable and fiber optic) locations are approximate. Call 811 for locates before digging. Level D Mark-ups - Records Used

NOTE:
THIS PROJECT CURRENTLY MOSTLY REFLECTS FIBER WORK. COPPER WORKERS ARE BEING SUBMITTED FOR DISCONTINUANCE AND ARE PENDING APPROVAL OF THE PROCESS BY REGULATORY BEFORE THE COPPER CAN BE MARKED FOR REMOVAL. COPPER WILL BE COVERED ON AN UPDATED VERSION OF THIS PROJECT OR A SEPERATE PROJECT DEPENDING ON TIMING OF REGULATORY PROCESS.

