

LEE COUNTY BOARD OF COUNTY COMMISSIONERS

PUBLIC WORKS ADMINISTRATION DEPARTMENT OF TRANSPORTATION CONTRACT PLANS

COMPONENTS OF CONTRACT PLANS SET

ROADWAY PLANS
BRIDGE PLANS



PLANS OF PROPOSED

BURNT STORE ROAD WIDENING INTERIM 4-LANE IMPROVEMENT - NORTH SEGMENT

COUNTY PROJECT NO. 4088

INDEX OF PLANS

SHEET NO.	SHEET DESCRIPTION
1	Key Sheet
2	Summary of Pay Items
3	General Notes
4 - 5	Typical Sections
6	Typical Sections Details
7 - 17	Summary of Quantities
18 - 22	Summary of Drainage Structures
23	Project Layout
24 - 40	Roadway Plan Sheets
41 - 56	Roadway Profile Sheets
57 - 59	Drainage Structures Data Sheet
60 - 95	Cross Sections
96 - 112	Utility Adjustment Sheets
113 - 114	Drainage Details
S-1 - S-41	Signing & Pavement Marking Plans
L-1 - L-4	Lighting Limits

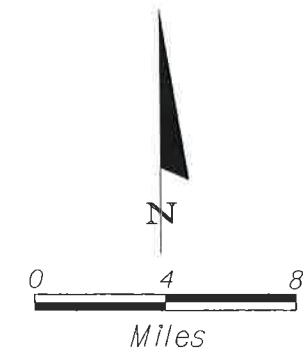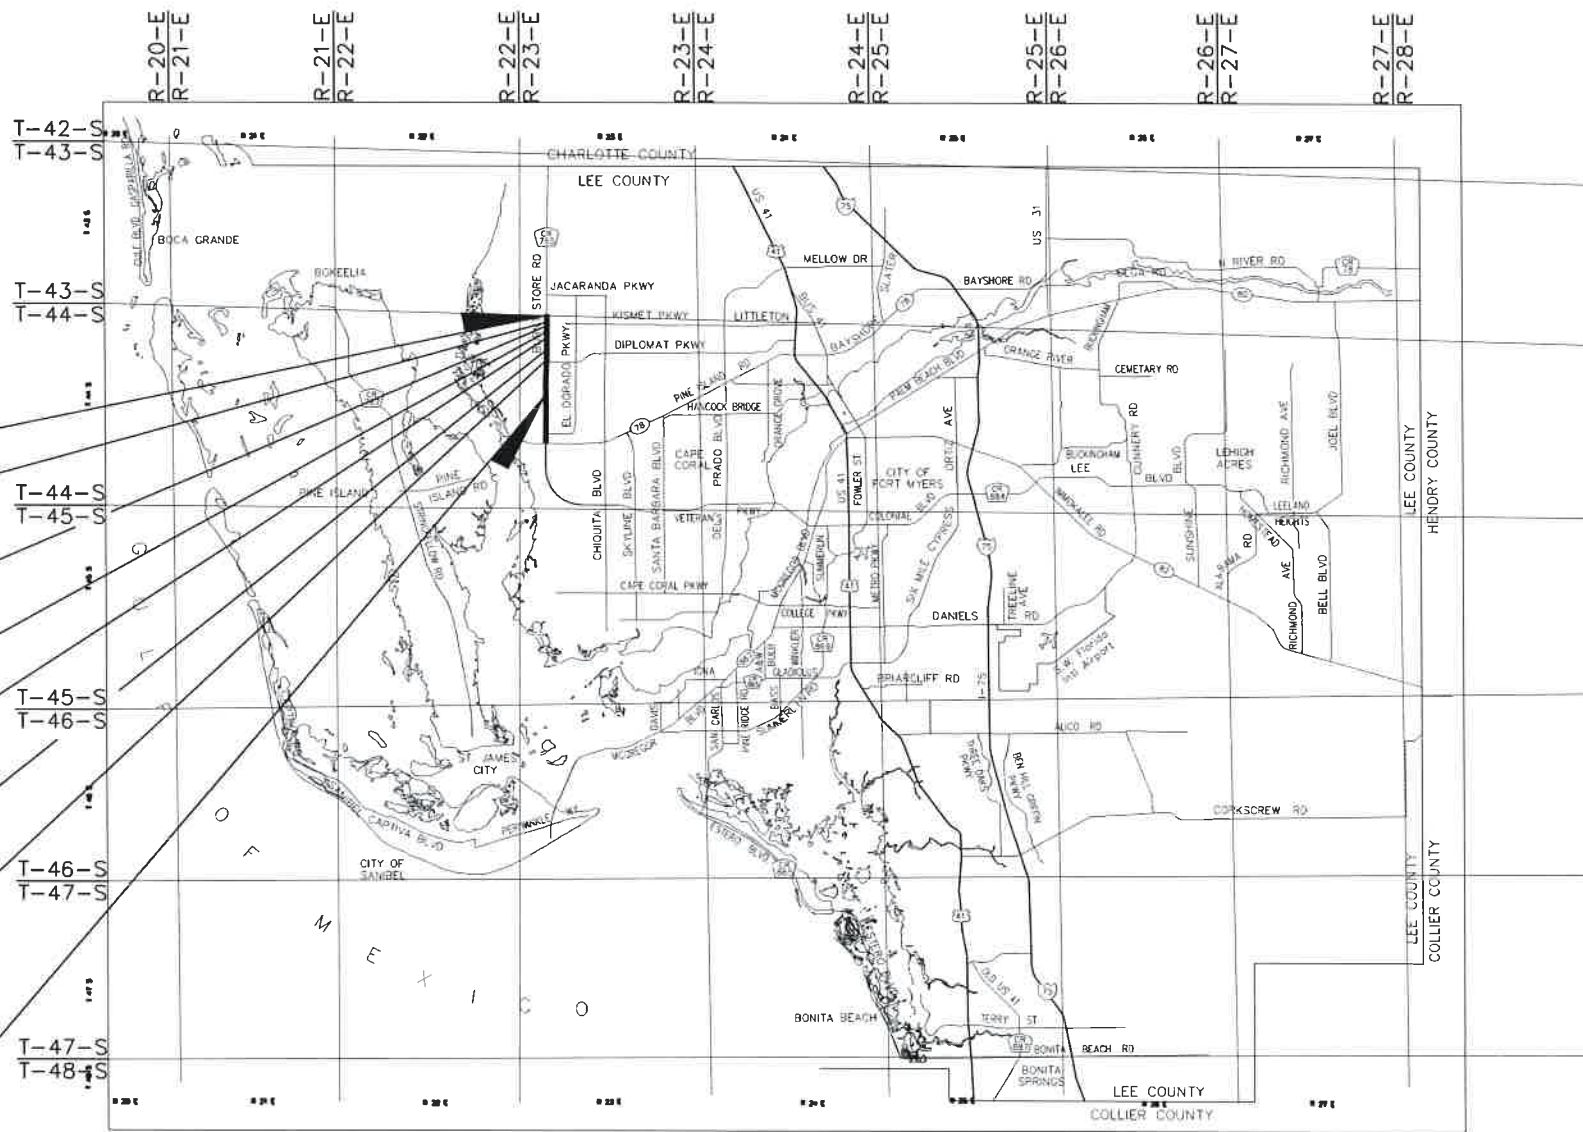

END PROJECT

☉ CONST. STA. 1321+05.43

END BRIDGE

STA. 1308+03.53

BEGIN BRIDGE

STA. 1305+75.28

END BRIDGE

STA. 1290+02.42

BEGIN BRIDGE

STA. 1288+50.26

END BRIDGE

STA. 1250+03.07

BEGIN BRIDGE

STA. 1247+99.07

BEGIN PROJECT

☉ CONST. STA 1218+63.02

PLANS PREPARED BY:
T. Y. LIN INTERNATIONAL
2400 FIRST STREET, SUITE 200
FORT MYERS, FLORIDA 33901
TEL. 239-332-4846
FAX. 239-332-4798
WWW.TYLIN.COM

NOTE: THE SCALE OF THESE PLANS MAY
HAVE CHANGED DUE TO REPRODUCTION.

100% SUBMITTAL
MARCH 4, 2015

LOCATION MAP LEE COUNTY, FLORIDA

KEY SHEET REVISIONS		
DATE	BY	DESCRIPTION



DATE 3-5-2015

GOVERNING STANDARDS AND SPECIFICATIONS:
FLORIDA DEPARTMENT OF TRANSPORTATION,
DESIGN STANDARDS DATED 2010, AND DIVISION
II AND III OF THE STANDARD SPECIFICATIONS
FOR ROAD AND BRIDGE CONSTRUCTION DATED
2007, AS AMENDED BY CONTRACT DOCUMENTS.


LEE COUNTY PROJECT MANAGER: SARAH CLARKE

SHEET NO.

1

PROPOSAL SUMMARY OF PAY ITEMS				
LEAD PROJECT: BURNT STORE ROAD NORTH SEGMENT				
COUNTY: LEE				
0001 SUMMARY OF ROADWAY				
Pay Item #	ITEM DESCRIPTION	UNIT	PLAN	FINAL
101-1	MOBILIZATION	LS	1	
101-1-1	AS-BUILTS	LS	1	
101-1-4	SCHEDULE	LS/DA	1	
102-1	MAINTENANCE OF TRAFFIC	LS	1	
104-11	FLOATING TURBIDITY BARRIER	LF	2376	
104-13-1	STAKED SILT FENCE TYPE III	LF	21766	
104-15	SOIL TRACKING PREVENTION DEVICE	EA	3	
107-1	LITTER REMOVAL	LS	1	
107-2	MOWING	LS	1	
110-1-1	CLEARING AND GRUBBING	LS/AC	1	
120-1	EXCAVATION	CY	36478	
120-6	EMBANKMENT	CY	153637	
160-4	TYPE B STABILIZATION	SY	88743	
285-704	OPTIONAL BASE, BASE GROUP 04	SY	20272	
285-712	OPTIONAL BASE, BASE GROUP 12	SY	42396	
286-2	TURNOUT CONSTRUCTION-ASPHALT	TN	8	
327-70-6	MILLING EXIST ASPH PAVT, 1 1/2" AVG DEPTH	SY	29531	
334-1-13	S-I ASPHALT PAVEMENT	TN	18655	
334-1-13	S-III ASPHALT PAVEMENT	TN	11555	
339-1	MISC ASPHALT PAVEMENT UNDER GUARDRAIL	TN	93	
400-0-11	CONCRETE GRAVITY WALL (NS)	CY	537	
400-1-2	CONCRETE CLASS I, ENDWALLS	CY	12	
425-1351	INLETS, CURB, TYPE P-5, <10'	EA	6	
425-1361	INLETS, CURB, TYPE P-6, <10'	EA	2	
425-1511	INLETS, DT BOT, TYPE B, <10'	EA	3	
425-1521	INLETS, DT BOT, TYPE C, <10'	EA	5	
425 1543	INLETS, DITCH BOTTOM, TYPE D, J BOT, <10'	EA	3	
425 1549	INLETS, DT BOT, TYPE D, MODIFY	EA	3	
425 1559	INLETS, DT BOT, TYPE E, MODIFY	EA	2	
425 1581	INLETS, DT BOT, TYPE H, <10'	EA	2	
425 1701	INLETS, GUTTER, TYPE S, <10'	EA	10	
425 2 41	MANHOLES, P-7, <10'	EA	1	
425 2 71	MANHOLES, J-7, <10'	EA	6	
430-171-101	PIPE CULVERT, OPTIONAL MATERIAL, ROUND, UP TO 24" S/CD	LF	4591	
430-171-102	PIPE CULVERT, OPTIONAL MATERIAL, ROUND, 25 TO 36" S/CD	LF	300	
430-171-103	PIPE CULVERT, OPTIONAL MATERIAL, ROUND, 37 TO 48" S/CD	LF	1436	
430-175-224	PIPE CULVERT, OPTIONAL MATERIAL, OTHER, MATERIAL, OTHER-ELIP/ARCH, 24"S/CD	LF	48	
0430-94-1	DESILTING PIPE, 0-24"	LF	675	
0430-94-2	DESILTING PIPE, 25-36"	LF	171	
0430-95-0	DESILTING CONCRETE BOX CULVERT	CY	12	
430-982-129	MITERED END SECTION, OPTIONAL ROUND, 24" CD	EA	4	
430-984-125	MITERED END SECTION, OPTIONAL ROUND, 18" SD	EA	9	
430-984-129	MITERED END SECTION, OPTIONAL ROUND, 24" SD	EA	17	
430-984-629	MITERED END SECT, OPTIONAL - ELLIPTICAL /ARCH, 24" SD	EA	2	
515-2-301	PED/BICYCLE RAILING, ALUMINUM, 42"	LF	2796	
515-3-2	HANDRAIL, ALUMINUM	LF	27	
520-1-7	TYPE E CURB AND GUTTER	LF	1617	
520-2-4	TYPE D MODIFIED	LF	1406	
520-5-11	4 FT TRAFFIC SEPARATOR	LF	40	
520-6	SHOULDER GUTTER	LF	2237	
520-70	VARIABLE TRAFFIC SEPARATOR	SY	152	
522-1	CONC SIDEWALK 4"	SY	4152	
536-1-1	GUARDRAIL - ROADWAY	LF	2902	
536-73	GUARDRAIL REMOVAL	LF	172	
536-8-1	BRIDGE ANCHORAGE ASSEMBLY	EA	8	
536-85-22	END ANCHORAGE ASSEMBLY, TYPE FLARED	EA	1	
536-85-26	END ANCHORAGE ASSEMBLY, TYPE CRT	EA	12	
570-1-2	PERFORMANCE TURF (SOD)	SY	122687	

PAY ITEM NOTES:
1) COST OF PLUGGING SEAWALL TO BE INCLUDED IN 0110 1 1 CLEARING AND GRUBBING
2) COST OF DECTABLE WARNING DEVICES TO BE INCLUDED IN 0522 1 CONCRETE SIDEWALK 4"
3) 0102-2 MAINTENANCE OF TRAFFIC SHALL INCLUDE THE DESIGN OF TRAFFIC CONTROL PLANS BY A PROFESSIONAL ENGINEER, LICENSED TO PRACTICE IN THE STATE OF FLORIDA.

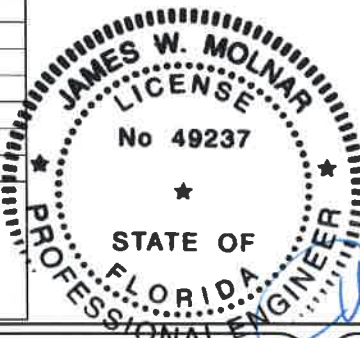

PROPOSAL SUMMARY OF PAY ITEMS				
LEAD PROJECT: BURNT STORE ROAD NORTH SEGMENT				
COUNTY: LEE				
0002 SUMMARY OF STRUCTURES				
Pay Item #	ITEM DESCRIPTION	UNIT	PLAN	FINAL
400-2-10	CONCRETE CLASS II, APPROACH SLABS	CY	448	
415-1-9	REINFORCING STEEL- APPROACH SLABS	LB	89,611	
400-2-11	CONCRETE CLASS II, RETAINING WALLS	CY	378	
415-1-3	REINFORCING STEEL- RETAINING WALL	LB	66,192	
400-4-4	CONCRETE CLASS IV, SUPERSTRUCTURE	CY	1,175	
415-1-4	REINFORCING STEEL - SUPERSTRUCTURE	LB	240,863	
400-4-5	CONCRETE CLASS IV, SUBSTRUCTURE	CY	612	
415-1-5	REINFORCING STEEL- SUBSTRUCTURE	LB	88,796	
400-9	BRIDGE DECK GROOVING AND PLANING	SY	4,515	
400-143	CLEANING & COATING CONCRETE SURFACE, CLASS 5	SF	14,410	
400-147	COMPOSITE NEOPRENE PADS	CF	37	
450-1-3	PRESTRESSED BEAMS, TYPE IV	LF	2,403	
450-1-4	PRESTRESSED BEAMS, TYPE V	LF	1,213	
455-14-3	CONCRETE SHEET PILING, 10"X30"	LF	7,331	
455-18	PROTECTION OF EXISTING STRUCTURES	LS	1	
455-34-5	PRESTRESSED CONCRETE PILING, 24" SQ	LF	8,610	
455-87	ANCHOR BAR, STEEL	EA	60	
458-1-11	BRIDGE DECK EXPANSION JOINT, NEW CONSTRUCTION, F&I	LF	403	
521-5-1	CONCRETE TRAFFIC RAILING, BRIDGE 32" F - SHAPE	LF	1,529	
521-6-11	CONCRETE PARAPET, PEDESTRIAN/BICYCLE,	LF	764	
460-70-3	ALUMINUM BULLET RAILINGS, TRIPLE RAIL	LF	764	
524-2-2	CONCRETE SLOPE PAVEMENT, NON REINFORCED	SY	808	

PROPOSAL SUMMARY OF PAY ITEMS				
LEAD PROJECT: BURNT STORE ROAD NORTH SEGMENT				
COUNTY: LEE				
0003 SUMMARY OF SIGNING & PAVEMENT MARKING				
Pay Item #	ITEM DESCRIPTION	UNIT	PLAN	FINAL
0700 20 11	SINGLE POST SIGN, F&I GROUND MOUNT, LESS THAN 12 SF	AS	144	
0706 3	RETRO-REFLECTIVE PAVEMENT MARKERS	EA	846	
0711 11111	THERMOPLASTIC, STANDARD, WHITE, SOLID, 6"	NM	6.24	
0711 11112	THERMOPLASTIC, STANDARD, WHITE, SOLID, 8"	NM	0.22	
0711 11113	THERMOPLASTIC, STANDARD, WHITE, SOLID, 12"	NM	0.31	
0711 11114	THERMOPLASTIC, STANDARD, WHITE, SOLID, 18"	NM	0.09	
0711 11115	THERMOPLASTIC, STANDARD, WHITE, SOLID, 24"	NM	0.12	
0711 11131	THERMOPLASTIC, STANDARD, WHITE, SKIP 10-30, 6"	GM	3.13	
0711 11160	THERMOPLASTIC, STANDARD, WHITE, MESSAGE (ONLY)	EA	43	
0711 11160	THERMOPLASTIC, STANDARD, WHITE, MESSAGE (MERGE)	EA	1	
0711 11160	THERMOPLASTIC, STANDARD, WHITE, MESSAGE (BICYCLE)	EA	89	
0711 11170	THERMOPLASTIC, STANDARD, WHITE, ARROW (LEFT DIRECTIONAL ARROW)	EA	39	
0711 11170	THERMOPLASTIC, STANDARD, WHITE, ARROW (RIGHT DIRECTIONAL ARROW)	EA	25	
0711 11170	THERMOPLASTIC, STANDARD, WHITE, ARROW (LEFT TURN-THRU COMBINATION DIRECTIONAL ARROW)	EA	2	
0711 11170	THERMOPLASTIC, STANDARD, WHITE, ARROW (Merge Directional Arrow)	EA	3	
0711 11211	THERMOPLASTIC, STANDARD, YELLOW, SOLID, 6"	NM	4.89	
0711 11224	THERMOPLASTIC, STANDARD, YELLOW, SOLID, 18"	NM	0.03	

PROPOSAL SUMMARY OF PAY ITEMS				
LEAD PROJECT: BURNT STORE ROAD NORTH SEGMENT				
COUNTY: LEE				
0004 SUMMARY OF LIGHTING				
ITEM	DESCRIPTION	UNIT	PLAN	FINAL
715-2-11	CONDUIT, FURNISH & INSTALL, UNDERGROUND	LF	81	
715-2-13	CONDUIT, FURNISH & INSTALL, SURFACE MOUNT	LF	546	
715-1-12	LIGHTING CONDUCTORS, F&I, INSULATED, NO.8 - 6	LF	627	
715-7-11	LOAD CENTER, F&I, SECONDARY VOLTAGE	EA	2	
715-11-125	LUMINAIRE, F&I, UNDER DECK, FLOOD	EA	8	
715-500-3	POLE CABLE DISTRIBUTION SYSTEM, WALL MOUNT	EA	8	

NO.	DATE	BY	REVISIONS - DESCRIPTION

T.Y. LIN INTERNATIONAL
2400 FIRST STREET
SUITE 200
FORT MYERS, FLORIDA 33901
TEL. (239) 332-4846
FAX. (239) 332-4798
WWW.TYLIN.COM

APPROVED BY:
JAMES MOLNAR, P.E.
REGISTERED PROFESSIONAL ENGINEER
FLORIDA CERTIFICATE NO. 49237
3-5-2015

PUBLIC WORKS
LEE COUNTY
SOUTHWEST
FLORIDA
1500 MONROE STREET
FORT MYERS, FLORIDA 33901
(239) 479-8900 www.lee-county.com/publicworks/default.htm

SUMMARY OF PAY ITEMS
BURNT STORE ROAD

SHEET NO.
2

GENERAL NOTES:

1. EXISTING DRAINAGE STRUCTURES WITHIN THE CONSTRUCTION LIMITS SHALL REMAIN, UNLESS OTHERWISE NOTED.
2. ANY SURVEY MARKER WITHIN THE LIMITS OF CONSTRUCTION IS TO BE PROTECTED. IF A CORNER MONUMENT IS IN DANGER OF BEING DESTROYED, THE ENGINEER SHALL BE NOTIFIED.
3. B.M. DATA IS NATIONAL GEODESIC VERTICAL DATUM (NGVD) OF 1929 (NGVD-'29), ANY NGVD '29 OR NAVD '88 MONUMENT WITHIN THE LIMITS OF CONSTRUCTION IS TO BE PROTECTED. IF IN DANGER OF DAMAGE, THE PROJECT ENGINEER SHALL NOTIFY: LEE COUNTY SURVEY DEPARTMENT
4. THE STATIONS AND OFFSETS ARE FROM THE CENTERLINE OF CONSTRUCTION LINES UNLESS OTHERWISE NOTED ON PLANS.
5. RIGHT OF WAY FOR BURNT STORE ROAD IS DIMENSIONED TO BASELINE OF SURVEY.
6. DISPOSAL OF MILLED MATERIAL, EXCAVATED MATERIAL, DEBRIS AND CONCRETE REMOVABLE ITEMS SHALL BE MADE AT A LEGAL DISPOSAL SITE OR BY OTHER PRIOR APPROVED MANNER BY THE CONTRACTOR. DO NOT DEPOSIT MATERIALS CLEARED FROM SITE ONTO ADJACENT PROPERTY. CONTRACTOR IS RESPONSIBLE FOR ALL MATERIALS REMOVED FROM SITE.
7. REMOVE ALL LOOSE MILLED MATERIAL FROM THE ROADWAY WITHIN 24 HOURS OF MILLING AND TO THE SATISFACTION OF THE ENGINEER. KEEP THE DRAINAGE SYSTEM FREE OF CONSTRUCTION DEBRIS.
8. DEWATERING PERMITS, IF REQUIRED SHALL BE SOLICITED AND SECURED BY THE CONTRACTOR.
9. THE CONTRACTOR IS TO USE CAUTION WHEN WORKING IN OR AROUND AREAS OF OVERHEAD TRANSMISSION LINES OR UNDERGROUND UTILITIES. THE APPROPRIATE UTILITY COMPANY SHALL BE NOTIFIED 48 HOURS IN ADVANCE OF ANY EXCAVATION INVOLVING THEIR UTILITIES SO THAT A COMPANY REPRESENTATIVE CAN BE PRESENT.
10. THE LOCATION OF THE UTILITIES SHOWN IN THE PLANS ARE BASED ON LIMITED INVESTIGATION TECHNIQUES AND SHOULD BE CONSIDERED APPROXIMATE ONLY. THE VERIFIED LOCATIONS/ELEVATIONS APPLY ONLY AT THE POINTS SHOWN, INTERPOLATIONS BETWEEN THESE POINTS HAVE NOT BEEN VERIFIED. THE EXACT LOCATION SHALL BE DETERMINED BY THE CONTRACTOR DURING CONSTRUCTION.
11. FOR UTILITY ADJUSTMENT SYMBOL, SEE INDEX NO. 002
12. IF THE CONTRACTOR ELECTS TO UTILIZE OFF-DUTY LAW ENFORCEMENT OFFICERS FOR WORK, THE COST OF OFF-DUTY OFFICERS SHALL BE INCLUDED IN THE COST OF THE WORK ELEMENT BEING PERFORMED.
13. THE CONTRACTOR'S ATTENTION IS DIRECTED TO THE SPECIAL PROVISIONS OF THIS CONTRACT WHICH REQUIRE THE PREPARATION AND APPROVAL OF AN EROSION CONTROL PLAN THAT ADDRESSES THE PREVENTION, CONTROL AND ABATEMENT OF WATER POLLUTION.
14. UTILITY OWNERS:

Comcast
Mr. Mark Cook
12641 Corporate Lakes Drive
Fort Myers, FL 33913
(239) 432-1805 415-4742
mark_cook@cable.comcast.com

FPL Fibernet LLC
Mr. Danny Haskett
9250 W. Flagler Street
Miami, FL 33 174
305-552-2931
Danny.haskett@fpl.com

Greater Pine Island Water Association
Mr. William Thacher
5281 Pine Island Rd.
Bokella, FL 33922
239-283-1071
wthacher@pinelandwater.com

CenturyLink
Mr. Von Thayer
4195 Kings Hwy
Port Charlotte, FL 33980
941-637-5145
Von.Thayer@centurylink.com

Lee County Electric Co-Op
Mr. Tom Bailey
4980 Bayline Drive
N. Fort Myers, FL 33917
239-656-2414
Tom.bailey@lecec.net

 
Lee County DOT - Signalization
Mr. James Fencil
5650 Enterprise Pkwy
Ft. Myers, FL 33905
239-533-9500
jfencil@leegov.com

City of Cape Coral
Mr. Jody Sorrels
P O Box 150027
Cape Coral, FL 33915
239-242-3227
jsorrels@capecoral.net

Lee County Utilities
Mr. David Reycraft
1500 Monroe Street, 3
Fort Myers, FL 33901
239-533-8150
dreycraft@leegov.com

15. CONSTRUCT DRIVEWAY TURNOUTS IN ACCORDANCE TO STANDARD INDEX 515. MAINTAIN ACCESS TO DRIVEWAYS BY LIMITING CONSTRUCTION TO HALF A TURNOUT AT A TIME.
16. IN ANY EXCAVATION WORK IT SHOULD BE NOTED THAT THE WATER TABLE IS HIGH IN THIS AREA. CONTRACTOR SHOULD BE AWARE OF WET CONDITIONS ALONG THE TOE OF THE ROADWAY EMBANKMENT. CONTRACTOR SHOULD CONSIDER CONSTRUCTION METHODS FOR OPERATING EQUIPMENT OVER SOFT SOILS MAY BE REQUIRED WHEN WORKING NEAR OR ALONG THE TOE OF THE ROADWAY EMBANKMENT.
17. NO MATERIALS OR MACHINERY ARE TO BE STORED IN WETLAND AREA. CONSTRUCTION EQUIPMENT SHALL NOT BE USED TO REMOVE DEBRIS FROM WETLAND AREA UNLESS A PERMIT HAS BEEN OBTAINED.
18. ALL HAY BALES AND SILT FENCE SHALL BE REMOVED AT THE COMPLETION OF THE PROJECT.
19. THE CONTRACTOR IS TO MAINTAIN AND KEEP STREET NAME IDENTIFICATION VISIBLE DURING CONSTRUCTION OPERATIONS IN ORDER TO FACILITATE EMERGENCY VEHICLE TRAFFIC.
20. SPECIAL ATTENTION IS DIRECTED TO THE FACT THAT PORTIONS OF SOME DRAINAGE STRUCTURES EXTEND INTO THE STABILIZED PORTION OF THE ROAD BED AND EXTREME CAUTION WILL BE NECESSARY IN STABILIZATION OPERATIONS AT THOSE LOCATIONS. THE CONTRACTOR MUST UDE STATIC ROLLING COMPACTION WHILE WORKING ON OR NEAR, NEW OR EXISTING DRAINAGE STRUCTURES THAT EXTEND INTO THE ROADWAY BASE.
21. ALL CURB CUT RAMPS TO COMPLY WITH STANDARD INDEX 304.
22. UTILITIES TO REMAIN UNLESS OTHERWISE NOTED IN THE PLANS.
23. COST OF LONGITUDINAL AND PERPENDICULAR SAW CUTS AT PAVEMENT FEATHERING LOCATIONS AND PAVEMENT WIDENING ARE INCIDENTAL TO THE MILLING AND RESURFACING.
24. ANY CONSTRUCTION ACTIVITY OUTSIDE THE EXISTING RIGHT OF WAY LINE SHOULD BE COORDINATED WITH THE ADJACENT PROPERTY OWNER.
25. A STORMWATER POLLUTION PREVENTION PLAN SHALL BE PREPARED IN ACCORDANCE WITH SECTION 104. THE NOTICE OF INTENT SHALL BE PREPARED FOR THE NPDES STORMWATER PERMIT AND SUBMITTED TO OBTAIN PERMIT COVERAGE. FULL COMPENSATION FOR ALL ITEMS AND WORK SHALL BE INCLUDED IN THE COST OF MAINTENANCE OF TRAFFIC.
26. ALL CURB CUT RAMPS SHALL RECEIVE A CURB RAMP DETECTABLE WARNING.
27. GUARDRAIL SHALL BE CONSTRUCTED PER FDOT STANDARD INDEX 400 AS REVISED ON JUNE 6, 2014.


PLAN SHEET LEGEND:



MILL & RESURFACE AREA



SURVEY BENCH MARK

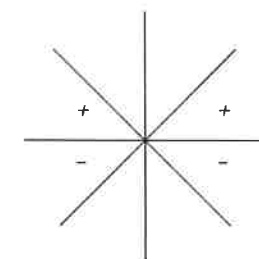

SUPERELEVATION CONVENTION



NO.	DATE	BY	REVISIONS - DESCRIPTION

T.Y. LIN INTERNATIONAL
2400 FIRST STREET
SUITE 200
FORT MYERS, FLORIDA 33901
TEL. (239) 332-4846
FAX. (239) 332-4798
WWW.TYLIN.COM



APPROVED BY
JAMES W. MOLNAR
REGISTERED PROFESSIONAL ENGINEER
FLORIDA CERTIFICATE NO. 49237
3-5-2015

PUBLIC WORKS
LEE COUNTY
SOUTHWEST
FLORIDA
1500 MONROE STREET
FORT MYERS, FLORIDA 33901
(239) 479-8900 www.lee-county.com/publicworks/dot/le.htm

DEPARTMENT
of
TRANSPORTATION

GENERAL NOTES
BURNT STORE ROAD

SHEET NO.
3

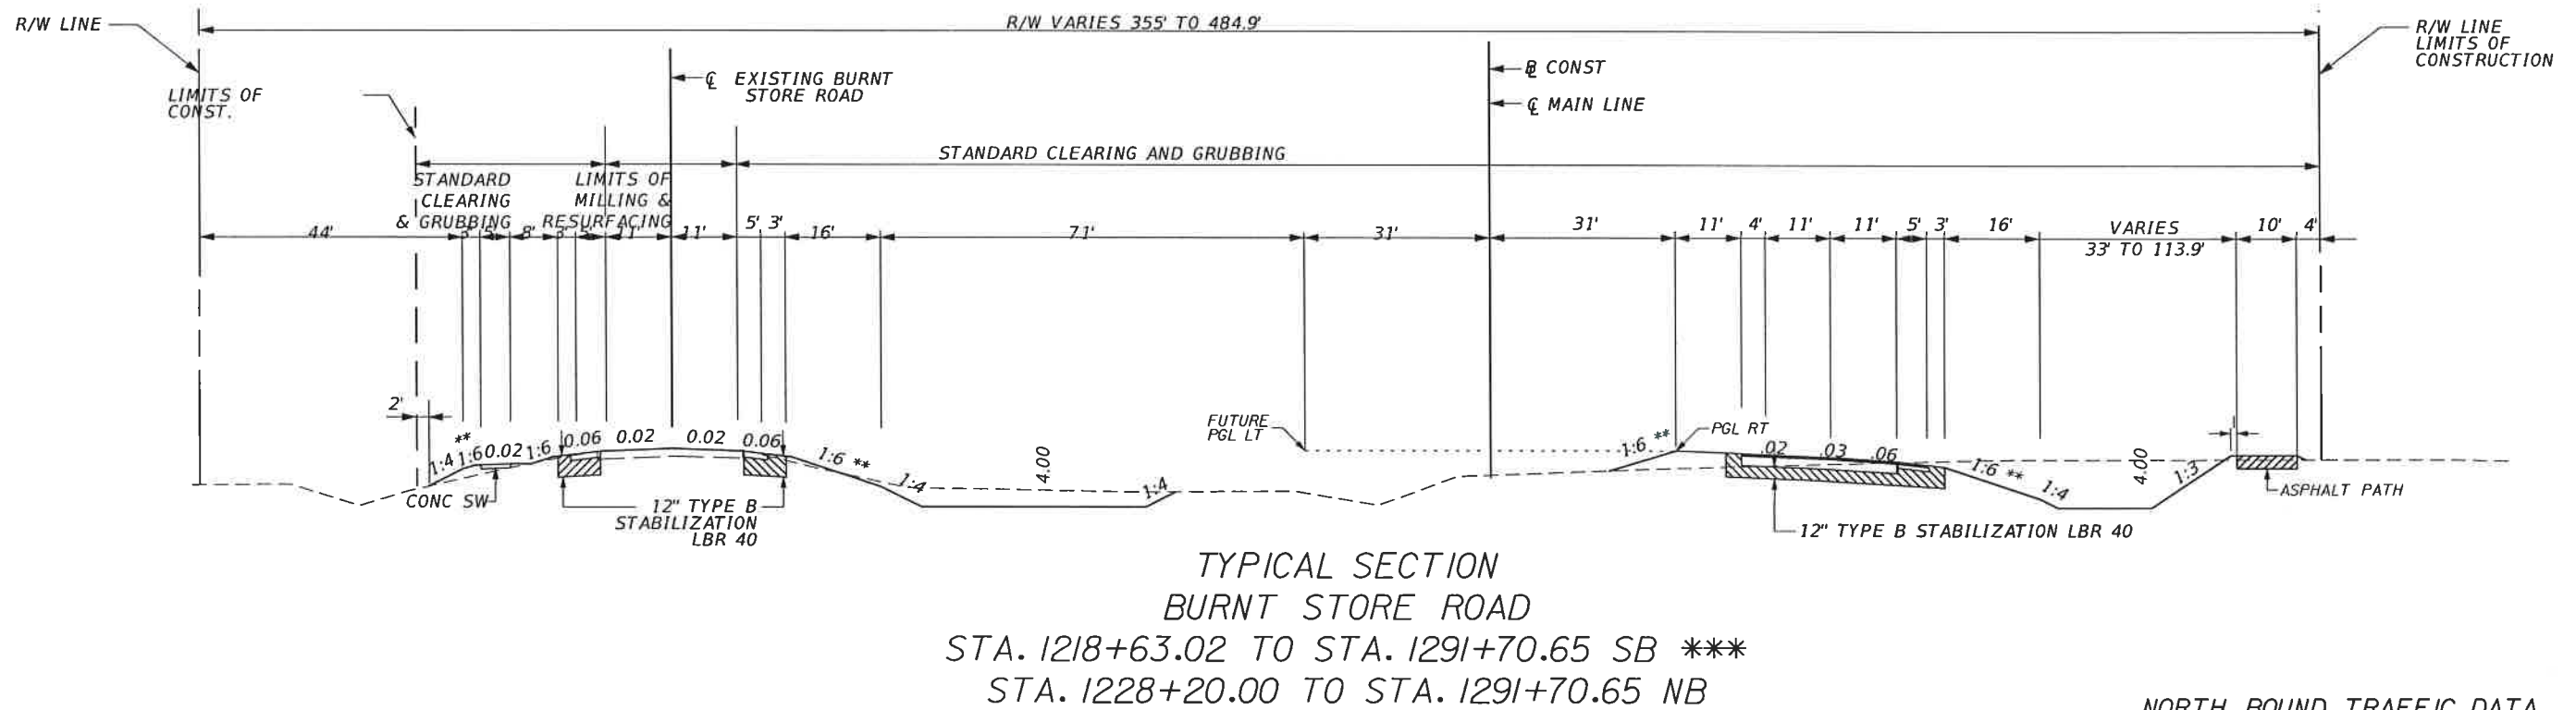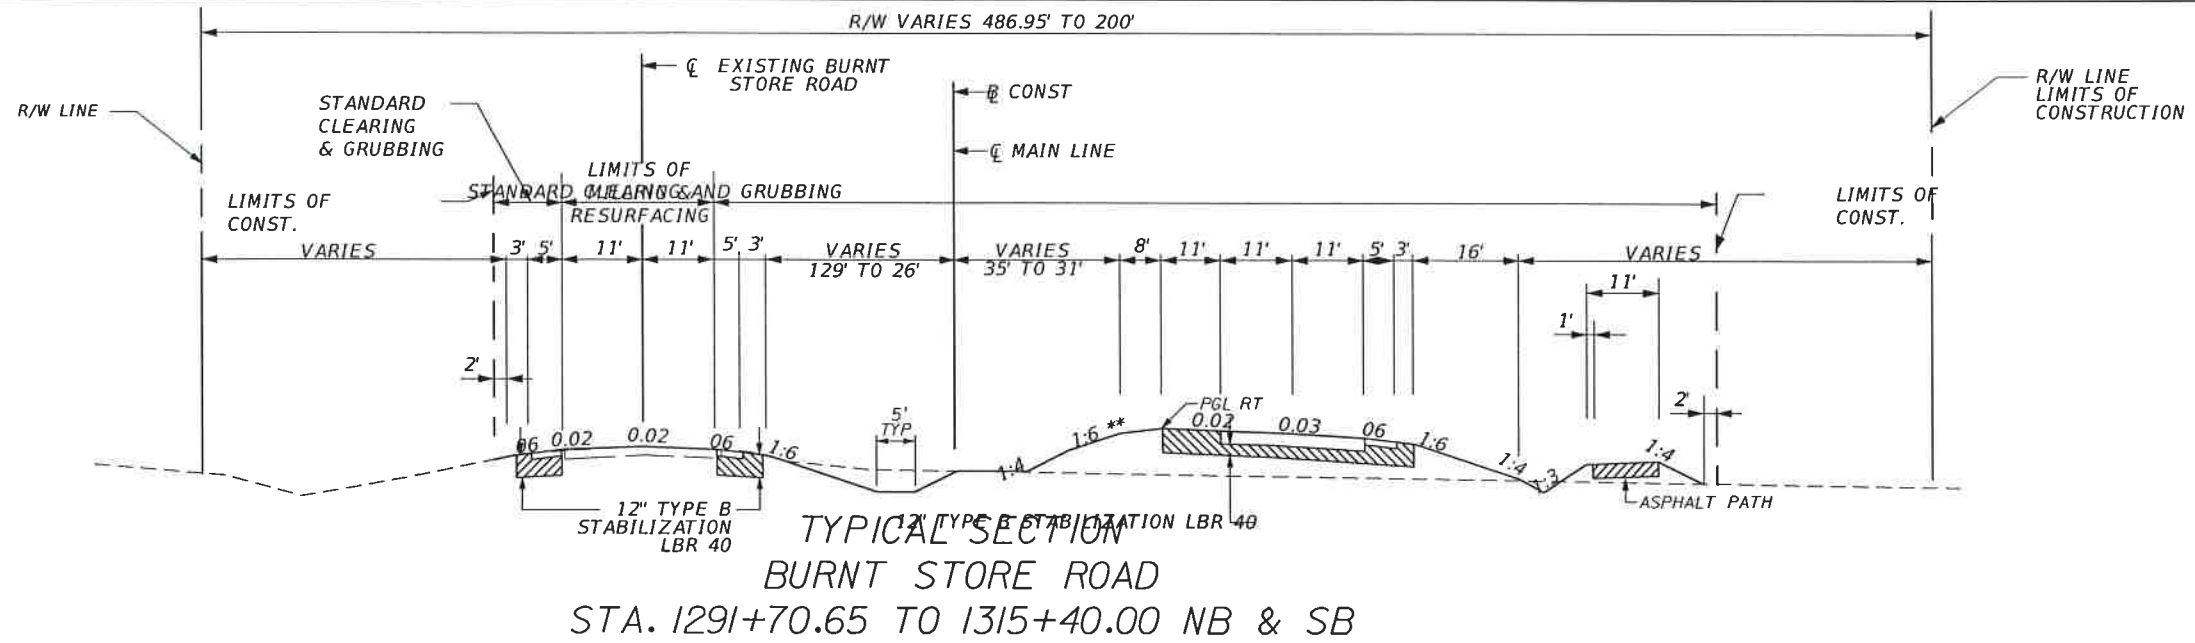

SOUTH BOUND FRONTAGE TRAFFIC DATA

CURRENT YEAR = 2015 AADT = 15,206
 ESTIMATED OPENING YEAR = 2016 AADT = 15,925
 ESTIMATED DESIGN YEAR = 2036 AADT = 30,313
 K = % D = 50 % T = 6 % (24 HOUR)
 DESIGN HOUR T = 6%
 DESIGN SPEED = 50 MPH

NORTH BOUND LANES

NEW CONSTRUCTION

1" TYPE S-III
 3" TYPE S-I
 OPTIONAL BASE GROUP 12
 TYPE B STAB (LBR 40)

SHOULDER PAVEMENT

2" TYPE S-III
 OPTIONAL BASE GROUP 4
 TYPE B STAB (LBR 40)


NORTH BOUND TRAFFIC DATA

CURRENT YEAR = 2015 AADT = 15,206
 ESTIMATED OPENING YEAR = 2016 AADT = 15,925
 ESTIMATED DESIGN YEAR = 2036 AADT = 30,313
 K = % D = 50 % T = 6 % (24 HOUR)
 DESIGN HOUR T = 6%
 DESIGN SPEED = 50 MPH

** 1:6 FOR FILLS TO 5'
 1:6 TO CLEAR ZONE & 1:4 FOR FILLS 5' TO 10'
 1:6 TO CLEAR ZONE & 1:3 FOR FILLS 10' TO 20'

*** SEE TYPICAL SECTION DETAILS FOR SB TRANSITIONS TO FLAT SLAB BRIDGES

SOUTH BOUND LANES SEE TYPICAL SECTION DETAILS FOR MILLING & RESURFACING AND SHOULDER PAVEMENT DESIGN

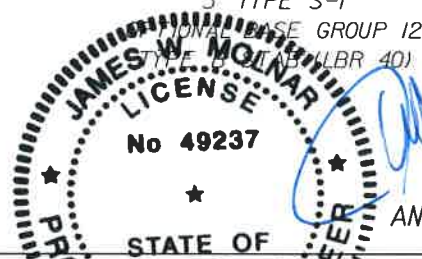

NO.	DATE	BY	REVISIONS - DESCRIPTION

T.Y. LIN INTERNATIONAL
 2400 FIRST STREET SUITE 200
 FORT MYERS, FLORIDA 33901
 TEL. (239) 332-4846 FAX. (239) 332-4798
 WWW.TYLIN.COM



DESIGNED BY
JAMES W. MOLNAR, P.E.
 REGISTERED PROFESSIONAL ENGINEER
 FLORIDA CERTIFICATE NO. 49237
 3-5-2015

PUBLIC WORKS LEE COUNTY SOUTHWEST FLORIDA
 1500 MONROE STREET FORT MYERS, FLORIDA 33901
 12391 479-8900 www.lee-county.com/publicworks/detail.htm
 rshields 3/6/2015 4:05:48 PM

DEPARTMENT of TRANSPORTATION
 FORT MYERS, FLORIDA 33901

TYPICAL SECTIONS BURNT STORE ROAD

SHEET NO. 4

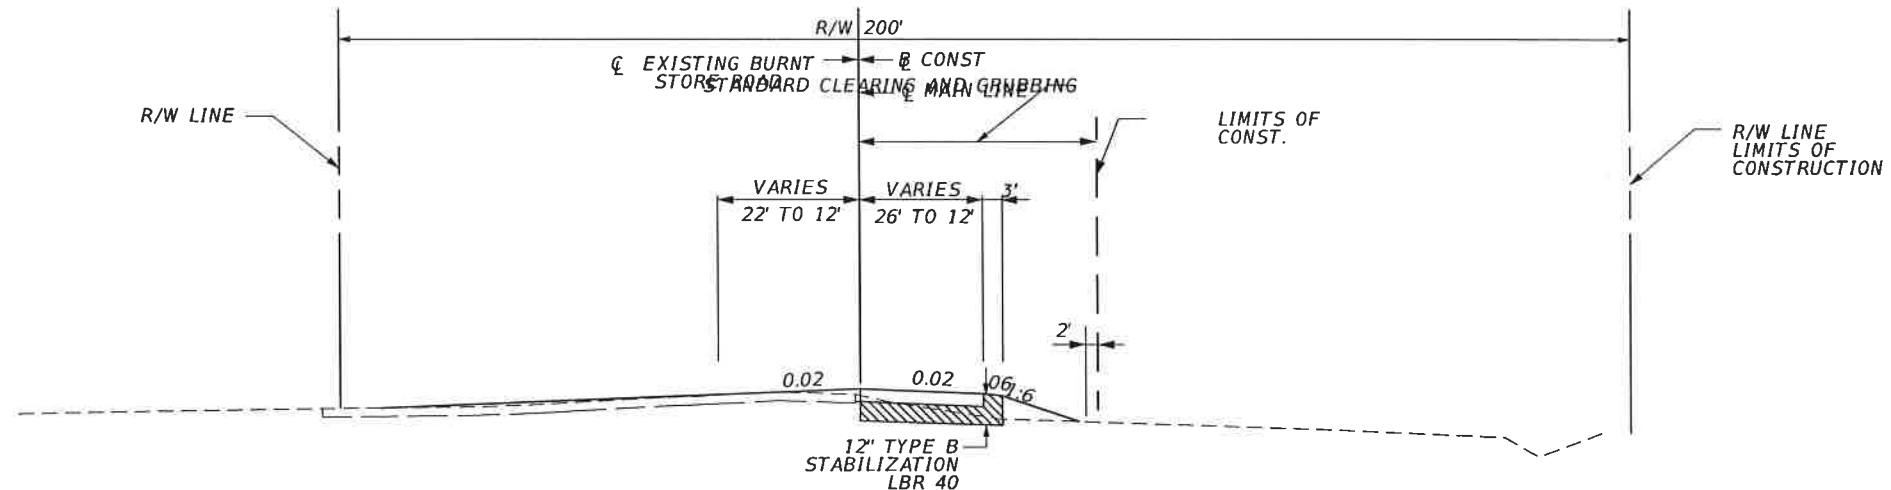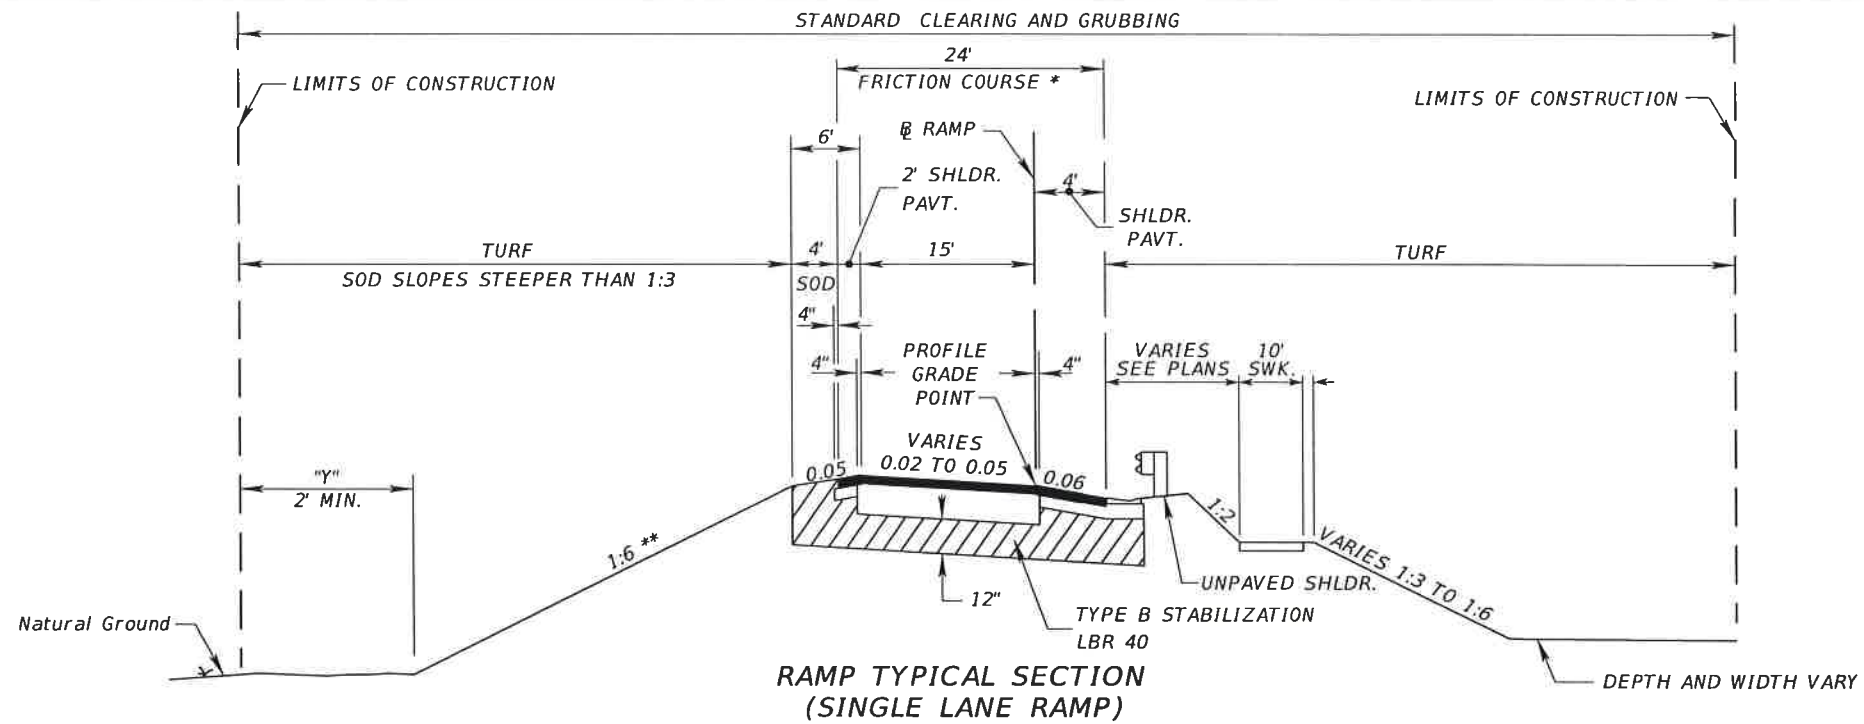

TYPICAL SECTION BURNT STORE ROAD
 STA. 1315+40.00 TO 1321+00.00 NB & SB
 WIDENING SEE TYPICAL SECTION DETAILS
 NORTH BOUND LANES

SOUTH BOUND FRONTAGE TRAFFIC DATA

CURRENT YEAR = 2015 AADT = 15,206
 ESTIMATED OPENING YEAR = 2016 AADT = 15,925
 ESTIMATED DESIGN YEAR = 2036 AADT = 30,313
 K = % D = 50 % T = 6 % (24 HOUR)
 DESIGN HOUR T = 6%
 DESIGN SPEED = 50 MPH

NEW CONSTRUCTION

1" TYPE S-III
 3" TYPE S-I
 OPTIONAL BASE GROUP 12
 TYPE B STAB (LBR 40)


SHOULDER PAVEMENT

1" TYPE S-III
 1" TYPE S-I
 OPTIONAL BASE GROUP 4
 TYPE B STAB (LBR 40)

NORTH BOUND TRAFFIC DATA

CURRENT YEAR = 2015 AADT = 15,206
 ESTIMATED OPENING YEAR = 2016 AADT = 15,925
 ESTIMATED DESIGN YEAR = 2036 AADT = 30,313
 K = % D = 50 % T = 6 % (24 HOUR)
 DESIGN HOUR T = 6%
 DESIGN SPEED = 50 MPH

SOUTH BOUND LANES SEE
 TYPICAL SECTION DETAILS
 FOR MILLING & RESURFACING
 AND SHOULDER PAVEMENT

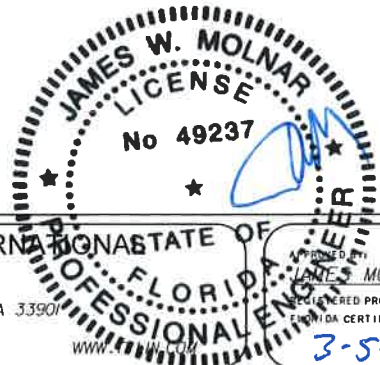

T.Y. LIN INTERNATIONAL
 2400 FIRST STREET
 SUITE 200
 FORT MYERS, FLORIDA 33901
 TEL. (239) 332-4846
 FAX. (239) 332-4798

JAMES W. MOLNAR, P.E.
 REGISTERED PROFESSIONAL ENGINEER
 FLORIDA CERTIFICATE NO. 49237
 3-5-2015


PUBLIC WORKS
 LEE COUNTY
 SOUTHWEST
 FLORIDA
 1500 MONROE STREET
 FORT MYERS, FLORIDA 33901
 12391 479-8900 www.lee-county.com/publicworks/default.htm

DEPARTMENT
 of
 TRANSPORTATION

TYPICAL SECTIONS
BURNT STORE ROAD

SHEET NO.
 5

NO.	DATE	BY	REVISIONS - DESCRIPTION

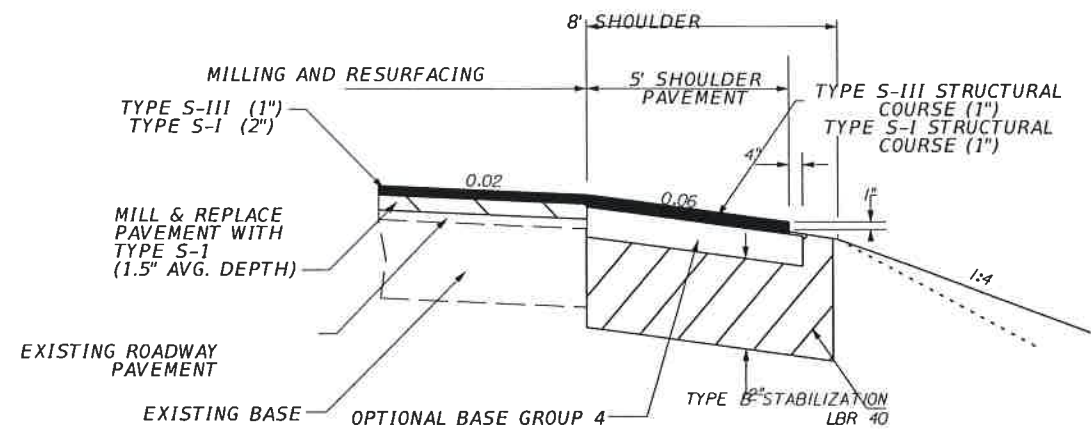


MILLING & RESURFACING & SHOULDER PAVEMENT DETAIL

WIDENING

TYPE S-III STRUCTURAL COURSE (1")
 TYPE S-1 STRUCTURAL COURSE (3.5")
 OBG 10
 TYPE B STAB (LBR 40)

SHOULDER PAVEMENT

TYPE S-III STRUCTURAL COURSE (1")
 TYPE S-1 STRUCTURAL COURSE (1")
 OPTIONAL BASE GROUP 4
 TYPE B STAB (LBR 40)

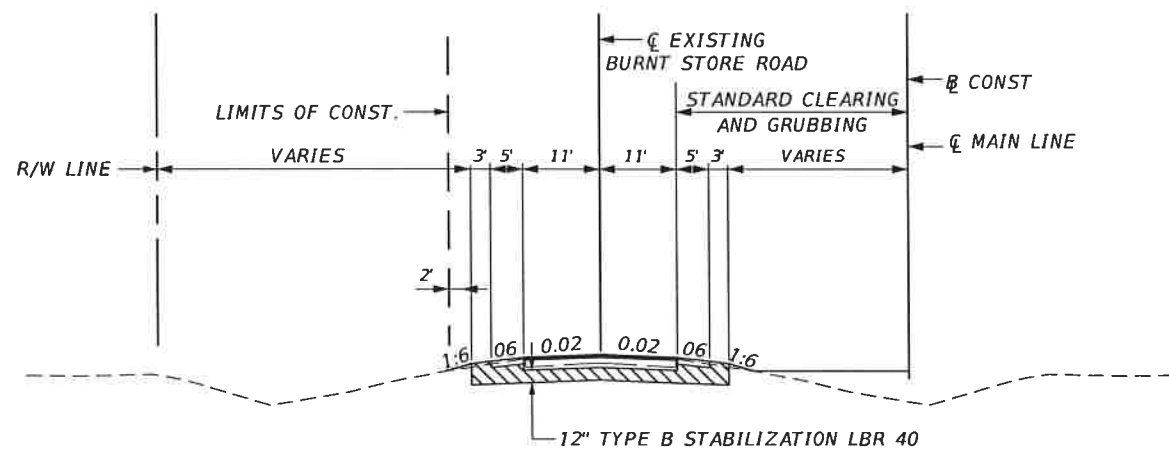


SB TYPICAL SECTION EXISTING APPROACH TO FLAT SLAB BRIDGE

NEW CONSTRUCTION

1" TYPE S-III
 3" TYPE S-1
 OPTIONAL BASE GROUP 12
 TYPE B STAB (LBR 40)


SOUTH BOUND LANES SEE TYPICAL SECTION DETAILS FOR MILLING & RESURFACING AND SHOULDER PAVEMENT

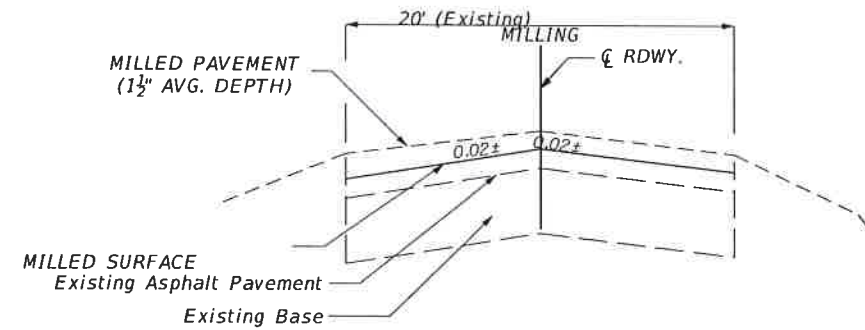


MILLING DETAIL

MILLING

MILL EXISTING ASPHALT PAVEMENT (1 1/2" AVG. DEPTH)

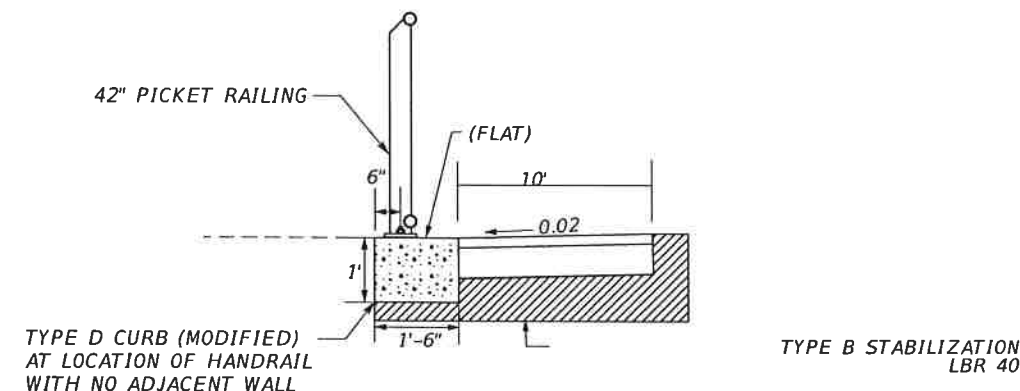


TYPE B STABILIZATION LBR 40

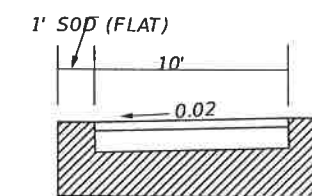

TYPE B STABILIZATION LBR 40

NEW ASPHALT PATH

S-III STRUCTURAL COURSE (1.5")
 OBG 4
 TYPE B STAB (LBR 40)

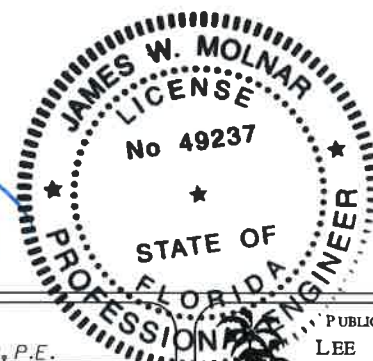

APPROVED BY:
JAMES MOLNAR, P.E.
 REGISTERED PROFESSIONAL ENGINEER
 FLORIDA CERTIFICATE NO. 49237

3-5-2015

PUBLIC WORKS
 LEE COUNTY
 SOUTHWEST
 FLORIDA
 1500 MONROE STREET
 FORT MYERS, FLORIDA 33901
 1231 479-8900 www.lee-county.com/publicworks/ast/itm.htm

rshelds 3/16/2015 4:05:50 PM

NO.	DATE	BY	REVISIONS - DESCRIPTION

T.Y. LIN INTERNATIONAL
 2400 FIRST STREET
 SUITE 200
 FORT MYERS, FLORIDA 33901
 TEL. (239) 332-4846
 FAX. (239) 332-4798
 WWW.TYLIN.COM

TYPICAL SECTIONS DETAILS
BURNT STORE ROAD

SHEET NO.
6

T:\Tampa\Legacy\Projects\581595.00_Burnt_Store_RD\Burnt_Store_roadway\TYPSEDD01.dgn

Default


SUMMARY OF LUMP SUM ITEMS

PAY ITEM NO.	PAY ITEM DESCRIPTION	QUANTITY		DESIGN NOTES	CONSTRUCTION REMARKS
		P	F		
101-1	MOBILIZATION	1			
101-1-1	AS-BUILTS	1			
101-1-4	SCHEDULE	1			
102-1	MAINTENANCE OF TRAFFIC	1		INCLUDE THE DESIGN OF TRAFFIC CONTROL PLANS BY A PROFESSIONAL ENGINEER	
110-1-1	CLEARING AND GRUBBING	1		79.25 AC TOTAL AREA INCLUDES COST OF PLUGGING SEAWALL	
455-18	PROTECTION OF EXISTING STRUCTURES	1			

SUMMARY OF EARTHWORK

PAY ITEM NO.	PAY ITEM DESCRIPTION	CY		DESIGN NOTES	CONSTRUCTION REMARKS
		P	F		
	MAINLINE EARTHWORK				
	EMBANKMENT	130887			
	EXCAVATION	31018			
	EMBANKMENT SEAWALLS	2333			
	EXCAVATION SEAWALLS	2333			
	EMBANKMENT RAMPS 1 + 2	10360			
	EXCAVATION RAMPS 1 + 2	1108			
	EMBANKMENT RAMPS 3 + 4	5057			
	EXCAVATION RAMPS 3 + 4	19			
	EMBANKMENT CROSSOVER	5000			
	EXCAVATION CROSSOVER	2000			
	TOTAL EARTHWORK				
120-6	EMBANKMENT	153637			
120-1	EXCAVATION	36478			

EARTHWORK HAS BEEN CALCULATED USING THE 12.5 INCH (NB) AND 9.5 INCH (SB) BASE OPTION. IF ANOTHER OPTION IS CONSTRUCTED, THERE SHALL BE NO COMPENSATION FOR ADDITIONAL COSTS.

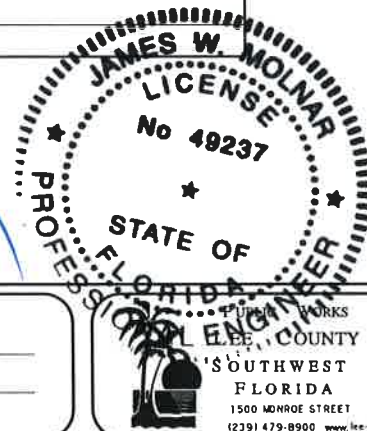

NO.	DATE	BY	REVISIONS - DESCRIPTION

T.Y. LIN INTERNATIONAL
 2400 FIRST STREET
 SUITE 200
 FORT MYERS, FLORIDA 33901
 TEL. (239) 332-4846
 FAX. (239) 332-4798
 WWW.TYLIN.COM

APPROVED BY:
JAMES MOLNAR, P.E.
 REGISTERED PROFESSIONAL ENGINEER
 FLORIDA CERTIFICATE NO. 49237
 3-5-2015

PLANNING & PUBLIC WORKS
 HIGHLAND COUNTY
 SOUTHWEST
 FLORIDA
 1500 MONROE STREET
 FORT MYERS, FLORIDA 33901
 (239) 479-8900 www.hccounty.com/publicworks/default.htm
 rshelds 3/6/2015 4:05:52 PM

SUMMARY OF QUANTITIES

BURNT STORE ROAD


SHEET NO.
 7
 Default


SUMMARY OF LITTER REMOVAL AND MOWING

CONST. PHASE	LOCATION STA. TO STA.	SIDE	DURATION (DAYS)	FREQUENCY (DAYS)	LITTER REMOVAL						MOWING						DESIGN NOTES	CONSTRUCTION REMARKS	
					0107 1						0107 2								
					AREA ID	LENGTH	WIDTH	CYCLES	AREA		AREA ID	LENGTH	WIDTH	CYCLES	AREA				
									AC/CYCLE	TOTAL (AC)					AC/CYCLE	TOTAL (AC)			
1	1218+00.00 TO 1319+00.00	LT /RT	30	30	N/A	10100.0	300.0	1	69.559	69.559	N/A	10100.0	225.0	1	52.169	52.169	TOTAL AREA PER CYCLE		
1	1218+00.00 TO 1319+00.00	LT /RT	30	30	N/A	10100.0	300.0	1	69.559	69.559	N/A	10100.0	225.0	1	52.169	52.169			
1	1218+00.00 TO 1319+00.00	LT /RT	30	30	N/A	10100.0	300.0	1	69.559	69.559	N/A	10100.0	226.0	1	52.401	52.401			
1	1218+00.00 TO 1319+00.00	LT /RT	30	30	N/A	10100.0	300.0	1	69.559	69.559	N/A	10100.0	227.0	1	52.633	52.633			
1	1218+00.00 TO 1319+00.00	LT /RT	30	30	N/A	10100.0	300.0	1	69.559	69.559	N/A	10100.0	228.0	1	52.865	52.865			
1	1218+00.00 TO 1319+00.00	LT /RT	30	30	N/A	10100.0	300.0	1	69.559	69.559	N/A	10100.0	229.0	1	53.097	53.097			
1	1218+00.00 TO 1319+00.00	LT /RT	30	30	N/A	10100.0	300.0	1	69.559	69.559	N/A	10100.0	230.0	1	53.329	53.329			
1	1218+00.00 TO 1319+00.00	LT /RT	30	30	N/A	10100.0	300.0	1	69.559	69.559	N/A	10100.0	231.0	1	53.561	53.561			
1	1218+00.00 TO 1319+00.00	LT /RT	30	30	N/A	10100.0	300.0	1	69.559	69.559	N/A	10100.0	232.0	1	53.792	53.792			
1	1218+00.00 TO 1319+00.00	LT /RT	30	30	N/A	10100.0	300.0	1	69.559	69.559	N/A	10100.0	233.0	1	54.024	54.024			
1	1218+00.00 TO 1319+00.00	LT /RT	30	30	N/A	10100.0	300.0	1	69.559	69.559	N/A	10100.0	234.0	1	54.256	54.256			
1	1218+00.00 TO 1319+00.00	LT /RT	30	30	N/A	10100.0	300.0	1	69.559	69.559	N/A	10100.0	235.0	1	54.488	54.488			
1	1218+00.00 TO 1319+00.00	LT /RT	30	30	N/A	10100.0	300.0	1	69.559	69.559	N/A	10100.0	236.0	1	54.720	54.720			
1	1218+00.00 TO 1319+00.00	LT /RT	30	30	N/A	10100.0	300.0	1	69.559	69.559	N/A	10100.0	237.0	1	54.952	54.952			
1	1218+00.00 TO 1319+00.00	LT /RT	30	30	N/A	10100.0	300.0	1	69.559	69.559	N/A	10100.0	238.0	1	55.184	55.184			
1	1218+00.00 TO 1319+00.00	LT /RT	30	30	N/A	10100.0	300.0	1	69.559	69.559	N/A	10100.0	239.0	1	55.416	55.416			
1	1218+00.00 TO 1319+00.00	LT /RT	30	30	N/A	10100.0	300.0	1	69.559	69.559	N/A	10100.0	240.0	1	55.647	55.647			
1	1218+00.00 TO 1319+00.00	LT /RT	30	30	N/A	10100.0	300.0	1	69.559	69.559	N/A	10100.0	241.0	1	55.879	55.879			
1	1218+00.00 TO 1319+00.00	LT /RT	30	30	N/A	10100.0	300.0	1	69.559	69.559	N/A	10100.0	242.0	1	56.111	56.111			
1	1218+00.00 TO 1319+00.00	LT /RT	30	30	N/A	10100.0	300.0	1	69.559	69.559	N/A	10100.0	243.0	1	56.343	56.343			
1	1218+00.00 TO 1319+00.00	LT /RT	30	30	N/A	10100.0	300.0	1	69.559	69.559	N/A	10100.0	244.0	1	56.575	56.575			
2	1218+00.00 TO 1319+00.00	LT /RT	30	30	N/A	10100.0	300.0	1	69.559	69.559	N/A	10100.0	245.0	1	56.807	56.807			
2	1218+00.00 TO 1319+00.00	LT /RT	30	30	N/A	10100.0	300.0	1	69.559	69.559	N/A	10100.0	246.0	1	57.039	57.039			
2	1218+00.00 TO 1319+00.00	LT /RT	30	30	N/A	10100.0	300.0	1	69.559	69.559	N/A	10100.0	247.0	1	57.270	57.270			
2	1218+00.00 TO 1319+00.00	LT /RT	30	30	N/A	10100.0	300.0	1	69.559	69.559	N/A	10100.0	248.0	1	57.502	57.502			
SUB-TOTAL:										1738.981	SUB-TOTAL:						1368.230		
TOTAL:										1738.98	TOTAL:						1368.23		

NO.	DATE	BY	REVISIONS - DESCRIPTION

T.Y. LIN INTERNATIONAL
 2400 FIRST STREET
 SUITE 200
 FORT MYERS, FLORIDA 33901
 TEL. (239) 332-4846
 FAX. (239) 332-4798
 WWW.TYLIN.COM

APPROVED BY:

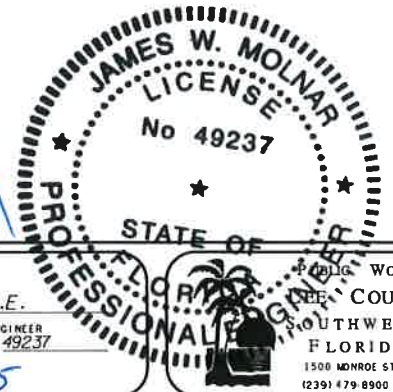JAMES MOLNAR, P.E.
 REGISTERED PROFESSIONAL ENGINEER
 FLORIDA CERTIFICATE NO. 49237
 3-5-2015



PUBLIC WORKS
 S.W. COUNTY
 SOUTHWEST
 FLORIDA
 1500 MONROE STREET
 FORT MYERS, FLORIDA 33901
 (239) 479-8900 www.sw-county.com/publicworks/dstitle.htm
 rshields 3/6/2015 4:05:53 PM

SUMMARY OF QUANTITIES


BURNT STORE ROAD

SHEET NO.
 8
 Default

SUMMARY OF GUARDRAIL

LOCATION		GUARDRAIL		BRIDGE ANCHORAGE ASSEMBLY		END ANCHORAGE ASSEMBLY		GUARDRAIL REMOVAL		RUB RAIL		DESIGN NOTES	CONSTRUCTION REMARKS
STA. TO STA.		0536 1 1		0536 8 1		0536 85 26		0536 73		0536 5 A			
		LF		EA		EA		LF		LF			
		P	F	P	F	P	F	P	F	P	F		
1247+19.07 TO 1247+86.98	RT	67.9											
1244+60.00 TO 1247+19.07	RT	259.1											
1250+33.07 TO 1254+00.00	RT	366.9											
1259+44.21 TO 1260+43.32	RT	99.1											
1287+70.26 TO 1288+38.16	RT	67.9											
1290+32.42 TO 1293+00.00	RT	267.6											
1285+00.00 TO 1287+70.26	RT	270.3											
1304+78.21 TO 1305+45.46	RT	67.3											
1305+45.46 TO 1308+83.62	RT	338.2											
1246+98.50 TO 1247+86.98	RT	88.5											
1250+33.07 TO 1252+08.61	RT	175.5											
1285+00.00 TO 1288+38.16	RT	338.2											
1290+32.42 TO 1291+22.77	RT	90.4											
1304+77.53 TO 1305+45.45	RT	67.9											
1308+33.70 TO 1309+20.77	RT	87.1											
1309+20.77 TO 1312+07.94	RT	287.2											
	RT			8								AT BRIDGES	
1244+60.00	RT					1						CRT	
1246+98.51	RT					1						CRT	
1252+08.61	RT					1						CRT	
1254+00.00	RT					1						CRT	
1291+22.56	RT					1						CRT	
1293+00.00	RT					1						CRT	
1285+00.00	RT					1						CRT	
1284+99.98	RT					1						CRT	
1304+78.22	RT					1						CRT	
1304+77.53	RT					1						CRT	
1308+83.60	RT					1						CRT	
1312+07.94	RT					1						CRT	
1259+44.21	RT					1						FLARED 536-85-22	
1298+23.68 TO 1299+95.93	LT							172.3					
SUB-TOTAL:		2939		8		13		172					
TOTAL:		2939		8		13		172					

ALL GUARDRAIL TO BE SET AT 12.5 INCREMENTS WITH ADJUSTMENTS FOR BRIDGE CONNECTION AND END TREATMENTS

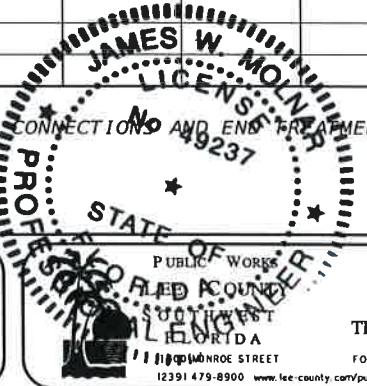

NO.	DATE	BY	REVISIONS - DESCRIPTION

T.Y. LIN INTERNATIONAL
 2400 FIRST STREET
 SUITE 200
 FORT MYERS, FLORIDA 33901
 TEL. (239) 332-4846
 FAX. (239) 332-4798
 WWW.TYLIN.COM

APPROVED BY:
JAMES MOLNAR, P.E.
 REGISTERED PROFESSIONAL ENGINEER
 FLORIDA CERTIFICATE NO. 19237
 3-5-2015


DEPARTMENT of TRANSPORTATION
 FORT MYERS, FLORIDA 33901
 12391 479-8900 www.fcc-county.com/publicworks/dotlike.htm
 3/6/2015 4:05:55 PM

SUMMARY OF QUANTITIES
BURNT STORE ROAD

SHEET NO.
 10
 Default

SUMMARY OF PAVEMENT

PAY ITEM NO.	PAY ITEM DESCRIPTION	LOCATION		SIDE	AREA ID	LENGTH	WIDTH	UNIT	QUANTITY		TOTAL		DESIGN NOTES	CONSTRUCTION REMARKS
		STA. TO STA.	DESCRIPTION						P	F	P	F		
0327-70-6	MILLING EXISTING ASPHALT PAVEMENT, 1.5 INCH AVG.	1218+63.02 TO 1247+19.31	SOUTHBOUND ROADWAY	LT	N/A	2856	VARIES	SY	8998					
0327-70-6	MILLING EXISTING ASPHALT PAVEMENT, 1.5 INCH AVG.	1248+28.83 TO 1249+72.94	SOUTHBOUND ROADWAY	LT	N/A	144	VARIES	SY	645					
0327-70-6	MILLING EXISTING ASPHALT PAVEMENT, 1.5 INCH AVG.	1250+99.31 TO 1287+64.98	SOUTHBOUND ROADWAY	LT	N/A	3666	VARIES	SY	10889					
0327-70-6	MILLING EXISTING ASPHALT PAVEMENT, 1.5 INCH AVG.	1288+89.24 TO 1289+62.46	SOUTHBOUND ROADWAY	LT	N/A	73	VARIES	SY	323					
0327-70-6	MILLING EXISTING ASPHALT PAVEMENT, 1.5 INCH AVG.	1290+84.98 TO 1304+71.13	SOUTHBOUND ROADWAY	LT	N/A	1386	VARIES	SY	4472					
0327-70-6	MILLING EXISTING ASPHALT PAVEMENT, 1.5 INCH AVG.	1305+81.27 TO 1307+97.43	SOUTHBOUND ROADWAY	LT	N/A	216	VARIES	SY	971					
0327-70-6	MILLING EXISTING ASPHALT PAVEMENT, 1.5 INCH AVG.	1309+30.91 TO 1321+05.43	SOUTHBOUND ROADWAY	LT	N/A	1175	VARIES	SY	3233					
	TOTAL							SY	29531					
0160-4	TYPE B STABILIZATION	1218+00.00 TO 1319+00.00	SOUTHBOUND INSIDE SHLD	LT	N/A	10100	8.0	SY	8978					
0160-4	TYPE B STABILIZATION	1218+00.00 TO 1319+00.00	SOUTHBOUND OUTSIDE SHLD	LT	N/A	10100	8.0	SY	8978					
0160-4	TYPE B STABILIZATION	1218+00.00 TO 1319+00.00	CROSSOVER SHOULDERS	MEDIAN	N/A	1600	16.0	SY	2844				TOT SHLD WIDTH 8'+8'=16'	
0160-4	TYPE B STABILIZATION	1218+84.00 TO 1247+70.00	MEDIAN AND NB MAINLINE	RT	26582	2886	VARIES	SY	11754					
0160-4	TYPE B STABILIZATION	1250+33.00 TO 1288+20.00	MEDIAN AND NB MAINLINE	RT	26759	3787	VARIES	SY	15925					
0160-4	TYPE B STABILIZATION	1290+32.00 TO 1305+45.00	MEDIAN AND NB MAINLINE	RT	26792	1513	VARIES	SY	5751					
0160-4	TYPE B STABILIZATION	1308+33.00 TO 1321+05.00	MEDIAN AND NB MAINLINE	RT	26738	1272	VARIES	SY	2940					
0160-4	TYPE B STABILIZATION	1218+00.00 TO 1247+70.00	NB OUTSIDE SHOULDERS	RT	N/A	2970	8.0	SY	2640					
0160-4	TYPE B STABILIZATION	1250+25.00 TO 1288+20.00	NB OUTSIDE SHOULDERS	RT	N/A	3795	8.0	SY	3373					
0160-4	TYPE B STABILIZATION	1290+25.00 TO 1305+40.00	NB OUTSIDE SHOULDERS	RT	N/A	1515	8.0	SY	1347					
0160-4	TYPE B STABILIZATION	1308+30.00 TO 1321+30.00	NB OUTSIDE SHOULDERS	RT	N/A	1300	8.0	SY	1156					
0160-4	TYPE B STABILIZATION	1218+00.00 TO 1247+70.00	NB INSIDE SHOULDERS	RT	N/A	2970	3.0	SY	990					
0160-4	TYPE B STABILIZATION	1250+25.00 TO 1288+20.00	NB INSIDE SHOULDERS	RT	N/A	3795	3.0	SY	1265					
0160-4	TYPE B STABILIZATION	1290+25.00 TO 1305+40.00	NB INSIDE SHOULDERS	RT	N/A	1515	3.0	SY	505					
0160-4	TYPE B STABILIZATION	1308+30.00 TO 1321+30.00	NB INSIDE SHOULDERS	RT	N/A	1300	3.0	SY	433					
0160-4	TYPE B STABILIZATION FOR PATH	1219+40.00 TO 1312+94.00	FACTOR PATH ASPHALT	RT	N/A	9354	12.0	SY	15441				FACTOR = 1.2	
0160-4	TYPE B STABILIZATION	1+00.00 TO 5+59.91	RAMP 1	RT	N/A	460	VARIES	SY	1039					
0160-4	TYPE B STABILIZATION	1+00.00 TO 4+57.20	RAMP 2	RT	N/A	357	VARIES	SY	732					
0160-4	TYPE B STABILIZATION	1+00.00 TO 3+80.00	RAMP 3	RT	N/A	280	VARIES	SY	887					
0160-4	TYPE B STABILIZATION	3+00.00 TO 5+87.09	RAMP 4	RT	N/A	287	VARIES	SY	827					
0160-4	TYPE B STABILIZATION	1234+41.73 TO 1238+87.33	SB TURN LANE	LT	N/A	446	VARIES	SY	669					
0160-4	TYPE B STABILIZATION	1247+19.31 TO 1248+28.83	SB NEW CONST.	LT	N/A	110	VARIES	SY	268					
0160-4	TYPE B STABILIZATION	1249+72.94 TO 1251+19.56	SB NEW CONST.	LT	N/A	147	VARIES	SY	343					
0160-4	TYPE B STABILIZATION	1263+25.16 TO 1265+74.31	SB TURN LANE	LT	N/A	249	VARIES	SY	339					
0160-4	TYPE B STABILIZATION	1287+40.88 TO 1288+89.24	SB NEW CONST.	LT	N/A	148	VARIES	SY	334					
0160-4	TYPE B STABILIZATION	1289+65.52 TO 1291+11.88	SB NEW CONST.	LT	N/A	146	VARIES	SY	334					
0160-4	TYPE B STABILIZATION	1304+71.13 TO 1305+81.27	SB NEW CONST.	LT	N/A	110	VARIES	SY	271					
0160-4	TYPE B STABILIZATION	1307+94.43 TO 1309+30.91	SB NEW CONST.	LT	N/A	136	VARIES	SY	325					
0160-4	TYPE B STABILIZATION	1218+63.02 TO 1321+30.00	MISC WIDENING SIDE ST RADIUS	LT	N/A	10267	VARIES	SY	325					
	TOTAL							SY	88743					

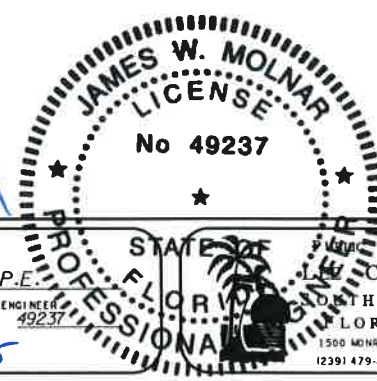

NO.	DATE	BY	REVISIONS - DESCRIPTION

T.Y. LIN INTERNATIONAL
 2400 FIRST STREET
 SUITE 200
 FORT MYERS, FLORIDA 33901
 TEL. (239) 332-4846
 FAX. (239) 332-4798
 WWW.TYLIN.COM

APPROVED BY:
JAMES MOLNAR, P.E.
 REGISTERED PROFESSIONAL ENGINEER
 FLORIDA CERTIFICATE NO. 49237
 3-5-2015

STATE OF FLORIDA
 PROFESSIONAL ENGINEER

WORKS DEPARTMENT
 COUNTY of
 TRANSPORTATION
 1500 MONROE STREET
 FORT MYERS, FLORIDA 33901
 (239) 479-8900 www.fsc.state.fl.us/publicworks/default.htm
 rsh/elds: 3/6/2015 4:05:58 PM

SUMMARY OF QUANTITIES

BURNT STORE ROAD

SHEET NO.
 12

SUMMARY OF PAVEMENT

PAY ITEM NO.	PAY ITEM DESCRIPTION	LOCATION		SIDE	AREA ID	LENGTH	WIDTH	UNIT	QUANTITY		TOTAL		DESIGN NOTES	CONSTRUCTION REMARKS
		STA. TO STA.	DESCRIPTION						P	F	P	F		
0285-708	OPTIONAL BASE GROUP 4 FOR PATH	1219+40.00 TO 1312+94.00	FACTOR PATH ASPHALT	RT	N/A	9354	10.660	SY	550				FACTOR = 1.066	
0285-708	OPTIONAL BASE GROUP 4	1218+00.00 TO 1319+00.00	SOUTHBOUND INSIDE SHLD	LT	N/A	10100	5.333	SY	5985					
0285-708	OPTIONAL BASE GROUP 4	1218+00.00 TO 1319+00.00	SOUTHBOUND OUTSIDE SHLD	LT	N/A	10100	5.300	SY	5948					
0285-704	OPTIONAL BASE GROUP 4	1218+00.00 TO 1247+70.00	NB SHOULDERS	RT	N/A	2970	5.300	SY	1749				NB PAVED SHLD WIDTH+ 4IN	
0285-704	OPTIONAL BASE GROUP 4	1250+25.00 TO 1288+20.00	NB SHOULDERS	RT	N/A	3795	5.300	SY	2235					
0285-704	OPTIONAL BASE GROUP 4	1290+25.00 TO 1305+40.00	NB SHOULDERS	RT	N/A	1515	5.000	SY	842					
0285-704	OPTIONAL BASE GROUP 4	1308+30.00 TO 1321+30.00	NB SHOULDERS	RT	N/A	1300	5.300	SY	766					
0285-704	OPTIONAL BASE GROUP 4	1218+00.00 TO 1319+00.00	CROSSOVER SHOULDERS	MEDIAN	N/A	1600	8.600	SY	1529				SHLD WIDTH 3.3'+5.3'=8.6'	
0285-704	OPTIONAL BASE GROUP 4	1+00.00 TO 5+59.91	RAMP 1 SHOULDERS	LT/RT	N/A	460	VARIES	SY	233					
0285-704	OPTIONAL BASE GROUP 4	1+00.00 TO 4+57.20	RAMP 2 SHOULDERS	LT/RT	N/A	357	VARIES	SY	99					
0285-704	OPTIONAL BASE GROUP 4	1+00.00 TO 3+80.00	RAMP 3 SHOULDERS	LT/RT	N/A	280	VARIES	SY	157					
0285-704	OPTIONAL BASE GROUP 4	3+00.00 TO 5+87.09	RAMP 4 SHOULDERS	LT/RT	N/A	287	VARIES	SY	180					
	TOTAL							SY	20272					
0285-712	OPTIONAL BASE GROUP 12	1218+84.00 TO 1247+70.00	MEDIAN AND NB MAINLINE	RT	26582	2886	VARIES	SY	11754					
0285-712	OPTIONAL BASE GROUP 12	1250+33.00 TO 1288+20.00	MEDIAN AND NB MAINLINE	RT	26759	3787	VARIES	SY	15925					
0285-712	OPTIONAL BASE GROUP 12	1290+32.00 TO 1305+45.00	MEDIAN AND NB MAINLINE	RT	26792	1513	VARIES	SY	5751					
0285-712	OPTIONAL BASE GROUP 12	1308+33.00 TO 1321+05.00	MEDIAN AND NB MAINLINE	RT	26738	1272	VARIES	SY	2940					
0285-712	OPTIONAL BASE GROUP 12	1234+41.73 TO 1238+87.33	SB TURN LANE	LT	N/A	446	VARIES	SY	669					
0285-712	OPTIONAL BASE GROUP 12	1247+19.31 TO 1248+28.83	SB NEW CONST.	LT	N/A	110	VARIES	SY	268					
0285-712	OPTIONAL BASE GROUP 12	1249+72.94 TO 1251+19.56	SB NEW CONST.	LT	N/A	147	VARIES	SY	343					
0285-712	OPTIONAL BASE GROUP 12	1263+25.16 TO 1265+74.31	SB TURN LANE	LT	N/A	249	VARIES	SY	339					
0285-712	OPTIONAL BASE GROUP 12	1287+40.88 TO 1288+89.24	SB NEW CONST.	LT	N/A	148	VARIES	SY	334					
0285-712	OPTIONAL BASE GROUP 12	1289+65.52 TO 1291+11.88	SB NEW CONST.	LT	N/A	146	VARIES	SY	334					
0285-712	OPTIONAL BASE GROUP 12	1304+71.13 TO 1305+81.27	SB NEW CONST.	LT	N/A	110	VARIES	SY	271					
0285-712	OPTIONAL BASE GROUP 12	1307+94.43 TO 1309+30.91	SB NEW CONST.	LT	N/A	136	VARIES	SY	325					
0285-712	OPTIONAL BASE GROUP 12	1218+63.02 TO 1321+30.00	MISC WIDENING SIDE ST RADIUS	LT	N/A	10267	VARIES	SY	325					
0285-712	OPTIONAL BASE GROUP 12	1+00.00 TO 5+59.91	RAMP 1	RT	N/A	460	VARIES	SY	806					
0285-712	OPTIONAL BASE GROUP 12	1+00.00 TO 4+57.20	RAMP 2	RT	N/A	357	VARIES	SY	633					
0285-712	OPTIONAL BASE GROUP 12	1+00.00 TO 3+80.00	RAMP 3	RT	N/A	280	VARIES	SY	730					
0285-712	OPTIONAL BASE GROUP 12	3+00.00 TO 5+87.09	RAMP 4	RT	N/A	287	VARIES	SY	647					
	TOTAL								42396					



NO.	DATE	BY	REVISIONS - DESCRIPTION

T.Y. LIN INTERNATIONAL
 2400 FIRST STREET
 SUITE 200
 FORT MYERS, FLORIDA 33901
 TEL. (239) 332-4846
 FAX. (239) 332-4798
 WWW.TYLIN.COM

APPROVED BY:
JAMES MOLNAR, P.E.
 REGISTERED PROFESSIONAL ENGINEER
 FLORIDA CERTIFICATE NO. 49237
 3-5-2015

PUBLIC WORKS
LEE COUNTY
 SOUTHWEST
 FLORIDA
 1500 MONROE STREET
 FORT MYERS, FLORIDA 33901
 (239) 479-8900 www.lee-county.com/publicworks/default.htm


SUMMARY OF QUANTITIES

BURNT STORE ROAD

SHEET NO.
 12 A

SUMMARY OF PAVEMENT

PAY ITEM NO.	PAY ITEM DESCRIPTION	LOCATION		SIDE	AREA ID	LENGTH	WIDTH	UNIT	QUANTITY		TOTAL		DESIGN NOTES	CONSTRUCTION REMARKS
		STA. TO STA.	DESCRIPTION						P	F	P	F		
0334-1-13	ASPHALT CONCRETE 1 INCH THICK (FC)-S3	1218+84.00 TO 1247+70.00	MEDIAN AND NB MAINLINE	RT	26582	2886.0	VARIES	TN	646					
0334-1-13	ASPHALT CONCRETE 1 INCH THICK (FC)-S3	1250+33.00 TO 1288+20.00	MEDIAN AND NB MAINLINE	RT	26759	3787.0	VARIES	TN	876					
0334-1-13	ASPHALT CONCRETE 1 INCH THICK (FC)-S3	1290+32.00 TO 1305+45.00	MEDIAN AND NB MAINLINE	RT	26792	1513.0	VARIES	TN	316					
0334-1-13	ASPHALT CONCRETE 1 INCH THICK (FC)-S3	1308+33.00 TO 1321+05.00	MEDIAN AND NB MAINLINE	RT	26738	1272.0	VARIES	TN	162					
0334-1-13	S-111 ASPHALT CONCRETE 1 INCH THICK (FC /STRUCT.)	1218+00.00 TO 1319+00.00	SB OUTSIDE SHOULDERS	LT	N/A	10100.0	5.3	TN	2944					
0334-1-13	S-111 ASPHALT CONCRETE 1 INCH THICK (FC /STRUCT.)	1218+00.00 TO 1319+00.00	SB INSIDE SHOULDERS	LT	N/A	10100.0	4.3	TN	2389					
0334-1-13	S-111 ASPHALT CONCRETE 1 INCH THICK (FC /STRUCT.)	1218+00.00 TO 1247+70.00	NB OUTSIDE SHOULDERS	RT	N/A	2970.0	5.3	TN	866					
0334-1-13	S-111 ASPHALT CONCRETE 1 INCH THICK (FC /STRUCT.)	1250+25.00 TO 1288+20.00	NB OUTSIDE SHOULDERS	RT	N/A	3795.0	5.3	TN	1106					
0334-1-13	S-111 ASPHALT CONCRETE 1 INCH THICK (FC /STRUCT.)	1290+25.00 TO 1305+40.00	NB OUTSIDE SHOULDERS	RT	N/A	1515.0	5.3	TN	442					
0334-1-13	S-111 ASPHALT CONCRETE 1 INCH THICK (FC /STRUCT.)	1308+30.00 TO 1321+30.00	NB OUTSIDE SHOULDERS	RT	N/A	1300.0	5.3	TN	379					
0334-1-13	ASPHALT CONCRETE 1 INCH THICK (FC)-S3	1+00.00 TO 5+59.91	RAMP 1	RT	N/A	459.9	VARIES	TN	44				AREA=7252.44/9	
0334-1-13	ASPHALT CONCRETE 1 INCH THICK (FC)-S3	1+00.00 TO 4+57.20	RAMP 2	RT	N/A	357.2	VARIES	TN	35				AREA=5697.04/9	
0334-1-13	ASPHALT CONCRETE 1 INCH THICK (FC)-S3	1+00.00 TO 3+80.00	RAMP 3	RT	N/A	280.0	VARIES	TN	40				AREA=6573.87/9	
0334-1-13	ASPHALT CONCRETE 1 INCH THICK (FC)-S3	3+00.00 TO 5+87.09	RAMP 4	RT	N/A	287.1	VARIES	TN	36				AREA=5826.80/9	
0334-1-13	S-111 ASPHALT CONCRETE 1 INCH THICK (FC /STRUCT.)	1+00.00 TO 5+59.91	RAMP 1 SHOULDER	RT	N/A	459.9	VARIES	TN	13				AREA=2101/9	
0334-1-13	S-111 ASPHALT CONCRETE 1 INCH THICK (FC /STRUCT.)	1+00.00 TO 4+57.20	RAMP 2 SHOULDER	RT	N/A	357.2	VARIES	TN	5				AREA=891.97/9	
0334-1-13	S-111 ASPHALT CONCRETE 1 INCH THICK (FC /STRUCT.)	1+00.00 TO 3+80.00	RAMP 3 SHOULDER	RT	N/A	280.0	VARIES	TN	9				AREA=1411.61/9	
0334-1-13	S-111 ASPHALT CONCRETE 1 INCH THICK (FC /STRUCT.)	3+00.00 TO 5+87.09	RAMP 4 SHOULDER	RT	N/A	287.1	VARIES	TN	10				AREA=1618.47/9	
0334-1-13	S-111 ASPHALT CONCRETE 1.5 INCH THICK (PATH ASPHALT)	1219+40.00 TO 1237+90.00	PATH ASPHALT	RT	29097	1850.0	10.0	TN	169					
0334-1-13	S-111 ASPHALT CONCRETE 1.5 INCH THICK (PATH ASPHALT)	1238+20.00 TO 1245+00.00	PATH ASPHALT	RT	29094	680.0	10.0	TN	74					
0334-1-13	S-111 ASPHALT CONCRETE 1.5 INCH THICK (PATH ASPHALT)	1245+10.00 TO 1246+40.00	PATH ASPHALT	RT	29093	130.0	10.0	TN	12					
0334-1-13	S-111 ASPHALT CONCRETE 1.5 INCH THICK (PATH ASPHALT)	1246+60.00 TO 1248+25.00	PATH ASPHALT	RT	29092	165.0	10.0	TN	61					
0334-1-13	S-111 ASPHALT CONCRETE 1.5 INCH THICK (PATH ASPHALT)	1249+70.00 TO 1249+80.00	PATH ASPHALT	RT	29099	10.0	10.0	TN	169					
0334-1-13	S-111 ASPHALT CONCRETE 1.5 INCH THICK (PATH ASPHALT)	1263+10.00 TO 1280+85.00	PATH ASPHALT	RT	29102	1775.0	10.0	TN	164					
0334-1-13	S-111 ASPHALT CONCRETE 1.5 INCH THICK (PATH ASPHALT)	1281+20.00 TO 1288+92.00	PATH ASPHALT	RT	29108	772.0	10.0	TN	136					
0334-1-13	S-111 ASPHALT CONCRETE 1.5 INCH THICK (PATH ASPHALT)	1289+50.00 TO 1292+00.00	PATH ASPHALT	RT	29114	250.0	10.0	TN	89					
0334-1-13	S-111 ASPHALT CONCRETE 1.5 INCH THICK (PATH ASPHALT)	1291+20.00 TO 1291+40.00	PATH ASPHALT	RT	29116	20.0	10.0	TN	2					
0334-1-13	S-111 ASPHALT CONCRETE 1.5 INCH THICK (PATH ASPHALT)	1291+80.00 TO 1305+40.00	PATH ASPHALT	RT	29117	1360.0	10.0	TN	142					
0334-1-13	S-111 ASPHALT CONCRETE 1.5 INCH THICK (PATH ASPHALT)	1308+15.00 TO 1312+94.00	PATH ASPHALT	RT	29121	479.0	10.0	TN	43					
0334-1-13	ASPHALT CONCRETE 1 INCH THICK (FC)-S3	1234+41.73 TO 1238+87.33	SB TURN LANE	LT	N/A	445.6	VARIES	TN	37					
0334-1-13	ASPHALT CONCRETE 1 INCH THICK (FC)-S3	1247+19.31 TO 1248+28.83	SB NEW CONST.	LT	N/A	109.5	VARIES	TN	15					
0334-1-13	ASPHALT CONCRETE 1 INCH THICK (FC)-S3	1249+72.94 TO 1251+19.56	SB NEW CONST.	LT	N/A	146.6	VARIES	TN	19					
0334-1-13	ASPHALT CONCRETE 1 INCH THICK (FC)-S3	1263+25.16 TO 1265+74.31	SB TURN LANE	LT	N/A	249.1	VARIES	TN	19					
0334-1-13	ASPHALT CONCRETE 1 INCH THICK (FC)-S3	1287+40.88 TO 1288+89.24	SB NEW CONST.	LT	N/A	148.4	VARIES	TN	18					
0334-1-13	ASPHALT CONCRETE 1 INCH THICK (FC)-S3	1289+65.52 TO 1291+11.88	SB NEW CONST.	LT	N/A	146.4	VARIES	TN	18					
0334-1-13	ASPHALT CONCRETE 1 INCH THICK (FC)-S3	1304+71.13 TO 1305+81.27	SB NEW CONST.	LT	N/A	110.1	VARIES	TN	15					
0334-1-13	ASPHALT CONCRETE 1 INCH THICK (FC)-S3	1307+94.43 TO 1309+30.91	SB NEW CONST.	LT	N/A	136.5	VARIES	TN	18					
0334-1-13	ASPHALT CONCRETE 1 INCH THICK (FC)-S3	1218+63.02 TO 1321+30.00	MISC WIDENING SIDE ST RADIUS	LT	N/A	10267.0	VARIES	TN	18					
	TOTAL								11555					

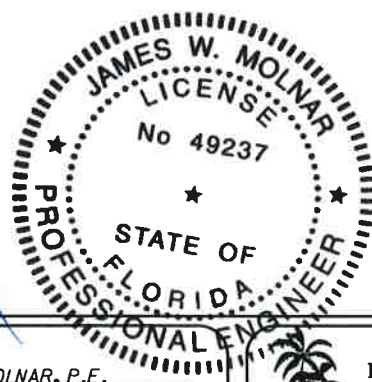

[Handwritten Signature]

APPROVED BY:
JAMES MOLNAR, P.E.
 REGISTERED PROFESSIONAL ENGINEER
 FLORIDA CERTIFICATE NO. 49237
 3-5-2015

PUBLIC WORKS
 LEE COUNTY
 SOUTHWEST
 FLORIDA
 1500 MONROE STREET
 FORT MYERS, FLORIDA 33901
 (239) 479-8900 www.lee-county.com/publicworks/default.htm

SUMMARY OF QUANTITIES
BURNT STORE ROAD


NO.	DATE	BY	REVISIONS - DESCRIPTION

T.Y. LIN INTERNATIONAL
 2400 FIRST STREET
 SUITE 200
 FORT MYERS, FLORIDA 33901
 TEL. (239) 332-4846
 FAX. (239) 332-4798
 WWW.TYLIN.COM

SHEET NO.
13

SUMMARY OF PAVEMENT

PAY ITEM NO.	PAY ITEM DESCRIPTION	LOCATION		SIDE	AREA ID	LENGTH	WIDTH	UNIT	QUANTITY		TOTAL		DESIGN NOTES	CONSTRUCTION REMARKS
		STA. TO STA.	DESCRIPTION						P	F	P	F		
0334-1-13	ASPHALT CONCRETE 1.5 INCH THICK (FC)-S1	1218+63.02 TO 1247+19.31	SOUTHBOUND RESURFACING	LT	N/A	2856.3	VARIES	TN	742					
0334-1-13	ASPHALT CONCRETE 1.5 INCH THICK (FC)-S1	1248+28.83 TO 1249+72.94	SOUTHBOUND RESURFACING	LT	N/A	144.1	VARIES	TN	53					
0334-1-13	ASPHALT CONCRETE 1.5 INCH THICK (FC)-S1	1250+99.31 TO 1287+64.98	SOUTHBOUND RESURFACING	LT	N/A	3665.7	VARIES	TN	898					
0334-1-13	ASPHALT CONCRETE 1.5 INCH THICK (FC)-S1	1288+89.24 TO 1289+62.46	SOUTHBOUND RESURFACING	LT	N/A	73.2	VARIES	TN	27					
0334-1-13	ASPHALT CONCRETE 1.5 INCH THICK (FC)-S1	1290+84.98 TO 1304+71.13	SOUTHBOUND RESURFACING	LT	N/A	1386.2	VARIES	TN	369					
0334-1-13	ASPHALT CONCRETE 1.5 INCH THICK (FC)-S1	1305+81.27 TO 1307+97.43	SOUTHBOUND RESURFACING	LT	N/A	216.2	VARIES	TN	80					
0334-1-13	ASPHALT CONCRETE 1.5 INCH THICK (FC)-S1	1309+30.91 TO 1321+05.43	SOUTHBOUND RESURFACING	LT	N/A	1174.5	VARIES	TN	267					
0334-1-13	S-1 ASPHALT CONCRETE 1 INCH THICK (FC /STRUCT.)	1218+00.00 TO 1319+00.00	SB OUTSIDE SHOULDERS	LT	N/A	10100.0	5.3	TN	2944					
0334-1-13	S-1 ASPHALT CONCRETE 1 INCH THICK (FC /STRUCT.)	1218+00.00 TO 1319+00.00	SB INSIDE SHOULDERS	LT	N/A	10100.0	4.3	TN	2389					
0334-1-13	S-1 ASPHALT CONCRETE 1 INCH THICK (FC /STRUCT.)	1218+00.00 TO 1247+70.00	NB OUTSIDE SHOULDERS	RT	N/A	2970.0	5.3	TN	866					
0334-1-13	S-1 ASPHALT CONCRETE 1 INCH THICK (FC /STRUCT.)	1250+25.00 TO 1288+20.00	NB OUTSIDE SHOULDERS	RT	N/A	3795.0	5.3	TN	1106					
0334-1-13	S-1 ASPHALT CONCRETE 1 INCH THICK (FC /STRUCT.)	1290+25.00 TO 1305+40.00	NB OUTSIDE SHOULDERS	RT	N/A	1515.0	5.3	TN	442					
0334-1-13	S-1 ASPHALT CONCRETE 1 INCH THICK (FC /STRUCT.)	1308+30.00 TO 1321+30.00	NB OUTSIDE SHOULDERS	RT	N/A	1300.0	5.3	TN	379					
0334-1-13	S1 ASPHALT CONCRETE 3 INCH THICK STRUCT. COURSE	1+00.00 TO 5+59.91	RAMP 1	RT	N/A	459.9	VARIES	TN	133				AREA=7252.44/9	
0334-1-13	S1 ASPHALT CONCRETE 3 INCH THICK STRUCT. COURSE	1+00.00 TO 4+57.20	RAMP 2	RT	N/A	357.2	VARIES	TN	104				AREA=5697.04/9	
0334-1-13	S1 ASPHALT CONCRETE 3 INCH THICK STRUCT. COURSE	1+00.00 TO 3+80.00	RAMP 3	RT	N/A	280.0	VARIES	TN	121				AREA=6573.87/9	
0334-1-13	S1 ASPHALT CONCRETE 3 INCH THICK STRUCT. COURSE	3+00.00 TO 5+87.09	RAMP 4	RT	N/A	287.1	VARIES	TN	107				AREA=5826.80/9	
0334-1-13	S-1 ASPHALT CONCRETE 1 INCH THICK (FC /STRUCT.)	1+00.00 TO 5+59.91	RAMP 1 SHOULDER	RT	N/A	459.9	VARIES	TN	13				AREA=2101/9	
0334-1-13	S-1 ASPHALT CONCRETE 1 INCH THICK (FC /STRUCT.)	1+00.00 TO 4+57.20	RAMP 2 SHOULDER	RT	N/A	357.2	VARIES	TN	5				AREA=891.97/9	
0334-1-13	S-1 ASPHALT CONCRETE 1 INCH THICK (FC /STRUCT.)	1+00.00 TO 3+80.00	RAMP 3 SHOULDER	RT	N/A	280.0	VARIES	TN	9				AREA=1411.61/9	
0334-1-13	S-1 ASPHALT CONCRETE 1 INCH THICK (FC /STRUCT.)	3+00.00 TO 5+87.09	RAMP 4 SHOULDER	RT	N/A	287.1	VARIES	TN	10				AREA=1618.47/9	
0334-1-13	S1 ASPHALT CONCRETE 3 INCH THICK STRUCT. COURSE	1218+84.00 TO 1247+70.00	MEDIAN AND NB MAINLINE	RT	26582	2886.0	VARIES	TN	1939				2 LIFTS	
0334-1-13	S1 ASPHALT CONCRETE 3 INCH THICK STRUCT. COURSE	1250+33.00 TO 1288+20.00	MEDIAN AND NB MAINLINE	RT	26759	3787.0	VARIES	TN	2628				2 LIFTS	
0334-1-13	S1 ASPHALT CONCRETE 3 INCH THICK STRUCT. COURSE	1290+32.00 TO 1305+45.00	MEDIAN AND NB MAINLINE	RT	26792	1513.0	VARIES	TN	949				2 LIFTS	
0334-1-13	S1 ASPHALT CONCRETE 3 INCH THICK STRUCT. COURSE	1308+33.00 TO 1321+05.00	MEDIAN AND NB MAINLINE	RT	26738	1272.0	VARIES	TN	485				2 LIFTS	
0334-1-13	S-1 ASPHALT CONCRETE 1.5 INCH THICK (PATH ASPHALT)	1219+40.00 TO 1237+90.00	PATH ASPHALT	RT	29097	1850.0	10.0	TN	169				2 LIFTS	
0334-1-13	S-1 ASPHALT CONCRETE 1.5 INCH THICK (PATH ASPHALT)	1238+20.00 TO 1245+00.00	PATH ASPHALT	RT	29094	680.0	10.0	TN	74				2 LIFTS	
0334-1-13	S-1 ASPHALT CONCRETE 1.5 INCH THICK (PATH ASPHALT)	1245+10.00 TO 1246+40.00	PATH ASPHALT	RT	29093	130.0	10.0	TN	12				2 LIFTS	
0334-1-13	S-1 ASPHALT CONCRETE 1.5 INCH THICK (PATH ASPHALT)	1246+60.00 TO 1248+25.00	PATH ASPHALT	RT	29092	165.0	10.0	TN	61				2 LIFTS	
0334-1-13	S-1 ASPHALT CONCRETE 1.5 INCH THICK (PATH ASPHALT)	1249+70.00 TO 1249+80.00	PATH ASPHALT	RT	29099	10.0	10.0	TN	169				2 LIFTS	
0334-1-13	S-1 ASPHALT CONCRETE 1.5 INCH THICK (PATH ASPHALT)	1263+10.00 TO 1280+85.00	PATH ASPHALT	RT	29102	1775.0	10.0	TN	164				2 LIFTS	
0334-1-13	S-1 ASPHALT CONCRETE 1.5 INCH THICK (PATH ASPHALT)	1281+20.00 TO 1288+92.00	PATH ASPHALT	RT	29108	772.0	10.0	TN	136				2 LIFTS	
0334-1-13	S-1 ASPHALT CONCRETE 1.5 INCH THICK (PATH ASPHALT)	1289+50.00 TO 1292+00.00	PATH ASPHALT	RT	29114	250.0	10.0	TN	89				2 LIFTS	
0334-1-13	S-1 ASPHALT CONCRETE 1.5 INCH THICK (PATH ASPHALT)	1291+20.00 TO 1291+40.00	PATH ASPHALT	RT	29116	20.0	10.0	TN	2				2 LIFTS	
0334-1-13	S-1 ASPHALT CONCRETE 1.5 INCH THICK (PATH ASPHALT)	1291+80.00 TO 1305+40.00	PATH ASPHALT	RT	29117	1360.0	10.0	TN	142				2 LIFTS	
0334-1-13	S-1 ASPHALT CONCRETE 1.5 INCH THICK (PATH ASPHALT)	1308+15.00 TO 1312+94.00	PATH ASPHALT	RT	29121	479.0	10.0	TN	43				2 LIFTS	
0334-1-13	S1 ASPHALT CONCRETE 3 INCH THICK STRUCT. COURSE	1234+41.73 TO 1238+87.33	SB TURN LANE	LT	N/A	445.6	VARIES	TN	110					
0334-1-13	S1 ASPHALT CONCRETE 3 INCH THICK STRUCT. COURSE	1247+19.31 TO 1248+28.83	SB NEW CONST.	LT	N/A	109.5	VARIES	TN	44					
0334-1-13	S1 ASPHALT CONCRETE 3 INCH THICK STRUCT. COURSE	1249+72.94 TO 1251+19.56	SB NEW CONST.	LT	N/A	146.6	VARIES	TN	57					
0334-1-13	S1 ASPHALT CONCRETE 3 INCH THICK STRUCT. COURSE	1263+25.16 TO 1265+74.31	SB TURN LANE	LT	N/A	249.1	VARIES	TN	56					
0334-1-13	S1 ASPHALT CONCRETE 3 INCH THICK STRUCT. COURSE	1287+40.88 TO 1288+89.24	SB NEW CONST.	LT	N/A	148.4	VARIES	TN	55					
0334-1-13	S1 ASPHALT CONCRETE 3 INCH THICK STRUCT. COURSE	1289+65.52 TO 1291+11.88	SB NEW CONST.	LT	N/A	146.4	VARIES	TN	55					
0334-1-13	S1 ASPHALT CONCRETE 3 INCH THICK STRUCT. COURSE	1304+71.13 TO 1305+81.27	SB NEW CONST.	LT	N/A	110.1	VARIES	TN	45					
0334-1-13	S1 ASPHALT CONCRETE 3 INCH THICK STRUCT. COURSE	1307+94.43 TO 1309+30.91	SB NEW CONST.	LT	N/A	136.5	VARIES	TN	54					
0334-1-13	S1 ASPHALT CONCRETE 3 INCH THICK STRUCT. COURSE	1218+63.02 TO 1321+30.00	MISC WIDENING SIDE ST RADIUS	LT	N/A	10267.0	VARIES	TN	54					
	TOTAL								18655					
0286-2	TURNOUT CONSTRUCTION	2+35.00 TO 2+90.00	ASPHALT DRIVEWAY	LT	N/A	42440			8.36				RAMP 2	

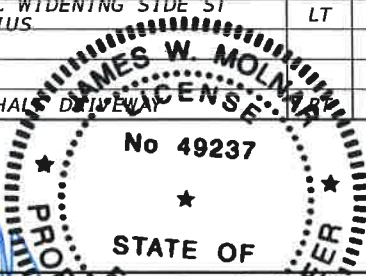

NO.	DATE	BY	REVISIONS - DESCRIPTION

T.Y. LIN INTERNATIONAL
 2400 FIRST STREET
 SUITE 200
 FORT MYERS, FLORIDA 33901
 TEL. (239) 332-4846
 FAX. (239) 332-4798
 WWW.TYLIN.COM

APPROVED BY:
JAMES W. MOLNAR, P.E.
 REGISTERED PROFESSIONAL ENGINEER
 FLORIDA CERTIFICATE NO. 49237
 3-5-2015

PUBLIC WORKS
 LEE COUNTY
 SOUTHWEST
 FLORIDA
 1500 MONROE STREET
 FORT MYERS, FLORIDA 33901
 12391 479-8900 www.lee-county.com/publicworks/default.htm


SUMMARY OF QUANTITIES
BURNT STORE ROAD

SHEET NO.
 13 A
 Default

T:\Tampa\Legacy\Projects\581595.00\Burnt_Store_RD\Burnt_Store\roadway\SUMQRD01.DGN

SUMMARY OF SIDEWALK & DETECTABLE WARNINGS

LOCATION STA. TO STA.	SIDE	AREA ID	LENGTH	WIDTH	CONC SIDEWALK 4"		CONC SIDEWALK 6"		BUS BAY/BOARDING PAD - CONCRETE		BUS SHELTER PAD - CONCRETE		DESIGN NOTES	CONSTRUCTION REMARKS
					0522 1		0522 2		0522 3		0522 4			
					SY		SY		SY		SY			
		P	F	P	F	P	F	P	F					
1219+80.00 TO 1229+80.00	LT	29087	1000.0	5.0	572.0									
1230+20.00 TO 1232+75.00	LT	29088	255.0	5.0	193.0									
1233+95.00 TO 1234+20.00	LT	29089	25.0	5.0	11.3									
1234+60.00 TO 1246+40.00	LT	29090	1180.0	5.0	644.0									
1246+80.00 TO 1247+00.00	LT	29091	20.0	5.0	29.7									
1250+40.00 TO 1251+20.00	LT	29100	80.0	5.0	36.8									
1251+60.00 TO 1262+40.00	LT	29101	1080.0	5.0	611.0									
1263+40.00 TO 1272+20.00	LT	29103	880.0	5.0	497.0									
1272+60.00 TO 1279+60.00	LT	29104	700.0	5.0	381.8									
1259+80.00 TO 1287+20.00	LT	29105	2740.0	5.0	394.0									
1287+40.00 TO 1287+90.00	LT	29140	50.0	5.0	29.0									
1293+60.00 TO 1296+80.00	LT	29118	320.0	5.0	285.0									
1297+20.00 TO 1300+75.00	LT	29119	355.0	5.0	192.0									
1301+20.00 TO 1303+90.00	LT	29120	270.0	5.0	146.0									
1219+47.41 TO 1219+52.43	RT		10.0	VARIES	6.1									
1237+88.68 TO 1237+94.15	RT		10.0	5.0	5.6									
1238+13.98 TO 1238+19.62	RT		10.0	VARIES	5.9									
1244+98.56 TO 1248+00.57	RT		10.0	5.0	5.6									
1245+06.50 TO 1245+08.51	RT		10.0	5.0	5.6									
1246+35.43 TO 1246+41.61	RT		10.0	5.0	5.6									
1246+59.06 TO 1246+63.69	RT		10.0	5.0	5.6									
1246+89.70 TO 1246+99.70	LT		10.0	5.0	5.6									
1250+69.17 TO 1250+79.33	LT		10.0	5.0	5.6									
1262+68.18 TO 1262+79.31	RT		10.0	VARIES	9.3									
1263+05.72 TO 1263+10.67	RT		10.0	5.0	5.6									
1280+87.67 TO 1280+93.33	RT		10.0	5.0	5.6									
1281+12.59 TO 1281+17.60	RT		10.0	5.0	5.6									
1287+75.73 TO 1287+85.73	LT		10.0	5.0	5.6									
1291+82.23 TO 1291+92.56	LT		10.0	5.0	5.6									
1290+98.73 TO 1291+08.73	RT		10.0	10.0	11.1									
1291+28.73 TO 1291+50.16	RT		10.0	VARIES	23.8									
1291+69.85 TO 1291+74.48	RT		10.0	5.0	5.6									
SUB-TOTAL :					4152									
TOTAL :					4152									

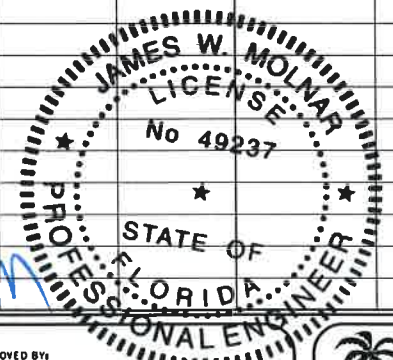

NO.	DATE	BY	REVISIONS - DESCRIPTION

T.Y. LIN INTERNATIONAL
 2400 FIRST STREET
 SUITE 200
 FORT MYERS, FLORIDA 33901
 TEL. (239) 332-4846
 FAX. (239) 332-4798
 WWW.TYLIN.COM

APPROVED BY:
JAMES MOLNAR, P.E.
 REGISTERED PROFESSIONAL ENGINEER
 FLORIDA CERTIFICATE NO. 49237
 3-5-2015


PUBLIC WORKS
 LEE COUNTY
 SOUTHWEST
 FLORIDA
 1500 MONROE STREET
 FORT MYERS, FLORIDA 33901
 12391 479-8900 www.lee-county.com/publicworks/default.htm

SUMMARY OF QUANTITIES
BURNT STORE ROAD

SHEET NO.
 14

SUMMARY OF RAILING

LOCATION STA. TO STA.	SIDE	METAL TRAFFIC RAILING		PIPE HANDRAIL - GUIDERAIL		PED/BICYCLE RAILING		HANDRAIL		DESIGN NOTES	CONSTRUCTION REMARKS	
		0460 71 A		0515 1 A		0515 2211		0515 3 A				
		LF		LF		LF		LF				
P	F	P	F	P	F	P	F	P	F			
1249+89.57 TO 1250+06.05	LT/RT					299.8					ALONG SIDEWALK UNDER BRIDGES	
1246+90.00 TO 1248+30.37	LT/RT					400.5					ALONG SIDEWALK UNDER BRIDGES	
1247+06.50 TO 1249+69.07	RT					263.0					ALONG SIDEWALK	
1288+53.70 TO 1288+55.16	LT/RT					303.3					ALONG SIDEWALK UNDER BRIDGES	
1289+69.14 TO 1289+99.42	LT/RT					402.3					ALONG SIDEWALK UNDER BRIDGES	
1298+85.88 TO 1299+06.42	RT					20.0						
1298+94.39 TO 1299+21.61	LT							27.2				
1251+10.00 TO 1253+10.00	RT					200.0					ON GRAVITY WALL	
1284+94.74 TO 1288+20.26	RT					325.5					ON GRAVITY WALL	
1303+60.53 TO 1305+45.58	RT					185.1					ON GRAVITY WALL	
1308+33.68 TO 1312+29.92	RT					396.2					ON GRAVITY WALL	
SUB-TOTAL:						2796			27			
TOTAL:						2796			27			

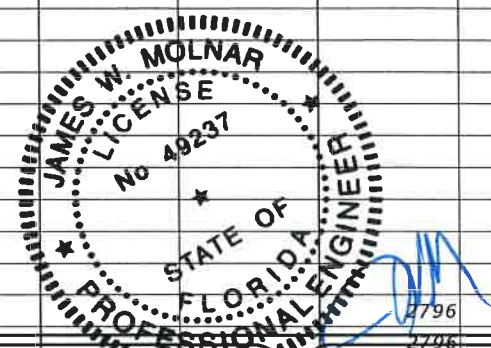

NO.	DATE	BY	REVISIONS - DESCRIPTION

T.Y. LIN INTERNATIONAL
 2400 FIRST STREET
 SUITE 200
 FORT MYERS, FLORIDA 33901
 TEL. (239) 332-4846
 FAX. (239) 332-4798
 WWW.TYLIN.COM

APPROVED BY:
JAMES MOLNAR, P.E.
 REGISTERED PROFESSIONAL ENGINEER
 FLORIDA CERTIFICATE NO. 49237
 3-5-2015

PUBLIC WORKS DEPARTMENT
 LEE COUNTY of
 SOUTHWEST TRANSPORTATION
 FLORIDA
 1500 MONROE STREET FORT MYERS, FLORIDA 33901
 (239) 479-8900 www.lee-county.com/publicworks/default.htm
 rsh/alds 3/6/2015 4:06:02 PM


SUMMARY OF QUANTITIES

BURNT STORE ROAD

SHEET NO.
 15
 Default

SUMMARY OF WALLS (GRAVITY)

WALL NO.	PAY ITEM NO.	PAY ITEM DESCRIPTION	LOCATION STA. TO STA.	SIDE	UNIT	QUANTITY		TOTAL		DESIGN NOTES	CONSTRUCTION REMARKS
						P	F	P	F		
		CONCRETE GRAVITY WALL (NS)	1308+33.48 TO 1312+29.92	RT	FT	396.4				ACTUAL STATIONS	
		CONCRETE GRAVITY WALL (NS)	1284+54.74 TO 1285+90.35	RT	FT	135.6					
		CONCRETE GRAVITY WALL (NS)	1250+04.17 TO 1251+07.05	RT	FT	104.5					
		CONCRETE GRAVITY WALL (NS)	1251+10.00 TO 1253+10.00	RT	FT	200.0					
		CONCRETE GRAVITY WALL (NS)	1251+07.05 TO 1252+00.00	RT	FT	93.0					
		CONCRETE GRAVITY WALL (NS)	1303+60.43 TO 1305+45.44	RT	FT	182.9					
		CONCRETE GRAVITY WALL (NS)	1285+90.35 TO 1288+20.26	RT	FT	231.1					
ALL WALLS	0400-0-11	CONCRETE GRAVITY WALL (NS)	1218+00.00 TO 1321+00.00	RT	LT	1343.5				AVERAGE HEIGHT 3.5' OR 0.4 CY/FT	
		TOTAL			CY	537.4					

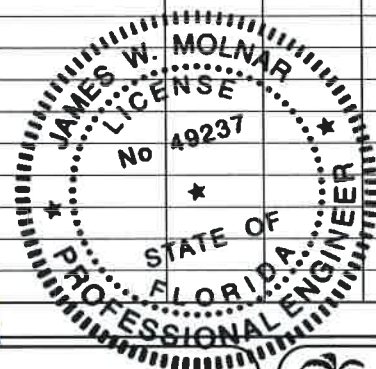

NO.	DATE	BY	REVISIONS - DESCRIPTION

T.Y. LIN INTERNATIONAL
 2400 FIRST STREET
 SUITE 200
 FORT MYERS, FLORIDA 33901
 TEL. (239) 332-4846
 FAX. (239) 332-4798
 WWW.TYLIN.COM

APPROVED BY:
JAMES MOLNAR, P.E.
 REGISTERED PROFESSIONAL ENGINEER
 FLORIDA CERTIFICATE NO. 49237
 3-5-2015


PUBLIC WORKS
 LEE COUNTY
 SOUTHWEST
 FLORIDA
 1500 MONROE STREET
 FORT MYERS, FLORIDA 33901
 12391 479-8900 www.lee-county.com/publicworks/default.htm

SUMMARY OF QUANTITIES
BURNT STORE ROAD

SHEET NO.
 16
 Default

SUMMARY OF PERFORMANCE TURF

LOCATION STA. TO STA.	SIDE	AREA ID	LENGTH	WIDTH	PERFORMANCE TURF		PERFORMANCE TURF (SOD)		PREPARED SOIL LAYER		DESIGN NOTES	CONSTRUCTION REMARKS
					0570 1 1		0570 1 2		0162 1 AB			
					SY		SY		SY			
P	F	P	F	P	F							
1218+00.00	1319+21.00	LT/RT	N/A	10121.0	109.0			364404				TOTAL CLEARING AND GRUBBING AREA MINUS PAVEMENT AND SWK.
								-4023				MINUS SIDEWALK
								-9436				MINUS PATH
								-1080				MINUS MISC. ASPHALT
								-3802				MINUS CURB AND GUTTER
								-223376				MINUS NEW ROADWAY
					SUB-TOTAL:			122687				
					TOTAL:			122687				

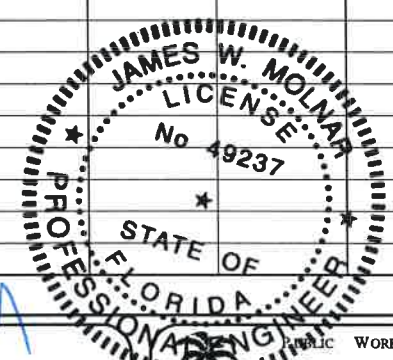

NO.	DATE	BY	REVISIONS - DESCRIPTION

T.Y. LIN INTERNATIONAL
 2400 FIRST STREET
 SUITE 200
 FORT MYERS, FLORIDA 33901
 TEL. (239) 332-4846
 FAX. (239) 332-4798
 WWW.TYLIN.COM


APPROVED BY:
JAMES MOLNAR, P.E.
 REGISTERED PROFESSIONAL ENGINEER
 FLORIDA CERTIFICATE NO. 49237
 3-5-2015

LEEE COUNTY
 DEPARTMENT of TRANSPORTATION
 PUBLIC WORKS
 SOUTHWEST FLORIDA
 1500 MONROE STREET
 FORT MYERS, FLORIDA 33901
 12391 479-8900 www.lee-county.com/publicworks/online.htm
 rshields 3/6/2015 4:06:04 PM

SUMMARY OF QUANTITIES
BURNT STORE ROAD

SHEET NO.
 17
 Default

STR. ID	STA	OFFSET	SIDE	TYPE	TOP / INLET ELEVATION	PIPE SIZE & DIRECTION	INV. ELEV.	PIPE SIZE & DIRECTION	INV. ELEV.	REMARKS	DESILTING QUANTITY (CY)	DESILTING QUANTITY (LF)
ES- 43	1217+98.66	199.06	LT	INLET, PIPE	2.88	24" RCP SOUTH	0.03 S. / 0.16 N.			CLEAN & DESILT		38
ES- 44	1218+01.39	30.54	LT	INLET, PIPE	2.82	24" RCP SOUTH	-0.13 S. / 0.06 N.			REMOVE INLET AND PIPE, PLUG SEAWALL		
ES- 45	1219+23.47	200.62	LT	PIPE		18" CMP N./S.	2.63 S. / 2.41 N.			CLEAN & DESILT		46
ES- 46	1219+29.58	30.73	LT	PIPE		24" CMP N./S.	3.07 S. / 3.03 N.			CLEAN & DESILT		44
ES- 47	1230+00.88	200.72	LT	PIPE		15" CMP N./S.	3.15 S. / 2.87 N.			CLEAN & DESILT		41
ES- 48	1246+54.60	200.92	LT	PIPE		18" CMP N./S.	3.05 S. / 2.97 N.			CLEAN & DESILT		44
ES- 49	1246+54.60	30.89	LT	INLET, PIPES	7.08	24" CMP NORTH	2.23 S. / 2.19 N.	24" CMP SOUTH	2.21 S. / 2.35 N.	REMOVE INLET AND PIPES		
ES- 50	1247+94.10	200.92	LT	INLET, PIPE	2.87	24" RCP NORTH	0.29 S. / 0.05 N.			CLEAN & DESILT		38
ES- 51	1247+94.10	30.89	LT	INLET, PIPE	2.73	24" RCP NORTH	0.01 S. / 0.01 N.			REMOVE INLET AND PIPE, PLUG SEAWALL		
ES- 52	1250+02.24	200.92	LT	INLET, PIPE	2.82	24" RCP SOUTH	0.04 S. / 0.34 N.			CLEAN & DESILT		38
ES- 53	1250+07.16	30.89	LT	INLET, PIPE	2.83	24" RCP SOUTH	-0.10 S. / 0.11 N.			REMOVE INLET AND PIPE, PLUG SEAWALL		
ES- 54	1251+29.25	200.92	LT	PIPE		24" CMP N./S.	3.40 S. / 3.31 N.			CLEAN & DESILT		43
ES- 55	1251+33.88	31.07	LT	PIPE		24" CMP N./S.	3.29 S. / 3.31 N.			REMOVE PIPE		
ES- 56	1262+96.73	201.00	LT	INLET, PIPES	7.60	18" CMP NORTH	4.25 S. / 4.14 N.	18" CMP SOUTH	4.24 S. / 4.25 N.	CLEAN & DESILT		79
ES- 57	1262+96.73	31.07	LT	PIPE		18" CMP N./S.	3.65 S. / 3.35 N.			REMOVE PIPE		
ES- 58	1279+79.57	200.45	LT	PIPE		18" CMP N./S.	4.48 S. / 4.53 N.			CLEAN & DESILT		44
ES- 59	1281+03.48	30.59	LT	PIPE		18" CMP N./S.	4.10 S. / 3.91 N.			REMOVE PIPE		
ES- 60	1287+31.43	200.41	LT	PIPE		18" CMP N./S.	4.05 S. / 4.06 N.			CLEAN & DESILT		44
ES- 61	1287+31.43	30.91	LT	PIPE		18" CMP N./S.	3.39 S. / 3.41 N.			REMOVE PIPE		
ES- 62	1288+57.23	200.93	LT	INLET, PIPE	3.69	24" RCP NORTH	0.38 S. / 0.24 N.			CLEAN & DESILT		34
ES- 63	1288+47.98	31.19	LT	INLET, PIPE	3.41	30" RCP NORTH	1.39 S. / 0.70 N.			REMOVE INLET AND PIPE, PLUG SEAWALL		
ES- 65	1290+01.20	31.19	LT	INLET, PIPE	3.73	18" RCP SOUTH	0.72 S. / 0.98 N.			REMOVE INLET AND PIPE, PLUG SEAWALL		
ES- 66	1291+21.77	200.76	LT	PIPE		18" CMP N./S.	4.03 S. / 4.13 N.			CLEAN & DESILT		46
ES- 67	1297+17.20	165.46	LT	PIPE		18" CMP N./S.	3.42 S. / 3.67 N.			CLEAN & DESILT		49
ES- 68	1299+07.04	105.83	LT	ENDWALL	6.72	8'X4' CBC	2.87 EAST			REMOVE ENDWALL, CLEAN AND DESILT 8'x4' CBC	11.85	
ES- 69	1299+02.28	65.77	LT	ENDWALL	7.08	8'X4' CBC	2.93 WEST			REMOVE ENDWALL, CLEAN AND DESILT 8'x4' CBC		
ES- 70	1301+10.15	117.10	LT	PIPE		18" CMP N./S.	3.63 S. / 3.60 N.			CLEAN & DESILT		47
ES- 71	1305+43.49	74.31	RT	INLET, PIPE	3.29	24" CMP NORTH	0.57 S. / -0.19 N.			REMOVE INLET AND PIPE, PLUG SEAWALL		
ES- 72			LT	INLET, PIPE		36" RCP SOUTH				CLEAN & DESILT		39
ES- 73			RT	INLET, PIPE		36" RCP SOUTH				REMOVE INLET AND PIPE, PLUG SEAWALL		
ES- 74			LT	INLET, PIPE		48" RCP SOUTH				CLEAN & DESILT		44
ES- 75			RT	INLET, PIPE		36" RCP SOUTH				REMOVE INLET AND PIPE, PLUG SEAWALL		
ES- 76	1315+81.93	68.59	LT	MES, PIPES		36" RCP NORTH	2.80	36" RCP NORTH	3.01	CLEAN & DESILT		44
ES- 77	1316+34.06	65.54	LT	MES, PIPES		36" RCP SOUTH	2.91	36" RCP SOUTH	2.95	CLEAN & DESILT		44
TOTALS											11.85	846

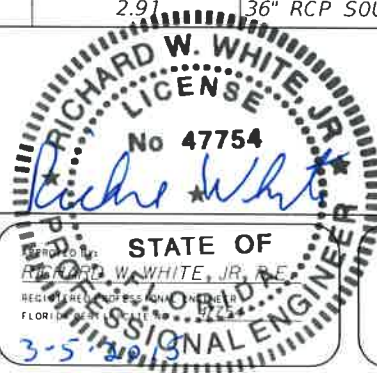

NO.	DATE	BY	REVISIONS - DESCRIPTION

T.Y. LIN INTERNATIONAL
 2400 FIRST STREET
 SUITE 200
 FORT MYERS, FLORIDA 33901
 TEL. (239) 332-4846
 FAX. (239) 332-4798
 WWW.TYLIN.COM

STATE OF
 PUBLIC WORKS
 LEE COUNTY
 DEPARTMENT
 of
 TRANSPORTATION
 1500 MONROE STREET
 FORT MYERS, FLORIDA 33901
 12391 479 8900 www.lee-county.com/publicworks/default.htm
 3/5/2015 4:25:13 PM

**SUMMARY OF DRAINAGE STRUCTURES
 EXISTING
 BURNT STORE ROAD**

SHEET NO.
 18

QUANTITY	STR. ID	STATION	OFFSET	SIDE	DESCRIPTION	BARRELS	STORM DRAIN OPTIONAL MATERIAL						CURB INLETS		MANHOLES				INLETS TYPE	DITCH BOTTOM INLETS						MITERED END SECTIONS			CONC. ENDWALLS	REMARKS				
							ROUND						P-5	P-6	P-7	J-7	B	C		D MOD.	E MOD.	H	D MOD. (J BOT.)	18"	24"	19"x30"								
							18"	24"	30"	36"	42"	48"	ELLIP.	19"x30"	< 10'	< 10'	< 10'	< 10'		< 10'	< 10'	< 10'	< 10'	< 10'	SD	CD	SD	SD						
P	S-321	1254+98.18	76.40'	RT	INLET, PIPE	1		105																										
F																																		
P	S-322	1256+03.28	112.93'	RT	MES	1																												
F																																		
P	S-323	1258+20.09	113.90'	RT	MES, PIPE	1		302																										
F																																		
P	S-324	1261+24.60	104.40'	RT	INLET, PIPE	1		80																										
F																																		
P	S-325	1262+07.11	101.41'	RT	INLET, PIPE	1		119																										
F																																		
P	S-326	1262+68.84	99.67'	LT	MES, PIPE	1		64																										
F																																		
P	S-326A	126338.96	94.51	LT	MES, PIPE	1		75																										
F																																		
P	S-327	1263+29.82	108.30'	RT	MES	1																												
F																																		
P	S-328	1264+20.24	87.91'	LT	MES	1																												
F																																		
P	S-329	1270+65.65	91.02'	LT	MES, PIPE	1		42																										
F																																		
P	S-330	1271+14.22	98.62'	LT	MES	1																												
F																																		
P	S-331	1278+79.96	99.54'	LT	INLET, PIPE	1		200																										
F																																		
P	S-332	1278+80.00	103.98'	RT	INLET, PIPE	1				57																								
F																																		
P	S-333	1278+80.04	161.01'	RT	ENDWALL	1																												
F																																		
P	S-334	1280+60.41	108.32'	RT	MES, PIPE	1		73																										
F																																		
P	S-335	1280+72.58	100.57'	LT	MES, PIPE	1		61																										
F																																		
P	S-336	1281+40.52	108.48'	RT	MES	1																												
F																																		
P	S-337	1281+41.24	98.79'	LT	MES	1																												
F																																		
P	S-338	1282+48.39	110.72'	RT	MES	1																												
F																																		
P	S-339	1283+70.78	76.12'	RT	INLET, PIPE	1		121																										
F																																		
P	S-340	1286+70.00	87.12'	RT	INLET, PIPE	1		295																										
F																																		
SHEET SUMMARY						P TOTAL	0	1537	0	57	0	0	0	0	2	0	0	3	1	0	2	0	0	0	0	0	0	12	0	4.53				
						F TOTAL																												

NO	DATE	BY	REVISIONS - DESCRIPTION



T.Y. LIN INTERNATIONAL
2400 FIRST STREET
SUITE 200
FORT MYERS, FLORIDA 33901
TEL. (239) 532-4846
FAX. (239) 332-4798
WWW.TYLIN.COM

STATE OF
RICHARD W. WHITE, JR., P.E.
REGISTERED PROFESSIONAL ENGINEER
FLORIDA LICENSE No. 47754
3-5-2015

PUBLIC WORKS
LEE COUNTY
SOUTHWEST
FLORIDA
1500 MONROE STREET
FORT MYERS, FLORIDA 33901
(239) 479-6300 www.lee-county.com/publicworks/default.htm
dwwerner 3/5/2015 4:25:23 PM

SUMMARY OF DRAINAGE STRUCTURES
PROPOSED
BURNT STORE ROAD


SHEET NO.
20
Default

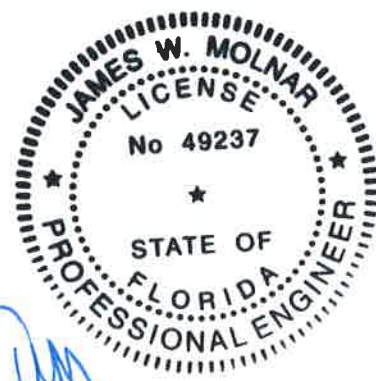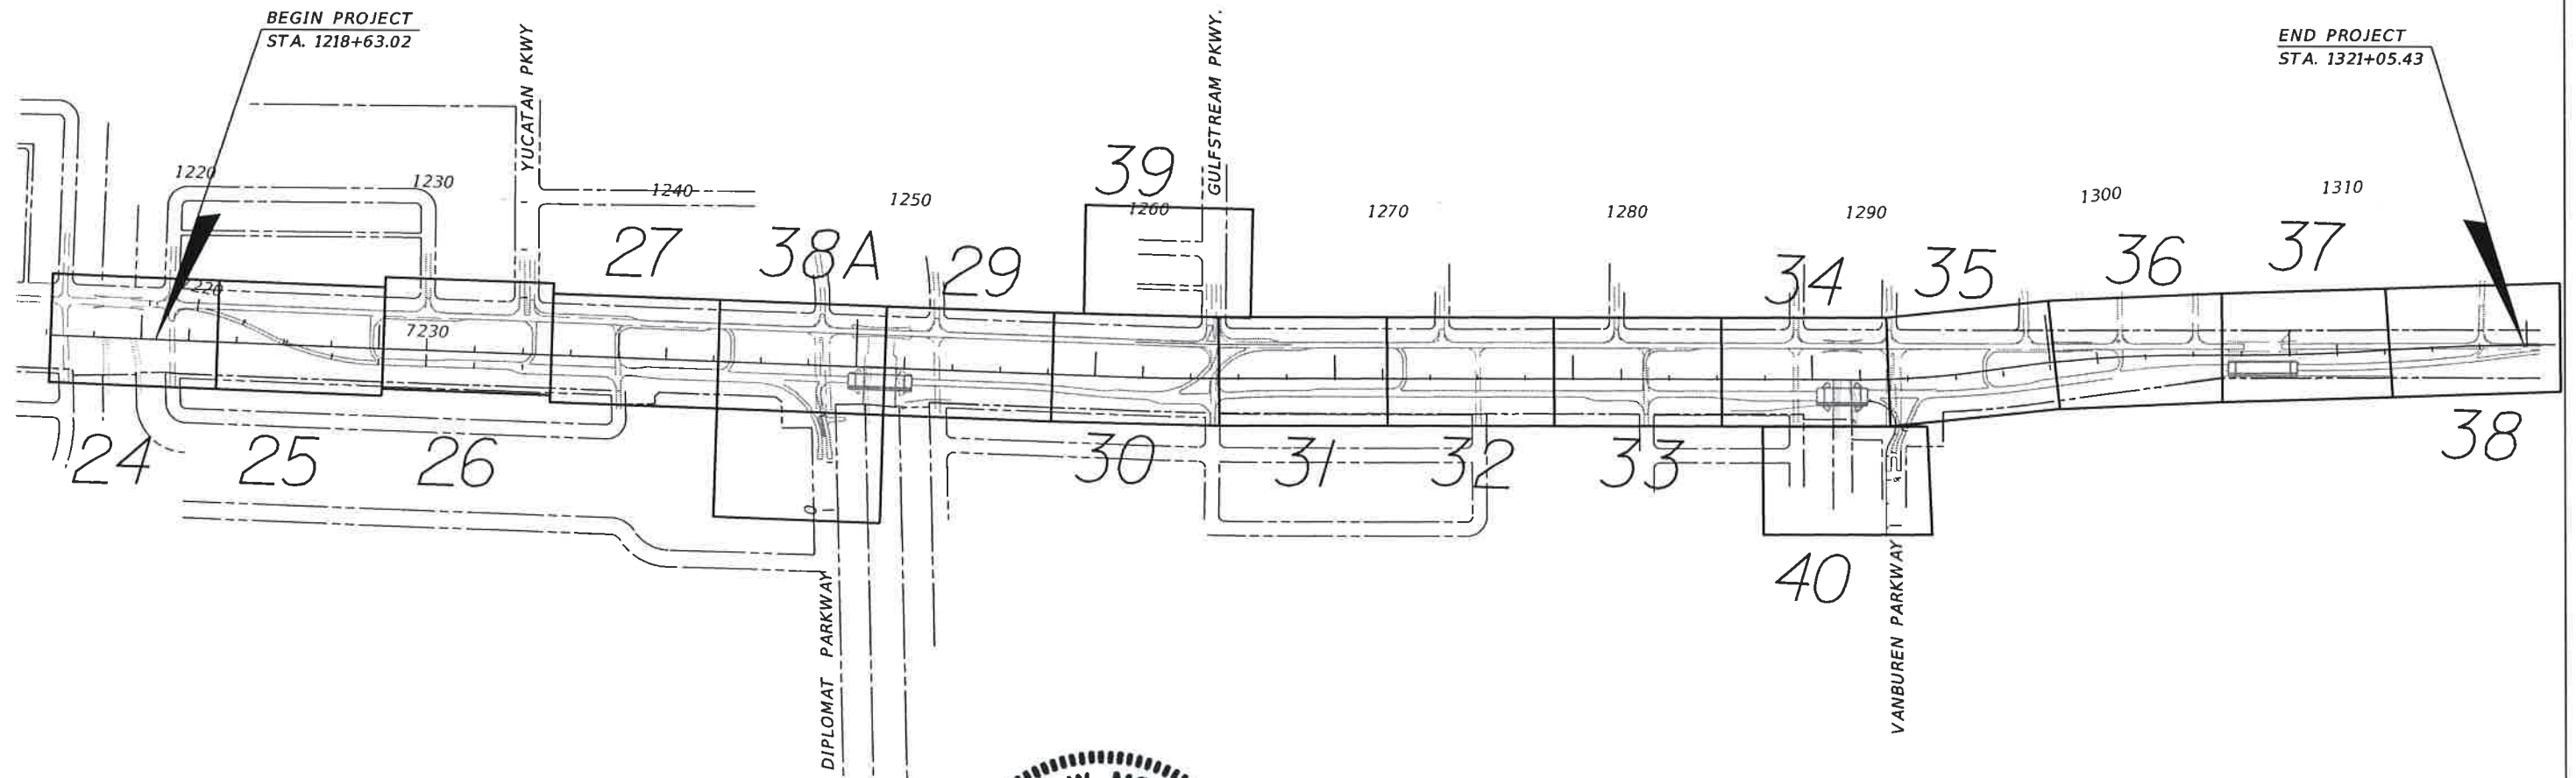

NO.	DATE	BY	REVISIONS	DESCRIPTION

T.Y. LIN INTERNATIONAL
 2400 FIRST STREET
 SUITE 200
 FORT MYERS, FLORIDA 33901
 TEL. (239) 332-4846
 FAX. (239) 332-4798
 WWW.TYLIN.COM

APPROVED BY:
JAMES W. MOLNAR, P.E.
 REGISTERED PROFESSIONAL ENGINEER
 FLORIDA CERTIFICATE NO. 49237
 3-5-2015



 PUBLIC WORKS
 LEE COUNTY
 SOUTHWEST
 FLORIDA
 1500 MONROE STREET
 FORT MYERS, FLORIDA 33901
 (239) 479-8900 www.lee-county.com/publicworks/detail.htm
 DEPARTMENT
 of
 TRANSPORTATION

PROJECT LAYOUT SHEET
BURNT STORE ROAD

SHEET NO.
 23

STA. 1216+20.00


STA. 1223+20.00

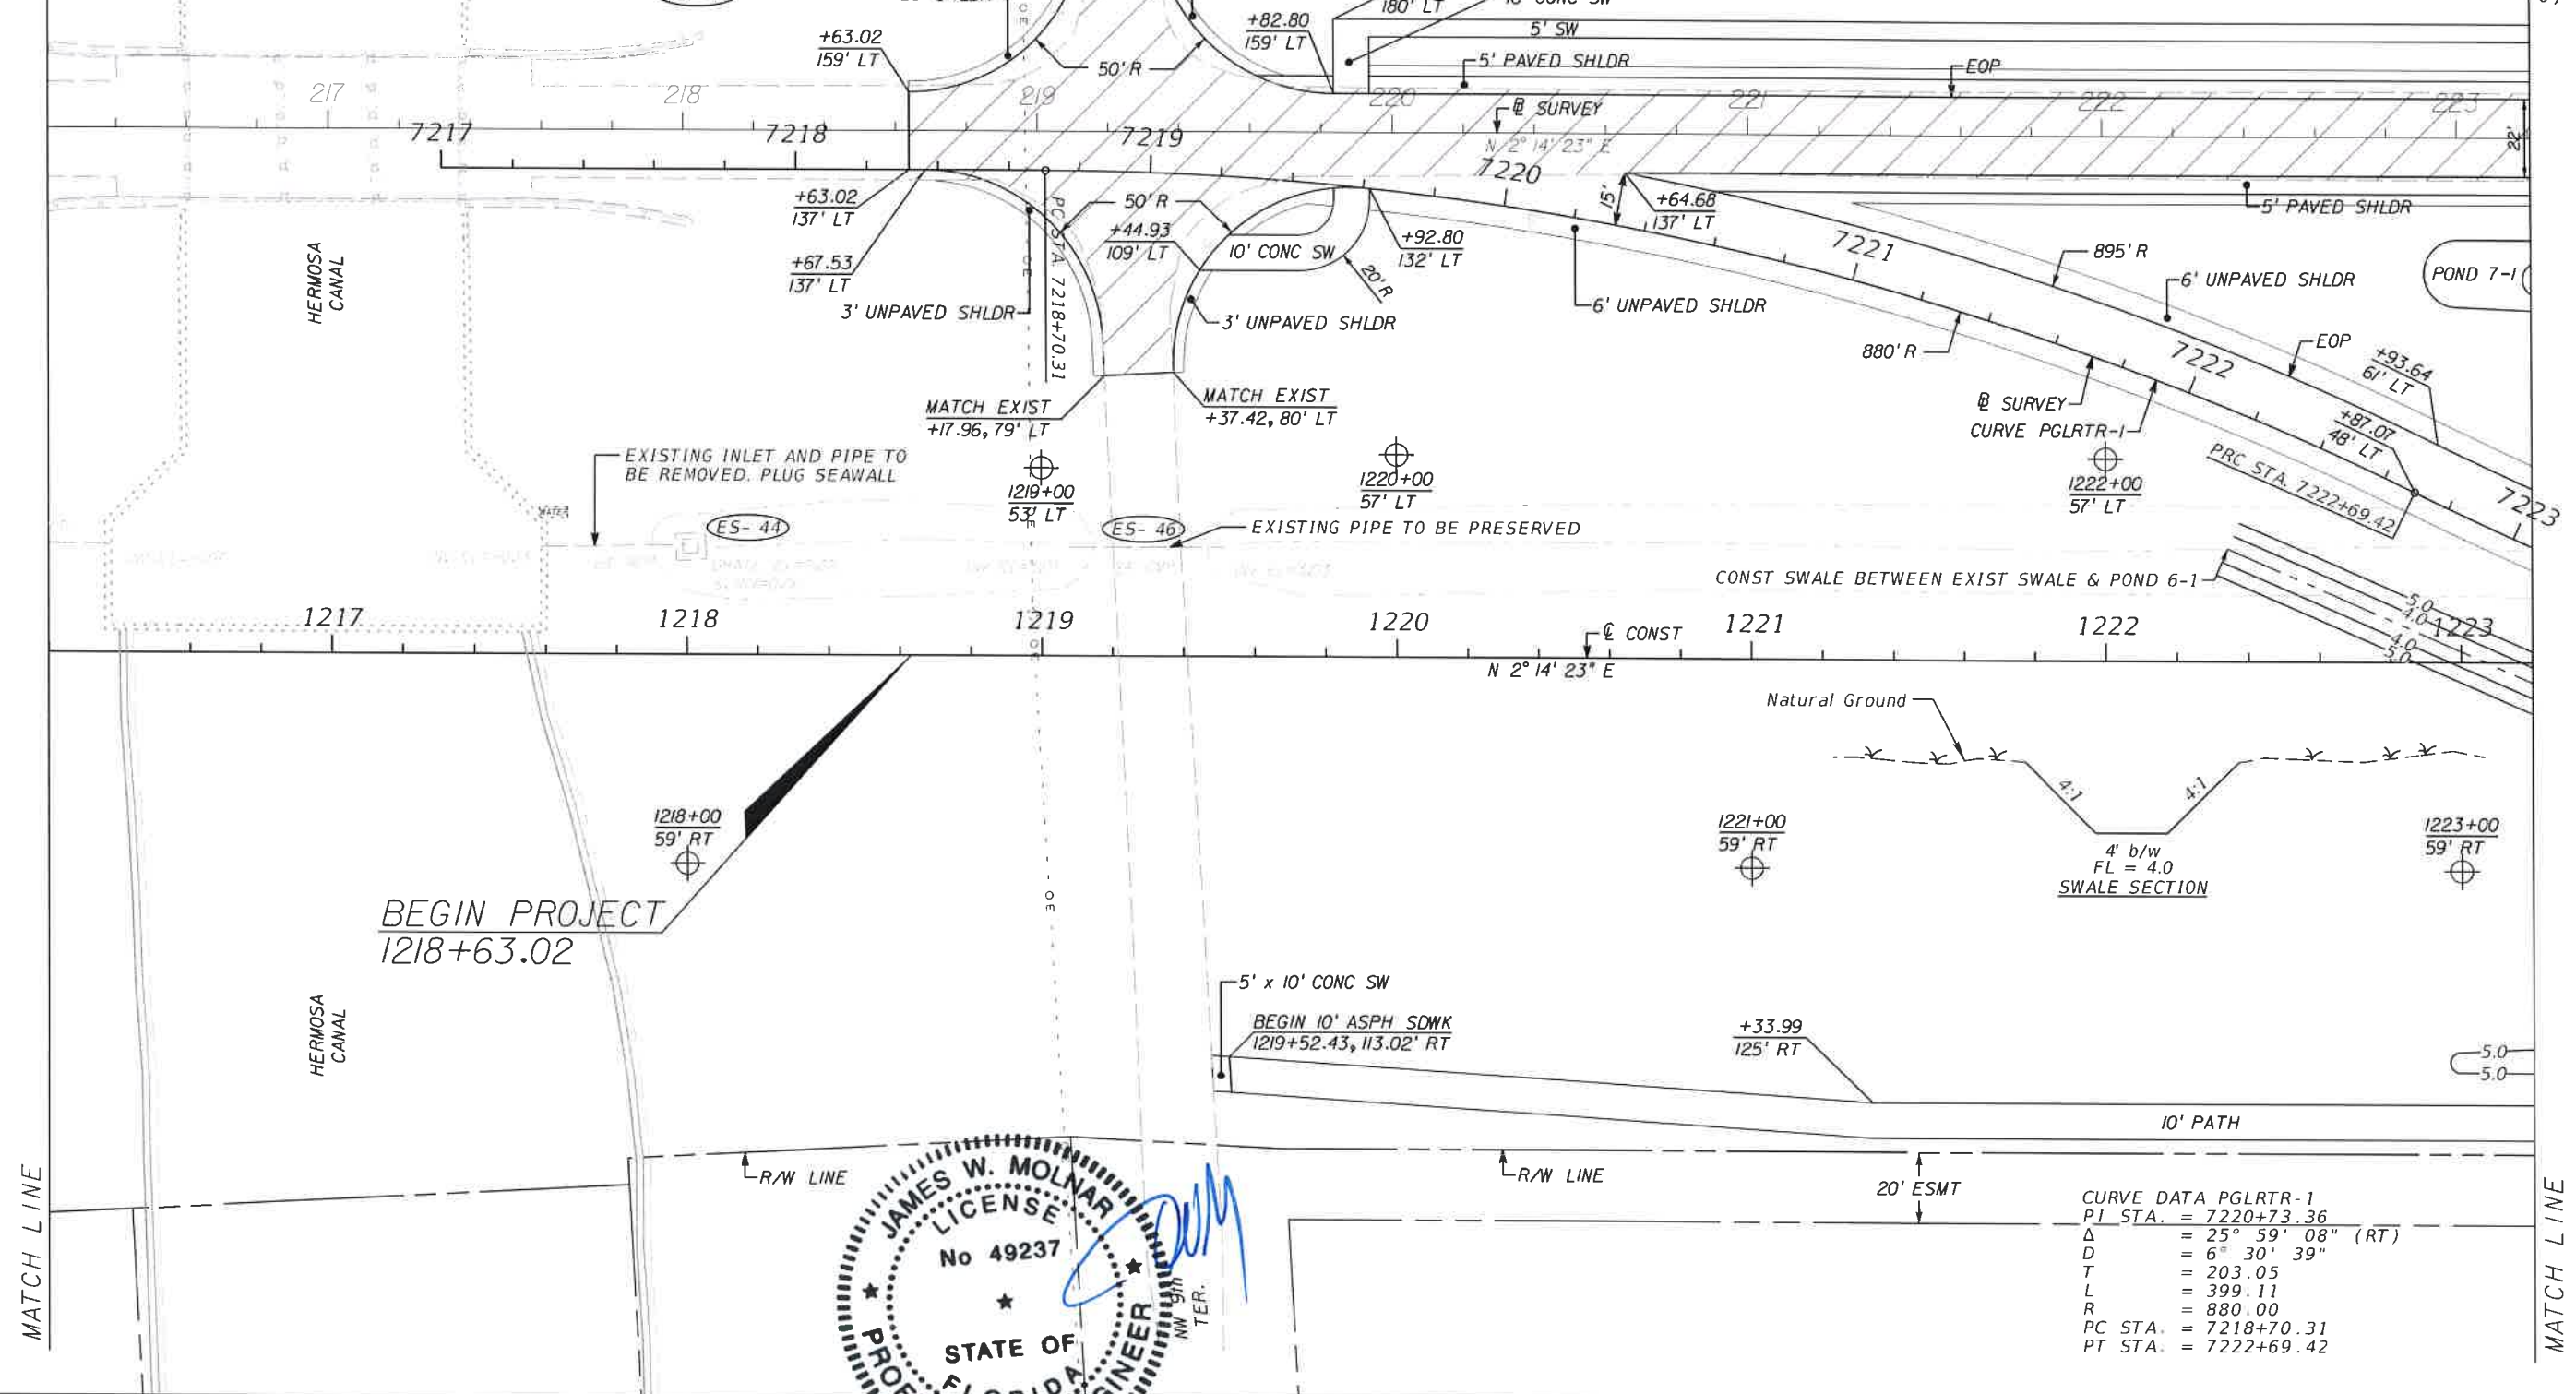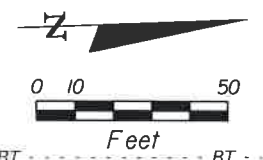

BEGIN PROJECT
1218+63.02

CURVE DATA PGLRTR-1

PI STA.	= 7220+73.36
Δ	= 25° 59' 08" (RT)
D	= 6° 30' 39"
T	= 203.05
L	= 399.11
R	= 880.00
PC STA.	= 7218+70.31
PT STA.	= 7222+69.42

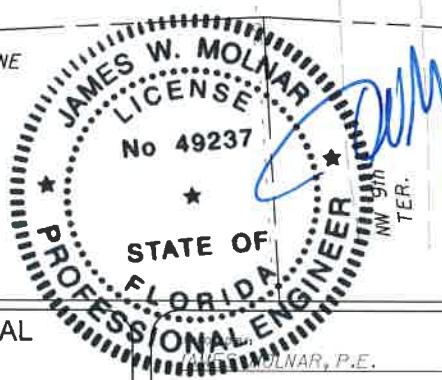

NO.	DATE	BY	REVISIONS - DESCRIPTION

T.Y. LIN INTERNATIONAL
2400 FIRST STREET
SUITE 200
FORT MYERS, FLORIDA 33901
TEL. (239) 332-4846
FAX. (239) 332-4798
WWW.TYLIN.COM

JAMES W. MOLNAR, P.E.
REGISTERED PROFESSIONAL ENGINEER
FLORIDA CERTIFICATE NO. 49237
3-5-2015

PUBLIC WORKS
LEE COUNTY
SOUTHWEST FLORIDA
1300 MINOR STREET
(239) 419-8900 www.lee-county.com/publicworks/dotille.htm

DEPARTMENT
of
TRANSPORTATION
FORT MYERS, FLORIDA 33901
4:51:28 PM


PLAN SHEET
STA. 1216+20.00 TO STA. 1223+20.00
BURNT STORE ROAD

SHEET NO.
24
Default

T:\Temp\Legacy\Project\581595.00\Burnt_Store_Rd\Burnt_Store_roadway\planr18.dgn


STA. 1223+20.00

STA. 1230+20.00

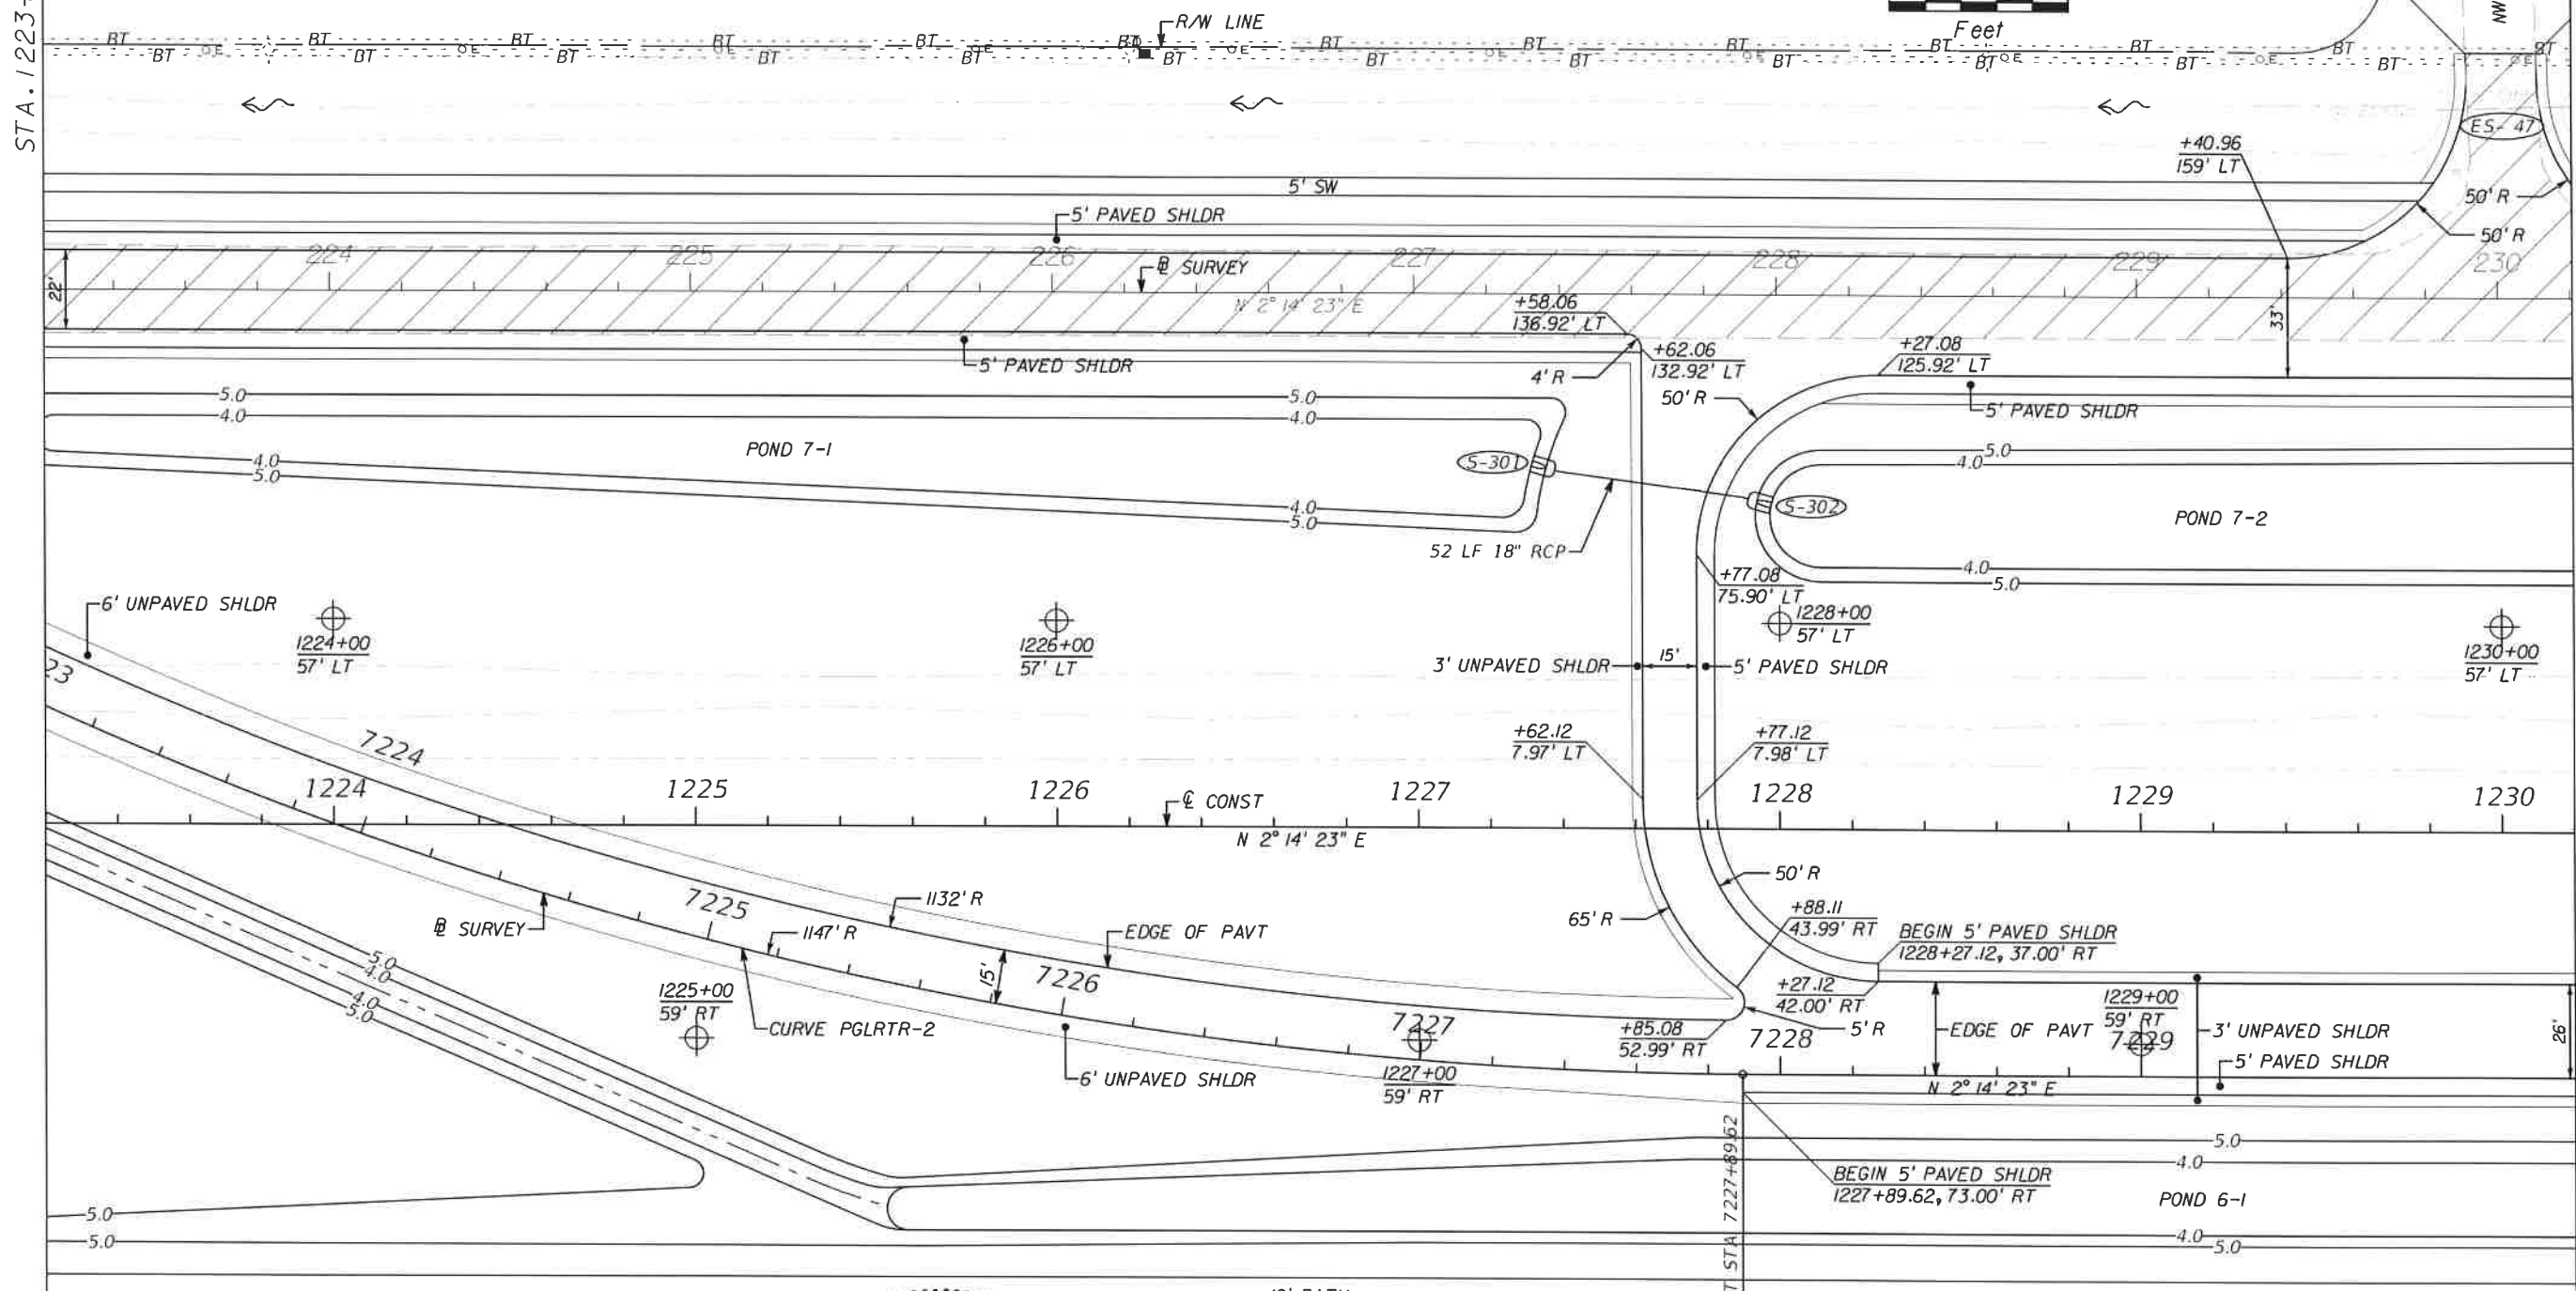

MATCH LINE

MATCH LINE

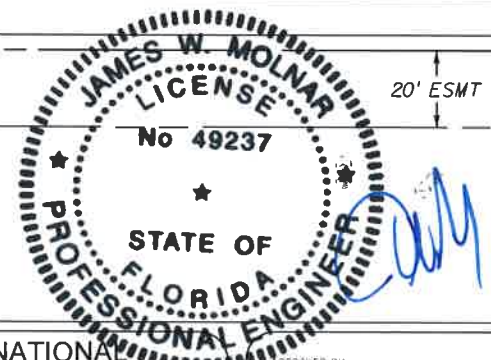

CURVE DATA PGLRTR-2

PI STA.	= 7225+34.07
Δ	= 25° 59' 08" (LT)
D	= 4° 59' 43"
T	= 264.65
L	= 520.20
R	= 1,147.00
PC STA.	= 7222+69.42
PT STA.	= 7227+89.62

NO.	DATE	BY	REVISIONS - DESCRIPTION

T.Y. LIN INTERNATIONAL
 2400 FIRST STREET
 SUITE 200
 FORT MYERS, FLORIDA 33901
 TEL. (239) 332-4846
 FAX. (239) 332-4798
 WWW.TYLIN.COM

APPROVED BY:
JAMES MOLNAR, P.E.
 REGISTERED PROFESSIONAL ENGINEER
 FLORIDA CERTIFICATE NO. 49237
 3-5-2015



PUBLIC WORKS
LEE COUNTY
SOUTHWEST
FLORIDA
 1300 MONROE STREET
 FORT MYERS, FLORIDA 33901
 (239) 479-8900 www.lee-county.com/publicworks/default.htm

PLAN SHEET
STA. 1223+20.00 TO STA. 1230+20.00
BURNT STORE ROAD

SHEET NO.
 25

STA. 1230+20.00

STA. 1237+20.00

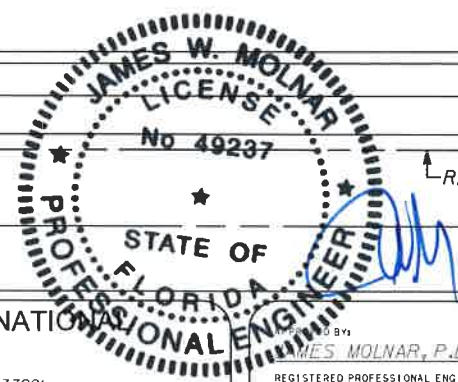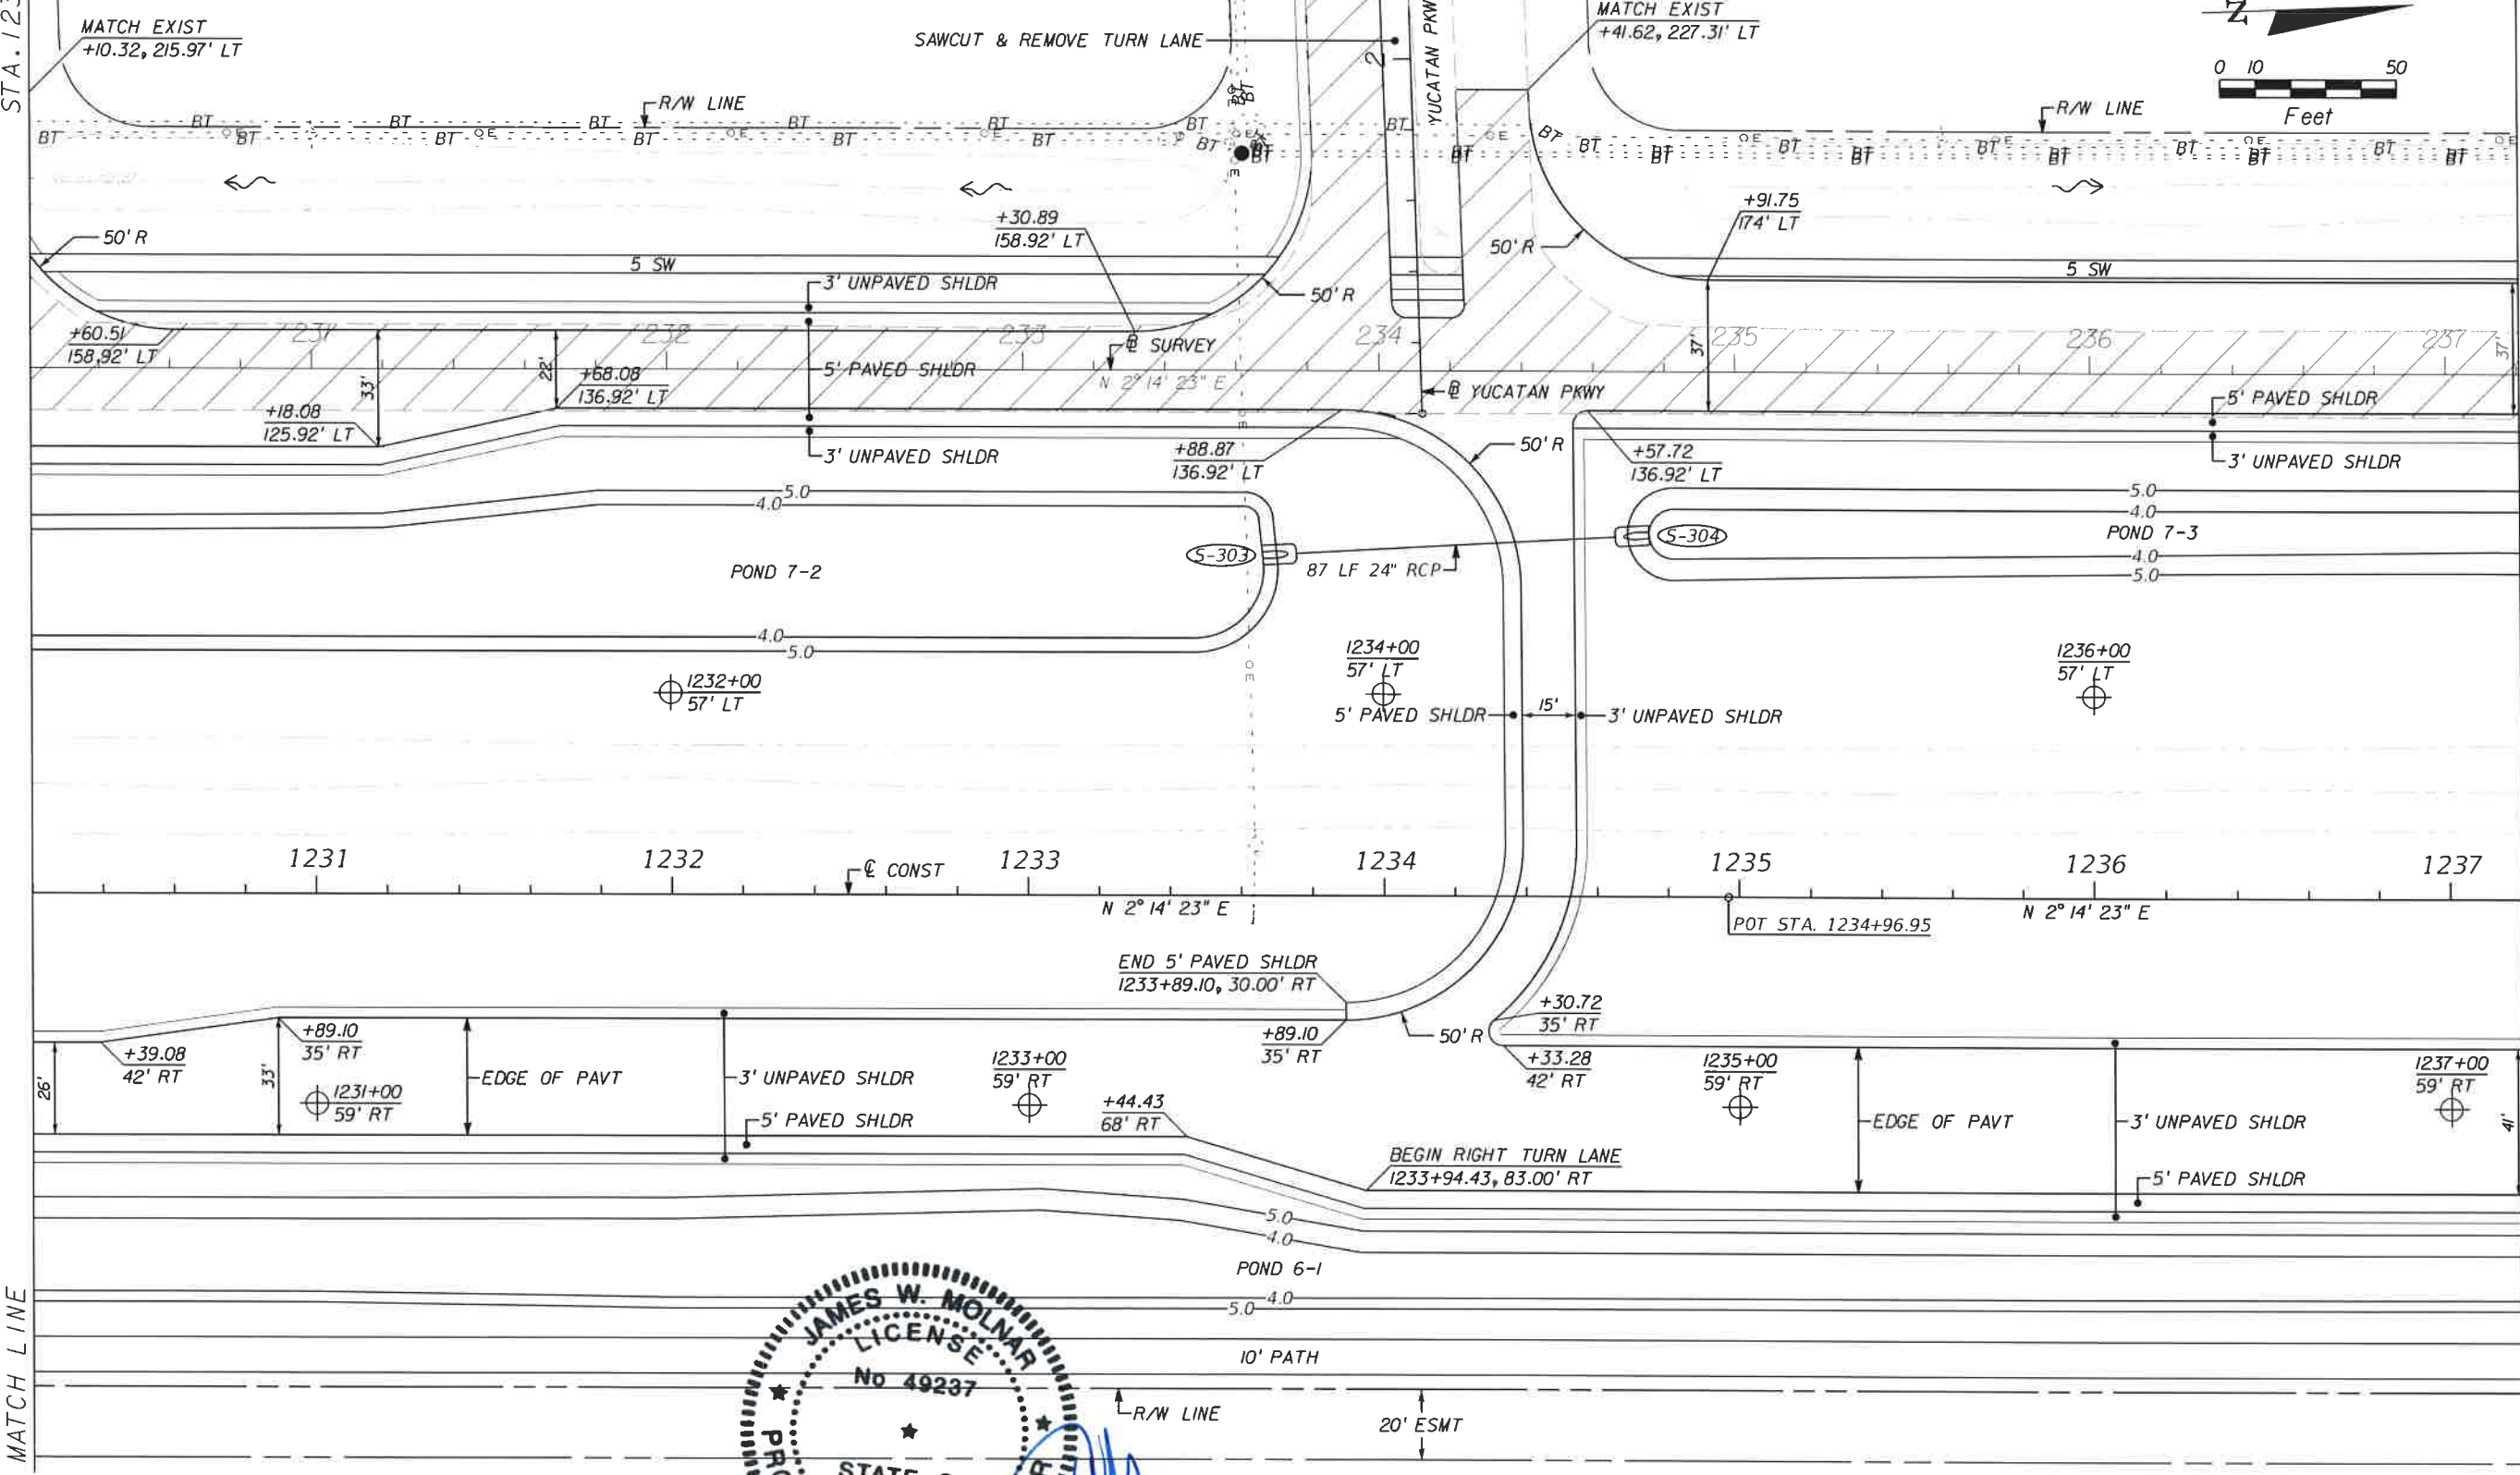

NO.	DATE	BY	REVISIONS - DESCRIPTION

T.Y. LIN INTERNATIONAL
 2400 FIRST STREET
 SUITE 200
 FORT MYERS, FLORIDA 33901
 TEL. (239) 332-4846
 FAX. (239) 332-4798
 WWW.TYLIN.COM

JAMES W. MOLNAR, P.E.
 REGISTERED PROFESSIONAL ENGINEER
 FLORIDA CERTIFICATE NO. 49237
 3-5-2015

PUBLIC WORKS
LEE COUNTY
SOUTHWEST
FLORIDA
 1500 MINOR STREET
 FORT MYERS, FLORIDA 33901
 (239) 479-8900 www.lee-county.com/publicworks/dotfile.htm


DEPARTMENT
of
TRANSPORTATION

PLAN SHEET
STA. 1230+20.00 TO STA. 1237+20.00
BURNT STORE ROAD

SHEET NO.
 26

STA. 1237+20.00

STA. 1244+20.00

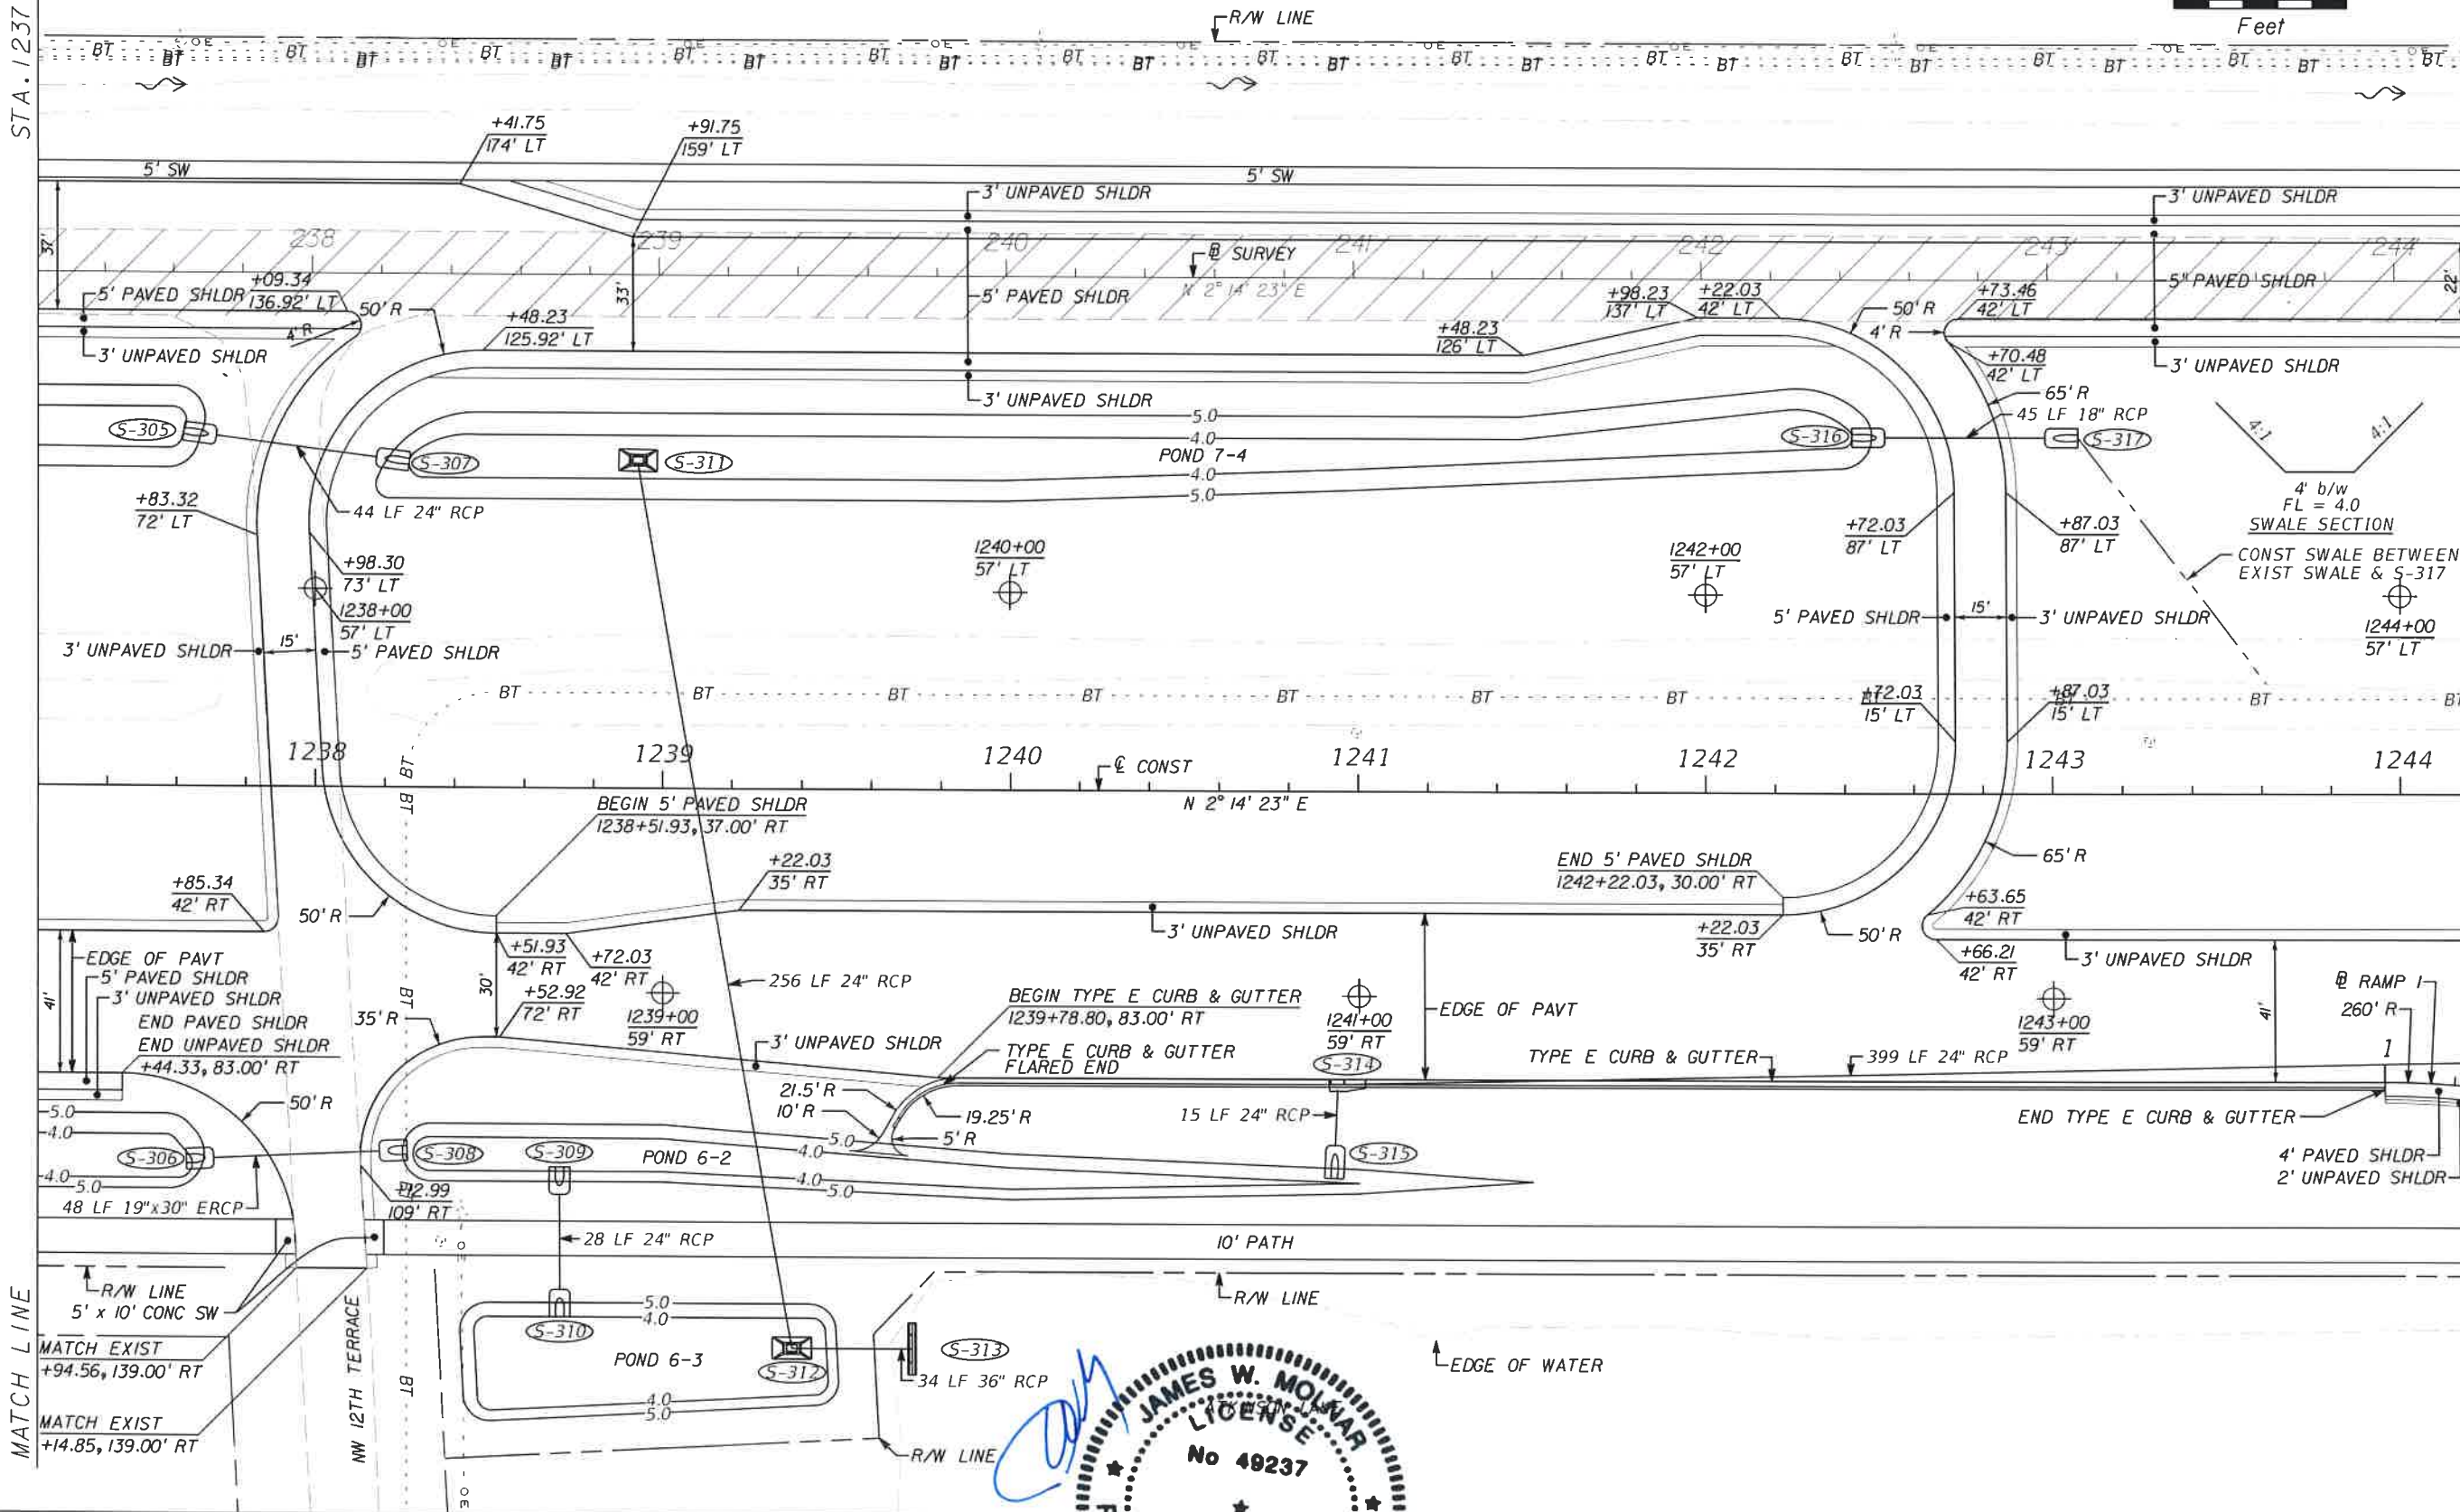


MATCH LINE

MATCH LINE

NO.	DATE	BY	REVISIONS - DESCRIPTION

T.Y. LIN INTERNATIONAL
 2400 FIRST STREET
 SUITE 200
 FORT MYERS, FLORIDA 33901
 TEL. (239) 332-4846
 FAX. (239) 332-4798
 WWW.TYLIN.COM

APPROVED BY:
JAMES W. MOLNAR
 REGISTERED PROFESSIONAL
 FLORIDA CERTIFICATE NO.
 3-5-2015

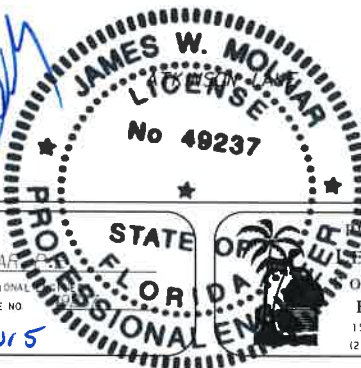


PUBLIC WORKS
 HEE COUNTY
 DEPARTMENT
 of
 TRANSPORTATION
 FORT MYERS, FLORIDA 33901
 1500 MONROE STREET
 (239) 479-8900 www.hee-county.com/publicworks/ds/Title.htm

PLAN SHEET
STA. 1237+20.00 TO STA. 1244+20.00
BURNT STORE ROAD

SHEET
 NO.
 27

STA. 1244+20.00

STA. 1251+20.00

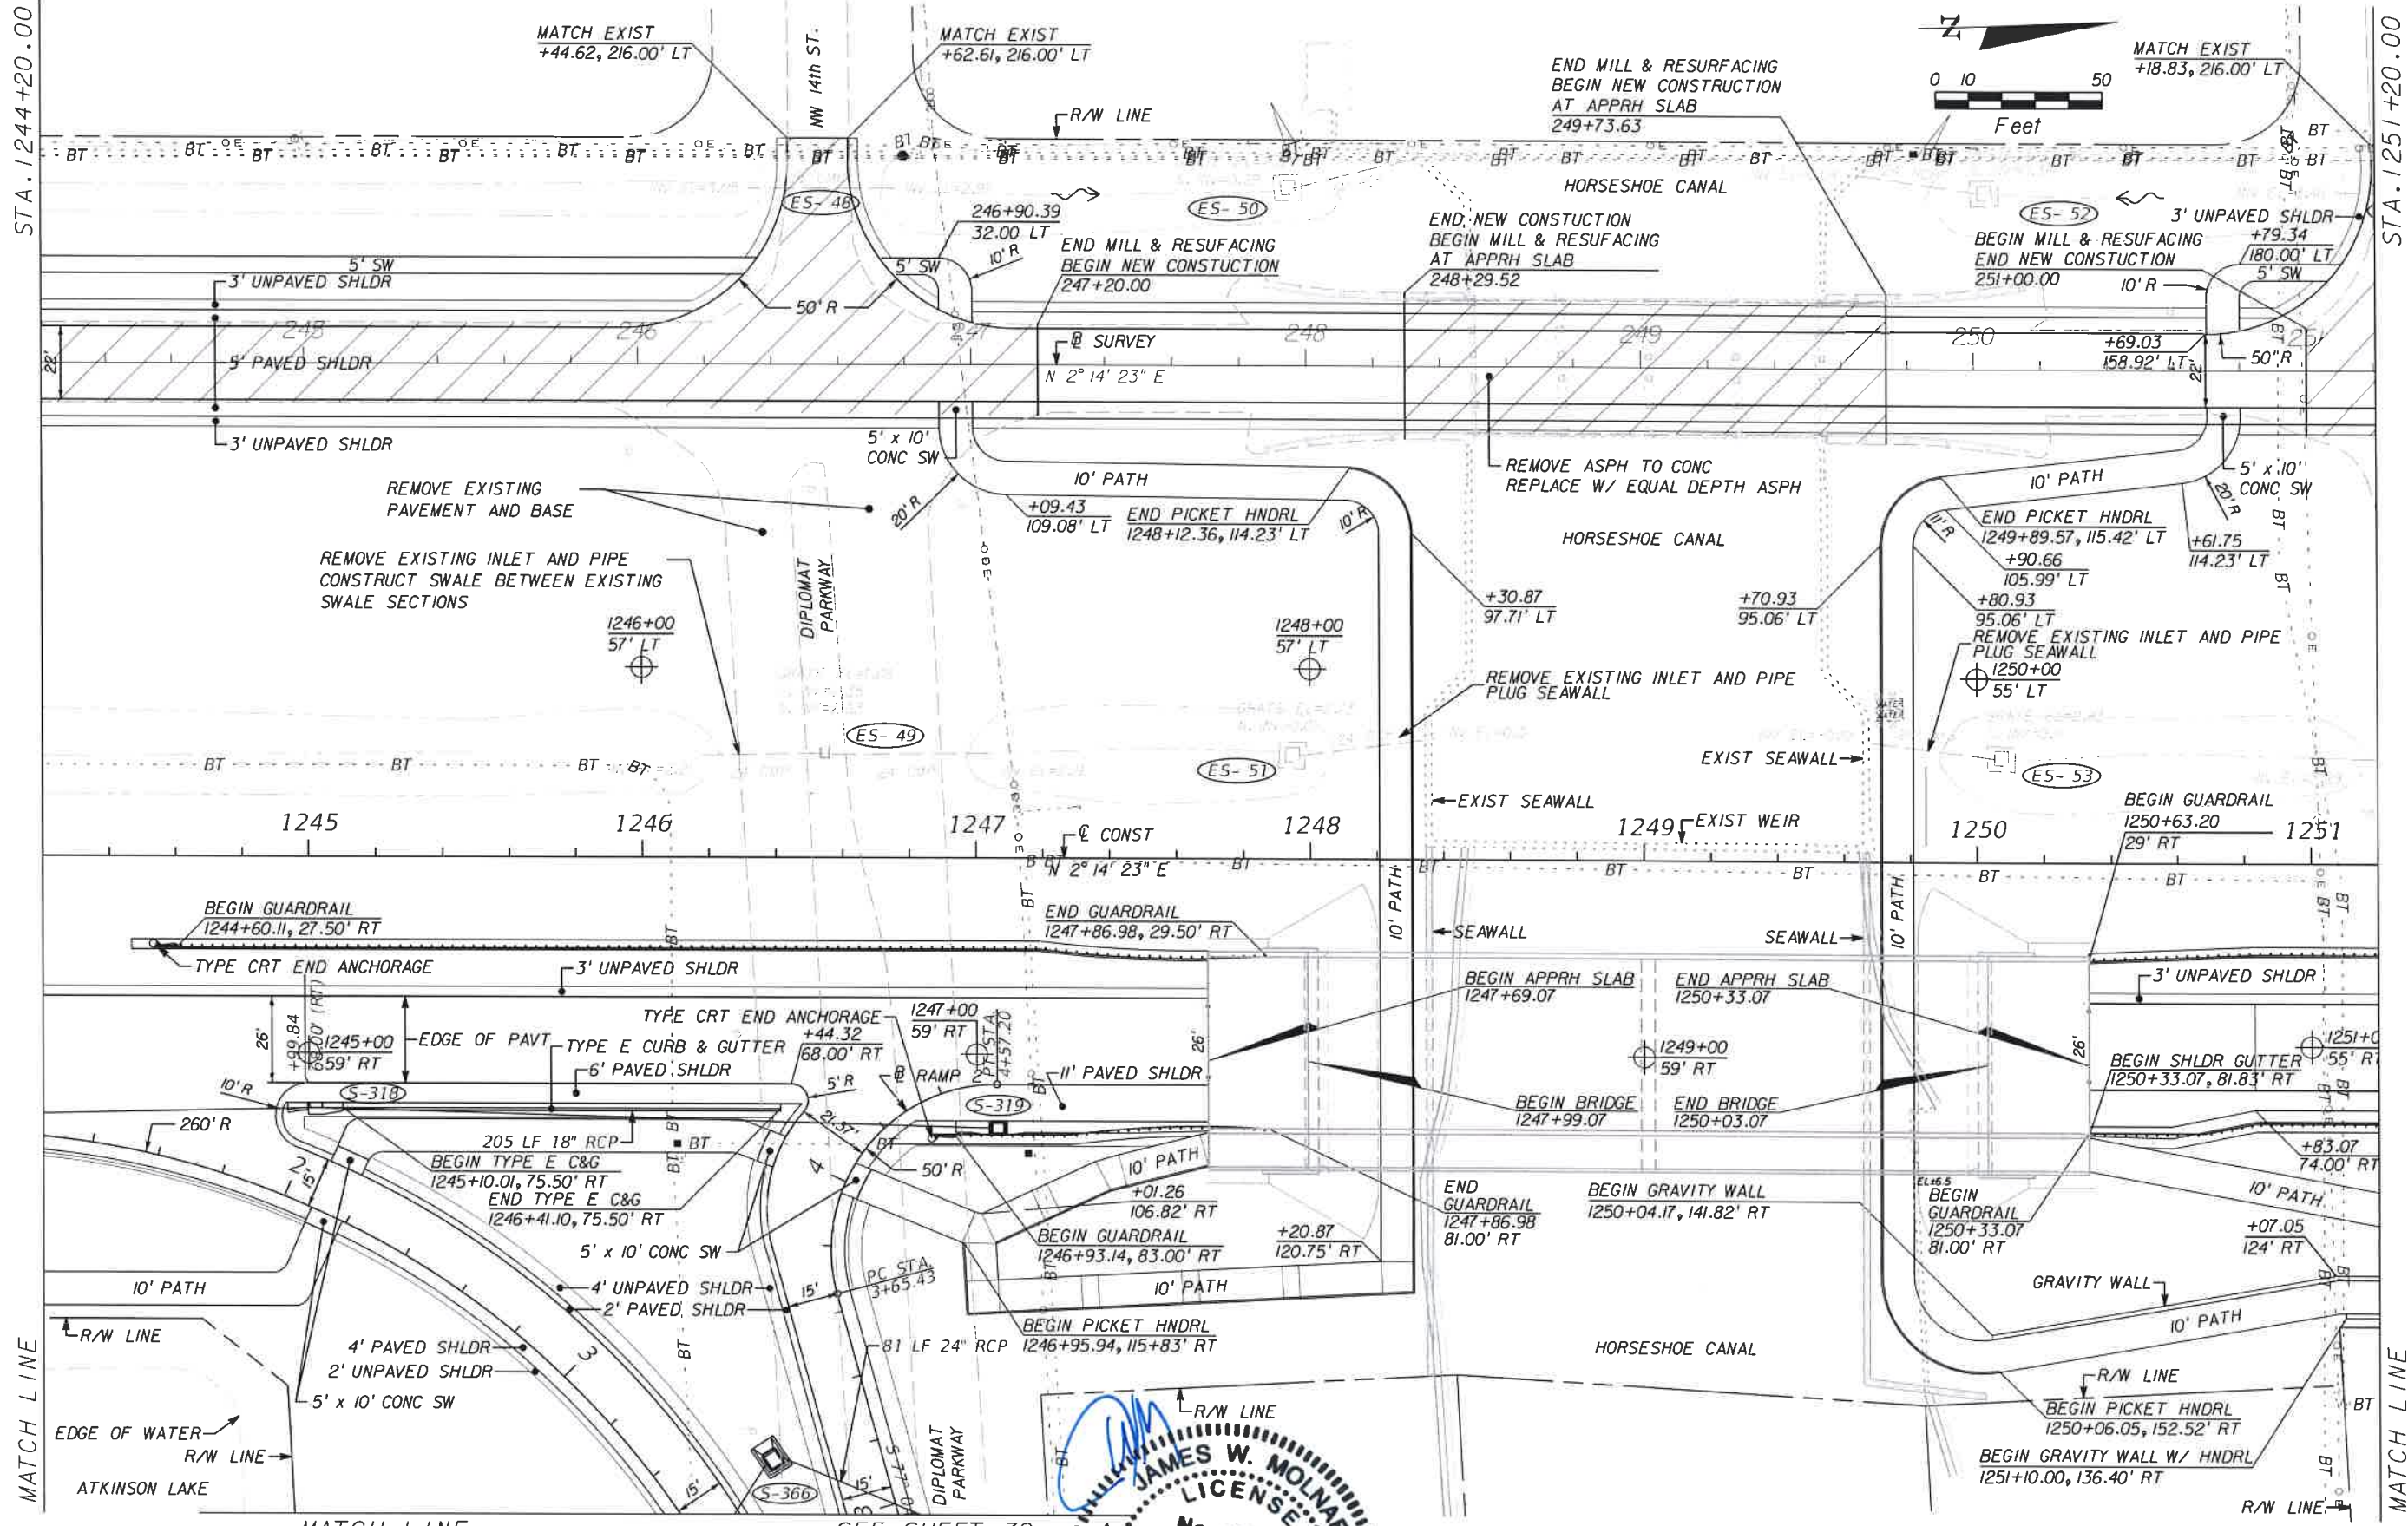

NO.	DATE	BY	REVISIONS - DESCRIPTION

T.Y. LIN INTERNATIONAL
 2400 FIRST STREET
 SUITE 200
 FORT MYERS, FLORIDA 33901
 TEL. (239) 332-4846
 FAX. (239) 332-4798
 WWW.TYLIN.COM




APPROVED BY:
JAMES W. MOLNAR
 REGISTERED PROFESSIONAL ENGINEER
 FLORIDA CERTIFICATE NO. 49237
 3-5-2015

PLANNING WORKS
 LEE COUNTY
 PALM BEACH WEST
 FLORIDA
 100 MONROE STREET
 FORT MYERS, FLORIDA 33901
 rshields 3/4/2015 4:54:56 PM

PLAN SHEET
STA. 1244+20.00 TO STA. 1251+20.00
BURNT STORE ROAD

SHEET NO.
 28

T:\Tampa\Legacy\Projects\581595.00-Burnt_Store_RD\Burnt_Store_roadway\planr22.dgn

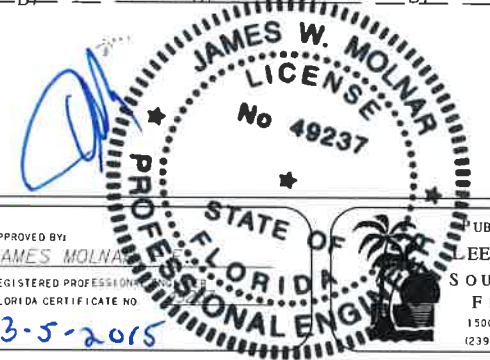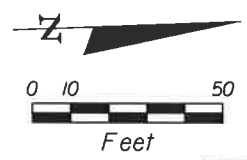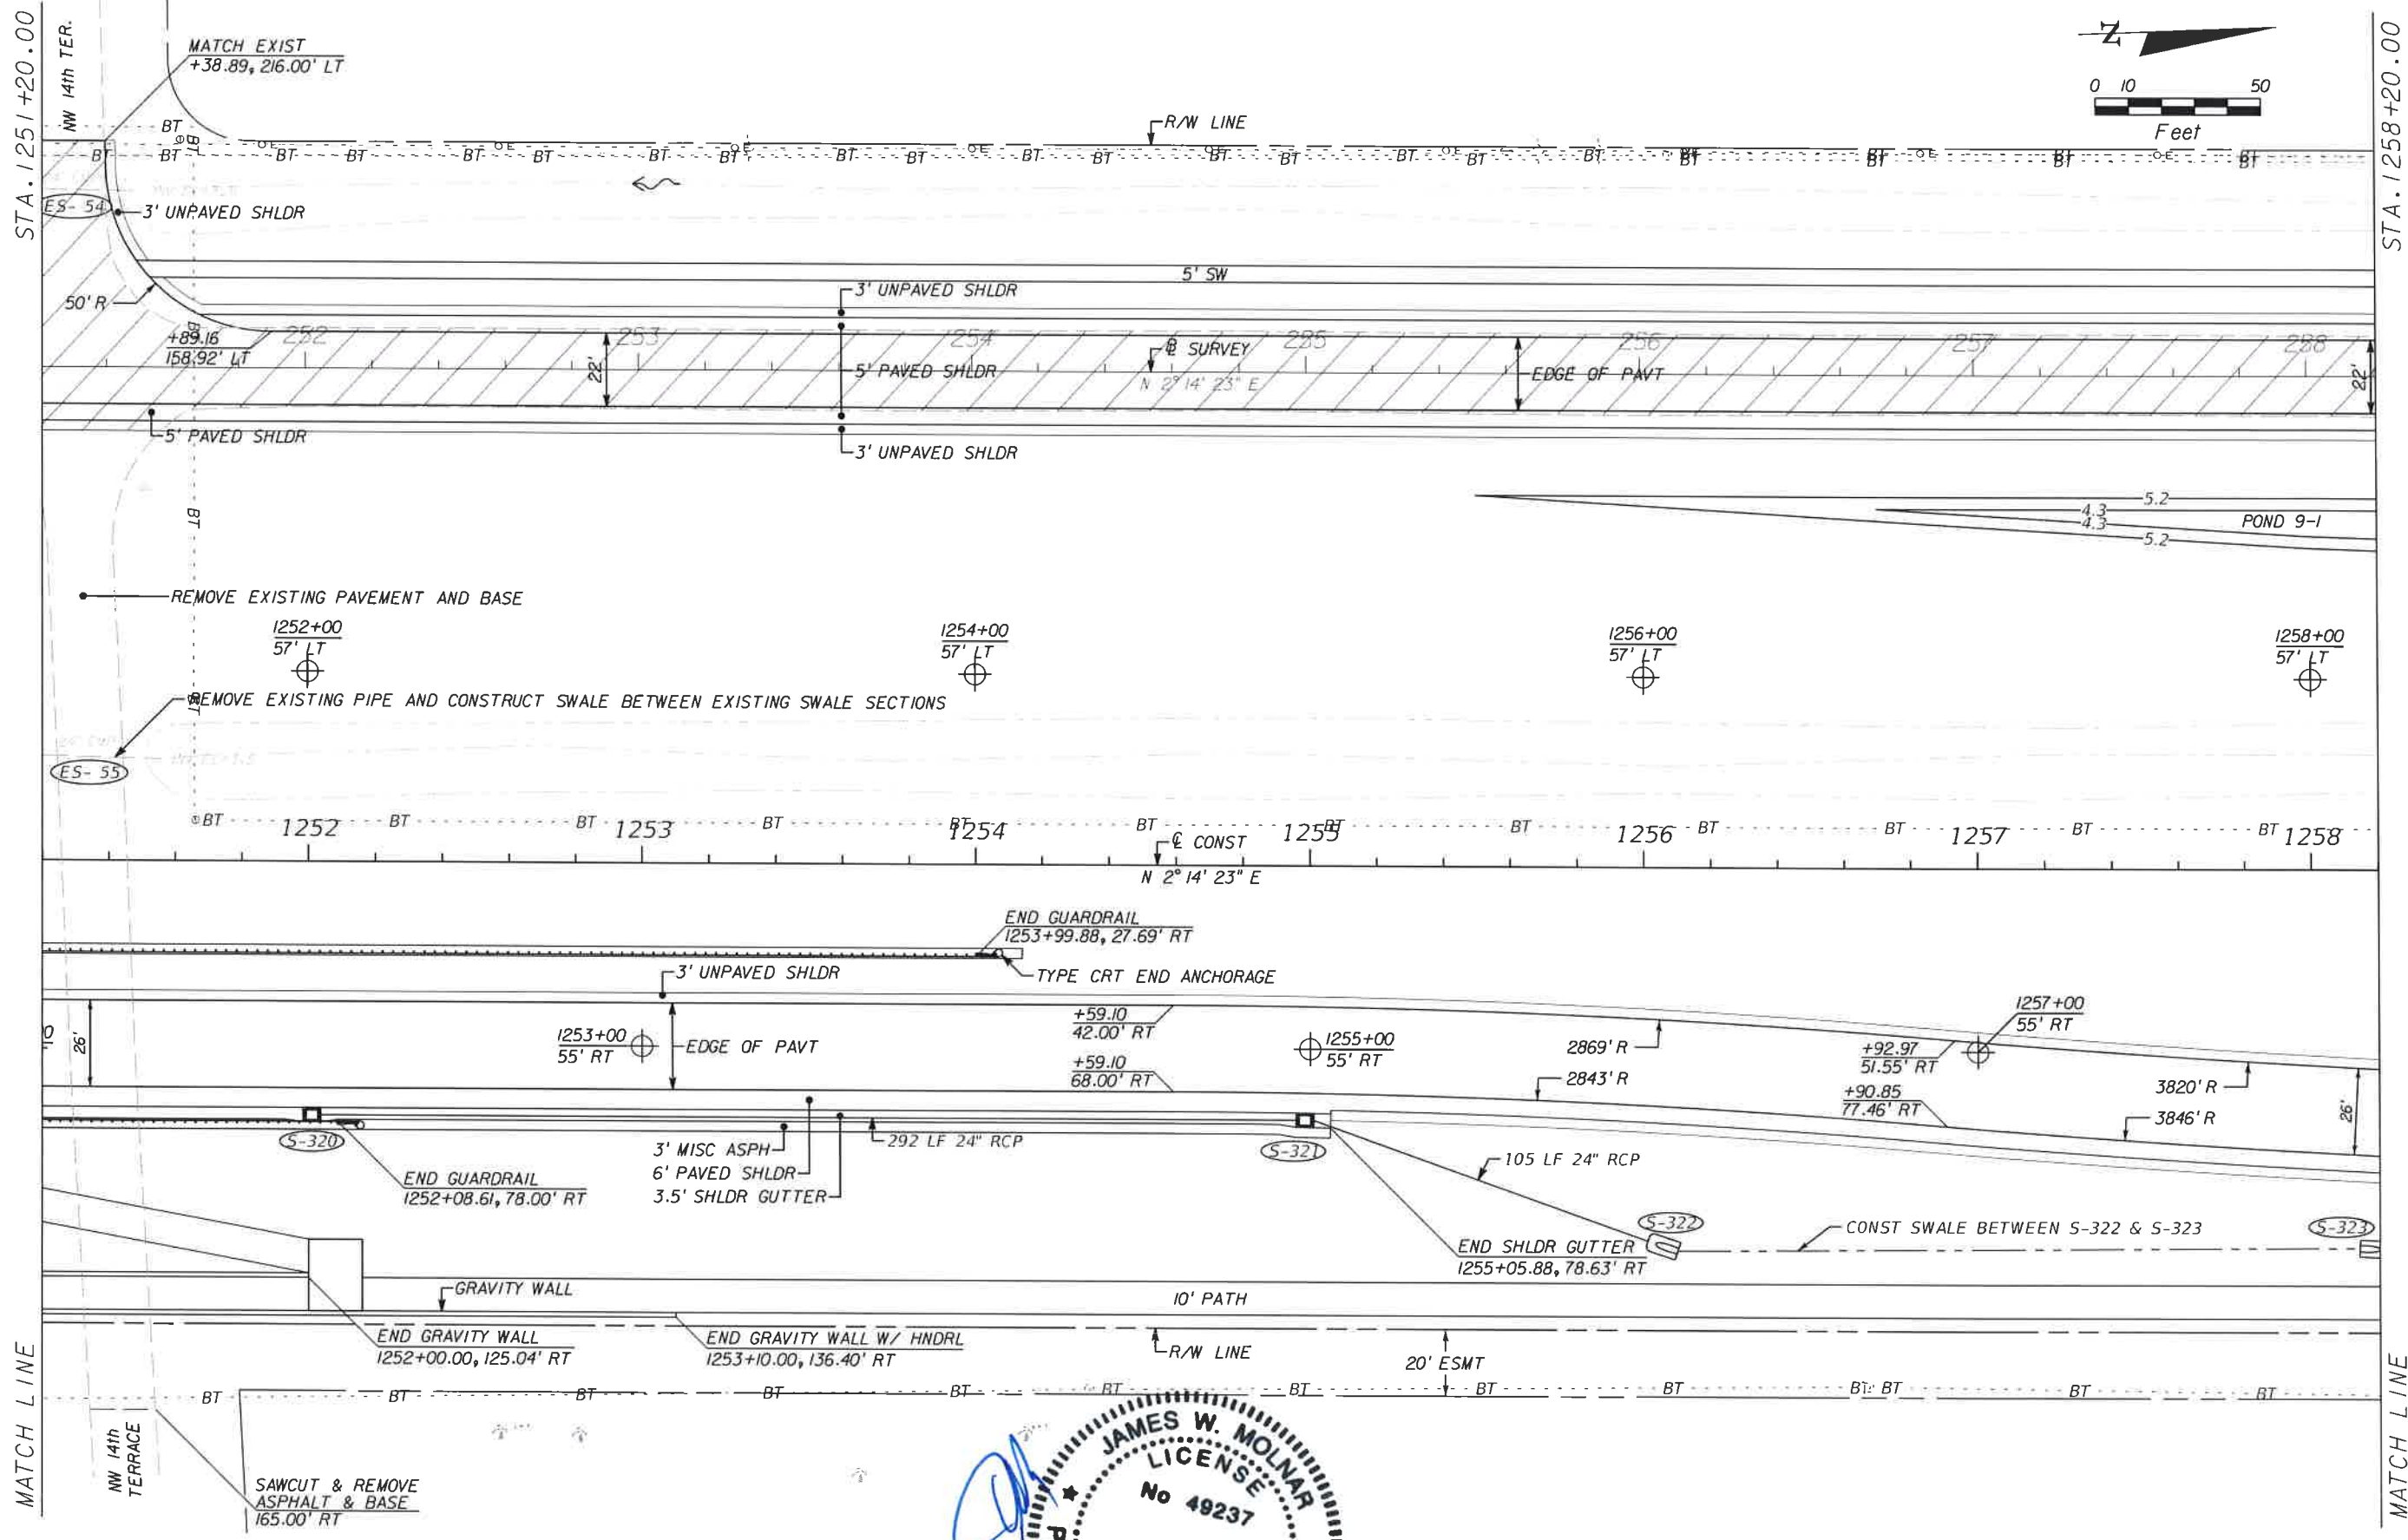

NO.	DATE	BY	REVISIONS	DESCRIPTION

T.Y. LIN INTERNATIONAL
 2400 FIRST STREET
 SUITE 200
 FORT MYERS, FLORIDA 33901
 TEL. (239) 332-4846
 FAX. (239) 332-4798
 WWW.TYLIN.COM

APPROVED BY:
JAMES W. MOLNAR
 REGISTERED PROFESSIONAL ENGINEER
 FLORIDA CERTIFICATE NO. 49237
 3-5-2015

PUBLIC WORKS
 LEE COUNTY
 SOUTHWEST FLORIDA
 1500 MONROE STREET
 FORT MYERS, FLORIDA 33901
 (239) 479-8900 www.lee-county.com/publicworks/default.htm
 rah/lda 3/4/2015 4:55:47 PM


DEPARTMENT of TRANSPORTATION

PLAN SHEET
STA. 1251+20.00 TO STA. 1258+20.00
BURNT STORE ROAD

SHEET NO.
 29


STA. 1258+20.00

STA. 1265+20.00

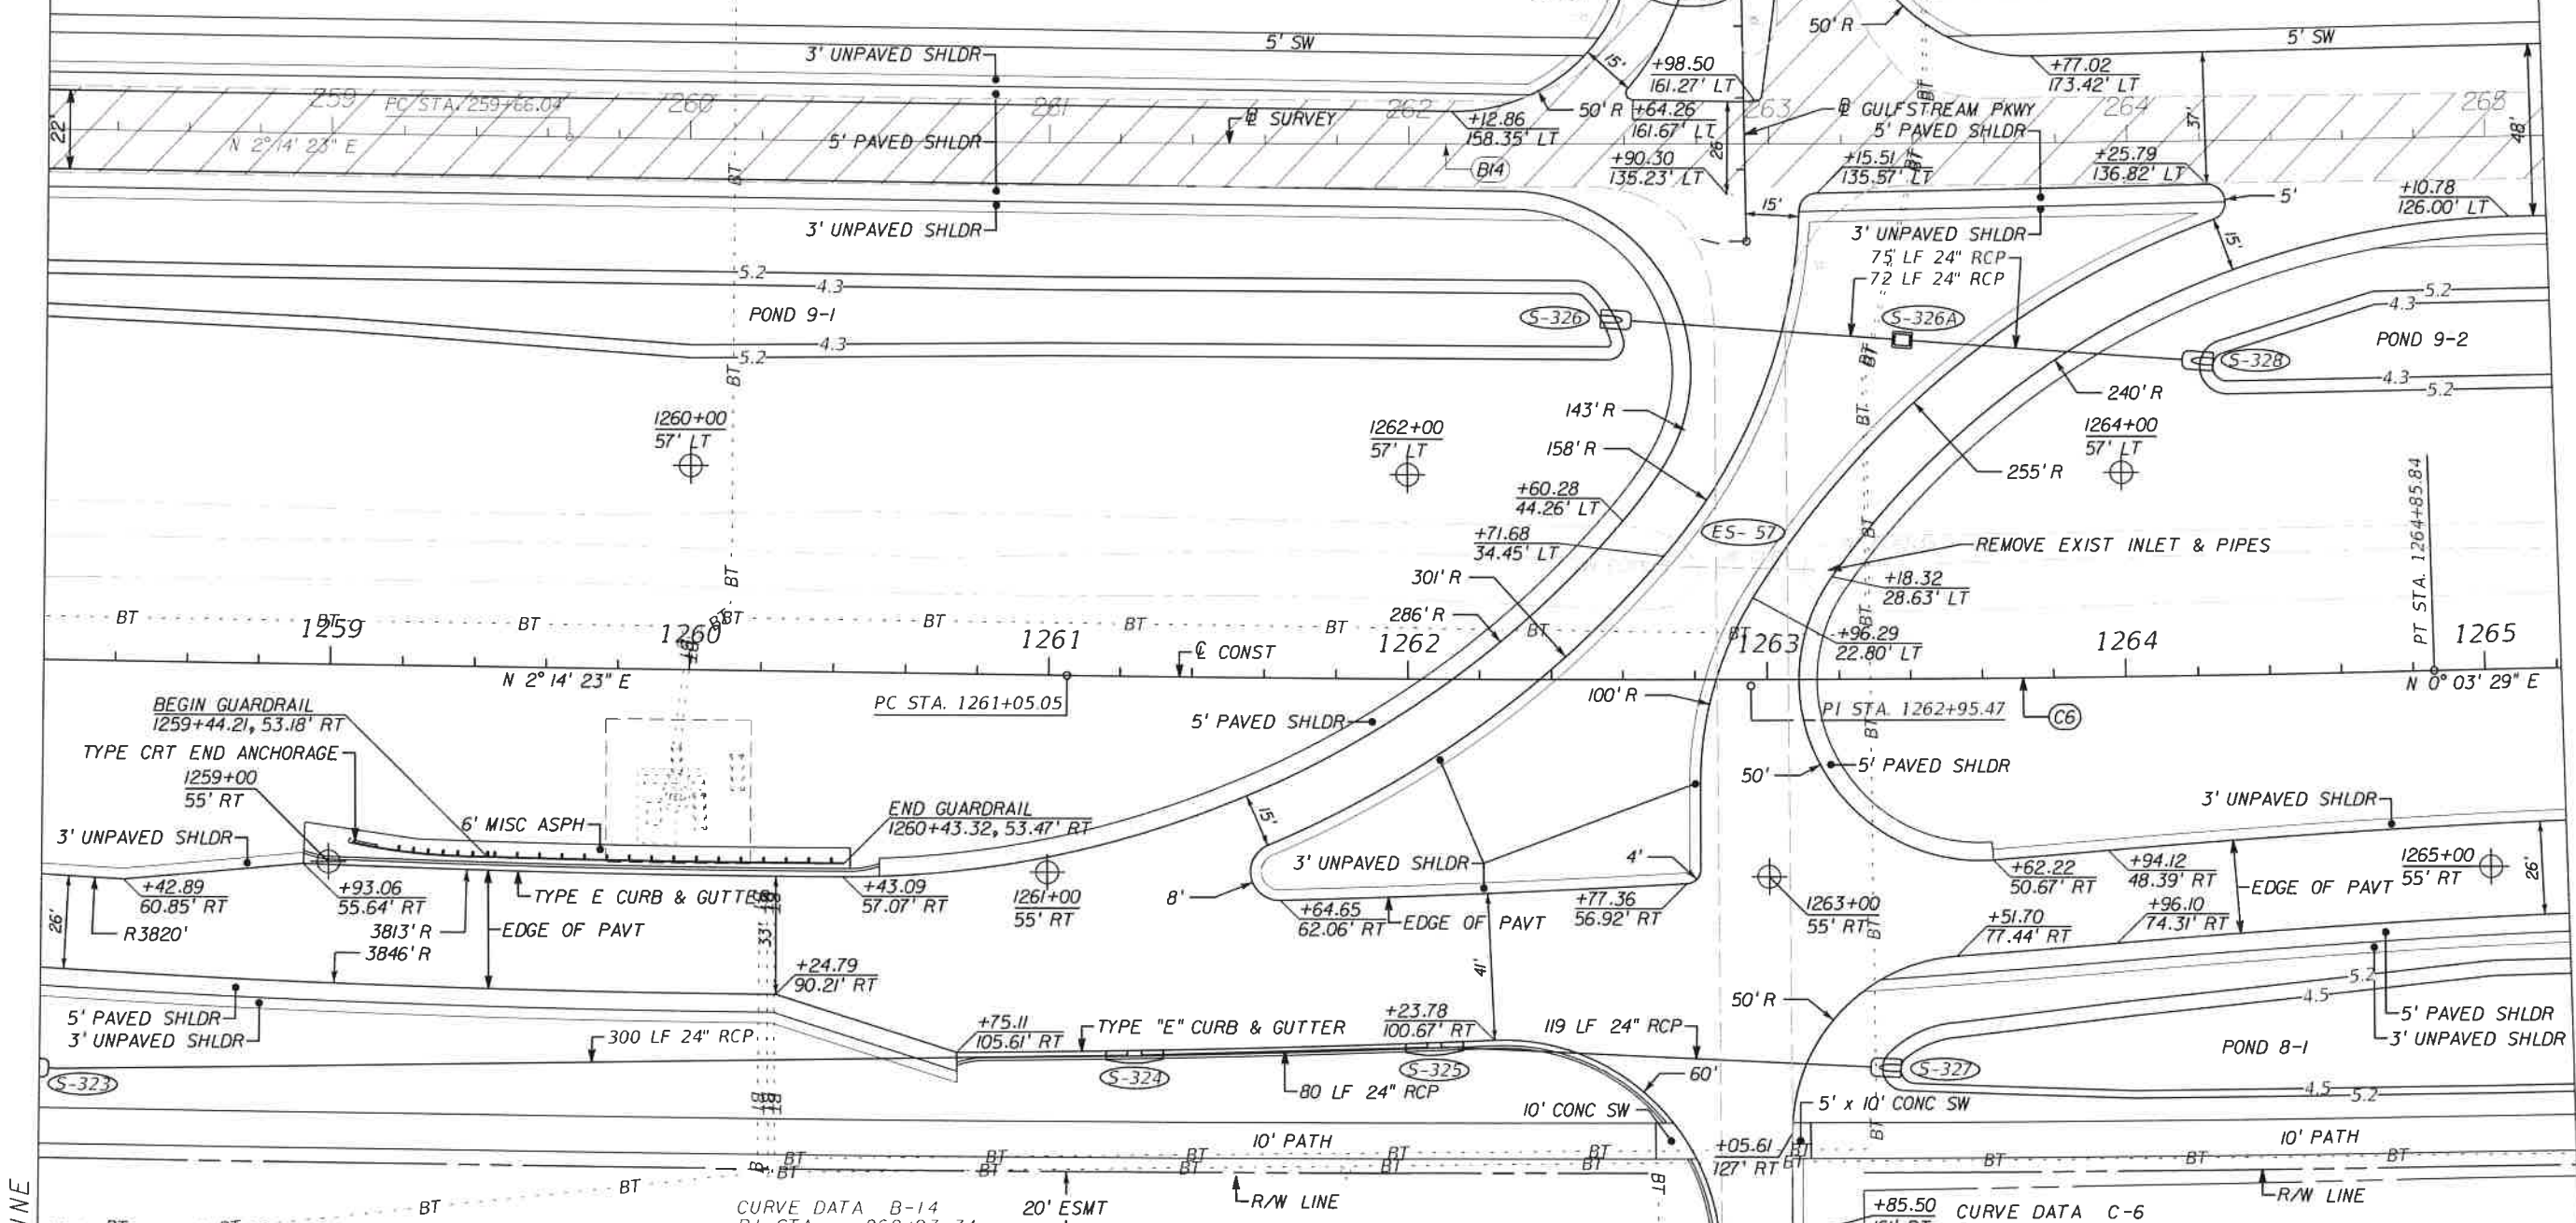

CURVE DATA B-14
 PI STA. = 262+93.34
 DELTA = 2° 10' 54" (LT)
 D = 0° 20' 00"
 T = 327.30
 L = 654.52
 R = 17,188.73
 PC STA. = 259+66.04
 PT STA. = 266+20.56

CURVE DATA C-6
 PI STA. = 1262+95.47
 DELTA = 2° 10' 54" (LT)
 D = 0° 34' 23"
 T = 190.42
 L = 380.79
 R = 10,000.00
 PC STA. = 1261+05.05
 PT STA. = 1264+85.84

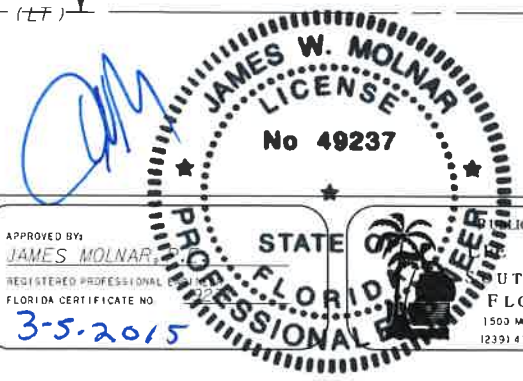

NO.	DATE	BY	REVISIONS - DESCRIPTION

T.Y. LIN INTERNATIONAL
 2400 FIRST STREET
 SUITE 200
 FORT MYERS, FLORIDA 33901
 TEL. (239) 332-4846
 FAX. (239) 332-4798
 WWW.TYLIN.COM

APPROVED BY:
JAMES W. MOLNAR
 REGISTERED PROFESSIONAL ENGINEER
 FLORIDA CERTIFICATE NO. 49237
 3-5-2015



PUBLIC WORKS
 COUNTY OF SOUTHWEST FLORIDA
 DEPARTMENT of TRANSPORTATION
 FORT MYERS, FLORIDA 33901
 1500 MONROE STREET
 12391 479-8900 www.fwp.com/publicworks/dsdlife.htm
 rshields 3/4/2015 4:56:38 PM

PLAN SHEET
STA. 1258+20.00 TO STA. 1265+20.00
BURNT STORE ROAD

SHEET NO.
 30

STA. 1265+20.00


STA. 1272+20.00

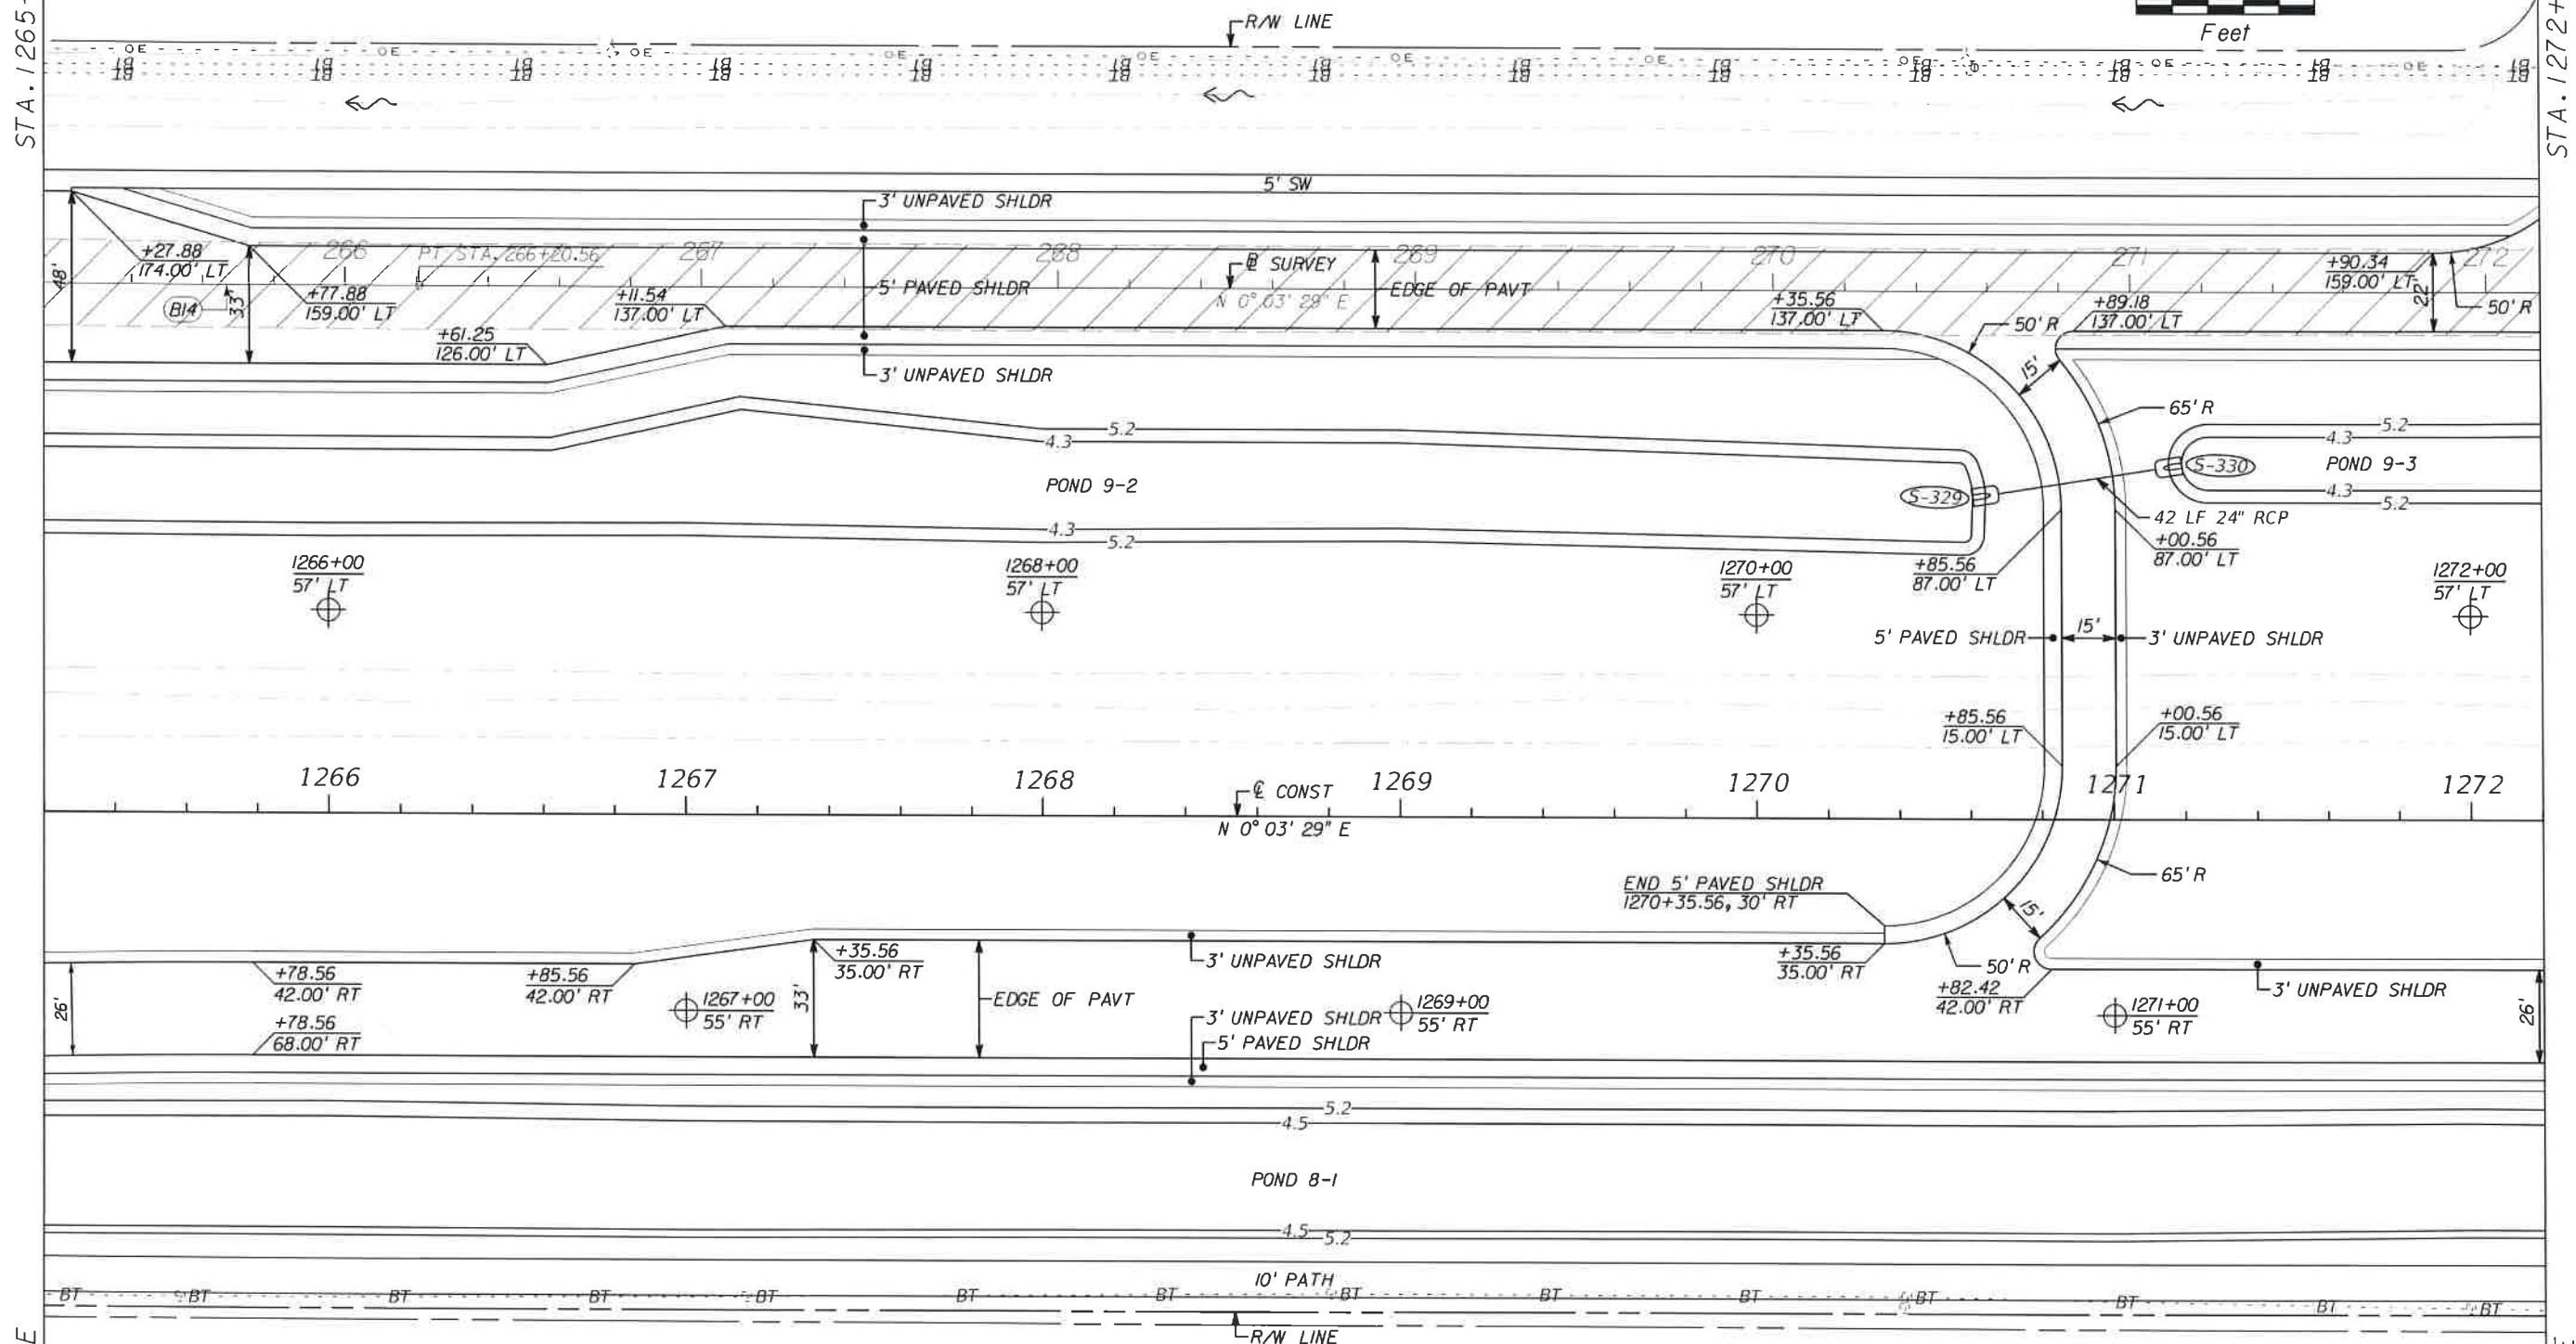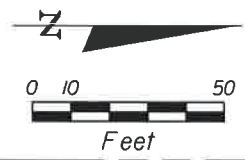

MATCH LINE

CURVE DATA B-14
 PI STA. = 262+93.34
 DELTA = 2° 10' 54" (LT)
 D = 0° 20' 00"
 T = 327.30
 L = 654.52
 R = 17,188.73
 PC STA. = 259+66.04
 PT STA. = 266+20.56

MATCH LINE

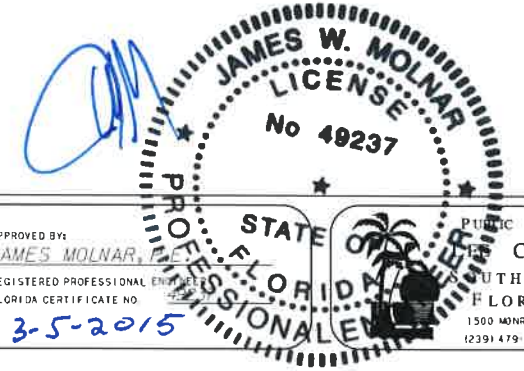

NO.	DATE	BY	REVISIONS - DESCRIPTION

T.Y. LIN INTERNATIONAL
 2400 FIRST STREET
 SUITE 200
 FORT MYERS, FLORIDA 33901
 TEL. (239) 332-4846
 FAX. (239) 332-4798
 WWW.TYLIN.COM

APPROVED BY:
JAMES W. MOLNAR, P.E.
 REGISTERED PROFESSIONAL ENGINEER
 FLORIDA CERTIFICATE NO. 49237
 3-5-2015


PUBLIC WORKS
 LEWIS COUNTY
 SOUTHWEST
 FLORIDA
 1500 MONROE STREET
 FORT MYERS, FLORIDA 33901
 12391 479-8900 www.lee-county.com/publicworks/dsllite.htm
 rshields 3/4/2015 4:57:28 PM

PLAN SHEET
STA. 1265+20.00 TO STA. 1272+20.00
BURNT STORE ROAD

SHEET NO.
 31
 Default

STA. 1272+20.00

STA. 1279+20.00

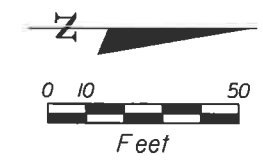

MATCH EXIST
+40.37, 216.00' LT
MATCH EXIST
+61.48, 216.00' LT

NW 17th LANE

50' R

R/W LINE

+11.44
159.00' LT

B SURVEY
N 0° 03' 29" E

3' UNPAVED SHLDR
5' SW
5' PAVED SHLDR
3' UNPAVED SHLDR

5.2-4.3
POND 9-3
4.3-5.2

S-331

1274+00
57' LT

REMOVE EXISTING PAVEMENT AND BASE

1276+00
57' LT

1278+00
57' LT

1273

1274

1275

1276

1277

1278

1279

CONST
N 0° 03' 29" E

200 LF 24" RCP

1273+00
55' RT

EDGE OF PAVT
1275+00
55' RT

3' UNPAVED SHLDR
5' PAVED SHLDR

1277+00
55' RT

TYPE "E" CURB & GUTTER
BEGIN TYPE E CURB & GUTTER
+93.57, 83.00' RT
+43.57
68.00' RT
1279+00
55' RT

S-332

POND 8-1

4.5-5.2

10' PATH

57 LF 36" RCP

S-333

MATCH LINE

R/W LINE

NW 17th LANE

SAWCUT & REMOVE
ASPHALT & BASE
165.00' RT



NO.	DATE	BY	REVISIONS - DESCRIPTION



T.Y. LIN INTERNATIONAL
2400 FIRST STREET
SUITE 200
FORT MYERS, FLORIDA 33901
TEL. (239) 332-4846
FAX. (239) 332-4798
WWW.TYLIN.COM

APPROVED BY
JAMES W. MOLNAR
REGISTERED PROFESSIONAL ENGINEER
FLORIDA CERTIFICATE NO. 49237
3-5-2015

PUBLIC WORKS
LEE COUNTY
OUTHWEST
FLORIDA
1500 MONROE STREET
FORT MYERS, FLORIDA 33901
12391 479-8900 www.lee-county.com/public-works/default.htm
rsfields 3/4/2015 4:58:20 PM

PLAN SHEET
STA. 1272+20.00 TO STA. 1279+20.00
BURNT STORE ROAD


SHEET NO.
32
Default

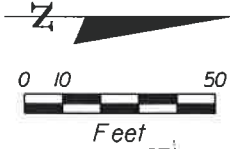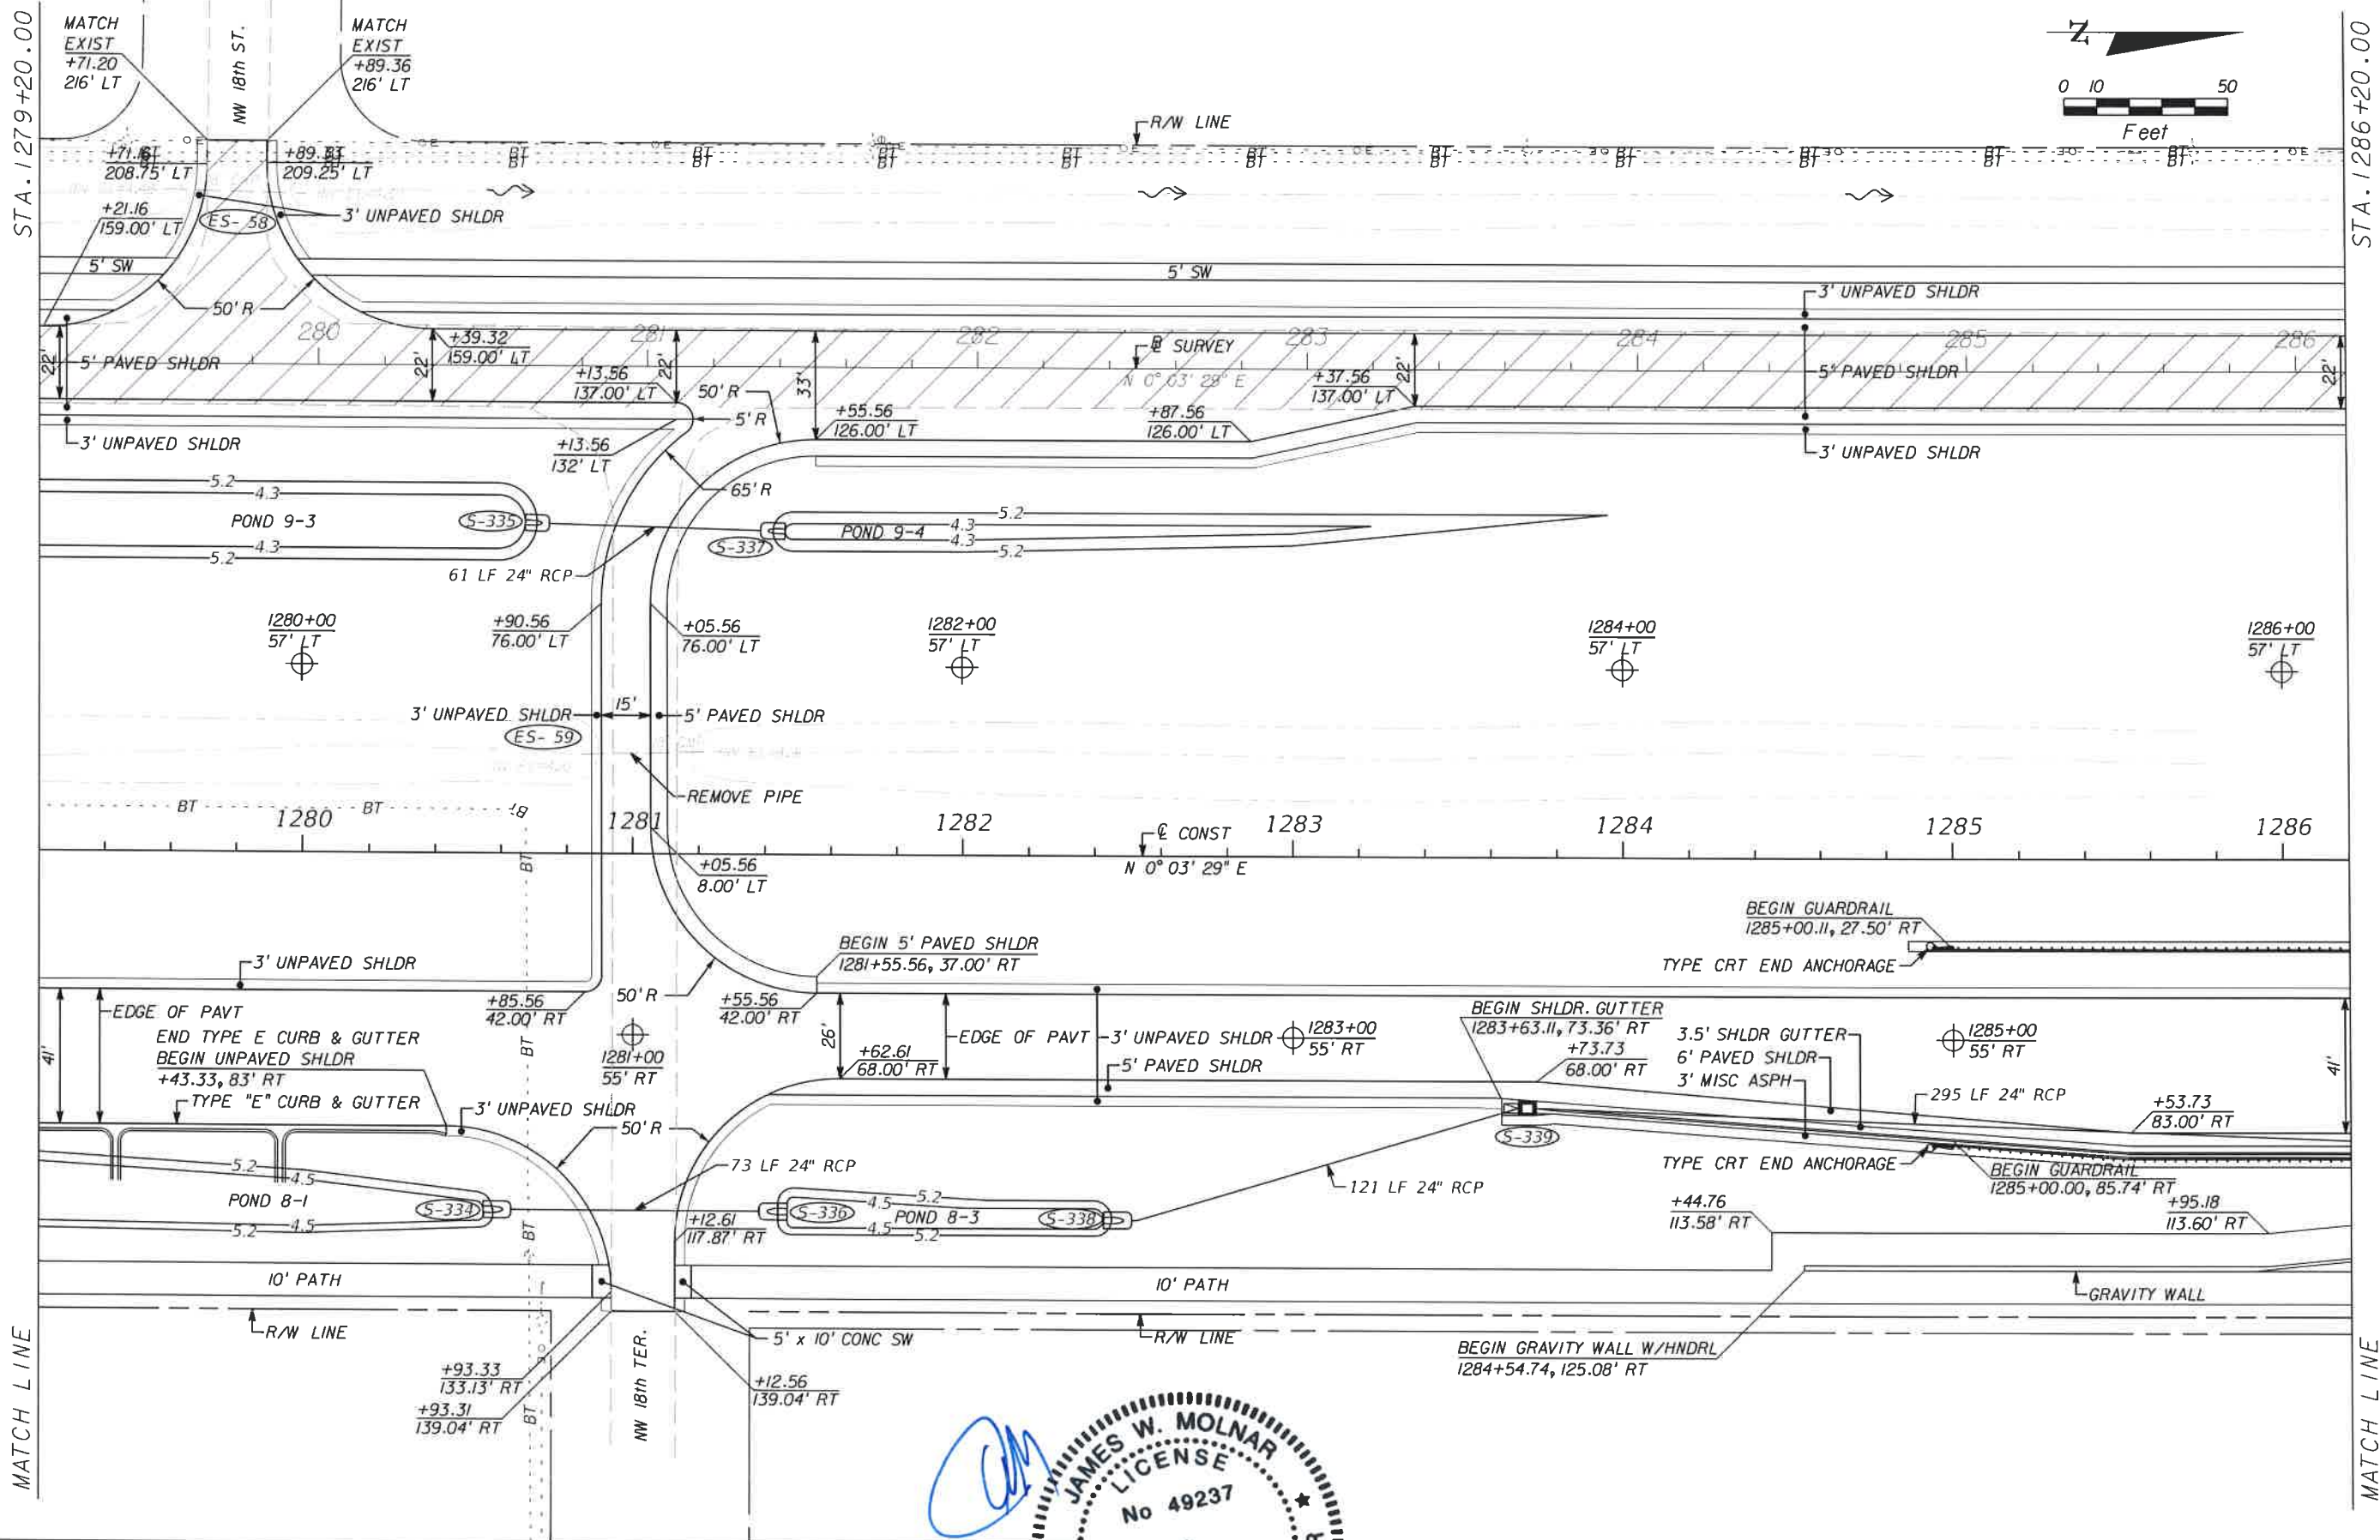

NO.	DATE	BY	REVISIONS - DESCRIPTION

T.Y. LIN INTERNATIONAL
 2400 FIRST STREET
 SUITE 200
 FORT MYERS, FLORIDA 33901
 TEL. (239) 332-4846
 FAX. (239) 332-4798
 WWW.TYLIN.COM

APPROVED BY:
JAMES W. MOLNAR
 REGISTERED PROFESSIONAL ENGINEER
 FLORIDA CERTIFICATE NO.
3-5-2015

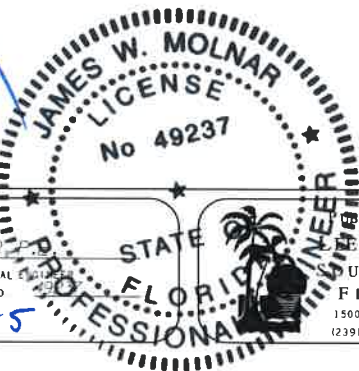




PUBLIC WORKS
 DEPARTMENT
 of
 TRANSPORTATION
 FORT MYERS, FLORIDA 33901
 1500 MONROE STREET
 (239) 479-8900
 www.flhwy.com

PLAN SHEET
STA. 1279+20.00 TO STA. 1286+20.00
BURNT STORE ROAD

SHEET NO.
33

STA. 1286+20.00

STA. 1293+20.00

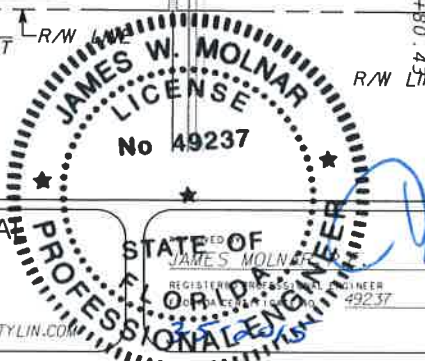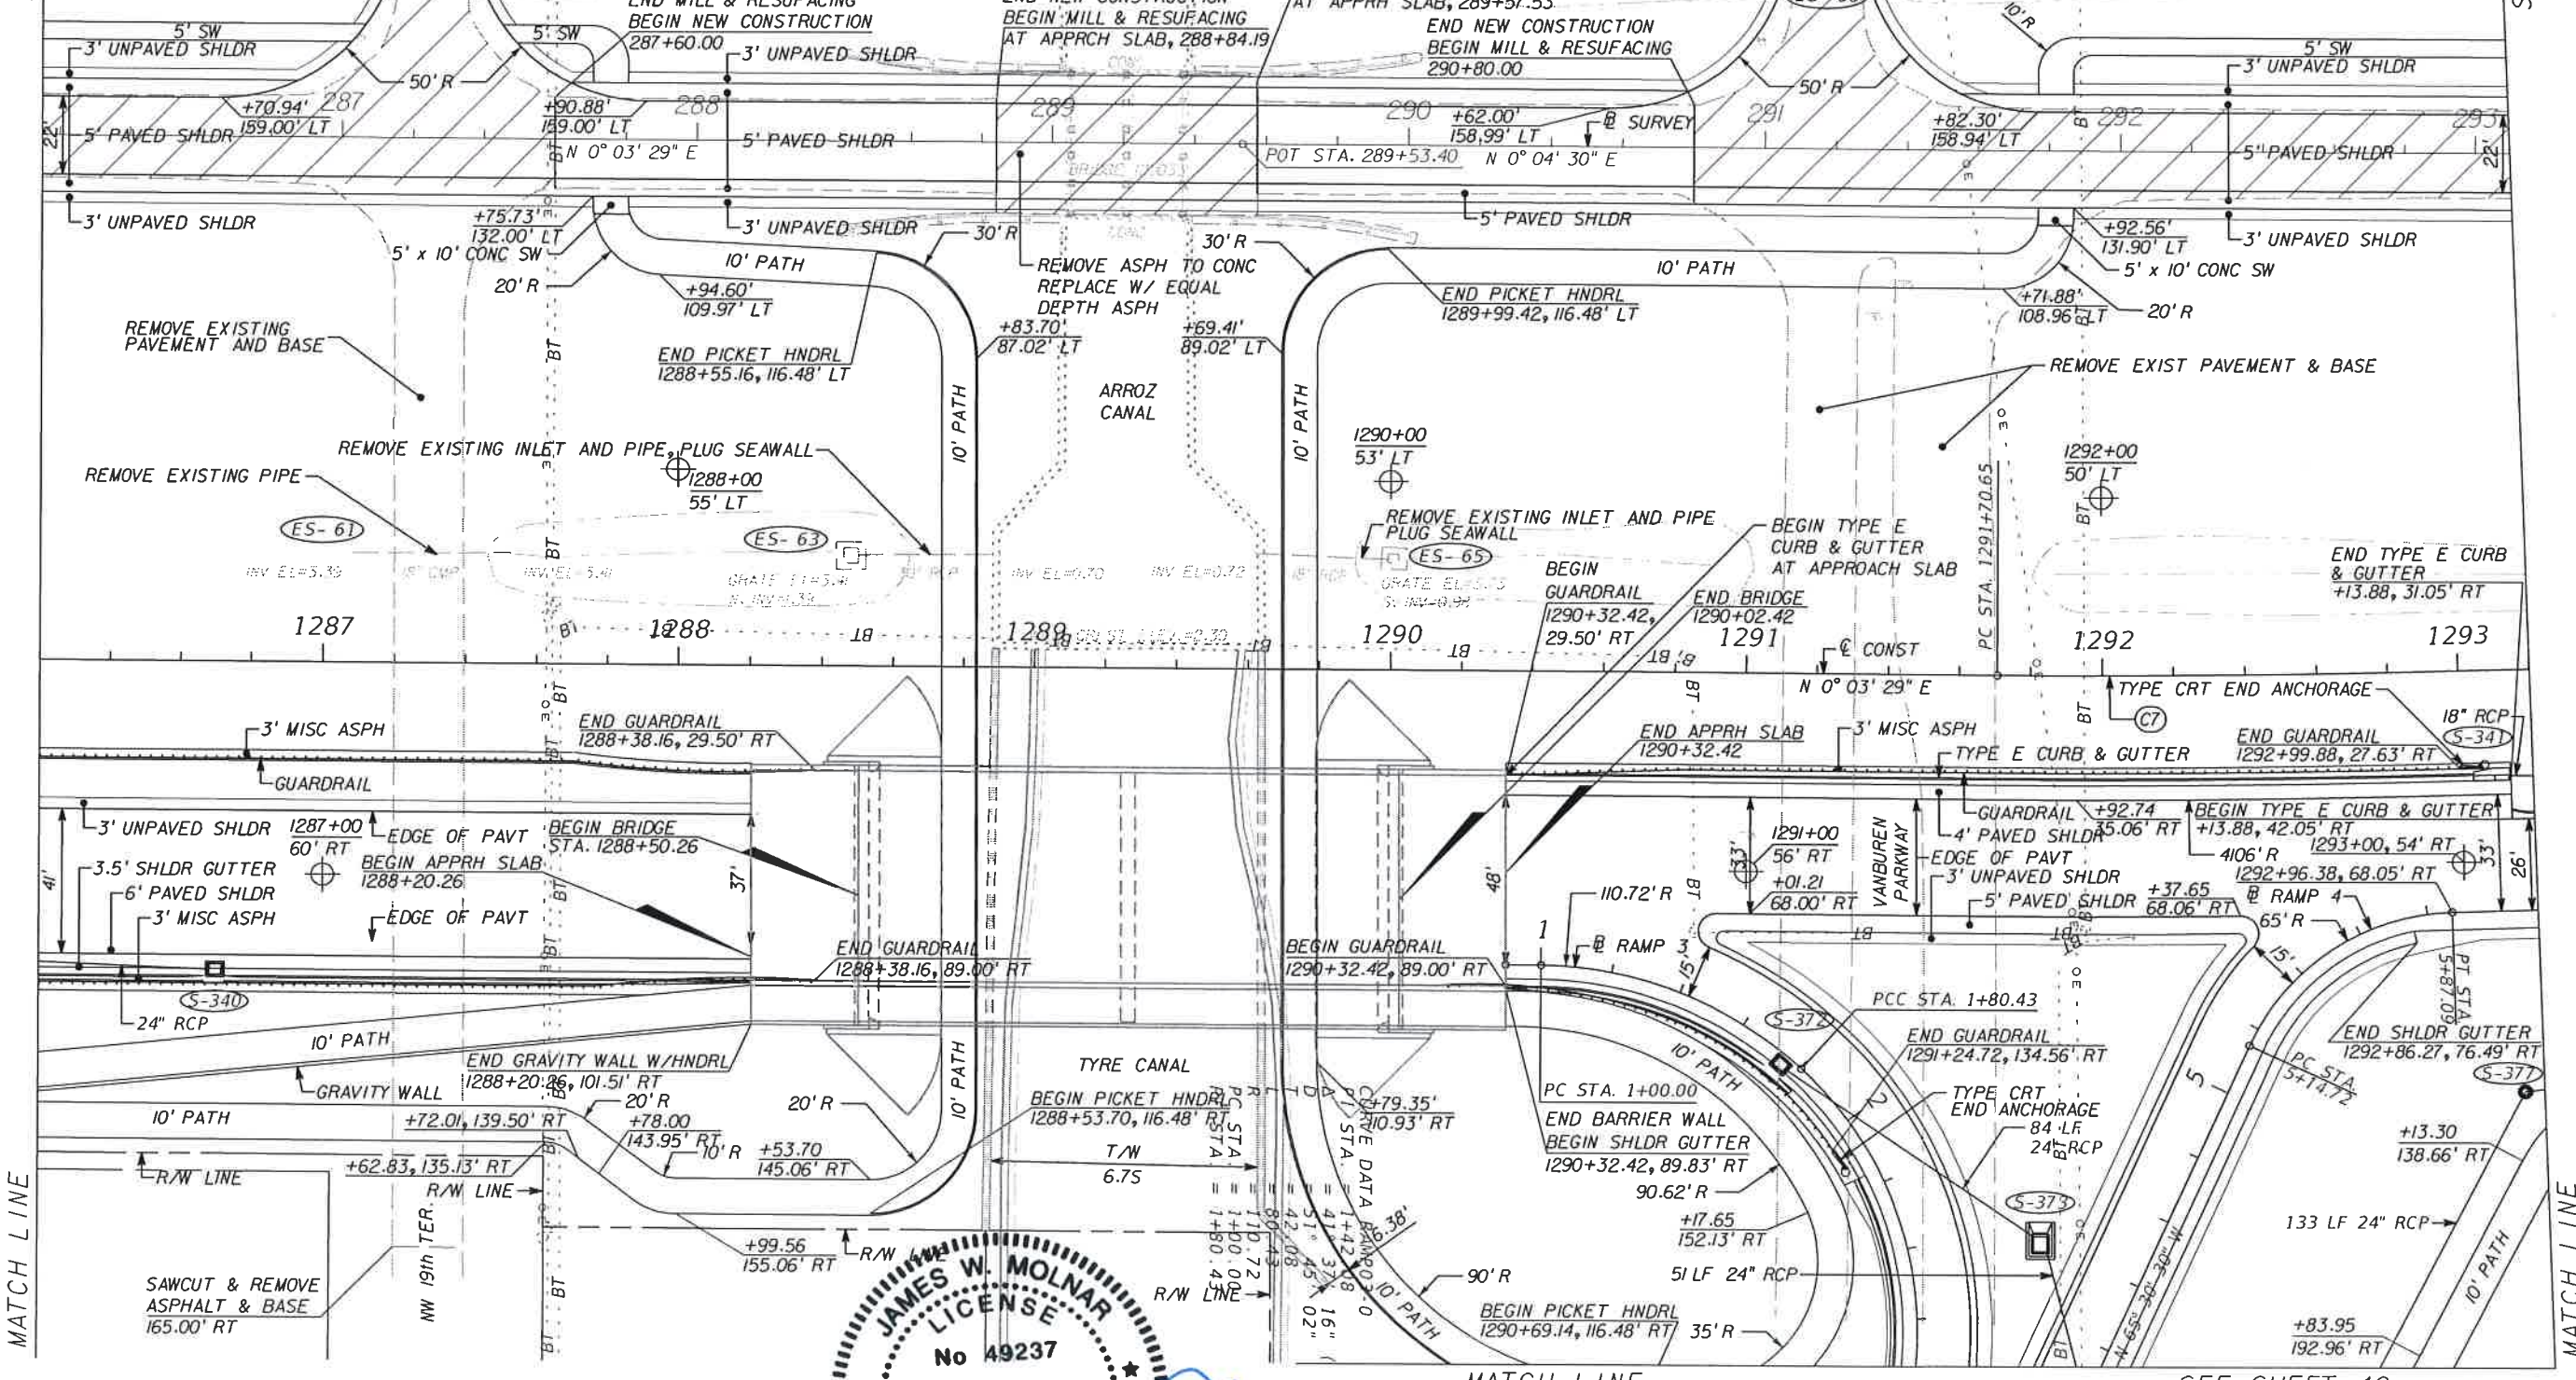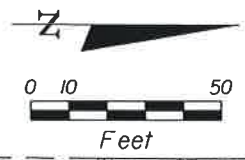

NO	DATE	BY	REVISIONS - DESCRIPTION

T.Y. LIN INTERNATIONAL
 2400 FIRST STREET
 SUITE 200
 FORT MYERS, FLORIDA 33901
 TEL. (239) 332-4846
 FAX. (239) 332-4798
 WWW.TYLIN.COM


PUBLIC WORKS
 LEE COUNTY
 SOUTHWEST
 FLORIDA
 1500 MONROE STREET
 FORT MYERS, FLORIDA 33901
 TEL. (239) 479-8900
 WWW.LEE.COUNTY.FL.GOV

DEPARTMENT
 of
 TRANSPORTATION
 PLAN SHEET
 STA. 1286+20.00 TO STA. 1293+20.00
 BURNT STORE ROAD

SHEET
 NO.
 34

T:\Temp\Legacy\Projects\581595.00\Burnt_Store_RD\Burnt_Store_Roadway\planrd28.dgn
 4/28/19 PM



STA. 1300+20.00

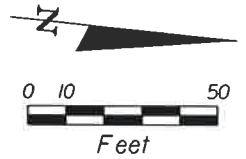

MATCH LINE

STA. 1293+20.00

MATCH LINE

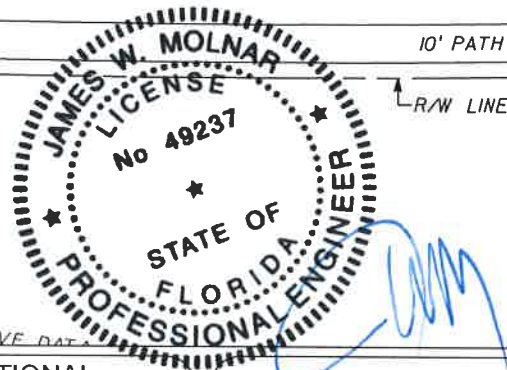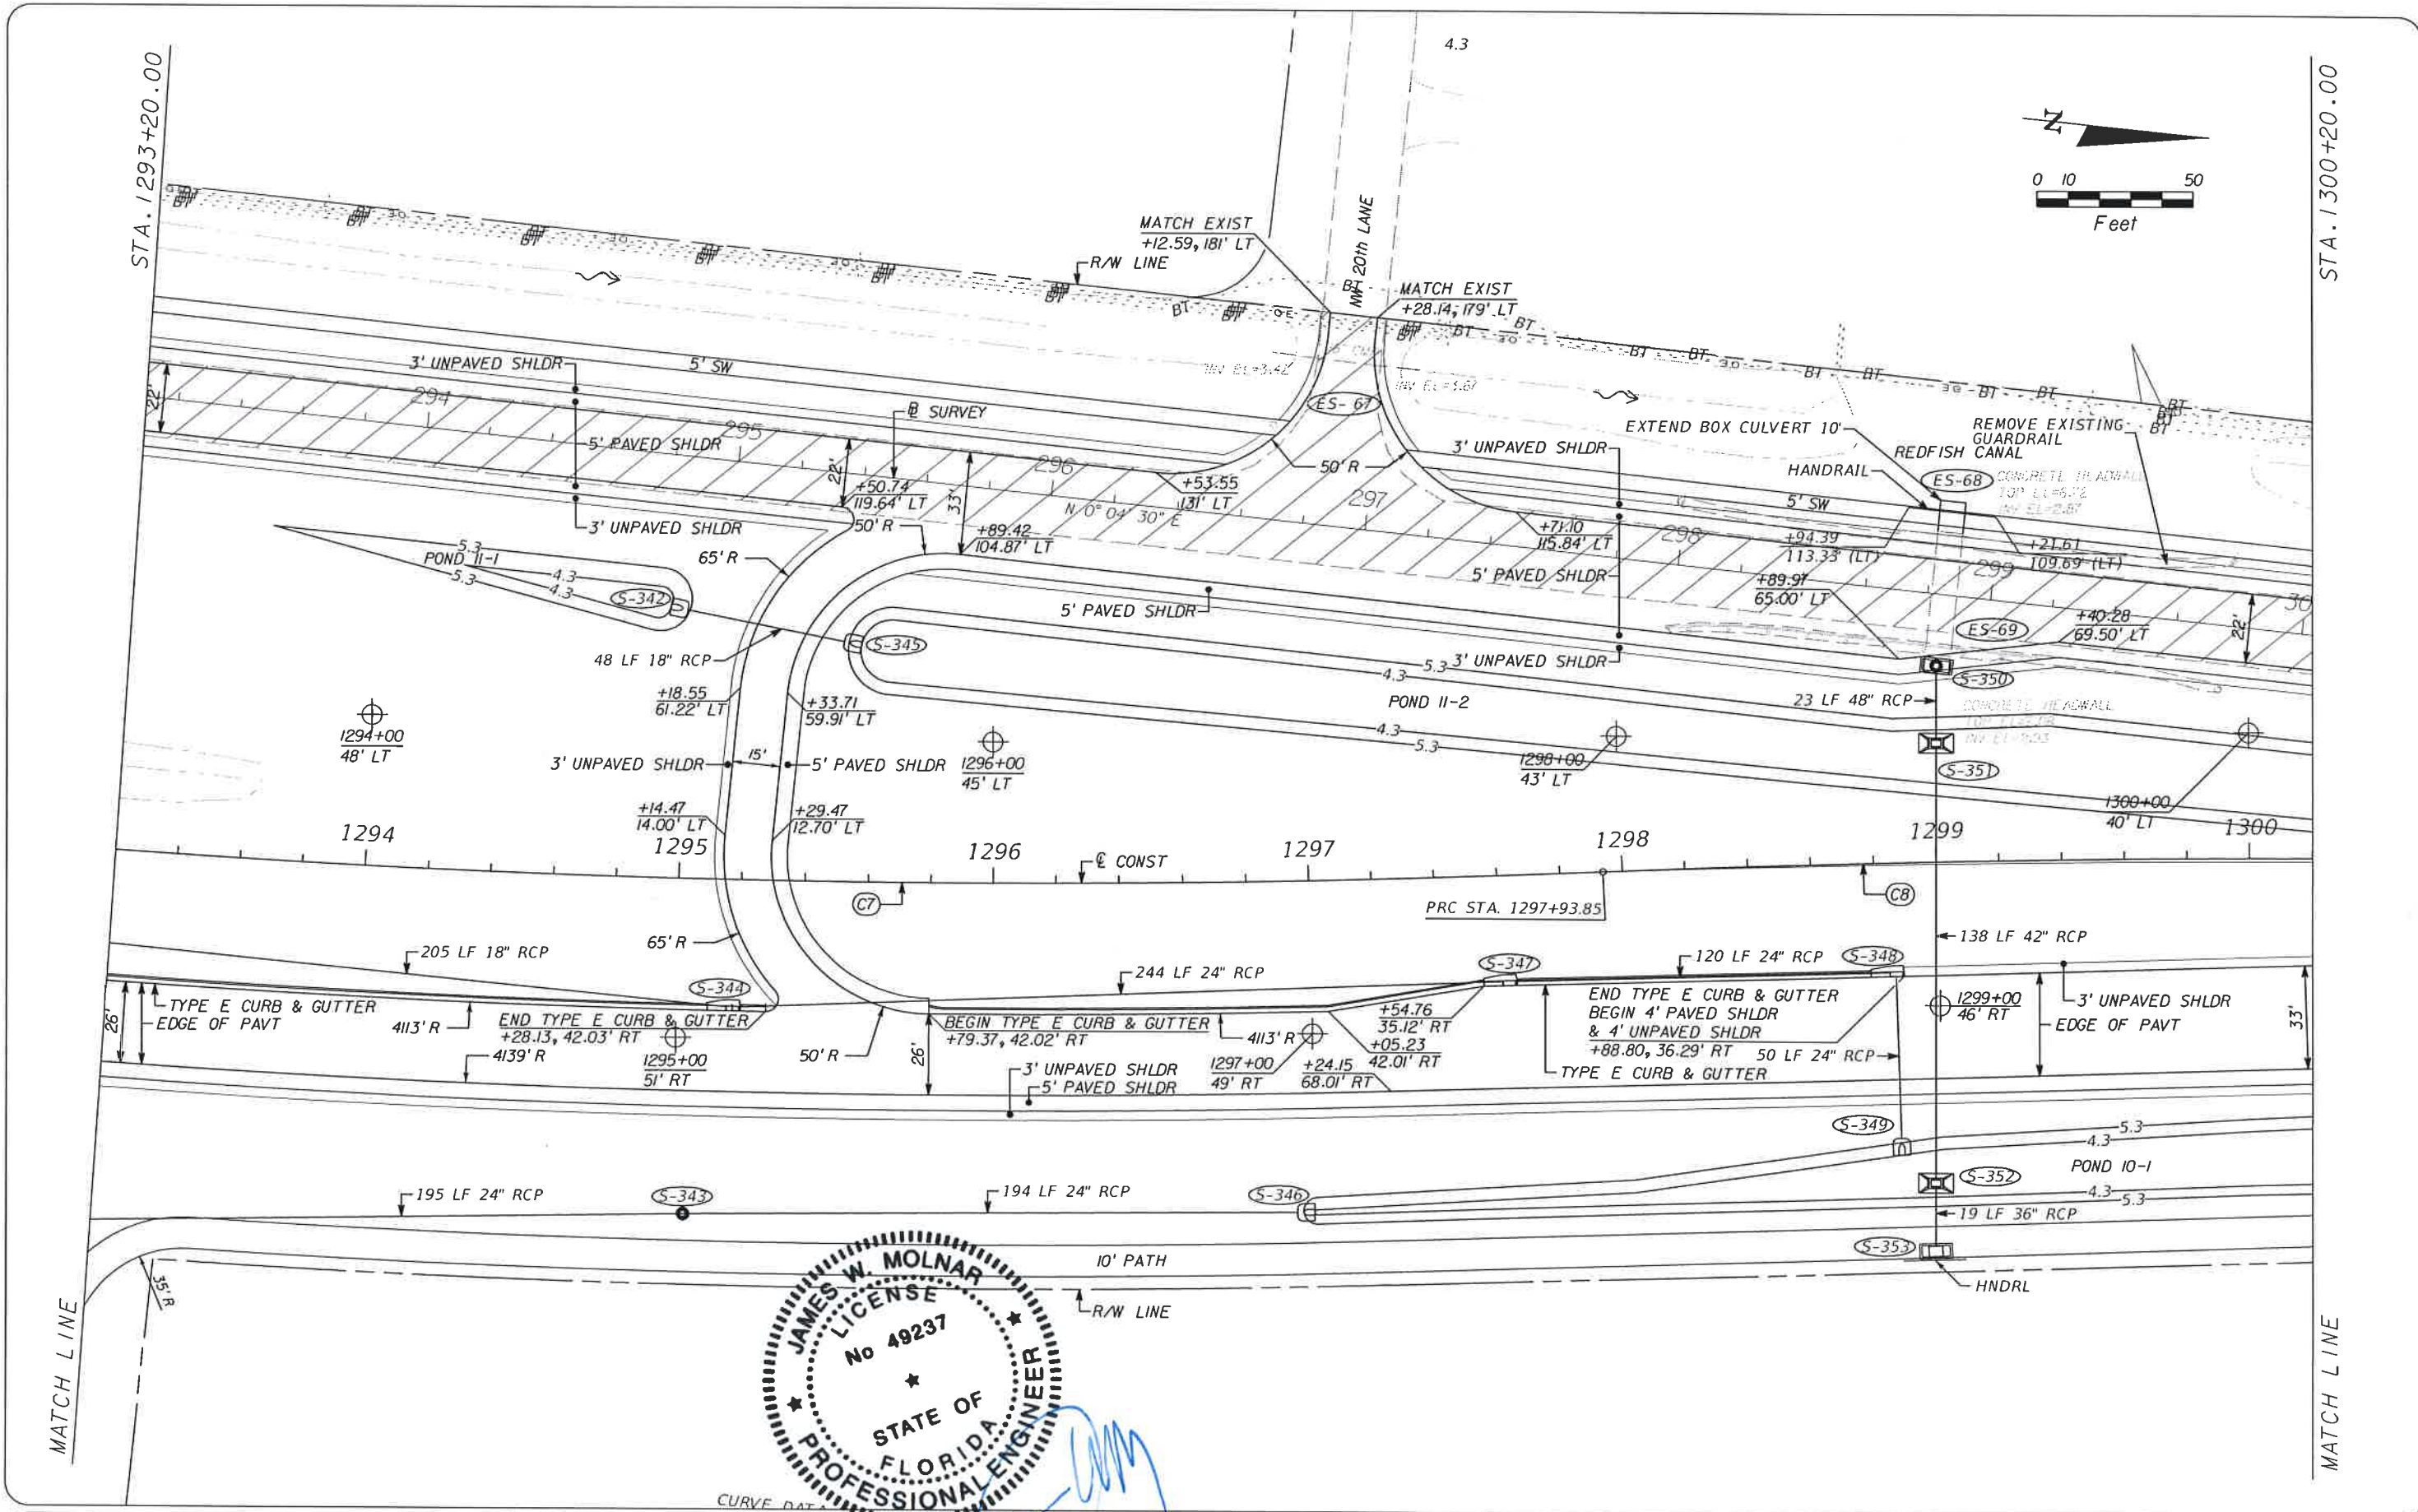

NO.	DATE	BY	REVISIONS - DESCRIPTION

T.Y. LIN INTERNATIONAL
 2400 FIRST STREET
 SUITE 200
 FORT MYERS, FLORIDA 33901
 TEL. (239) 332-4846
 FAX. (239) 332-4798
 WWW.TYLIN.COM

APPROVED BY:
JAMES MOLNAR, P.E.
 REGISTERED PROFESSIONAL ENGINEER
 FLORIDA CERTIFICATE NO. 49237
 3-5-2015

PUBLIC WORKS
LEE COUNTY
 DEPARTMENT
 of
SOUTHWEST
FLORIDA
 1500 MONROE STREET
 FORT MYERS, FLORIDA 33901
 12391 479 8900 www.lee-county.com/publicworks/default.htm
 3/5/2015 4:29:02 PM

PLAN SHEET
STA. 1293+20.00 TO STA. 1300+20.00
BURNT STORE ROAD




SHEET NO.
 35

T:\Temp\Legacy\Project\581595.00_Burnt_Store_RD\Burnt_Store_Roadway\planr29.dgn

Default

STA. 1300+20.00

STA. 1307+20.00

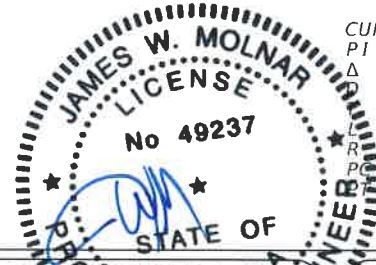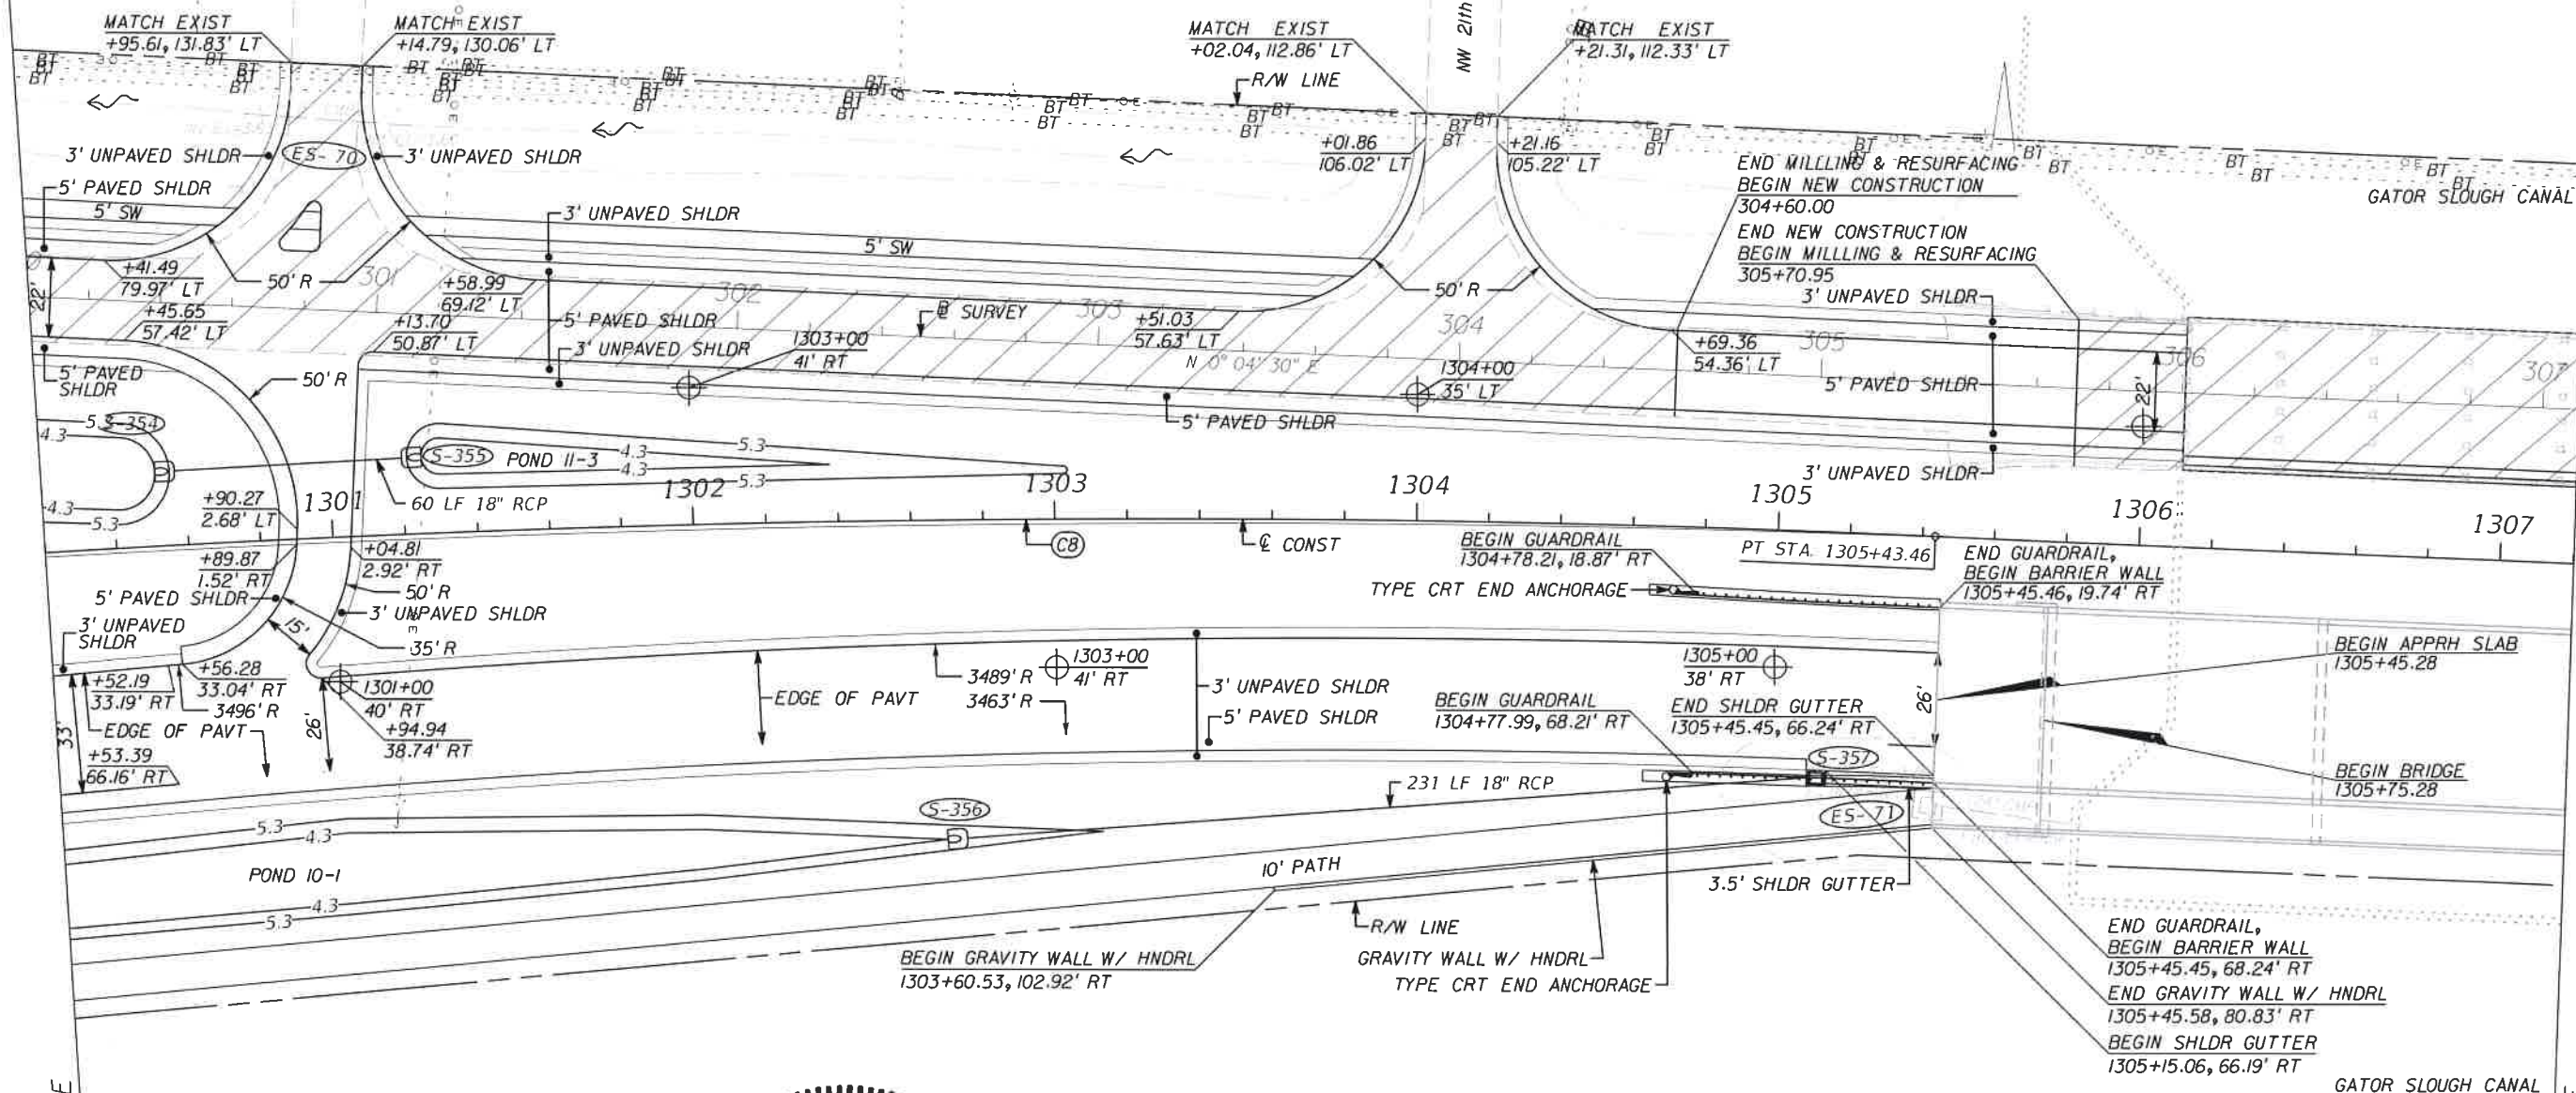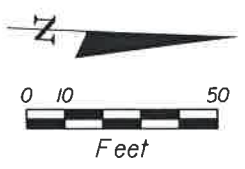

CURVE DATA C-8
 PI STA. = 1301+69.39
 Δ = 8° 47' 17" (RT)
 = 1° 10' 20"
 = 375.54
 = 749.61
 = 4.887.33
 PC STA. = 1297+93.85
 PT STA. = 1305+43.46

NO.	DATE	BY	REVISIONS - DESCRIPTION

T.Y. LIN INTERNATIONAL
 2400 FIRST STREET
 SUITE 200
 FORT MYERS, FLORIDA 33901
 TEL. (239) 332-4845
 FAX. (239) 332-4798
 WWW.TYLIN.COM

APPROVED BY:
 JAMES MOLNAR, P.E.
 REGISTERED PROFESSIONAL ENGINEER
 FLORIDA CERTIFICATE NO. 49237
 3-5-2015

PUBLIC WORKS
 LEE COUNTY
 SOUTHWEST
 FLORIDA
 1500 MONROE STREET
 FORT MYERS, FLORIDA 33901
 (239) 479-8900 www.lee-county.com/publicworks/default.htm



DEPARTMENT
 of
 TRANSPORTATION

PLAN SHEET
 STA. 1300+20.00 TO STA. 1307+20.00
 BURNT STORE ROAD


SHEET NO.
 36

STA. 1307+20.00

STA. 1314+20.00

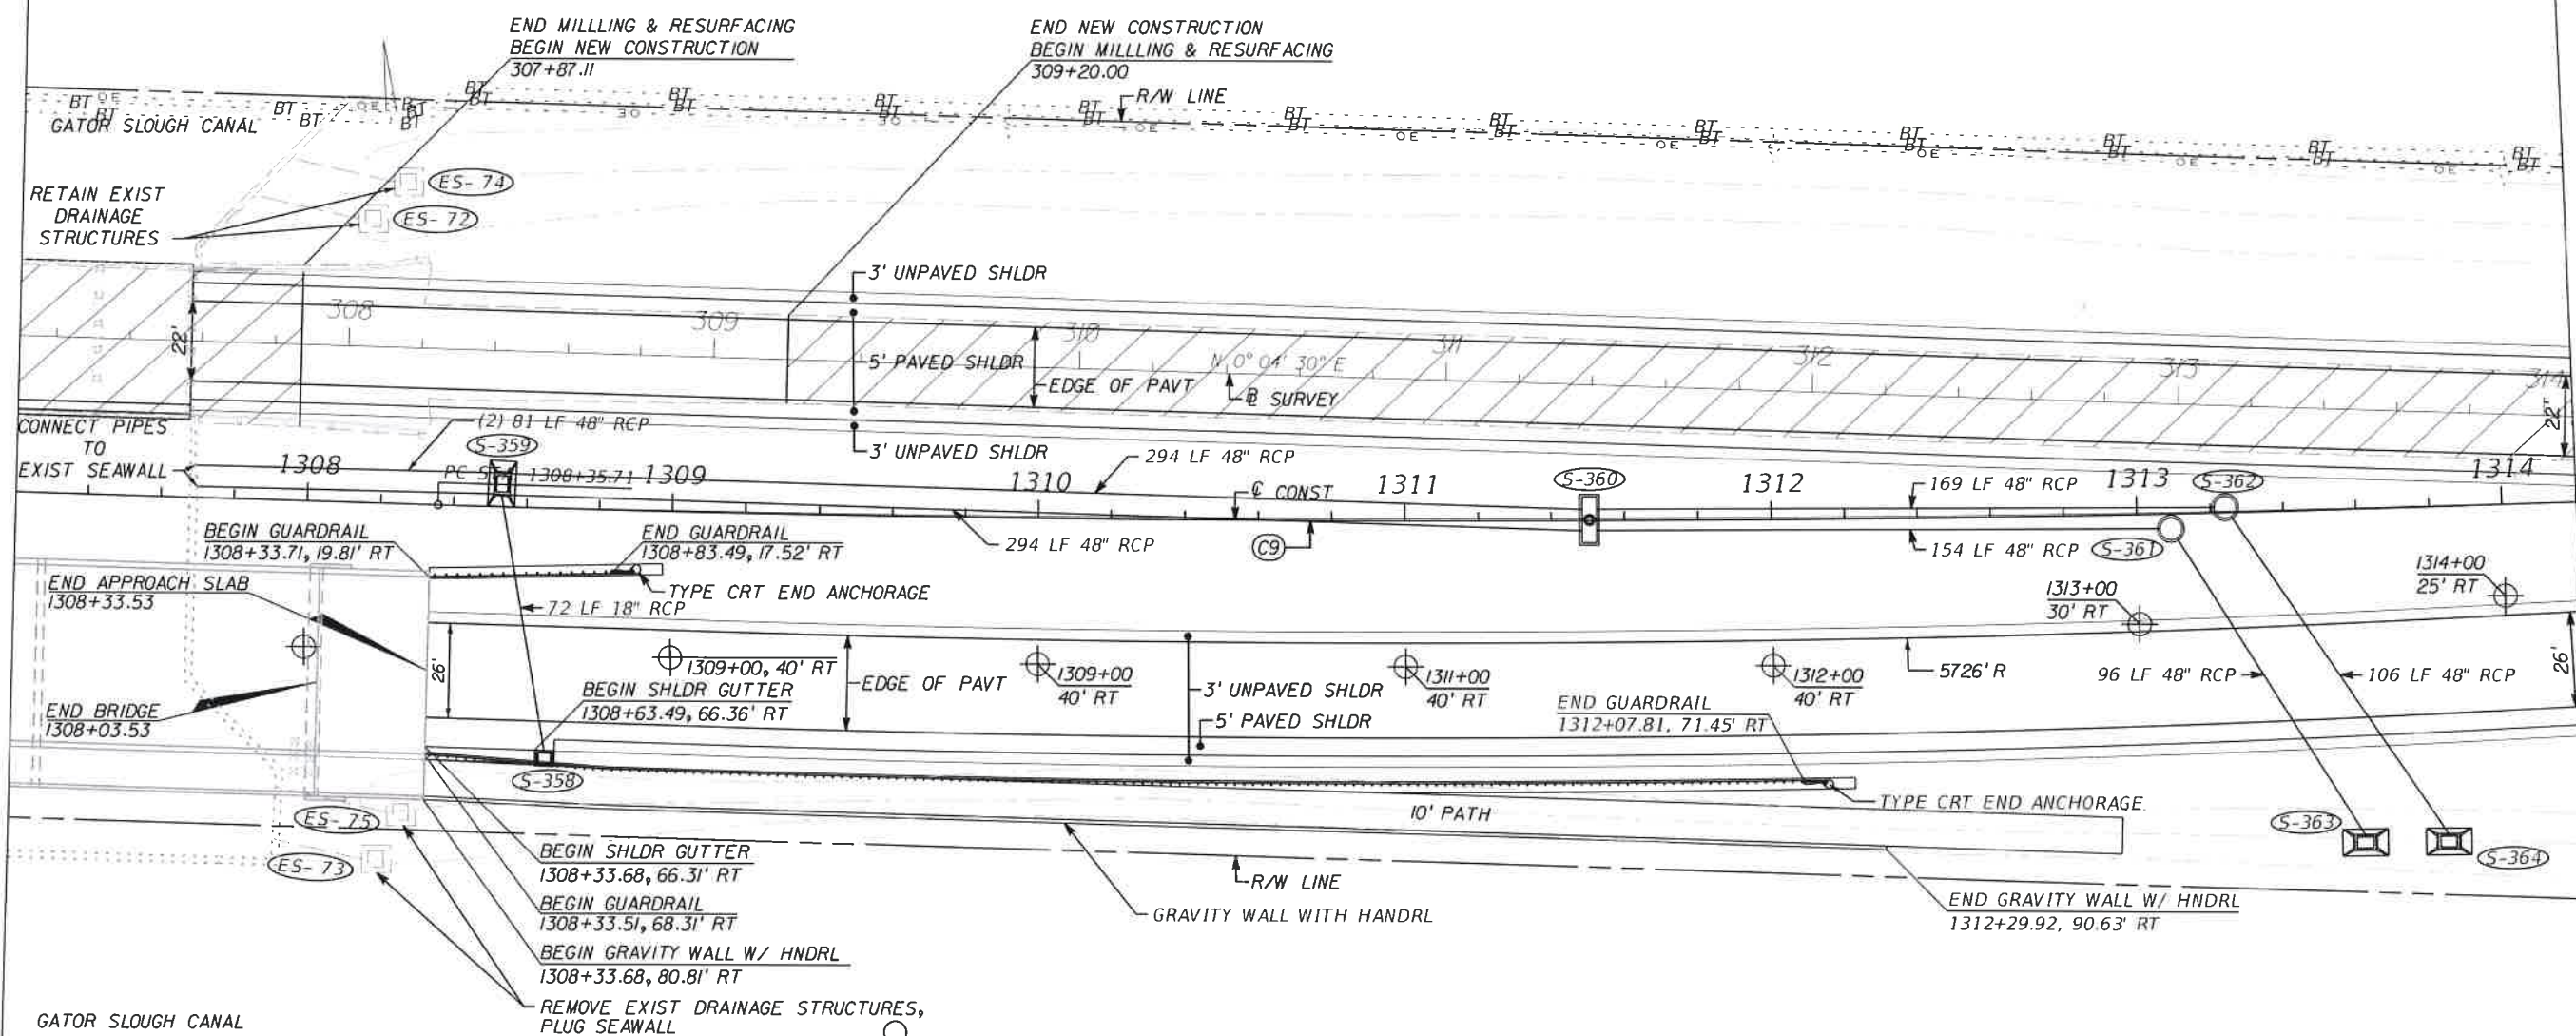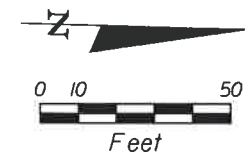

CURVE DATA C-9
 PI STA. = 1311+33.70
 Δ = 3° 51' 42" (LT)
 D = 0° 38' 53"
 T = 297.99
 L = 595.75
 R = 8,839.51
 PC STA. = 1308+35.71
 PT STA. = 1314+31.46

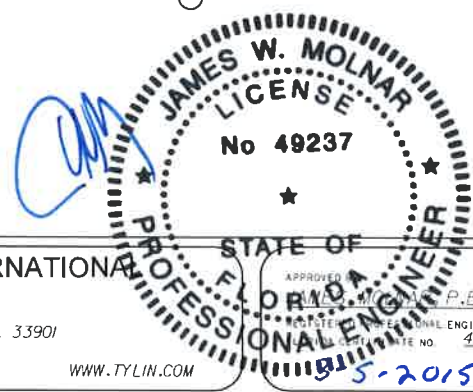

T.Y. LIN INTERNATIONAL
 2400 FIRST STREET
 SUITE 200
 FORT MYERS, FLORIDA 33901
 TEL. (239) 332-4846
 FAX. (239) 332-4798
 WWW.TYLIN.COM

PUBLIC WORKS
 LEE COUNTY
 SOUTHWEST
 FLORIDA
 1500 MONROE STREET
 FORT MYERS, FLORIDA 33901
 (239) 479-8900 www.lee-county.com/publicworks/default.htm

DEPARTMENT
 of
 TRANSPORTATION

PLAN SHEET
 STA. 1307+20.00 TO STA. 1314+20.00
 BURNT STORE ROAD

NO.	DATE	BY	REVISIONS - DESCRIPTION

SHEET NO.
 37


STA. 1314+20.00

PRC STA. 1314+31.46

MATCH LINE

MATCH EXIST
+08.95, 184.18' LT

MATCH EXIST
+28.53, 182.60' LT

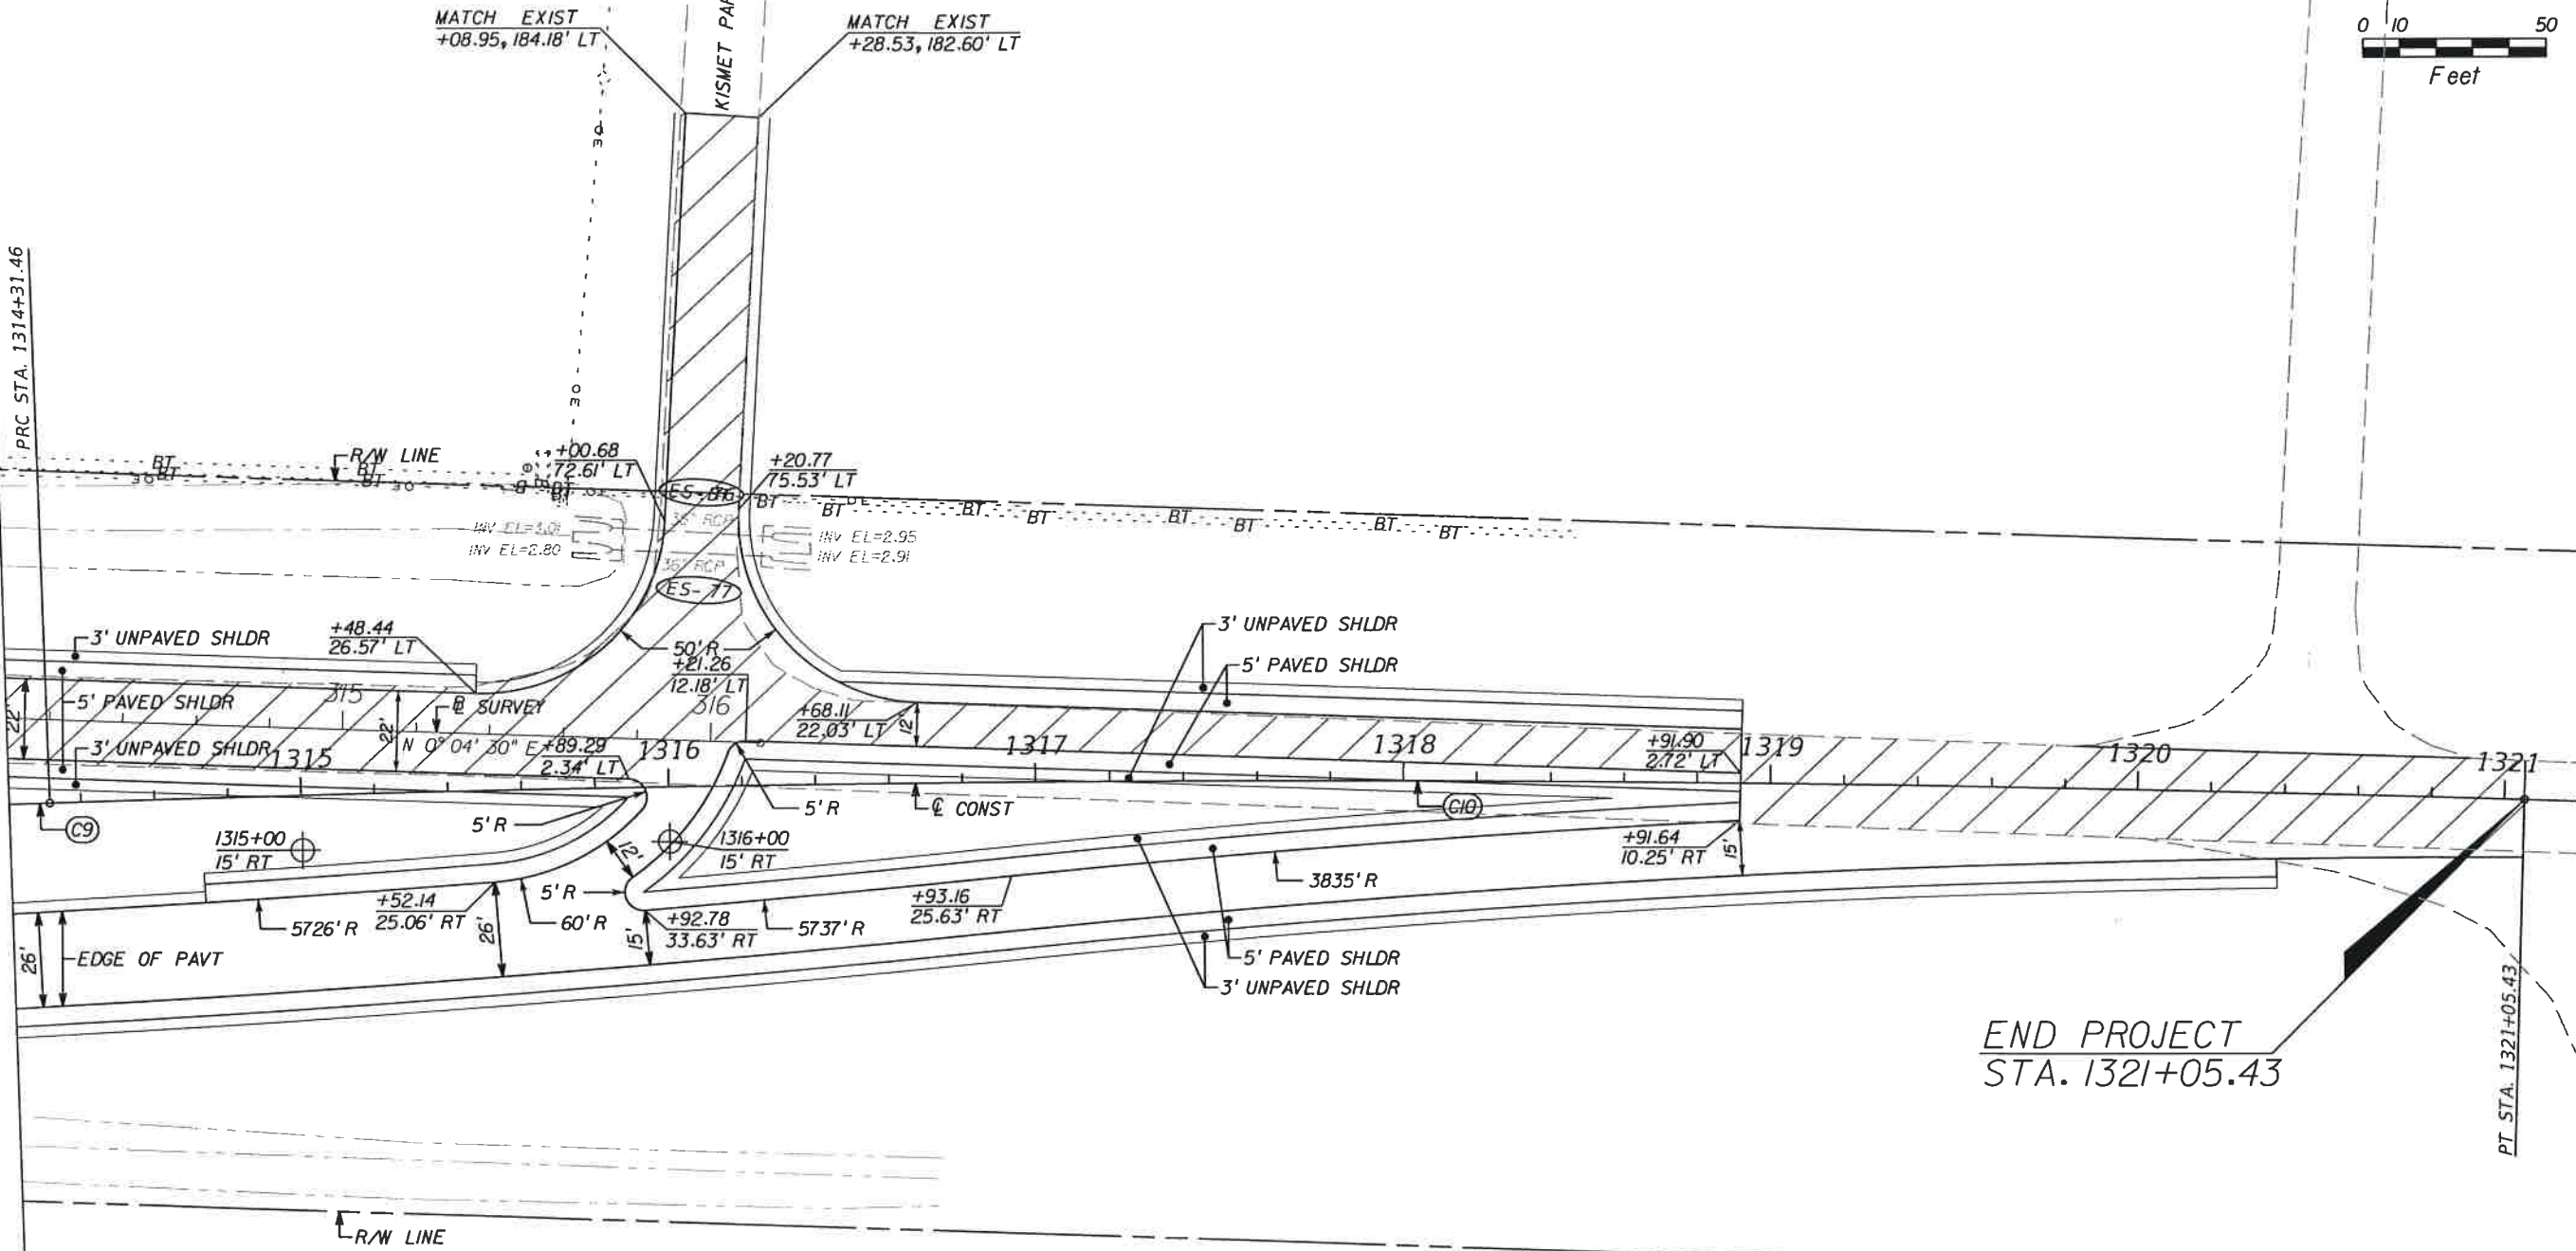

END PROJECT
STA. 1321+05.43

PT STA. 1321+05.43



CURVE DATA C-10
 PI STA. = 1317+68.58
 Δ = 3° 51' 42" (RT)
 D = 0° 34' 23"
 T = 337.11
 L = 673.97
 R = 10,000.00
 PC STA. = 1314+31.46
 PT STA. = 1321+05.43

NO.	DATE	BY	REVISIONS - DESCRIPTION

T.Y. LIN INTERNATIONAL
 2400 FIRST STREET
 SUITE 200
 FORT MYERS, FLORIDA 33901
 TEL. (239) 332-4846
 FAX. (239) 332-4798
 WWW.TYLIN.COM



JAMES W. MOLNAR, P.E.
 REGISTERED PROFESSIONAL ENGINEER
 FLORIDA CERTIFICATE NO. 49237
 3/5/2015

PUBLIC WORKS
LEE COUNTY
SOUTHWEST
FLORIDA
 1500 MONROE STREET
 FORT MYERS, FLORIDA 33901
 (239) 479-8900 www.lee-county.com/publicworks/default.htm

PLAN SHEET
STA. 1314+20.00 TO STA. 1321+19.86
BURNT STORE ROAD

SHEET NO.
 38
 Default

ESTRAVITA CANAL

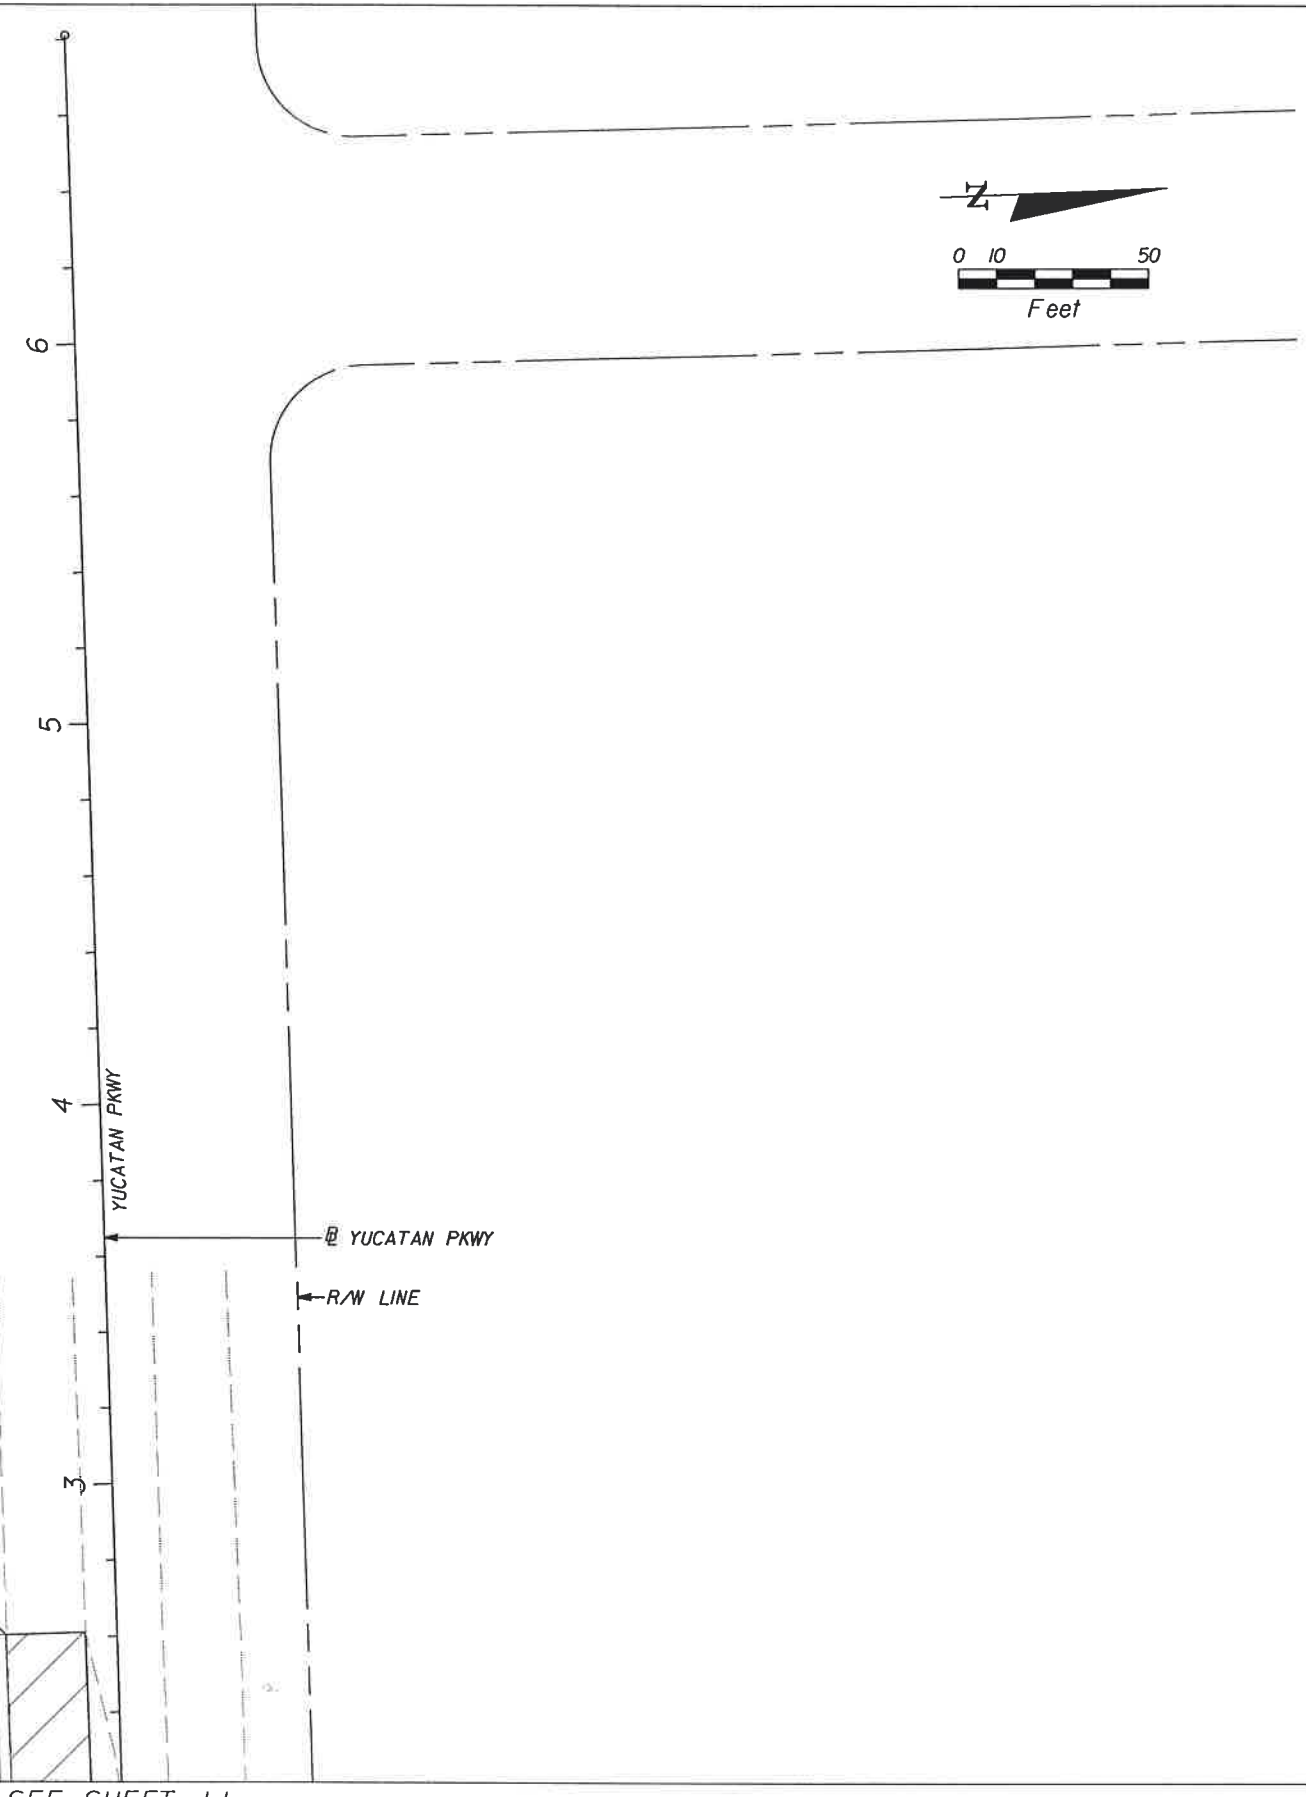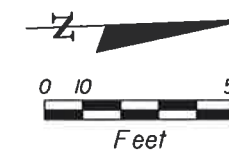


MATCH EXIST
+78.12, 296.24' LT

MATCH LINE SEE SHEET 11

NO.	DATE	BY	REVISIONS - DESCRIPTION




T.Y. LIN INTERNATIONAL
 2400 FIRST STREET
 SUITE 200
 FORT MYERS, FLORIDA 33901
 TEL. (239) 332-4846
 FAX. (239) 332-4798
 WWW.TY.LIN.COM

REGISTERED BY
JAMES W. MOLNAR, P.E.
 REGISTERED PROFESSIONAL ENGINEER
 FLORIDA CERTIFICATE NO. 49237
 3-5-2015

 PUBLIC WORKS
LEE COUNTY
 SOUTHWEST
 FLORIDA
 1500 MONROE STREET
 FORT MYERS, FLORIDA 33901
 (239) 479-8900 www.lee-county.com/publicworks/office.htm
 dwerner 3/5/2015 10:49:00 AM

PLAN SHEET
YUCATAN PKWY
BURNT STORE ROAD


SHEET NO.
 38A

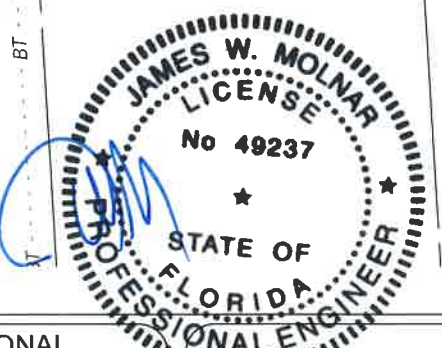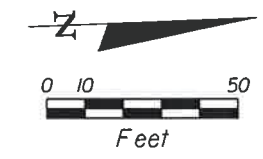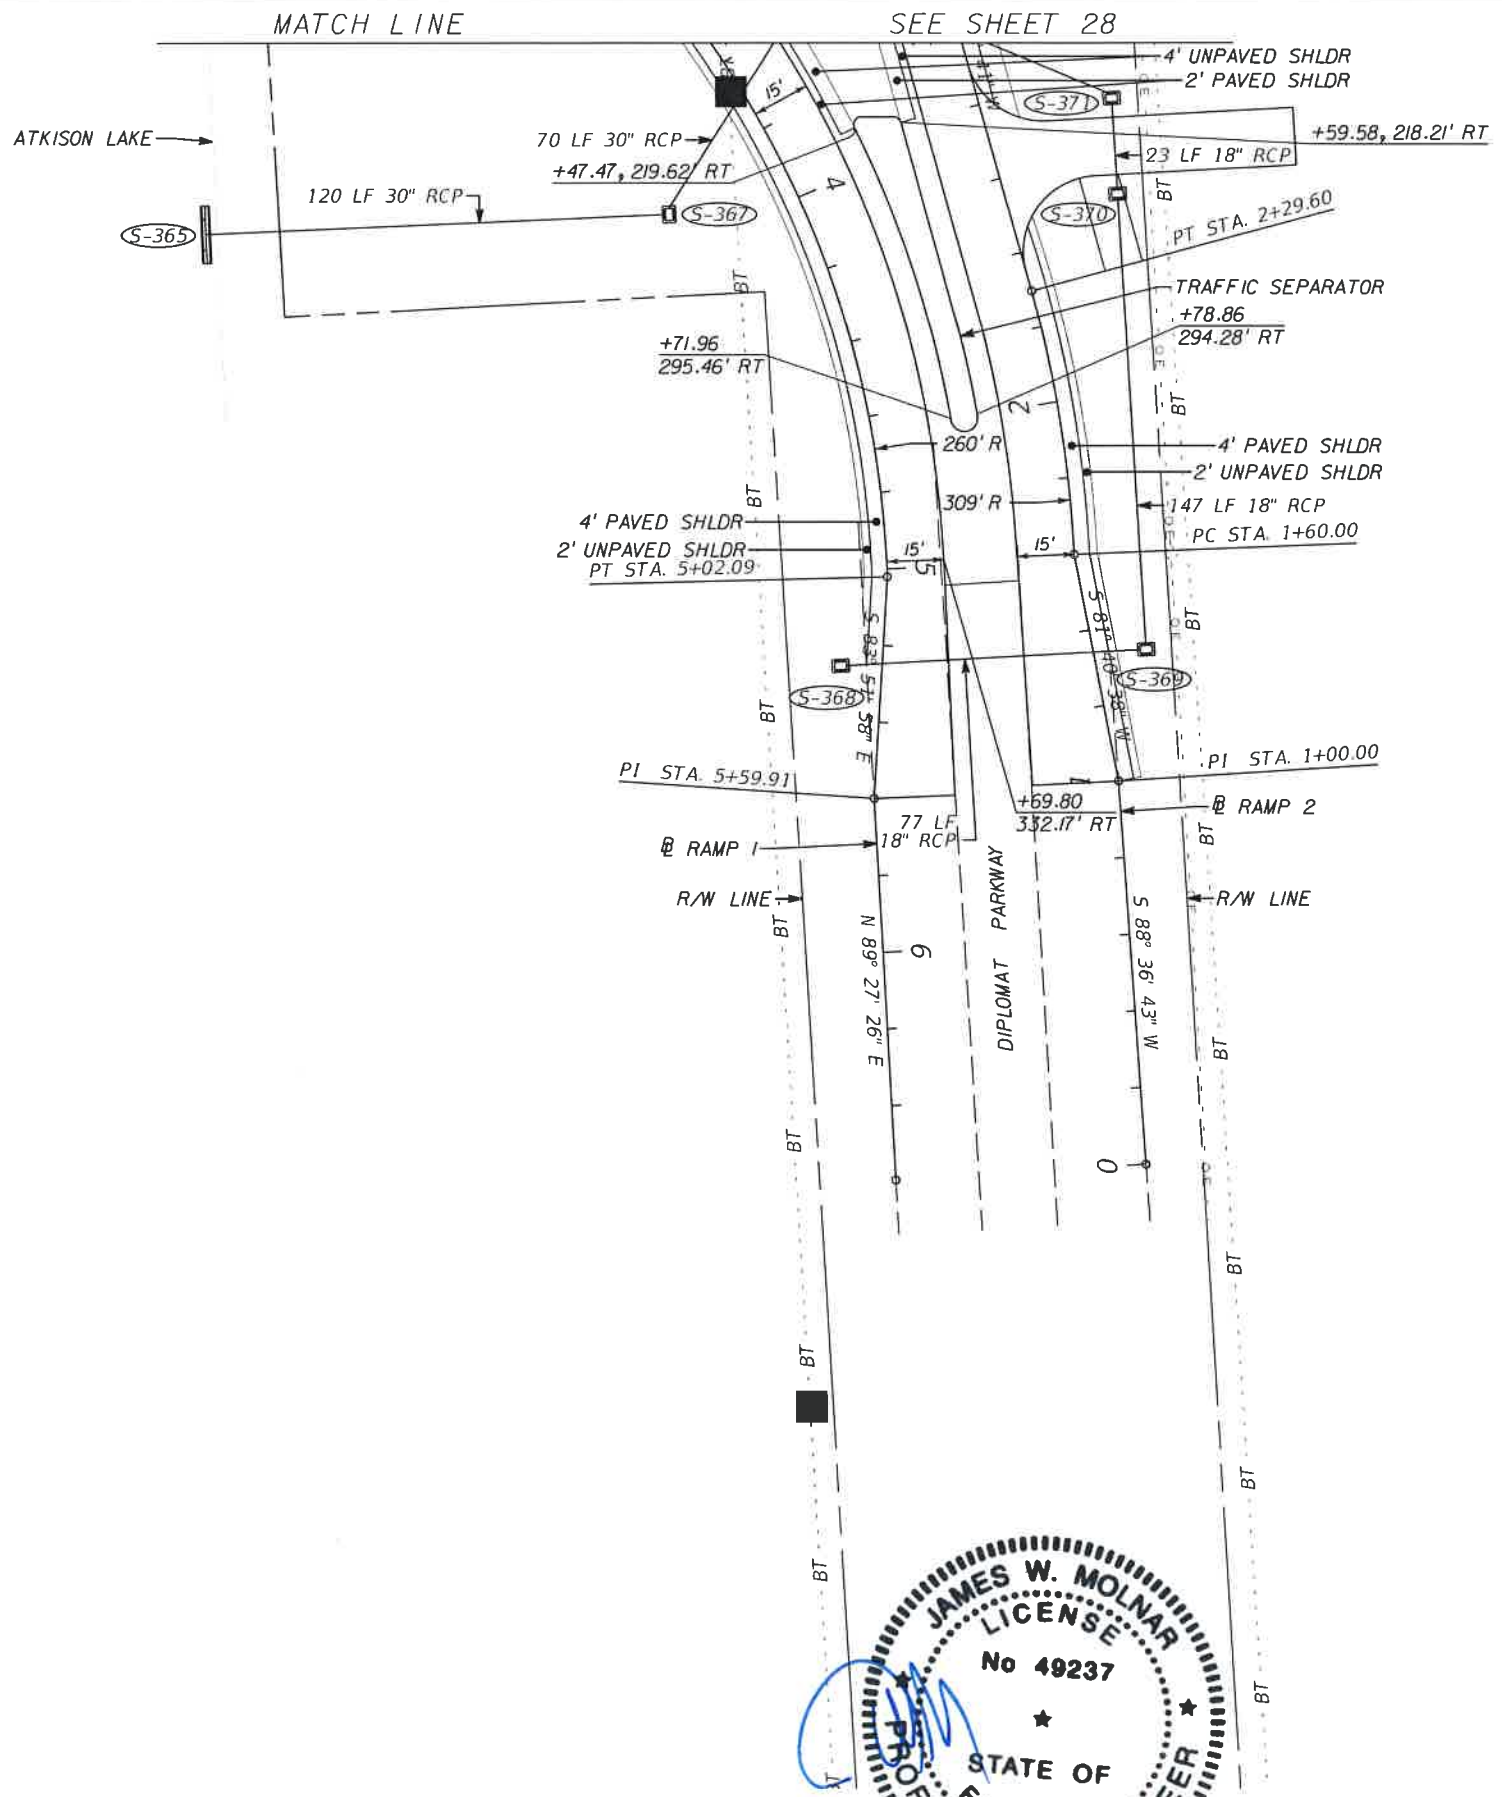

NO.	DATE	BY	REVISIONS - DESCRIPTION



T.Y. LIN INTERNATIONAL
 2400 FIRST STREET
 SUITE 200
 FORT MYERS, FLORIDA 33901
 TEL. (239) 332-4846
 FAX. (239) 332-4798
 WWW.TYLIN.COM

APPROVED BY
JAMES W. MOLNAR, P.E.
 REGISTERED PROFESSIONAL ENGINEER
 FLORIDA CERTIFICATE NO. 49237
 3-5-2015

 PUBLIC WORKS
 LEE COUNTY
 SOUTHWEST
 FLORIDA
 1500 MONROE STREET
 FORT MYERS, FLORIDA 33901
 (239) 479-8900 www.lee-county.com/publicworks/default.htm
 rshields 3/4/2015 5:36:08 PM

PLAN SHEET
DIPLOMAT PARKWAY
BURNT STORE ROAD

SHEET NO.
39
 Default

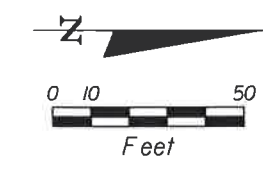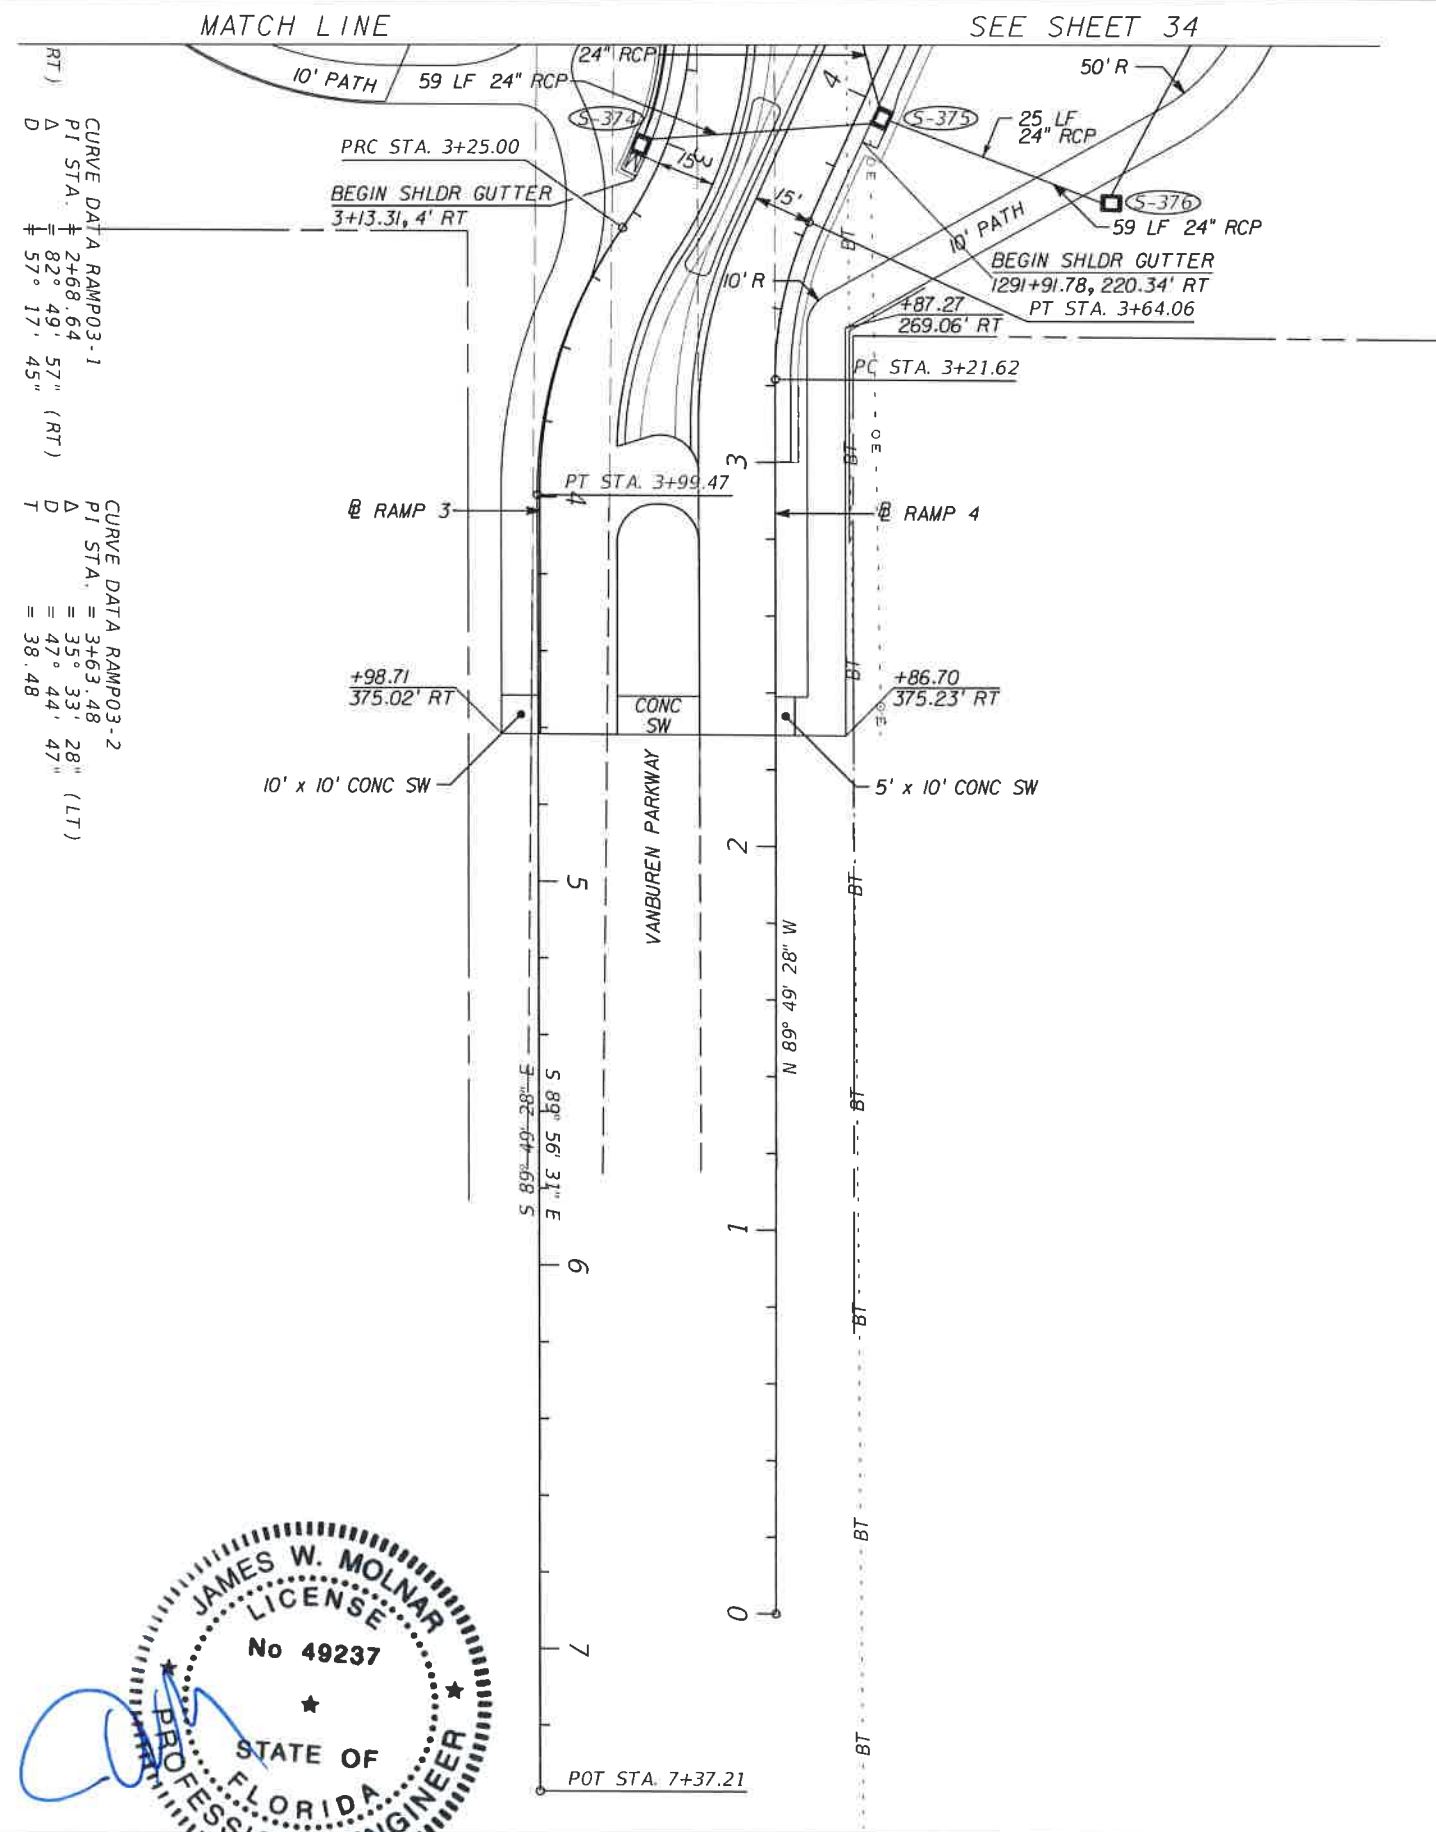

CURVE DATA RAMP03-1
 P I STA. = 2+68.64
 Δ = 82° 49' 57" (RT)
 D = 57° 17' 45"

CURVE DATA RAMP03-2
 P I STA. = 3+63.48
 Δ = 35° 33' 28" (LT)
 D = 47° 44' 47"
 T = 38.48

NO.	DATE	BY	REVISIONS - DESCRIPTION



T.Y. LIN INTERNATIONAL
 2400 FIRST STREET
 SUITE 200
 FORT MYERS, FLORIDA 33901
 TEL. (239) 332-4846
 FAX. (239) 332-4798
 WWW.TYLIN.COM

APPROVED BY
JAMES MOLNAR, P.E.
 REGISTERED PROFESSIONAL ENGINEER
 FLORIDA CERTIFICATE NO. 49237
 3-5-2015

PUBLIC WORKS
 LEE COUNTY
 SOUTHWEST
 FLORIDA
 1500 MONROE STREET
 FORT MYERS, FLORIDA 33901
 12391 479-8900 www.lee-county.com/publicworks/default.htm
 rshields 3/4/2015 5:06:58 PM

PLAN SHEET
VANBUREN PARKWAY
BURNT STORE ROAD

SHEET NO.
 40
 Default

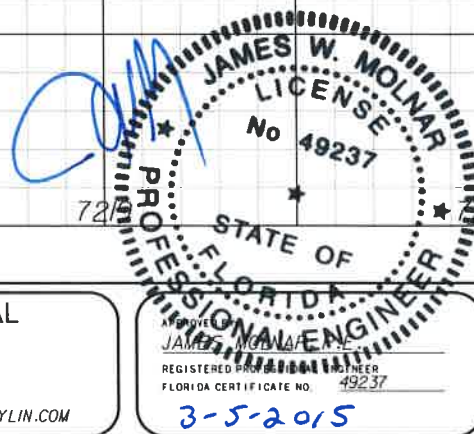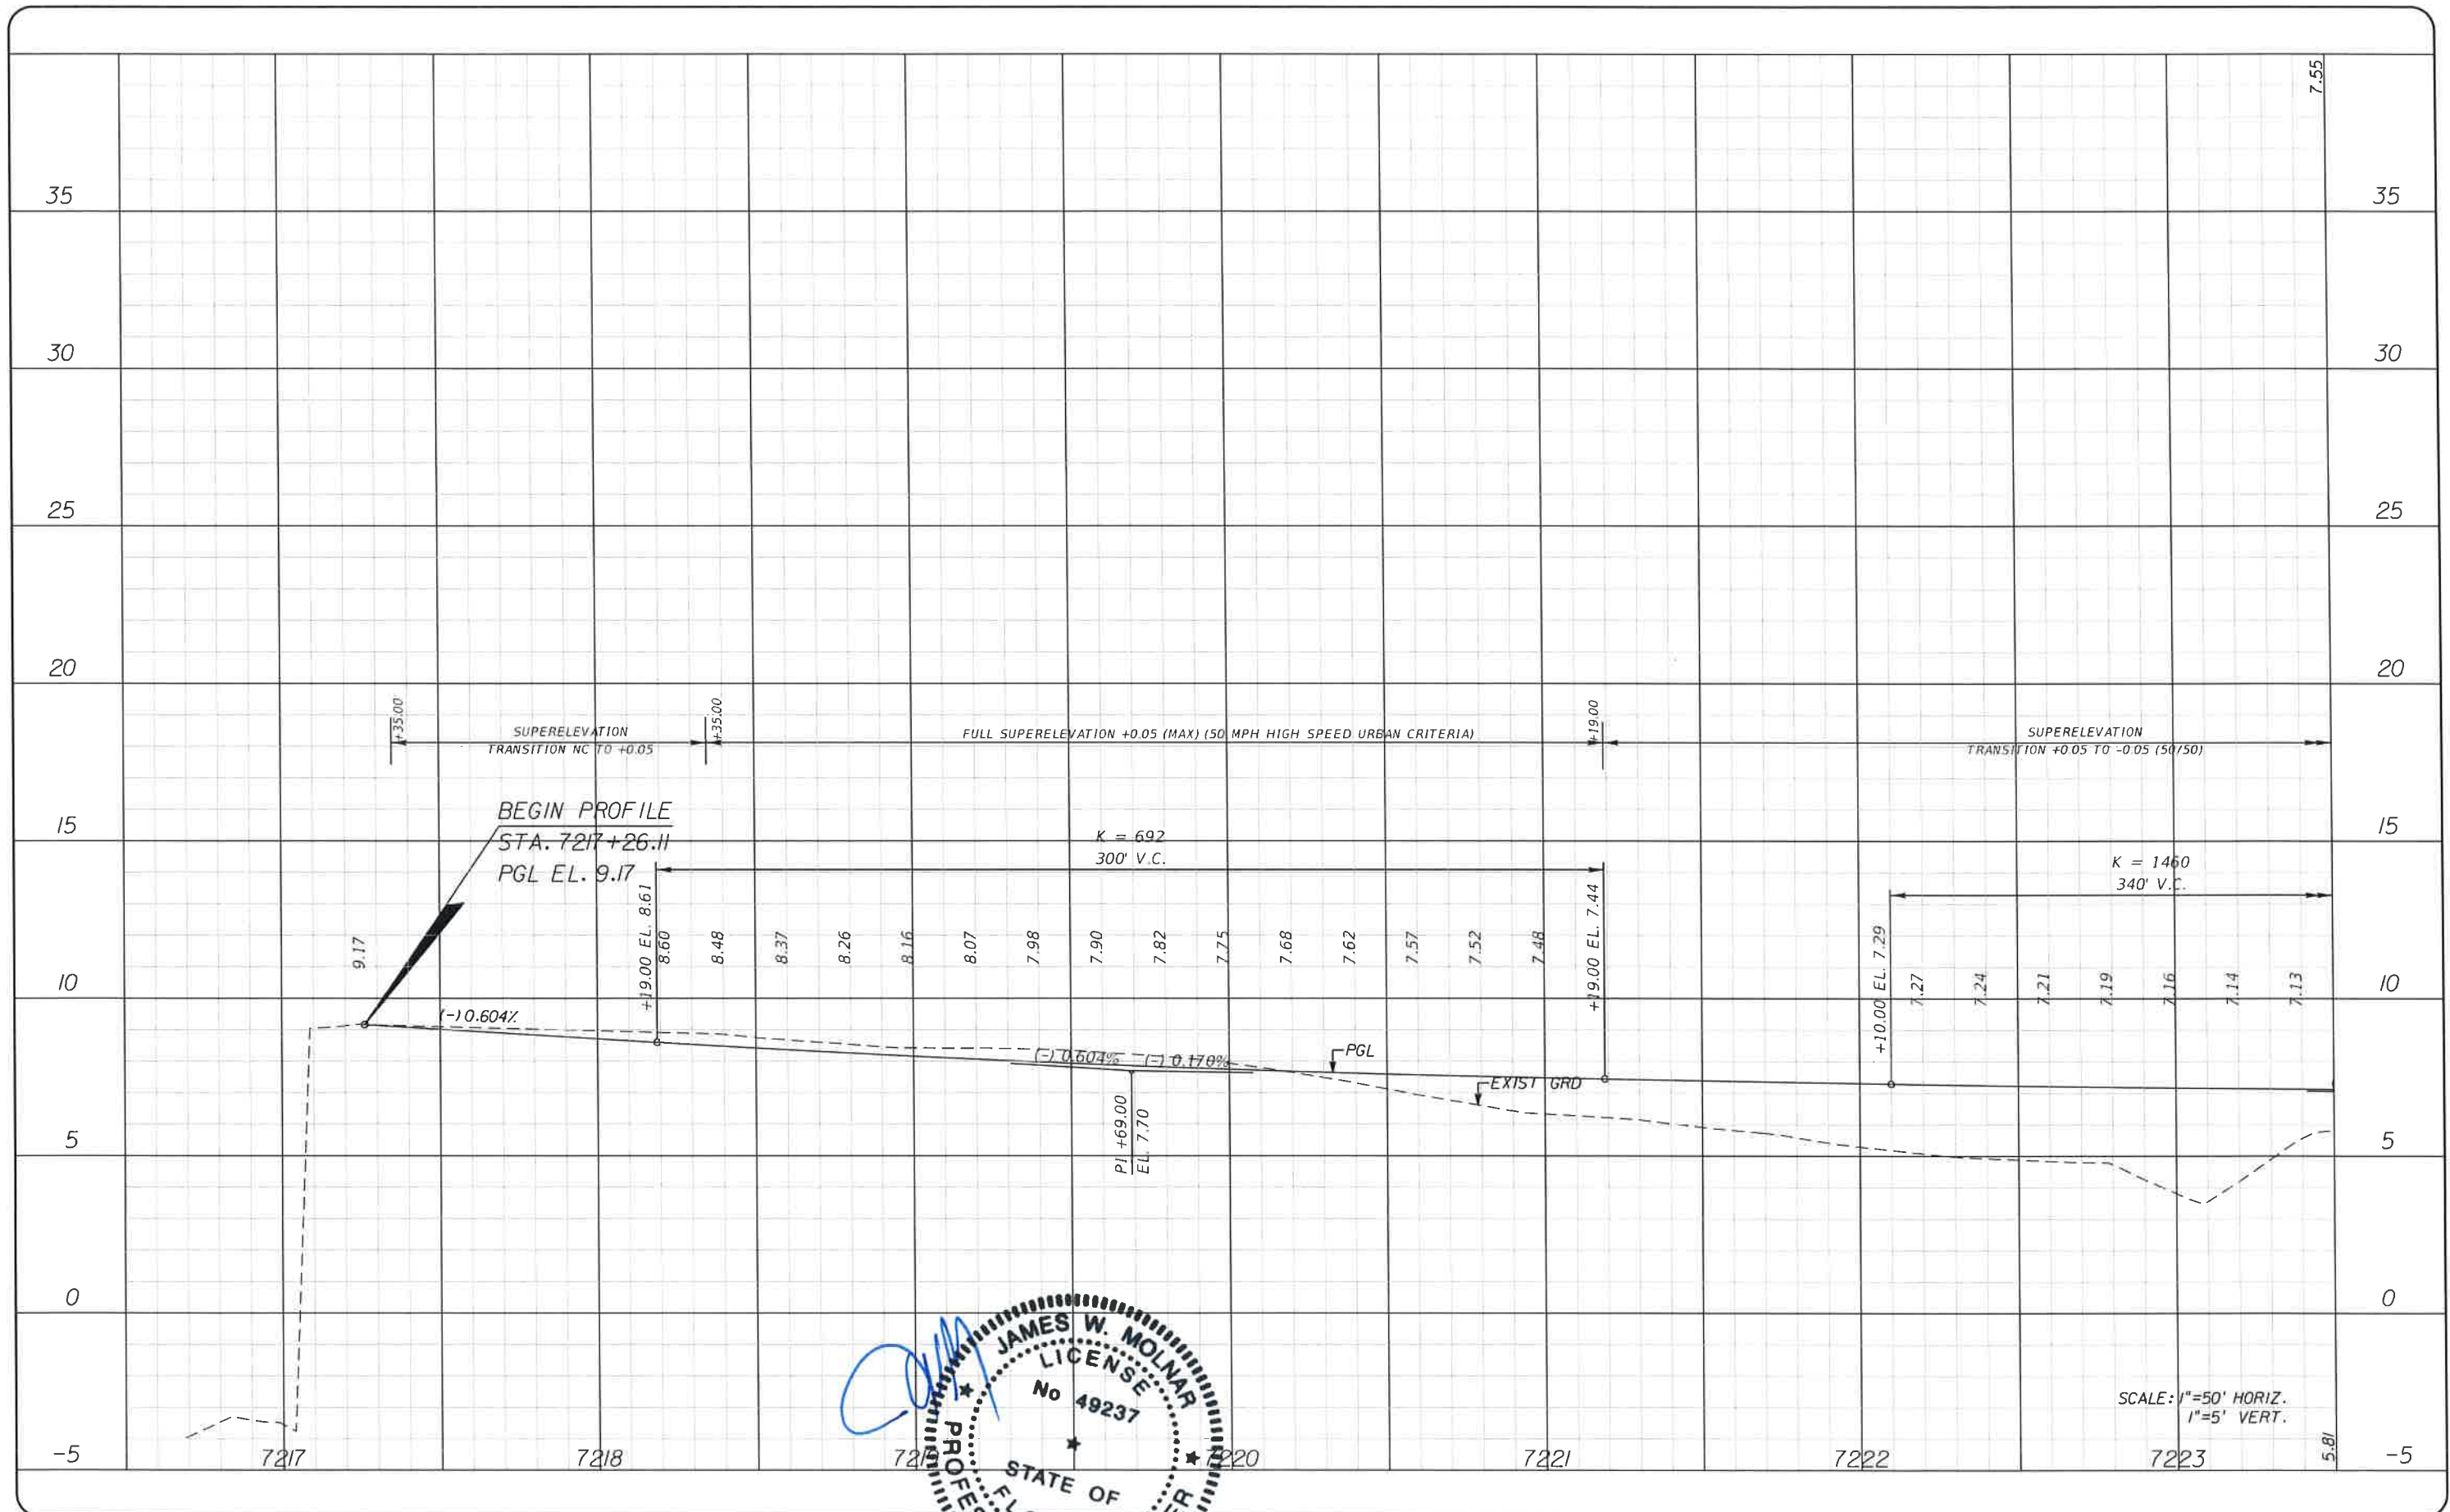

NO.	DATE	BY	REVISIONS - DESCRIPTION

T.Y. LIN INTERNATIONAL
 2400 FIRST STREET
 SUITE 200
 FORT MYERS, FLORIDA 33901
 TEL. (239) 332-4846
 FAX. (239) 332-4798
 WWW.TYLIN.COM



JAMES W. MOLNAR
 REGISTERED PROFESSIONAL ENGINEER
 FLORIDA CERTIFICATE NO. 49237
 3-5-2015

PUBLIC WORKS
 LEE COUNTY
 SOUTHWEST FLORIDA
 1500 MONROE STREET
 FORT MYERS, FLORIDA 33901
 (239) 479-8900
 www.lee-county.com/publicworks/office.htm

DEPARTMENT of TRANSPORTATION

PROFILE SHEET
STA. 7216+50 TO STA. 7223+50
BURNT STORE ROAD

SHEET NO. 41

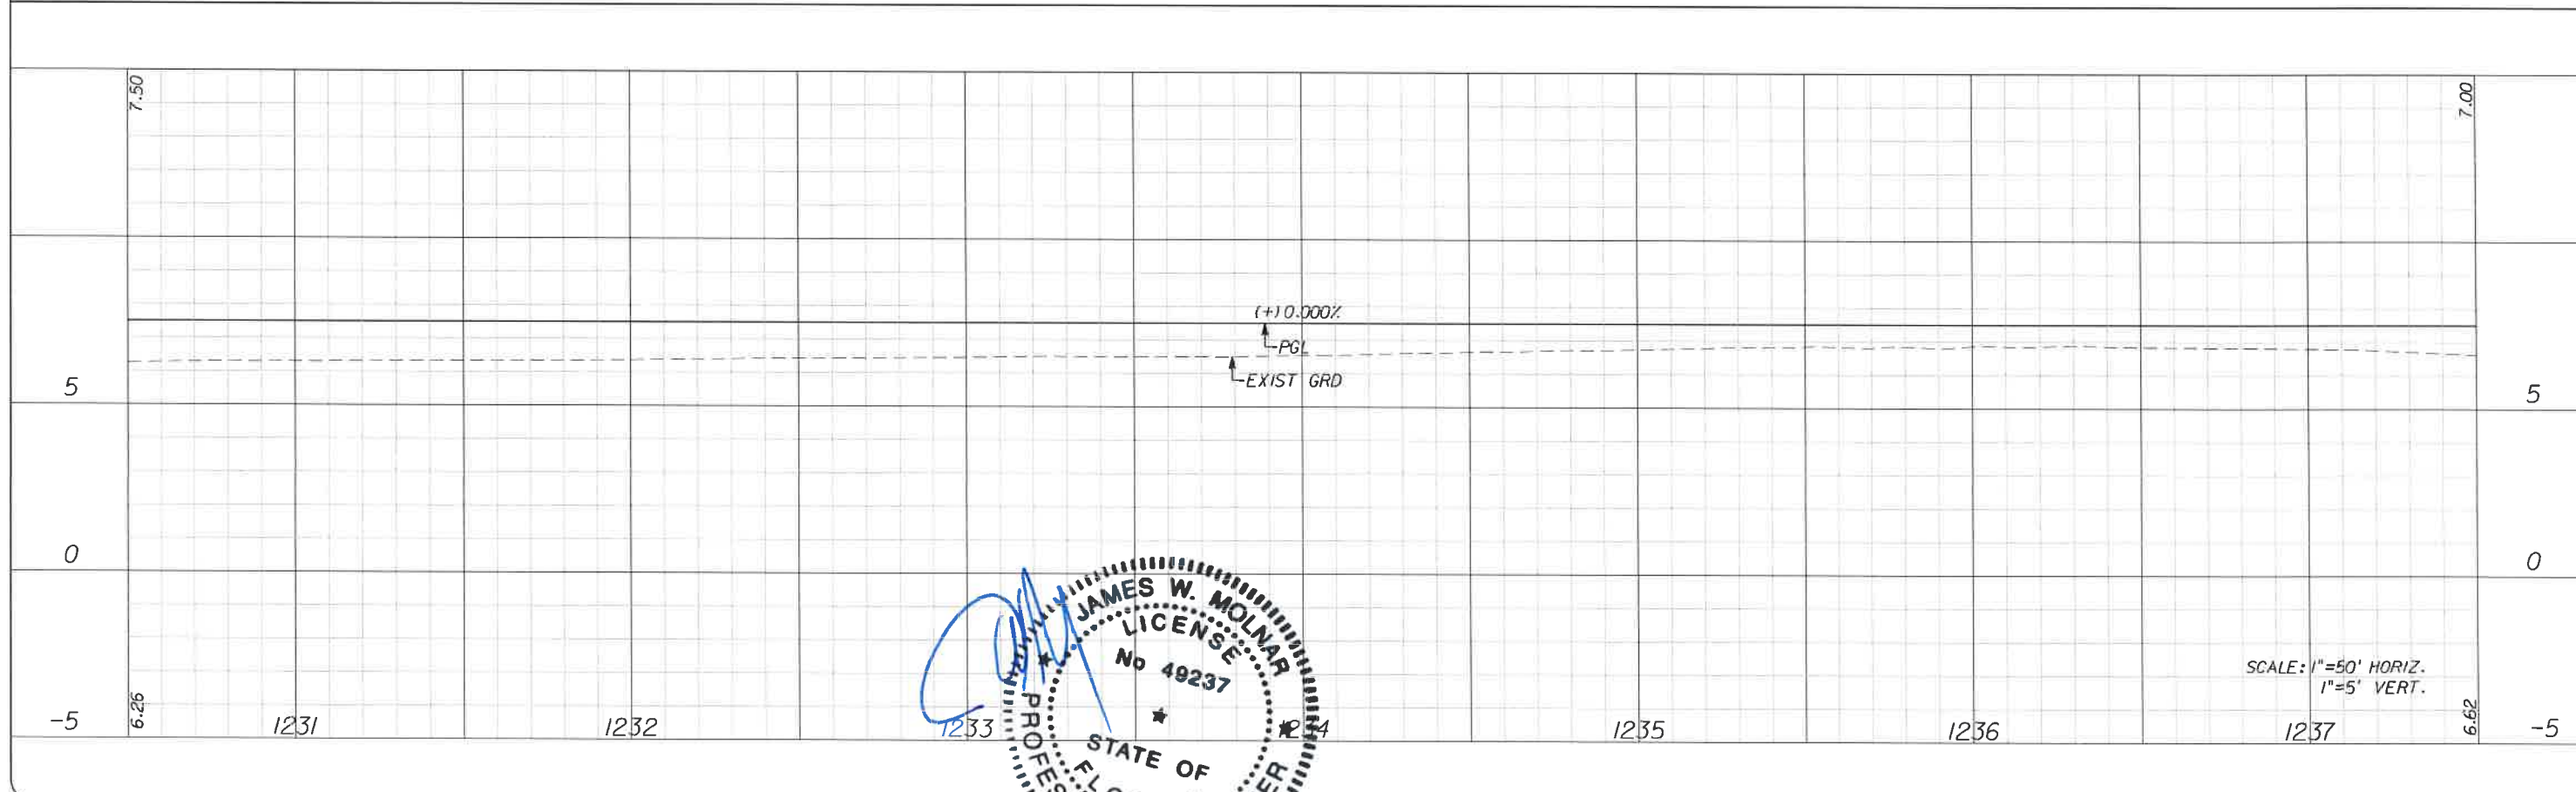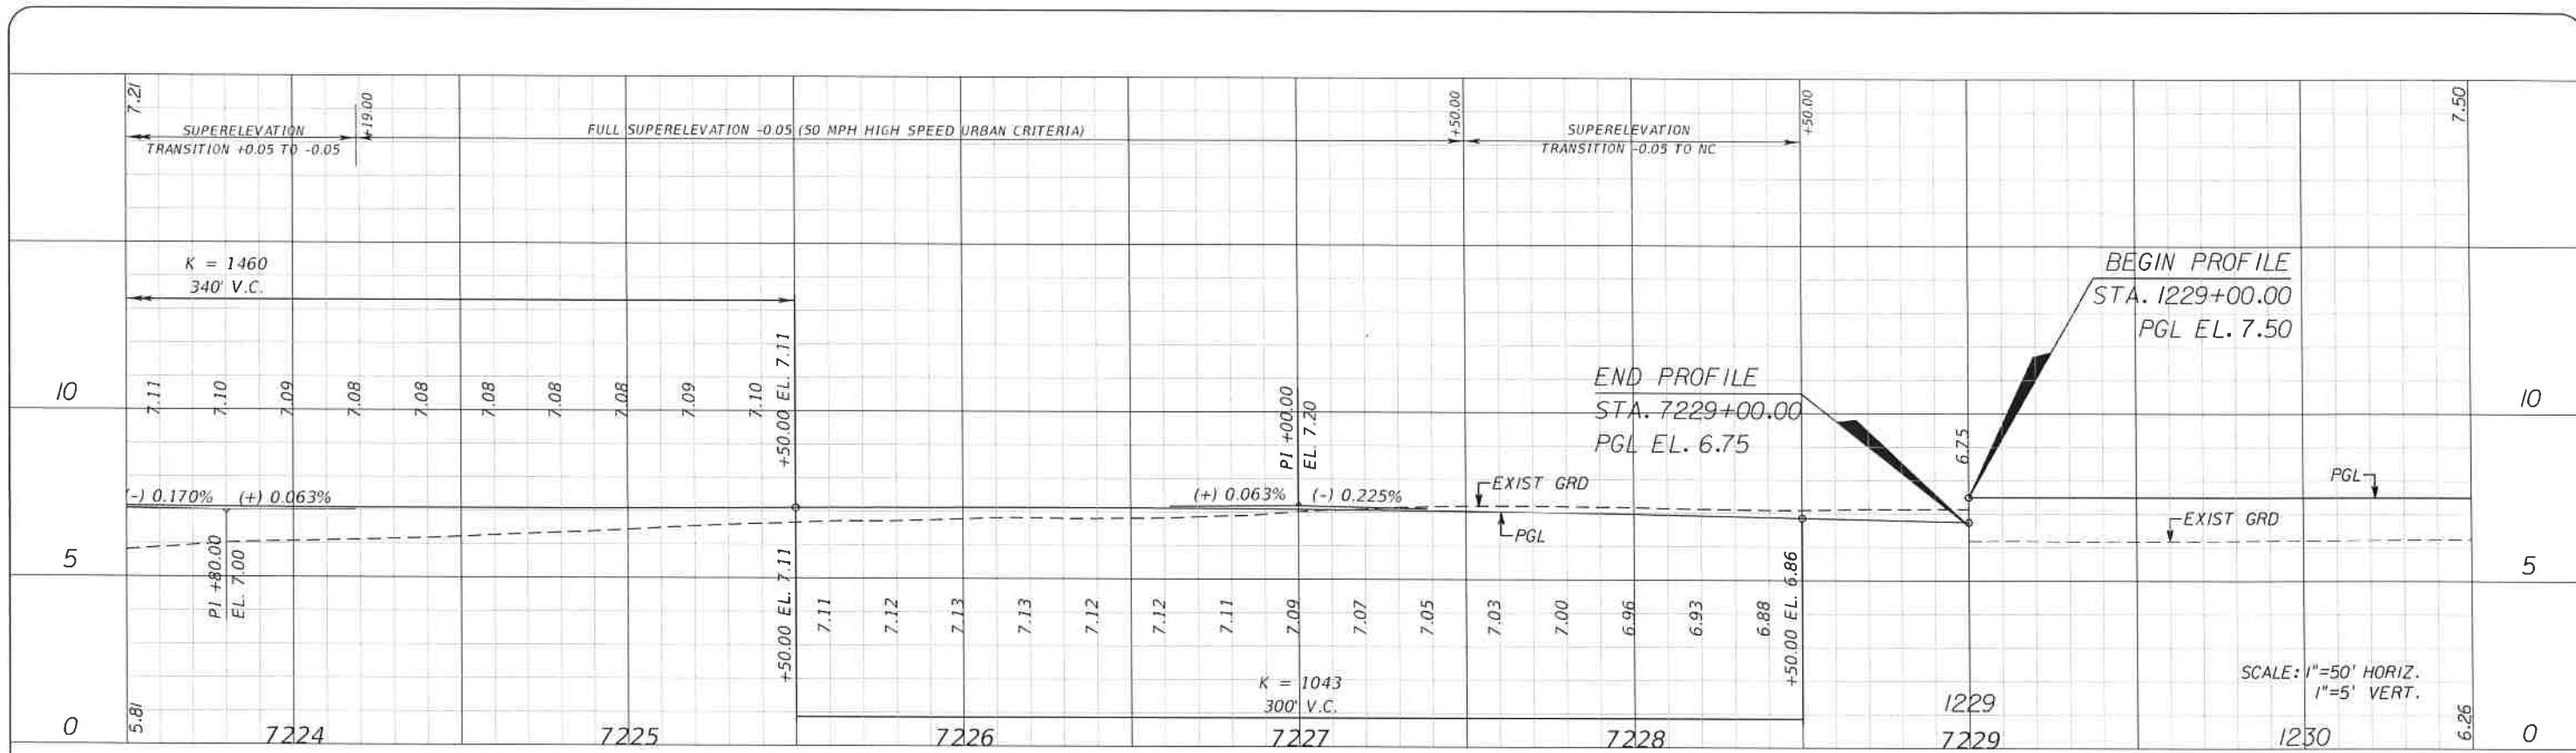

NO.	DATE	BY	REVISIONS - DESCRIPTION


T.Y. LIN INTERNATIONAL
 2400 FIRST STREET
 SUITE 200
 FORT MYERS, FLORIDA 33901
 TEL. (239) 332-4846
 FAX. (239) 332-4798
 WWW.TYLIN.COM

APPROVED
JAMES W. MOLNAR, P.E.
 REGISTERED PROFESSIONAL ENGINEER
 FLORIDA CERTIFICATE NO. 49237
 3-5-2015


PUBLIC WORKS
LEE COUNTY
SOUTHWEST
FLORIDA
 1500 MONROE STREET
 FORT MYERS, FLORIDA 33901
 (239) 479-8900 www.lcc-county.com/publicworks/default.htm
 rshfields 3/4/2015 5:07:03 PM

PROFILE SHEET
STA. 7223+50 TO STA. 1237+50
BURNT STORE ROAD

SHEET NO.
 42

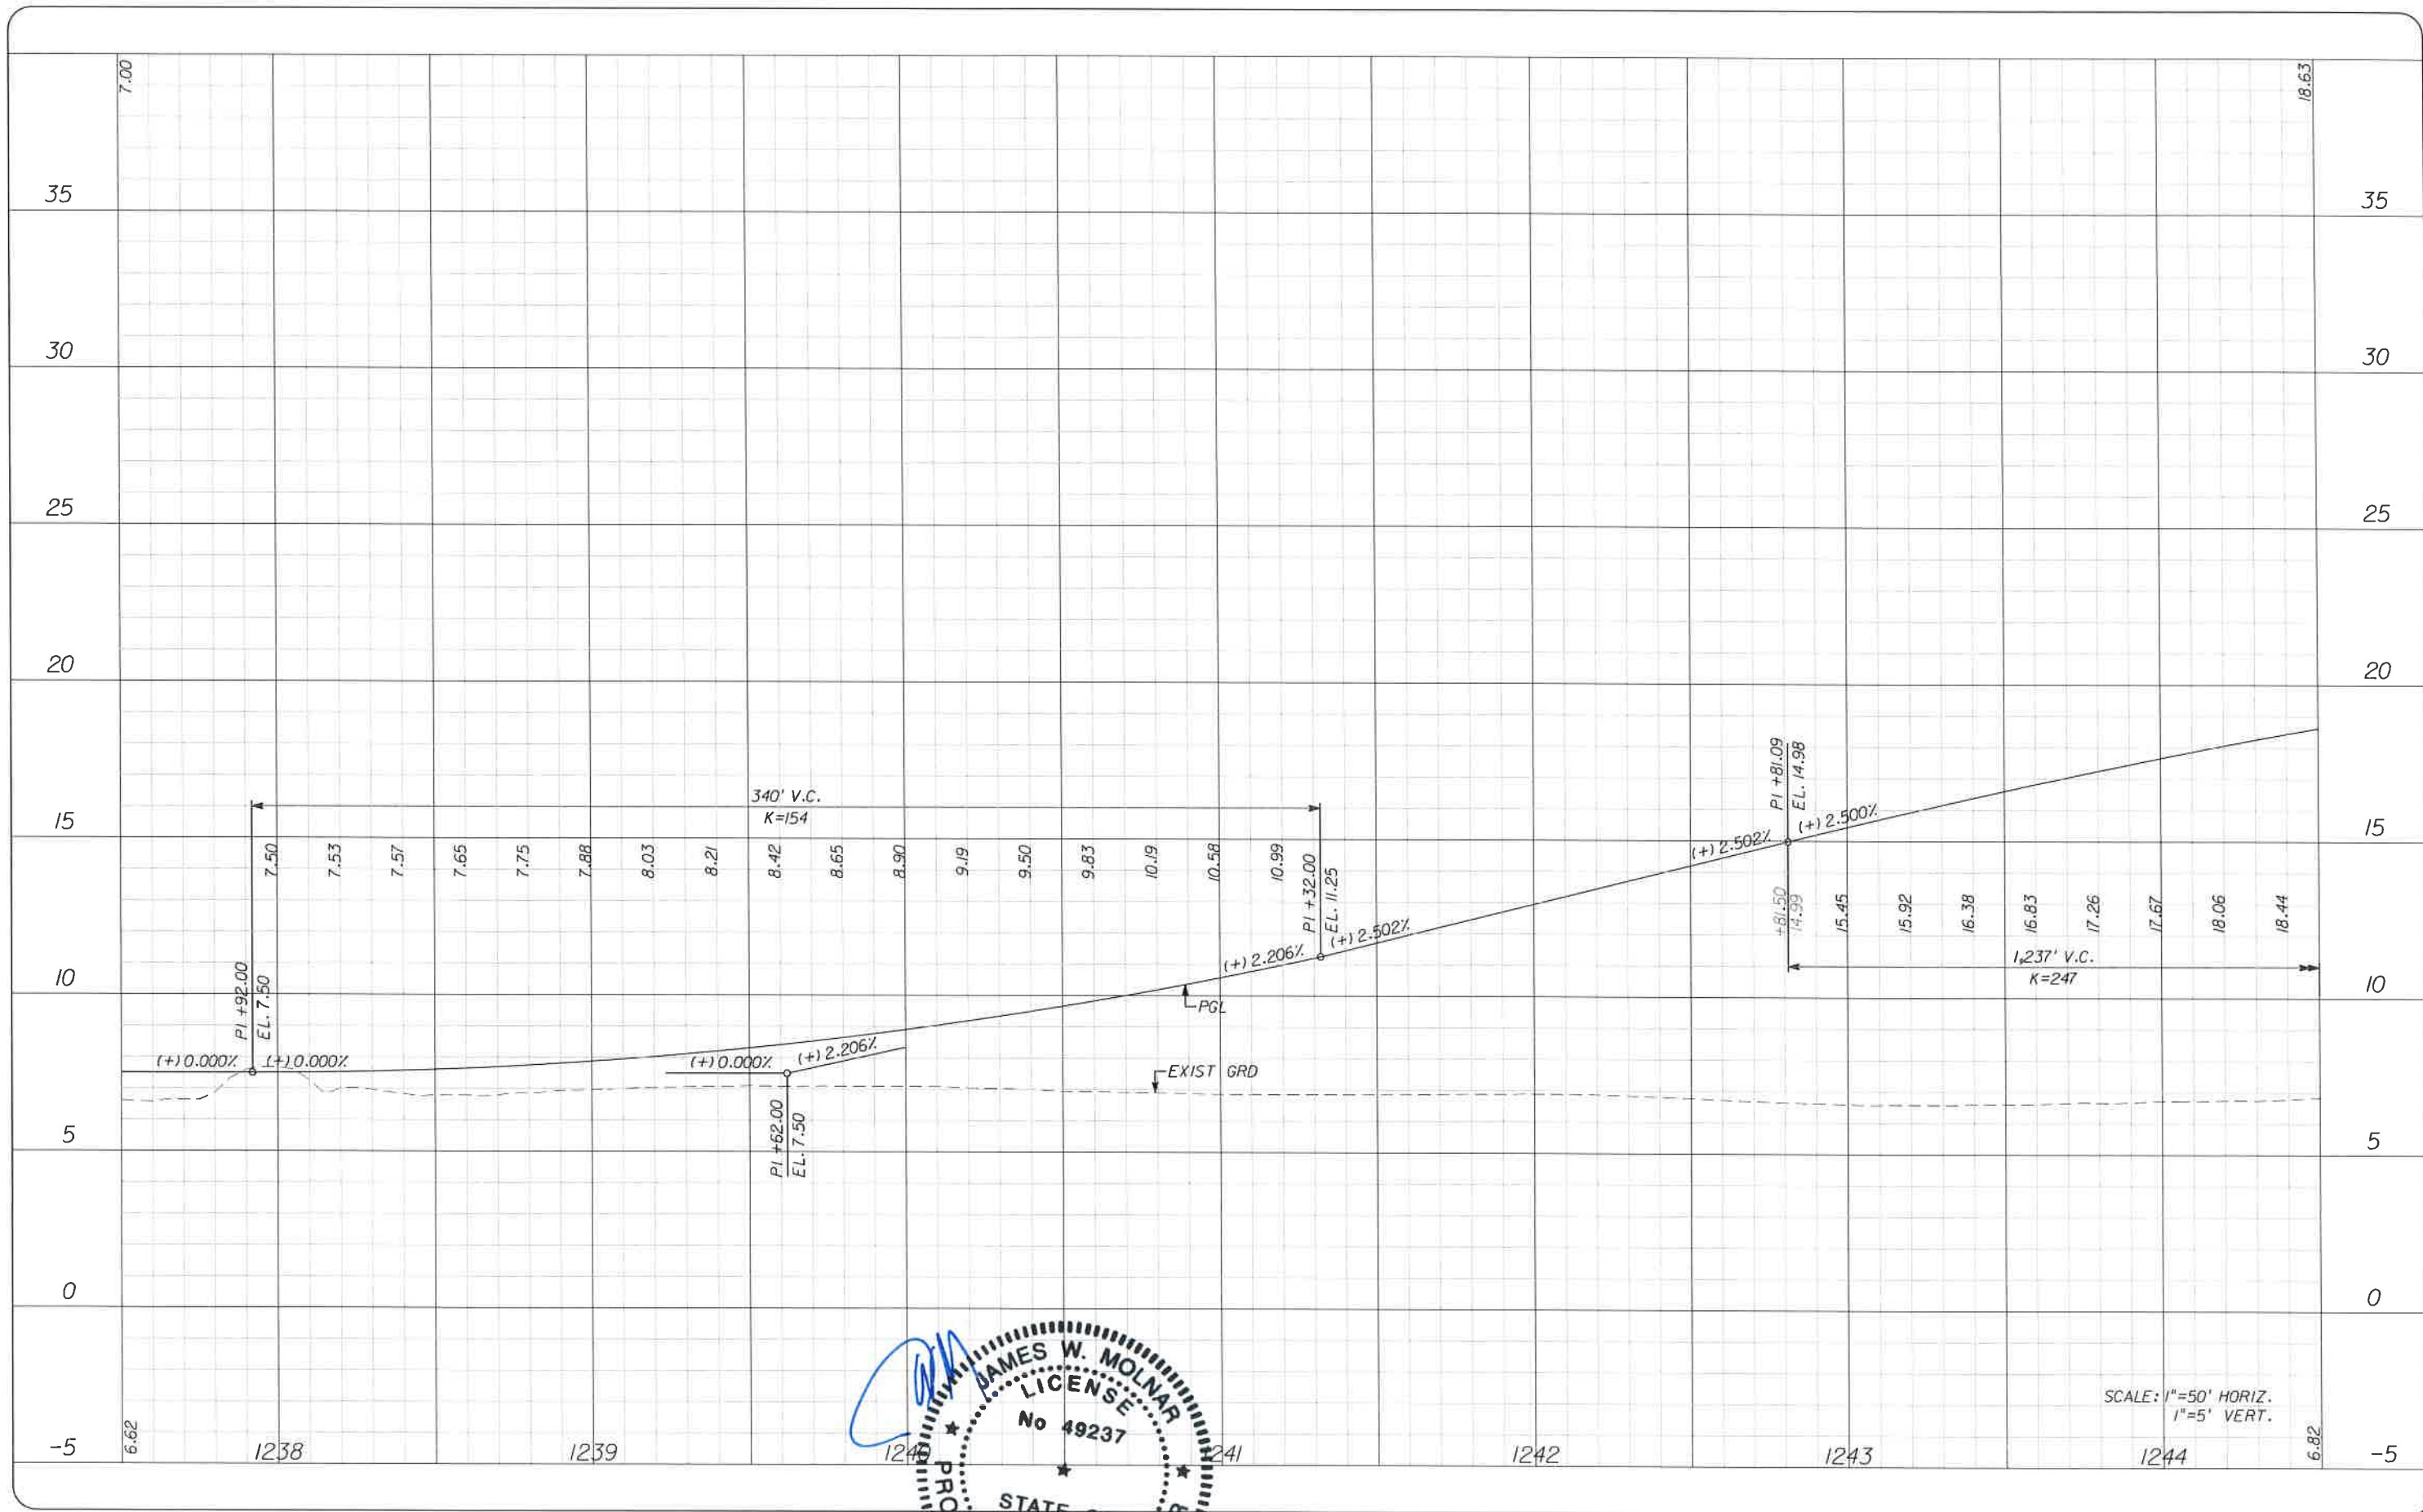

SCALE: 1"=50' HORIZ.
1"=5' VERT.

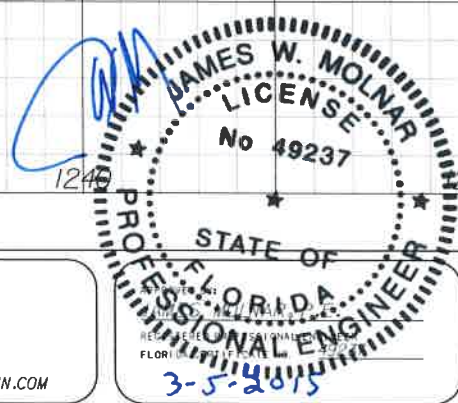

NO.	DATE	BY	REVISIONS - DESCRIPTION


T.Y. LIN INTERNATIONAL
2400 FIRST STREET
SUITE 200
FORT MYERS, FLORIDA 33901
TEL. (239) 332-4846
FAX. (239) 332-4798
WWW.TYLIN.COM

PUBLIC WORKS
LEE COUNTY
SOUTHWEST
FLORIDA
1500 MONROE STREET
12391 479-8900 www.lee-county.com/publicworks/default.htm

DEPARTMENT
of
TRANSPORTATION
FORT MYERS, FLORIDA 33901
5307:04 PM

PROFILE SHEET
STA. 1237+50 TO STA. 1244+50
BURNT STORE ROAD

SHEET NO.
43

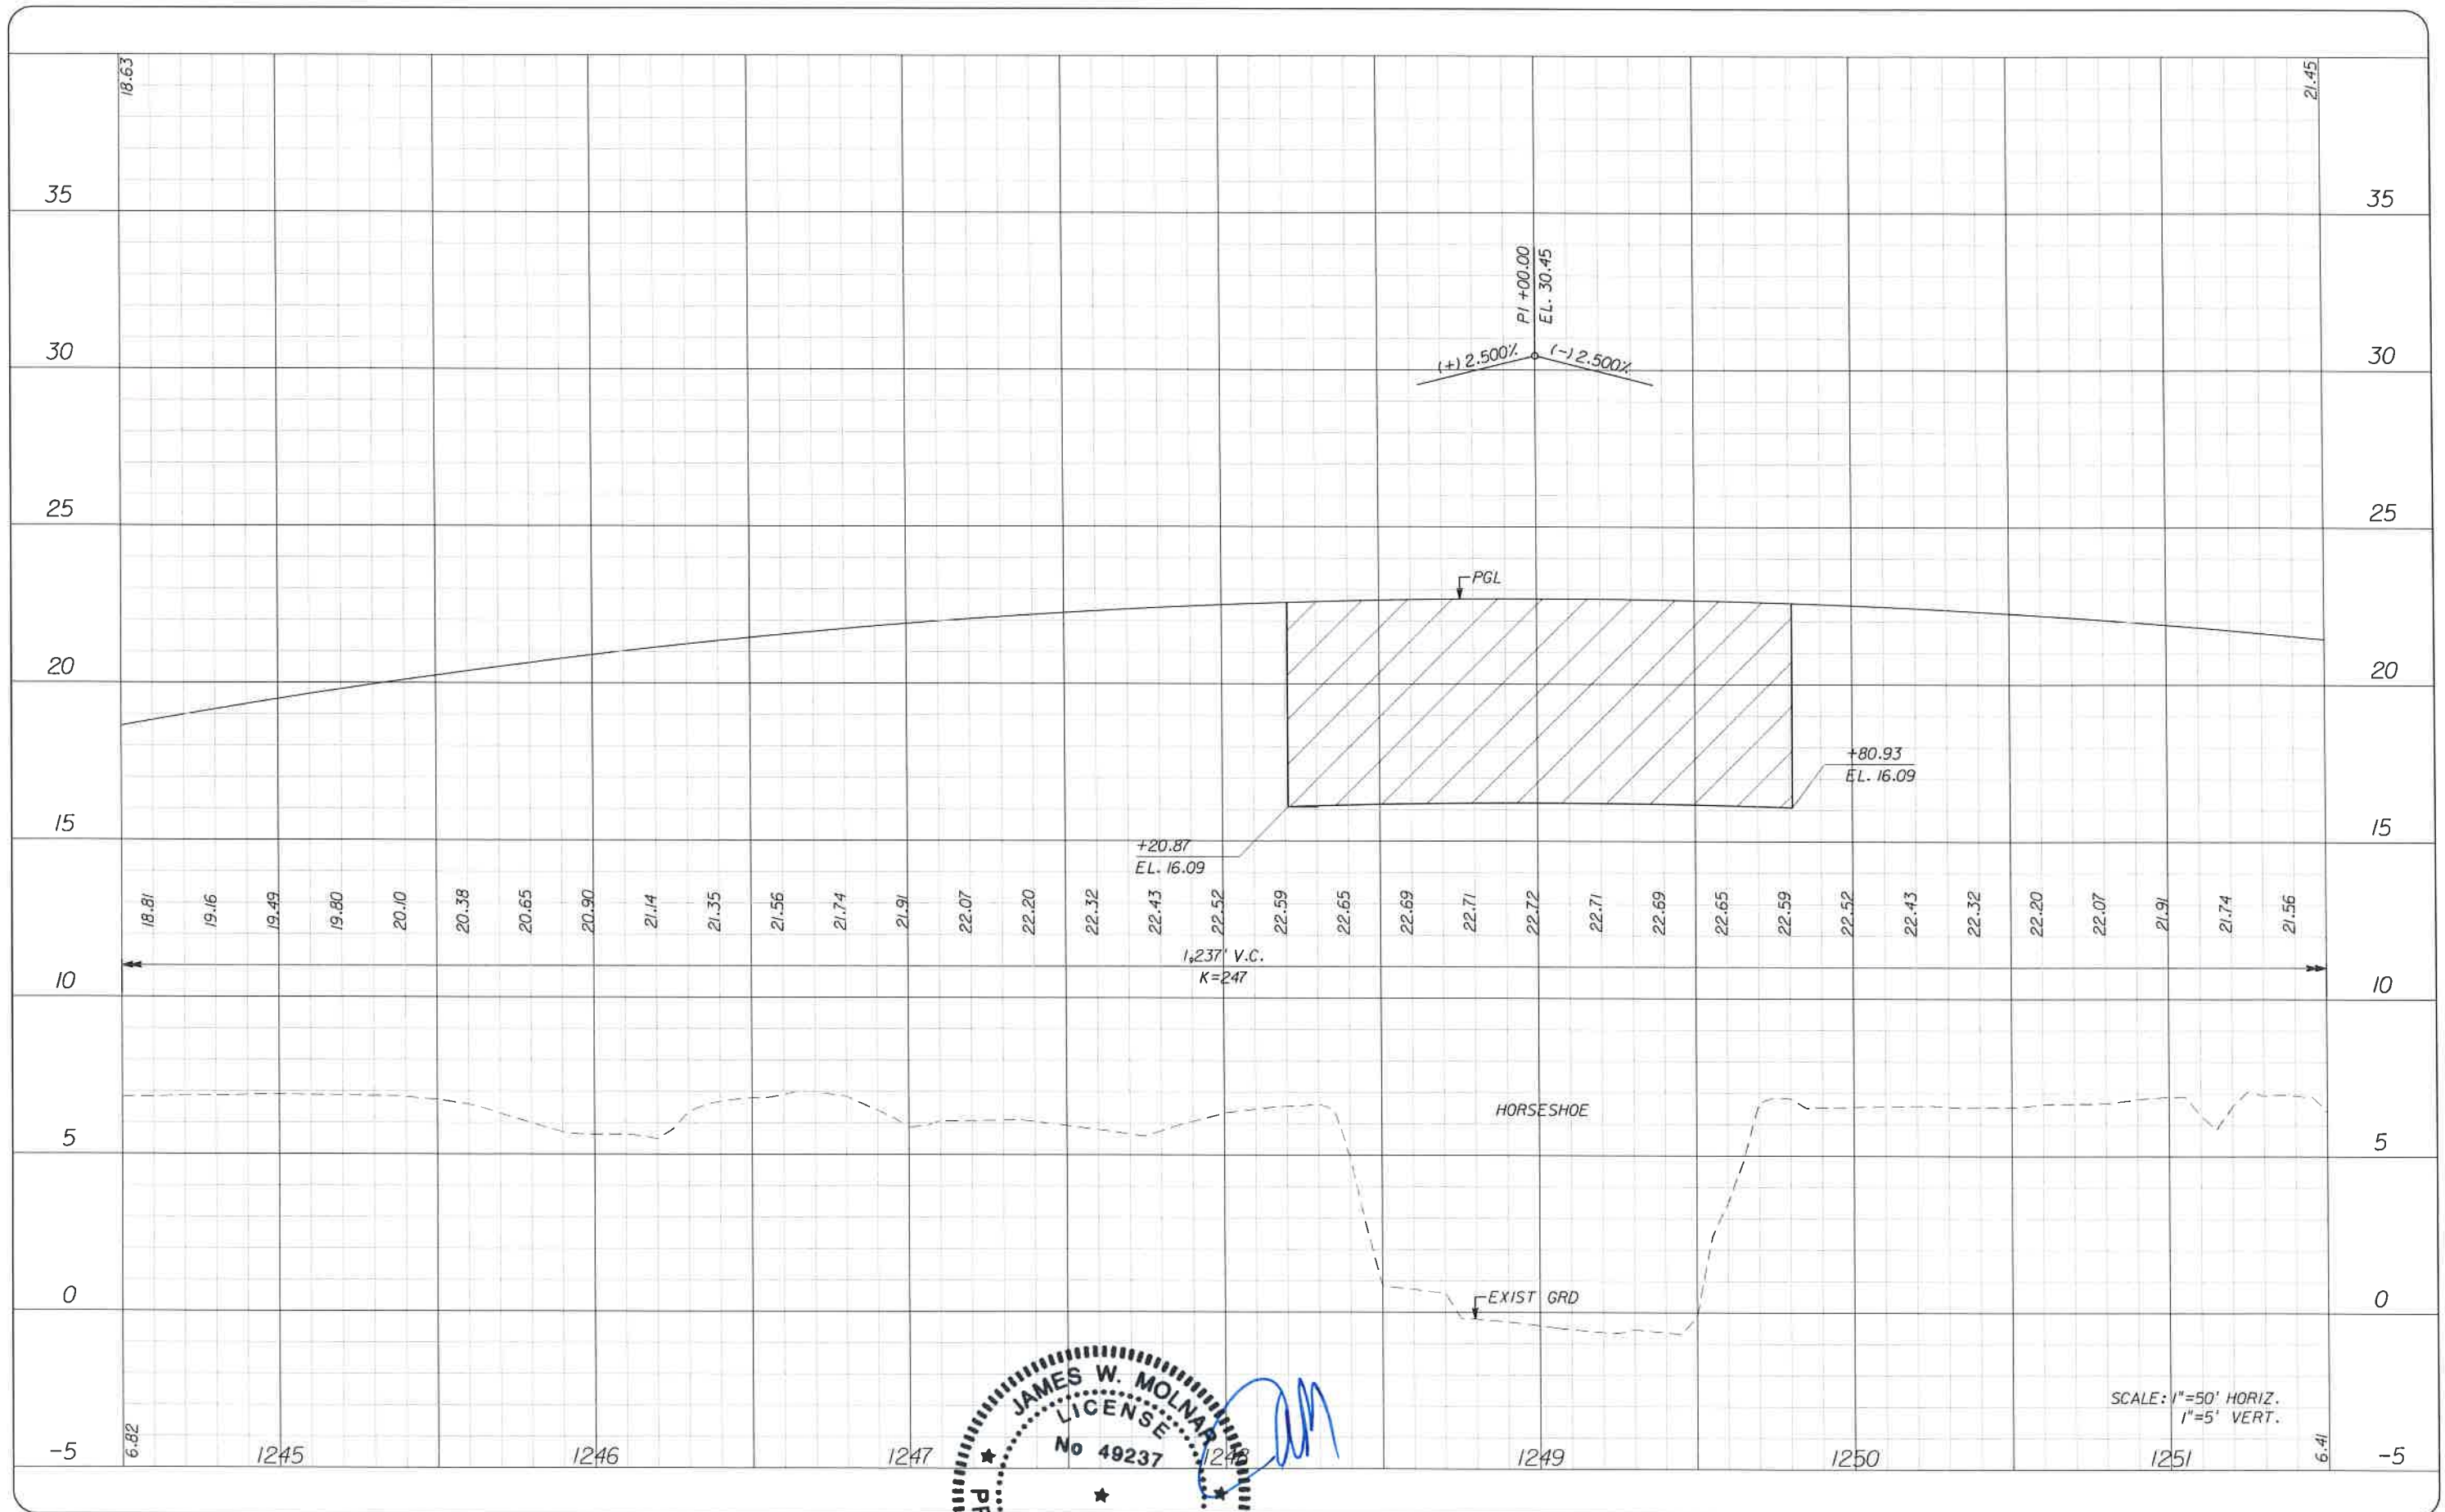

SCALE: 1"=50' HORIZ.
 1"=5' VERT.

NO.	DATE	BY	REVISIONS - DESCRIPTION

T.Y. LIN INTERNATIONAL
 2400 FIRST STREET
 SUITE 200
 FORT MYERS, FLORIDA 33901
 TEL. (239) 332-4846
 FAX. (239) 332-4798
 WWW.TYLIN.COM




PUBLIC WORKS
LEE COUNTY
SOUTHWEST
FLORIDA
 1500 MONROE STREET
 FORT MYERS, FLORIDA 33901
 (239) 479-8900 www.lcc-county.com/publicworks/dotfile.htm

DEPARTMENT
of
TRANSPORTATION
 FORT MYERS, FLORIDA 33901


PROFILE SHEET
STA. 1244+50 TO STA. 1251+50
BURNT STORE ROAD

SHEET NO.
 44

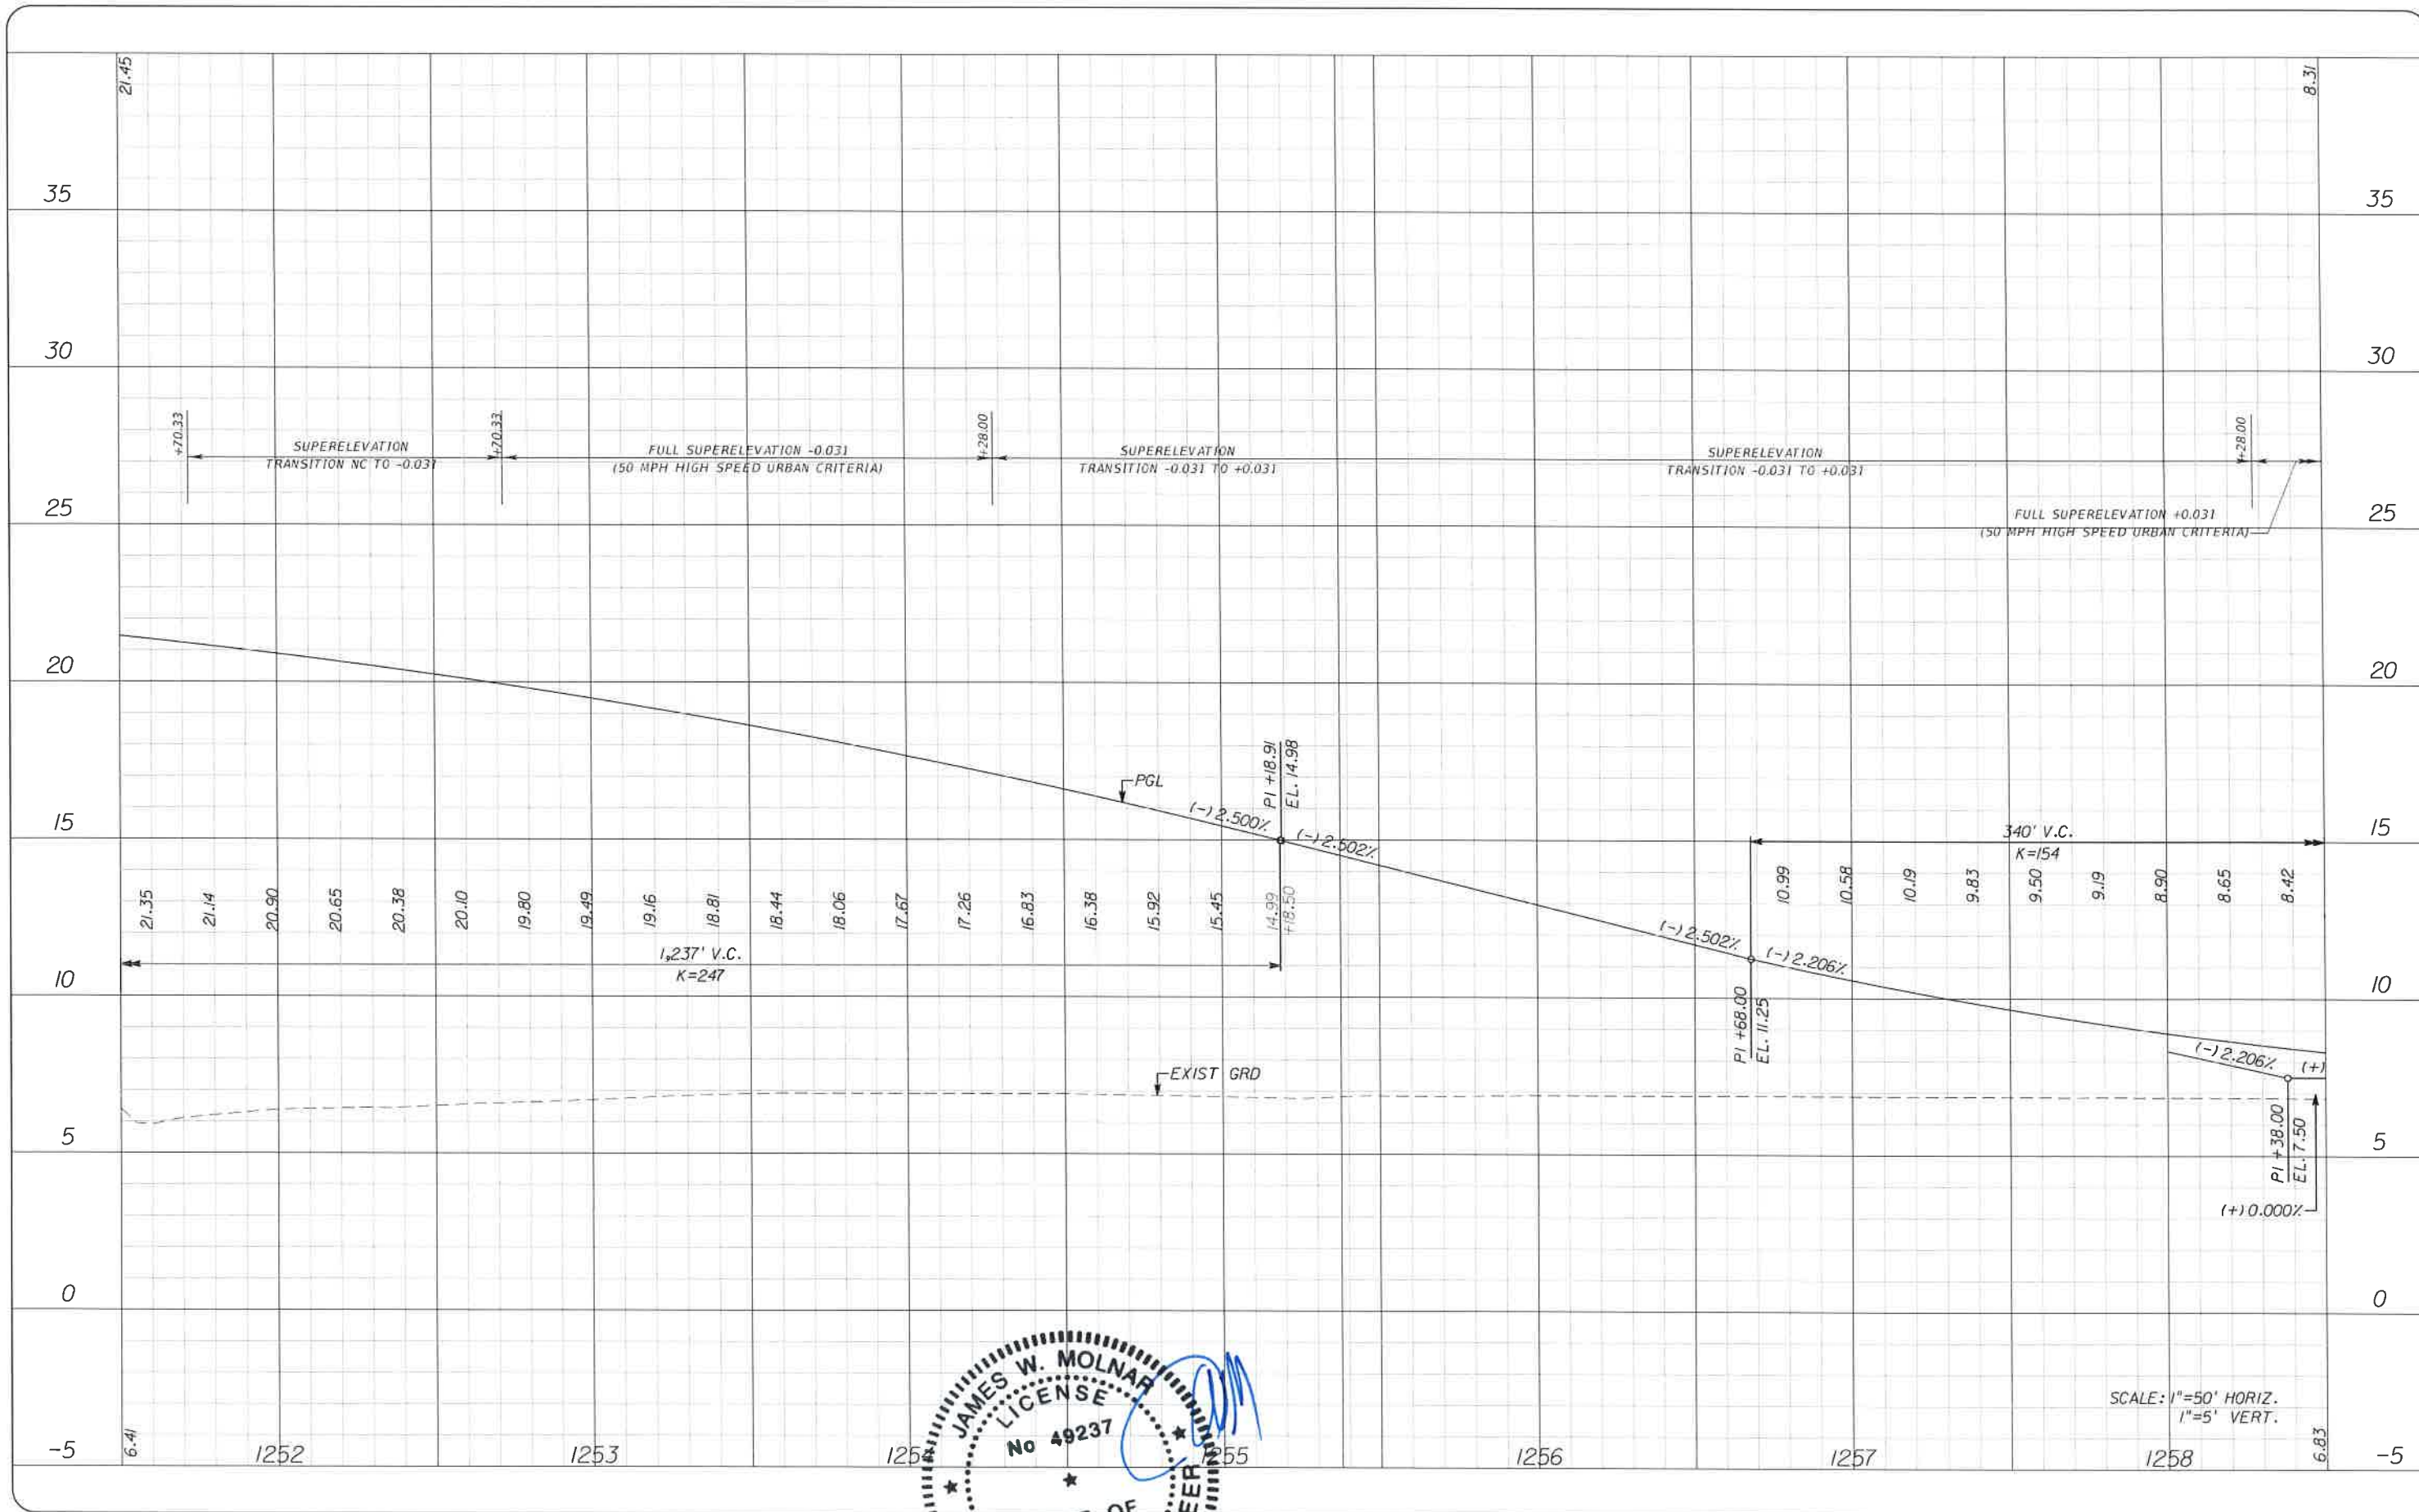

NO.	DATE	BY	REVISIONS - DESCRIPTION

T.Y. LIN INTERNATIONAL
 2400 FIRST STREET
 SUITE 200
 FORT MYERS, FLORIDA 33901
 TEL. (239) 332-4846
 FAX. (239) 332-4798
 WWW.TYLIN.COM



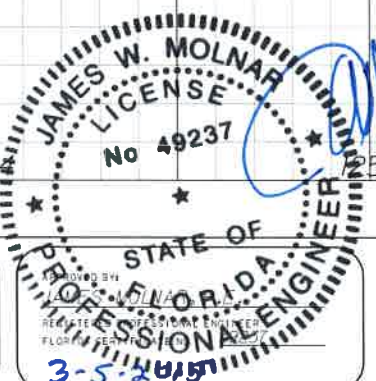


PUBLIC WORKS
LEE COUNTY
SOUTHWEST
FLORIDA
 1500 MONROE STREET
 FORT MYERS, FLORIDA 33901
 (239) 479-8900 www.lee-county.com/publicworks/online.htm

DEPARTMENT
of
TRANSPORTATION

PROFILE SHEET
STA. 1251+50 TO STA. 1258+50
BURNT STORE ROAD

SHEET
NO.
45

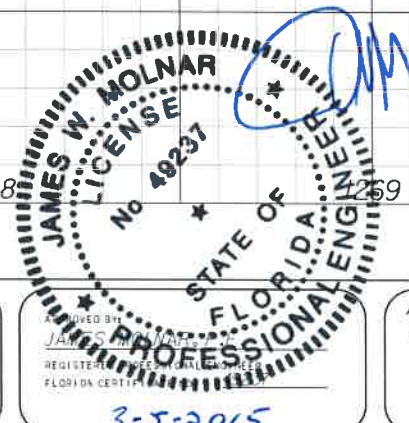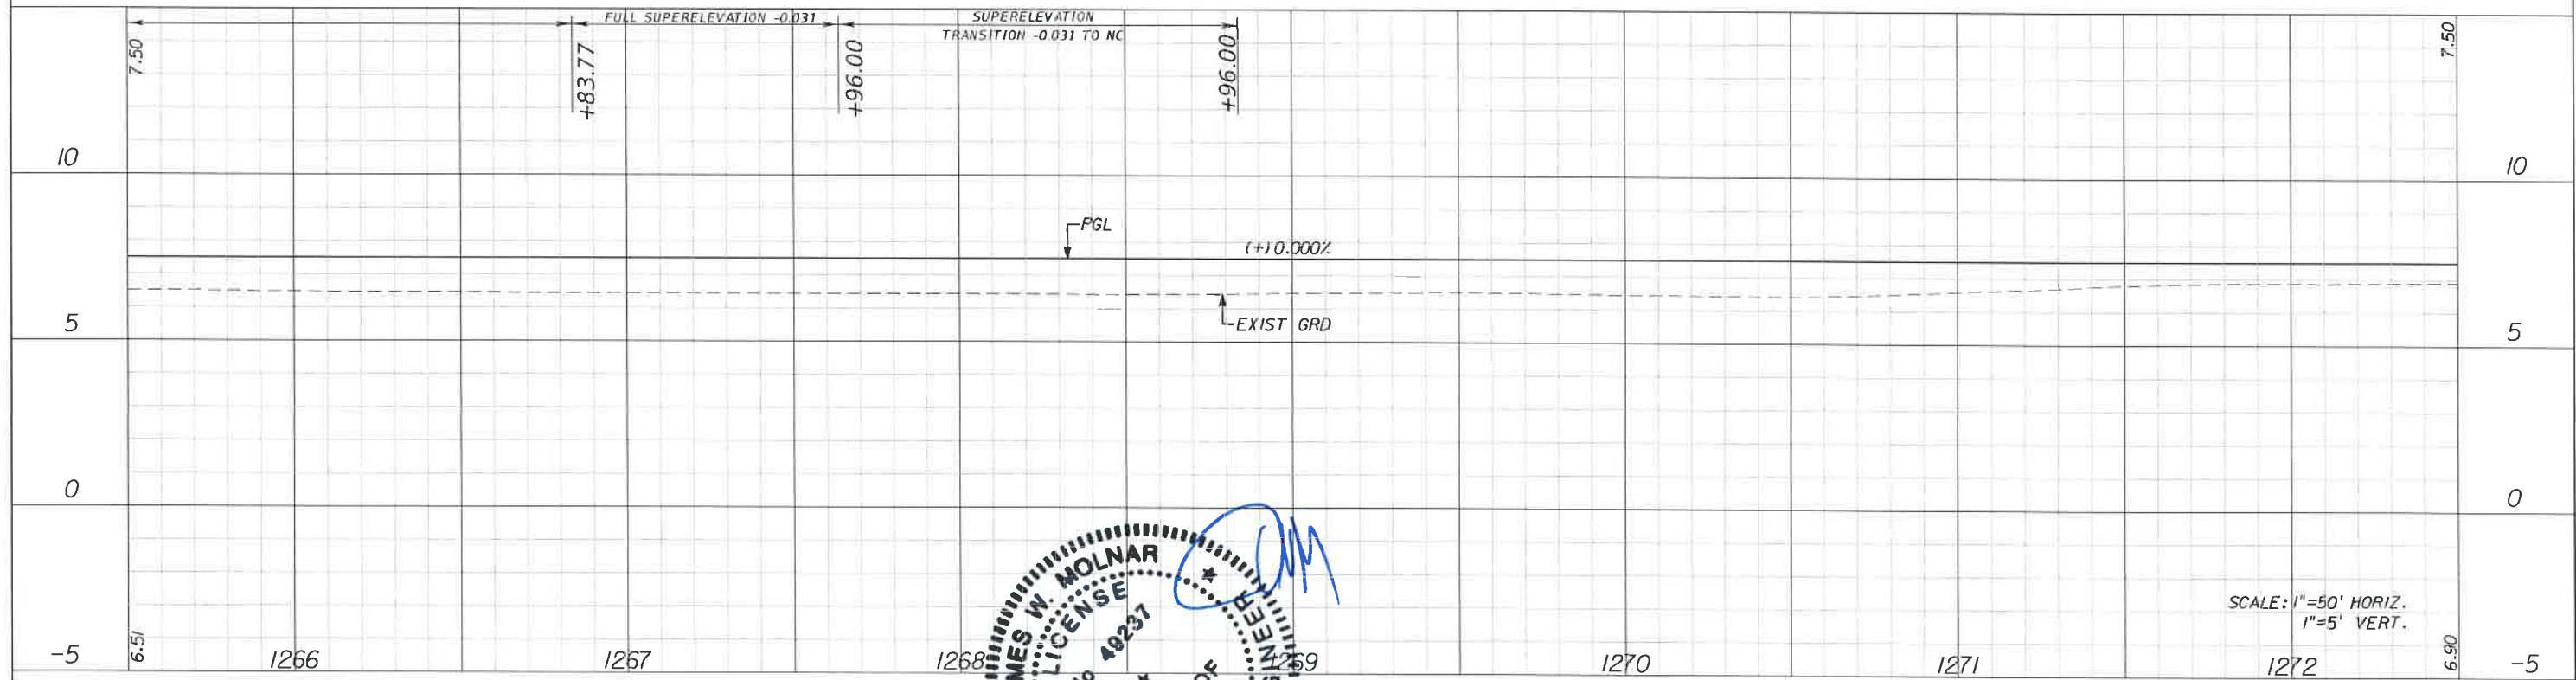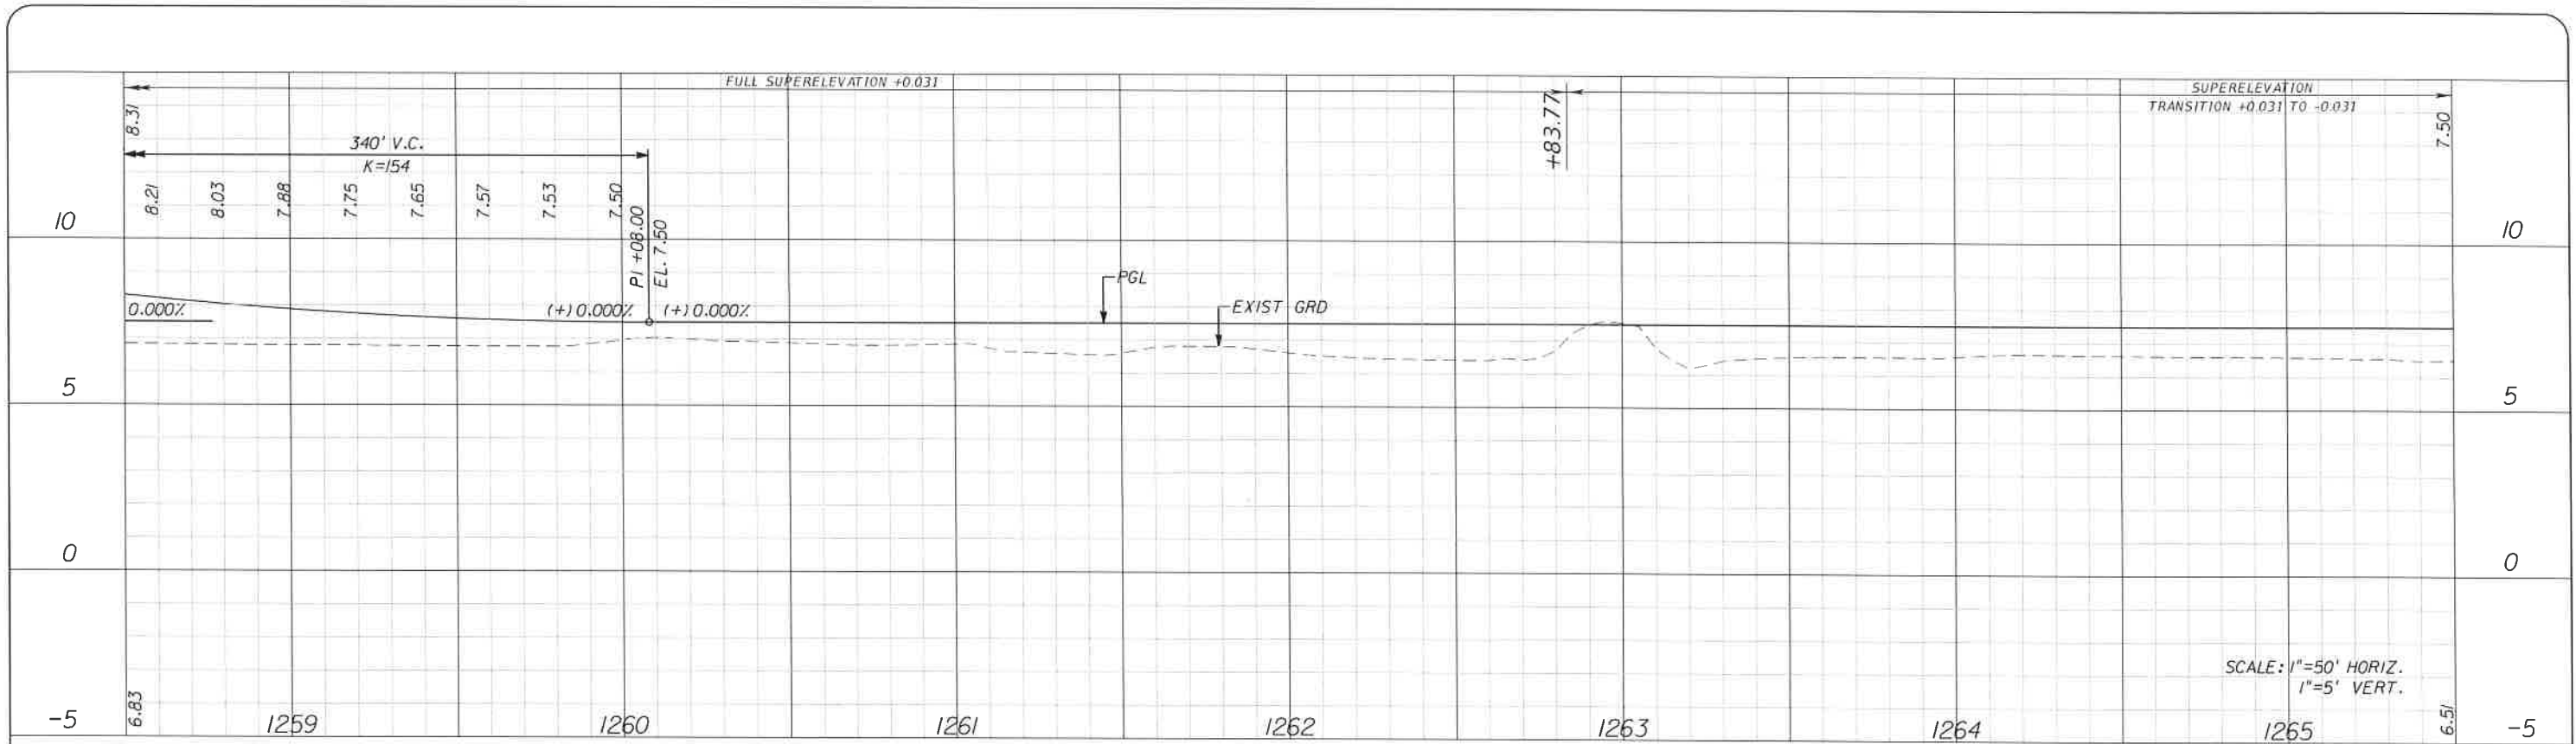

NO.	DATE	BY	REVISIONS - DESCRIPTION




T.Y. LIN INTERNATIONAL
 2400 FIRST STREET
 SUITE 200
 FORT MYERS, FLORIDA 33901
 TEL. (239) 332-4846
 FAX. (239) 332-4798
 WWW.TYLIN.COM

PUBLIC WORKS
LEE COUNTY
SOUTHWEST
FLORIDA
 1500 MONROE STREET
 FORT MYERS, FLORIDA 33901
 (239) 479-8900
 www.lee-county.com/publicworks/default.htm

DEPARTMENT
of
TRANSPORTATION

PROFILE SHEET
STA. 1258+50 TO STA. 1272+50
BURNT STORE ROAD

SHEET NO.
 46

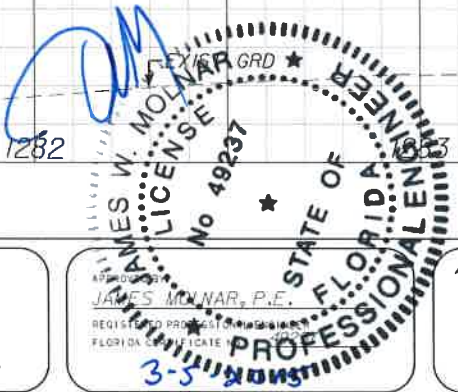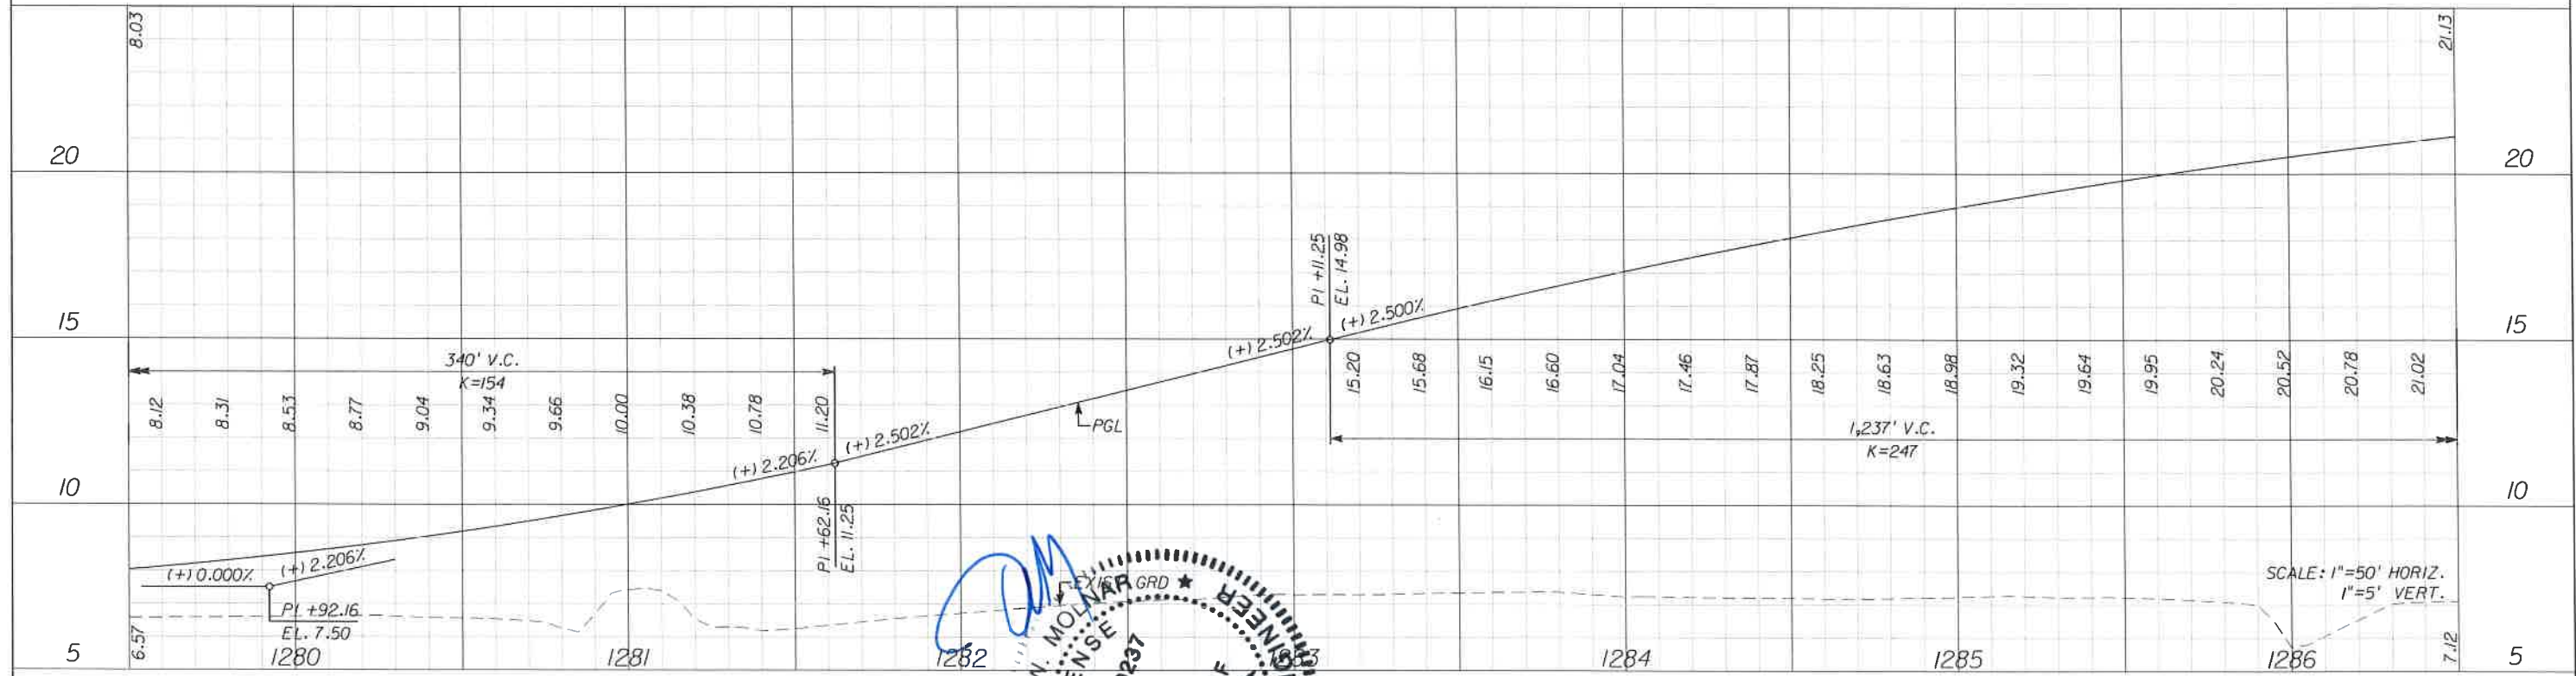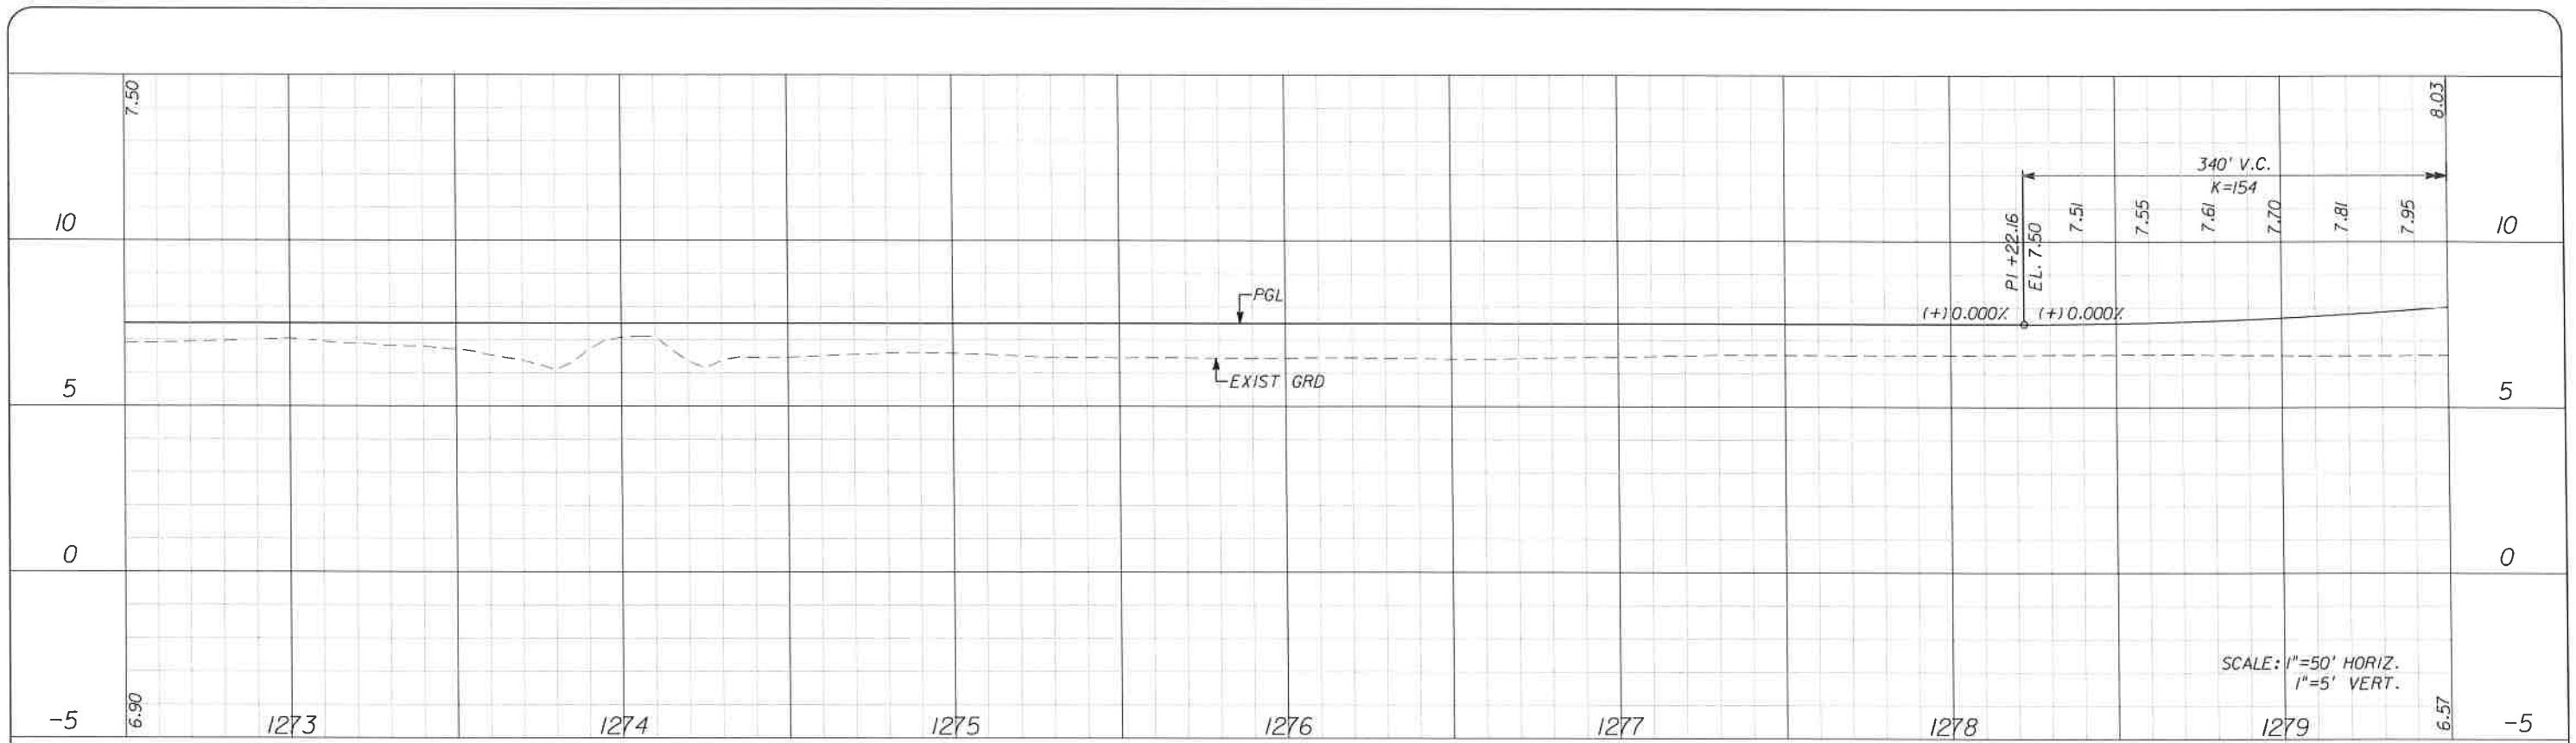

NO.	DATE	BY	REVISIONS - DESCRIPTION

T.Y. LIN INTERNATIONAL
 2400 FIRST STREET
 SUITE 200
 FORT MYERS, FLORIDA 33901
 TEL. (239) 332-4846
 FAX. (239) 332-4798
 WWW.TYLIN.COM


JAMES W. MOLNAR, P.E.
 LICENSE No. 49237
 STATE OF FLORIDA
 PROFESSIONAL ENGINEER

PUBLIC WORKS
LEE COUNTY
SOUTHWEST
FLORIDA
 1500 MONROE STREET
 12391 479-8900 www.lee-county.com/publicworks/ds/rttkr.htm

DEPARTMENT
of
TRANSPORTATION
 FORT MYERS, FLORIDA 33901

PROFILE SHEET
STA. 1272+50 TO STA. 1286+50
BURNT STORE ROAD

SHEET NO.
 47

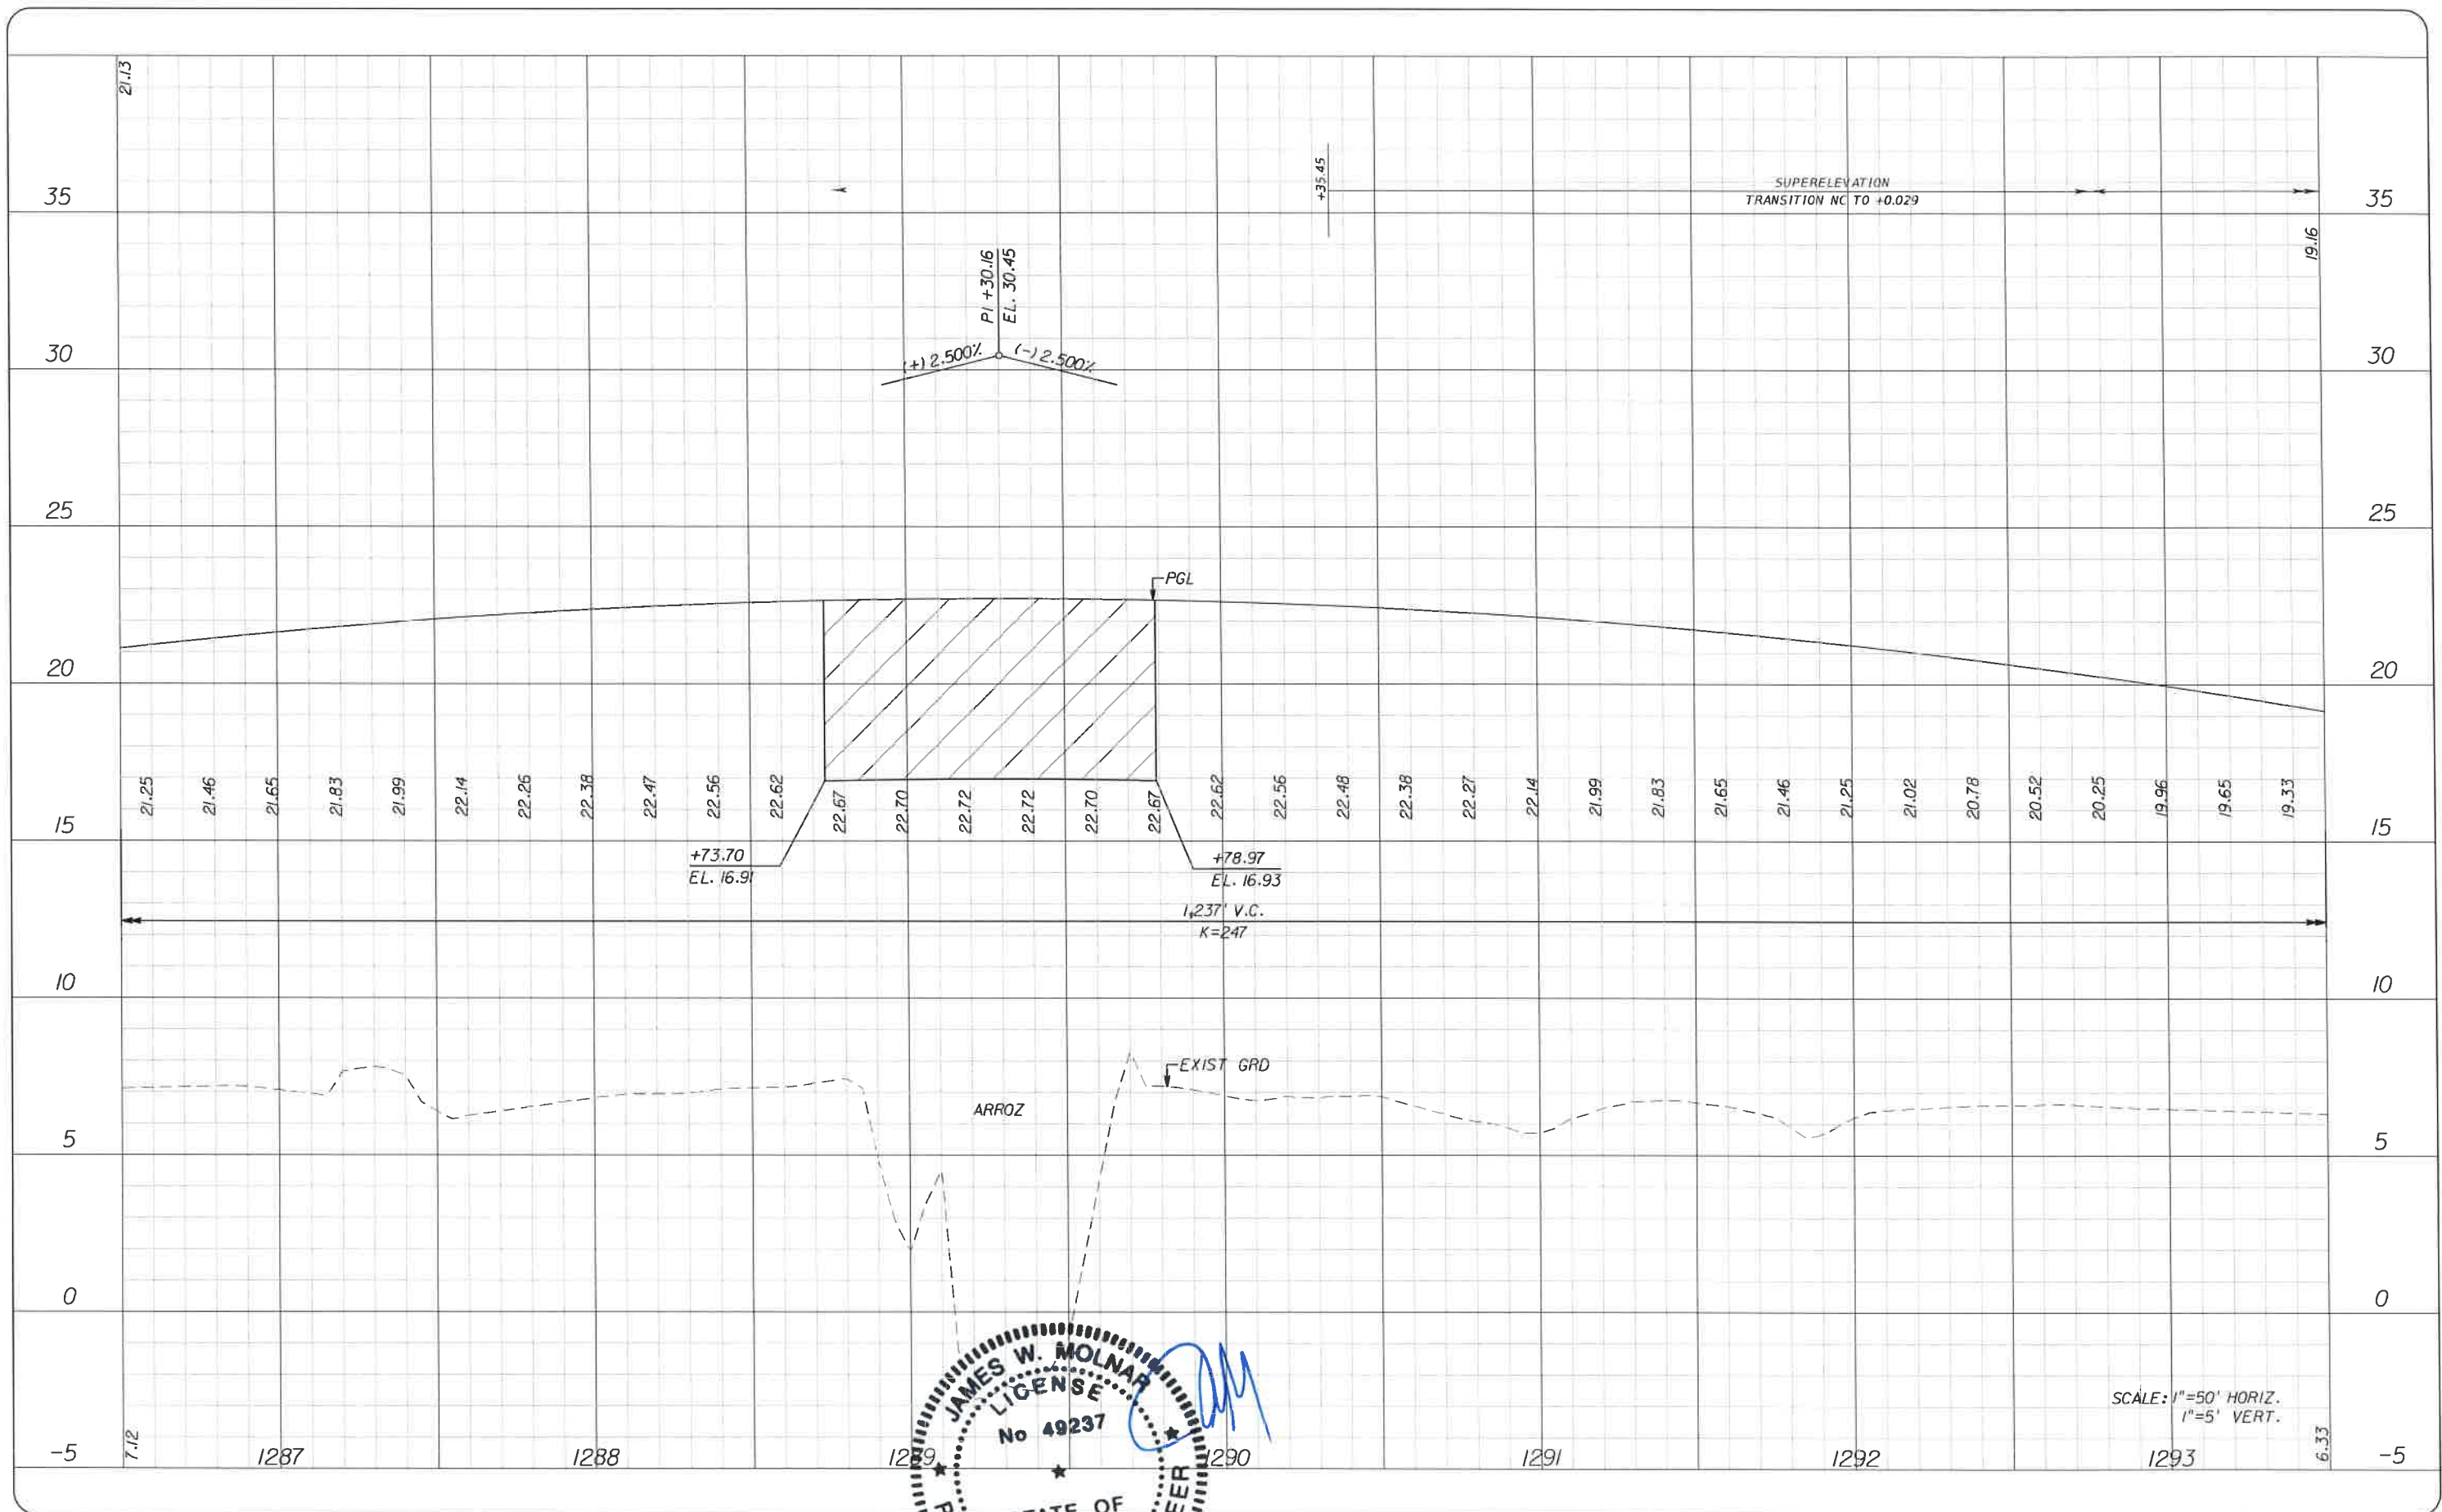

SCALE: 1"=50' HORIZ.
1"=5' VERT.




T.Y. LIN INTERNATIONAL
2400 FIRST STREET
SUITE 200
FORT MYERS, FLORIDA 33901
TEL. (239) 332-4846
FAX. (239) 332-4798
WWW.TYLIN.COM

PUBLIC WORKS
LEE COUNTY
SOUTHWEST
FLORIDA
1303 MONROE STREET
FORT MYERS, FLORIDA 33901
12391 479-8900 www.lee-county.com/publicworks/default.htm

DEPARTMENT
of
TRANSPORTATION
PROFILE SHEET
STA. 1286+50 TO STA. 1293+50
BURNT STORE ROAD

SHEET
NO.
48
Default

NO.	DATE	BY	REVISIONS - DESCRIPTION

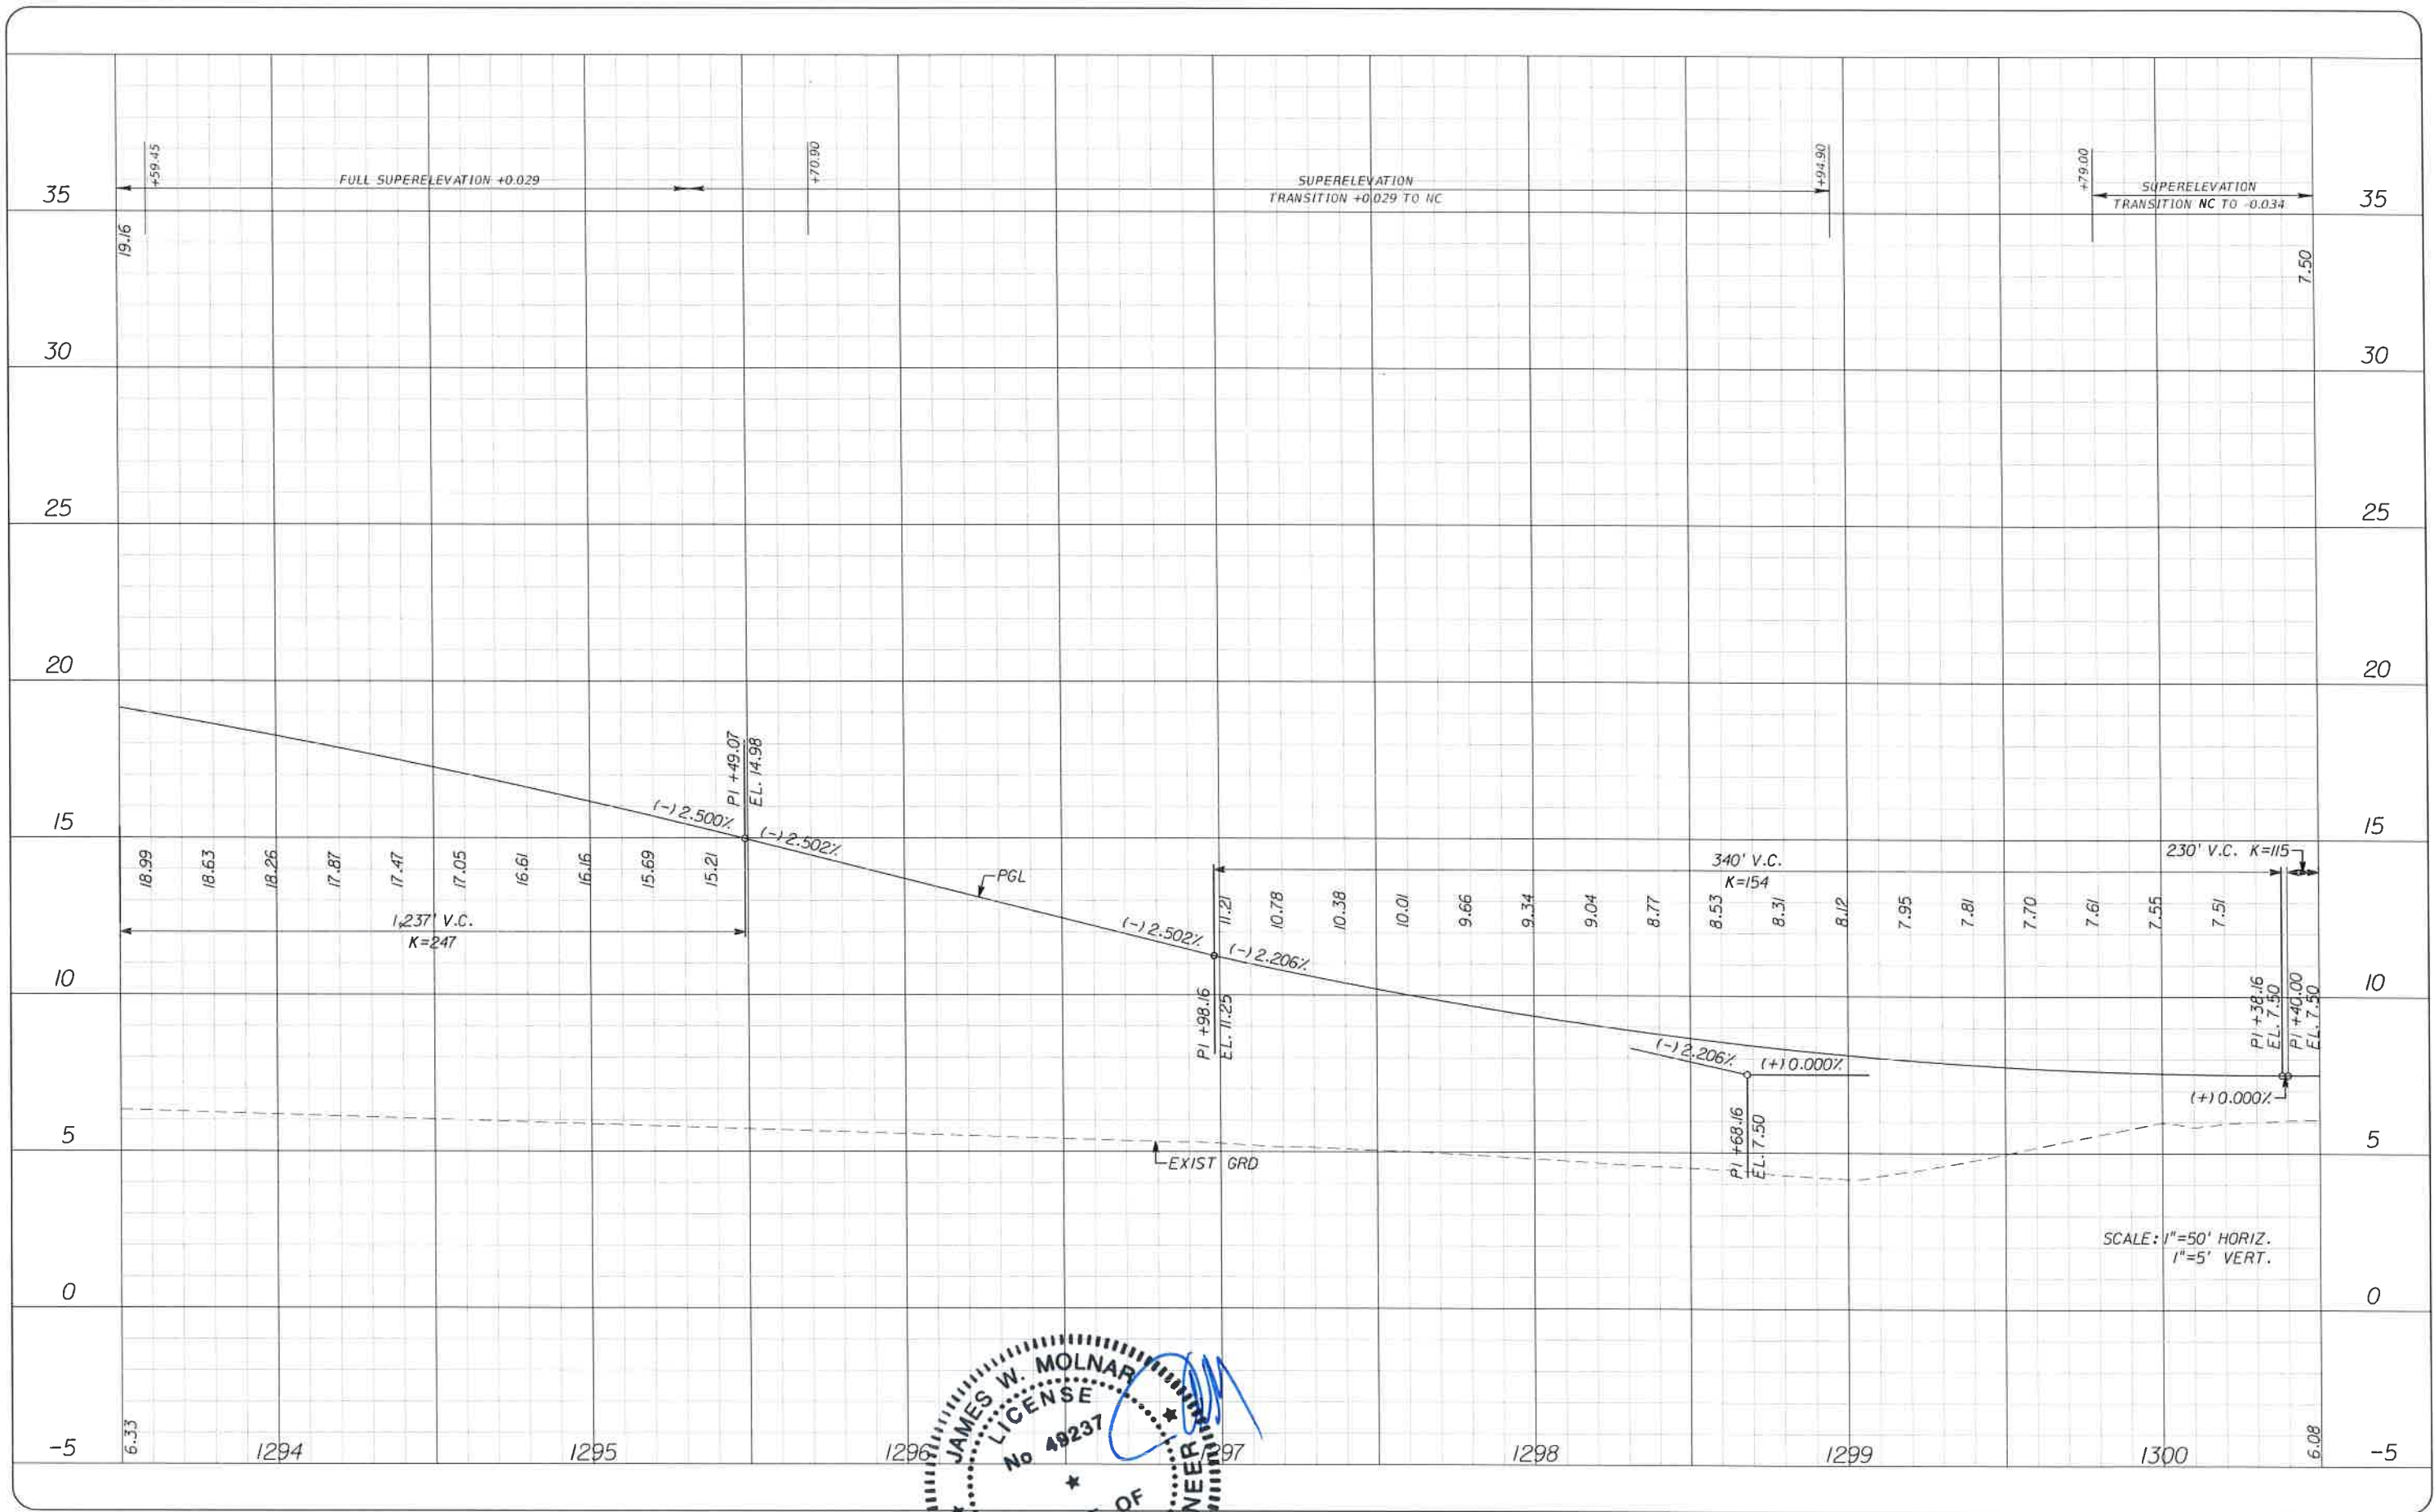

SCALE: 1"=50' HORIZ.
1"=5' VERT.



T.Y. LIN INTERNATIONAL
2400 FIRST STREET
SUITE 200
FORT MYERS, FLORIDA 33901
TEL. (239) 332-4846
FAX. (239) 332-4798
WWW.TYLIN.COM


PUBLIC WORKS
LEE COUNTY
SOUTHWEST
FLORIDA
1500 MONROE STREET
12391 479-8900 www.lee-county.com/publicworks/forinfo.htm

DEPARTMENT
of
TRANSPORTATION
FORT MYERS, FLORIDA 33901

PROFILE SHEET
STA. 1293+50 TO STA. 1300+50
BURNT STORE ROAD

SHEET
NO.
49

NO.	DATE	BY	REVISIONS - DESCRIPTION

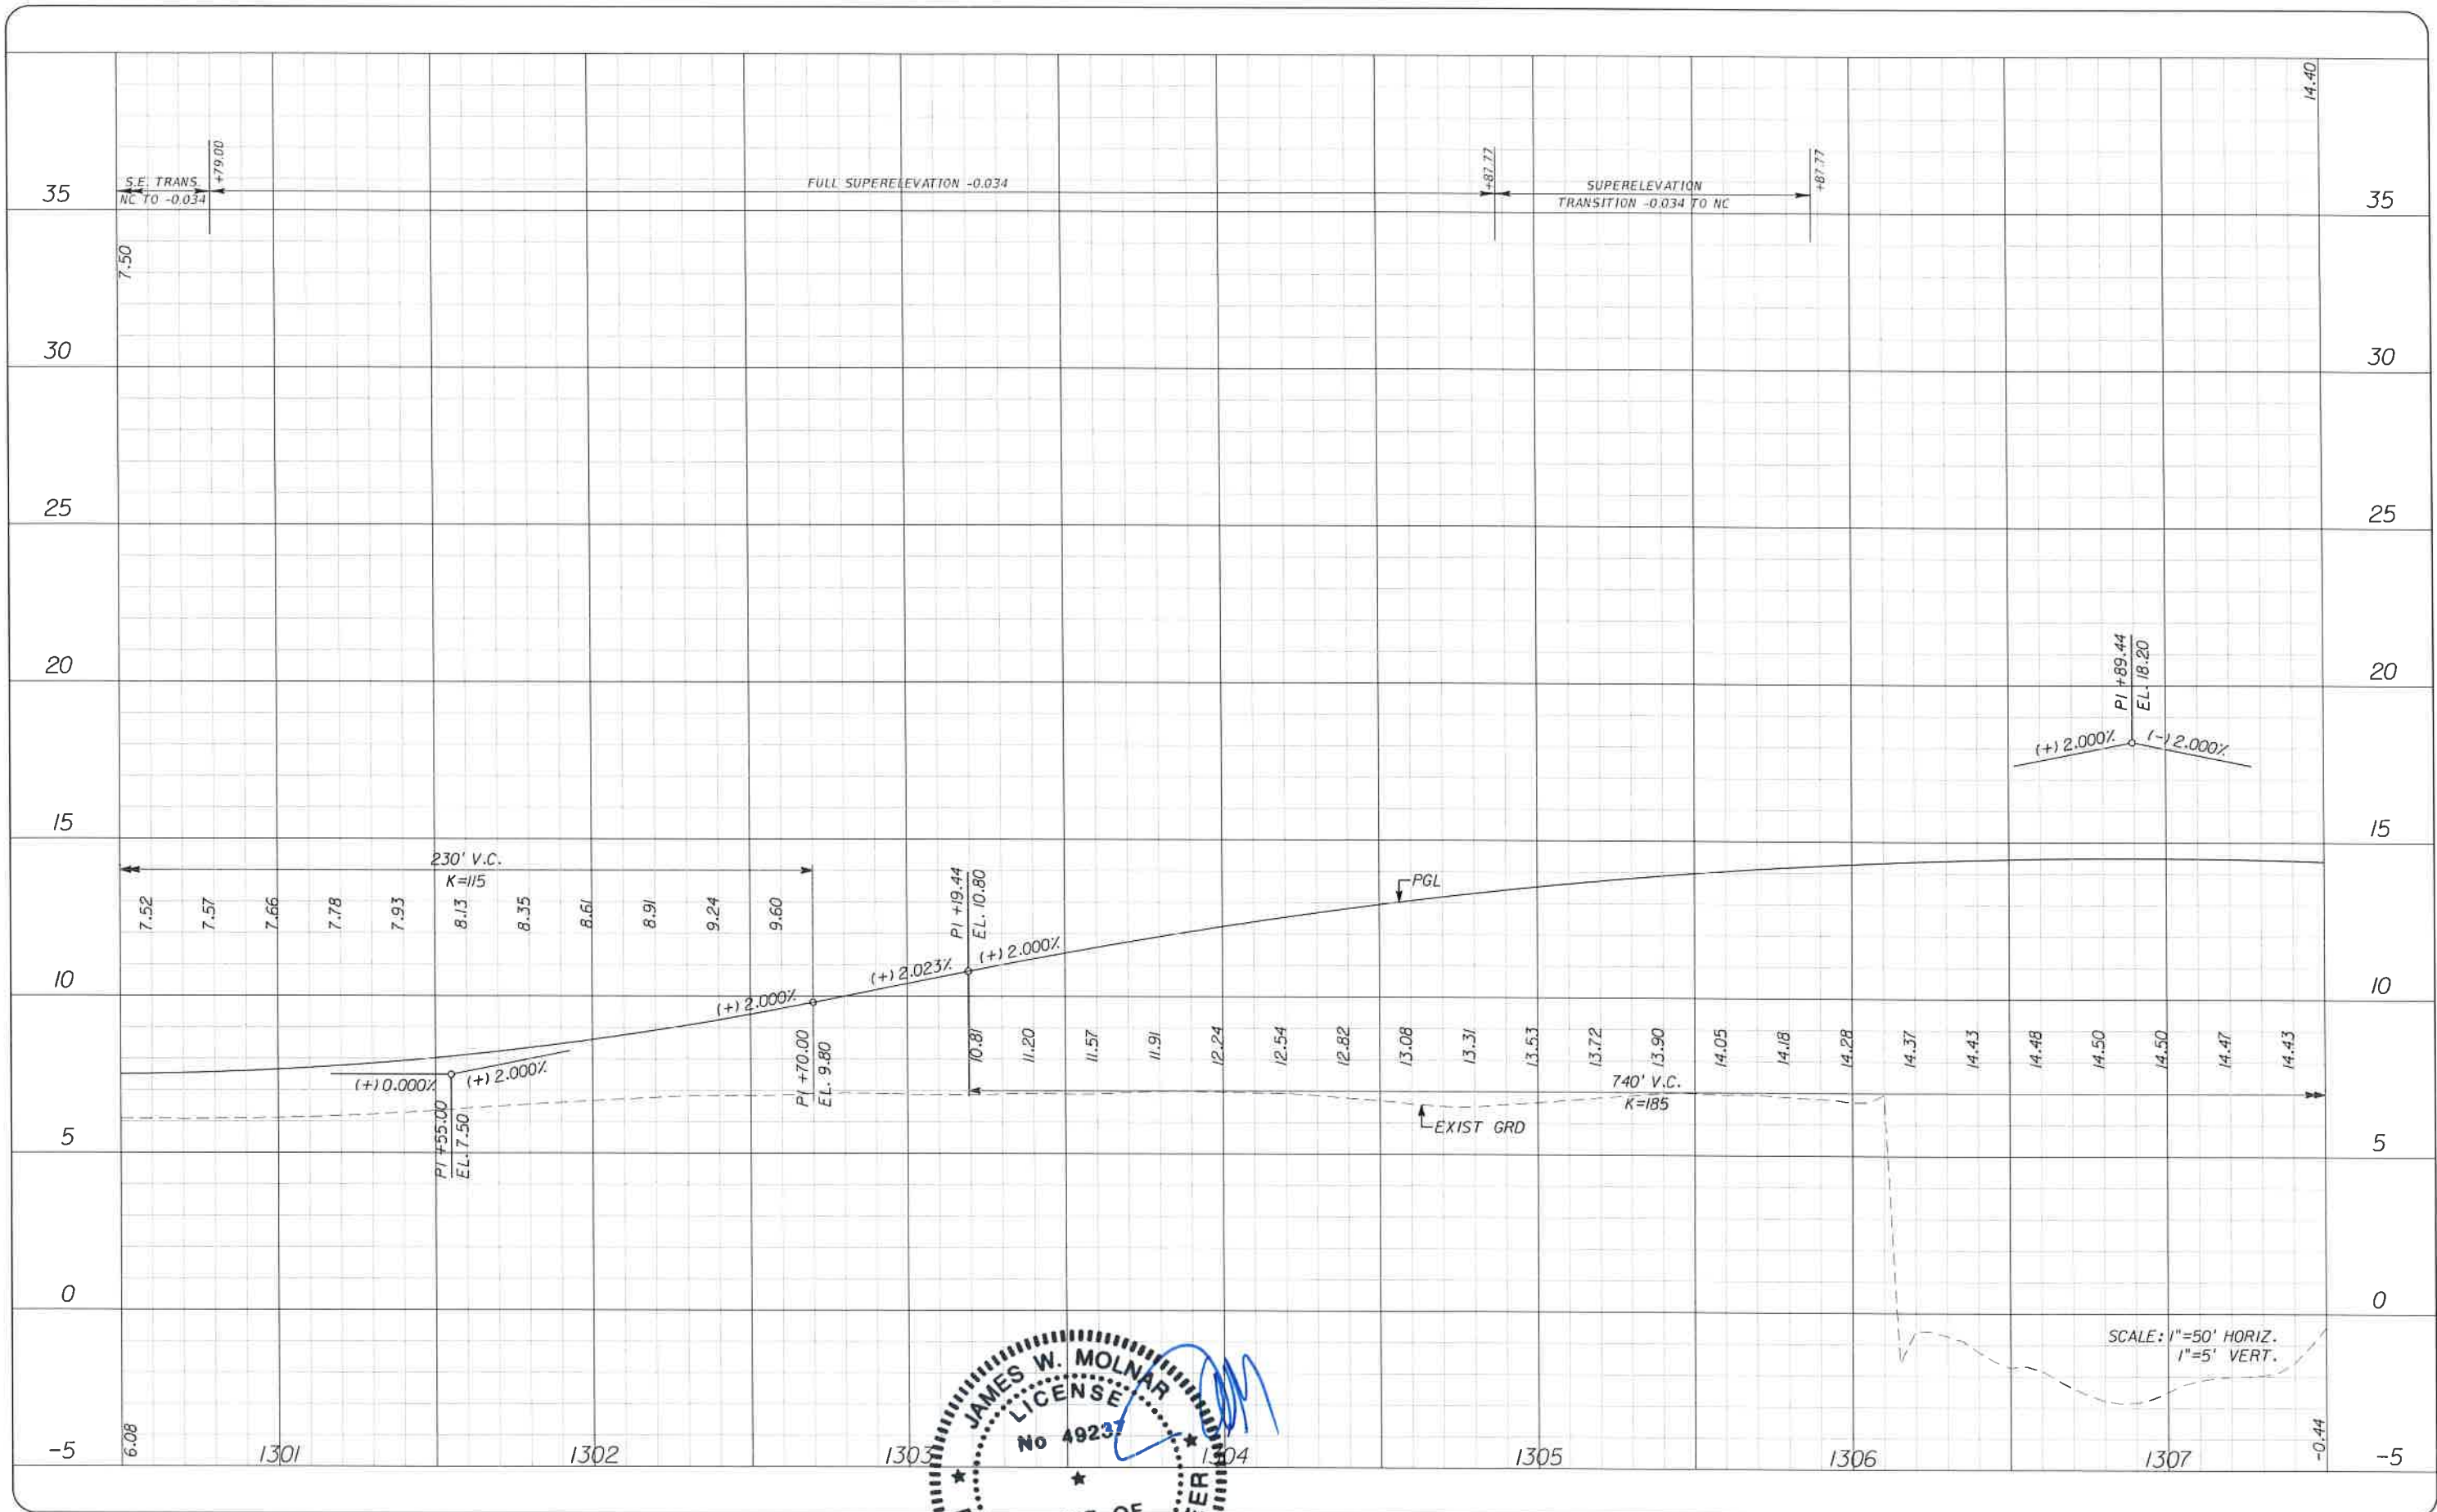

SCALE: 1"=50' HORIZ.
1"=5' VERT.



T.Y. LIN INTERNATIONAL
 2400 FIRST STREET
 SUITE 200
 FORT MYERS, FLORIDA 33901
 TEL. (239) 332-4846
 FAX. (239) 332-4798
 WWW.TYLIN.COM


PUBLIC WORKS
LEE COUNTY
SOUTHWEST
FLORIDA
 1500 MONROE STREET
 (239) 479-8900
 www.lee-county.com/publicworks/online.htm

DEPARTMENT
of
TRANSPORTATION
 FORT MYERS, FLORIDA 33901


PROFILE SHEET
STA. 1300+50 TO STA. 1307+50
BURNT STORE ROAD

NO.	DATE	BY	REVISIONS - DESCRIPTION

SHEET NO. 50
Default

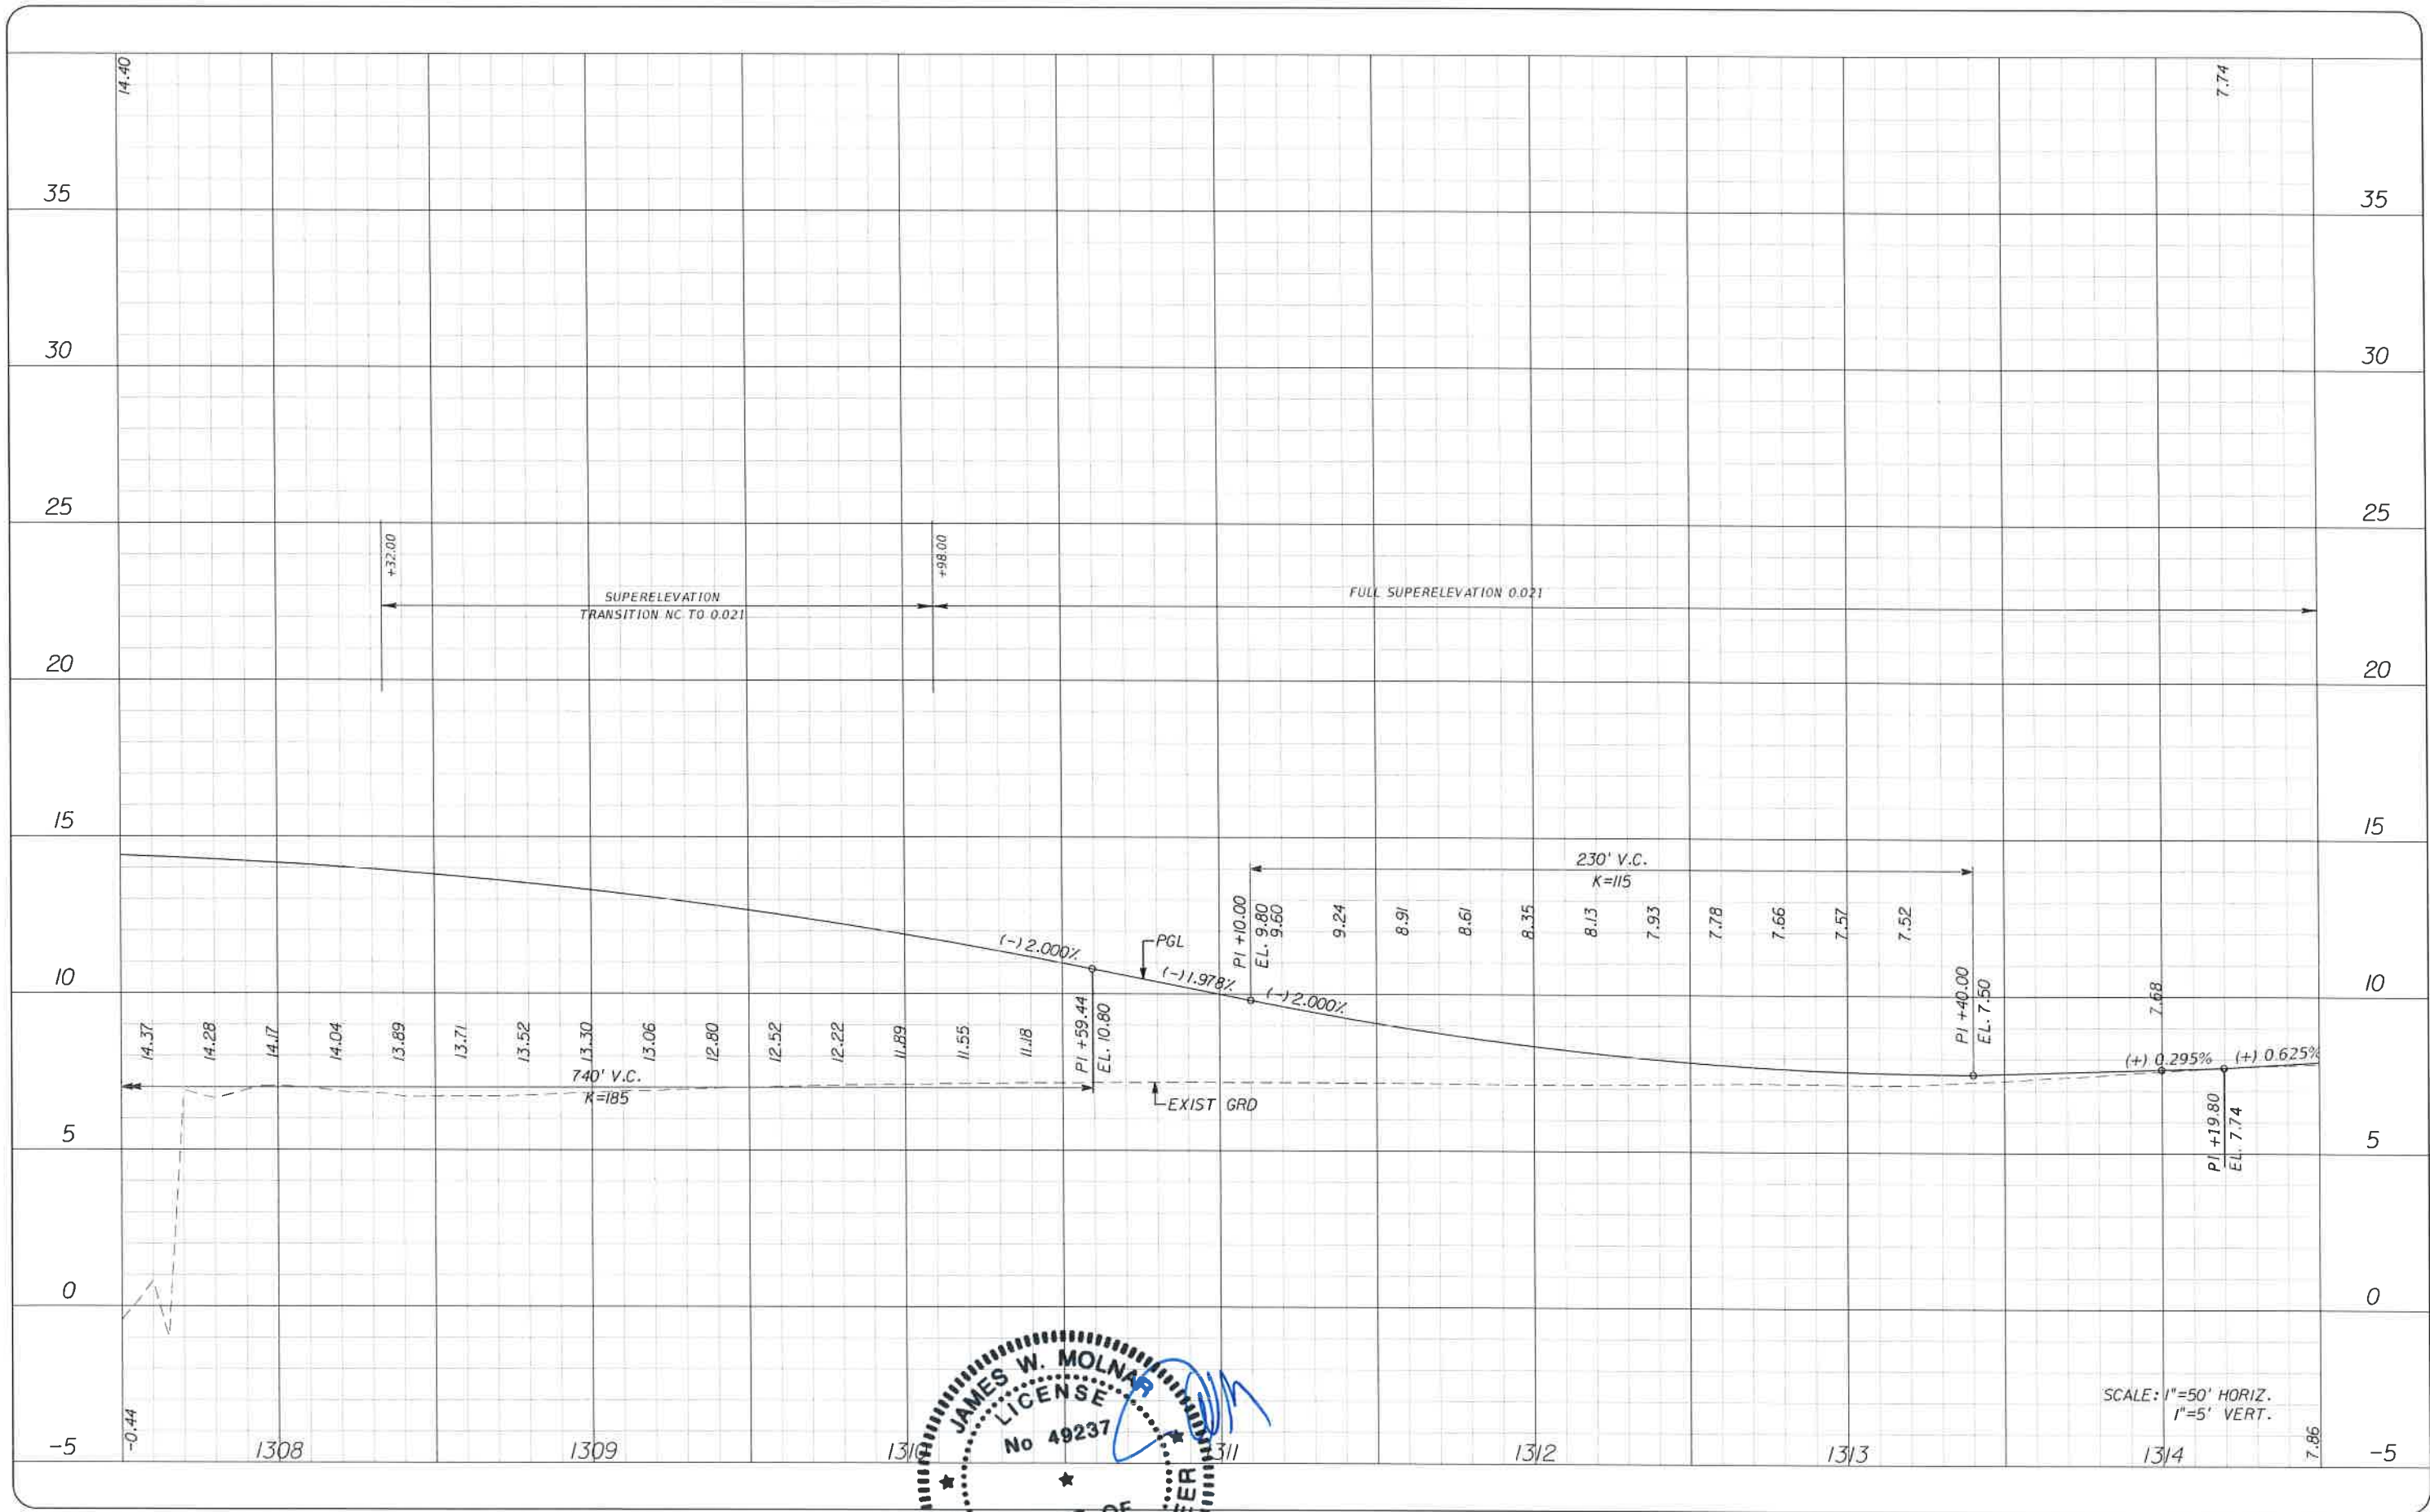

SCALE: 1"=50' HORIZ.
1"=5' VERT.

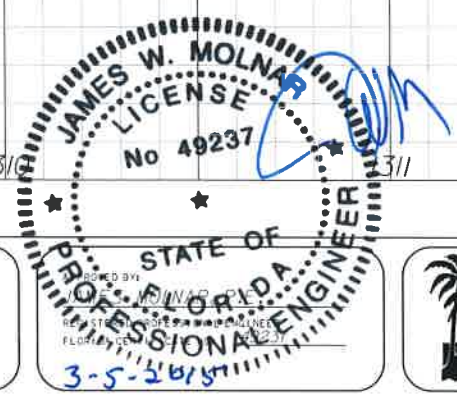

NO.	DATE	BY	REVISIONS - DESCRIPTION


T.Y. LIN INTERNATIONAL
 2400 FIRST STREET
 SUITE 200
 FORT MYERS, FLORIDA 33901
 TEL. (239) 332-4846
 FAX. (239) 332-4798
 WWW.TYLIN.COM

PUBLIC WORKS
LEE COUNTY
SOUTHWEST
FLORIDA
 1500 MONROE STREET
 FORT MYERS, FLORIDA 33901
 (239) 479-8900 www.lee-county.com/publicworks/office.htm

DEPARTMENT
of
TRANSPORTATION
 FORT MYERS, FLORIDA 33901

PROFILE SHEET
STA. 1307+50 TO STA. 1314+50
BURNT STORE ROAD

SHEET NO.
 51

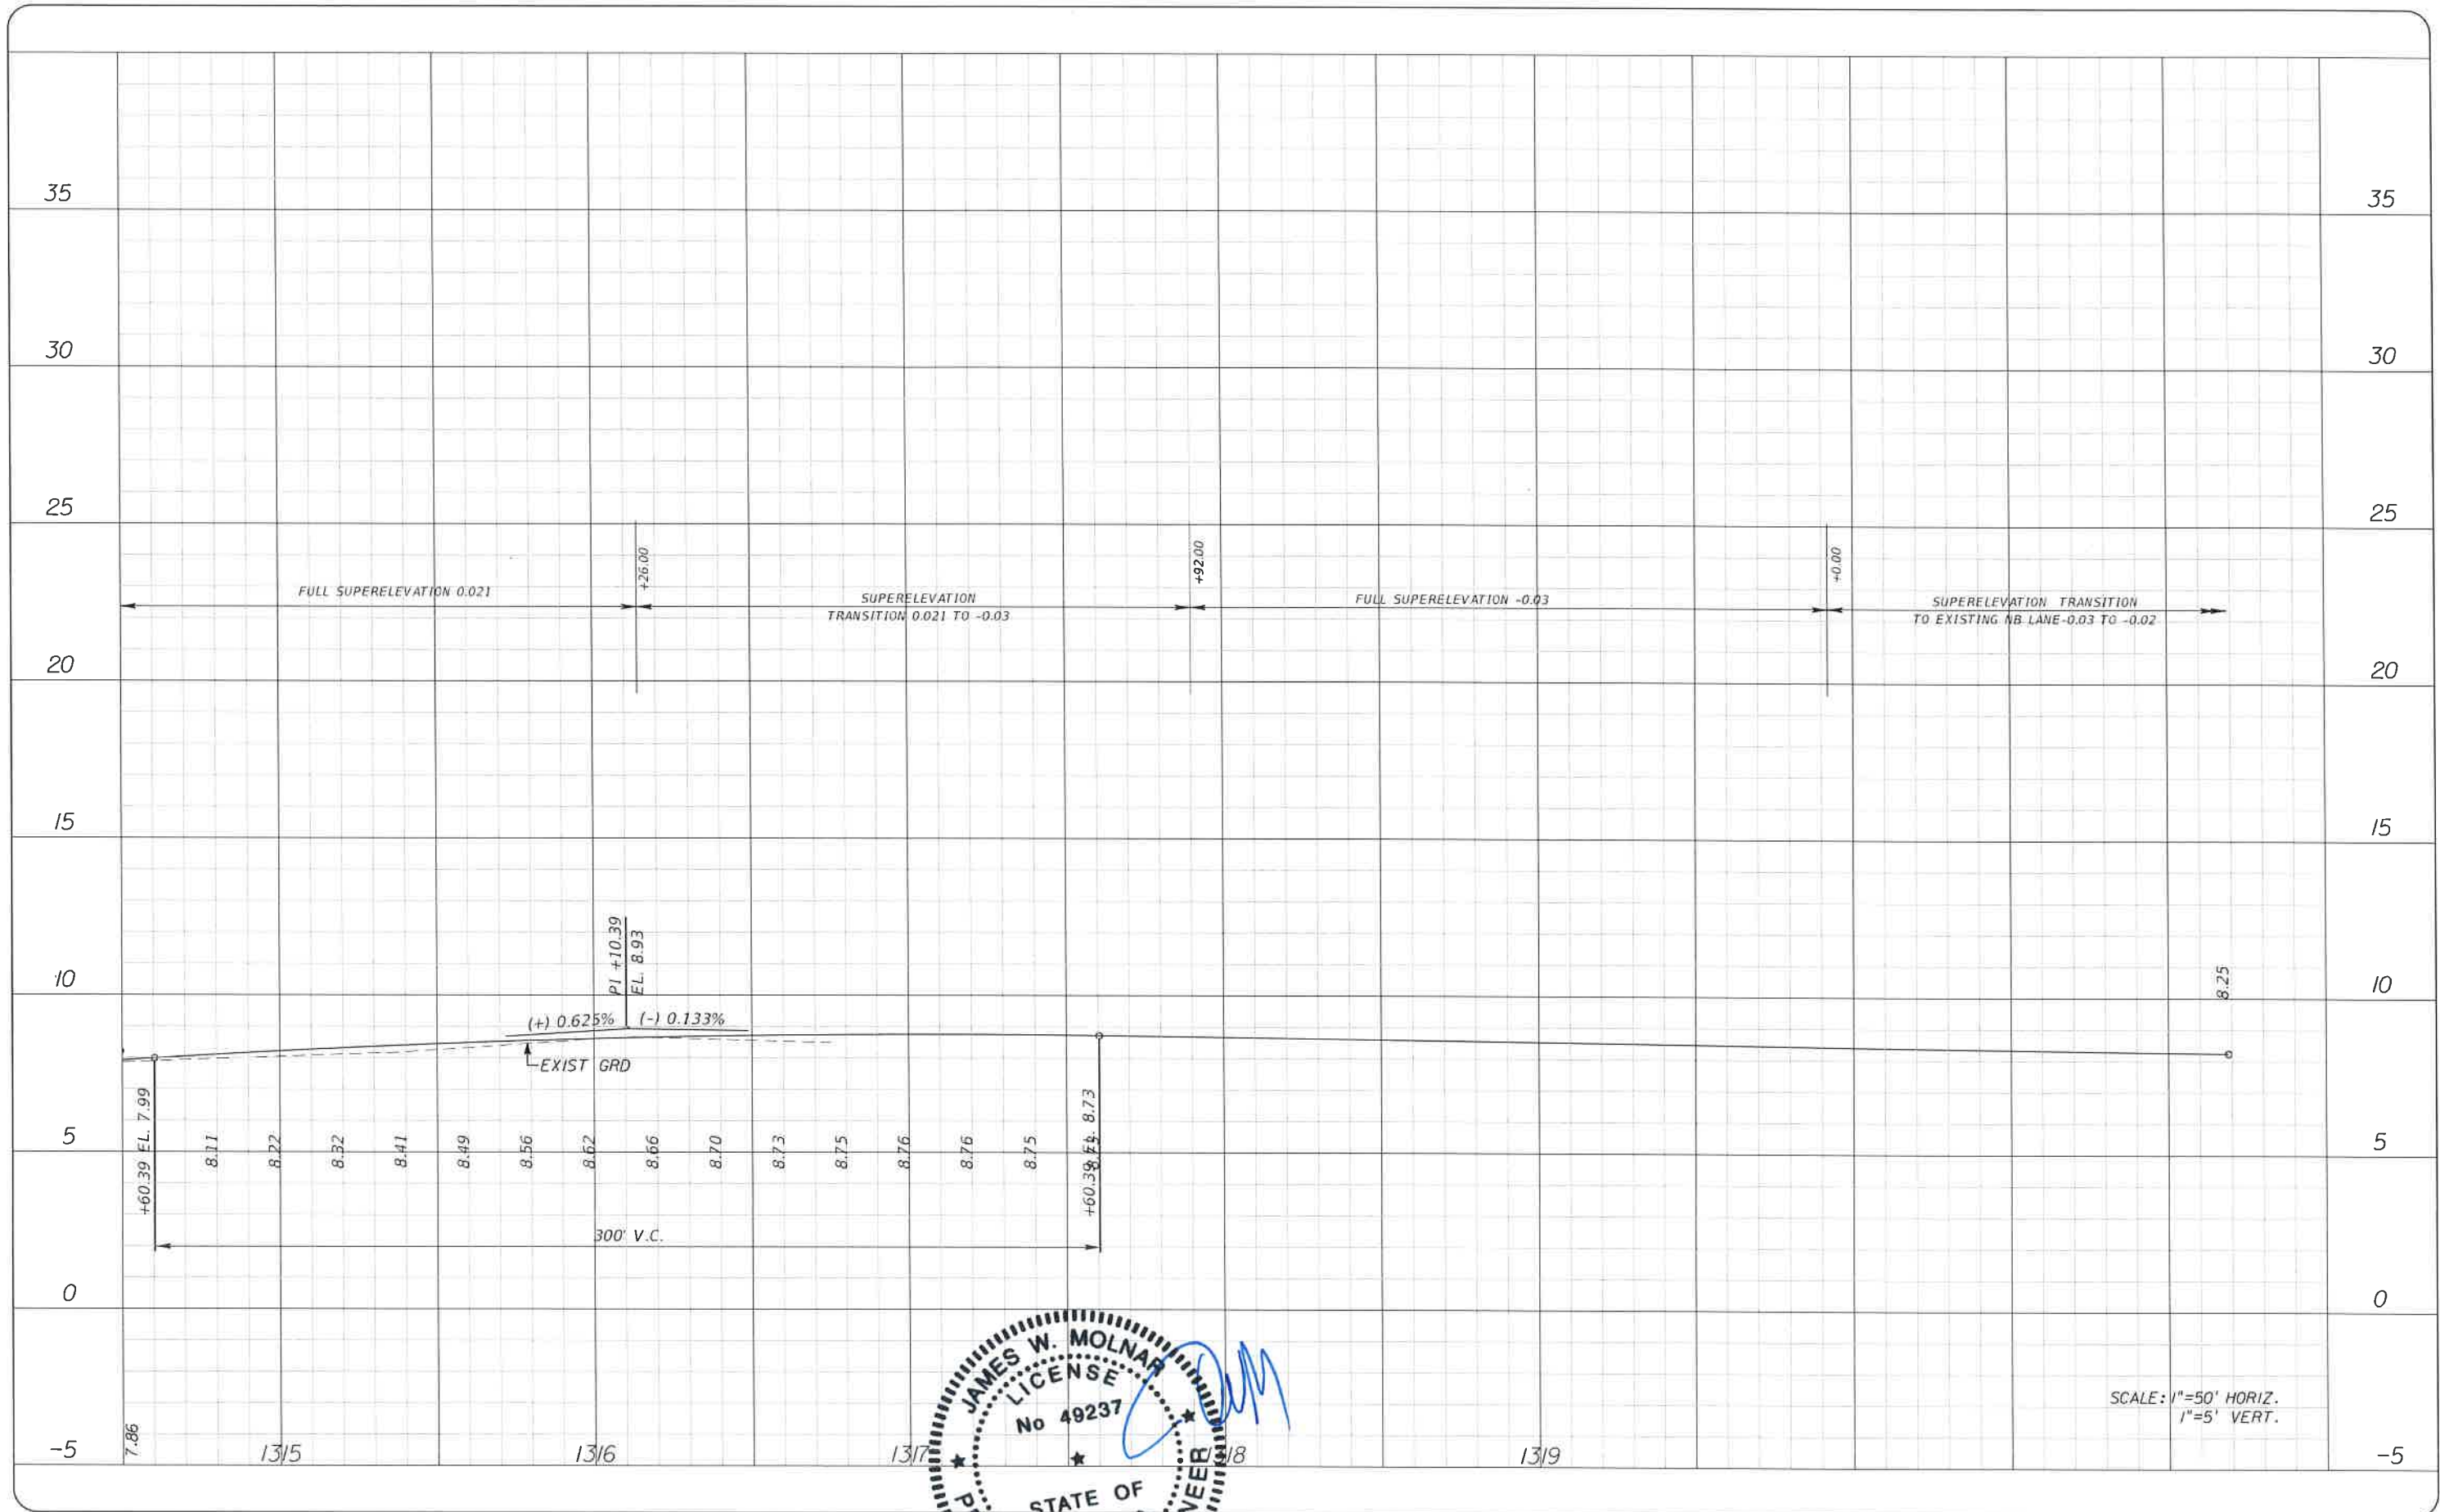

NO.	DATE	BY	REVISIONS - DESCRIPTION



T.Y. LIN INTERNATIONAL
 2400 FIRST STREET
 SUITE 200
 FORT MYERS, FLORIDA 33901
 TEL. (239) 332-4846
 FAX. (239) 332-4798
 WWW.TYLIN.COM

PUBLIC WORKS
LEE COUNTY
SOUTHWEST
FLORIDA
 1500 MONROE STREET
 FORT MYERS, FLORIDA 33901
 (239) 479-8900
 www.lee-county.com/publicworks/soilinfo.htm

DEPARTMENT
of
TRANSPORTATION
 FORT MYERS, FLORIDA 33901

PROFILE SHEET
STA. 1314+50 TO STA. 1319+98
BURNT STORE ROAD

SHEET NO.
 52

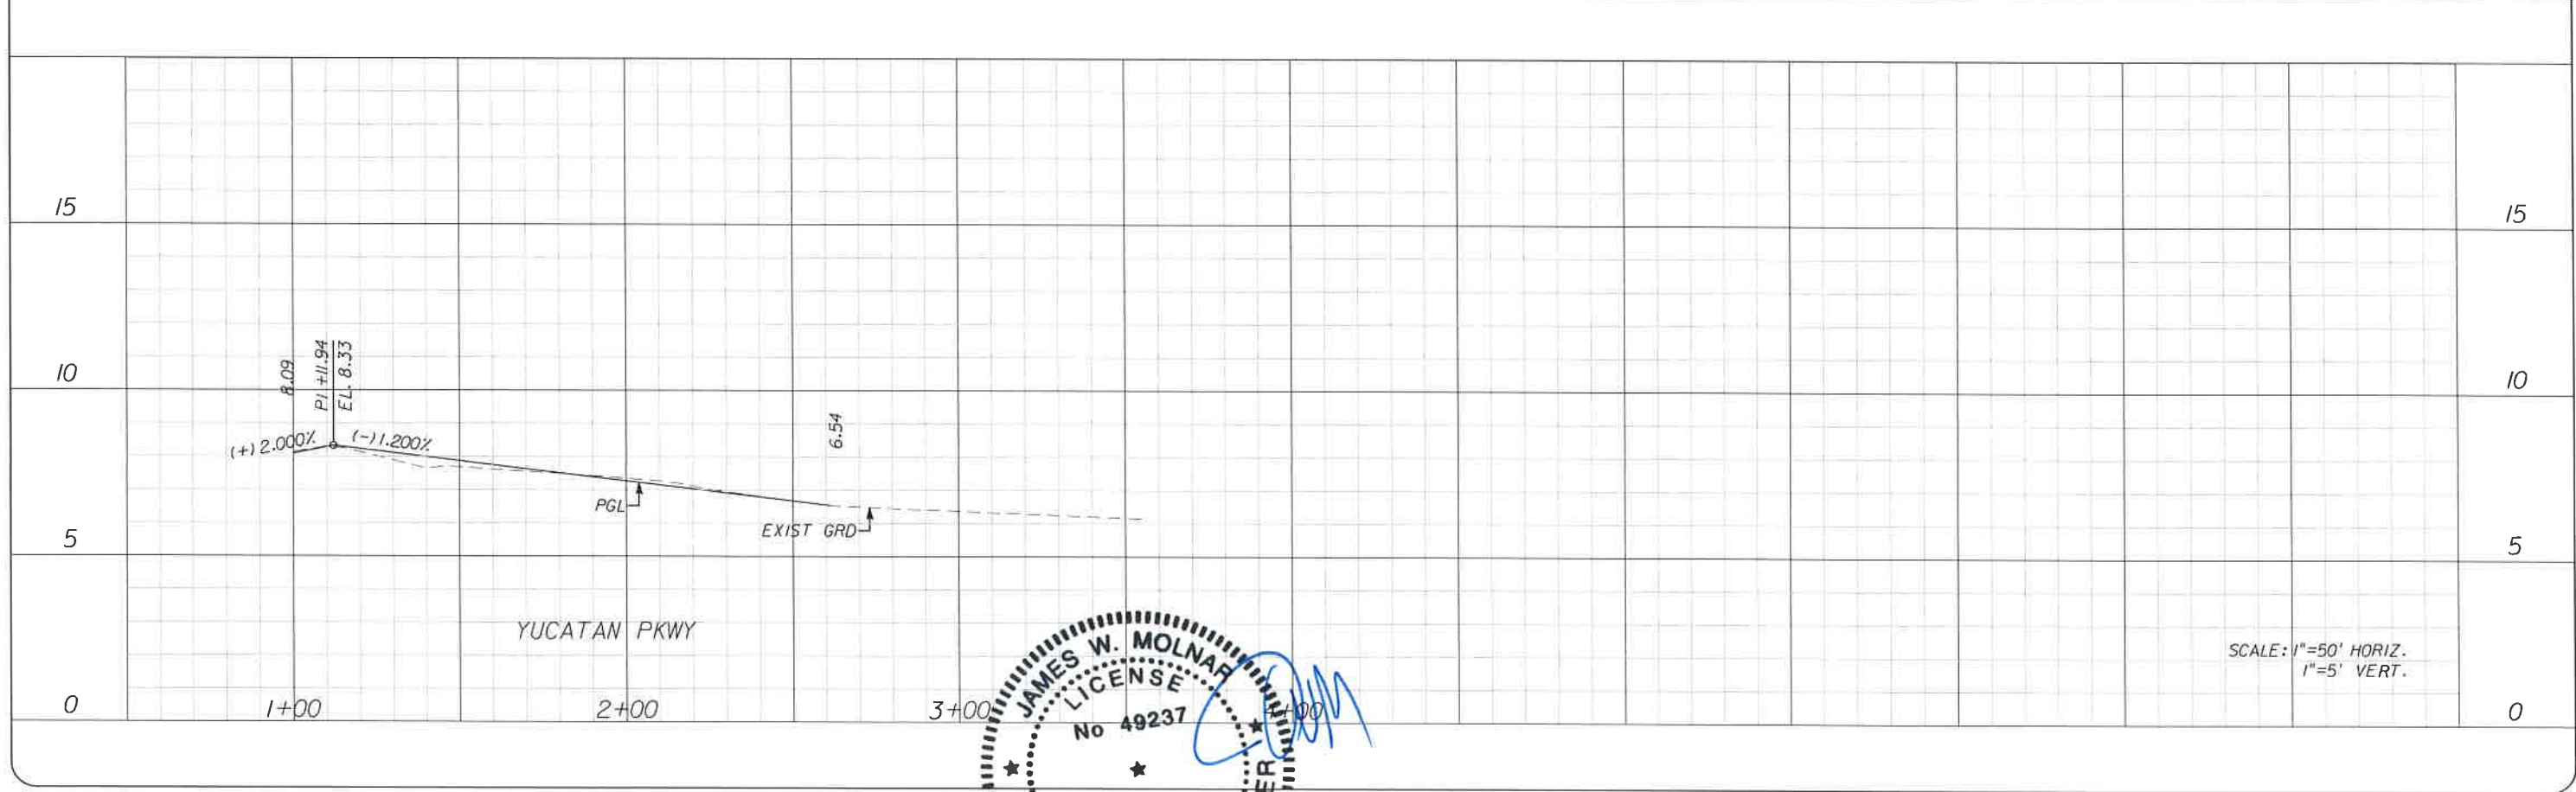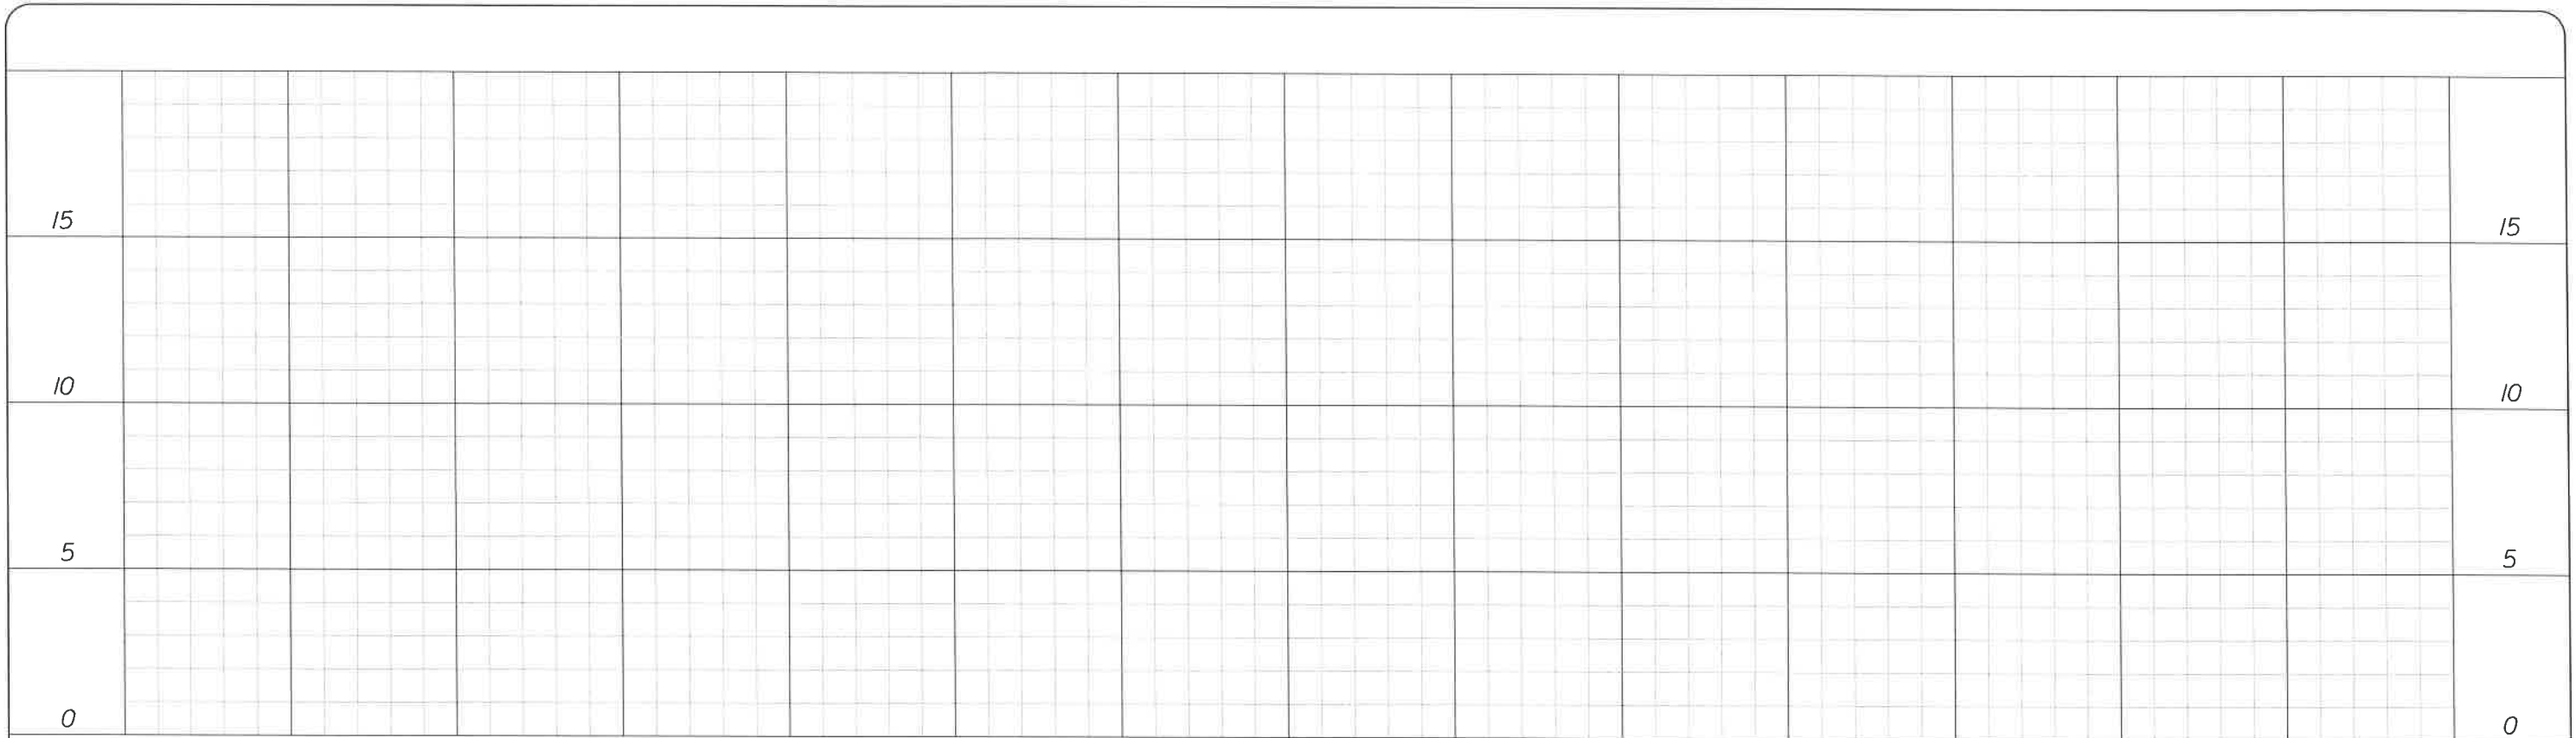

SCALE: 1"=50' HORIZ.
1"=5' VERT.

NO.	DATE	BY	REVISIONS - DESCRIPTION

T.Y. LIN INTERNATIONAL
 2400 FIRST STREET
 SUITE 200
 FORT MYERS, FLORIDA 33901
 TEL. (239) 332-4846
 FAX. (239) 332-4798
 WWW.TYLIN.COM






PUBLIC WORKS
LEE COUNTY
SOUTHWEST
FLORIDA
 1500 MONROE STREET
 (239) 479-8900 www.lee-county.com/publicworks/databases.htm

DEPARTMENT
of
TRANSPORTATION
 FORT MYERS, FLORIDA 33901

PROFILE SHEET
YUCATAN PKWY
BURNT STORE ROAD

SHEET NO.
 53

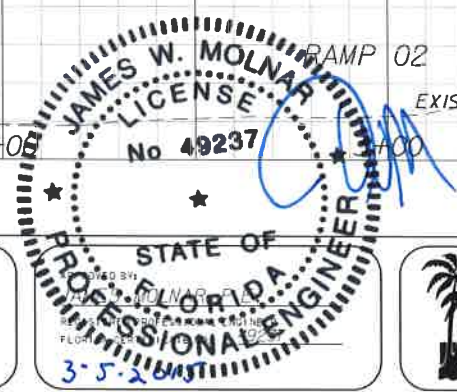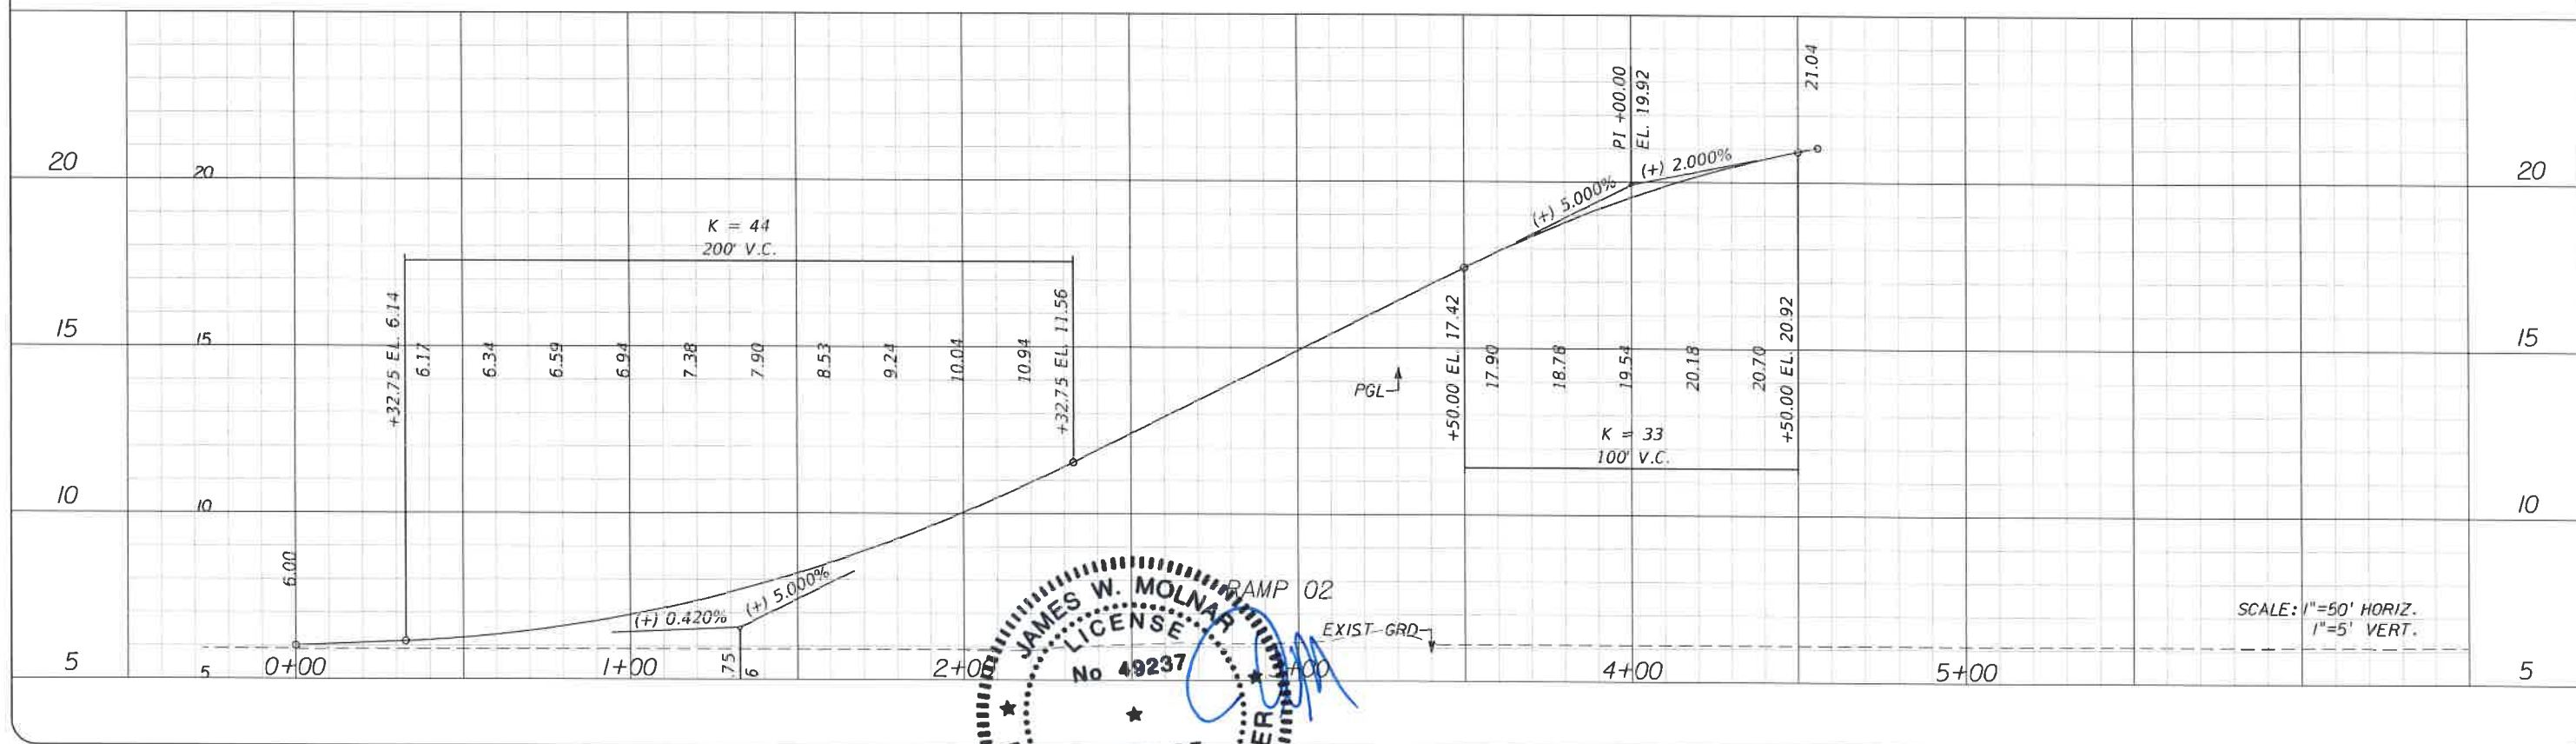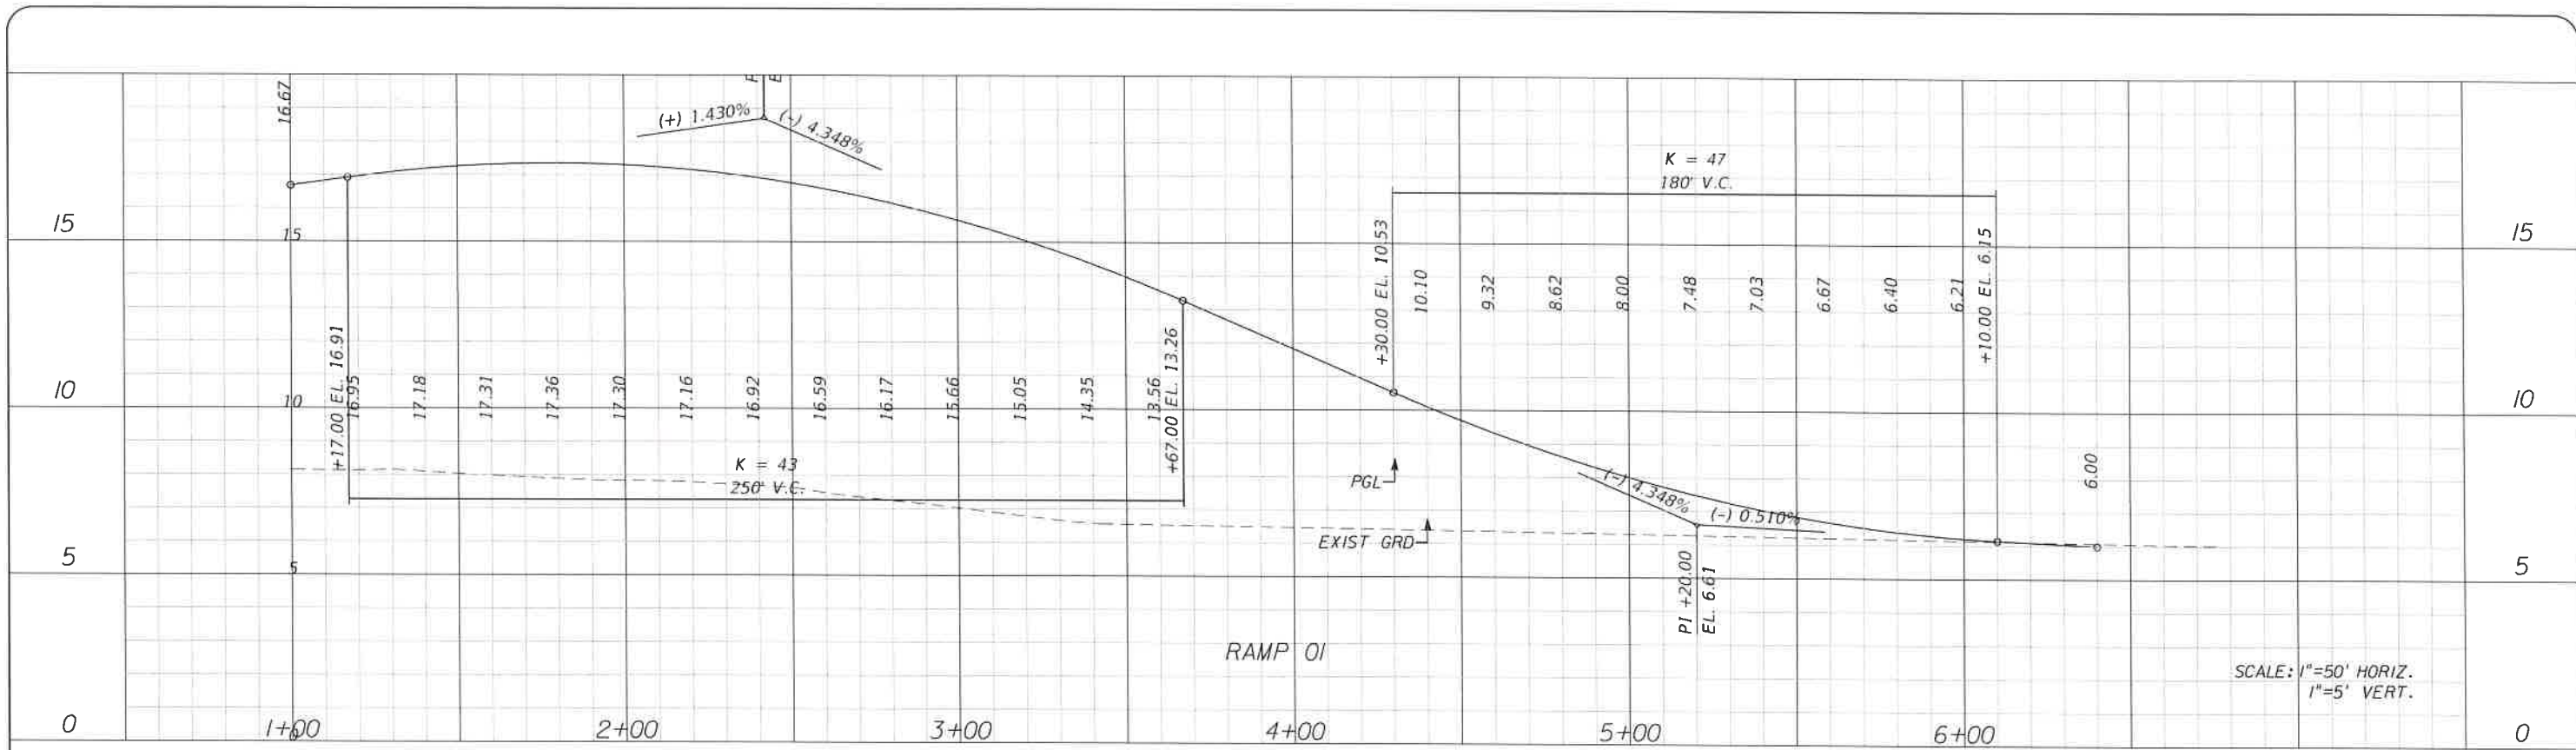


T.Y. LIN INTERNATIONAL
 2400 FIRST STREET
 SUITE 200
 FORT MYERS, FLORIDA 33901
 TEL. (239) 332-4846
 FAX. (239) 332-4798
 WWW.TYLIN.COM

PUBLIC WORKS
LEE COUNTY
SOUTHWEST
FLORIDA
 1500 MANHOE STREET
 FORT MYERS, FLORIDA 33901
 (239) 479-8900 www.lee-county.com/public-works/default.htm


DEPARTMENT
of
TRANSPORTATION
PROFILE SHEET
RAMP 01 & RAMP 02
BURNT STORE ROAD

NO.	DATE	BY	REVISIONS - DESCRIPTION

SHEET NO.
 54
 Default

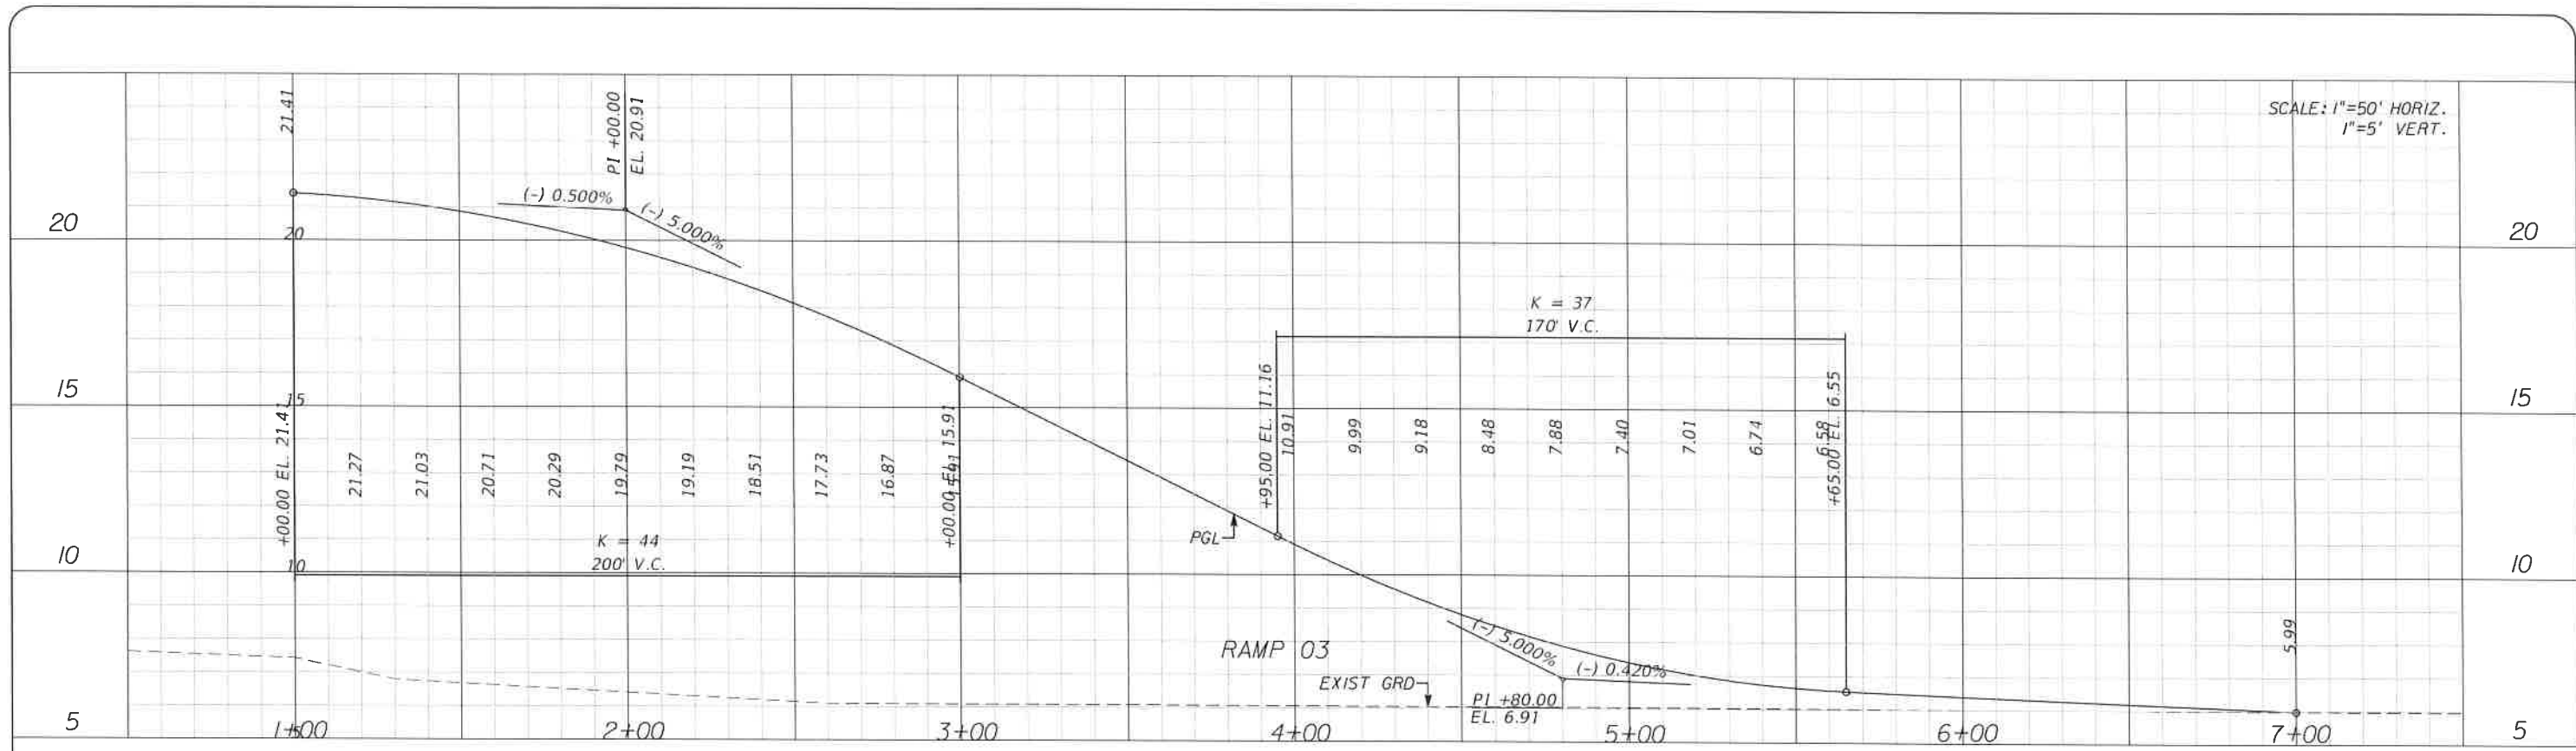

SCALE: 1"=50' HORIZ.
1"=5' VERT.

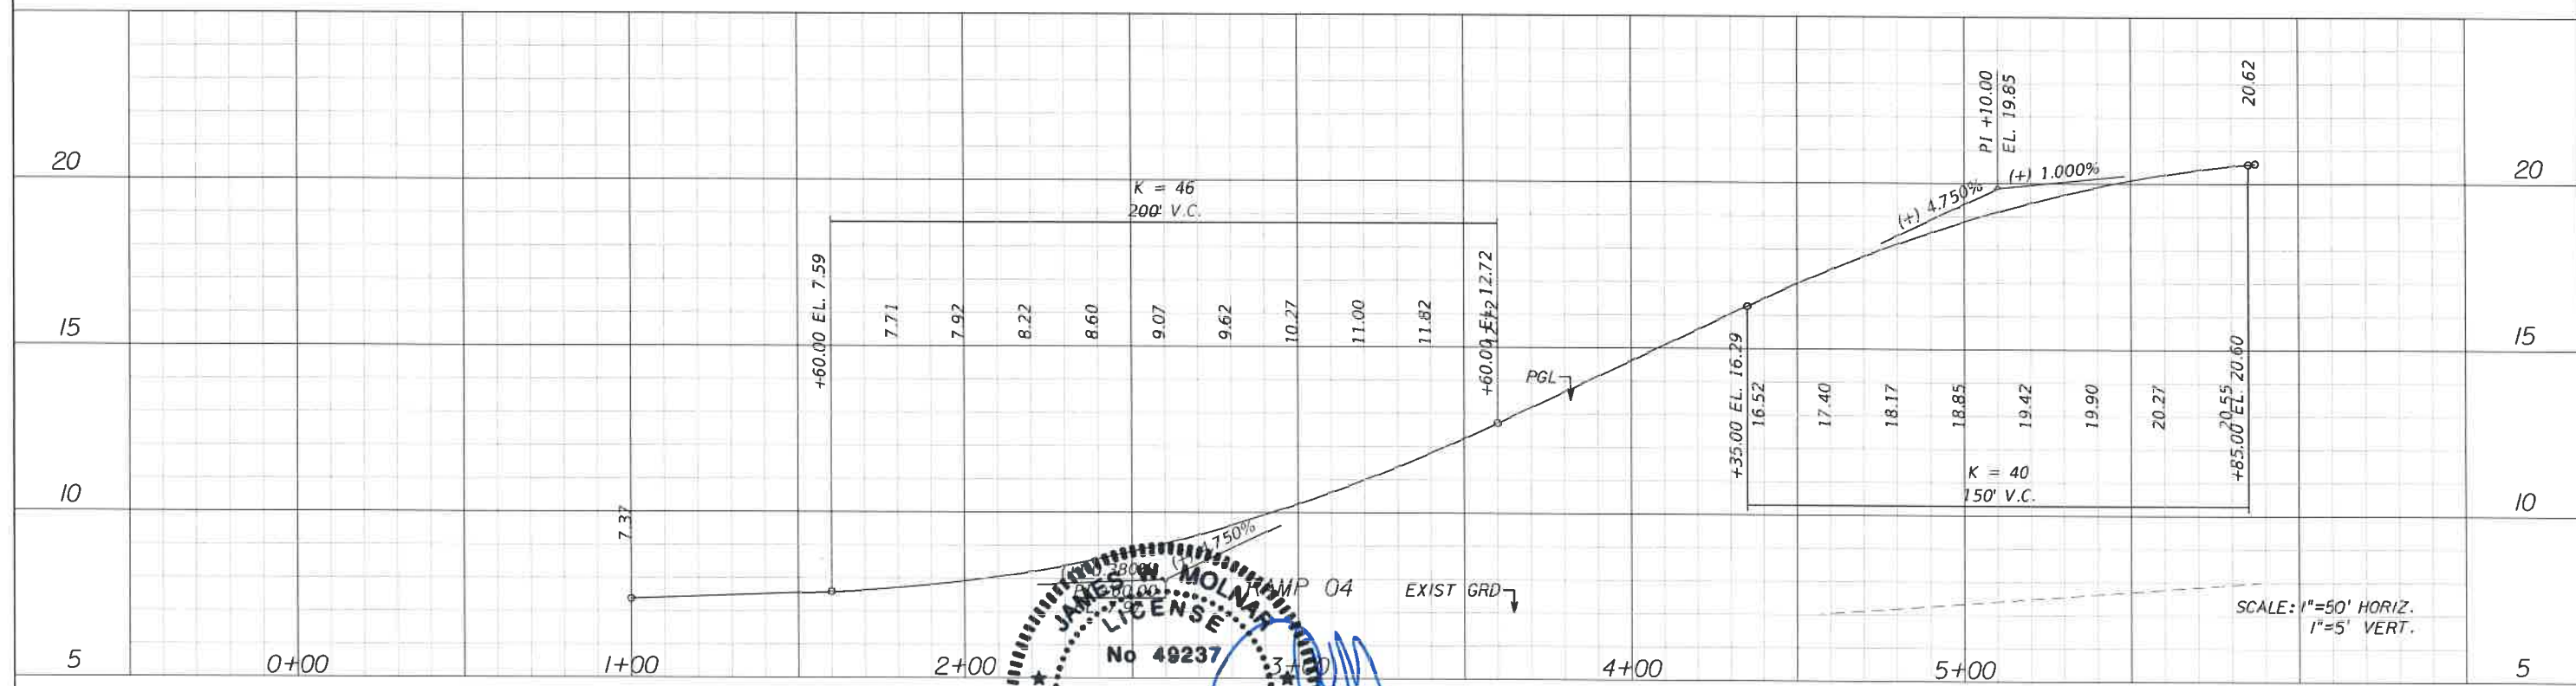

SCALE: 1"=50' HORIZ.
1"=5' VERT.



NO.	DATE	BY	REVISIONS - DESCRIPTION



T.Y. LIN INTERNATIONAL
2400 FIRST STREET
SUITE 200
FORT MYERS, FLORIDA 33901
TEL. (239) 332-4846
FAX. (239) 332-4798
WWW.TYLIN.COM

APPROVED
JAMES W. MOLNAR
REGISTERED PROFESSIONAL ENGINEER
FLORIDA CERTIFICATE NO. 49237
3-5-2015

PUBLIC WORKS
LEE COUNTY
SOUTHWEST
FLORIDA
1500 MONROE STREET
FORT MYERS, FLORIDA 33901
12391 479-8900
www.lee-county.com/public-works/office.htm
rshields 3/4/2015 9:07:23 PM

PROFILE SHEET
RAMP 03 & RAMP 04
BURNT STORE ROAD

SHEET NO.
55
Default

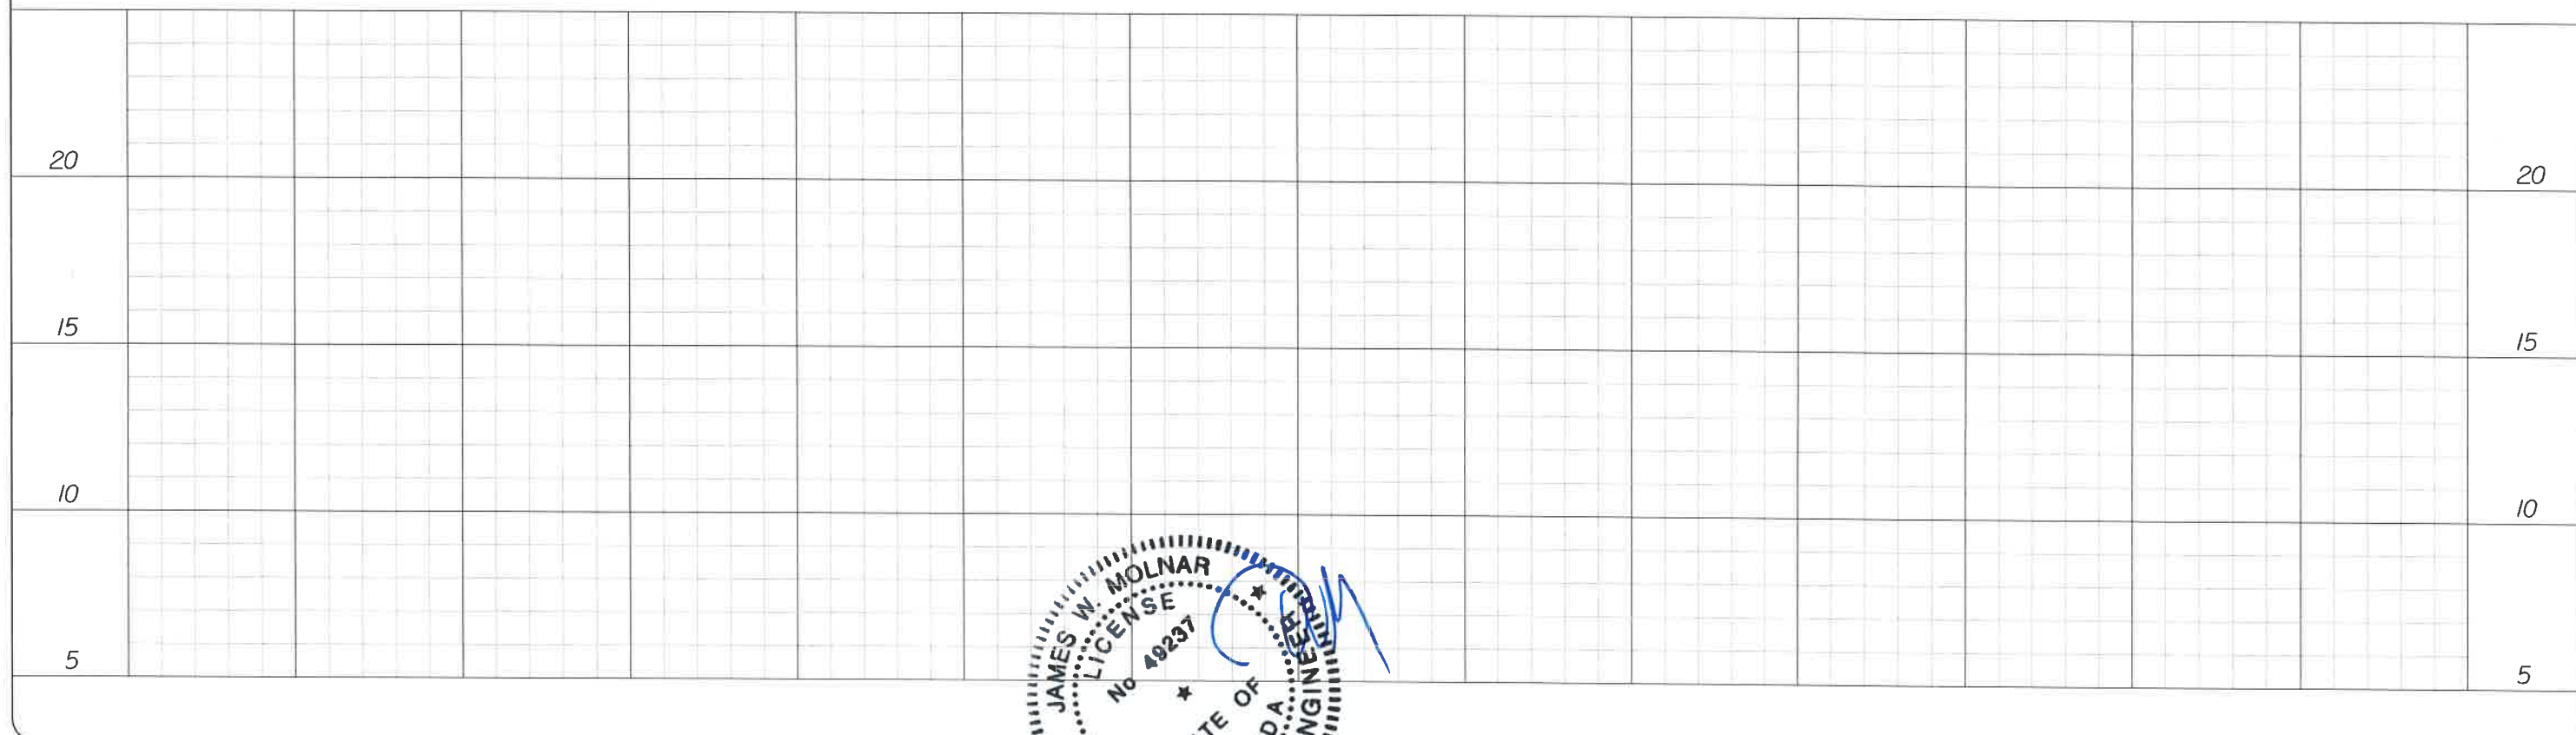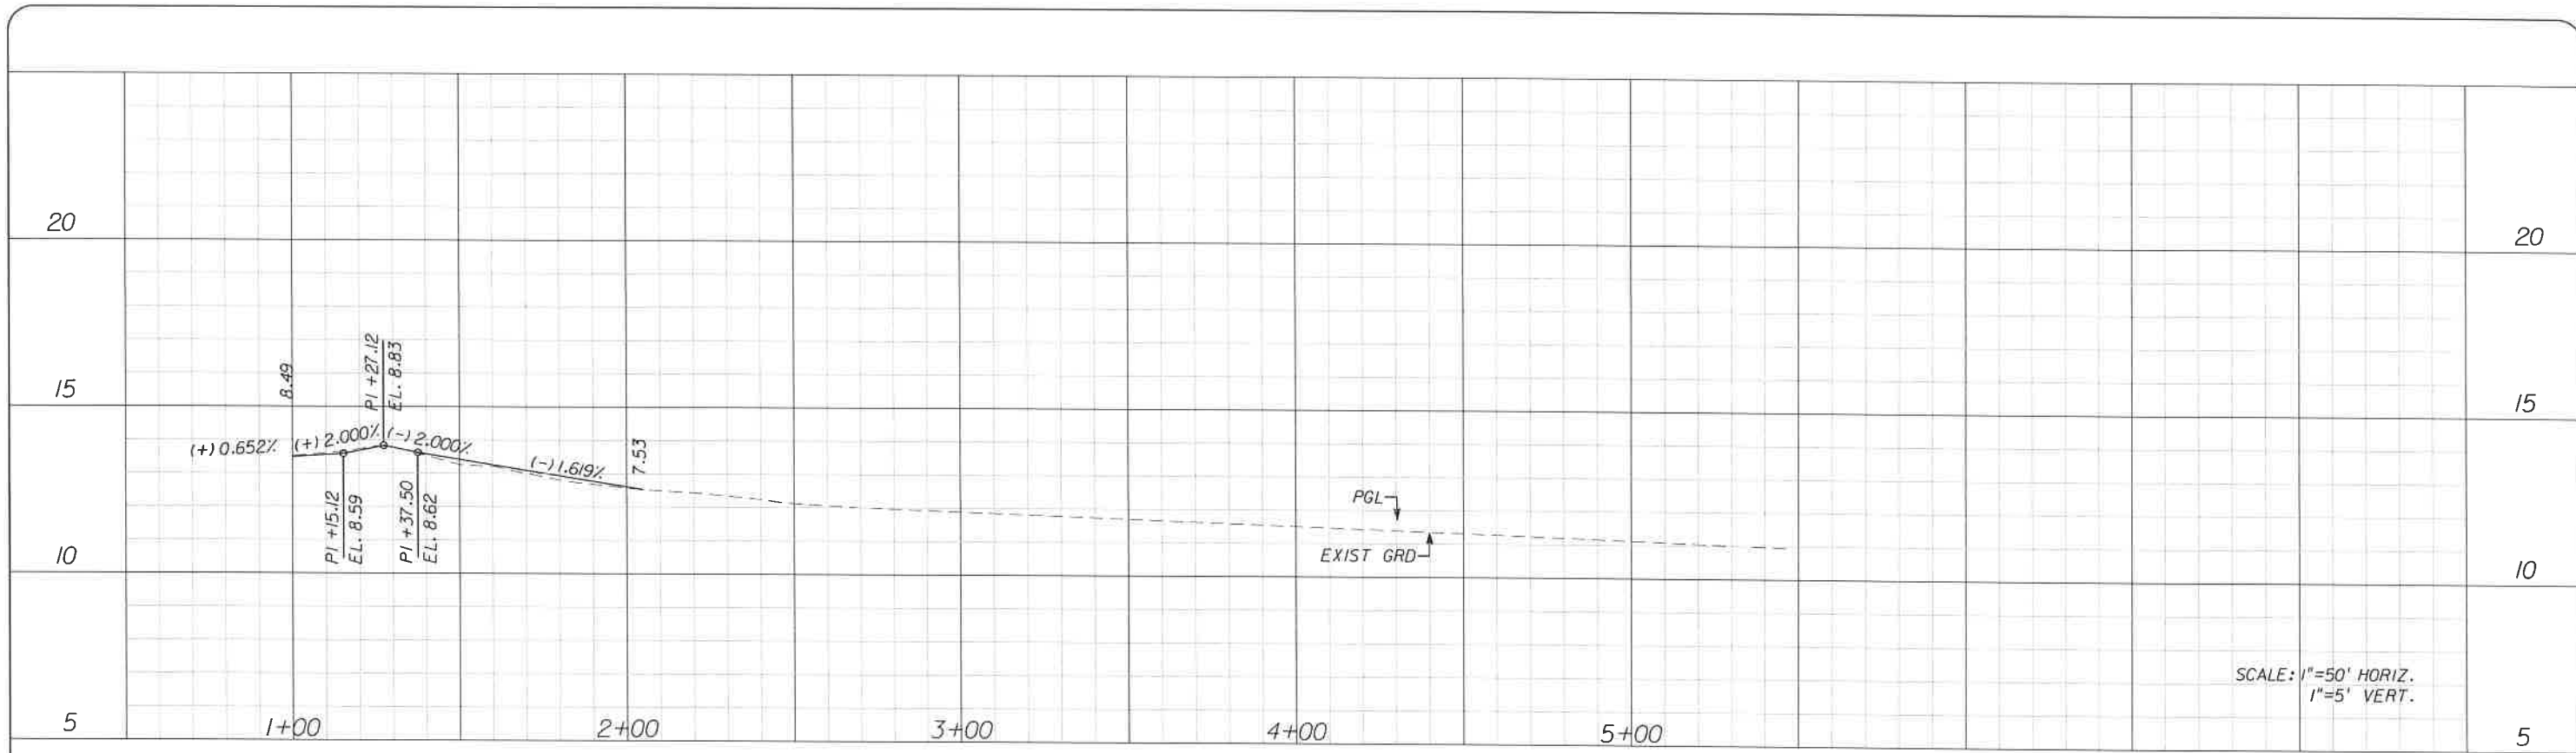

NO.	DATE	BY	REVISIONS - DESCRIPTION

T.Y. LIN INTERNATIONAL
 2400 FIRST STREET
 SUITE 200
 FORT MYERS, FLORIDA 33901
 TEL. (239) 332-4846
 FAX. (239) 332-4798
 WWW.TYLIN.COM

APPROVED BY
JAMES W. MOLNAR
 REGISTERED PROFESSIONAL ENGINEER
 FLORIDA CERTIFICATE
3-5-2015


PUBLIC WORKS
 LEE COUNTY
 SOUTHWEST
 FLORIDA
 1500 MONROE STREET
 FORT MYERS, FLORIDA 33901
 12391 479-8900 www.lee-county.com/publicworks/default.htm

DEPARTMENT
 of
 TRANSPORTATION

PROFILE SHEET
GULFSTREAM PKWY
BURNT STORE ROAD

SHEET
 NO.
56
 Default

STR. ID	STA	OFFSET	SIDE	TYPE	TOP/ INLET ELEVATIO N	PIPE SIZE & DIRECTION	INV. ELEV.	PIPE SIZE & DIRECTION	INV. ELEV.	PIPE SIZE & DIRECTION	INV. ELEV.	PIPE SIZE & DIRECTION	INV. ELEV.	REMARKS
S- 301	1227+35.45	99.81'	LT	18" SD MES		18" NORTH	4.00							
S- 302	1227+93.82	90.83'	LT	18" SD MES		18" SOUTH	4.00							
S- 303	1233+73.44	96.35'	LT	24" SD MES		24" NORTH	4.00							
S- 304	1234+67.89	101.51'	LT	24" SD MES		24" SOUTH	4.00							
S- 305	1237+69.11	101.35'	LT	24" SD MES		19"x30" NORTH	4.00							
S- 306	1237+68.23	107.38'	RT	19"x30" SD MES		24" NORTH	4.00							
S- 307	1238+20.11	94.71'	LT	24" SD MES		19"x30" SOUTH	4.00							
S- 308	1238+20.93	104.98'	RT	19"x30" SD MES		24" SOUTH	4.00							
S- 309	1238+70.01	114.72'	RT	24" CD MES		24" EAST	4.00							
S- 310	1238+70.08	144.46'	RT	24" CD MES		24" WEST	4.00							
S- 311	1238+93.13	94.56'	LT	INLET, TYPE D, MODIFY	6.20	24" EAST	1.00	17" WIDE x 16.8" HIGH SLOTS N & S	4.8					CS-7 WITH SKIMMERS NORTH & SOUTH (INDEX 240), H = 18"
S- 312	1239+36.96	161.35'	RT	INLET, TYPE E, MODIFY	6.10	24" WEST	0.50	36" NORTH	0	20" WIDE x 15.6" HIGH SLOTS N & S	4.8			CS-6 WITH SKIMMERS NORTH & SOUTH (INDEX 240), H = 16"
S- 313	1239+71.32	161.35'	RT	36" ENDWALL		36" SOUTH	0.00							
S- 314	1240+93.81	83.00'	RT	INLET, TYPE 5	9.16	24" EAST	4.46	24" NORTH	4.46					
S- 315	1240+93.06	104.55'	RT	24" CD MES		24" WEST	4.00							
S- 316	1242+49.45	102.61'	LT	18" SD MES		18" NORTH	4.00							
S- 317	1243+00.78	102.61'	LT	18" SD MES		18" SOUTH	4.00							
S- 318	1244+54.45	76.13'	RT	INLET, TYPE S	17.11	24" SOUTH	13.61	24" NORTH	13.61					
S- 319	1247+06.17	76.13'	RT	INLET, TYPE S	20.37	18" SOUTH	17.47							
S- 320	1252+00.94	76.13'	RT	INLET, TYPE S	19.30	24" NORTH	15.80							
S- 321	1254+98.18	76.40'	RT	INLET, TYPE S	13.44	24" SOUTH	9.94	24" NORTH	9.94					
S- 322	1256+03.28	112.93'	RT	24" SD MES		24" SOUTH	5.00							
S- 323	1258+20.09	113.90'	RT	24" SD MES		24" NORTH	5.00							
S- 324	1261+24.60	104.40'	RT	INLET, TYPE 6	8.26	24" SOUTH	3.56	24" NORTH	3.56					
S- 325	1262+07.11	101.41'	RT	INLET, TYPE 6	8.26	24" SOUTH	3.56	24" NORTH	3.56					
S- 326	1262+68.84	99.67'	LT	24" SD MES		24" NORTH	4.20							
S- 326A	1263+38.96	94.51'	LT	INLET, TYPE B	7.40	24" SOUTH	4.00	24" NORTH	4.00					
S- 327	1263+29.82	108.30'	RT	24" SD MES		24" SOUTH	4.20							
S- 328	1264+20.24	87.91'	LT	24" SD MES		24" SOUTH	4.20							
S- 329	1270+65.65	91.02'	LT	24" SD MES		24" NORTH								
S- 330	1271+14.22	98.62'	LT	24" SD MES		24" SOUTH								
S- 331	1278+79.96	99.54'	LT	INLET, TYPE D, MODIFY	6.20	24" EAST	1.00	16" WIDE x 15" HIGH SLOTS N & S	4.95					CS-9 WITH SKIMMERS NORTH & SOUTH (INDEX 240), H = 16"

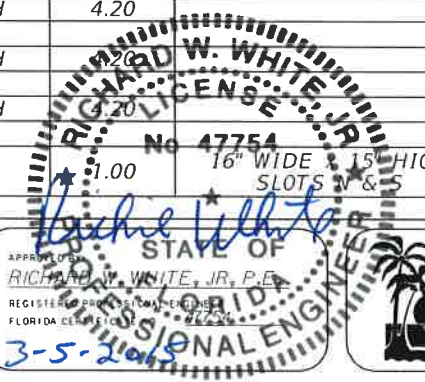

NO.	DATE	BY	REVISIONS - DESCRIPTION

T.Y. LIN INTERNATIONAL
2400 FIRST STREET
SUITE 200
FORT MYERS, FLORIDA 33901
TEL. (239) 332-4846
FAX. (239) 332-4798
WWW.TYLIN.COM

APPROVED
RICHARD W. WHITE, JR., P.E.
REGISTERED PROFESSIONAL ENGINEER
FLORIDA LICENSE NO. 47754
3-5-2015

PUBLIC WORKS
LEE COUNTY
SOUTHWEST
FLORIDA
1500 MONROE STREET
FORT MYERS, FLORIDA 33901
12391 479 8900 www.lee-county.com/publicworks/detail.htm
Dwerner 3/5/2015 11:00:58 AM


**DRAINAGE STRUCTURES
DATA SHEET
BURNT STORE ROAD**

SHEET NO.
57

STR. ID	STA	OFFSET	SIDE	TYPE	TOP/ INLET ELEVATION	PIPE SIZE & DIRECTION	INV. ELEV.	PIPE SIZE & DIRECTION	INV. ELEV.	PIPE SIZE & DIRECTION	INV. ELEV.	PIPE SIZE & DIRECTION	INV. ELEV.	REMARKS
S- 332	1278+80.00	103.98'	RT	INLET, TYPE D, MODIFY	6.50	24" WEST	0.00	36" EAST	0	15" WIDE x 16.8" HIGH SLOTS N & S	5.2			CS-8 WITH SKIMMERS NORTH & SOUTH (INDEX 240), H = 18"
S- 333	1278+80.04	161.01'	RT	36" ENDWALL		36" WEST	0.00							
S- 334	1280+60.41	108.32'	RT	24" SD MES		24" NORTH	4.20							
S- 335	1280+72.58	100.57'	LT	24" SD MES		24" NORTH	4.20							
S- 336	1281+40.52	108.48'	RT	24" SD MES		24" SOUTH	4.20							
S- 337	1281+41.24	98.79'	LT	24" SD MES		24" SOUTH	4.20							
S- 338	1282+48.39	110.72'	RT	24" SD MES		24" NORTH	4.20							
S- 339	1283+70.78	76.12'	RT	INLET, TYPE S	14.81	24" SOUTH	11.31	24" NORTH	11.31					
S- 340	1286+70.00	87.12'	RT	INLET, TYPE S	19.77	24" SOUTH	16.27							
S- 341	1293+11.40	31.05'	RT	INLET, TYPE P-5	19.78	24" NORTH	15.08							
S- 342	1295+03.36	85.46'	LT	18" SD MES		18" NORTH	4.30							
S- 343	1295+03.43	107.43'	RT	MANHOLE, TYPE P-7	10.00	24" SOUTH	4.59	24" NORTH	4.59					
S- 344	1295+17.76	42.03'	RT	INLET, TYPE P-5	15.60	24" SOUTH	10.90	24" NORTH	10.90					
S- 345	1295+49.31	80.30'	LT	18" SD MES		18" SOUTH	4.30							
S- 346	1296+93.20	104.63'	RT	24" SD MES		24" SOUTH	4.30							
S- 347	1297+62.69	35.19'	RT	INLET, TYPE P-5	9.96	24" SOUTH	5.26	24" NORTH	5.26					
S- 348	1298+86.28	36.29'	RT	INLET, TYPE P-5	8.25	24" SOUTH	3.95	24" EAST	3.95					
S- 349	1298+86.64	90.25'	RT	24" CD MES		24" WEST	4.30							
S- 350	1299+01.68	62.53'	LT	MANHOLE, TYPE J-7, 8'-0" x 4'-0"	8.16	6"x4" CBC WEST	2.93	48" EAST	-1.00					Est. Top Elevation
S- 351	1299+00.94	37.83'	LT	INLET, TYPE D, J BOTTOM, 6'-9" x 4'-0"	6.50	42" EAST	-0.50	48" WEST	-1.00	24" WIDE x 14.4" HIGH SLOTS N & S	5.3	3.0" DIAMETER ORIFICE NORTH	3.3	CS-11 WITH SKIMMERS NORTH & SOUTH (INDEX 240), H = 40"
S- 352	1298+97.11	102.81'	RT	INLET, TYPE D, J BOTTOM, 6'-0" x 4'-0"	6.50	36" EAST	0.00	42" WEST	-0.50	16" WIDE x 12" HIGH SLOTS N & S	5.5	3.0" DIAMETER ORIFICE NORTH	3.3	CS-110 WITH SKIMMERS NORTH & SOUTH (INDEX 240), H = 40"
S- 353	1298+96.56	124.50'	RT	MANHOLE, TYPE J-7, MODIFY, 10'-0" x 4'-0"	7.00	36" WEST	0.00	(2) 54" WIDE x 12" HIGH SLOTS EAST	3.30					
S- 354	1300+60.18	33.48'	LT	18" SD MES		18" NORTH	4.30							
S- 355	1301+16.35	29.63'	LT	18" SD MES		18" SOUTH	4.30							
S- 356	1302+53.28	86.24'	RT	18" SD MES		18" NORTH	4.30							
S- 357	1305+12.36	68.32'	RT	INLET, TYPE S	12.06	18" SOUTH	9.16							
S- 358	1308+66.13	68.49'	RT	INLET, TYPE S	12.07	18" WEST	9.17							
S- 359	1308+53.14	6.34'	LT	INLET, TYPE D, J BOTTOM, 12'-6" x 4'-0"	6.10	(2) 48" SOUTH	-1.30	48" NORTH	-1.30	18" EAST	2.50			CS-12
S- 360	1311+50.49	0.19'	LT	MANHOLE, TYPE 7, J BOTTOM, 12'-6" x 4'-0"	6.30	(2) 48" SOUTH	-1.30	(2) 48" NORTH	-1.30					
S- 361	1313+09.15	4.06'	RT	MANHOLE, TYPE 7, 8'-0" DIAMETER	6.40	48" SOUTH	-1.30	48" EAST	-1.30					

NO.	DATE	BY	REVISIONS - DESCRIPTION

T.Y. LIN INTERNATIONAL
2400 FIRST STREET
SUITE 200
FORT MYERS, FLORIDA 33901
TEL. (239) 332-4846
FAX. (239) 332-4798
WWW.TYLIN.COM

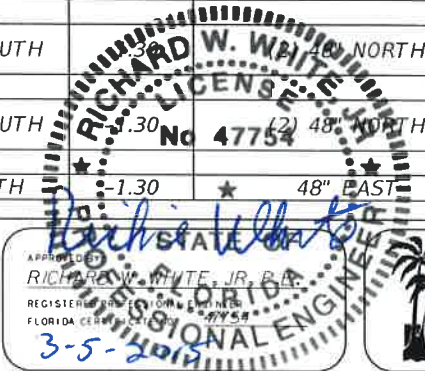

PUBLIC WORKS
LEE COUNTY
SOUTHWEST
FLORIDA
1500 MONROE STREET
FORT MYERS, FLORIDA 33901
(239) 479-8900
www.lee-county.com/pdw/works/delink.htm
Dwerner 3/5/2015 11:00:58 AM

**DRAINAGE STRUCTURES
DATA SHEET
BURNT STORE ROAD**

SHEET NO.
58

STR. ID	STA	OFFSET	SIDE	TYPE	TOP/ INLET ELEVATIO N	PIPE SIZE & DIRECTION	INV. ELEV.	PIPE SIZE & DIRECTION	INV. ELEV.	PIPE SIZE & DIRECTION	INV. ELEV.	PIPE SIZE & DIRECTION	INV. ELEV.	REMARKS
S- 362	1313+24.13	1.50'	LT	MANHOLE, TYPE 7, 8'-0" DIAMETER	6.40	48" SOUTH	-1.30	48" EAST	-1.30					
S- 363	1313+59.40	91.30'	RT	INLET, TYPE H	4.00	48" WEST	-1.30							
S- 364	1313+82.02	91.73'	RT	INLET, TYPE H	4.00	48" WEST	-1.30							
S- 365	1244+78.76	247.62'	RT	30" ENDWALL		30" NORTH	0.22							
S- 366	1246+38.42	181.14'	RT	INLET, TYPE B	4.50	30" SOUTHEAST	0.50	24" NORTHEAST	1.08					Single Slot, Assumed top elev.
S- 367	1245+99.32	242.18'	RT	INLET, TYPE C	14.00	30" SOUTH	0.40	30" NORTHWEST	0.40					Assumed top elev.
S- 368	1246+44.18	359.78'	RT	INLET, TYPE C	4.50	18" NORTH	1.90							Assumed top elev.
S- 369	1247+23.88	355.50'	RT	INLET, TYPE C	4.50	18" SOUTH	1.78	18" WEST	1.78					Assumed top elev.
S- 370	1247+15.91	236.80'	RT	INLET, TYPE C	4.50	18" EAST	1.61	18" WEST	1.61					Assumed top elev.
S- 371	1247+14.58	211.84'	RT	INLET, TYPE C	4.50	18" EAST	1.20	24" SOUTHWEST	1.20					Assumed top elev.
S- 372	1291+09.82	110.50'	RT	INLET, TYPE S	20.40	24" NORTHEAST	16.90							
S- 373	1291+82.55	160.46'	RT	INLET, TYPE B	16.70	24" SOUTHWEST	12.50	24" SOUTHEAST	12.50	24" NORTHEAST	12.50			Est. Grate Elevation
S- 374	1291+35.23	221.48'	RT	INLET, TYPE S	15.00	24" NORTHWEST	11.50							
S- 375	1291+96.66	214.27'	RT	INLET, TYPE S	13.84	24" NORTHEAST	5.39	24" SOUTHWEST	5.39					
S- 376	1292+52.72	236.90'	RT	INLET, TYPE E	8.50	24" NORTHWEST	5.30							Est. Grate Elevation
S- 377	1293+14.78	119.25'	RT	MANHOLE, TYPE J-7, 5'-0" DIAMETER	9.00	24" SOUTH	4.83	24" NORTH	4.83					Est. Top Elevation

NO.	DATE	BY	REVISIONS - DESCRIPTION

T.Y. LIN INTERNATIONAL
2400 FIRST STREET
SUITE 200
FORT MYERS, FLORIDA 33901
TEL. (239) 332-4846
FAX. (239) 332-4798
WWW.TYLIN.COM




PUBLIC WORKS
LEE COUNTY
SOUTHWEST
FLORIDA
1500 MONROE STREET
FORT MYERS, FLORIDA 33901
TEL. (239) 479-8900 www.lee-county.com/publicworks/office.htm

DEPARTMENT
of
TRANSPORTATION

3-5-2015
Dwerner 3/5/2015 11:00:59 AM


DRAINAGE STRUCTURES
DATA SHEET
BURNT STORE ROAD

SHEET
NO.
59

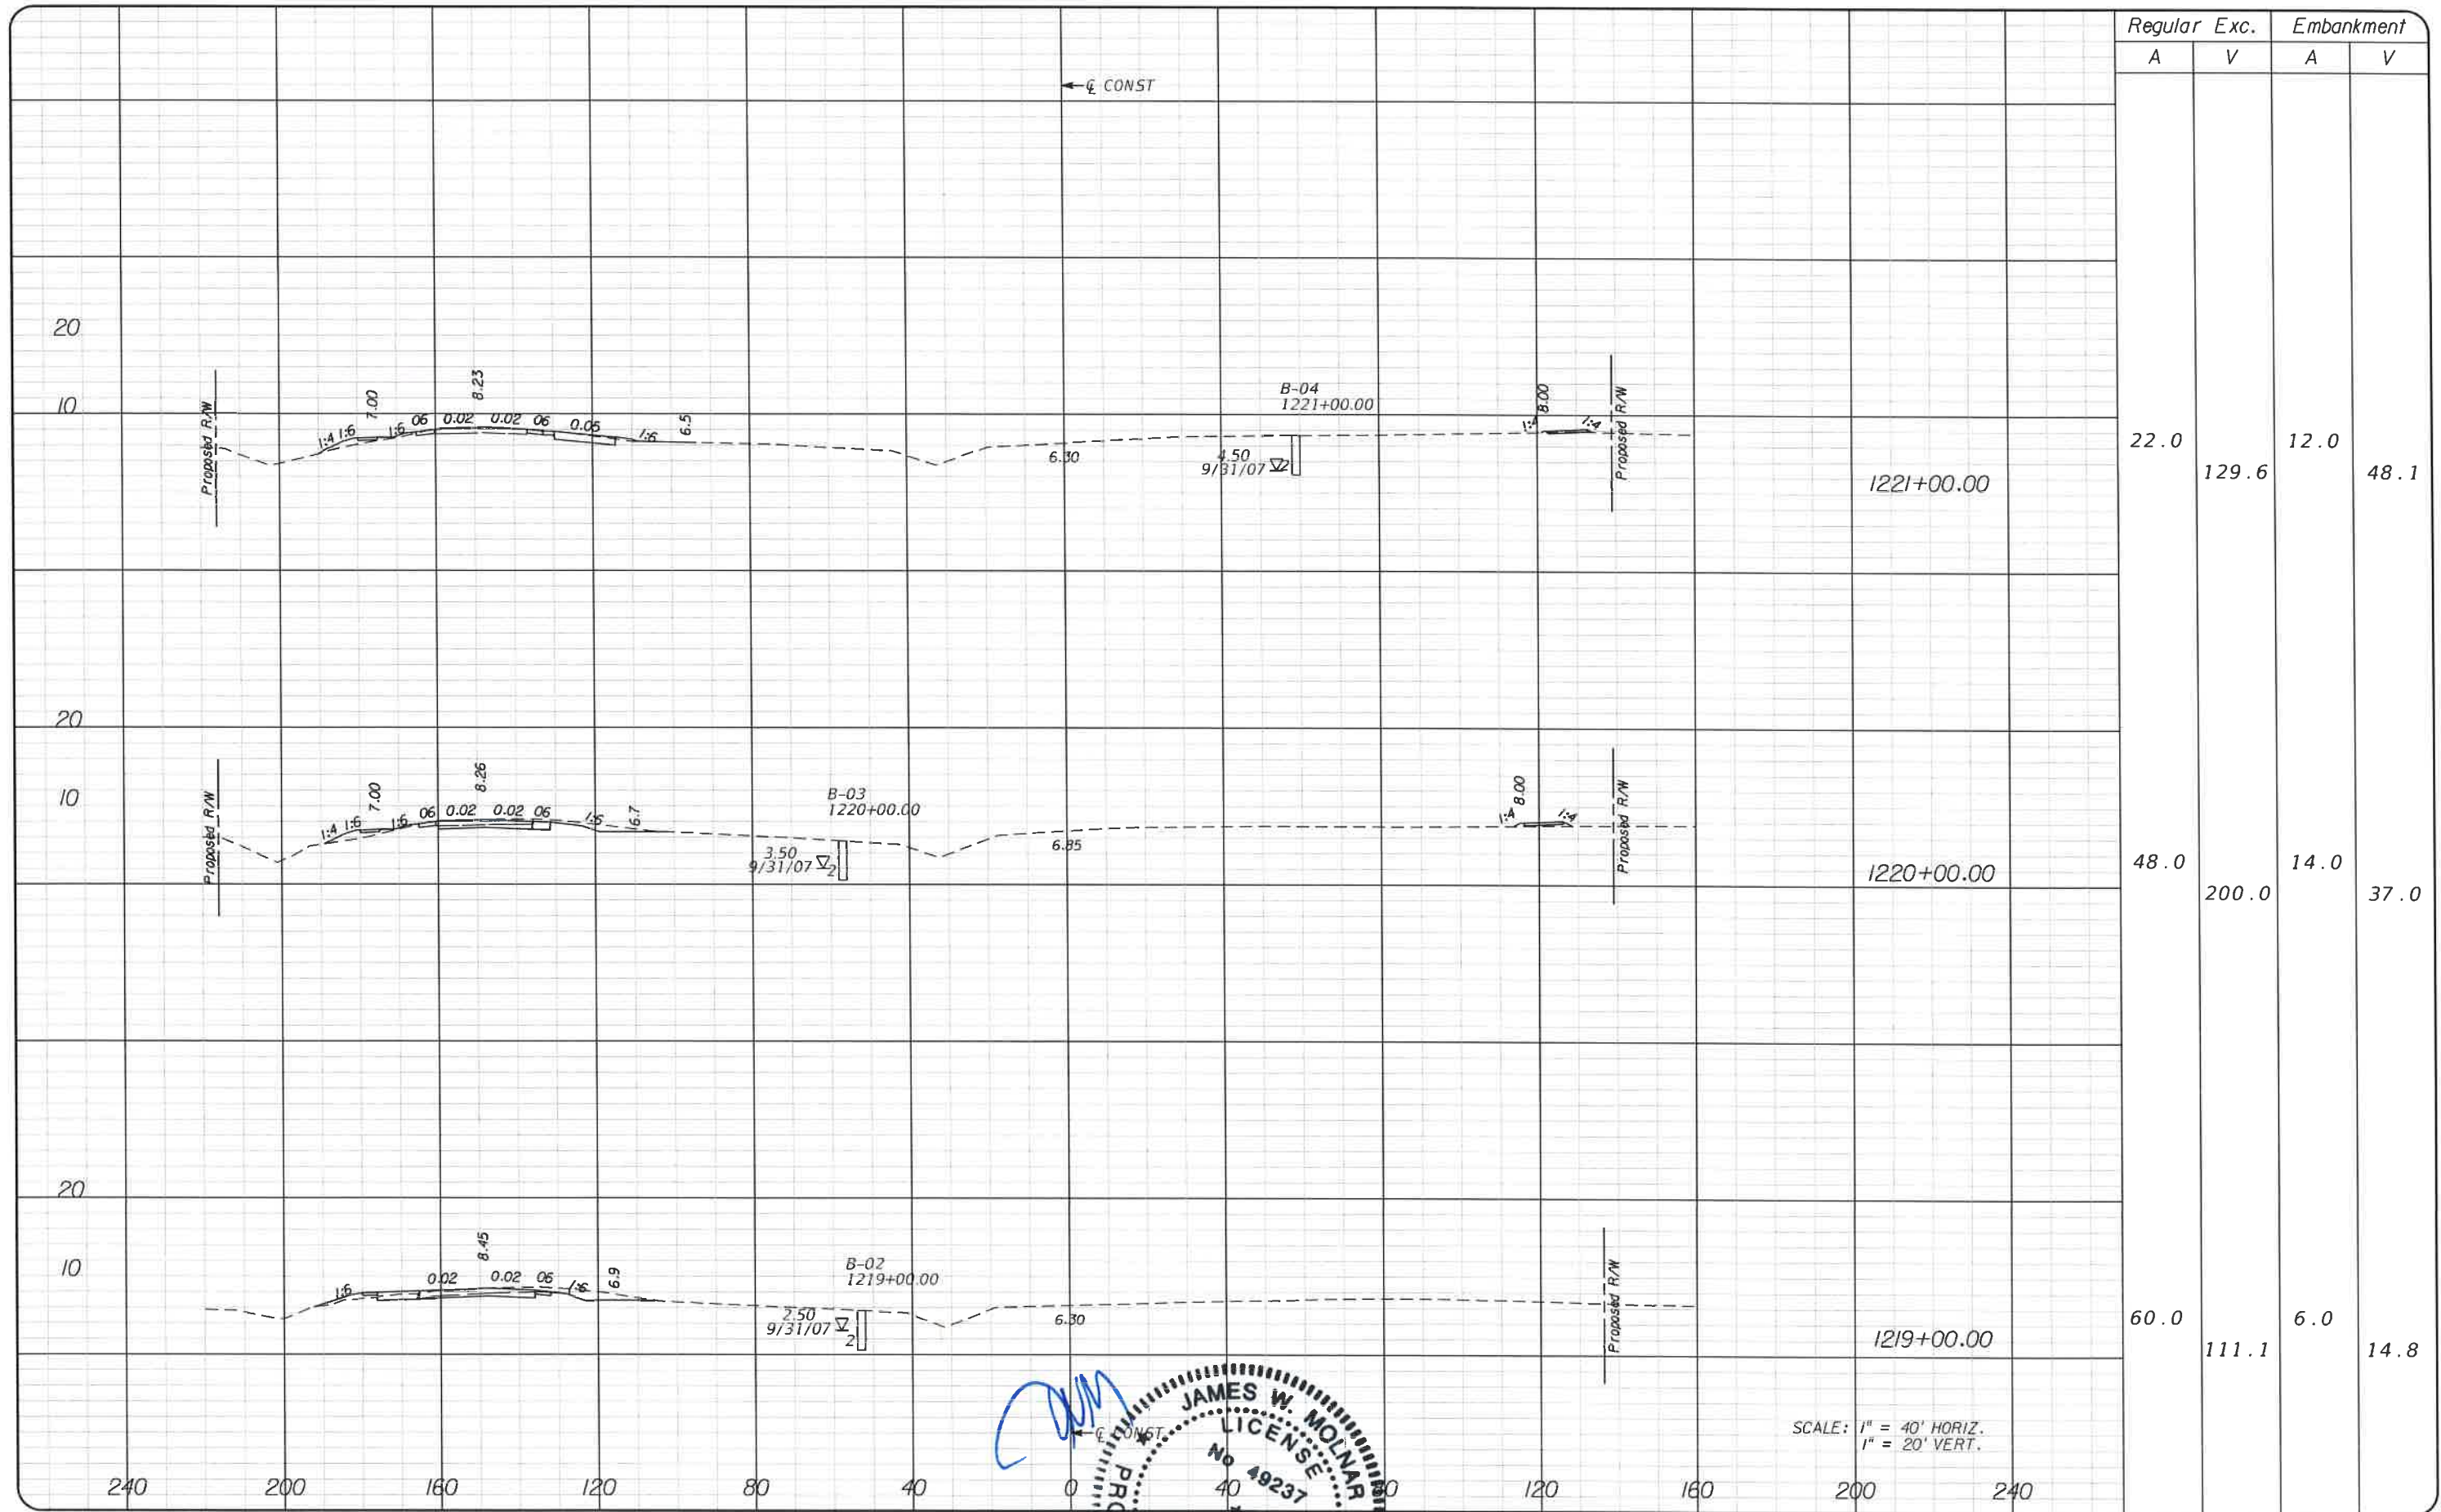

Regular		Exc.		Embankment	
A	V	A	V	A	V
22.0	129.6	12.0	48.1		
48.0	200.0	14.0	37.0		
60.0	111.1	6.0	14.8		

SCALE: 1" = 40' HORIZ.
1" = 20' VERT.

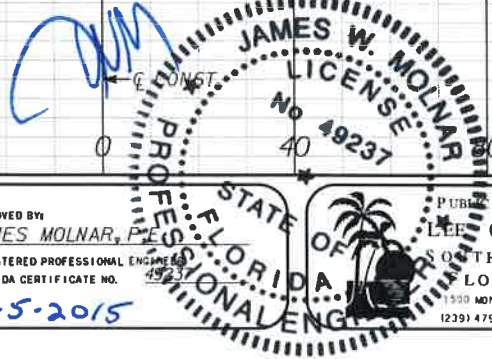

NO.	DATE	BY	REVISIONS - DESCRIPTION


T.Y. LIN INTERNATIONAL
2400 FIRST STREET
SUITE 200
FORT MYERS, FLORIDA 33901
TEL. (239) 332-4846
FAX. (239) 332-4798
WWW.TYLIN.COM

APPROVED BY
JAMES MOLNAR, P.E.
REGISTERED PROFESSIONAL ENGINEER
FLORIDA CERTIFICATE NO. 49237
3-5-2015


PUBLIC WORKS
LEE COUNTY
SOUTHWEST
FLORIDA
1930 MONROE STREET
FORT MYERS, FLORIDA 33901
www.lee-county.com/publicworks/adr/adr.htm
3/4/2015 5:07:57 PM

CROSS SECTIONS
BURNT STORE ROAD

SHEET NO.
60

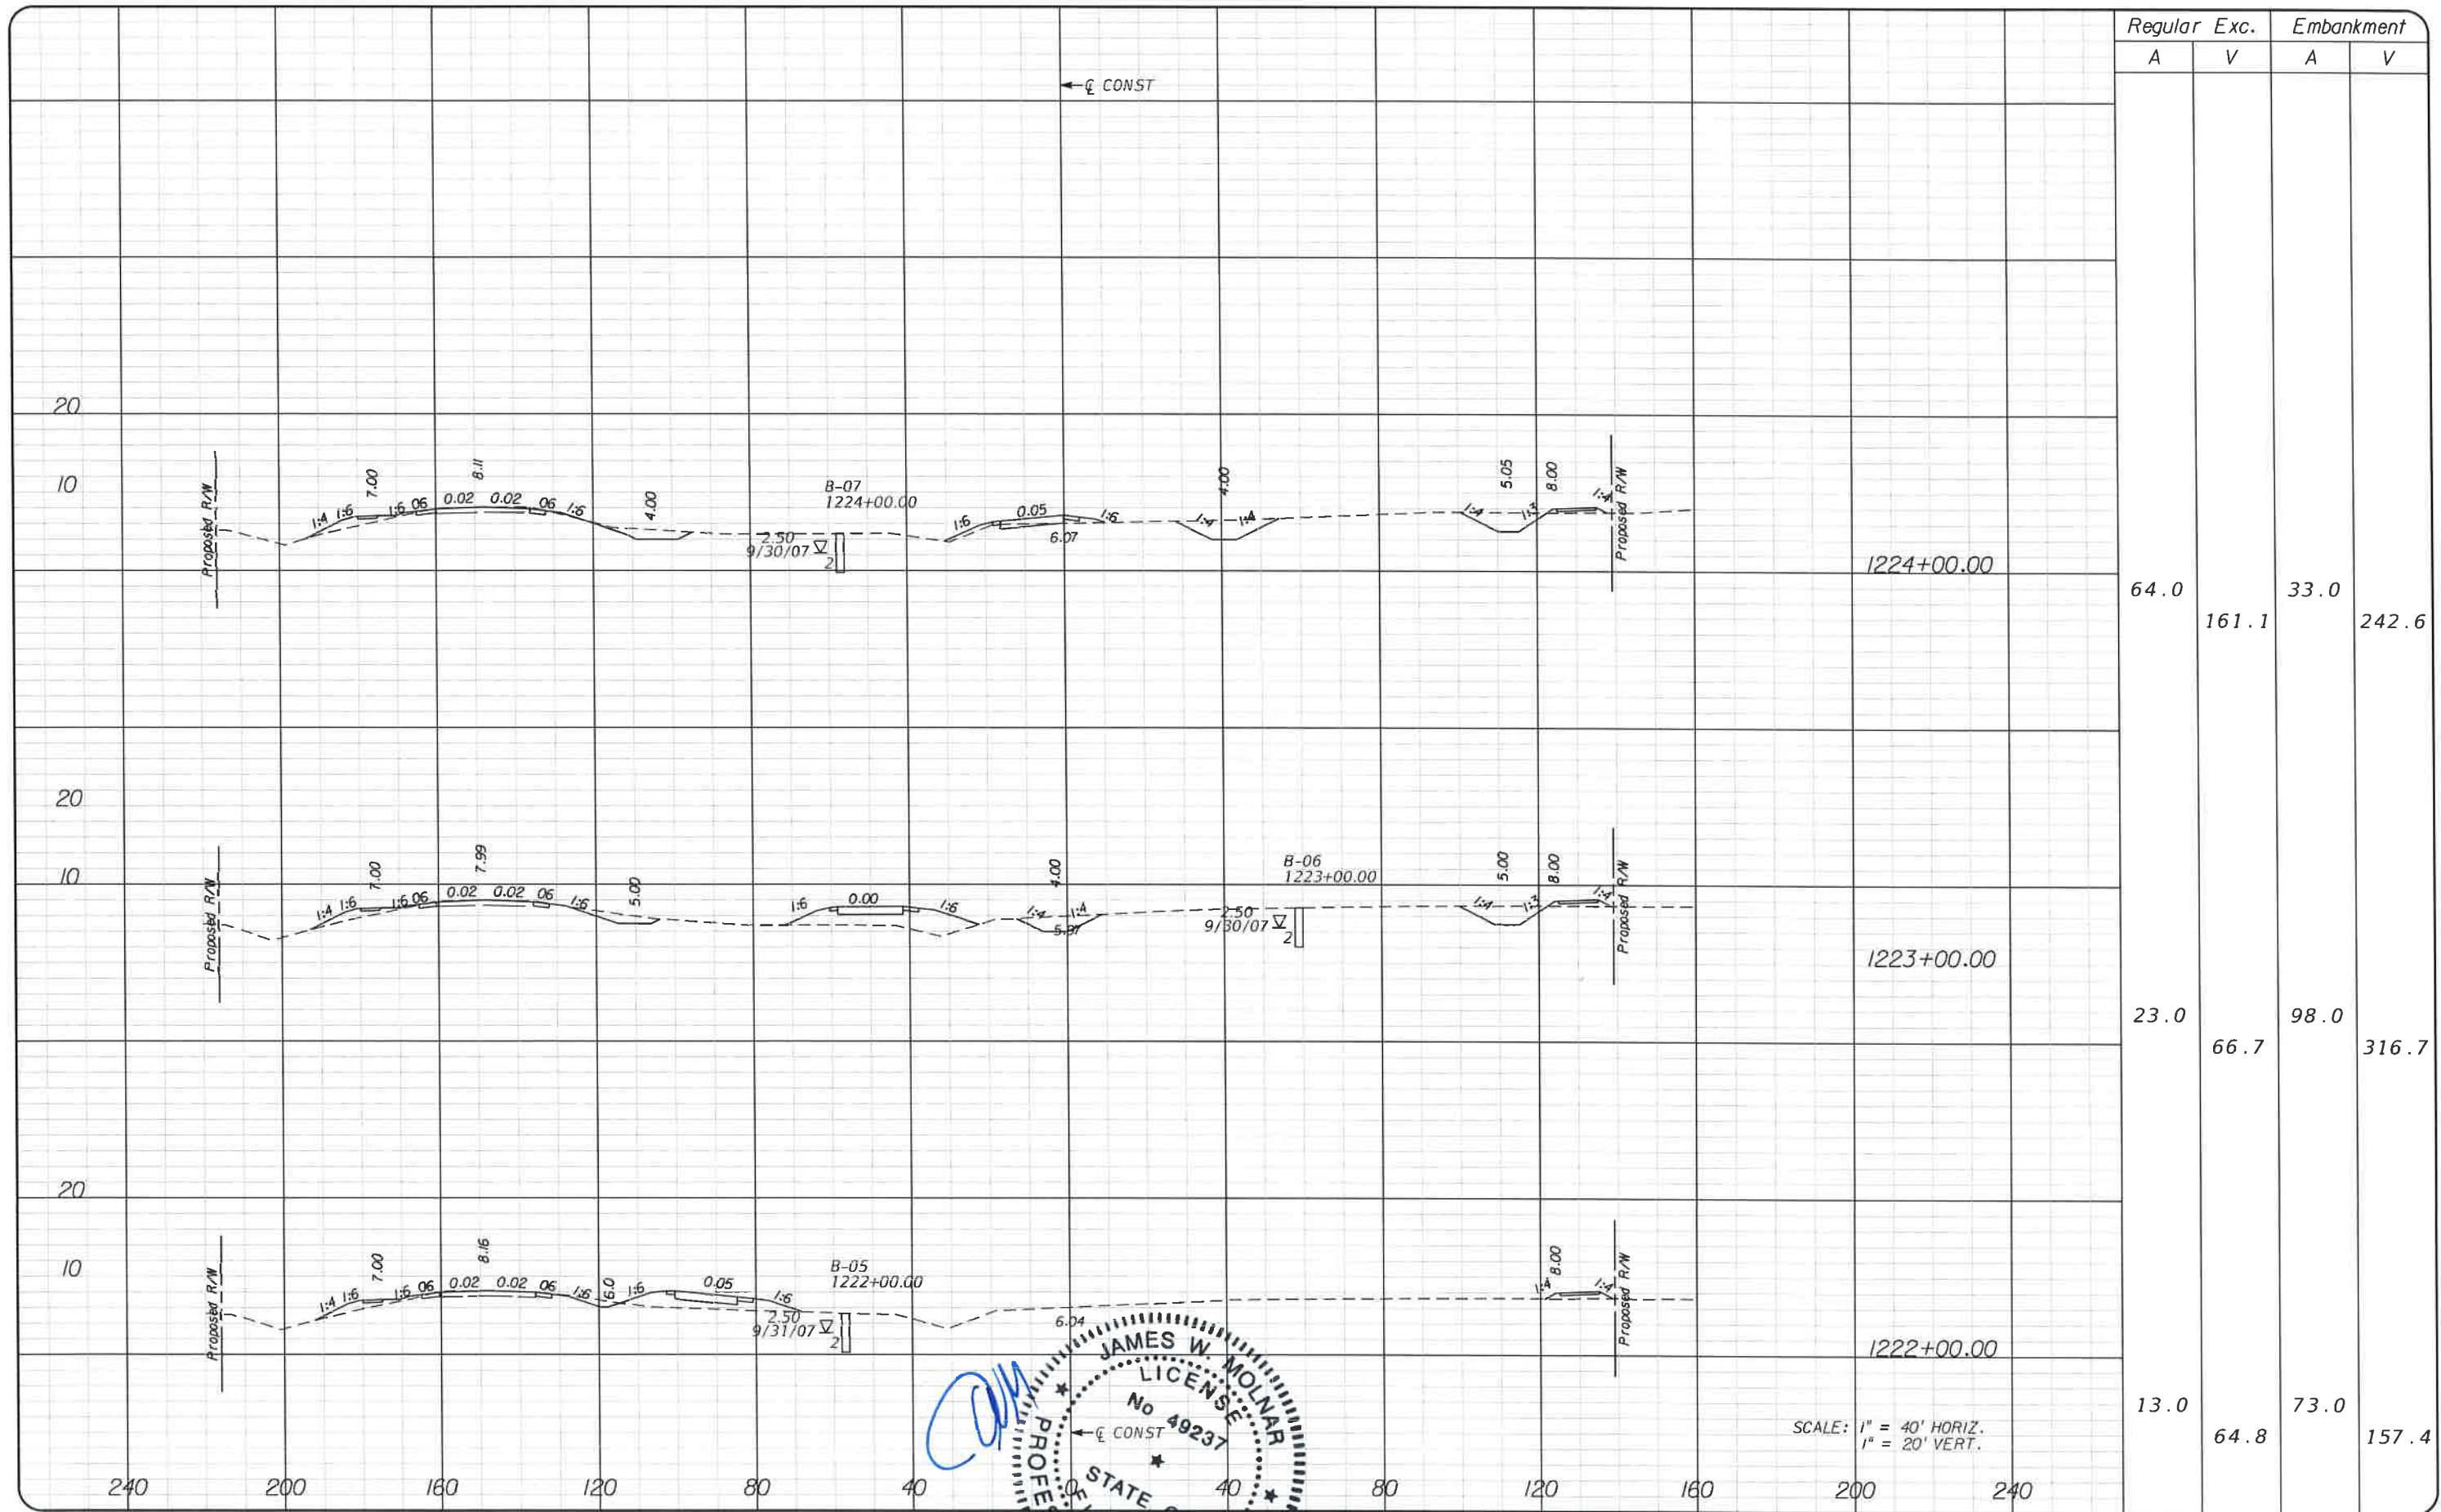

SCALE: 1" = 40' HORIZ.
1" = 20' VERT.

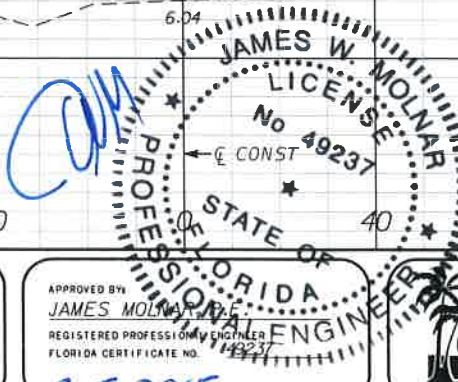

NO.	DATE	BY	REVISIONS - DESCRIPTION

T.Y. LIN INTERNATIONAL
2400 FIRST STREET
SUITE 200
FORT MYERS, FLORIDA 33901
TEL. (239) 332-4846
FAX. (239) 332-4798
WWW.TYLIN.COM


APPROVED BY
JAMES W. MOLNAR
REGISTERED PROFESSIONAL ENGINEER
FLORIDA CERTIFICATE NO. 49237
3-5-2015

PUBLIC WORKS
LEE COUNTY
SOUTHWEST
FLORIDA
1500 MONROE STREET
(239) 479-8900 www.lee-county.com/publicworks/rdutilite.htm

DEPARTMENT
of
TRANSPORTATION
FORT MYERS, FLORIDA 33901

CROSS SECTIONS
BURNT STORE ROAD

SHEET
NO.
61

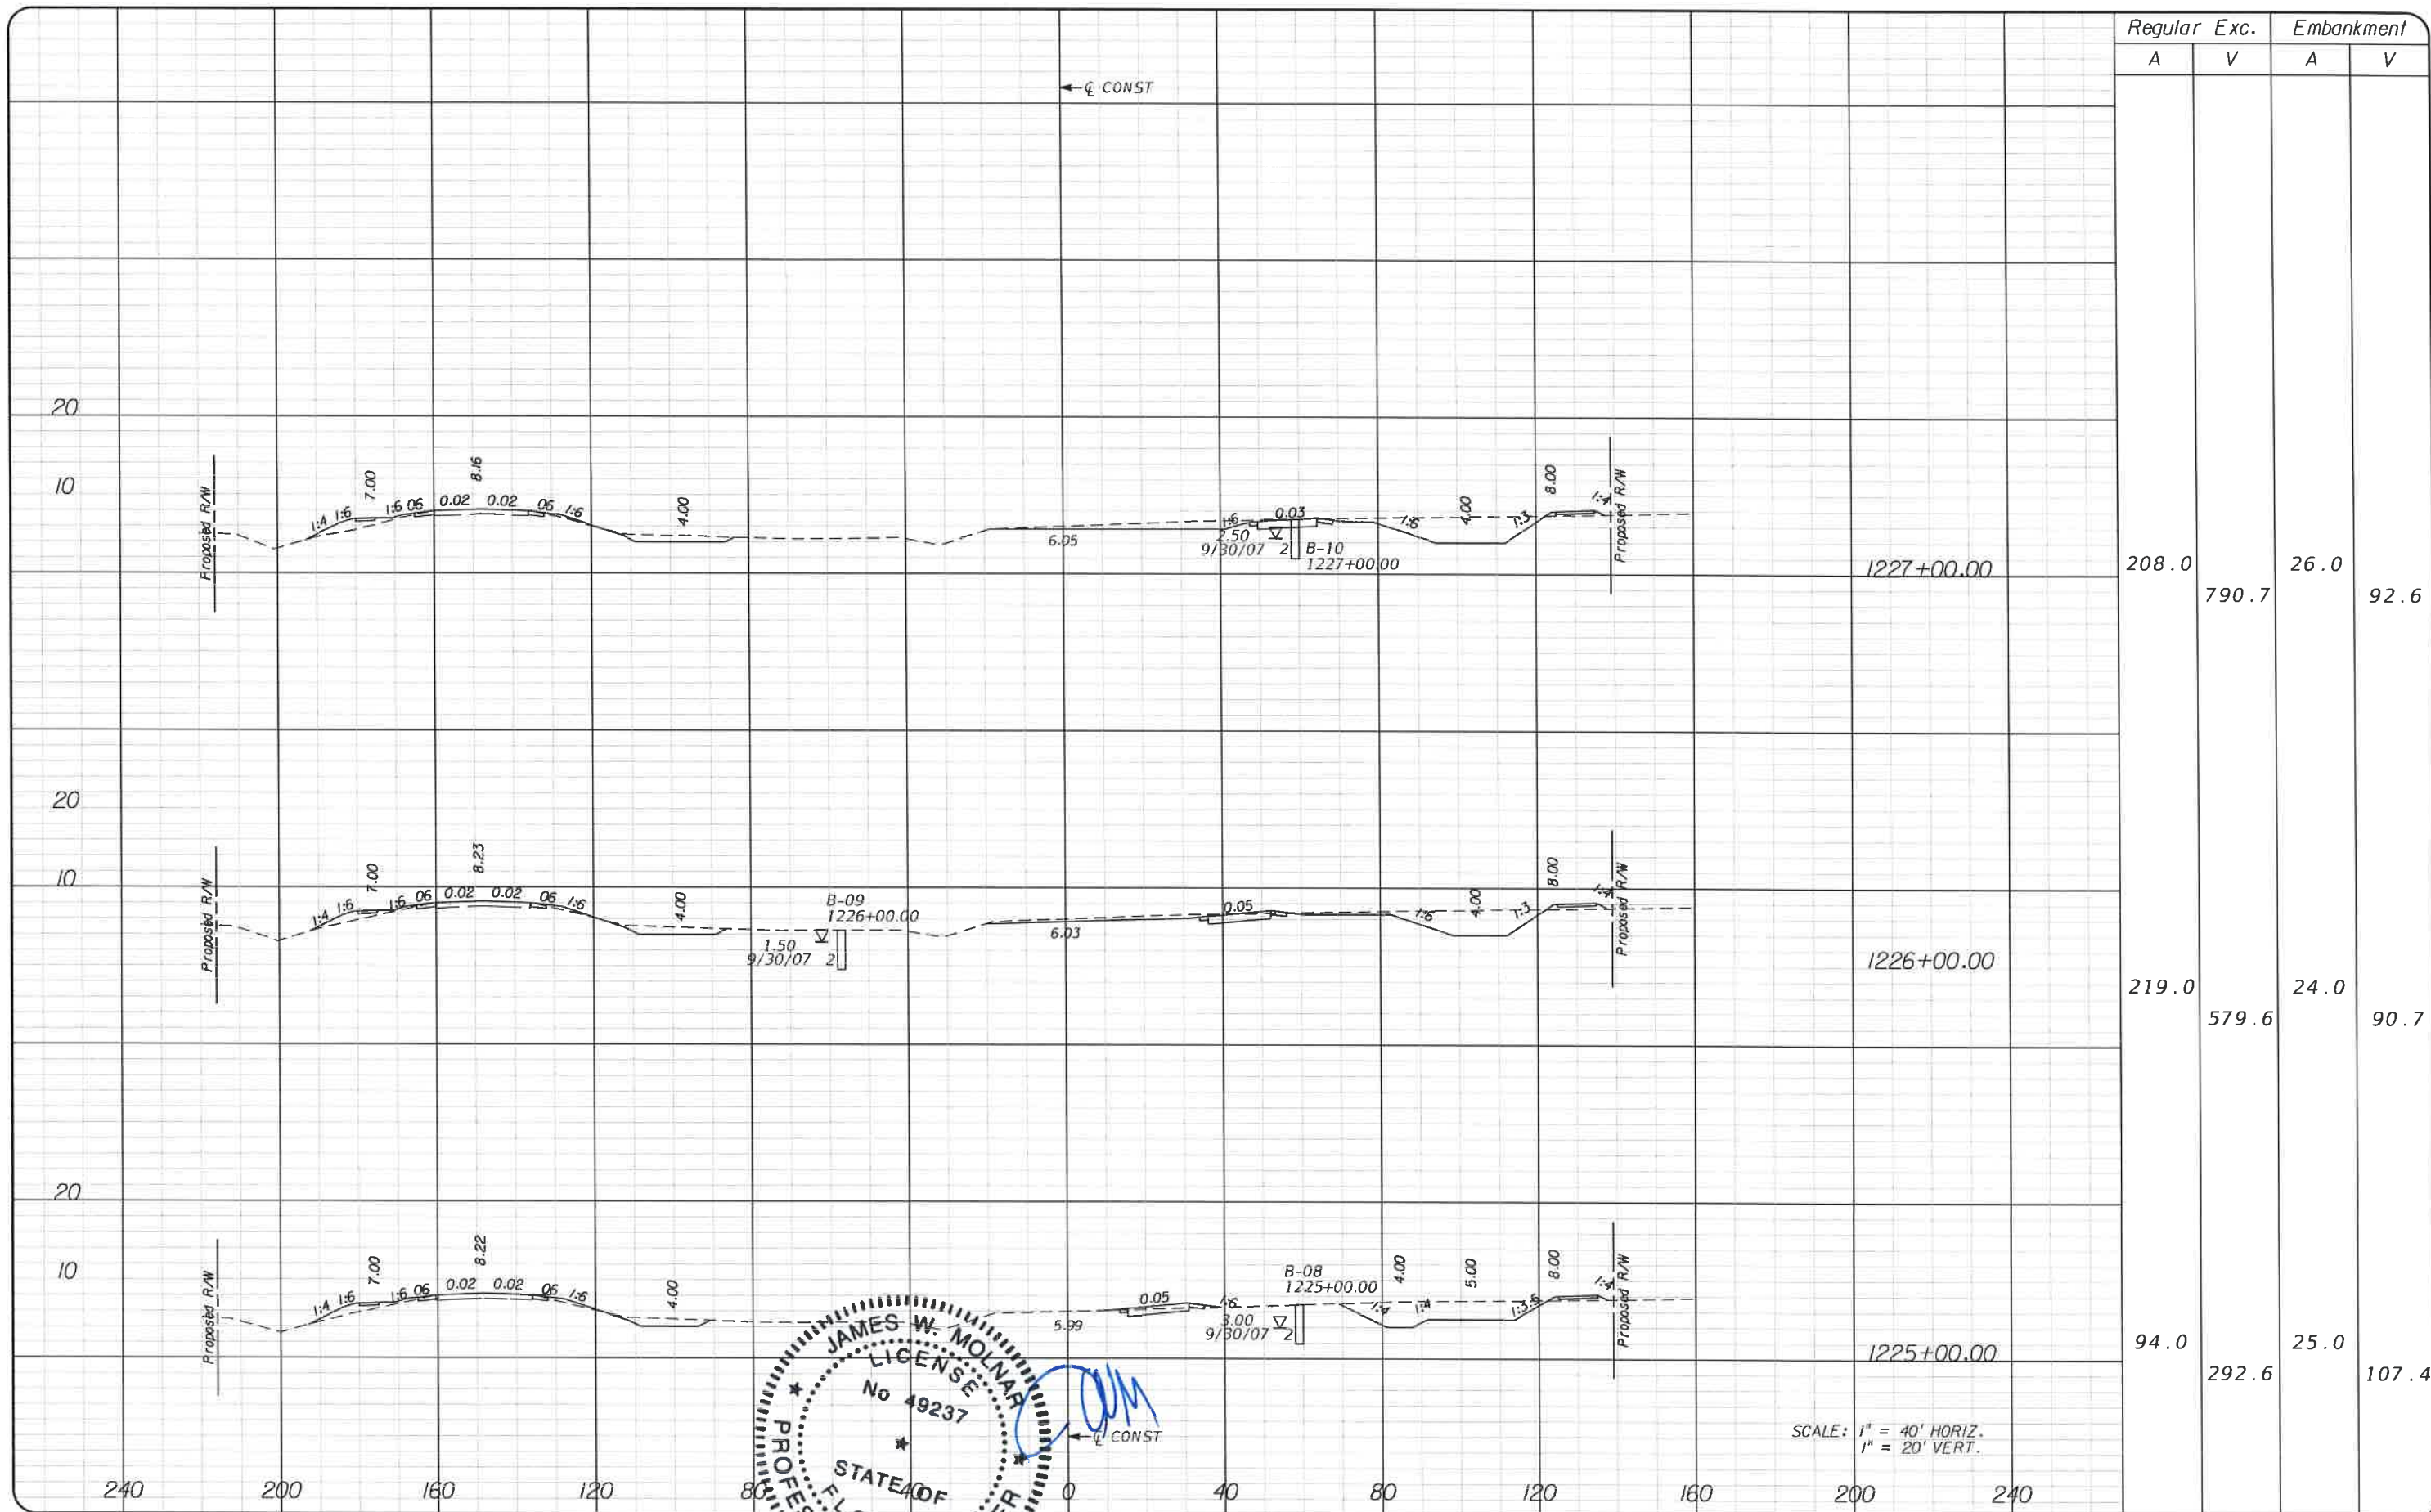

JAMES W. MOLNAR, P.E.
 LICENSE No. 49237
 PROFESSIONAL ENGINEER
 STATE OF FLORIDA

NO.	DATE	BY	REVISIONS - DESCRIPTION


T.Y. LIN INTERNATIONAL
 2400 FIRST STREET
 SUITE 200
 FORT MYERS, FLORIDA 33901
 TEL. (239) 332-4846
 FAX. (239) 332-4798
 WWW.TYLIN.COM

JAMES W. MOLNAR, P.E.
 REGISTERED PROFESSIONAL ENGINEER
 FLORIDA CERTIFICATE NO. 49237
 3-5-2015

PUBLIC WORKS
 LEE COUNTY
 DEPARTMENT of TRANSPORTATION
 SOUTHWEST FLORIDA
 1500 MONROE STREET
 FORT MYERS, FLORIDA 33901
 12391 479-8900

CROSS SECTIONS
BURNT STORE ROAD

SHEET NO.
 62

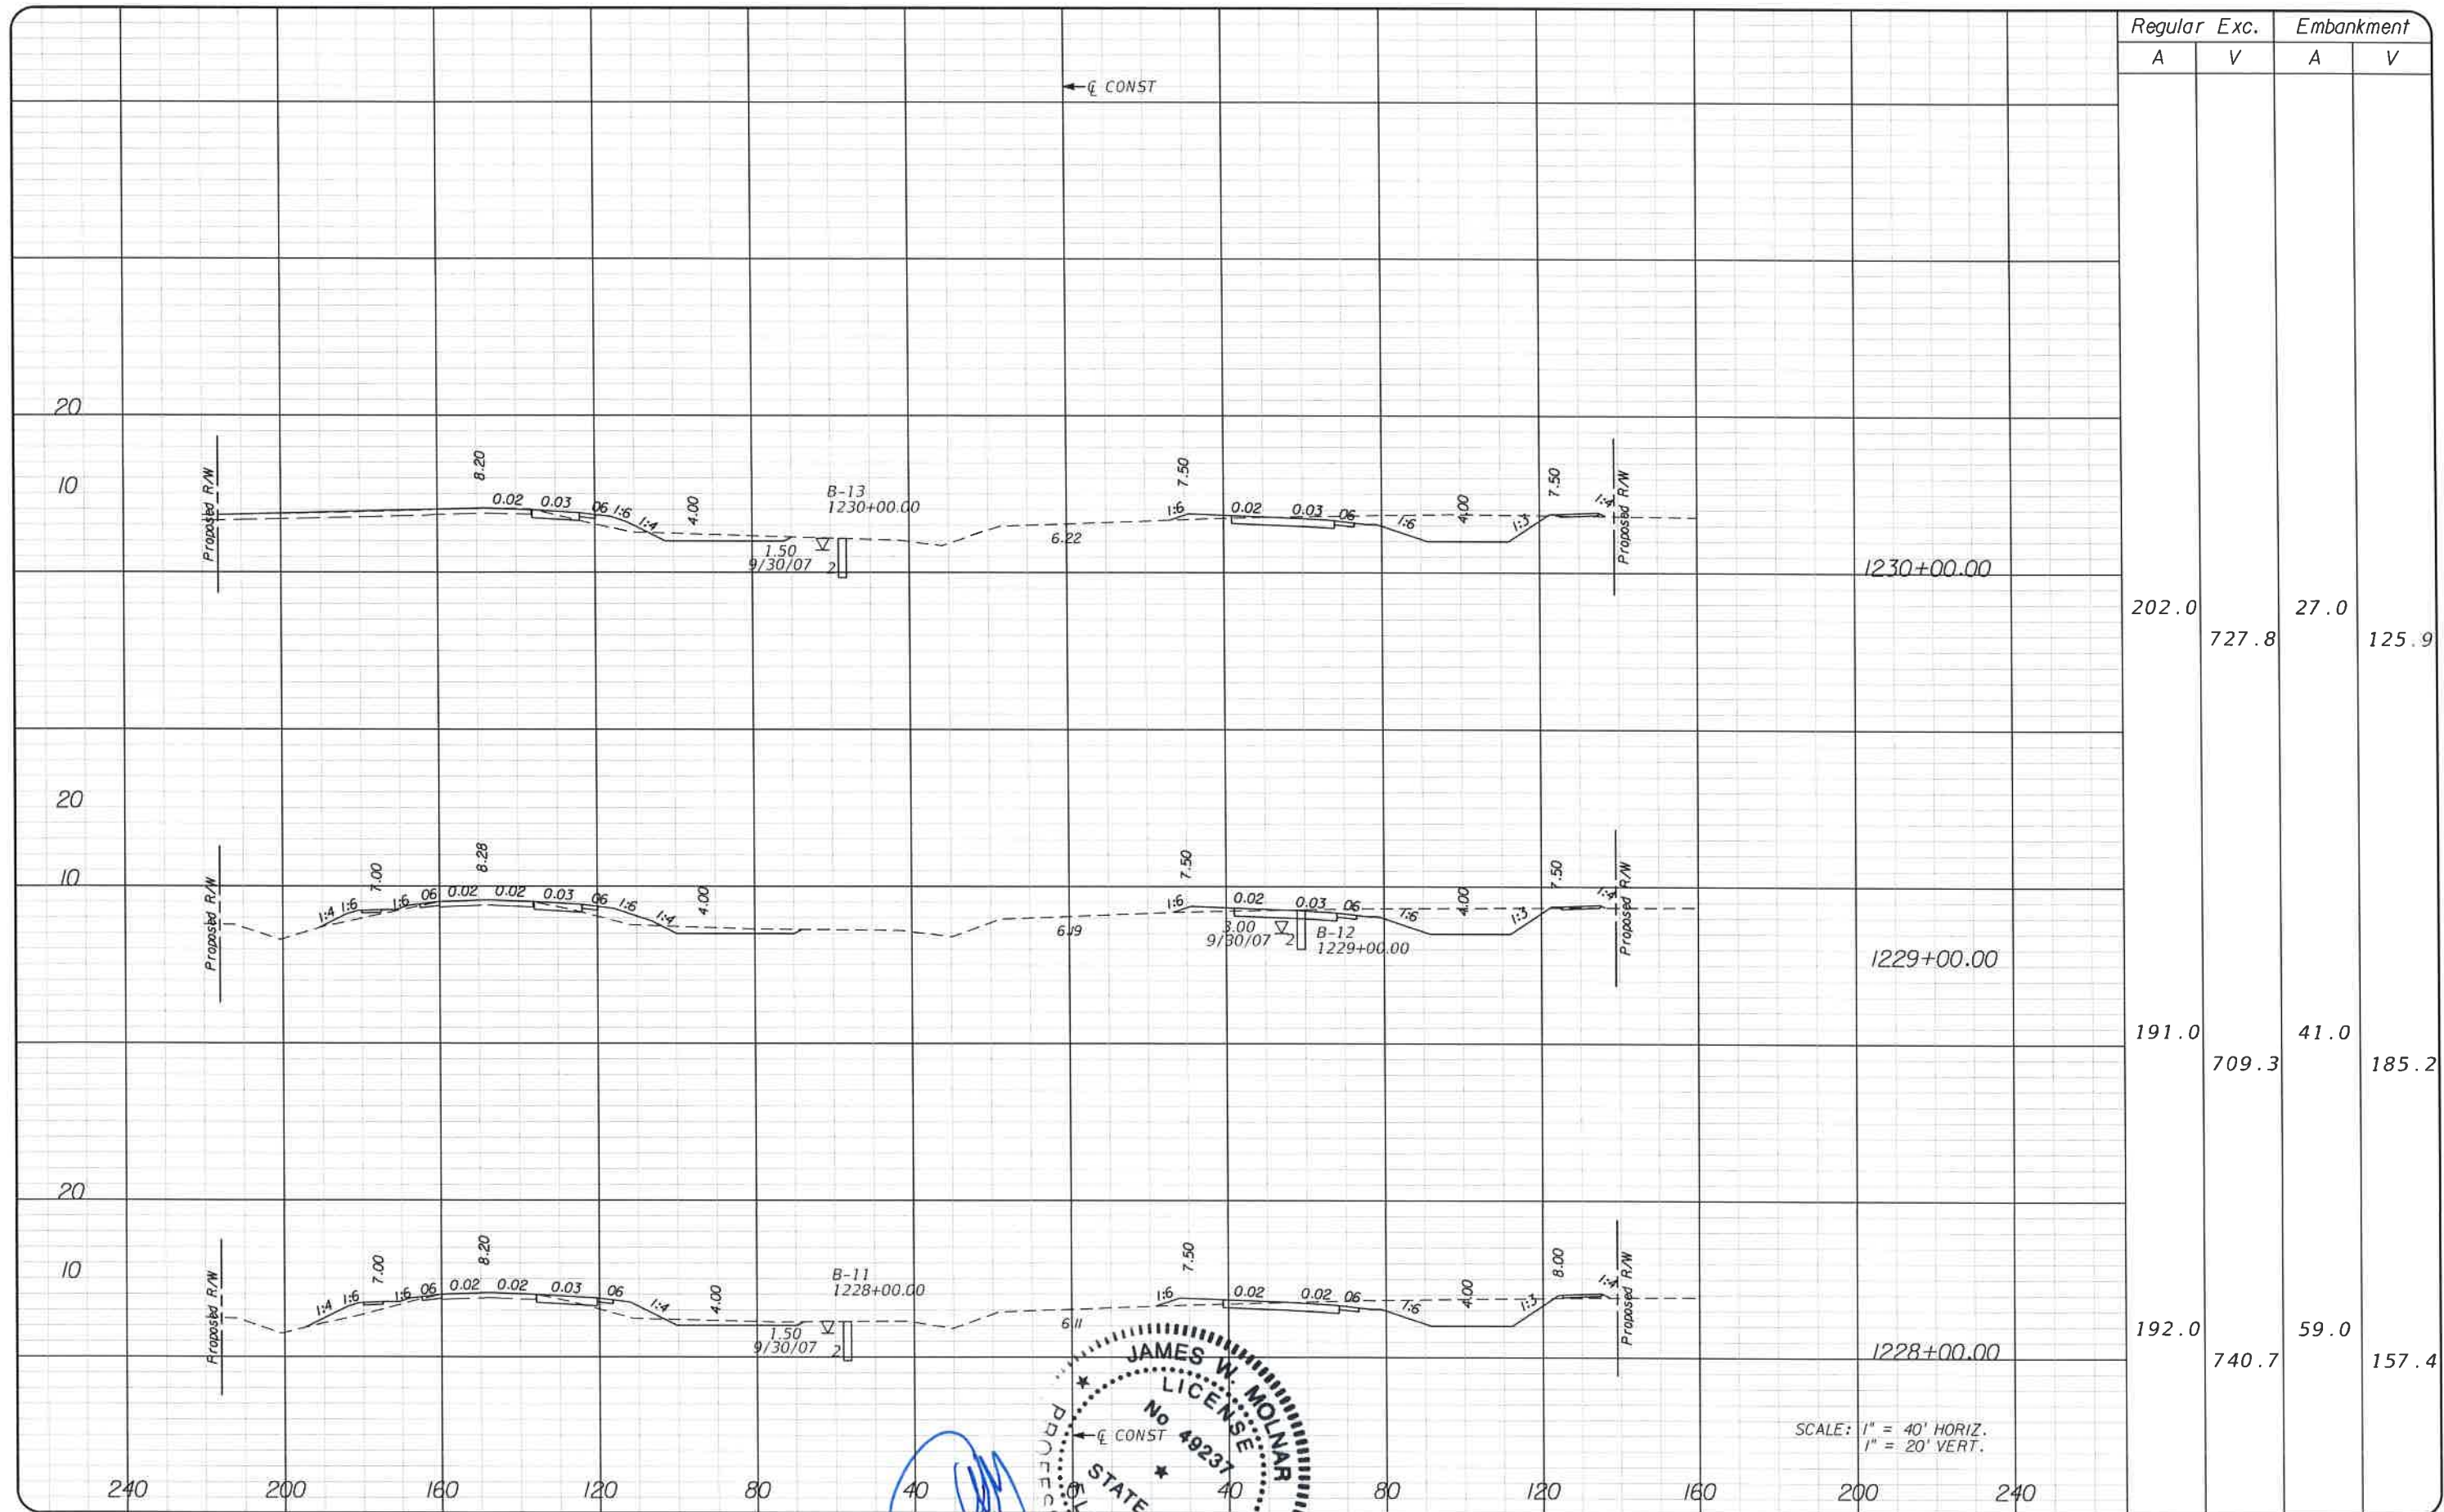

Regular		Exc.		Embankment	
A	V	A	V	A	V
202.0	727.8	27.0	125.9		
191.0	709.3	41.0	185.2		
192.0	740.7	59.0	157.4		

SCALE: 1" = 40' HORIZ.
1" = 20' VERT.

NO.	DATE	BY	REVISIONS - DESCRIPTION


T.Y. LIN INTERNATIONAL
2400 FIRST STREET
SUITE 200
FORT MYERS, FLORIDA 33901
TEL. (239) 332-4846
FAX. (239) 332-4798
WWW.TYLIN.COM

APPROVED BY
JAMES MOLNAR
REGISTERED PROFESSIONAL ENGINEER
FLORIDA CERTIFICATE NO. 48231
3-5-2015

PUBLIC WORKS
LEE COUNTY
SOUTHWEST
FLORIDA
1500 MONROE STREET
FORT MYERS, FLORIDA 33901
12391 419-8900
www.lee-county.com/publicworks/leesite.nhn

CROSS SECTIONS
BURNT STORE ROAD

SHEET NO.
63

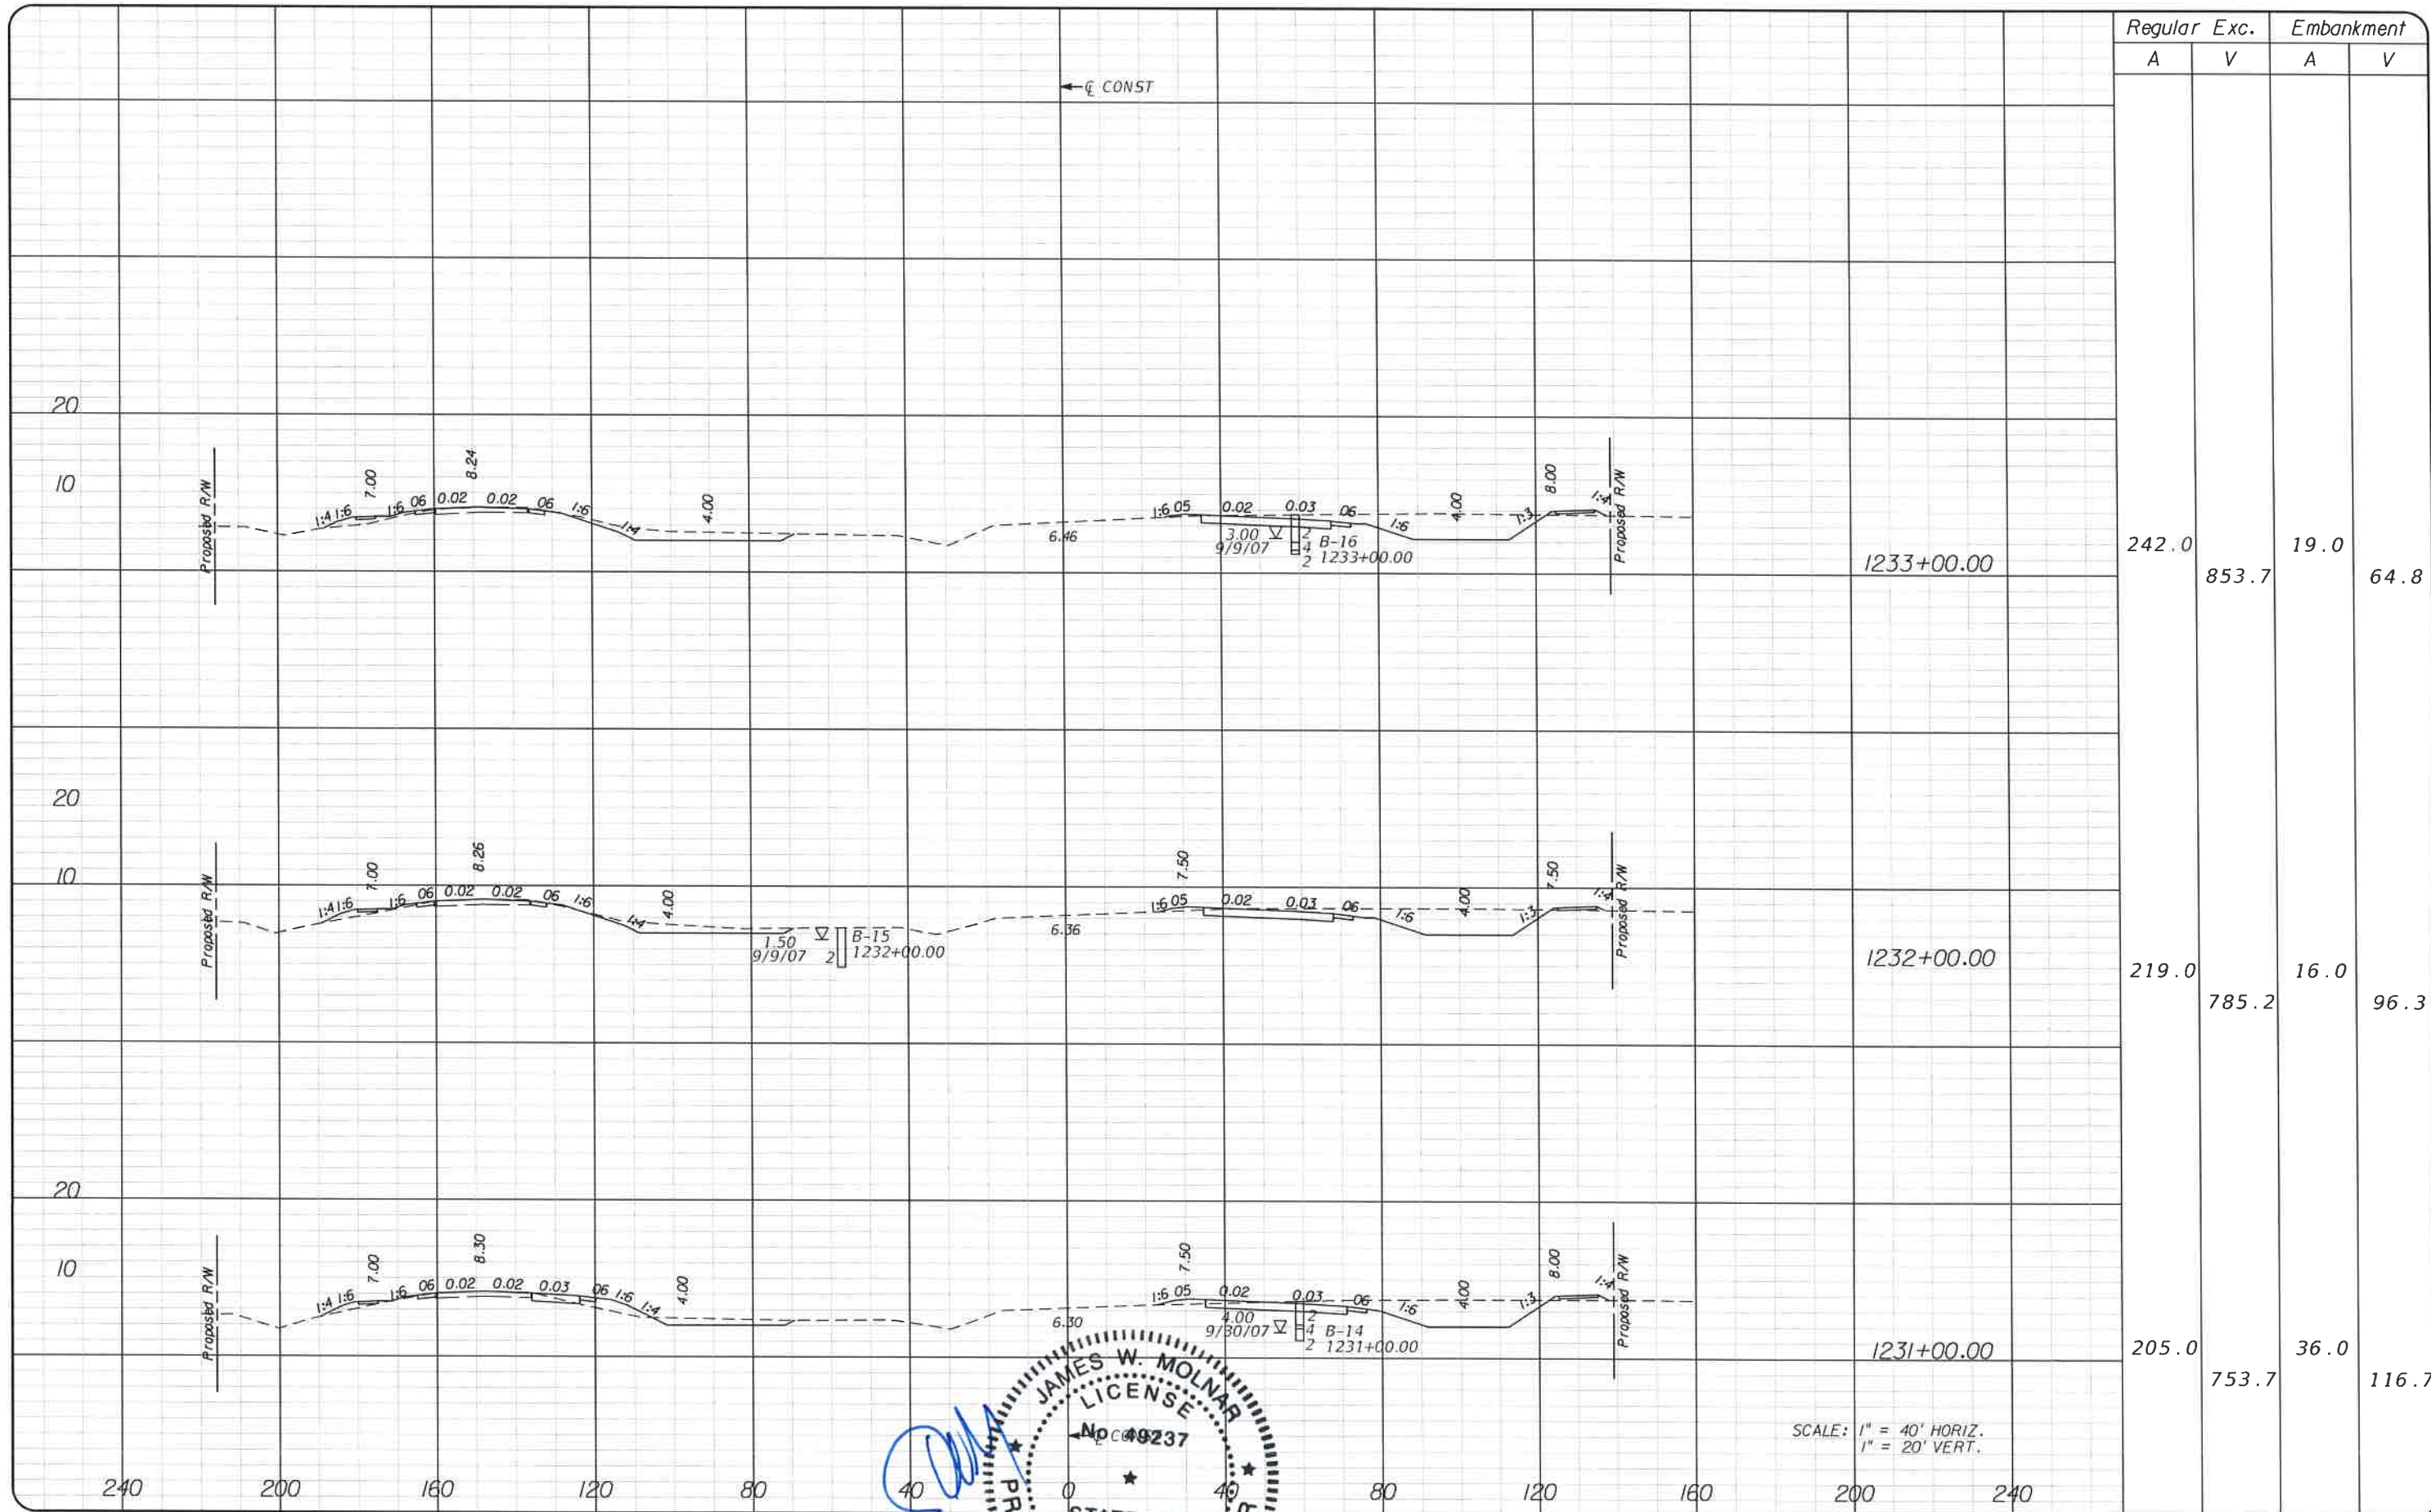

Regular		Exc.		Embankment	
A	V	A	V	A	V
242.0	853.7	19.0	64.8		
219.0	785.2	16.0	96.3		
205.0	753.7	36.0	116.7		

SCALE: 1" = 40' HORIZ.
1" = 20' VERT.

NO.	DATE	BY	REVISIONS - DESCRIPTION


T.Y. LIN INTERNATIONAL
2400 FIRST STREET
SUITE 200
FORT MYERS, FLORIDA 33901
TEL. (239) 332-4846
FAX. (239) 332-4798
WWW.TYLIN.COM

APPROVED BY
JAMES W. MOLNAR
REGISTERED PROFESSIONAL ENGINEER
FLORIDA CERTIFICATE NO. 49237
3-5-2015

PUBLIC WORKS
LEE COUNTY
SOUTHWEST
FLORIDA
1900 MONROE STREET
FORT MYERS, FLORIDA 33901
12391 479-8900 www.lee-county.com/publicworks/delille.htm

CROSS SECTIONS
BURNT STORE ROAD

SHEET NO.
64

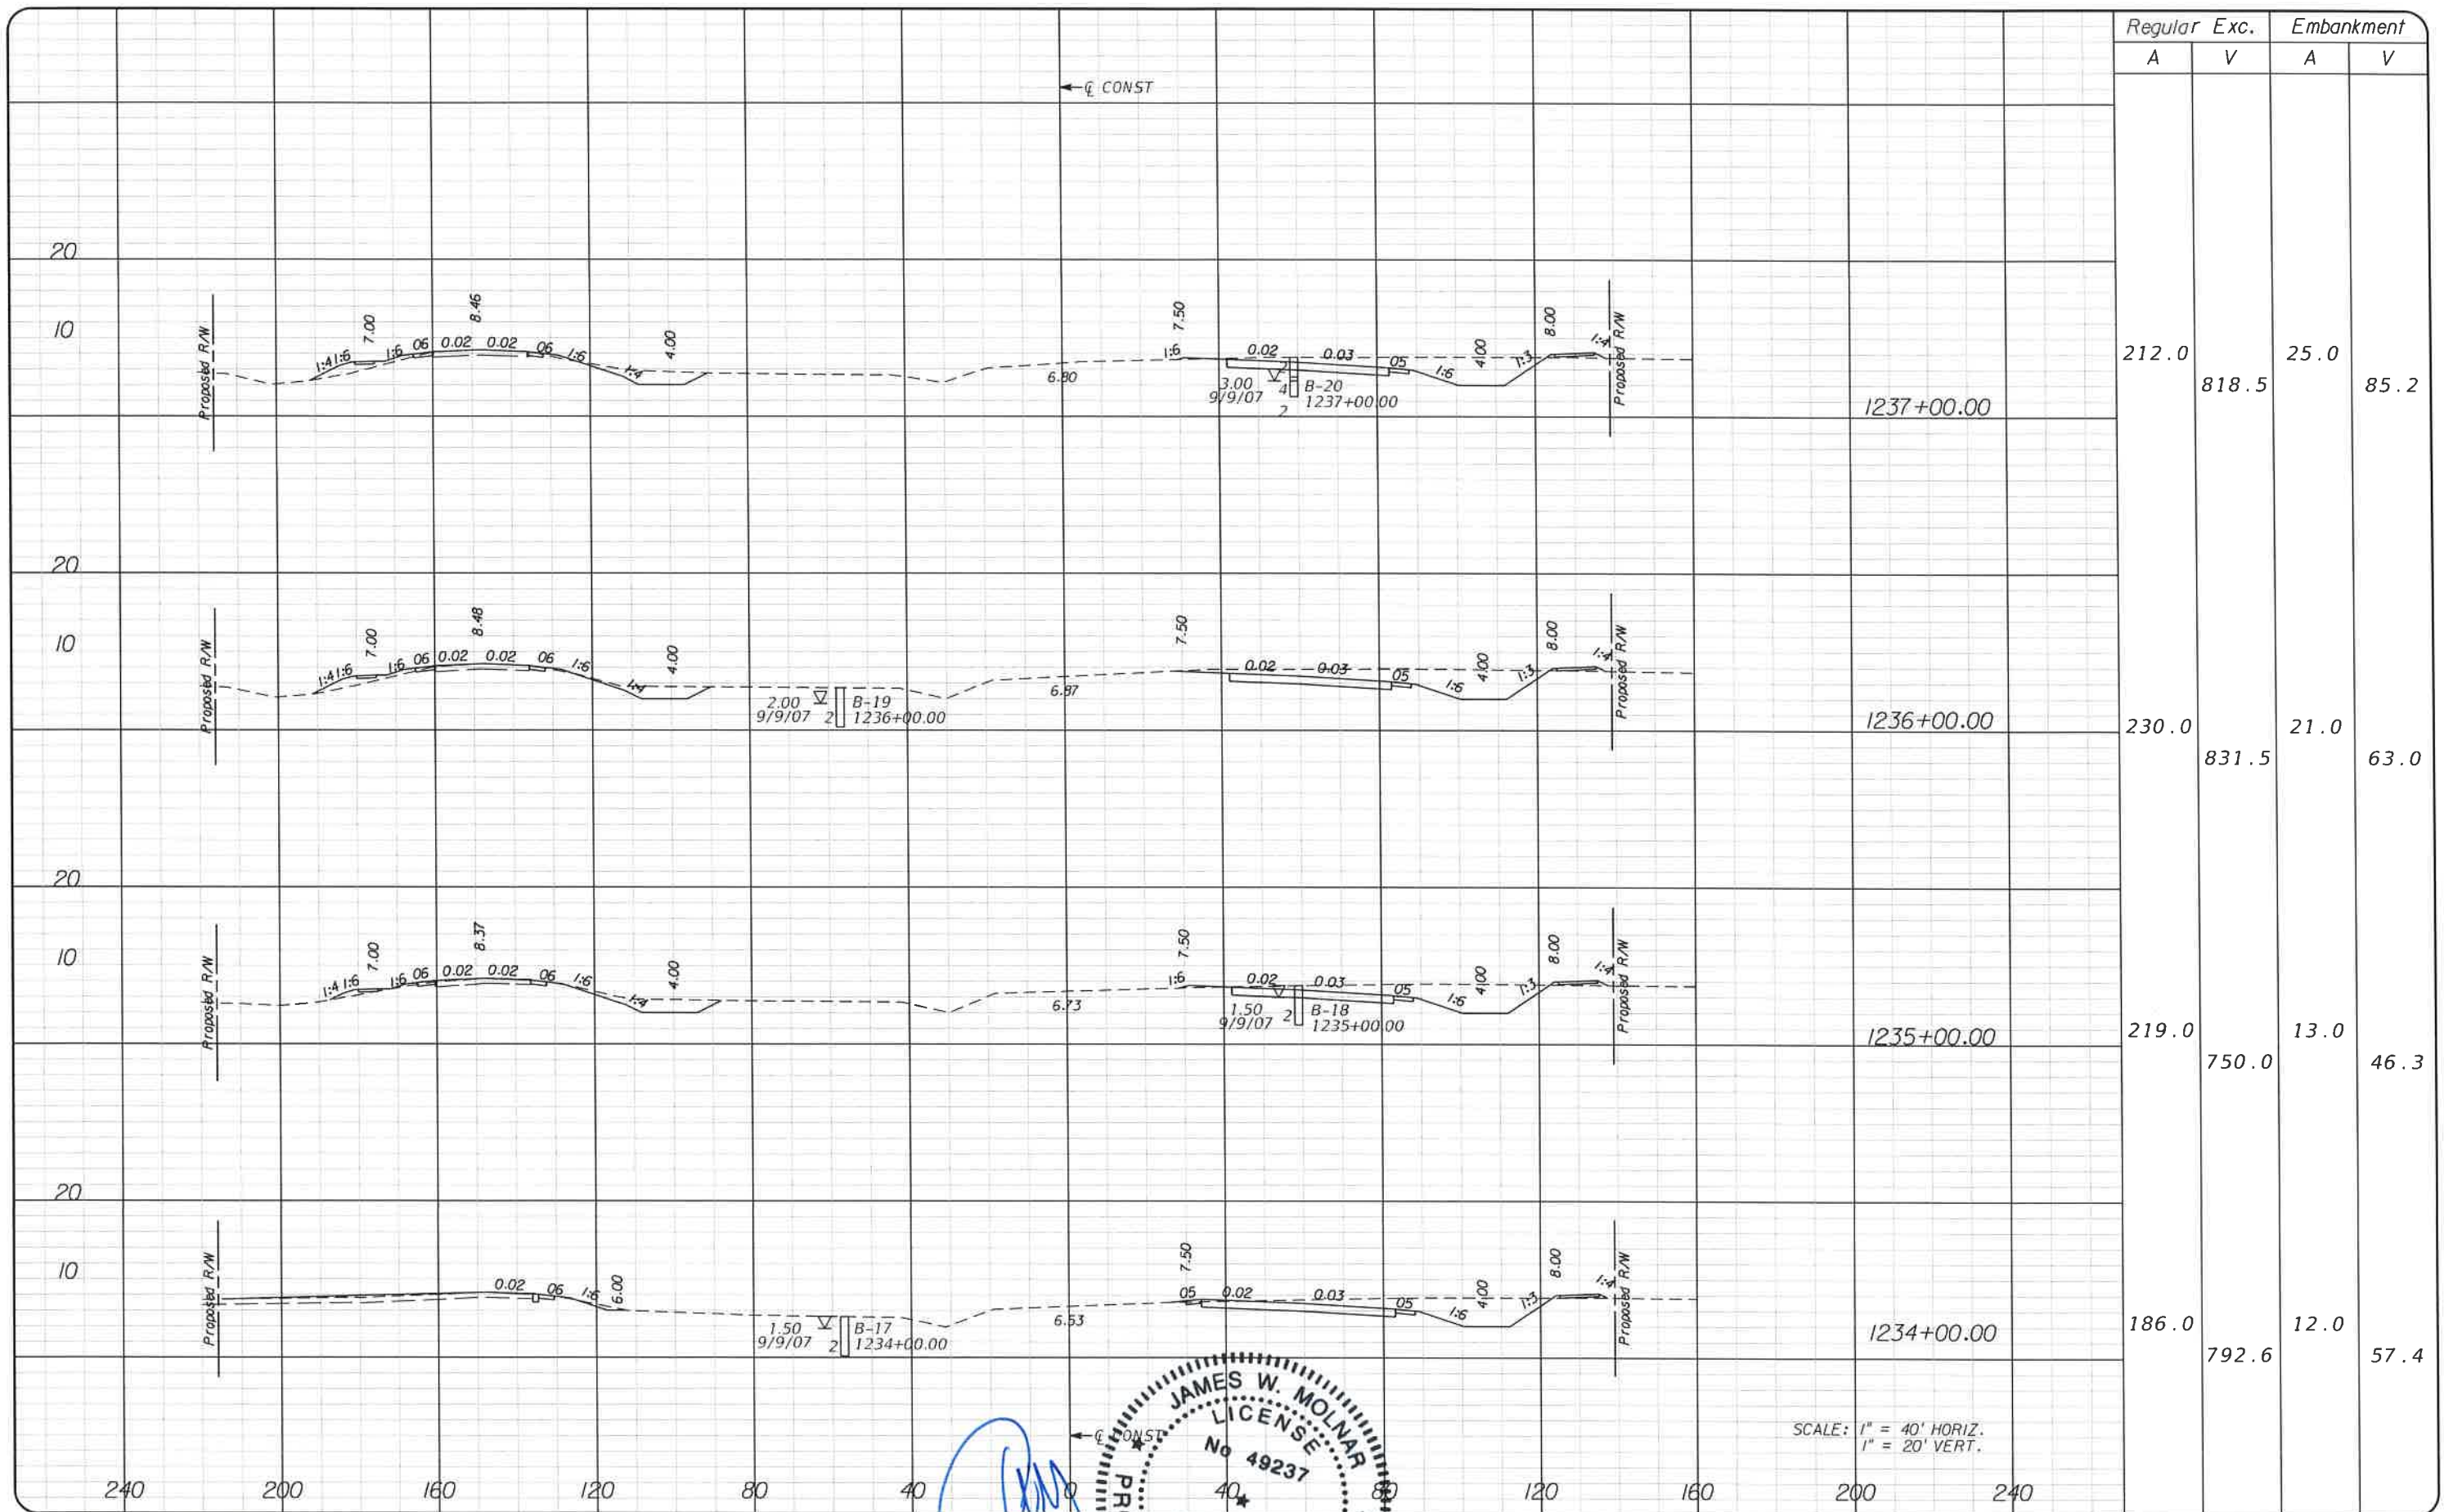


SCALE: 1" = 40' HORIZ.
1" = 20' VERT.

NO.	DATE	BY	REVISIONS - DESCRIPTION

T.Y. LIN INTERNATIONAL
2400 FIRST STREET
SUITE 200
FORT MYERS, FLORIDA 33901
TEL. (239) 332-4846
FAX. (239) 332-4798
WWW.TYLIN.COM


APPROVED BY:
JAMES W. MOLNAR, P.E.
REGISTERED PROFESSIONAL ENGINEER
FLORIDA CERTIFICATE NO. 49237
3-5-2015

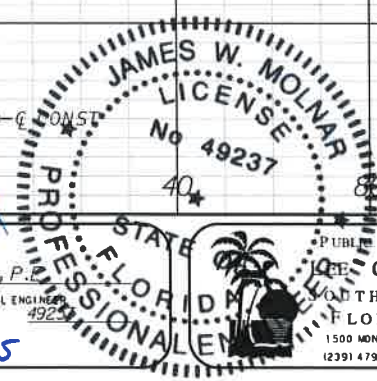

DEPARTMENT of TRANSPORTATION
FORT MYERS, FLORIDA 33901
1500 MONROE STREET
TEL. (239) 479-8900
www.tre.state.fl.us/publicworks/fdot/0101a.htm
3/4/2015 5:08:00 PM

CROSS SECTIONS
BURNT STORE ROAD

SHEET NO.
65

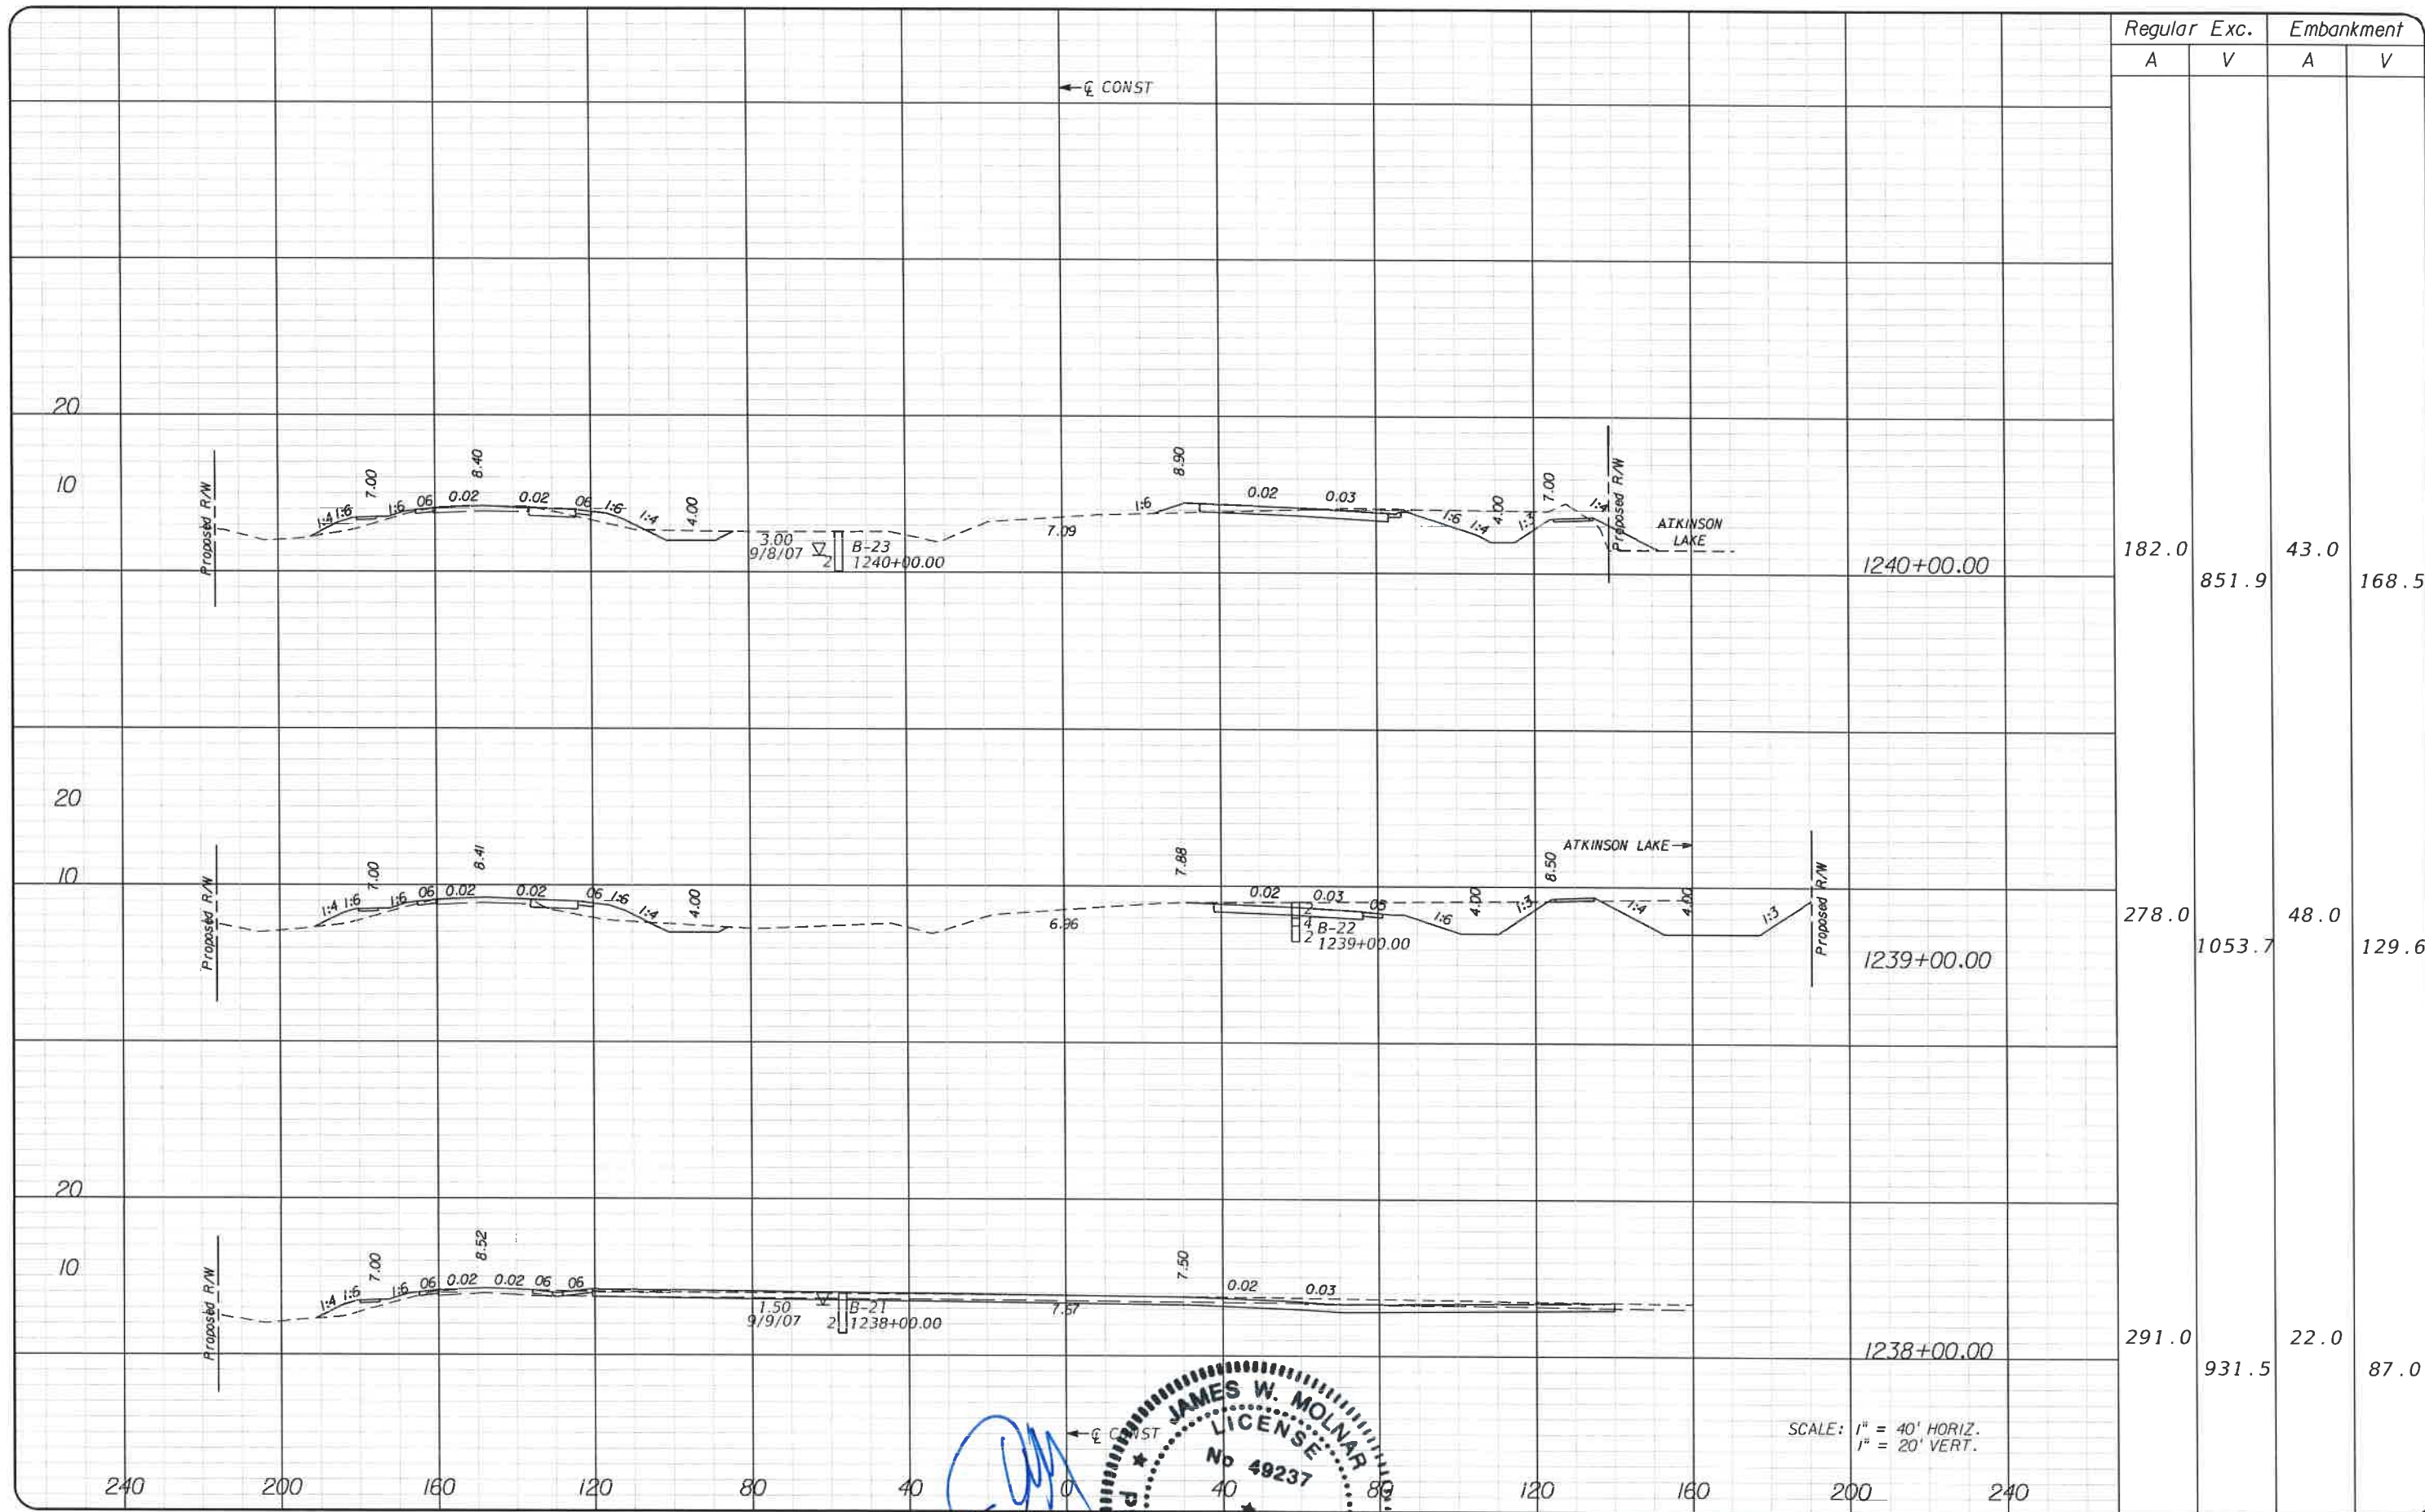

SCALE: 1" = 40' HORIZ.
1" = 20' VERT.

NO.	DATE	BY	REVISIONS - DESCRIPTION

T.Y. LIN INTERNATIONAL
2400 FIRST STREET
SUITE 200
FORT MYERS, FLORIDA 33901
TEL. (239) 332-4846
FAX. (239) 332-4798
WWW.TYLIN.COM

APPROVED BY:
JAMES W. MOLNAR, P.E.
REGISTERED PROFESSIONAL ENGINEER
FLORIDA CERTIFICATE NO. 49237
3-5-2015




APPROVED BY:
JAMES W. MOLNAR, P.E.
REGISTERED PROFESSIONAL ENGINEER
FLORIDA CERTIFICATE NO. 49237
3-5-2015

FLORIDA DEPARTMENT OF TRANSPORTATION
PUBLIC WORKS
LEWIS COUNTY
SOUTHWEST FLORIDA
1500 MONROE STREET
FORT MYERS, FLORIDA 33901
TEL. (239) 479-8900
WWW.FDOT.COM

CROSS SECTIONS
BURNT STORE ROAD

SHEET NO.
66

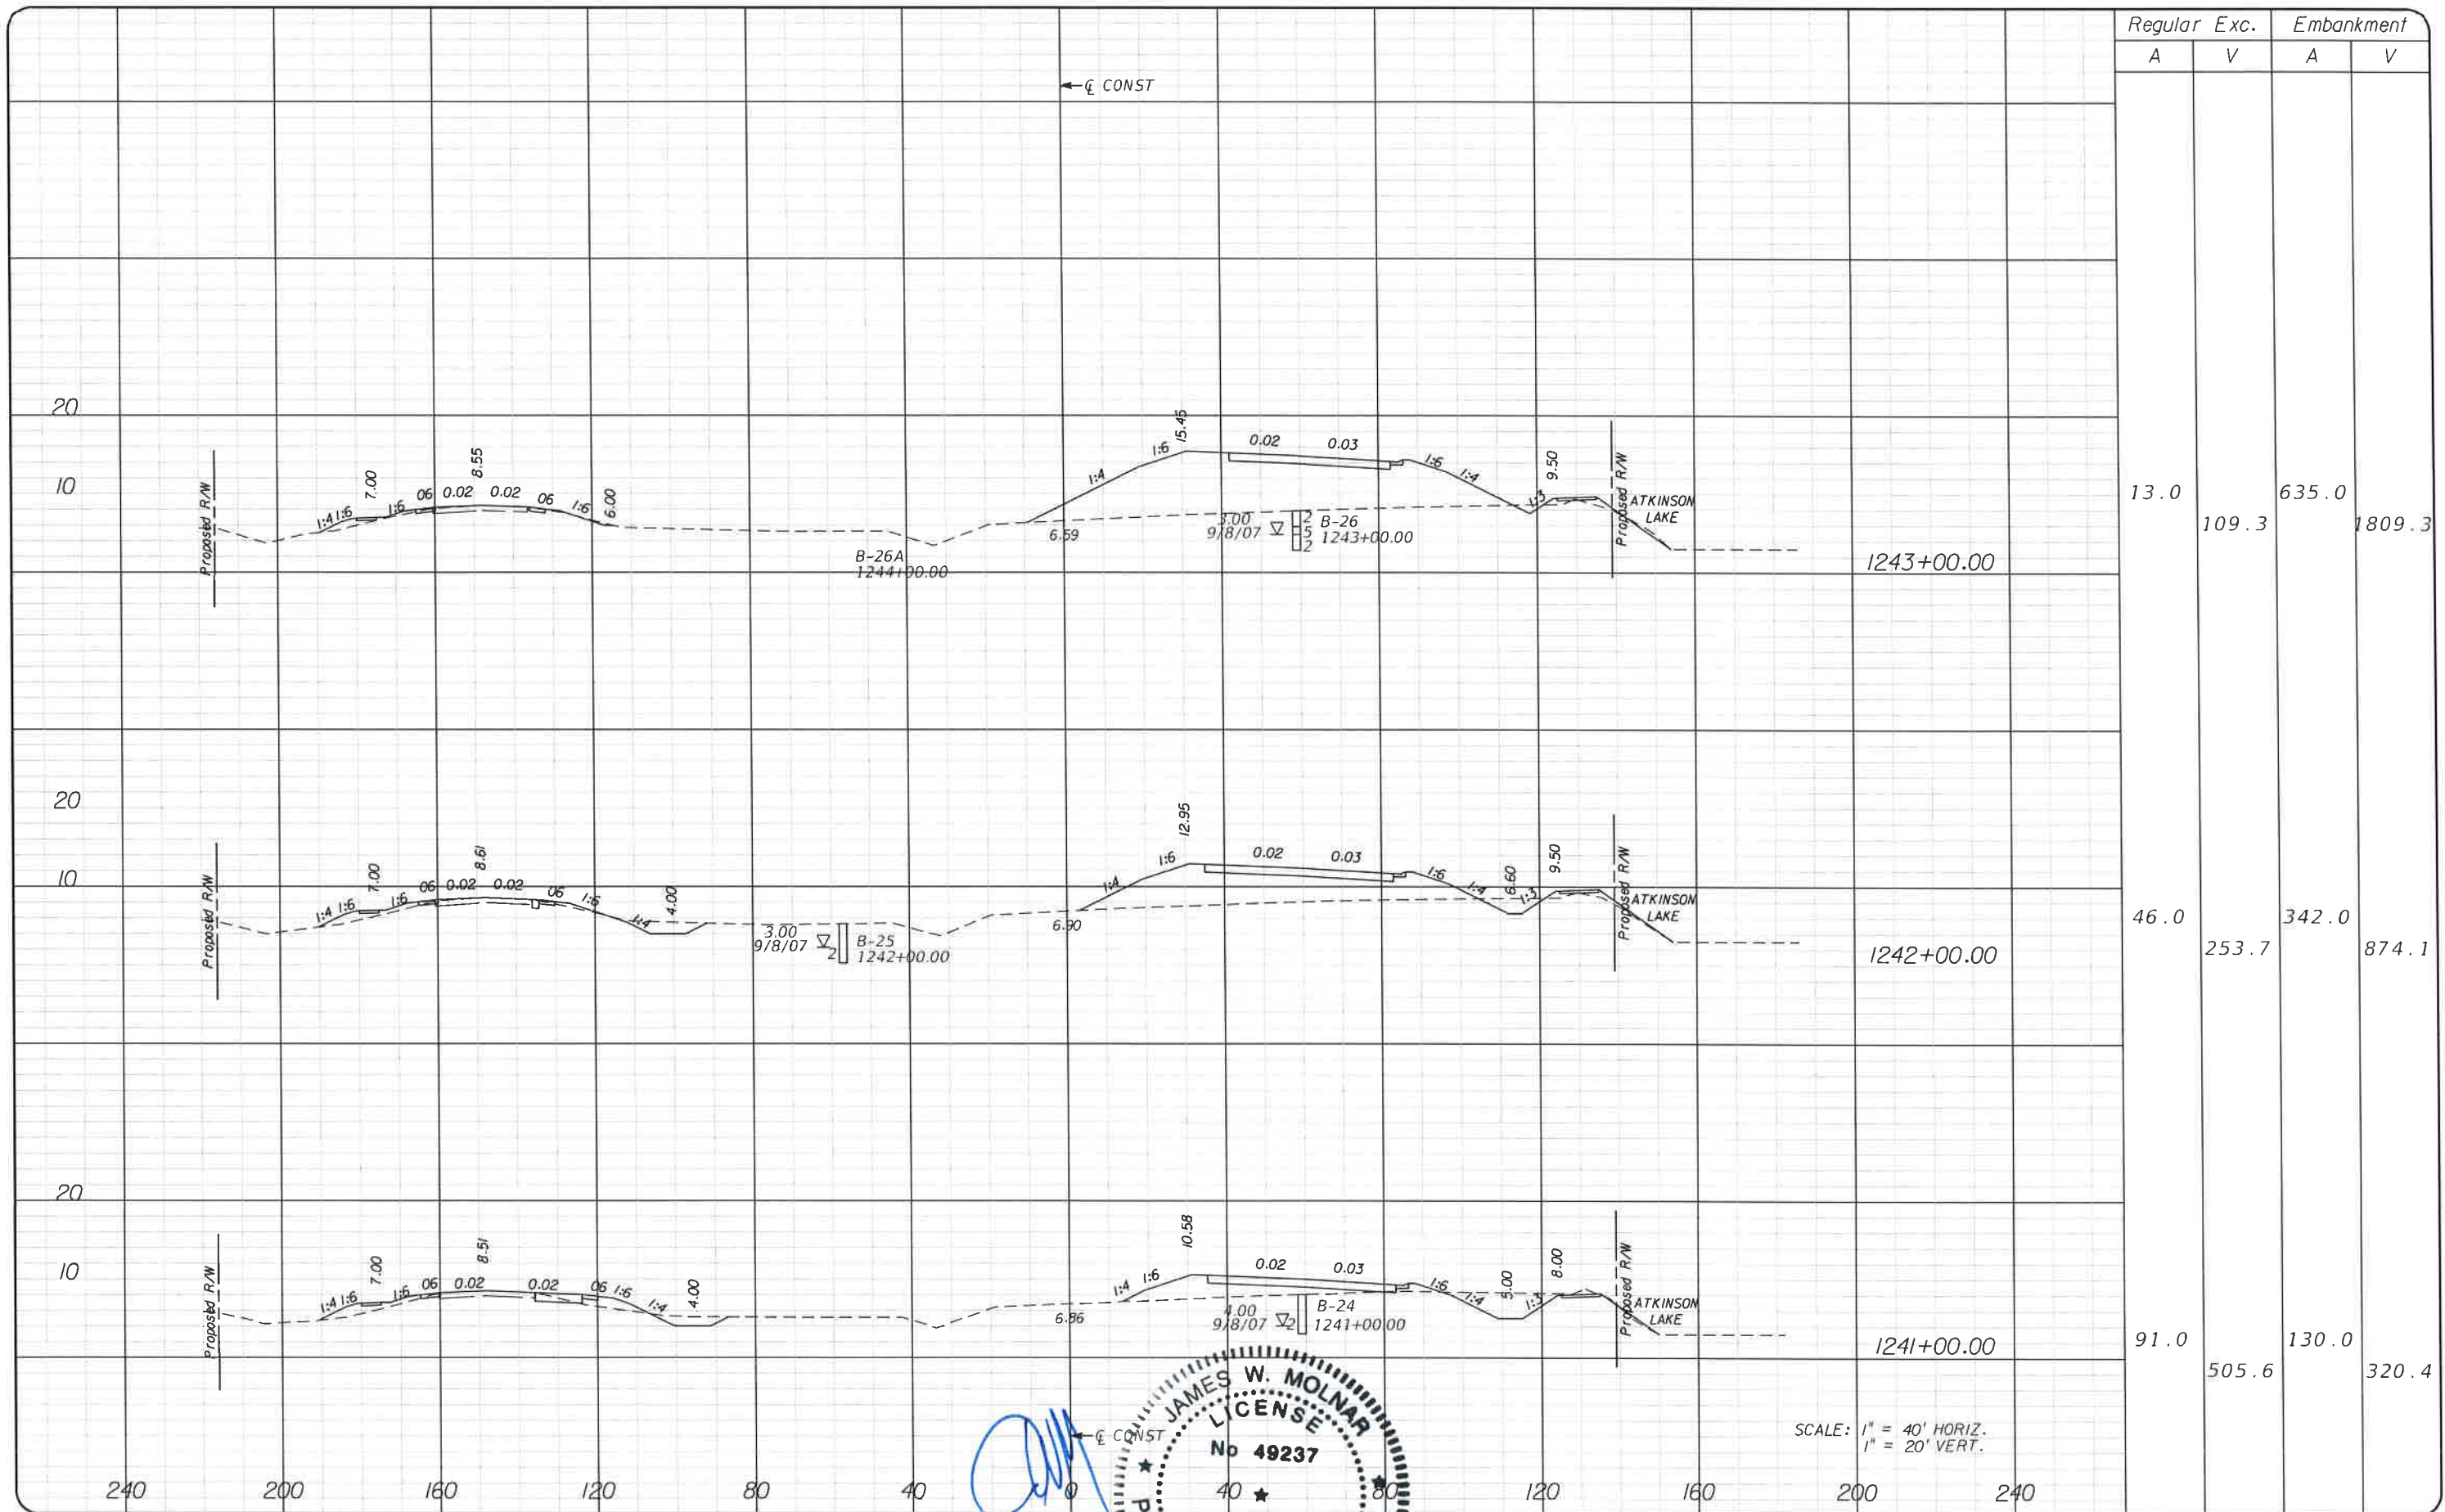

APPROVED BY: **JAMES W. MOLNAR, P.E.**
 REGISTERED PROFESSIONAL ENGINEER
 FLORIDA CERTIFICATE NO. 49237
 3-5-2015

SCALE: 1" = 40' HORIZ.
 1" = 20' VERT.


NO.	DATE	BY	REVISIONS - DESCRIPTION

T.Y. LIN INTERNATIONAL
 2400 FIRST STREET
 SUITE 200
 FORT MYERS, FLORIDA 33901
 TEL. (239) 332-4846
 FAX. (239) 332-4798
 WWW.TYLIN.COM

DEPARTMENT of TRANSPORTATION
 COUNTY OF LEWIS
 FORT MYERS, FLORIDA 33901
 (239) 479-8900 www.lee-county.com/publicworks/rdoffice.htm

CROSS SECTIONS
BURNT STORE ROAD

SHEET NO.
 67

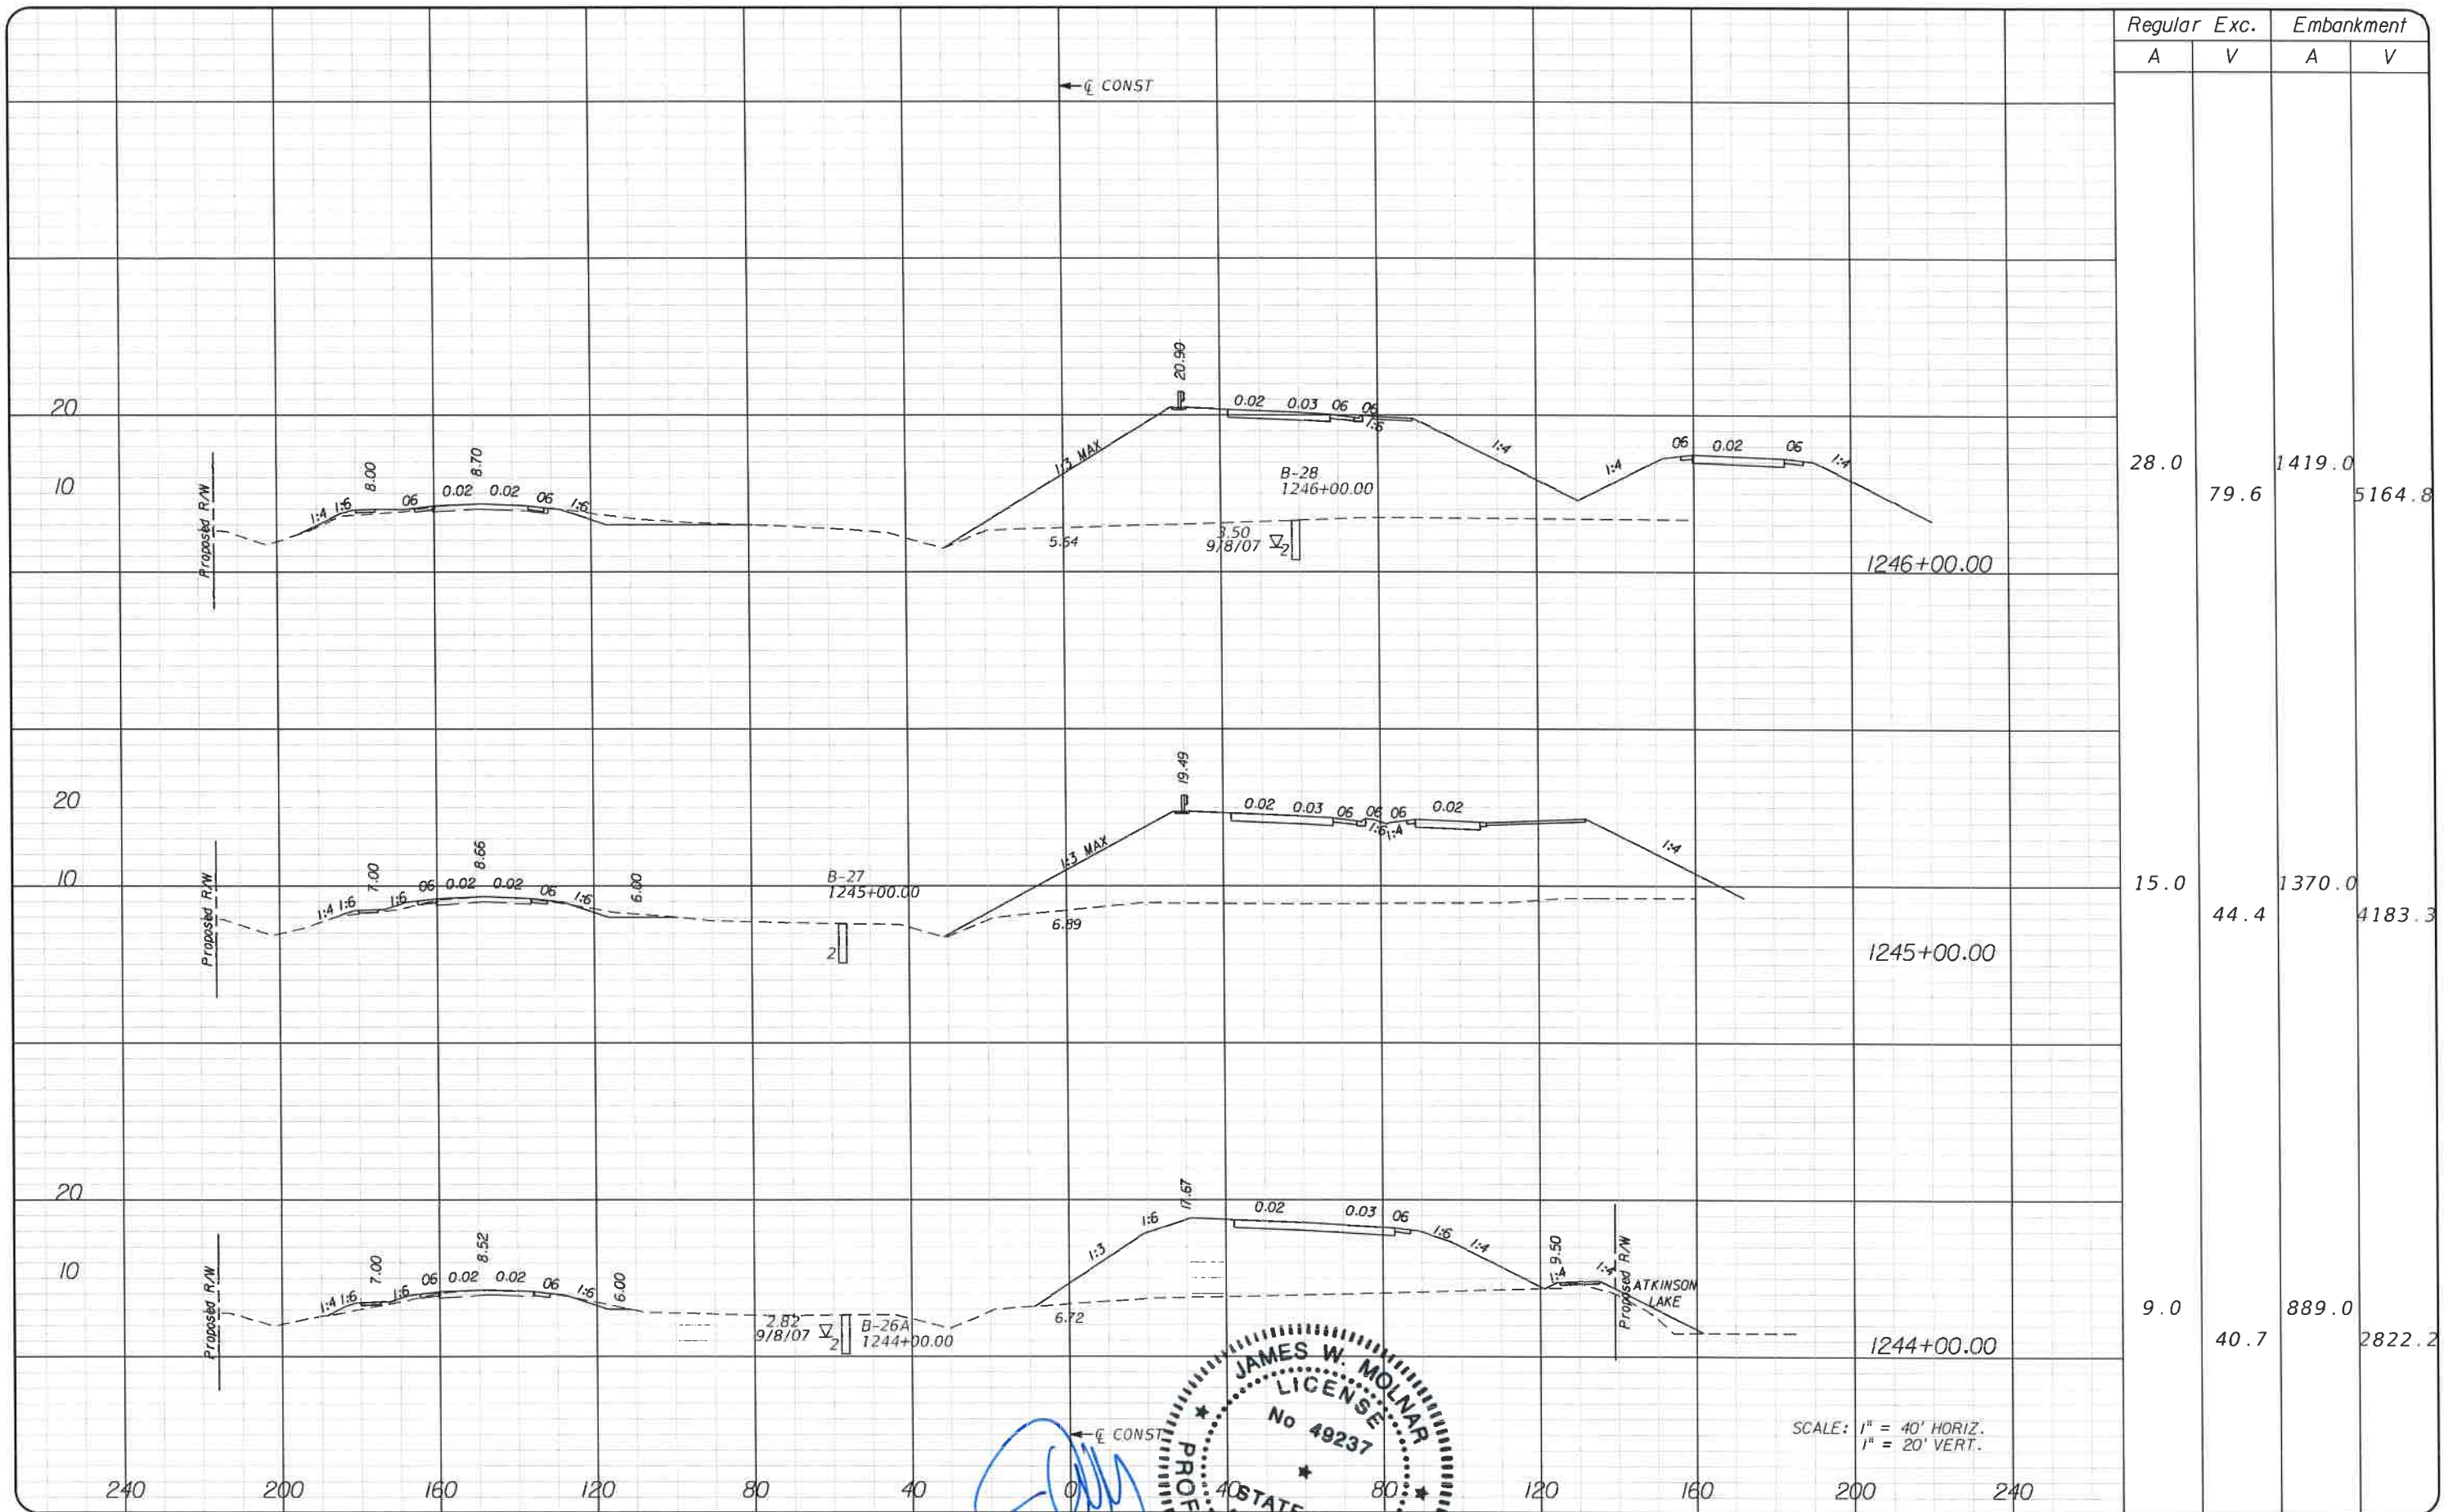

Regular		Exc.		Embankment	
A	V	A	V	A	V
28.0	79.6	1419.0		5164.8	
15.0	44.4	1370.0		4183.3	
9.0	40.7	889.0		2822.2	

SCALE: 1" = 40' HORIZ.
1" = 20' VERT.

← CONST



NO.	DATE	BY	REVISIONS - DESCRIPTION


T.Y. LIN INTERNATIONAL
2400 FIRST STREET
SUITE 200
FORT MYERS, FLORIDA 33901
TEL. (239) 332-4846
FAX. (239) 332-4798
WWW.TYLIN.COM

APPROVED BY
JAMES W. MOLNAR, P.E.
REGISTERED PROFESSIONAL ENGINEER
FLORIDA CERTIFICATE NO. 49237
3-5-2015

DEPARTMENT
of
TRANSPORTATION
FORT MYERS, FLORIDA 33901
1300 MONROE STREET
www.fdot.com

CROSS SECTIONS
BURNT STORE ROAD

SHEET
NO.
68

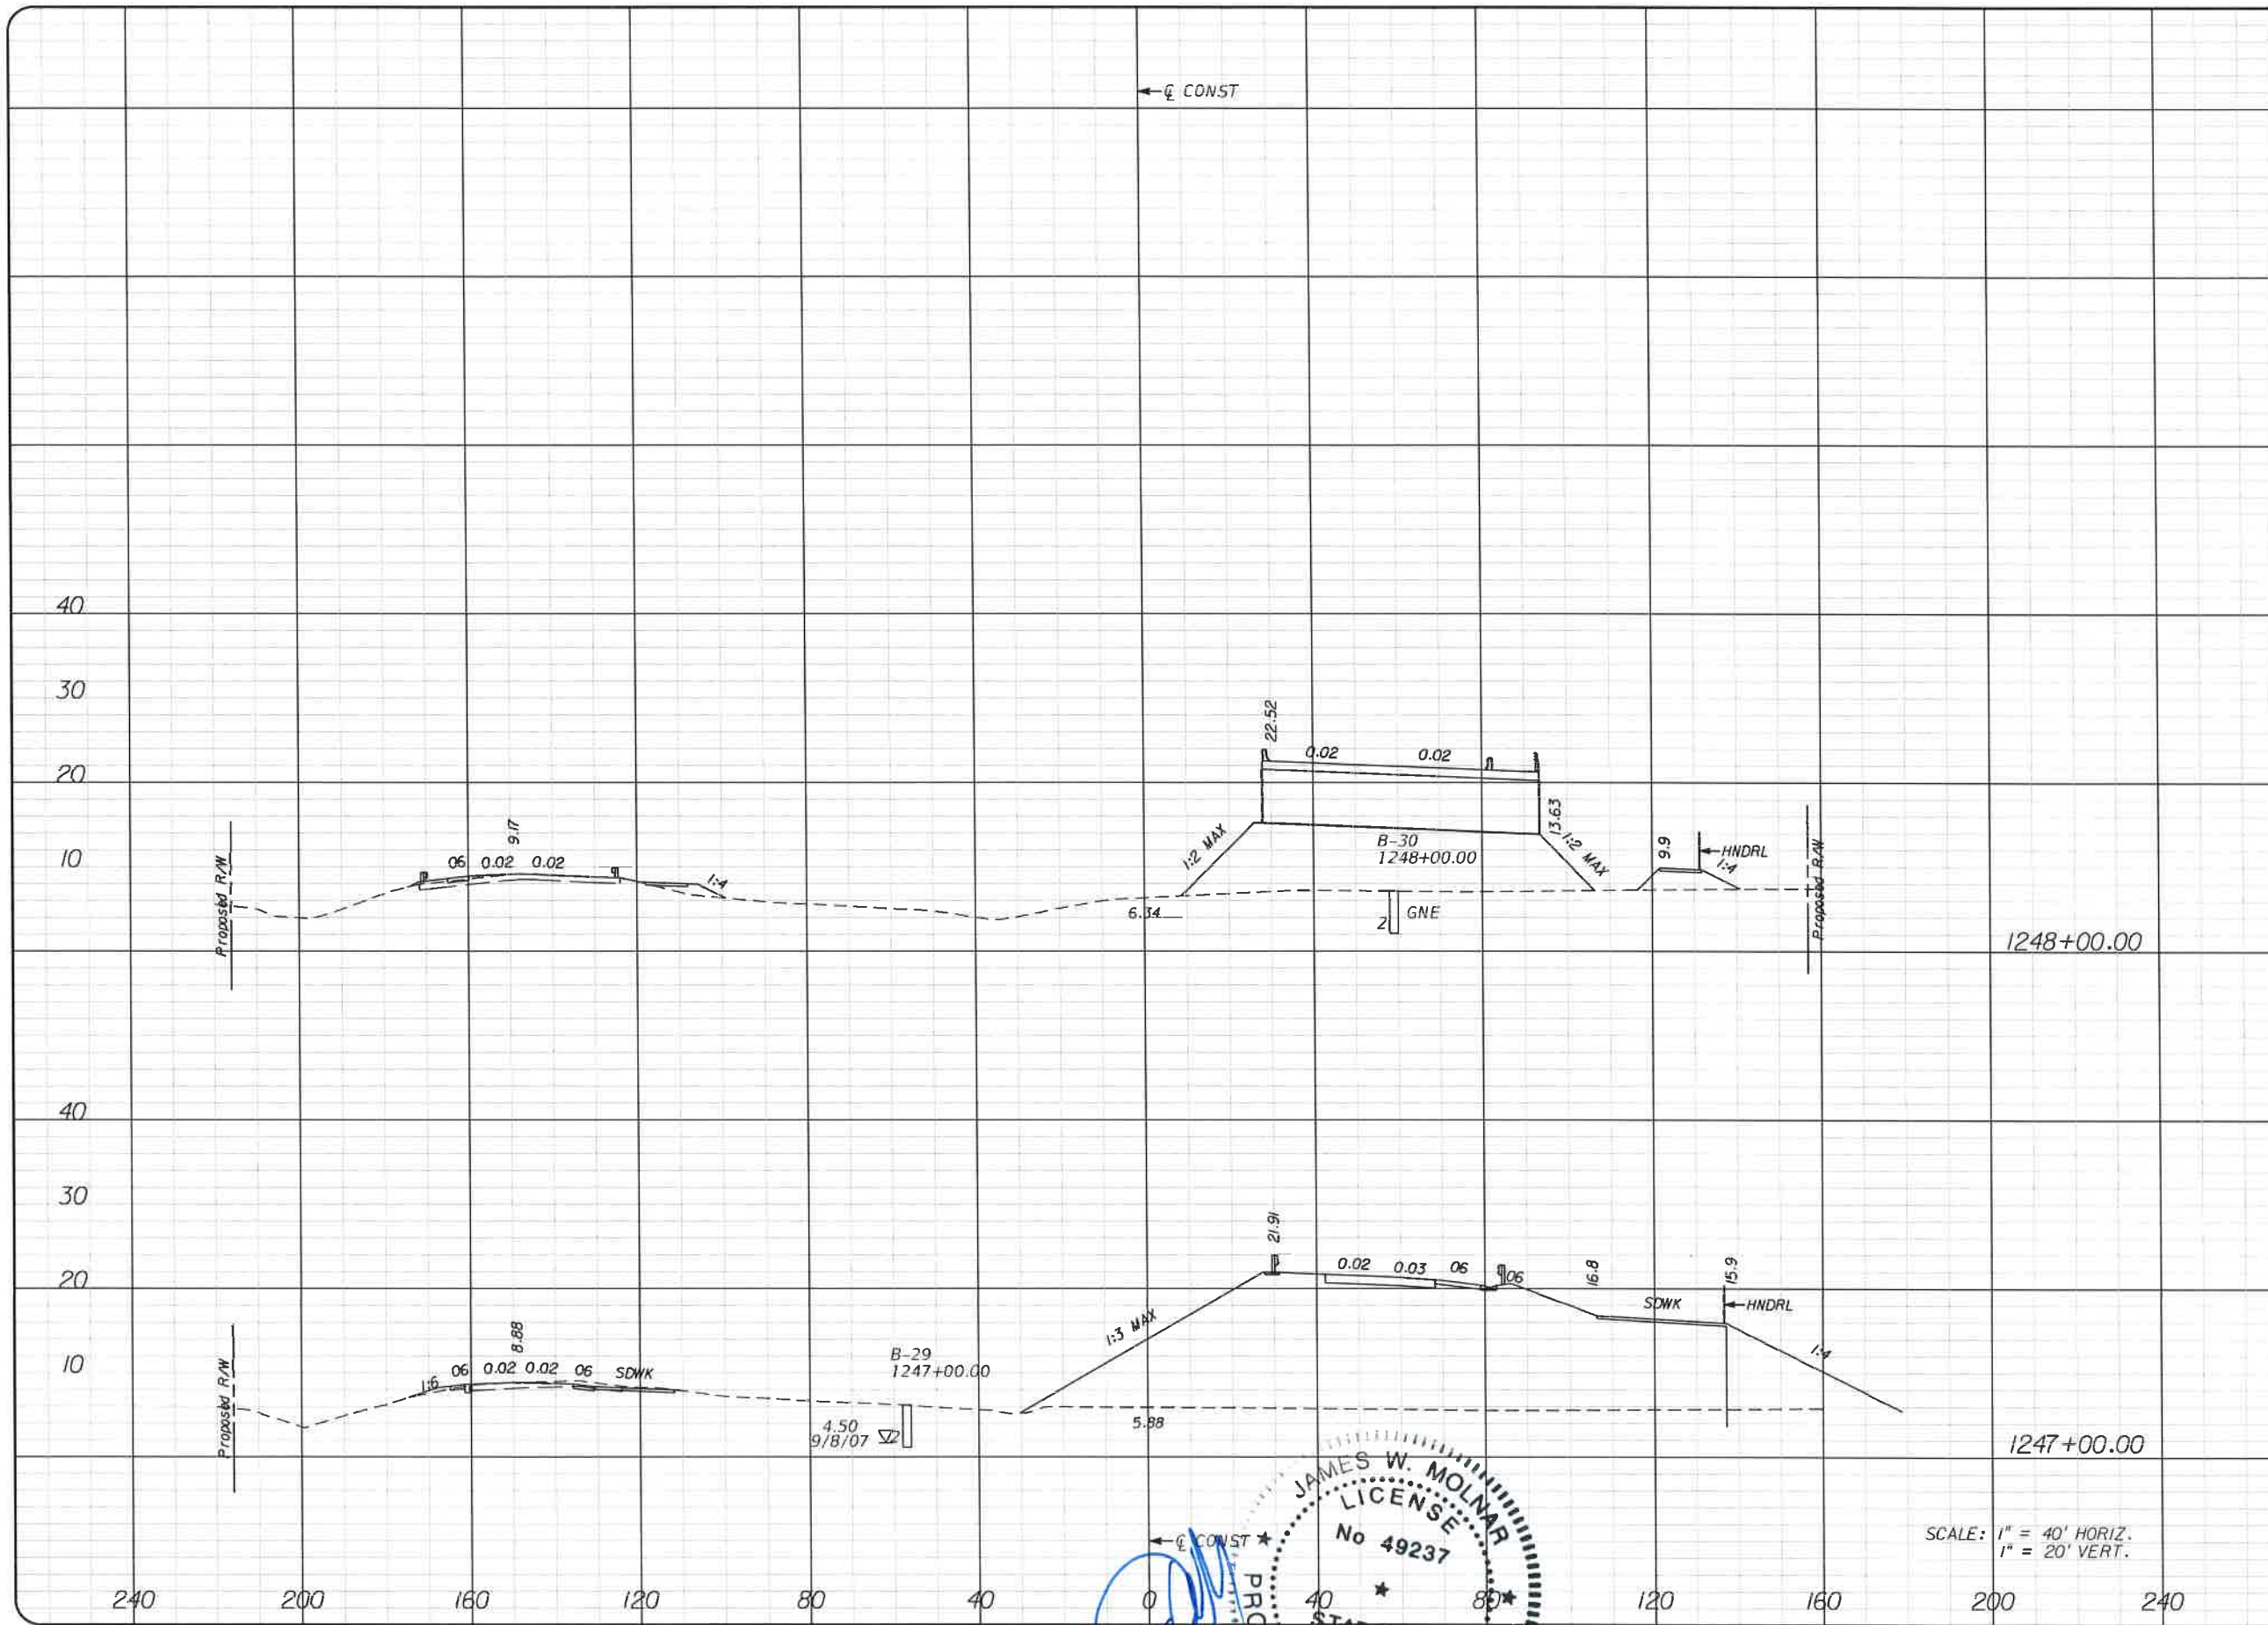

Regular		Exc.		Embankment	
A	V	A	V	A	V
2.0	38.5	640.0		5316.8	
19.0	87.0	2258.0		6809.3	

SCALE: 1" = 40' HORIZ.
1" = 20' VERT.

NO.	DATE	BY	REVISIONS - DESCRIPTION

T.Y. LIN INTERNATIONAL
2400 FIRST STREET
SUITE 200
FORT MYERS, FLORIDA 33901
TEL. (239) 332-4846
FAX. (239) 332-4798
WWW.TY.LIN.COM


APPROVED BY:
JAMES W. MOLNAR, P.E.
REGISTERED PROFESSIONAL ENGINEER
FLORIDA CERTIFICATE NO. 49237
3-5-2015

STATE OF FLORIDA
DEPARTMENT of TRANSPORTATION
FORT MYERS, FLORIDA 33901
12391 479-8900 www.lee-county.com/publicworks/dotfile.htm

CROSS SECTIONS
BURNT STORE ROAD

SHEET NO.
69



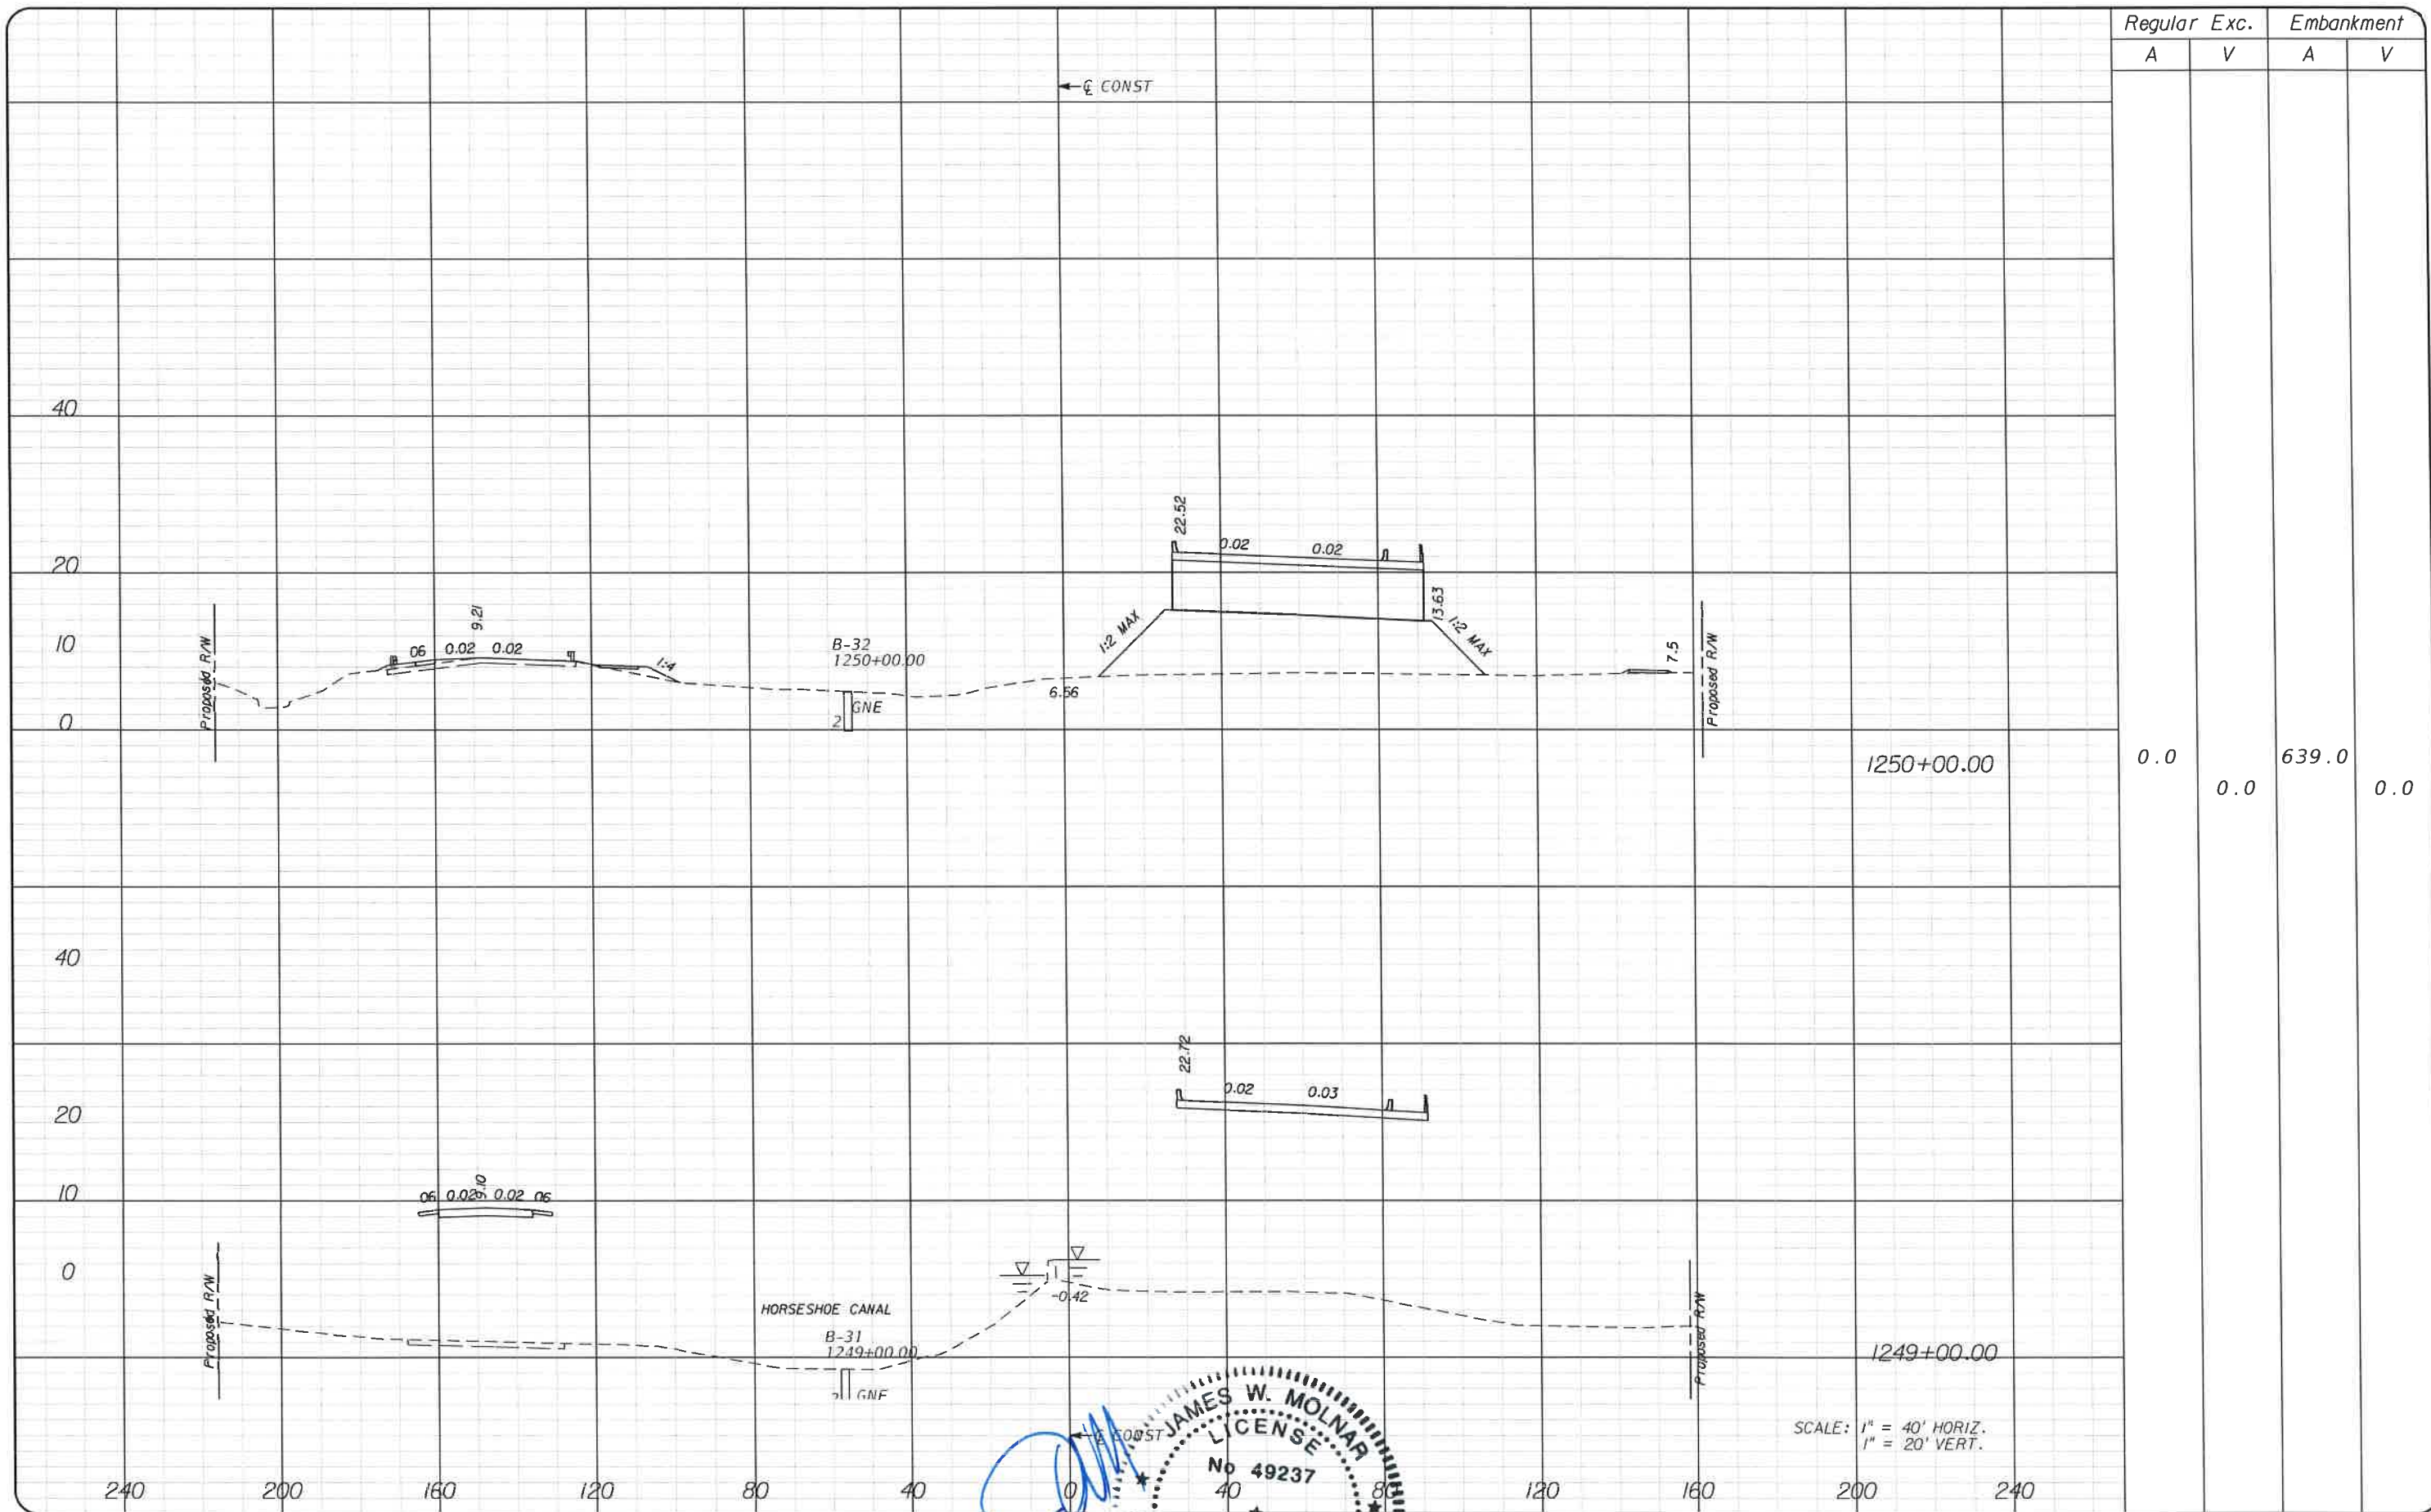

Regular		Exc.		Embankment	
A	V	A	V	A	V
0.0	0.0	0.0	0.0	639.0	0.0

SCALE: 1" = 40' HORIZ.
1" = 20' VERT.

NO.	DATE	BY	REVISIONS - DESCRIPTION

T.Y. LIN INTERNATIONAL
2400 FIRST STREET
SUITE 200
FORT MYERS, FLORIDA 33901
TEL. (239) 332-4846
FAX. (239) 332-4798
WWW.TYLIN.COM


APPROVED BY:
JAMES W. MOLNAR, P.E.
REGISTERED PROFESSIONAL ENGINEER
FLORIDA CERTIFICATE NO. 49237
3-5-2015

JAMES W. MOLNAR
LICENSE
No 49237

STATE OF FLORIDA
PUBLIC WORKS
LEEE COUNTY
DEPARTMENT
of
TRANSPORTATION
FORT MYERS, FLORIDA 33901
MONROE STREET
TEL. (239) 479-8900 www.lee-county.com/publicworks/delittle.htm


CROSS SECTIONS
BURNT STORE ROAD

SHEET
NO.
70

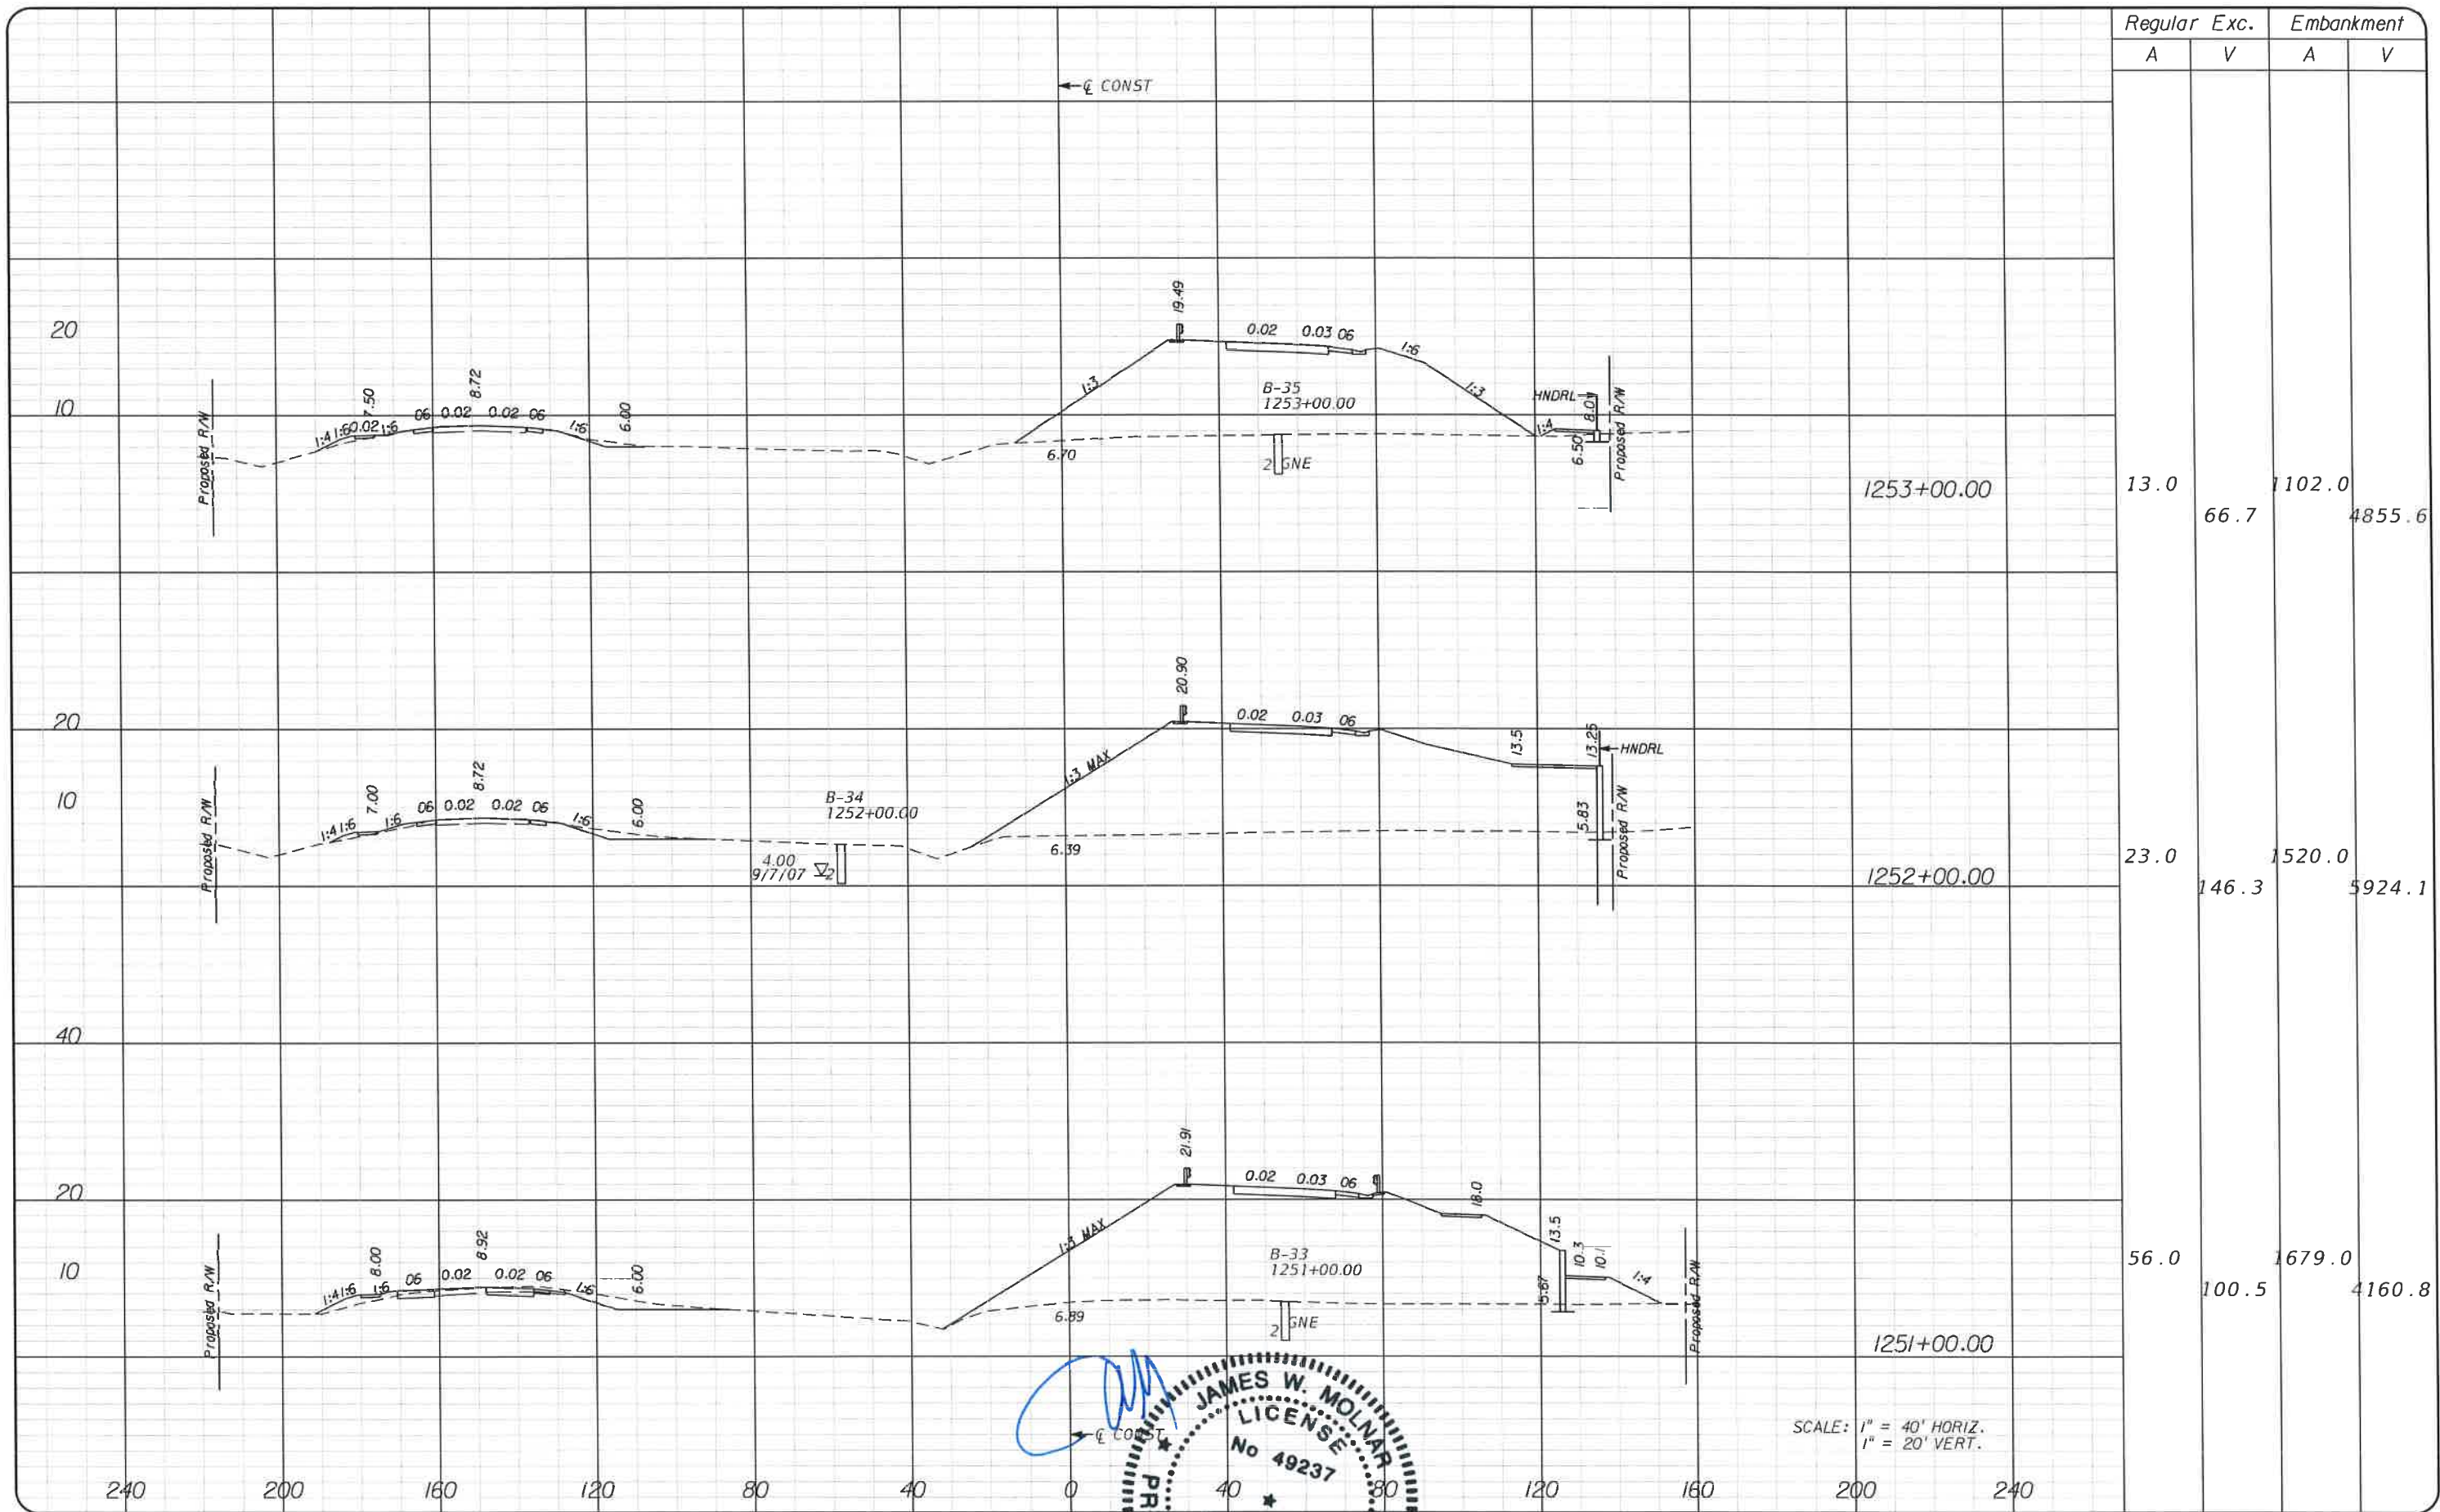

Regular		Exc.		Embankment	
A	V	A	V	A	V
13.0	66.7	102.0	4855.6		
23.0	146.3	1520.0	5924.1		
56.0	100.5	1679.0	4160.8		

SCALE: 1" = 40' HORIZ.
1" = 20' VERT.

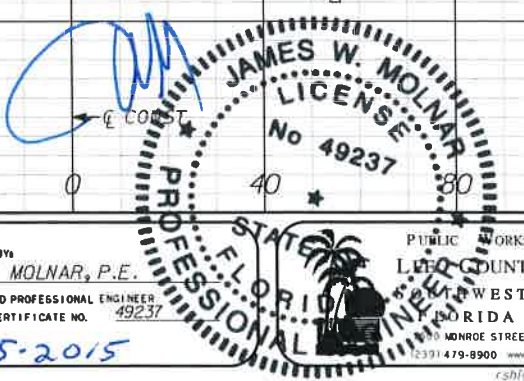

NO.	DATE	BY	REVISIONS - DESCRIPTION


T.Y. LIN INTERNATIONAL
2400 FIRST STREET
SUITE 200
FORT MYERS, FLORIDA 33901
TEL. (239) 332-4846
FAX. (239) 332-4798
WWW.TYLIN.COM

APPROVED BY:
JAMES W. MOLNAR, P.E.
REGISTERED PROFESSIONAL ENGINEER
FLORIDA CERTIFICATE NO. 49237
3-5-2015

FLORIDA DEPARTMENT OF TRANSPORTATION
PUBLIC WORKS
LEWIS COUNTY
WEST FLORIDA
MONROE STREET
FORT MYERS, FLORIDA 33901

CROSS SECTIONS
BURNT STORE ROAD

SHEET NO.
71

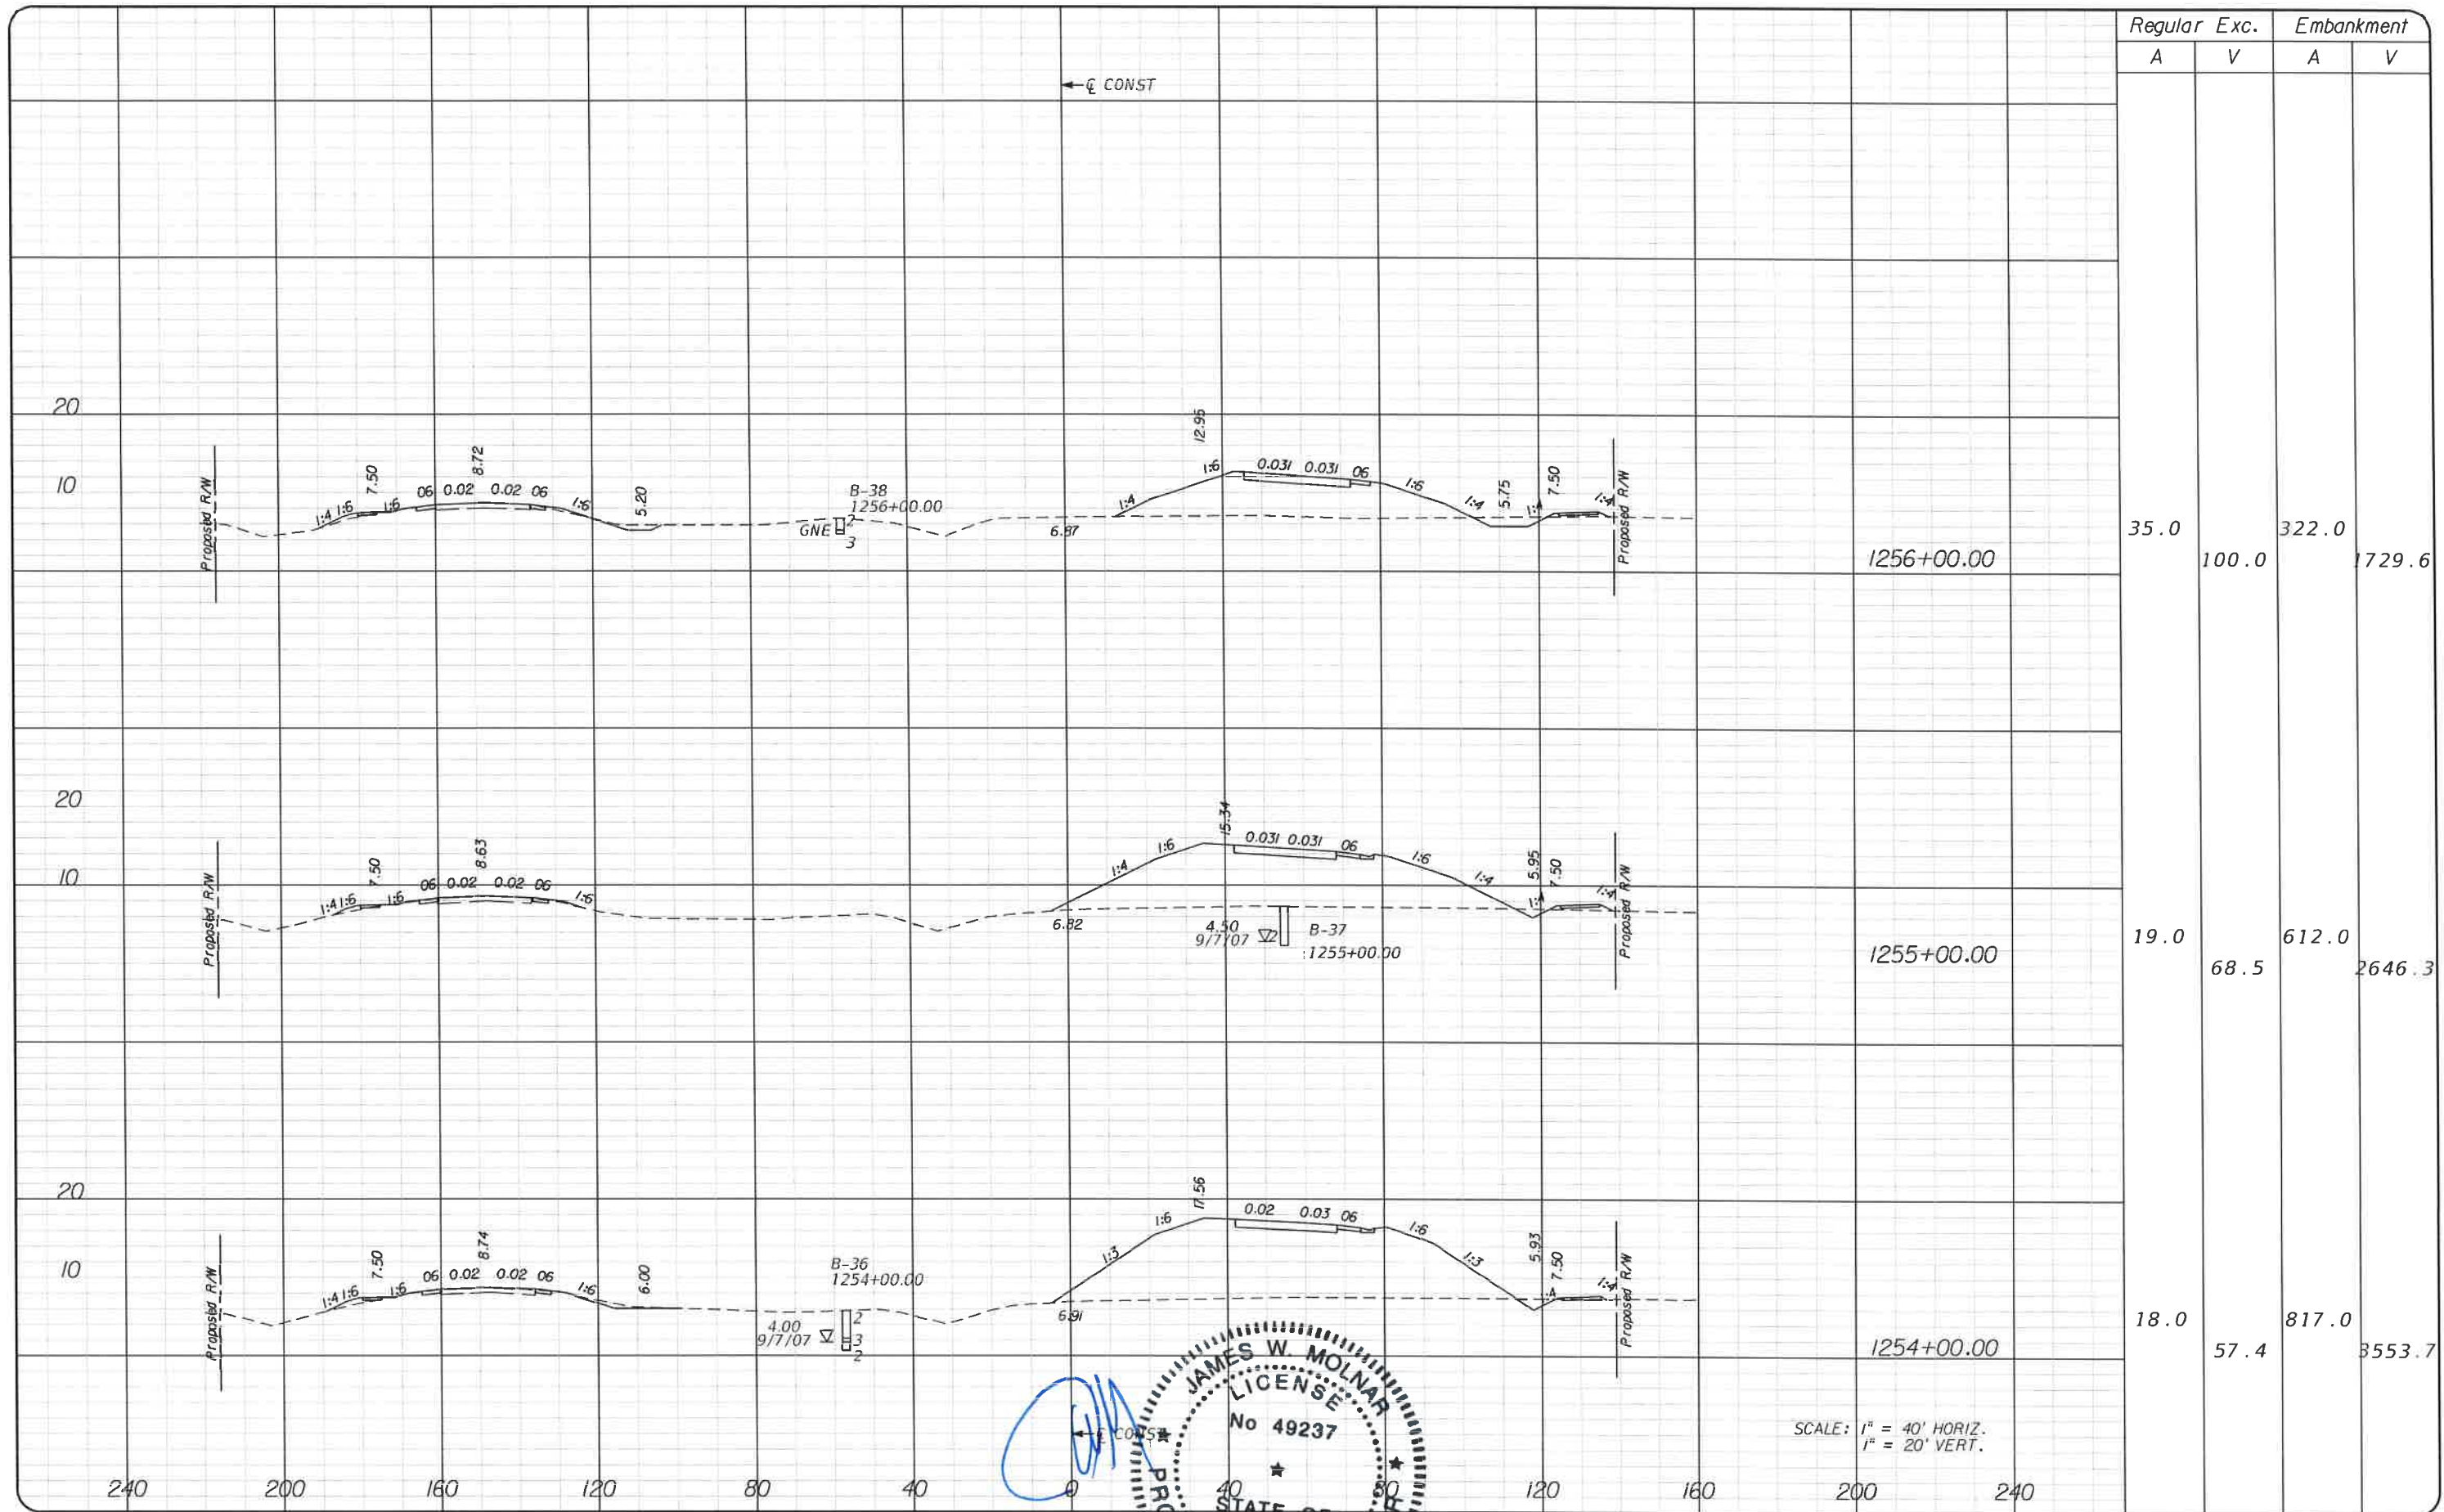

	Regular		Exc.		Embankment	
	A	V	A	V	A	V
1256+00.00	35.0	100.0	322.0		1729.6	
1255+00.00	19.0	68.5	612.0		2646.3	
1254+00.00	18.0	57.4	817.0		3553.7	

SCALE: 1" = 40' HORIZ.
1" = 20' VERT.



NO.	DATE	BY	REVISIONS - DESCRIPTION


T.Y. LIN INTERNATIONAL
2400 FIRST STREET
SUITE 200
FORT MYERS, FLORIDA 33901
TEL. (239) 332-4846
FAX. (239) 332-4798
WWW.TYLIN.COM

APPROVED BY
JAMES MOLNAR, P.E.
REGISTERED PROFESSIONAL ENGINEER
FLORIDA CERTIFICATE NO. 49237
3-5-2015

DEPARTMENT
of
TRANSPORTATION
FORT MYERS, FLORIDA 33901
1500 MONROE STREET
12391 479-8900 www.fee-county.com/publicworks/dot/leilc.htm

CROSS SECTIONS
BURNT STORE ROAD

SHEET
NO.
72

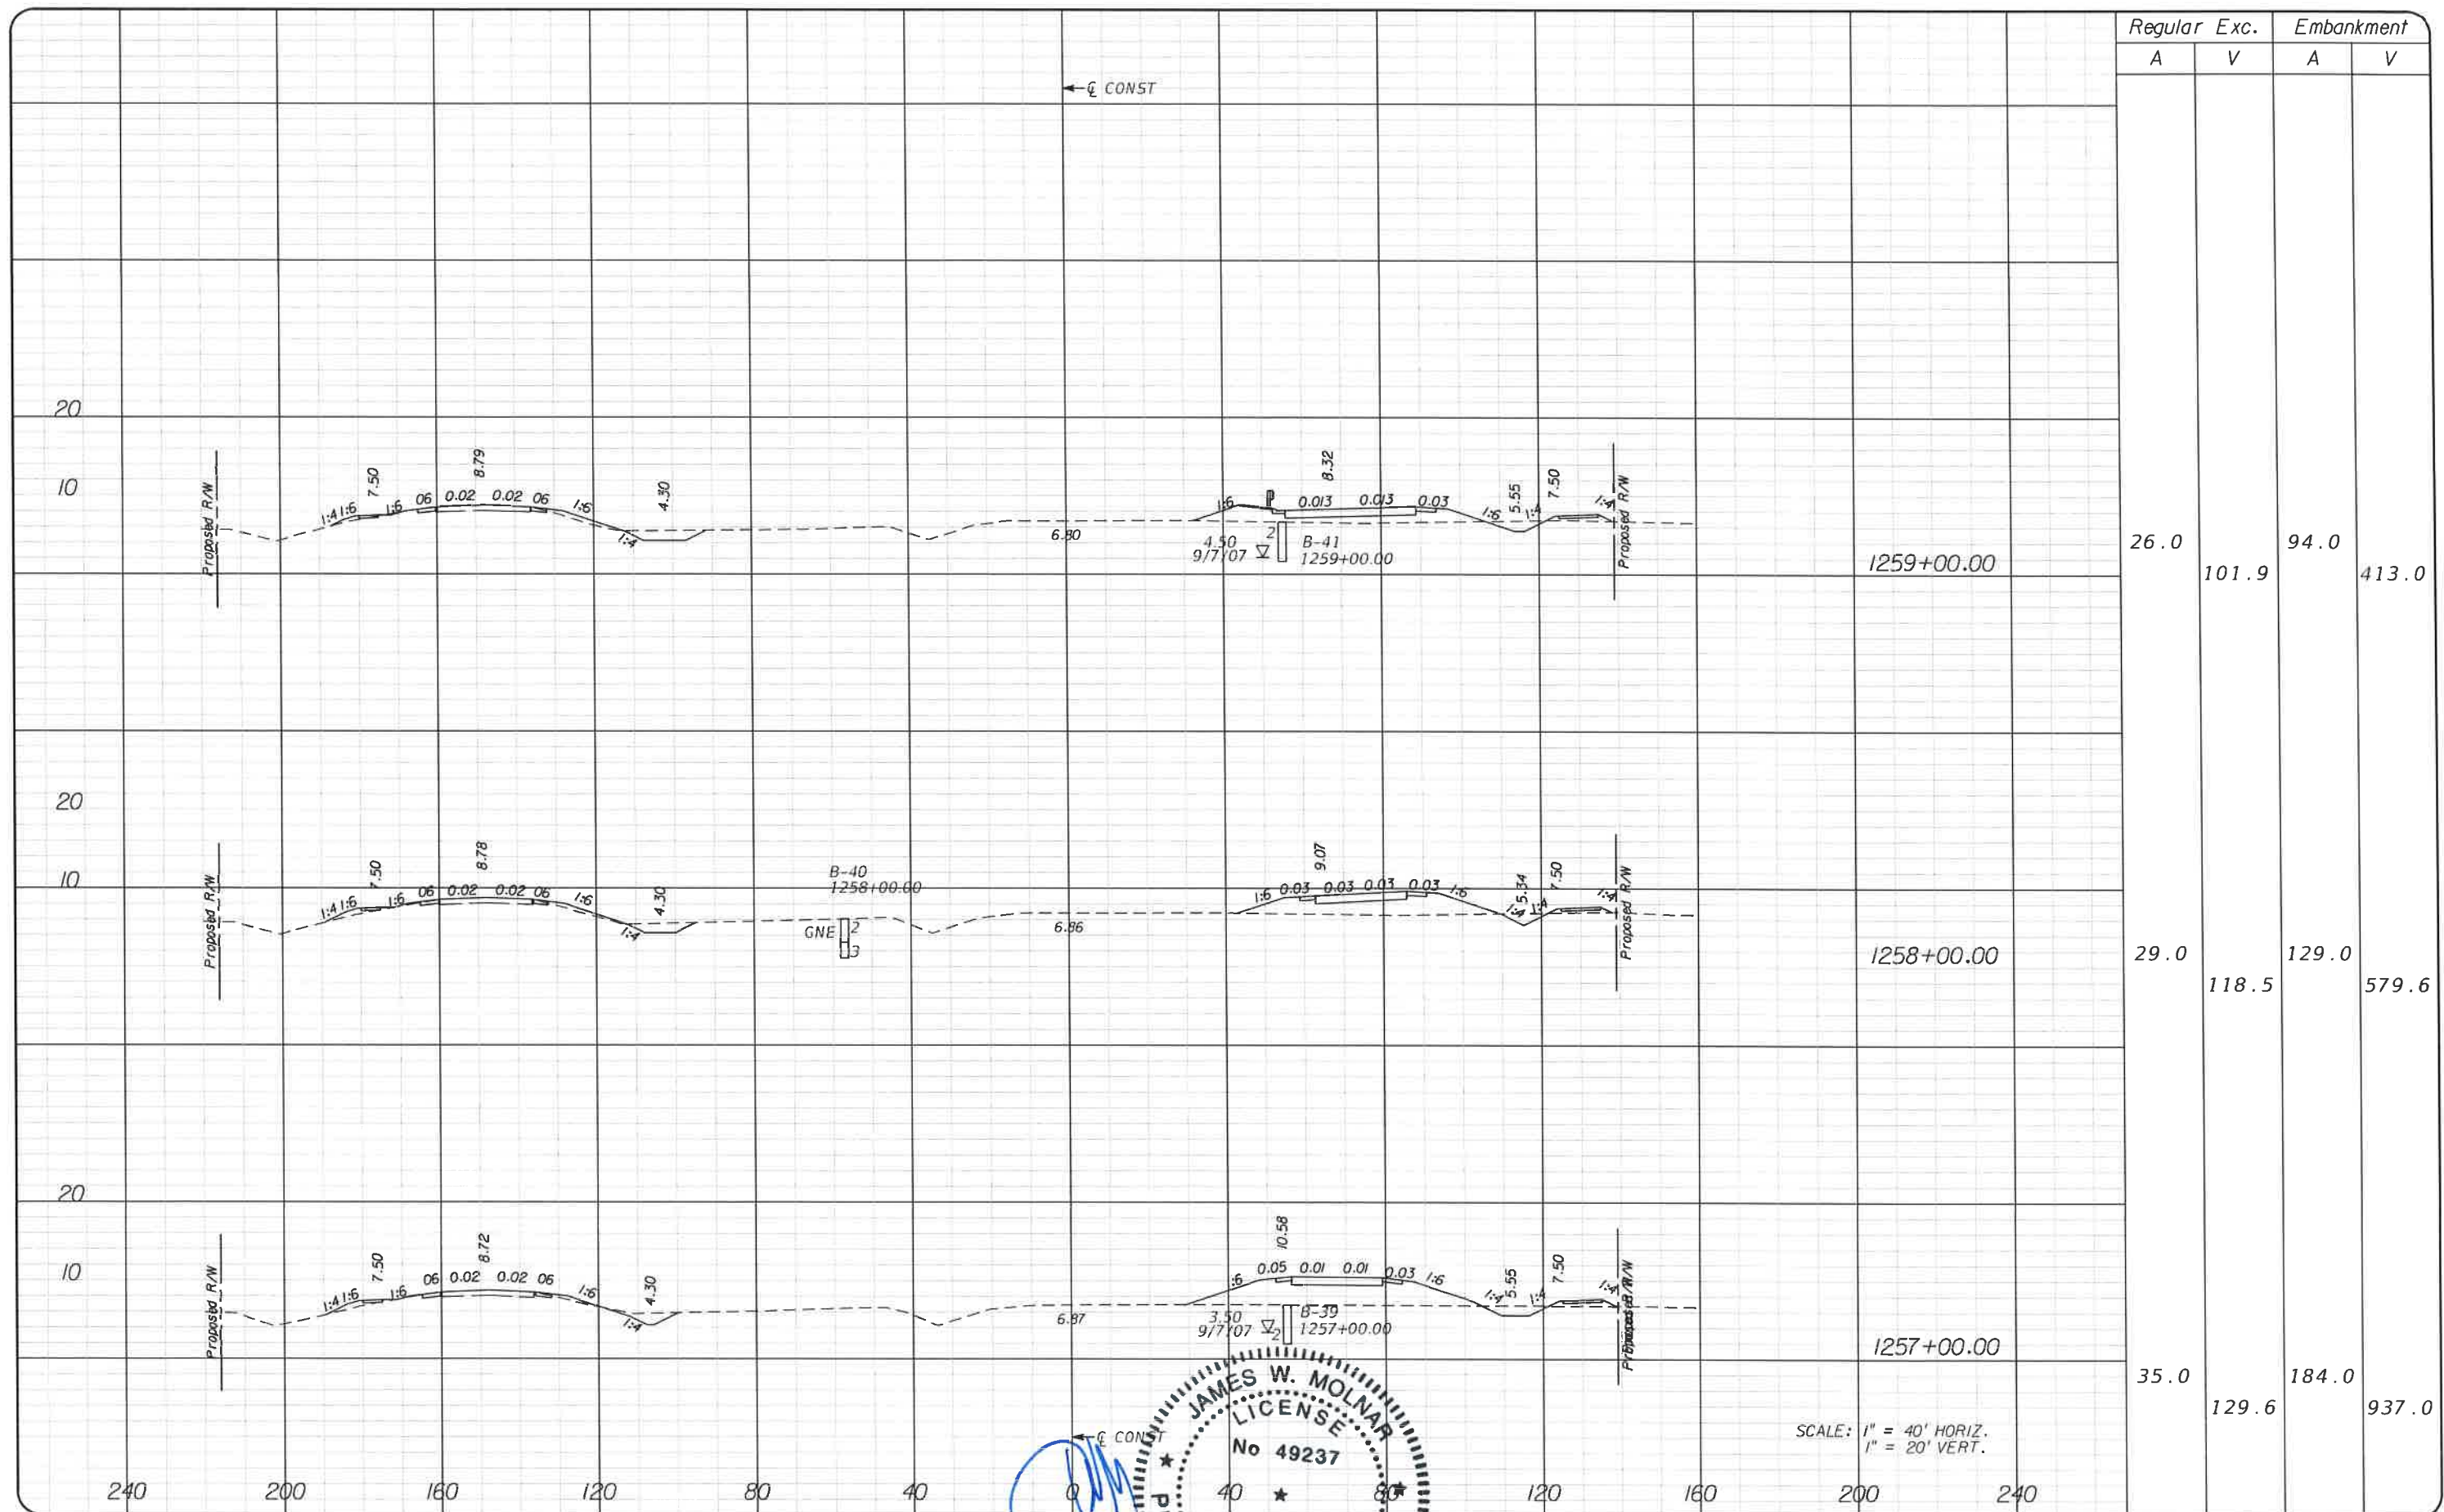

Regular		Exc.		Embankment	
A	V	A	V	A	V
26.0	101.9	94.0	413.0		
29.0	118.5	129.0	579.6		
35.0	129.6	184.0	937.0		

SCALE: 1" = 40' HORIZ.
1" = 20' VERT.

NO.	DATE	BY	REVISIONS - DESCRIPTION


T.Y. LIN INTERNATIONAL
2400 FIRST STREET
SUITE 200
FORT MYERS, FLORIDA 33901
TEL. (239) 332-4846
FAX. (239) 332-4798
WWW.TYLIN.COM

APPROVED BY
JAMES W. MOLNAR, P.E.
REGISTERED PROFESSIONAL ENGINEER
FLORIDA CERTIFICATE NO. 49237
3-5-2015

STATE OF FLORIDA
DEPARTMENT OF TRANSPORTATION
FORT MYERS, FLORIDA 33901


CROSS SECTIONS
BURNT STORE ROAD

SHEET NO.
73

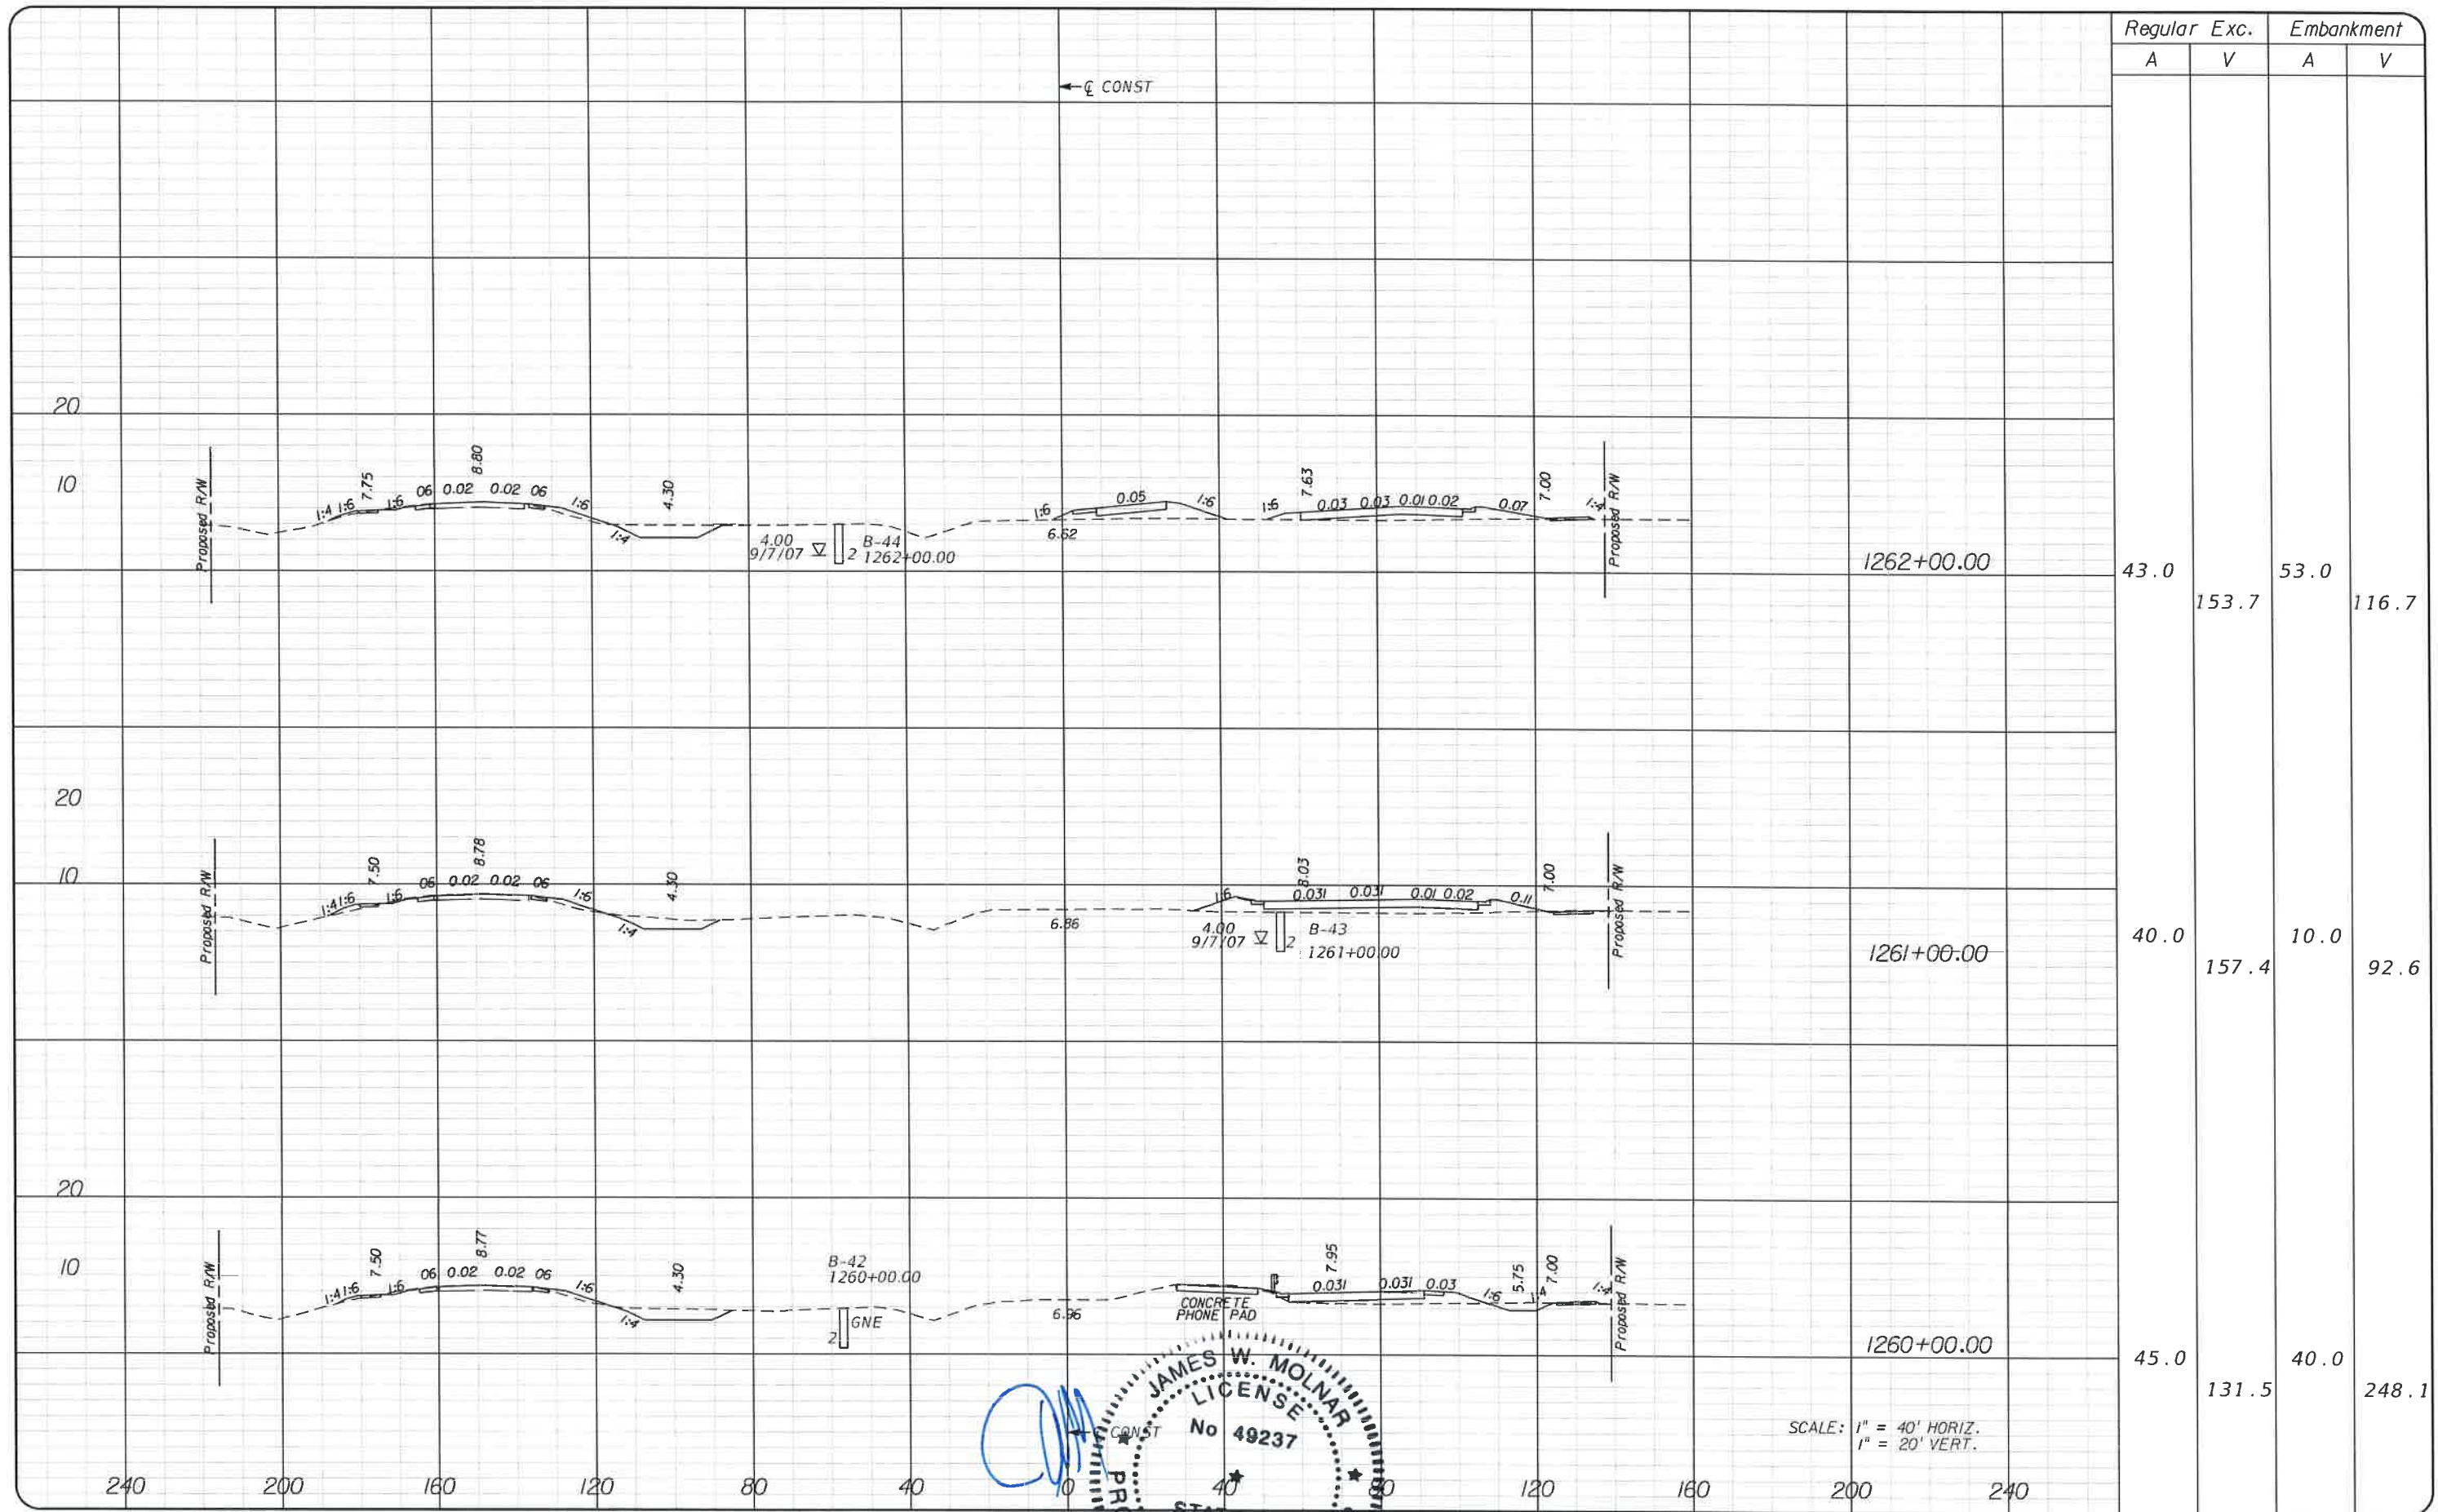

Regular		Exc.		Embankment	
A	V	A	V	A	V
43.0	153.7	53.0	116.7		
40.0	157.4	10.0	92.6		
45.0	131.5	40.0	248.1		

SCALE: 1" = 40' HORIZ.
1" = 20' VERT.

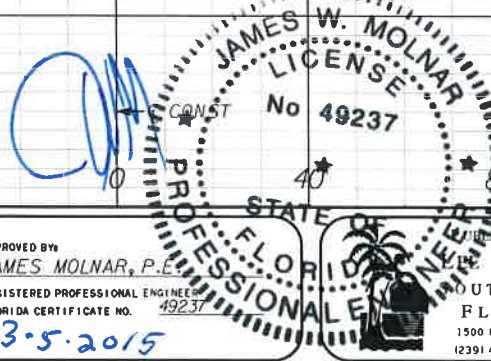

NO.	DATE	BY	REVISIONS - DESCRIPTION


T.Y. LIN INTERNATIONAL
2400 FIRST STREET
SUITE 200
FORT MYERS, FLORIDA 33901
TEL. (239) 332-4846
FAX. (239) 332-4798
WWW.TYLIN.COM

APPROVED BY:
JAMES W. MOLNAR, P.E.
REGISTERED PROFESSIONAL ENGINEER
FLORIDA CERTIFICATE NO. 49237
3.5.2015

PUBLIC WORKS
LEEE COUNTY
DEPARTMENT
of
TRANSPORTATION
SOUTHWEST
FLORIDA
1500 MONROE STREET
FORT MYERS, FLORIDA 33901
(239) 479-8900 www.leecounty.com/publicworks/default.htm

CROSS SECTIONS
BURNT STORE ROAD

SHEET NO.
74

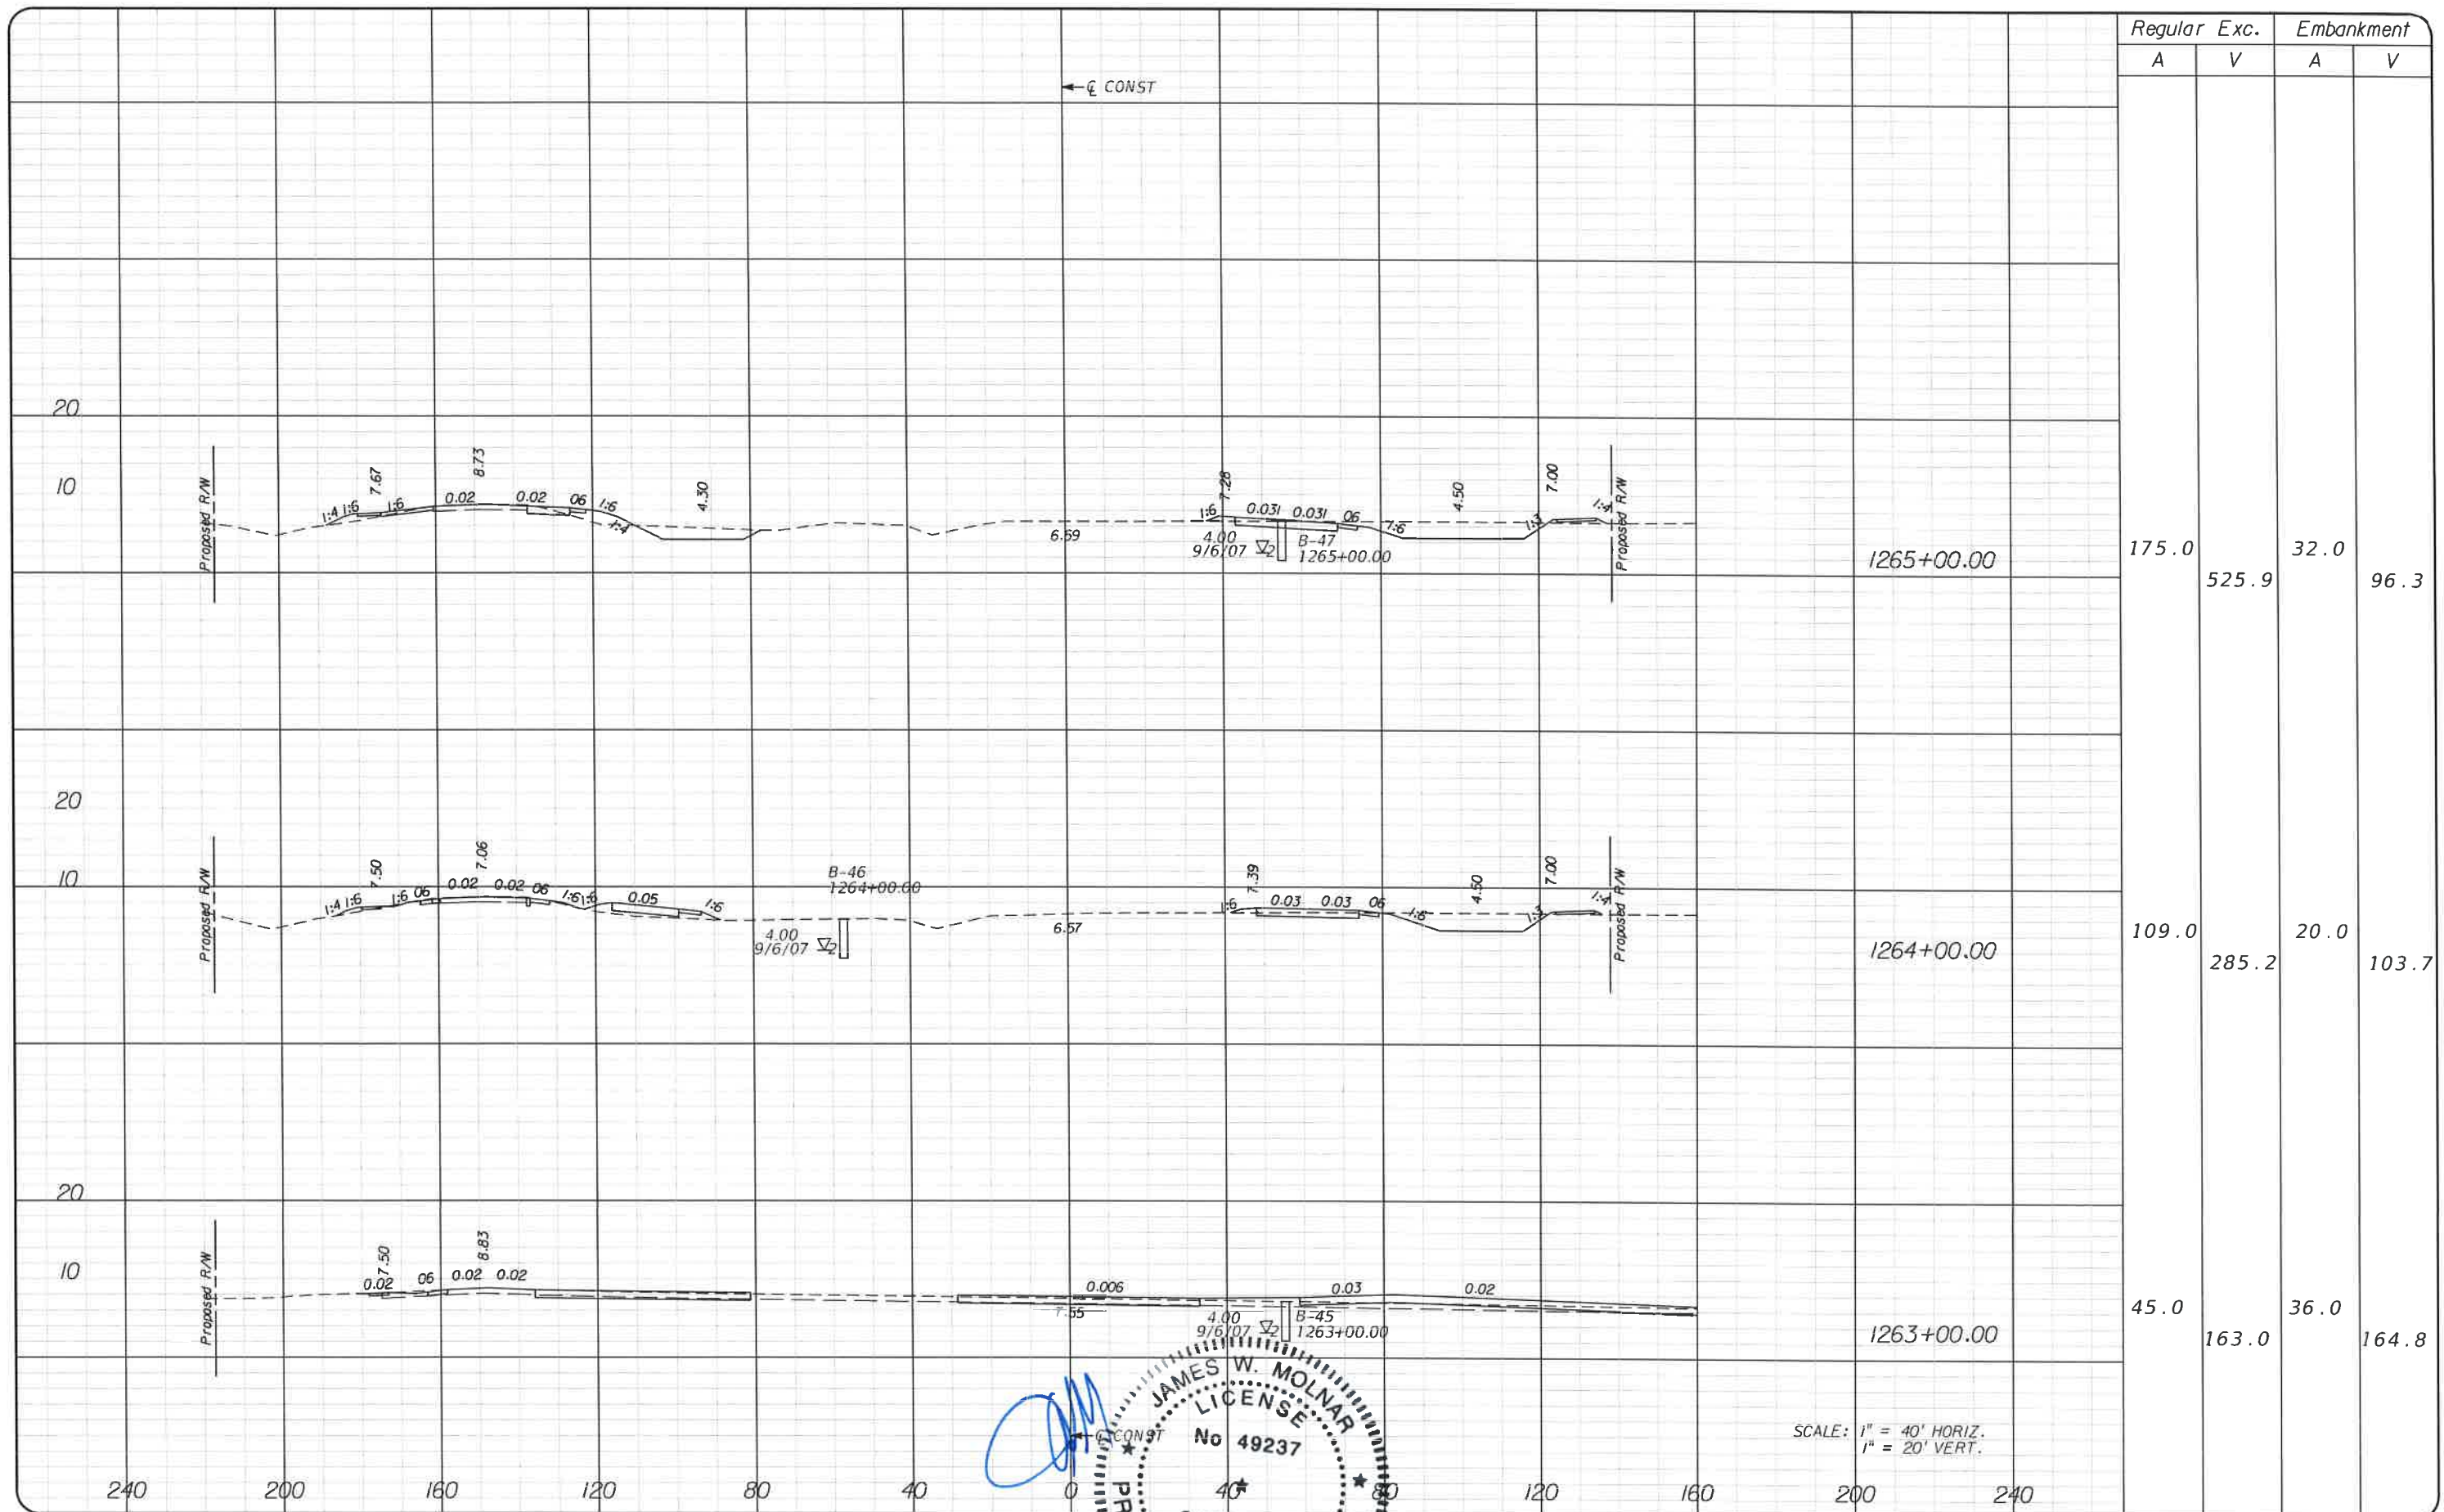

Station	Regular		Exc.		Embankment	
	A	V	A	V	A	V
1265+00.00	175.0	525.9	32.0	96.3		
1264+00.00	109.0	285.2	20.0	103.7		
1263+00.00	45.0	163.0	36.0	164.8		

APPROVED BY: JAMES W. MOLNAR, P.E.
 REGISTERED PROFESSIONAL ENGINEER
 FLORIDA CERTIFICATE NO. 49237
 3-5-2015

SCALE: 1" = 40' HORIZ.
1" = 20' VERT.


NO.	DATE	BY	REVISIONS - DESCRIPTION

T.Y. LIN INTERNATIONAL
 2400 FIRST STREET
 SUITE 200
 FORT MYERS, FLORIDA 33901
 TEL. (239) 332-4846
 FAX. (239) 332-4798
 WWW.TYLIN.COM

APPROVED BY: JAMES W. MOLNAR, P.E.
 REGISTERED PROFESSIONAL ENGINEER
 FLORIDA CERTIFICATE NO. 49237
 3-5-2015
 PUBLIC WORKS
 COUNTY OF SOUTHWEST FLORIDA
 DEPARTMENT OF TRANSPORTATION
 FORT MYERS, FLORIDA 33901
 (239) 479-8900
 www.fsc-county.com/publicworks/rd/office.htm
 rshields 3/4/2015 5:08:08 PM

CROSS SECTIONS
BURNT STORE ROAD

SHEET NO.
 75

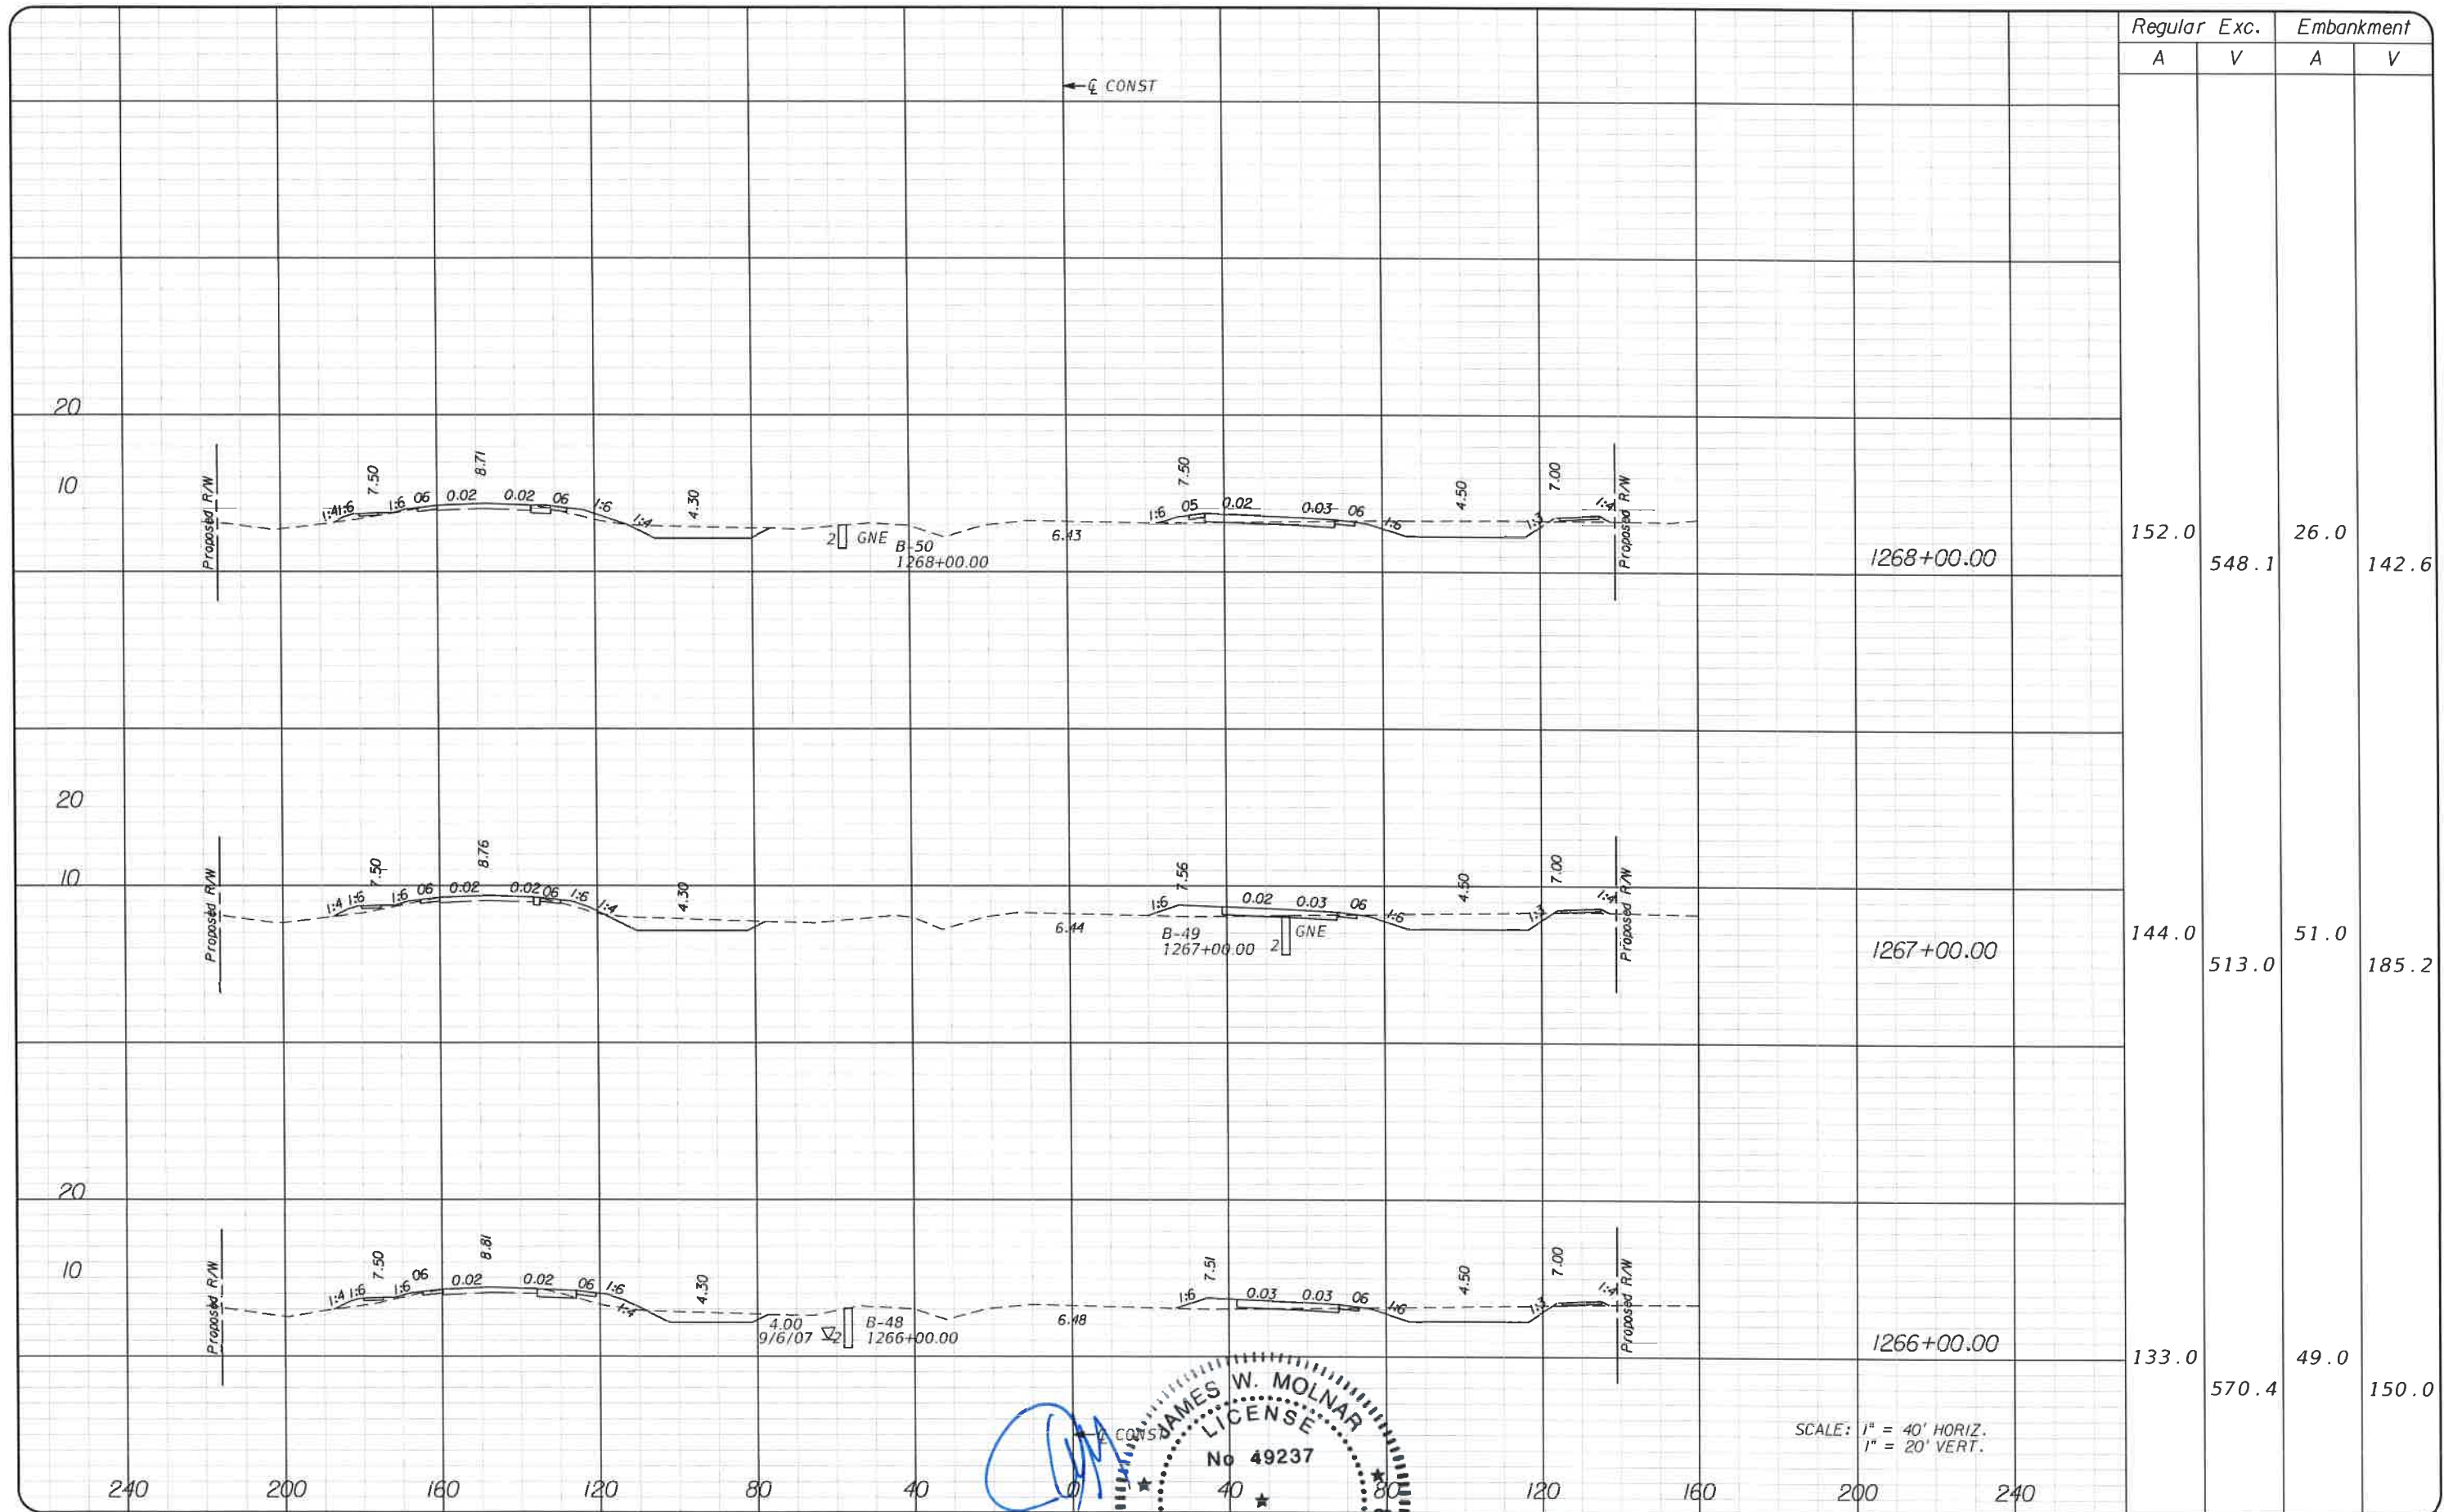

Regular		Exc.		Embankment	
A	V	A	V	A	V
152.0	548.1	26.0	142.6		
144.0	513.0	51.0	185.2		
133.0	570.4	49.0	150.0		

SCALE: 1" = 40' HORIZ.
1" = 20' VERT.



NO.	DATE	BY	REVISIONS - DESCRIPTION


T.Y. LIN INTERNATIONAL
2400 FIRST STREET
SUITE 200
FORT MYERS, FLORIDA 33901
TEL. (239) 332-4846
FAX. (239) 332-4798
WWW.TYLIN.COM

APPROVED BY:
JAMES MOLNAR, P.E.
REGISTERED PROFESSIONAL ENGINEER
FLORIDA CERTIFICATE NO. 49237
3-5-2015

DEPARTMENT of TRANSPORTATION
FORT MYERS, FLORIDA 33901

CROSS SECTIONS
BURNT STORE ROAD

SHEET NO.
76

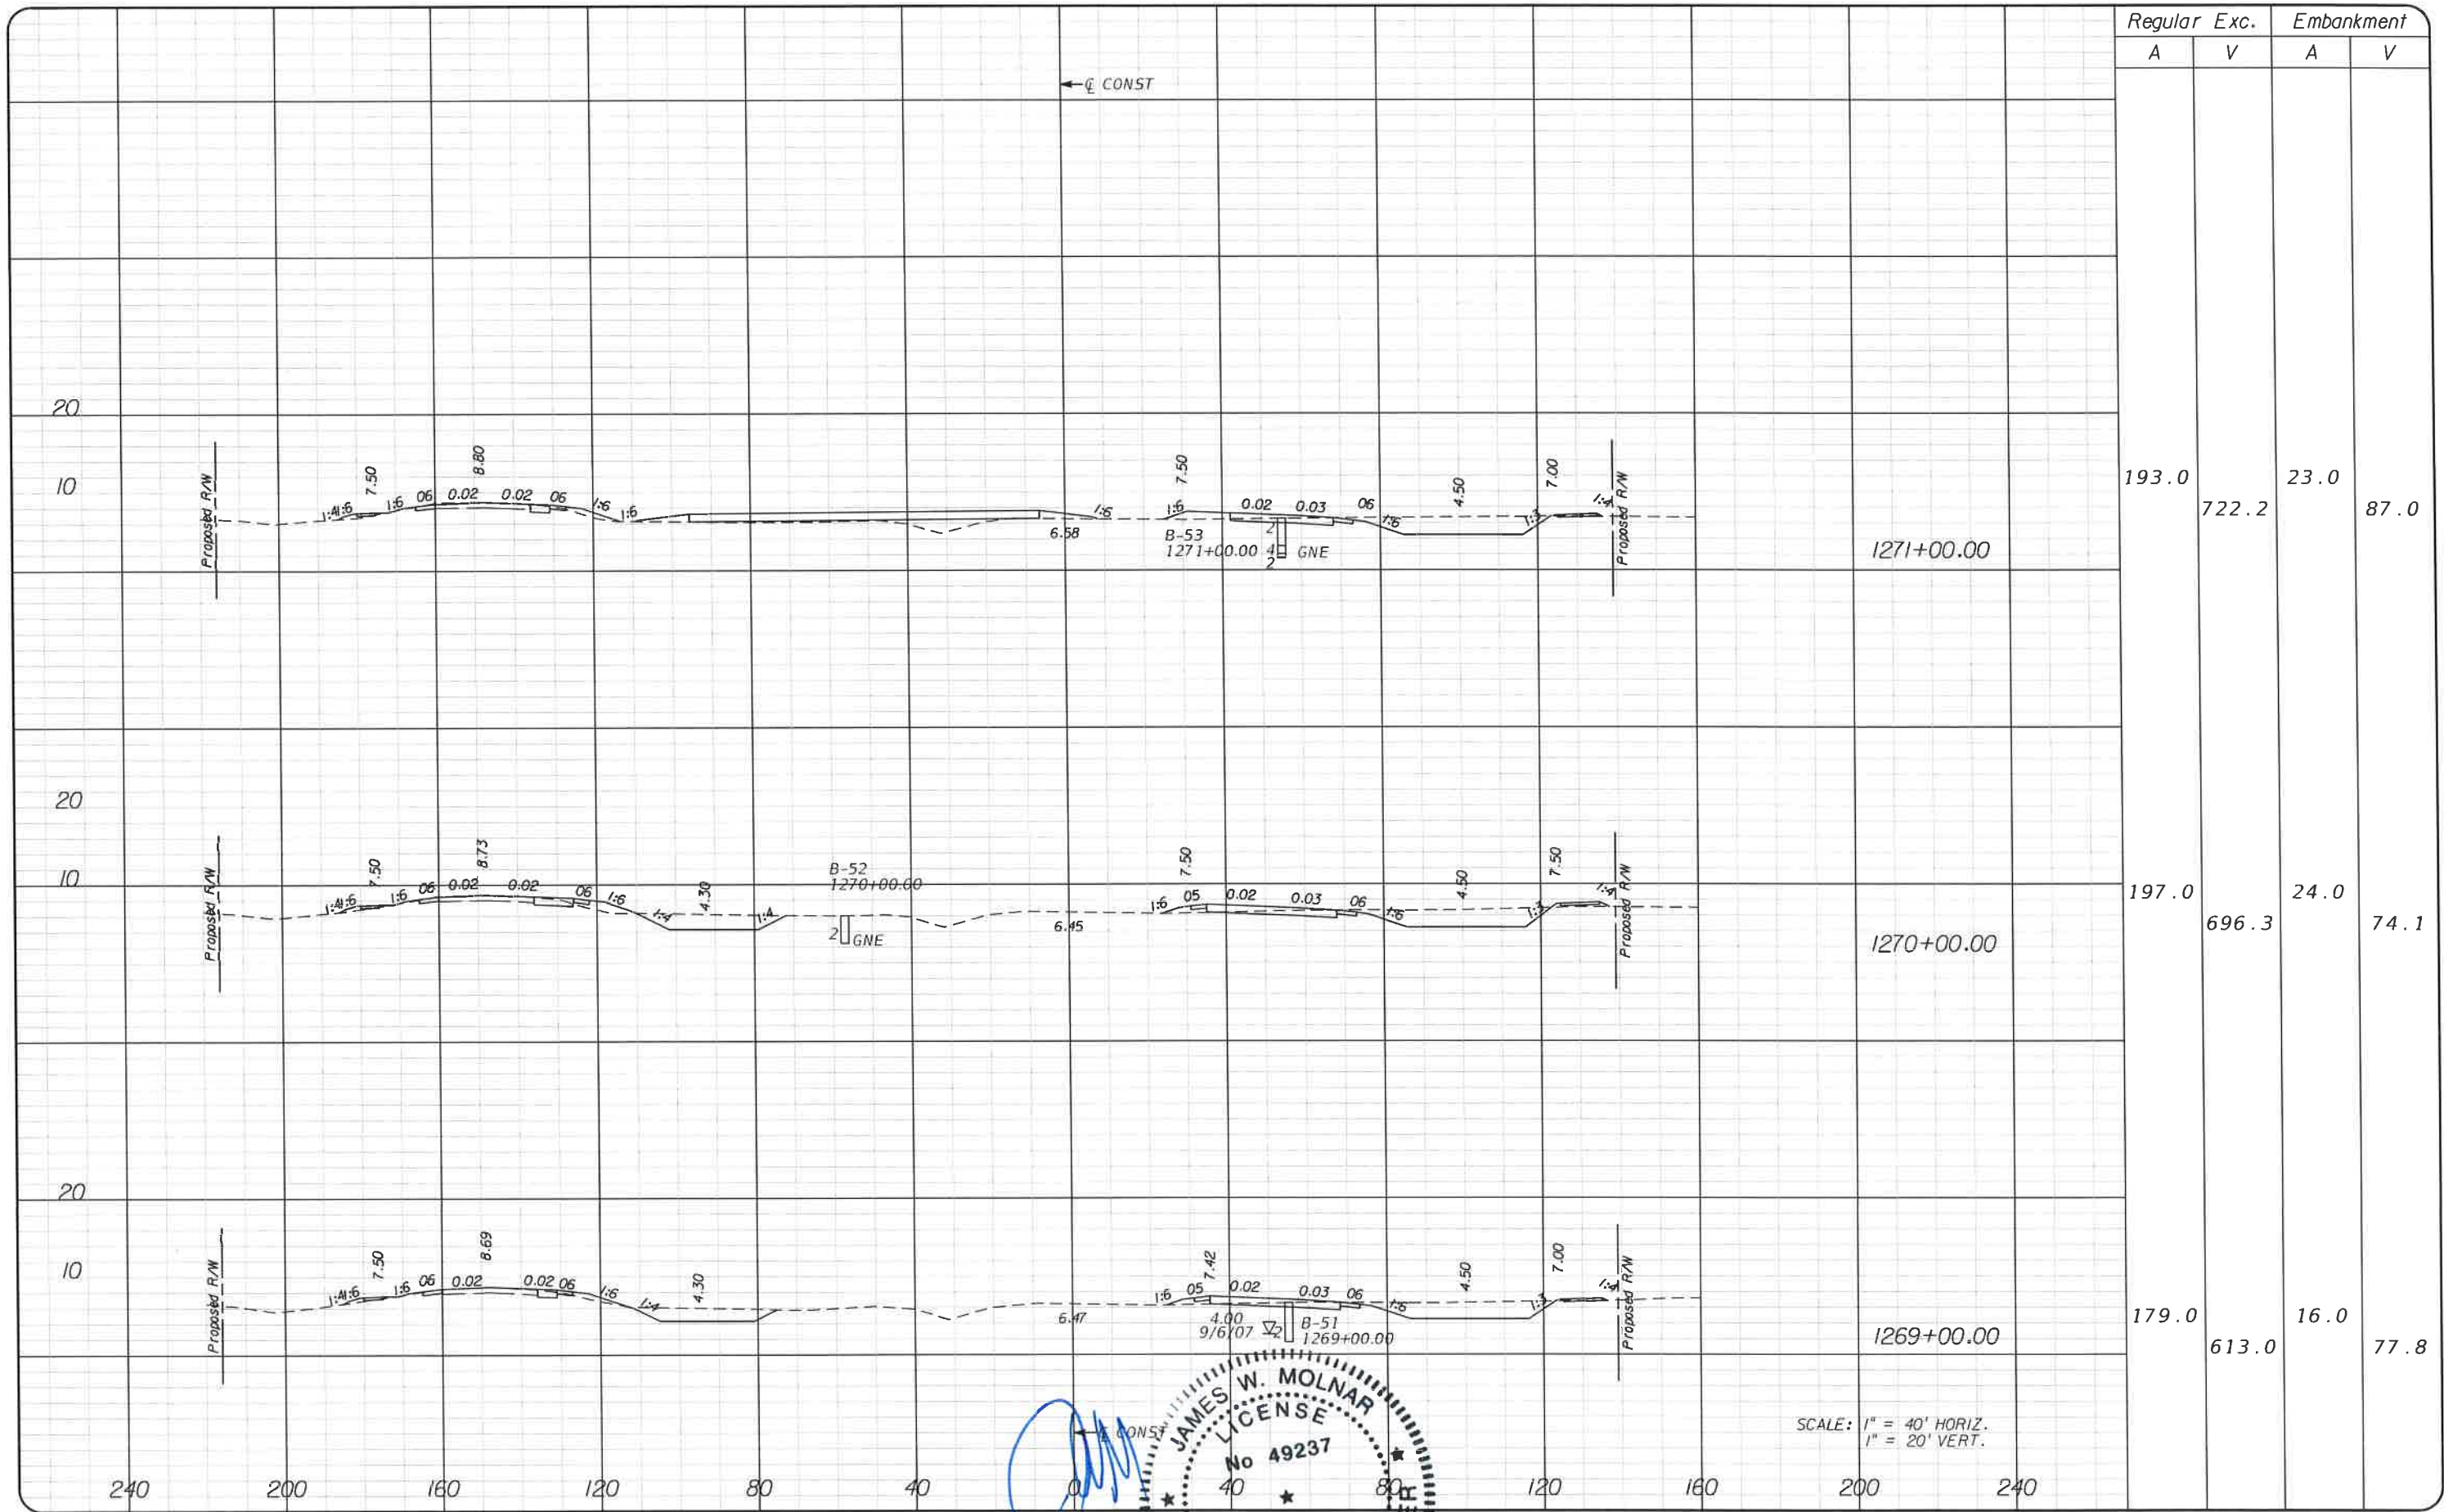


Regular		Exc.		Embankment	
A	V	A	V	A	V
193.0	722.2	23.0	87.0		
197.0	696.3	24.0	74.1		
179.0	613.0	16.0	77.8		

NO.	DATE	BY	REVISIONS - DESCRIPTION

T.Y. LIN INTERNATIONAL
 2400 FIRST STREET
 SUITE 200
 FORT MYERS, FLORIDA 33901
 TEL. (239) 332-4846
 FAX. (239) 332-4798
 WWW.TYLIN.COM

APPROVED BY
JAMES MOLNAR, P.E.
 REGISTERED PROFESSIONAL ENGINEER
 FLORIDA CERTIFICATE NO. 49237
 3-5-2015

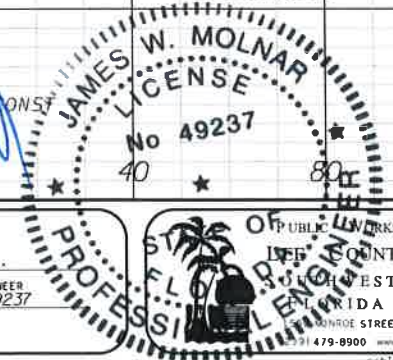


DEPARTMENT of TRANSPORTATION
 FORT MYERS, FLORIDA 33901
 3/4/2015 5:08:08 PM

CROSS SECTIONS
BURNT STORE ROAD

SHEET NO.
 77

T:\V\amp\Legacy\Project\581595-00_Burnt_Store_RD\Burnt_Store_Roadway\RD\SRD011.dgn Rdxsrd.dwg

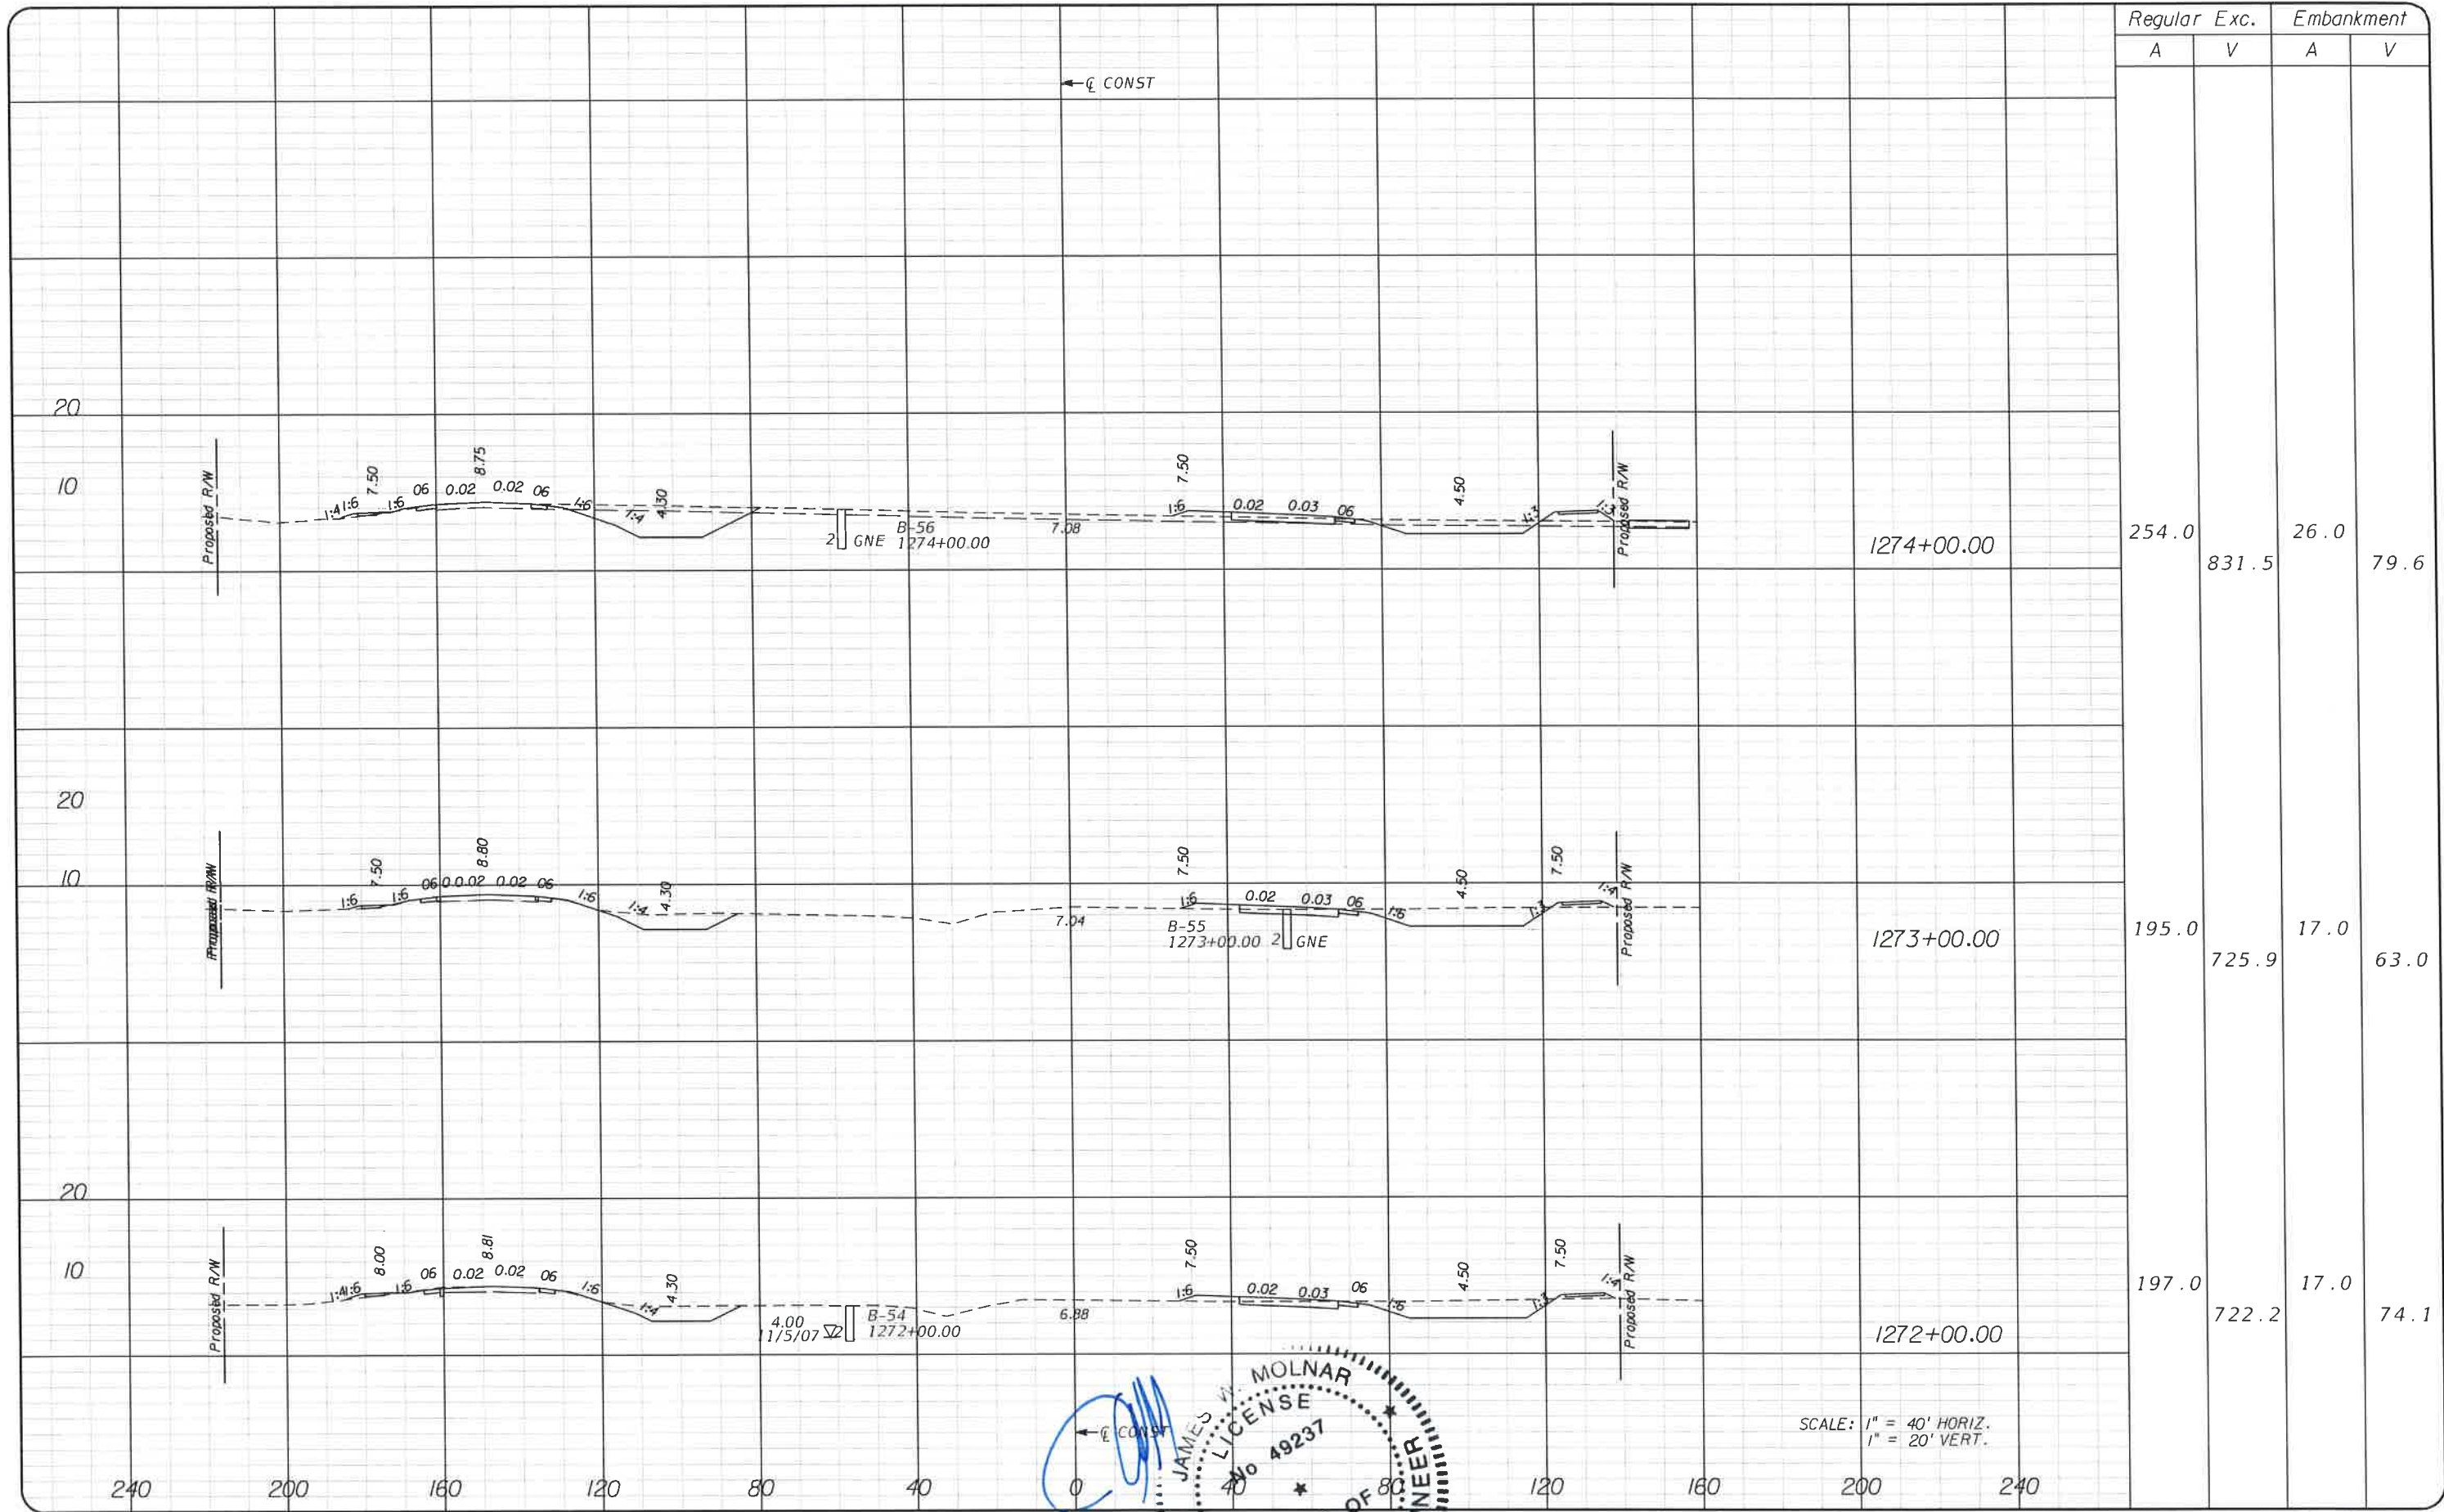


Regular Exc. Embankment

A V A V

Station	Regular A	Exc. V	Embankment A	Embankment V
1274+00.00	254.0	831.5	26.0	79.6
1273+00.00	195.0	725.9	17.0	63.0
1272+00.00	197.0	722.2	17.0	74.1

SCALE: 1" = 40' HORIZ.
1" = 20' VERT.

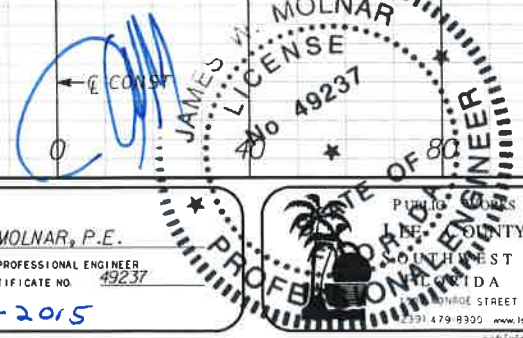

NO.	DATE	BY	REVISIONS	DESCRIPTION

T.Y. LIN INTERNATIONAL
 2400 FIRST STREET
 SUITE 200
 FORT MYERS, FLORIDA 33901
 TEL. (239) 332-4846
 FAX. (239) 332-4798
 WWW.TYLIN.COM


APPROVED BY:
JAMES MOLNAR, P.E.
 REGISTERED PROFESSIONAL ENGINEER
 FLORIDA CERTIFICATE NO. 49237
 3-5-2015

PIPING DIVISION
 HIGHLAND COUNTY
 1601 W. STATE ST
 FORT MYERS, FLORIDA 33901
 TEL. (239) 479-8300
 WWW.HCCOUNTY.COM/PUBLICWORKS/STILLSITE.HTM

DEPARTMENT
 of
 TRANSPORTATION
 FORT MYERS, FLORIDA 33901

CROSS SECTIONS
BURNT STORE ROAD

SHEET NO.
 78

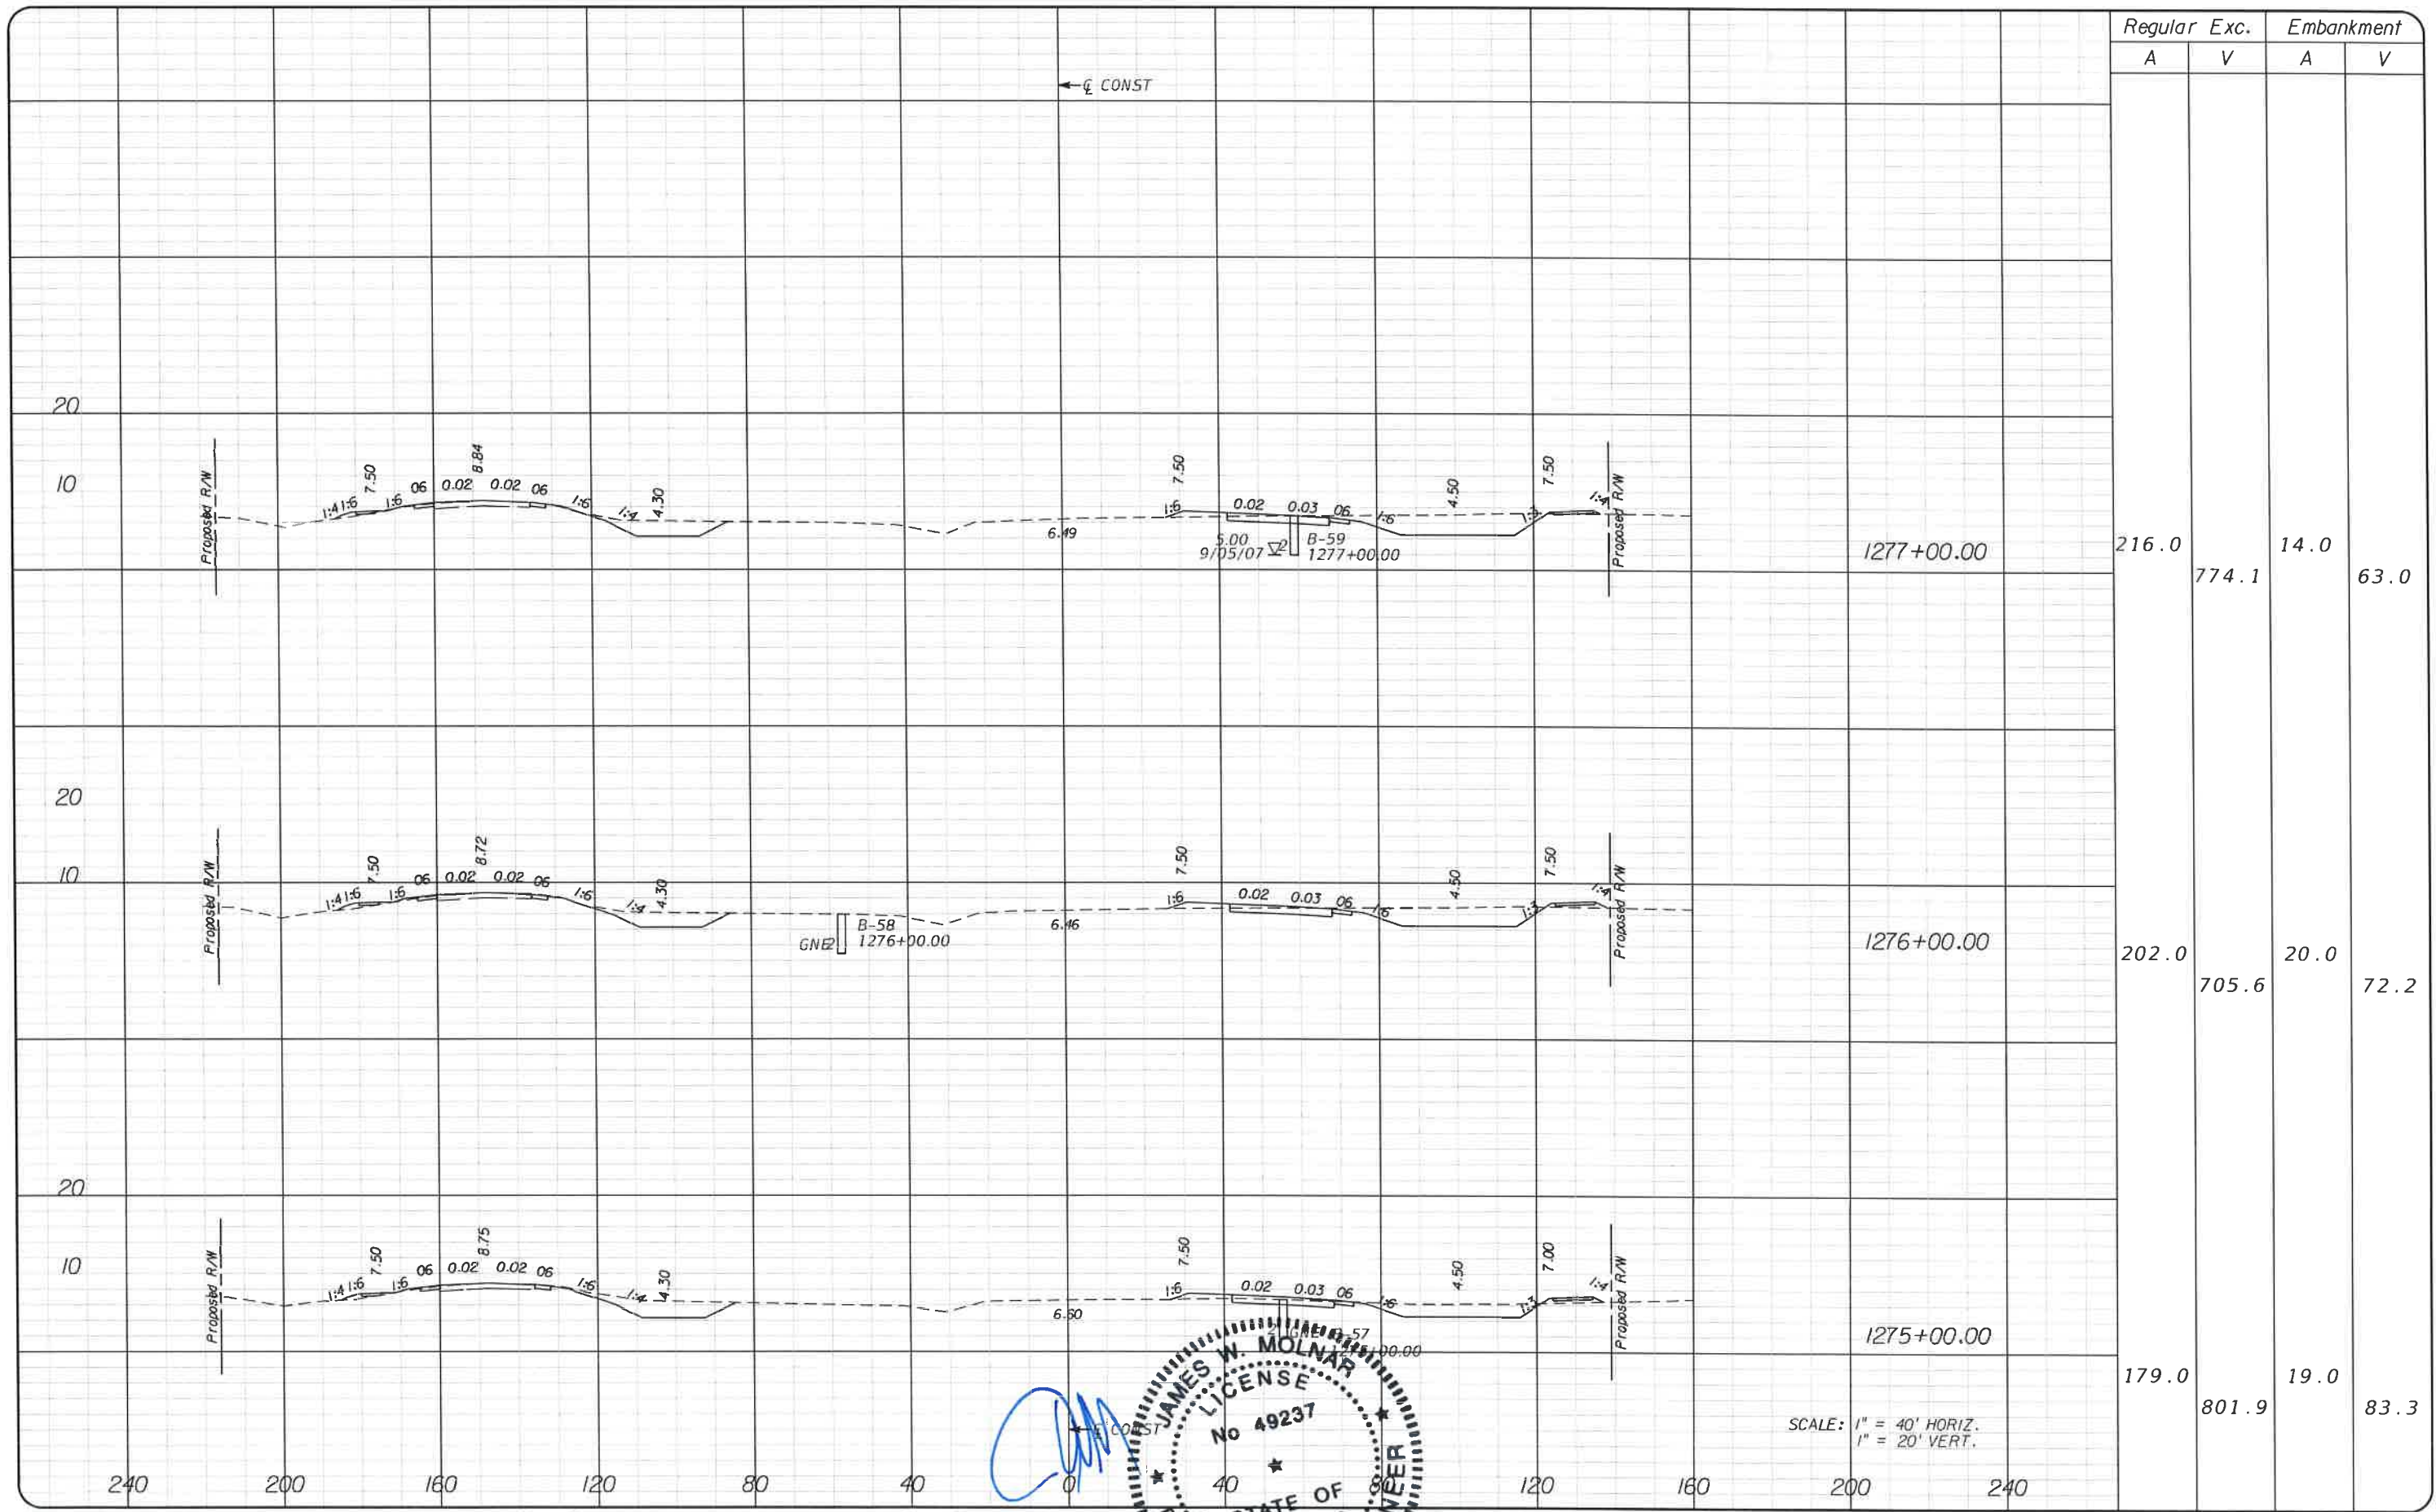

Regular		Exc.		Embankment	
A	V	A	V	A	V
216.0	774.1	14.0	63.0		
202.0	705.6	20.0	72.2		
179.0	801.9	19.0	83.3		

SCALE: 1" = 40' HORIZ.
1" = 20' VERT.

[Handwritten Signature]



NO.	DATE	BY	REVISIONS - DESCRIPTION


T.Y. LIN INTERNATIONAL
2400 FIRST STREET
SUITE 200
FORT MYERS, FLORIDA 33901
TEL. (239) 332-4846
FAX. (239) 332-4798
WWW.TYLIN.COM

APPROVED BY
JAMES MOLNAR, P.E.
REGISTERED PROFESSIONAL ENGINEER
FLORIDA CERTIFICATE NO. 49237
3-5-2015

LEEDS ENGINEERING WORKS
COUNTY OF LEWIS
STATE OF FLORIDA
1500 MONROE STREET
FORT MYERS, FLORIDA 33901
(239) 479-8900 www.leeds-engineering.com

CROSS SECTIONS
BURNT STORE ROAD

SHEET NO.
79

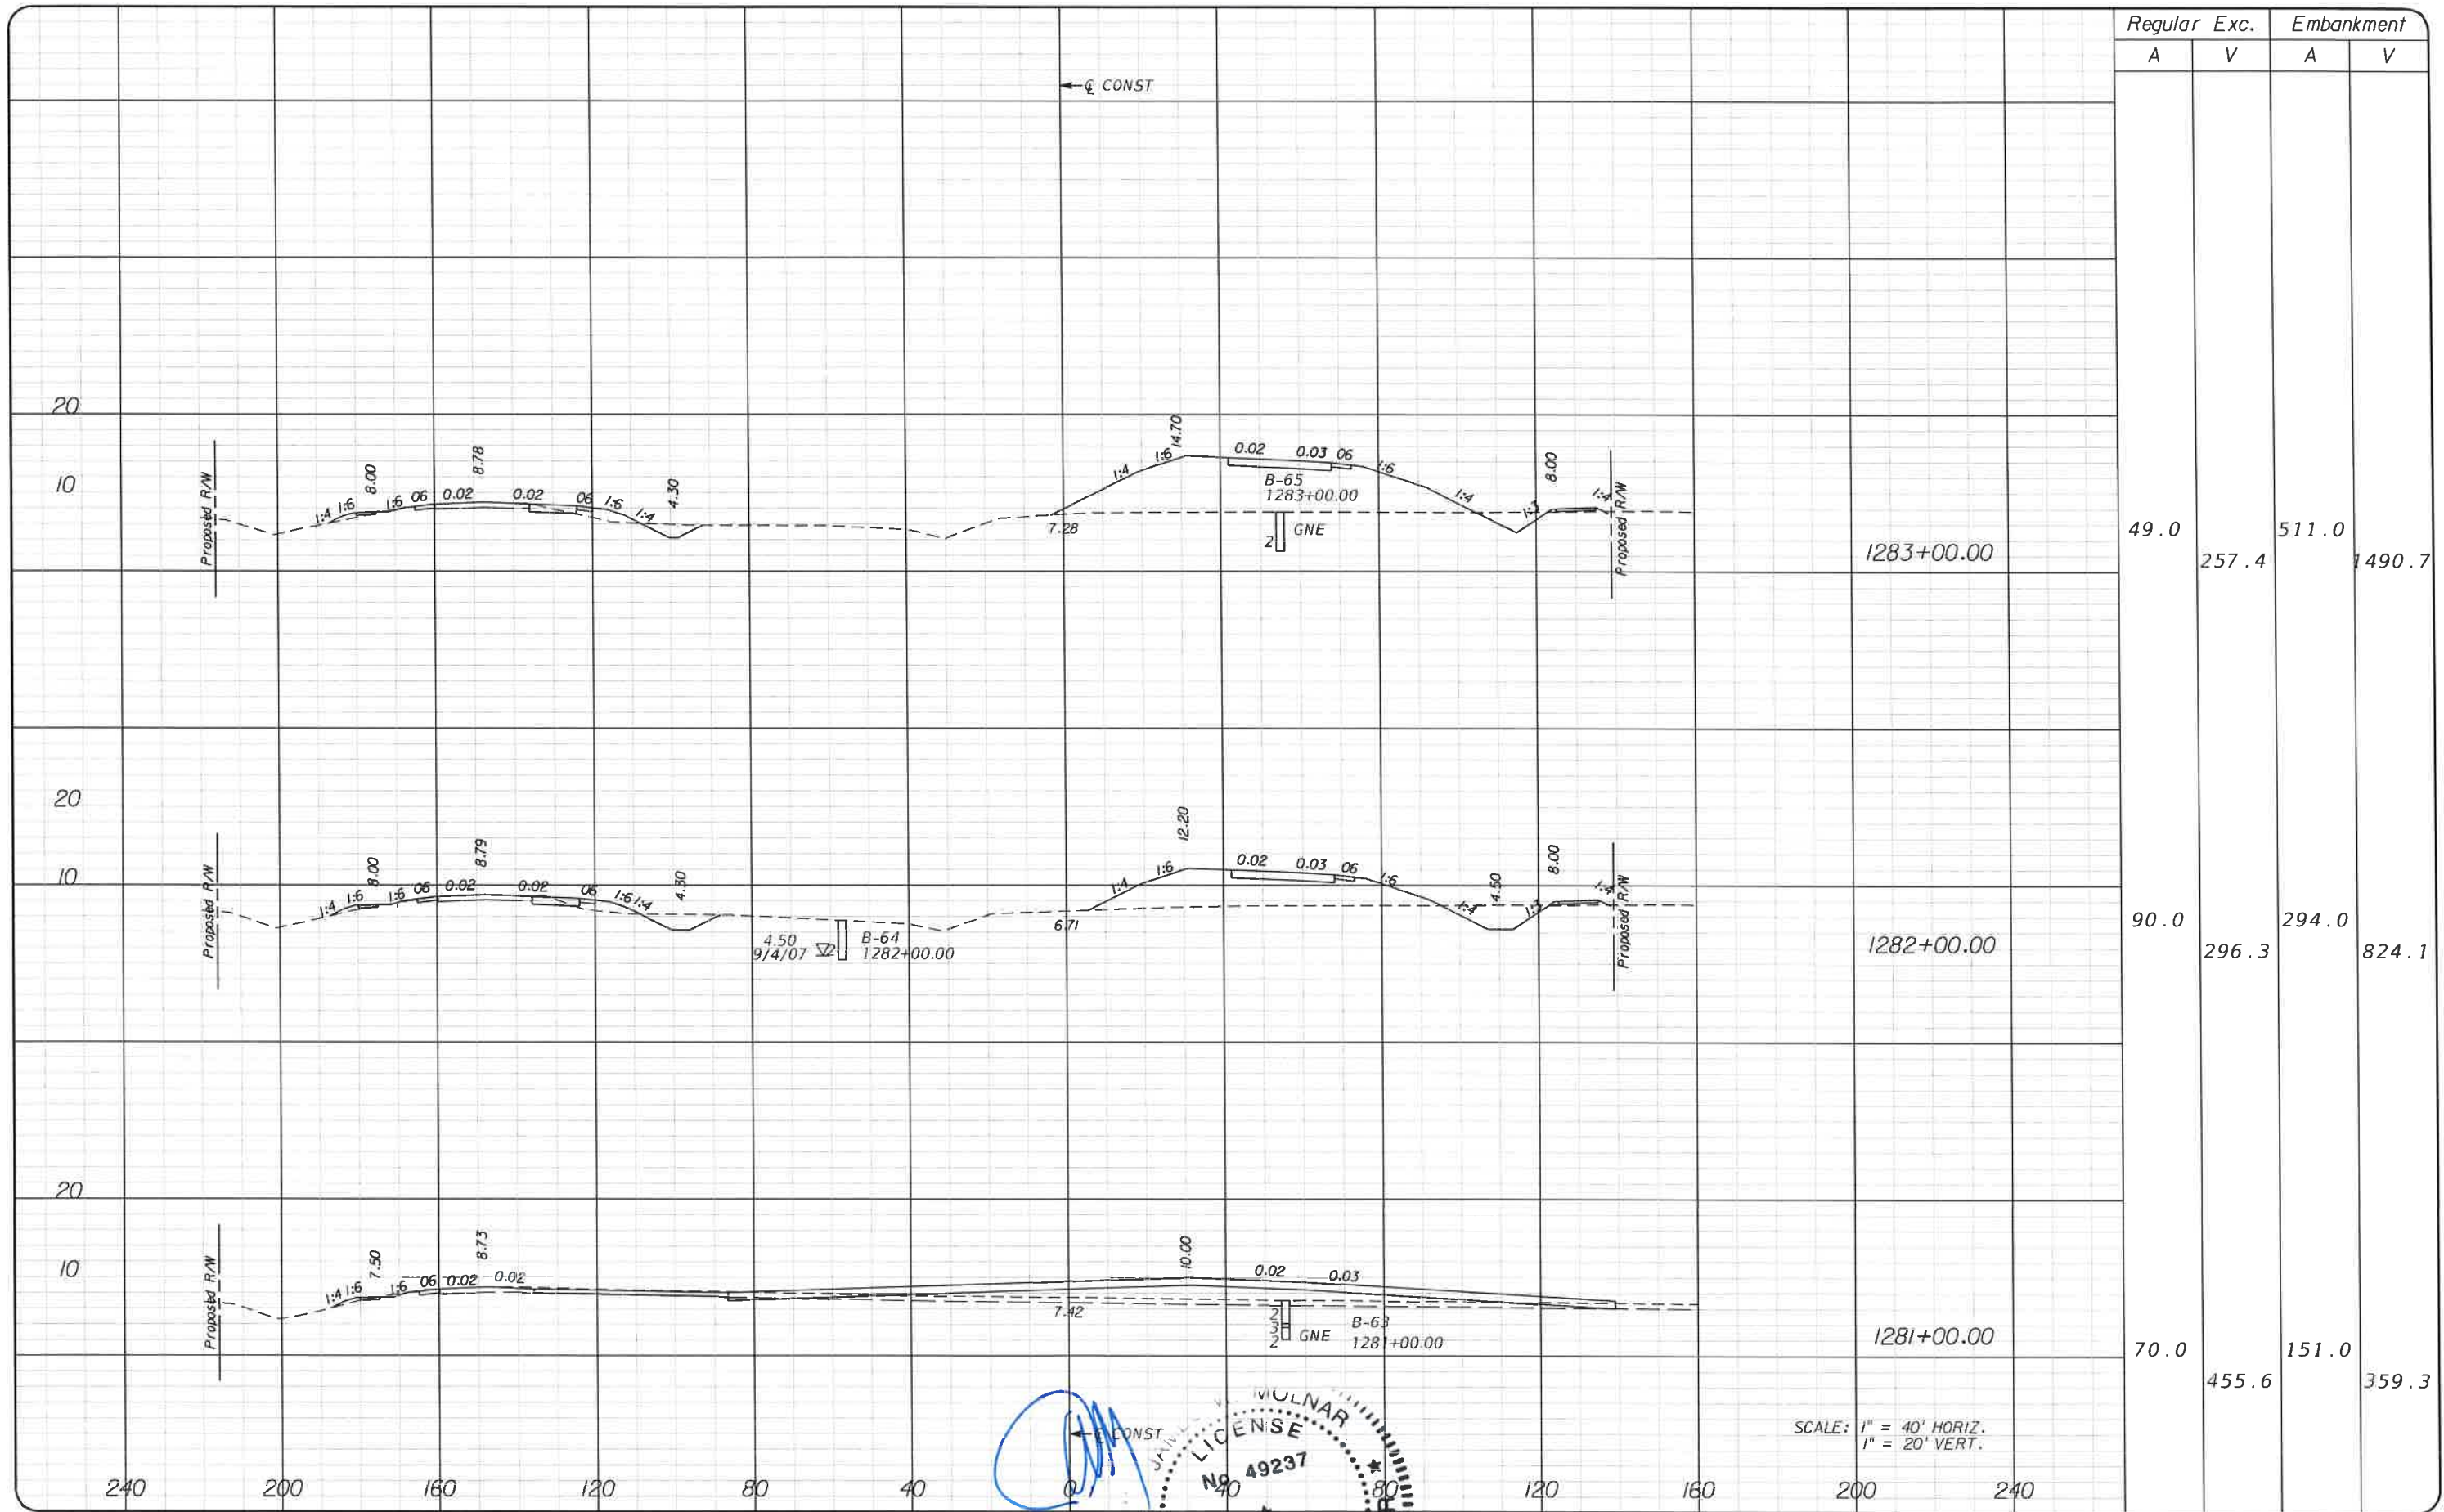

APPROVED BY: **JAMES MOLNAR, P.E.**
 REGISTERED PROFESSIONAL ENGINEER
 FLORIDA CERTIFICATE NO. 49237
 3-5-2015

T.Y. LIN INTERNATIONAL
 2400 FIRST STREET
 SUITE 200
 FORT MYERS, FLORIDA 33901
 TEL. (239) 332-4846
 FAX. (239) 332-4798
 WWW.TYLIN.COM


APPROVED BY: **JAMES MOLNAR, P.E.**
 REGISTERED PROFESSIONAL ENGINEER
 FLORIDA CERTIFICATE NO. 49237
 3-5-2015

DEPARTMENT of TRANSPORTATION
 FORT MYERS, FLORIDA 33901

CROSS SECTIONS
BURNT STORE ROAD

SHEET NO.
 81

NO.	DATE	BY	REVISIONS - DESCRIPTION

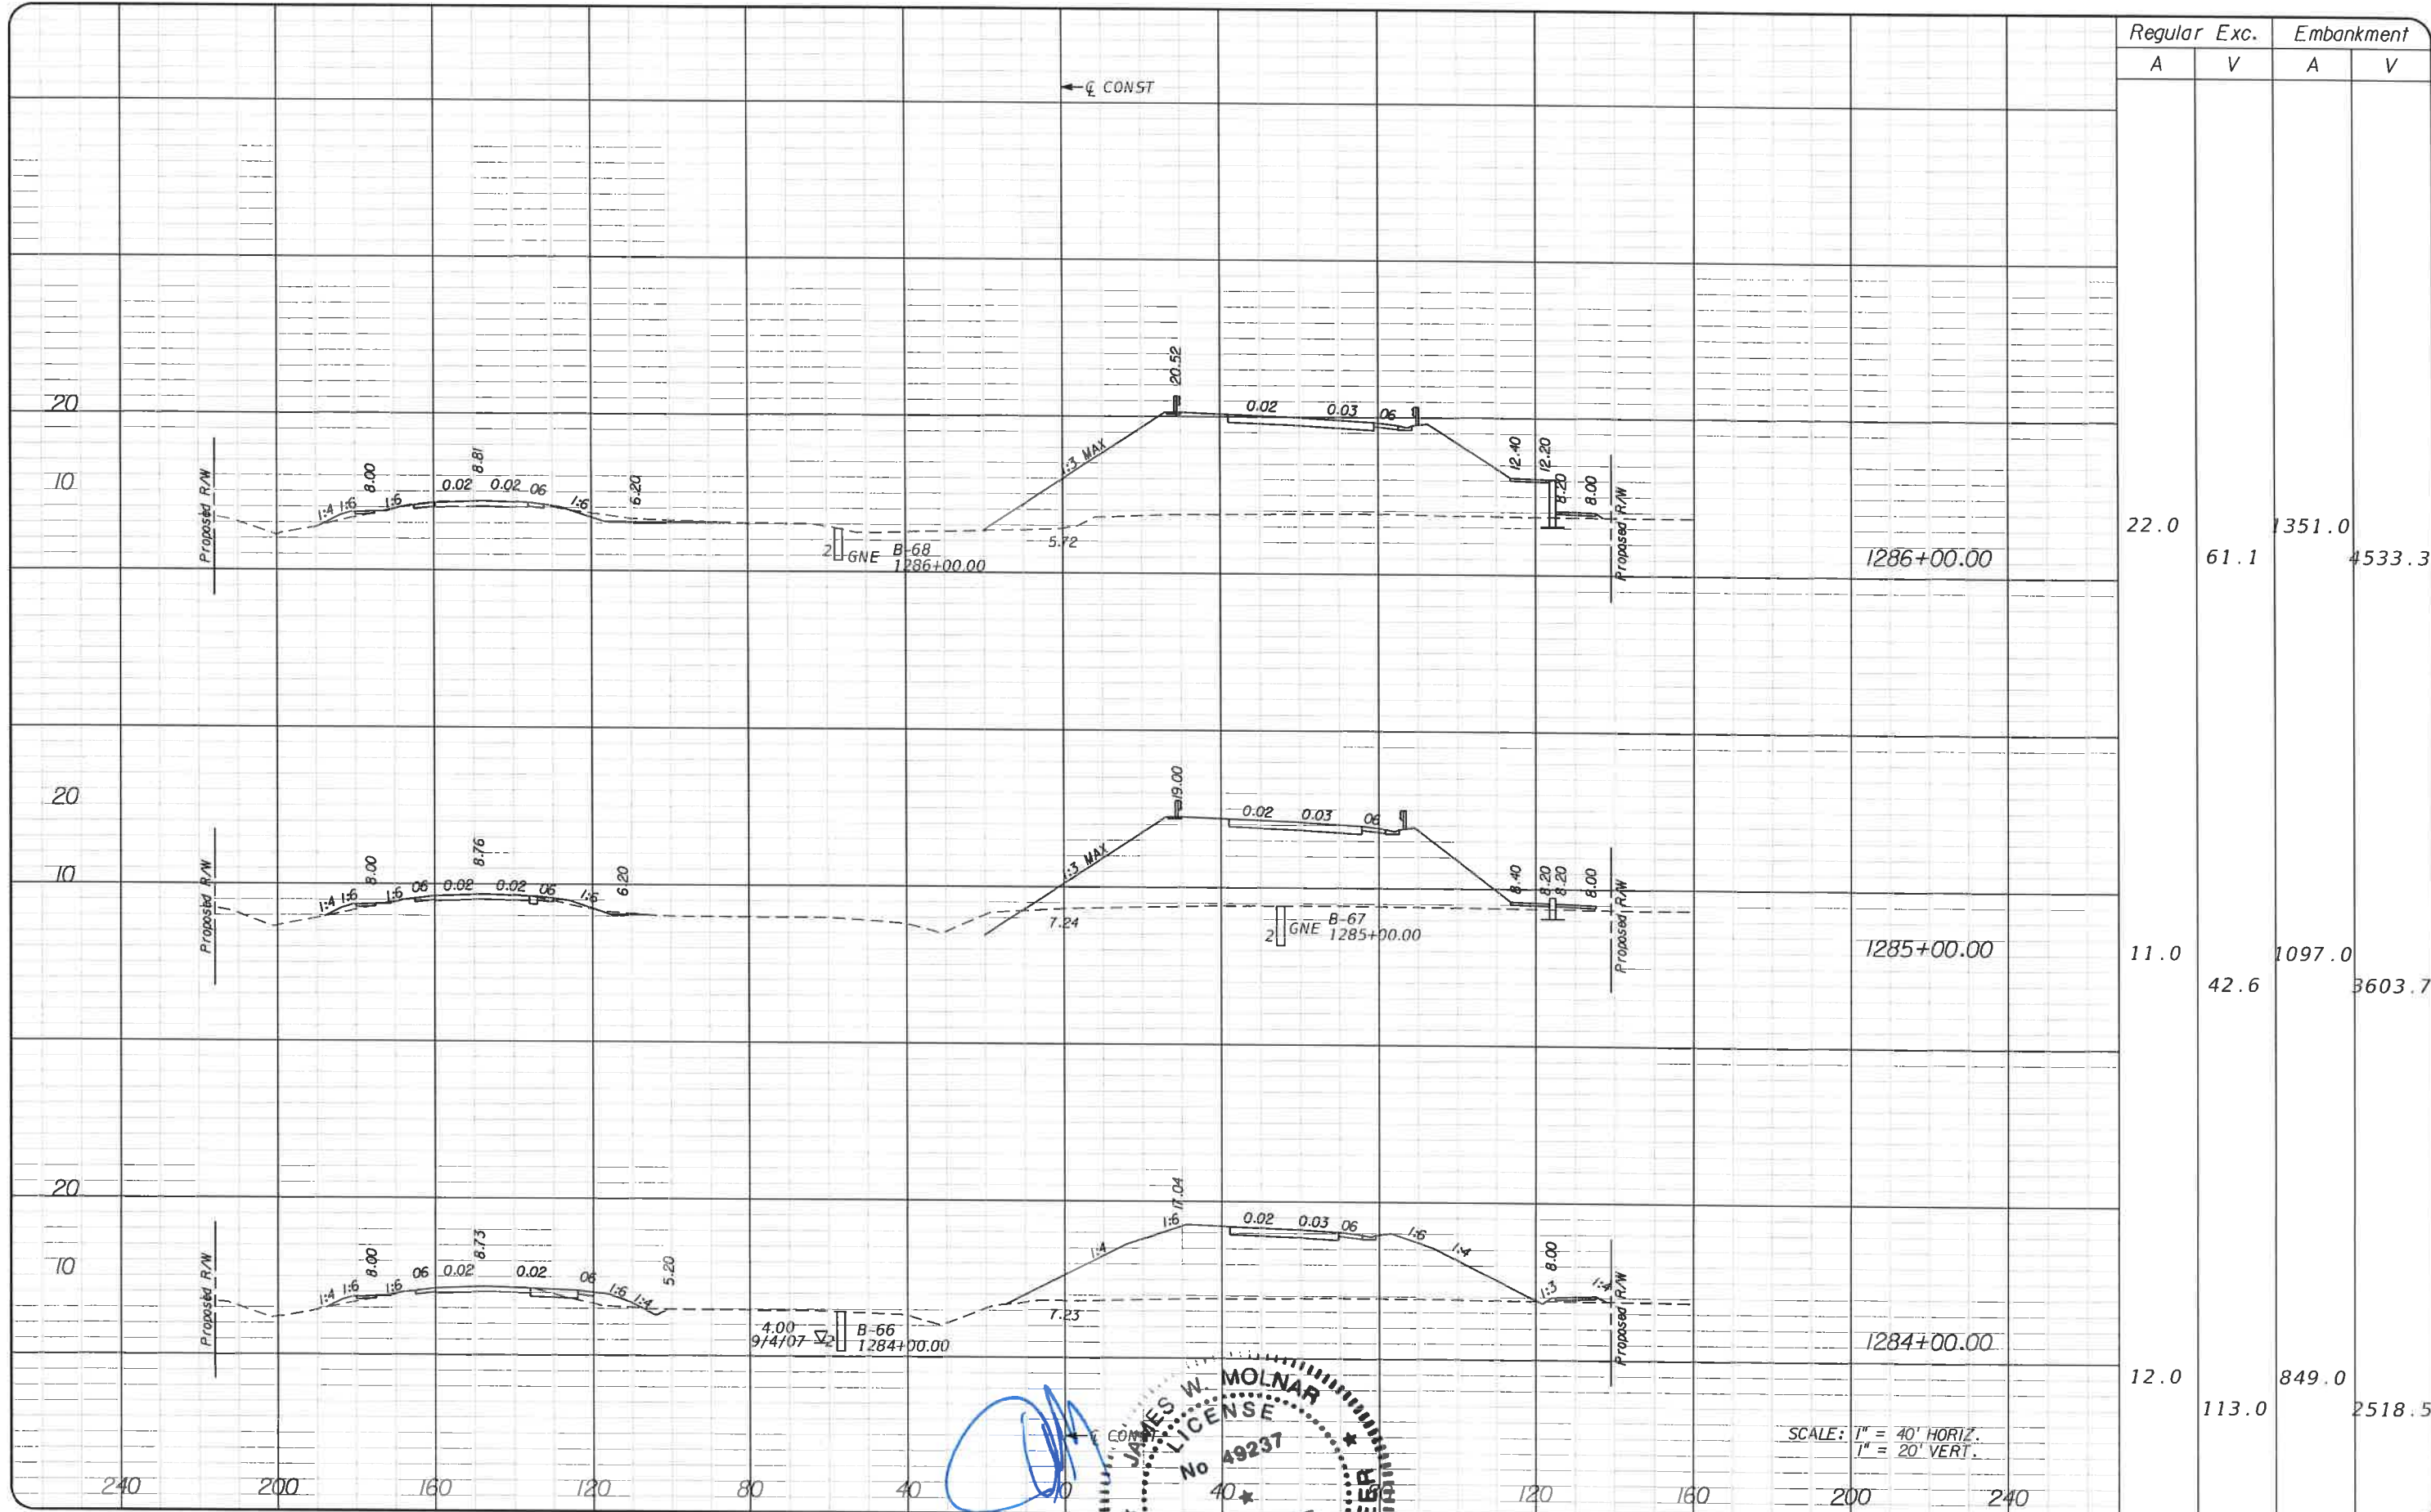

Station	Regular		Exc.		Embankment	
	A	V	A	V	A	V
1286+00.00	22.0	61.1	351.0		4533.3	
1285+00.00	11.0	42.6	1097.0		3603.7	
1284+00.00	12.0	113.0	849.0		2518.5	

SCALE: 1" = 40' HORIZ.
1" = 20' VERT.

NO.	DATE	BY	REVISIONS - DESCRIPTION


T.Y. LIN INTERNATIONAL
2400 FIRST STREET
SUITE 200
FORT MYERS, FLORIDA 33901
TEL. (239) 332-4846
FAX. (239) 332-4798
WWW.TYLIN.COM

APPROVED BY:
JAMES W. MOLNAR, P.E.
REGISTERED PROFESSIONAL ENGINEER
FLORIDA CERTIFICATE NO. 49237
3-5-2015

STATE OF FLORIDA
PUBLIC WORKS
COUNTY OF LEWIS
DEPARTMENT of TRANSPORTATION
FORT MYERS, FLORIDA 33901
1500 MONROE STREET
(239) 479-8900 www.le-county.com/publicworks/dotfile.htm

CROSS SECTIONS
BURNT STORE ROAD

SHEET NO.
82

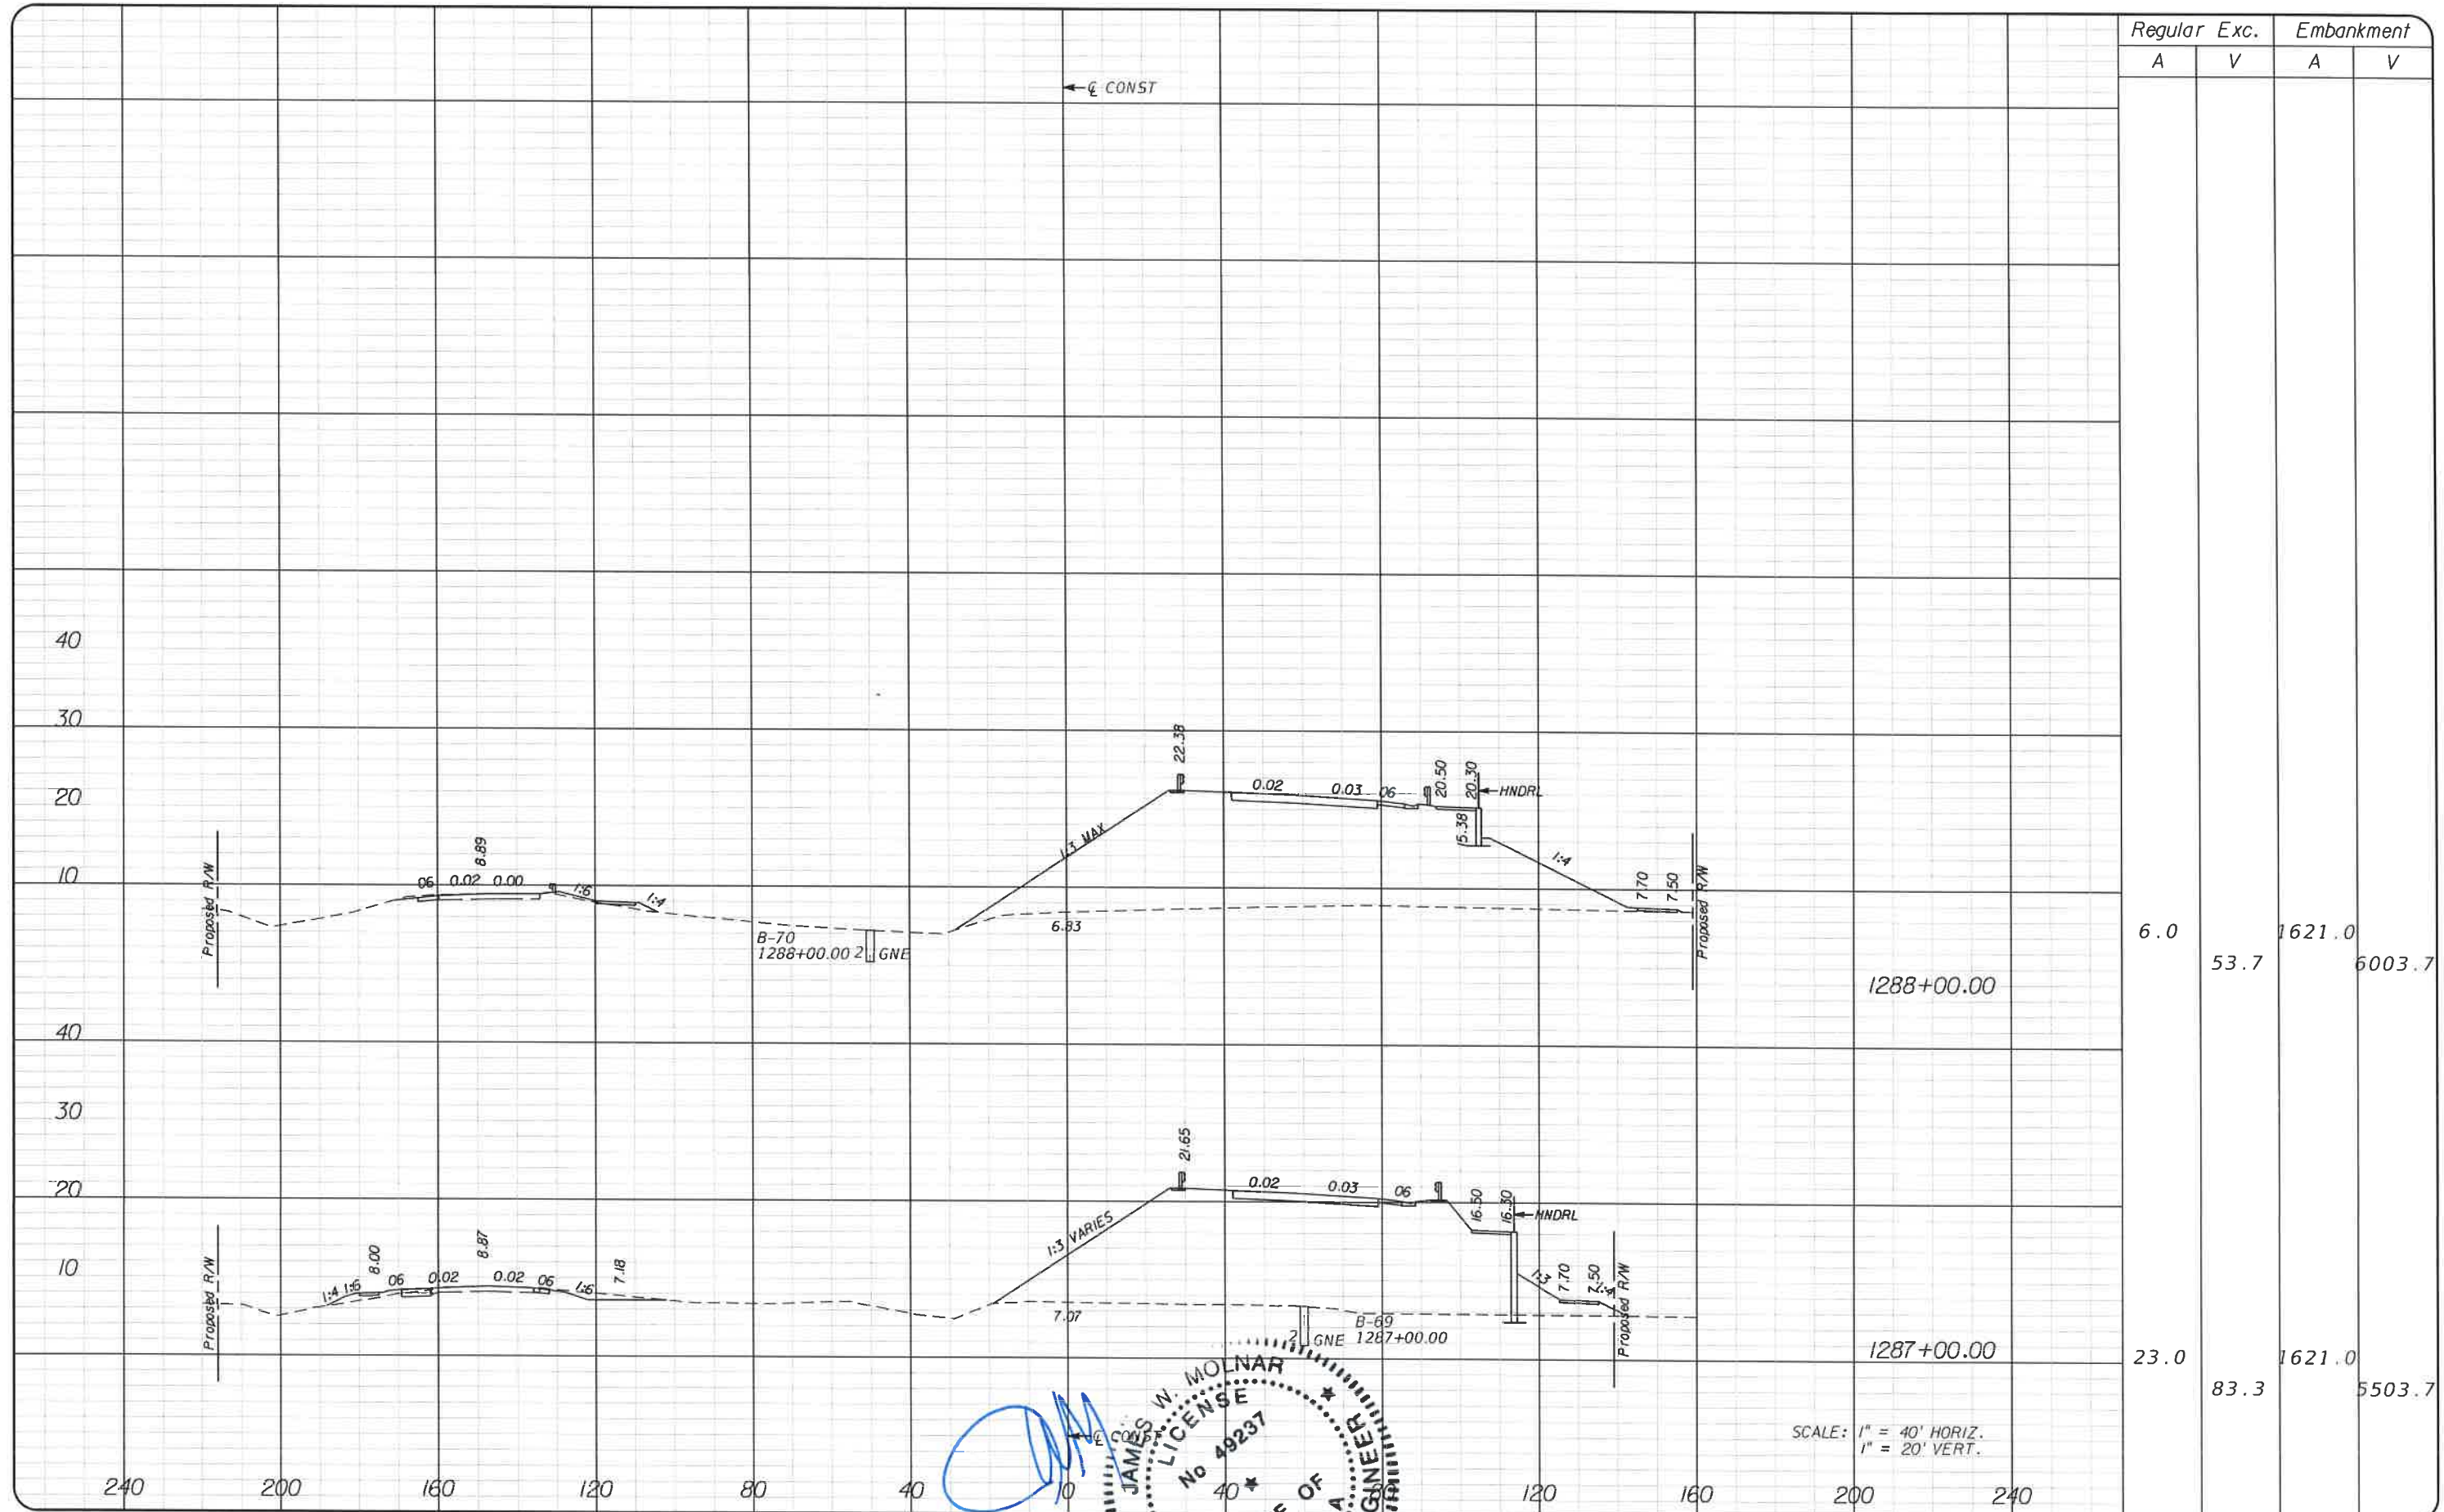

Regular		Exc.		Embankment	
A	V	A	V	A	V
6.0	53.7			1621.0	6003.7
23.0	83.3			1621.0	5503.7

SCALE: 1" = 40' HORIZ.
1" = 20' VERT.

NO.	DATE	BY	REVISIONS - DESCRIPTION


T.Y. LIN INTERNATIONAL
2400 FIRST STREET
SUITE 200
FORT MYERS, FLORIDA 33901
TEL. (239) 332-4846
FAX. (239) 332-4798
WWW.TYLIN.COM

APPROVED BY:
JAMES W. MOLNAR, P.E.
REGISTERED PROFESSIONAL ENGINEER
FLORIDA CERTIFICATE NO. 49237
3-5-2015

FLORIDA ENGINEERS & SURVEYORS
STATE OF FLORIDA
LEON COUNTY
1500 MONROE STREET
FORT MYERS, FLORIDA 33901
TEL. (239) 479-8900
www.lec-county.com/publicworks/submit.htm

CROSS SECTIONS
BURNT STORE ROAD

SHEET NO.
83

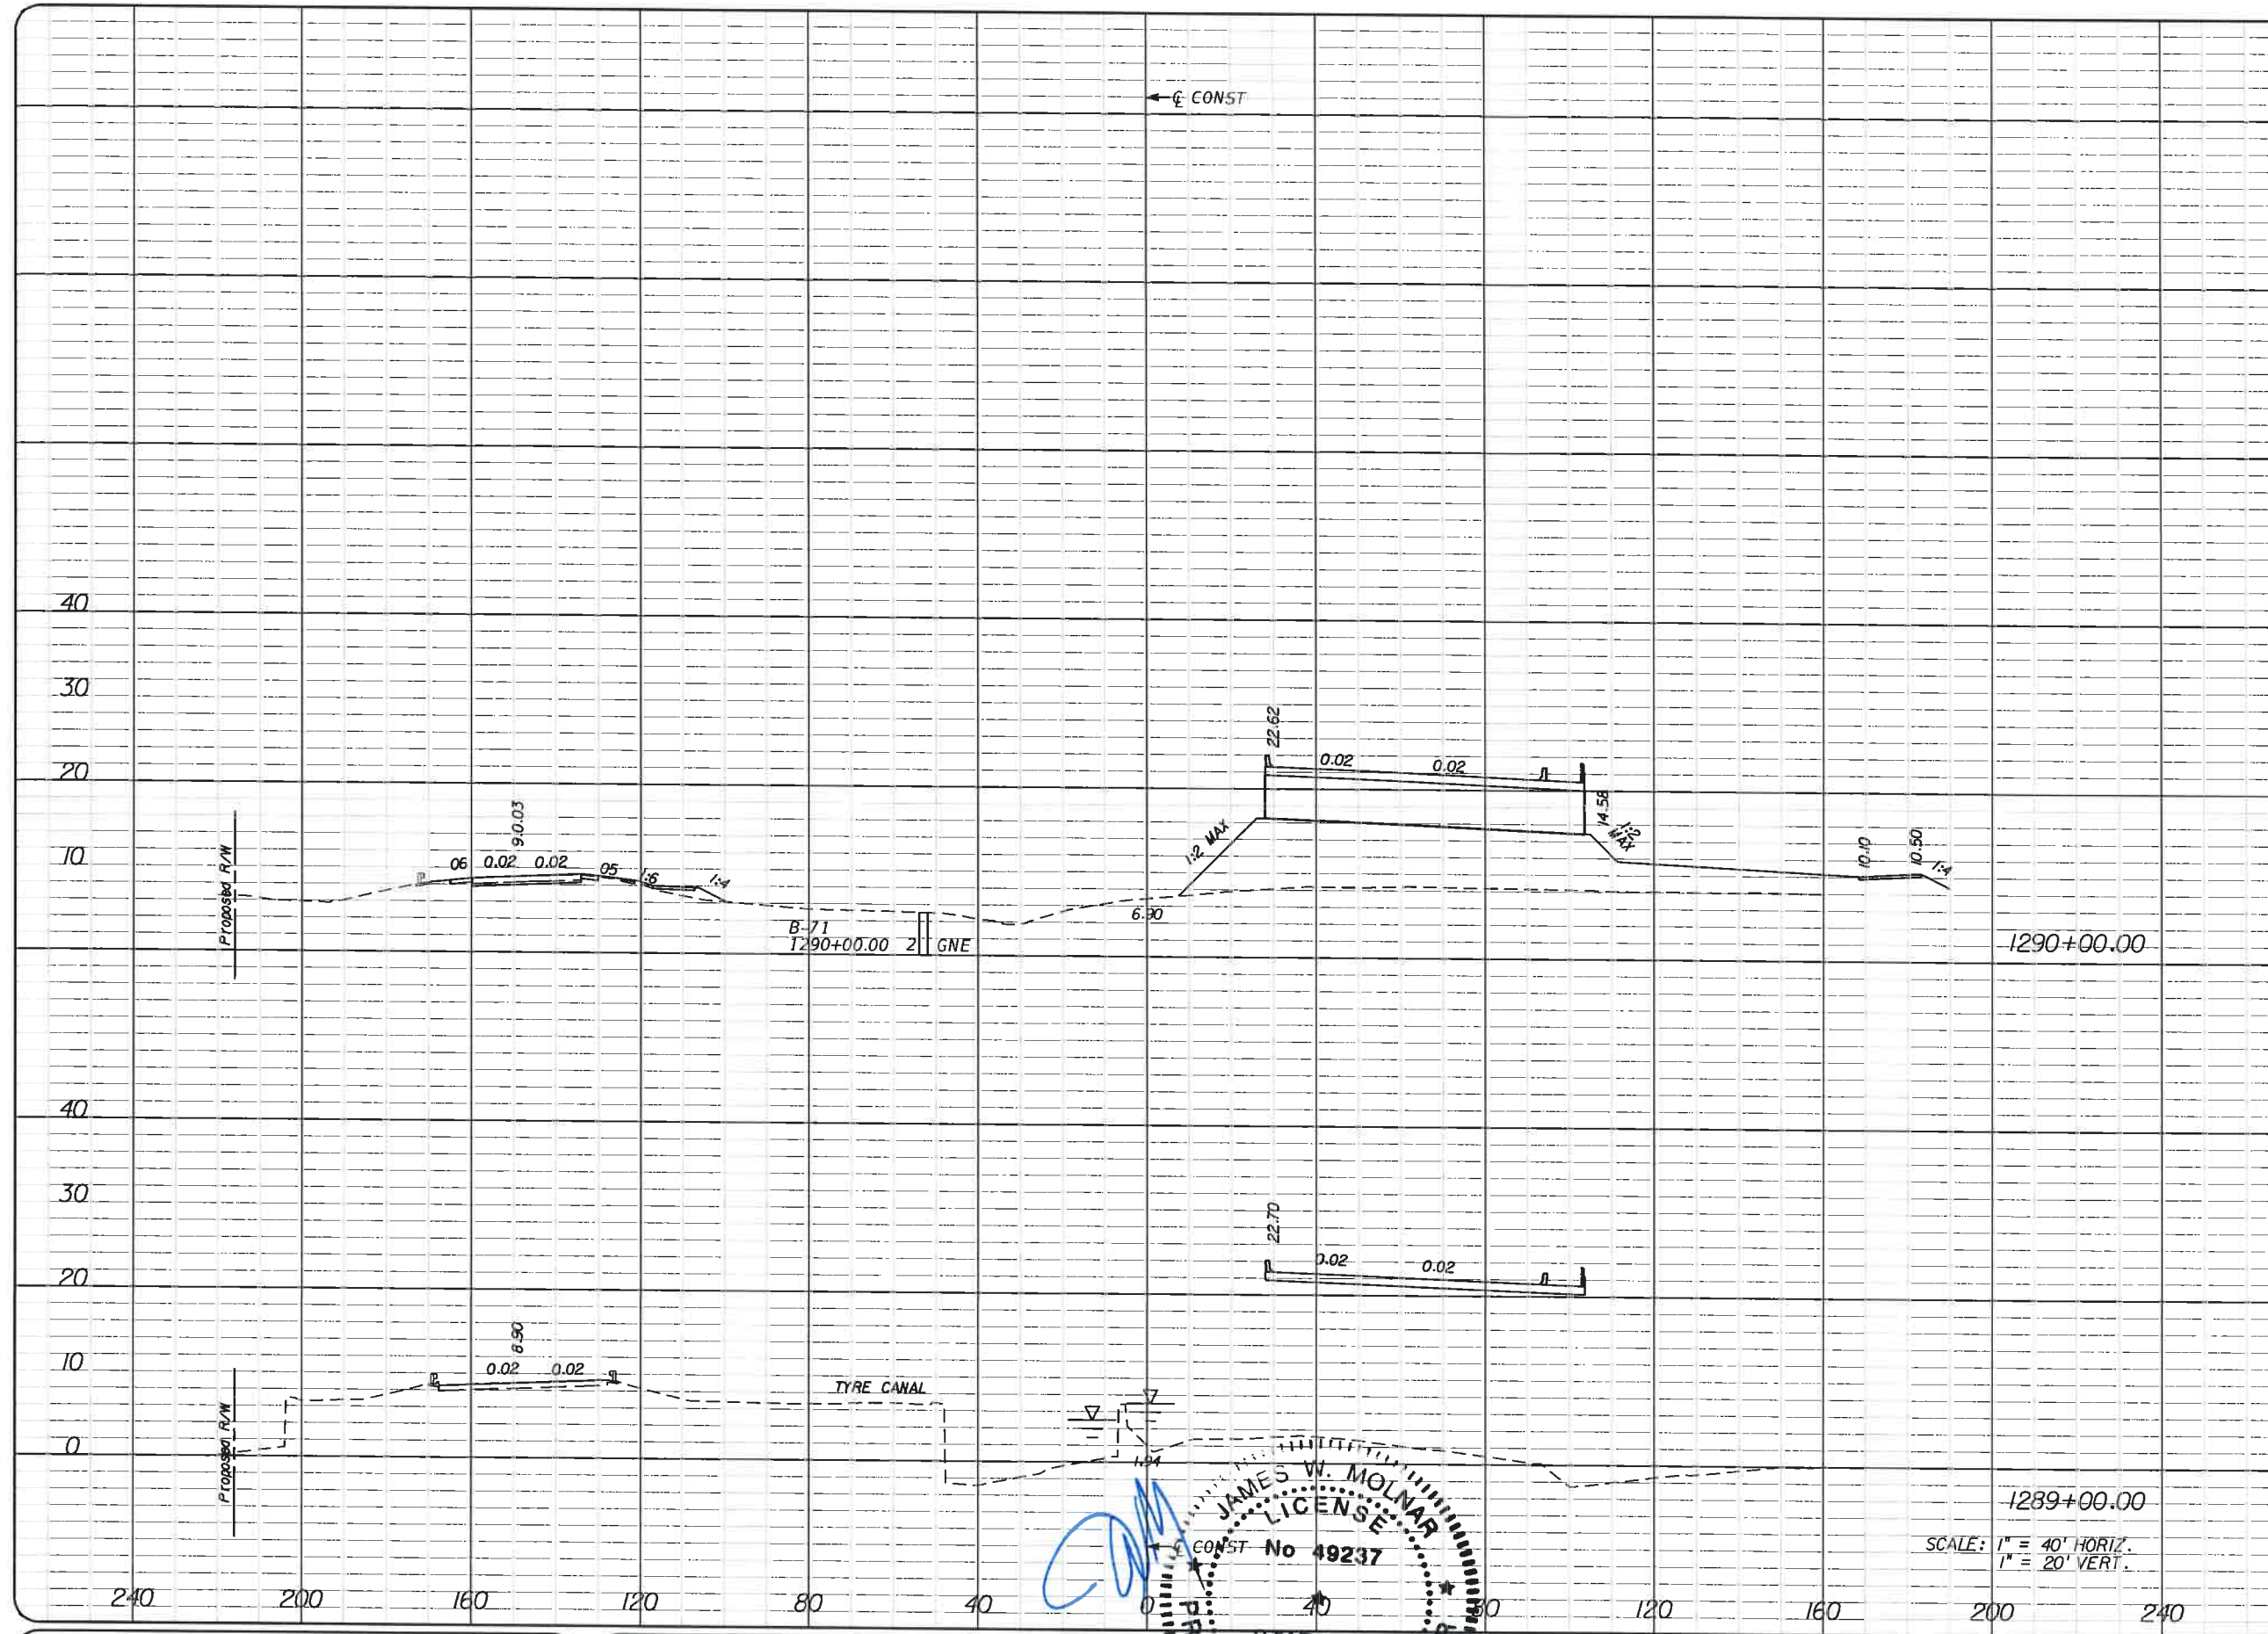

Regular		Exc.		Embankment	
A	V	A	V	A	V
29.0			32.6	722.0	2180.7

NO.	DATE	BY	REVISIONS - DESCRIPTION


T.Y. LIN INTERNATIONAL
 2400 FIRST STREET
 SUITE 200
 FORT MYERS, FLORIDA 33901
 TEL. (239) 332-4846
 FAX. (239) 332-4798
 WWW.TYLIN.COM

APPROVED BY
JAMES W. MOLNAR, P.E.
 REGISTERED PROFESSIONAL ENGINEER
 FLORIDA CERTIFICATE NO. 49237
 3-5-2015

LEEE COUNTY PUBLIC WORKS
 DEPARTMENT of TRANSPORTATION
 1500 MANHOPE STREET
 FORT MYERS, FLORIDA 33901
 (239) 479-8900 www.leecounty.com/publicworks/dot/leec.htm

CROSS SECTIONS
BURNT STORE ROAD

SHEET NO.
 84

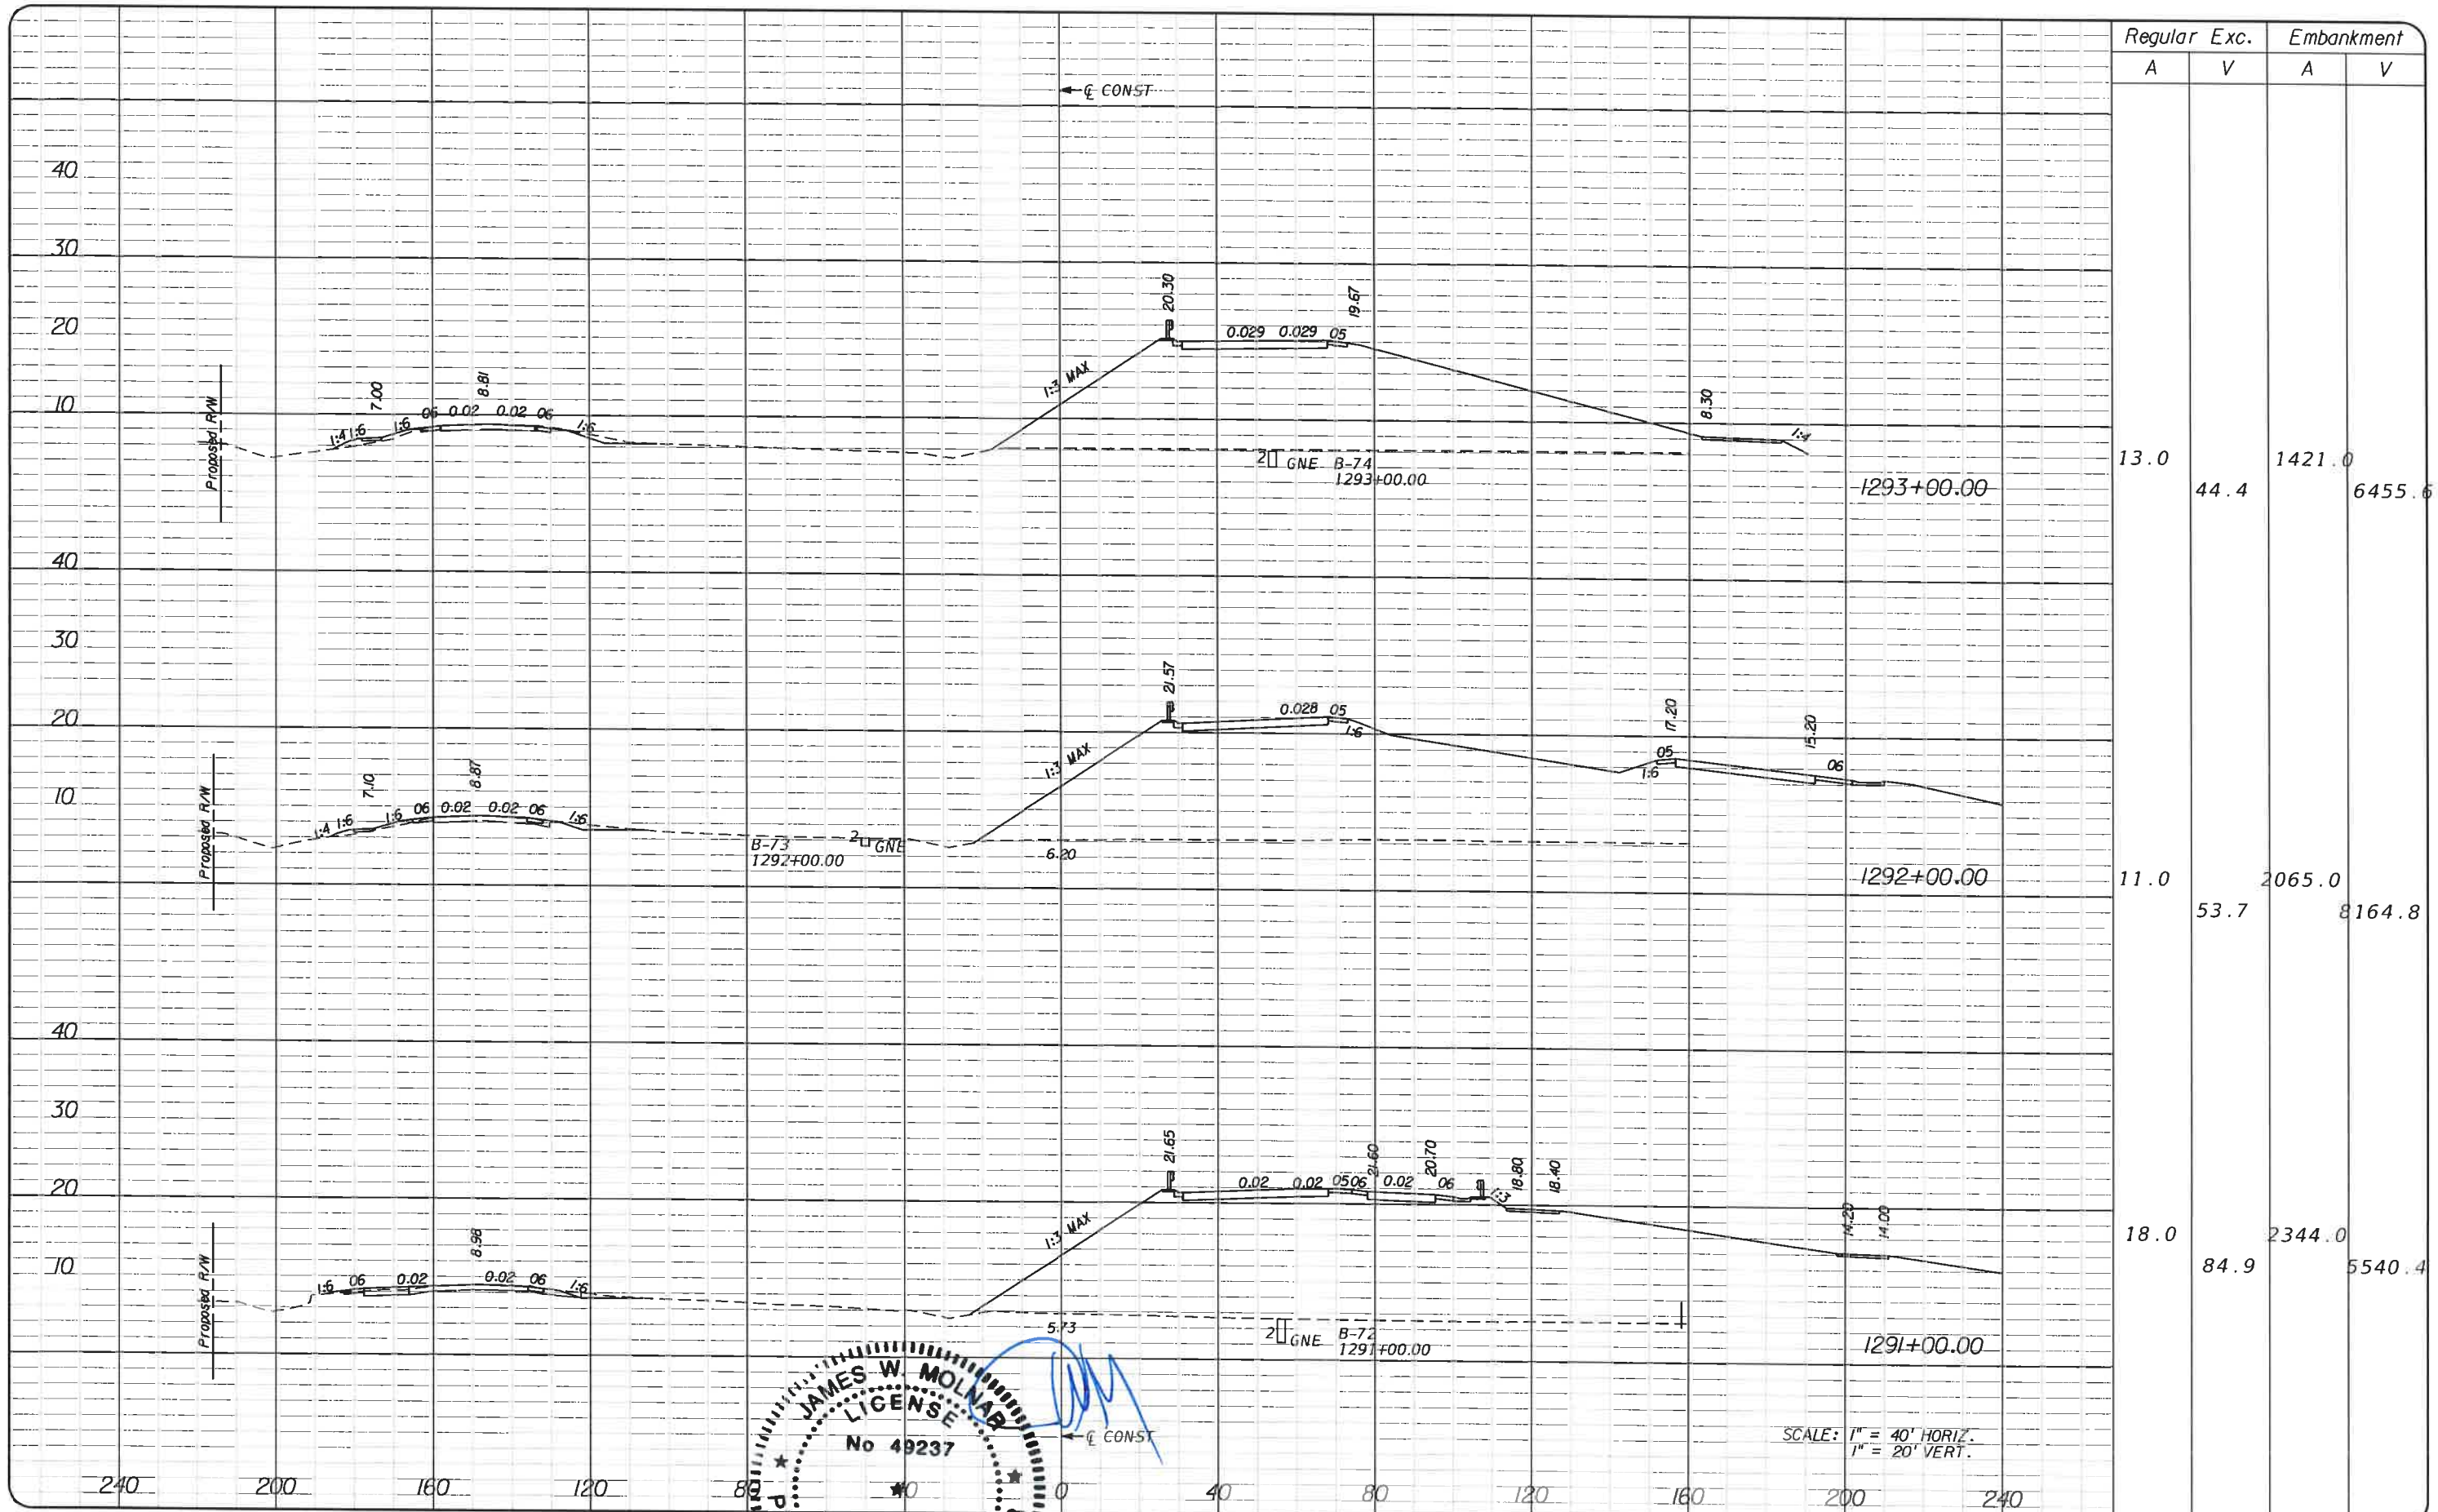

Regular		Exc.		Embankment	
A	V	A	V	A	V
13.0	44.4			1421.0	6455.6
11.0	53.7			2065.0	8164.8
18.0	84.9			2344.0	5540.4

APPROVED: JAMES W. MOLNAR, P.E.
 LICENSE No. 49237
 PROFESSIONAL ENGINEER
 STATE OF FLORIDA
 3-5-2015

T.Y. LIN INTERNATIONAL
 2400 FIRST STREET
 SUITE 200
 FORT MYERS, FLORIDA 33901
 TEL. (239) 332-4846
 FAX. (239) 332-4798
 WWW.TYLIN.COM


PUBLIC WORKS
 LEE COUNTY
 DEPARTMENT of TRANSPORTATION
 SOUTHWEST FLORIDA
 1500 MONROE STREET
 FORT MYERS, FLORIDA 33901
 (239) 479-8900 www.lee-county.com/publicworks/dotlite.htm

CROSS SECTIONS
BURNT STORE ROAD

SHEET NO.
 85

NO.	DATE	BY	REVISIONS - DESCRIPTION

SCALE: 1" = 40' HORIZ.
 1" = 20' VERT.

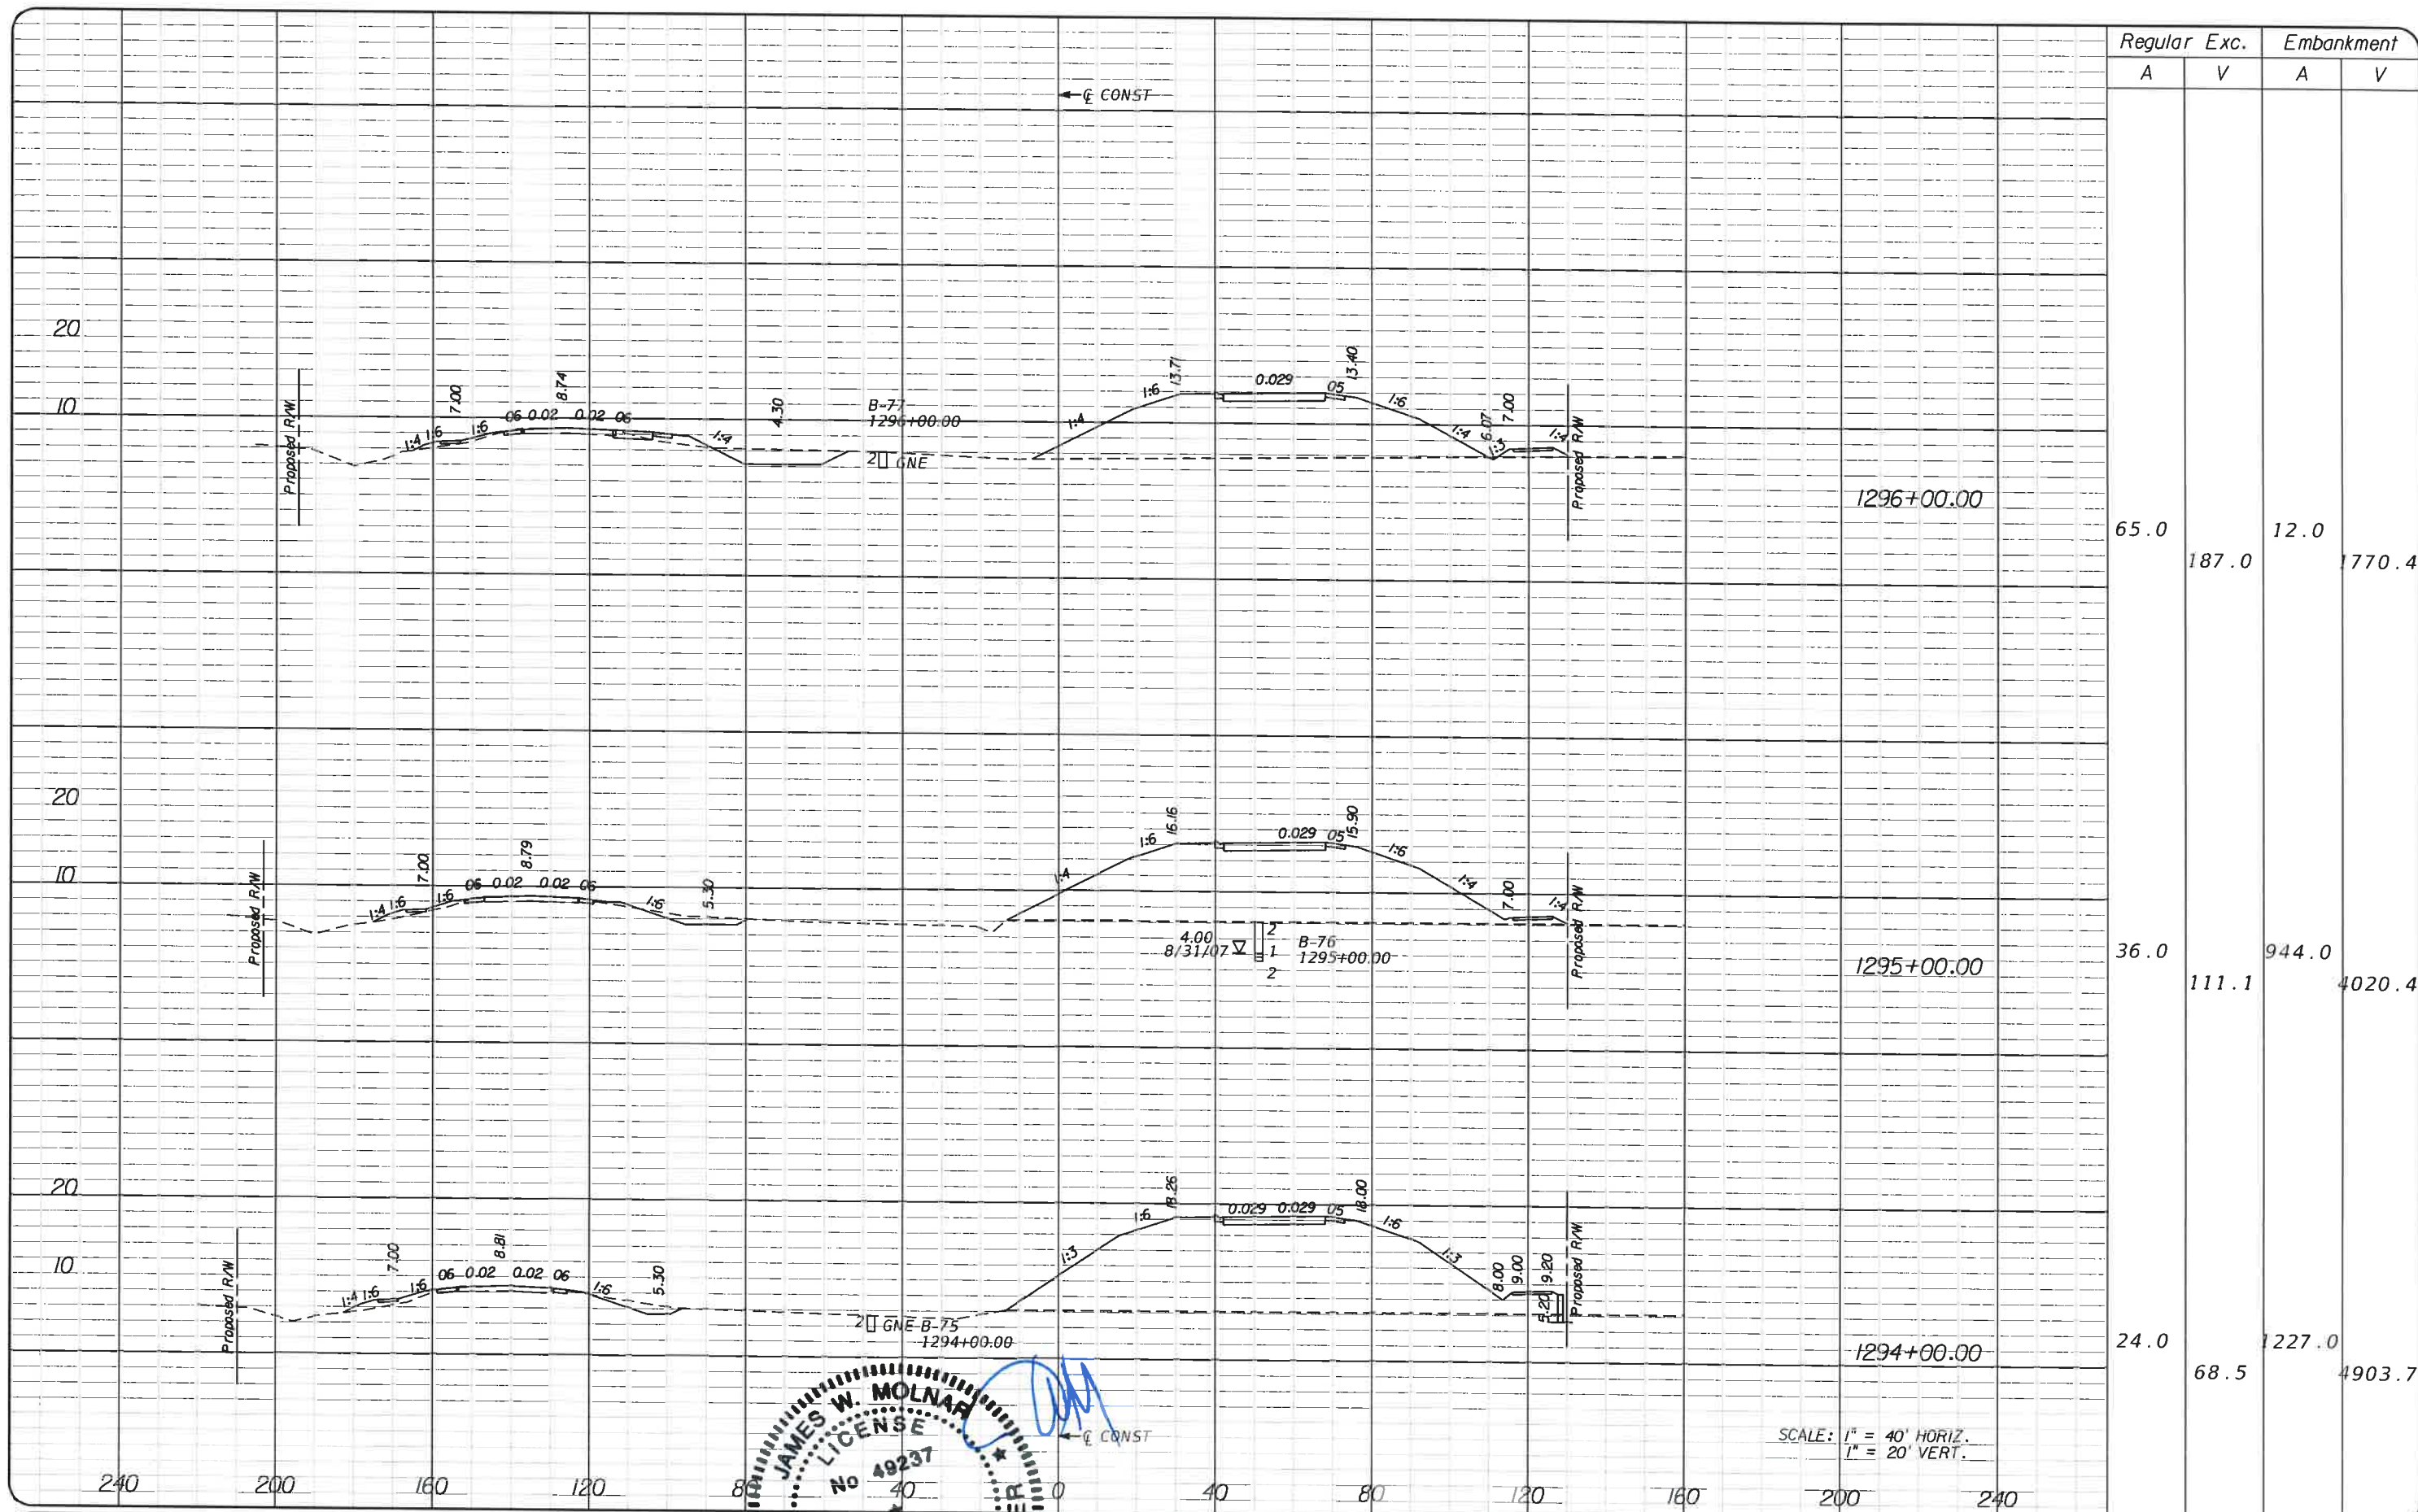

Regular		Exc.		Embankment	
A	V	A	V	A	V
65.0	187.0	12.0		1770.4	
36.0	111.1	944.0		4020.4	
24.0	68.5	1227.0		4903.7	

NO.	DATE	BY	REVISIONS - DESCRIPTION


T.Y. LIN INTERNATIONAL
 2400 FIRST STREET
 SUITE 200
 FORT MYERS, FLORIDA 33901
 TEL. (239) 332-4846
 FAX. (239) 332-4798
 www.tylin.com

JAMES W. MOLNAR
 LICENSE No. 49237
 PROFESSIONAL ENGINEER
 STATE OF FLORIDA
 APPROVED 3/4/2015

PUBLIC WORKS
 LEE COUNTY
 DEPARTMENT of TRANSPORTATION
 SOUTHWEST FLORIDA
 1500 MONROE STREET
 FORT MYERS, FLORIDA 33901
 (239) 479-8900 www.lee-county.com/publicworks/dot/le.htm

CROSS SECTIONS
BURNT STORE ROAD

T:\Temp\Legacy\Projects\581595.00_Burnt_Store_RD\Burnt_Store_Roadway\RD\SRD01N.dgn
 3/4/2015 5:38:53 PM
 Rtxstd.shg

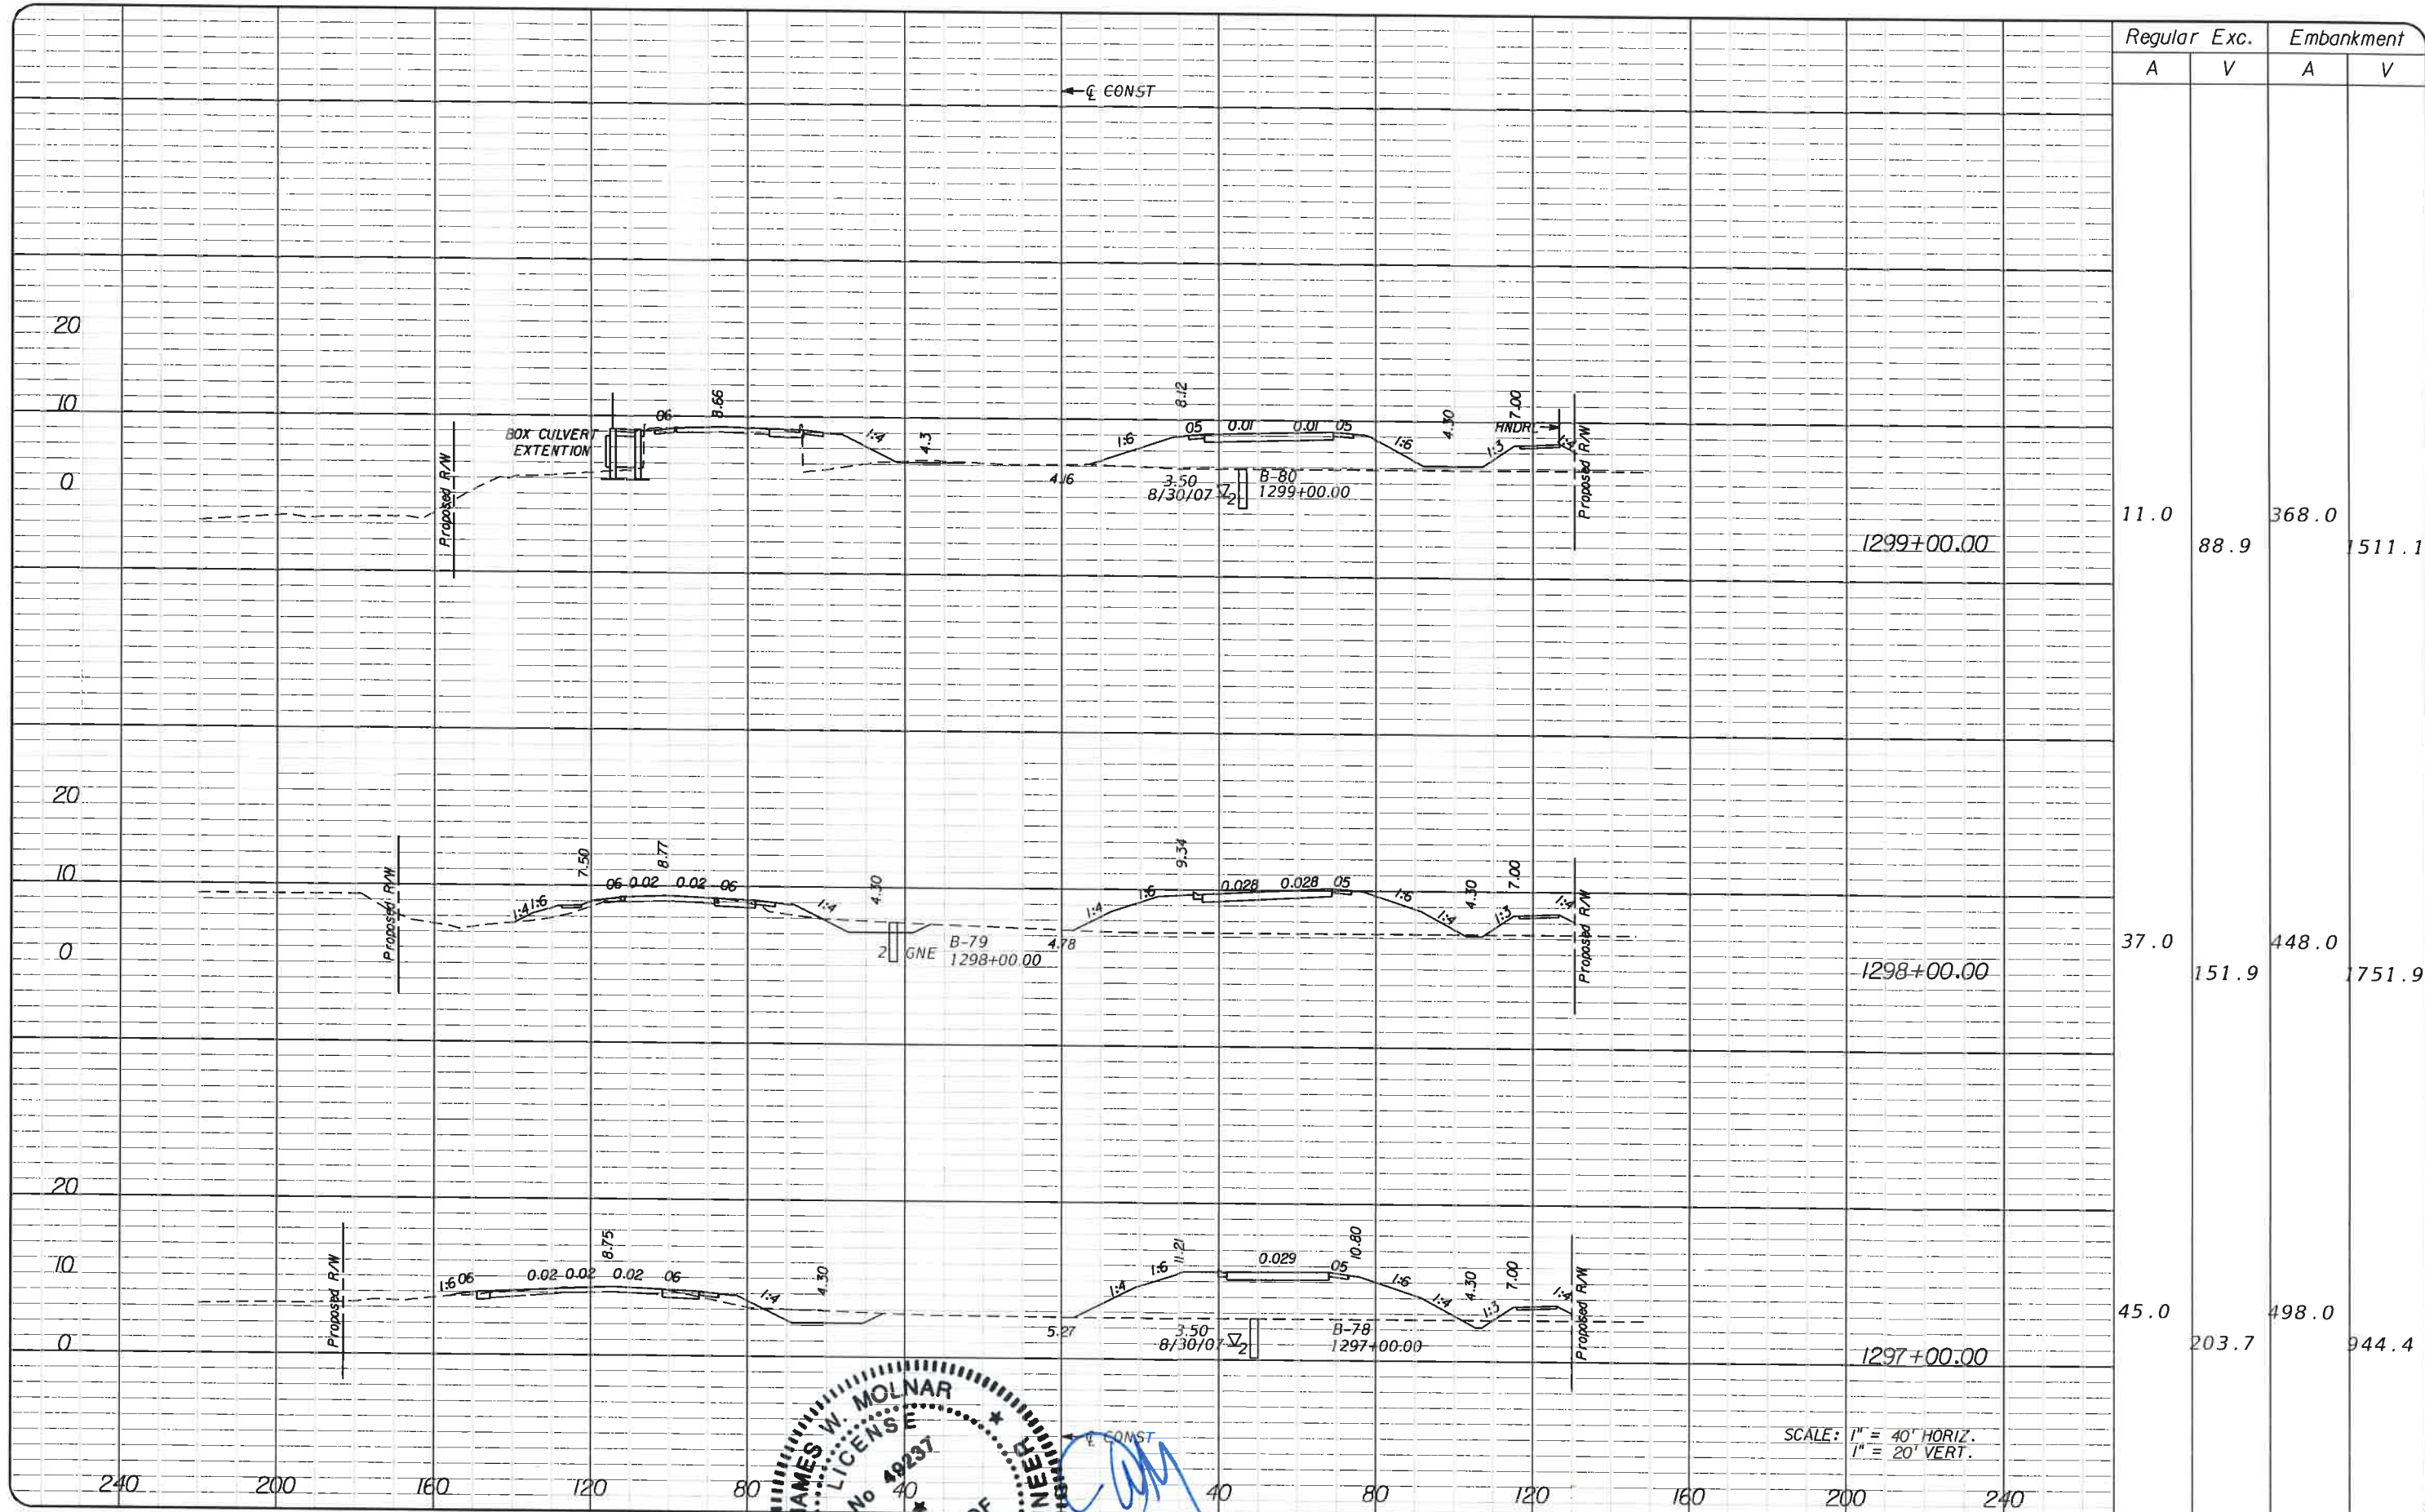

SCALE: 1" = 40' HORIZ.
1" = 20' VERT.

JAMES W. MOLNAR
 LICENSED PROFESSIONAL ENGINEER
 No. 49237
 STATE OF FLORIDA
 PROFESSIONAL ENGINEER
 2015


T.Y. LIN INTERNATIONAL
 2400 FIRST STREET
 SUITE 200
 FORT MYERS, FLORIDA 33901
 TEL. (239) 332-4846
 FAX. (239) 332-4798
 WWW.TYLIN.COM

PUBLIC WORKS
LEE COUNTY
 DEPARTMENT
 of
SOUTHWEST
FLORIDA
 1500 MONROE STREET
 FORT MYERS, FLORIDA 33901
 (239) 479-8900 www.lee-county.com/publicworks/rdstills.htm
 3/4/2015 5:28:14 PM

CROSS SECTIONS
BURNT STORE ROAD

SHEET
 NO.
 87

NO.	DATE	BY	REVISIONS - DESCRIPTION

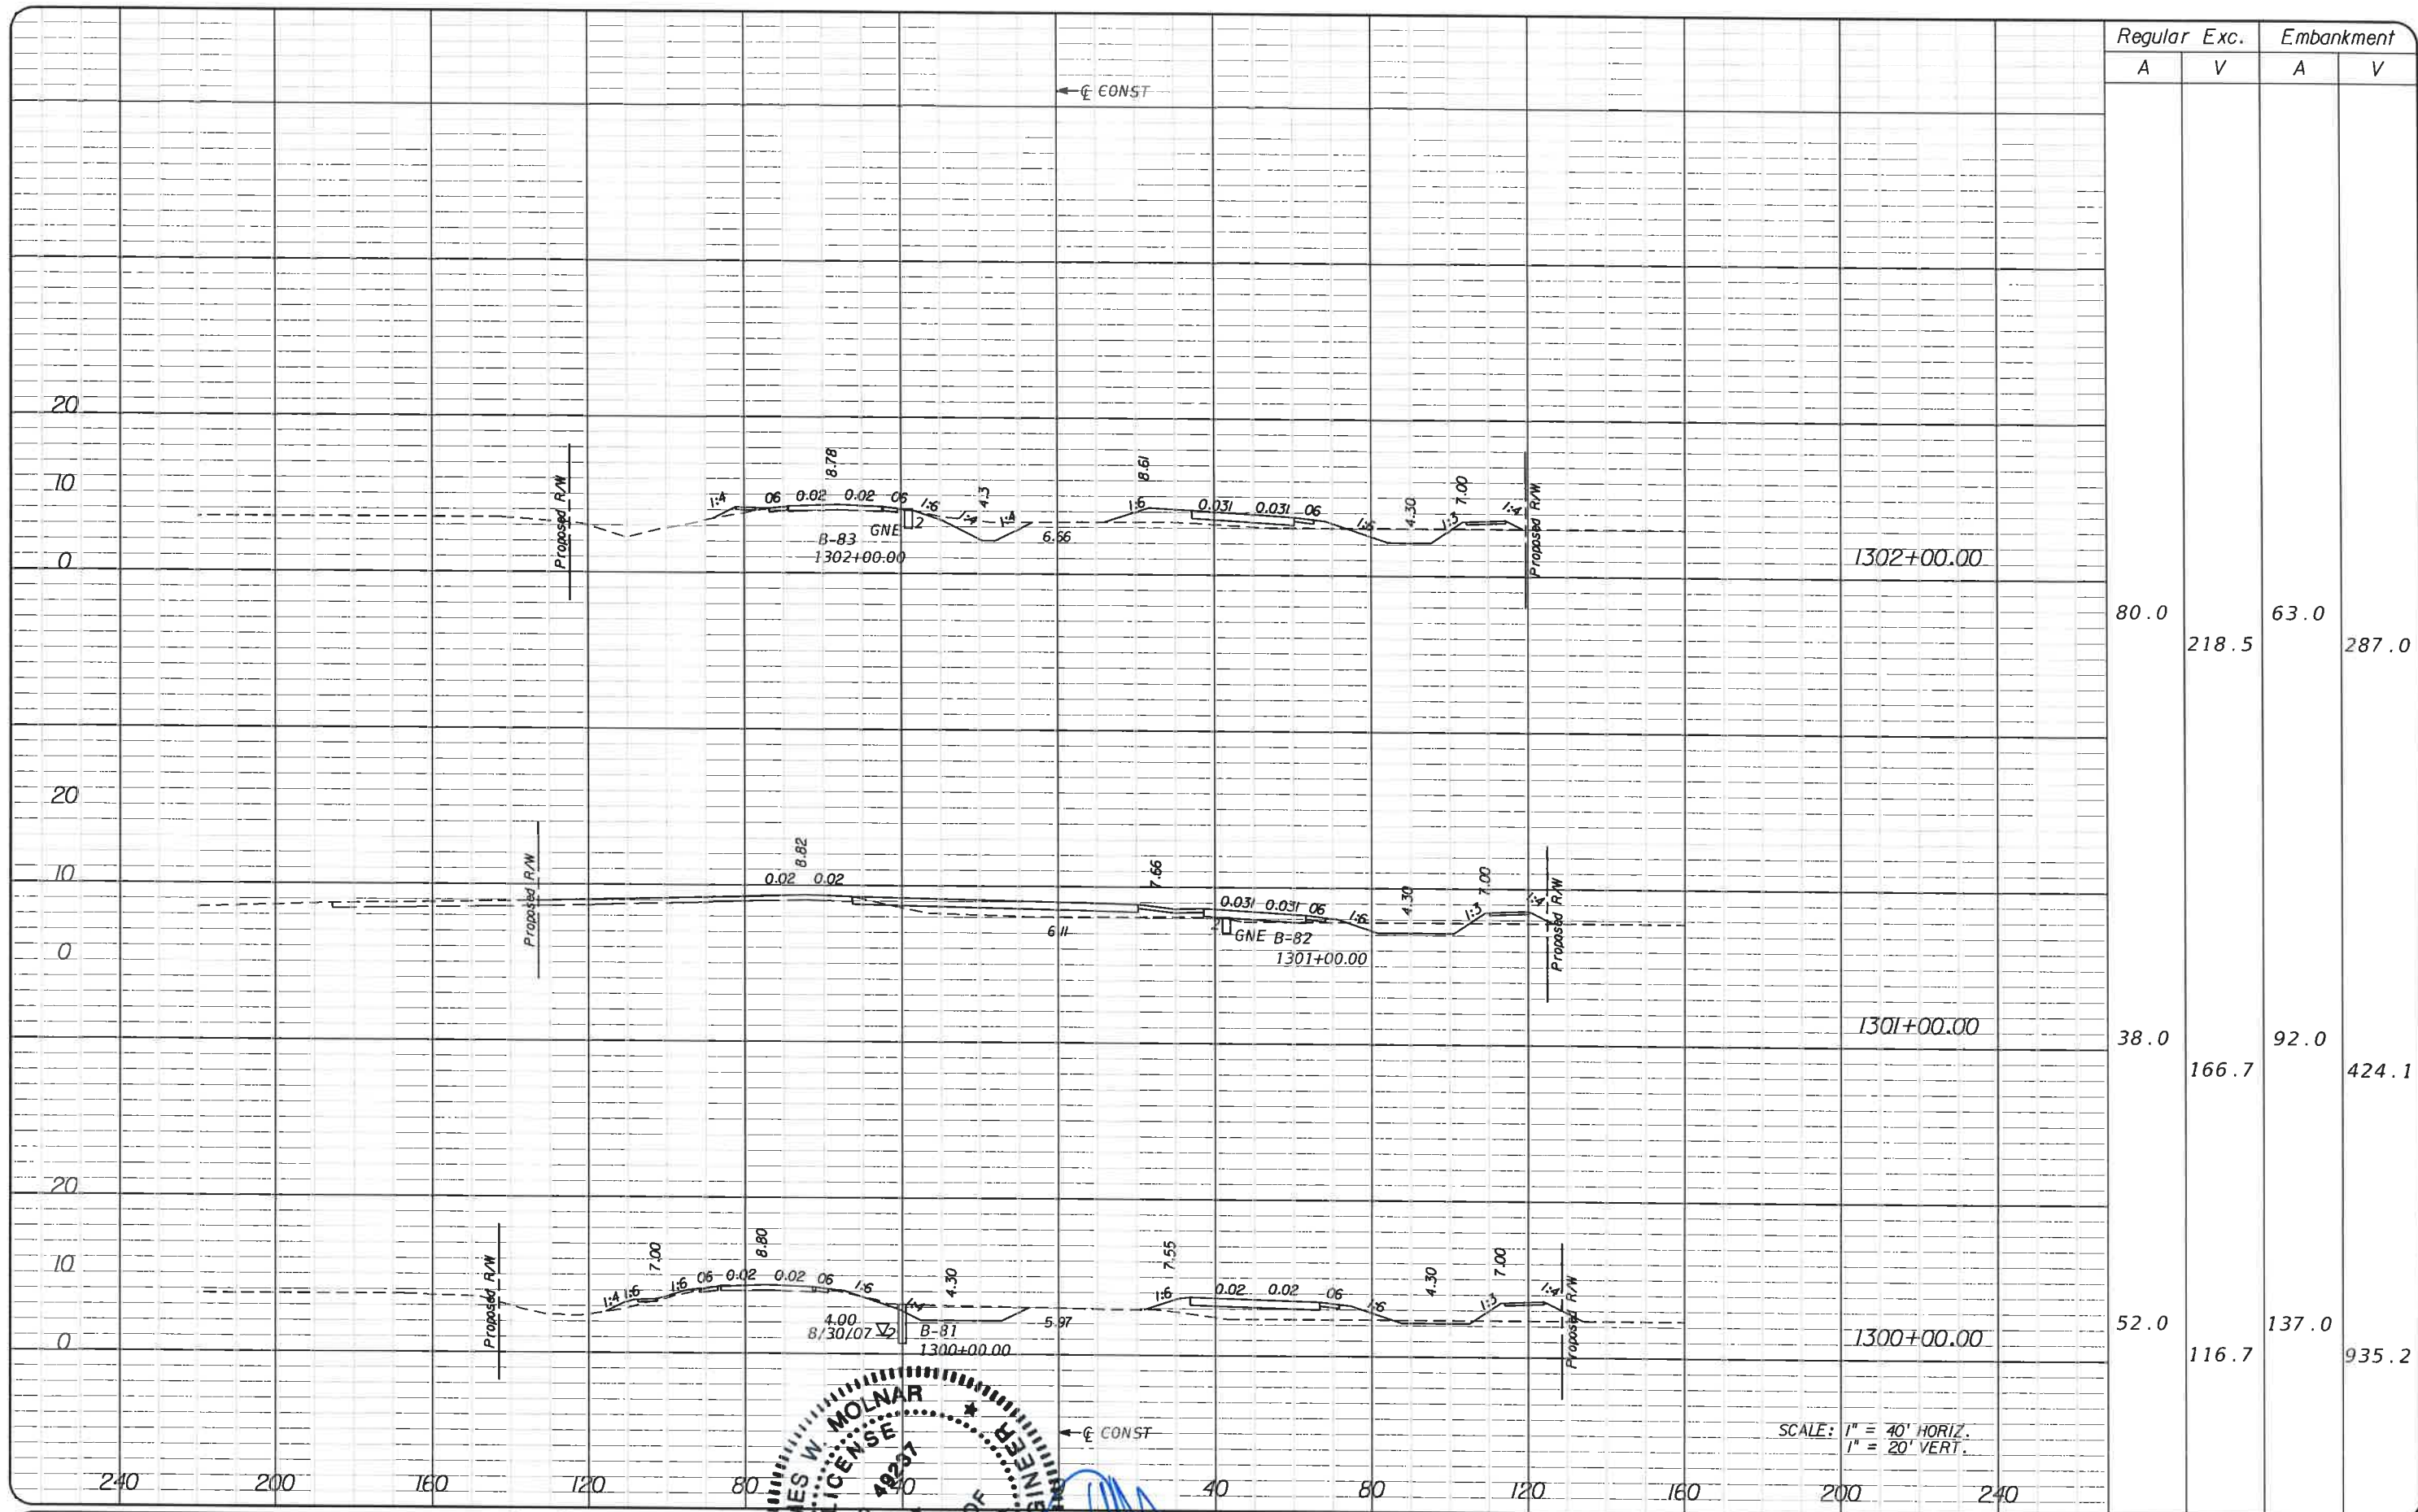

Regular Exc. Embankment

A V A V

Station	Regular A	Exc. V	Embankment A	Embankment V
1302+00.00	80.0	218.5	63.0	287.0
1301+00.00	38.0	166.7	92.0	424.1
1300+00.00	52.0	116.7	137.0	935.2

SCALE: 1" = 40' HORIZ.
1" = 20' VERT.

NO.	DATE	BY	REVISIONS - DESCRIPTION


T.Y. LIN INTERNATIONAL
 2400 FIRST STREET
 SUITE 200
 FORT MYERS, FLORIDA 33901
 TEL. (239) 332-4846
 FAX. (239) 332-4798
 WWW.TYLIN.COM

APPROVED
JAMES W. MOLNAR, P.E.
 REGISTERED PROFESSIONAL ENGINEER
 LICENSE NO. 49237
 2015

PUBLIC WORKS
LEE COUNTY
 DEPARTMENT
 of
 TRANSPORTATION
 SOUTHWEST
 FLORIDA
 1500 MONROE STREET
 FORT MYERS, FLORIDA 33901
 (239) 478-8900
 www.lee-county.com/publicworks/mst/ps/ps.htm

CROSS SECTIONS
BURNT STORE ROAD

SHEET NO.
 88

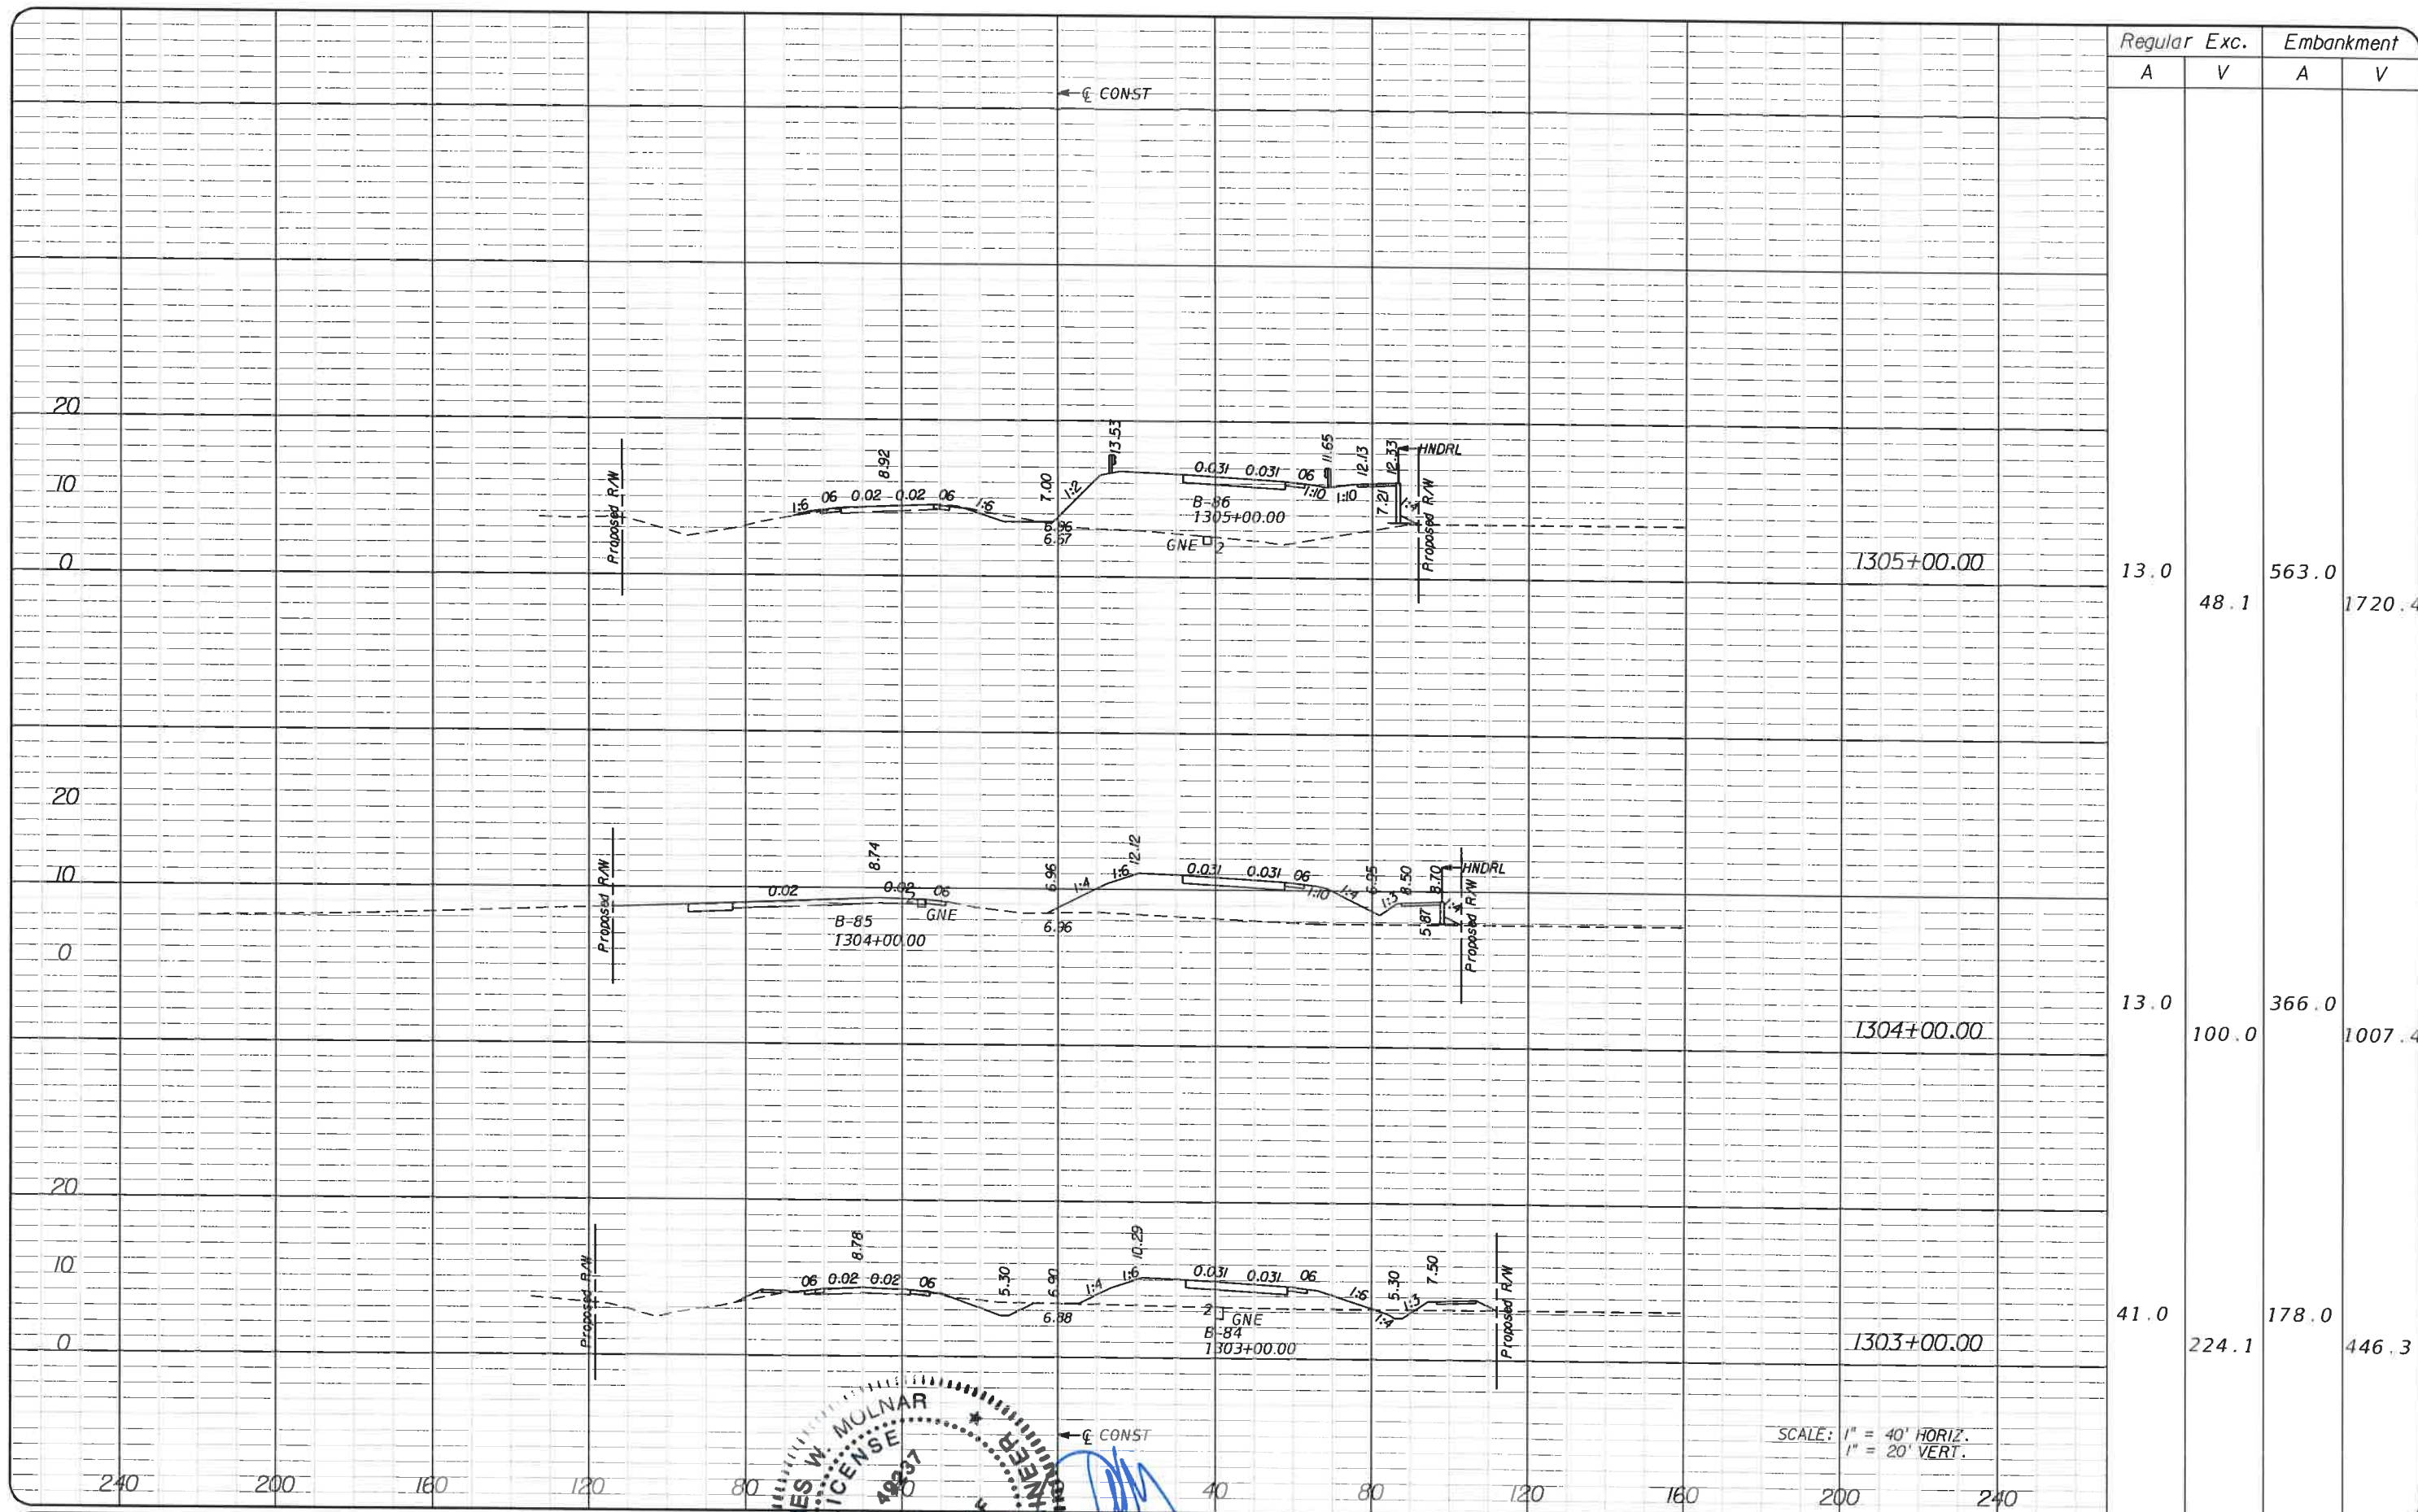

Regular		Exc.		Embankment	
A	V	A	V	A	V
13.0	48.1	563.0		1720.4	
13.0	100.0	366.0		1007.4	
41.0	224.1	178.0		446.3	

SCALE: 1" = 40' HORIZ.
1" = 20' VERT.

NO.	DATE	BY	REVISIONS - DESCRIPTION


T.Y. LIN INTERNATIONAL
2400 FIRST STREET
SUITE 200
FORT MYERS, FLORIDA 33901
TEL. (239) 332-4846
FAX. (239) 332-4798
WWW.TYLIN.COM

PROPOSED BY
JAMES W. MOLNAR, P.E.
REGISTERED PROFESSIONAL ENGINEER
FLORIDA LICENSE NO. 49237
DATE: 3/4/2015

PUBLIC WORKS
LEE COUNTY
SOUTHWEST
FLORIDA
1500 MONROE STREET
FORT MYERS, FLORIDA 33901
1231 479-8900 www.lee-county.com/publicworks/submit.htm


CROSS SECTIONS
BURNT STORE ROAD

SHEET NO.
89

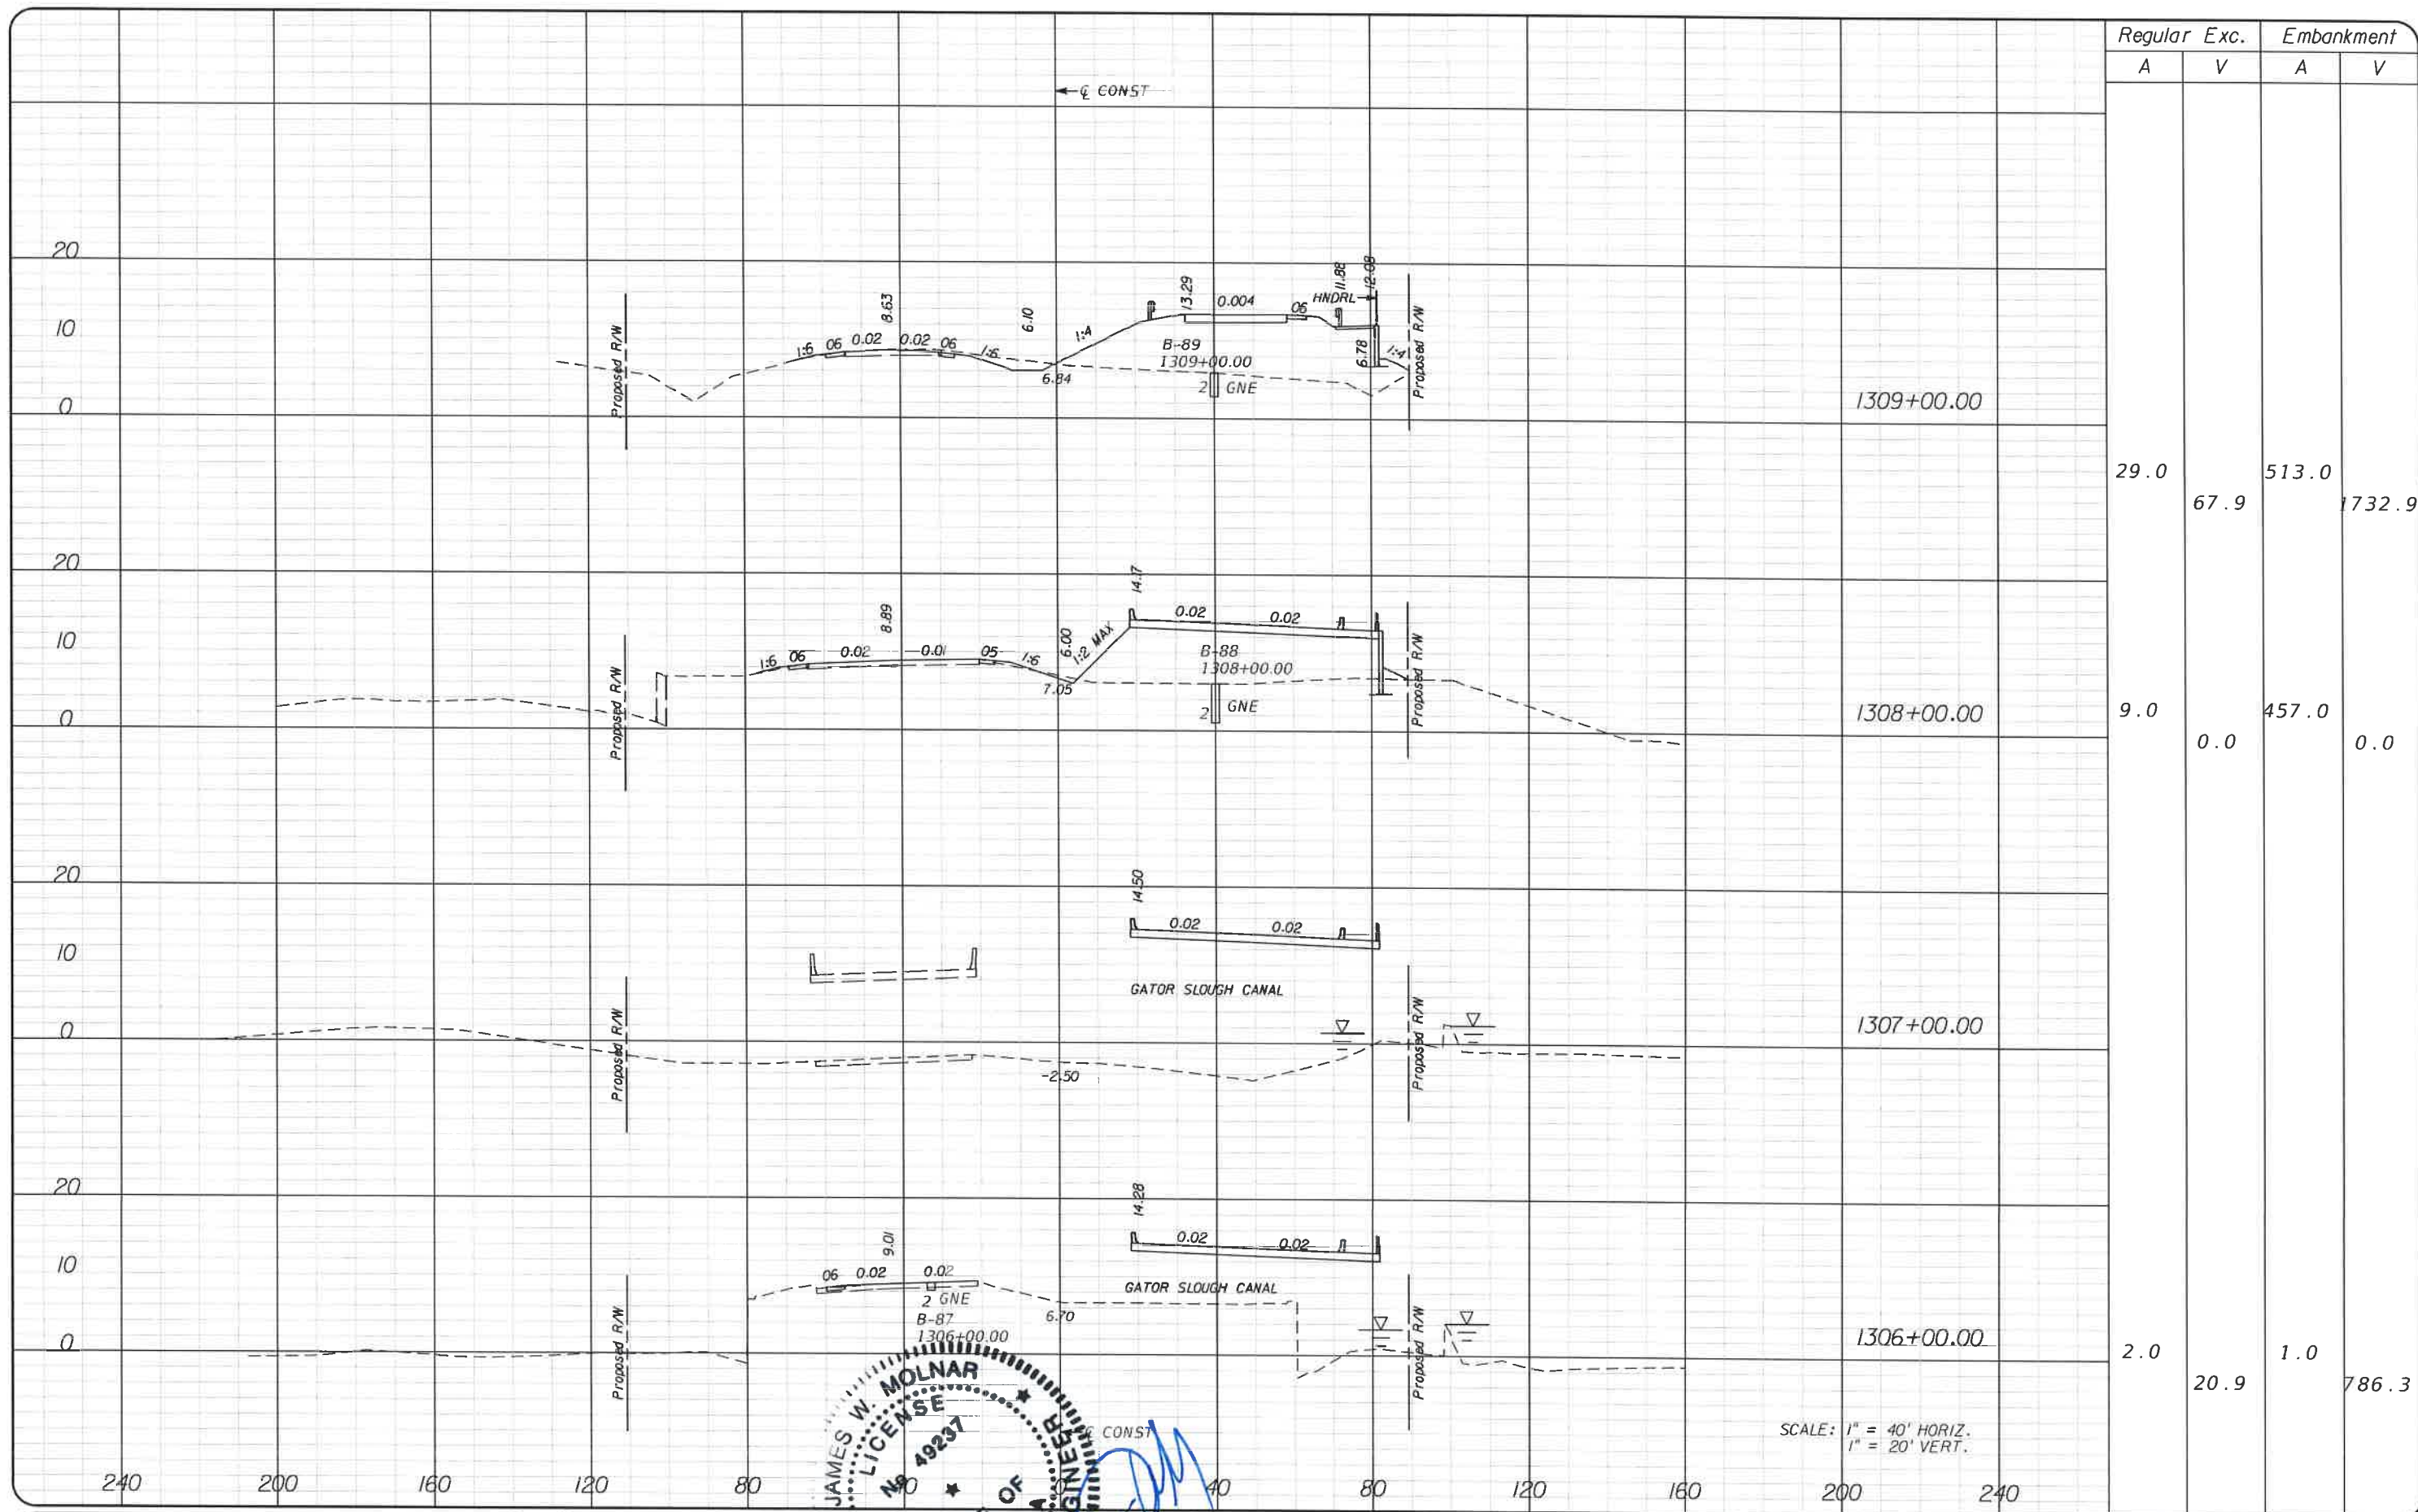

	Regular		Exc.		Embankment	
	A	V	A	V	A	V
1309+00.00						
	29.0		67.9		513.0	1732.9
1308+00.00						
	9.0		0.0		457.0	0.0
1307+00.00						
1306+00.00						
	2.0		20.9		1.0	786.3

SCALE: 1" = 40' HORIZ.
1" = 20' VERT.

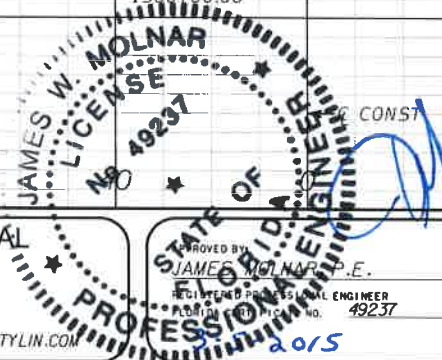

NO.	DATE	BY	REVISIONS - DESCRIPTION

T.Y. LIN INTERNATIONAL
2400 FIRST STREET
SUITE 200
FORT MYERS, FLORIDA 33901
TEL. (239) 332-4846
FAX. (239) 332-4798
WWW.TYLIN.COM


APPROVED BY
JAMES W. MOLNAR, P.E.
PROFESSIONAL ENGINEER
LICENSE NO. 49237
2015

PUBLIC WORKS
LEE COUNTY
SOUTHWEST
FLORIDA
1500 MONROE STREET
FORT MYERS, FLORIDA 33901
12391 479-8900

DEPARTMENT
of
TRANSPORTATION

CROSS SECTIONS
BURNT STORE ROAD

SHEET NO.
90

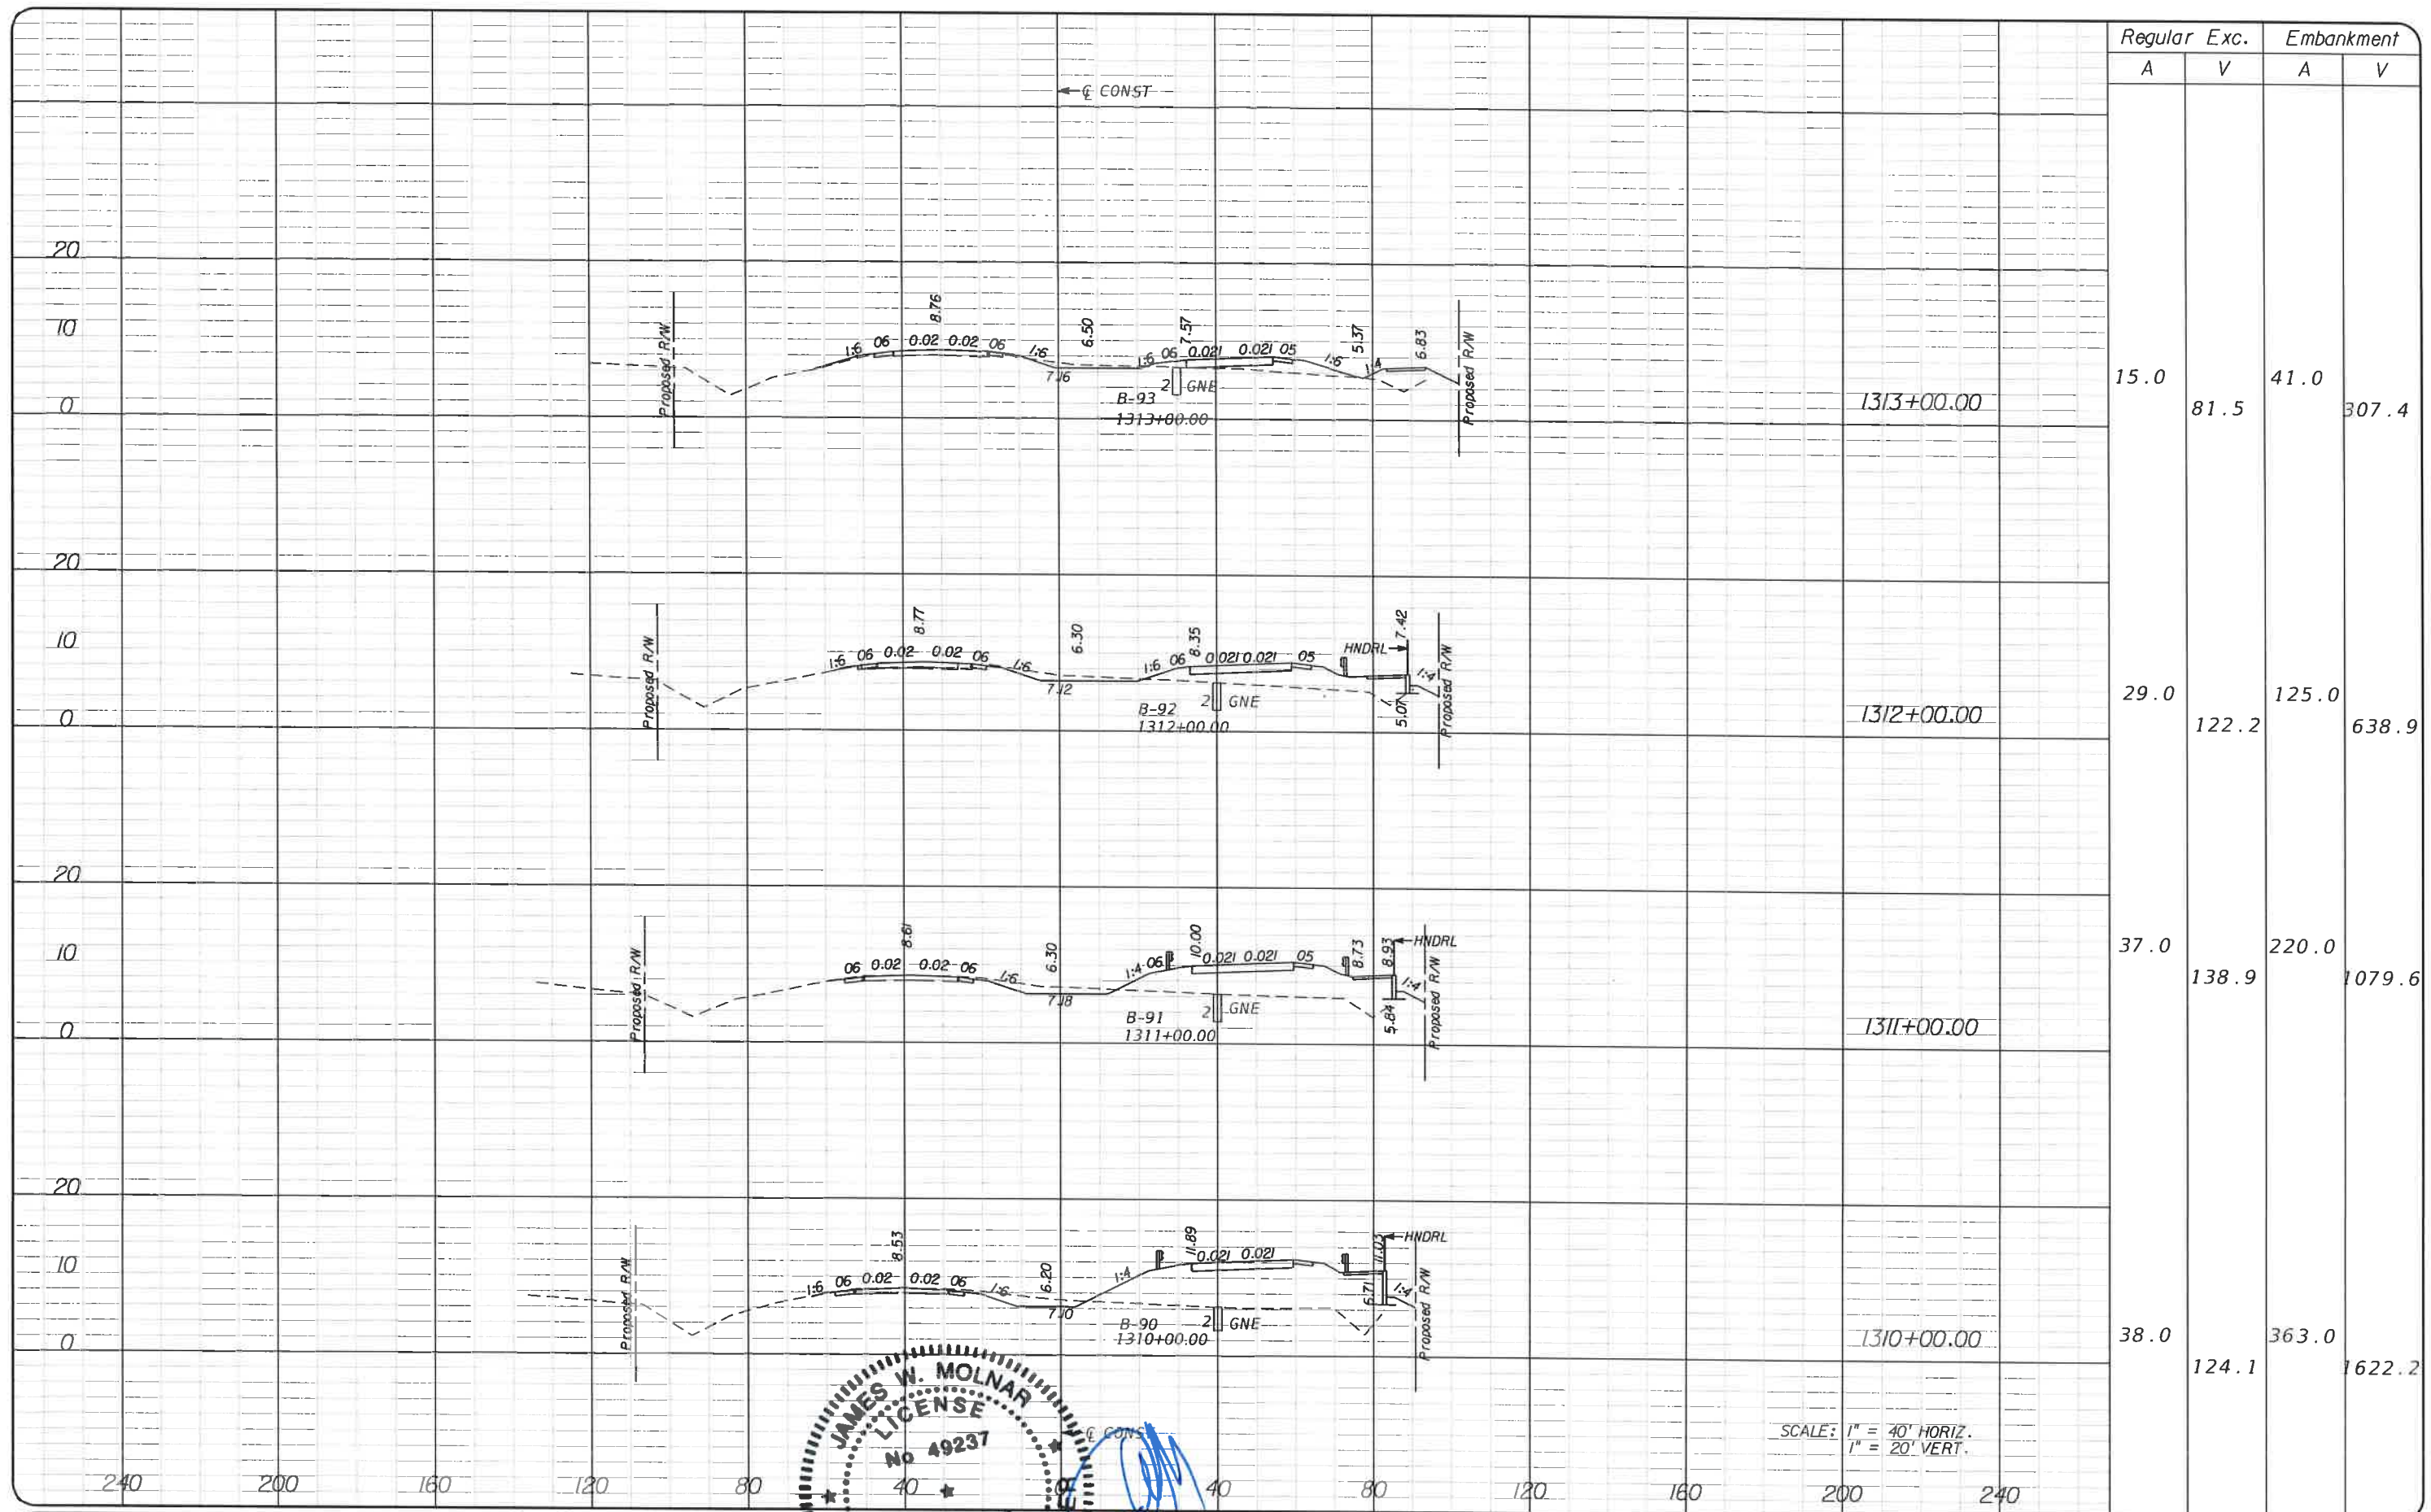

	Regular Exc.		Embankment	
	A	V	A	V
1313+00.00	15.0	81.5	41.0	307.4
1312+00.00	29.0	122.2	125.0	638.9
1311+00.00	37.0	138.9	220.0	1079.6
1310+00.00	38.0	124.1	363.0	1622.2

No.	DATE	BY	REVISIONS - DESCRIPTION

T.Y. LIN INTERNATIONAL
 2400 FIRST STREET
 SUITE 200
 FORT MYERS, FLORIDA 33901
 TEL. (239) 332-4846
 FAX. (239) 332-4798
 WWW.TYLIN.COM


APPROVED BY
JAMES W. MOLNAR, P.E.
 REGISTERED PROFESSIONAL ENGINEER
 LICENSE NO. 49237

PUBLIC WORKS
LEE COUNTY
 SOUTHWEST
 FLORIDA
 1500 MONROE STREET
 (239) 479-8900 www.lee-county.com/publicworks/dot/le_hm

DEPARTMENT
 of
TRANSPORTATION
 FORT MYERS, FLORIDA 33901

CROSS SECTIONS
BURNT STORE ROAD

SHEET
 NO.
 91

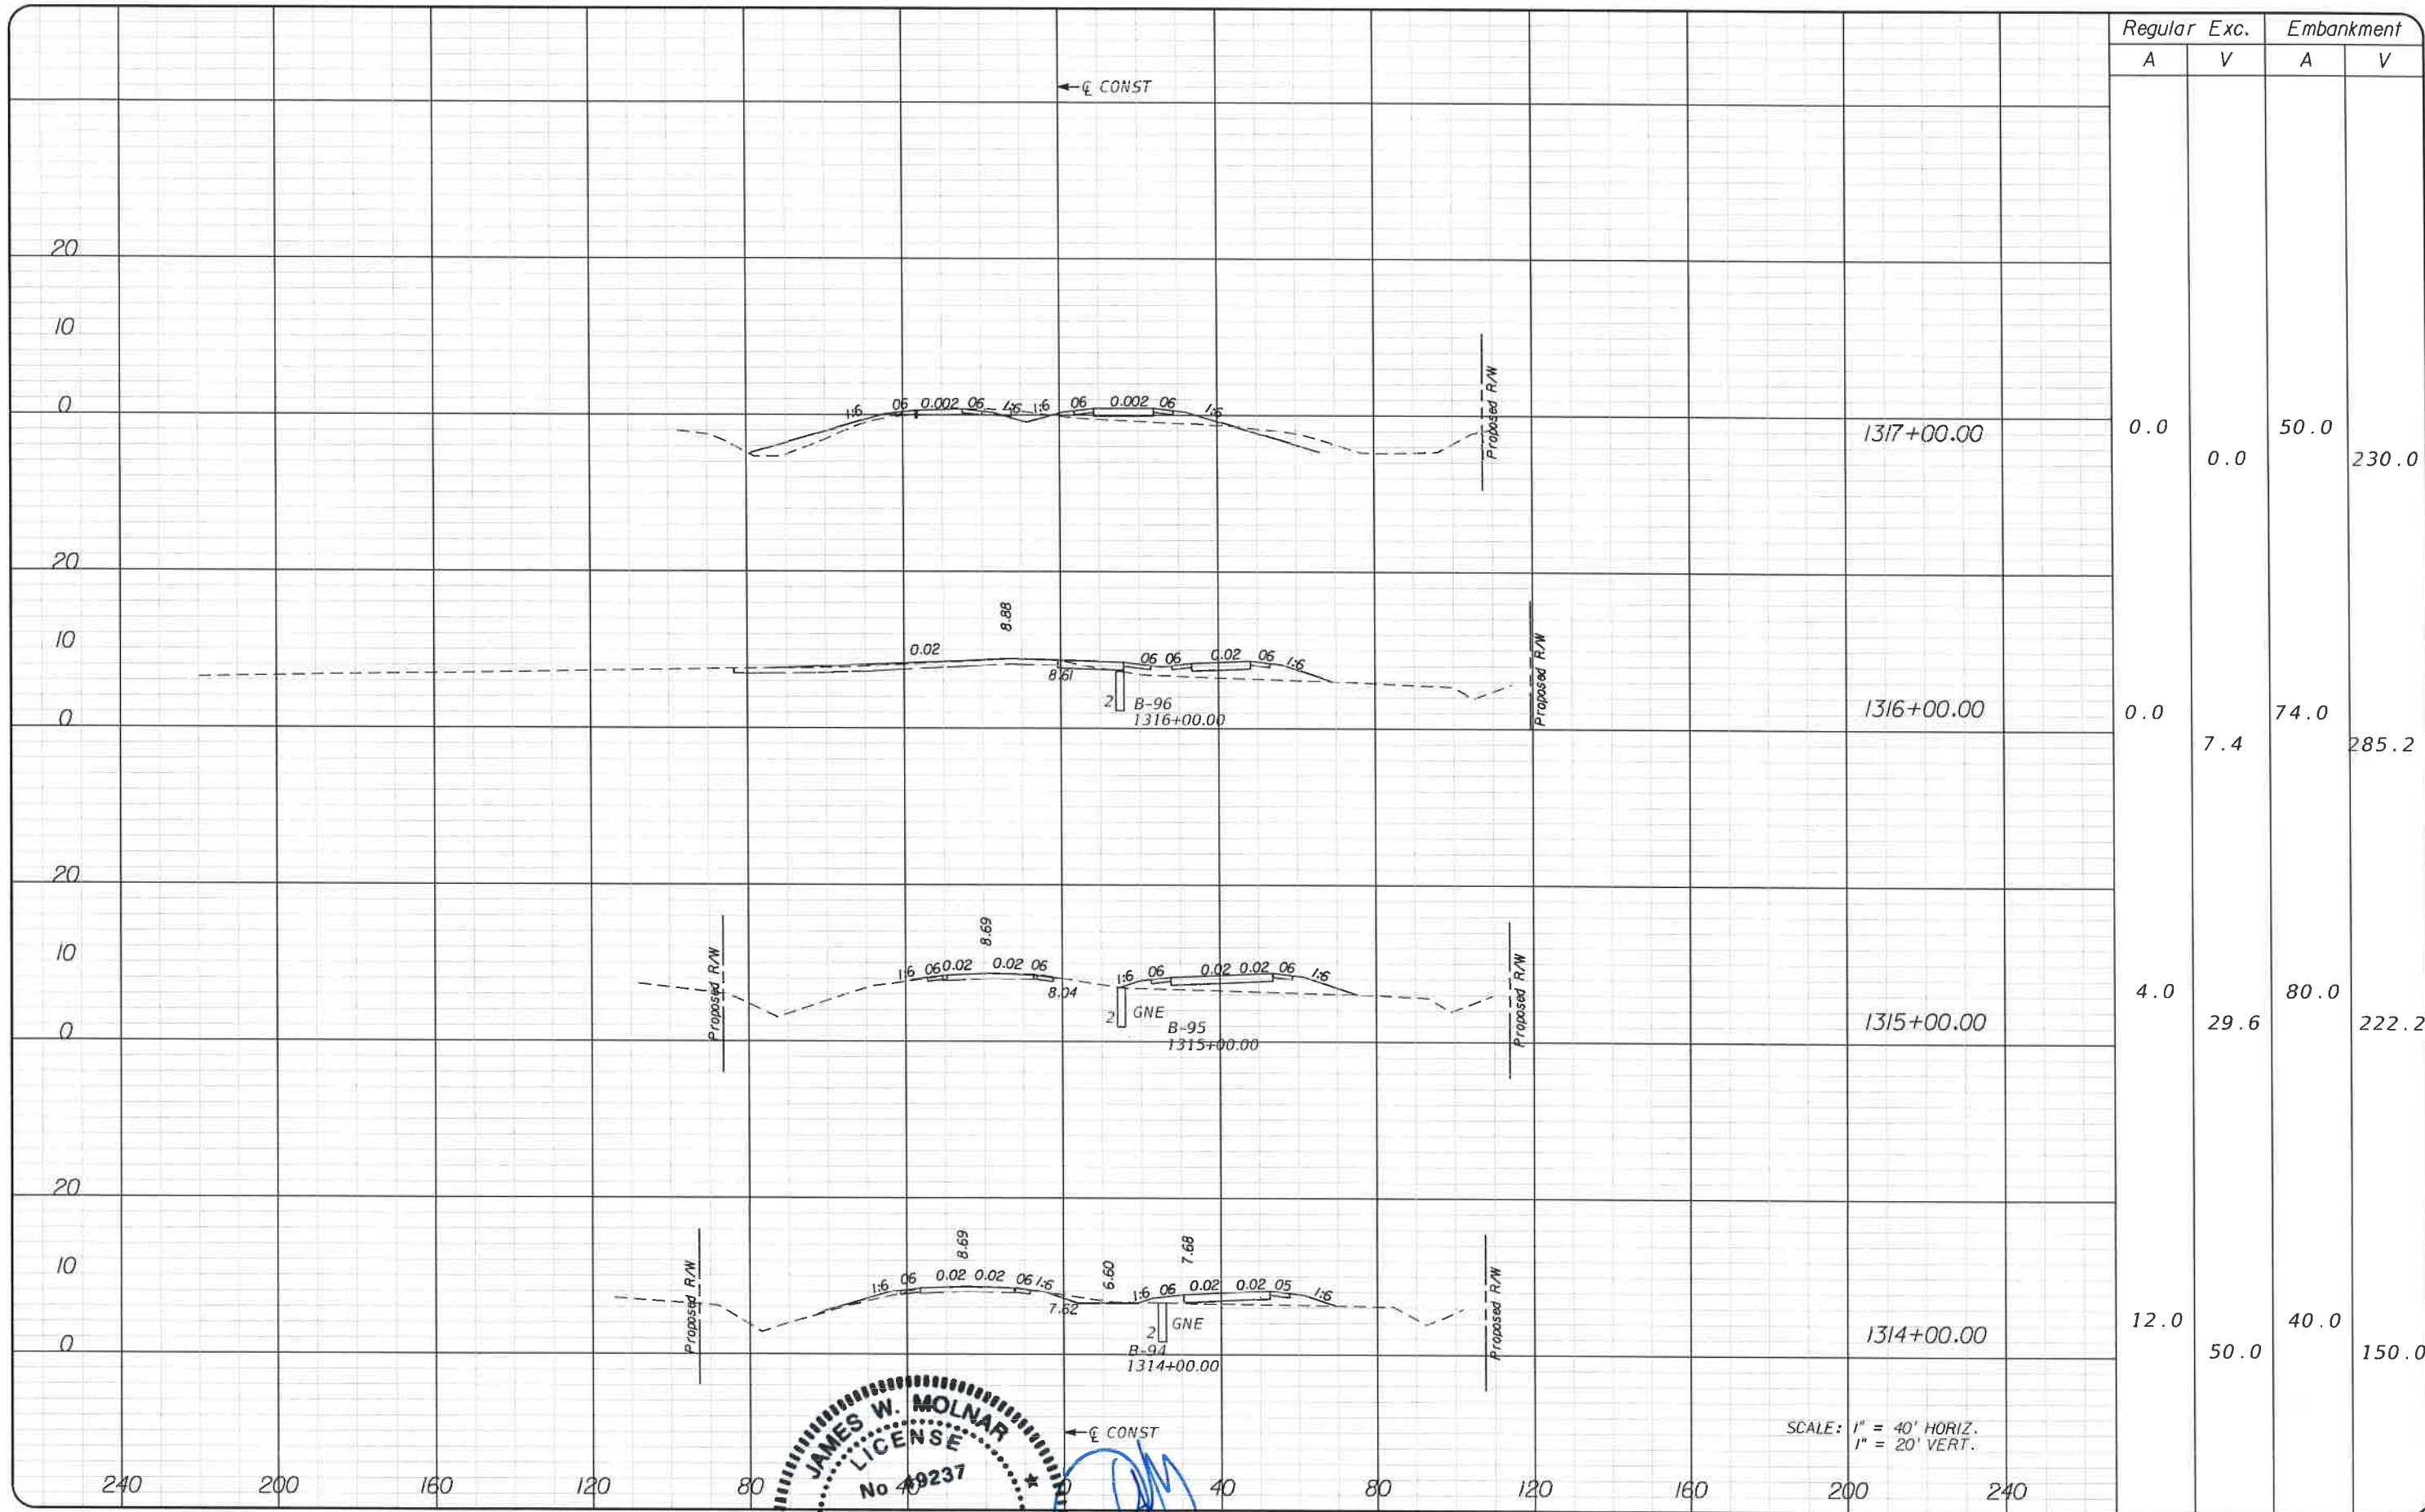

Regular		Exc.		Embankment	
A	V	A	V	A	V
0.0	0.0	50.0		230.0	
0.0	7.4	74.0		285.2	
4.0	29.6	80.0		222.2	
12.0	50.0	40.0		150.0	

SCALE: 1" = 40' HORIZ.
1" = 20' VERT.

APPROVED BY: **JAMES W. MOLNAR, P.E.**
 REGISTERED PROFESSIONAL ENGINEER
 LICENSE NO. 49237

T.Y. LIN INTERNATIONAL
 2400 FIRST STREET
 SUITE 200
 FORT MYERS, FLORIDA 33901
 TEL. (239) 332-4846
 FAX. (239) 332-4798

PUBLIC WORKS
LEE COUNTY
 DEPARTMENT
 of
 TRANSPORTATION
 SOUTHWEST
 FLORIDA
 1300 MONROE STREET
 FORT MYERS, FLORIDA 33901
 12391 479-8900 www.lee-county.com/publicworks/delittle.htm


CROSS SECTIONS
BURNT STORE ROAD

SHEET
 NO.
 92

NO.	DATE	BY	REVISIONS - DESCRIPTION

T:\Tampa\Legacy\Project\581595.00_Burnt_Store_RD\Burnt_Store_Roadway\RD\SR0001.dgn P:\ksr\shg


SUMMARY OF EARTHWORK		
PAY ITEM DESCRIPTION	CY	
	P	F
MAINLINE EARTHWORK		
EMBANKMENT	130887	
EXCAVATION	31018	

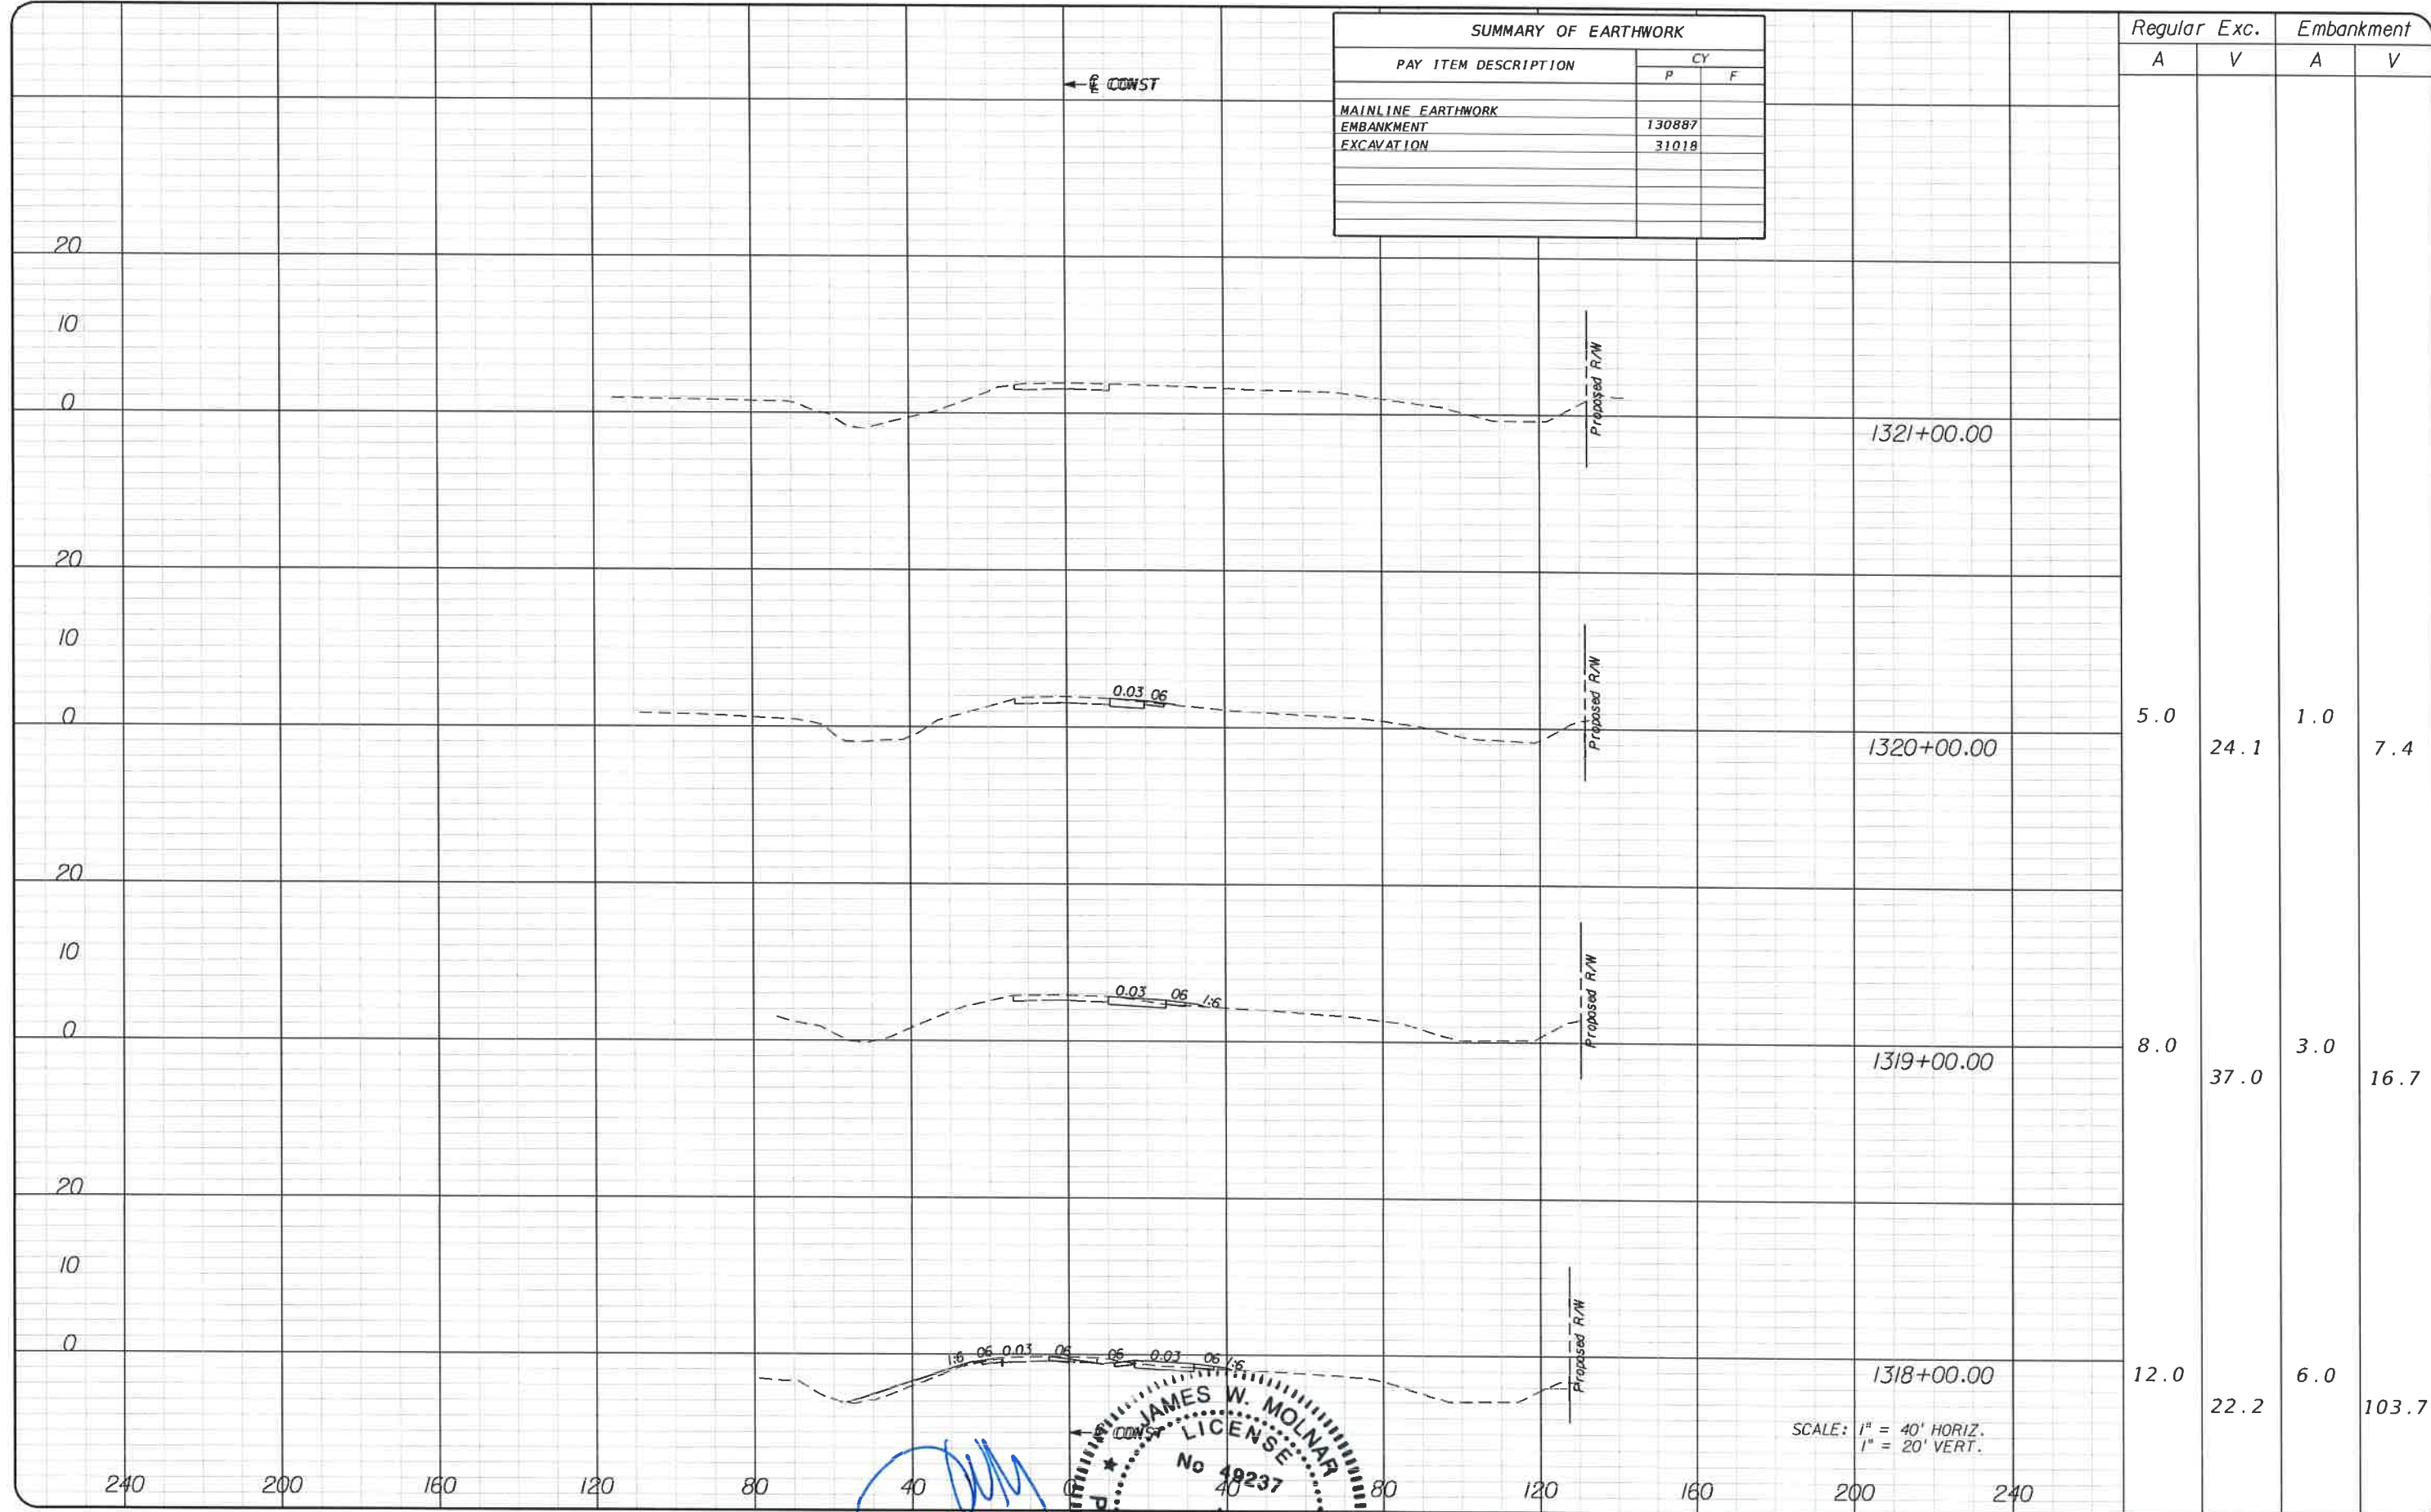

NO.	DATE	BY	REVISIONS - DESCRIPTION

T.Y. LIN INTERNATIONAL
 2400 FIRST STREET
 SUITE 200
 FORT MYERS, FLORIDA 33901
 TEL. (239) 332-4846
 FAX. (239) 332-4798
 WWW.TYLIN.COM

APPROVED BY
JAMES W. MOLNAR
 REGISTERED PROFESSIONAL ENGINEER
 FLORIDA CERTIFICATE NO. 49237
 3-5-2015

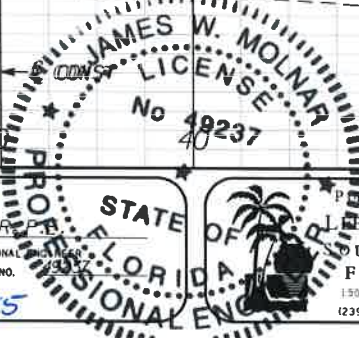


PUBLIC WORKS
 LEHIGH COUNTY
 SOUTHWEST
 FLORIDA
 1500 MONROE STREET
 FORT MYERS, FLORIDA 33901
 (239) 479-8900 www.lec-county.com/publicworks/dotitle.htm

CROSS SECTIONS
BURNT STORE ROAD

SHEET NO.
 93

Regular		Exc.		Embankment	
A	V	A	V	A	V

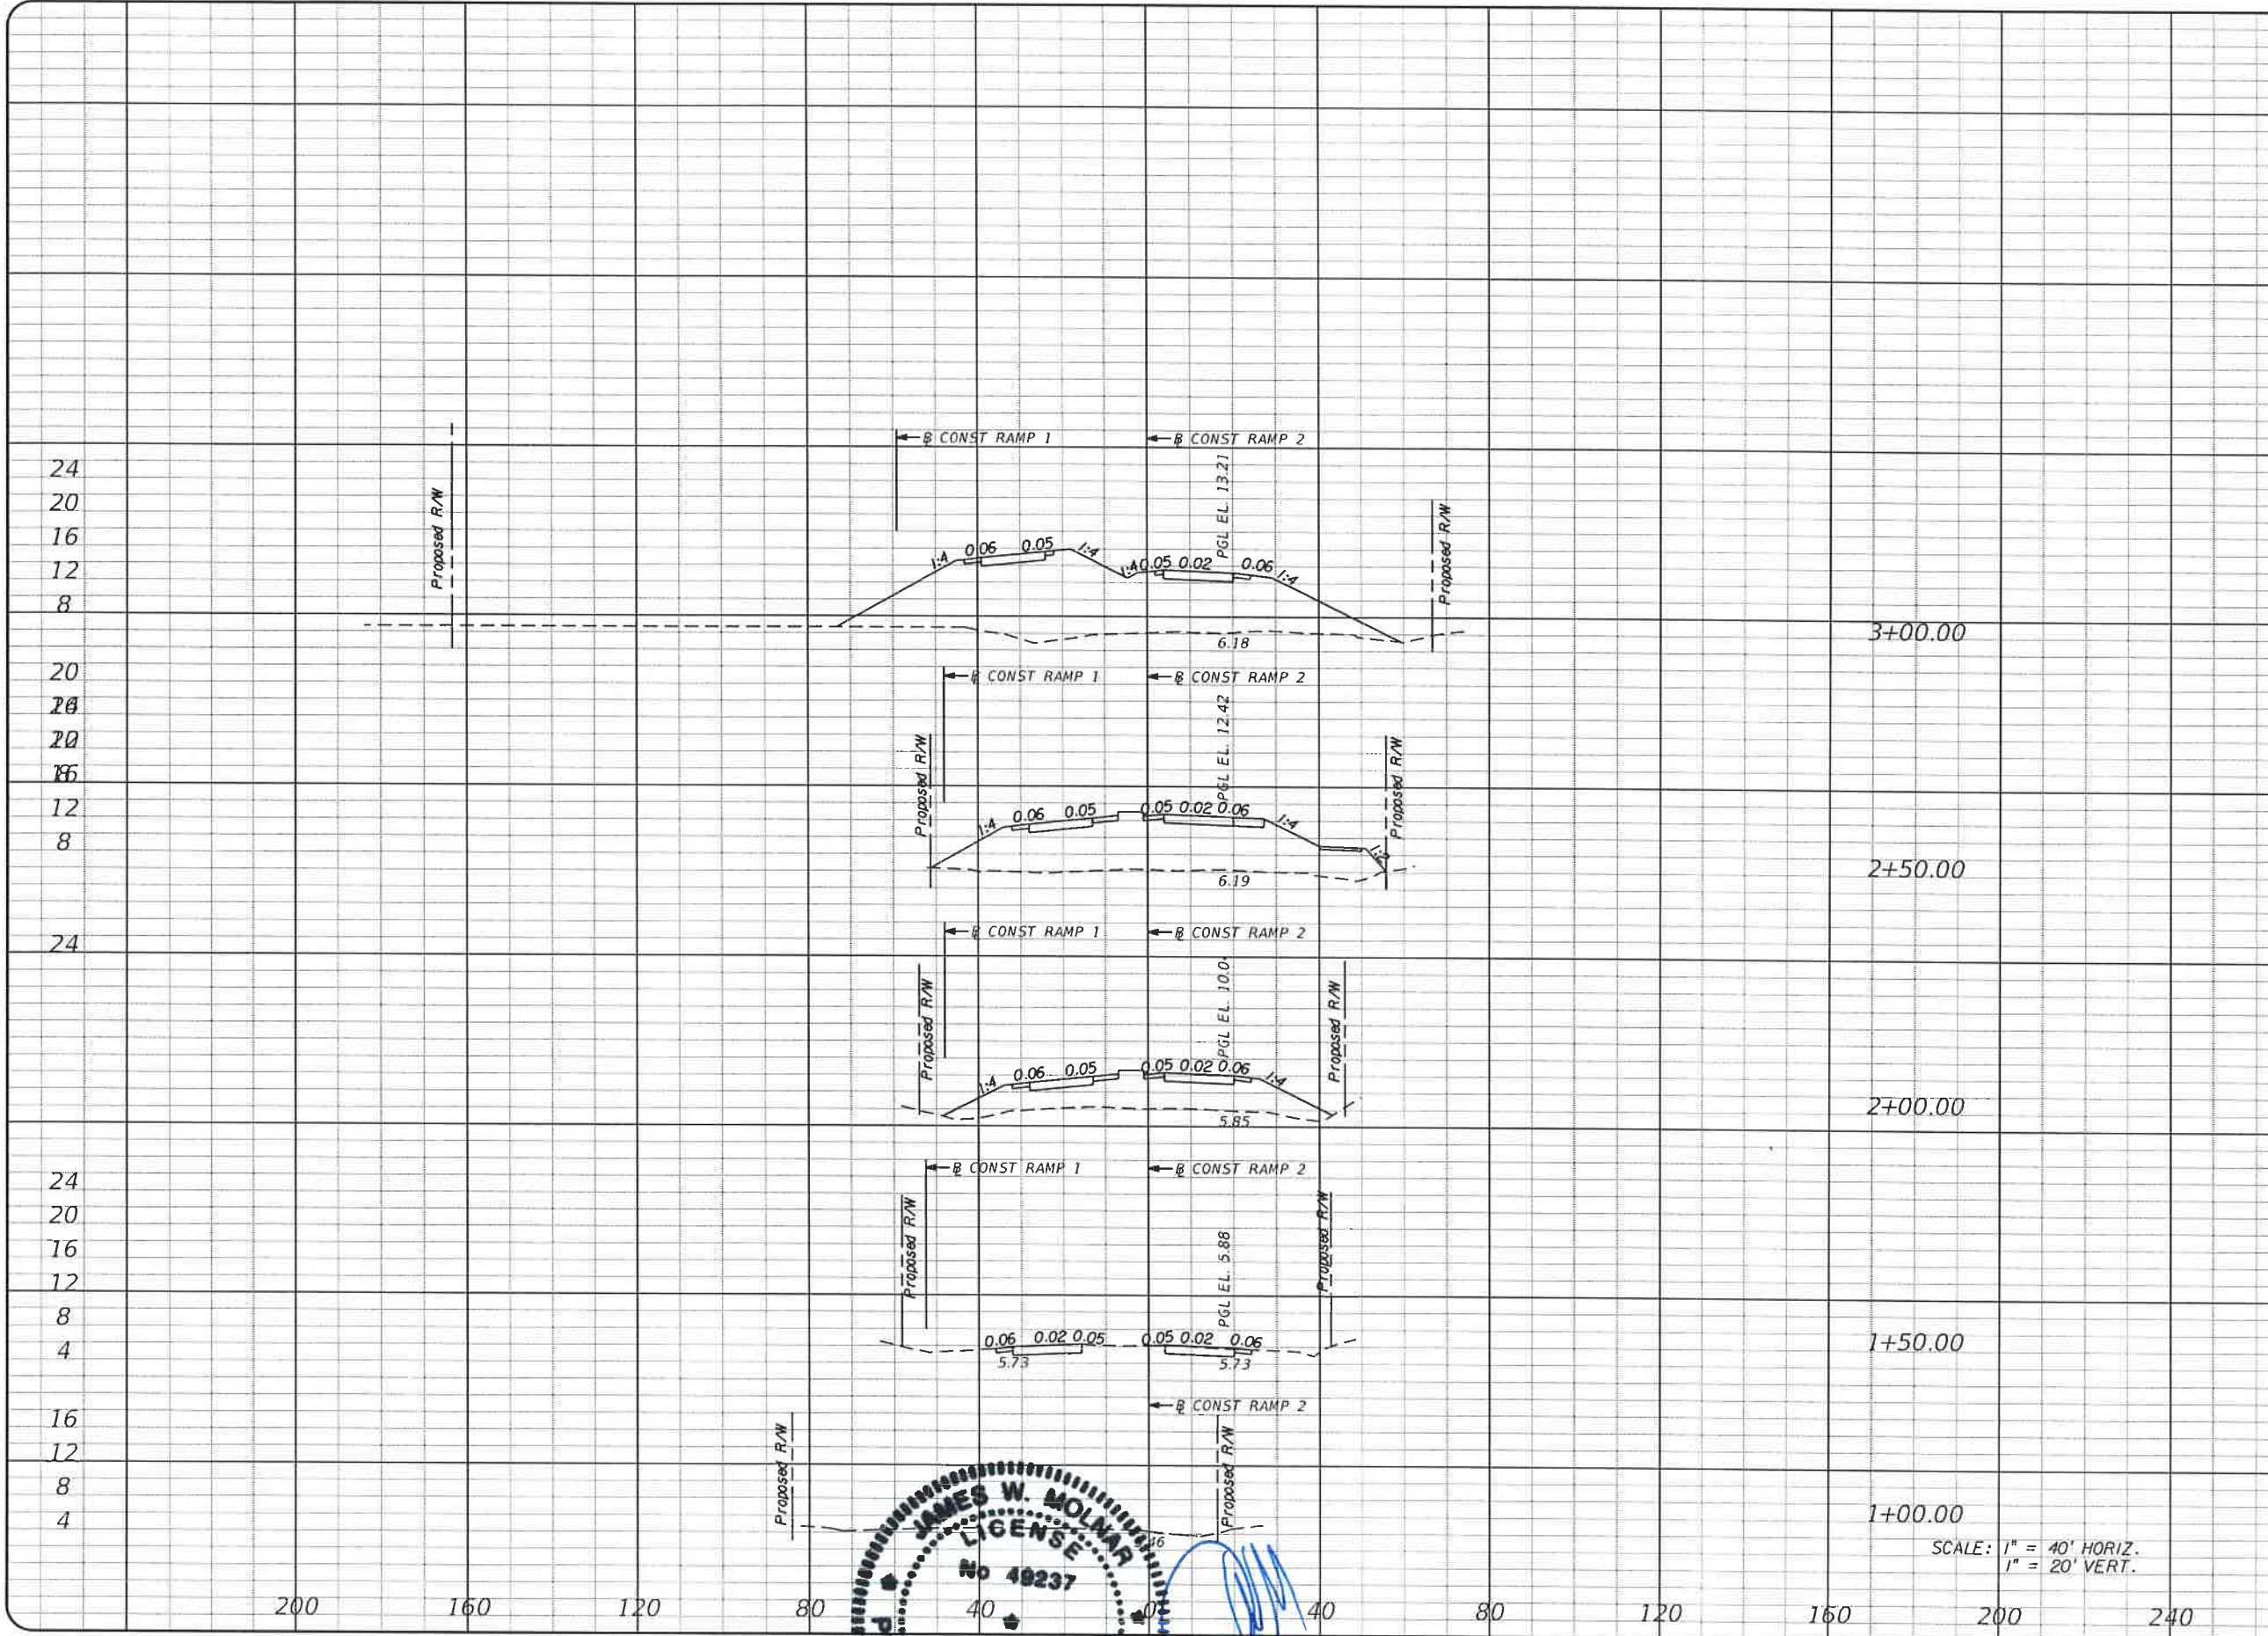

0	0	775	0	0
0	0	0	0	1167
0	0	0	0	486
0	0	0	0	666
0	0	0	0	261
34	1108	0	0	8527
0	0	0	0	0
0	0	0	0	0

SCALE: 1" = 40' HORIZ.
1" = 20' VERT.

NO.	DATE	BY	REVISIONS - DESCRIPTION

T.Y. LIN INTERNATIONAL
2400 FIRST STREET
SUITE 200
FORT MYERS, FLORIDA 33901
TEL. (239) 332-4846
FAX. (239) 332-4798
WWW.TYLIN.COM

STATE OF FLORIDA
LICENSE
No. 49237
JAMES W. MOLNAR, P.E.
REGISTERED PROFESSIONAL ENGINEER
LICENSE NO. 49237
2015


PUBLIC WORKS
LEE COUNTY
SOUTHWEST
FLORIDA
1500 MONROE STREET
(239) 479-8900 www.lee-county.com/publicworks/office.htm

DEPARTMENT
of
TRANSPORTATION
FORT MYERS, FLORIDA 33901


**RAMP 1 & RAMP 2
CROSS SECTIONS
BURNT STORE ROAD**

SHEET
NO.
94

Regular		Exc.		Embankment	
A	V	A	V	A	V
0				197	
6			6	341	498
5			8	589	665
0			5	831	1332
0			0	1441	2562
0			0	0	0

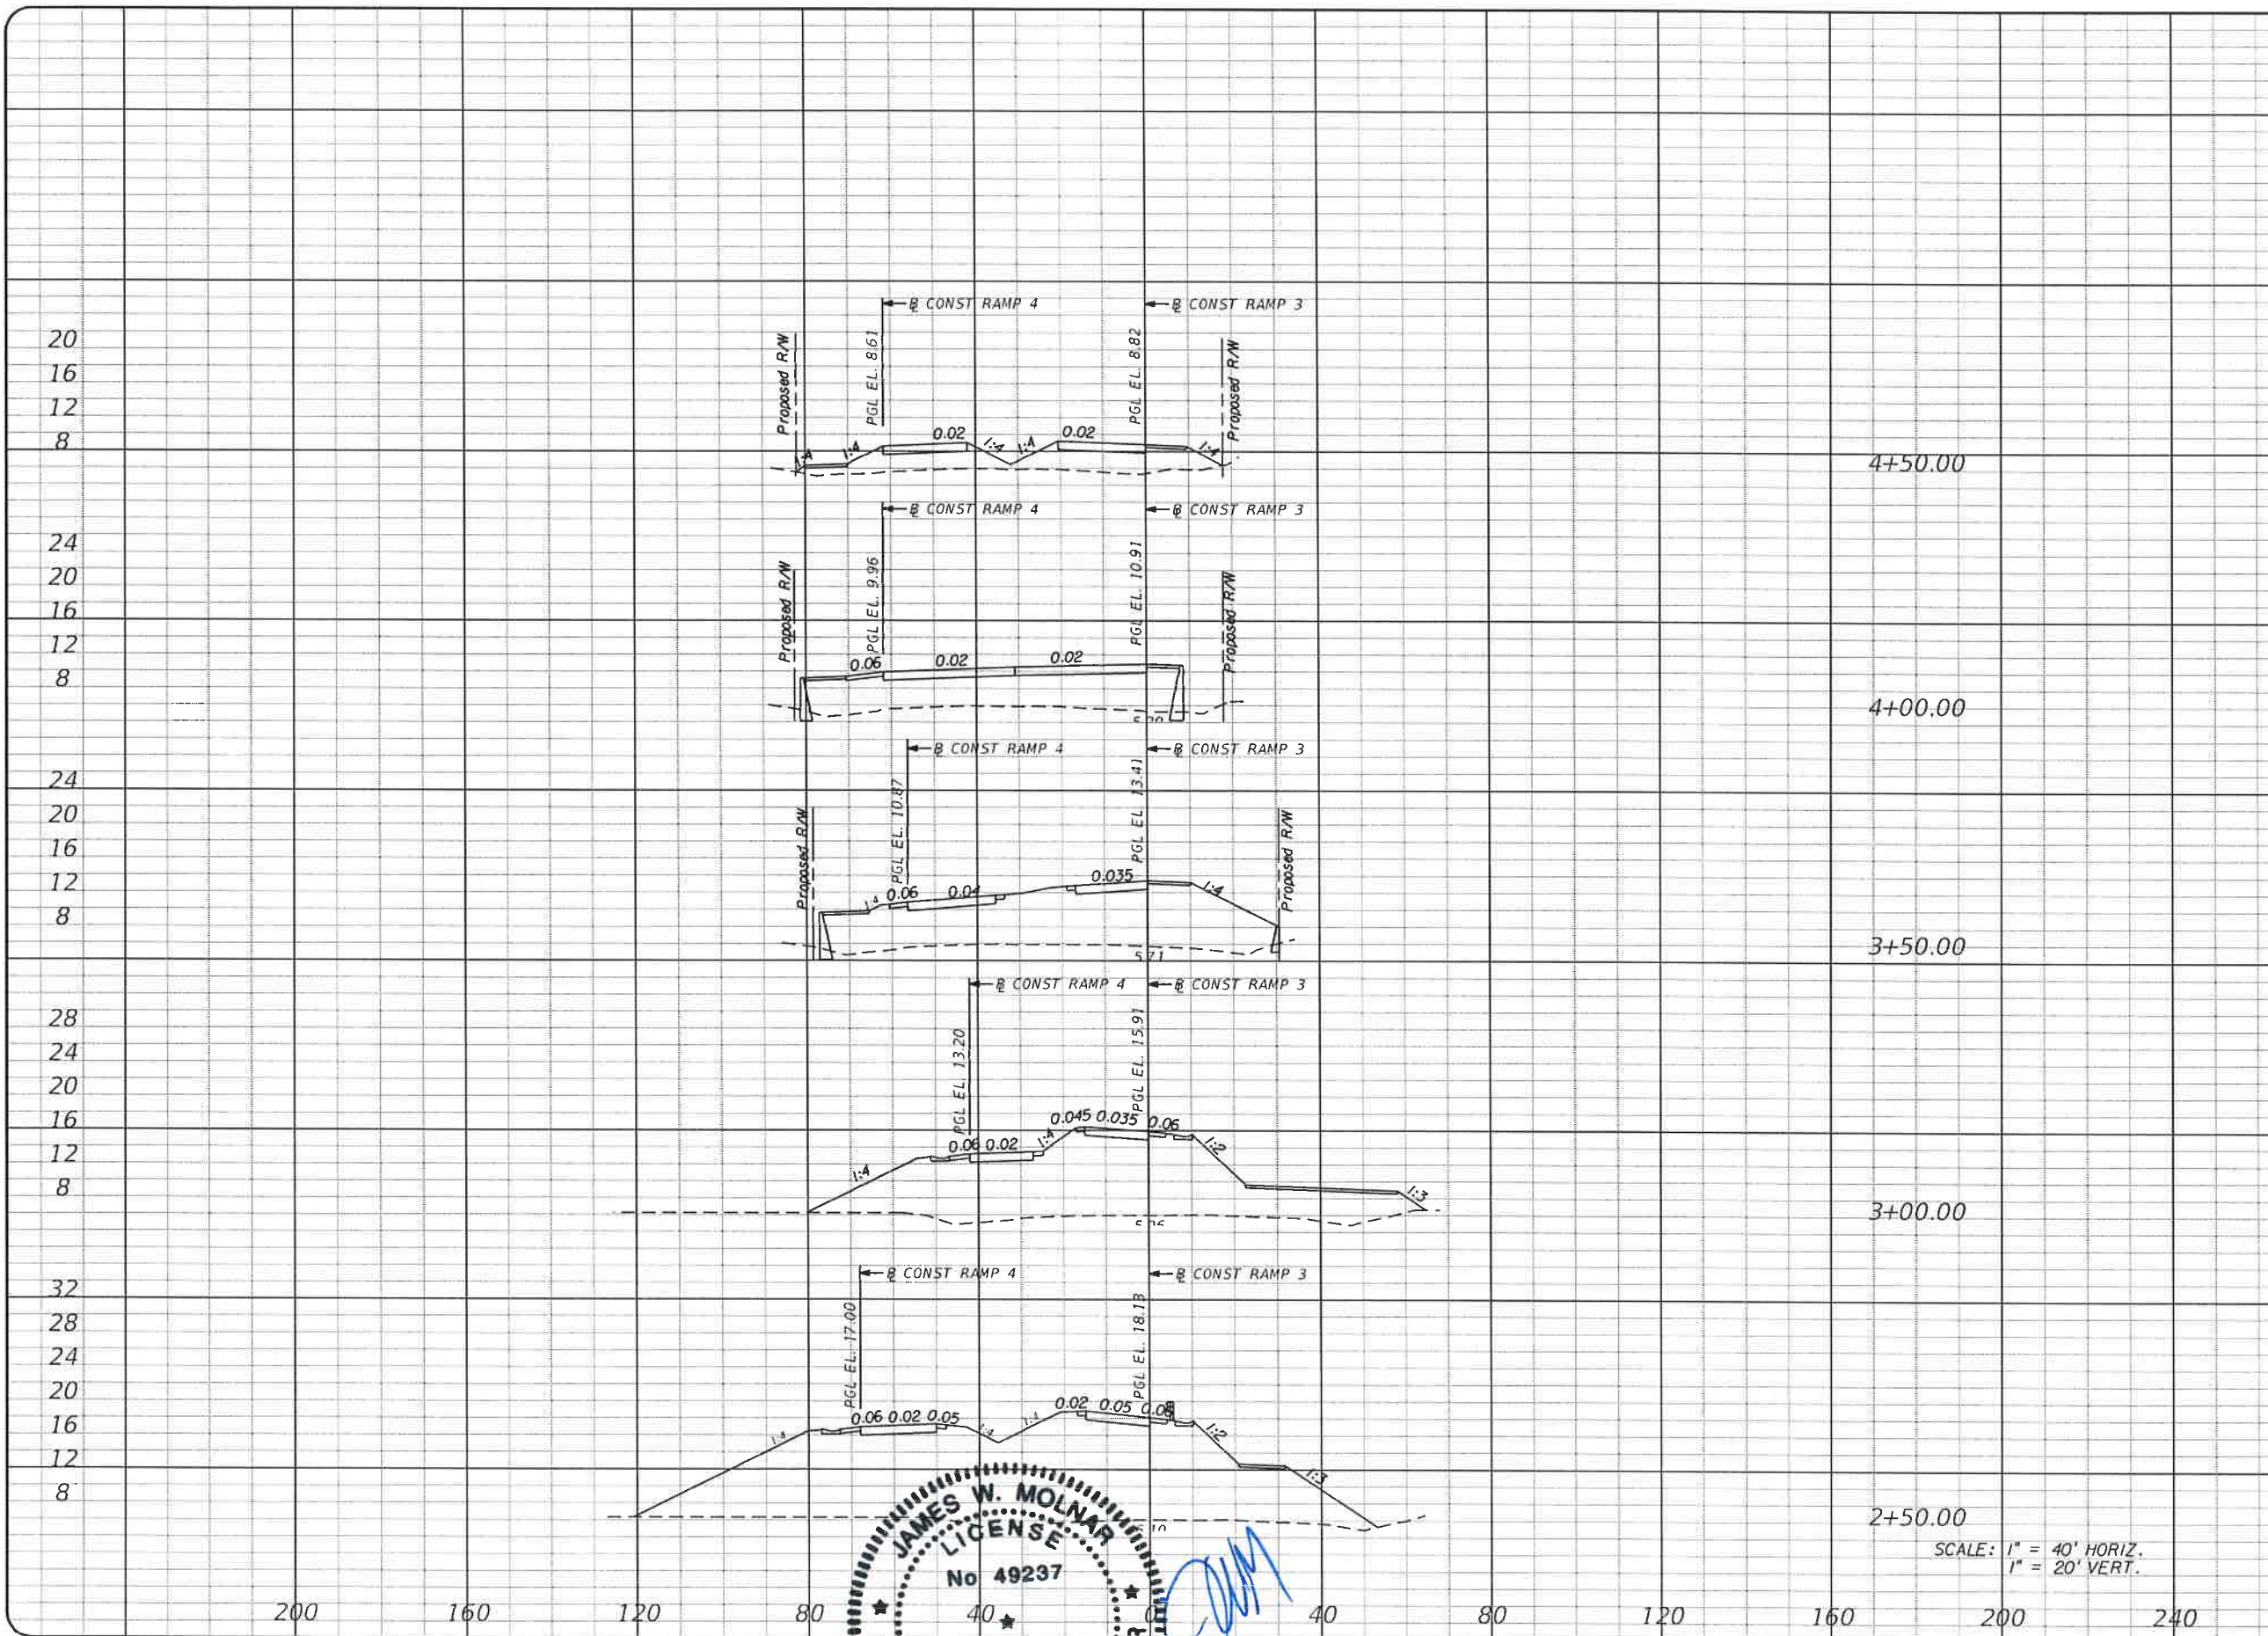

SCALE: 1" = 40' HORIZ.
1" = 20' VERT.

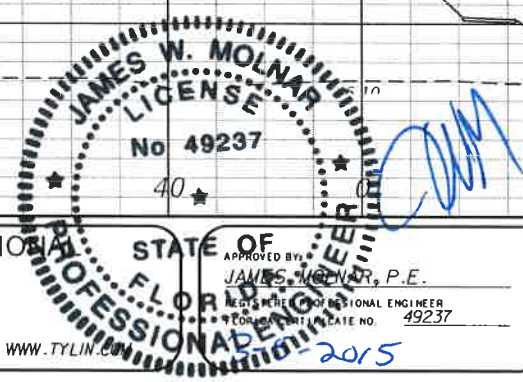

NO.	DATE	BY	REVISIONS / DESCRIPTION

T.Y. LIN INTERNATIONAL
2400 FIRST STREET
SUITE 200
FORT MYERS, FLORIDA 33901
TEL. (239) 332-4846
FAX. (239) 332-4798
WWW.TYLIN.COM

APPROVED BY: JAMES W. MOLNAR, P.E.
REGISTERED PROFESSIONAL ENGINEER
FLORIDA LICENSE NO. 49237
2015

PUBLIC WORKS
LEE COUNTY
SOUTHWEST
FLORIDA
1500 MONROE STREET
FORT MYERS, FLORIDA 33901
TEL. (239) 479-8900 www.lee-county.com/publicworks/sdtitle.htm

DEPARTMENT
of
TRANSPORTATION
FORT MYERS, FLORIDA 33901


dwerner 3/5/2015 11:54:23 AM

**RAMP 3 & RAMP 4
CROSS SECTIONS
BURNT STORE ROAD**

SHEET NO.
95

T:\Tamp\Legacy\Project\581595.00_Burnt_Store_RD\Burnt_Store\roadway\RDxSRD02N.dgn

Rdxsrtd_shg

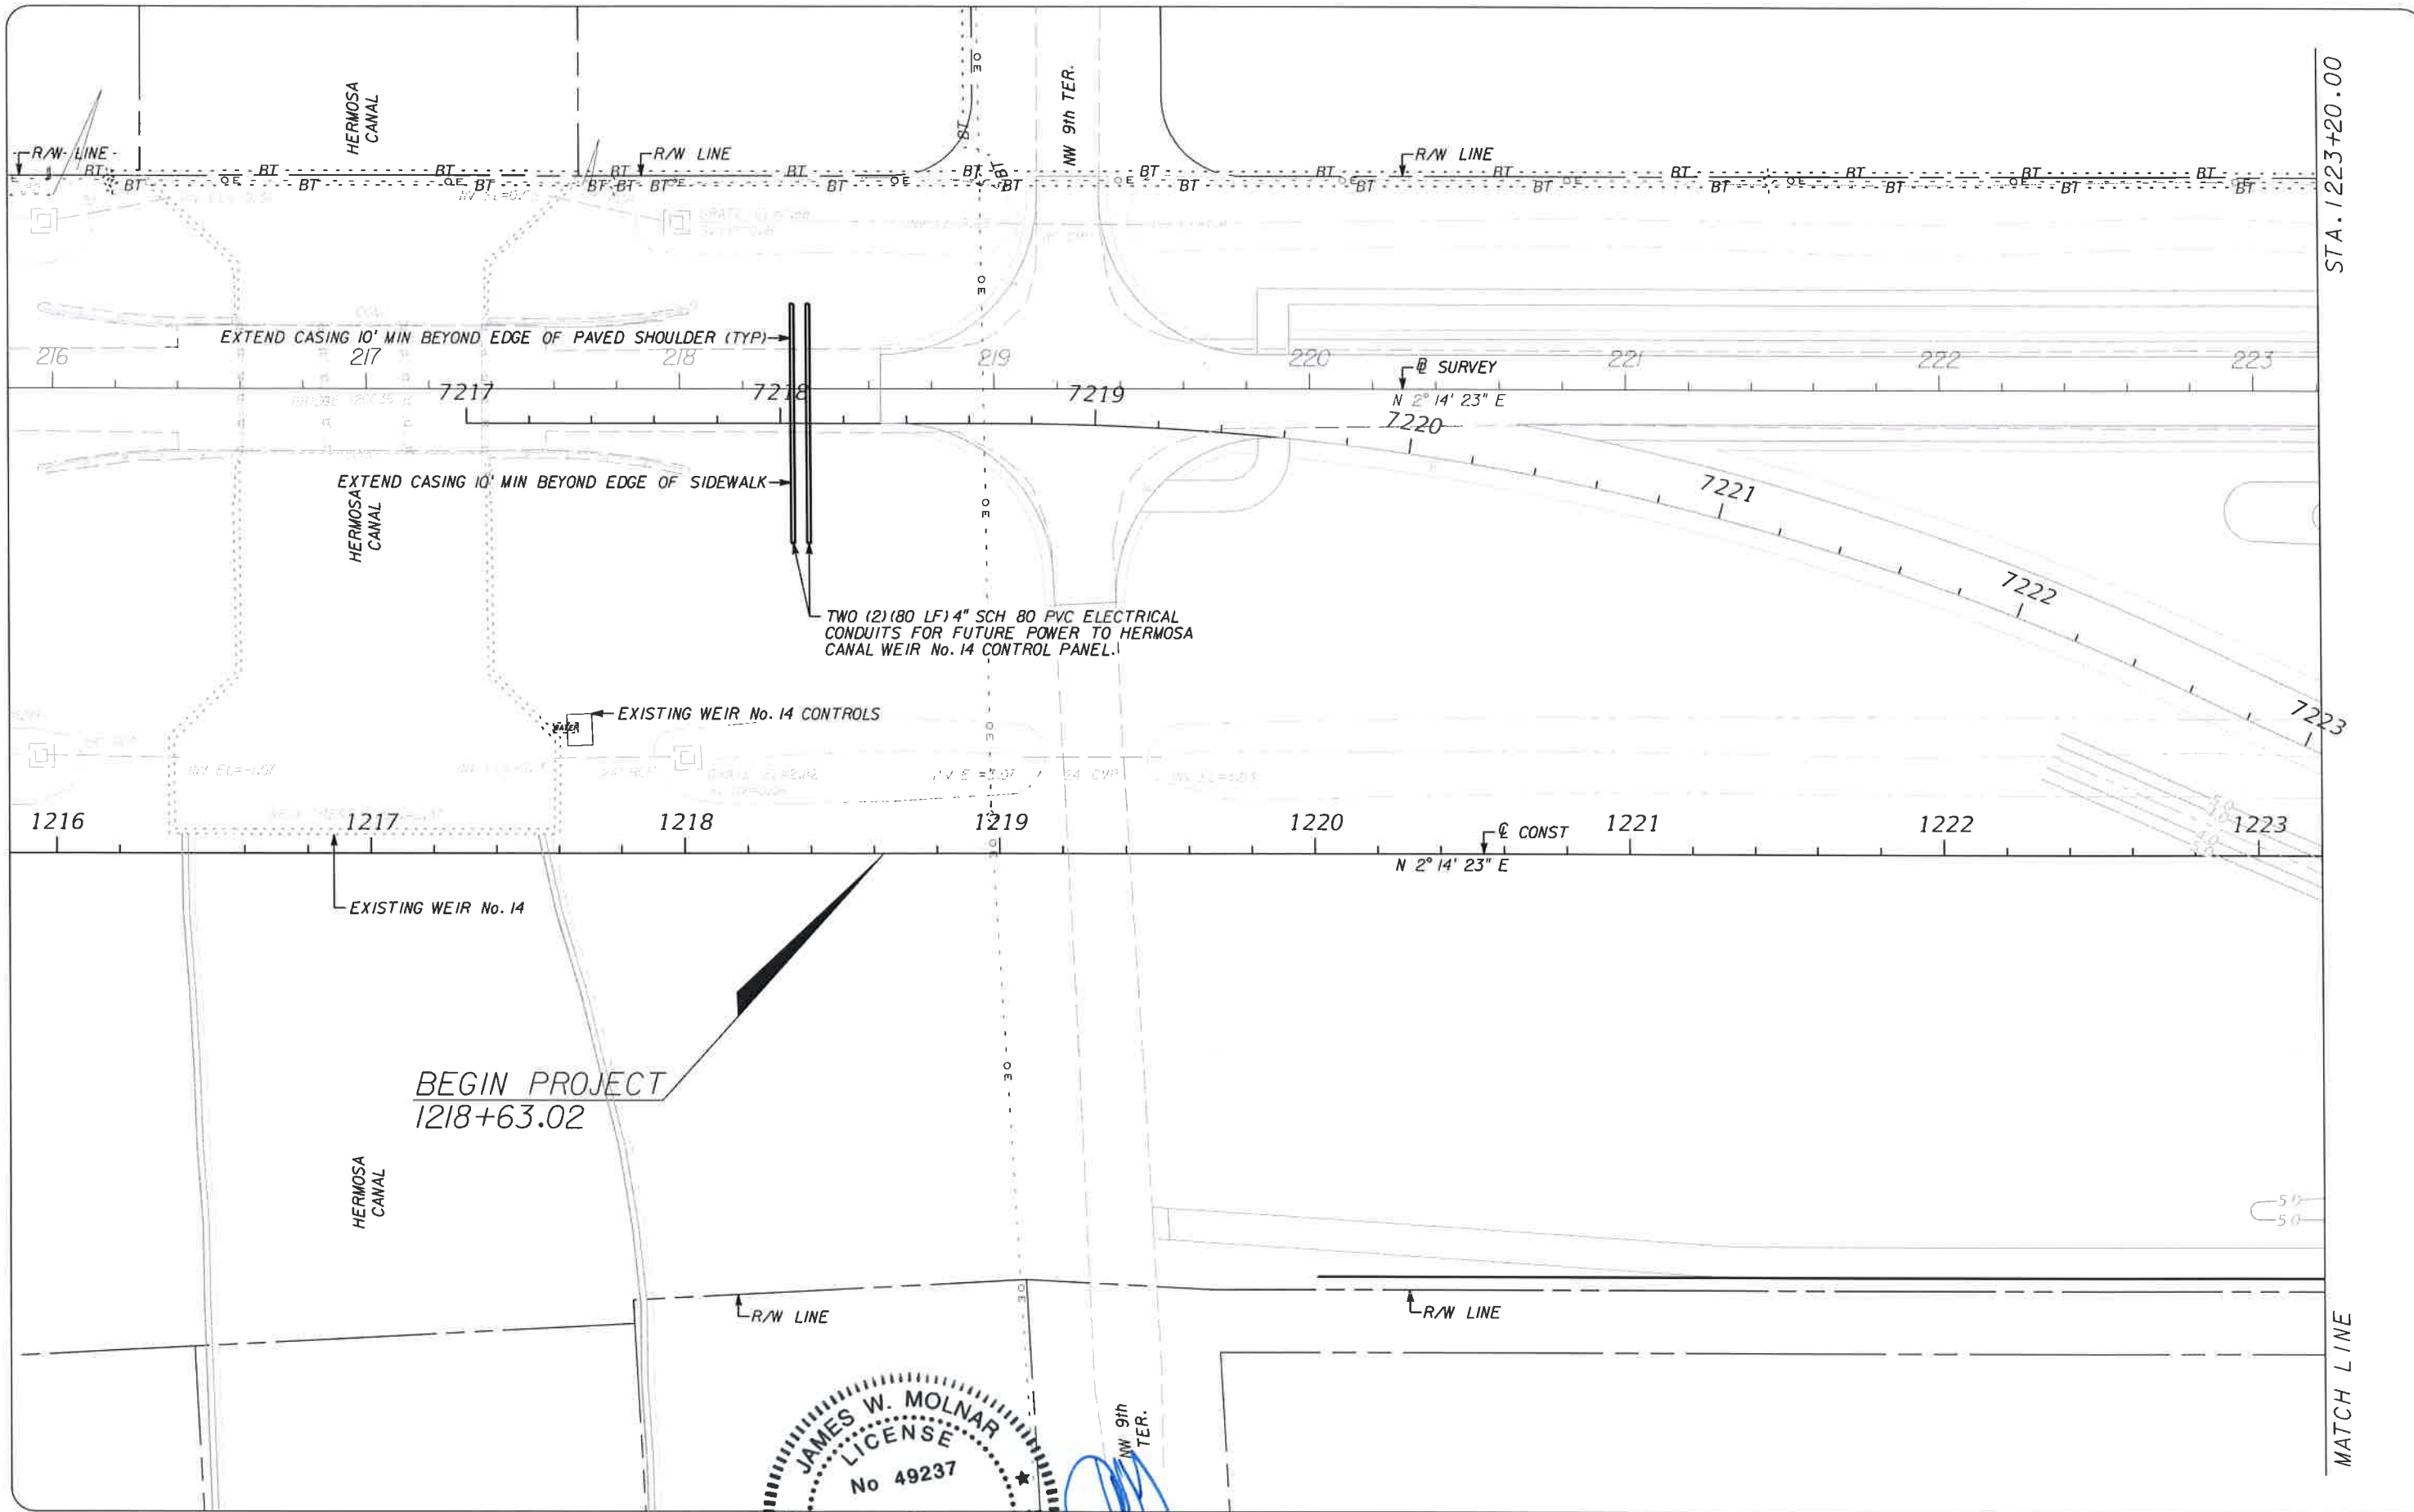

STA. 1223+20.00

MATCH LINE

NO.	DATE	BY	REVISIONS - DESCRIPTION

T.Y. LIN INTERNATIONAL
 2400 FIRST STREET
 SUITE 200
 FORT MYERS, FLORIDA 33901
 TEL. (239) 332-4846
 FAX. (239) 332-4798

JAMES W. MOLNAR
 LICENSE No 49237
 STATE OF FLORIDA
 PROFESSIONAL ENGINEER

2015

PUBLIC WORKS
LEE COUNTY
SOUTHWEST
FLORIDA
 1500 MONROE STREET
 FORT MYERS, FLORIDA 33901
 (239) 479-8900 www.lee-county.com/publicworks/suitts.htm


DEPARTMENT
of
TRANSPORTATION
 FORT MYERS, FLORIDA 33901

UTILITY ADJUSTMENT SHEET
STA. 1216+20.00 TO STA. 1223+20.00
BURNT STORE ROAD

SHEET NO.
 96

STA. 1223+20.00

STA. 1230+20.00

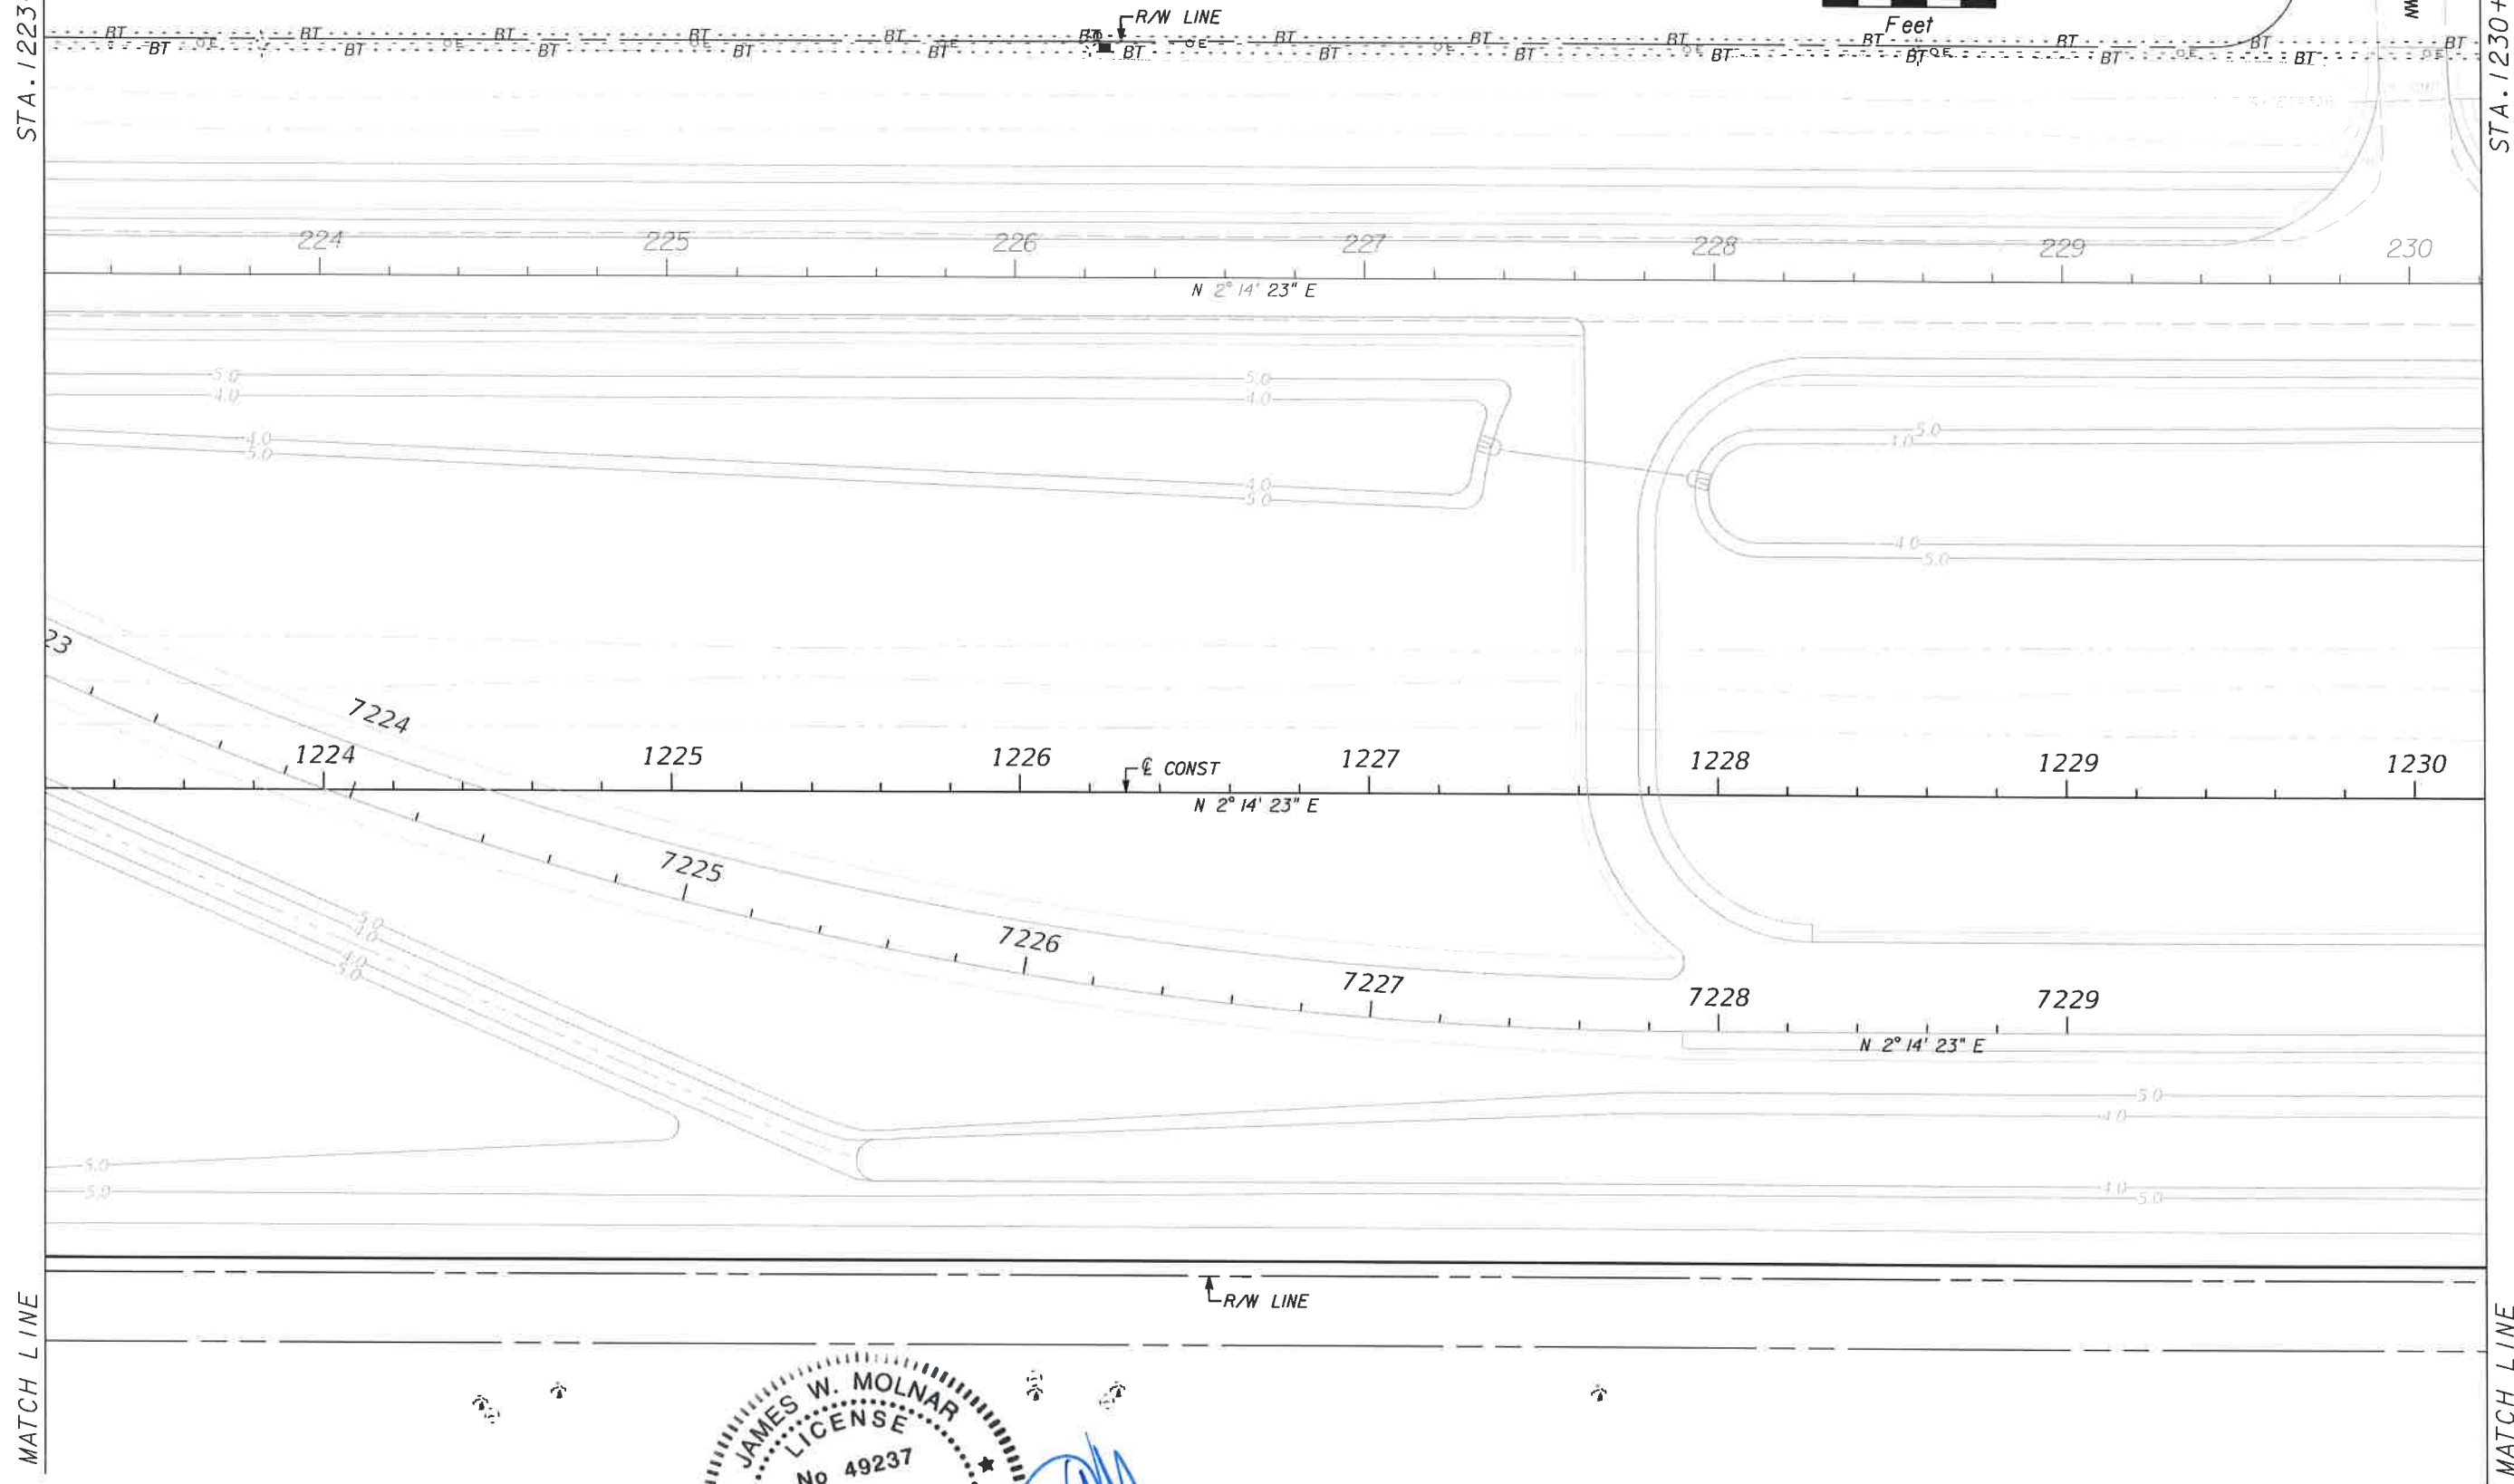

MATCH LINE

MATCH LINE

NO.	DATE	BY	REVISIONS - DESCRIPTION

T.Y. LIN INTERNATIONAL
 2400 FIRST STREET
 SUITE 200
 FORT MYERS, FLORIDA
 TEL. (239) 332-4846
 FAX. (239) 332-4798

JAMES W. MOLNAR
 LICENSE
 No 49237
 REGISTERED PROFESSIONAL ENGINEER
 STATE OF FLORIDA
 DA CERTIFICATE NO 49237
 3-5-2015

PUBLIC WORKS
LEE COUNTY
SOUTHWEST
FLORIDA
 1500 MONROE STREET
 12391 479-8900 www.lcswfl.com/publicworks/default.htm



DEPARTMENT
of
TRANSPORTATION
 FORT MYERS FLORIDA 33901

UTILITY ADJUSTMENT SHEET
STA. 1223+20.00 TO STA. 1230+20.00
BURNT STORE ROAD

SHEET NO.
 97

STA. 1237+20.00


STA. 1244+20.00

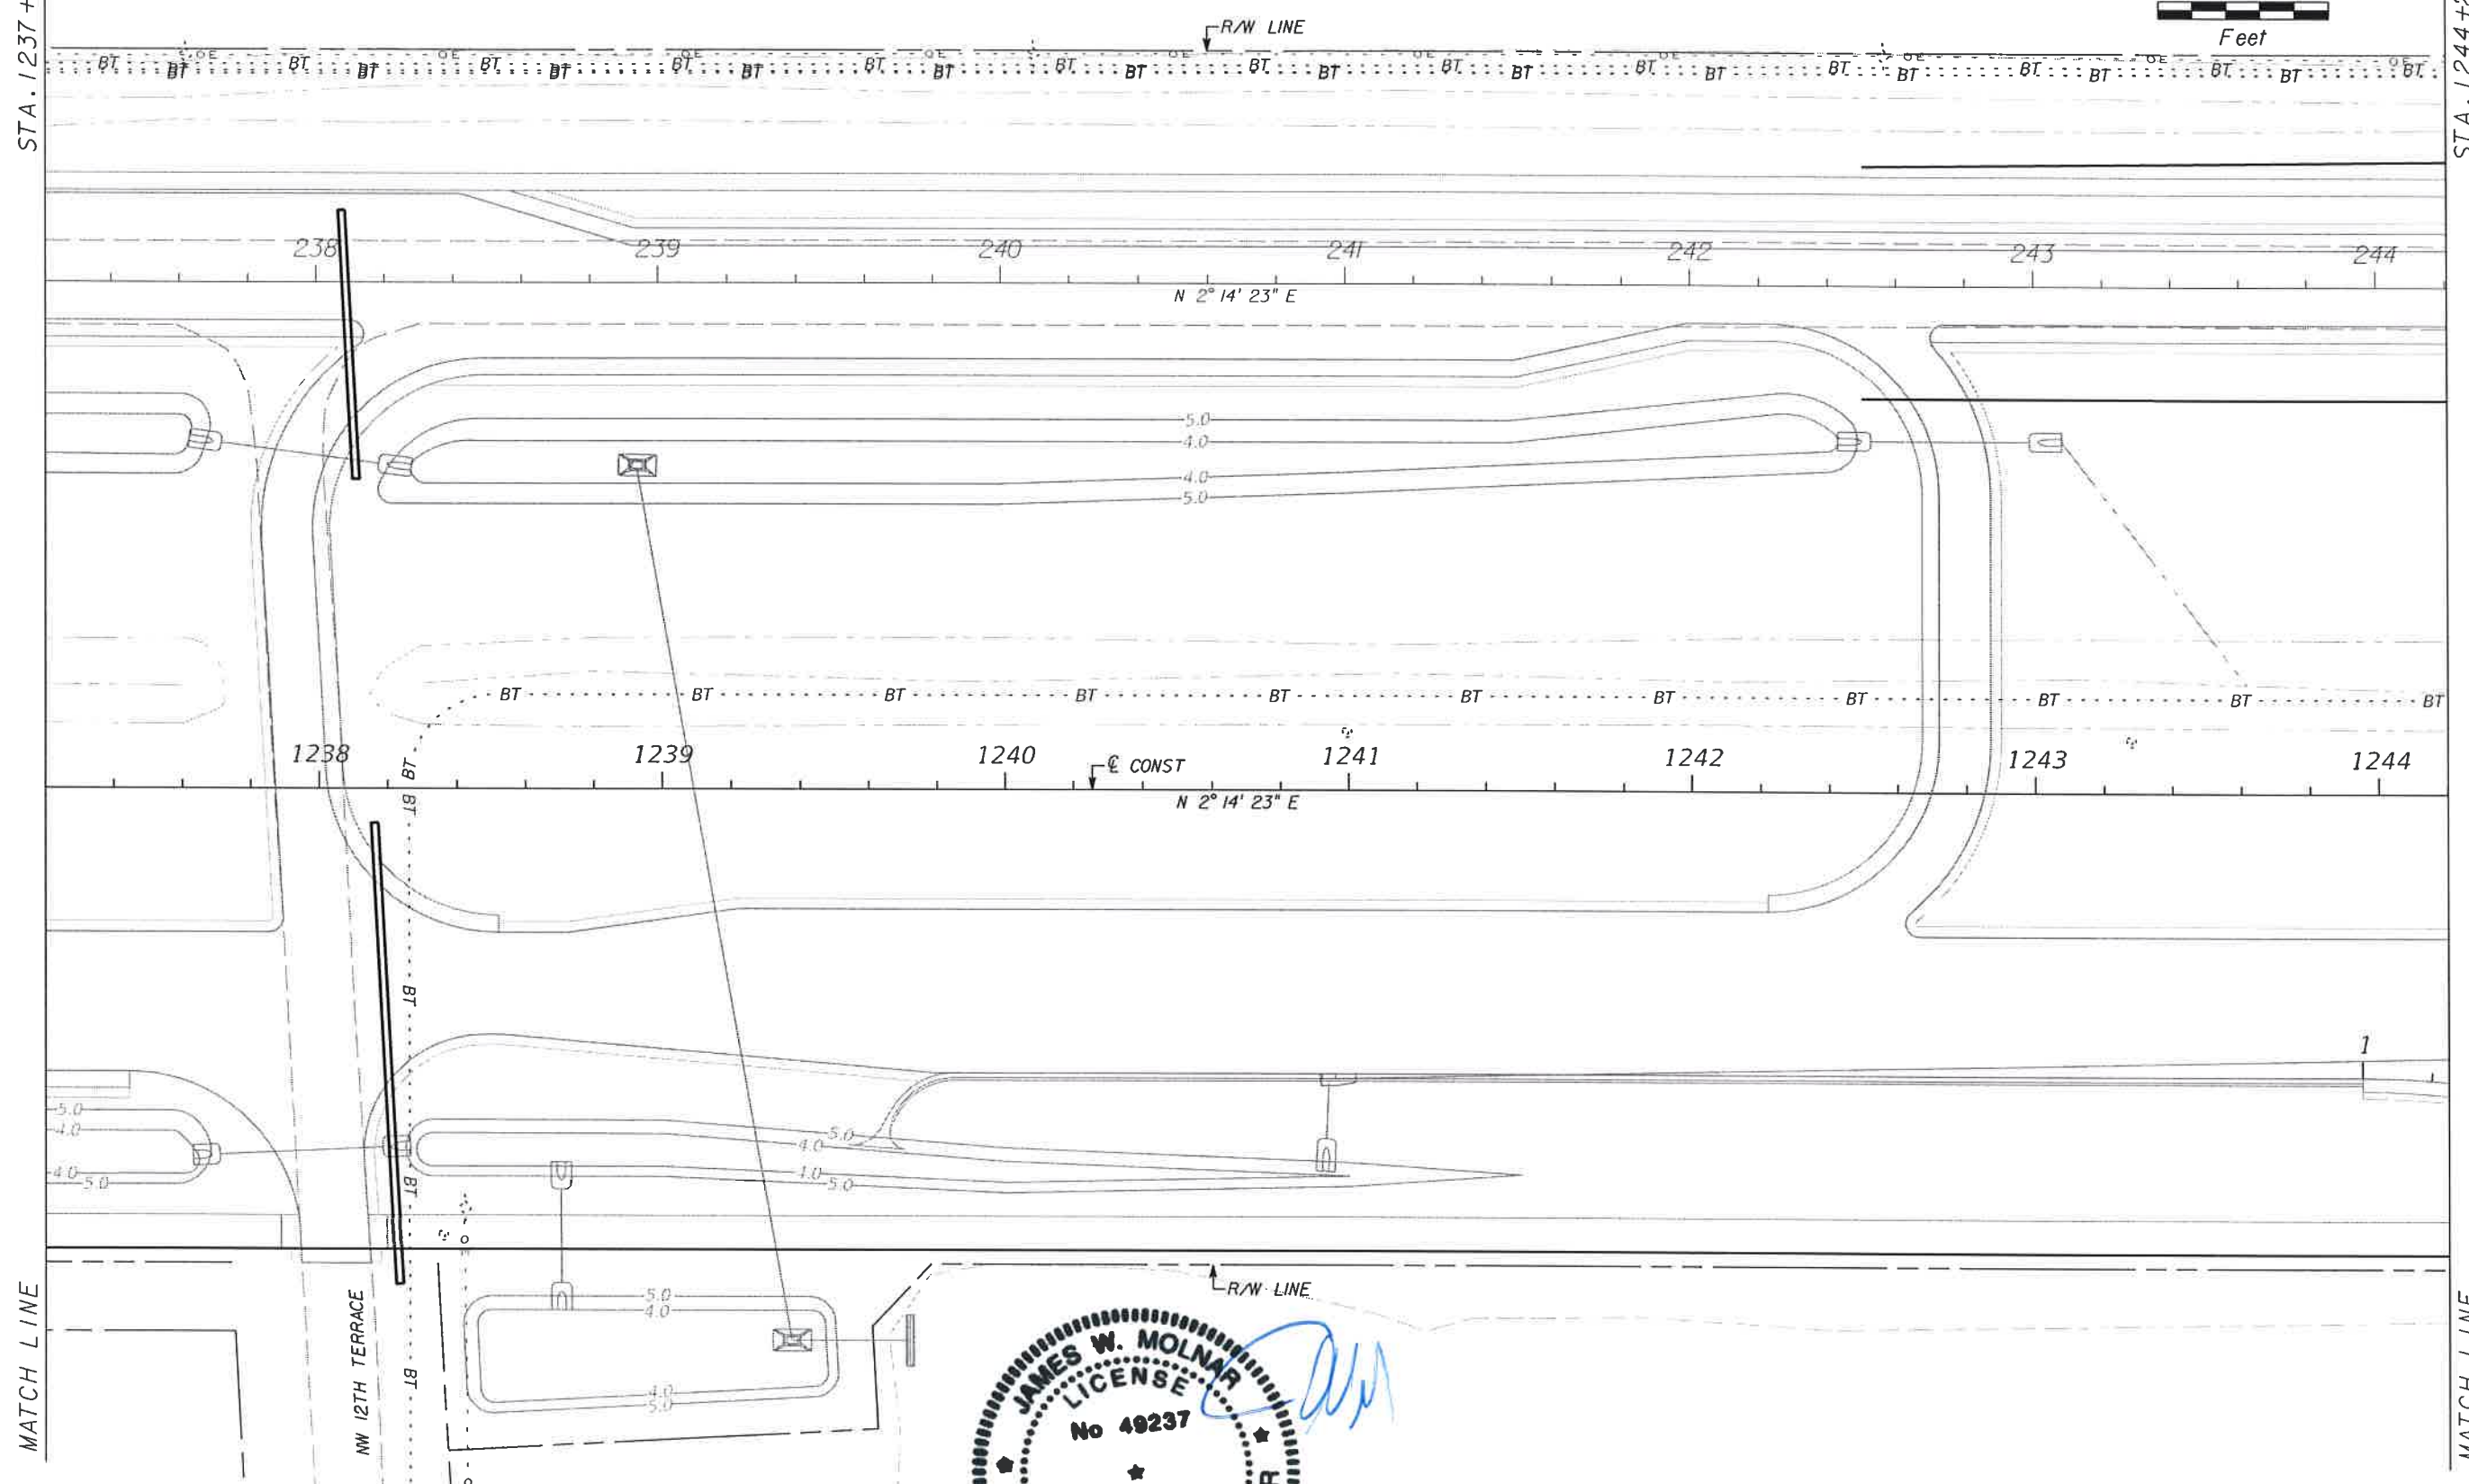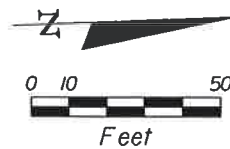

MATCH LINE

NW 12TH TERRACE

MATCH LINE

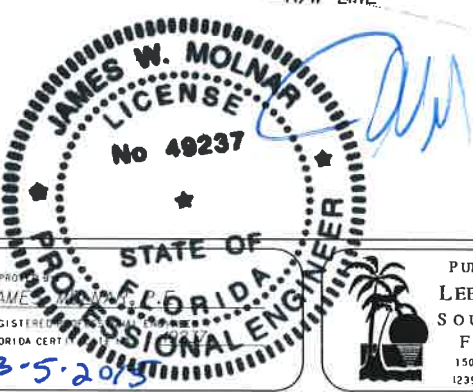

NO.	DATE	BY	REVISIONS - DESCRIPTION

T.Y. LIN INTERNATIONAL
 2400 FIRST STREET
 SUITE 200
 FORT MYERS, FLORIDA 33901
 TEL. (239) 332-4846
 FAX. (239) 332-4798
 WWW.TYLIN.COM

APPROVED
JAMES W. MOLNAR
 REGISTERED
 FLORIDA CERT.
PROFESSIONAL ENGINEER
 3-5-2015

PUBLIC WORKS
 LEE COUNTY
 DEPARTMENT
 of
 TRANSPORTATION
 SOUTHWEST
 FLORIDA
 1500 MONROE STREET
 FORT MYERS, FLORIDA 33901
 12391 479 8900 www.lee-county.com/public-works/transportation.htm
 rghfields 3/4/2015 5:31:00 PM


UTILITY ADJUSTMENT SHEET
STA. 1237+20.00 TO STA. 1244+20.00
BURNT STORE ROAD

SHEET NO.
 99
 Default

T:\Temp\Legacy\Project\581595.00_Burnt_Store_RD\Burnt_Store\utils\PLAN\NW21.dgn

STA. 1244+20.00

STA. 1251+20.00

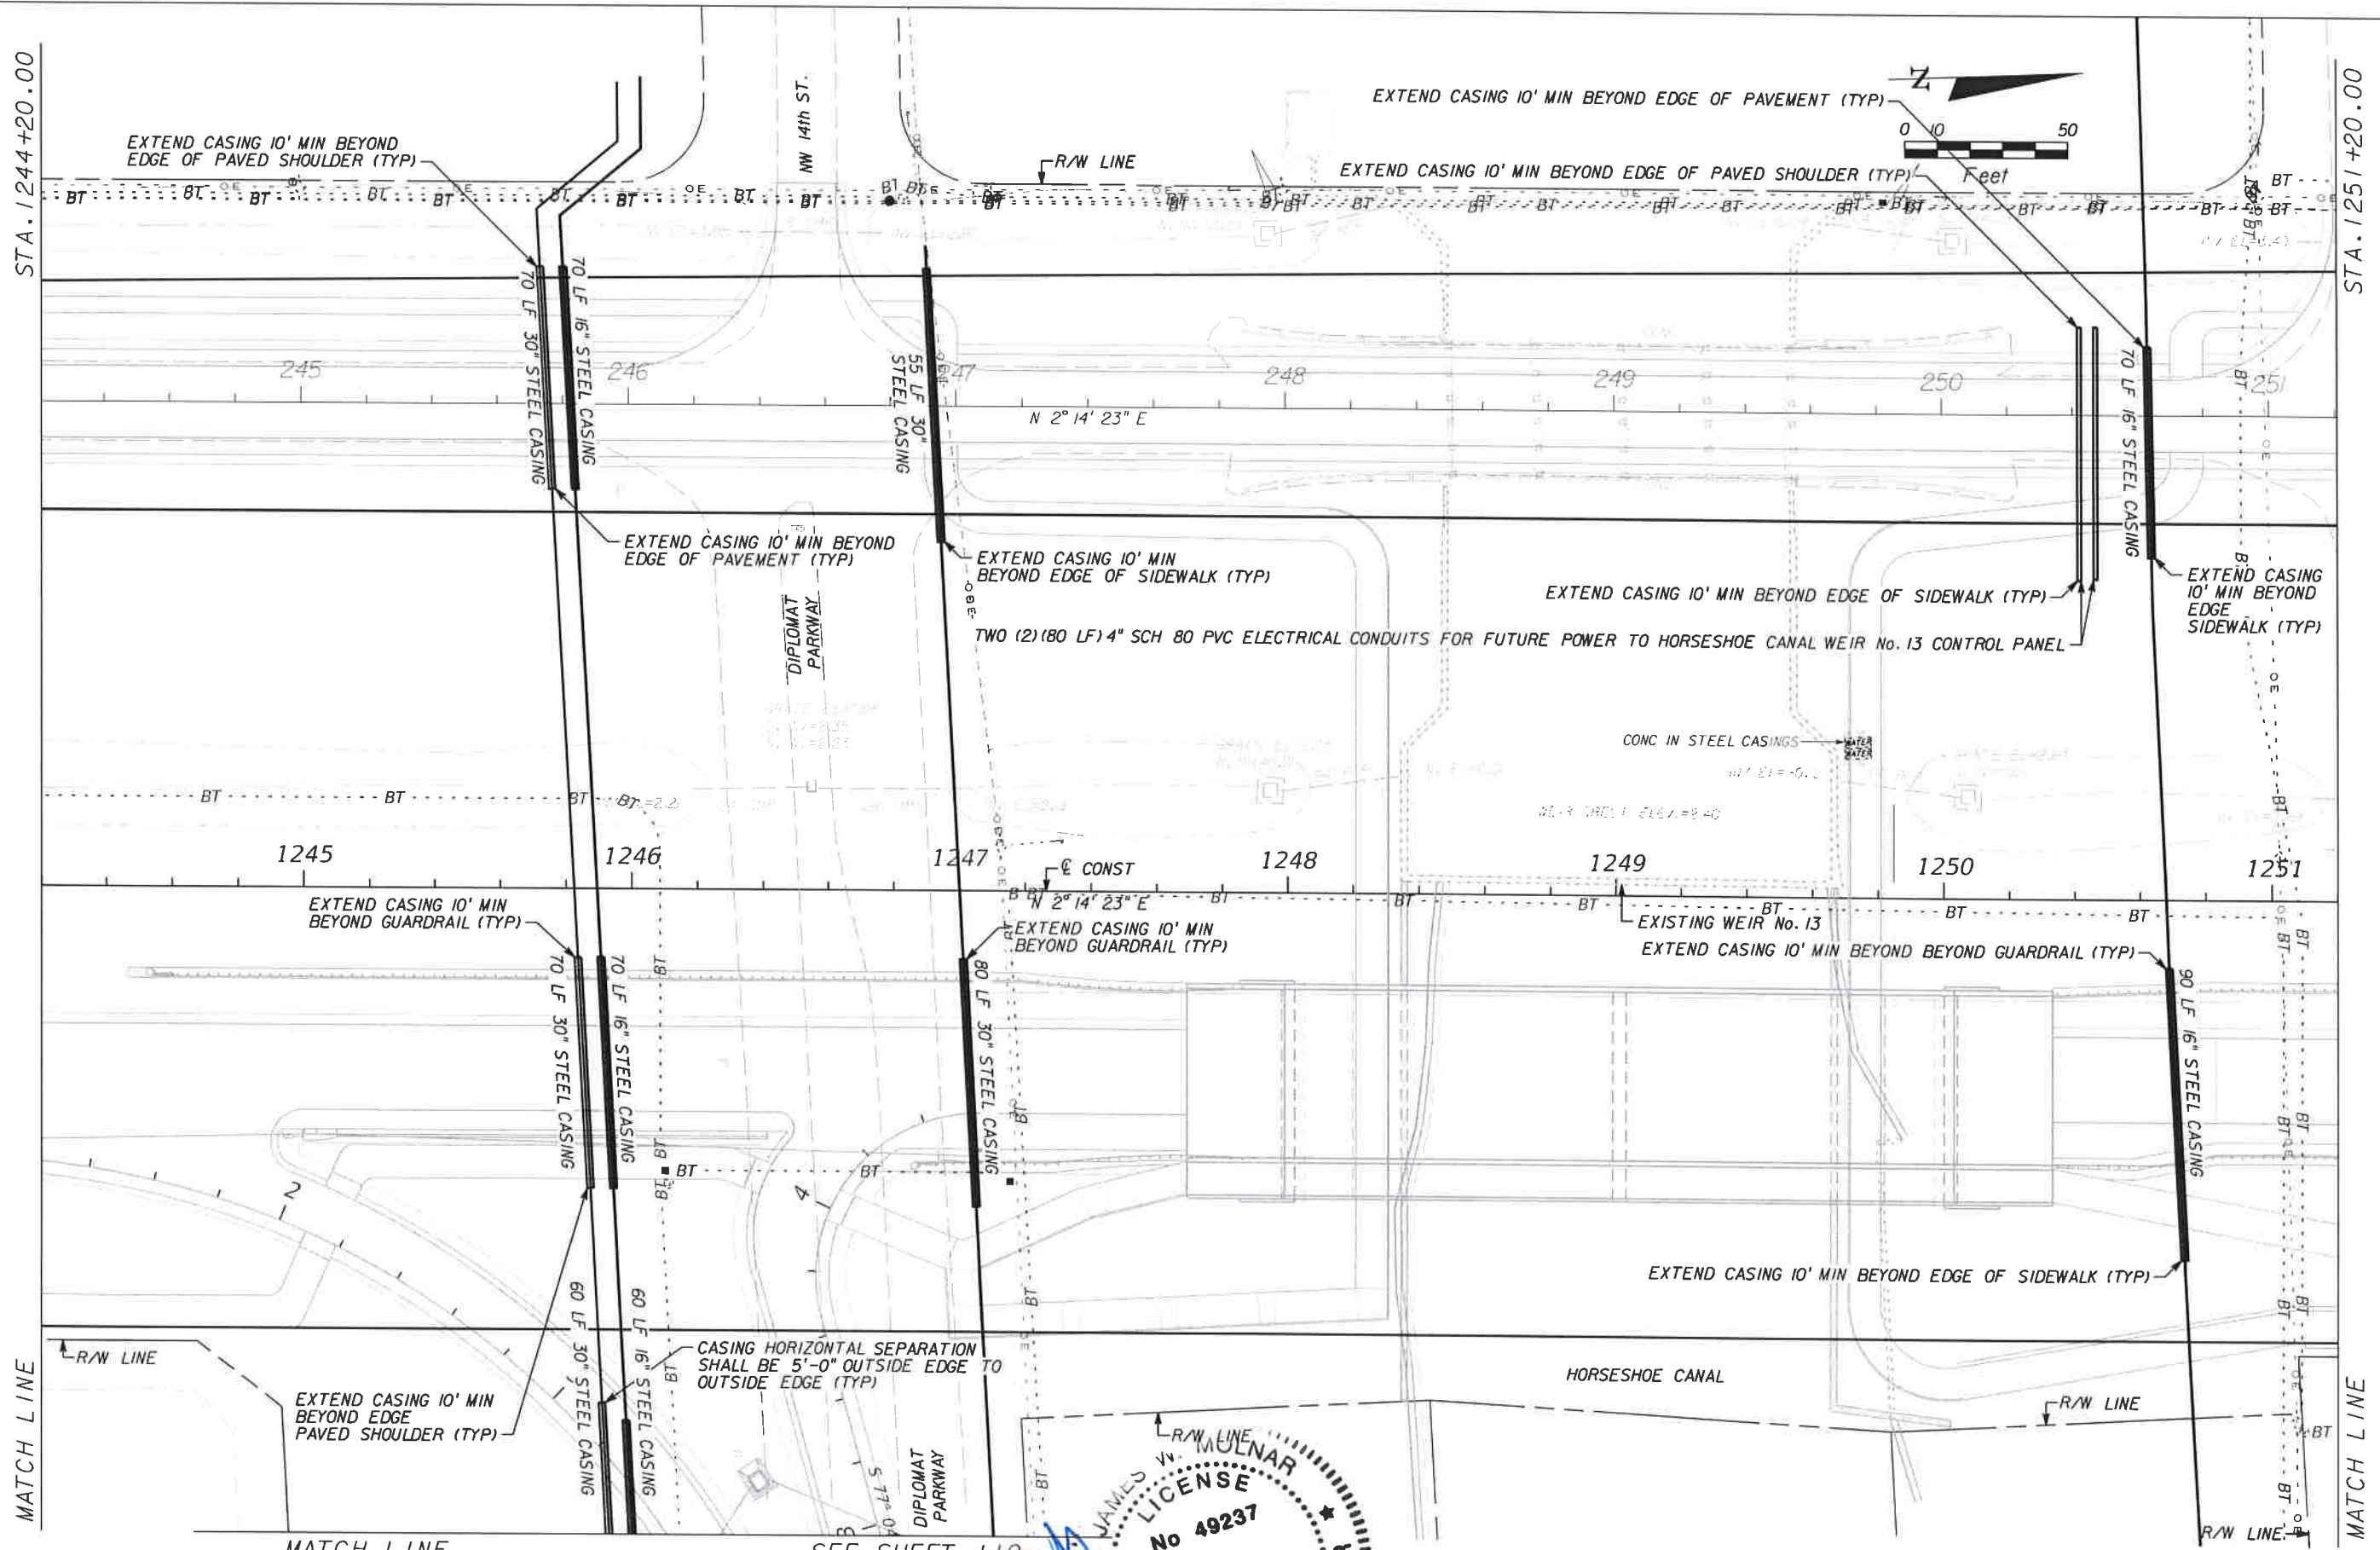

MATCH LINE

MATCH LINE


MATCH LINE

SEE SHEET 110

NO.	DATE	BY	REVISIONS - DESCRIPTION

T.Y. LIN INTERNATIONAL
 2400 FIRST STREET
 SUITE 200
 FORT MYERS, FLORIDA 33901
 TEL. (239) 332-4846
 FAX. (239) 332-4798
 WWW.TYLIN.COM

APPROVED BY:
JAMES W. MOLNAR, P.E.
 REGISTERED PROFESSIONAL ENGINEER
 FLORIDA CERTIFICATE NO. 49237
 3-5-2015

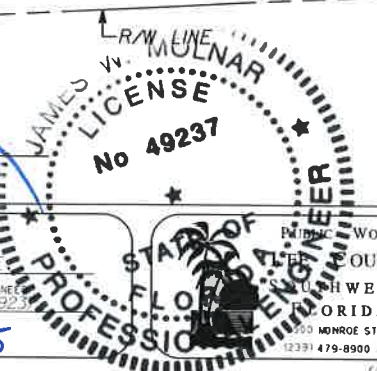



DEPARTMENT
 of
 TRANSPORTATION
 FORT MYERS, FLORIDA 33901

UTILITY ADJUSTMENT SHEET
STA. 1244+20.00 TO STA. 1251+20.00
BURNT STORE ROAD

SHEET NO.
 100

STA. 1251+20.00

STA. 1258+20.00

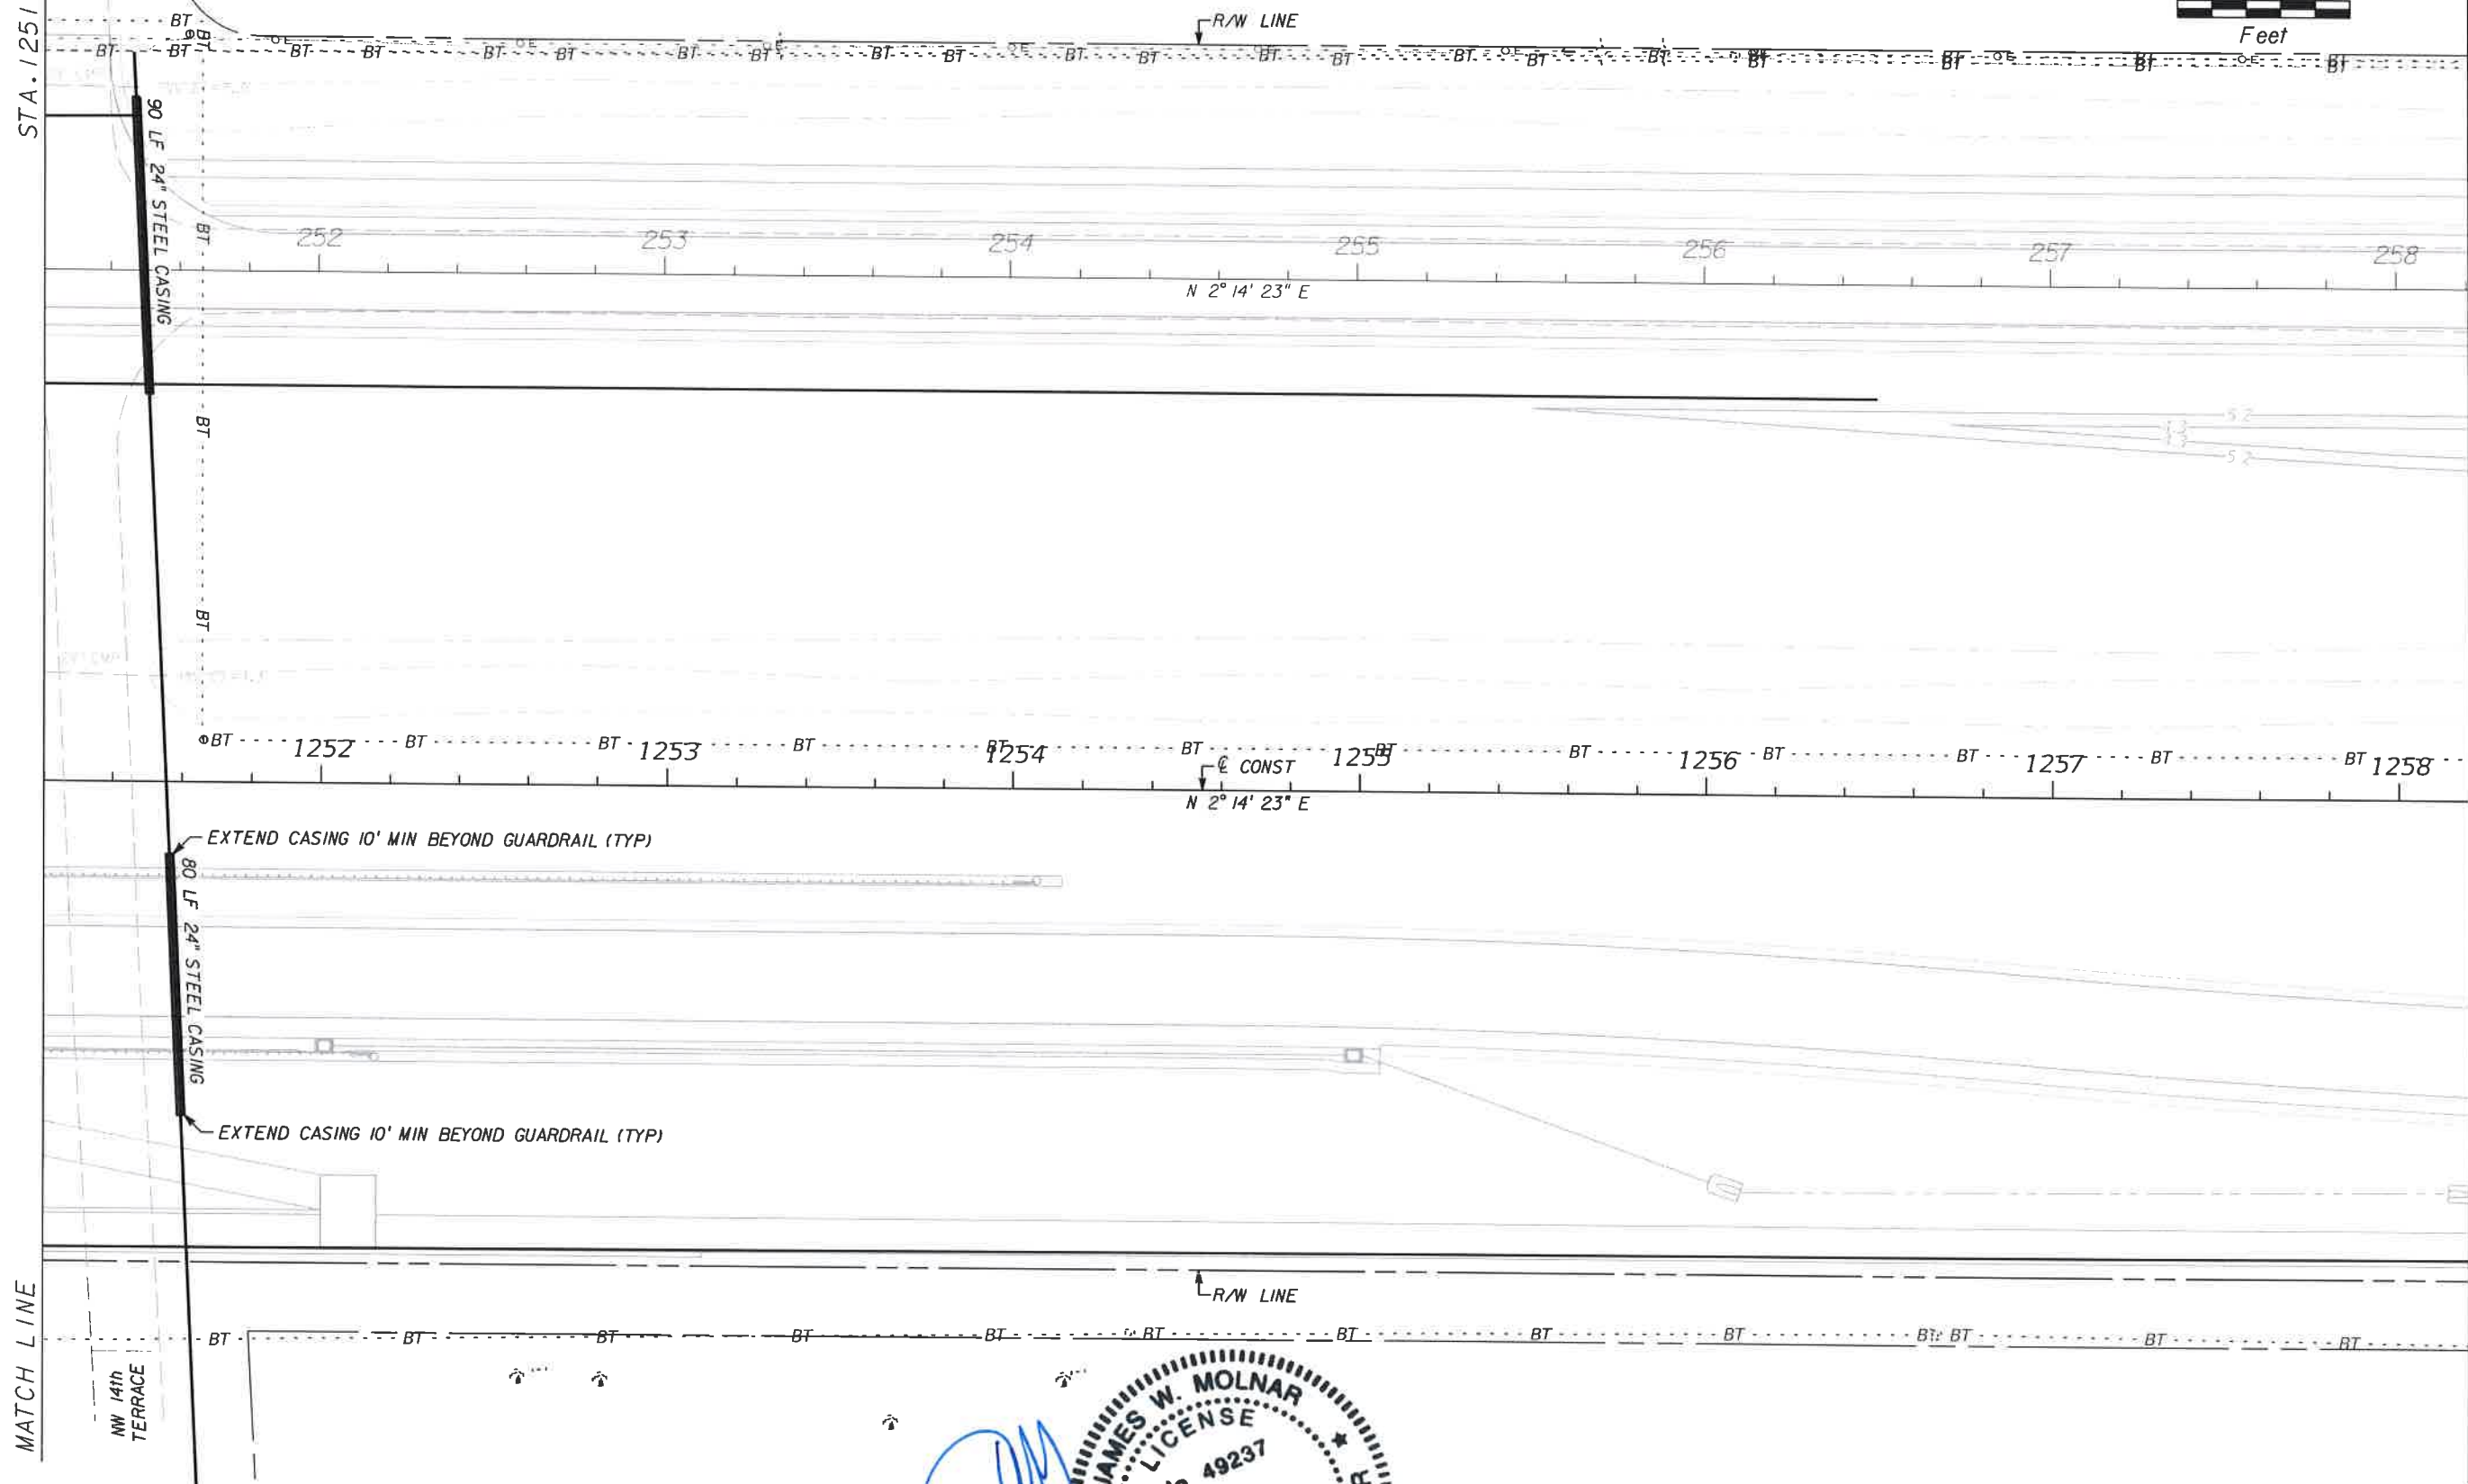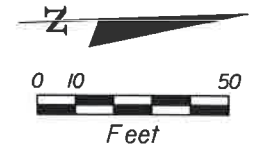

NO.	DATE	BY	REVISIONS - DESCRIPTION

T.Y. LIN INTERNATIONAL
 2400 FIRST STREET
 SUITE 200
 FORT MYERS, FLORIDA 33901
 TEL. (239) 332-4846
 FAX. (239) 332-4798
 WWW.TYLIN.COM

APPROVED BY:
JAMES W. MOLNAR, P.E.
 REGISTERED PROFESSIONAL ENGINEER
 FLORIDA CERTIFICATE NO. 49237
 3-5-2015



PUBLIC WORKS
 LEE COUNTY
 DEPARTMENT
 of
 TRANSPORTATION
 SOUTHWEST
 FLORIDA
 1500 MONROE STREET
 FORT MYERS, FLORIDA 33901
 1231 479-8900 www.lee-county.com/publicworks/dot/le.htm

UTILITY ADJUSTMENT SHEET
STA. 1251+20.00 TO STA. 1258+20.00
BURNT STORE ROAD

SHEET NO.
 101

STA. 1258+20.00

STA. 1265+20.00

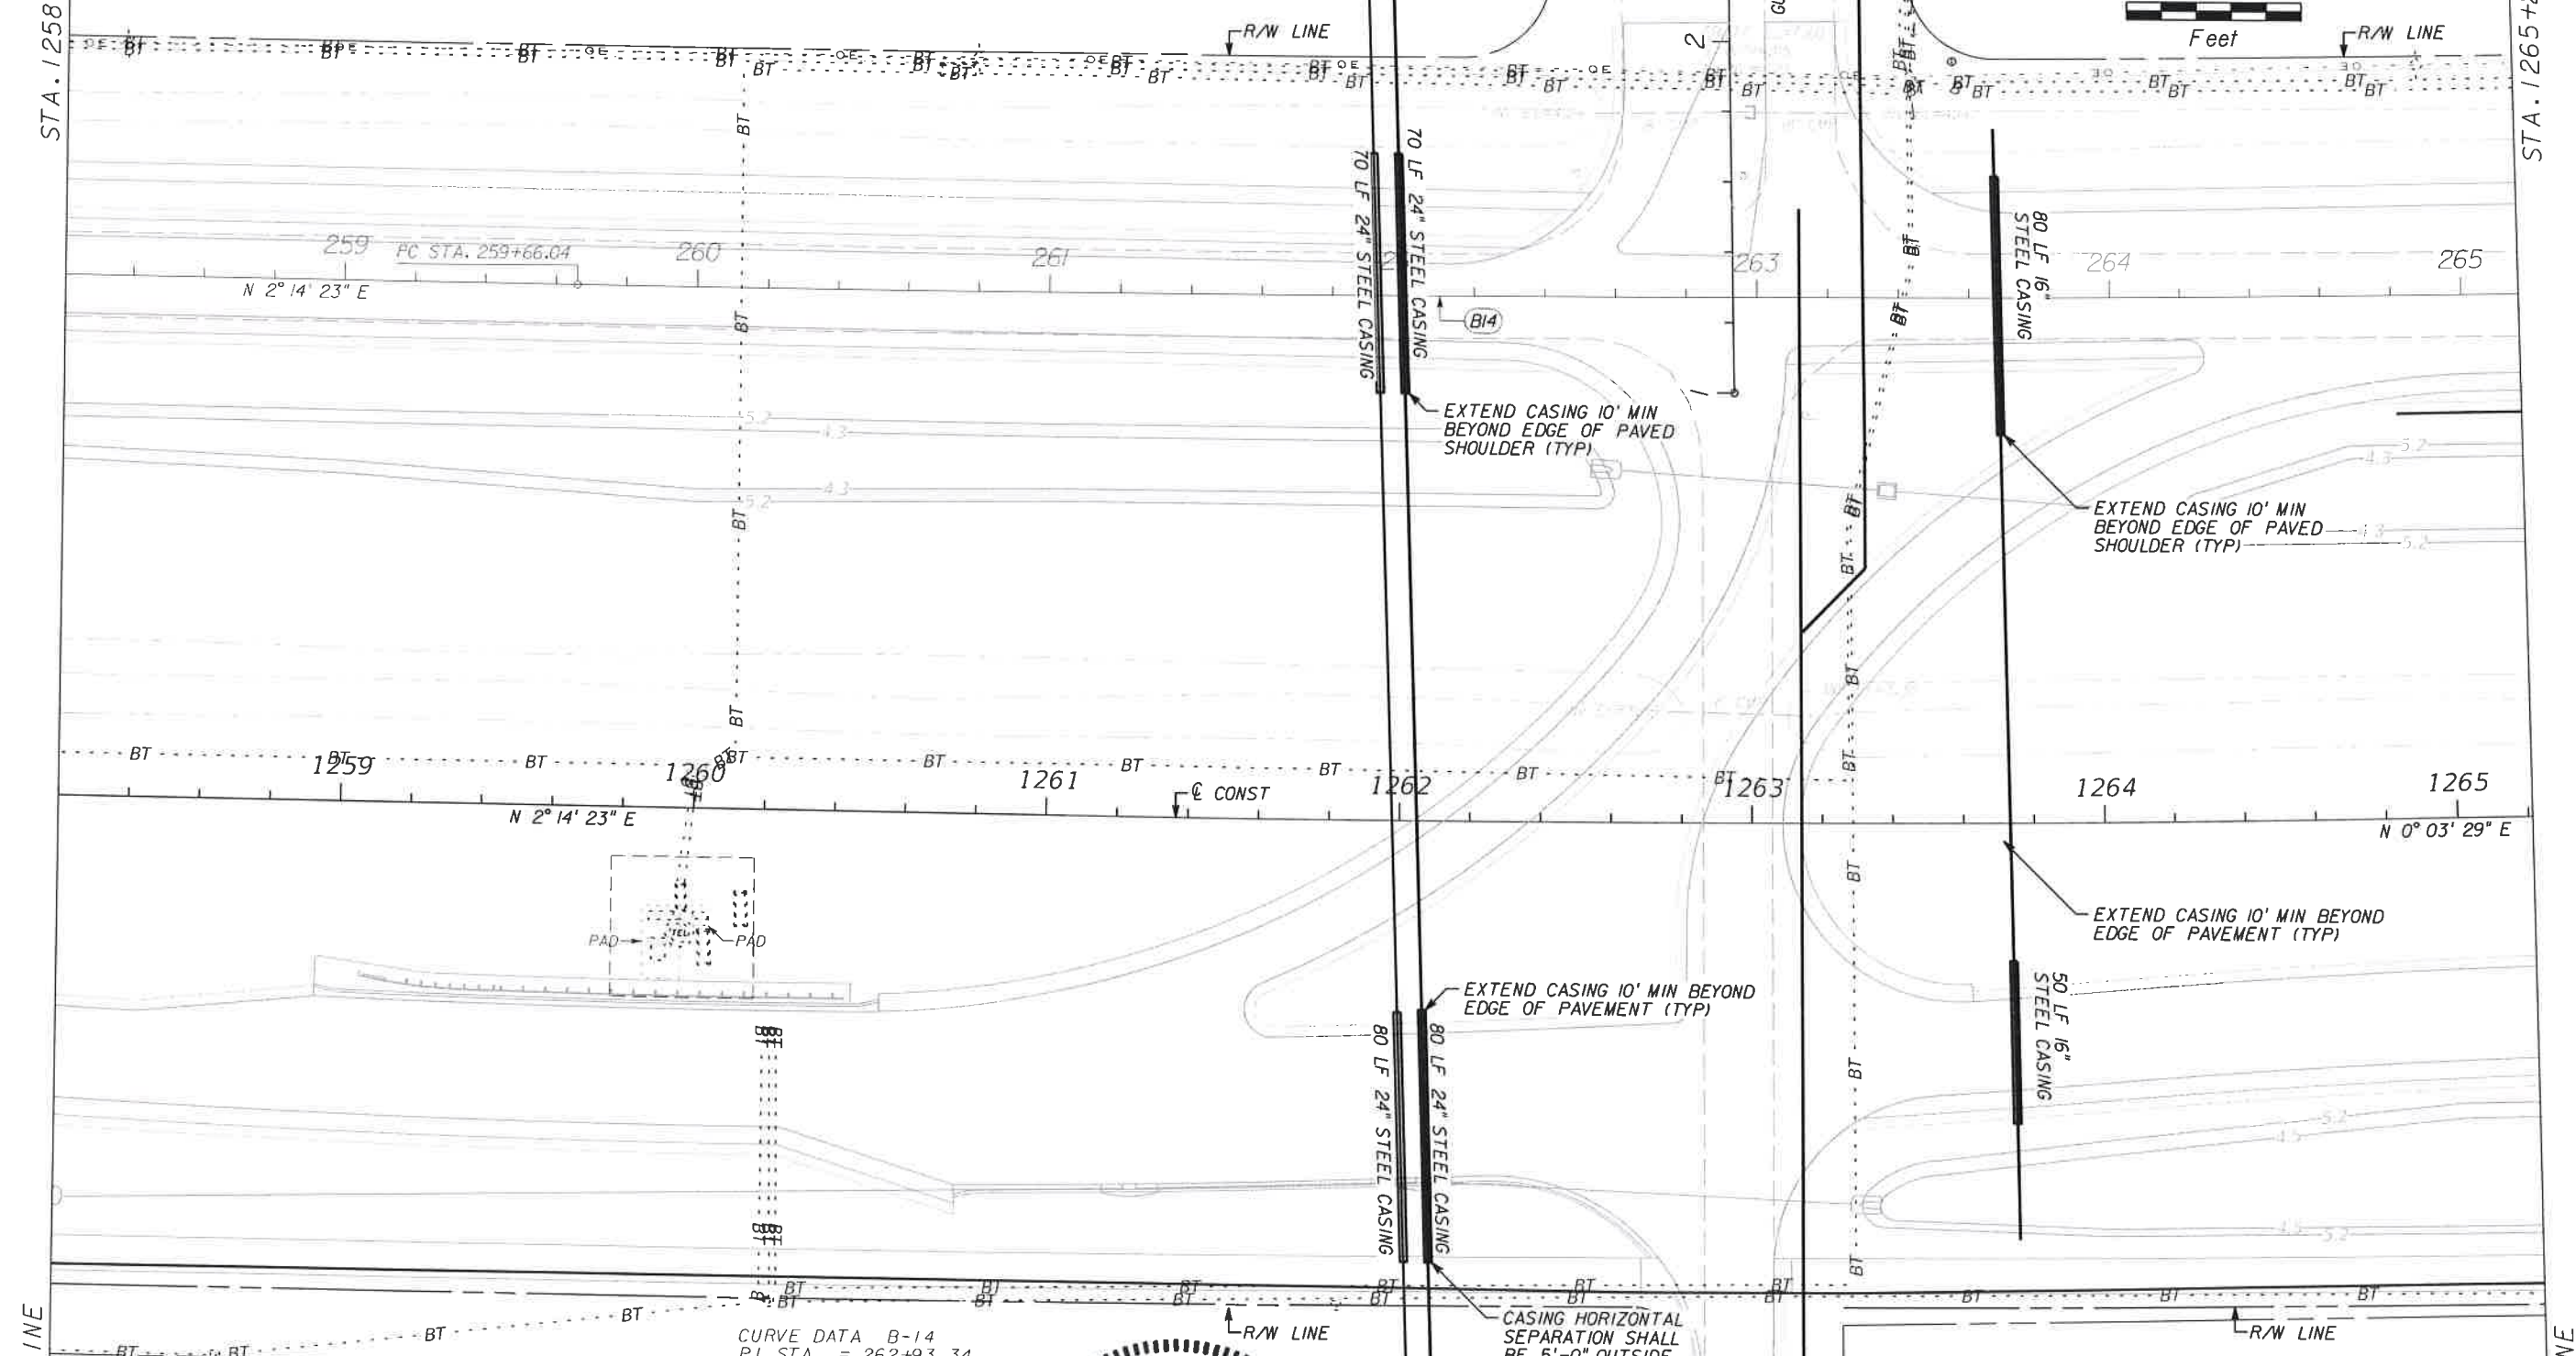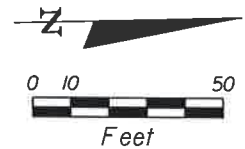

259 PC STA. 259+66.04
N 2° 14' 23" E

N 2° 14' 23" E

N 0° 03' 29" E

CURVE DATA B-14
PI STA. = 262+93.34
DELTA = 2° 10' 54" (LT)
D = 0° 20' 00"
T = 327.30
L = 654.52
R = 17,188.73
PC STA. = 259+66.04
PT STA. = 266+20.56

EXTEND CASING 10' MIN BEYOND EDGE OF PAVED SHOULDER (TYP)

EXTEND CASING 10' MIN BEYOND EDGE OF PAVED SHOULDER (TYP)


EXTEND CASING 10' MIN BEYOND EDGE OF PAVEMENT (TYP)

EXTEND CASING 10' MIN BEYOND EDGE OF PAVEMENT (TYP)

CASING HORIZONTAL SEPARATION SHALL BE 5'-0" OUTSIDE EDGE TO OUTSIDE EDGE (TYP)

MATCH LINE

MATCH LINE

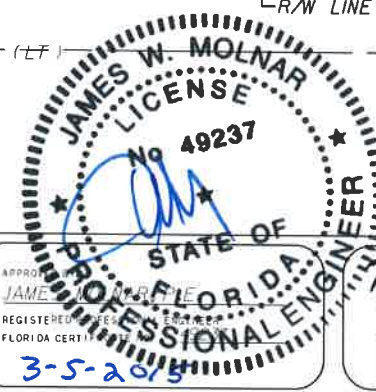

NO.	DATE	BY	REVISIONS - DESCRIPTION

T.Y. LIN INTERNATIONAL
2400 FIRST STREET
SUITE 200
FORT MYERS, FLORIDA 33901
TEL. (239) 332-4846
FAX. (239) 332-4798
WWW.TYLIN.COM

APPROVED
JAMES W. MOLNAR
REGISTERED PROFESSIONAL ENGINEER
FLORIDA CERT. No. 49237
3-5-2015


PUBLIC WORKS
LEE COUNTY
SOUTHWEST
FLORIDA
1500 MONROE STREET
FORT MYERS, FLORIDA 33901
(239) 479-8900 www.lee-county.com/publicworks/default.htm

DEPARTMENT
of
TRANSPORTATION
UTILITY ADJUSTMENT SHEET
STA. 1258+20.00 TO STA. 1265+20.00
BURNT STORE ROAD

SHEET NO.
102

STA. 1265+20.00

STA. 1272+20.00

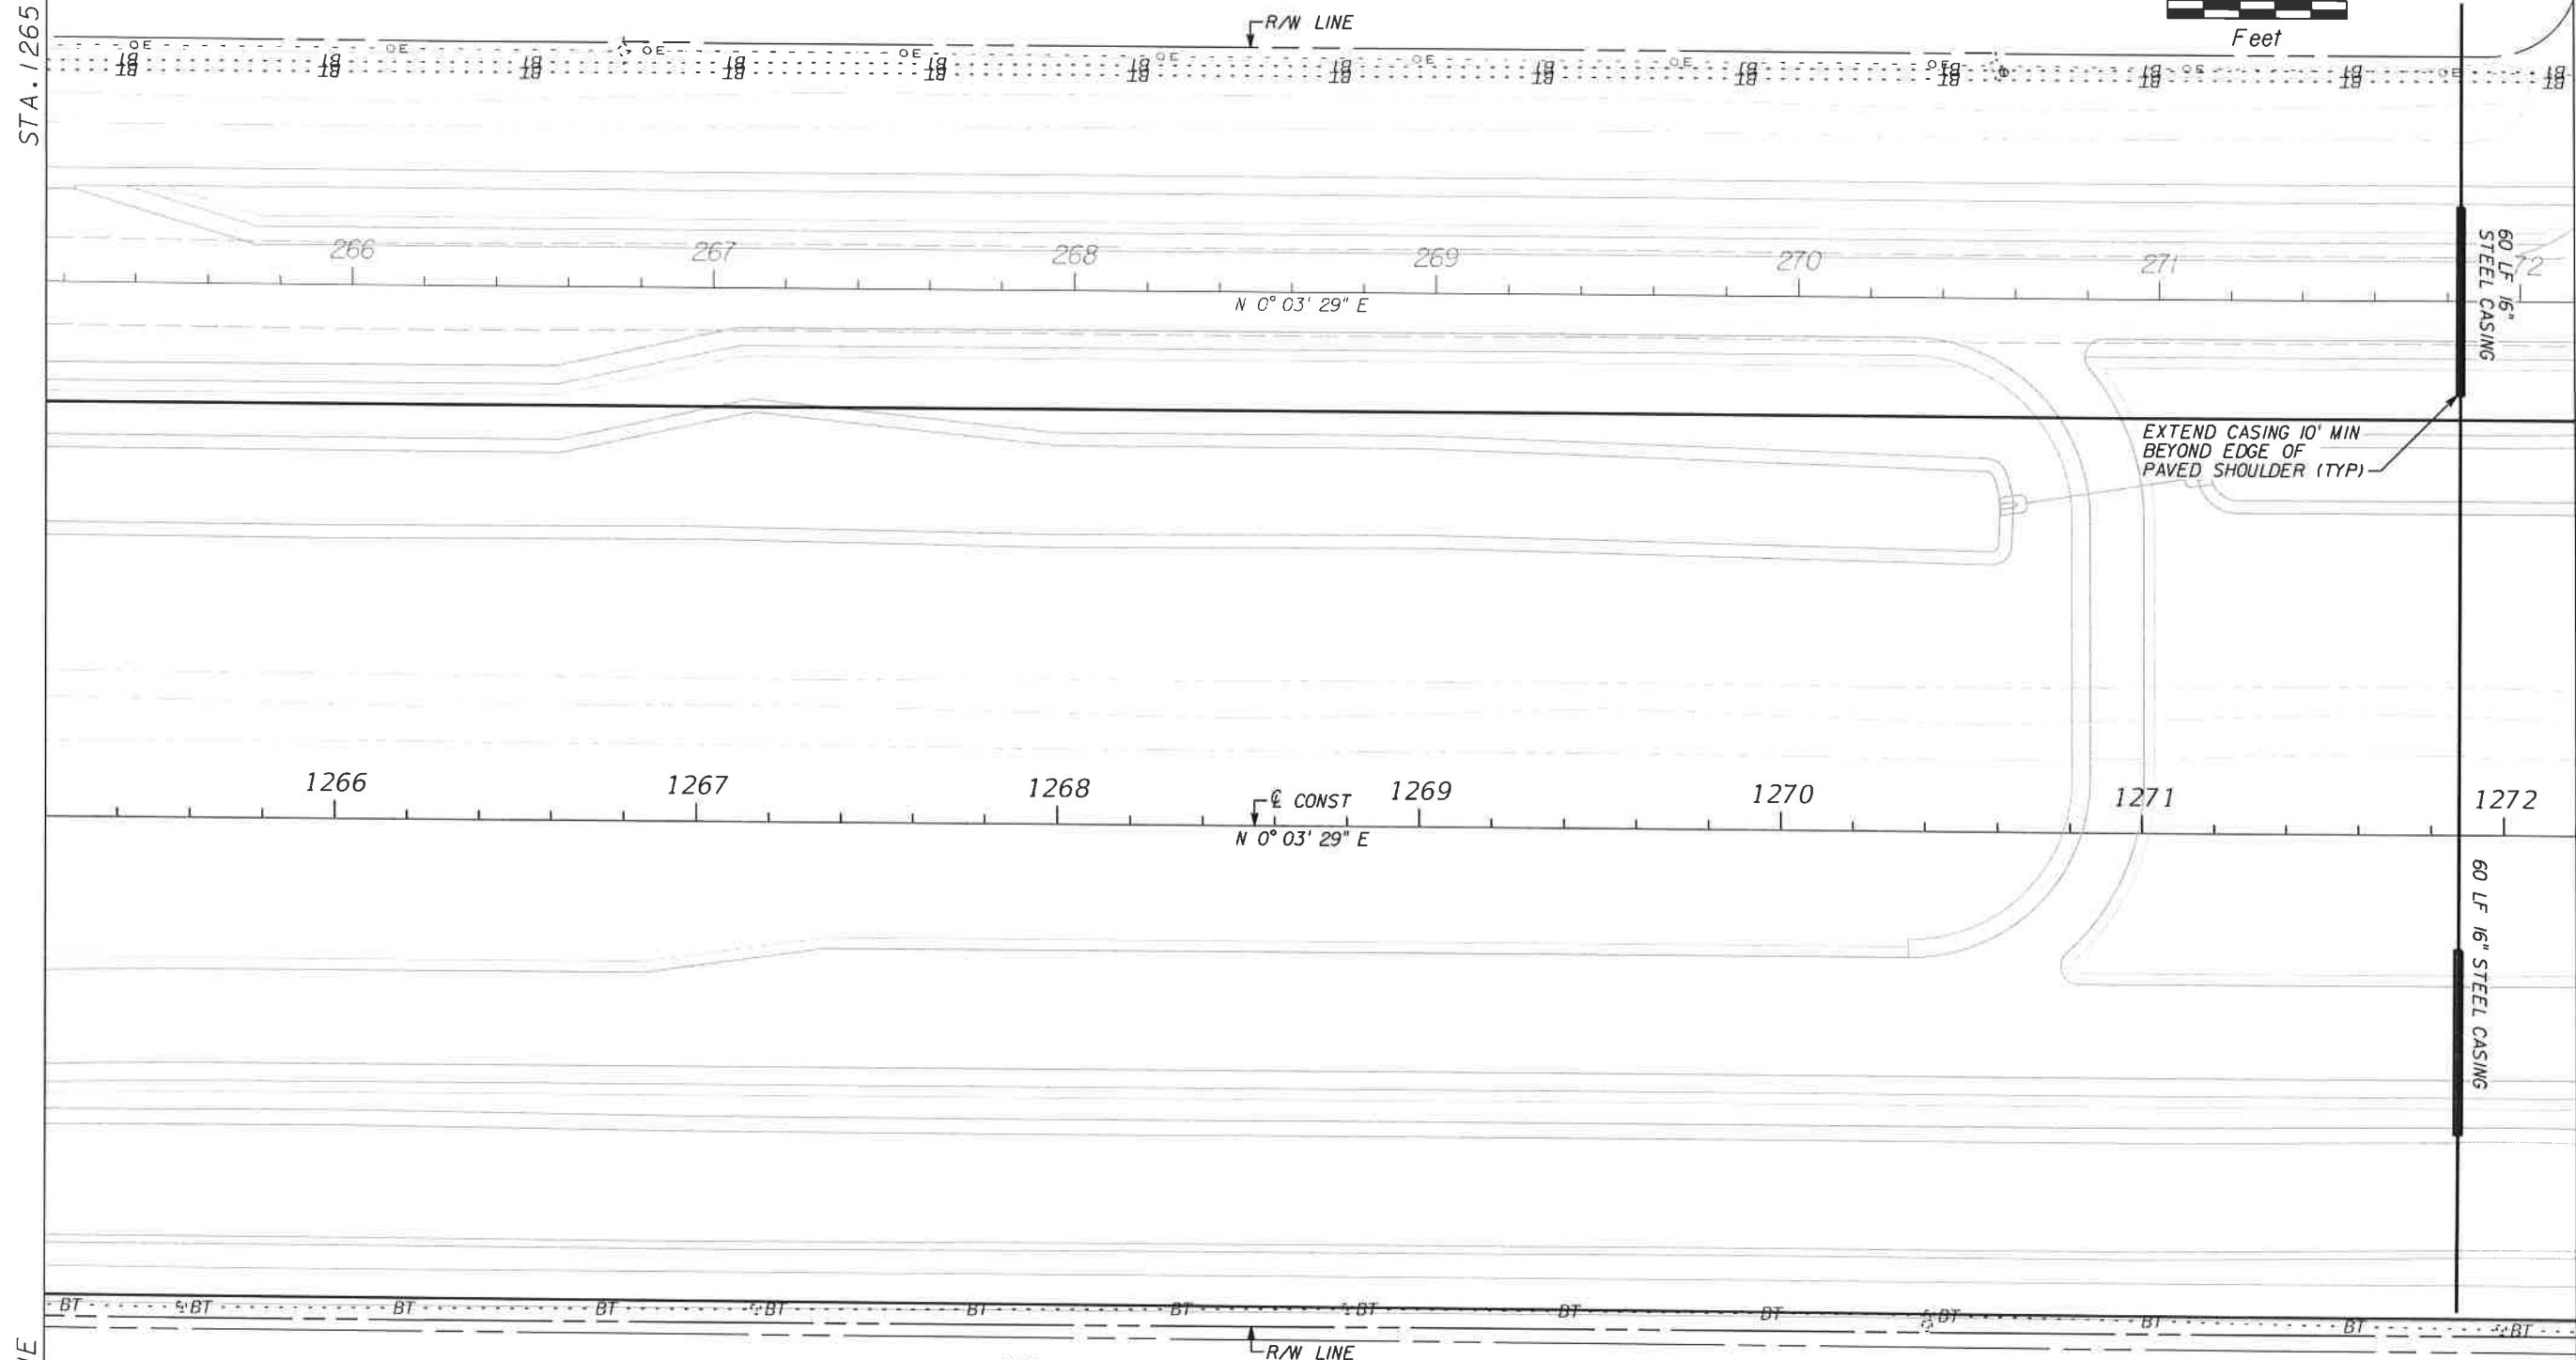

MATCH LINE

MATCH LINE

NO.	DATE	BY	REVISIONS - DESCRIPTION

T.Y. LIN INTERNATIONAL
 2400 FIRST STREET
 SUITE 200
 FORT MYERS, FLORIDA 33901
 TEL. (239) 332-4846
 FAX. (239) 332-4798
 WWW.TYLIN.COM



PUBLIC WORKS
LEE COUNTY
SOUTHWEST
FLORIDA
 1500 MONROE STREET
 FORT MYERS, FLORIDA 33901
 (239) 479-8900 www.lee-county.com/publicworks/dollie.htm


DEPARTMENT
of
TRANSPORTATION

UTILITY ADJUSTMENT SHEET
STA. 1265+20.00 TO STA. 1272+20.00
BURNT STORE ROAD

SHEET NO.
 103


STA. 1272+20.00

STA. 1279+20.00

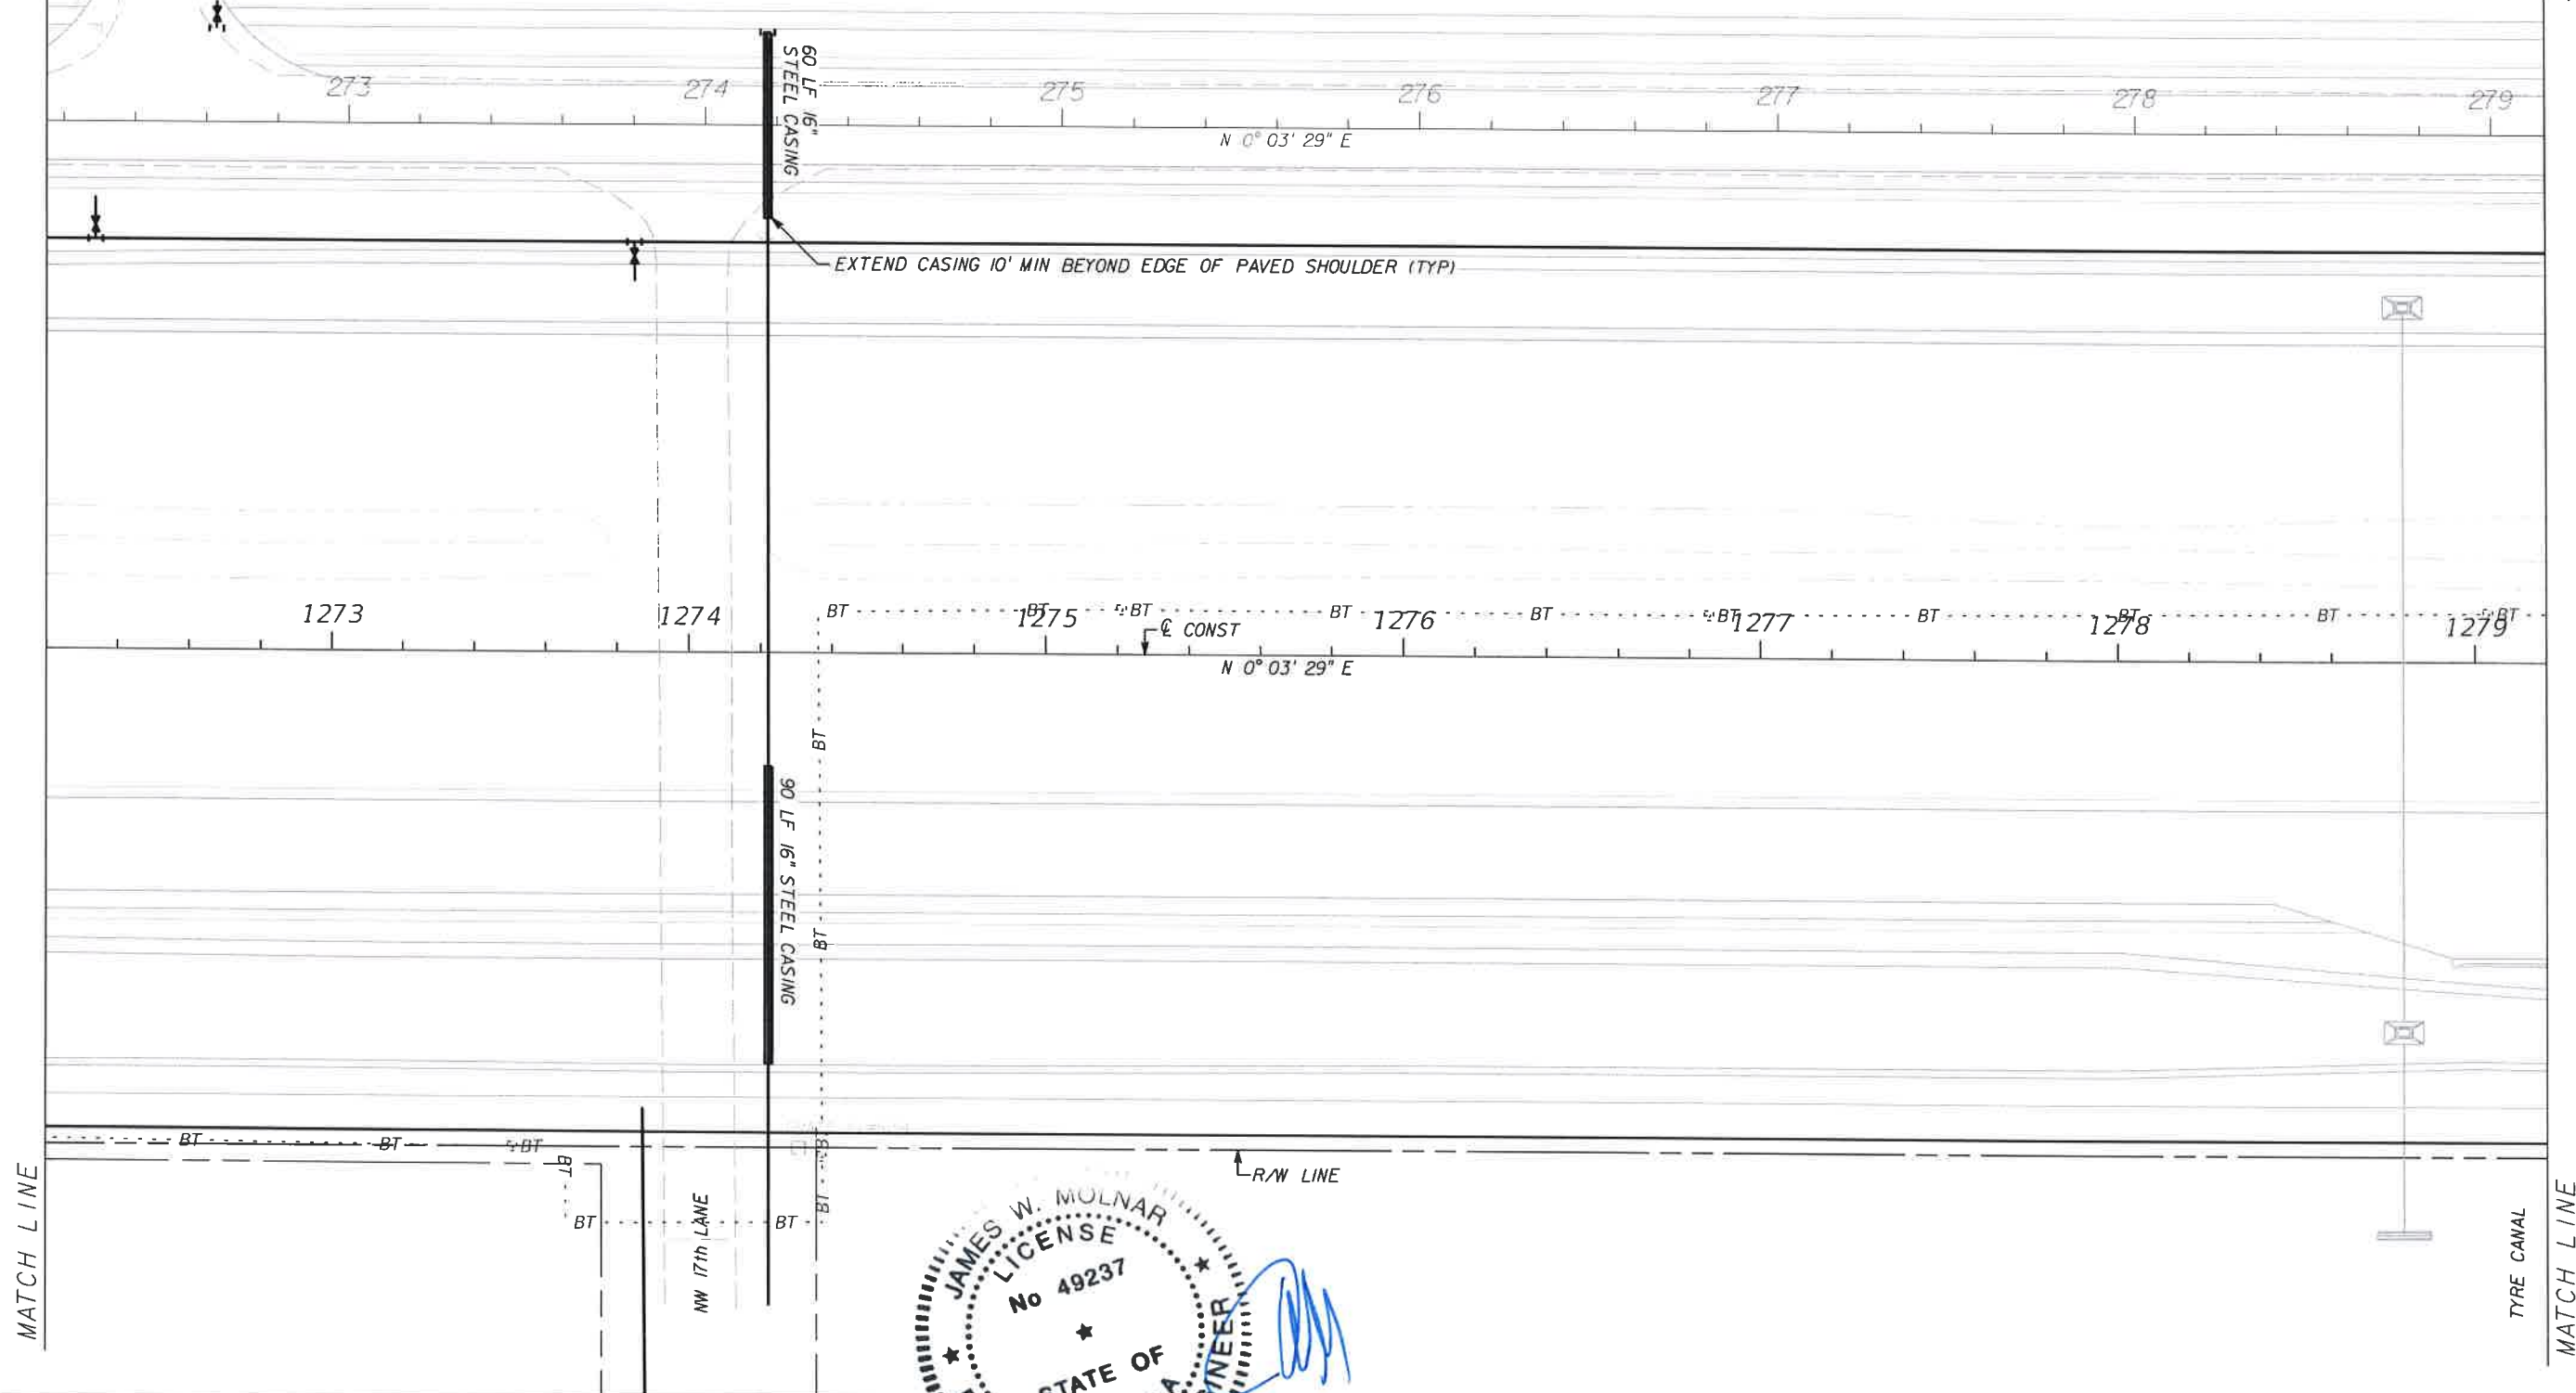

MATCH LINE

MATCH LINE

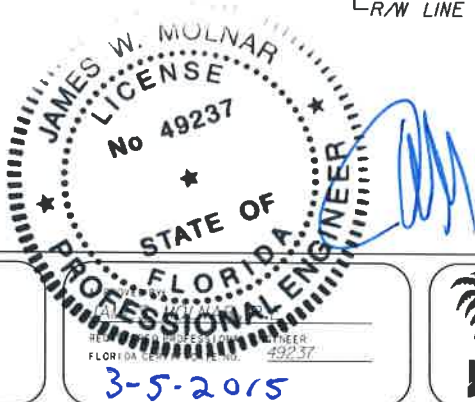

NO.	DATE	BY	REVISIONS DESCRIPTION

T.Y. LIN INTERNATIONAL
 2400 FIRST STREET
 SUITE 200
 FORT MYERS, FLORIDA 33901
 TEL. (239) 332-4846
 FAX. (239) 332-4798
 WWW.TYLIN.COM

3-5-2015


PUBLIC WORKS
 LEE COUNTY
 DEPARTMENT
 of
 TRANSPORTATION
 SOUTH WEST
 FLORIDA
 1500 MONROE STREET
 FORT MYERS, FLORIDA 33901
 (239) 479-8900 www.lee-county.com/publicworks/00004.htm

UTILITY ADJUSTMENT SHEET
STA. 1272+20.00 TO STA. 1279+20.00
BURNT STORE ROAD

SHEET NO.
 104


STA. 1279+20.00

STA. 1286+20.00

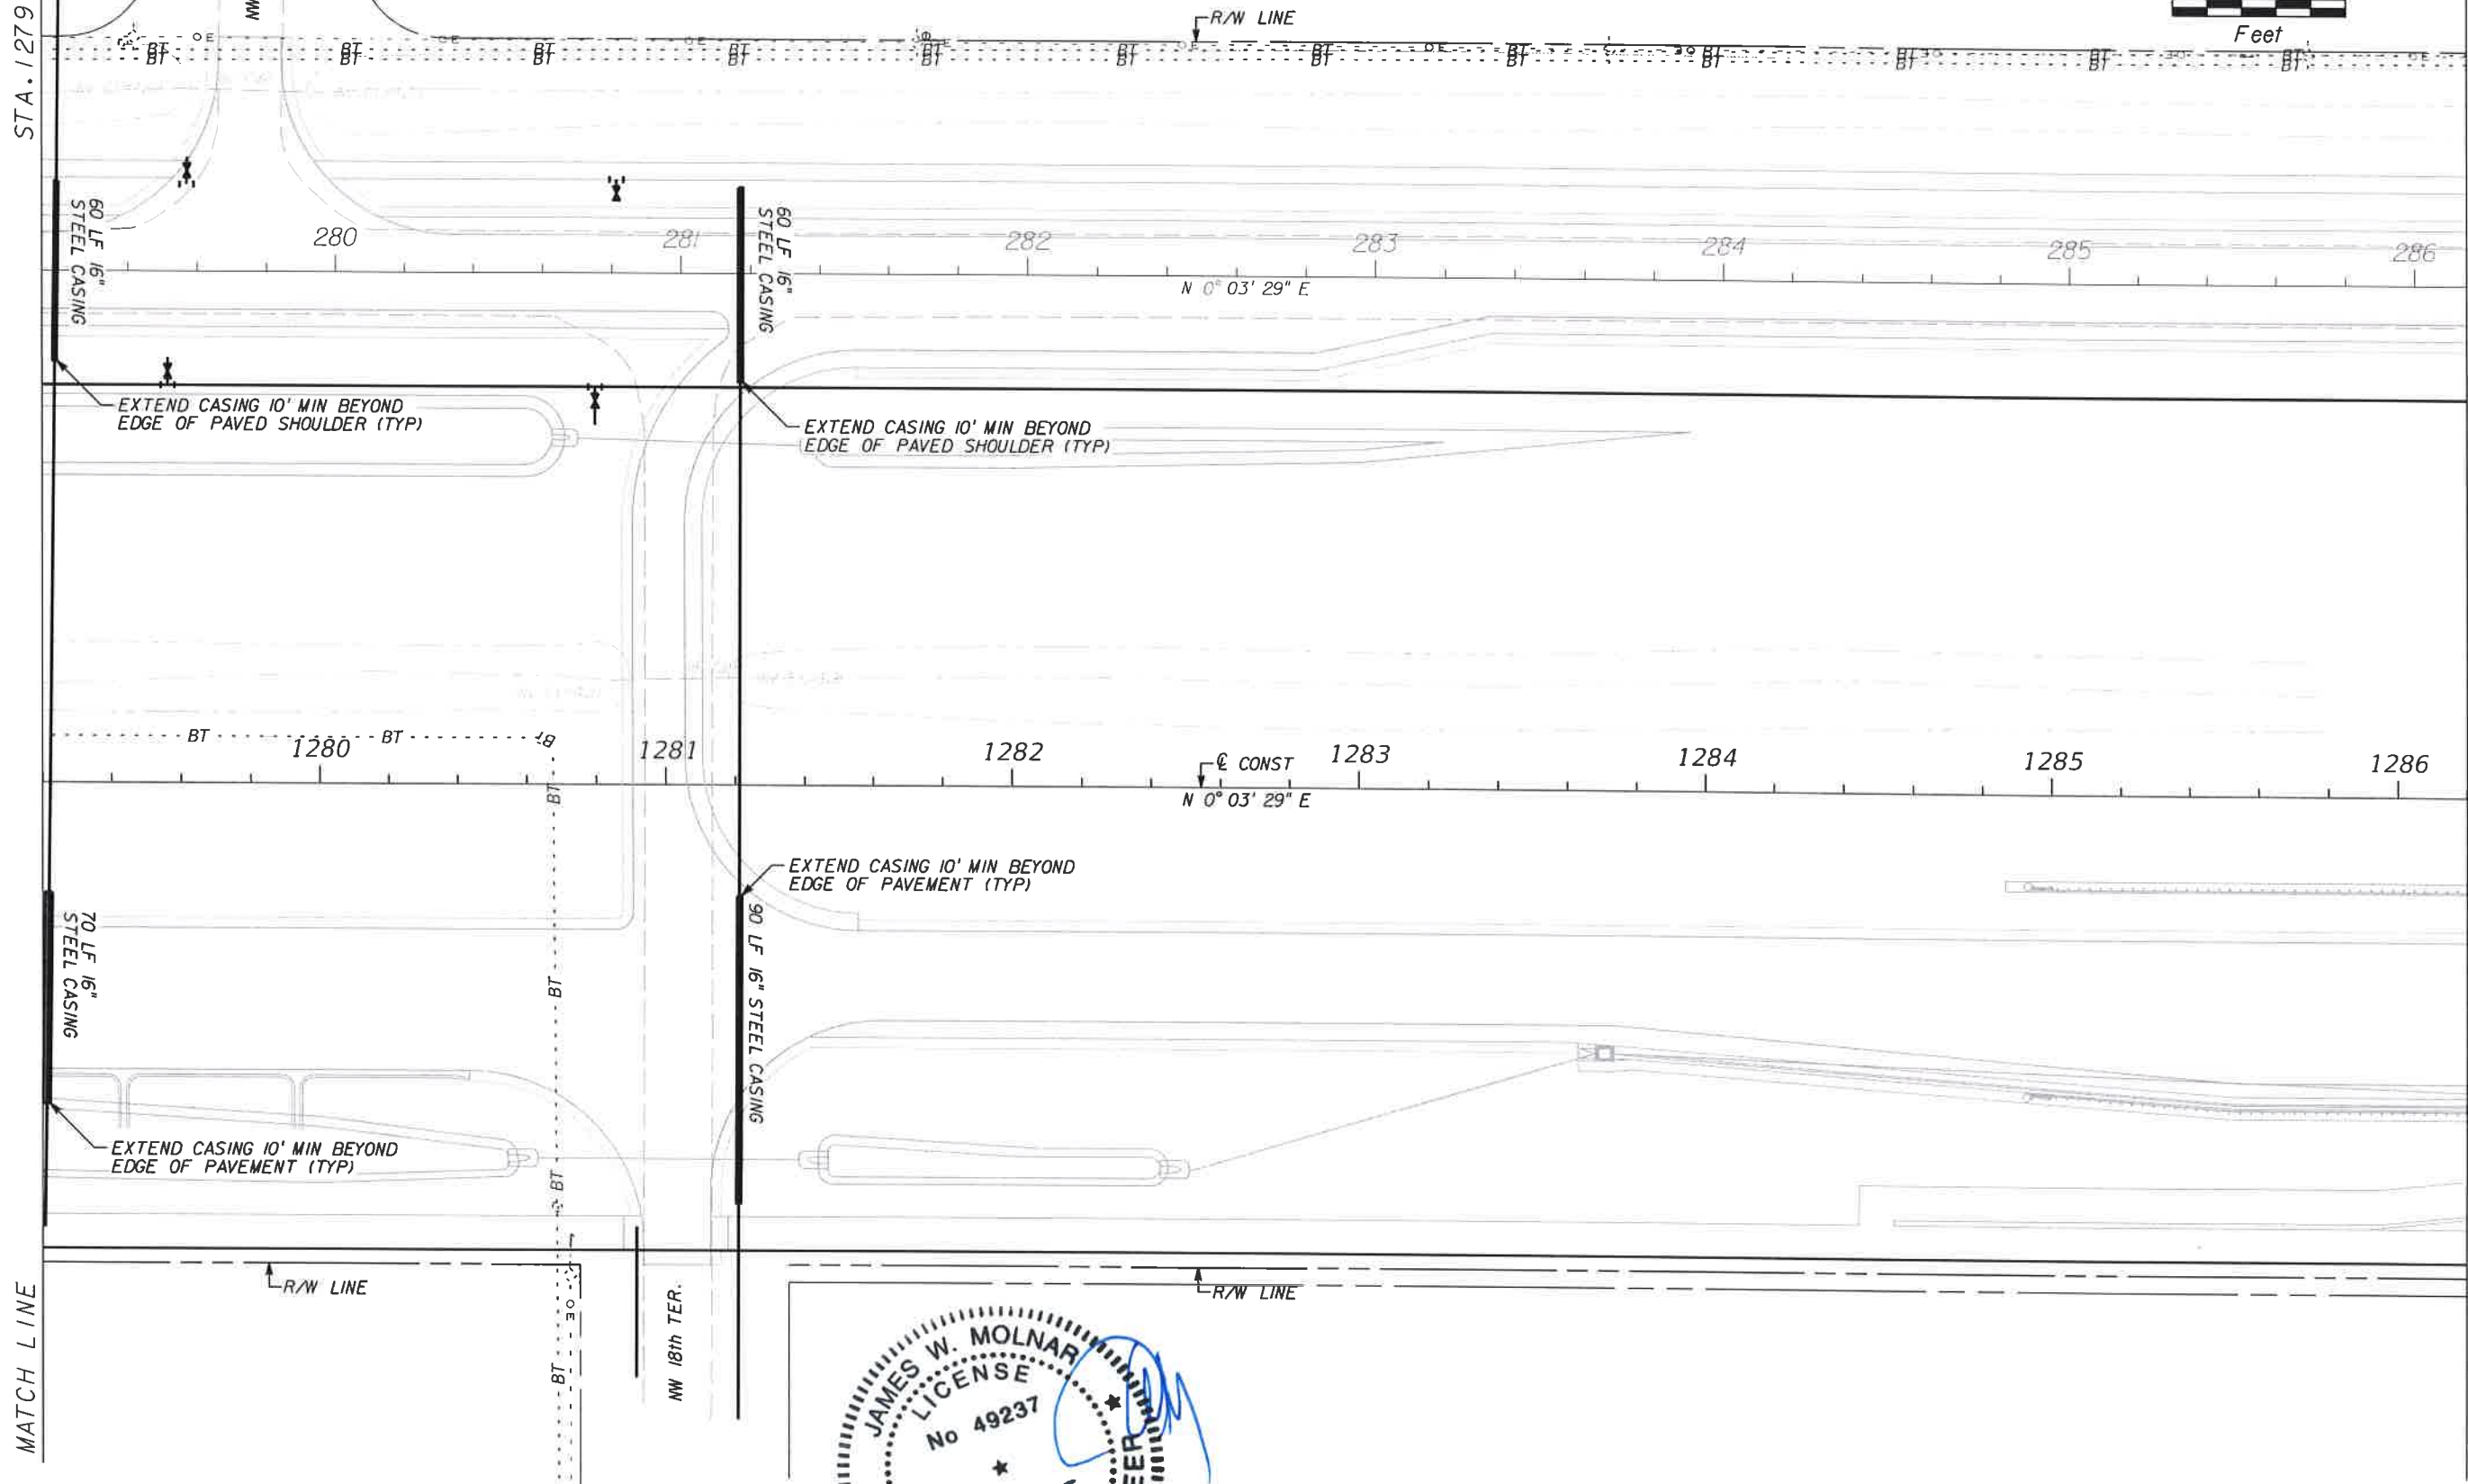

MATCH LINE

MATCH LINE

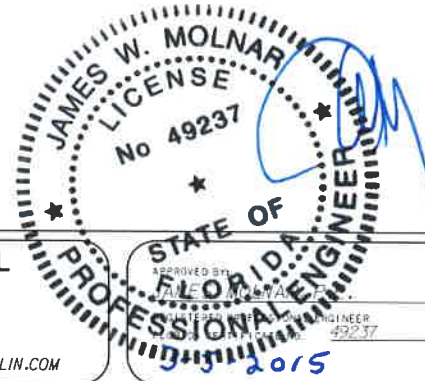

NO.	DATE	BY	REVISIONS - DESCRIPTION

T.Y. LIN INTERNATIONAL
 2400 FIRST STREET
 SUITE 200
 FORT MYERS, FLORIDA 33901
 TEL. (239) 332-4846
 FAX. (239) 332-4798
 WWW.TYLIN.COM

APPROVED BY
JAMES W. MOLNAR
 LICENSE No. 49237
 STATE OF FLORIDA
 PROFESSIONAL ENGINEER
 2015



PUBLIC WORKS
 LEE COUNTY
 DEPARTMENT of TRANSPORTATION
 SOUTHWEST FLORIDA
 1500 MONROE STREET FORT MYERS, FLORIDA 33901
 (239) 479-8900 www.lee-county.com/publicworks/leesville.htm

UTILITY ADJUSTMENT SHEET
STA. 1279+20.00 TO STA. 1286+20.00
BURNT STORE ROAD

SHEET NO.
 105


STA. 1293+20.00

STA. 1300+20.00

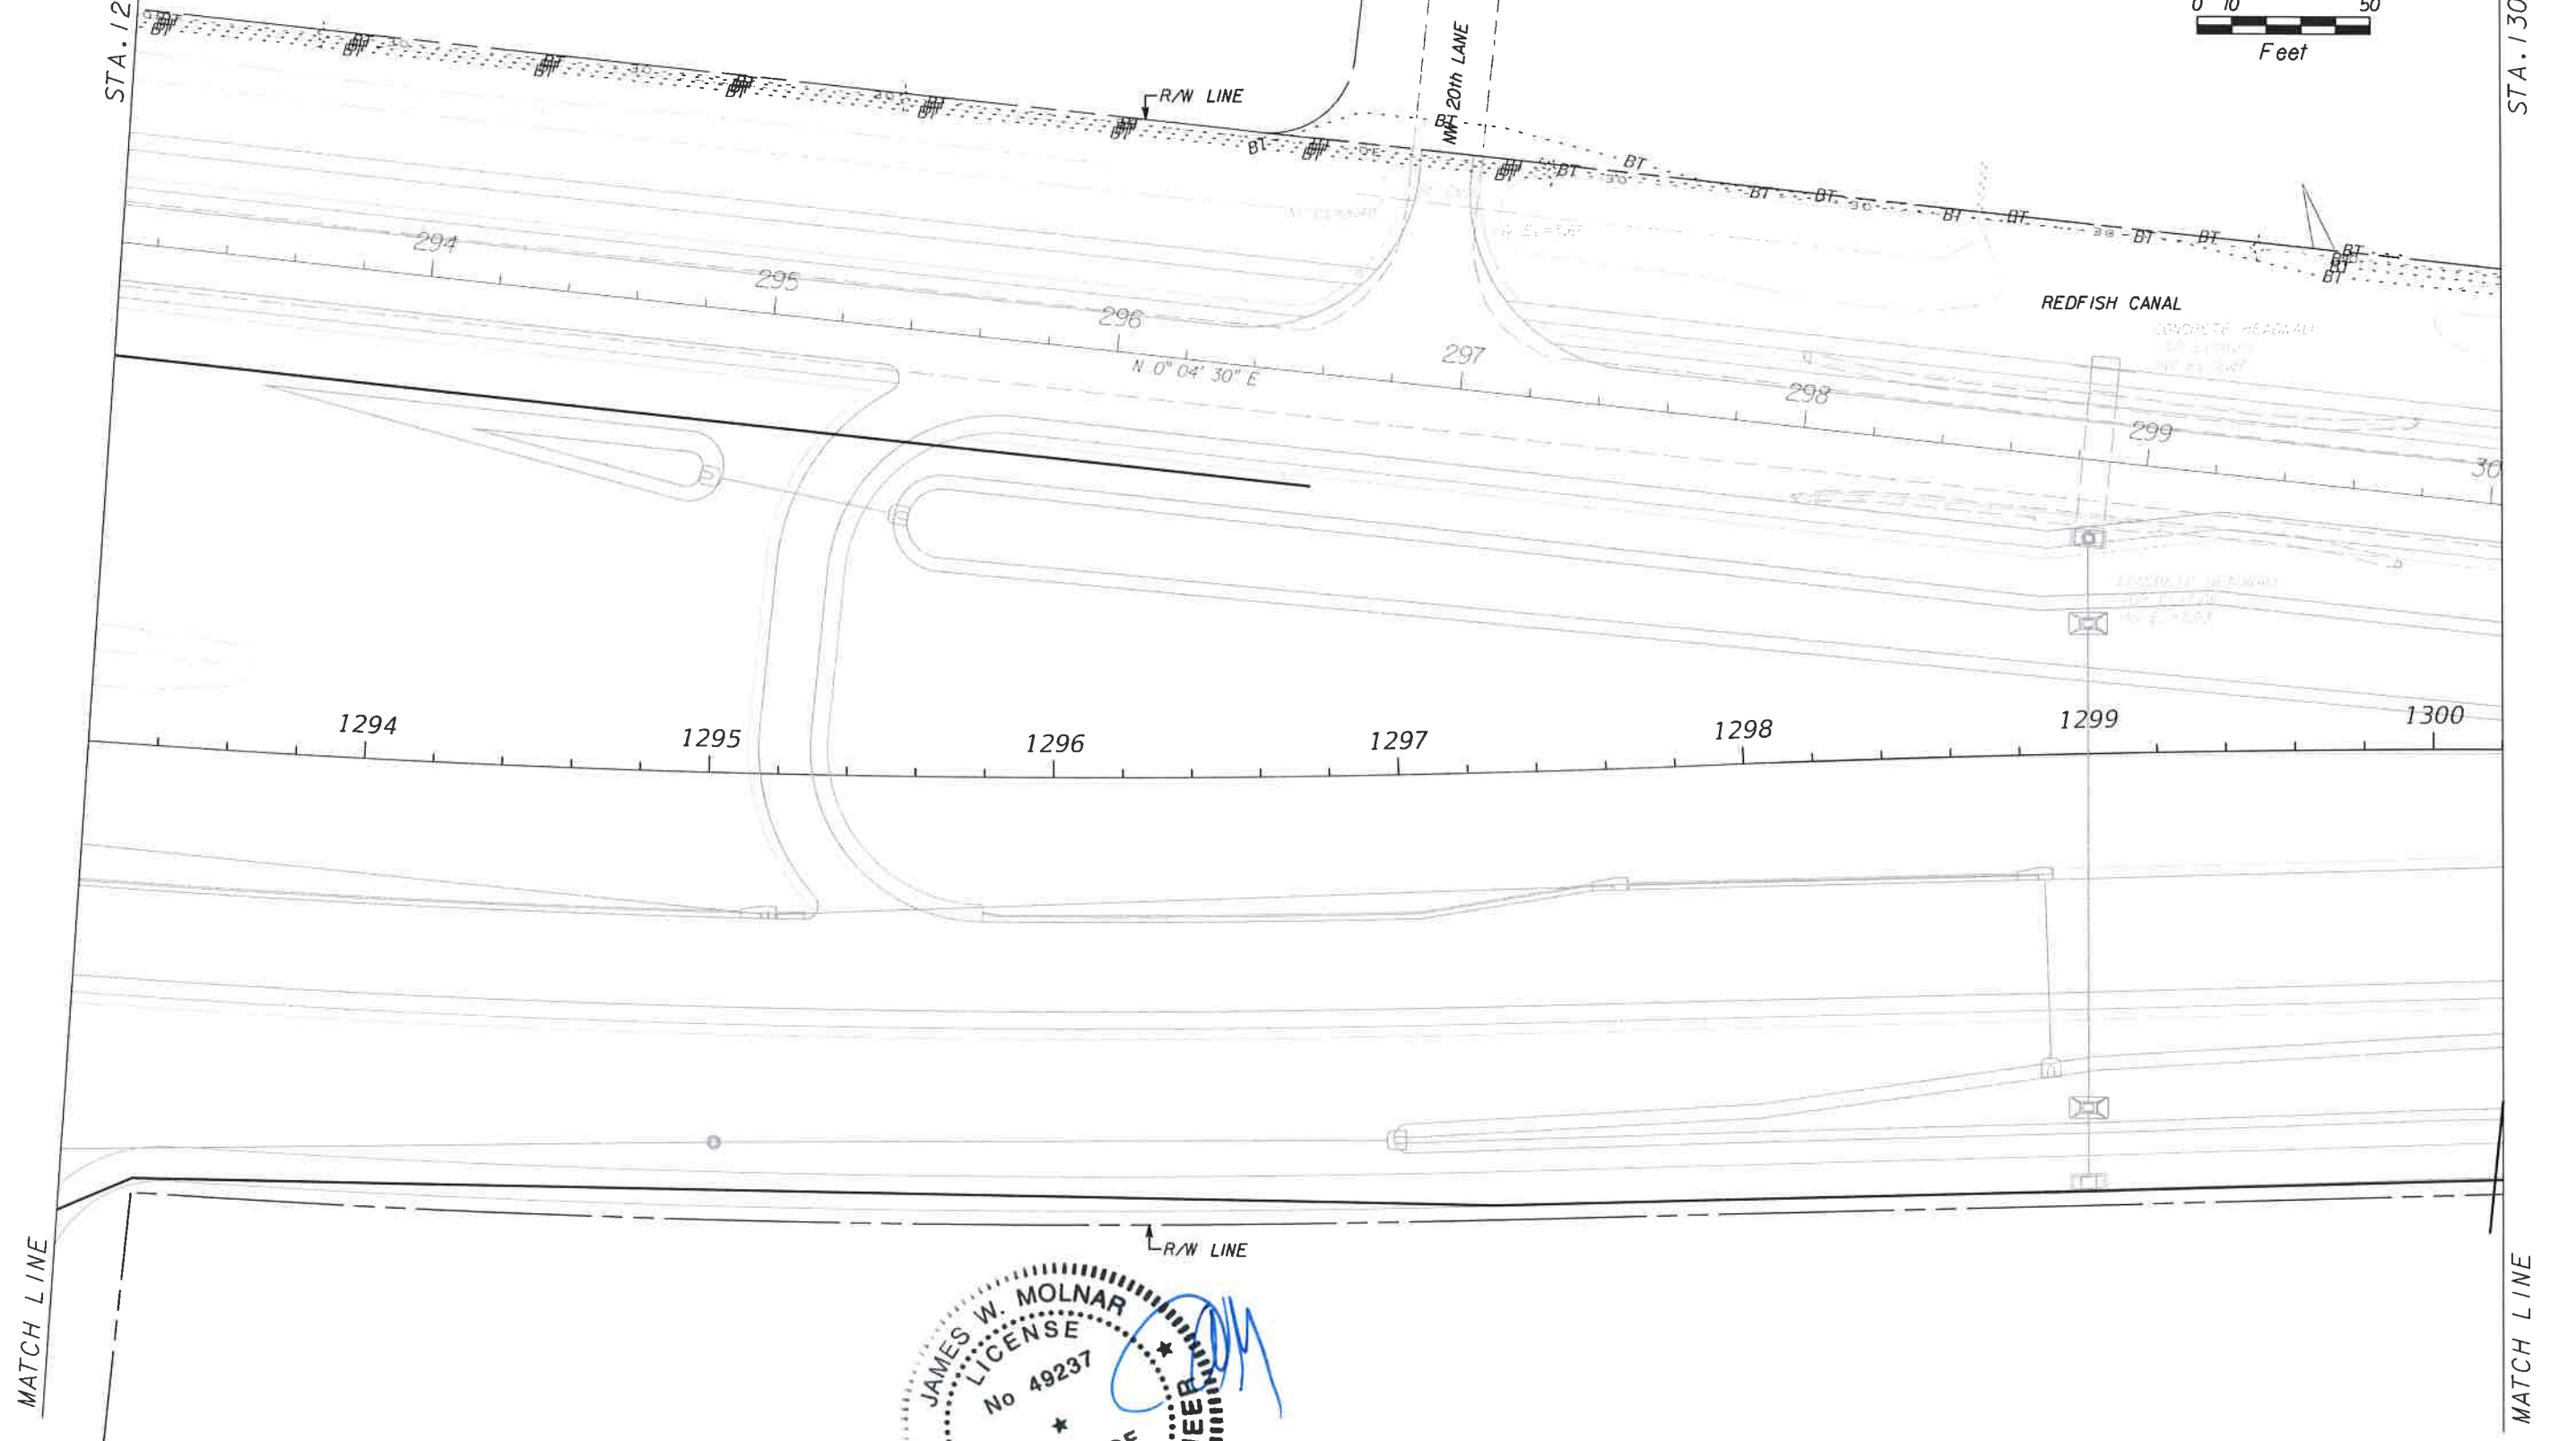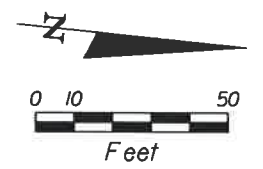

MATCH LINE

MATCH LINE

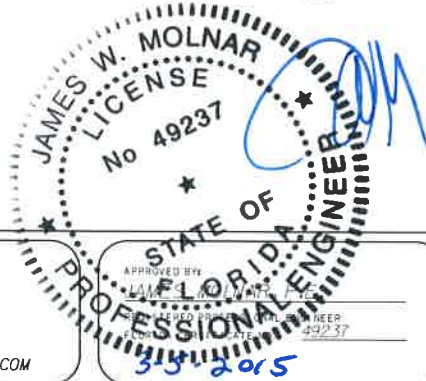

NO.	DATE	BY	REVISIONS - DESCRIPTION

T.Y. LIN INTERNATIONAL
 2400 FIRST STREET
 SUITE 200
 FORT MYERS, FLORIDA 33901
 TEL. (239) 332-4846
 FAX. (239) 332-4798
 WWW.TYLIN.COM

APPROVED BY
 JAMES W. MOLNAR
 LICENSE No. 49237
 STATE OF FLORIDA
 PROFESSIONAL ENGINEER
 3/3/2015

PUBLIC WORKS
LEE COUNTY
SOUTHWEST
FLORIDA
 1500 MONROE STREET
 (239) 479-8900 www.lee-county.com/publicworks/delille.htm




DEPARTMENT
of
TRANSPORTATION
 FORT MYERS, FLORIDA 33901

UTILITY ADJUSTMENT SHEET
STA. 1293+20.00 TO STA. 1300+20.00
BURNT STORE ROAD

SHEET NO.
 107

STA. 1300+20.00

STA. 1307+20.00

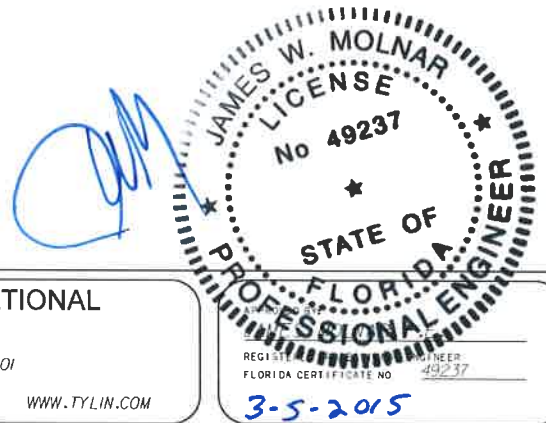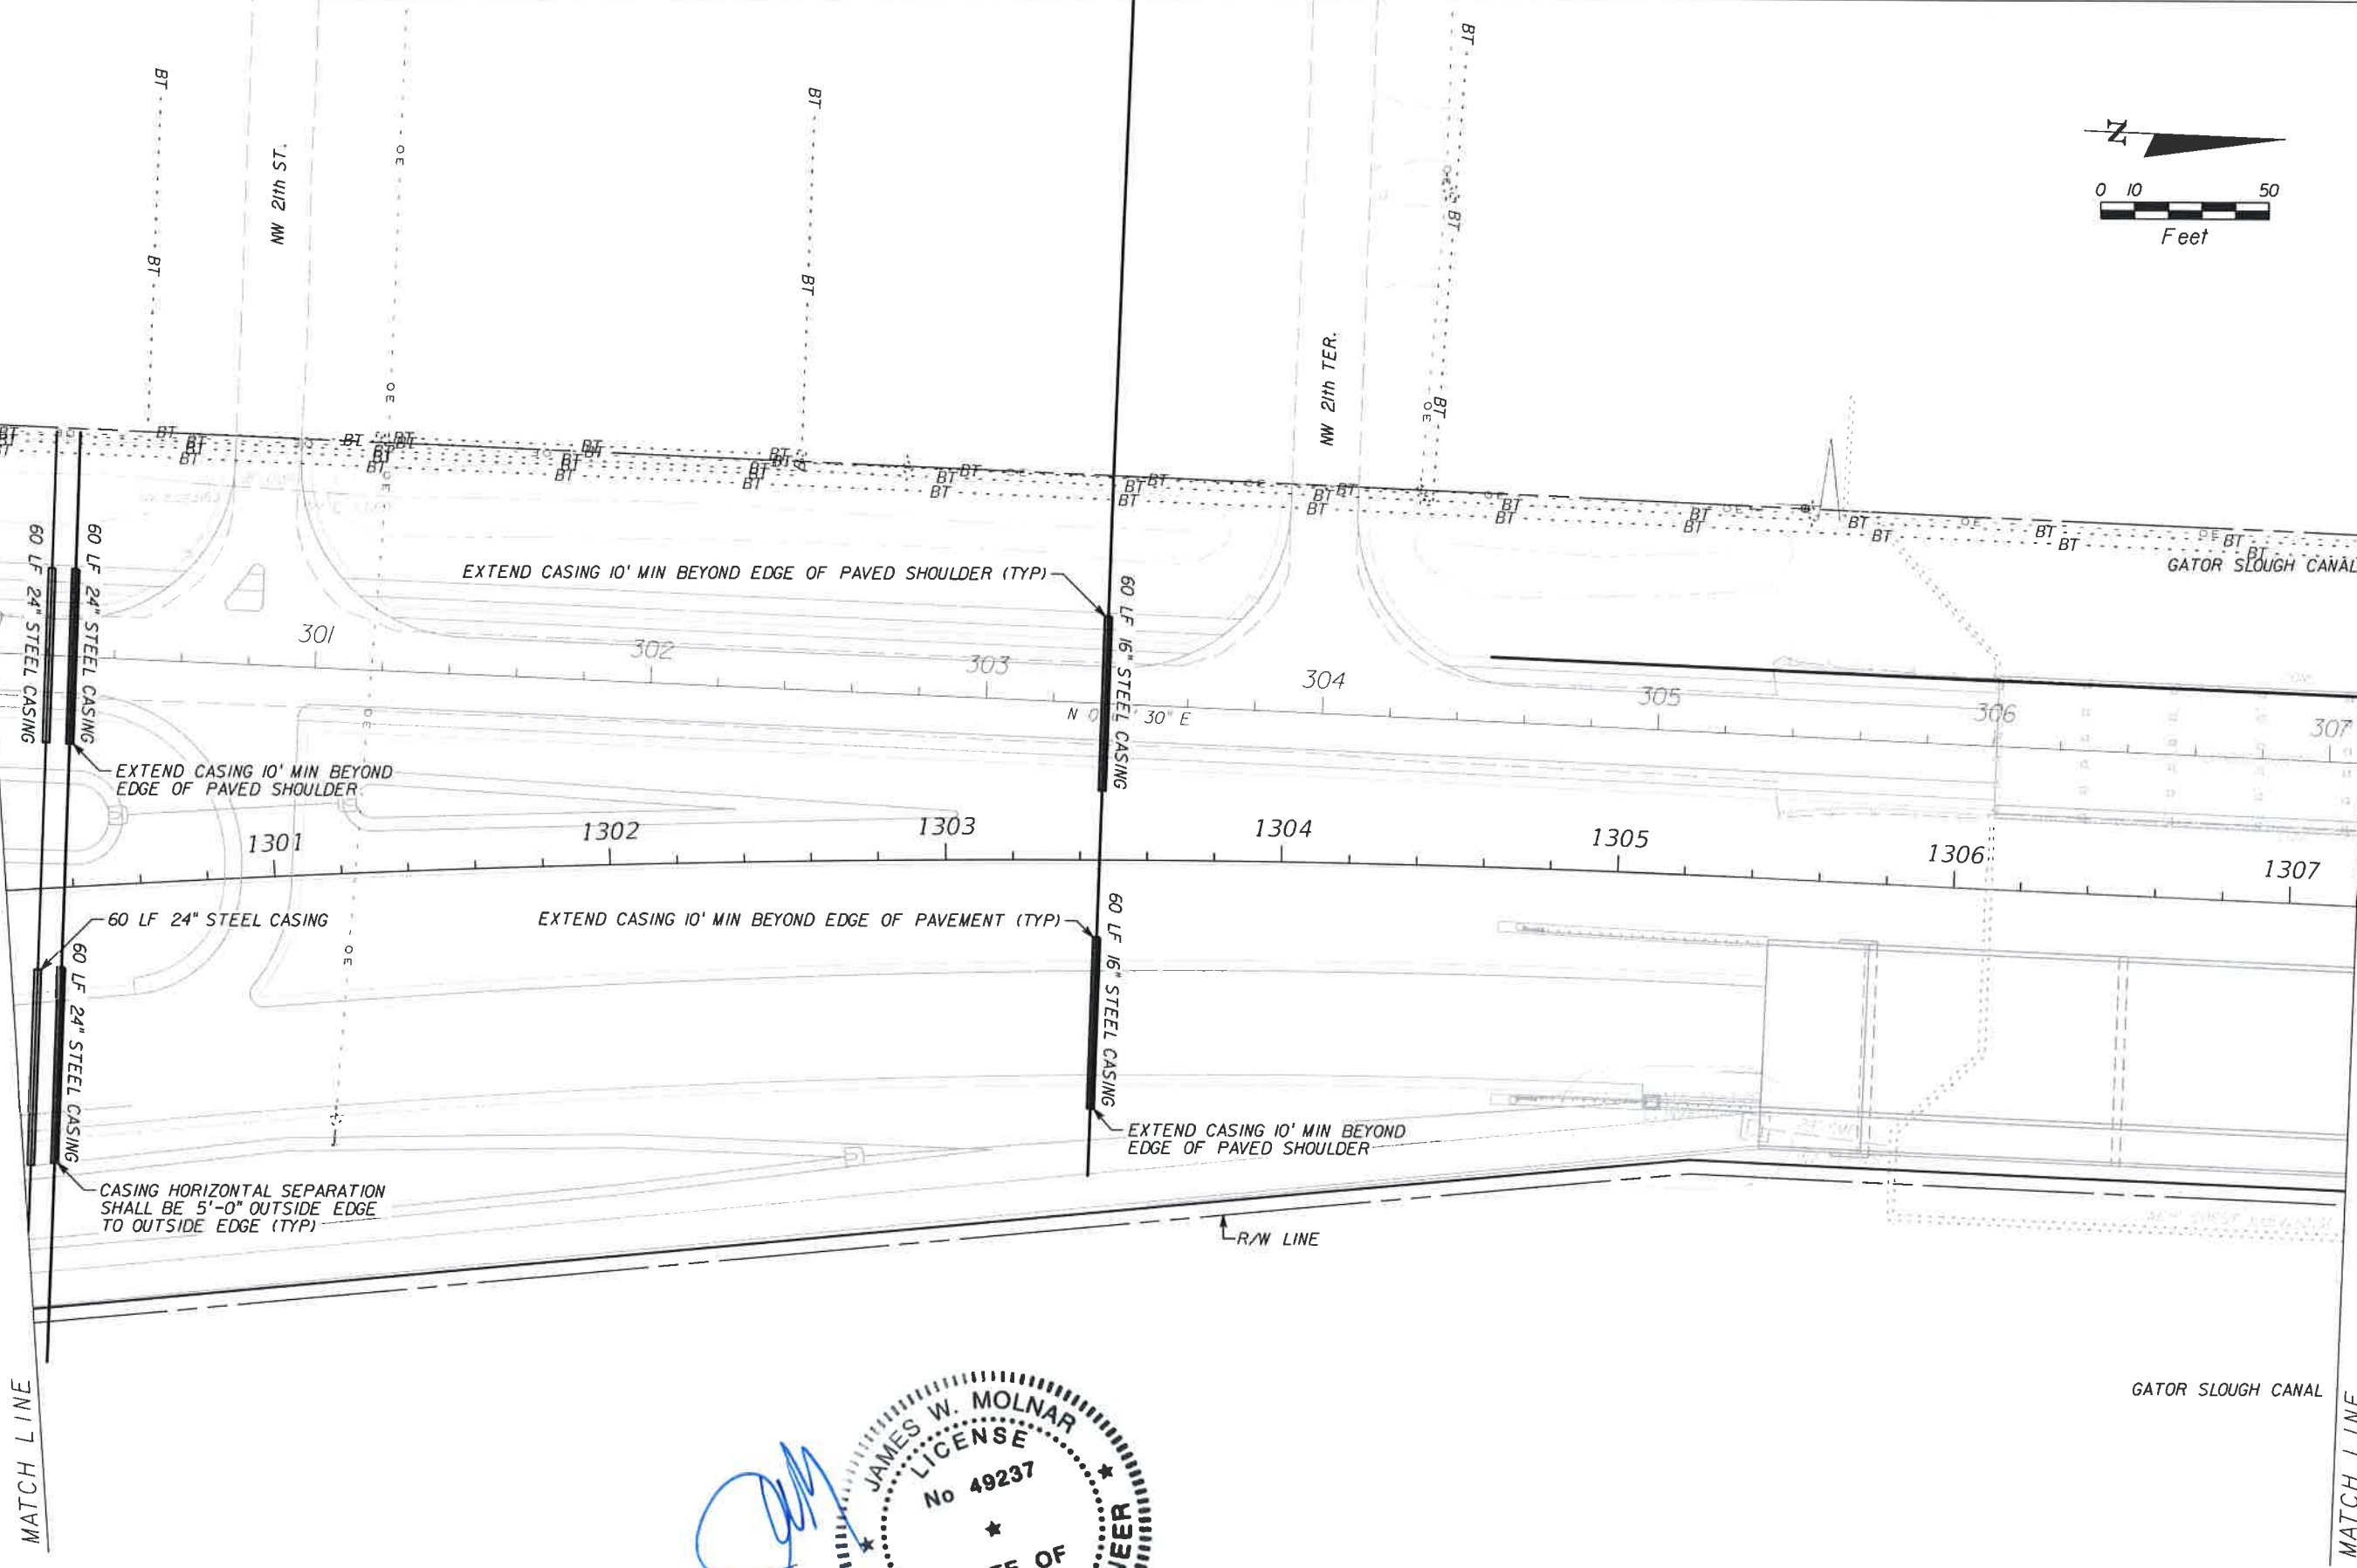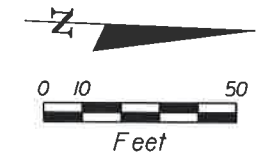

No.	DATE	BY	REVISIONS - DESCRIPTION

T.Y. LIN INTERNATIONAL
 2400 FIRST STREET
 SUITE 200
 FORT MYERS, FLORIDA 33901
 TEL. (239) 332-4846
 FAX. (239) 332-4798
 WWW.TYLIN.COM

JAMES W. MOLNAR
 LICENSE
 No 49237
 STATE OF
 FLORIDA
 PROFESSIONAL ENGINEER
 3-5-2015

PUBLIC WORKS
 LEE COUNTY
 SOUTHWEST
 FLORIDA
 1500 MONROE STREET
 12391 479-8900 www.lee-county.com/public-works/utilities.htm



DEPARTMENT
 of
TRANSPORTATION
 FORT MYERS, FLORIDA 33901

UTILITY ADJUSTMENT SHEET
STA. 1300+20.00 TO STA. 1307+20.00
BURNT STORE ROAD

SHEET NO.
108

STA. 1307+20.00

STA. 1314+20.00

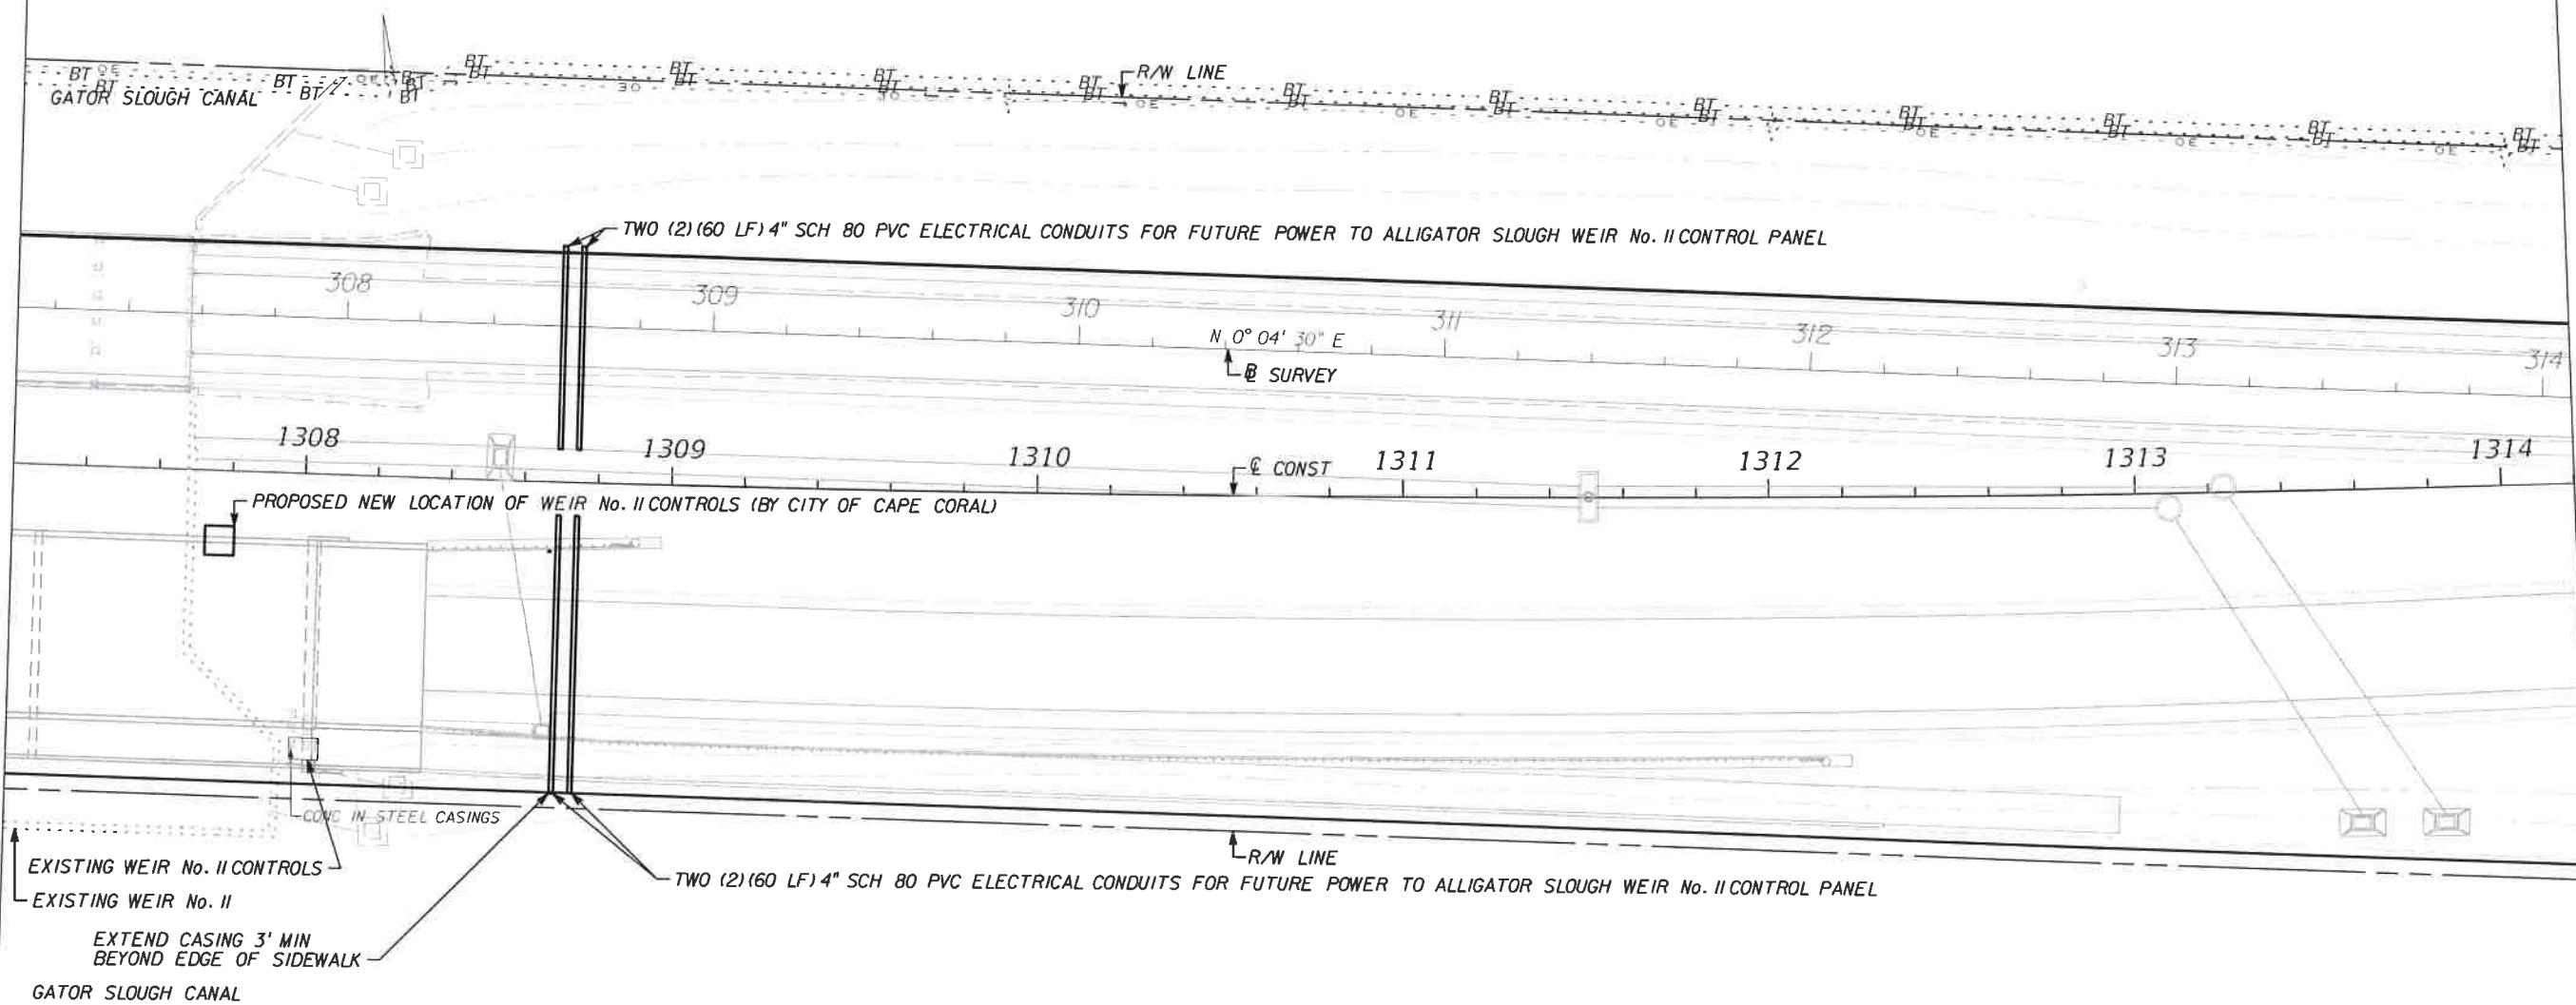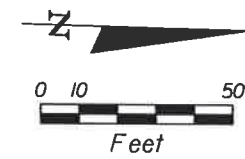

MATCH LINE

MATCH LINE

NO.	DATE	BY	REVISIONS	DESCRIPTION

T.Y. LIN INTERNATIONAL
 2400 FIRST STREET
 SUITE 200
 FORT MYERS, FLORIDA 33901
 TEL. (239) 332-4846
 FAX. (239) 332-4798
 WWW.TYLIN.COM




PUBLIC WORKS
LEE COUNTY
 DEPARTMENT
 of
TRANSPORTATION
 SOUTHWEST
 FLORIDA
 1500 MONROE STREET
 FORT MYERS, FLORIDA 33901
 (239) 479-8900 www.lee-county.com/publicworks/dot/le.htm

UTILITY ADJUSTMENT SHEET
STA. 1307+20.00 TO STA. 1314+20.00
BURNT STORE ROAD


SHEET NO.
 109

STA. 1314+20.00

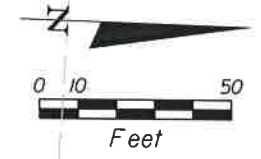

CASING HORIZONTAL SEPARATION SHALL BE 5'-0" OUTSIDE EDGE TO OUTSIDE EDGE (TYP)

KISMET PARKWAY

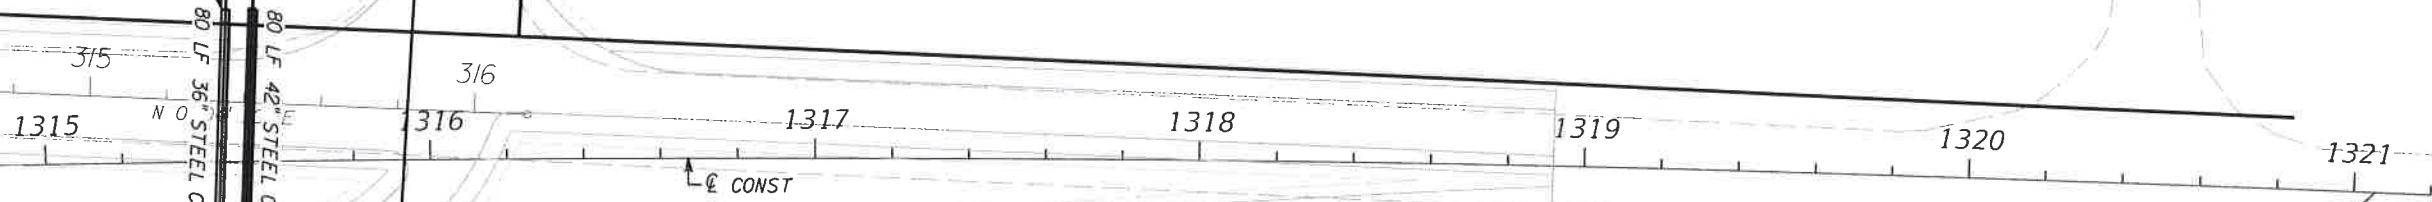

EXTEND CASING 10' MIN BEYOND EDGE UNPAVED SHOULDER (TYP)

END PROJECT STA. 1321+05.43

MATCH LINE

R/W LINE



NO.	DATE	BY	REVISIONS - DESCRIPTION

T.Y. LIN INTERNATIONAL
 2400 FIRST STREET
 SUITE 200
 FORT MYERS, FLORIDA 33901
 TEL. (239) 332-4846
 FAX. (239) 332-4798
 WWW.TYLIN.COM

FLORIDA PROFESSIONAL ENGINEER
 JAMES W. MOLNAR
 LICENSE No. 49237
 3-5-2015

PUBLIC WORKS
LEE COUNTY
SOUTHWEST
FLORIDA
 1500 MINROE STREET
 FORT MYERS, FLORIDA 33901
 (239) 479-8900 www.lee-county.com/publicworks/default.htm




DEPARTMENT
of
TRANSPORTATION

UTILITY ADJUSTMENT SHEET
STA. 1314+20.00 TO STA. 1321+19.86
BURNT STORE ROAD

SHEET NO.
 110

MATCH LINE

SEE SHEET 154

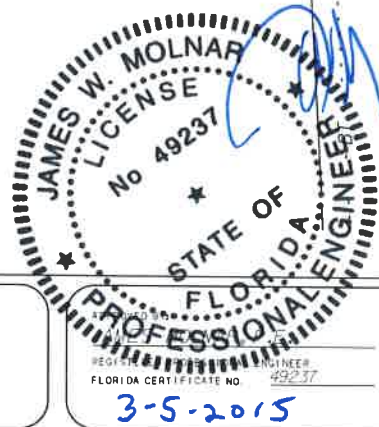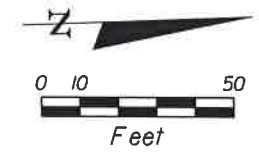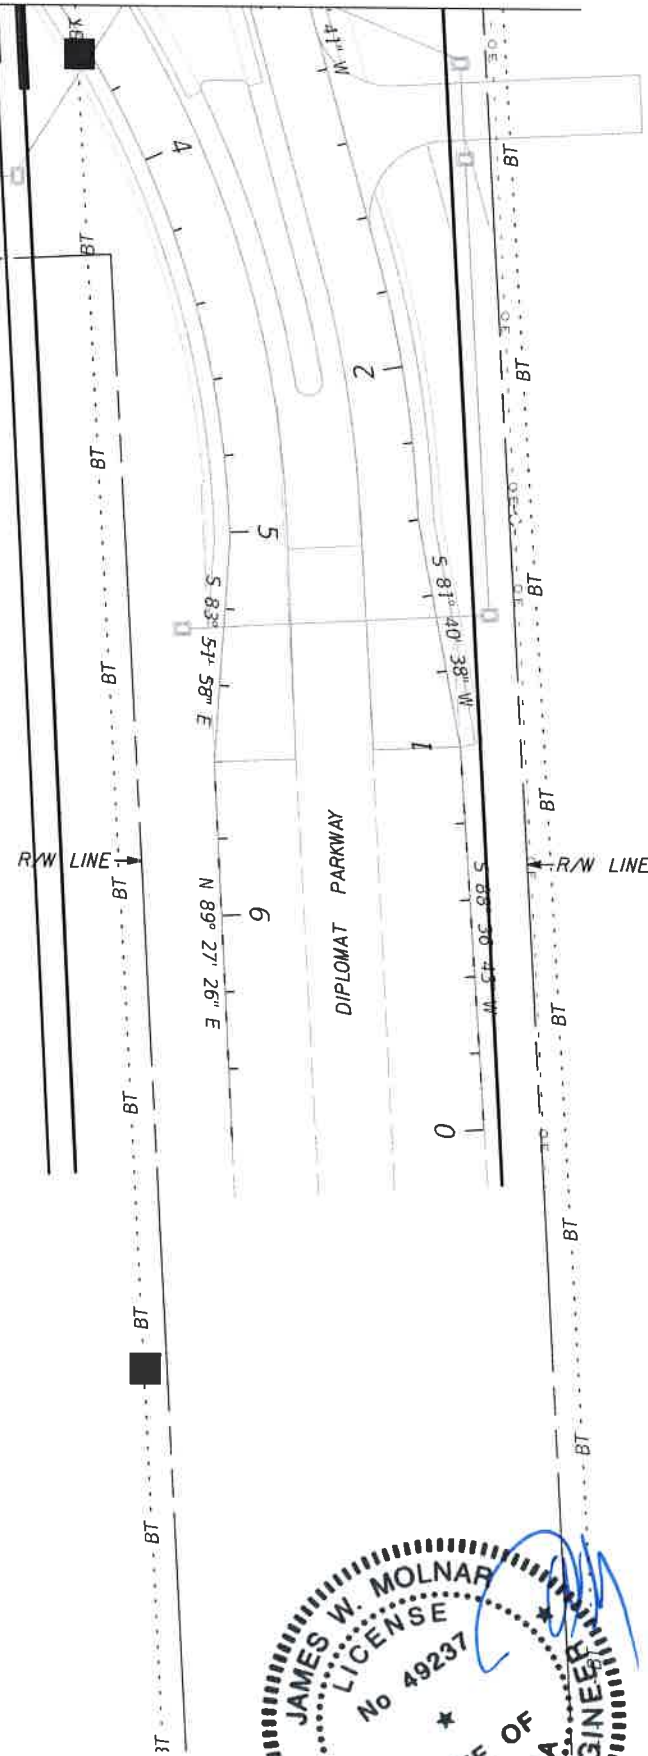

NO.	DATE	BY	REVISIONS - DESCRIPTION

T.Y. LIN INTERNATIONAL
 2400 FIRST STREET
 SUITE 200
 FORT MYERS, FLORIDA 33901
 TEL. (239) 332-4846
 FAX. (239) 332-4798
 WWW.TYLIN.COM

PUBLIC WORKS
LEE COUNTY
SOUTHWEST
FLORIDA
 1500 MINROE STREET
 FORT MYERS, FLORIDA 33901
 (239) 479-8900
 www.lee-county.com/publicworks/utilities.htm



DEPARTMENT
of
TRANSPORTATION

UTILITY ADJUSTMENT SHEET
DIPLOMAT PARKWAY
BURNT STORE ROAD

SHEET NO.
 III

MATCH LINE

SEE SHEET 104

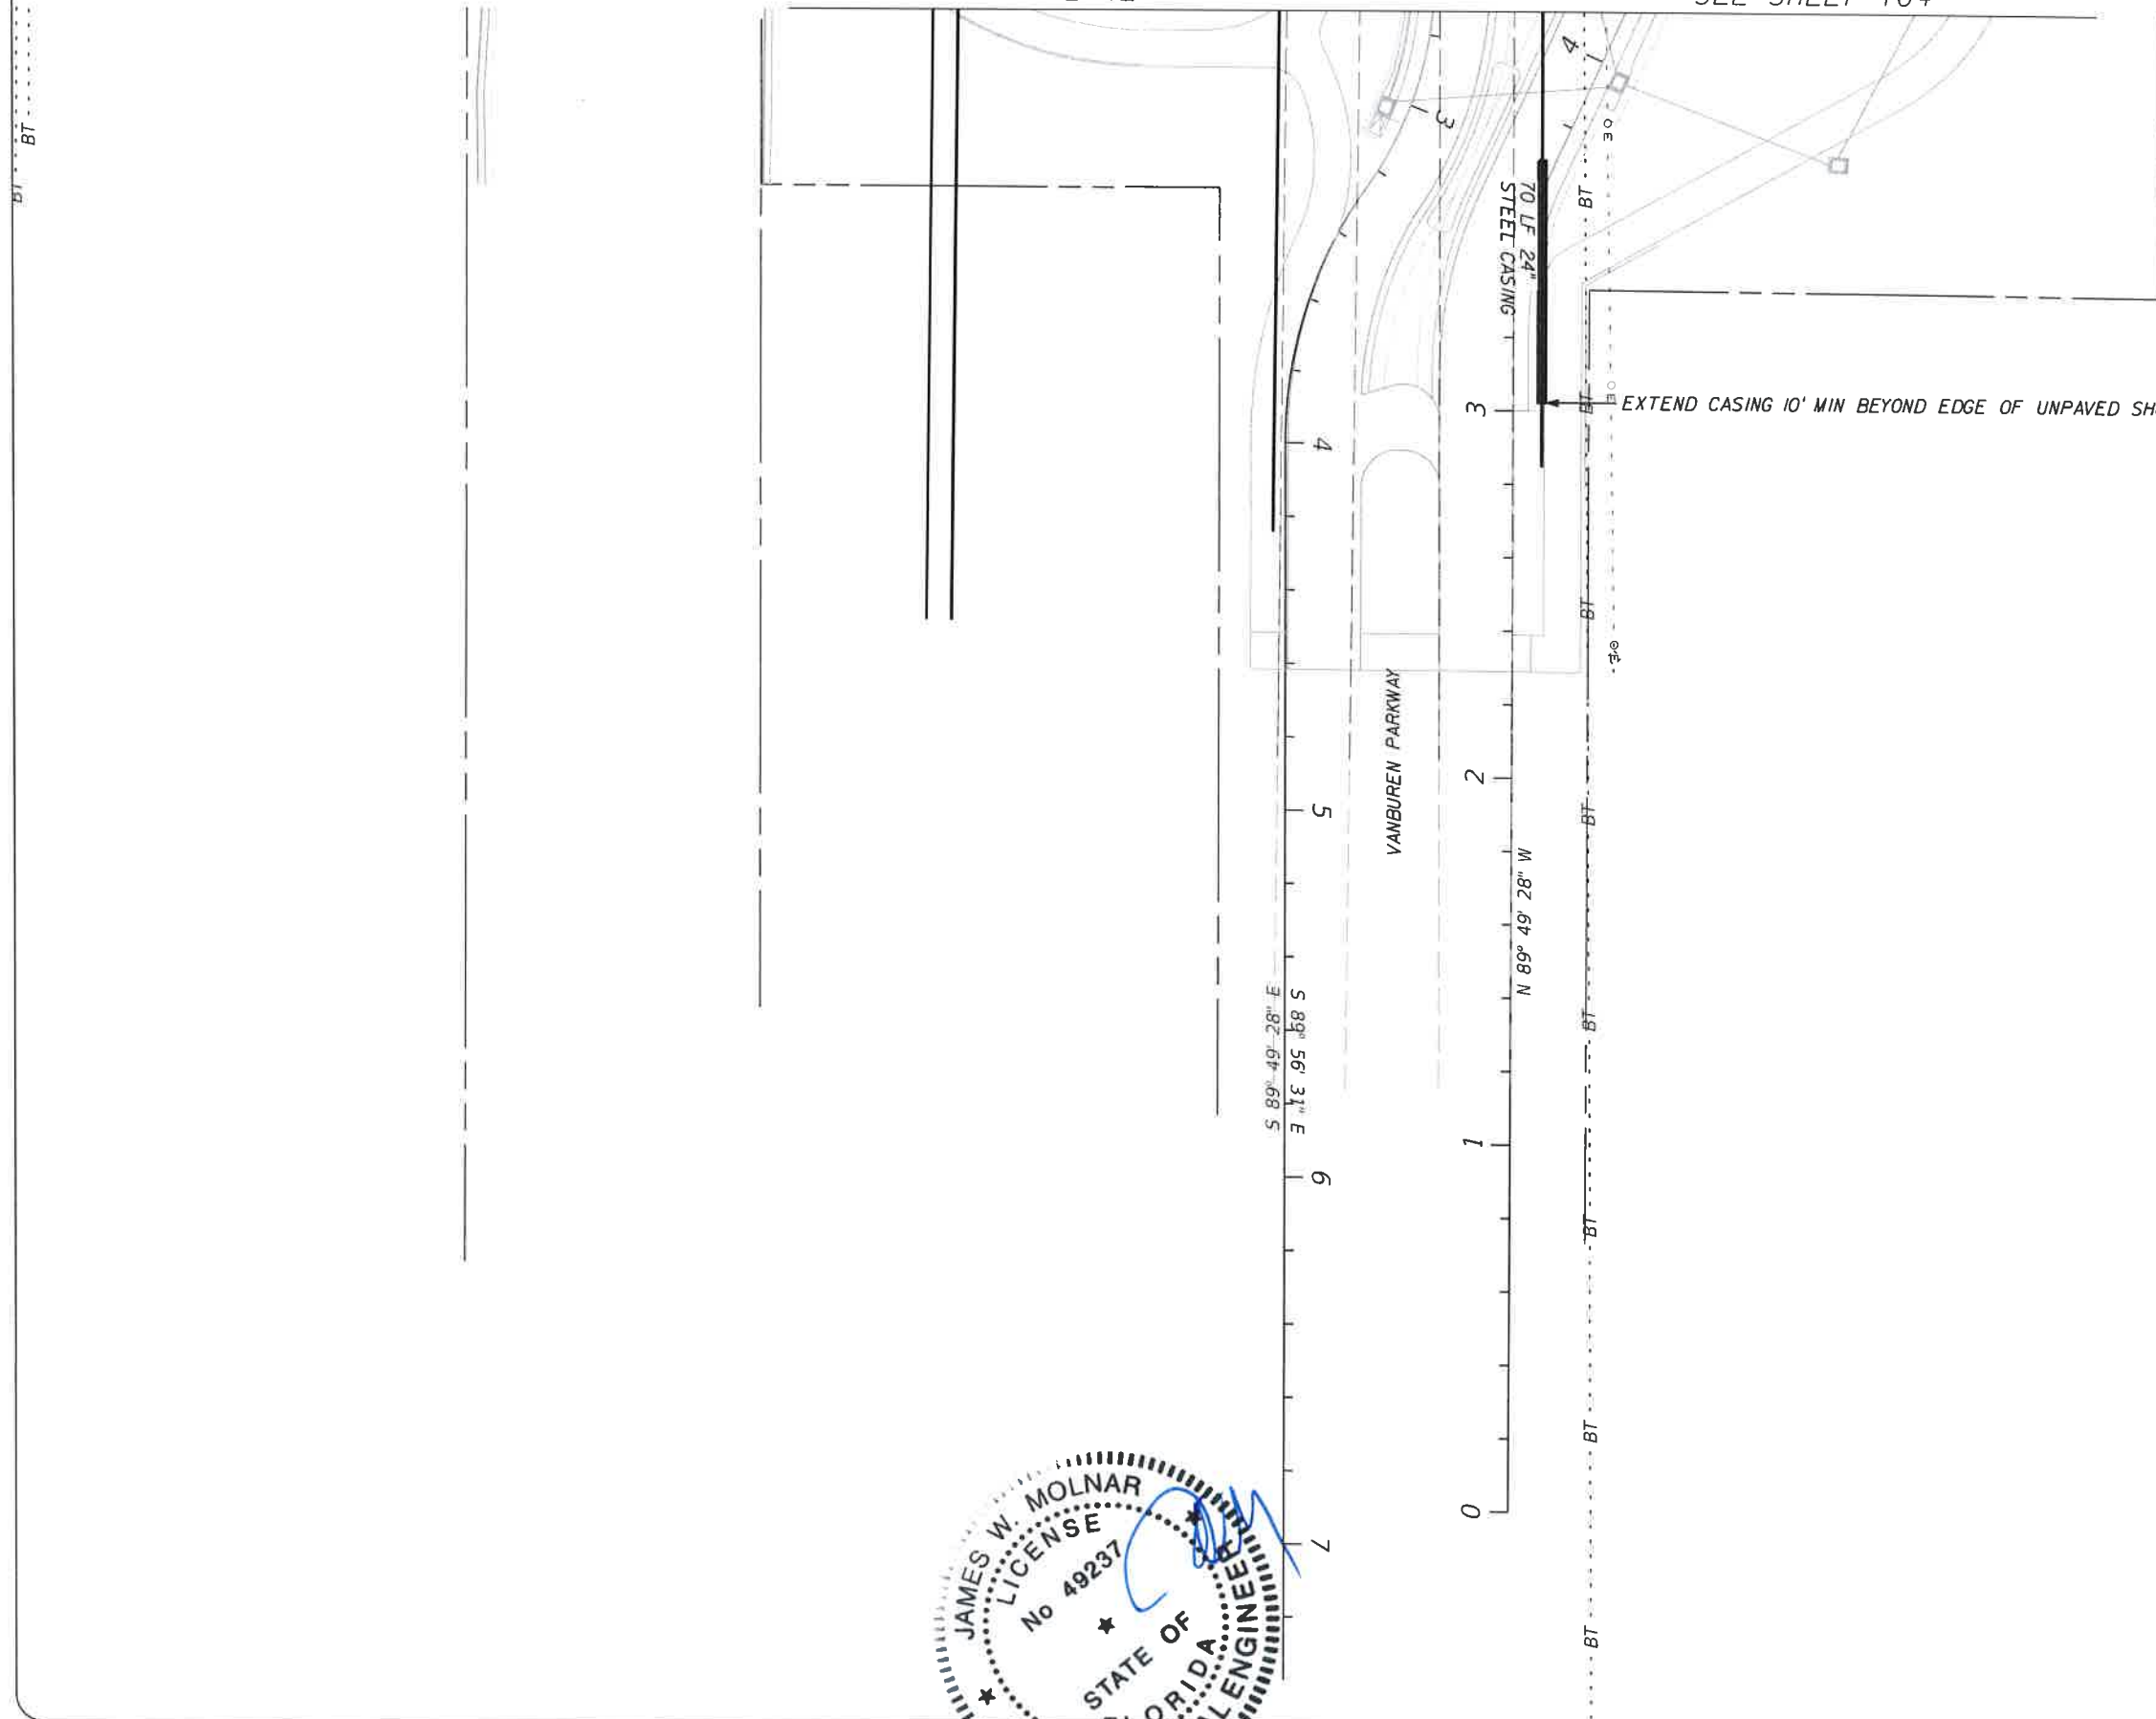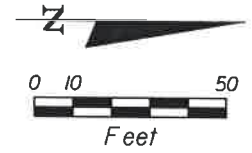

EXTEND CASING 10' MIN BEYOND EDGE OF UNPAVED SHOULDER (TYP)

VANBUREN PARKWAY

70 LF 24" STEEL CASING

S 89° 49' 28" E 58' 31" E

N 89° 49' 28" W



NO.	DATE	BY	REVISIONS - DESCRIPTION


T.Y. LIN INTERNATIONAL
 2400 FIRST STREET
 SUITE 200
 FORT MYERS, FLORIDA 33901
 TEL. (239) 332-4846
 FAX. (239) 332-4798
 WWW.TYLIN.COM

JAMES W. MOLNAR, P.E.
 REGISTERED PROFESSIONAL ENGINEER
 FLORIDA CERTIFICATE NO. 49237
 3-35-2015




PUBLIC WORKS
LEE COUNTY
 DEPARTMENT of TRANSPORTATION
 SOUTHWEST FLORIDA
 1500 MONROE STREET FORT MYERS, FLORIDA 33901
 12391 479-8900 www.lee-county.com/publicworks/dot/le.htm

UTILITY ADJUSTMENT SHEET
VANBUREN PARKWAY
BURNT STORE ROAD

SHEET NO.
 112

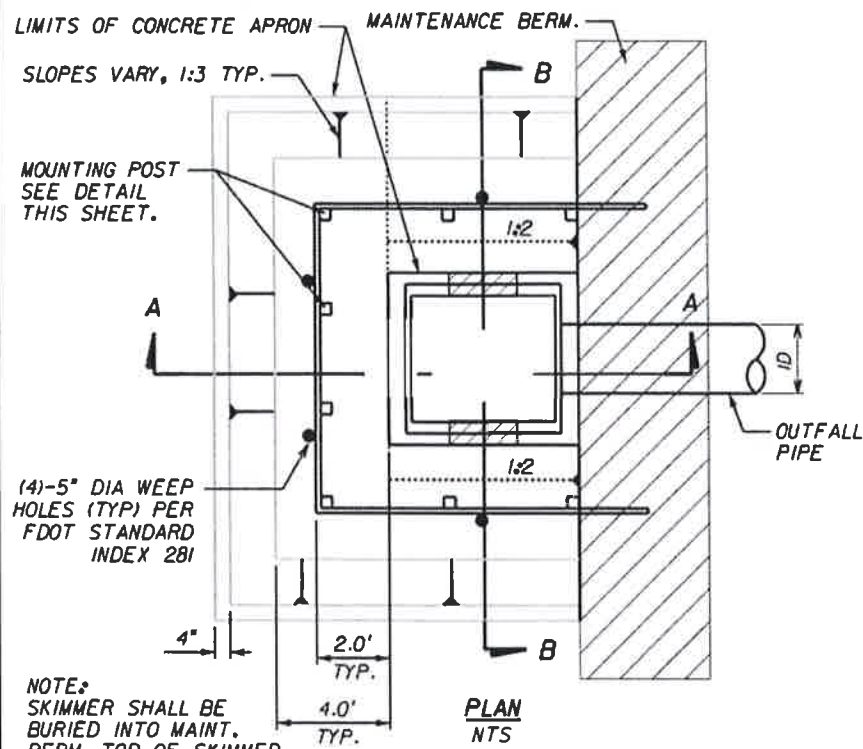


NOTE: SKIMMER SHALL BE BURIED INTO MAINT. BERM. TOP OF SKIMMER SHALL MATCH TOP OF BERM ELEVATION.

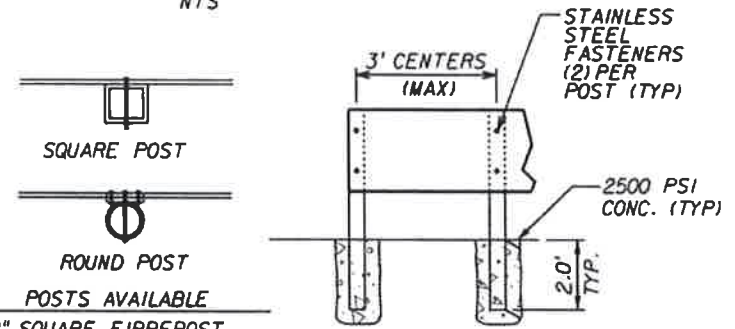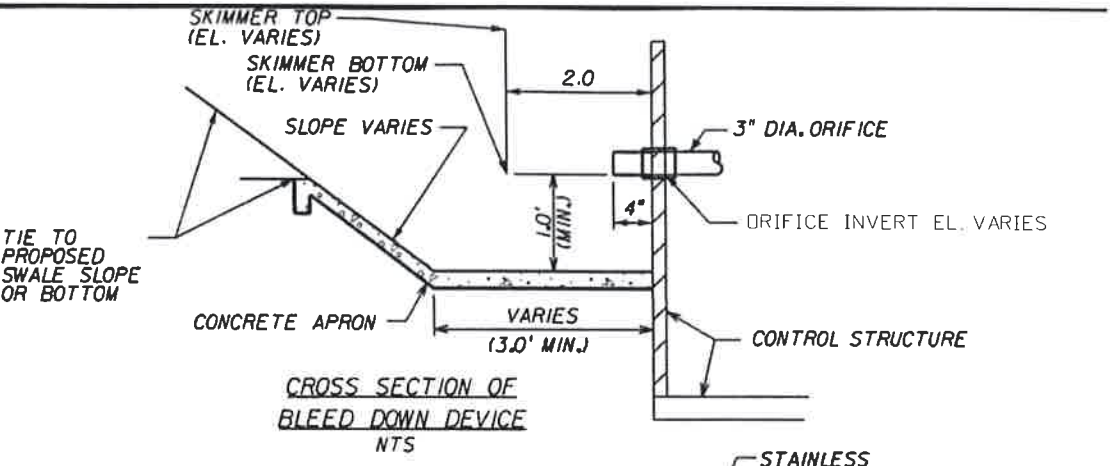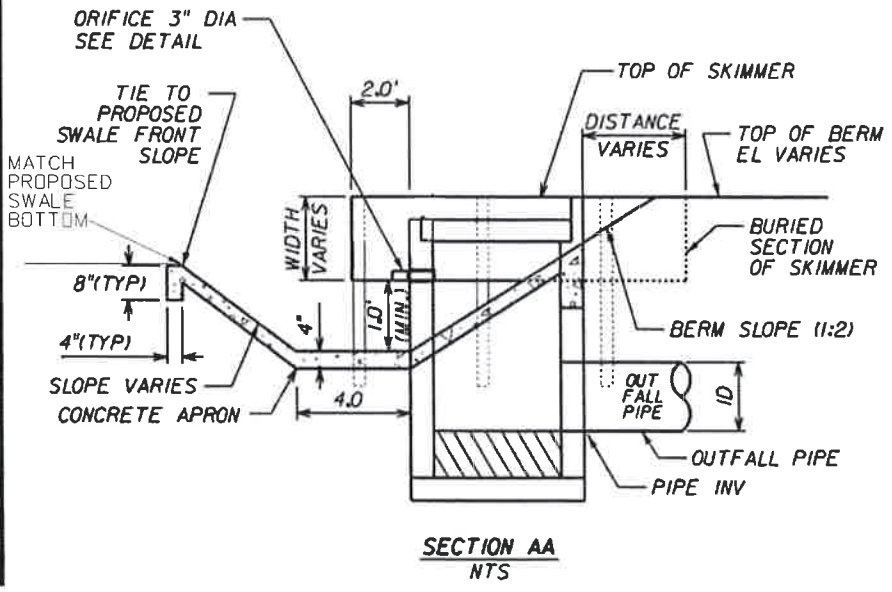

2" SQUARE FIBREPOST
3" SQUARE FIBREPOST
3" ROUND ALUMN. SCHED. 40
6" ROUND ALUMN. SCHED. 40

NOTE: BOLTS SHALL BE INSTALLED WITH HEADS ON OUTSIDE OF STRUCTURE AND OUTSIDE OF POSTS.

POST MOUNTED DETAIL FOR FIBERGLASS SKIMMER NTS

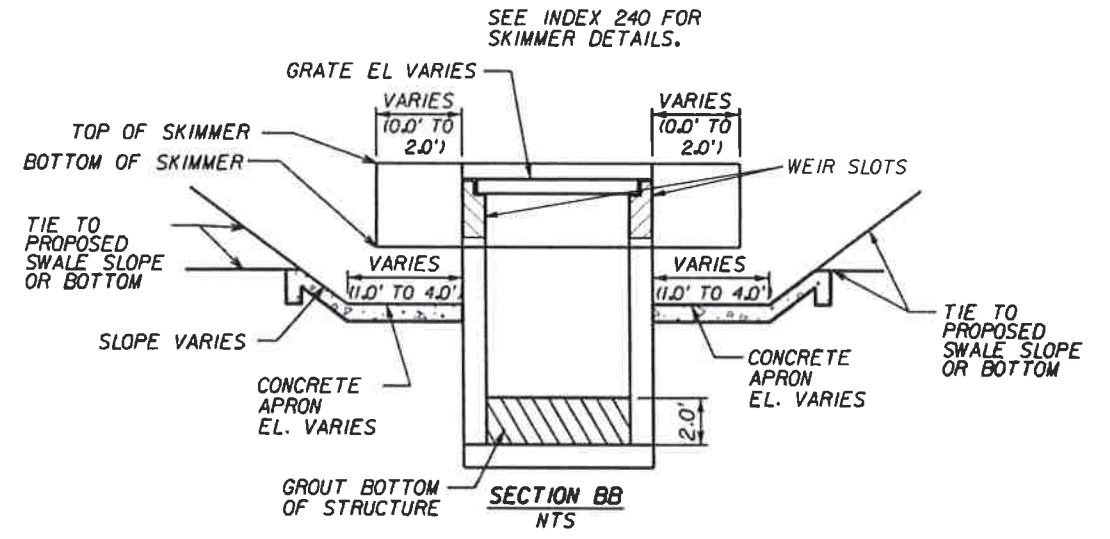


NOTES:

1. OUTFALL PIPE SHALL BE CONSTRUCTED IN THE LONG SIDE (4'-5") OF THE TYPE D INLET FOR ALL STRUCTURES.
2. SEE STANDARD INDEX 200, 201, 231 AND 281 FOR ADDITIONAL DETAILS.

DRY DETENTION STRUCTURES

Basin #	WSWT	Structure	Station	Offset	Top of Swale El.	Swale Bottom El.	Conc. Apron Bottom El. Ft.	Grate El. Ft.	Weir Invert Ft.	Weir Width in.	Orifice Invert El. Ft.	Orifice Dia. in.	Skimmer		Outfall Pipe			DHW 25-yr. - 72 hr. Ft.
													Top El. Ft.	Bottom El. Ft.	Pipe Size (ID) In.	Length Ft.	U/S Invert	
10	3.3	S-352	1298+97.11	102.81	7.0	4.3	2.3	6.50	5.5	16	6.50	3.30	42		0.00	0.00	6.3	
11	3.3	S-351	1299+00.94	-37.83	7.0	4.3	2.3	6.50	5.3	24	6.50	3.30	48		0.00	0.00	6.3	

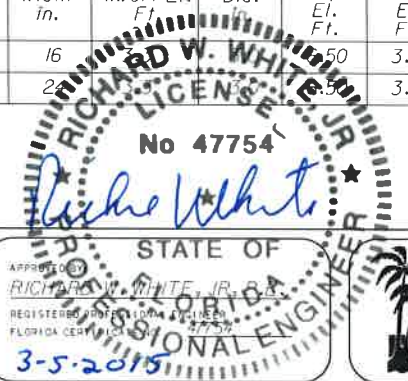

No.	DATE	BY	REVISIONS - DESCRIPTION




T.Y. LIN INTERNATIONAL
2400 FIRST STREET
SUITE 200
FORT MYERS, FLORIDA 33901
TEL. (239) 332-4846
FAX. (239) 332-4798
WWW.TYLIN.COM

APPROVED
RICHARD W. WHITE, JR., B.S.
REGISTERED PROFESSIONAL ENGINEER
FLORIDA CERT. NO. 47754
3-5-2015

PUBLIC WORKS
LEE COUNTY
SOUTHWEST
FLORIDA
1500 MONROE STREET
FORT MYERS, FLORIDA 33901
12391 479-8900 www.lee-county.com/publicworks/dsd/le.htm
3/4/2015 5:25:54 PM

DRAINAGE DETAILS
CONTROL STRUCTURES W/BLEEDERS
BURNT STORE ROAD

SHEET NO.
113

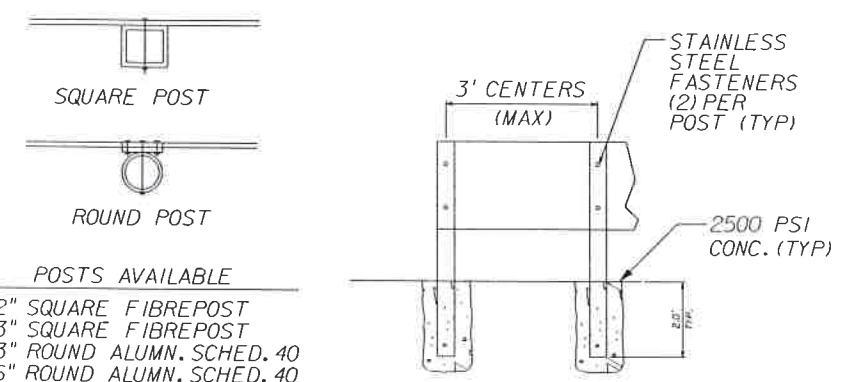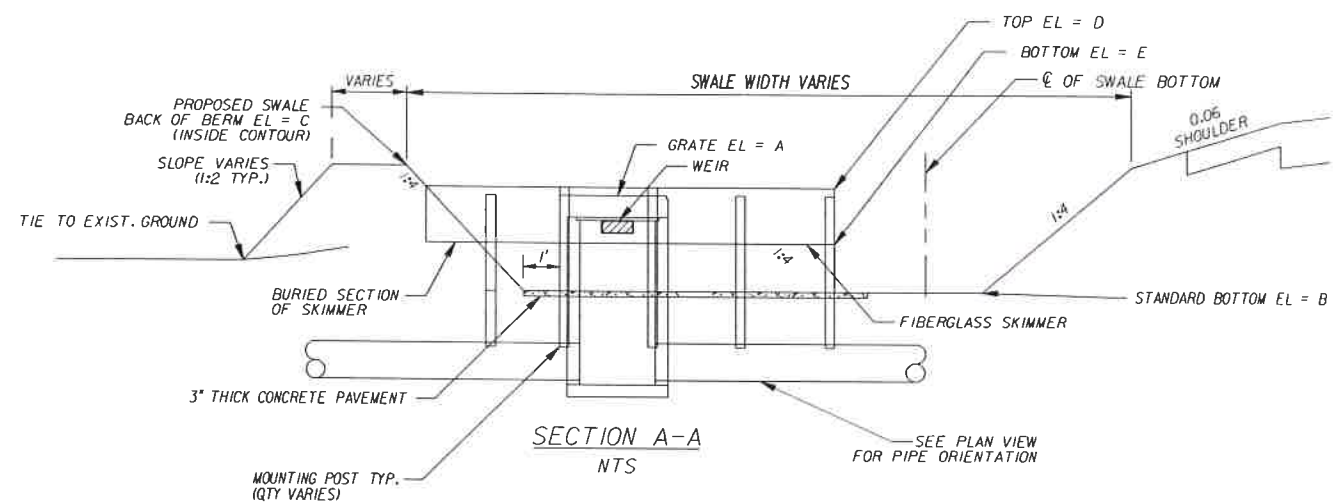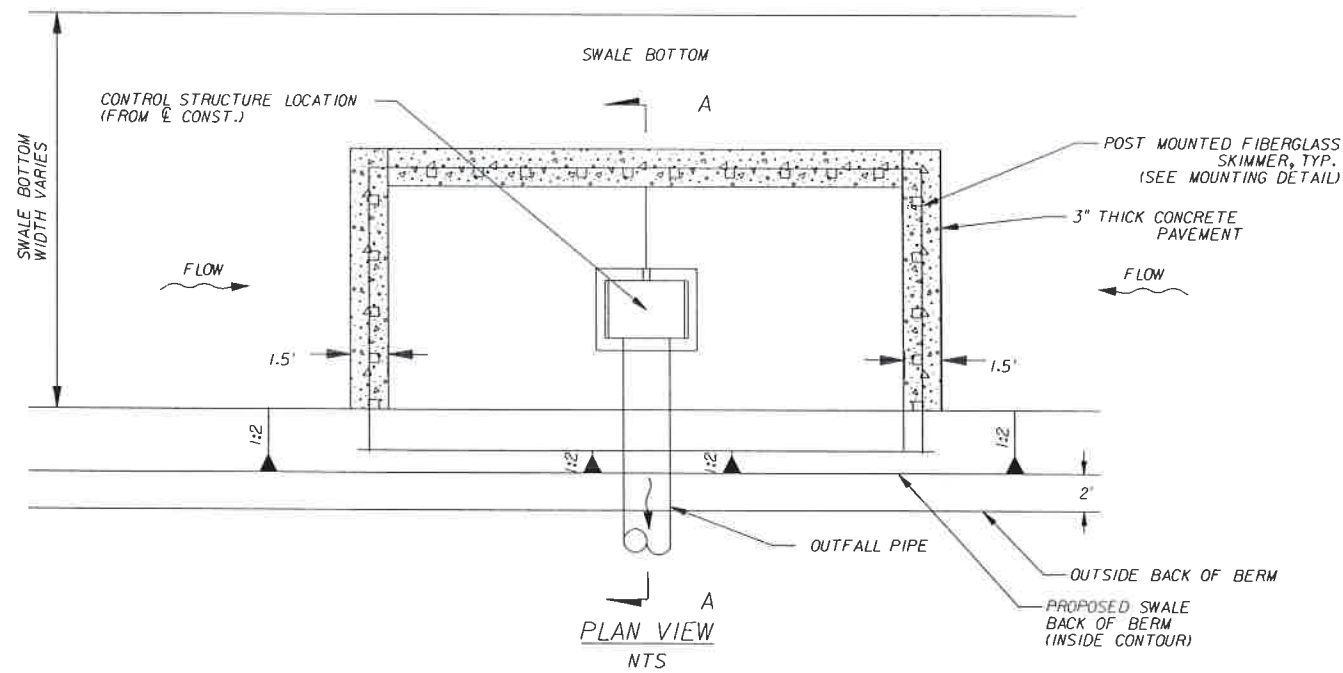

NOTES: 1. BOLTS SHALL BE INSTALLED WITH HEADS ON OUTSIDE OF STRUCTURE AND OUTSIDE OF POSTS.
2. SEE INDEX 240 FOR SKIMMER DETAILS.

POST MOUNTED DETAIL FOR FIBERGLASS SKIMMER
NTS

DRY RETENTION STRUCTURES

STRUCTURE ID NO.	BASIN #	WSWT (FT)	STATION	OFFSET	FDOT INLET TYPE	WEIR COUNT	WEIR SPAN (IN)	WEIR HEIGHT (IN)	WEIR CREST EL (FT)	GRATE ELEV. (FT)	25YR./3DAY DHW EL (FT)	BASIN BOTTOM (FT)	MIN. PERIMETER BERM (FT)	SKIMMER (FT)	
														TOP EL (J)	BOTTOM EL (K)
S-312	6	3.0	1239+36.96	161.35	E	2	20	15.60	4.80	6.10	5.92	4	6.5	6.10	4.80
S-311	7	3.0	1238+93.95	-91.88	D	2	17	16.80	4.80	6.20	5.94	4	6.5	6.20	4.80
S-332	8	3.2	1278+80.00	103+21	D	2	15	16.80	5.20	6.50	6.33	4.5	6.5	6.50	5.10
S-331	9	3.2	12780+80.00	-91.54	D	2	16	15.00	4.95	6.20	6.12	4.3	6.5	6.20	4.95



NO.	DATE	BY	REVISIONS	DESCRIPTION

T.Y. LIN INTERNATIONAL
2400 FIRST STREET
SUITE 200
FORT MYERS, FLORIDA 33901
TEL. (239) 332-4846
FAX. (239) 332-4798
WWW.TYLIN.COM

STATE OF FLORIDA
RICHARD W. WHITE, JR., P.E.
REGISTERED PROFESSIONAL ENGINEER
FLORIDA CERT. NO. 47754
3-5-2015

PUBLIC WORKS
LEE COUNTY
SOUTHWEST
FLORIDA
1500 MONROE STREET
FORT MYERS, FLORIDA 33901
12391 479-8900 www.lee-county.com/publicworks/dot/le.htm
Dwerter 3/5/2015 10:49:07 AM

DRAINAGE DETAILS
CONTROL STRUCTURES
BURNT STORE ROAD



SHEET NO.
114
Default

STA. 1216+20.00

STA. 1223+20.00

HERMOSA CANAL

HERMOSA CANAL

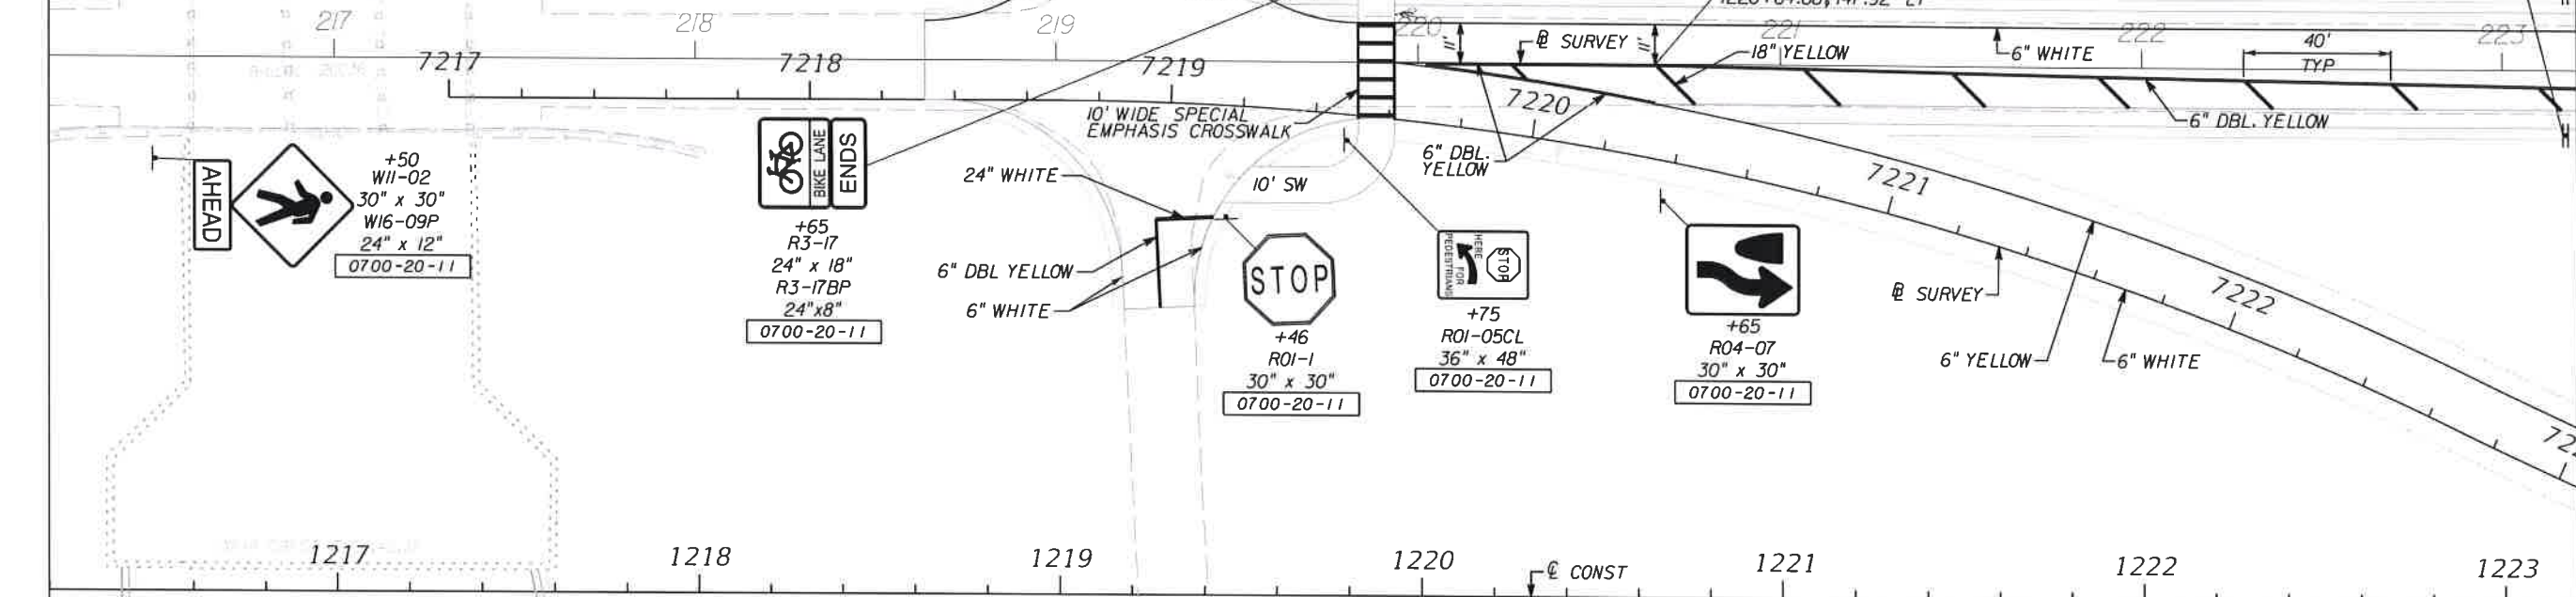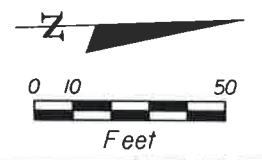

MATCH LINE

MATCH LINE

NO.	DATE	BY	REVISIONS - DESCRIPTION

T.Y. LIN INTERNATIONAL
 2400 FIRST STREET
 SUITE 200
 FORT MYERS, FLORIDA 33901
 TEL. (239) 332-4846
 FAX. (239) 332-4798
 WWW.TY.LIN.COM

JAMES W. MOLNAR
 LICENSE No 49237
 PROFESSIONAL ENGINEER
 STATE OF FLORIDA
 APPROVED BY: [Signature] P.E.
 DATE: 3/4/2015

PUBLIC WORKS
LEE COUNTY
 DEPARTMENT of TRANSPORTATION
 1500 MONROE STREET
 FORT MYERS, FLORIDA 33901
 (239) 479-8900 www.lee-county.com/publicworks/dot/le.htm

SIGNING & MARKING PLAN SHEET
STA. 1216+20.00 TO STA. 1223+20.00
BURNT STORE ROAD

SHEET NO.
 S-1
 Default


T:\Tampa\Legacy\Project\581595.00_Burnt_Store_RD\Burnt_Store\signing\plans\B.dgn 4:31:43 PM 3/4/2015

STA. 1223+20.00


STA. 1230+20.00

MATCH LINE

MATCH LINE

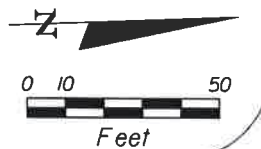


+58
W06-02
30" x 30"
0700-20-11

 

+82
R01-1
30" x 30"
0700-20-11



 
+96
R06-1L
36" x 12"
0700-20-11




+0
R2-1
30" x 36"
0700-20-11



 
+0
R2-1
30" x 36"
0700-20-11




+00
W04-02R
36" x 36"
0700-20-11

 


+56
W04-03L
36" x 36"
0700-20-11

 

+00
W04-03L
36" x 36"
0700-20-11

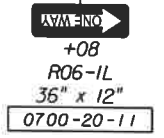

+08
R06-1L
36" x 12"
0700-20-11

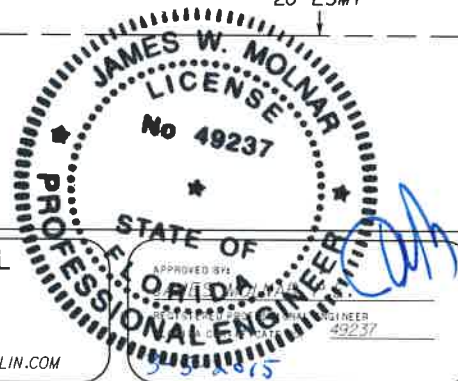

T.Y. LIN INTERNATIONAL
2400 FIRST STREET
SUITE 200
FORT MYERS, FLORIDA 33901
TEL. (239) 332-4846
FAX. (239) 332-4798
WWW.TYLIN.COM

PUBLIC WORKS
LEE COUNTY
SOUTHWEST
FLORIDA
1500 WENROE STREET
FORT MYERS, FLORIDA 33901
12391 478-8900 www.lee-county.com/publicworks/dot/lie.htm

DEPARTMENT
of
TRANSPORTATION



SIGNING & MARKING PLAN SHEET
STA. 1223+20.00 TO STA. 1230+20.00
BURNT STORE ROAD

SHEET NO.
S-2
Default

NO.	DATE	BY	REVISIONS - DESCRIPTION

STA. 1230+20.00

STA. 1237+20.00

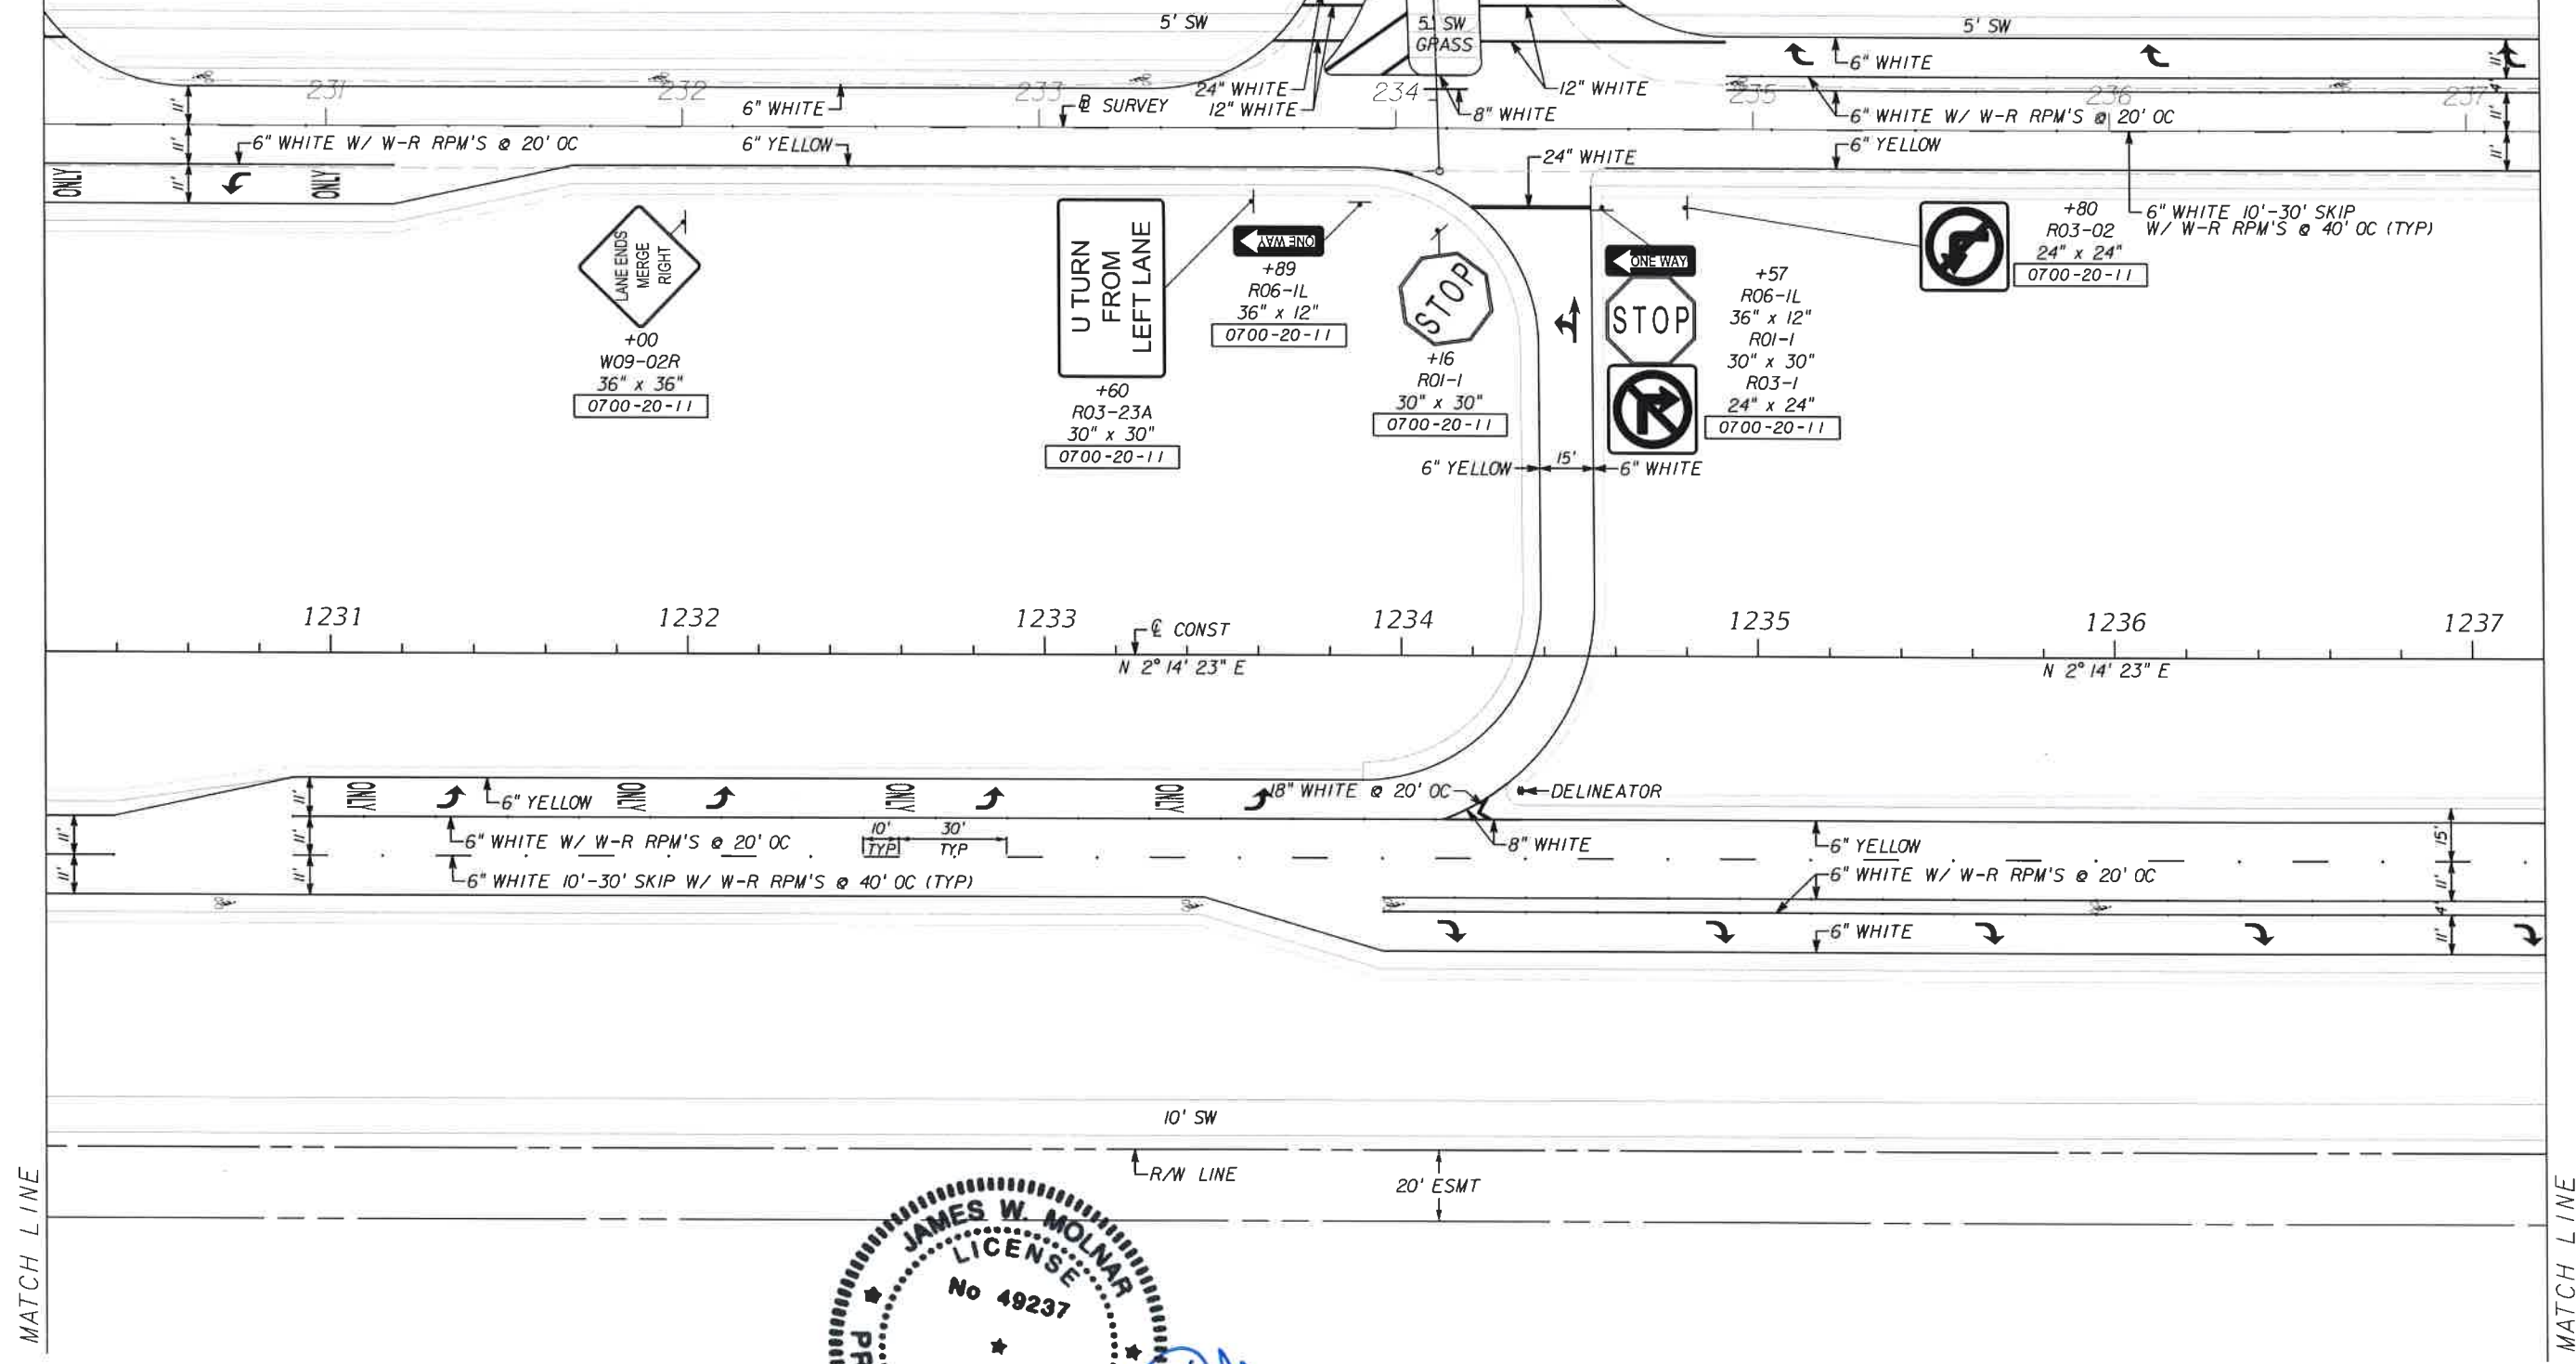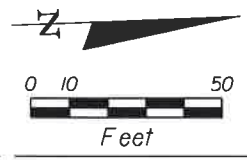

NO.	DATE	BY	REVISIONS - DESCRIPTION

T.Y. LIN INTERNATIONAL
 2400 FIRST STREET
 SUITE 200
 FORT MYERS, FLORIDA 33901
 TEL. (239) 332-4846
 FAX. (239) 332-4798
 WWW.TYLIN.COM

JAMES W. MOLNAR
 LICENSE
 No 49237
 PROFESSIONAL ENGINEER
 STATE OF FLORIDA
 3-5-2015



PUBLIC WORKS
LEE COUNTY
SOUTHWEST
FLORIDA
 1500 MINNIE STREET
 FORT MYERS, FLORIDA 33901
 12391 479-9999 www.lee-county.com/publicworks/default.htm

SIGNING & MARKING PLAN SHEET
STA. 1230+20.00 TO STA. 1237+20.00
BURNT STORE ROAD

SHEET NO.
S-3

STA. 1237+20.00

STA. 1244+20.00

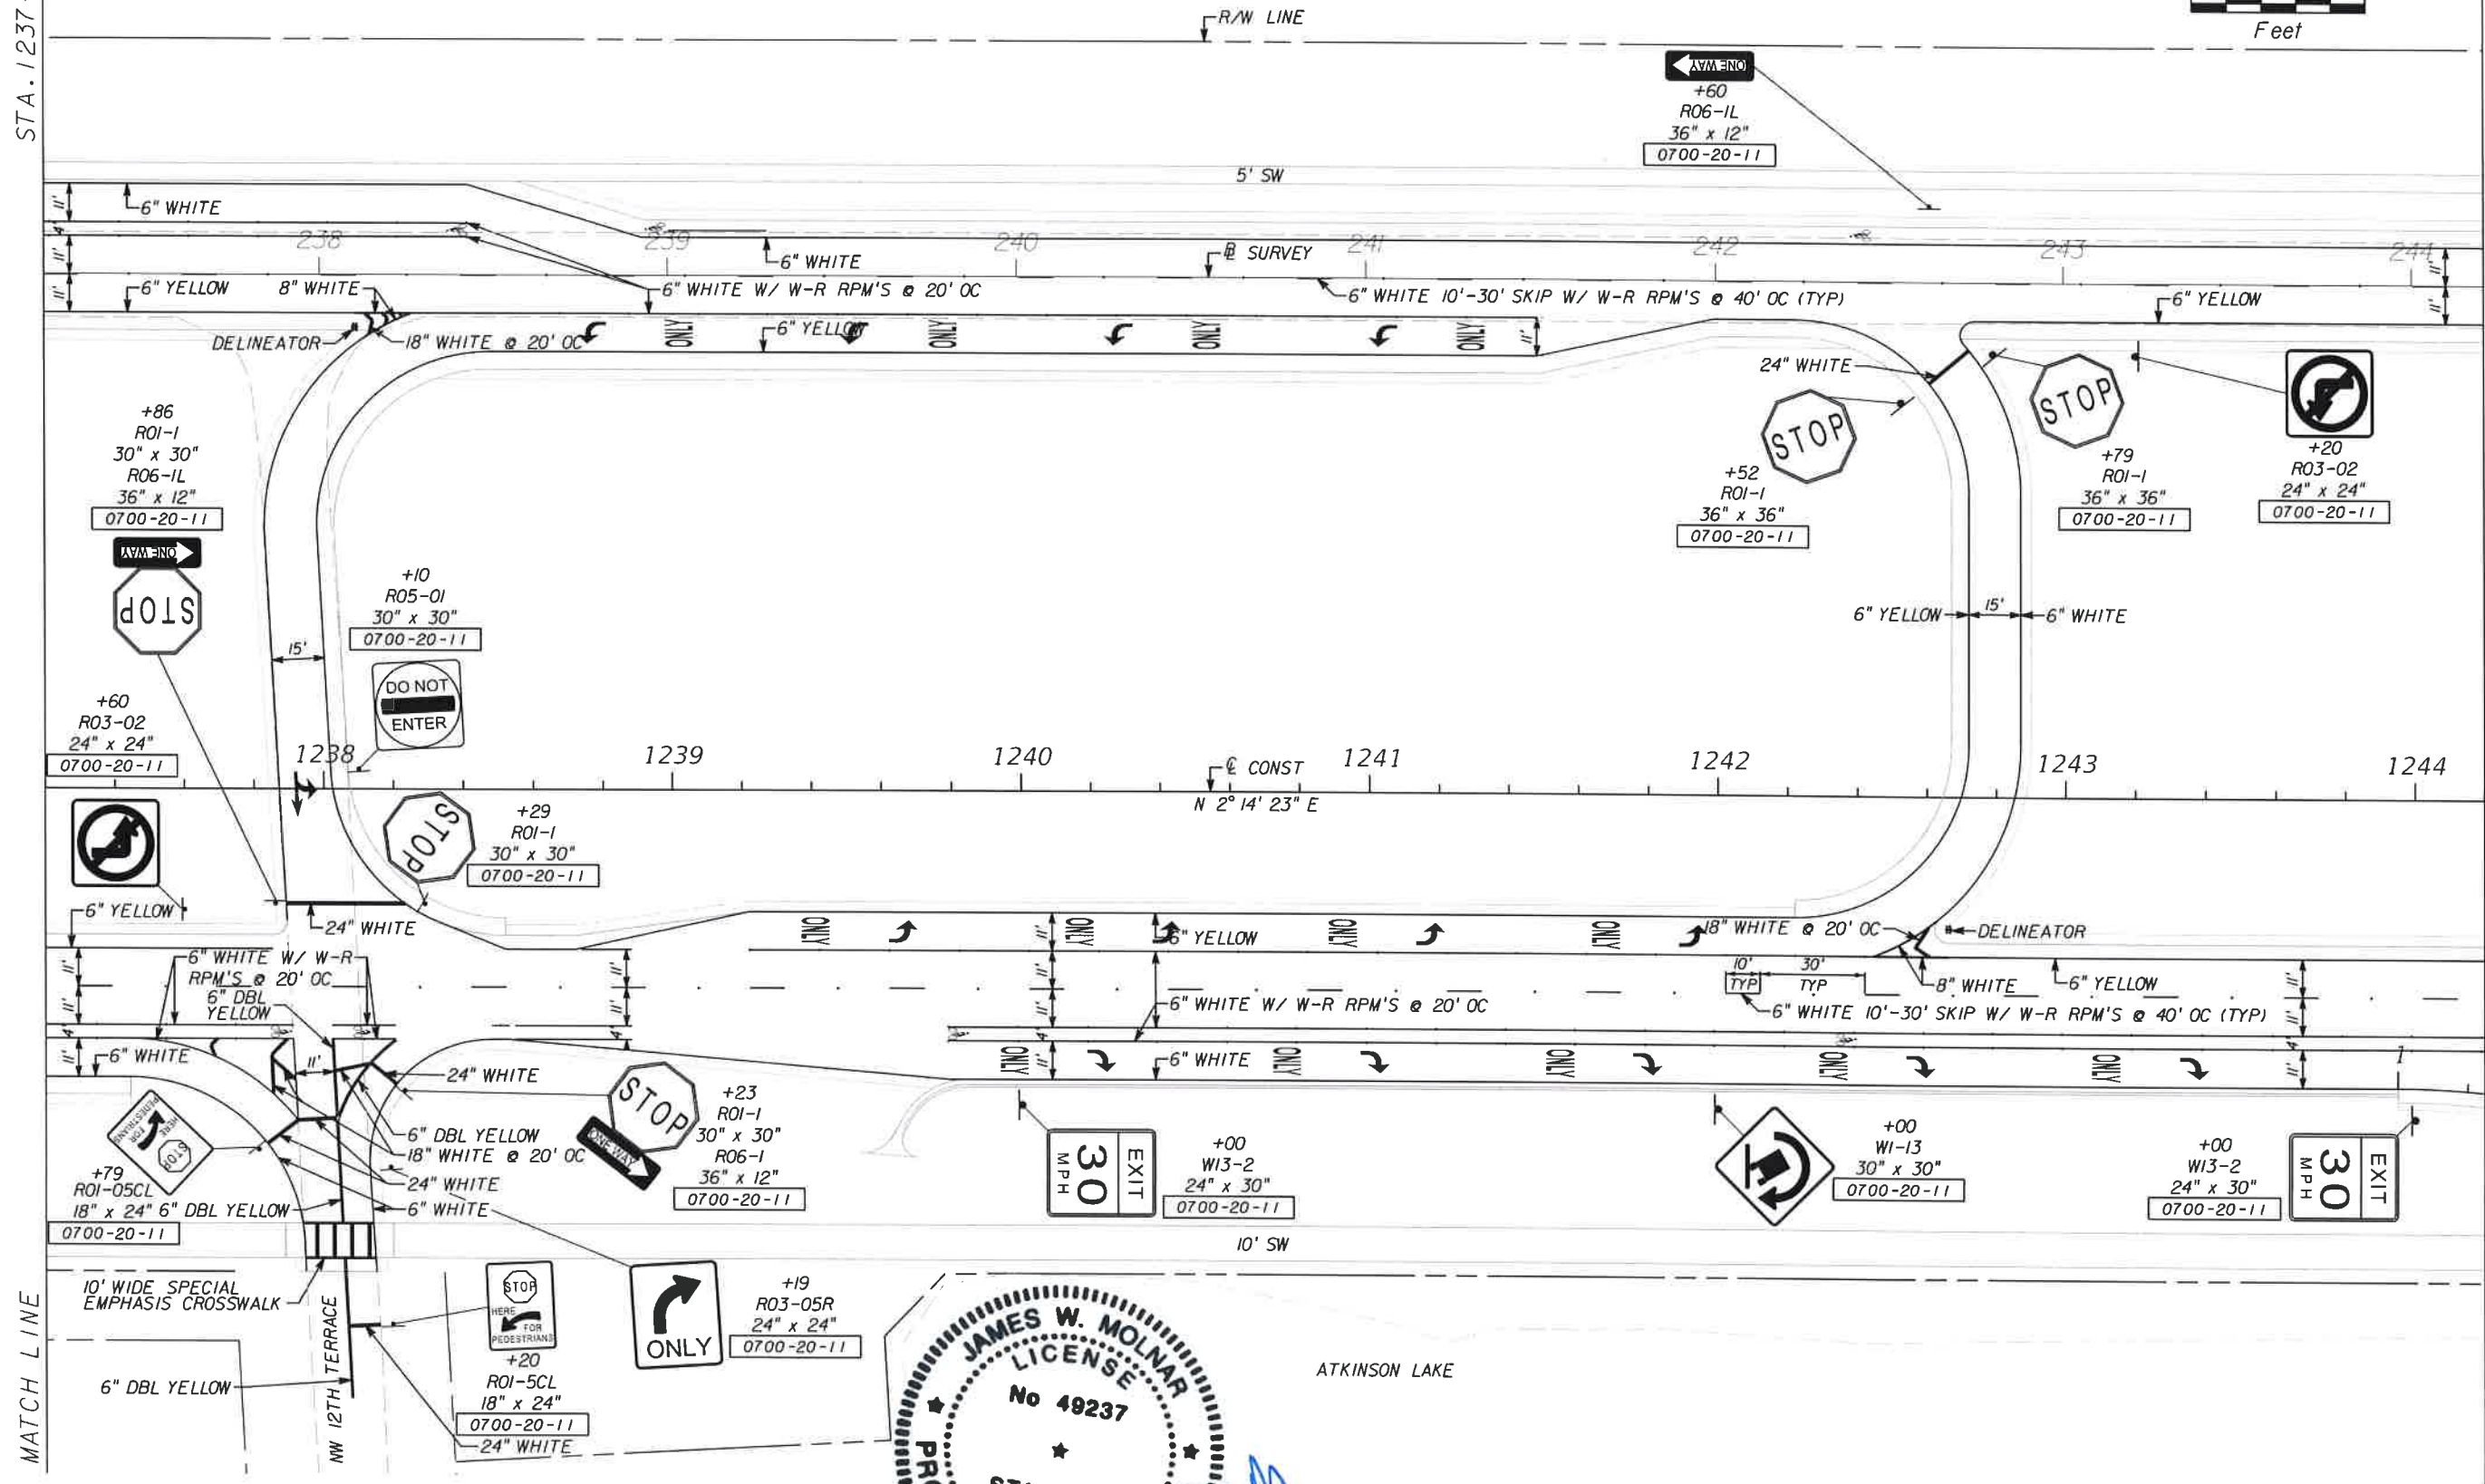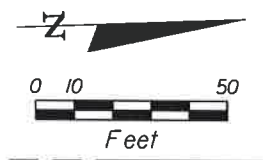

MATCH LINE

MATCH LINE

NO.	DATE	BY	REVISIONS - DESCRIPTION

T.Y. LIN INTERNATIONAL
 2400 FIRST STREET
 SUITE 200
 FORT MYERS, FLORIDA 33901
 TEL. (239) 332-4846
 FAX. (239) 332-4798
 WWW.TYLIN.COM



PUBLIC WORKS
 LEE COUNTY
 SOUTHWEST
 FLORIDA
 1500 MONROE STREET
 12391 479-8900 www.lee-county.com/publicworks/dotitle.htm


DEPARTMENT
 of
 TRANSPORTATION
 FORT MYERS, FLORIDA 33901

SIGNING & MARKING PLAN SHEET
STA. 1237+20.00 TO STA. 1244+20.00
BURNT STORE ROAD

SHEET NO.
 S-4

STA. 1244+20.00

STA. 1251+20.00

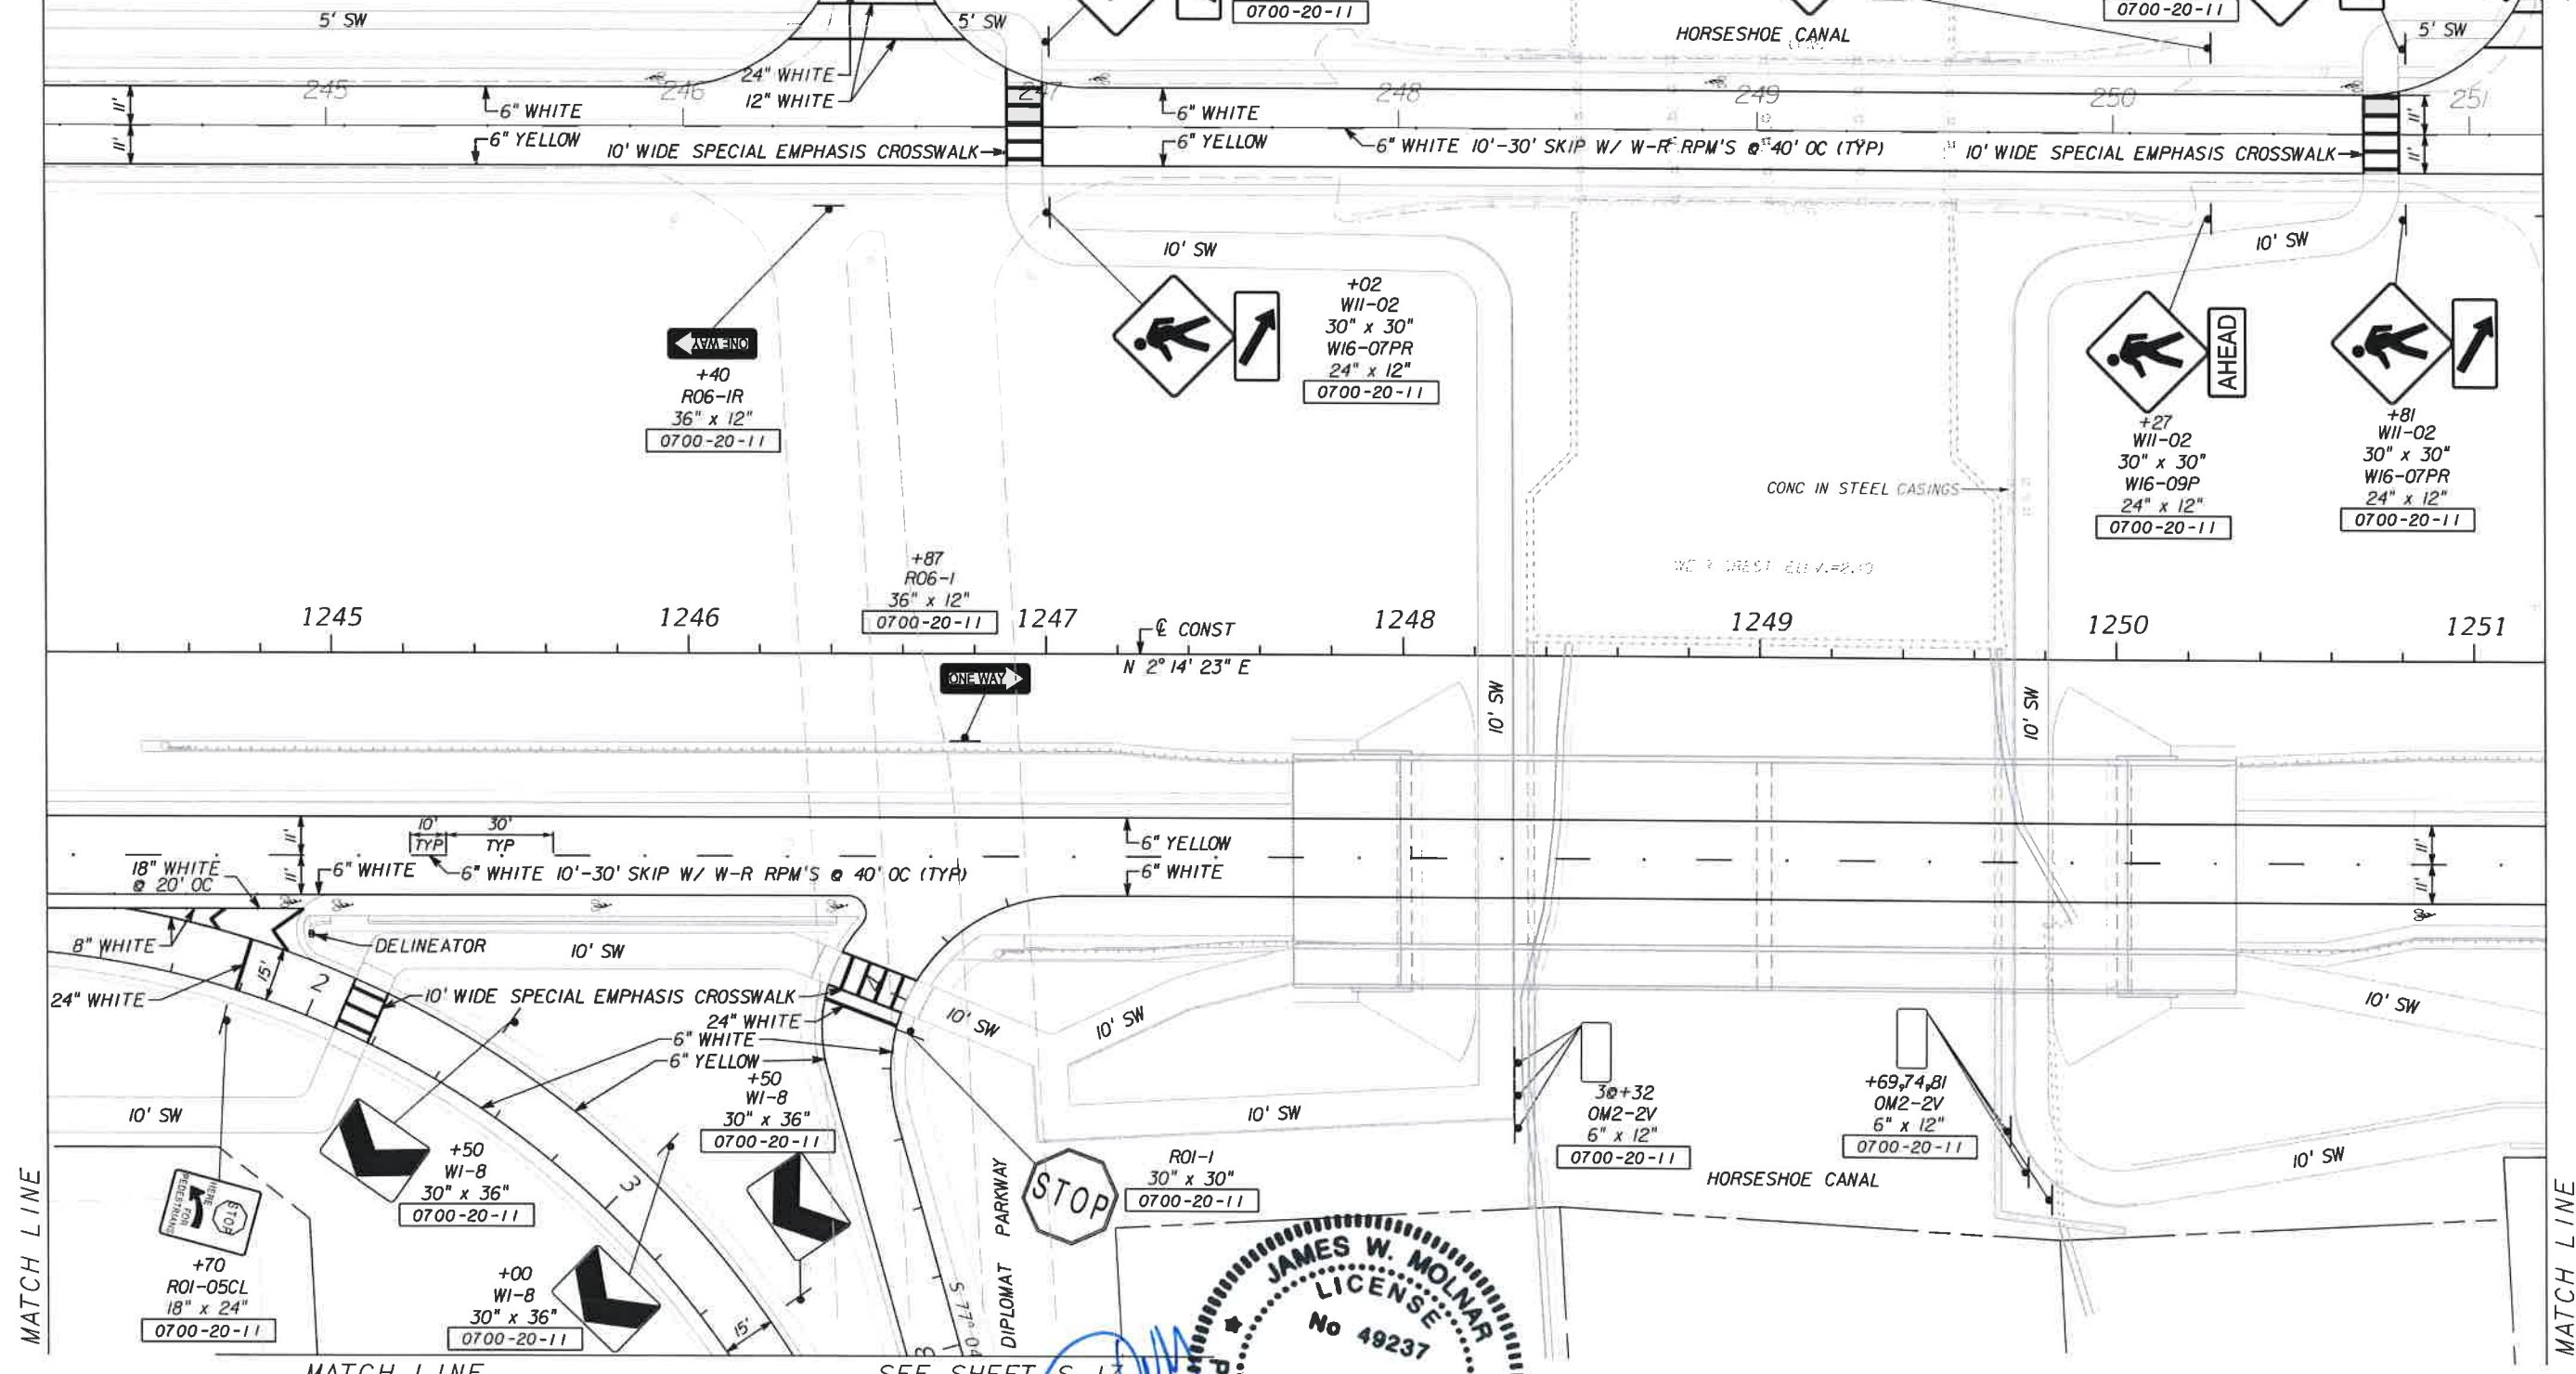

MATCH LINE

MATCH LINE


MATCH LINE

SEE SHEET S-17

NO.	DATE	BY	REVISIONS - DESCRIPTION

T.Y. LIN INTERNATIONAL
 2400 FIRST STREET
 SUITE 200
 FORT MYERS, FLORIDA 33901
 TEL. (239) 332-4846
 FAX. (239) 332-4798
 WWW.TY.LIN.COM

APPROVED BY:
JAMES W. MOLNAR, P.E.
 REGISTERED PROFESSIONAL ENGINEER
 FLORIDA CERTIFICATE NO. 49237
 3-5-2015

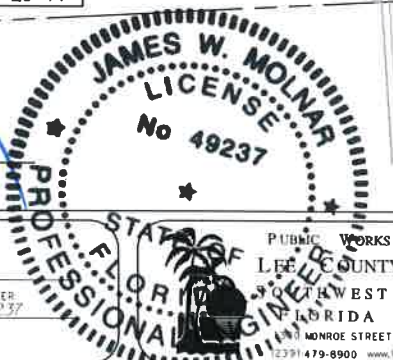

DEPARTMENT
 of
 TRANSPORTATION
 FORT MYERS, FLORIDA 33901

SIGNING & MARKING PLAN SHEET
STA. 1244+20.00 TO STA. 1251+20.00
BURNT STORE ROAD



SHEET
 NO.
 S-5

T:\Tango\Legacy\Proj\581595.00_Burnt_Store_RD\Burnt_Store\signing\plans\p22.dgn

Default

STA. 1251+20.00

STA. 1258+20.00

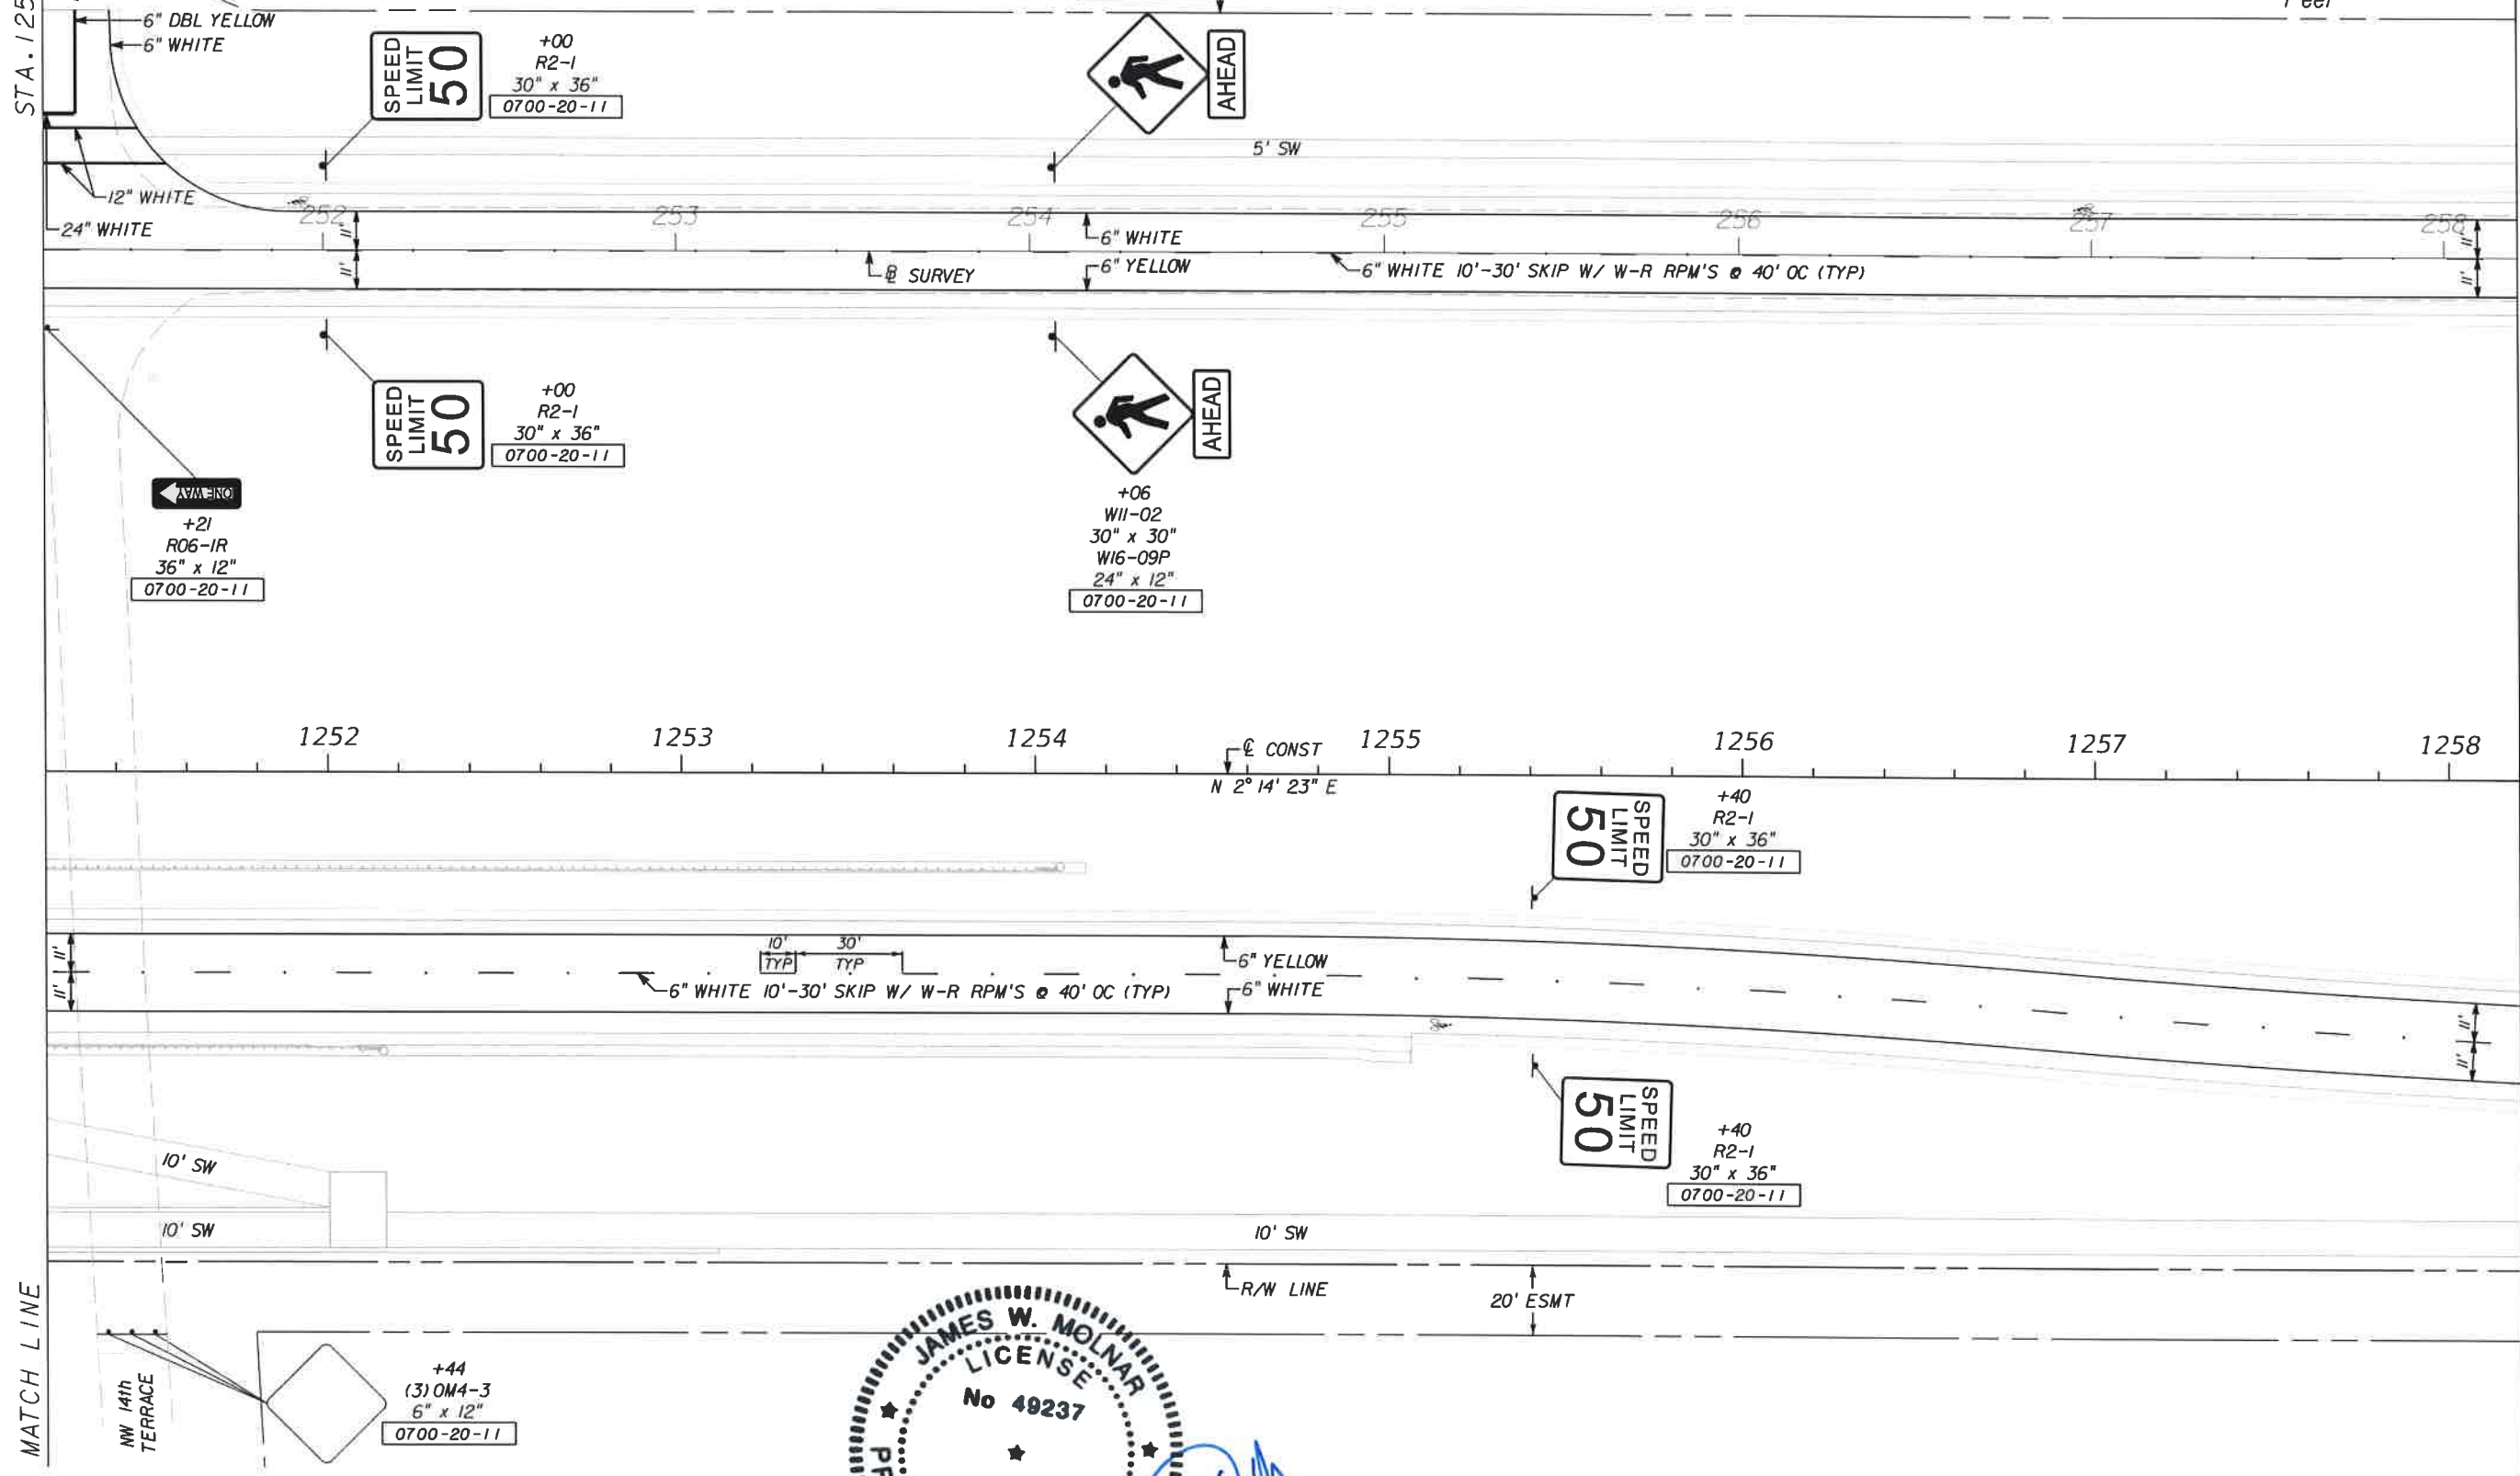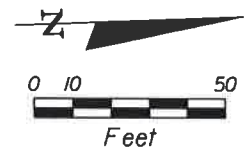

NO.	DATE	BY	REVISIONS - DESCRIPTION

T.Y. LIN INTERNATIONAL
 2400 FIRST STREET
 SUITE 200
 FORT MYERS, FLORIDA 33901
 TEL. (239) 332-4846
 FAX. (239) 332-4798
 WWW.TYLIN.COM

JAMES W. MOLNAR
 LICENSE
 No 49237
 STATE OF FLORIDA
 PROFESSIONAL ENGINEER
 3-5-2015



PUBLIC WORKS
 LEE COUNTY
 DEPARTMENT of TRANSPORTATION
 SOUTHWEST FLORIDA
 1500 MONROE STREET
 FORT MYERS, FLORIDA 33901
 12391 479-8900 www.lee-county.com/publicworks/default.htm

SIGNING & MARKING PLAN SHEET
 STA. 1251+20.00 TO STA. 1258+20.00
 BURNT STORE ROAD

SHEET NO.
 S-6

STA. 1258+20.00

STA. 1265+20.00

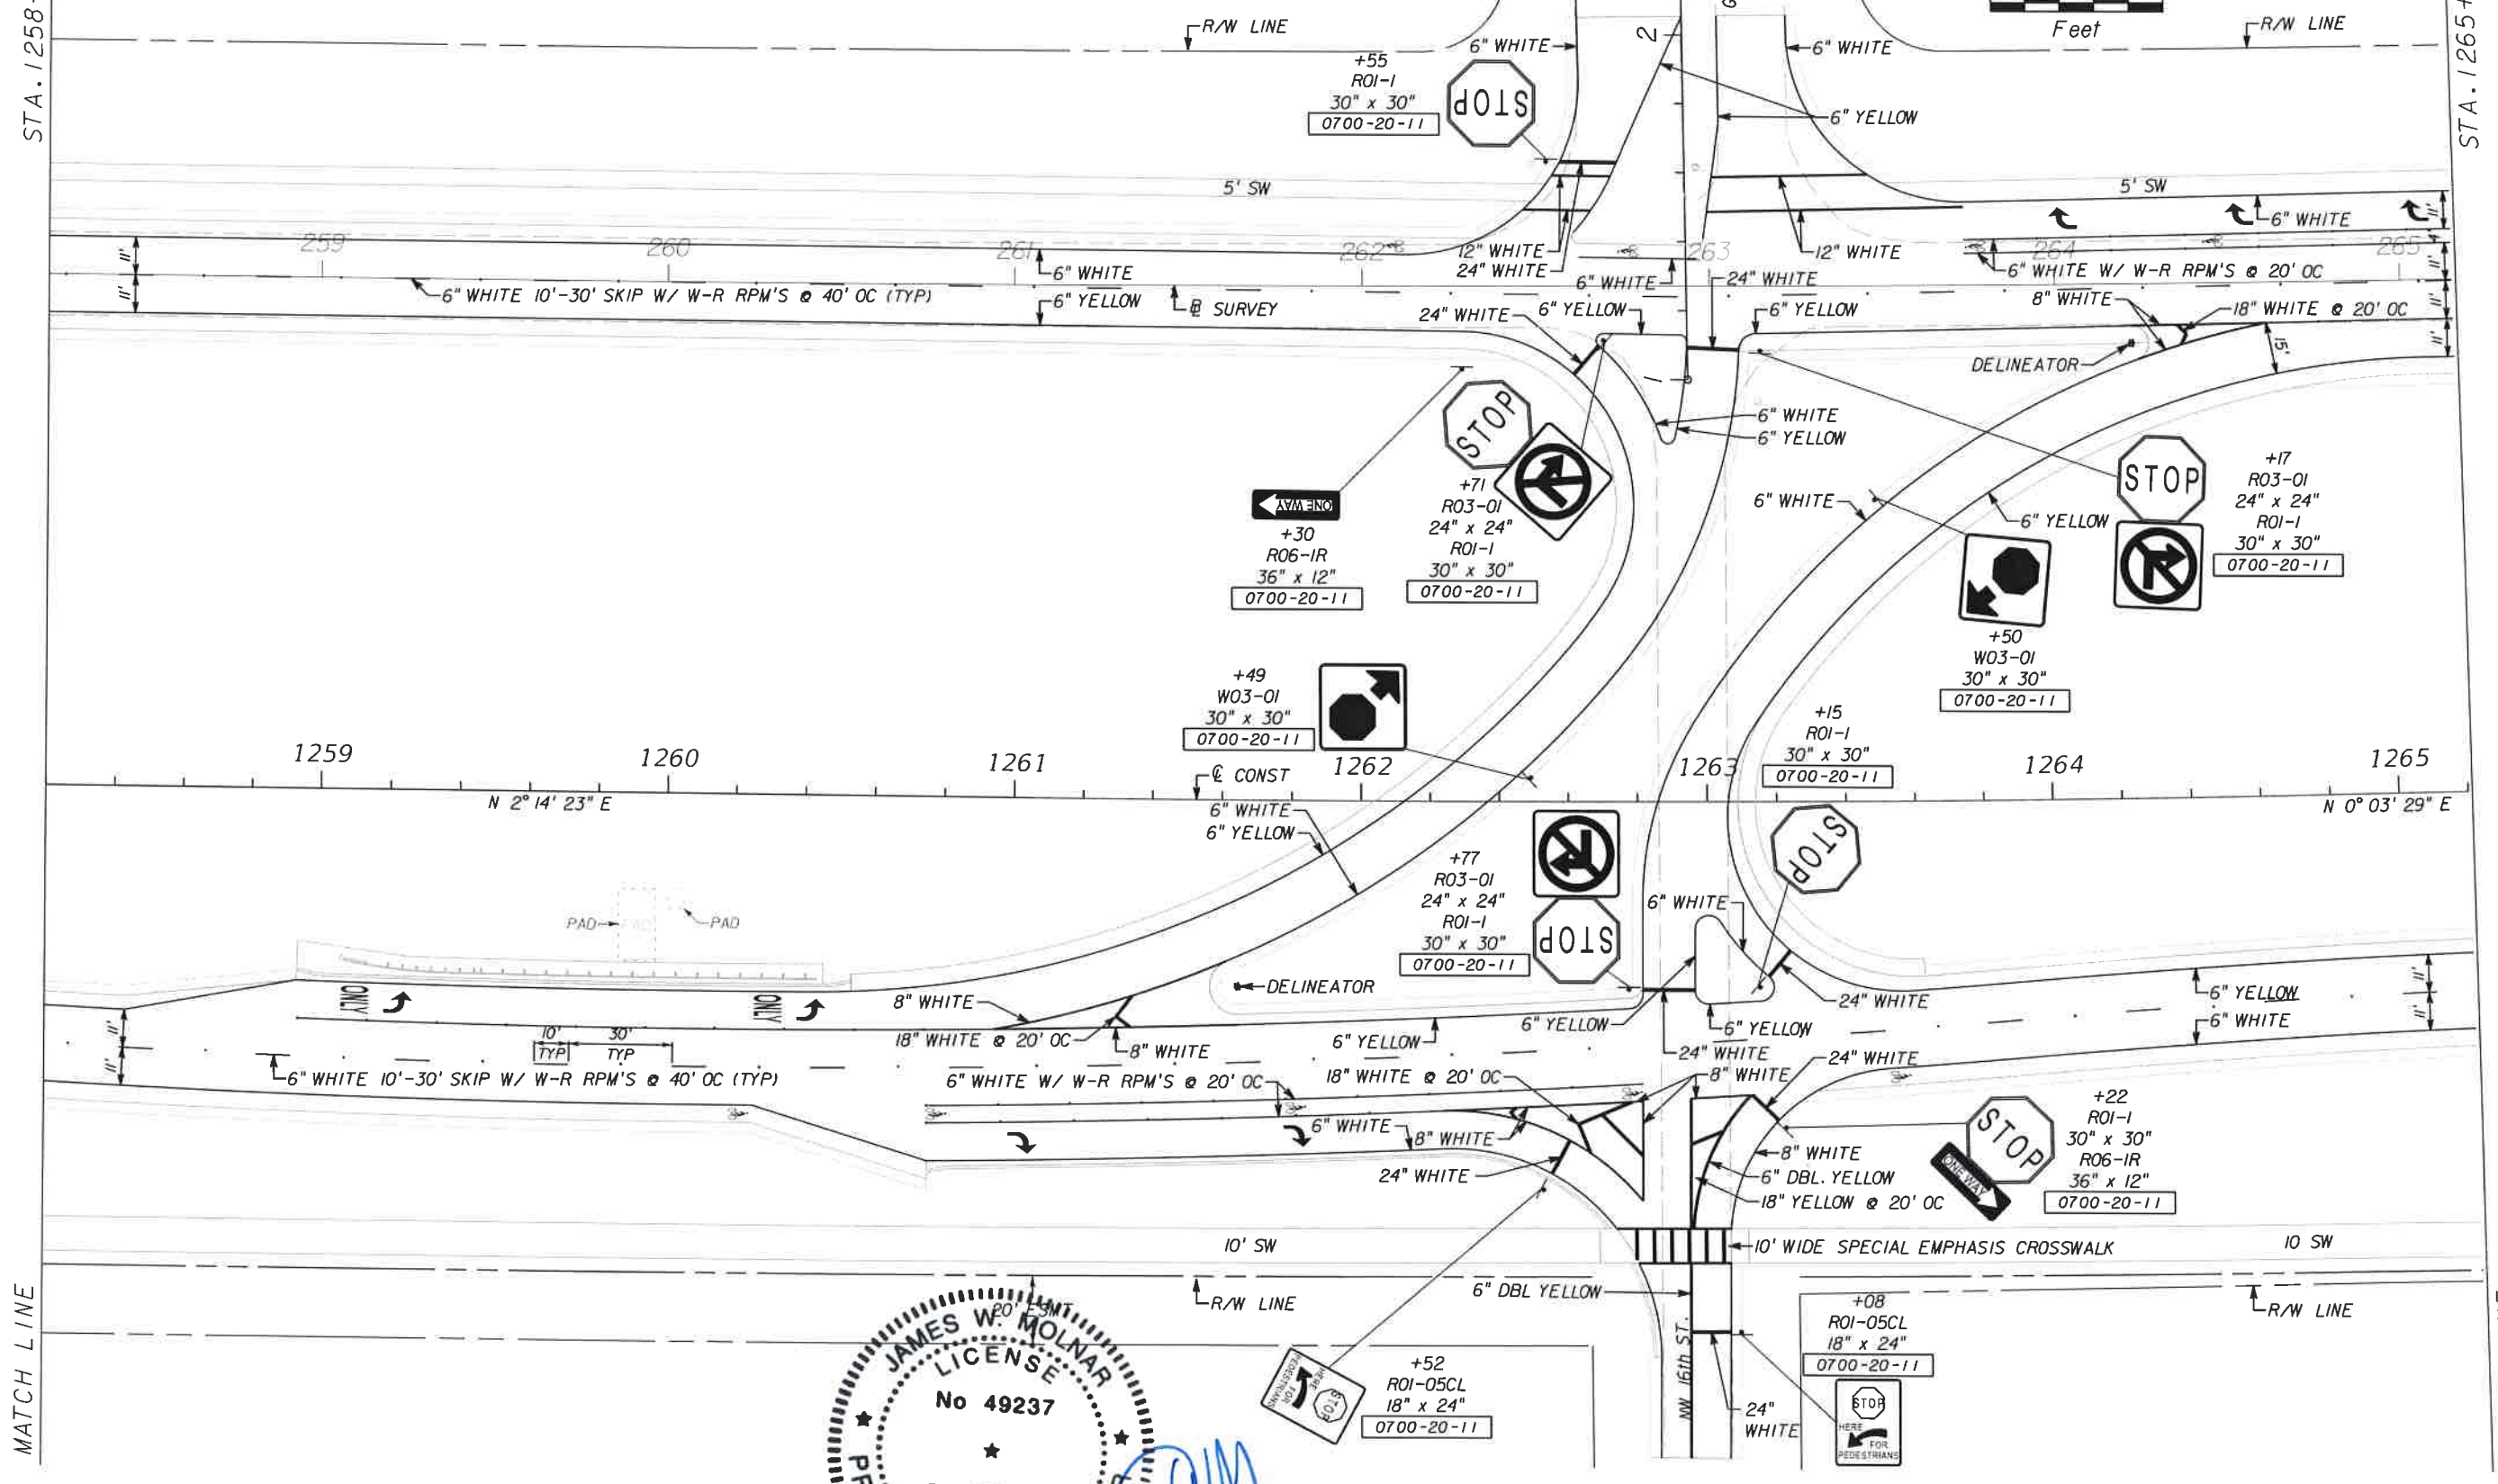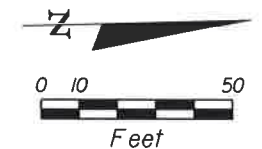

MATCH LINE

MATCH LINE

NO.	DATE	BY	REVISIONS - DESCRIPTION

T.Y. LIN INTERNATIONAL
 2400 FIRST STREET
 SUITE 200
 FORT MYERS, FLORIDA 33901
 TEL. (239) 332-4846
 FAX. (239) 332-4798
 WWW.TYLIN.COM

JAMES W. MOLNAR
 LICENSE No 49237
 STATE OF FLORIDA
 PROFESSIONAL ENGINEER
 3-5-2015

PUBLIC WORKS
LEE COUNTY
 DEPARTMENT of TRANSPORTATION
 1500 MENOR STREET
 FORT MYERS, FLORIDA 33901
 (239) 479-8900 www.lee-county.com/publicworks/default.htm
 rshldls 3/4/2015 4:36:29 PM

SIGNING & MARKING PLAN SHEET
STA. 1258+20.00 TO STA. 1265+20.00
BURNT STORE ROAD



SHEET NO.
 S-7

T:\Tampa\Legacy\Project\581595\00_Burnt_Store_RD\Burnt_Store_Signing\plan_s24.dgn

Default

STA. 1265+20.00

STA. 1272+20.00

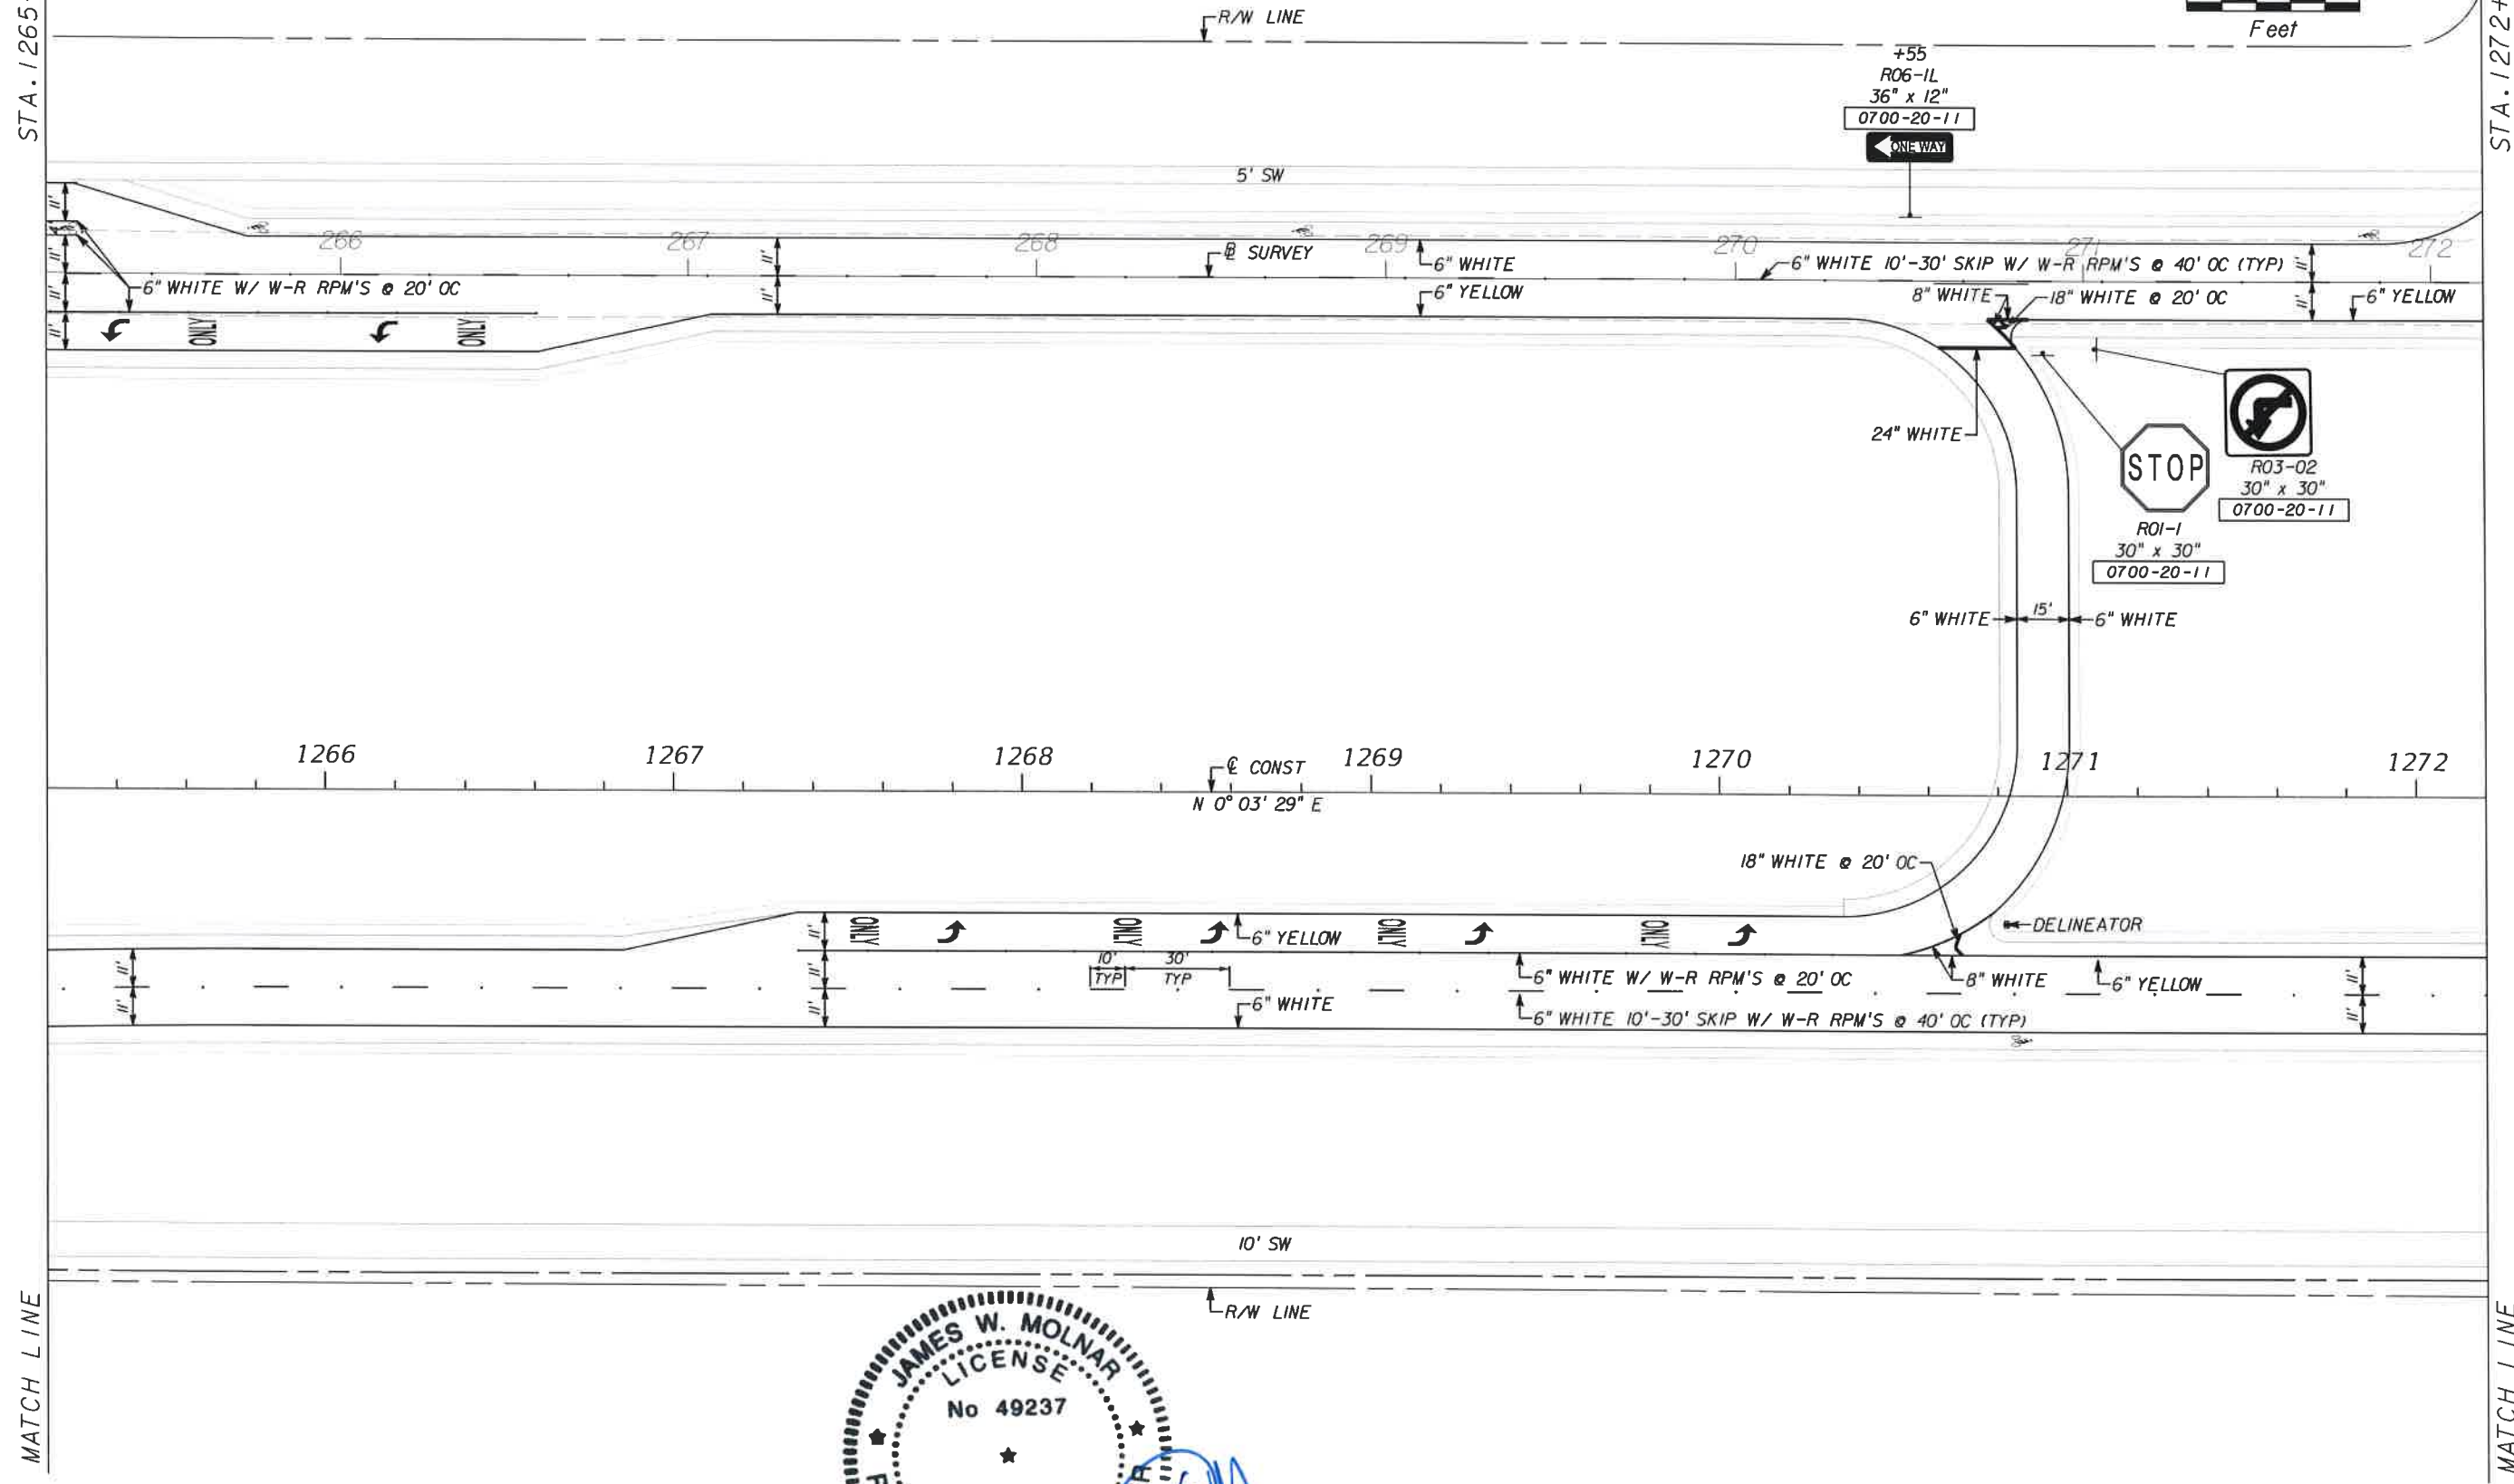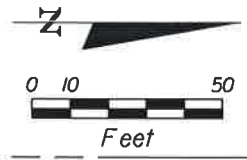


MATCH LINE

MATCH LINE

NO.	DATE	BY	REVISIONS - DESCRIPTION

T.Y. LIN INTERNATIONAL
 2400 FIRST STREET
 SUITE 200
 FORT MYERS, FLORIDA 33901
 TEL. (239) 332-4846
 FAX. (239) 332-4798
 WWW.TYLIN.COM

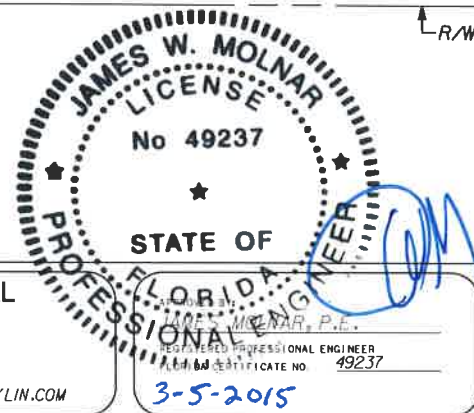

PUBLIC WORKS
LEE COUNTY
SOUTHWEST
FLORIDA
 1500 MONROE STREET
 12391 479-8900 www.lee-county.com/publicworks/default.htm


 




 
 
 

DEPARTMENT
of
TRANSPORTATION
 FORT MYERS, FLORIDA 33901

SIGNING & MARKING PLAN SHEET
STA. 1265+20.00 TO STA. 1272+20.00
BURNT STORE ROAD

SHEET NO.
S-8

STA. 1272+20.00

STA. 1279+20.00

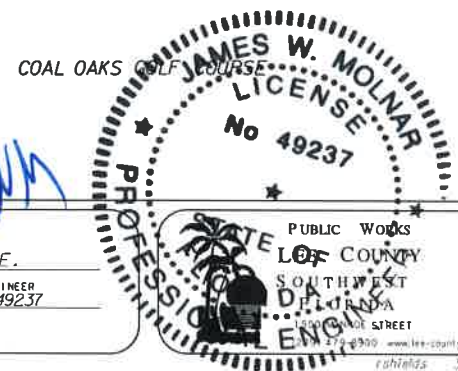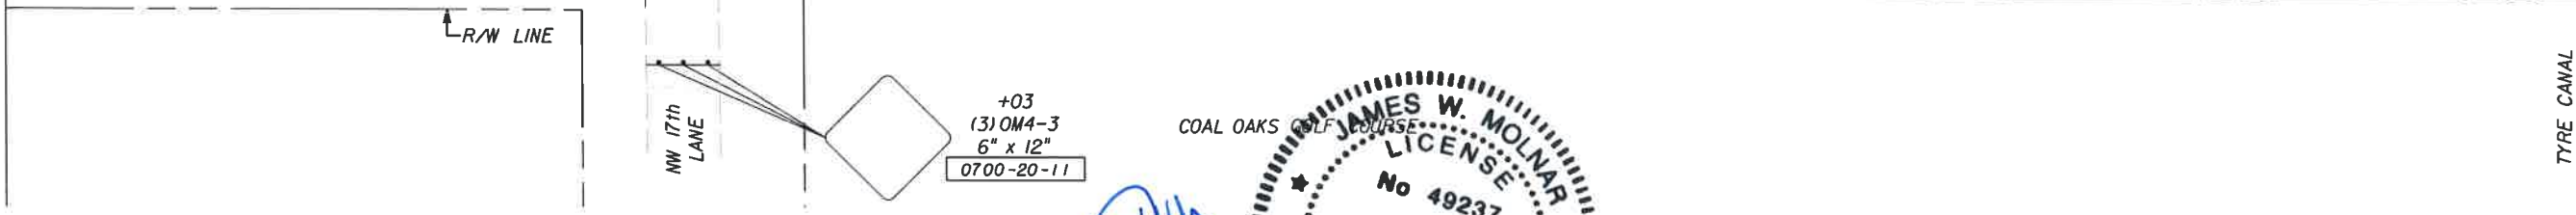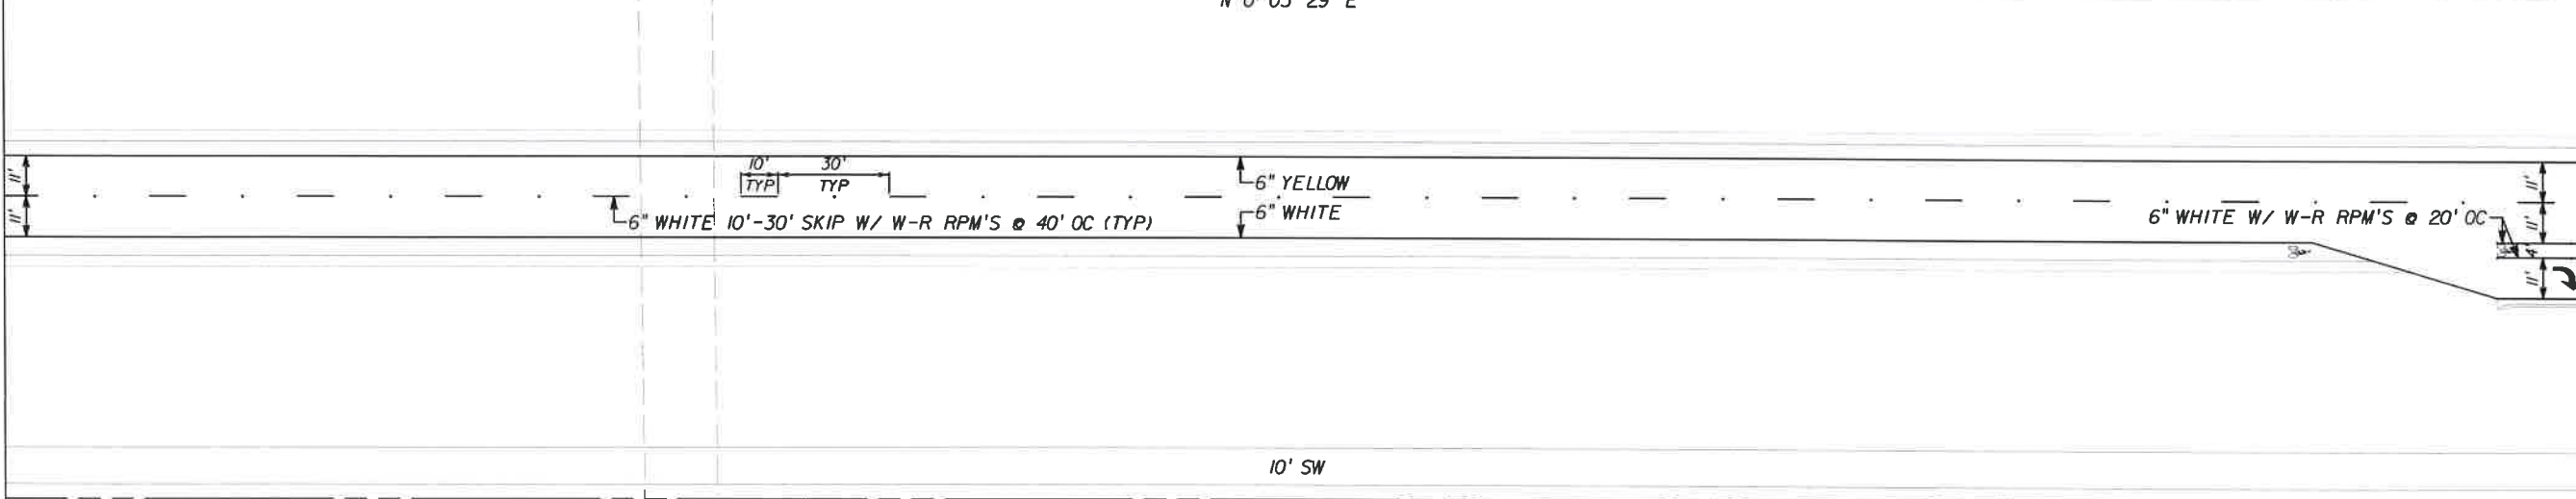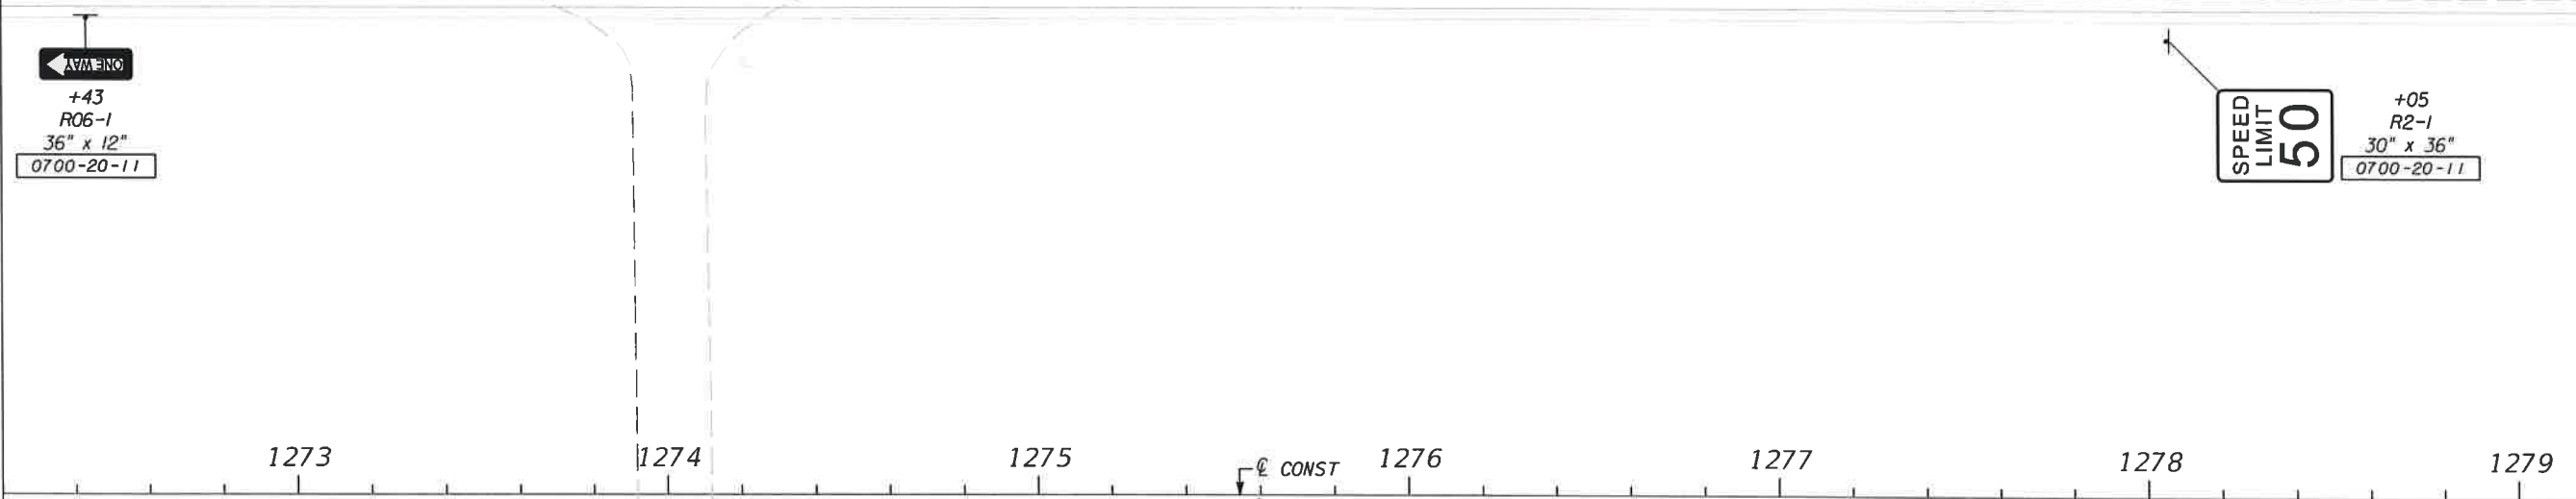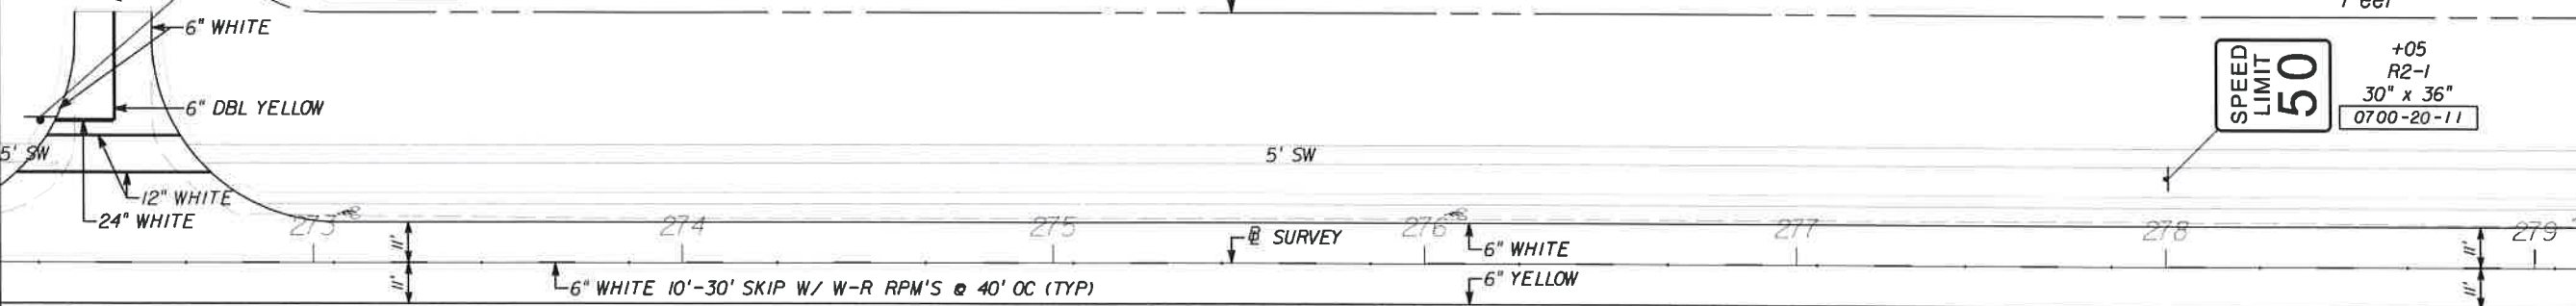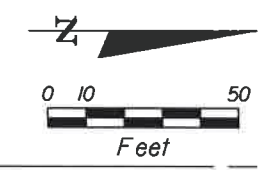

APPROVED BY:
JAMES MOLNAR, P.E.
 REGISTERED PROFESSIONAL ENGINEER
 FLORIDA CERTIFICATE NO. 49237
 3-5-2015

T.Y. LIN INTERNATIONAL
 2400 FIRST STREET
 SUITE 200
 FORT MYERS, FLORIDA 33901
 TEL. (239) 332-4846
 FAX. (239) 332-4798
 WWW.TYLIN.COM



NO.	DATE	BY	REVISIONS - DESCRIPTION

SIGNING & MARKING PLAN SHEET
STA. 1272+20.00 TO STA. 1279+20.00
BURNT STORE ROAD

SHEET NO.
S-9

STA. 1279+20.00

STA. 1286+20.00

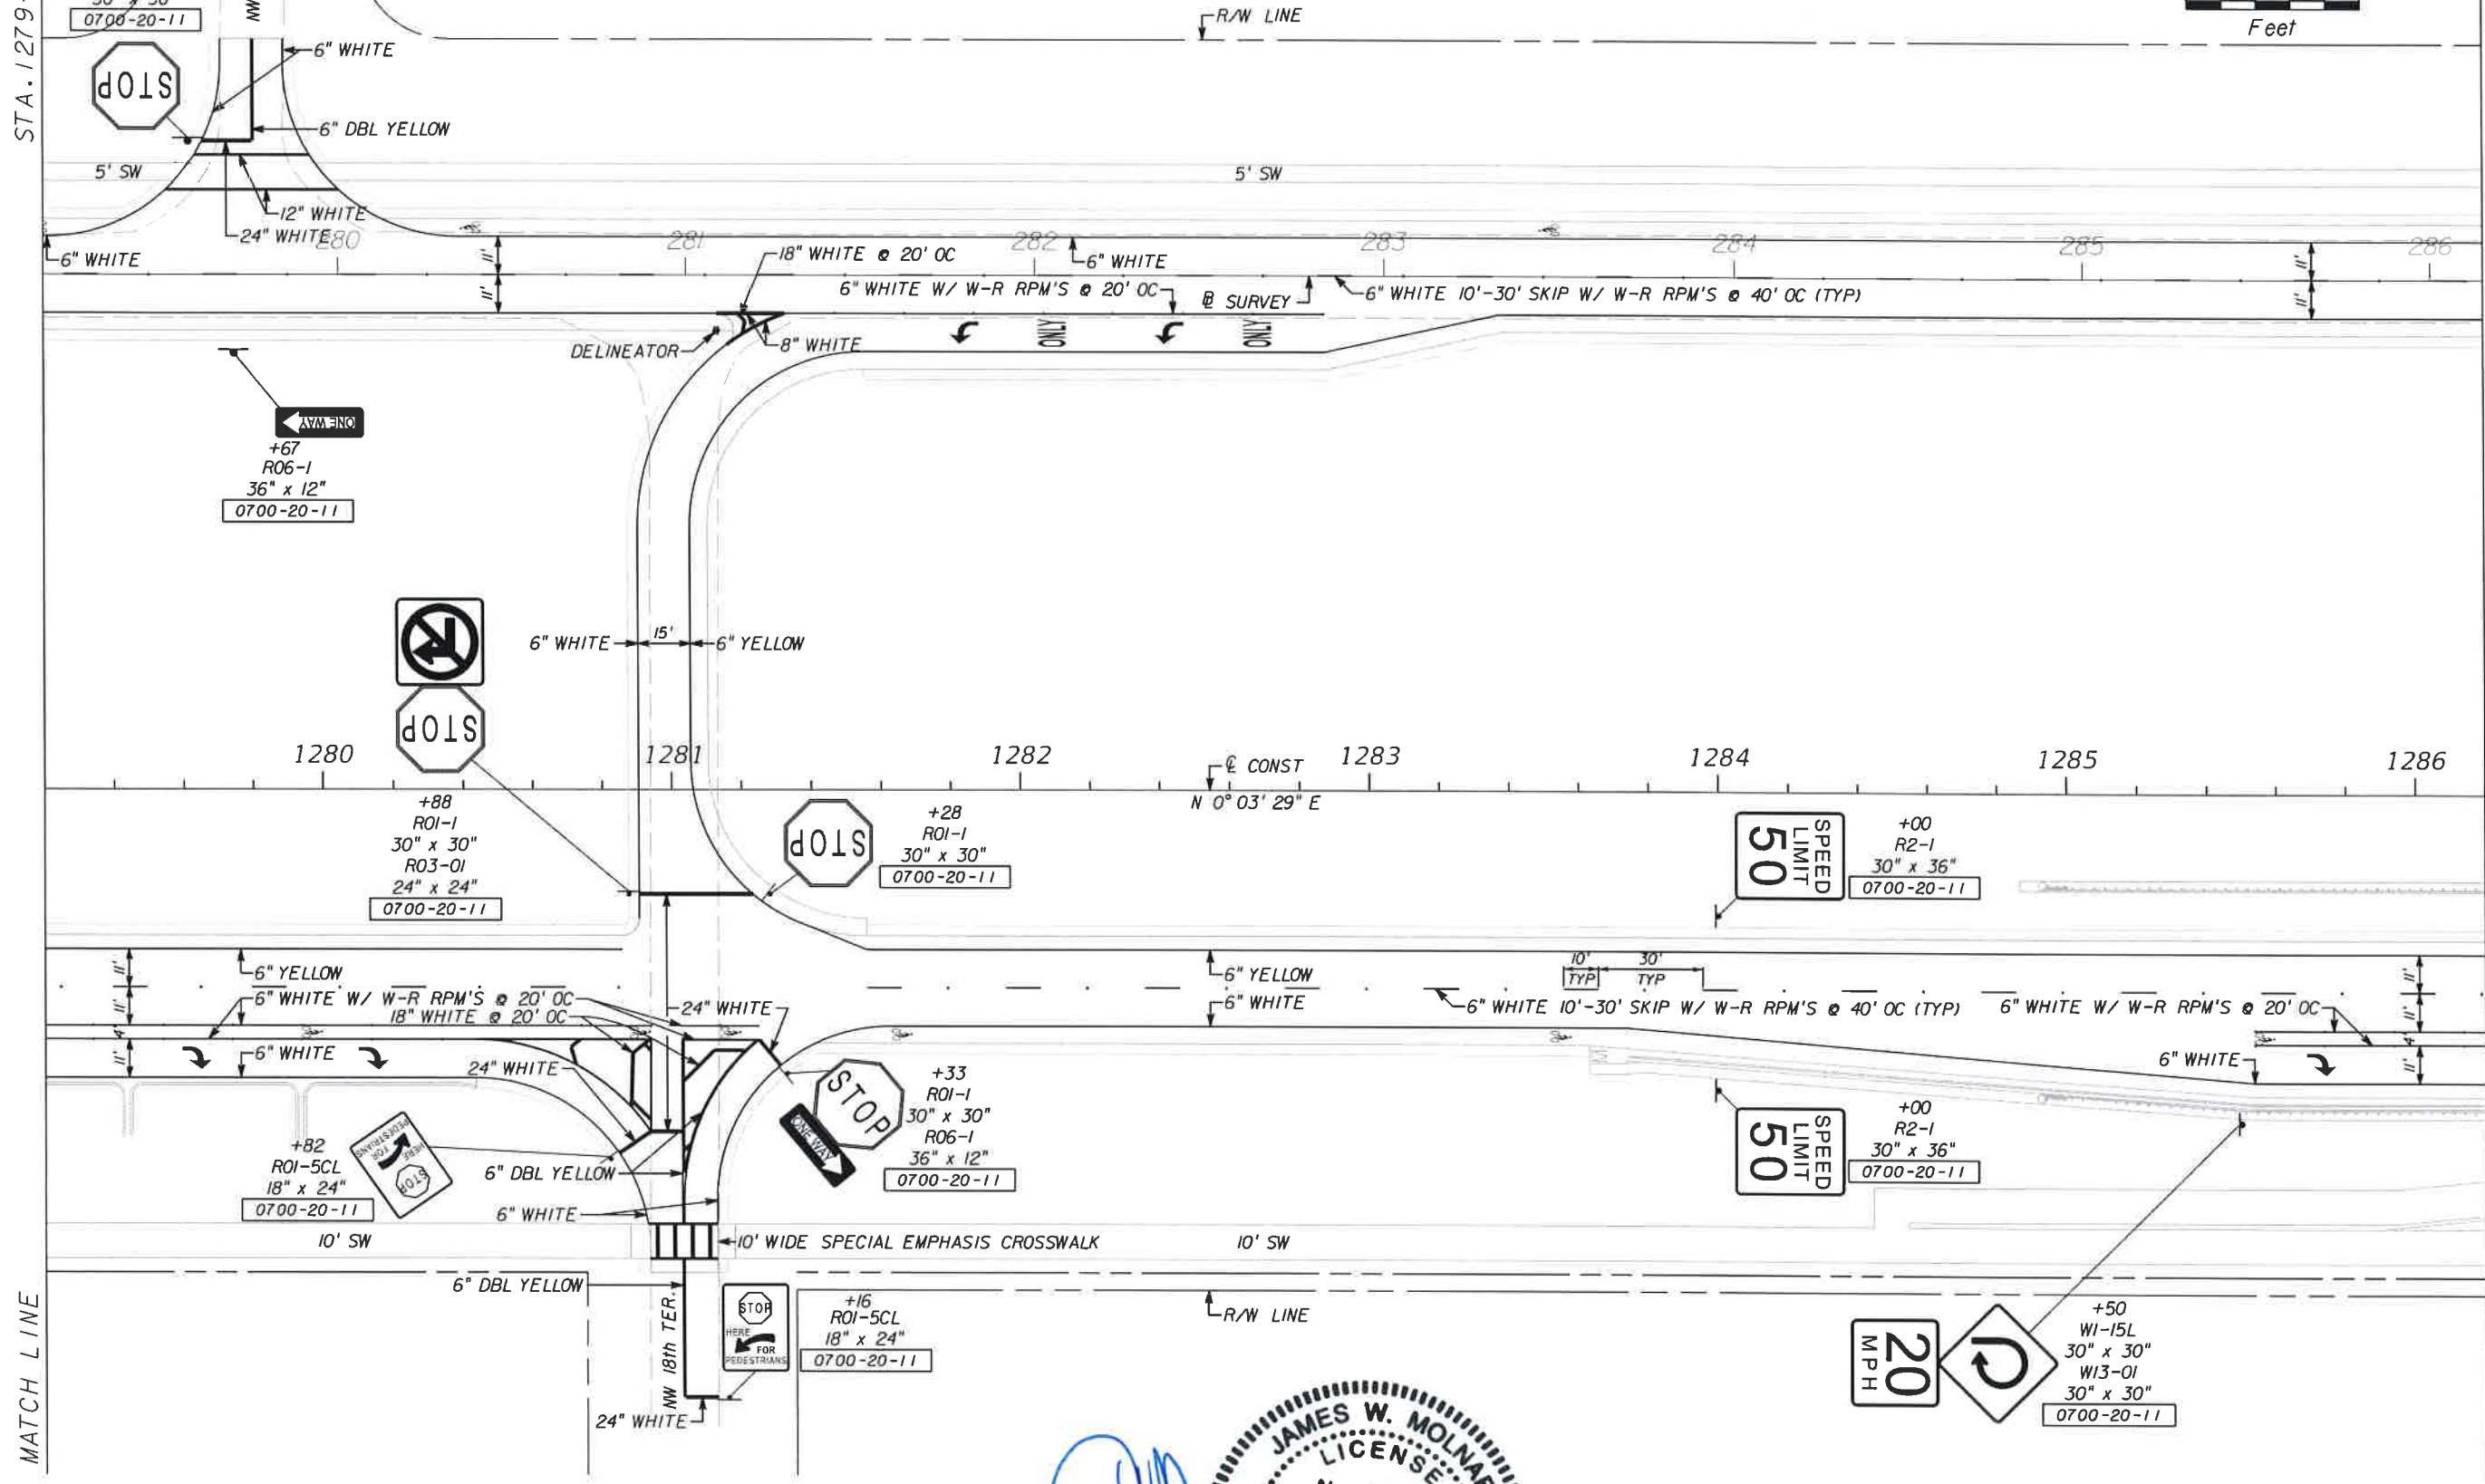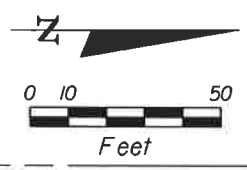

NO.	DATE	BY	REVISIONS - DESCRIPTION

T.Y. LIN INTERNATIONAL
 2400 FIRST STREET
 SUITE 200
 FORT MYERS, FLORIDA 33901
 TEL. (239) 332-4846
 FAX. (239) 332-4798
 WWW.TYLIN.COM

APPROVED BY
JAMES W. MOLNAR, P.E.
 REGISTERED PROFESSIONAL ENGINEER
 FLORIDA CERTIFICATE NO. 49237
 3-5-2015



DEPARTMENT
 of
 TRANSPORTATION
 FORT MYERS, FLORIDA 33901
www.lcc-county.com/public-works/dotitle.htm


SIGNING & MARKING PLAN SHEET
STA. 1279+20.00 TO STA. 1286+20.00
BURNT STORE ROAD

SHEET
 NO.
 S-10

T:\Temp\Legacy\Project\581595.00_Burnt_Store_RD\Burnt_Store\Signing\spansp27.dgn 3/4/2015 4:39:13 PM

STA. 1286+20.00

STA. 1293+20.00

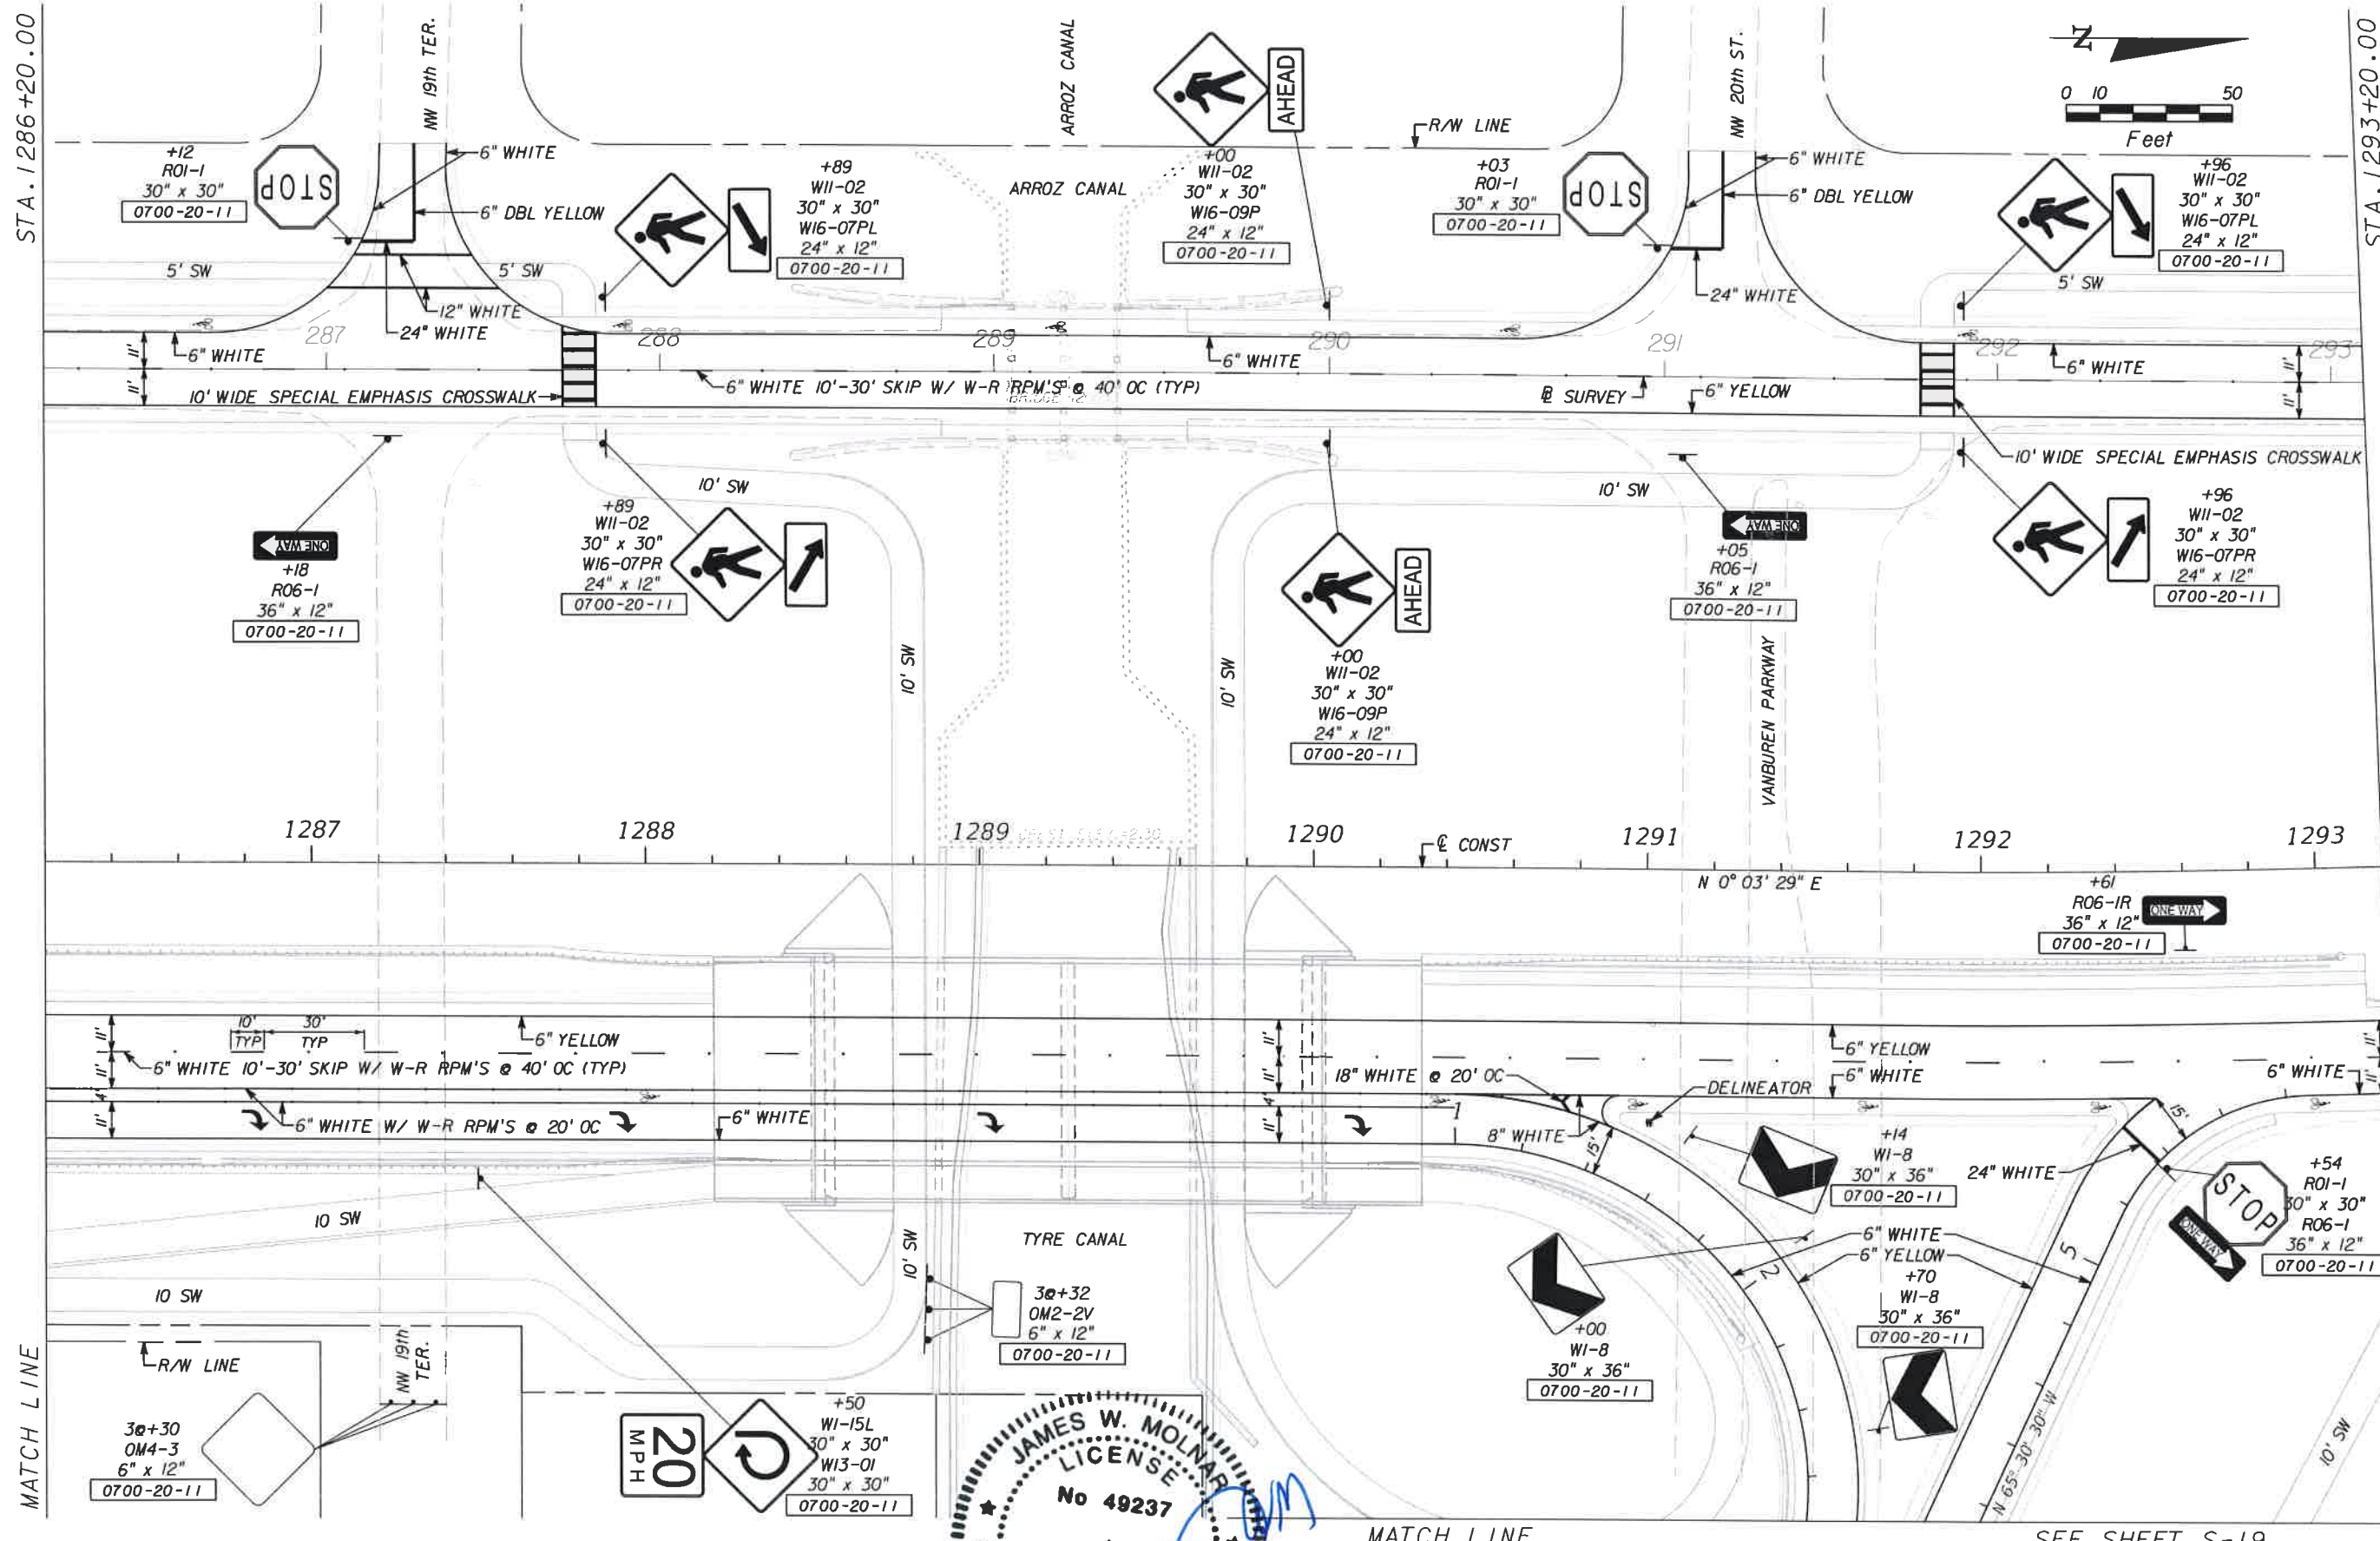

MATCH LINE

MATCH LINE

NO.	DATE	BY	REVISIONS - DESCRIPTION

T.Y. LIN INTERNATIONAL
 2400 FIRST STREET
 SUITE 200
 FORT MYERS, FLORIDA 33901
 TEL. (239) 332-4846
 FAX. (239) 332-4798
 WWW.TYLIN.COM

JAMES W. MOLNAR
 LICENSE
 No 49237
 PROFESSIONAL ENGINEER
 STATE OF FLORIDA
 3-5-2015

PUBLIC WORKS
 LEE COUNTY
 SOUTHWEST
 FLORIDA
 1500 MONROE STREET
 FORT MYERS, FLORIDA 33901
 (239) 479-8900
 www.lee-county.com/publicworks/quality.htm

SIGNING & MARKING PLAN SHEET
 STA. 1286+20.00 TO STA. 1293+20.00
BURNT STORE ROAD



SHEET NO.
 S-II

T:\Comp\Legacy\Project\581595.00_Burnt_Store_RD\Burnt_Store\signing\plans\28.dgn

Default

STA. 1293+20.00

STA. 1300+20.00

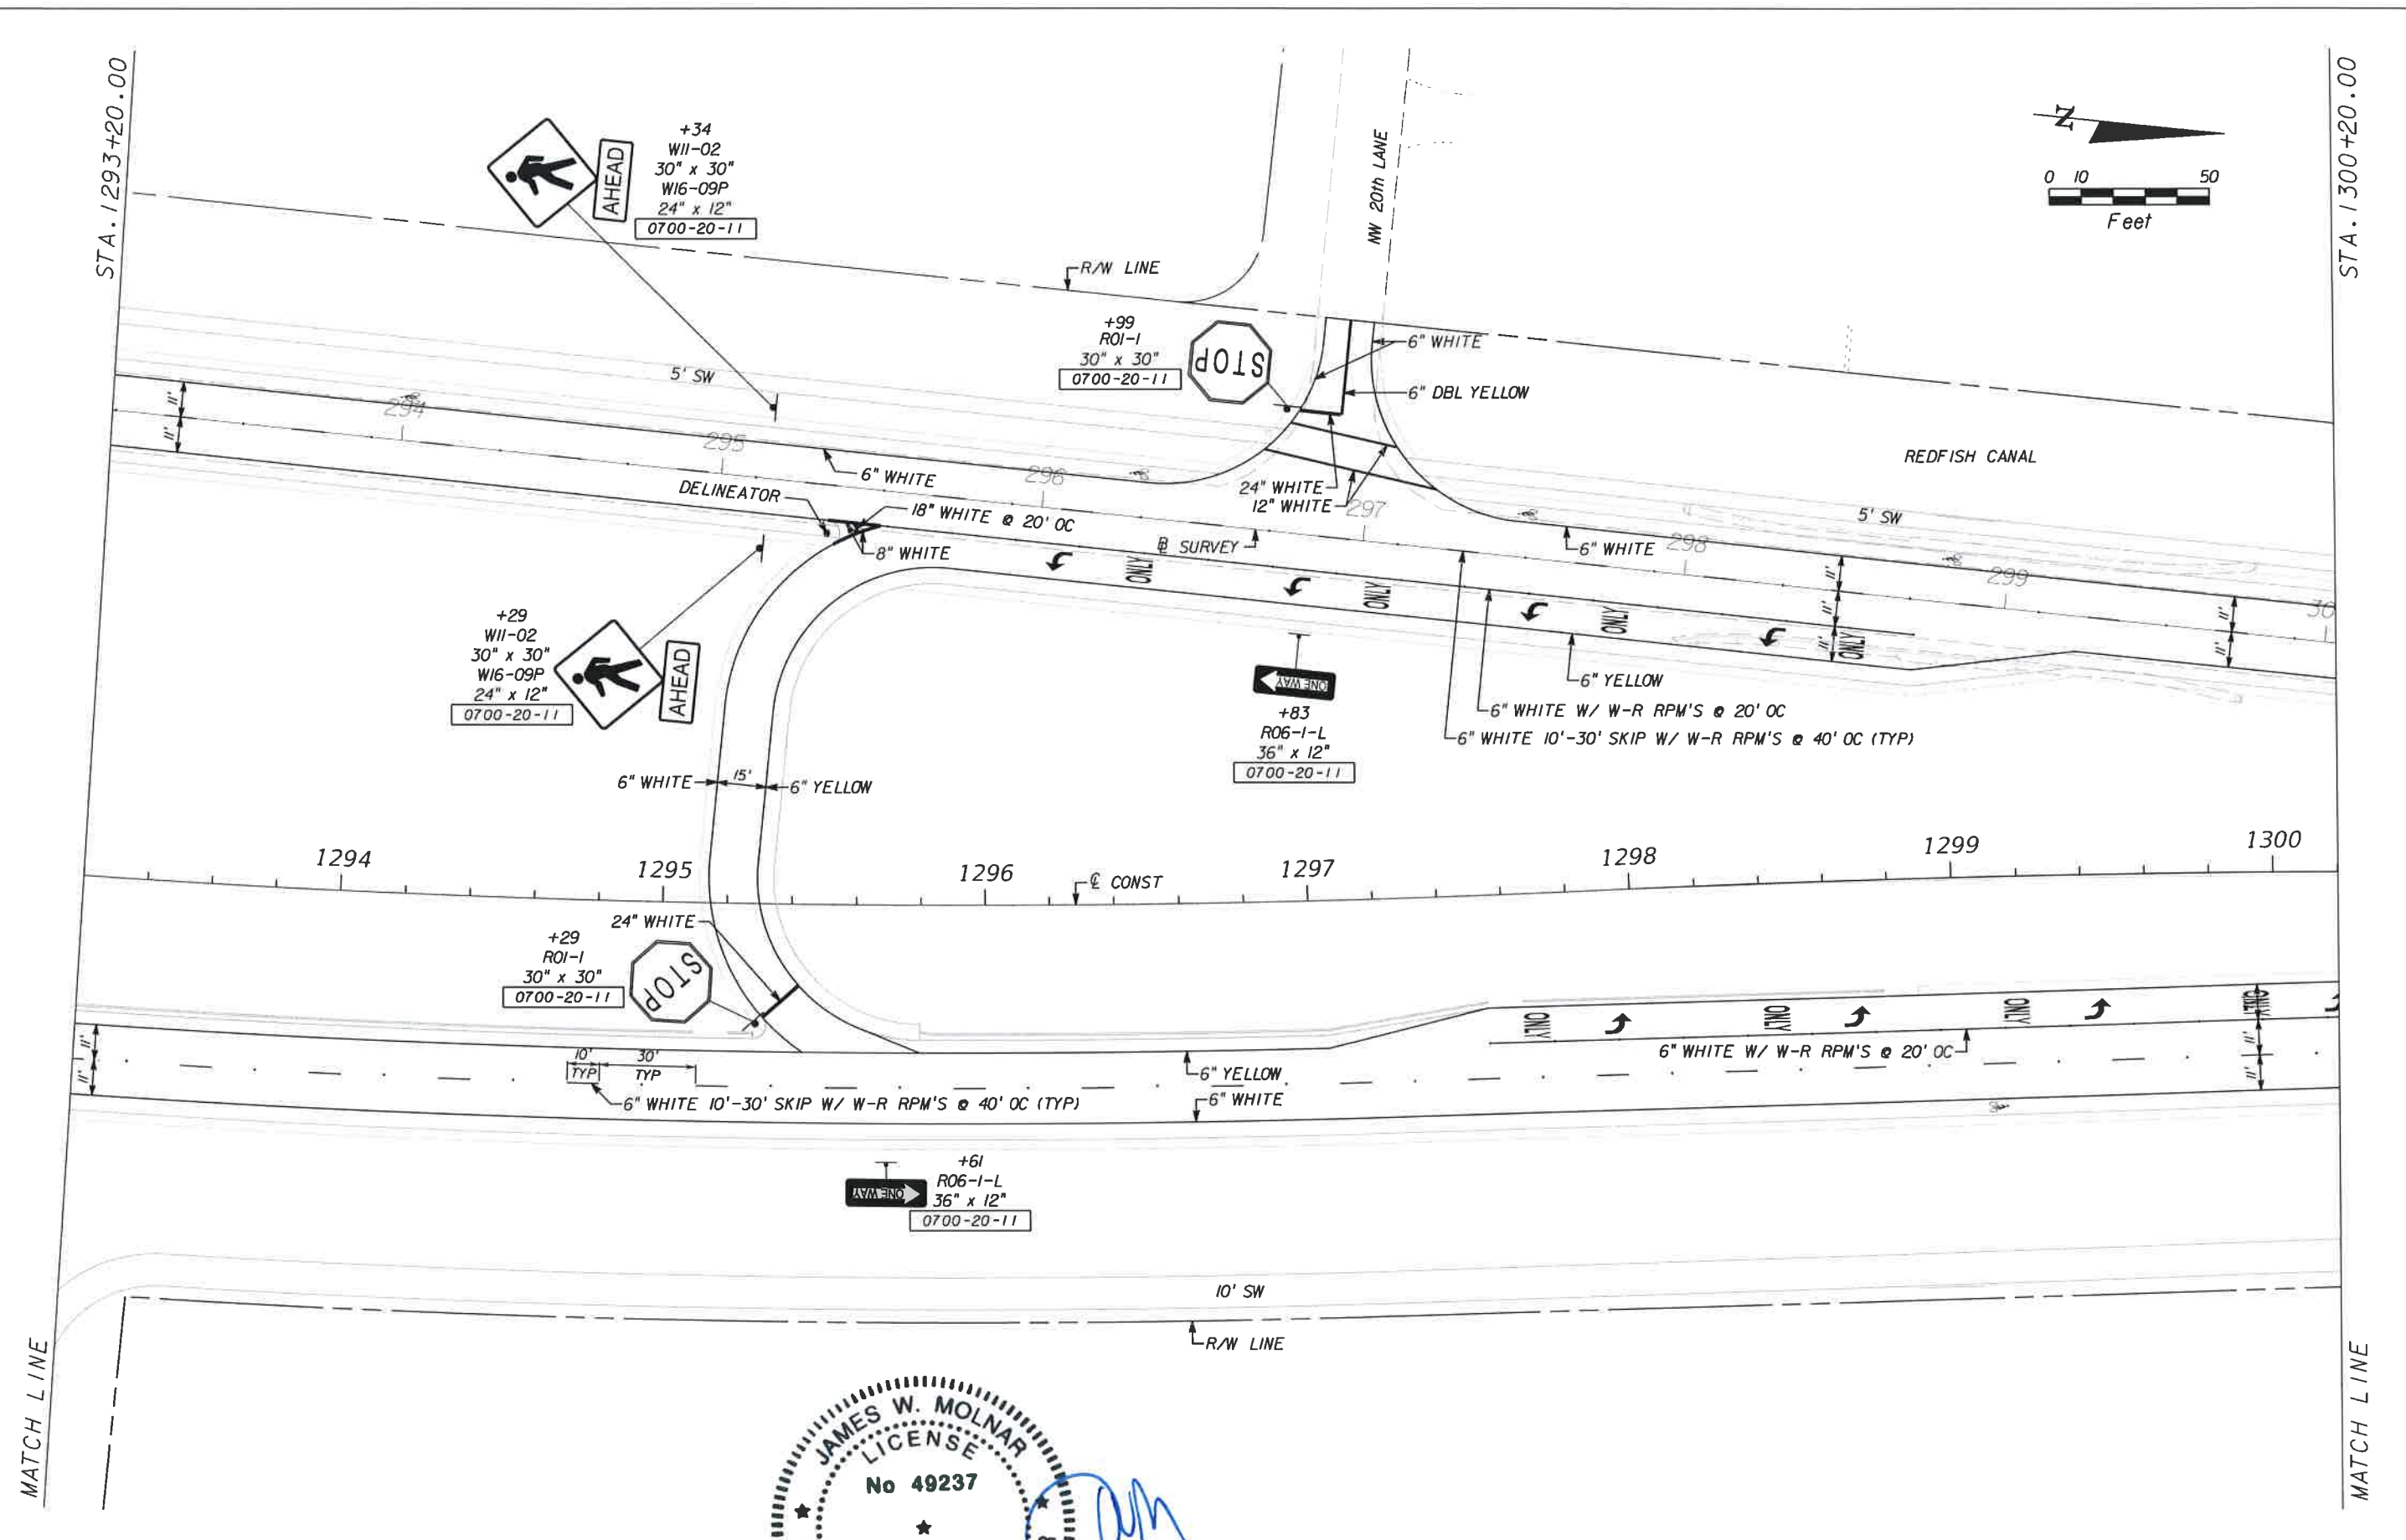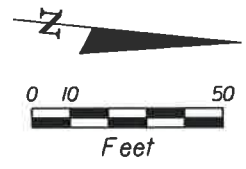

MATCH LINE

MATCH LINE

NO.	DATE	BY	REVISIONS - DESCRIPTION

T.Y. LIN INTERNATIONAL
 2400 FIRST STREET
 SUITE 200
 FORT MYERS, FLORIDA 33901
 TEL. (239) 332-4846
 FAX. (239) 332-4798
 WWW.TYLIN.COM

STATE OF FLORIDA
 PROFESSIONAL ENGINEER
 LICENSE No 49237
 JAMES W. MOLNAR
 APPROVED BY: [Signature] P.E.
 DATE NO. 49237

PUBLIC WORKS
LEE COUNTY
 SOUTHWEST
 FLORIDA
 1500 MONROE STREET
 FORT MYERS, FLORIDA 33901
 (239) 479-8900 www.lee-county.com/publicworks/office.htm



DEPARTMENT
 of
TRANSPORTATION

SIGNING & MARKING PLAN SHEET
STA. 1293+20.00 TO STA. 1300+20.00
BURNT STORE ROAD

SHEET NO.
S-12

STA. 1300+20.00

STA. 1307+20.00

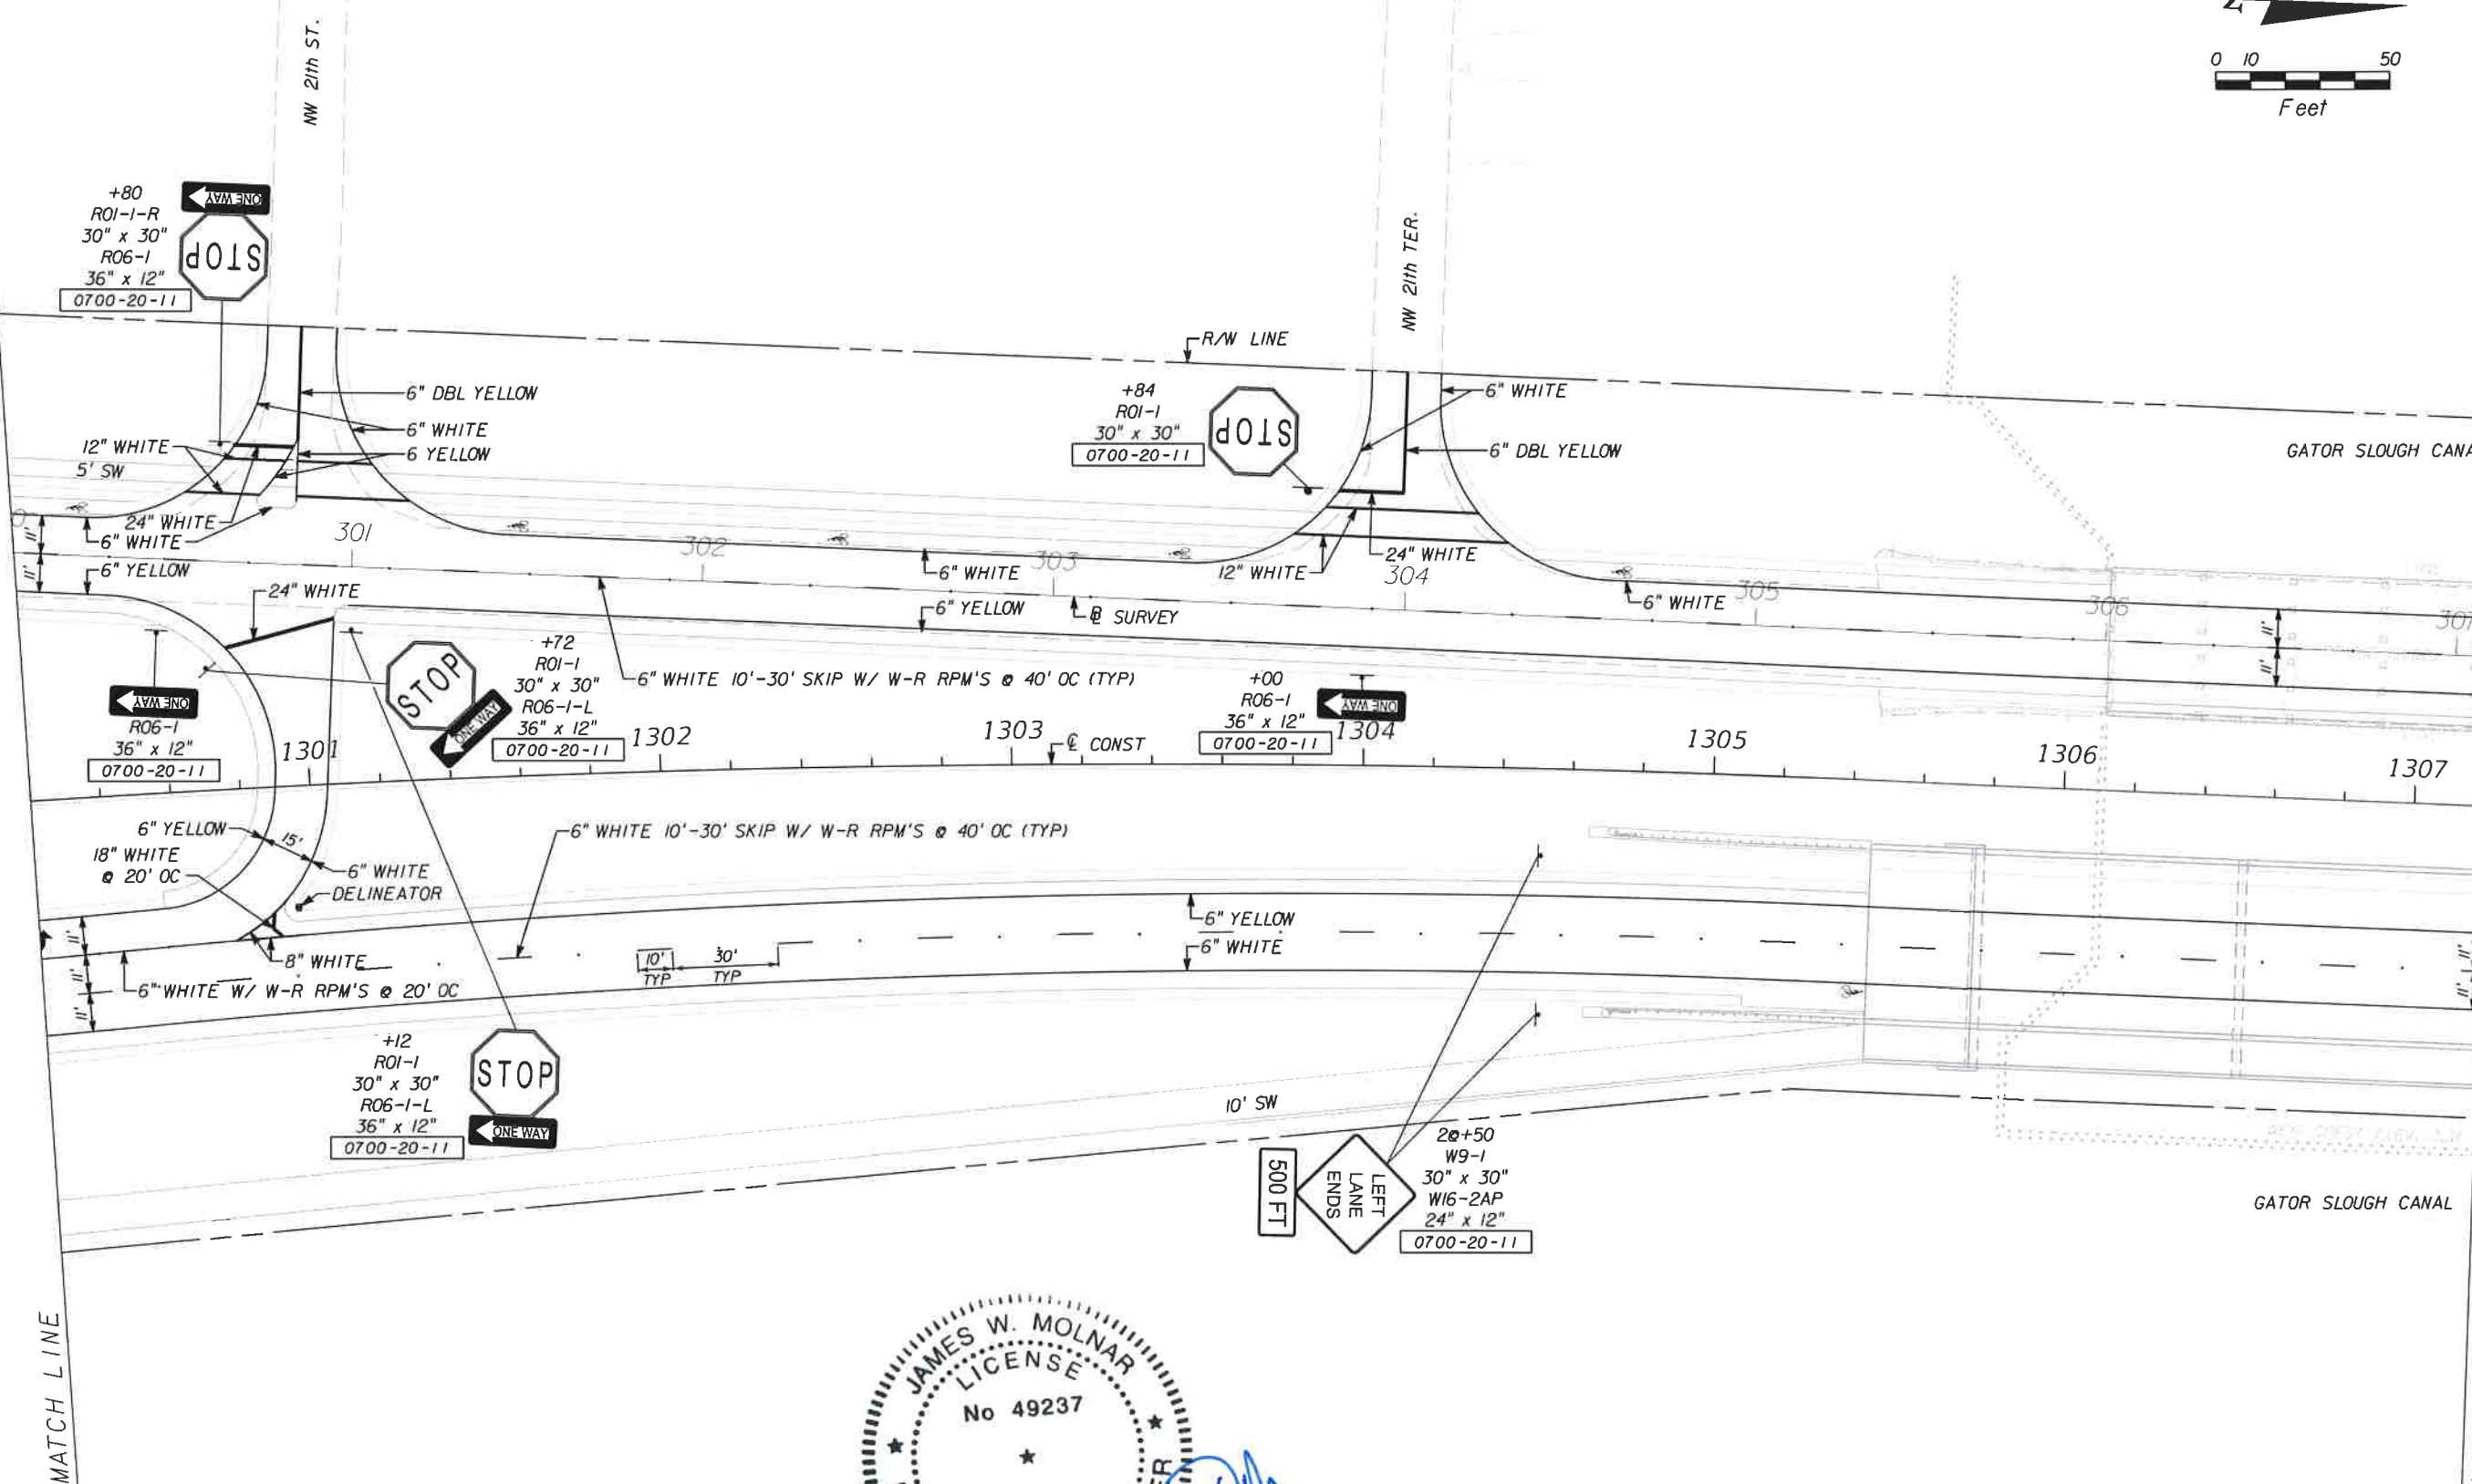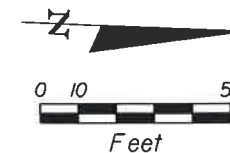

NO.	DATE	BY	REVISIONS - DESCRIPTION

T.Y. LIN INTERNATIONAL
 2400 FIRST STREET
 SUITE 200
 FORT MYERS, FLORIDA 33901
 TEL. (239) 332-4846
 FAX. (239) 332-4798
 WWW.TYLIN.COM

JAMES W. MOLNAR
 LICENSE
 No 49237
 STATE OF
 FLORIDA
 PROFESSIONAL ENGINEER
 REGISTRATION NO. 49237
 FLORIDA CERTIFICATE NO. 49237


PUBLIC WORKS
 LEE COUNTY
 DEPARTMENT
 of
 TRANSPORTATION
 SOUTHWEST
 FLORIDA
 1500 MONROE STREET
 FORT MYERS, FLORIDA 33901
 (239) 479-8900 www.lee-county.com/publicworks/default.htm

SIGNING & MARKING PLAN SHEET
STA. 1300+20.00 TO STA. 1307+20.00
BURNT STORE ROAD

SHEET
 NO.
S-13

STA. 1307+20.00

STA. 1314+20.00

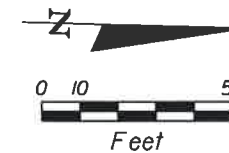


GATOR SLOUGH CANAL

R/W LINE

(2) @ +40
R2-1
30" x 36"
0700-20-11

SPEED
LIMIT
50

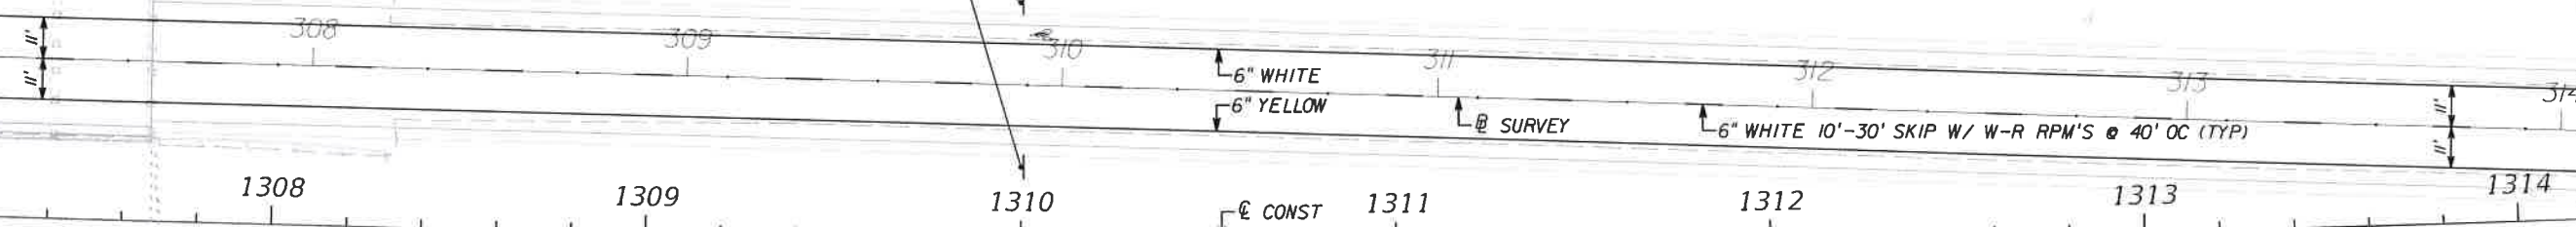

GATOR SLOUGH CANAL

R/W LINE

10' TYP
30' TYP
ONLY
6" WHITE 10'-30' SKIP W/ W-R RPM'S @ 40' OC (TYP)

+97
R03-17
24" x 18"
R03-17BP
24" x 8"
0700-20-11

MATCH LINE

MATCH LINE



NO.	DATE	BY	REVISIONS - DESCRIPTION

T.Y. LIN INTERNATIONAL
 2400 FIRST STREET
 SUITE 200
 FORT MYERS, FLORIDA 33901
 TEL. (239) 332-4846
 FAX. (239) 332-4798
 WWW.TYLIN.COM

REGISTRATION PROFESSIONAL ENGINEER
 FLORIDA CERTIFICATE NO. 49237
 3-5-2015



PUBLIC WORKS
LEE COUNTY
SOUTHWEST
FLORIDA
 1500 MONROE STREET
 FORT MYERS, FLORIDA 33901
 (239) 479-8900 www.lee-county.com/publicworks/default.htm

SIGNING & MARKING PLAN SHEET
STA. 1307+20.00 TO STA. 1314+20.00
BURNT STORE ROAD


SHEET NO.
 S-14
 Default

STA. 1314+20.00


MATCH LINE

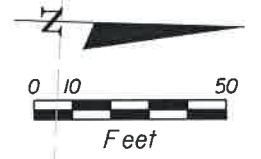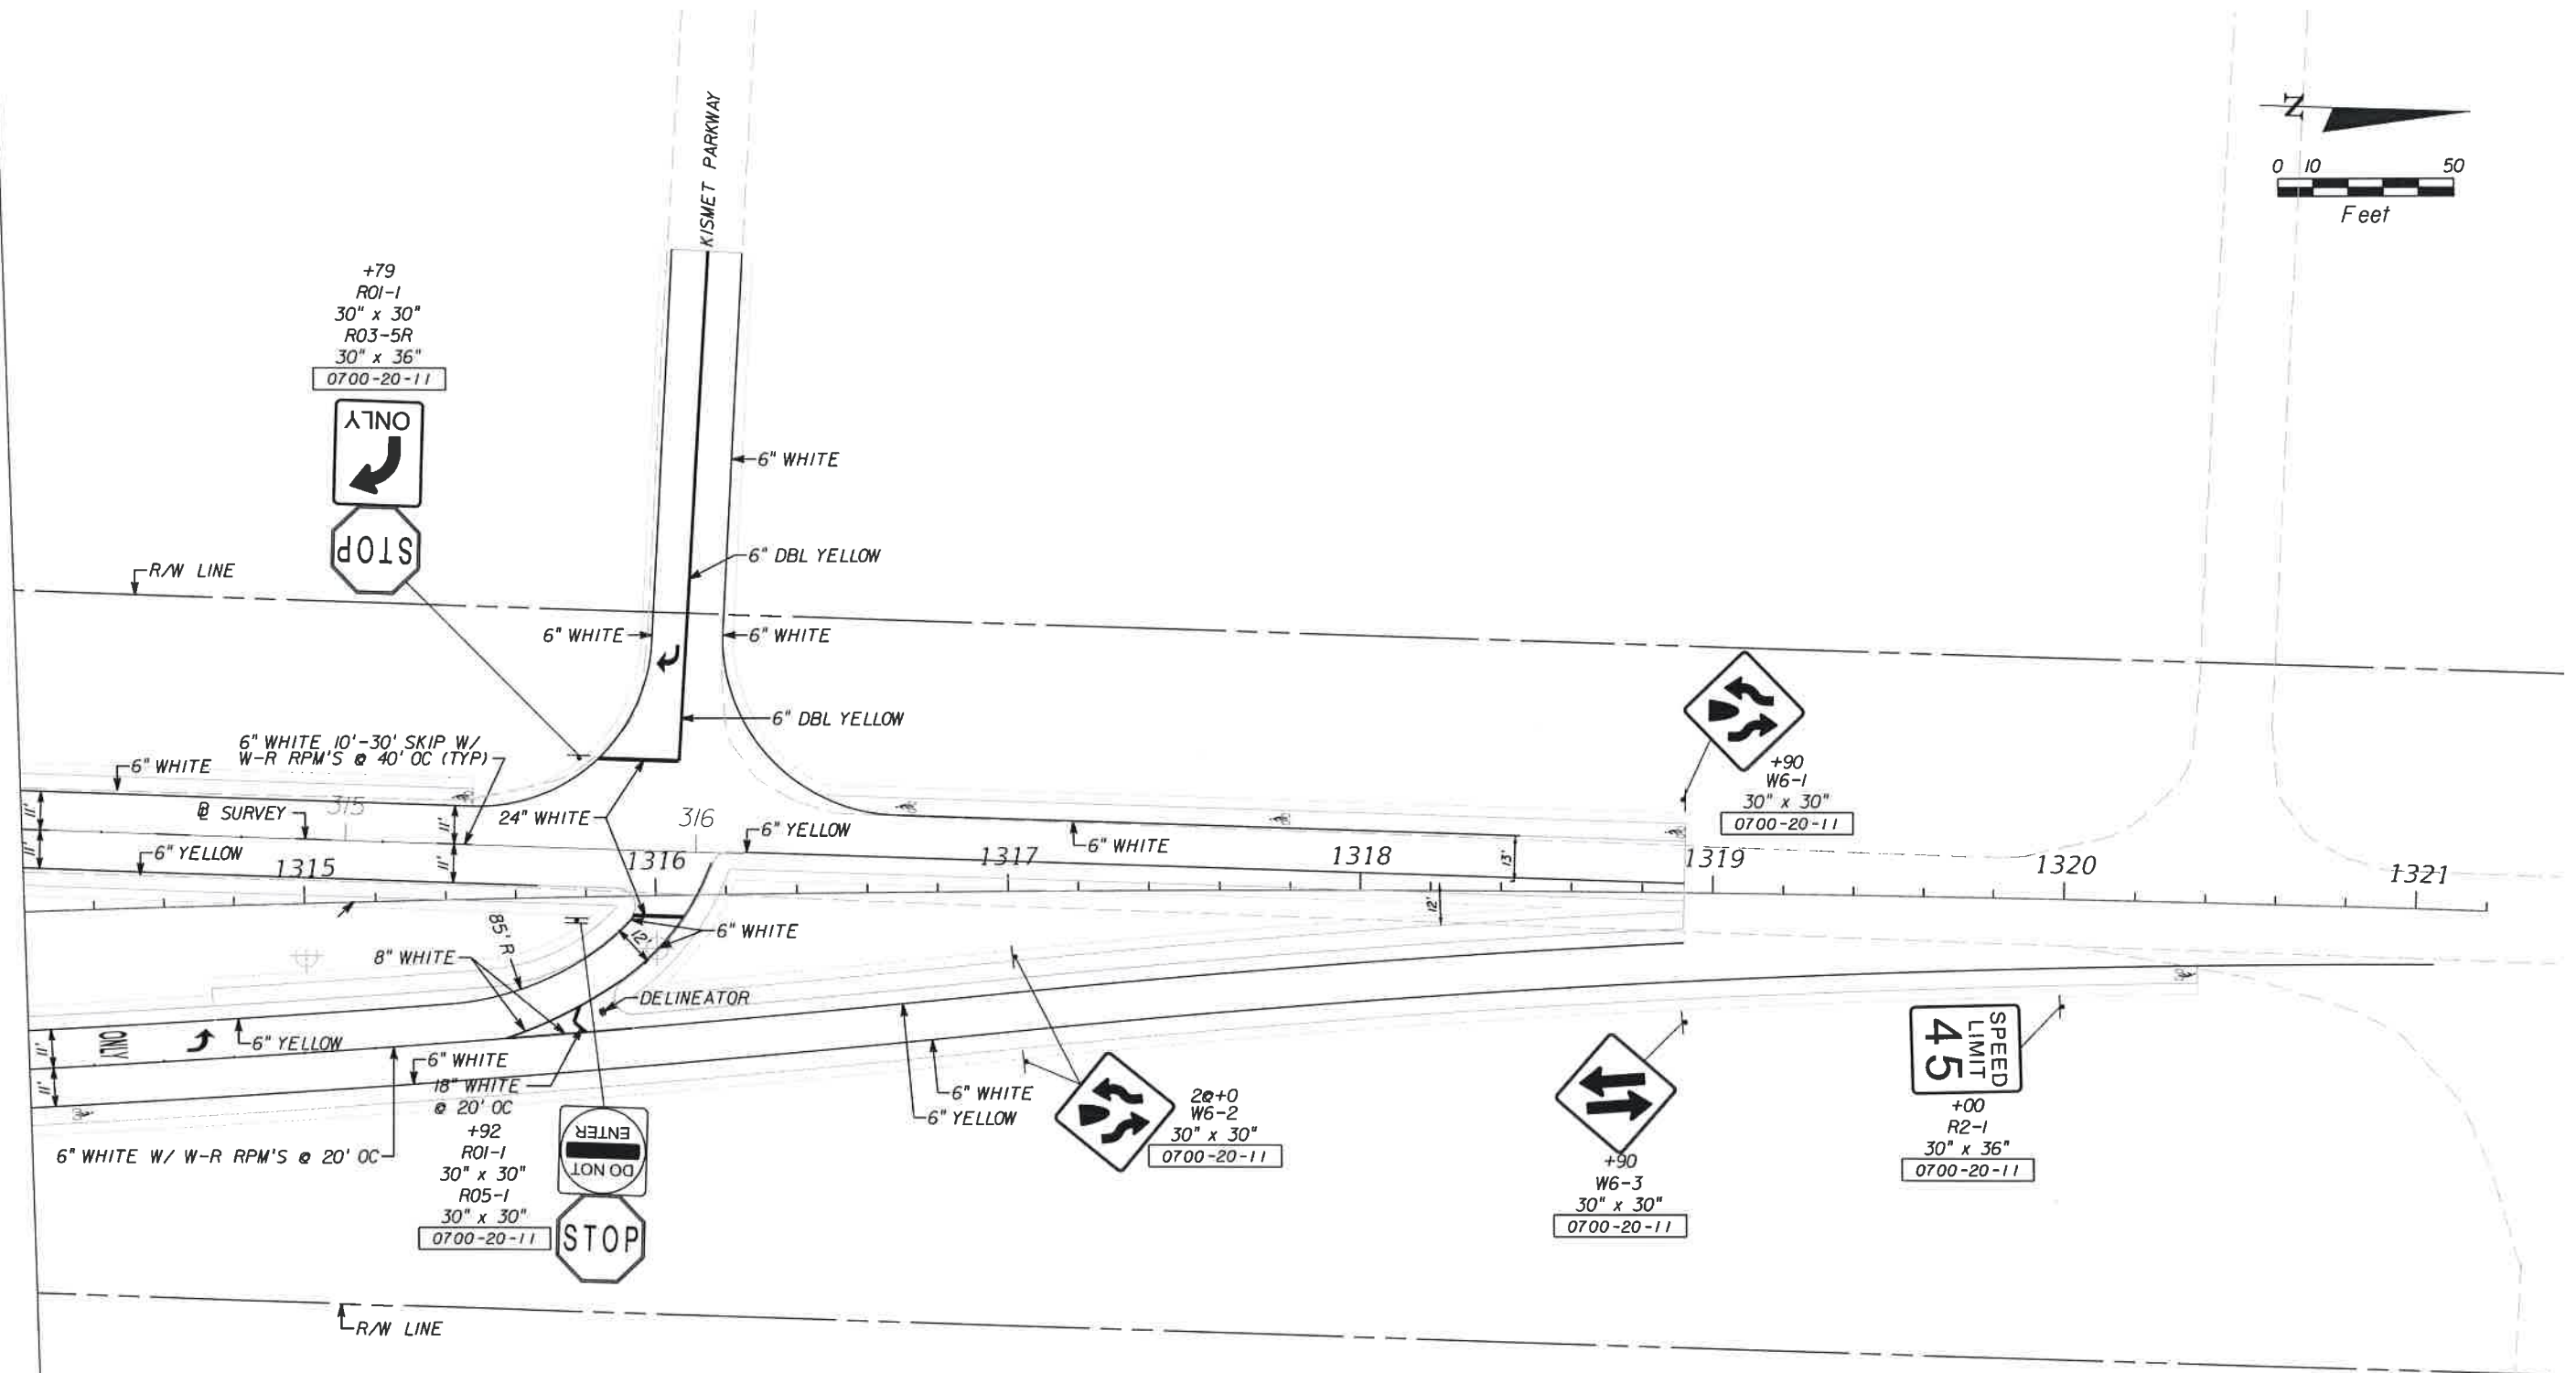


+79
 ROI-1
 30" x 30"
 R03-5R
 30" x 36"
 0700-20-11

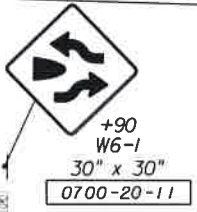

 +92
 ROI-1
 30" x 30"
 R05-1
 30" x 30"
 0700-20-11



20+0
 W6-2
 30" x 30"
 0700-20-11

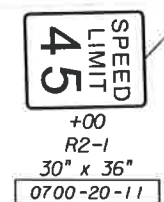

T.Y. LIN INTERNATIONAL
 2400 FIRST STREET
 SUITE 200
 FORT MYERS, FLORIDA 33901
 TEL. (239) 332-4846
 FAX. (239) 332-4798
 WWW.TYLIN.COM

PUBLIC WORKS
LEE COUNTY
 DEPARTMENT
 of
TRANSPORTATION
 SOUTH
 WEST
 FLORIDA
 1500 MONROE STREET
 FORT MYERS, FLORIDA 33901
 (239) 479-8900 www.lee-county.com/publicworks/default.htm

SIGNING & MARKING PLAN SHEET
STA. 1314+20.00 TO STA. 1321+19.86
BURNT STORE ROAD

SHEET
 NO.
 S-15


NO.	DATE	BY	REVISIONS - DESCRIPTION

MATCH LINE

SEE SHEET S-5





+50
WI-8
30" x 36"
0700-20-11

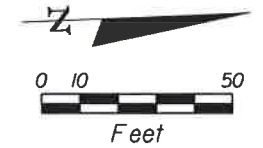

R/W LINE

R/W LINE

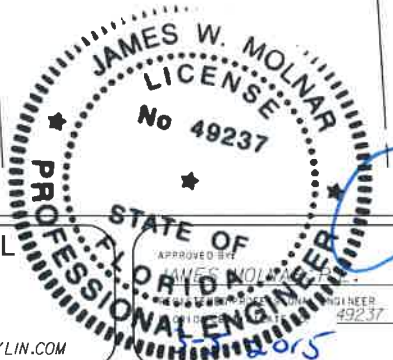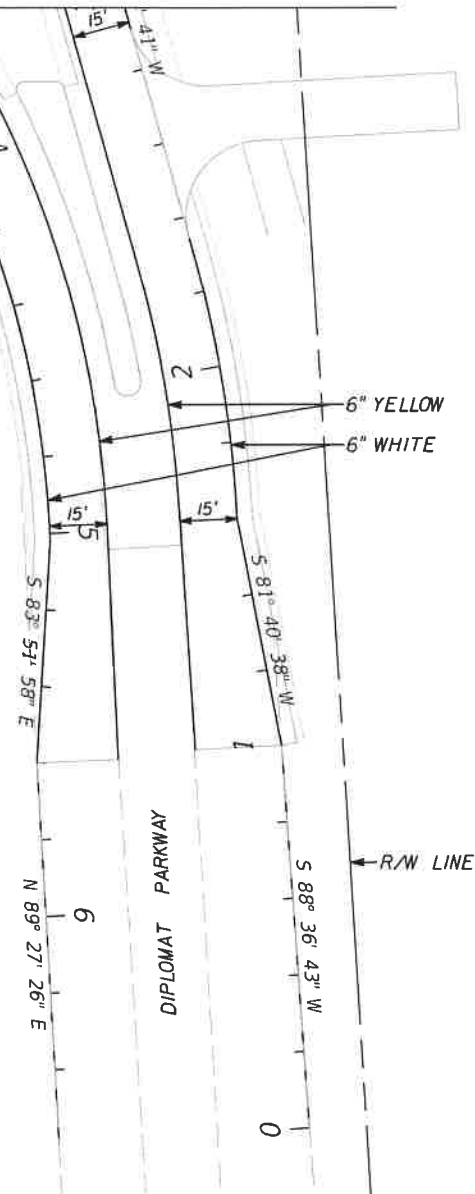

Handwritten signature and initials in blue ink over the seal.

NO.	DATE	BY	REVISIONS - DESCRIPTION

T.Y. LIN INTERNATIONAL
 2400 FIRST STREET
 SUITE 200
 FORT MYERS, FLORIDA 33901
 TEL. (239) 332-4846
 FAX. (239) 332-4798
 WWW.TYLIN.COM

PUBLIC WORKS
LEE COUNTY
SOUTHWEST
FLORIDA
 1500 MONROE STREET
 (239) 479-8900
www.lee-county.com/pdw/pdwsw/dallie.htm

DEPARTMENT
of
TRANSPORTATION
 FORT MYERS, FLORIDA 33901
www.lee-county.com/pdw/pdwsw/dallie.htm



SIGNING & MARKING PLAN SHEET
DIPLOMAT PARKWAY
BURNT STORE ROAD

SHEET NO.
S-16

MATCH LINE

SEE SHEET S-11

20 +00
WI-4
30" x 30"
0700-20-11

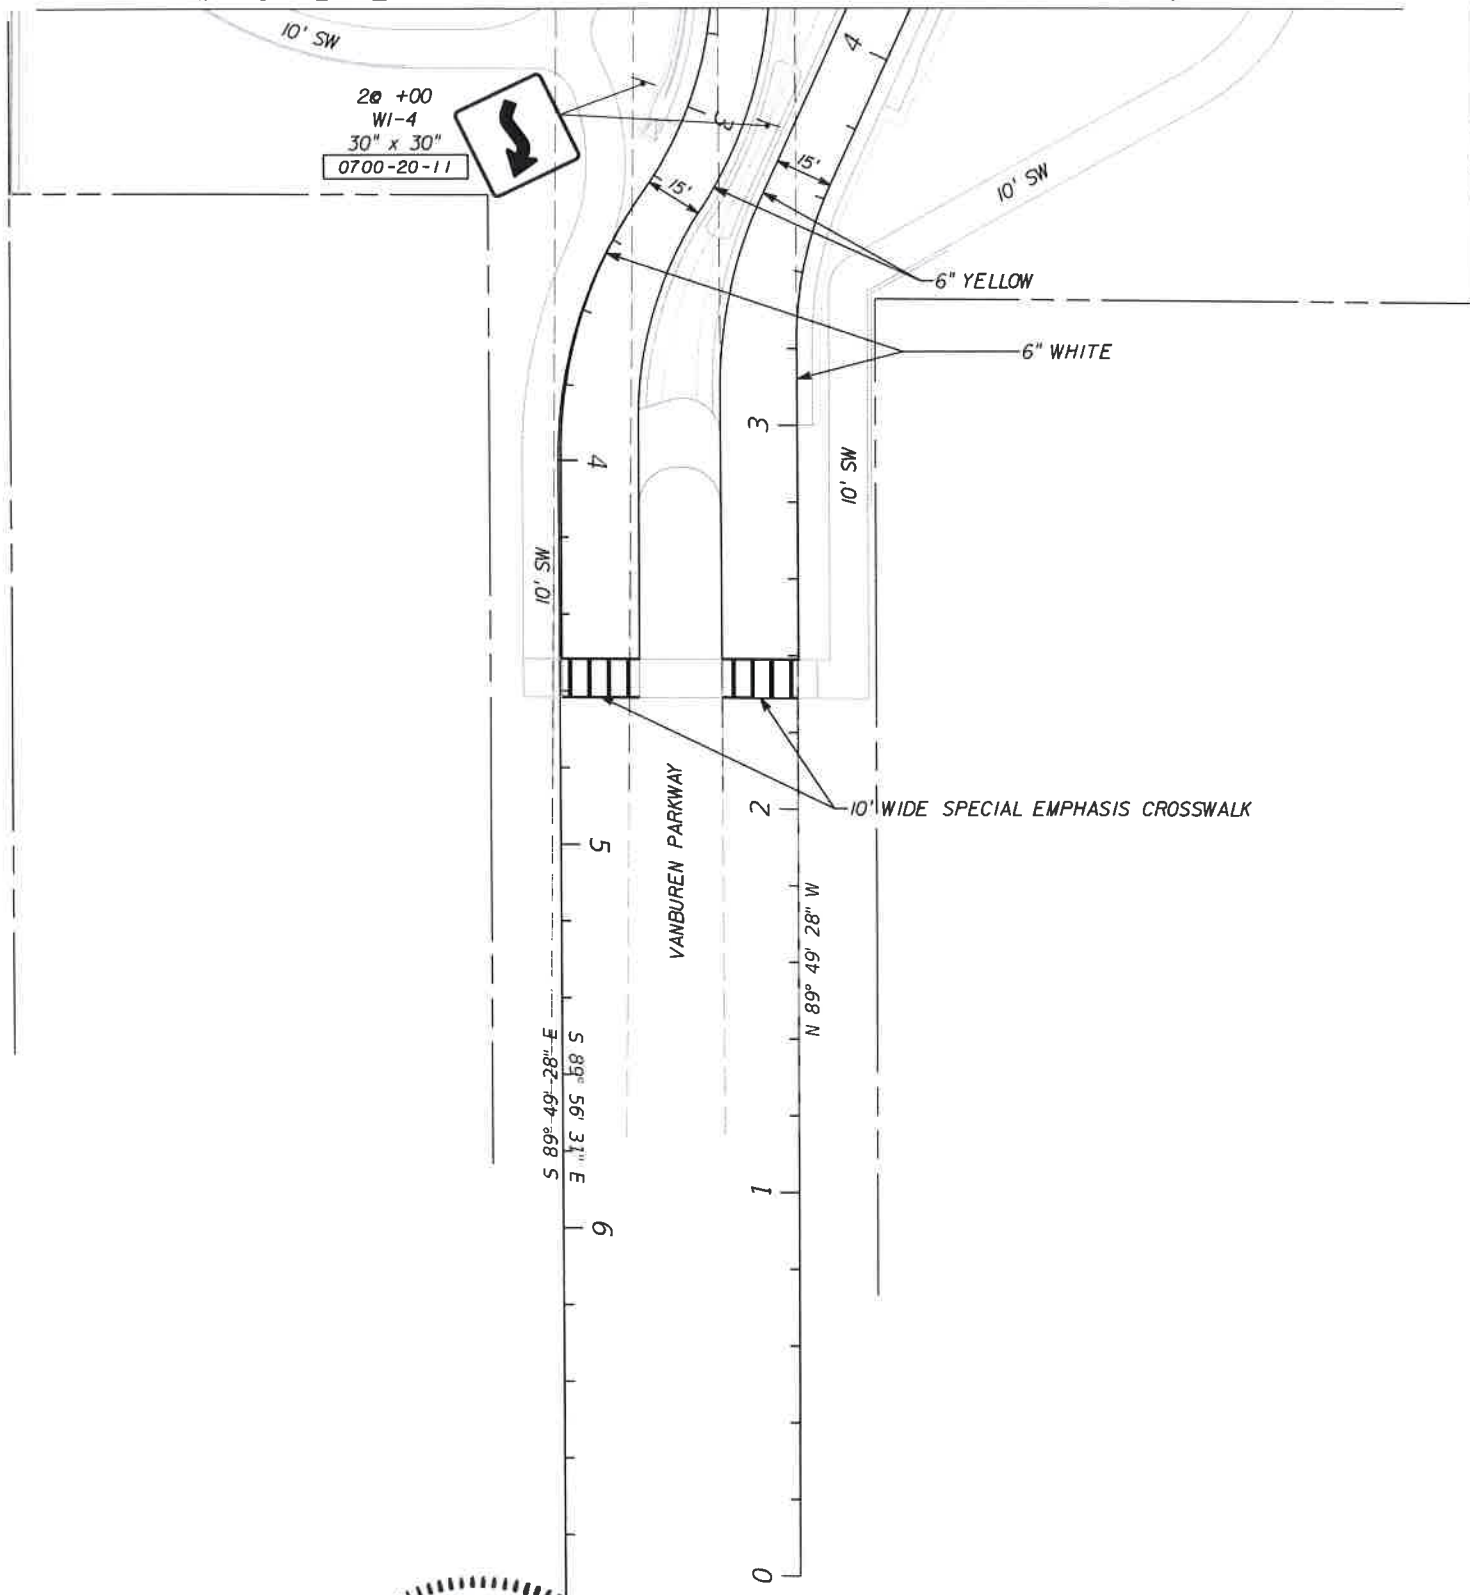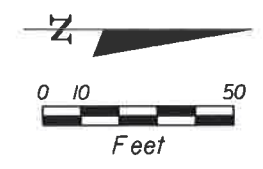

PUBLIC WORKS
LEE COUNTY
SOUTHWEST
FLORIDA
1300 MONROE STREET
FORT MYERS, FLORIDA 33901
12391 479-8900 www.lee-county.com/publicworks/office.htm

DEPARTMENT
of
TRANSPORTATION
FORT MYERS, FLORIDA 33901

rsbfelds 3/4/2015 4:45:21 PM

NO.	DATE	BY	REVISIONS - DESCRIPTION

T.Y. LIN INTERNATIONAL
2400 FIRST STREET
SUITE 200
FORT MYERS, FLORIDA 33901
TEL. (239) 332-4846
FAX. (239) 332-4798
WWW.TYLIN.COM

SIGNING & MARKING PLAN SHEET
VANBUREN PARKWAY
BURNT STORE ROAD

SHEET NO.
S-17

Service Point - refer to FDOT Design Standard,
Service Point detail, INDEX No. 17504
Minimum 60A, 240/120V, 10
Coordinate exact location with Lee County Cooperative

Const.
Burnt Store Rd.

1288

1289

1290

N 0°03'29" E

N 0°03'29" E

Conduit transition from
underground to under girder

See note 1
(Typ.)

(3)#8 in 1" C (Typ.)

Conduit Path (Typ.)
Supported from bottom
of girder

Arroz Canal

R/W Line

PLAN

35
25
15
5
-5

Lighting Fixture
(Typ.)

Conduit Path

35
25
15
5
-5

ELEVATION

NOTES

1. Lighting based on Topier LED fixture, catalog No. TT-A@-LED-E1-WG-CG, distributed by Lighting Dynamics. Equivalent fixtures acceptable upon review/approval by owner and engineer.


2. Minimum illumination is 2 fc.



NO.	DATE	BY	REVISIONS - DESCRIPTION

T.Y. LIN INTERNATIONAL
2400 FIRST STREET
SUITE 200
FORT MYERS, FLORIDA 33901
TEL. (239) 332-4846
FAX. (239) 332-4798
WWW.TYLIN.COM


APPROVED BY:
ENRIQUE SOSA, P.E.
REGISTERED PROFESSIONAL ENGINEER
FLORIDA CERTIFICATE NO. 53885

 PUBLIC WORKS
LEE COUNTY
SOUTHWEST
FLORIDA
1500 MONROE STREET
FORT MYERS, FLORIDA 33901
(239) 479-8900 www.lee-county.com/publicworks/detail.htm

DEPARTMENT
of
TRANSPORTATION

LIGHTING PLAN
ARROZ CANAL
BURNT STORE ROAD

SHEET
NO.
L-1

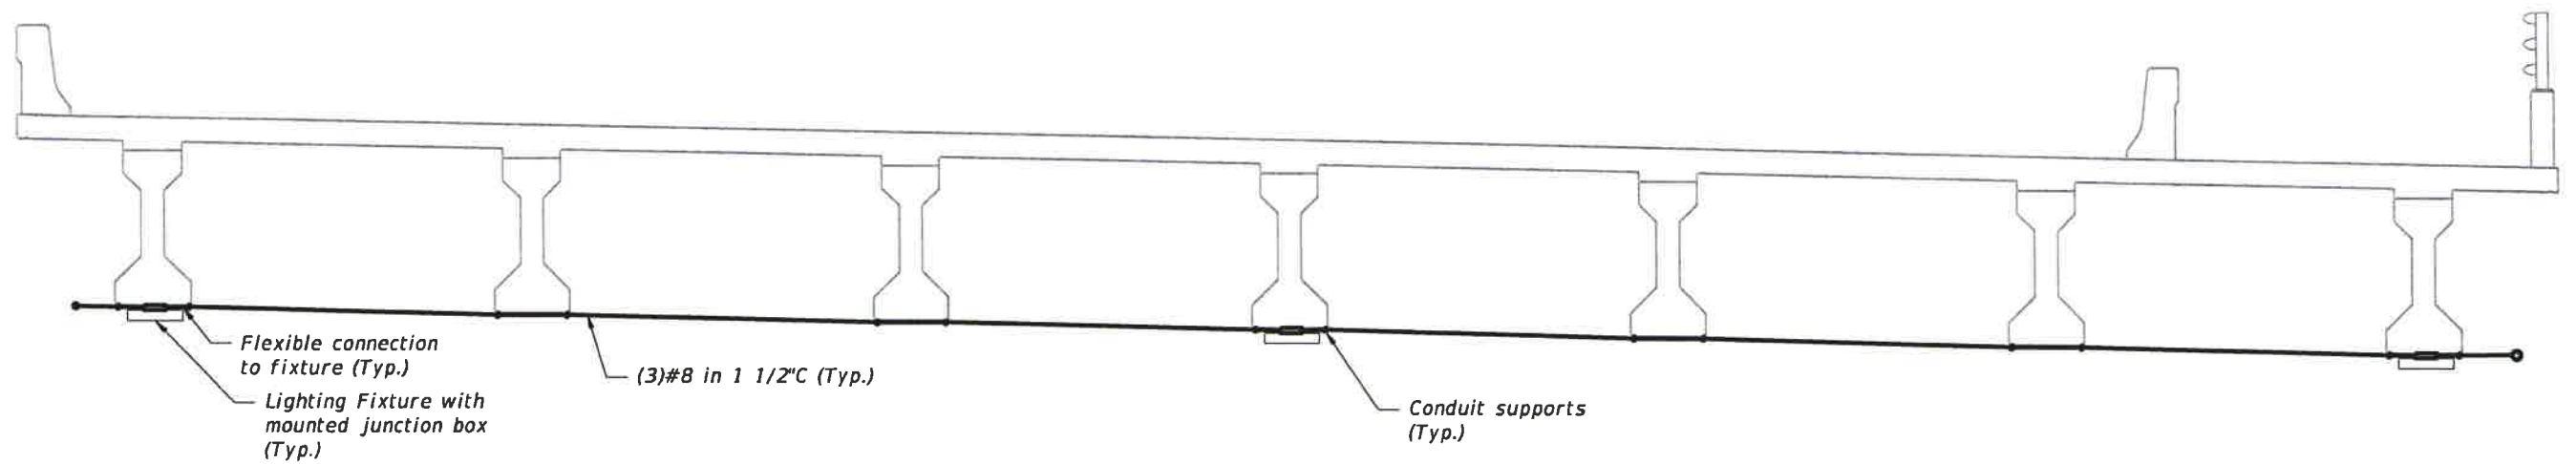


UNDER DECK SECTION



NO.	DATE	BY	REVISIONS - DESCRIPTION

T.Y. LIN INTERNATIONAL
 2400 FIRST STREET
 SUITE 200
 FORT MYERS, FLORIDA 33901
 TEL. (239) 332-4846
 FAX. (239) 332-4798
 WWW.TYLIN.COM

APPROVED BY
ENRIQUE SOSA, P.E.
 REGISTERED PROFESSIONAL ENGINEER
 FLORIDA CERTIFICATE NO. 53885

 PUBLIC WORKS
LEE COUNTY
 DEPARTMENT
 of
SOUTHWEST
FLORIDA
 1500 MONROE STREET
 FORT MYERS, FLORIDA 33901
 (239) 479-8900 www.lee-county.com/publicworks/detail.htm

LIGHTING PLAN
ARROZ CANAL

BURNT STORE ROAD

SHEET
 NO.
 L-2

Service Point - refer to FDOT Design Standard,
Service Point detail, INDEX No. 17504
Minimum 60A, 240/120V, 1Ø
Coordinate exact location with
Lee County Electric Cooperative

Conduit Transition from
under ground to under girder

See note 1
(Typ.)

(3)#8 in 1 1/2" C Typ.

Conduit Path (Typ.)
Supported from bottom
of girder

Lighting Fixture
(Typ.)

Conduit Path




NOTES:

1. Lighting based on Topier LED fixture, catalog No. TT-A2-LED-E1-WG-CG, distributed by Lighting Dynamics. Equivalent fixtures acceptable upon review/approval by owner and engineer.
2. Minimum illumination is 2 fc.

NO.	DATE	BY	REVISIONS - DESCRIPTION

T.Y. LIN INTERNATIONAL
2400 FIRST STREET
SUITE 200
FORT MYERS, FLORIDA 33901
TEL. (239) 332-4846
FAX. (239) 332-4798
WWW.TYLIN.COM

APPROVED BY:
ENRIQUE SOSA, P.E.
REGISTERED PROFESSIONAL ENGINEER
FLORIDA CERTIFICATE NO. 53885


 PUBLIC WORKS
LEE COUNTY
SOUTHWEST
FLORIDA
1500 MONROE STREET
FORT MYERS, FLORIDA 33901
12391 479 8900 www.lee-county.com/publicworks/default.htm

DEPARTMENT
of
TRANSPORTATION

LIGHTING PLAN
HORSESHOE CANAL
BURNT STORE ROAD

SHEET
NO.
L-3

(Index 820)

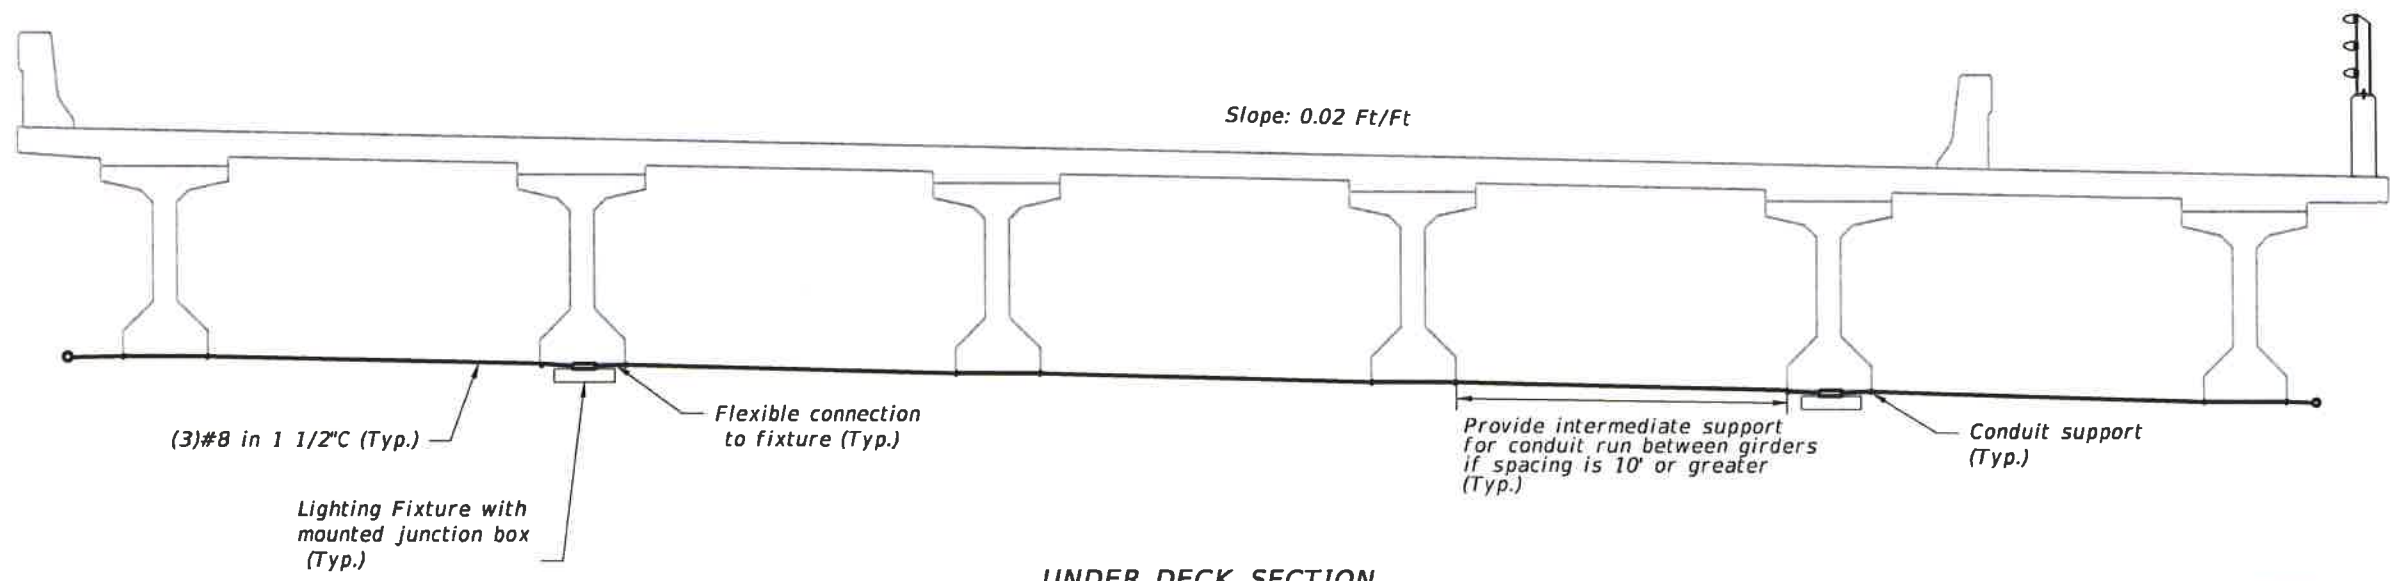


UNDER DECK SECTION



NO.	DATE	BY	REVISIONS - DESCRIPTION

T.Y. LIN INTERNATIONAL
2400 FIRST STREET
SUITE 200
FORT MYERS, FLORIDA 33901
TEL. (239) 332-4846
FAX. (239) 332-4798
WWW.TYLIN.COM

APPROVED BY:
ENRIQUE SOSA, P.E.
REGISTERED PROFESSIONAL ENGINEER
FLORIDA CERTIFICATE NO. 53885

 PUBLIC WORKS
LEE COUNTY
SOUTHWEST
FLORIDA
1500 MONROE STREET
FORT MYERS, FLORIDA 33901
TEL. (239) 479-8900 www.lee-county.com/publicworks/default.htm

DEPARTMENT
of
TRANSPORTATION

LIGHTING PLAN
HORSESHOE CANAL
BURNT STORE ROAD

SHEET
NO.
L-4