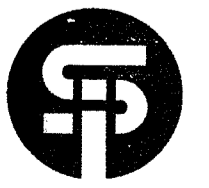


FORT MYERS BEACH
 POTABLE WATER DISTRIBUTION SYSTEM
 KEY MAP


Jul 14, 2006 - 1:34pm C.O. Neijers
 Z:\Current Projects\666-01-04 Ft. Myers Beach Potable Water Dist. System (07-14-05)\02 666-01-04 Partial Site Plan.dwg


REVISION	DATE	REMARKS	CHG. BY

THOMAS J. PUGH, P.E. FLORIDA CERTIFICATE NUMBER 48221 DATE JUL 14 2006	 SOURCE, INC. ENGINEERS - PLANNERS Engineering Business #2627 1334 LAFAYETTE STREET * CAPE CORAL, FL 33904 TELEPHONE (239)549-2345 FAX (239)549-6779	JOB NO. 666-01-04	SHEET NO. 1
		DATE 05-18-06	DRAWN BY: CON FILE NAME: 01-666.DWG

Jul 14, 2006 - 1:41pm C.O. Noguero
 Z:\Current Projects\666-01-04 Ft. Myers Beach Potable Water Dist. System (07-14-05)\02 666-01-04 Partial Site Plan.dwg


REVISION	DATE	REMARKS	CHG. BY

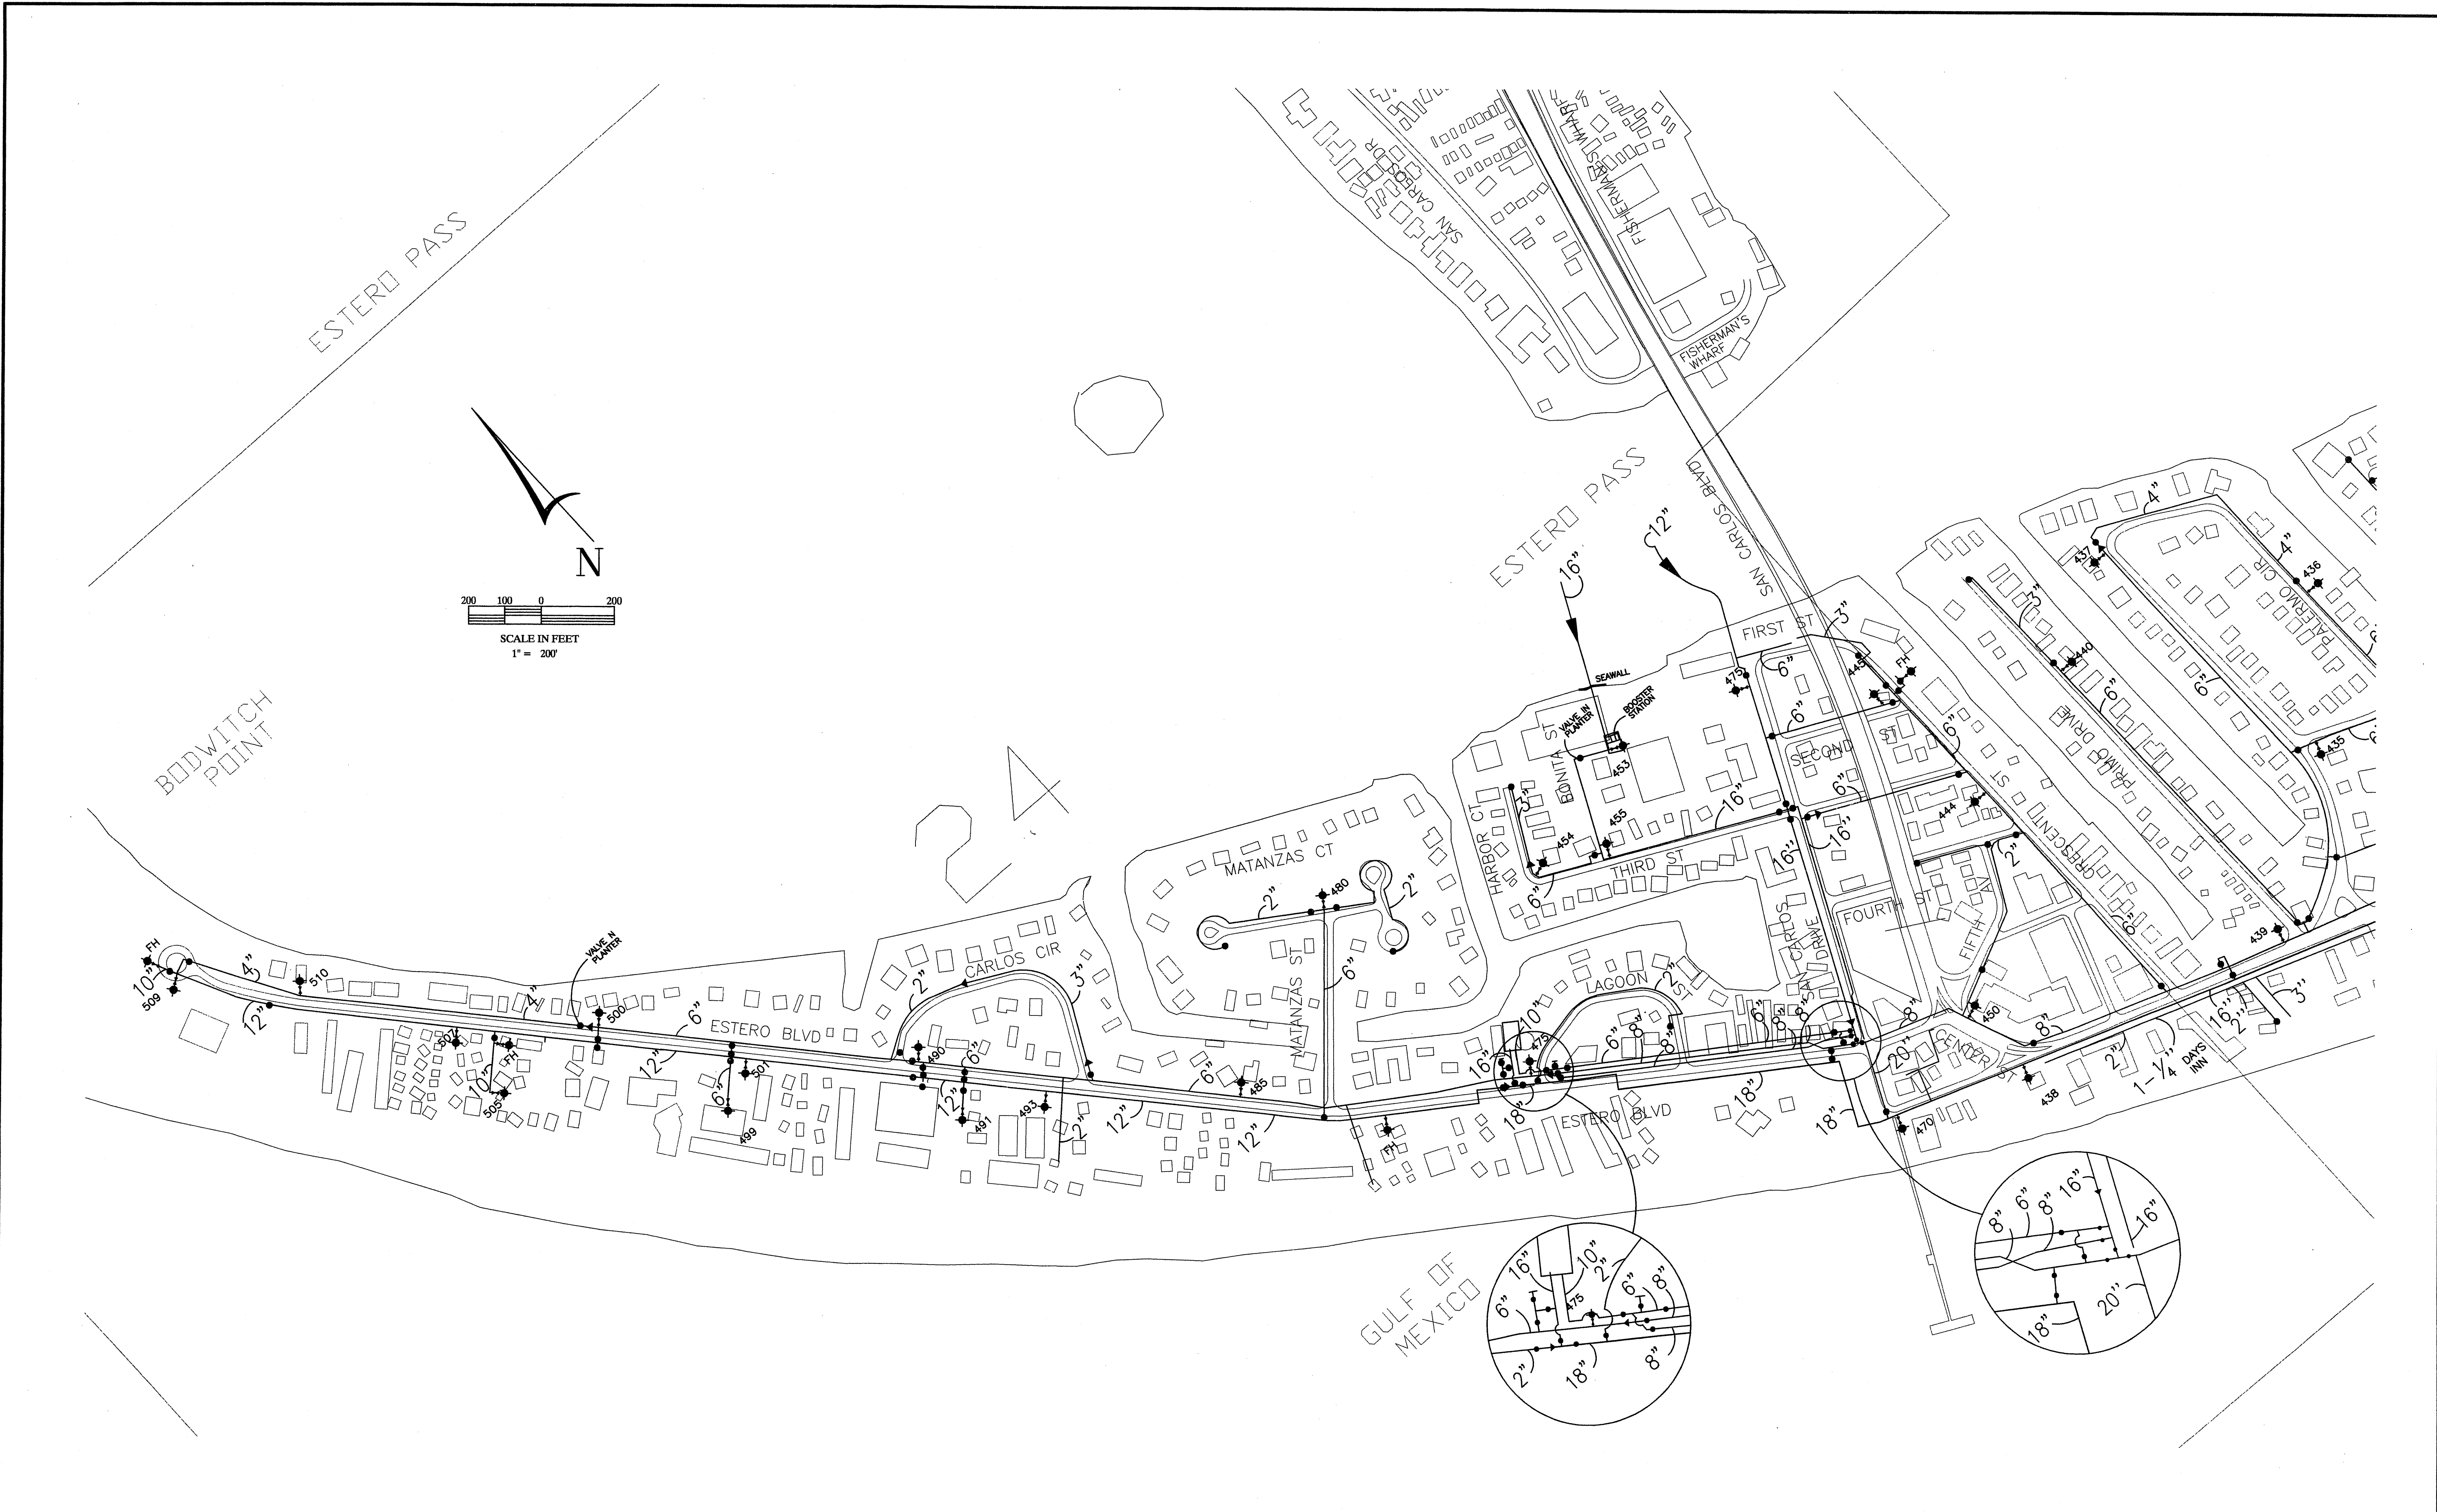

THOMAS J. PUGH, P.E. FLORIDA CERTIFICATE NUMBER 48221 DATE JUL 14 2006	 SOURCE, INC. ENGINEERS - PLANNERS Engineering Business #2527 1334 LAFAYETTE STREET * CAPE CORAL, FL 33904 TELEPHONE (239)549-2345 FAX (239)549-6779	JOB NO. 666-01-04	SHEET NO. 2
		DATE 05-18-06	OF 7 DRAWN BY: CON FILE NAME: 02-666.DWG


Jul 14, 2008 - 1:43pm C.O. Nejorro
 Z:\Current Projects\666-01-04 F. Myers Beach Potable Water Dist. System (07-14-05)\02 666-01-04 Partial Site Plan.dwg


REVISION	DATE	REMARKS	CHG. BY

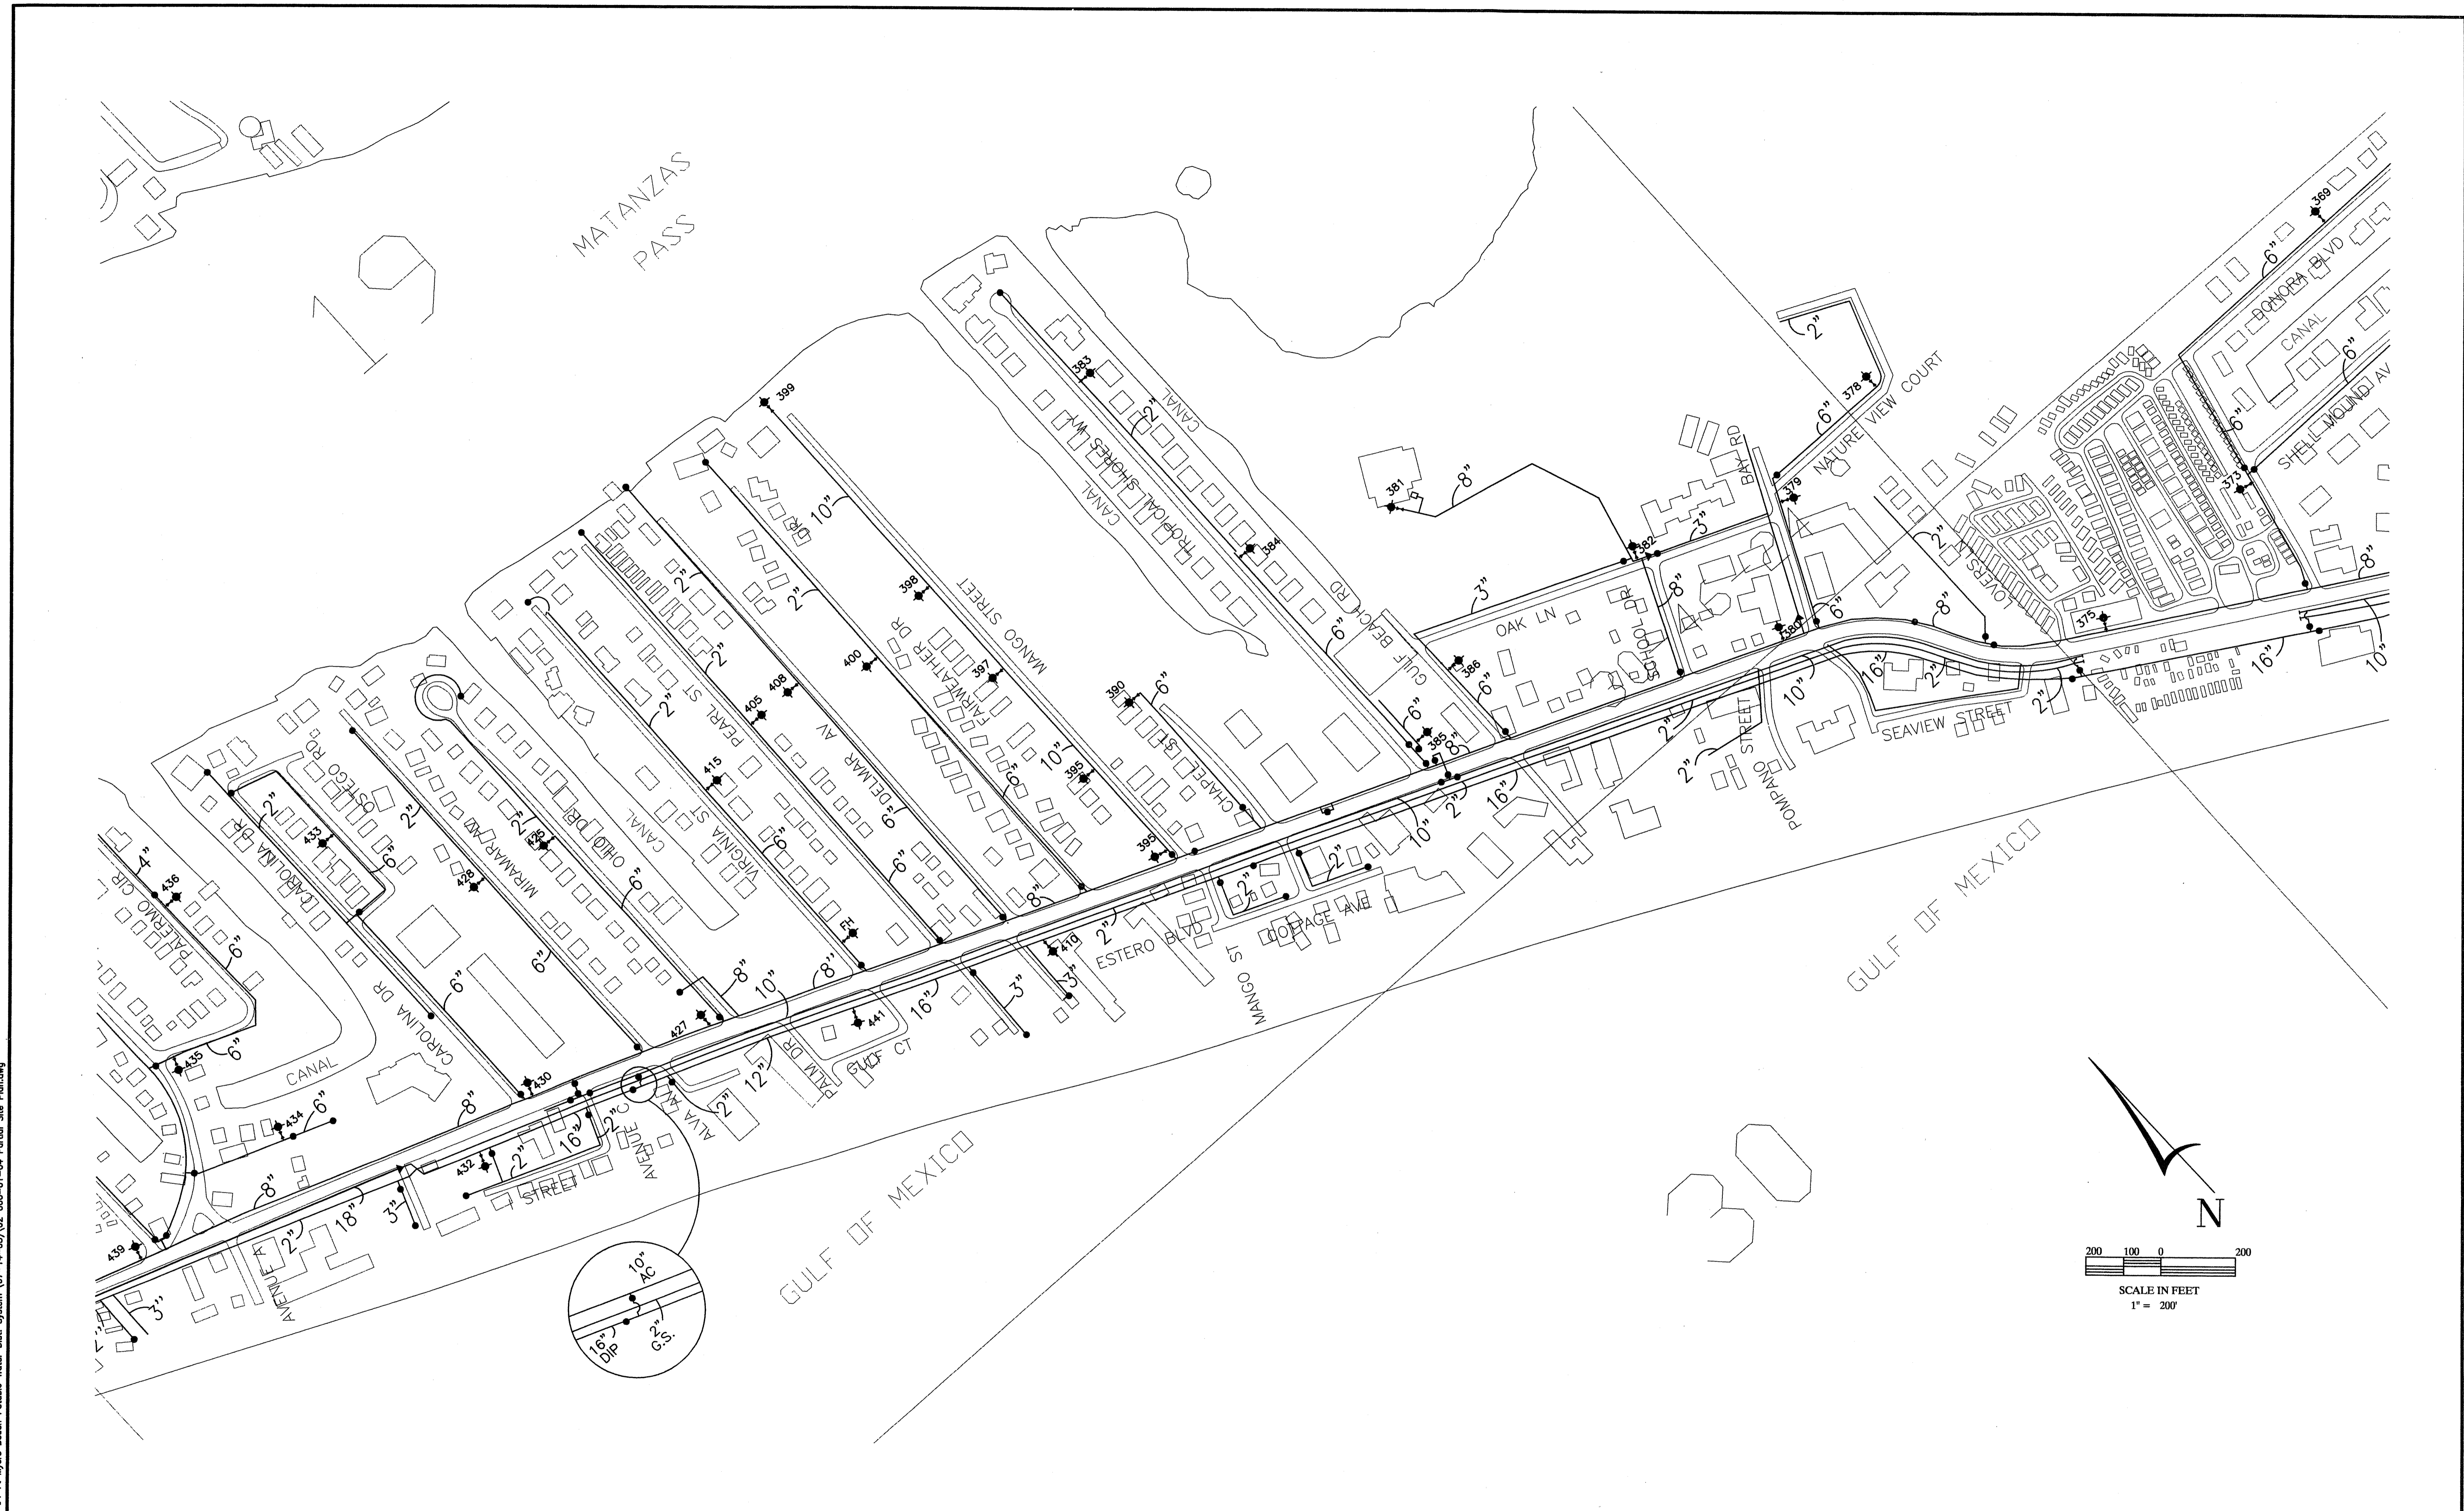

GULF OF MEXICO


MATANZAS PASS

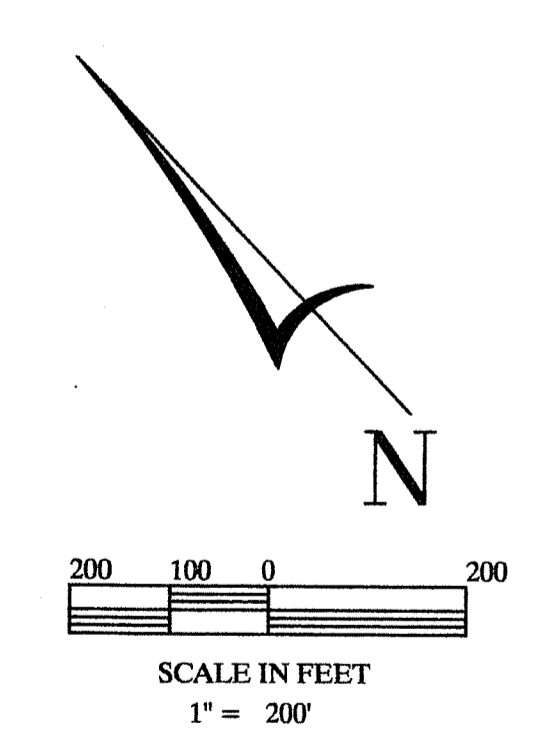


THOMAS J. PUGH, P.E. FLORIDA CERTIFICATE NUMBER 48221 DATE JUL 14 2006	 SOURCE, INC. ENGINEERS - PLANNERS <small>Engineering Business #2027</small>	JOB NO. 666-01-04	SHEET NO. 3
		DATE 05-18-06	DRAWN BY: CON
		1334 LAFAYETTE STREET • CAPE CORAL, FL 33904 TELEPHONE (239)548-2345 FAX (239)548-8779	FILE NAME: <small>02_666_PWS</small>

Jul 14, 2006 - 1:43pm C.O. Nigero
 Z:\Current Projects\666-01-04 Fl Myers Beach Potable Water Dist. System (07-14-05)\02 666-01-04 Partial Site Plan.dwg


REVISION	DATE	REMARKS	CHG. BY

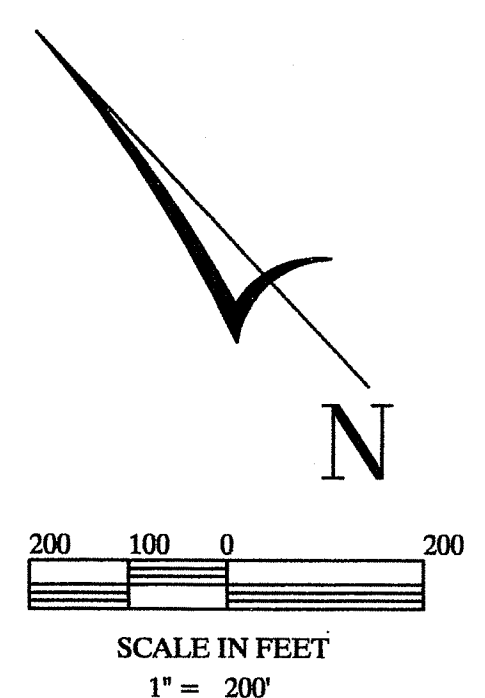


THOMAS J. PUGH, P.E. FLORIDA CERTIFICATE NUMBER 48221 DATE JUL 1 4 2006	 SOURCE, INC. ENGINEERS - PLANNERS <small>Engineering Business #2627</small>	JOB NO. 666-01-04	SHEET NO. 4
		DATE 05-18-06	DRAWN BY: CON FILE NAME: 04-666.DWG
1334 LAFAYETTE STREET • CAPE CORAL, FL 33904 TELEPHONE (239)549-2345 FAX (239)549-6779			

Jul 14, 2006 - 1:44pm C.O. Neijm
 Z:\Current Projects\666-01-04 Fl. Myers Beach Potable Water Dist. System (07-14-05)\02 666-01-04 Partial Site Plan.dwg


REVISION	DATE	REMARKS	CHG. BY

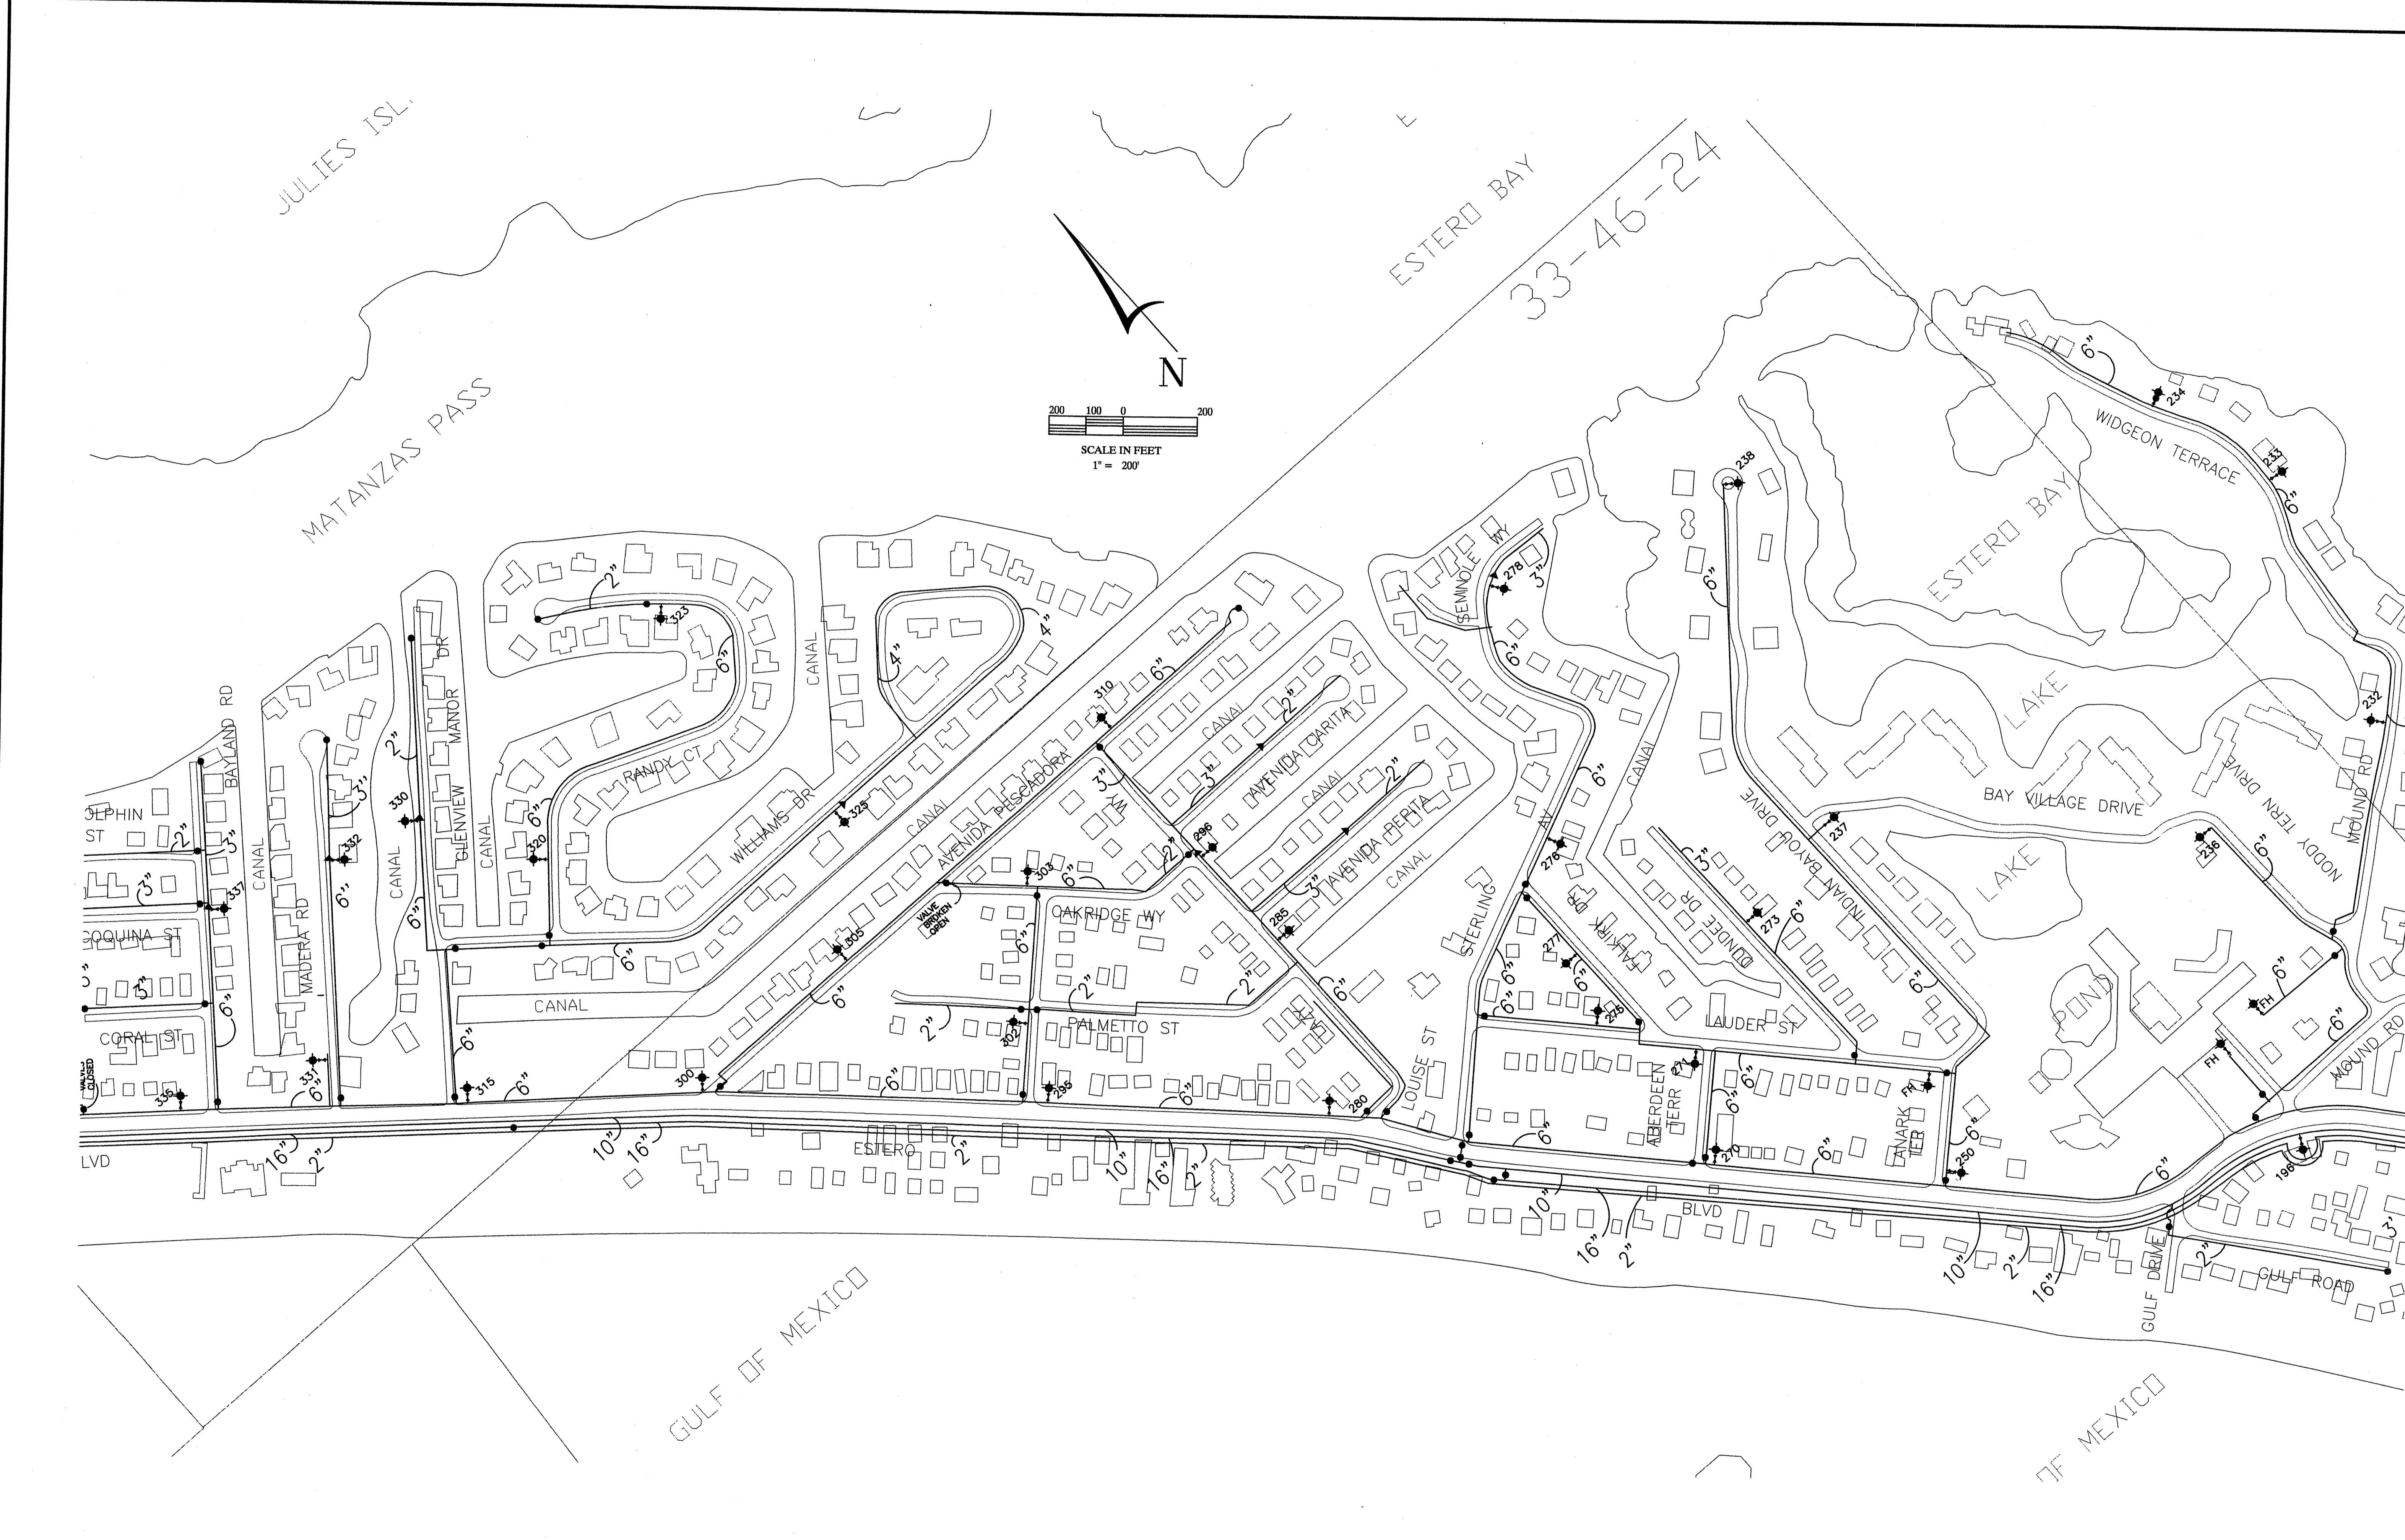


THOMAS J. PUGH, P.E. FLORIDA CERTIFICATE NUMBER 48221 DATE: JUL 14 2006	 SOURCE, INC. ENGINEERS - PLANNERS Engineering Business #2627 1334 LAFAYETTE STREET • CAPE CORAL, FL 33904 TELEPHONE (239)549-2345 FAX (239)549-6779	JOB NO. 666-01-04	SHEET NO. 5
		DATE 05-18-06	DRAWN BY: CON FILE NAME: 05-666.DWG

Jul 14, 2006 - 1:44pm C.O. Najera
Z:\Current Projects\666-01-04 Ft. Myers Beach Potable Water Dist. System (07-14-05)\02 666-01-04 Partial Site Plan.dwg


REVISION	DATE	REMARKS	CHG. BY

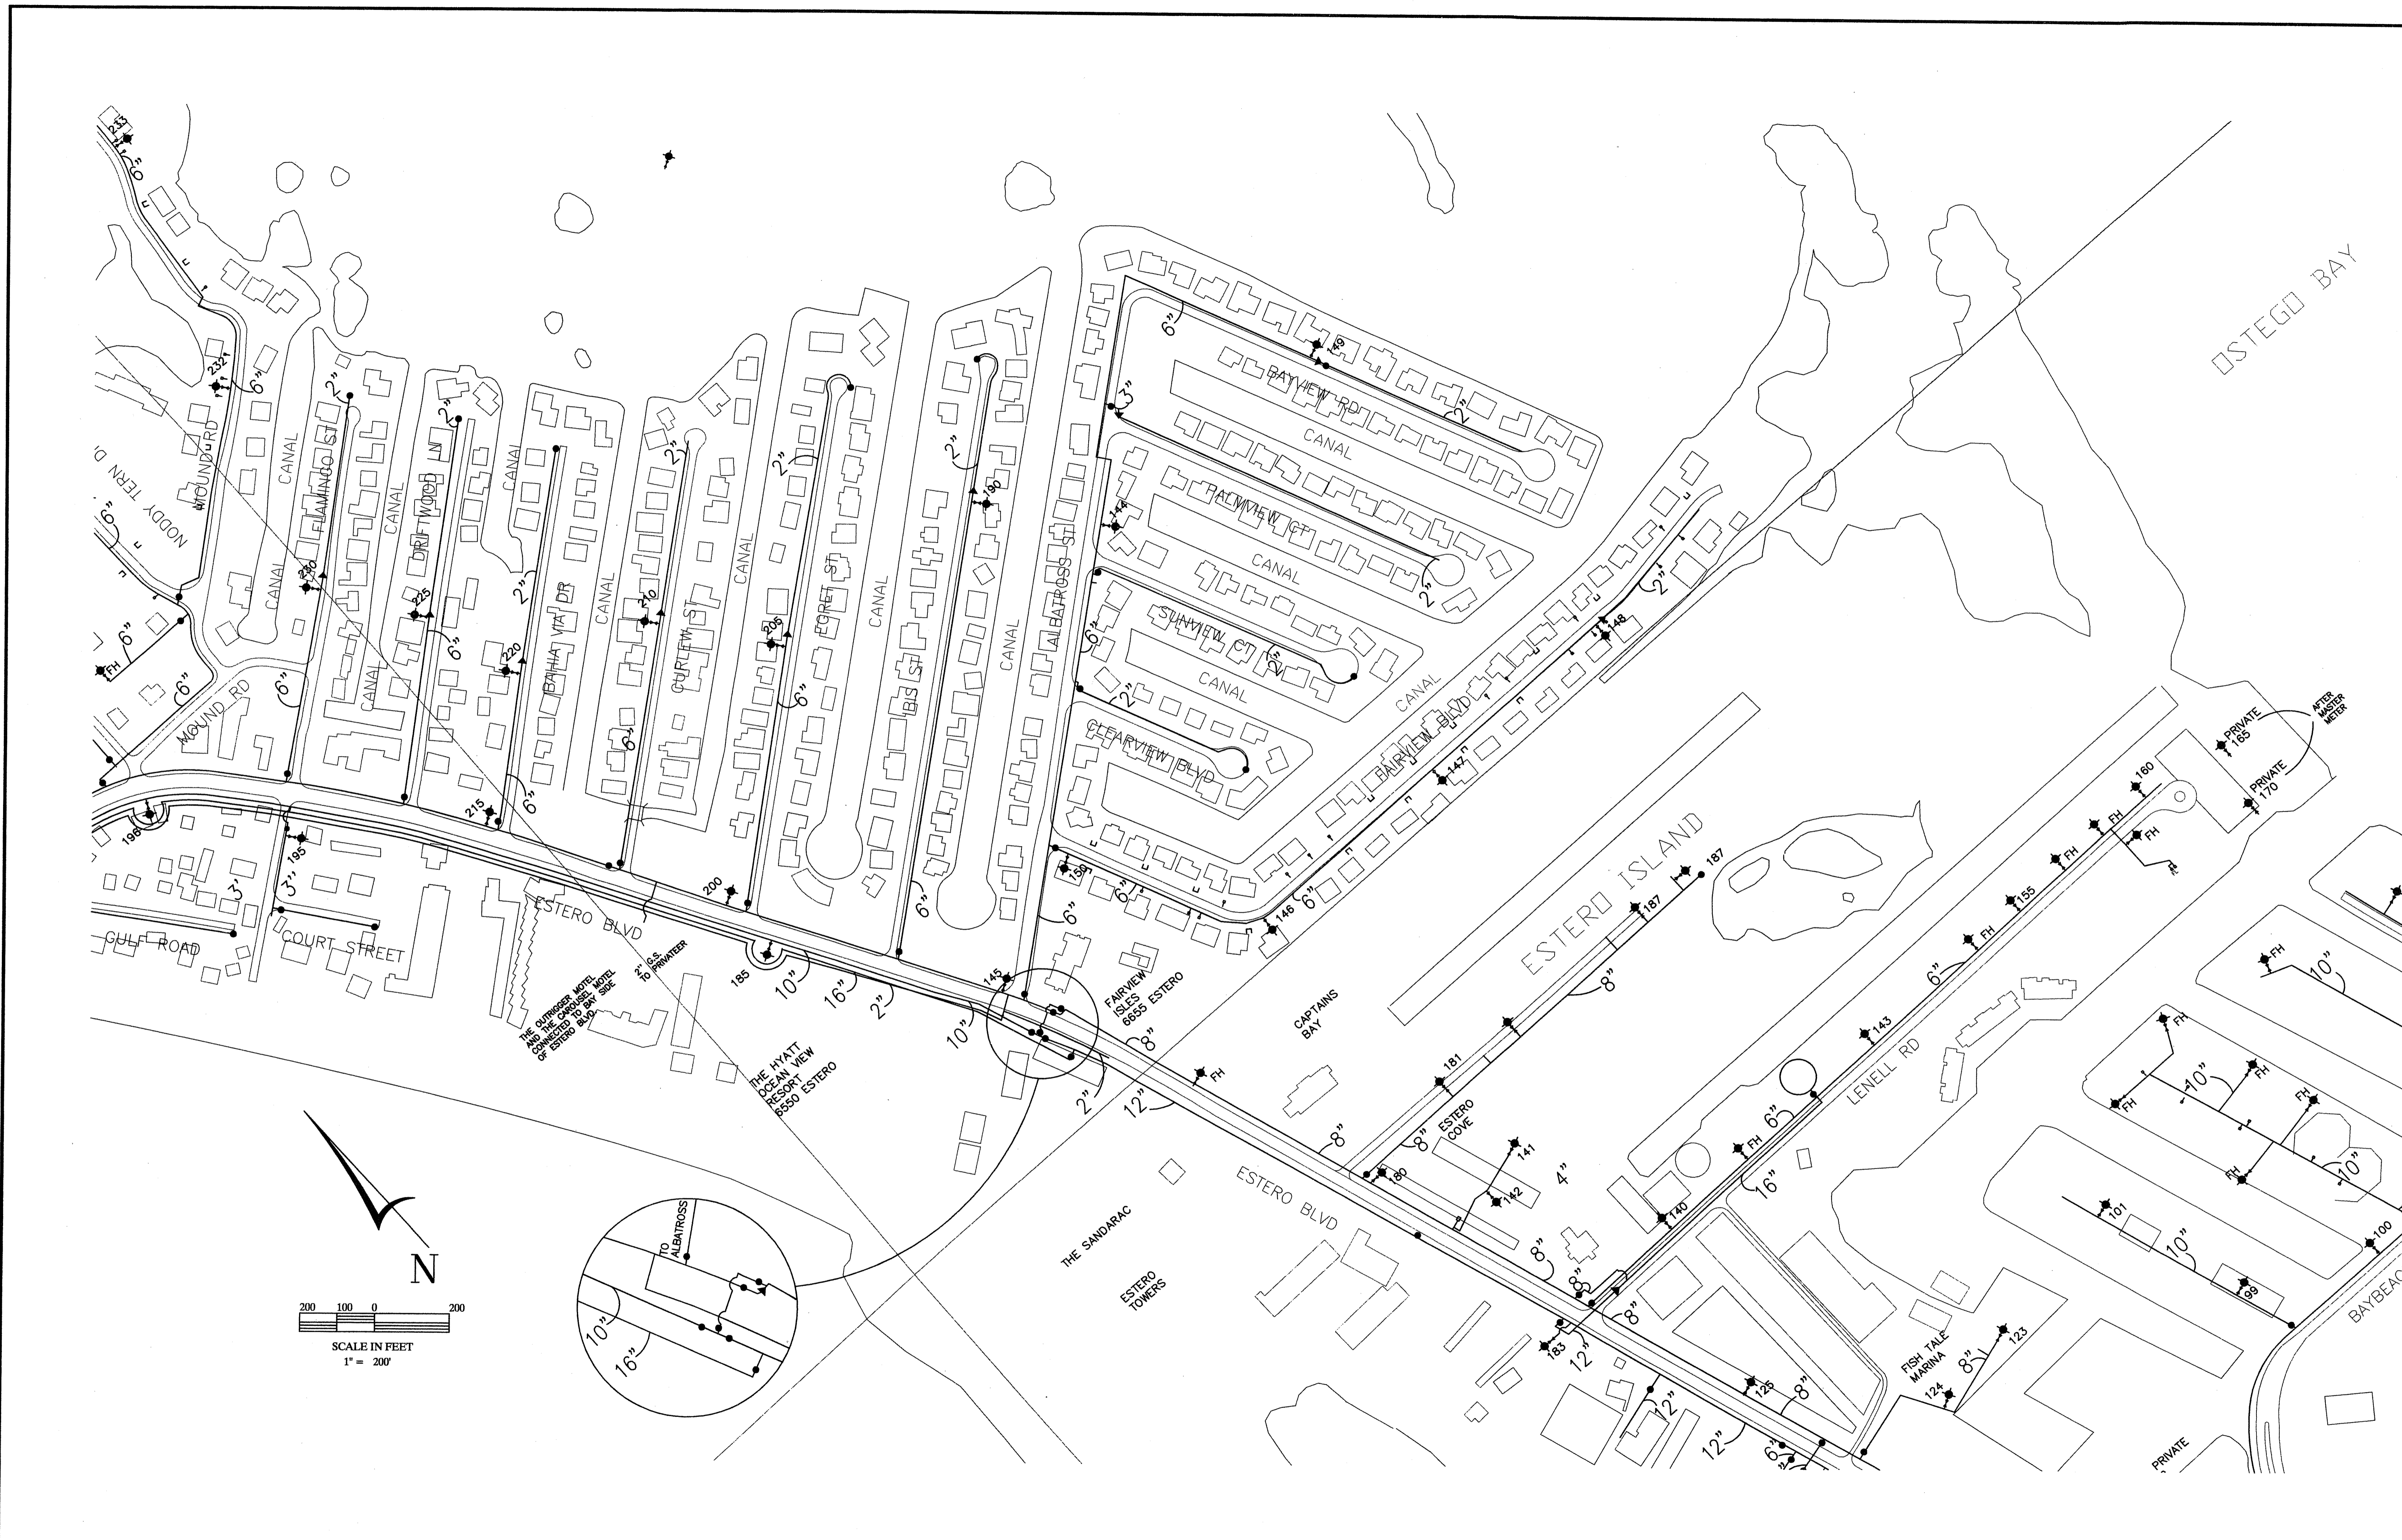

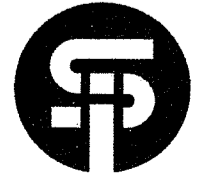
THOMAS J. PUGH, P.E. FLORIDA CERTIFICATE NUMBER 48221 DATE JUL 14 2006	 SOURCE, INC. ENGINEERS - PLANNERS Engineering Business #207 1334 LAFAYETTE STREET • CAPE CORAL, FL 33904 TELEPHONE (239)549-2345 FAX (239)549-6779	JOB NO. 666-01-04 DATE 05-18-06	SHEET NO. 6 OF 7 DRAWN BY: CON FILE NAME: 06-566.DWG
--	---	--	---

JUL 14, 2006 - 1:45PM C.C. NIEBERG
 Z:\Current Projects\666-01-04 Fl. Myers Beach Potable Water Dist. System (07-14-05)\02 666-01-04 Potable Site Plan.dwg

REVISION	DATE	REMARKS	CHG. BY

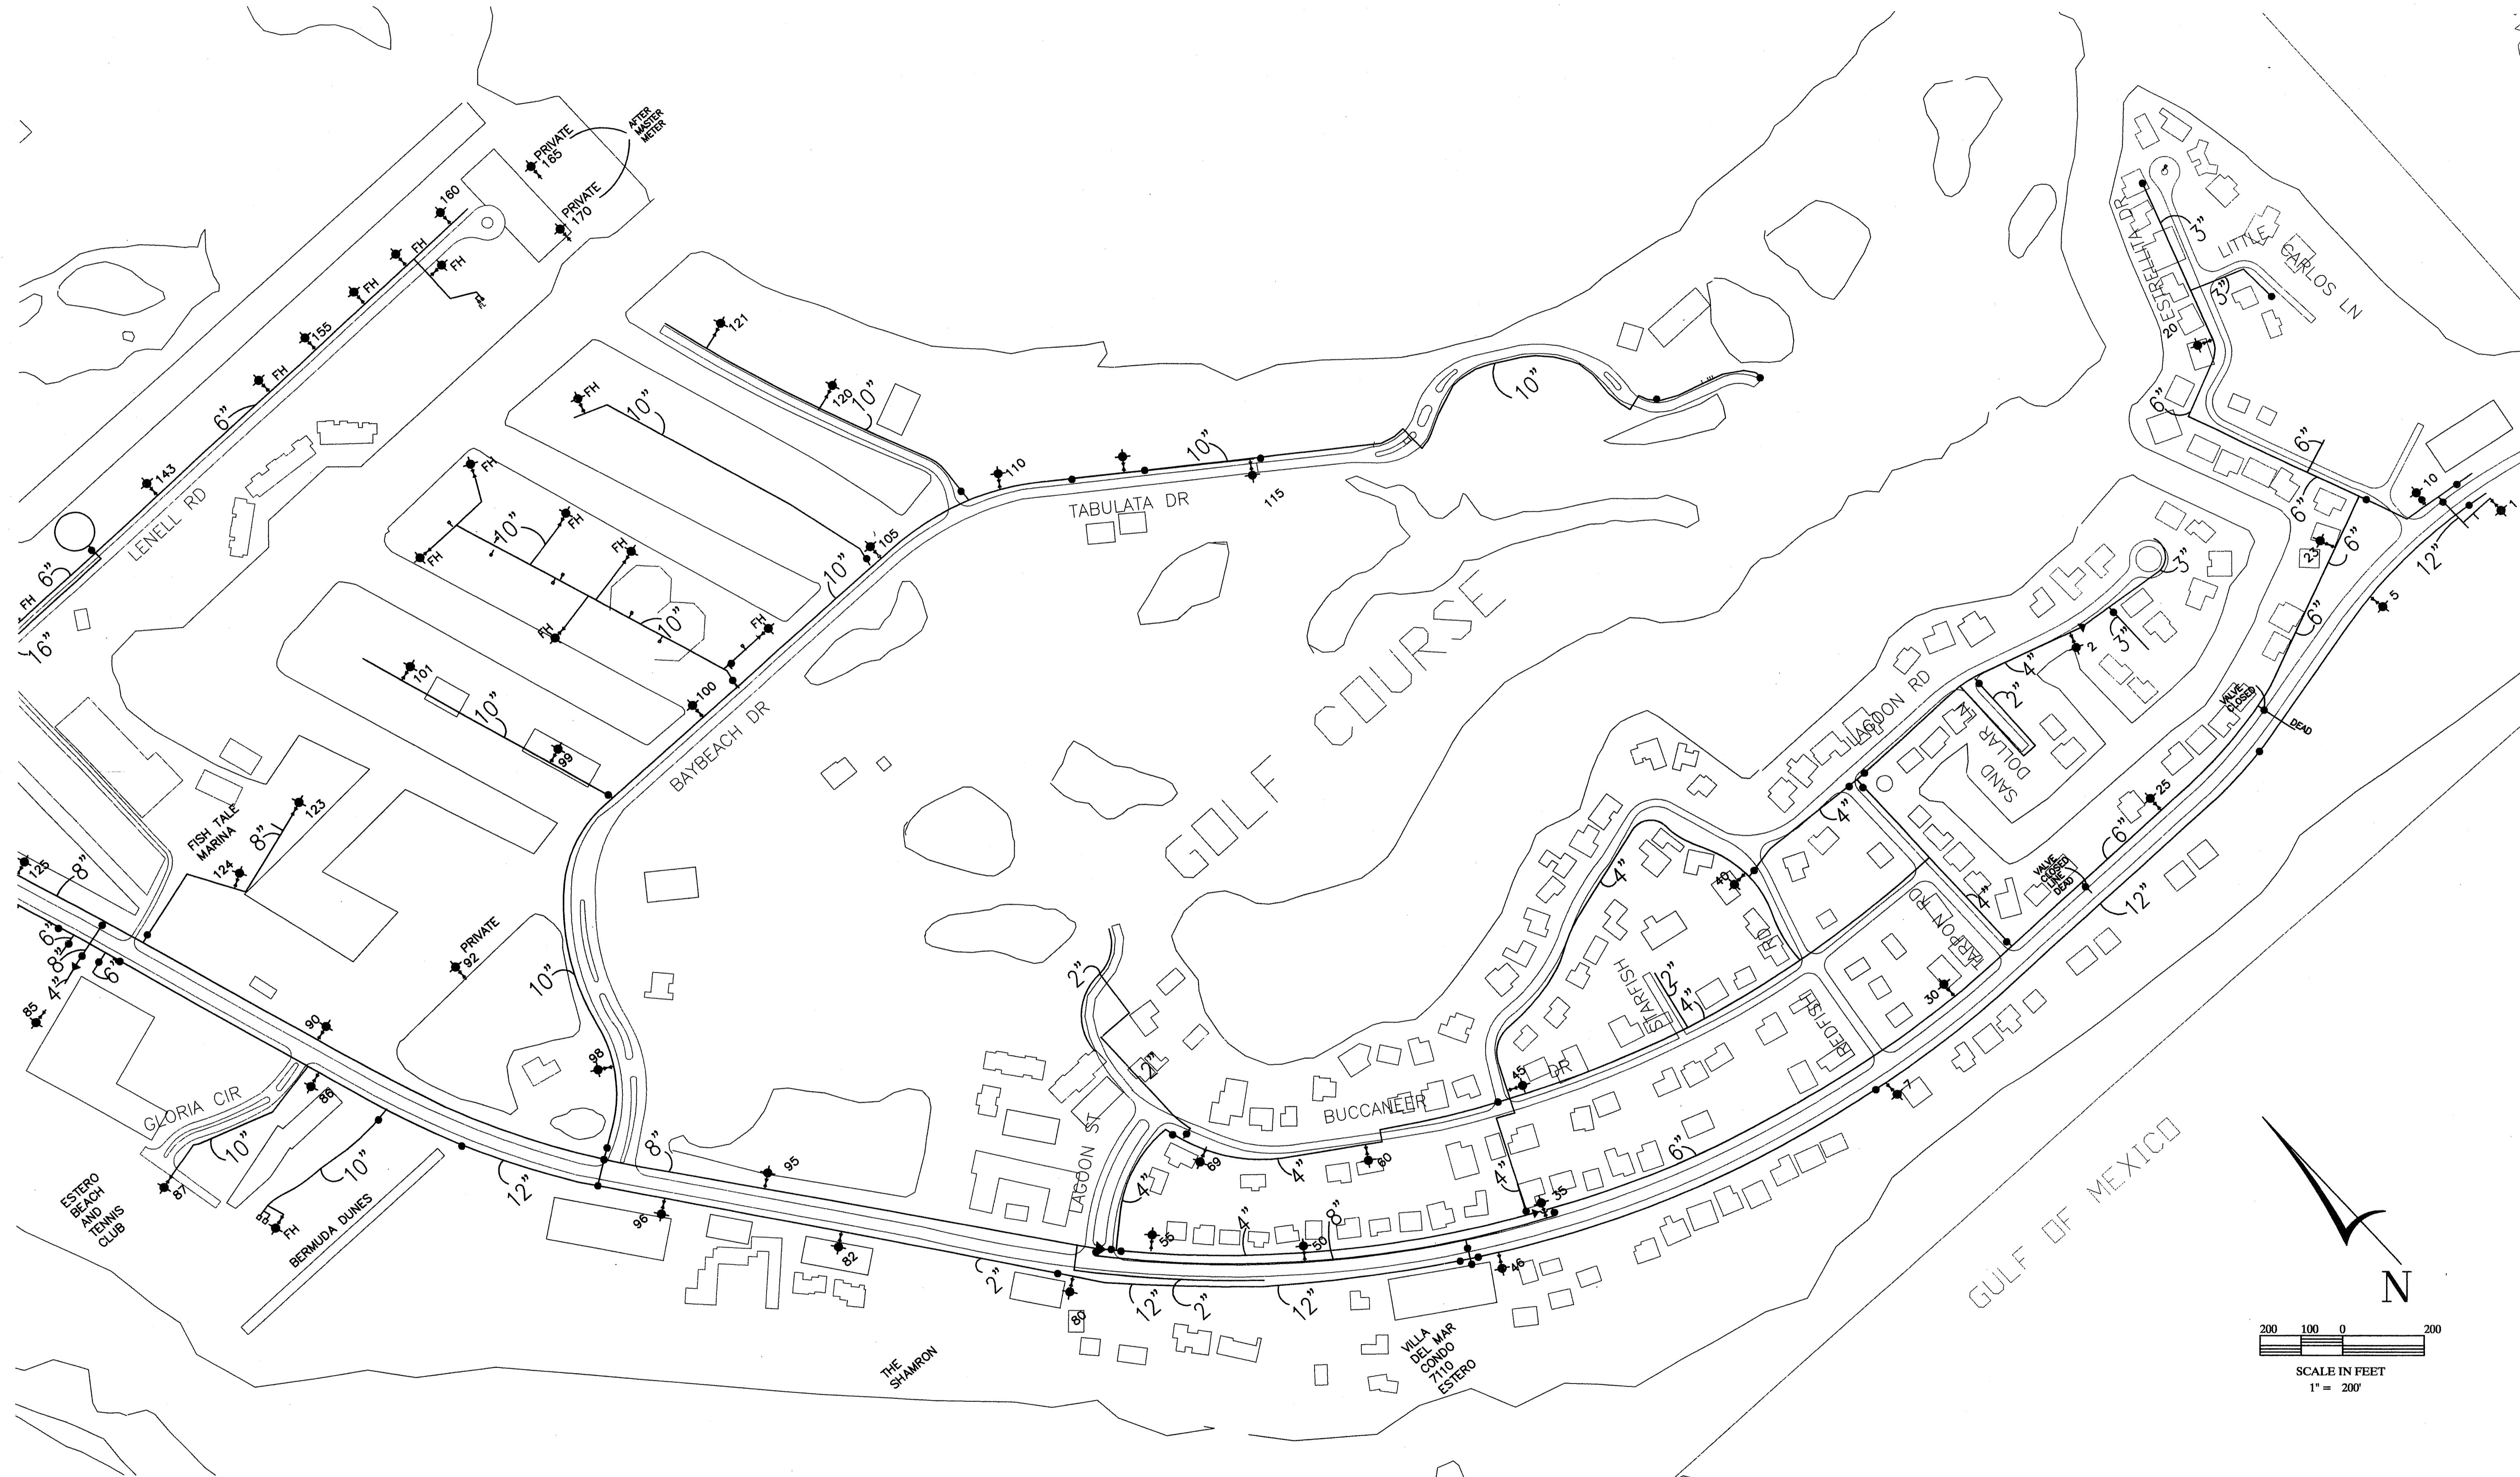

THOMAS J. PUGH, P.E. FLORIDA CERTIFICATE NUMBER 48221 DATE JUL 14 2006	 SOURCE, INC. ENGINEERS, PLANNERS Engineering Business #2827 1334 LAFAYETTE STREET • CAPE CORAL, FL 33904 TELEPHONE (239)549-2345 FAX (239)549-6779	JOB NO. 666-01-04	SHEET NO. 7
		DATE	OF 7
DATE	FILE NAME: 07-666.DWG	DATE 05-18-06	DRAWN BY: CON